

FIRE RATING FOR STAIRWELL MUST BE SHOWN

1
A **FIRST FLOOR PLAN**
SCALE: 3/8" = 1'-0"

FIRE LIFE SAFETY PLAN / EGRESS PLAN / EMERGENCY EXIT LIGHTS AND ILLUMINATION MUST BE PROVIDED


| | |
|----------|---------|
| Designed | D-DATE |
| Drawn | DR-DATE |
| Checked | C-DATE |
| Approved | Date |
| Title | |

ADDRESS
Fuquay Varina, North Carolina

Sheet Title .


Sheet Number.

A1

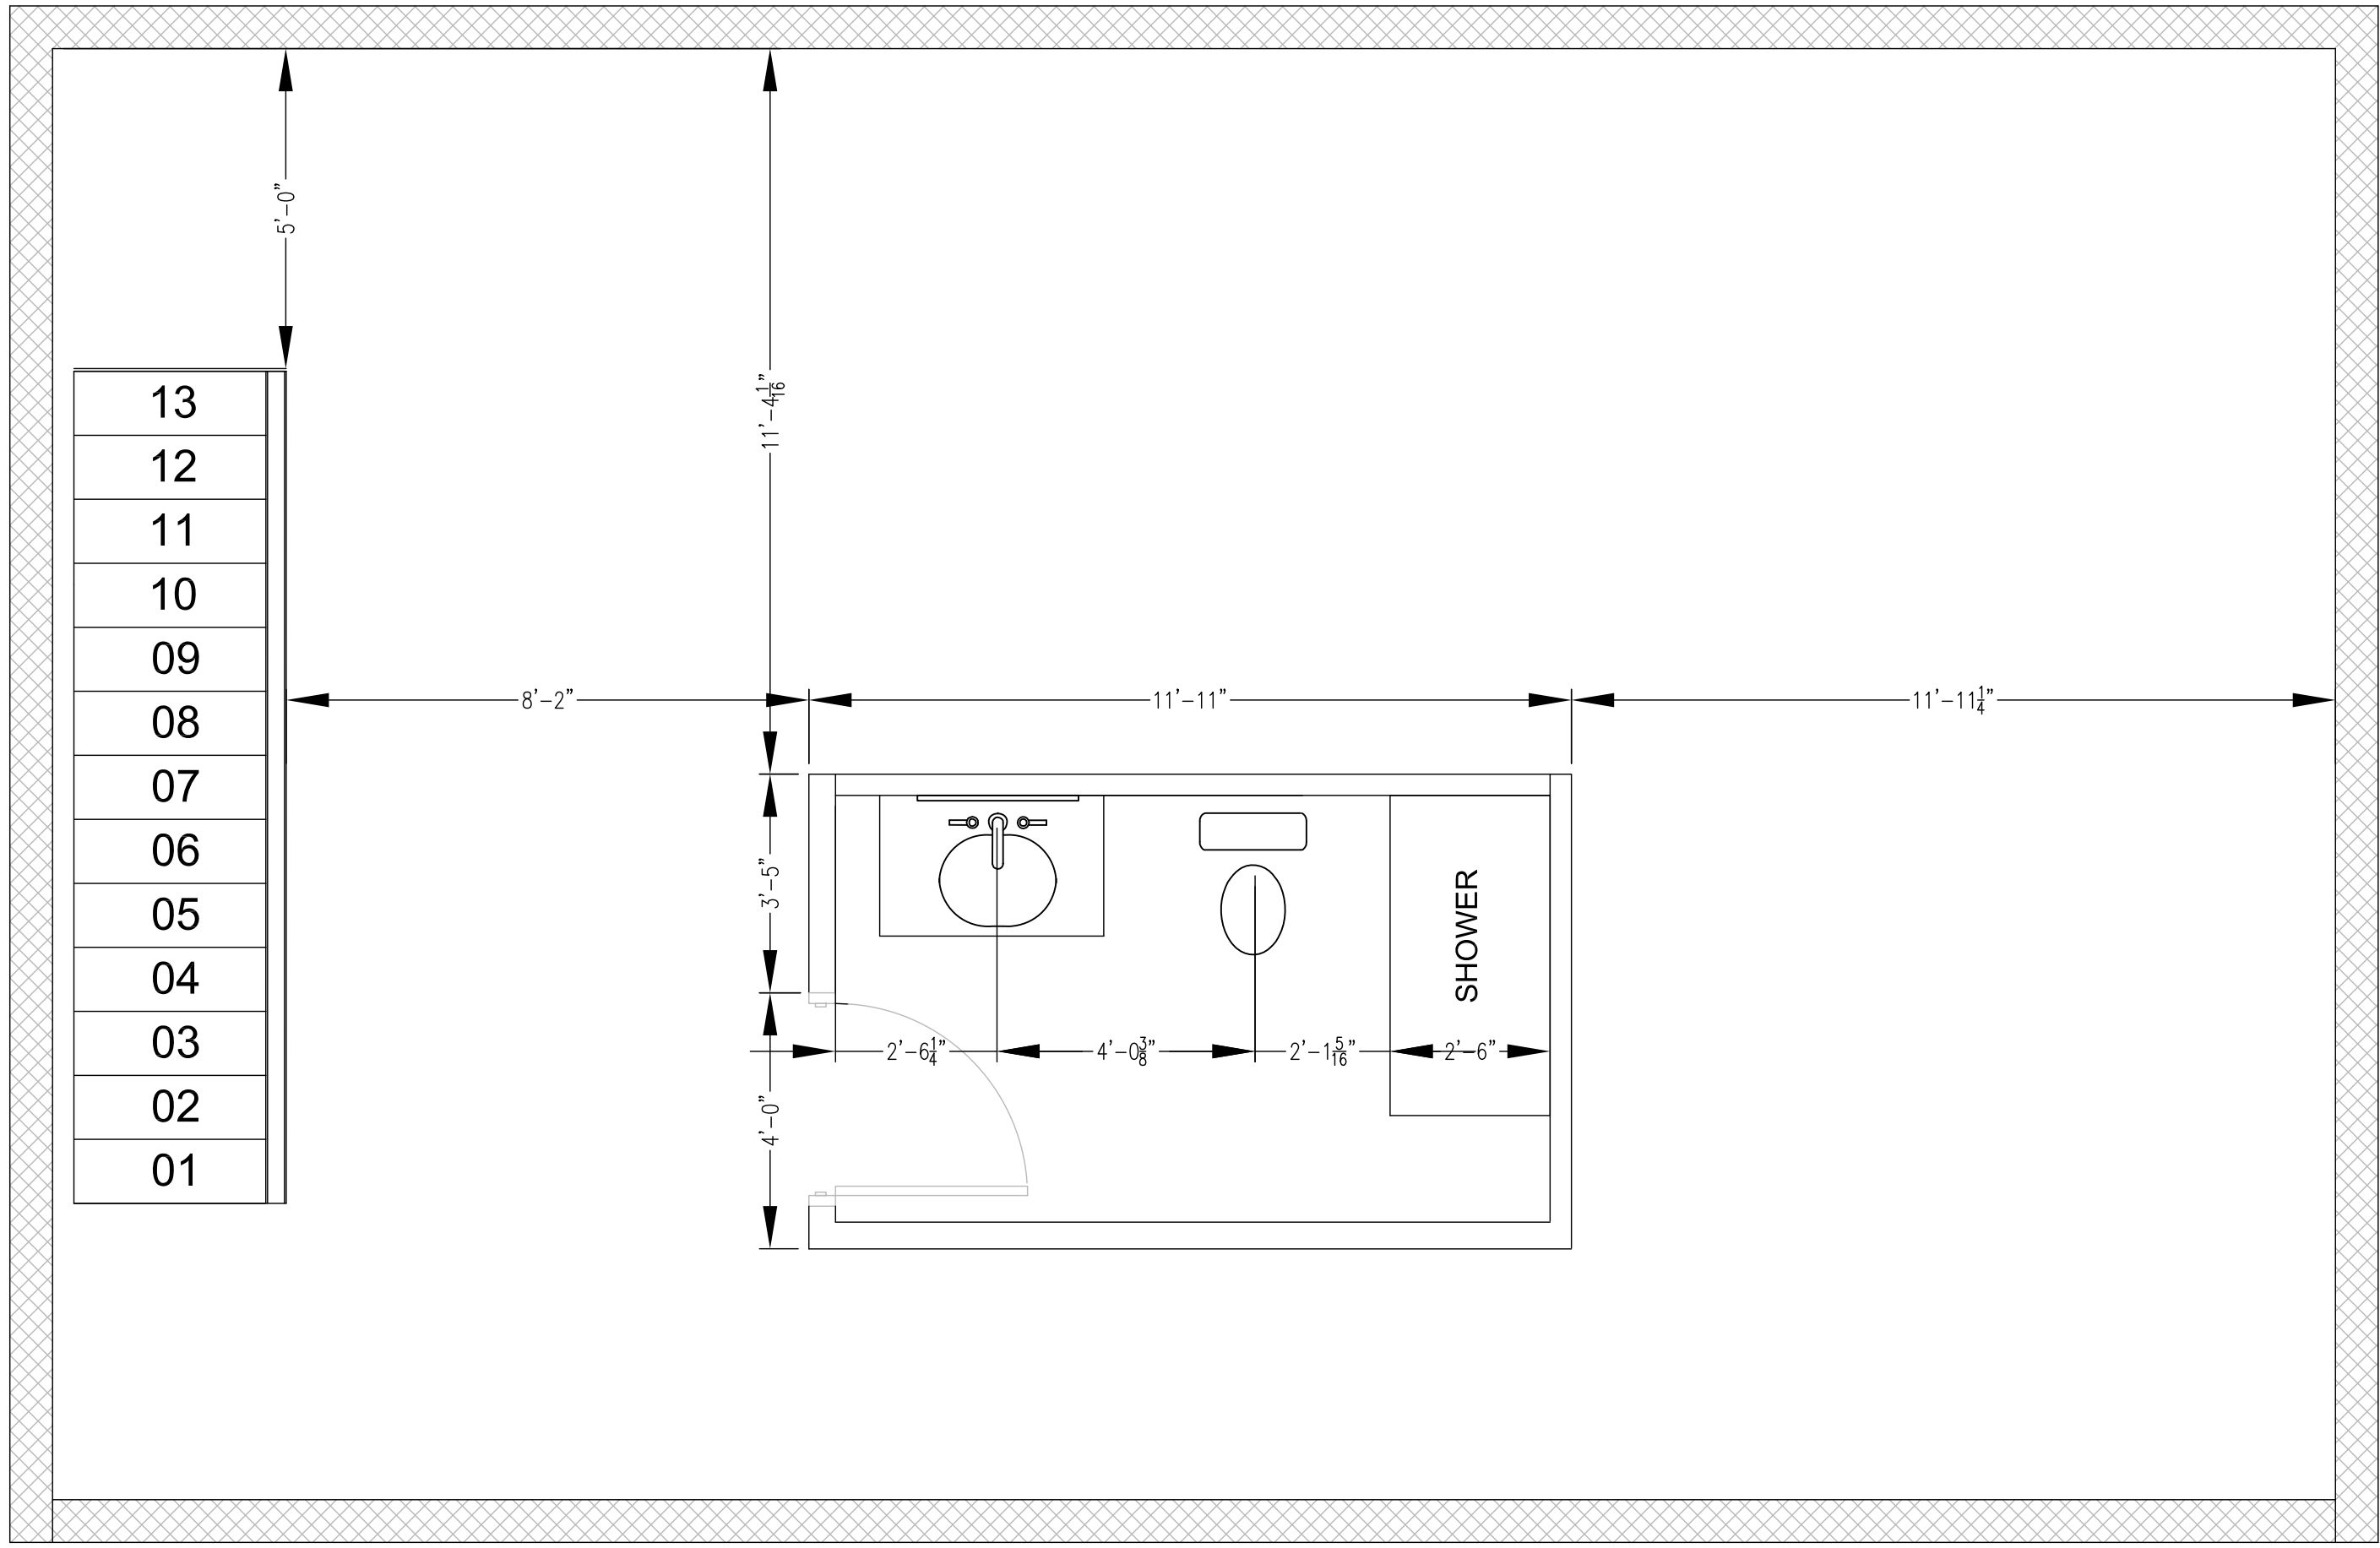


1
A-2 2ND FLOOR PLAN
SCALE: 3/8" = 1'-0"


| | |
|-------------------------------|---------|
| Designed | D-DATE |
| Drawn | DR-DATE |
| Checked | C-DATE |
| Approved | Date |
| Title | |
| ADDRESS | |
| CITY-STATE | |
| Fuquay Varina, North Carolina | |
| Sheet Title . | |
| Sheet Number. | |
| A2 | |

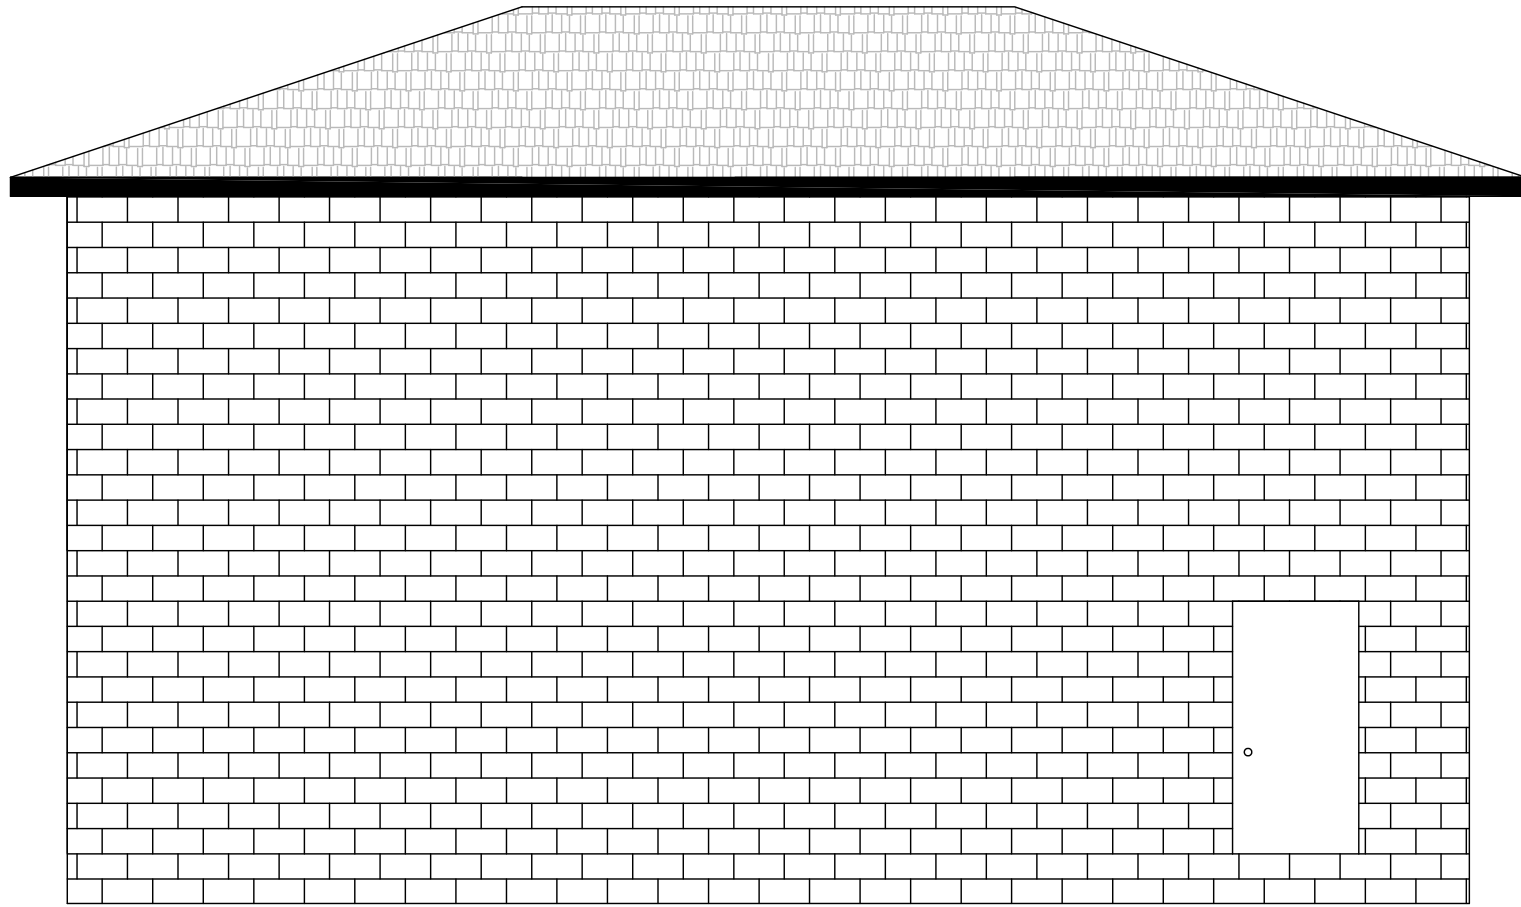


1
A-3 SIDE A ELEVATION
SCALE: 3/16" = 1'-0"

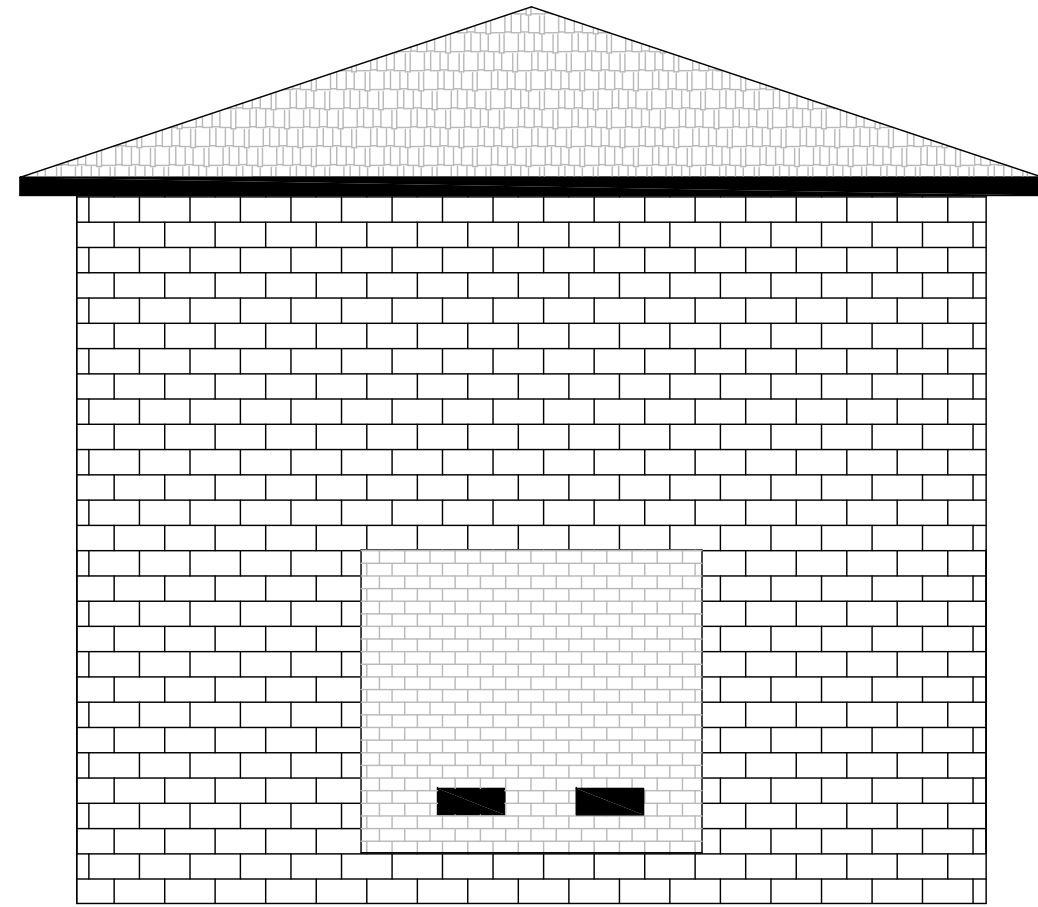

2
A-3 SIDE D ELEVATION
SCALE: 3/16" = 1'-0"

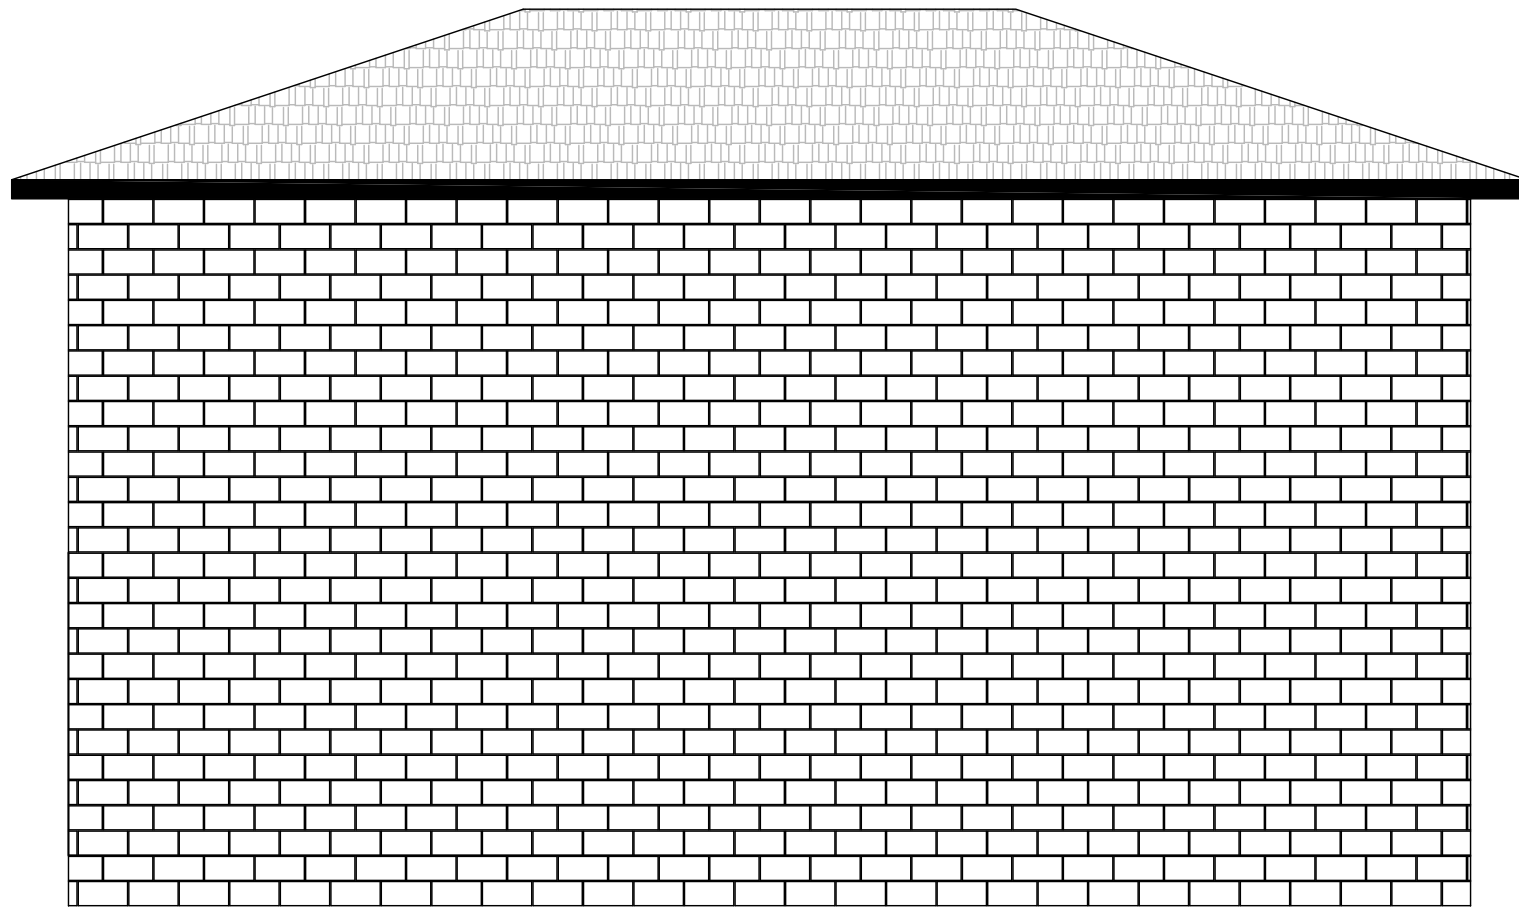

3
A-3 SIDE B ELEVATION
SCALE: 3/16" = 1'-0"

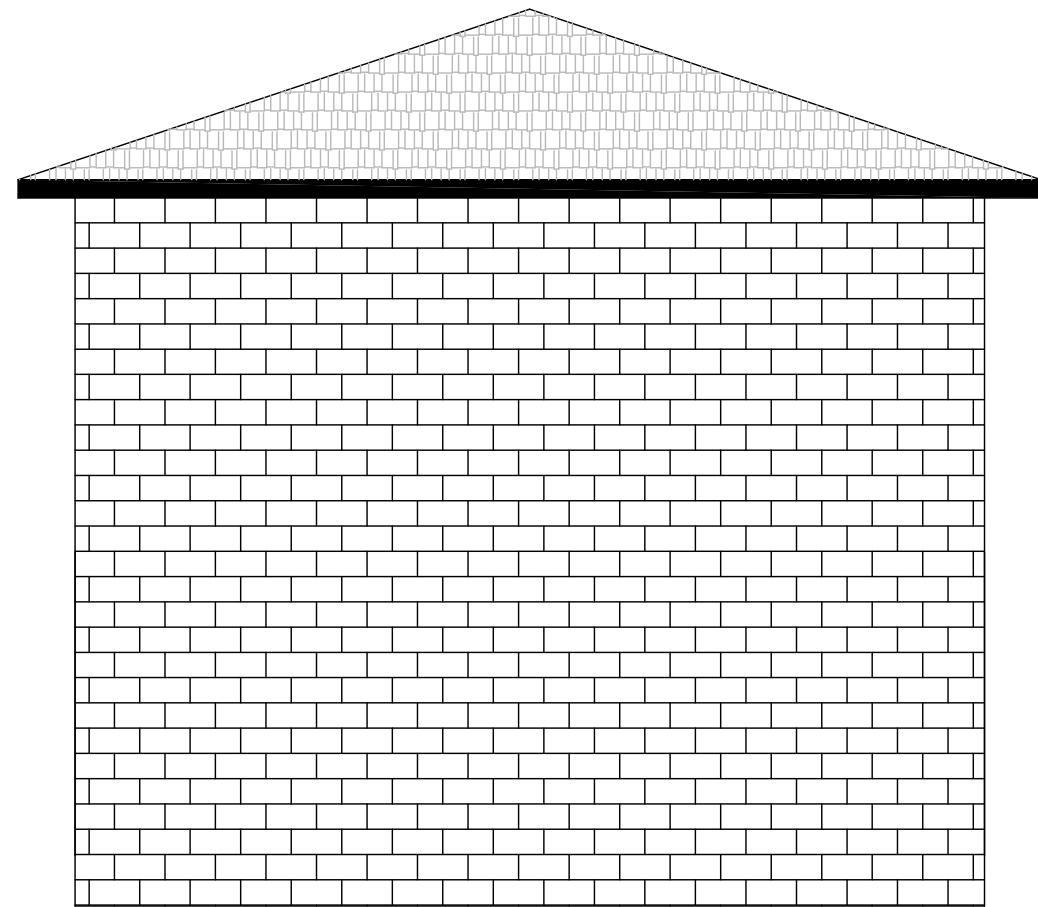

4
A-3 SIDE C ELEVATION
SCALE: 3/16" = 1'-0"


Designed _____ D-DATE _____
 Drawn _____ DR-DATE _____
 Checked _____ C-DATE _____
 Approved _____ Date _____
 Title _____

ADDRESS
 Fuquay Varina, North Carolina

Sheet Title .

Sheet Number.


A3

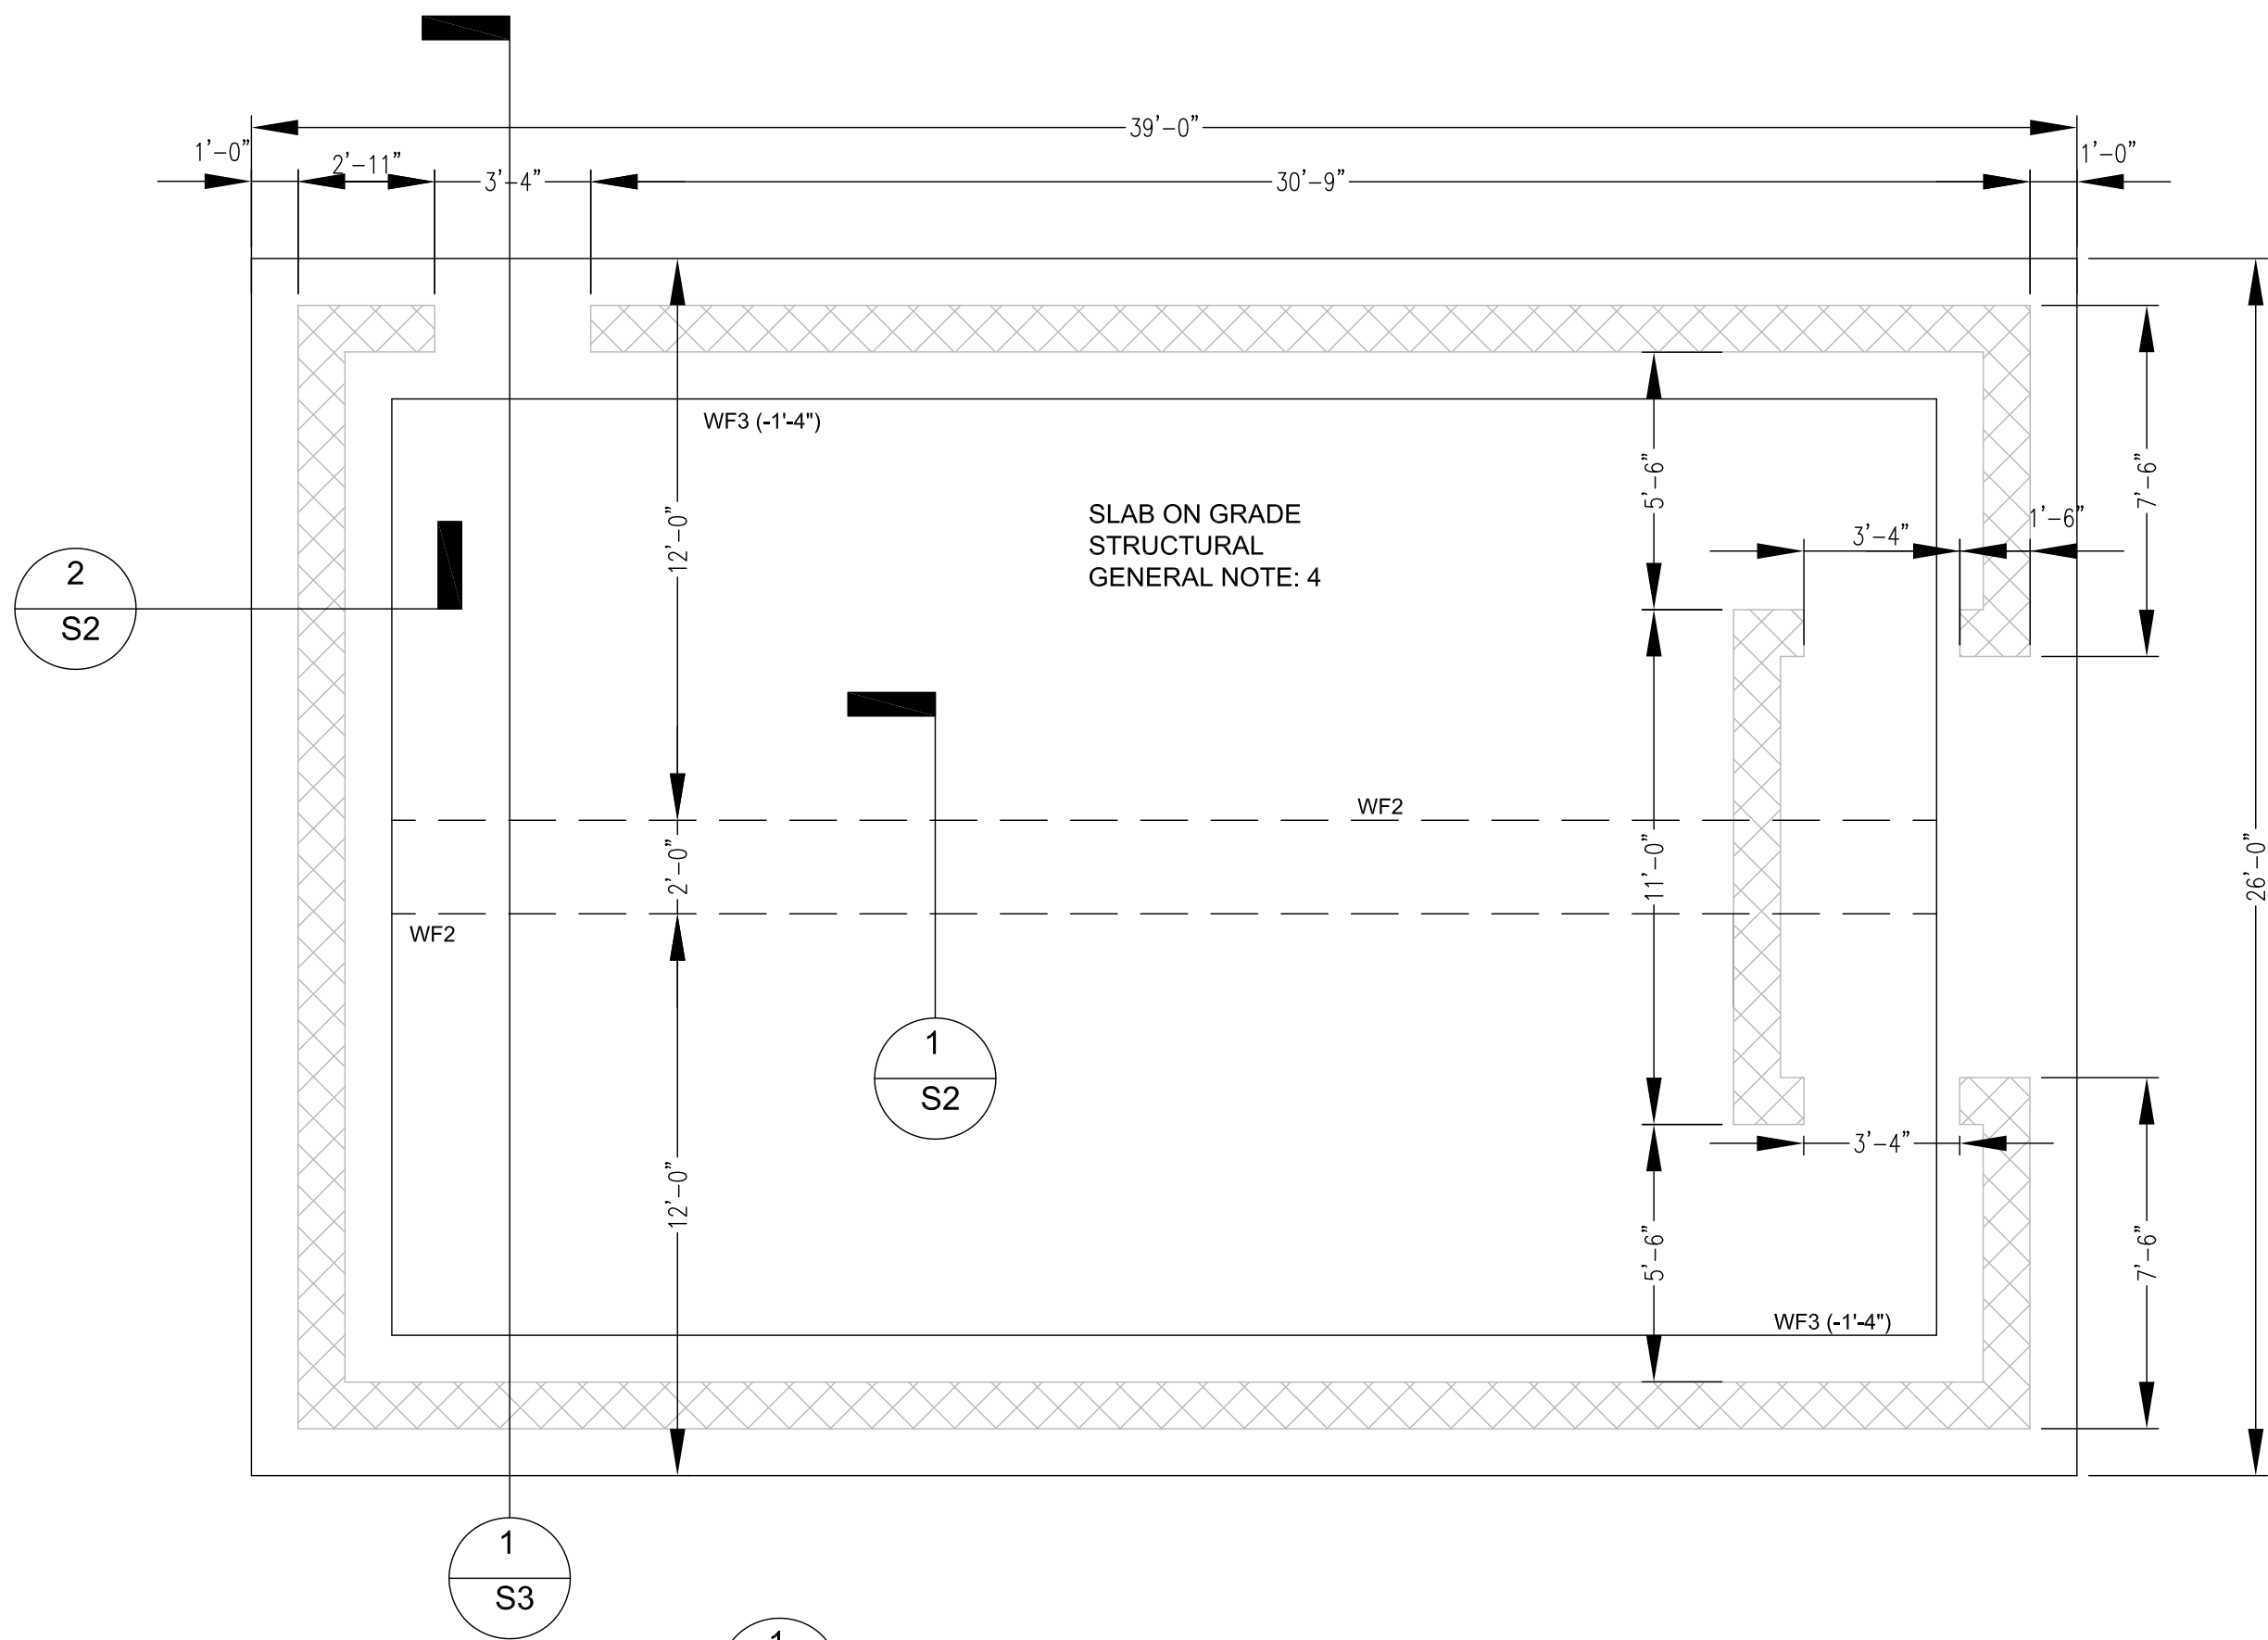

1
S3 FIRST FLOOR PLAN
SCALE: 1/4" = 1'-0"


| | |
|-------------------------------|---------|
| Designed | D-DATE |
| Drawn | DR-DATE |
| Checked | C-DATE |
| Approved | Date |
| Title | |
| ADDRESS | |
| CITY-STATE | |
| Fuquay Varina, North Carolina | |
| Sheet Title . | |
| Sheet Number. | |
| S1 | |

WF3

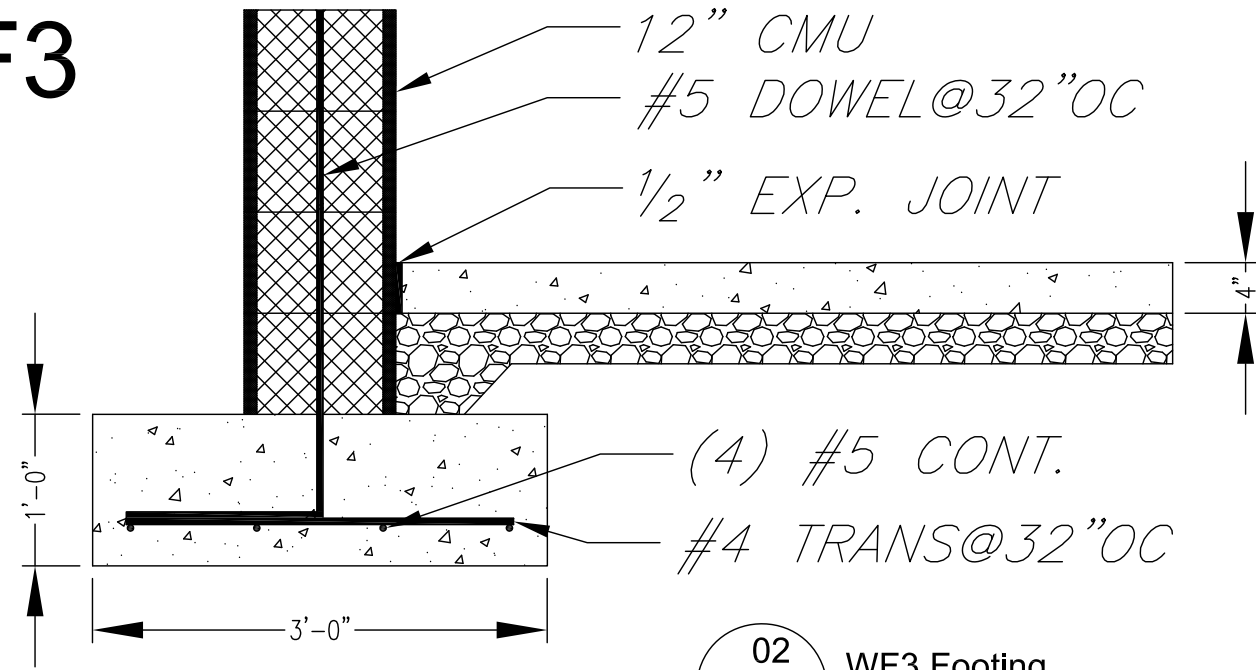


02 WF3 Footing
S2 SCALE: 3/4" = 1'-0"


WF2

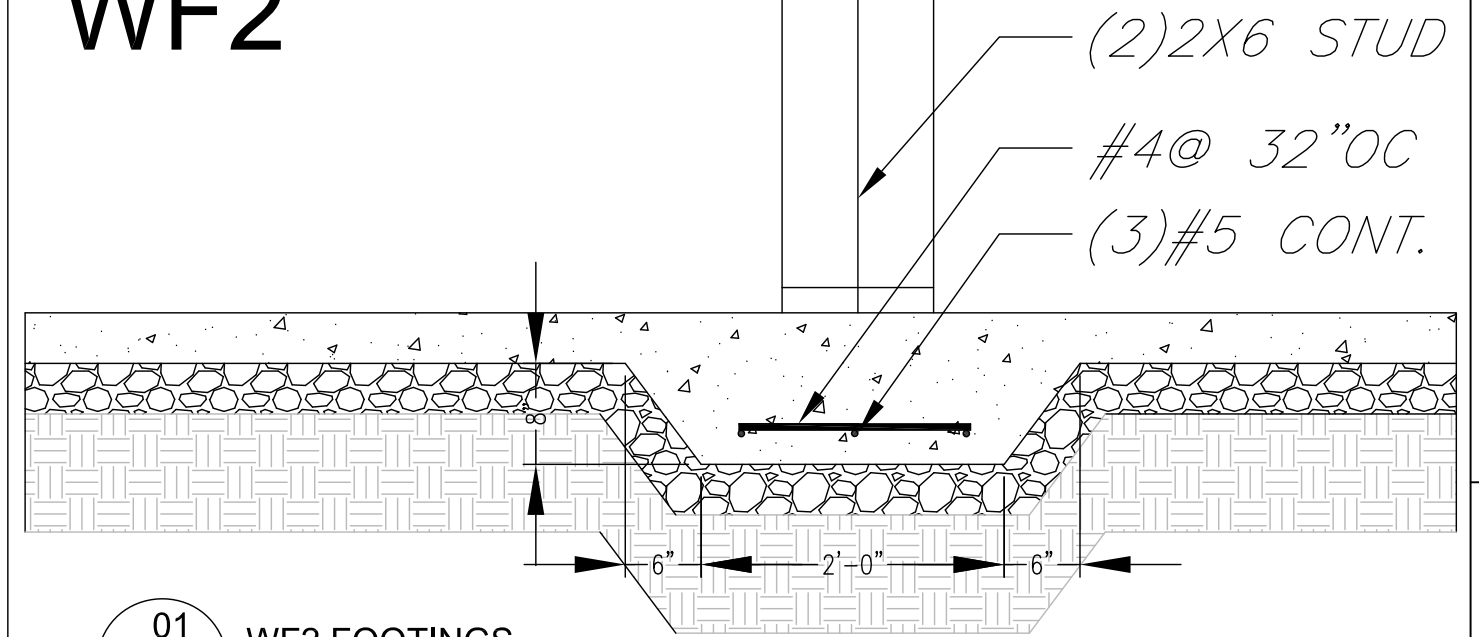


01 WF2 FOOTINGS
S2 SCALE: 3/4" = 1'-0"

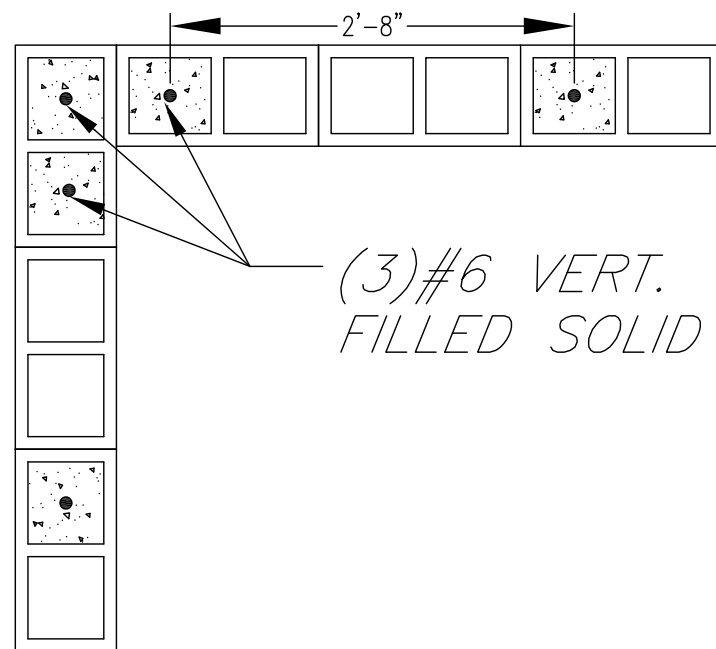

03 CMU CORNER DETAIL
S2 SCALE: 3/4" = 1'-0"

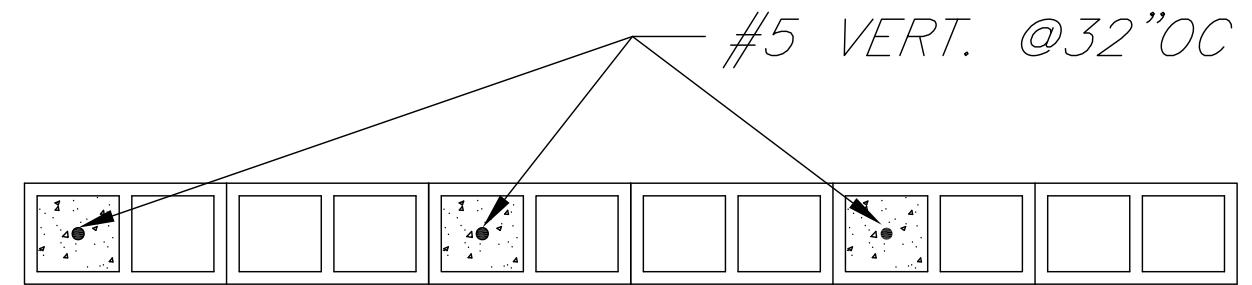

04 CONT. CMU WALL DETAIL
S2 SCALE: 3/4" = 1'-0"

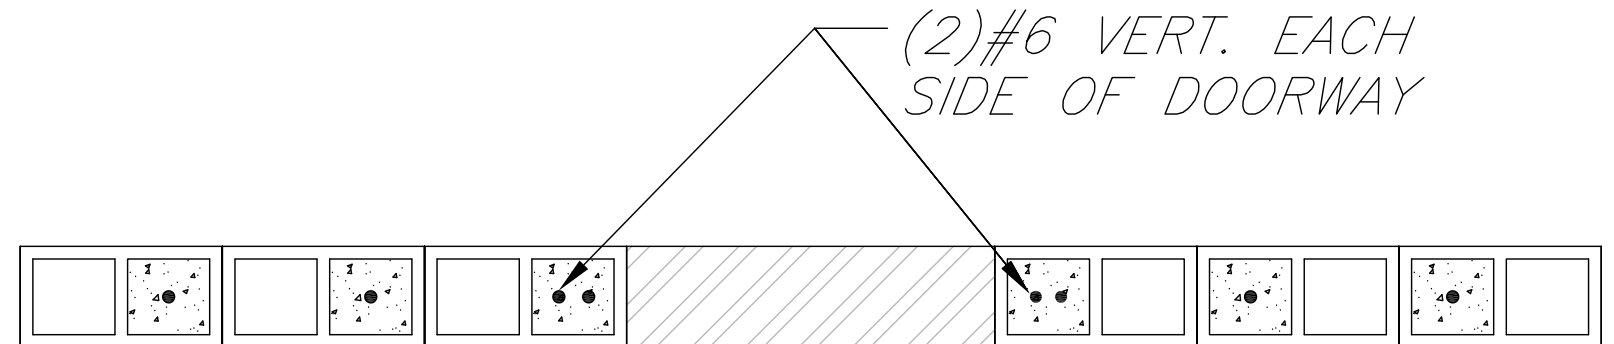

05 CMU DOOR WAY DETAIL
S2 SCALE: 3/4" = 1'-0"


Designed _____
Drawn _____
Checked _____
Approved _____
Title _____

ADDRESS _____
CITY-STATE _____
Fuquay Varina, North Carolina

Sheet Title .

Sheet Number.

S2

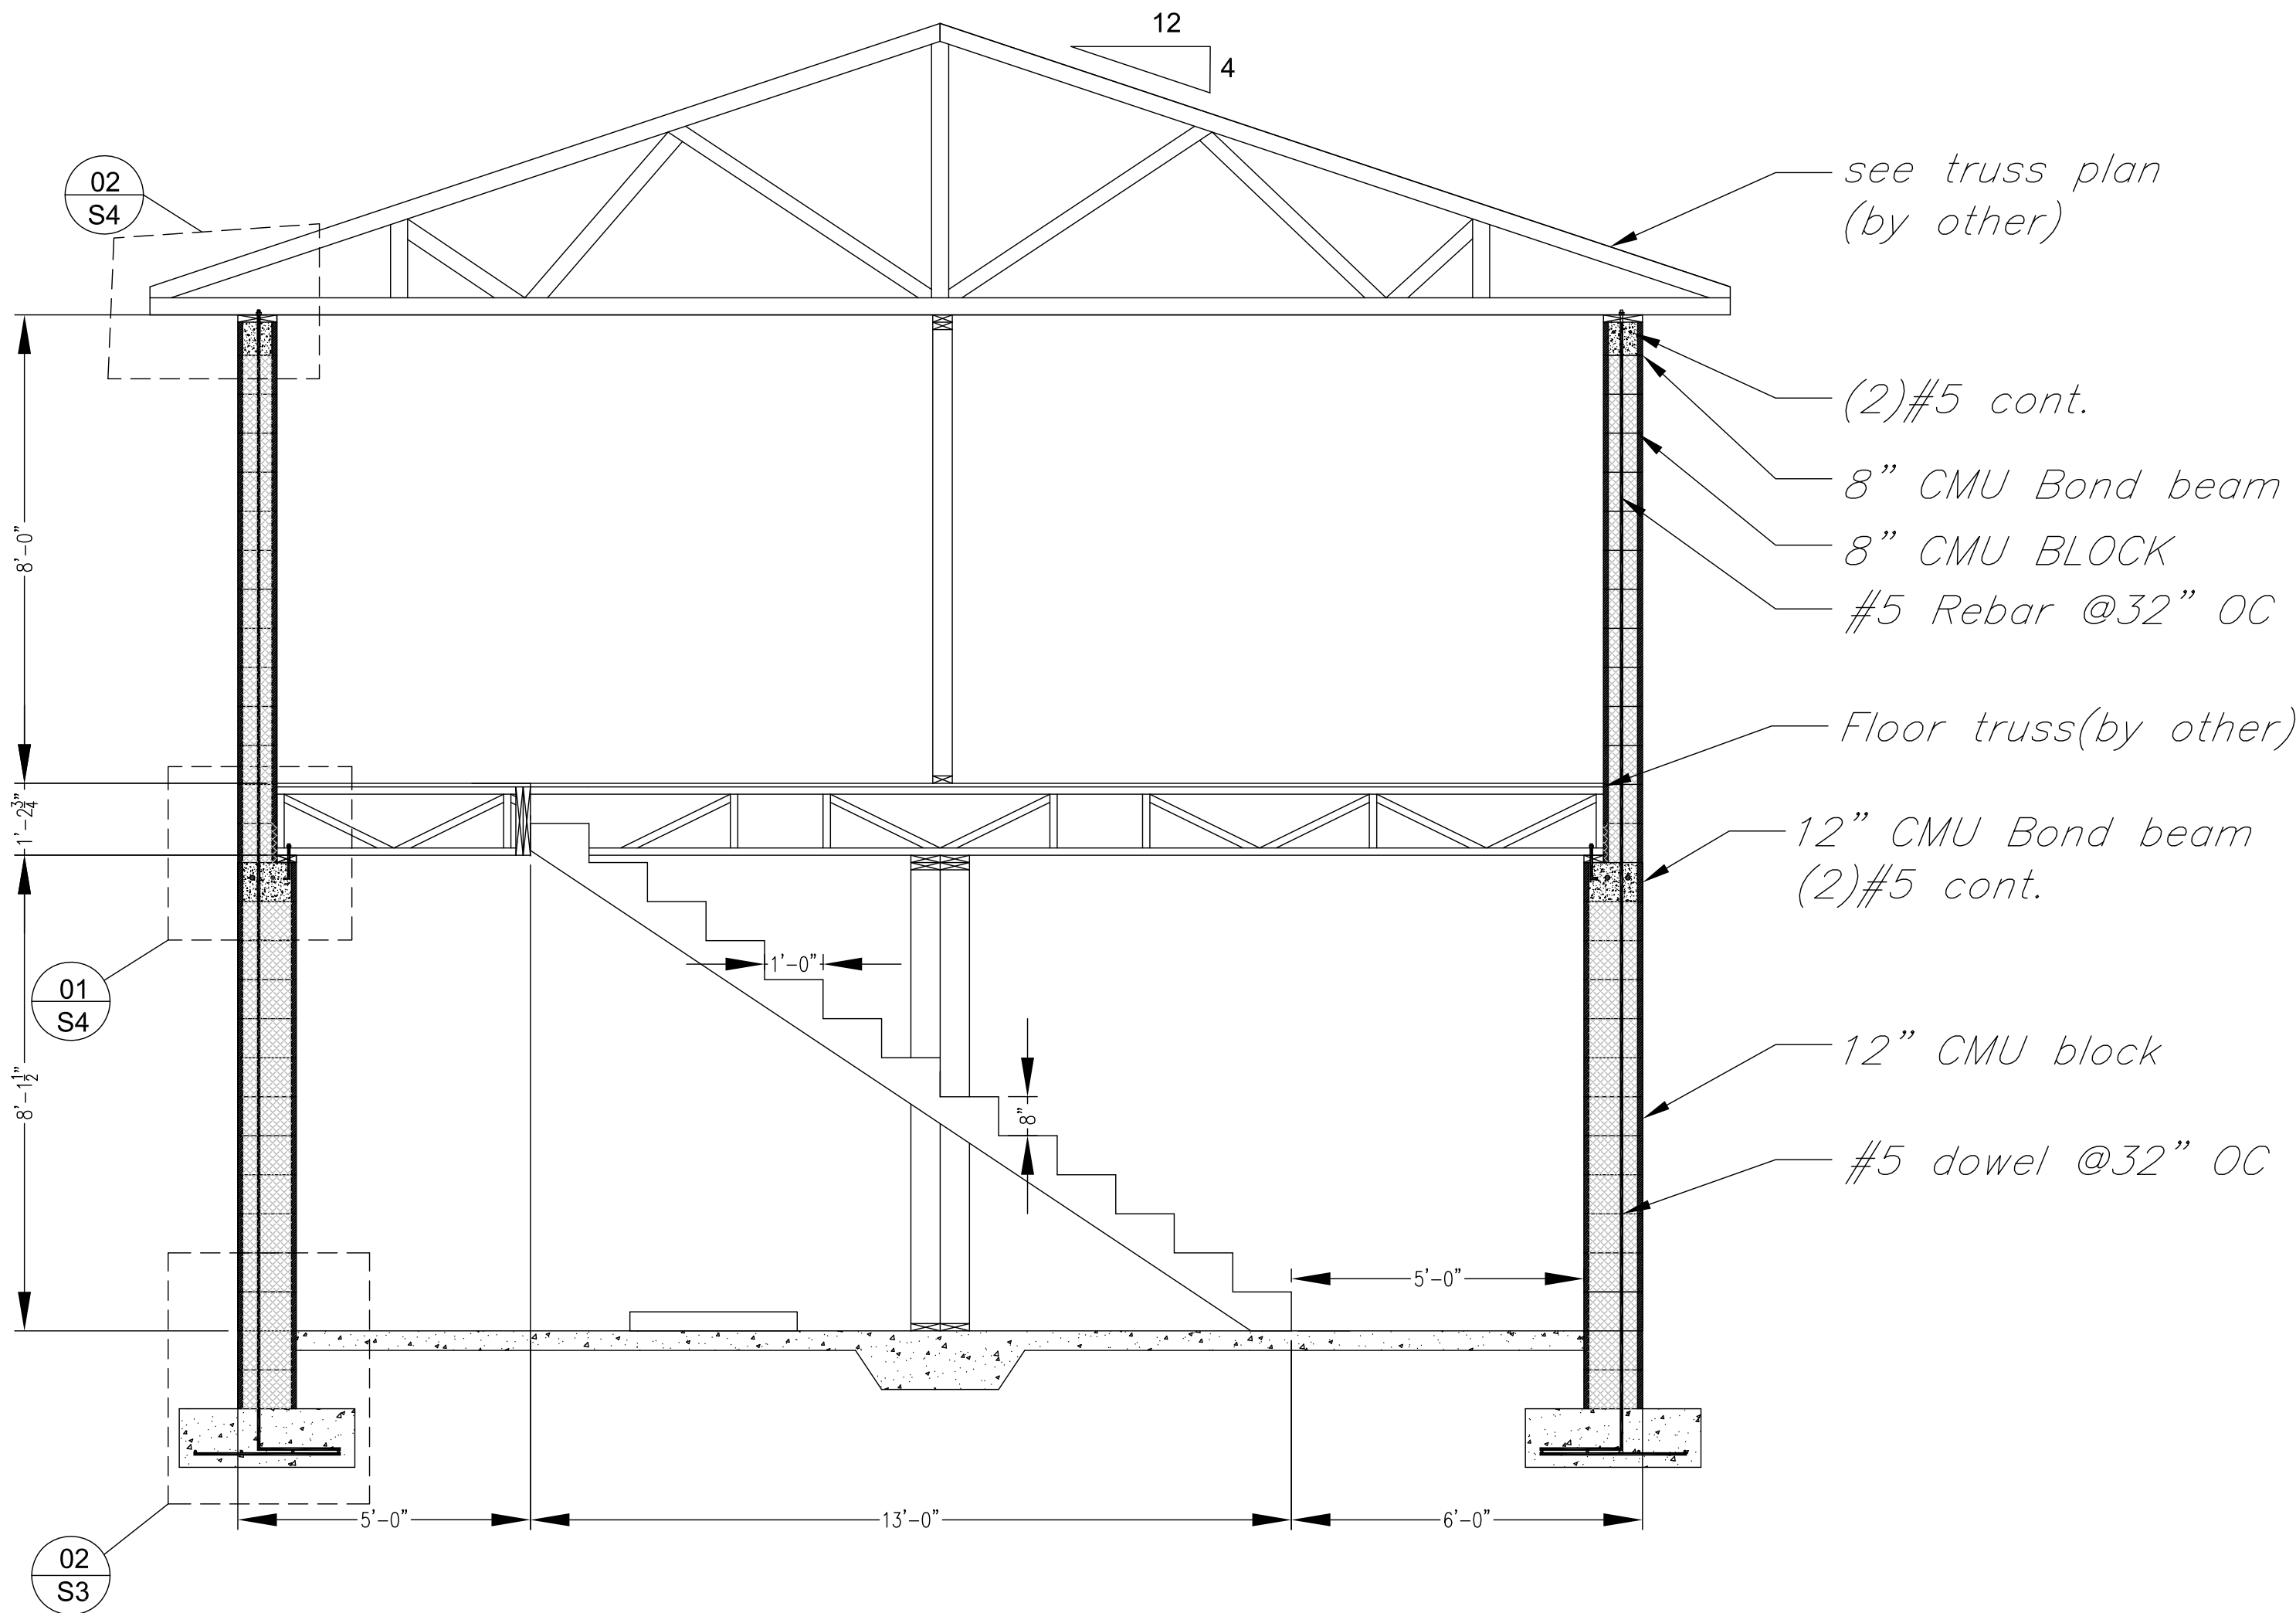

*see truss plan
(by other)*

(2)#5 cont.

8" CMU Bond beam

8" CMU BLOCK

#5 Rebar @32" OC



Floor truss(by other)

*12" CMU Bond beam
(2)#5 cont.*

12" CMU block

#5 dowel @32" OC

| | |
|-------------------------------|---------|
| Designed | D-DATE |
| Drawn | DR-DATE |
| Checked | C-DATE |
| Approved | Date |
| Title | |
| ADDRESS | |
| CITY-STATE | |
| Fuquay Varina, North Carolina | |
| Sheet Title . | |
| Sheet Number. | |
| S3 | |

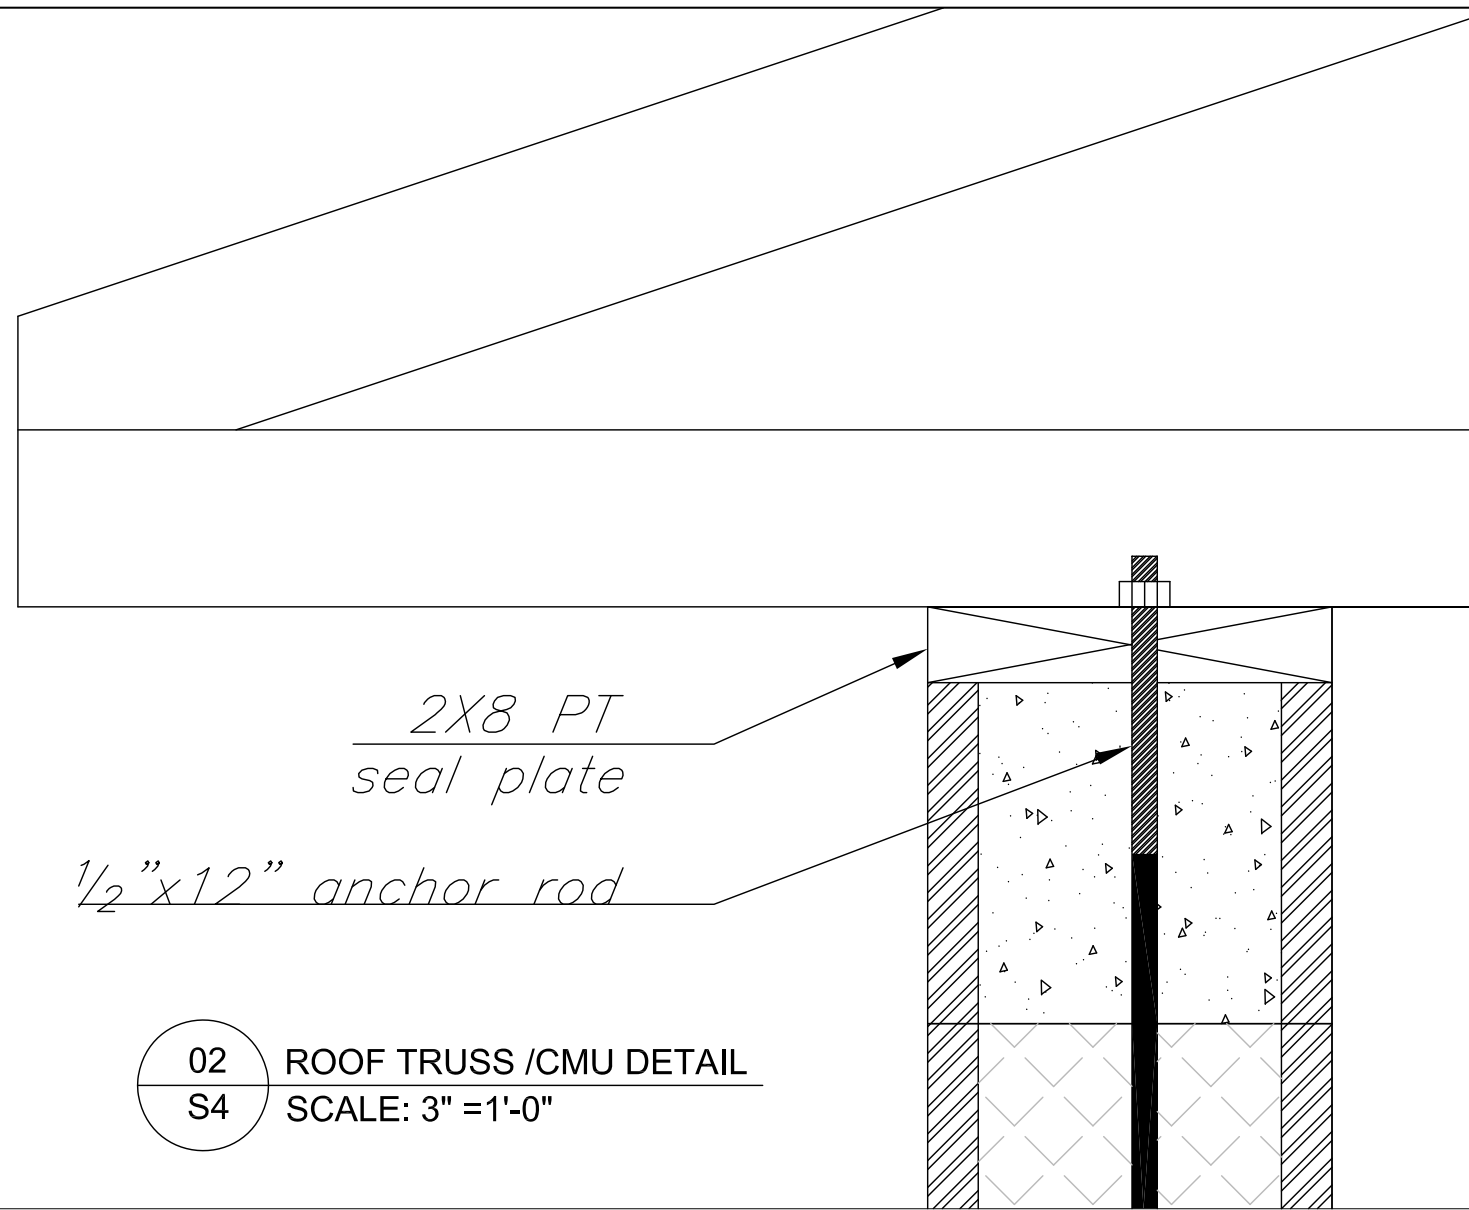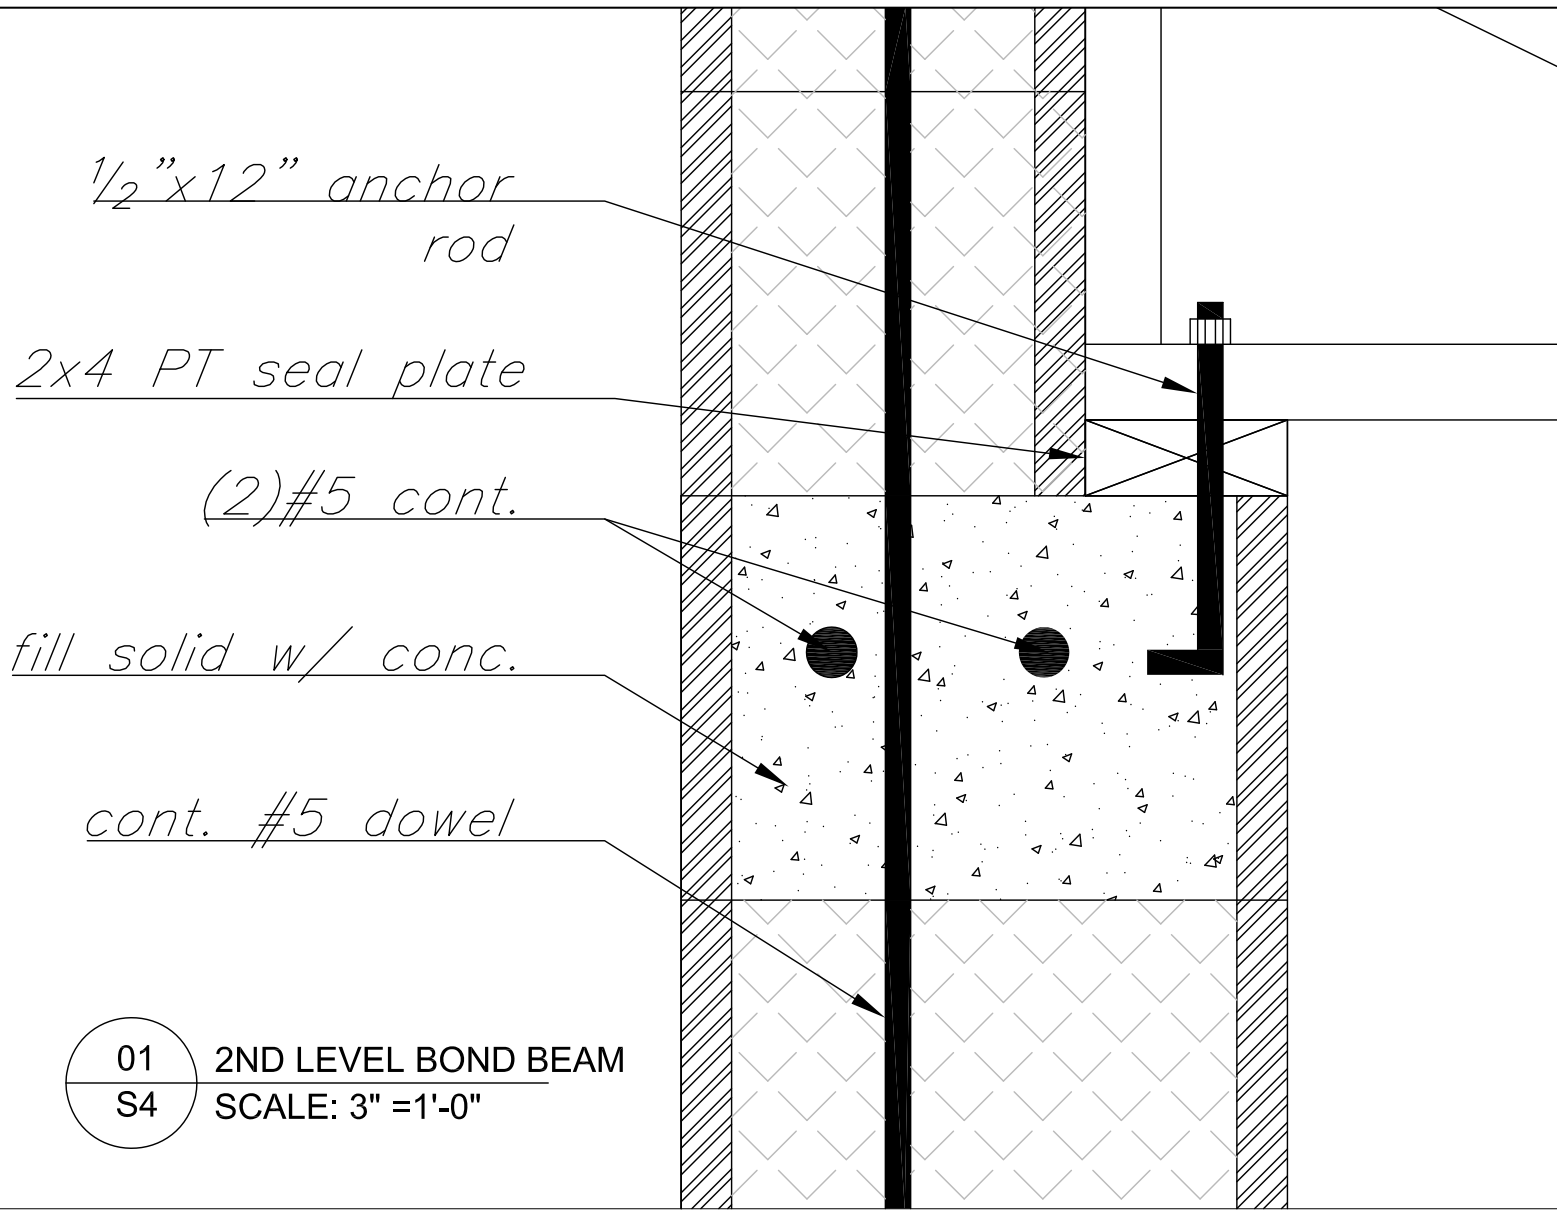


| | |
|----------|---------|
| Designed | D-DATE |
| Drawn | DR-DATE |
| Checked | C-DATE |
| Approved | Date |
| Title | |

ADDRESS
CITY-STATE
Fuquay Varina, North Carolina

Sheet Title .

Sheet Number.

S4

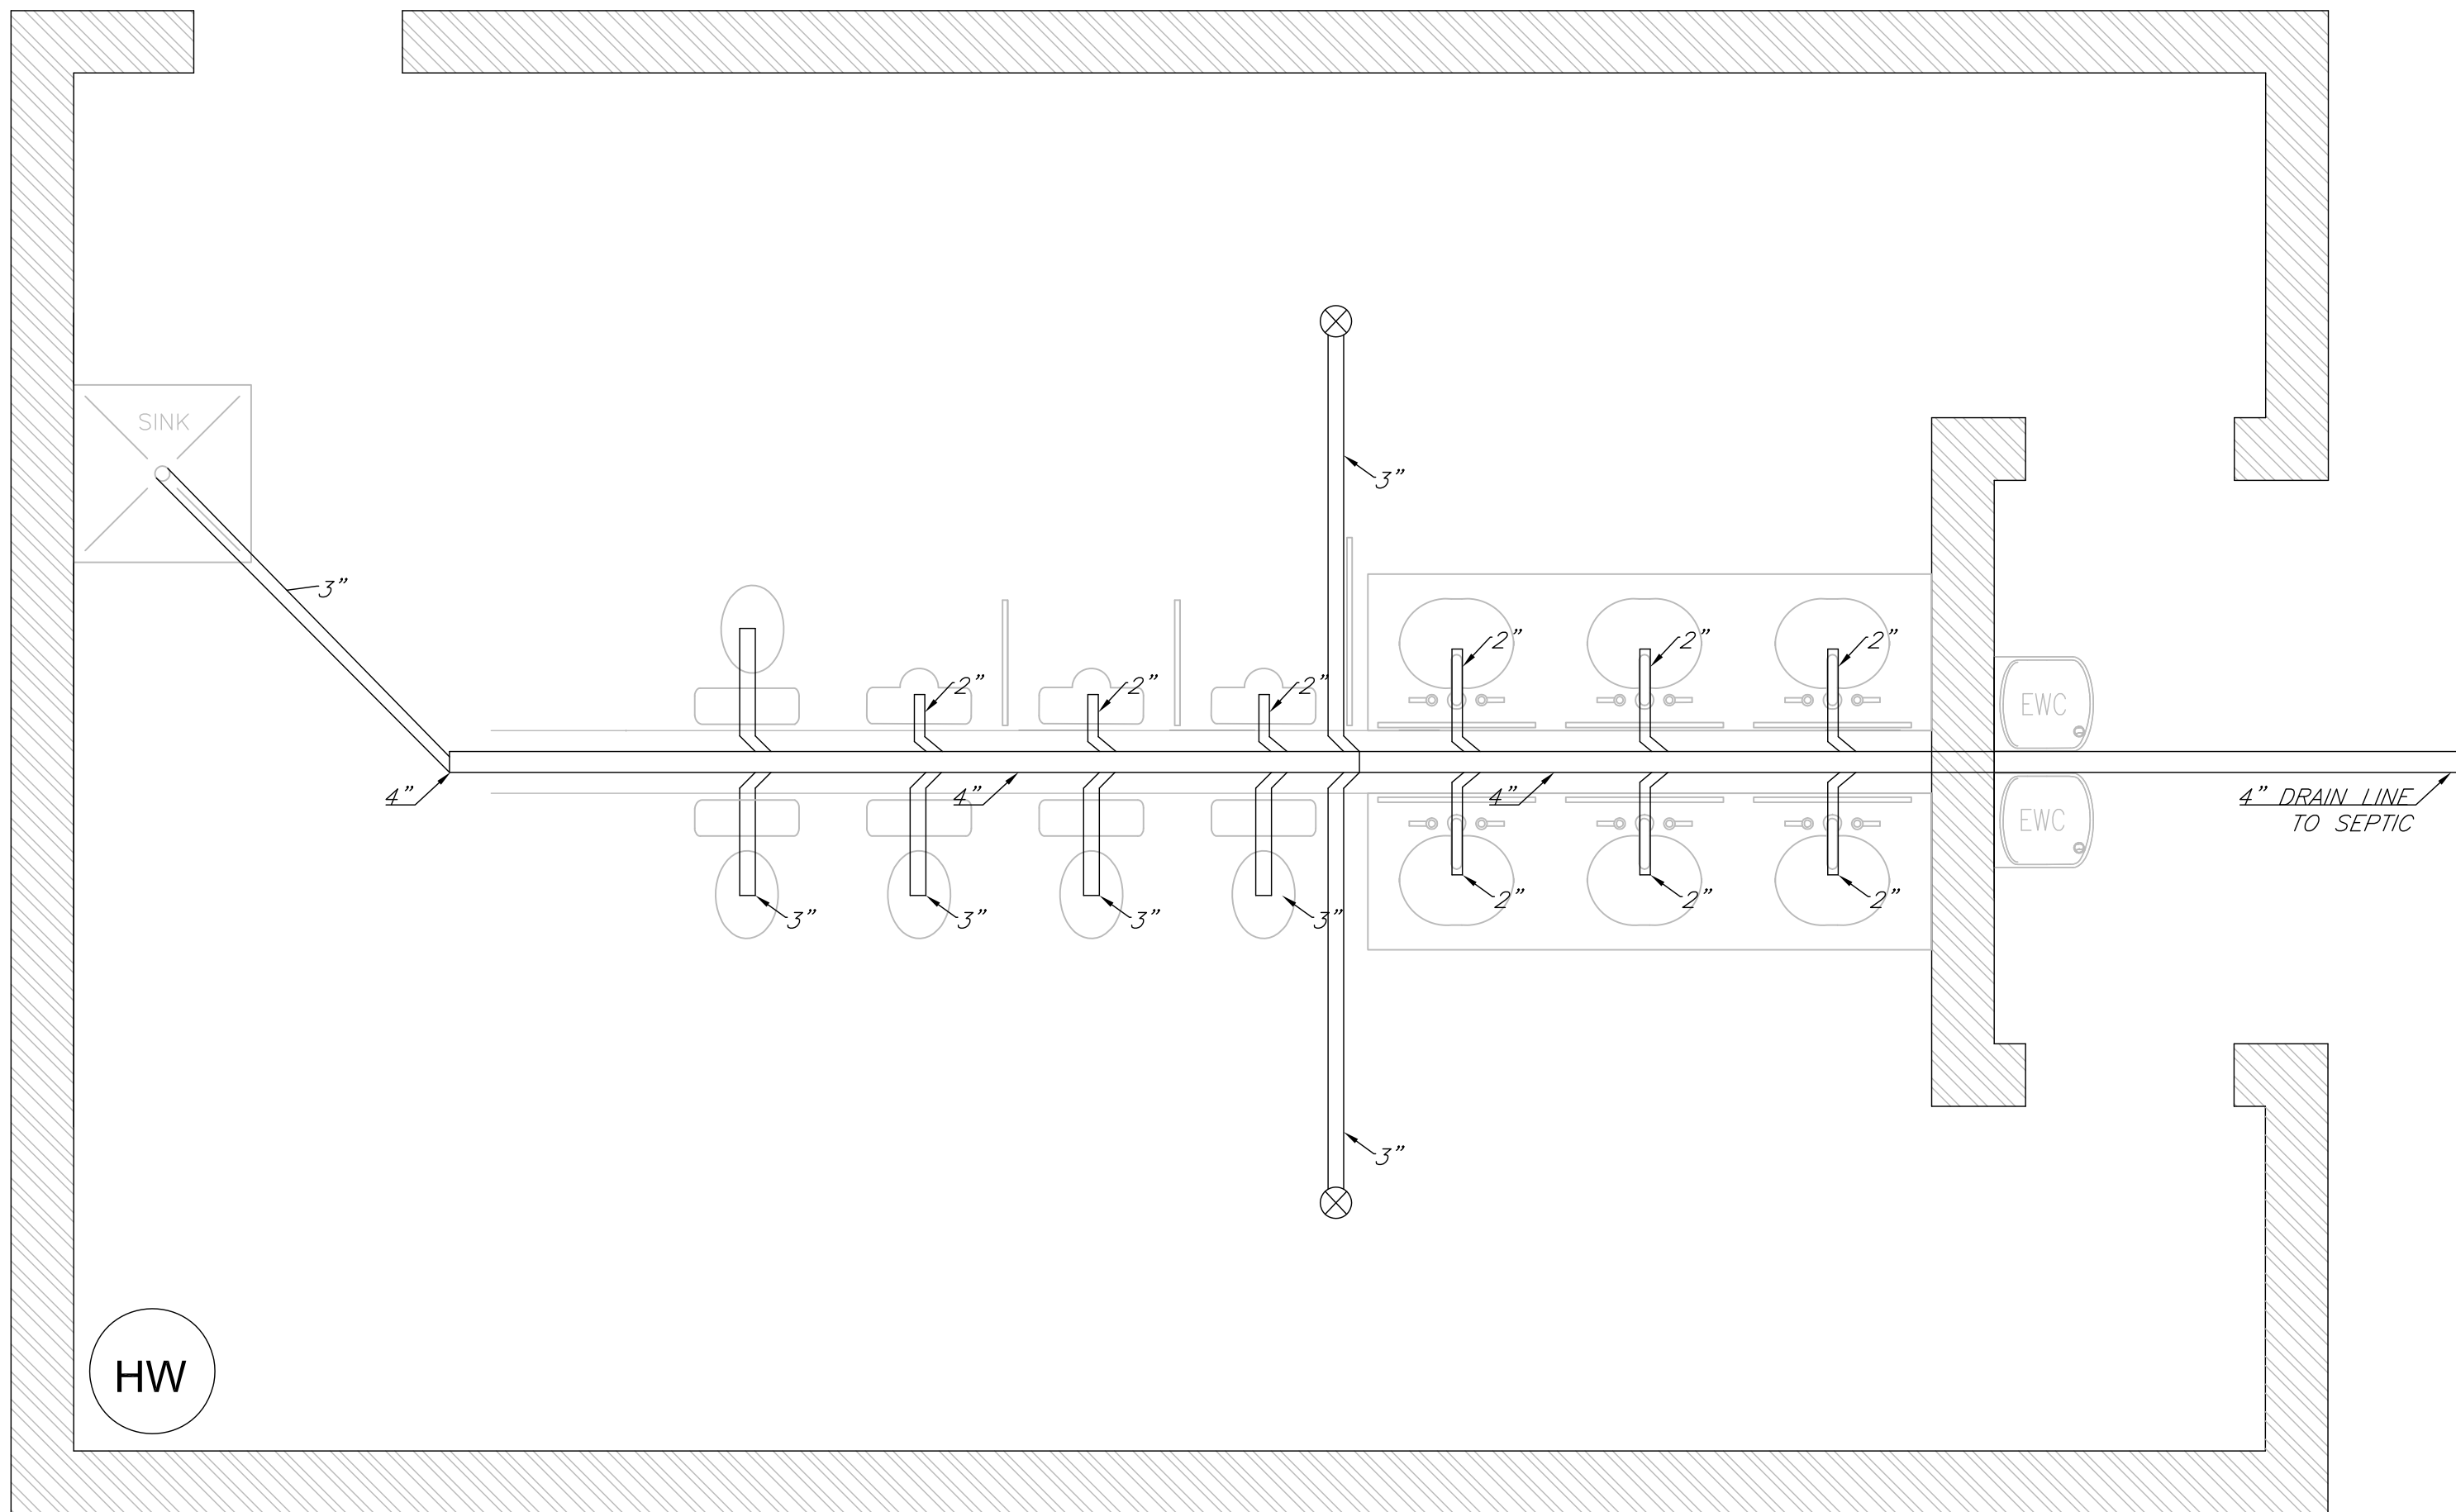

SINK

HW


EWC

EWC

4" DRAIN LINE TO SEPTIC


01 PLUMBING DRAINAGE
 P1 SCALE: 3/8" = 1'-0"

| | |
|-------------------------------|---------|
| Designed | D-DATE |
| Drawn | DR-DATE |
| Checked | C-DATE |
| Approved | Date |
| Title | |
| ADDRESS | |
| CITY-STATE | |
| Fuquay Varina, North Carolina | |
| Sheet Title . | |
| Sheet Number. | |
| P1 | |

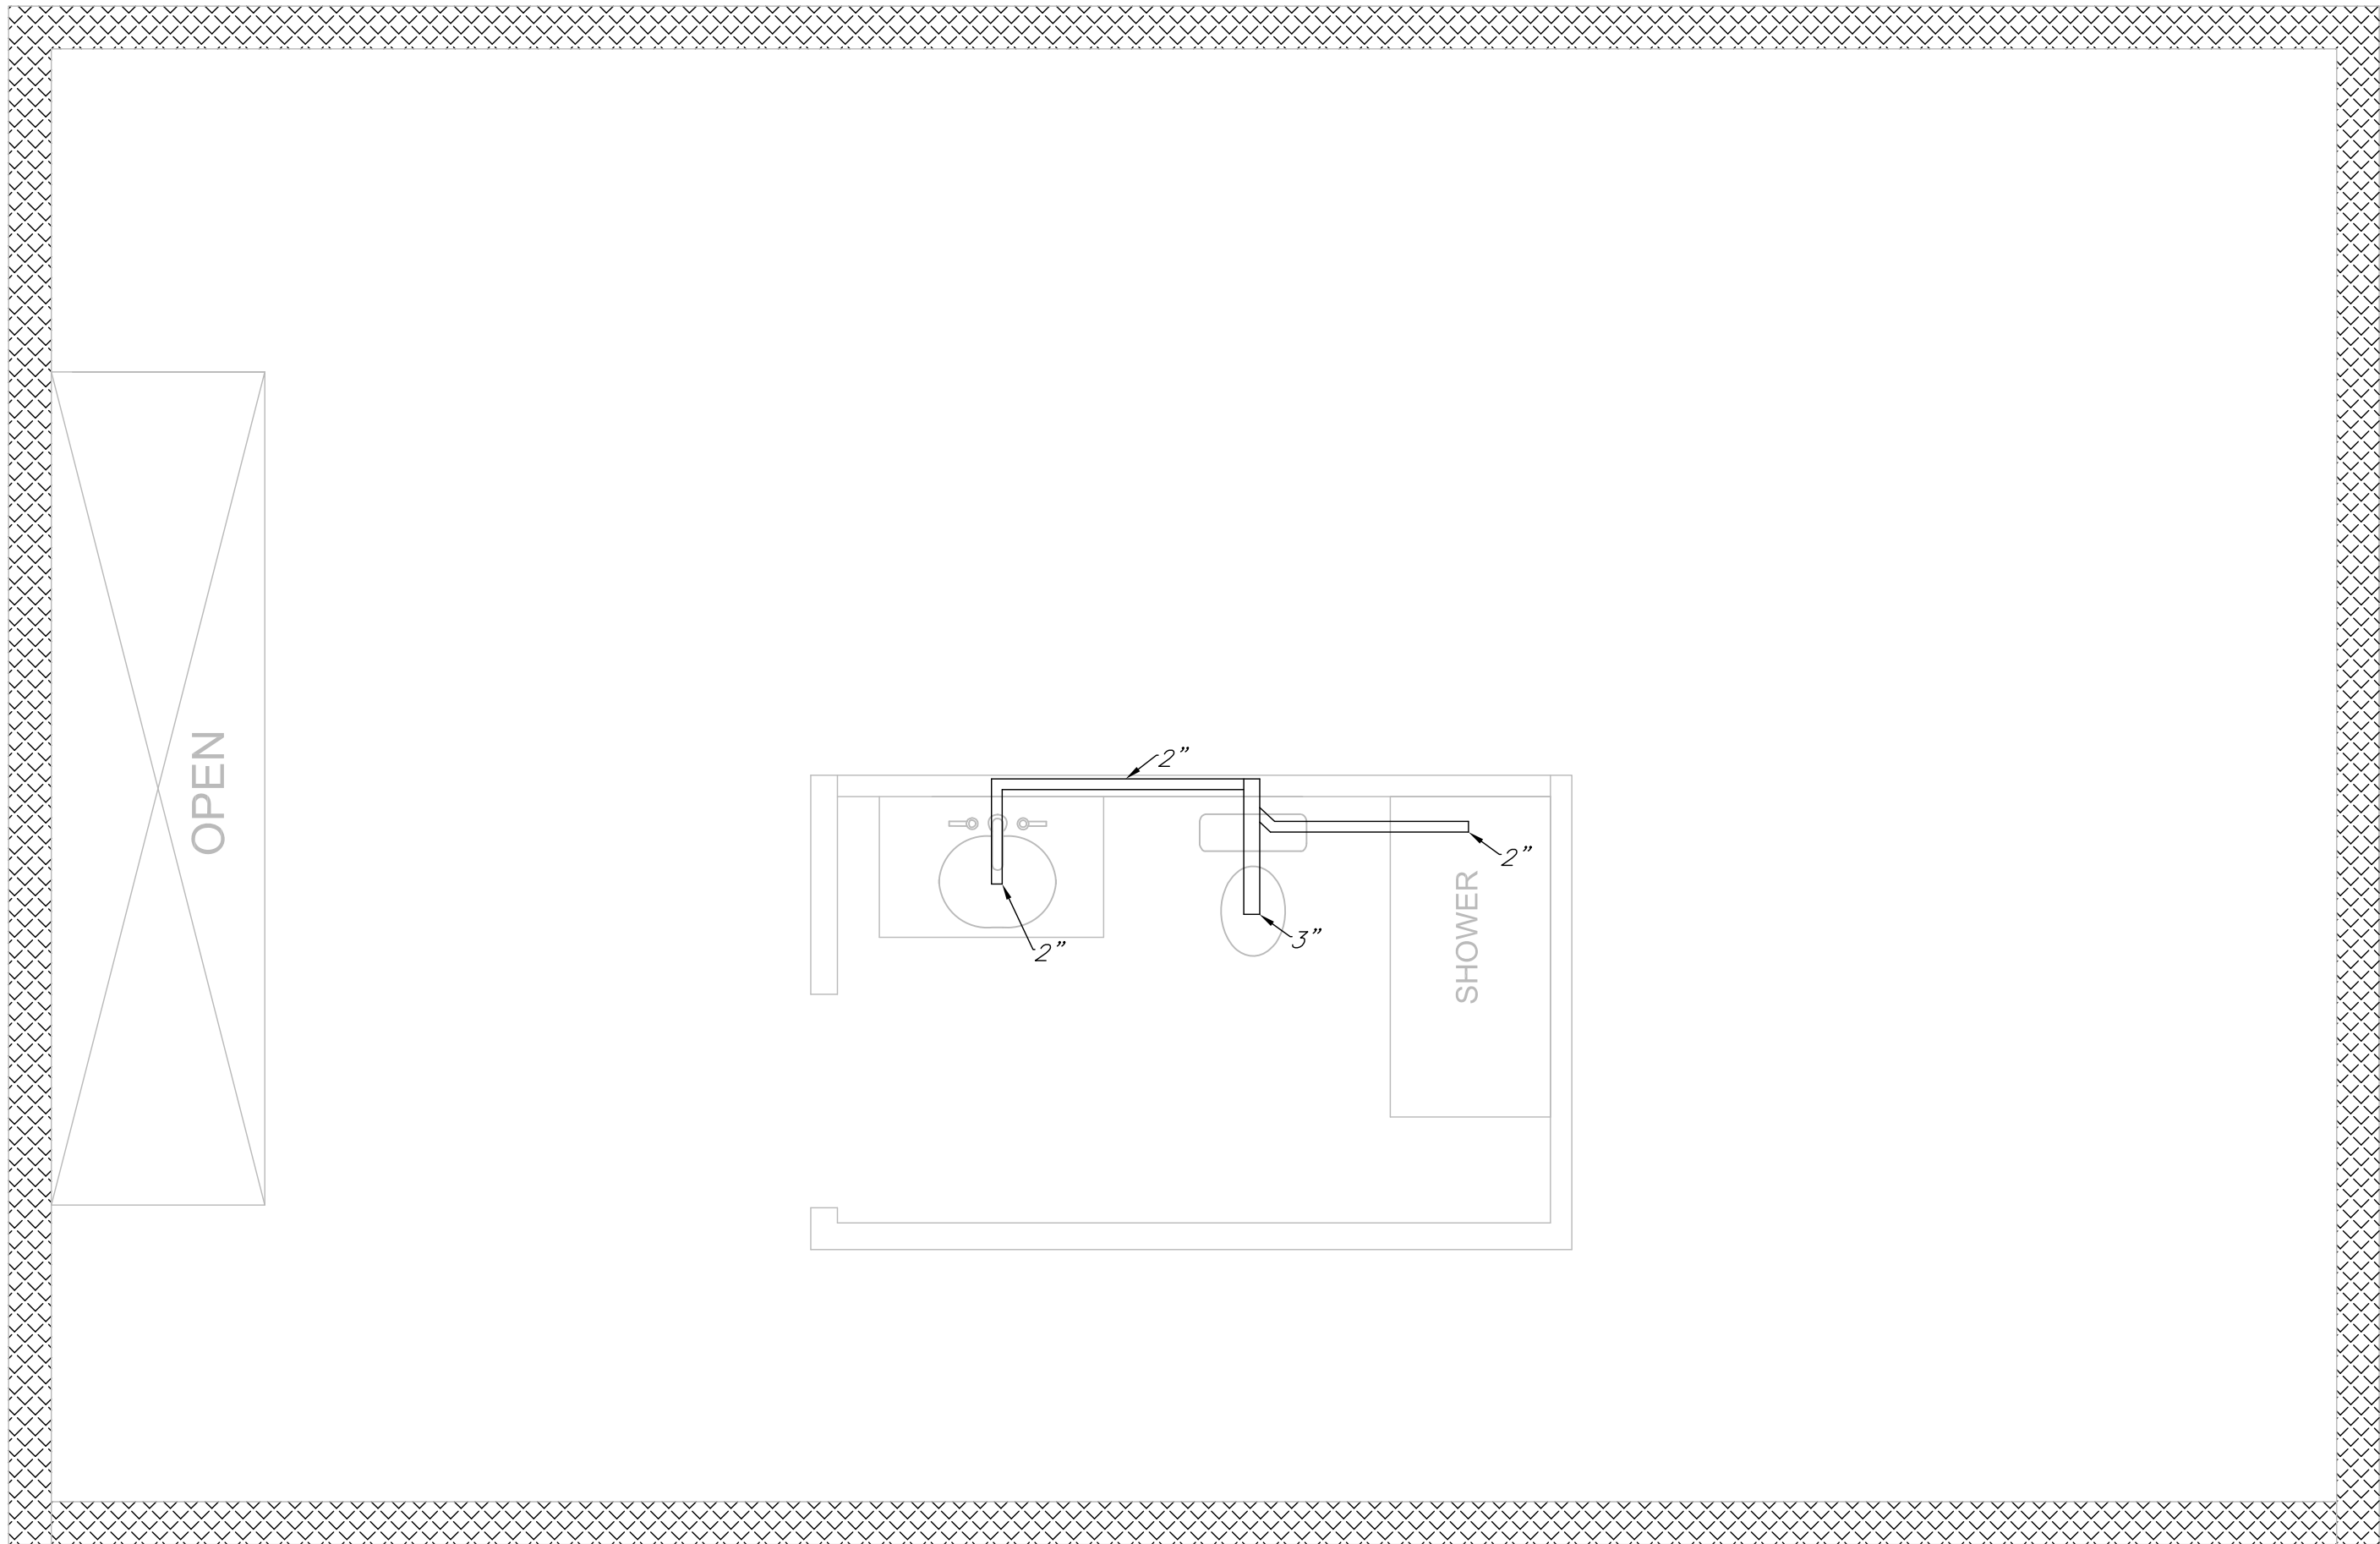


01 2ND FLOOR PLUMBING DRAINAGE
 P2 SCALE: 3/8" = 1'-0"

| | |
|-------------------------------|-----------|
| Designed | D-DATE |
| Drawn | DR-DATE |
| Checked | C-DATE |
| Approved | Date |
| Title | |
| ADDRESS | |
| CITY-STATE | |
| Fuquay Varina, North Carolina | |
| Sheet Title | |
| Sheet Number | P2 |

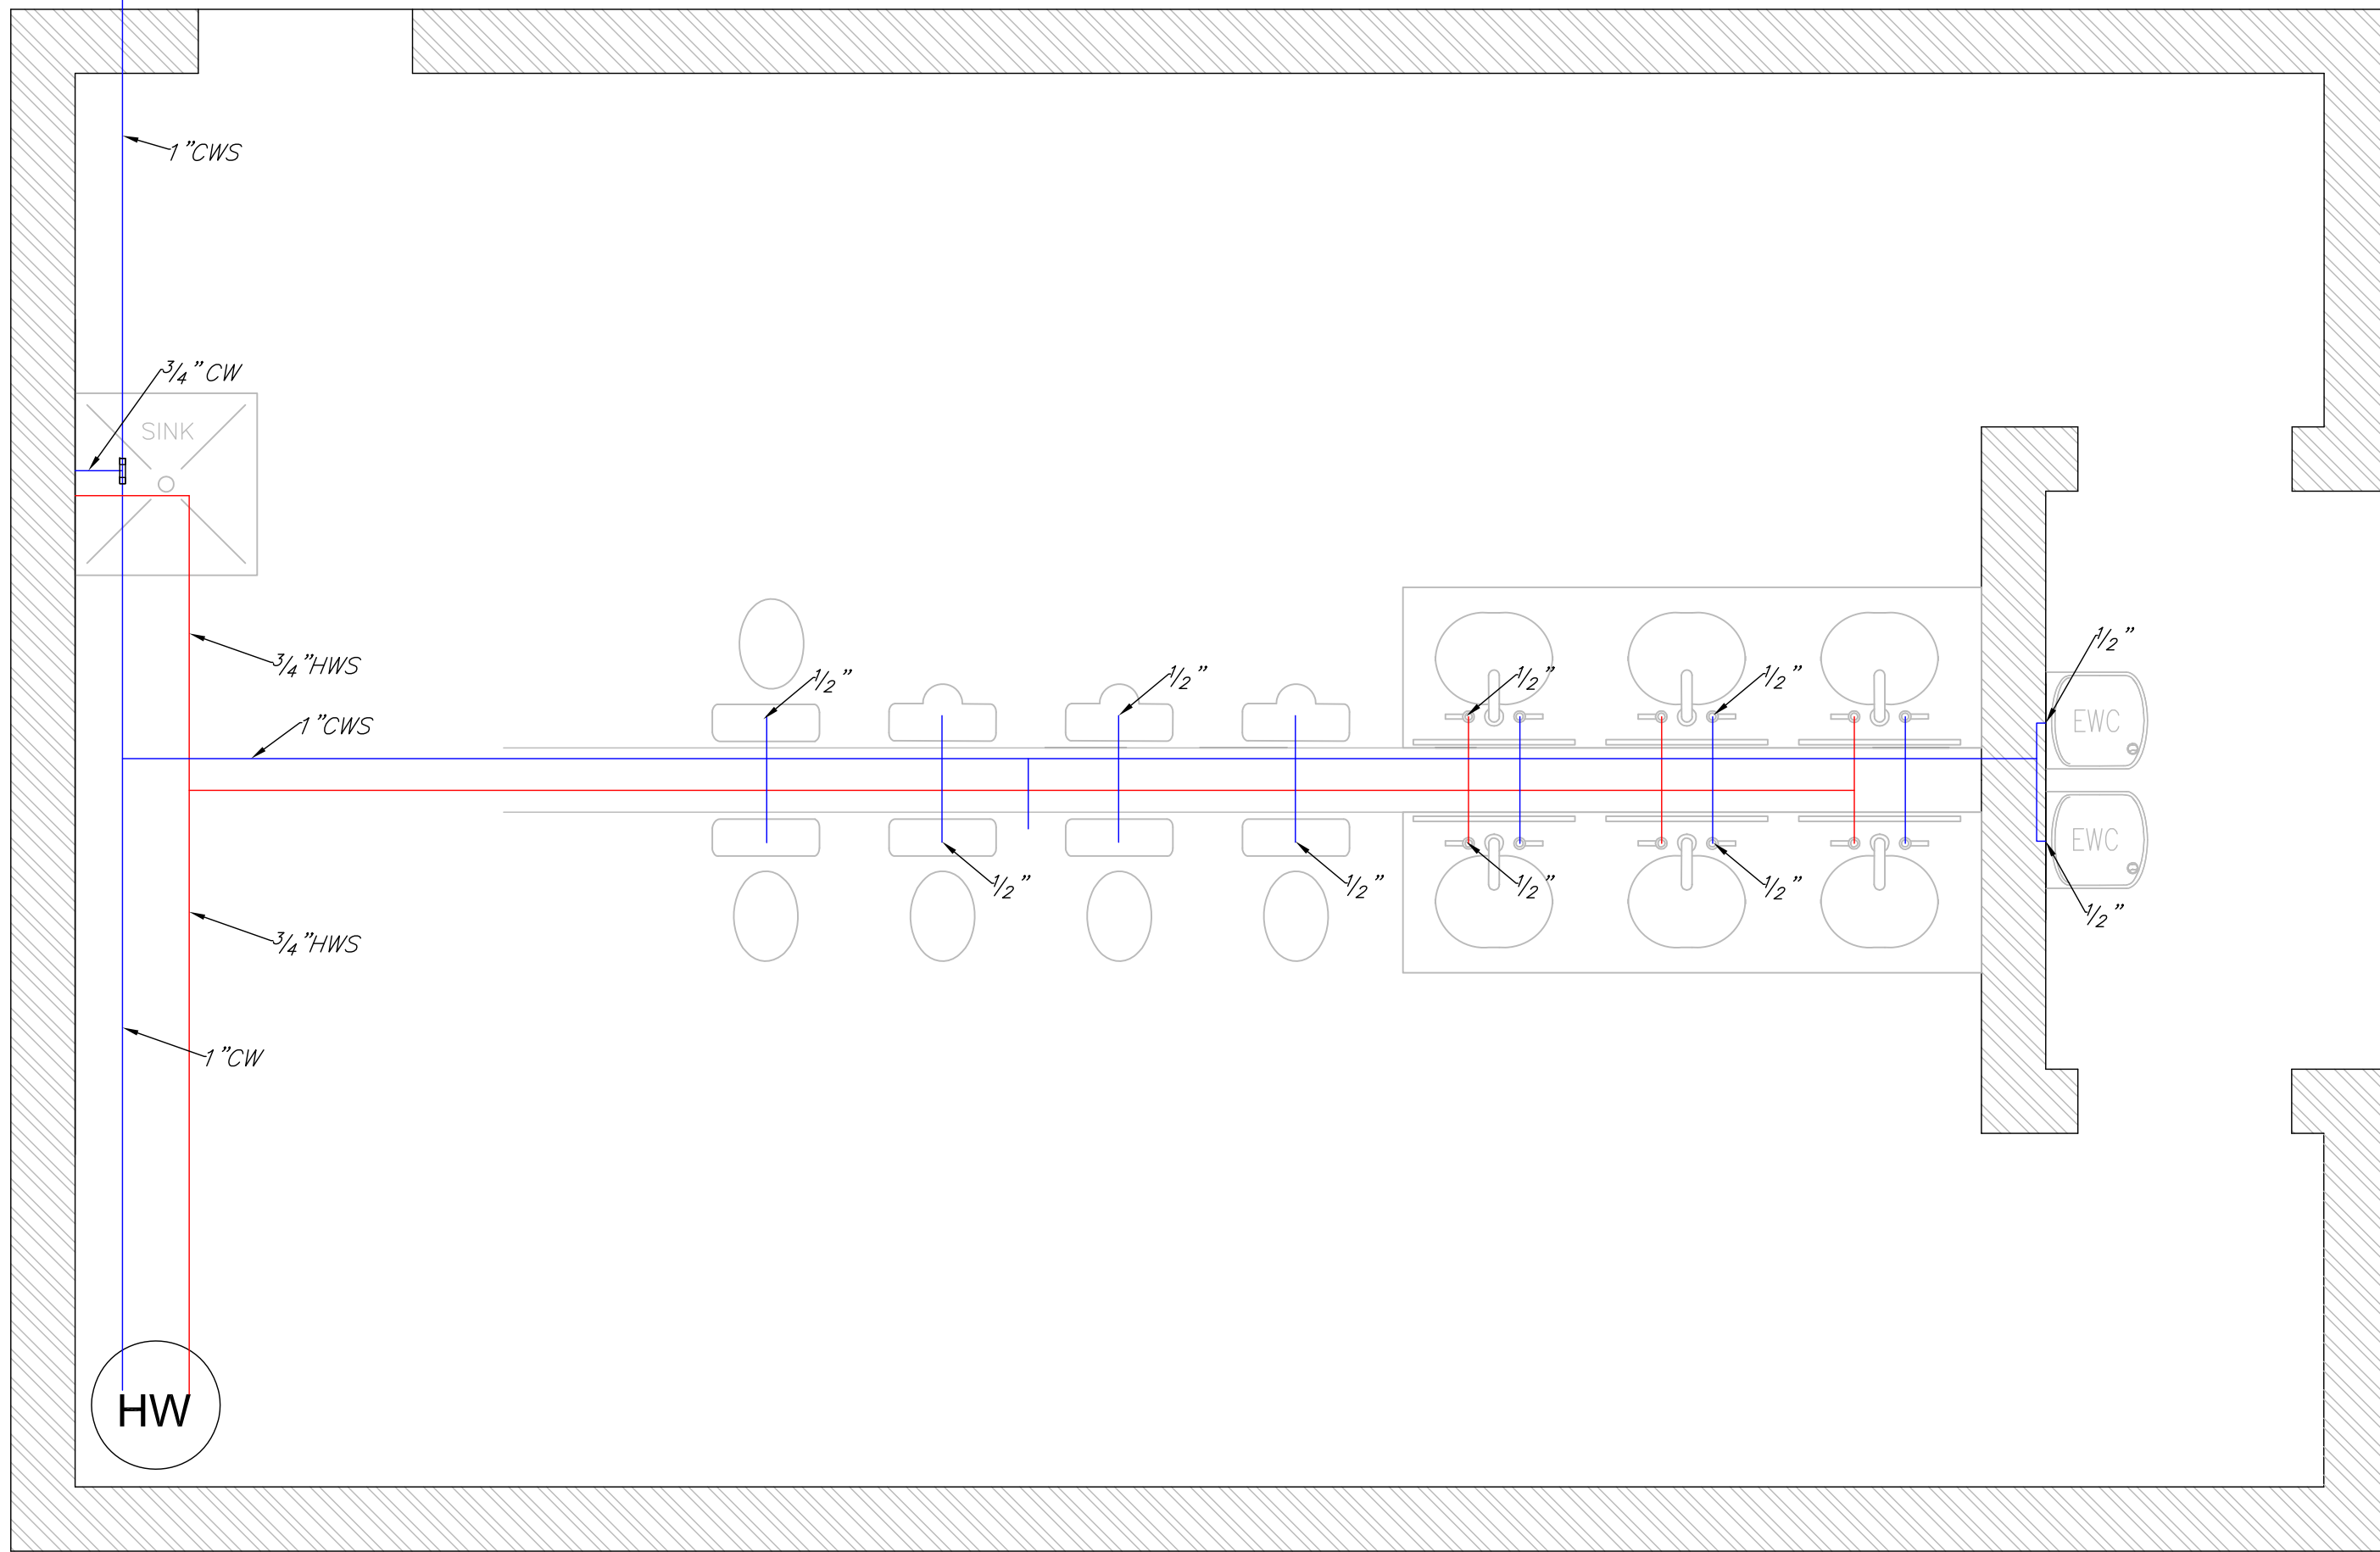


01 1ST FLOOR COLD/HOT WATER PLUMBING
 P3 SCALE: 3/8" = 1'-0"

| | |
|-------------------------------|---------|
| Designed | D-DATE |
| Drawn | DR-DATE |
| Checked | C-DATE |
| Approved | Date |
| Title | |
| ADDRESS | |
| CITY-STATE | |
| Fuquay Varina, North Carolina | |
| Sheet Title . | |
| Sheet Number. | |
| P3 | |

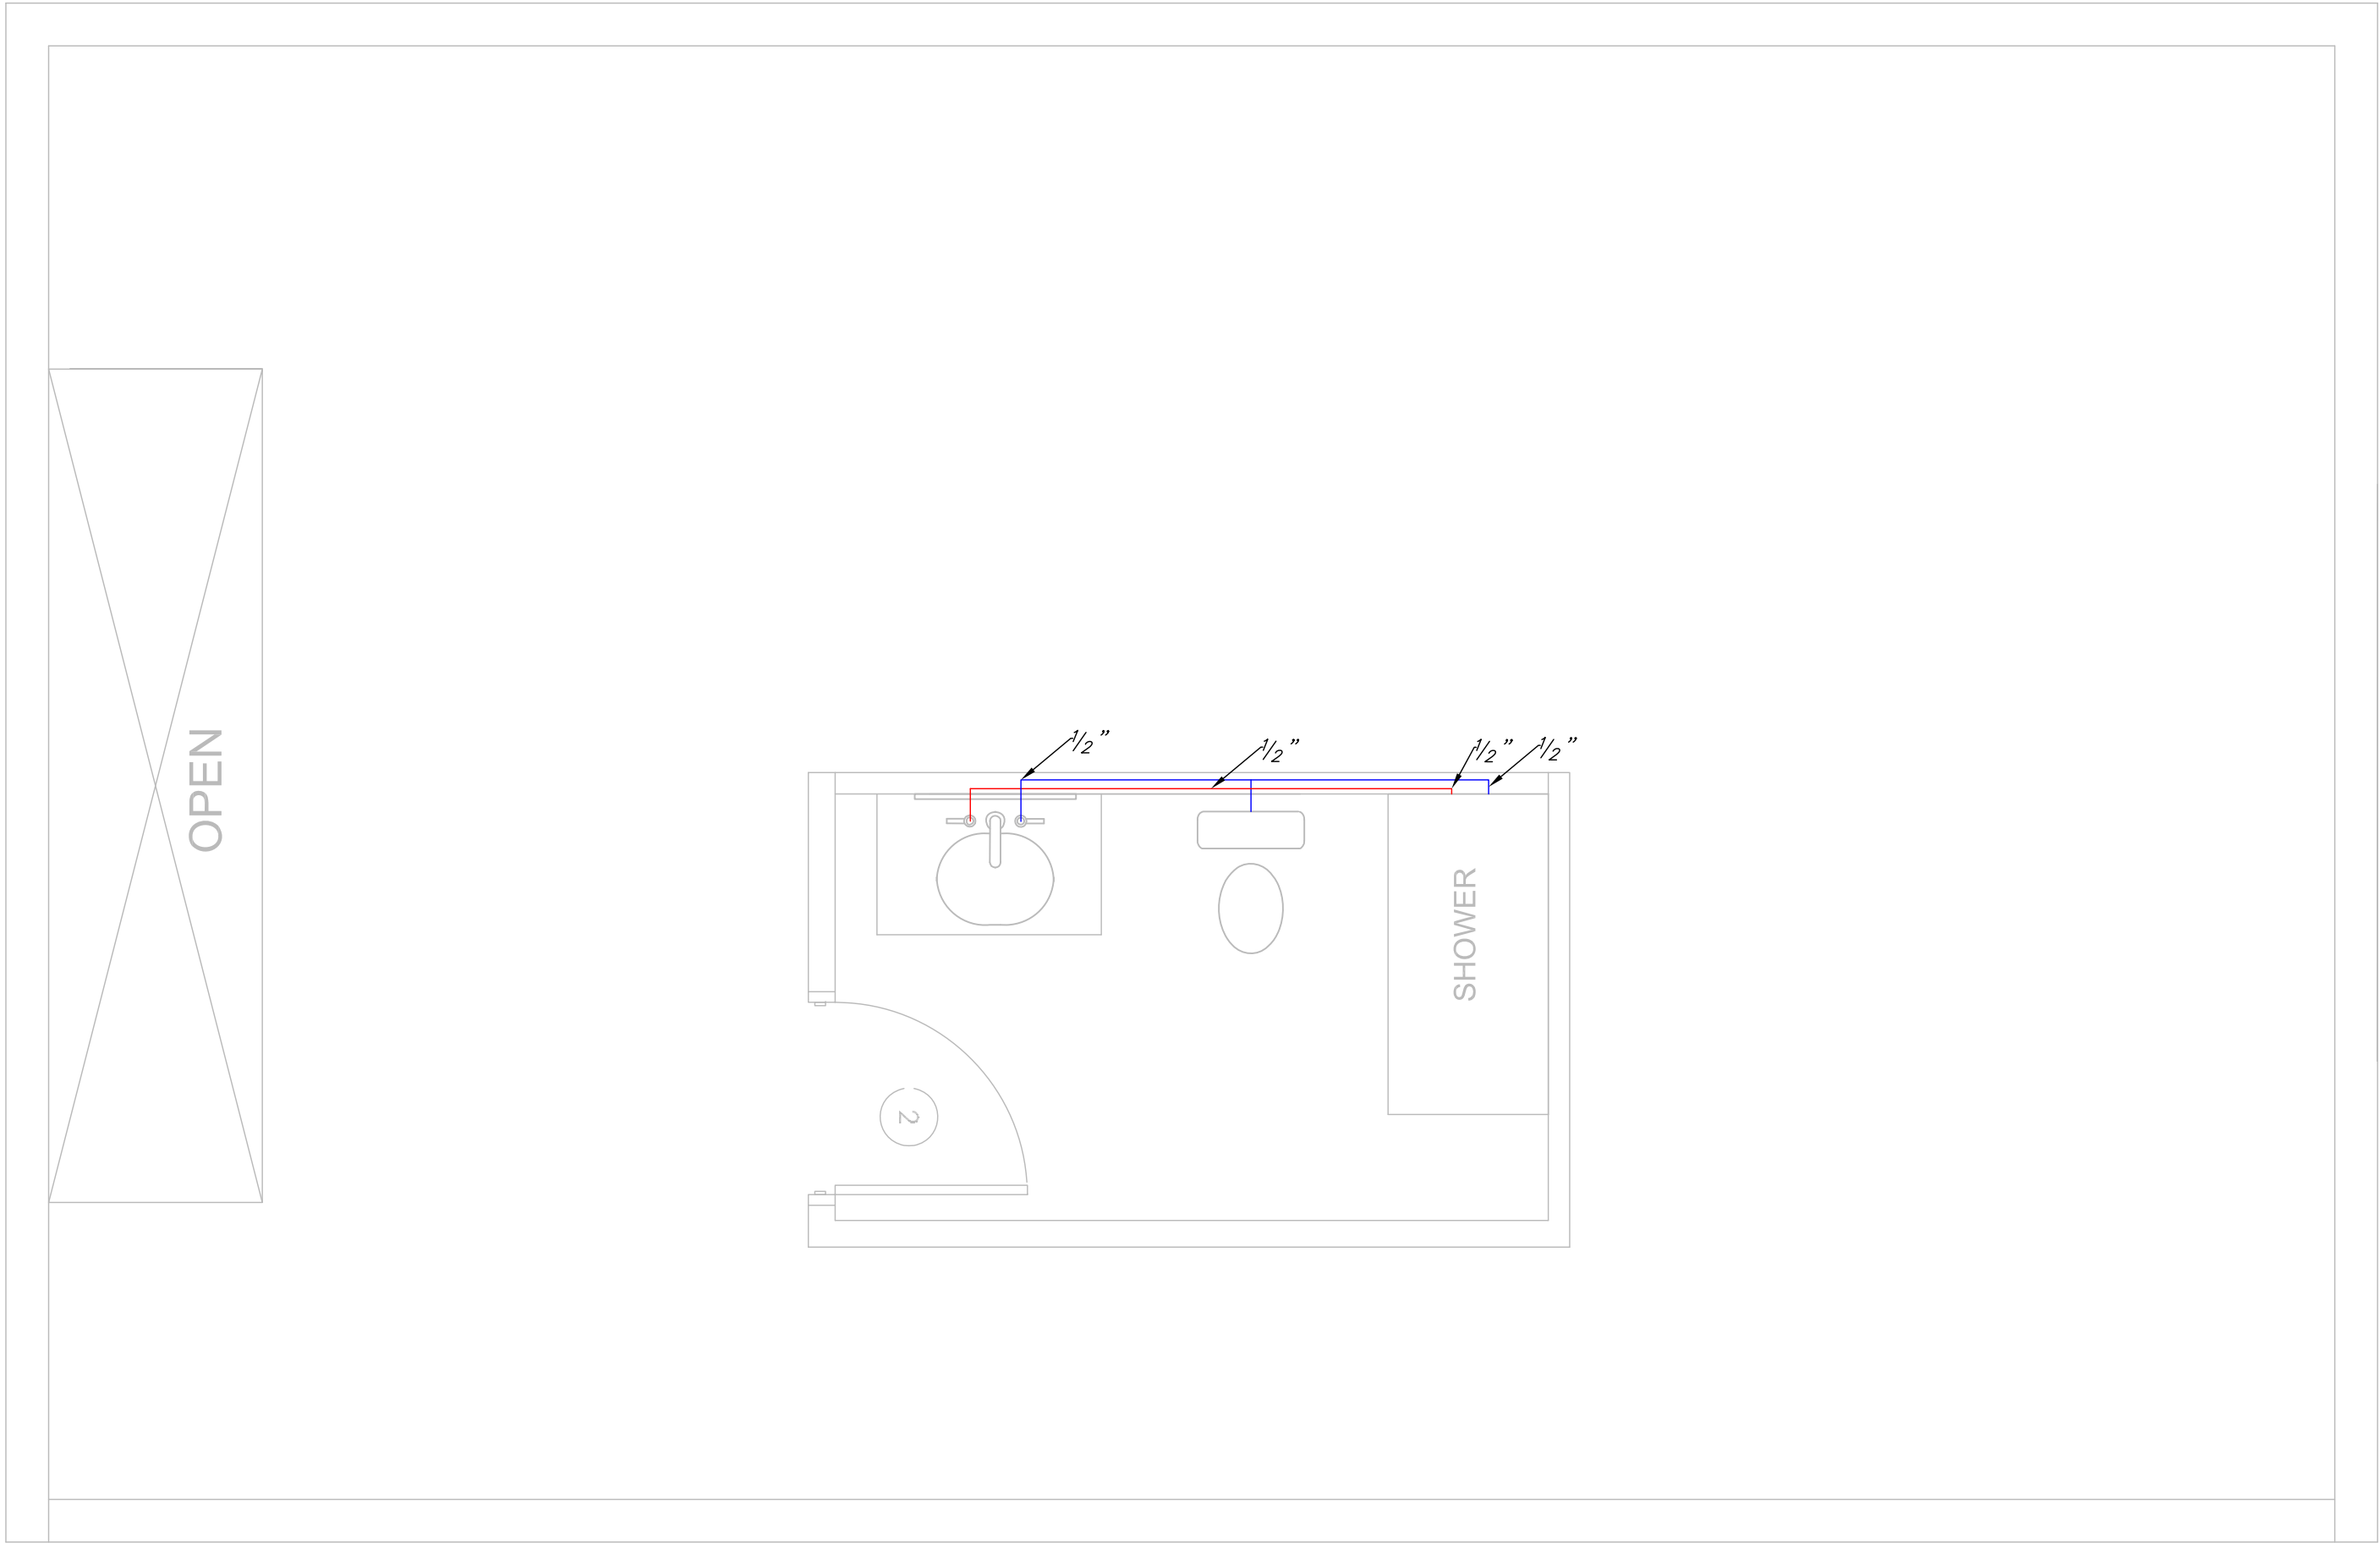


01 2ND FLOOR COLD/HOT WATER PLUMBING
 P4 SCALE: 3/8" = 1'-0"


| | |
|-------------------------------|---------|
| Designed | D-DATE |
| Drawn | DR-DATE |
| Checked | C-DATE |
| Approved | Date |
| Title | |
| ADDRESS | |
| CITY-STATE | |
| Fuquay Varina, North Carolina | |
| Sheet Title . | |
| Sheet Number. | |
| P4 | |

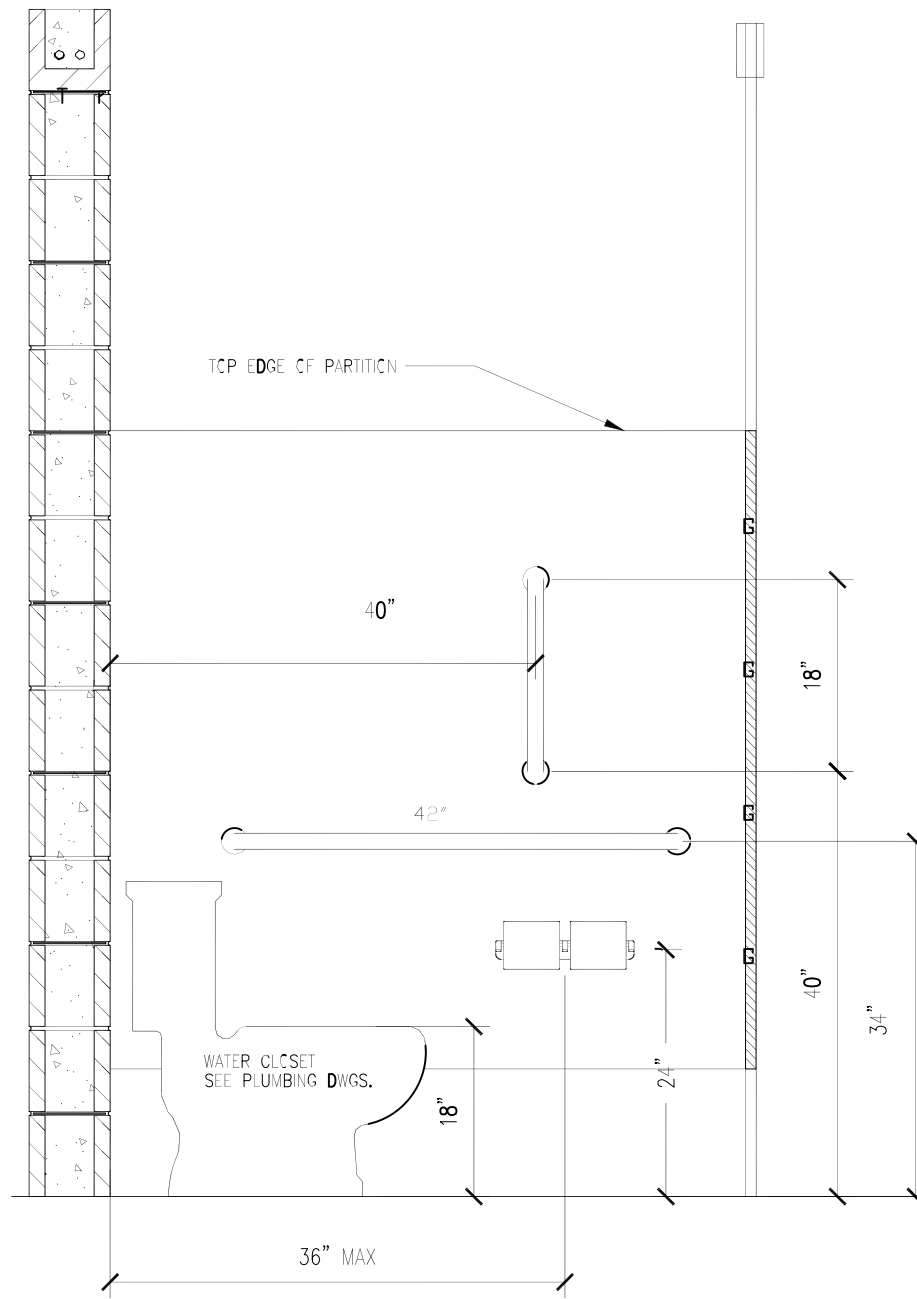

01 HANDICAP STALL
P5 SCALE: 3/4" = 1'-0"

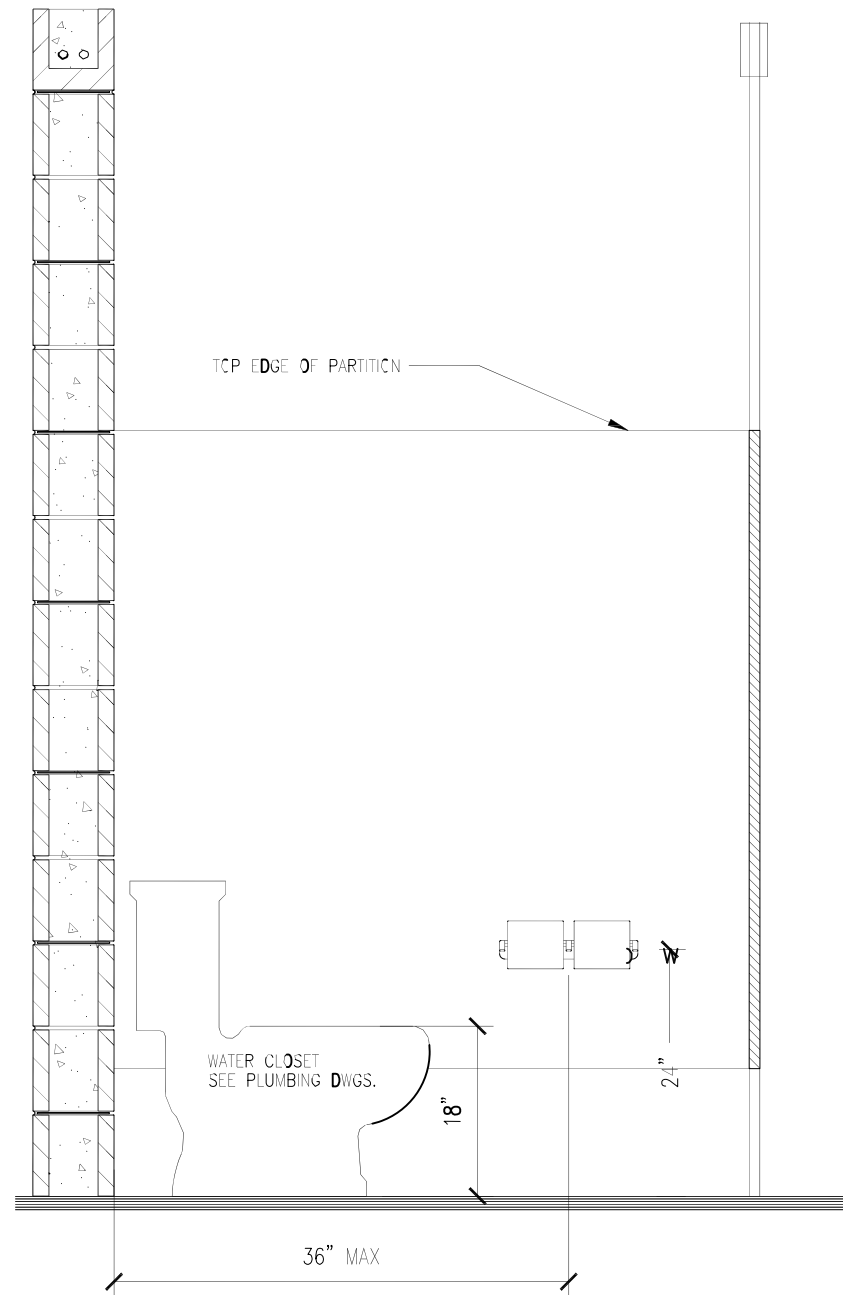

02 STANDARD STALL
P5 SCALE: 3/4" = 1'-0"

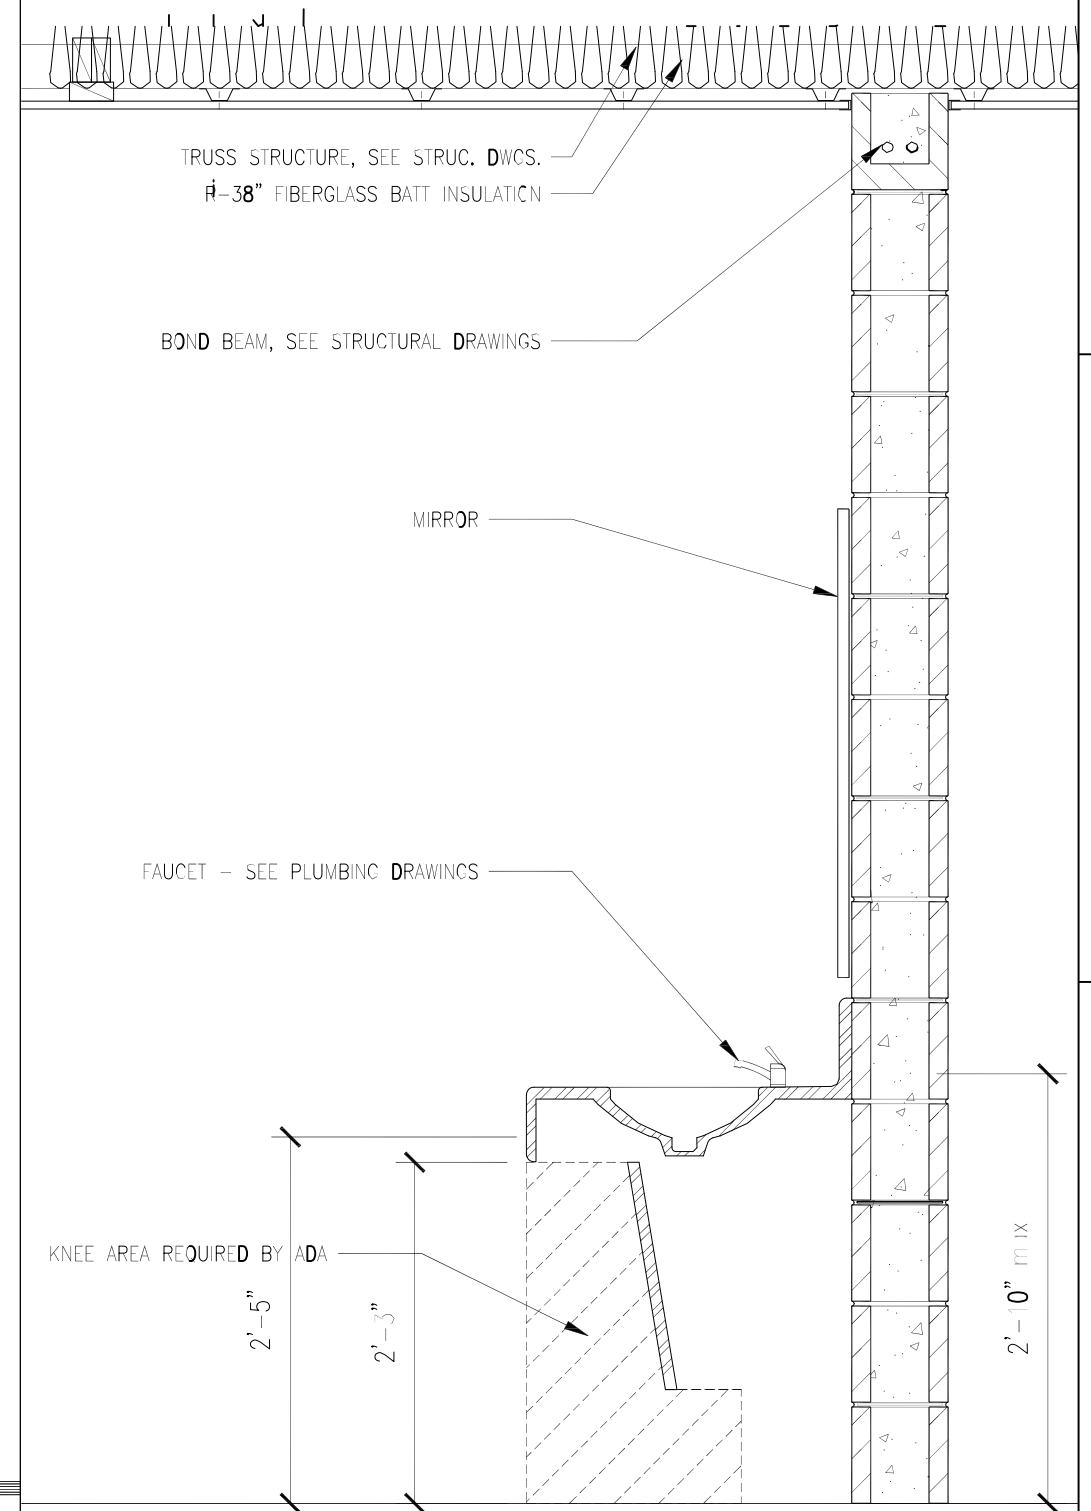

03 STANDARD SINK DETAIL
P5 SCALE: 3/4" = 1'-0"

Designed _____
Drawn _____
Checked _____
Approved _____
Title _____


ADDRESS _____
CITY-STATE _____
Fuquay Varina, North Carolina

Sheet Title _____

Sheet Number.

P5

D-DATE _____
DR-DATE _____
C-DATE _____
Date _____

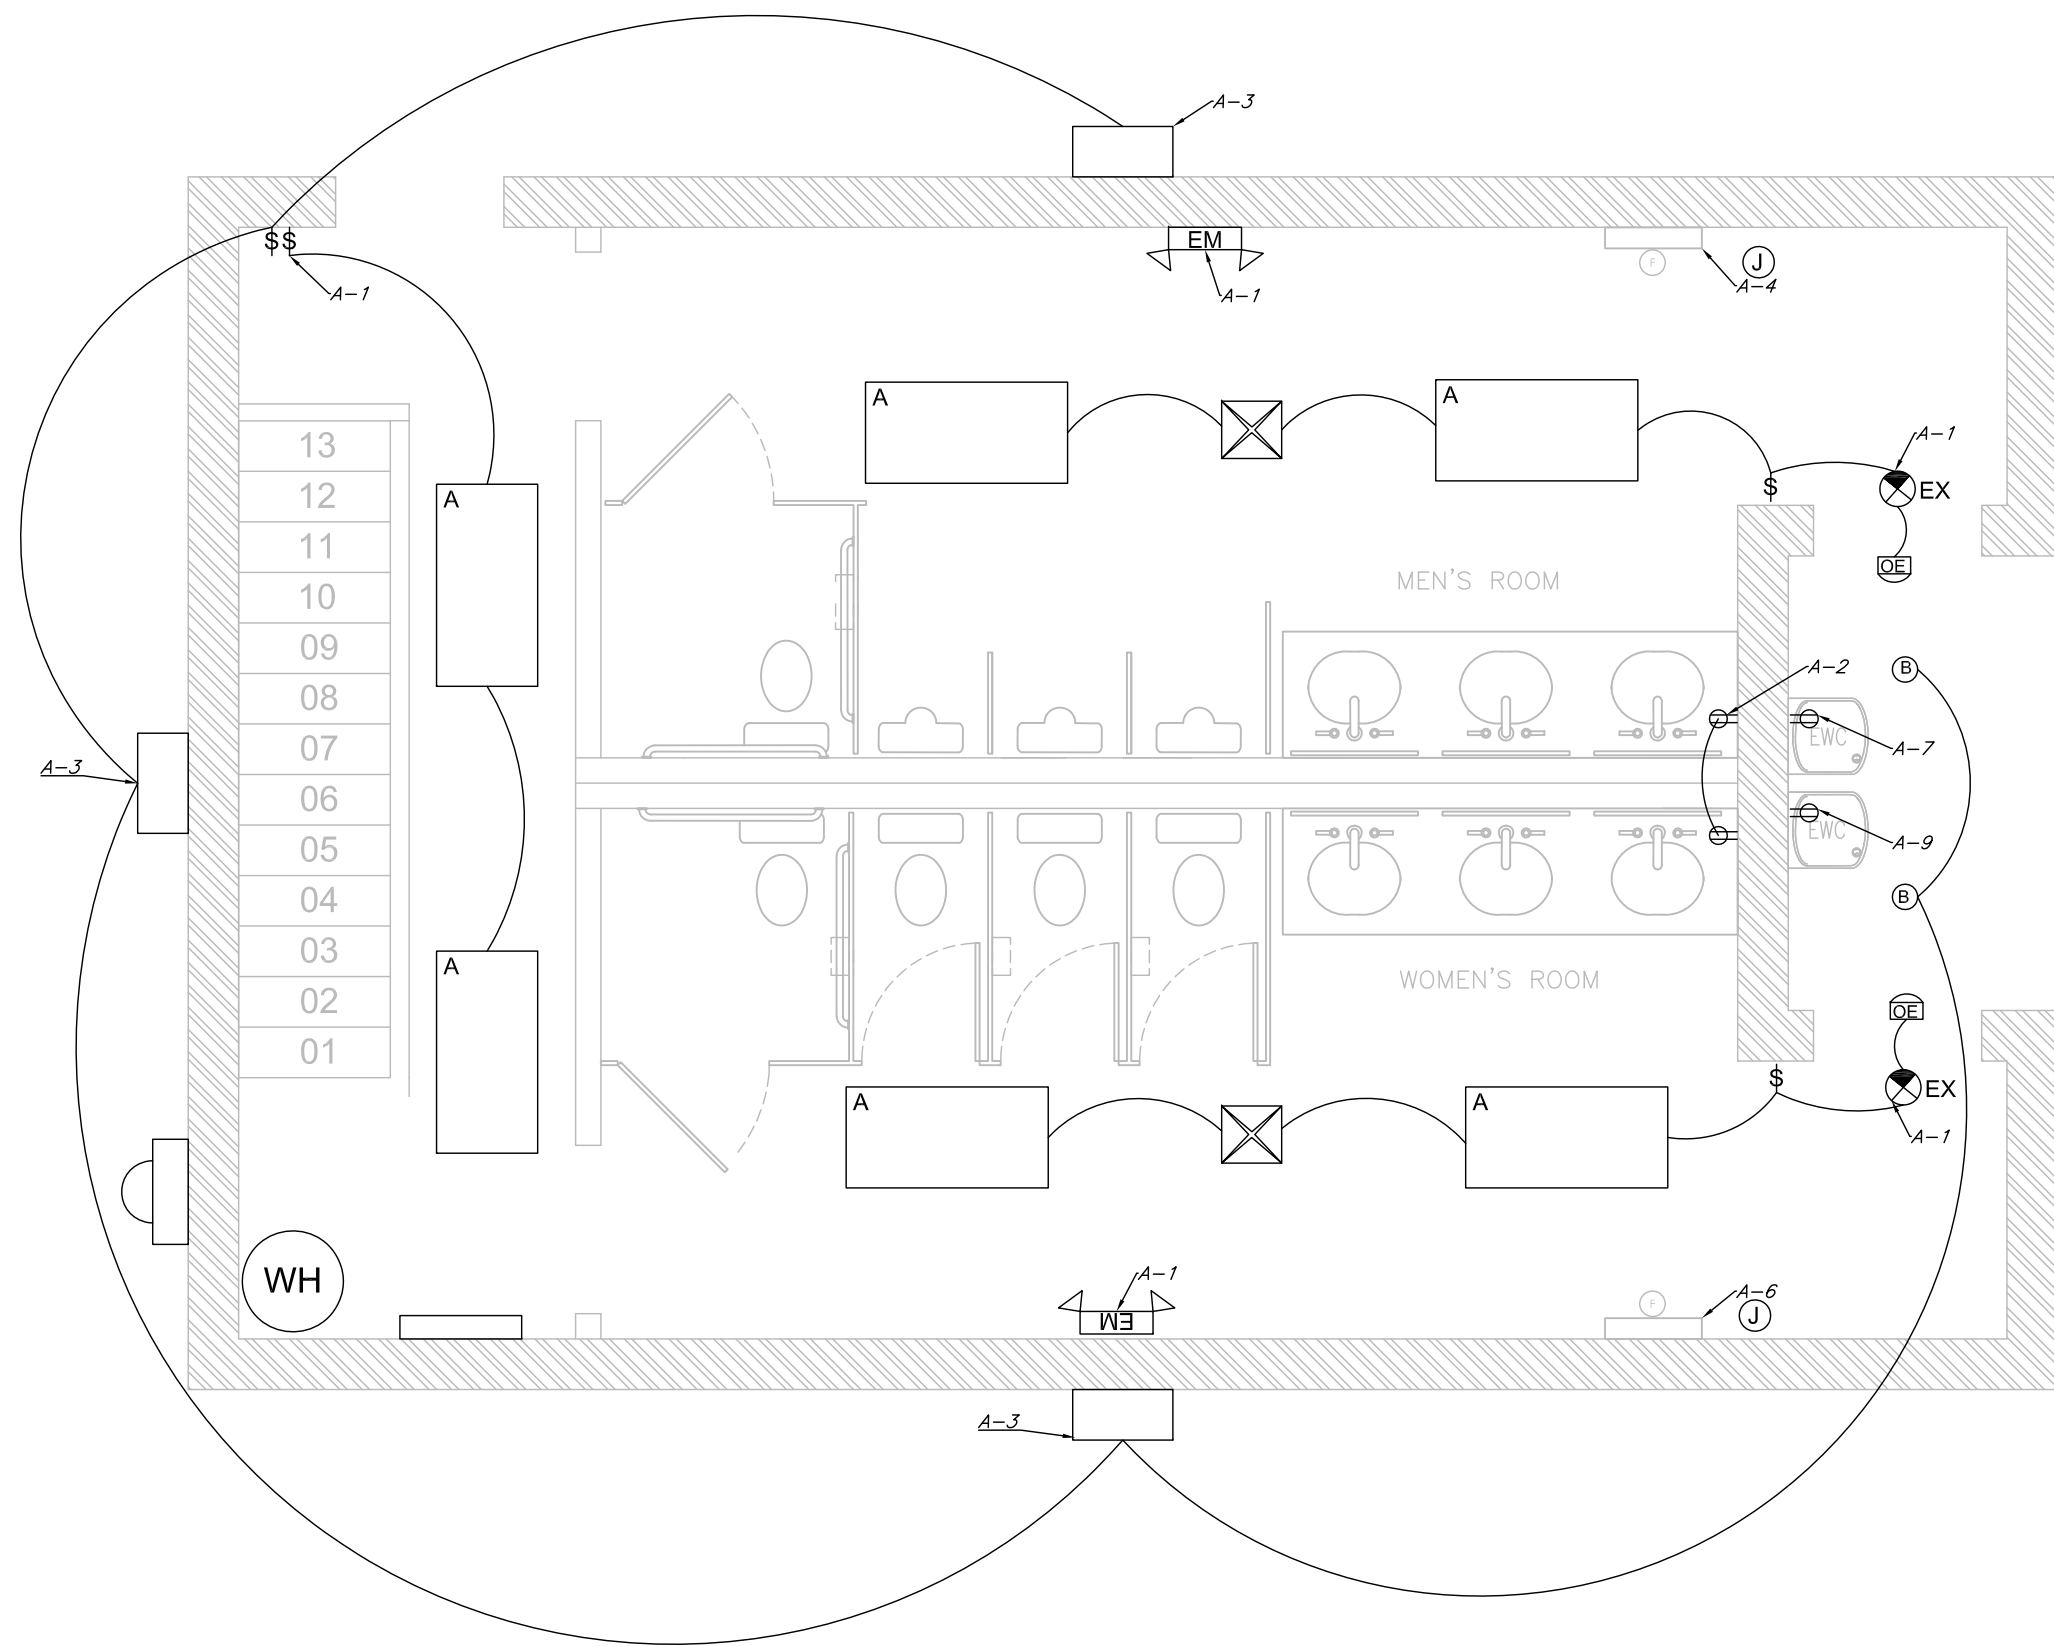

01 LIGHTING PLAN
 E1 SCALE: 1/4" = 1'-0"

| | |
|-------------------------------|---------|
| Designed | D-DATE |
| Drawn | DR-DATE |
| Checked | C-DATE |
| Approved | Date |
| Title | |
| ADDRESS | |
| CITY-STATE | |
| Fuquay Varina, North Carolina | |
| Sheet Title . | |
| Sheet Number. | |
| E1 | |