



1 FIRST FLOOR PLAN
 A SCALE: 3/8" = 1'-0"

Designed	D-DATE
Drawn	DR-DATE
Checked	C-DATE
Approved	Date
Title	
ADDRESS	
CITY-STATE	
Fuquay Varina, North Carolina	
Sheet Title .	
Sheet Number.	
A1	

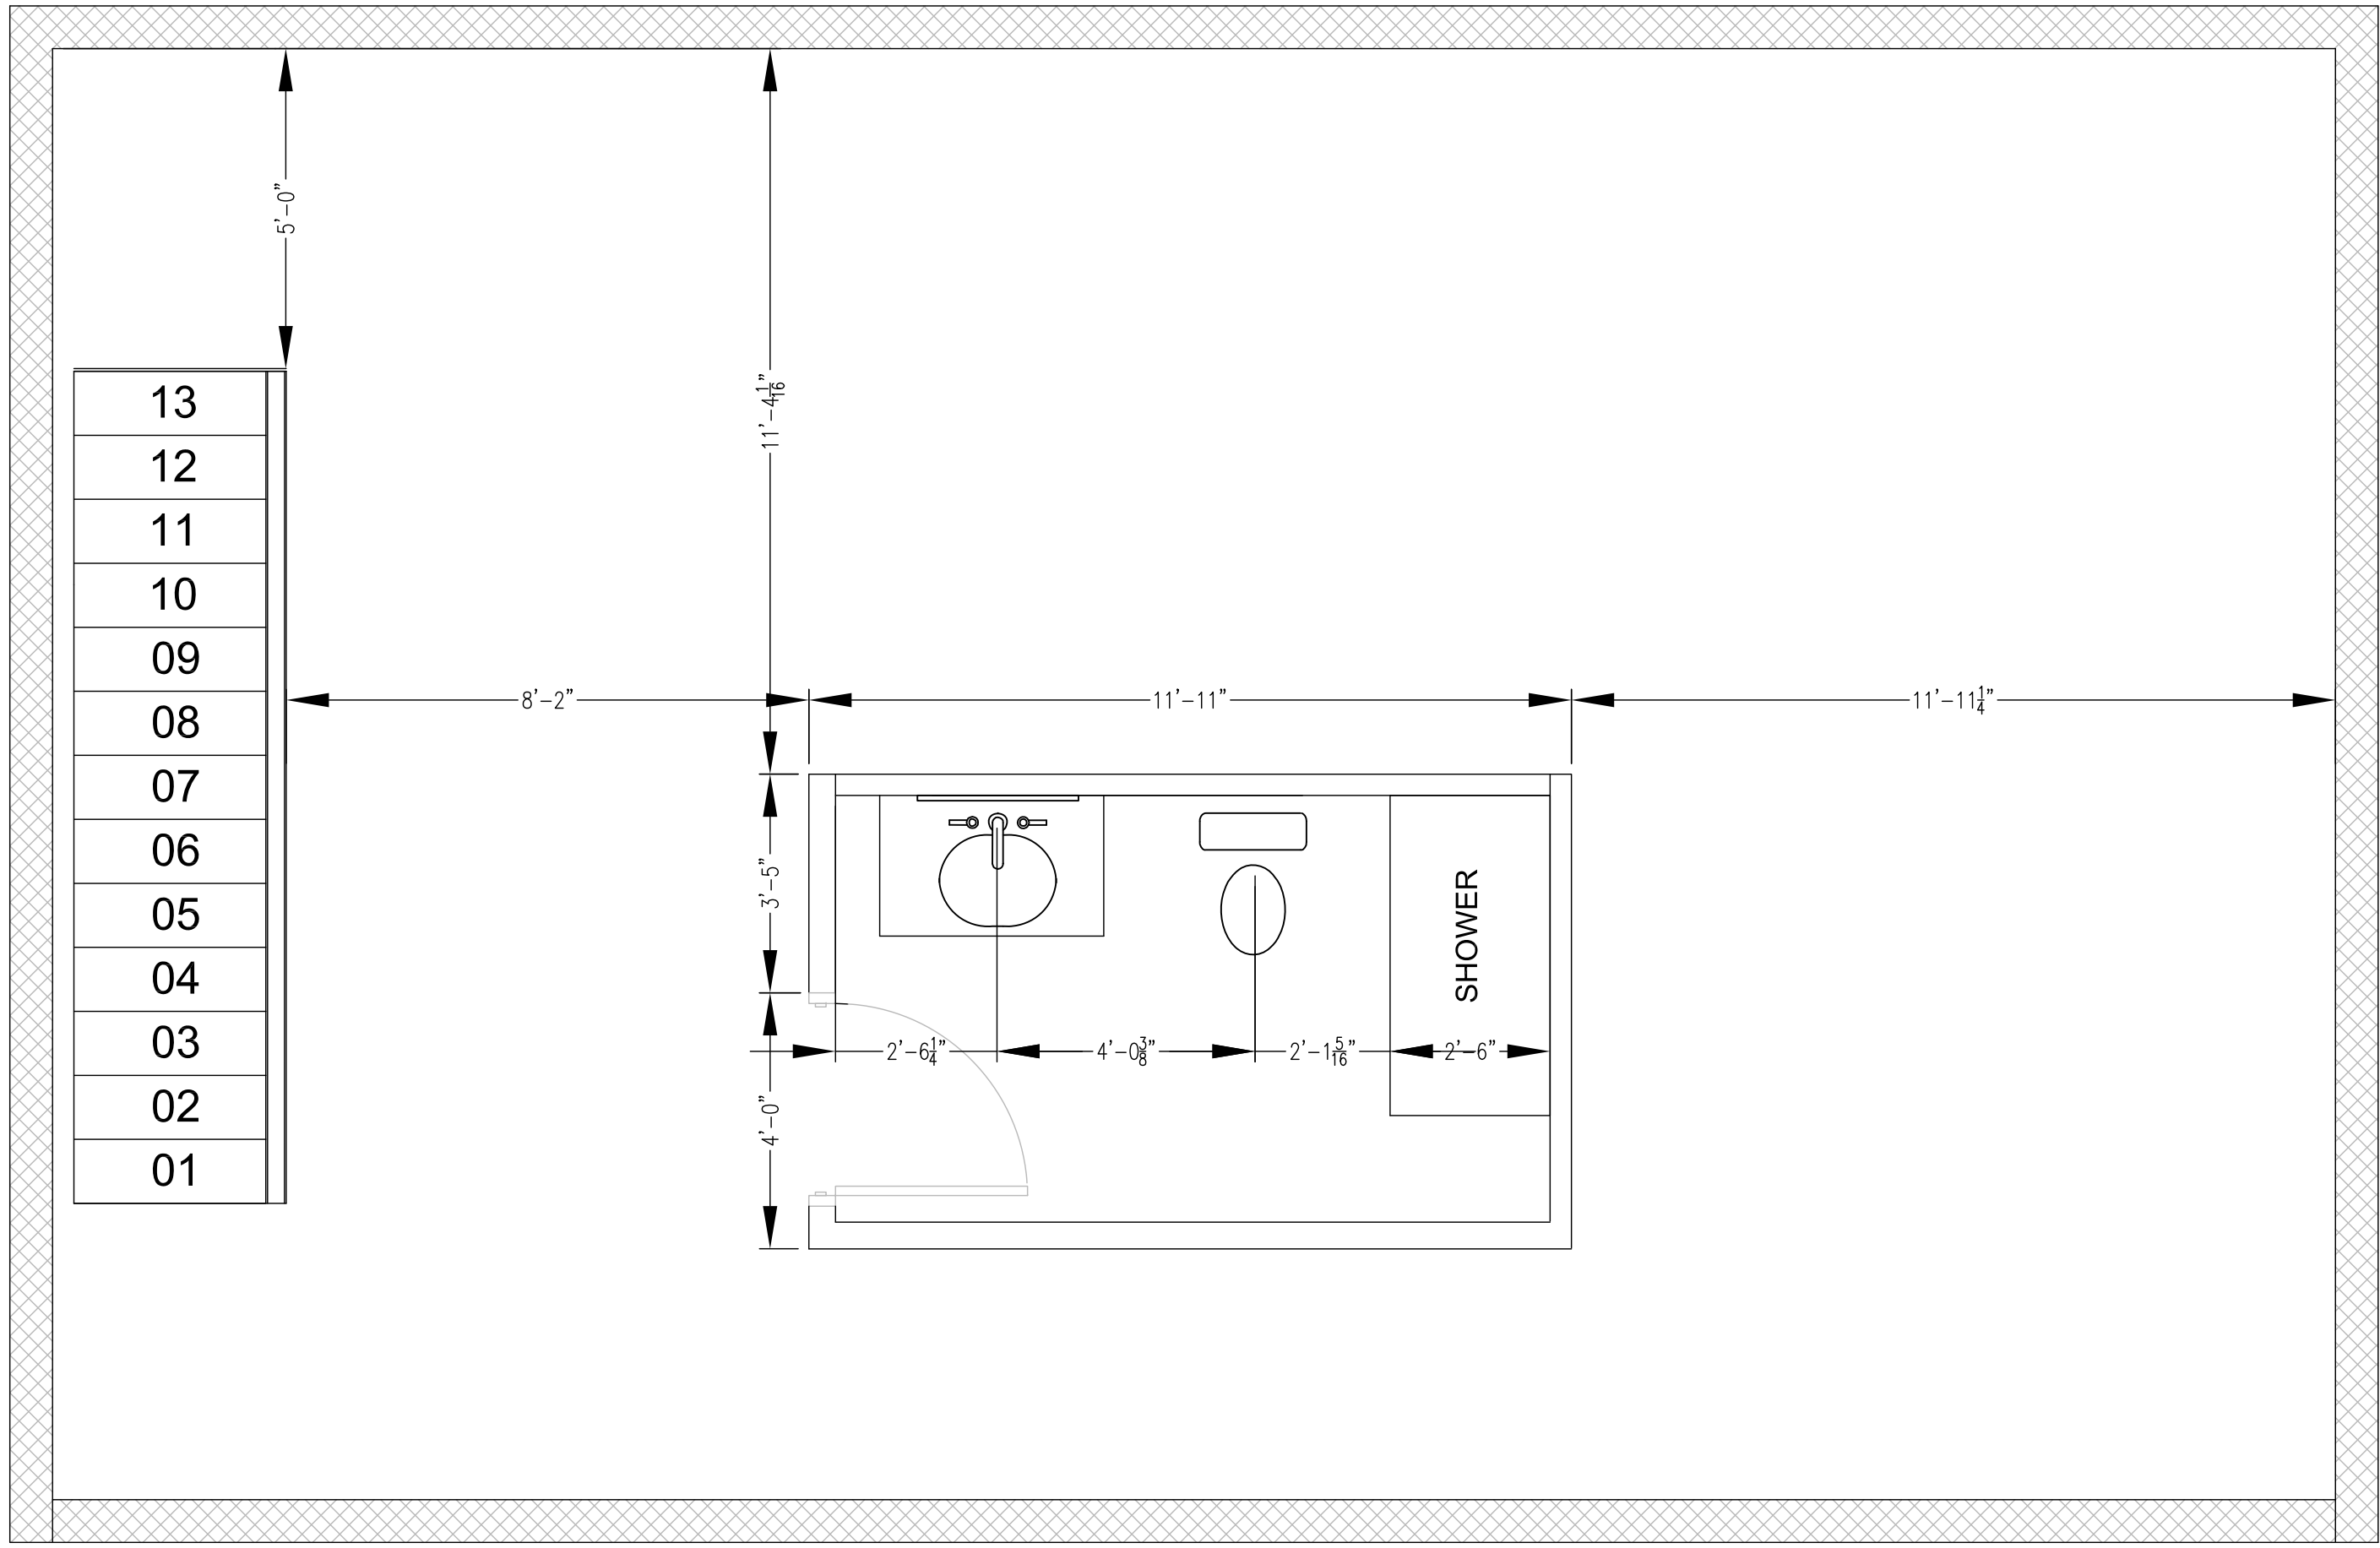


1
A-2 2ND FLOOR PLAN
SCALE: 3/8" = 1'-0"


Designed	D-DATE
Drawn	DR-DATE
Checked	C-DATE
Approved	Date
Title	
ADDRESS	
CITY-STATE	
Fuquay Varina, North Carolina	
Sheet Title .	
Sheet Number.	
A2	

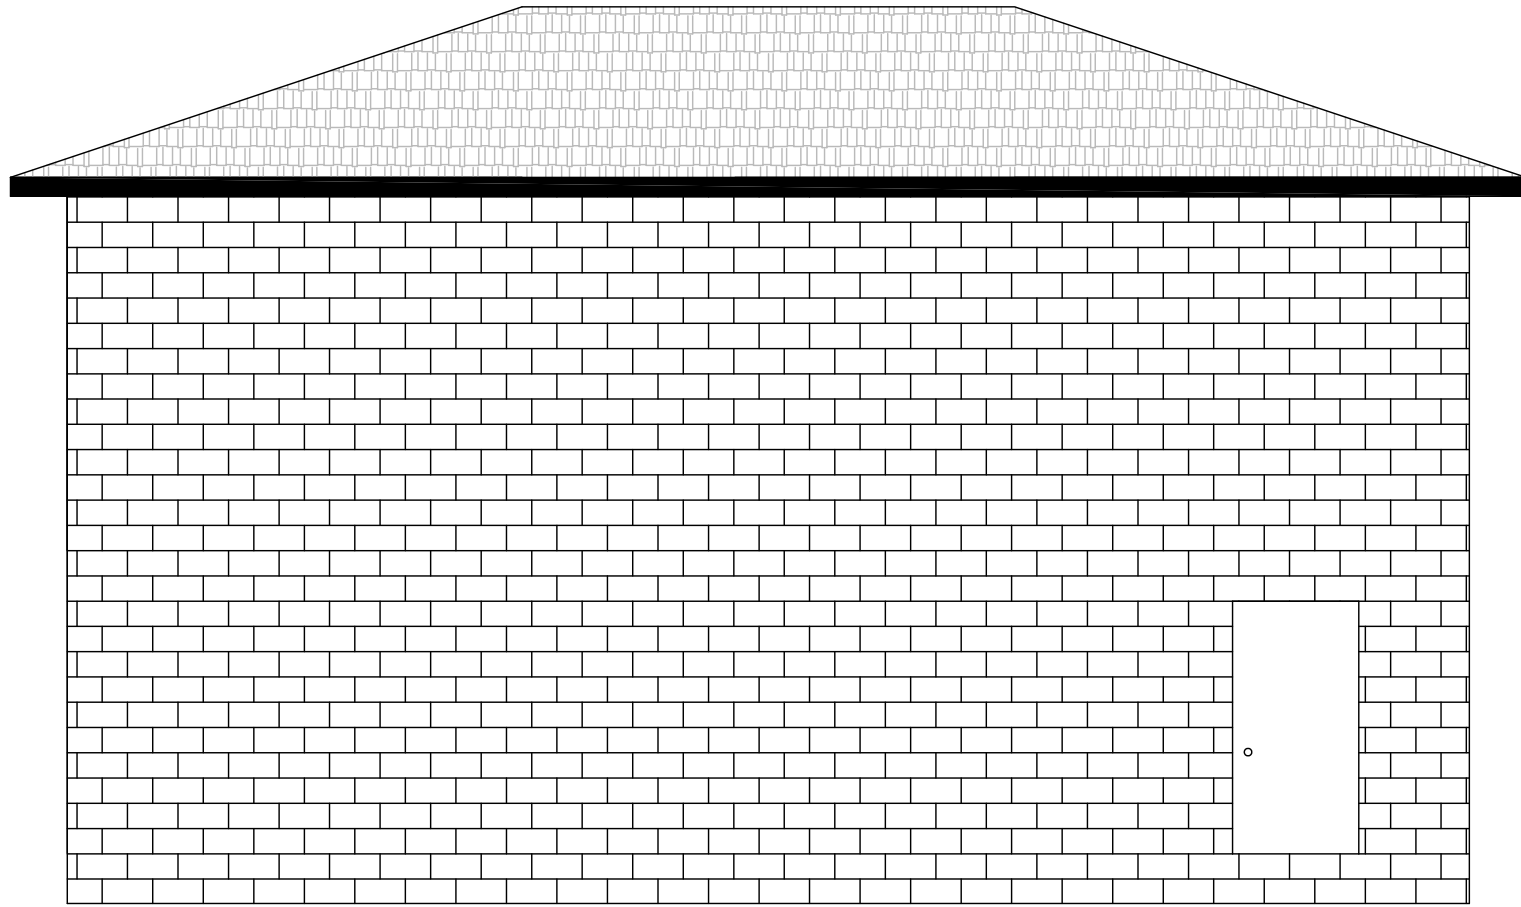


1
A-3 SIDE A ELEVATION
SCALE: 3/16" = 1'-0"

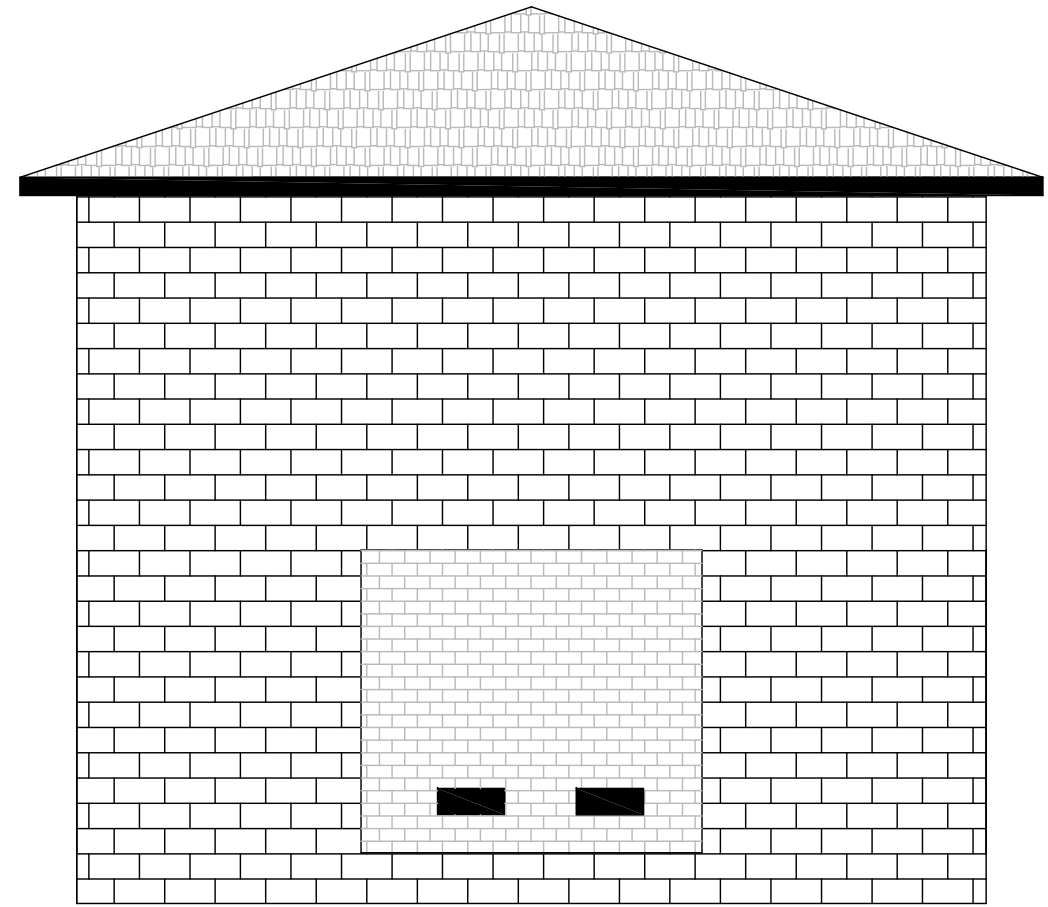

2
A-3 SIDE D ELEVATION
SCALE: 3/16" = 1'-0"

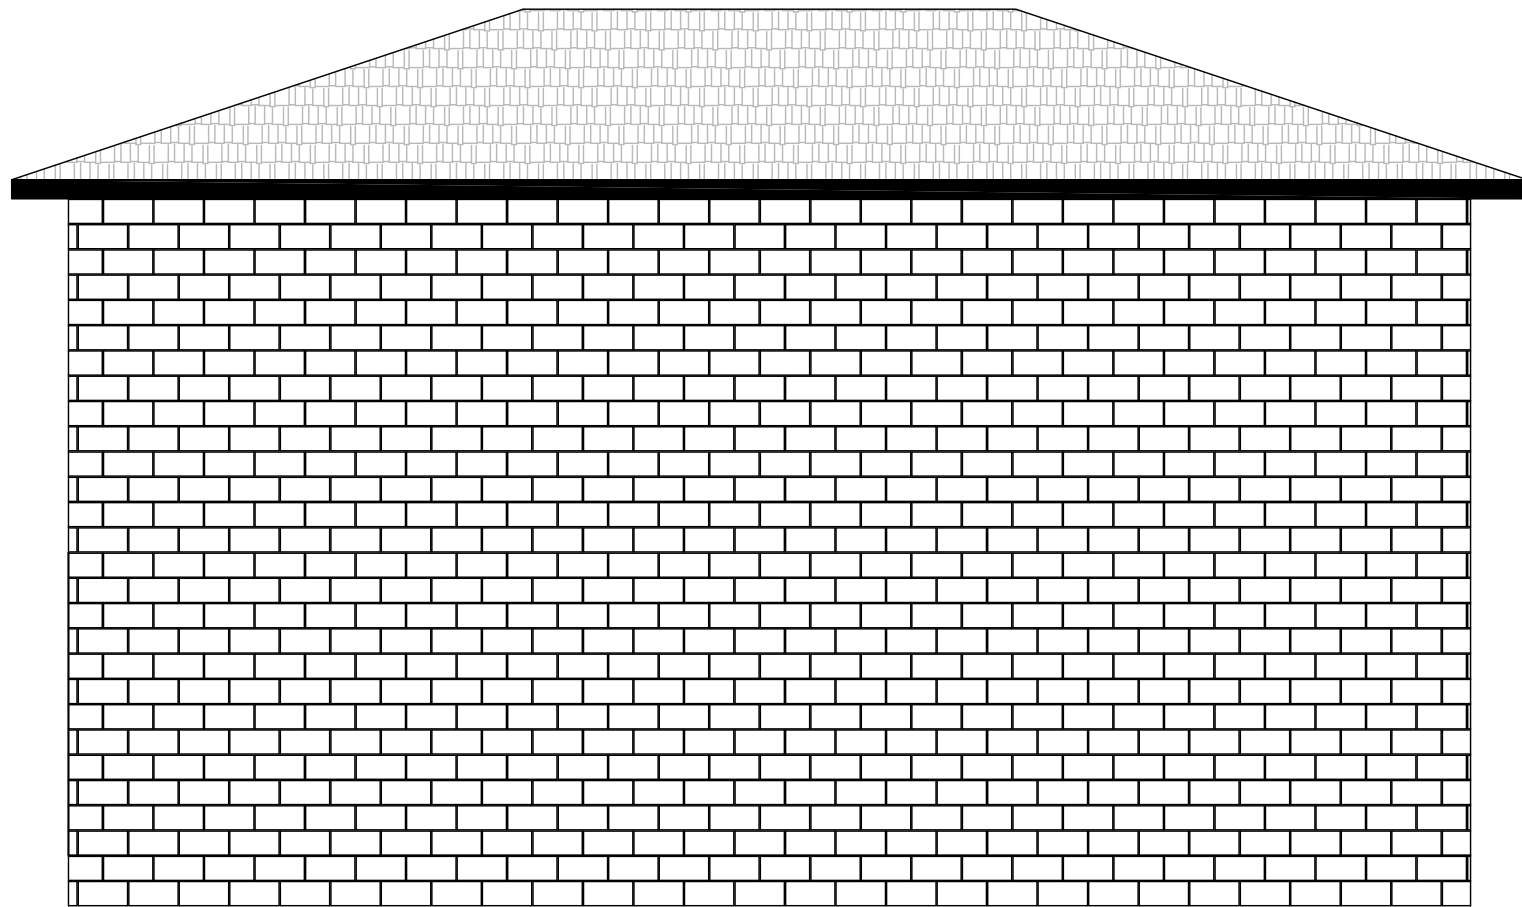

3
A-3 SIDE B ELEVATION
SCALE: 3/16" = 1'-0"

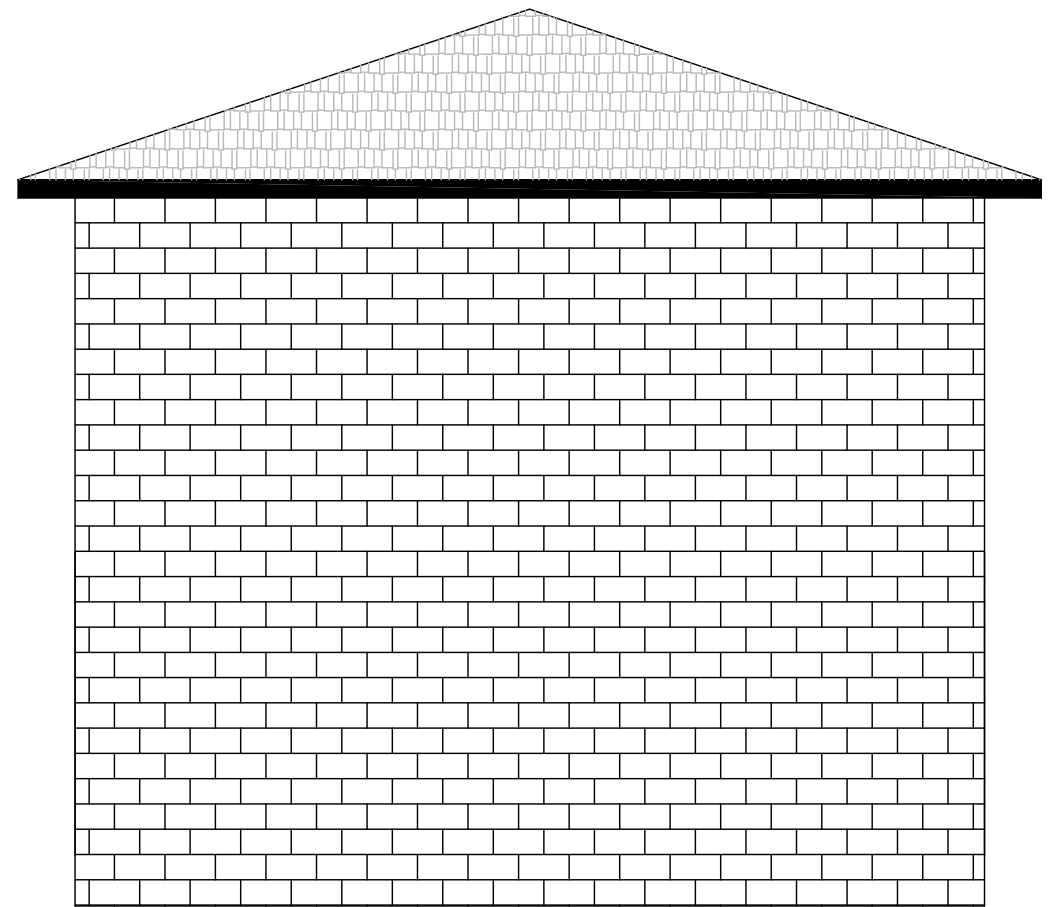

4
A-3 SIDE C ELEVATION
SCALE: 3/16" = 1'-0"


Designed _____ D-DATE _____
Drawn _____ DR-DATE _____
Checked _____ C-DATE _____
Approved _____ Date _____
Title _____

ADDRESS
CITY-STATE
Fuquay Varina, North Carolina

Sheet Title .

Sheet Number.

A3

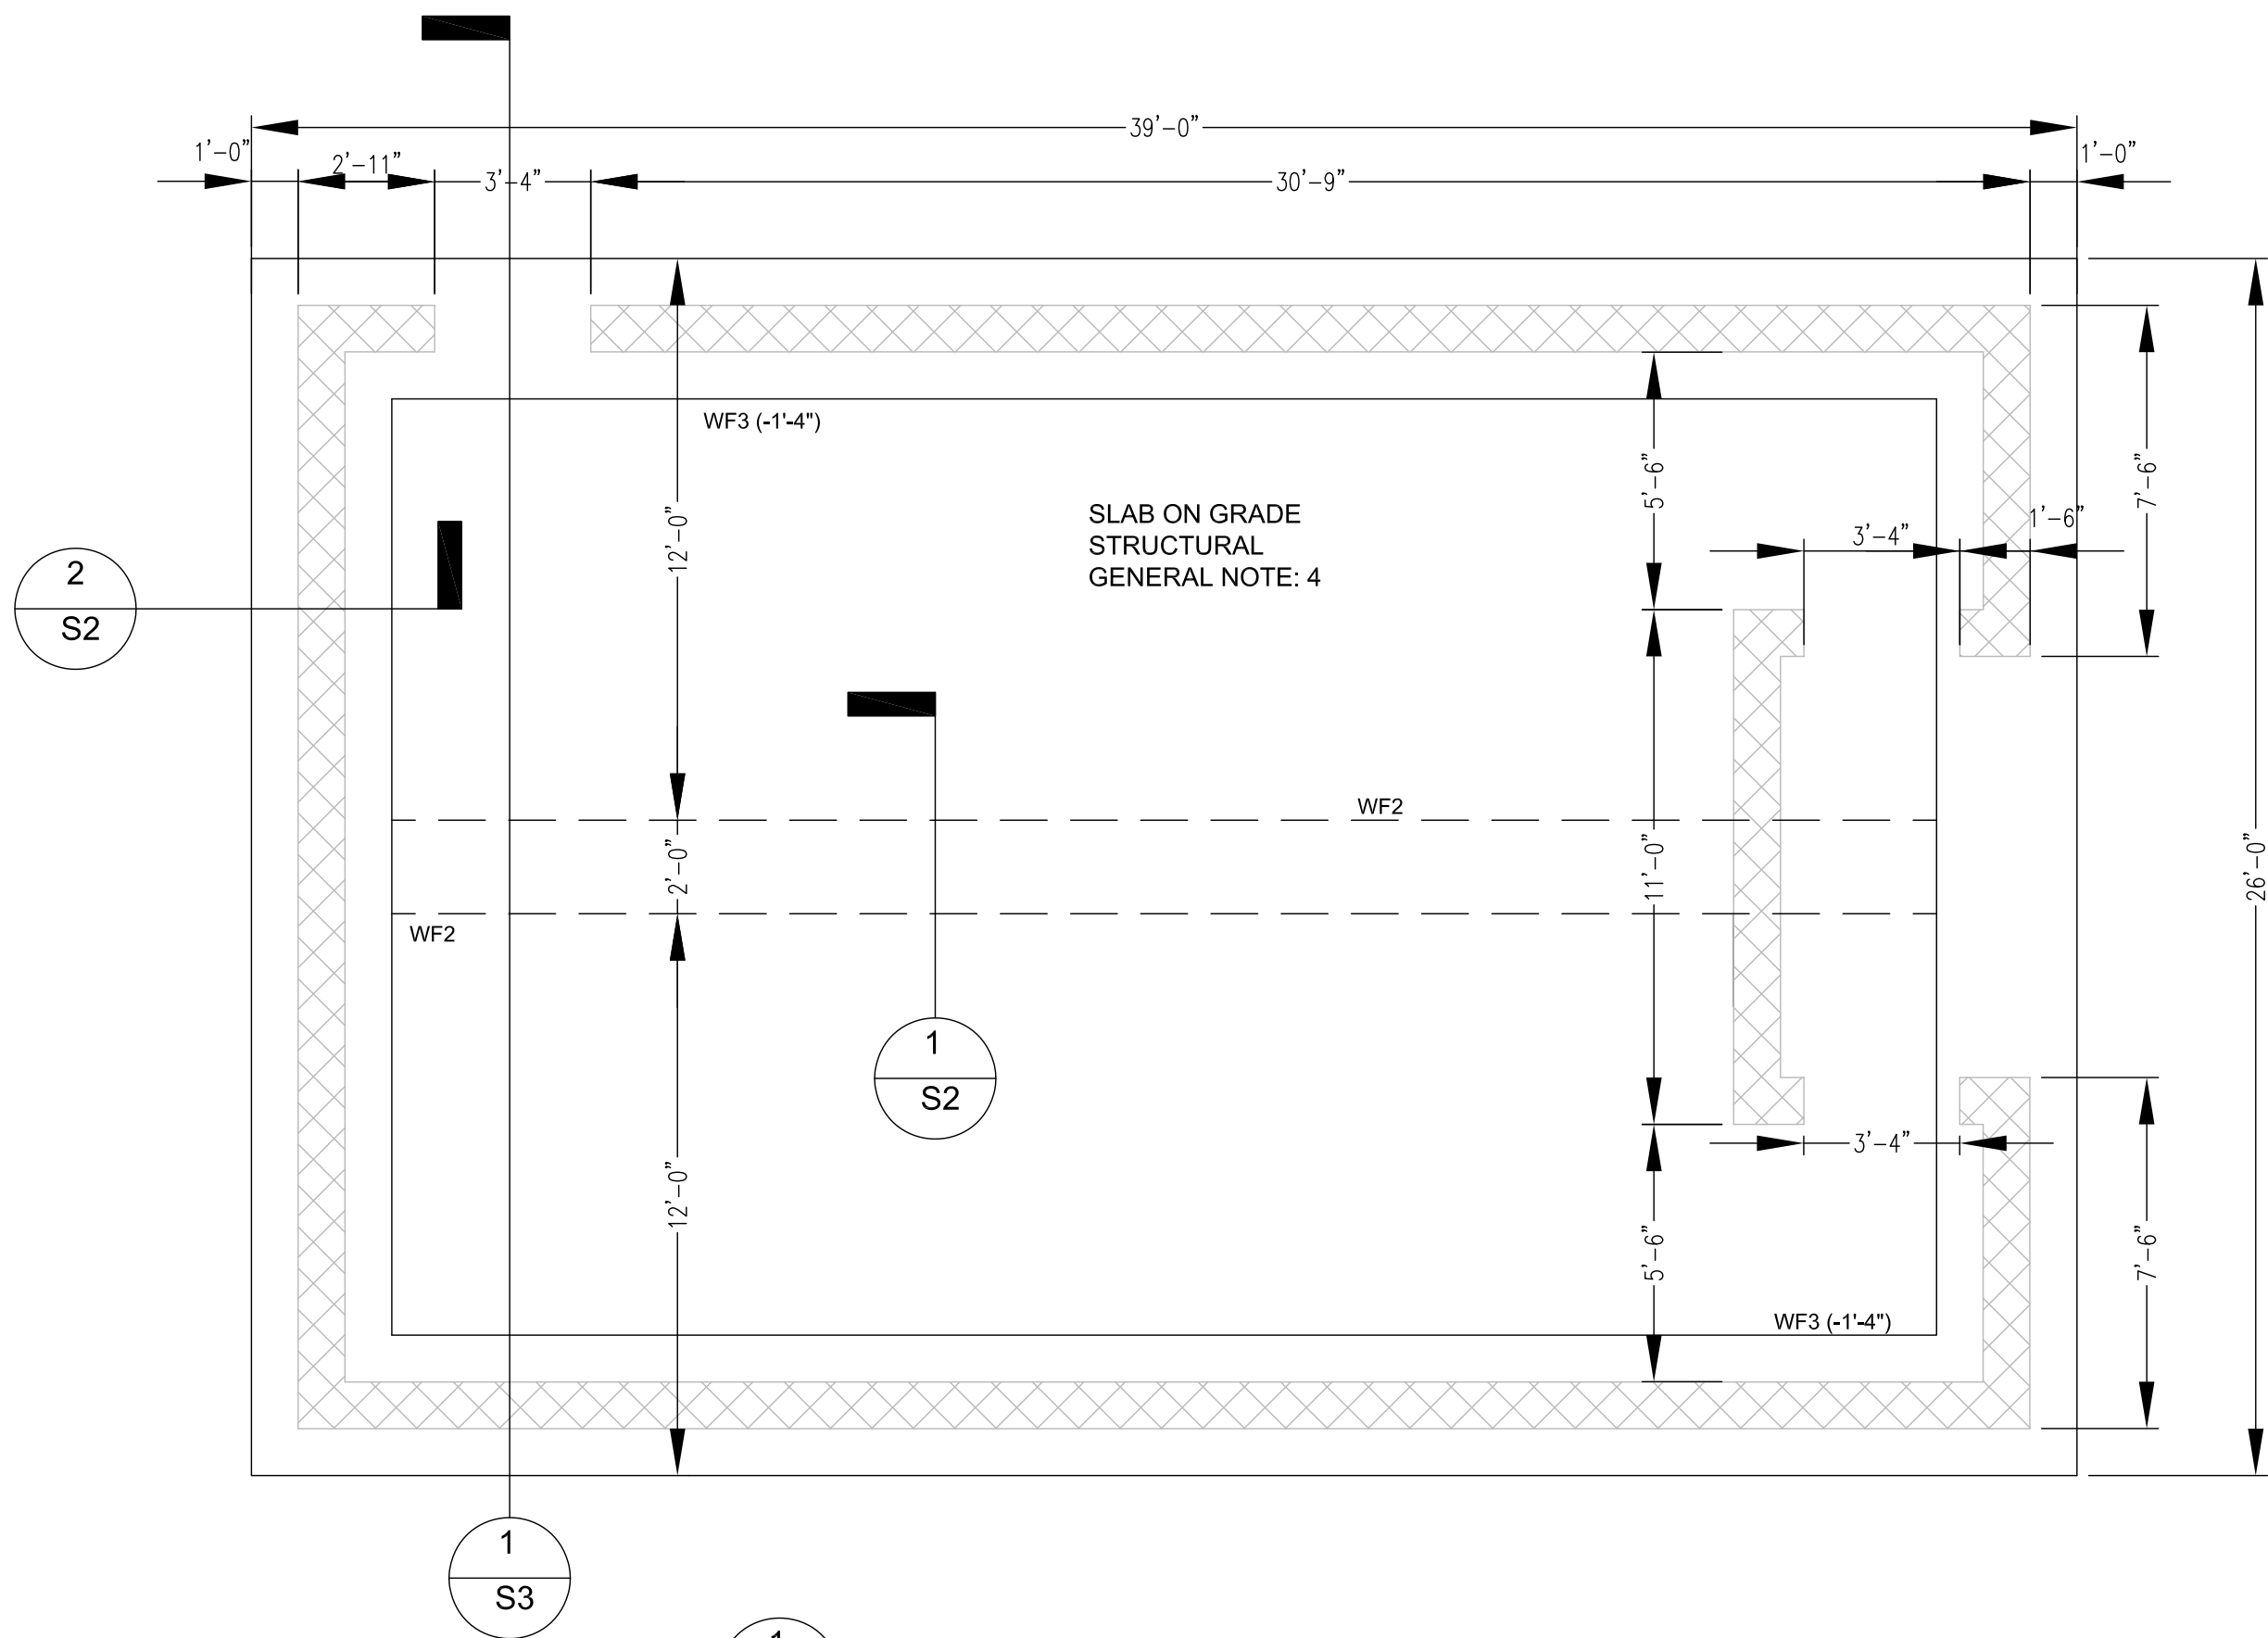


SLAB ON GRADE
STRUCTURAL
GENERAL NOTE: 4

1
S3 FIRST FLOOR PLAN
SCALE: 1/4" = 1'-0"


Designed	D-DATE
Drawn	DR-DATE
Checked	C-DATE
Approved	Date
Title	
ADDRESS	
CITY-STATE	
Fuquay Varina, North Carolina	
Sheet Title .	
Sheet Number.	
S1	

WF3

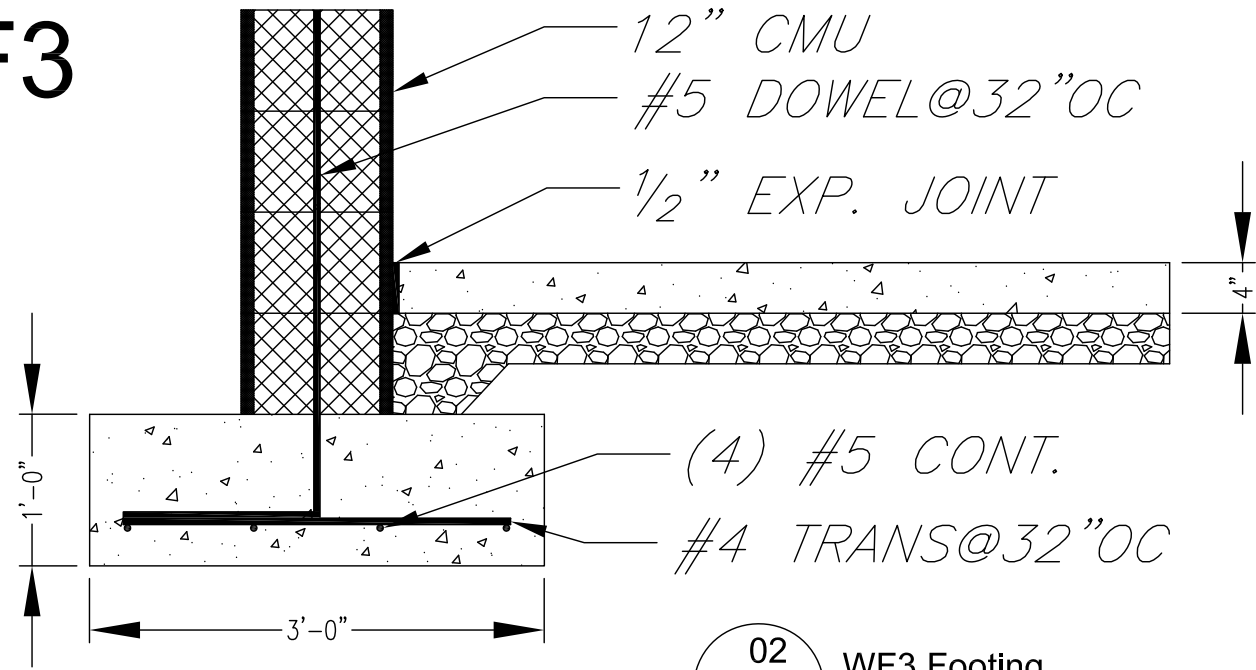


02 WF3 Footing
S2 SCALE: 3/4" = 1'-0"


WF2

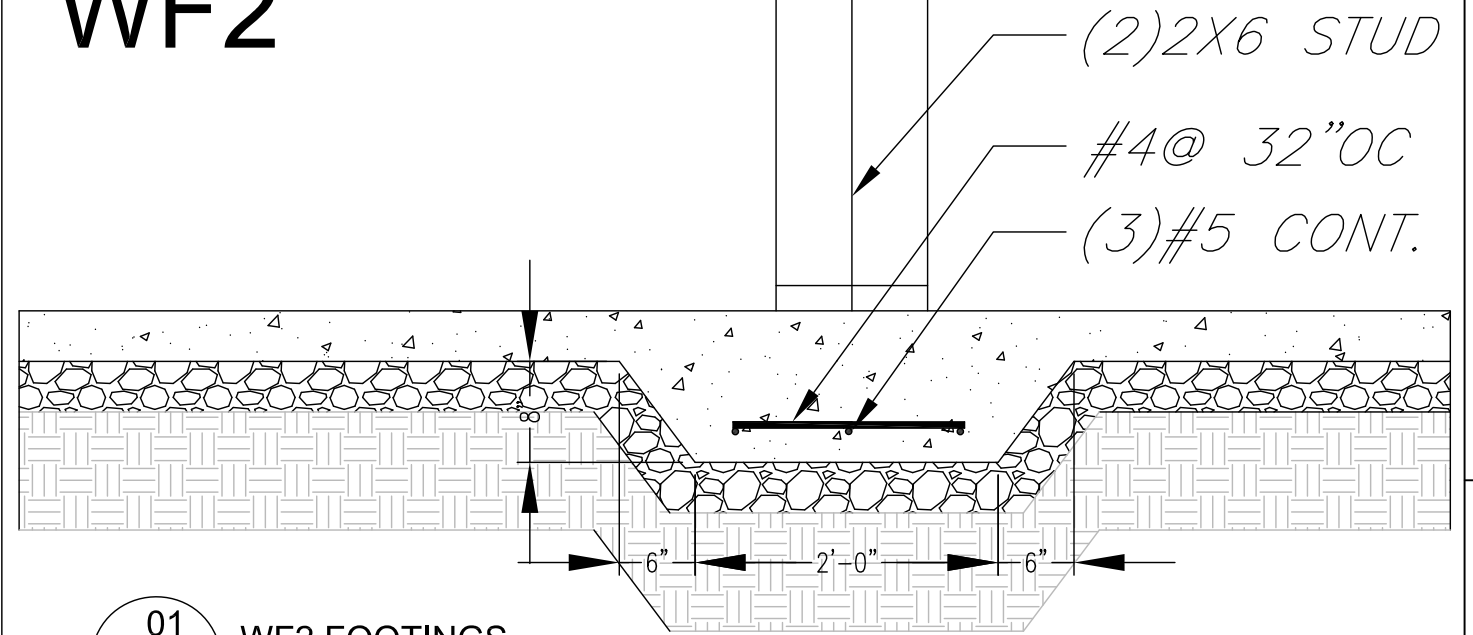


01 WF2 FOOTINGS
S2 SCALE: 3/4" = 1'-0"

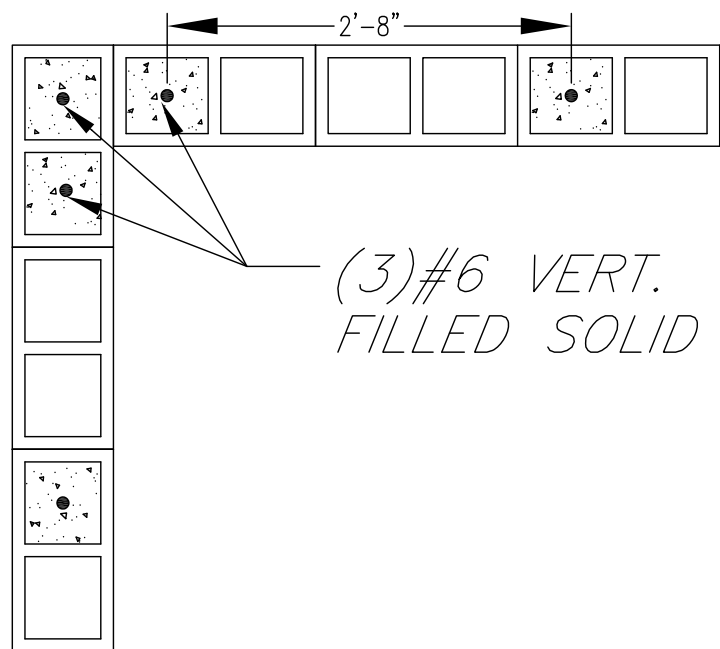

03 CMU CORNER DETAIL
S2 SCALE: 3/4" = 1'-0"

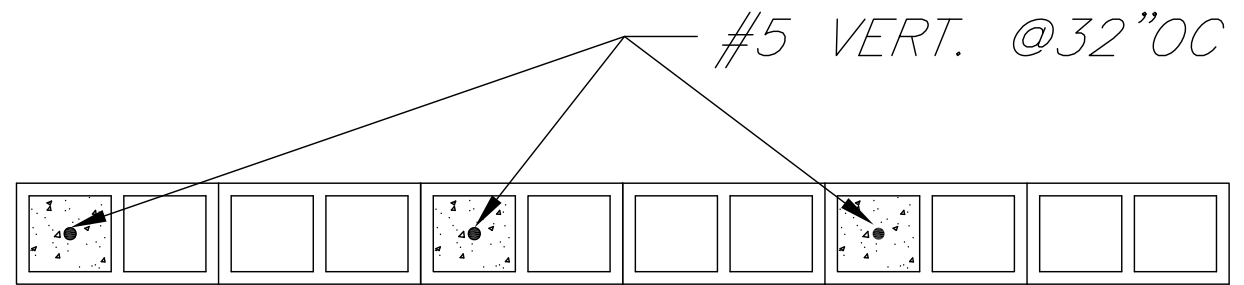


04 CONT. CMU WALL DETAIL
S2 SCALE: 3/4" = 1'-0"

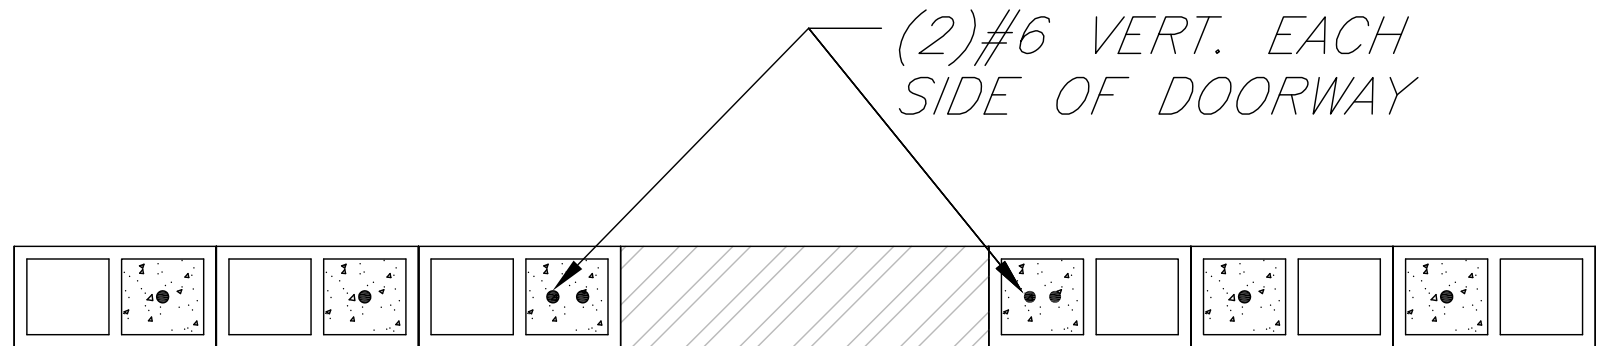


05 CMU DOOR WAY DETAIL
S2 SCALE: 3/4" = 1'-0"


Designed	D-DATE
Drawn	DR-DATE
Checked	C-DATE
Approved	Date
Title	
ADDRESS	
CITY-STATE	Fuquay Varina, North Carolina
Sheet Title	
Sheet Number	S2

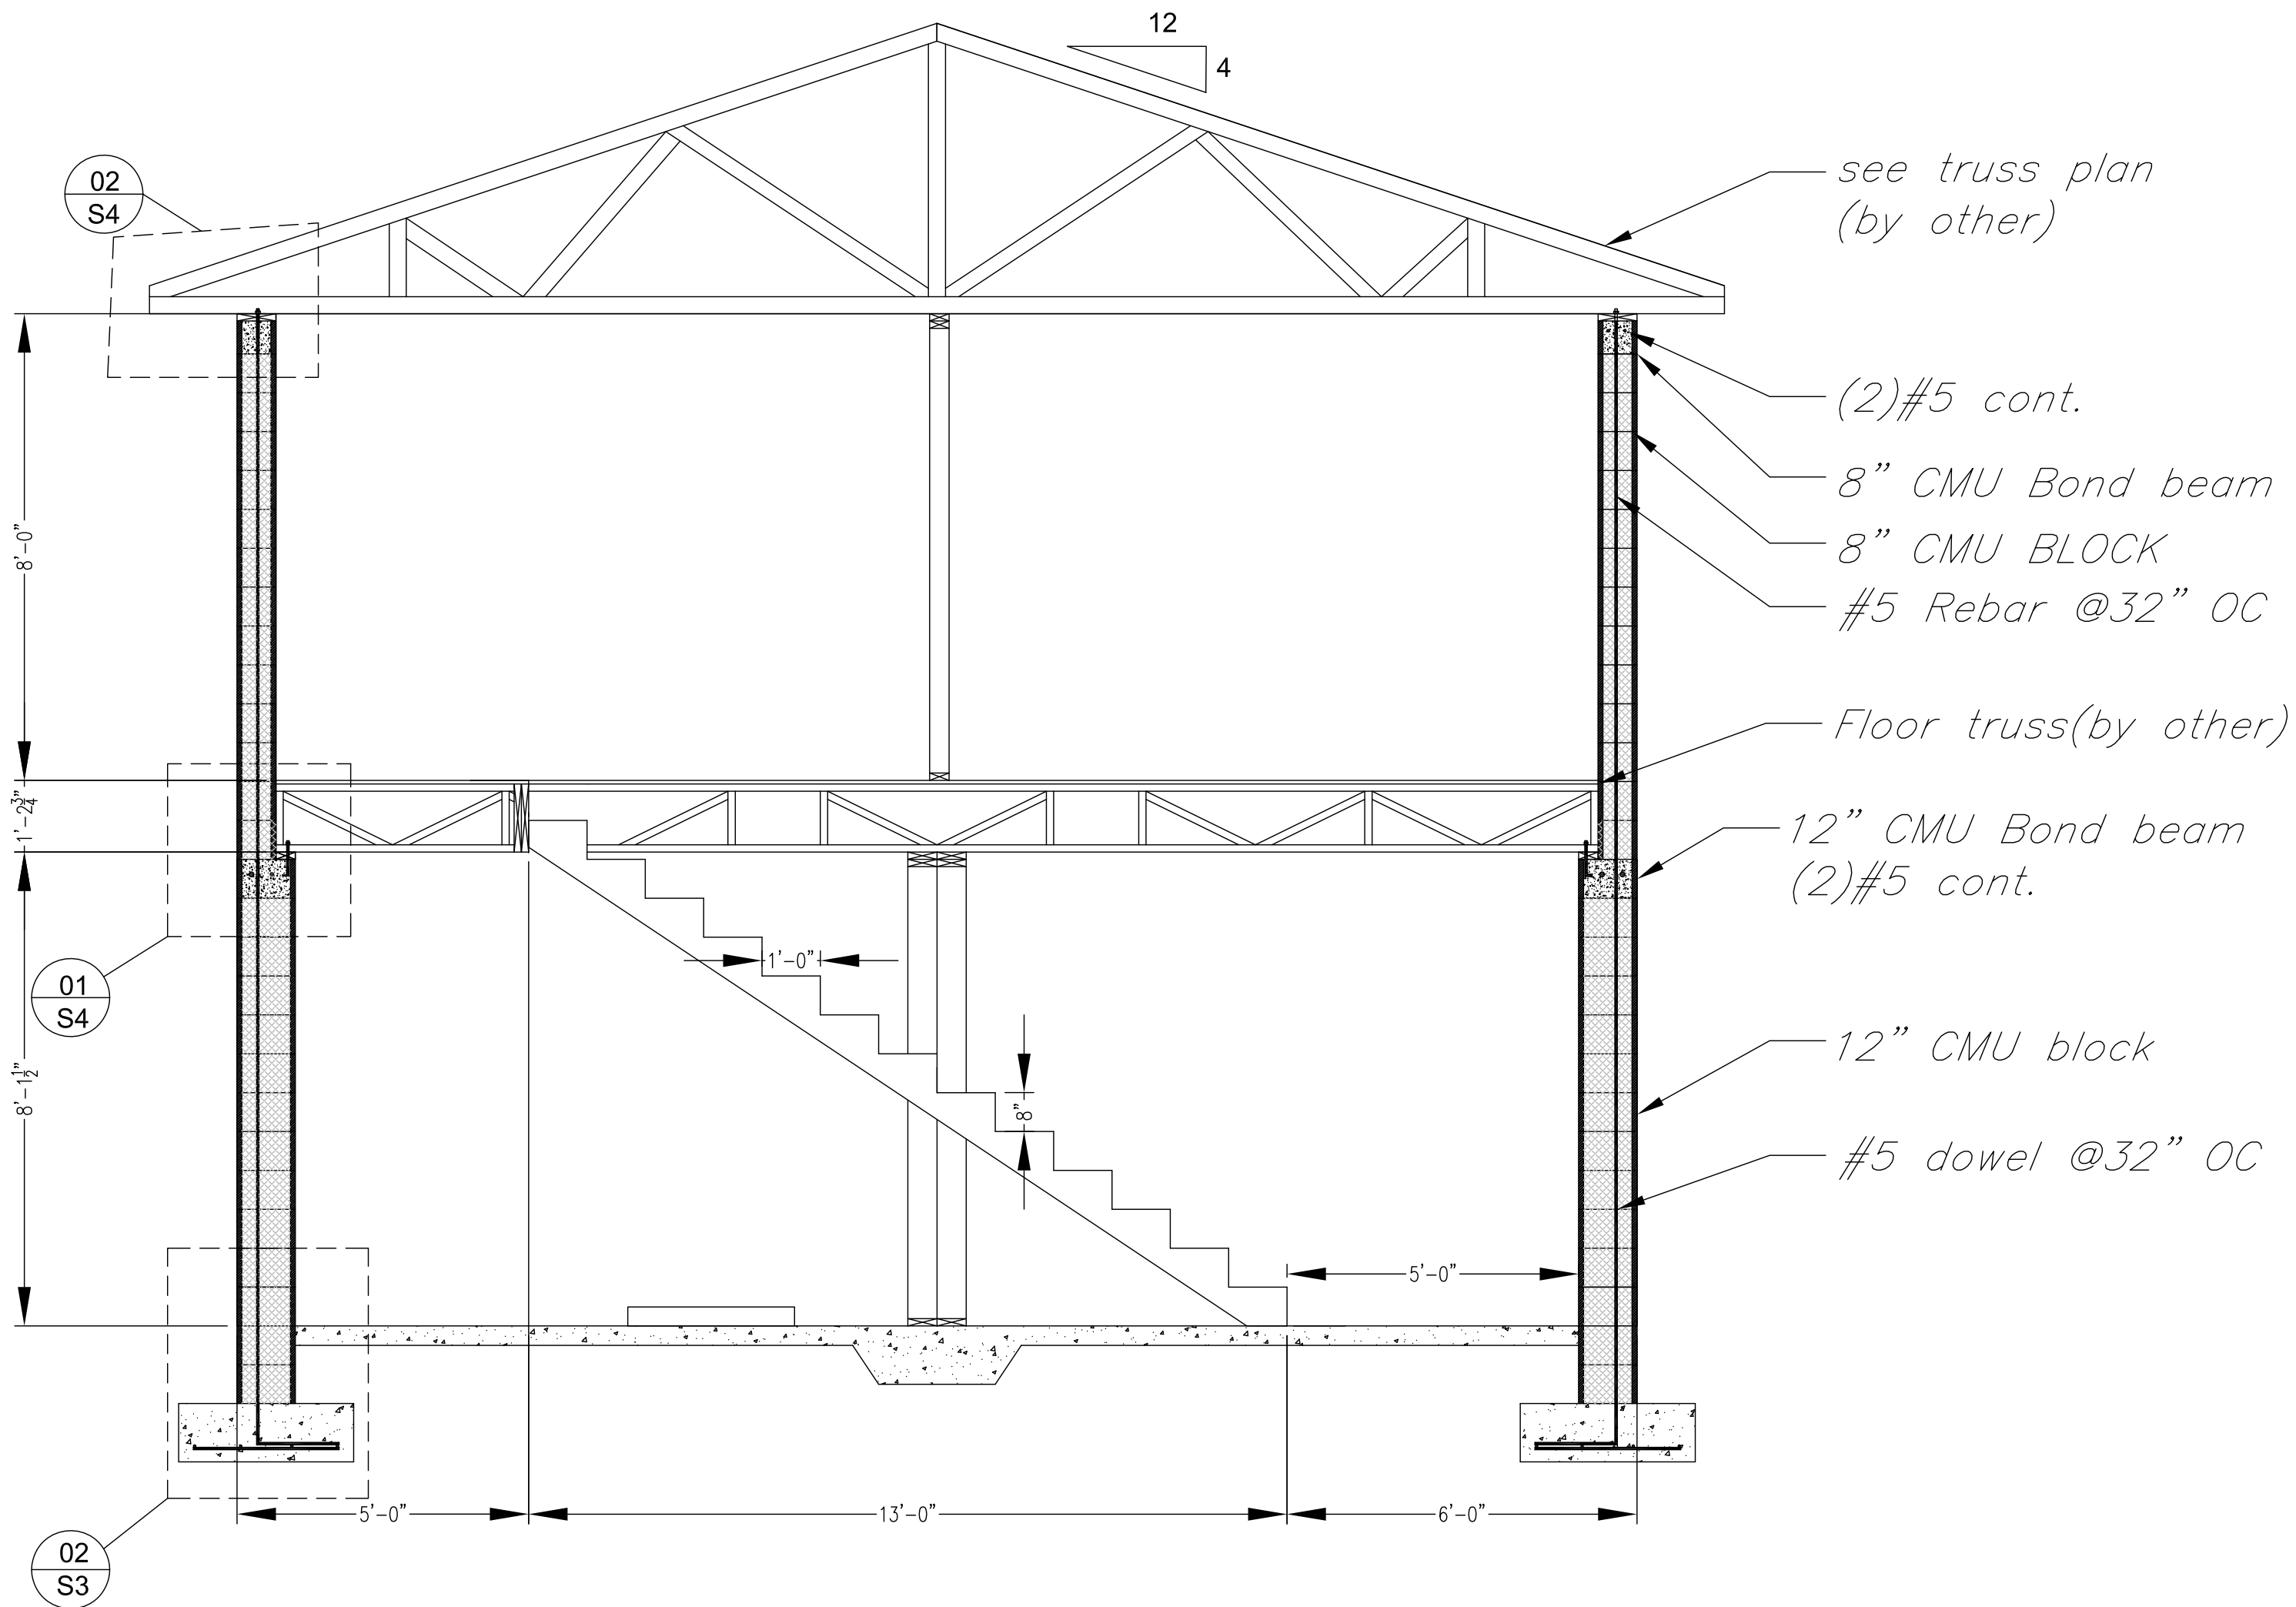

Designed	D-DATE
Drawn	DR-DATE
Checked	C-DATE
Approved	Date
Title	
ADDRESS	
CITY-STATE	
Fuquay Varina, North Carolina	
Sheet Title .	
Sheet Number.	
S3	

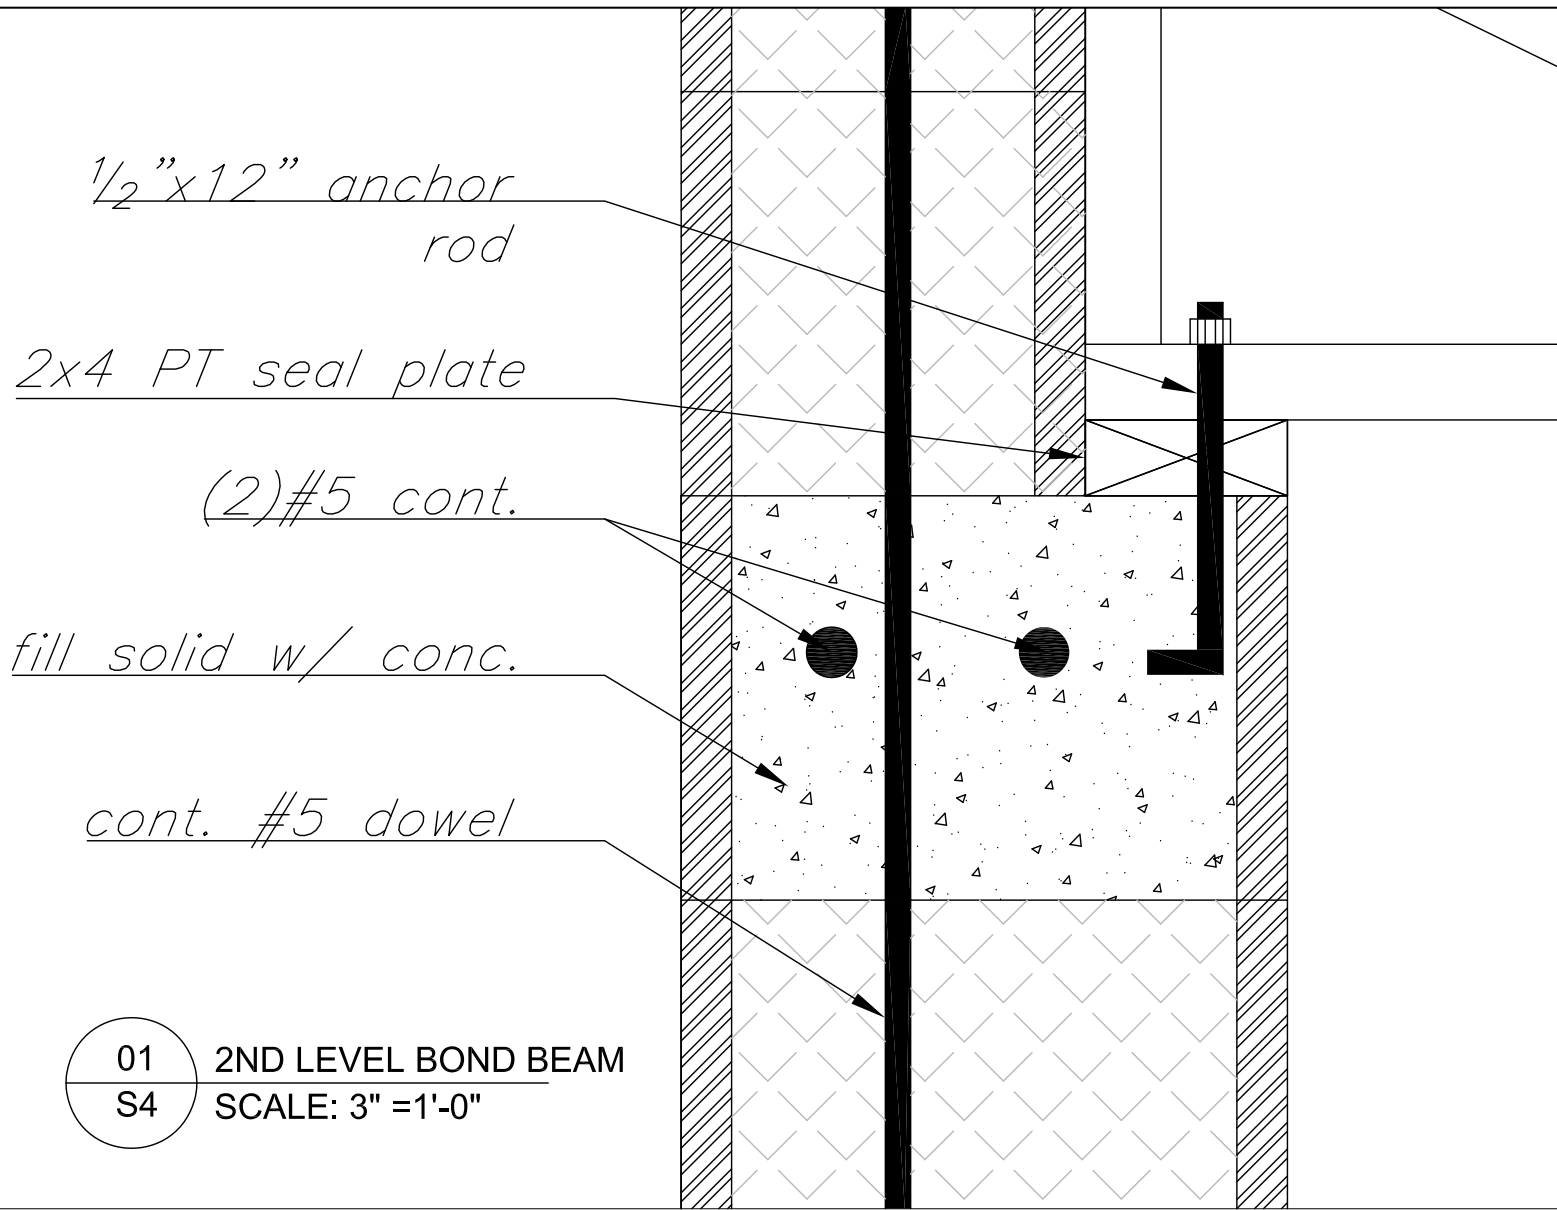

01 2ND LEVEL BOND BEAM
S4 SCALE: 3" = 1'-0"

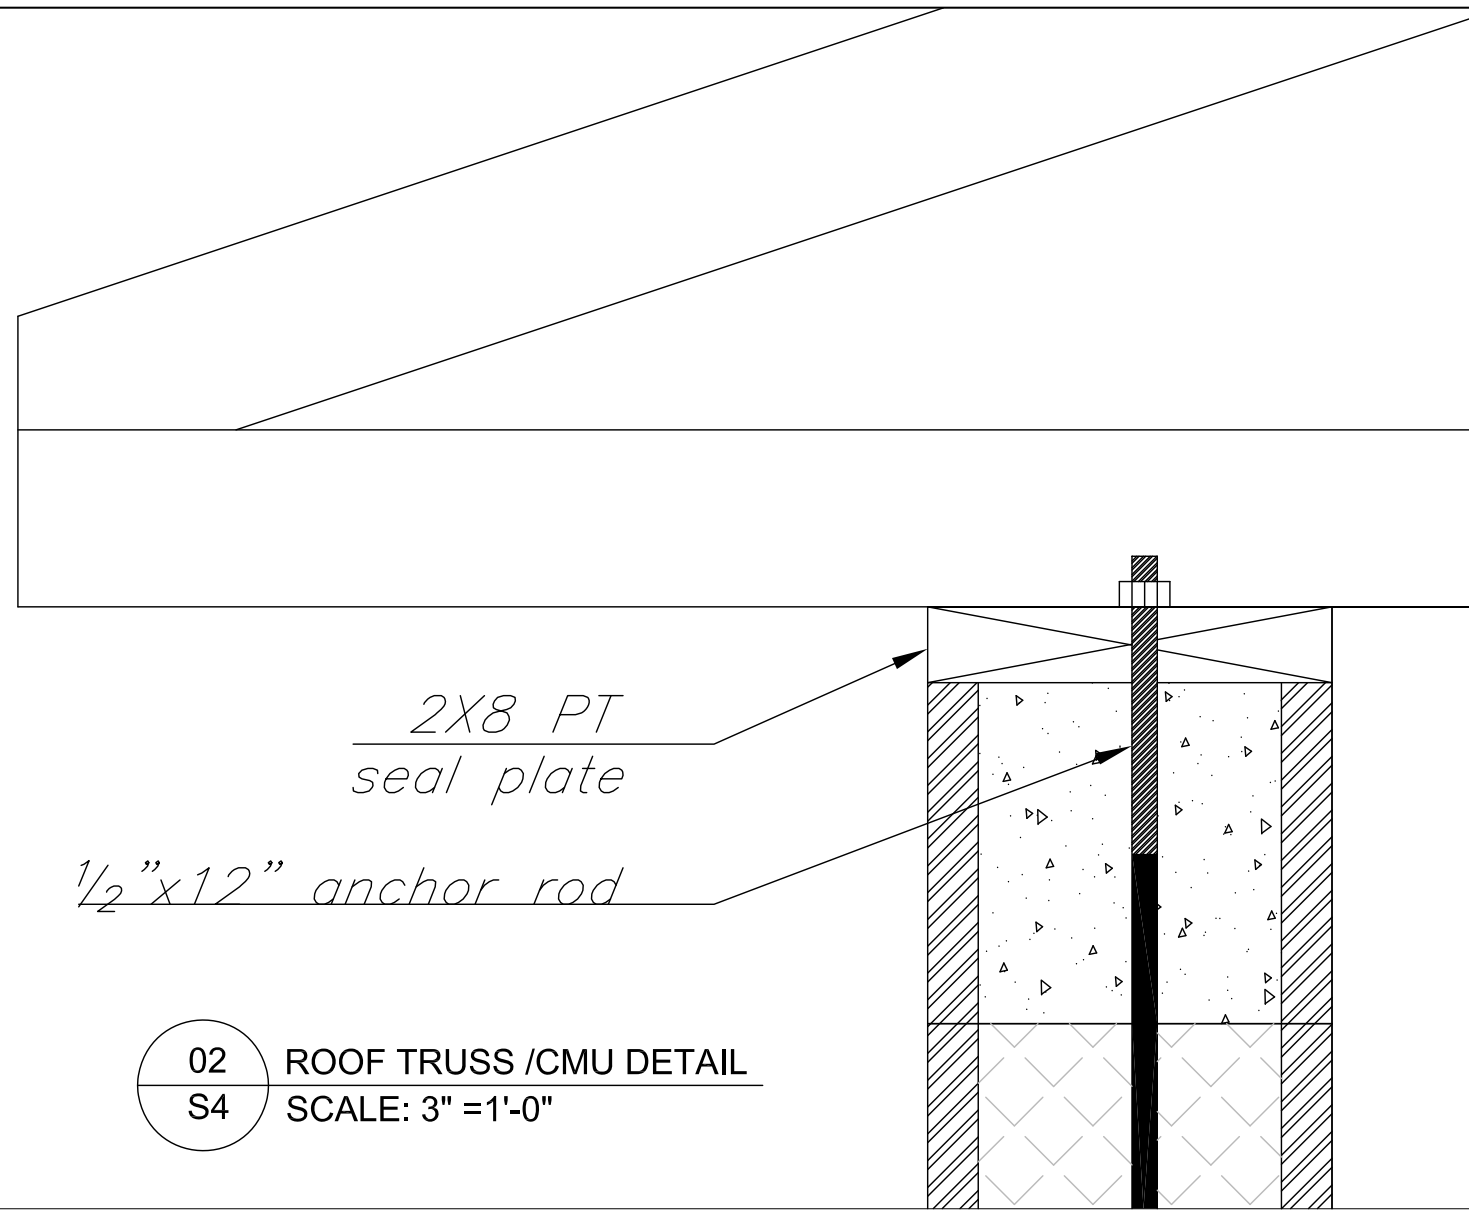

02 ROOF TRUSS /CMU DETAIL
S4 SCALE: 3" = 1'-0"

Designed	D-DATE
Drawn	DR-DATE
Checked	C-DATE
Approved	Date
Title	

ADDRESS


CITY-STATE

Fuquay Varina, North Carolina

Sheet Title .

Sheet Number.


S4

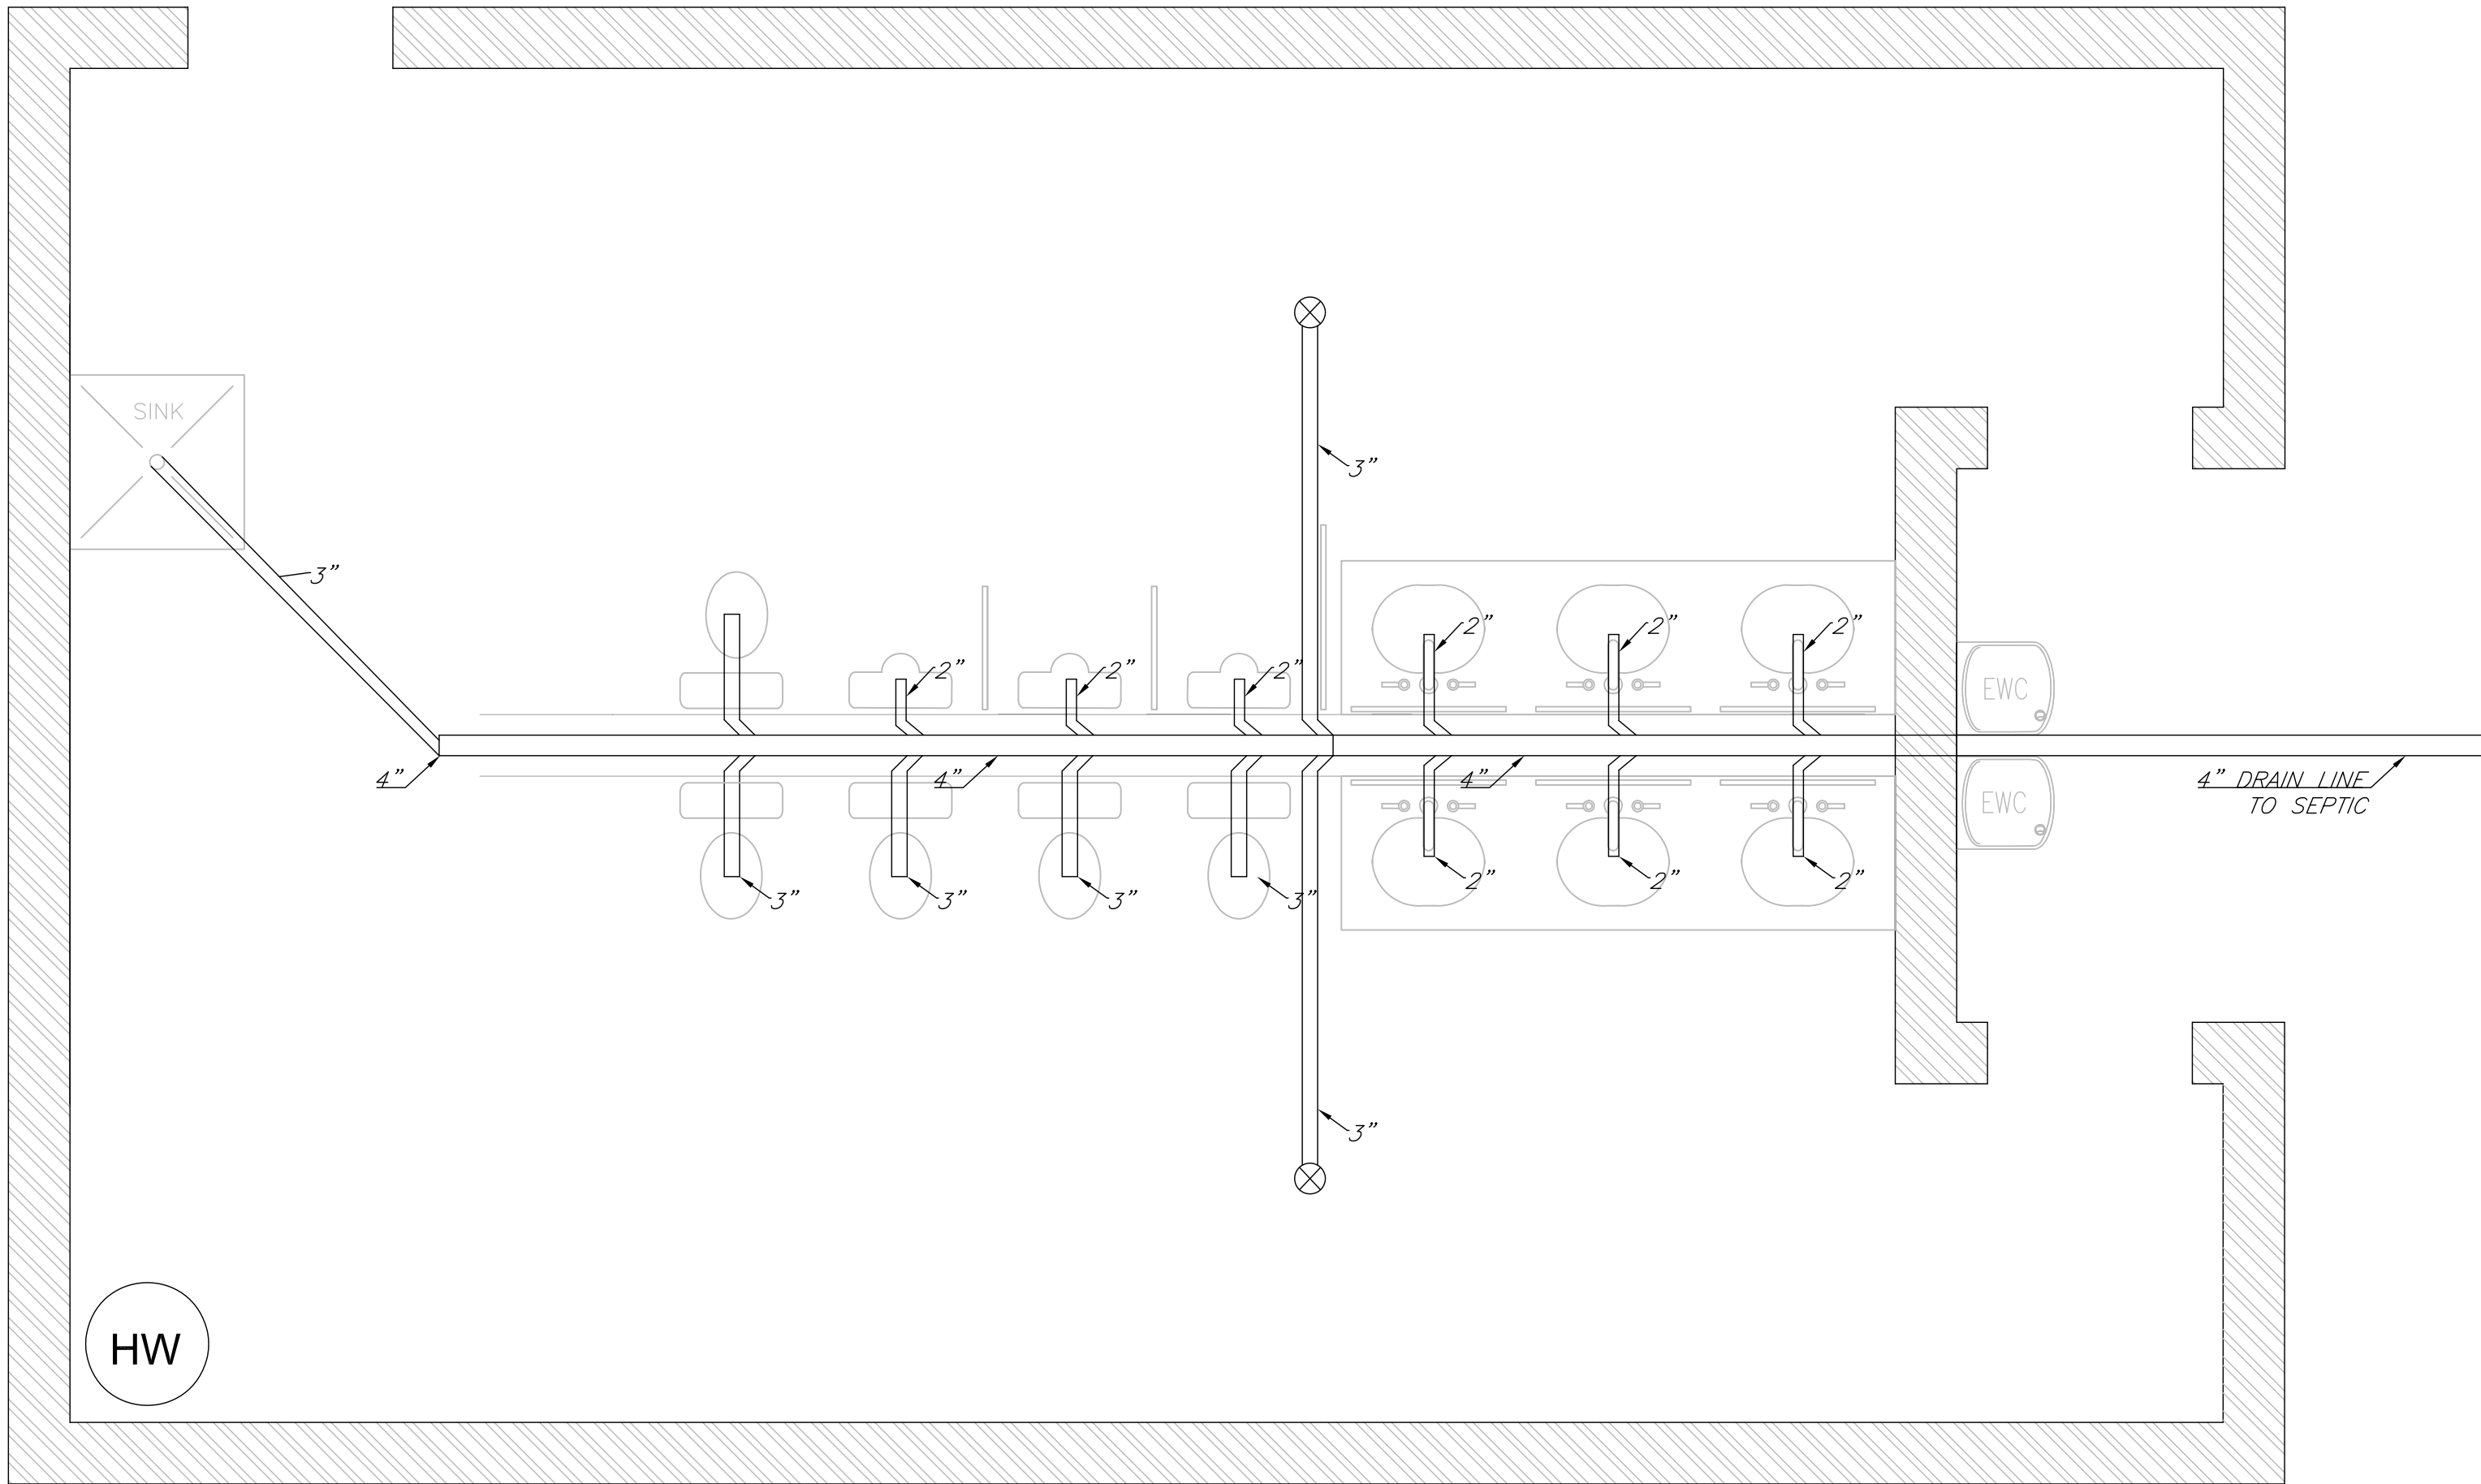

HW


01 PLUMBING DRAINAGE
 P1 SCALE: 3/8" = 1'-0"

Designed	D-DATE
Drawn	DR-DATE
Checked	C-DATE
Approved	Date
Title	
ADDRESS	
CITY-STATE	
Fuquay Varina, North Carolina	
Sheet Title .	
Sheet Number.	
P1	

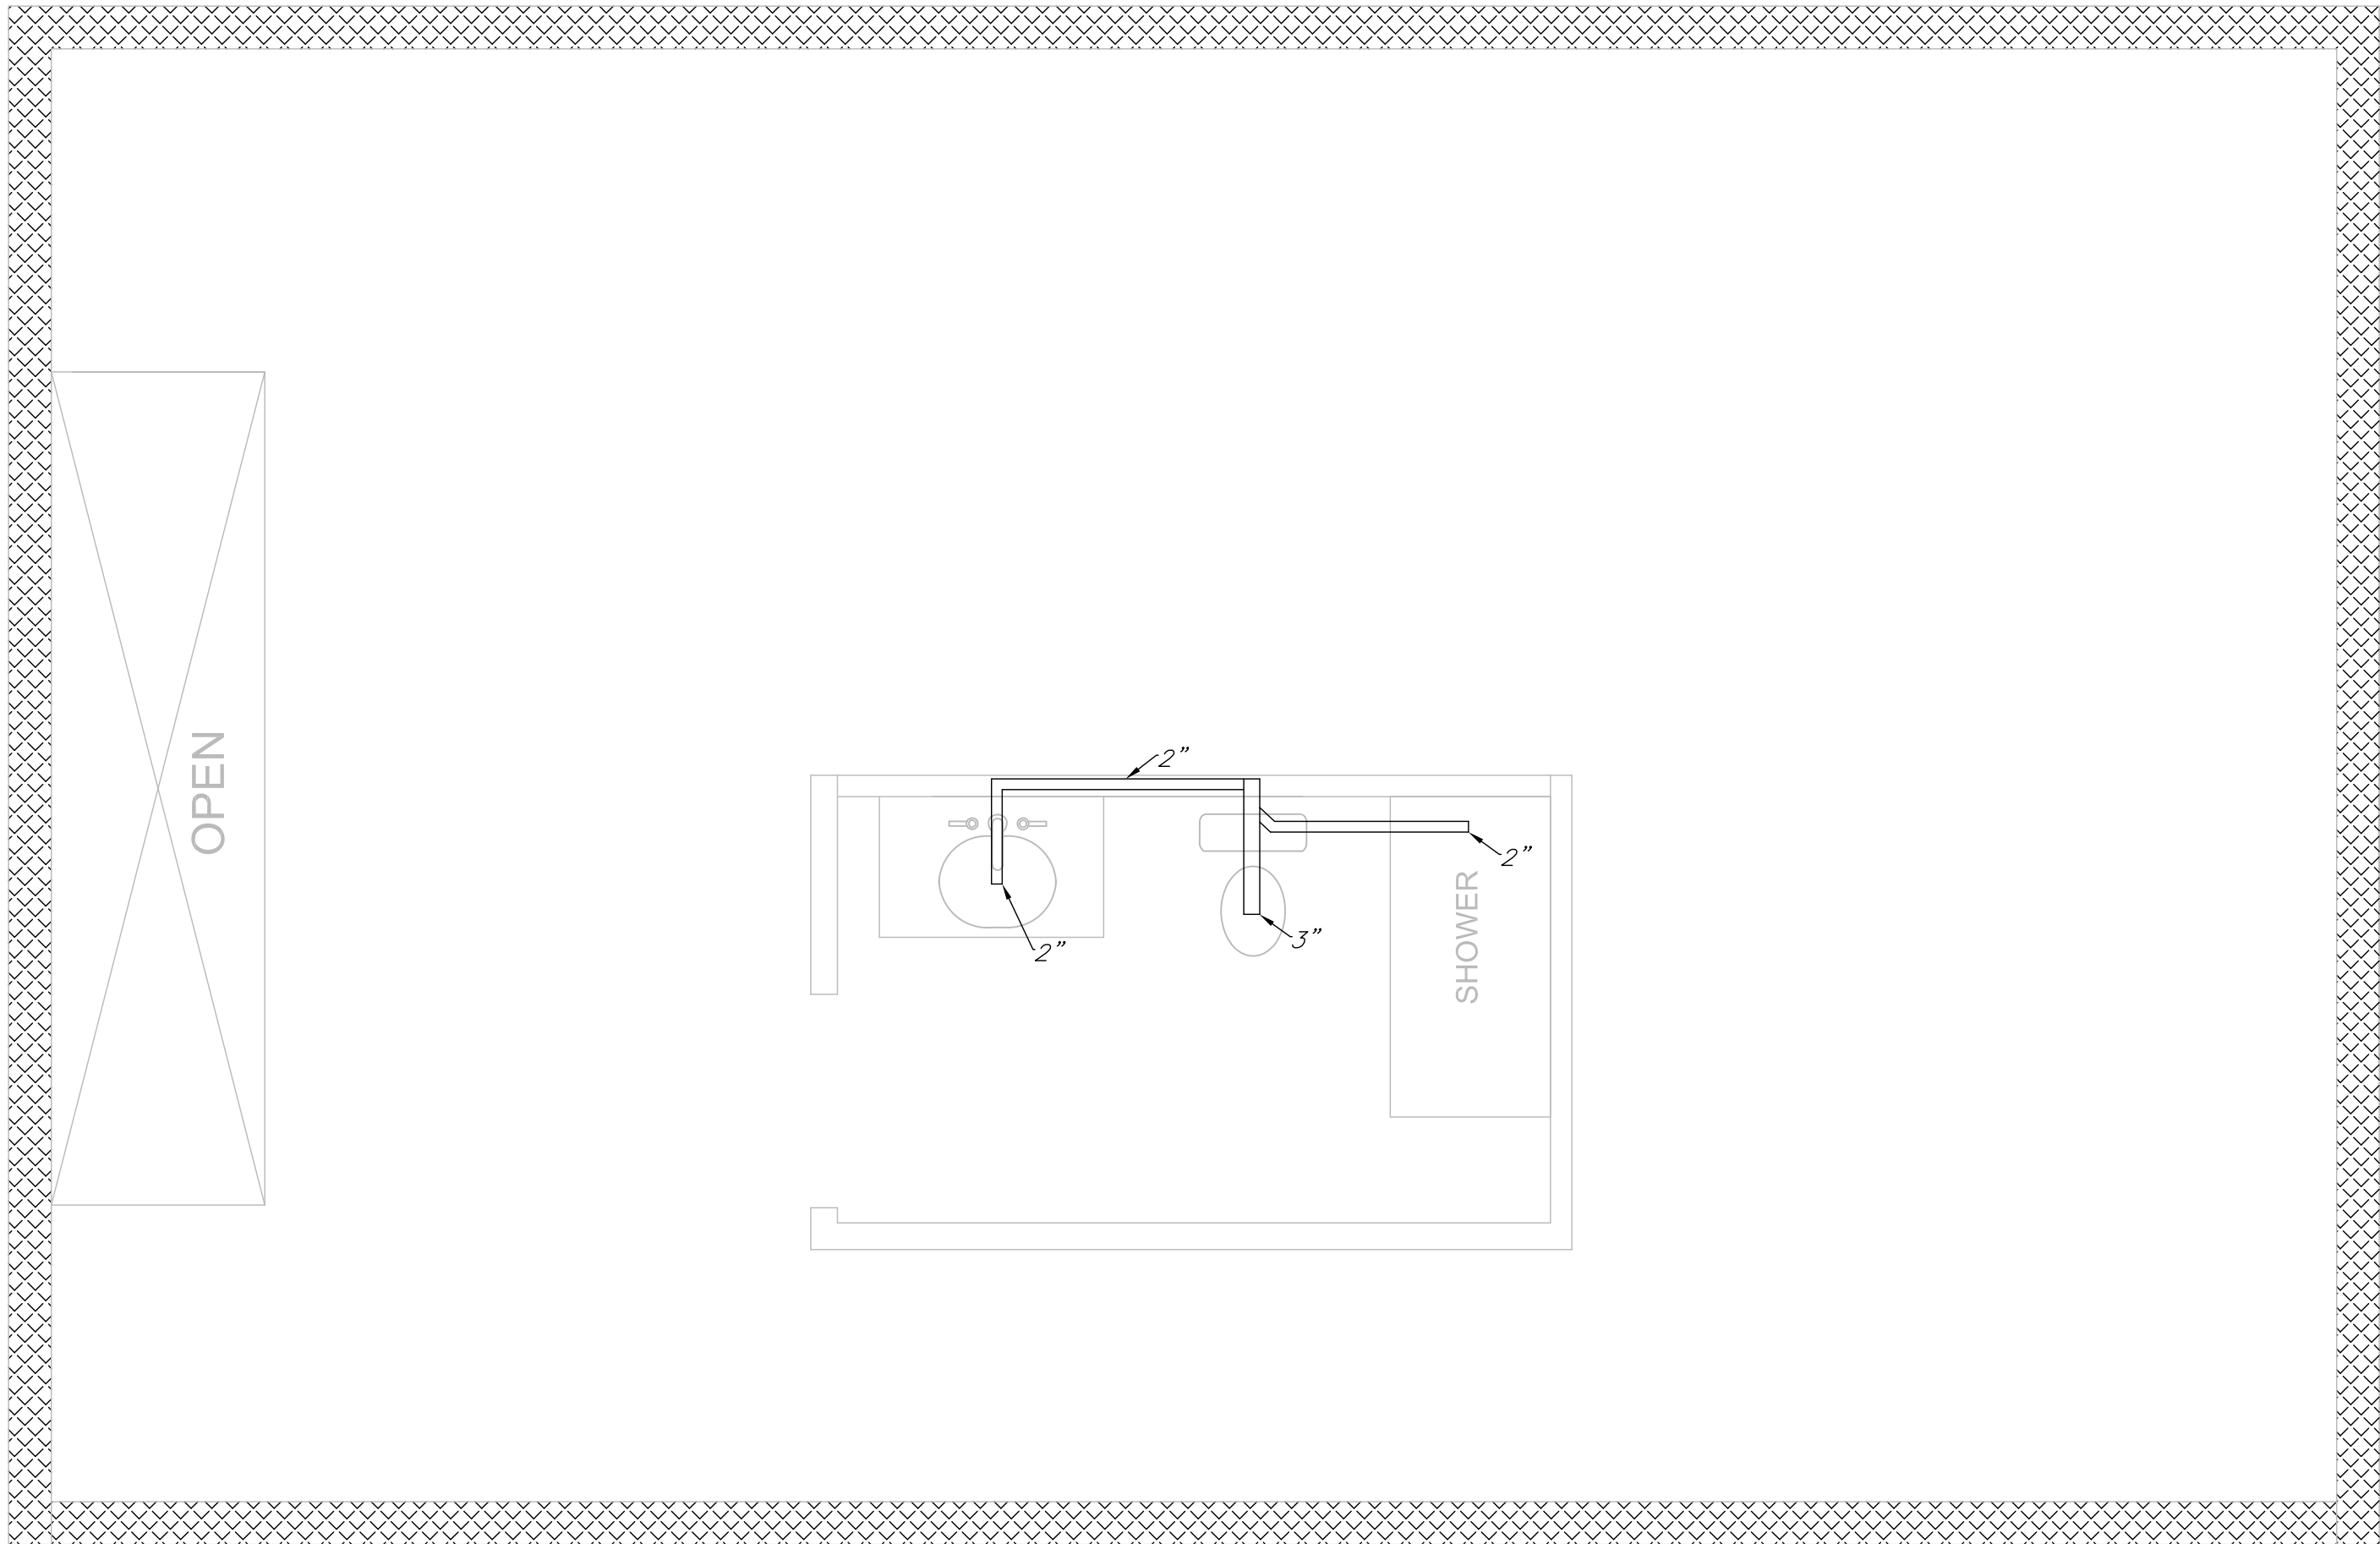


01 2ND FLOOR PLUMBING DRAINAGE
 P2 SCALE: 3/8" = 1'-0"

Designed	D-DATE
Drawn	DR-DATE
Checked	C-DATE
Approved	Date
Title	
ADDRESS	
CITY-STATE	
Fuquay Varina, North Carolina	
Sheet Title .	
Sheet Number.	
P2	

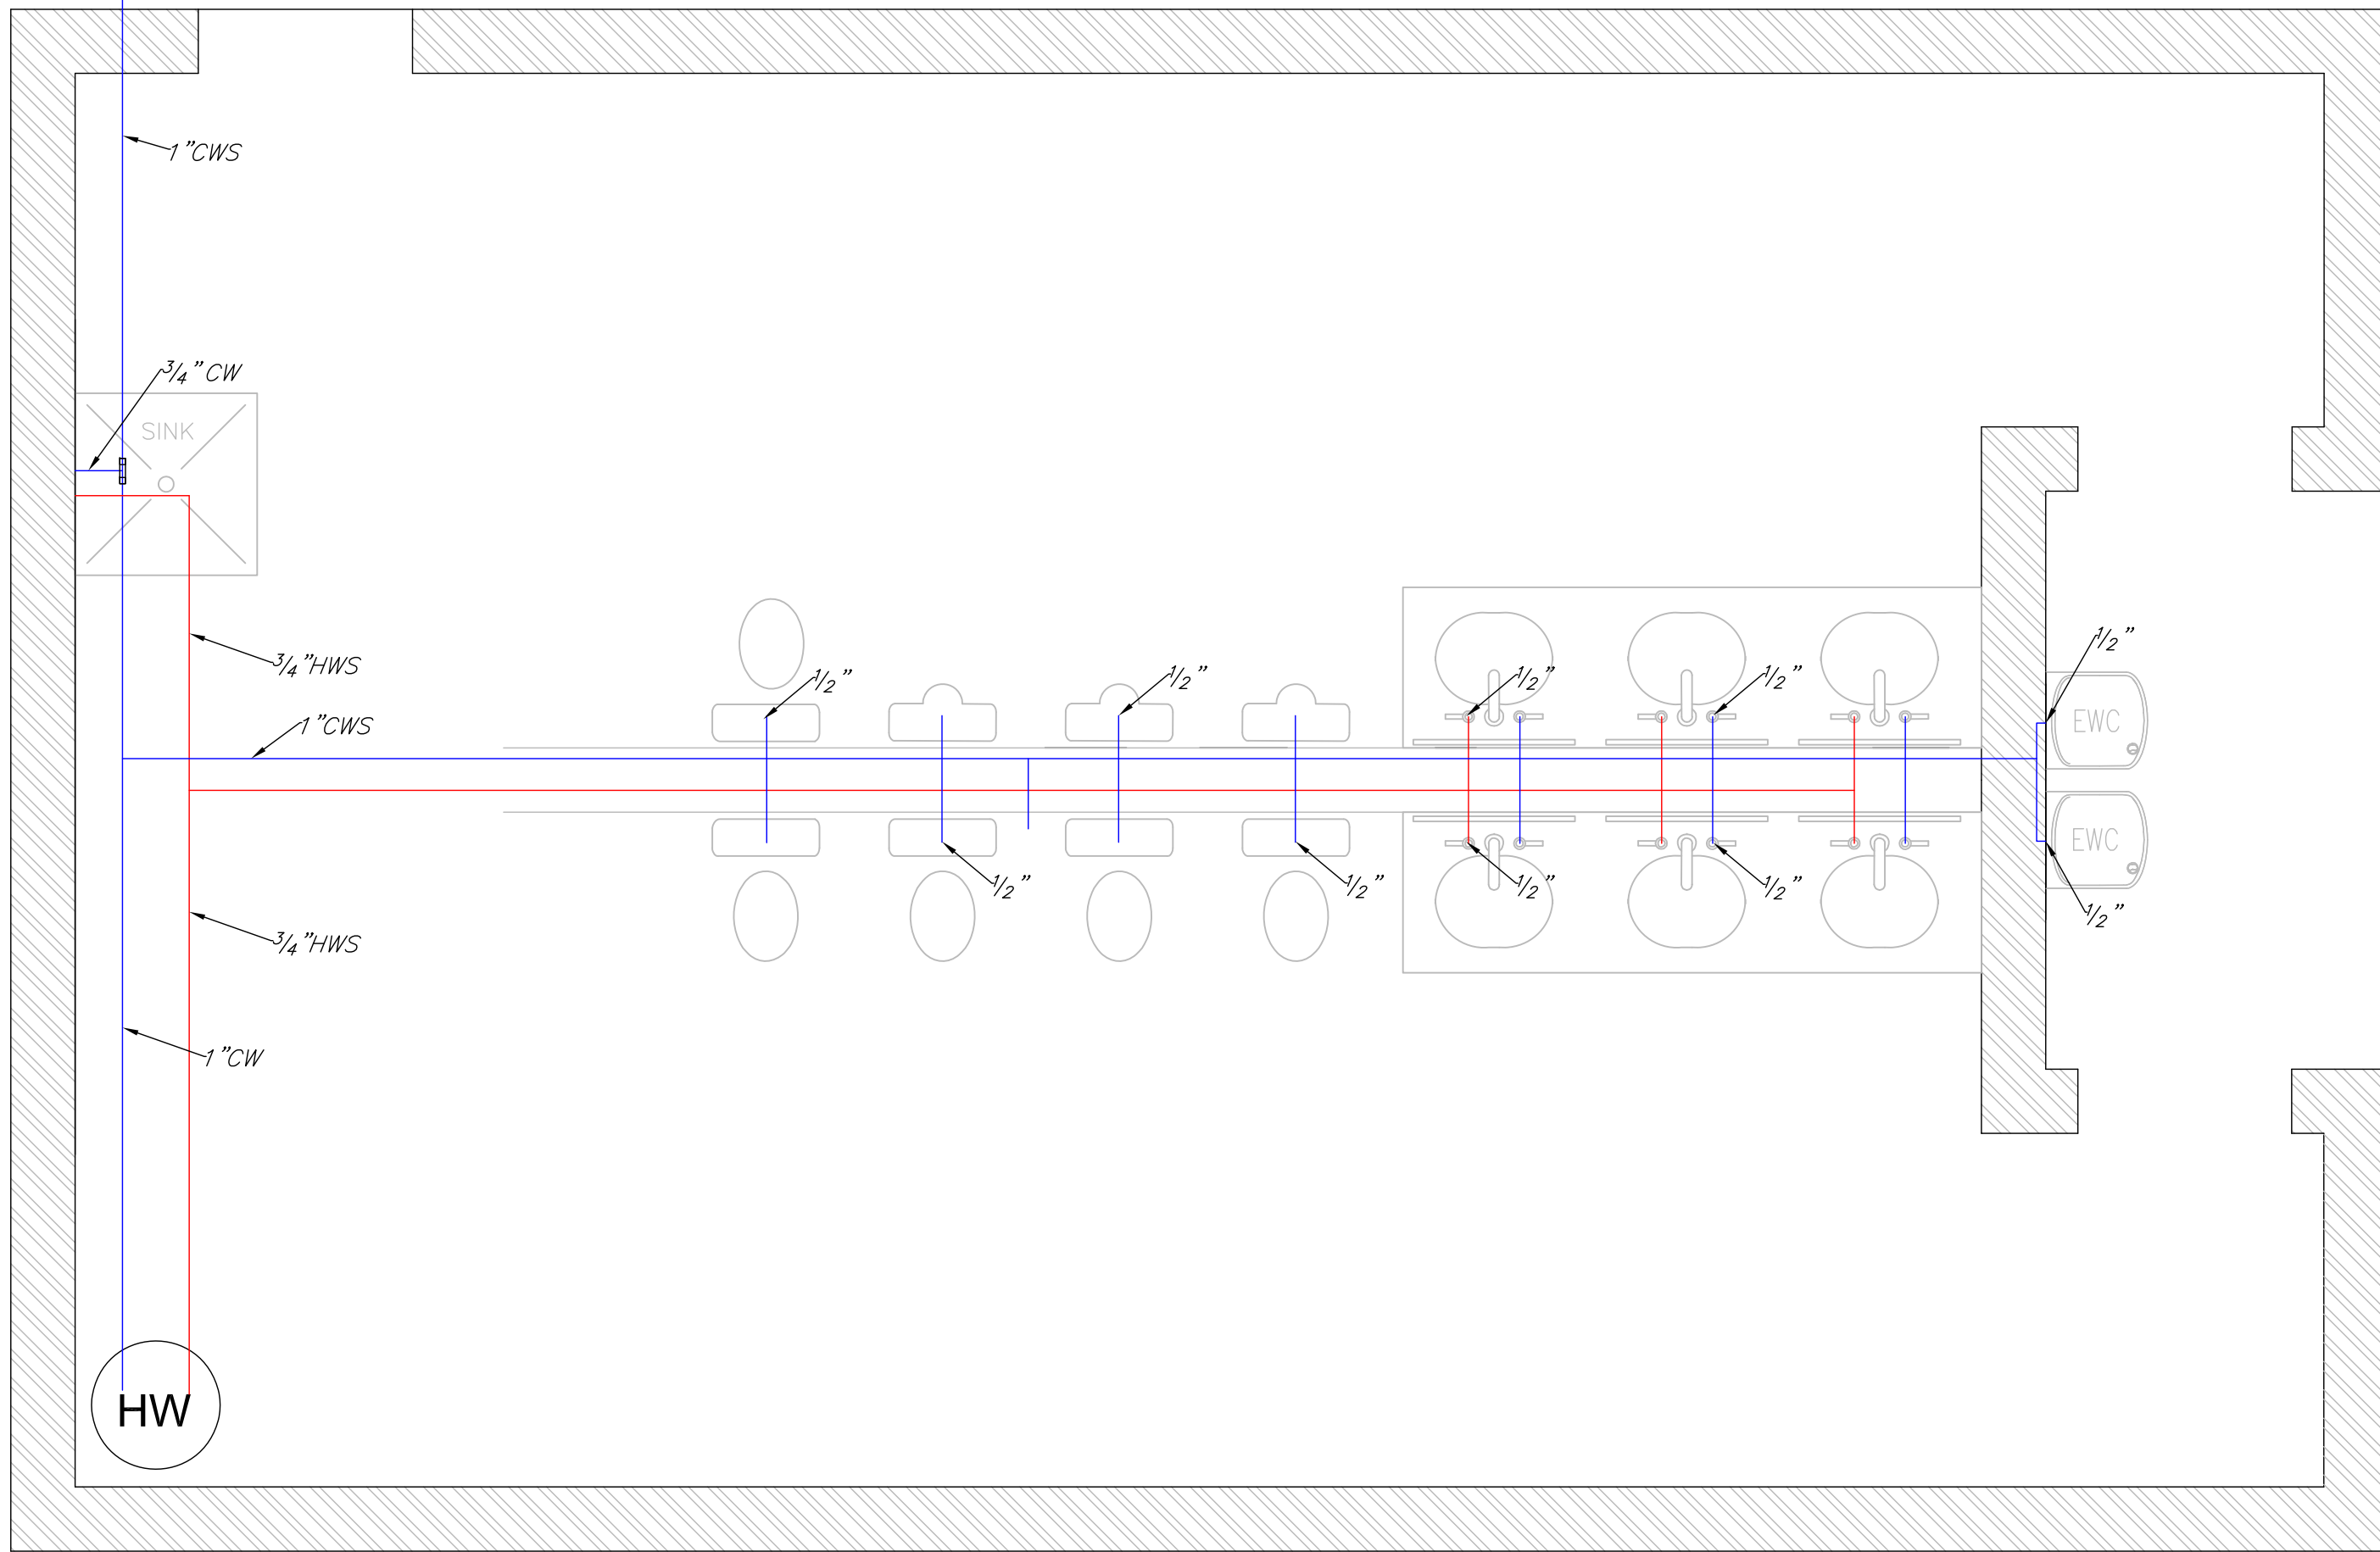


01 1ST FLOOR COLD/HOT WATER PLUMBING
 P3 SCALE: 3/8" = 1'-0"

Designed	D-DATE
Drawn	DR-DATE
Checked	C-DATE
Approved	Date
Title	
ADDRESS	
CITY-STATE	
Fuquay Varina, North Carolina	
Sheet Title .	
Sheet Number.	
P3	

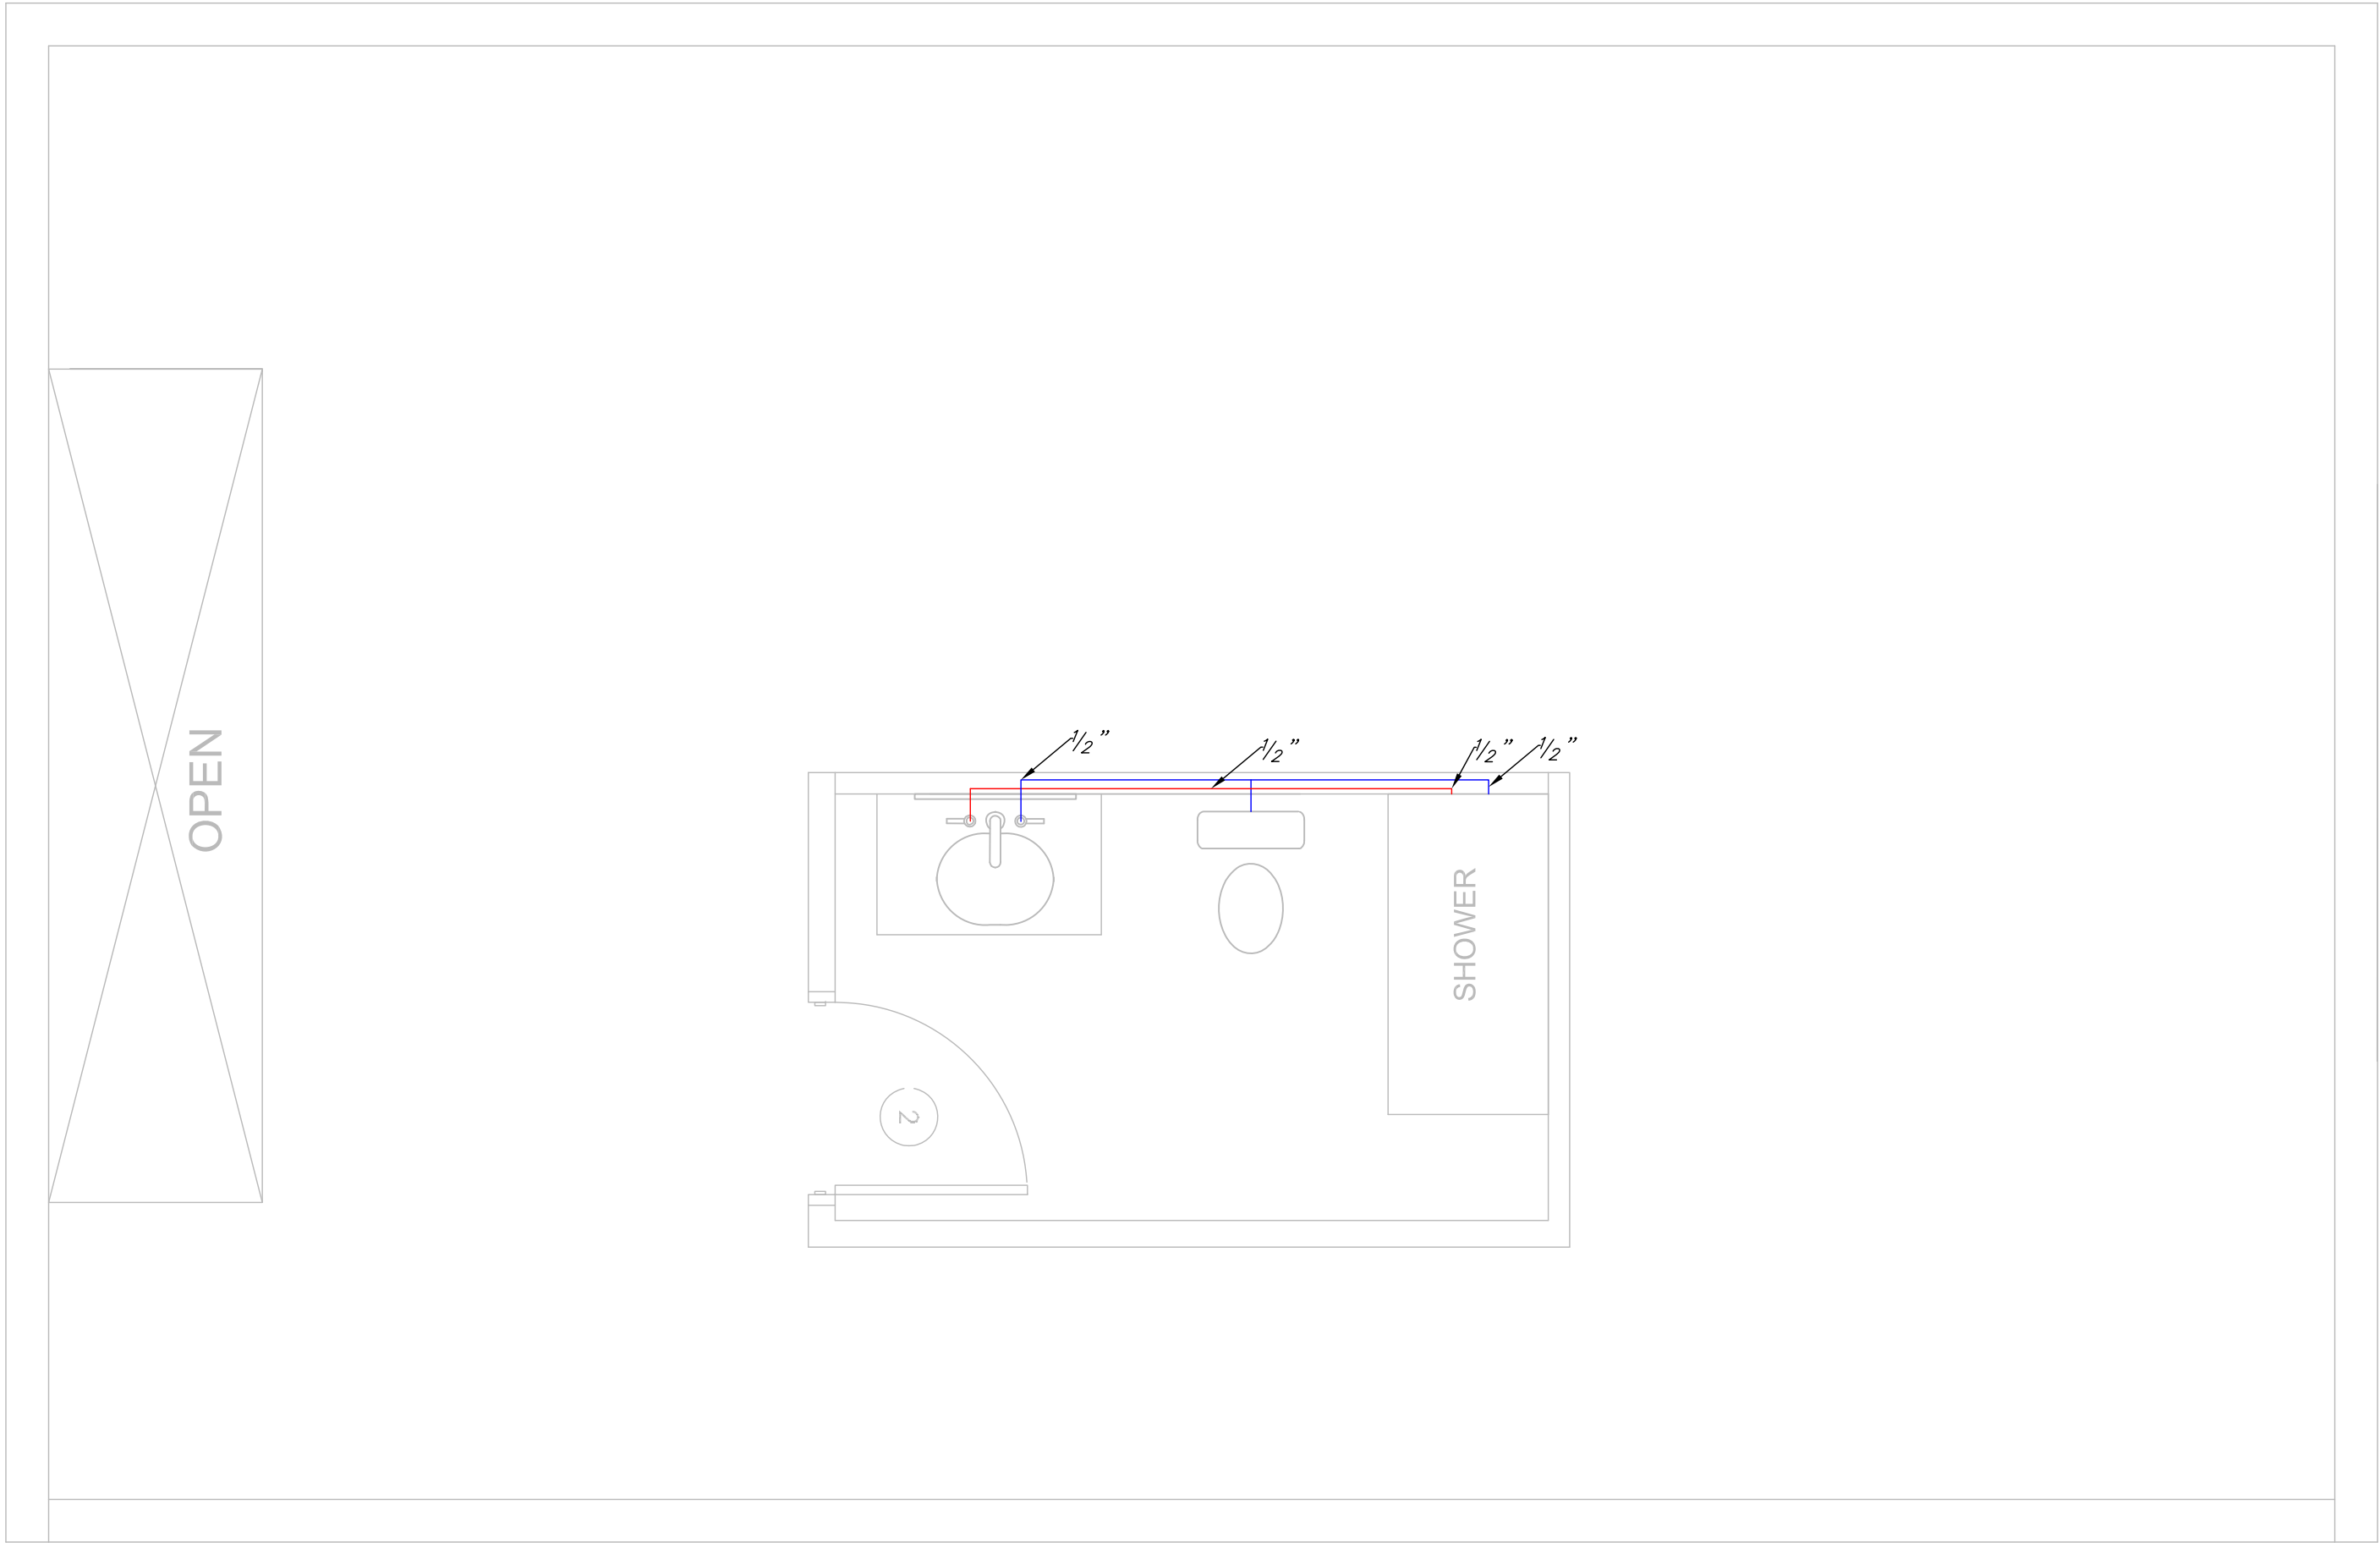


01 2ND FLOOR COLD/HOT WATER PLUMBING
 P4 SCALE: 3/8" = 1'-0"


Designed	D-DATE
Drawn	DR-DATE
Checked	C-DATE
Approved	Date
Title	
ADDRESS	
CITY-STATE	
Fuquay Varina, North Carolina	
Sheet Title .	
Sheet Number.	
P4	

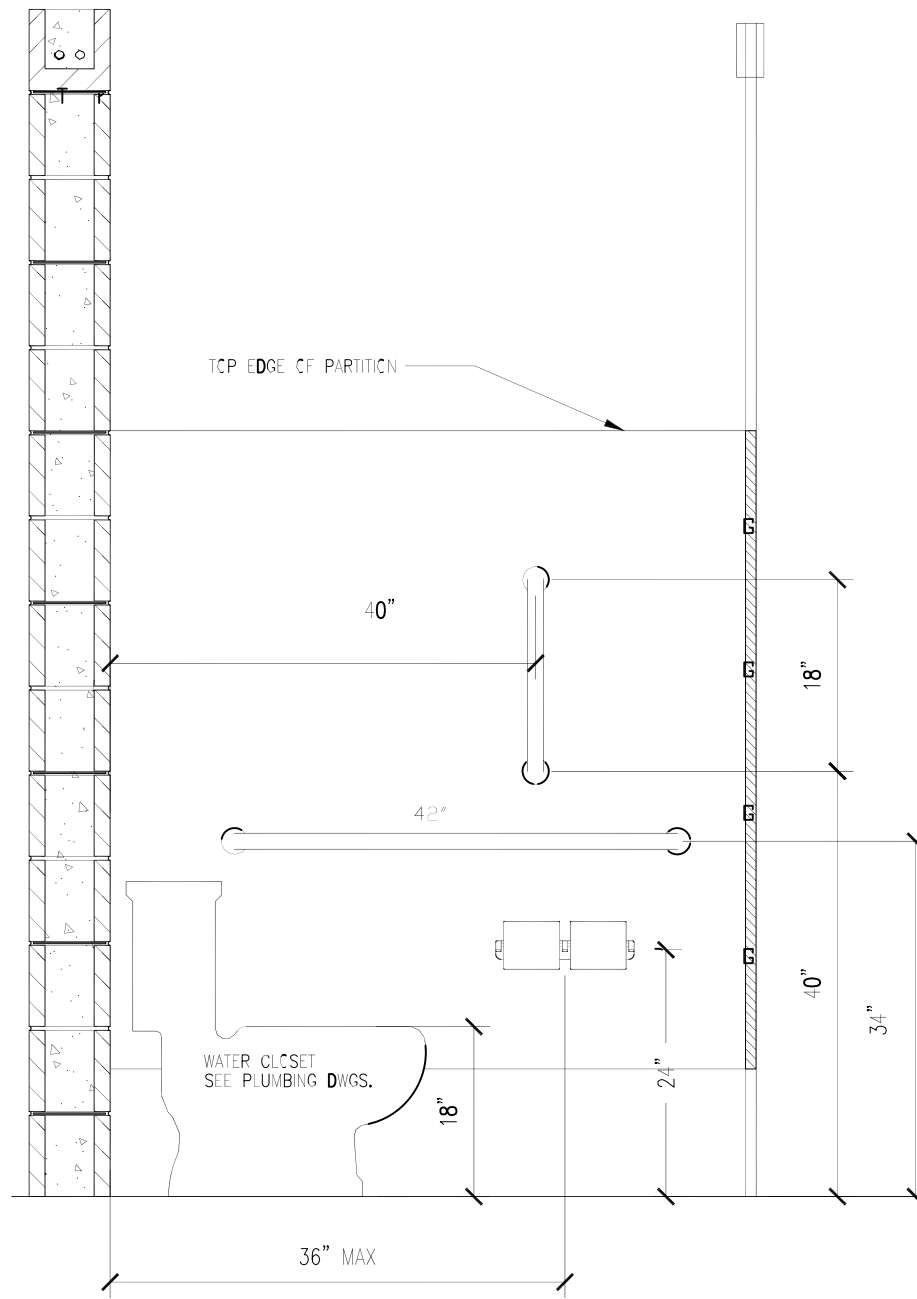

01 HANDICAP STALL
P5 SCALE: 3/4" = 1'-0"

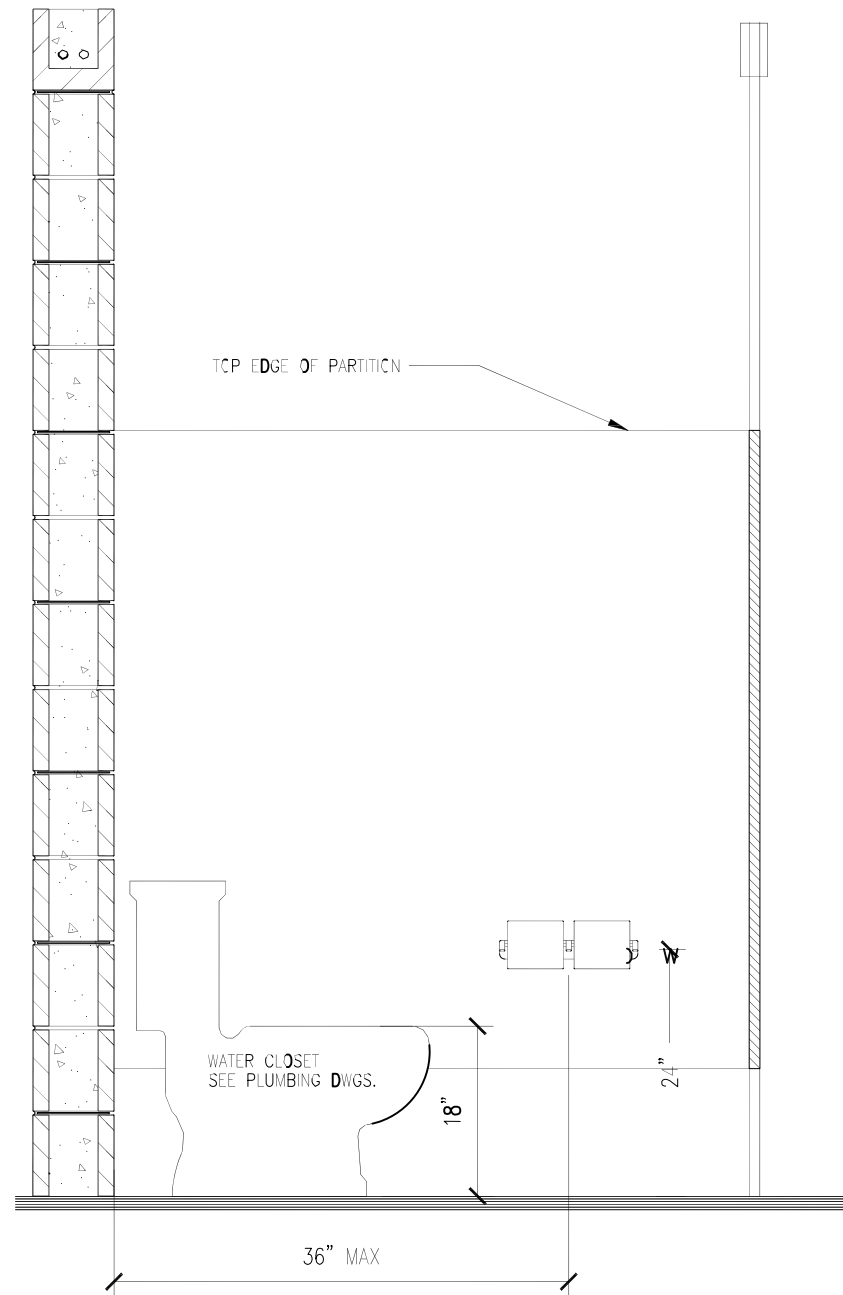

02 STANDARD STALL
P5 SCALE: 3/4" = 1'-0"

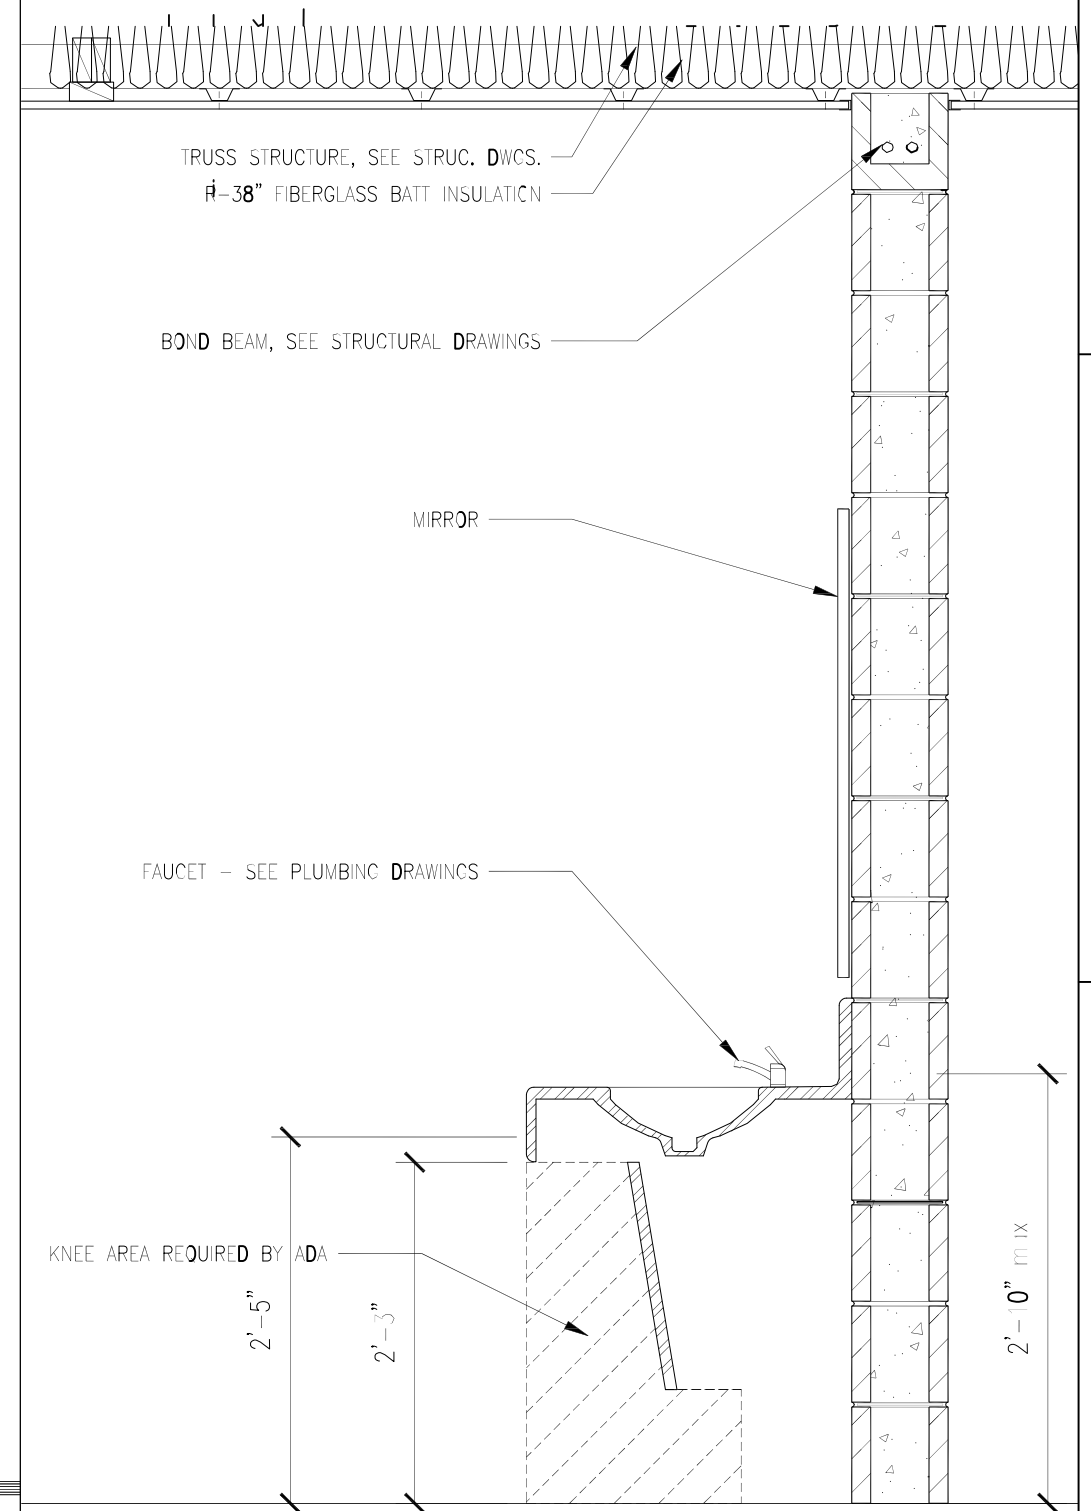

03 STANDARD SINK DETAIL
P5 SCALE: 3/4" = 1'-0"

Designed _____
Drawn _____
Checked _____
Approved _____
Title _____


ADDRESS _____
CITY-STATE _____
Fuquay Varina, North Carolina

Sheet Title _____

Sheet Number _____

P5

D-DATE _____
DR-DATE _____
C-DATE _____
Date _____

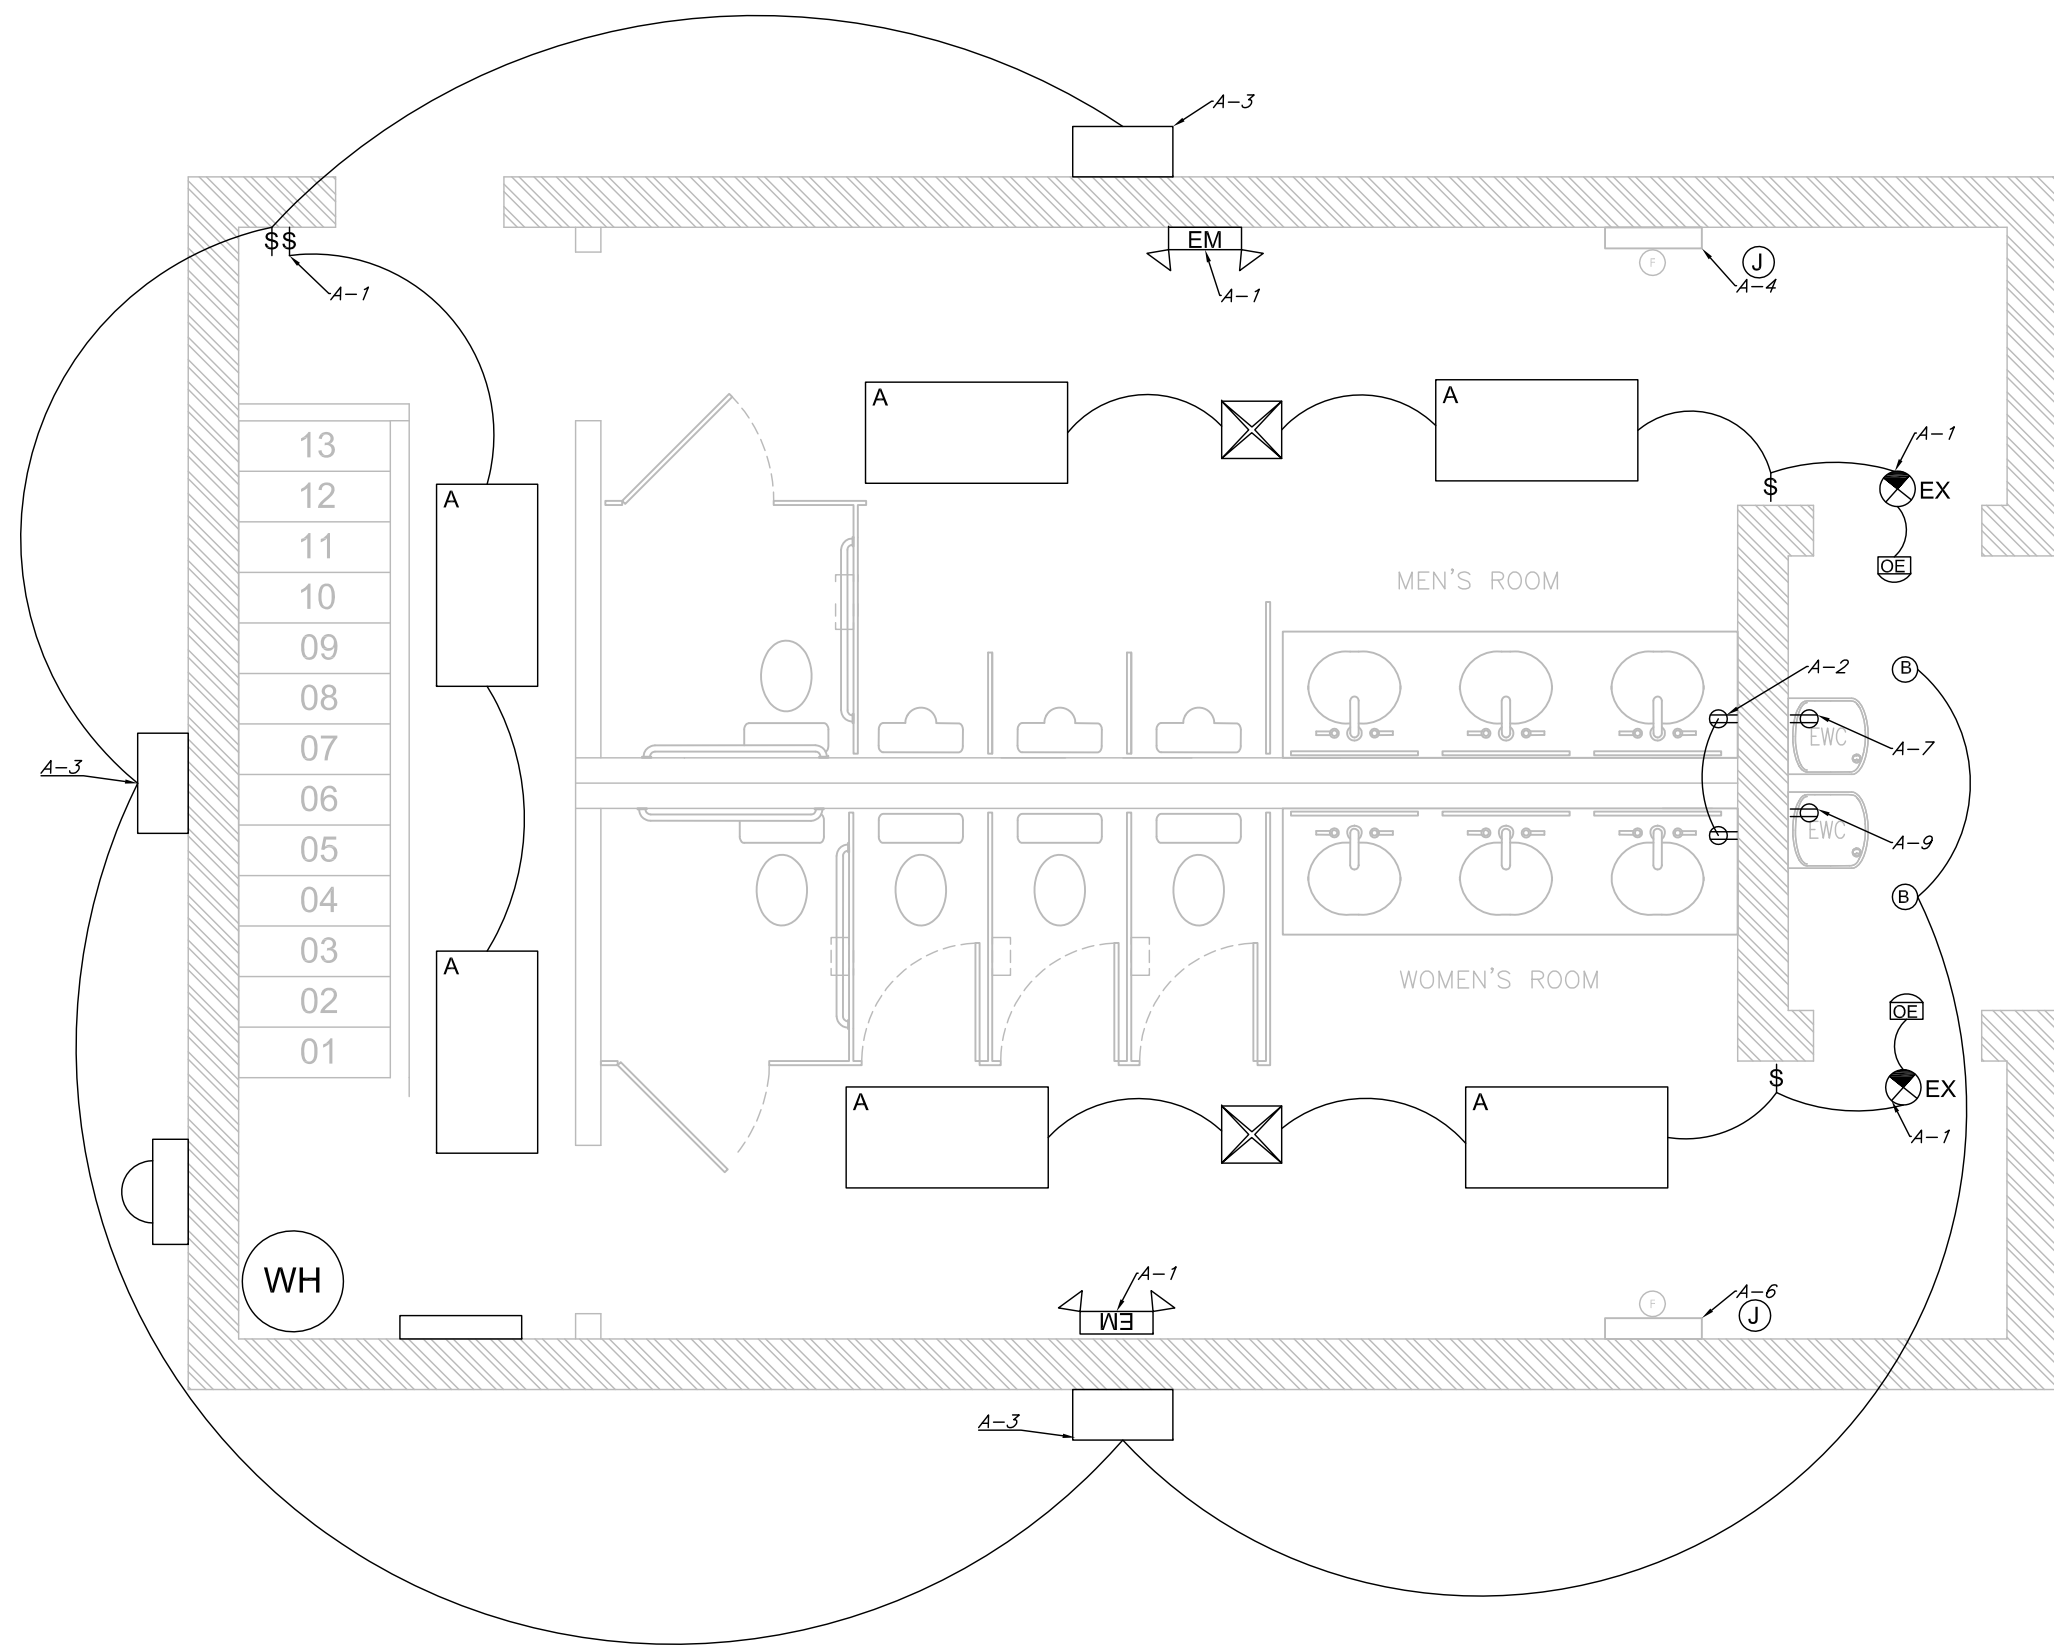

01 LIGHTING PLAN
 E1 SCALE: 1/4" = 1'-0"

Designed	D-DATE
Drawn	DR-DATE
Checked	C-DATE
Approved	Date
Title	
ADDRESS	
CITY-STATE	
Fuquay Varina, North Carolina	
Sheet Title .	
Sheet Number.	
E1	