


ITEMS BY QUEST	QTY
1 Logo Partition	1
2 Clear Partition	3
3a Graphic Partition 36" w	1
3b Graphic Partition 48" w	1
4 Around Town Wall Display & Panel	1
5 Community/Site Plan Wall Display & Panel	1
6 Floorplan Display & Panel	5
7 Equal Housing	2
8 Warranty Disclaimer (OPTIONAL)	1
9 Model Disclaimer (OPTIONAL)	1
10 Broker Policy (OPTIONAL)	1
11 No Public Restroom (OPTIONAL)	1
12a Maryland Registration (OPTIONAL)	1
12b Watch Your Step (OPTIONAL)	1
16 Adjustable Posts	3

ITEMS BY CLIENT	QTY
Copier	1
Floorplan Books (Order From Merrill)	
NEW 48" L Shaped Desk Setup w/NO Hutch	2
Executive Chair	2
Guest Chairs	4
Hospitality Console- 36"	1
Lateral File	1
Interior Designer Boards	3

FOLLOW THIS LEGEND TO ORDER YOUR SALES CENTER FURNITURE ON COUPA. (APX.4 WEEKS LEAD TIME)

GENERAL NOTES:

1. ADA COMPLIANT DOORBELL (MOUNT 30" ABOVE FINISHED EXTERIOR SLAB) AND SIGNAGE LOCATION
2. EXTERIOR LIGHT LOCATION
3. LOCATION OF RETAINING WALL IF REQUIRED TO MAINTAIN LEVEL WALKWAY TO MEET ADA COMPLIANCE. PROVIDE ADDITIONAL RAILING IF REQUIRED.
4. 3/0 ZERO THRESHOLD EXTERIOR DOOR. CUT FLUSH TO GARAGE FLOOR.

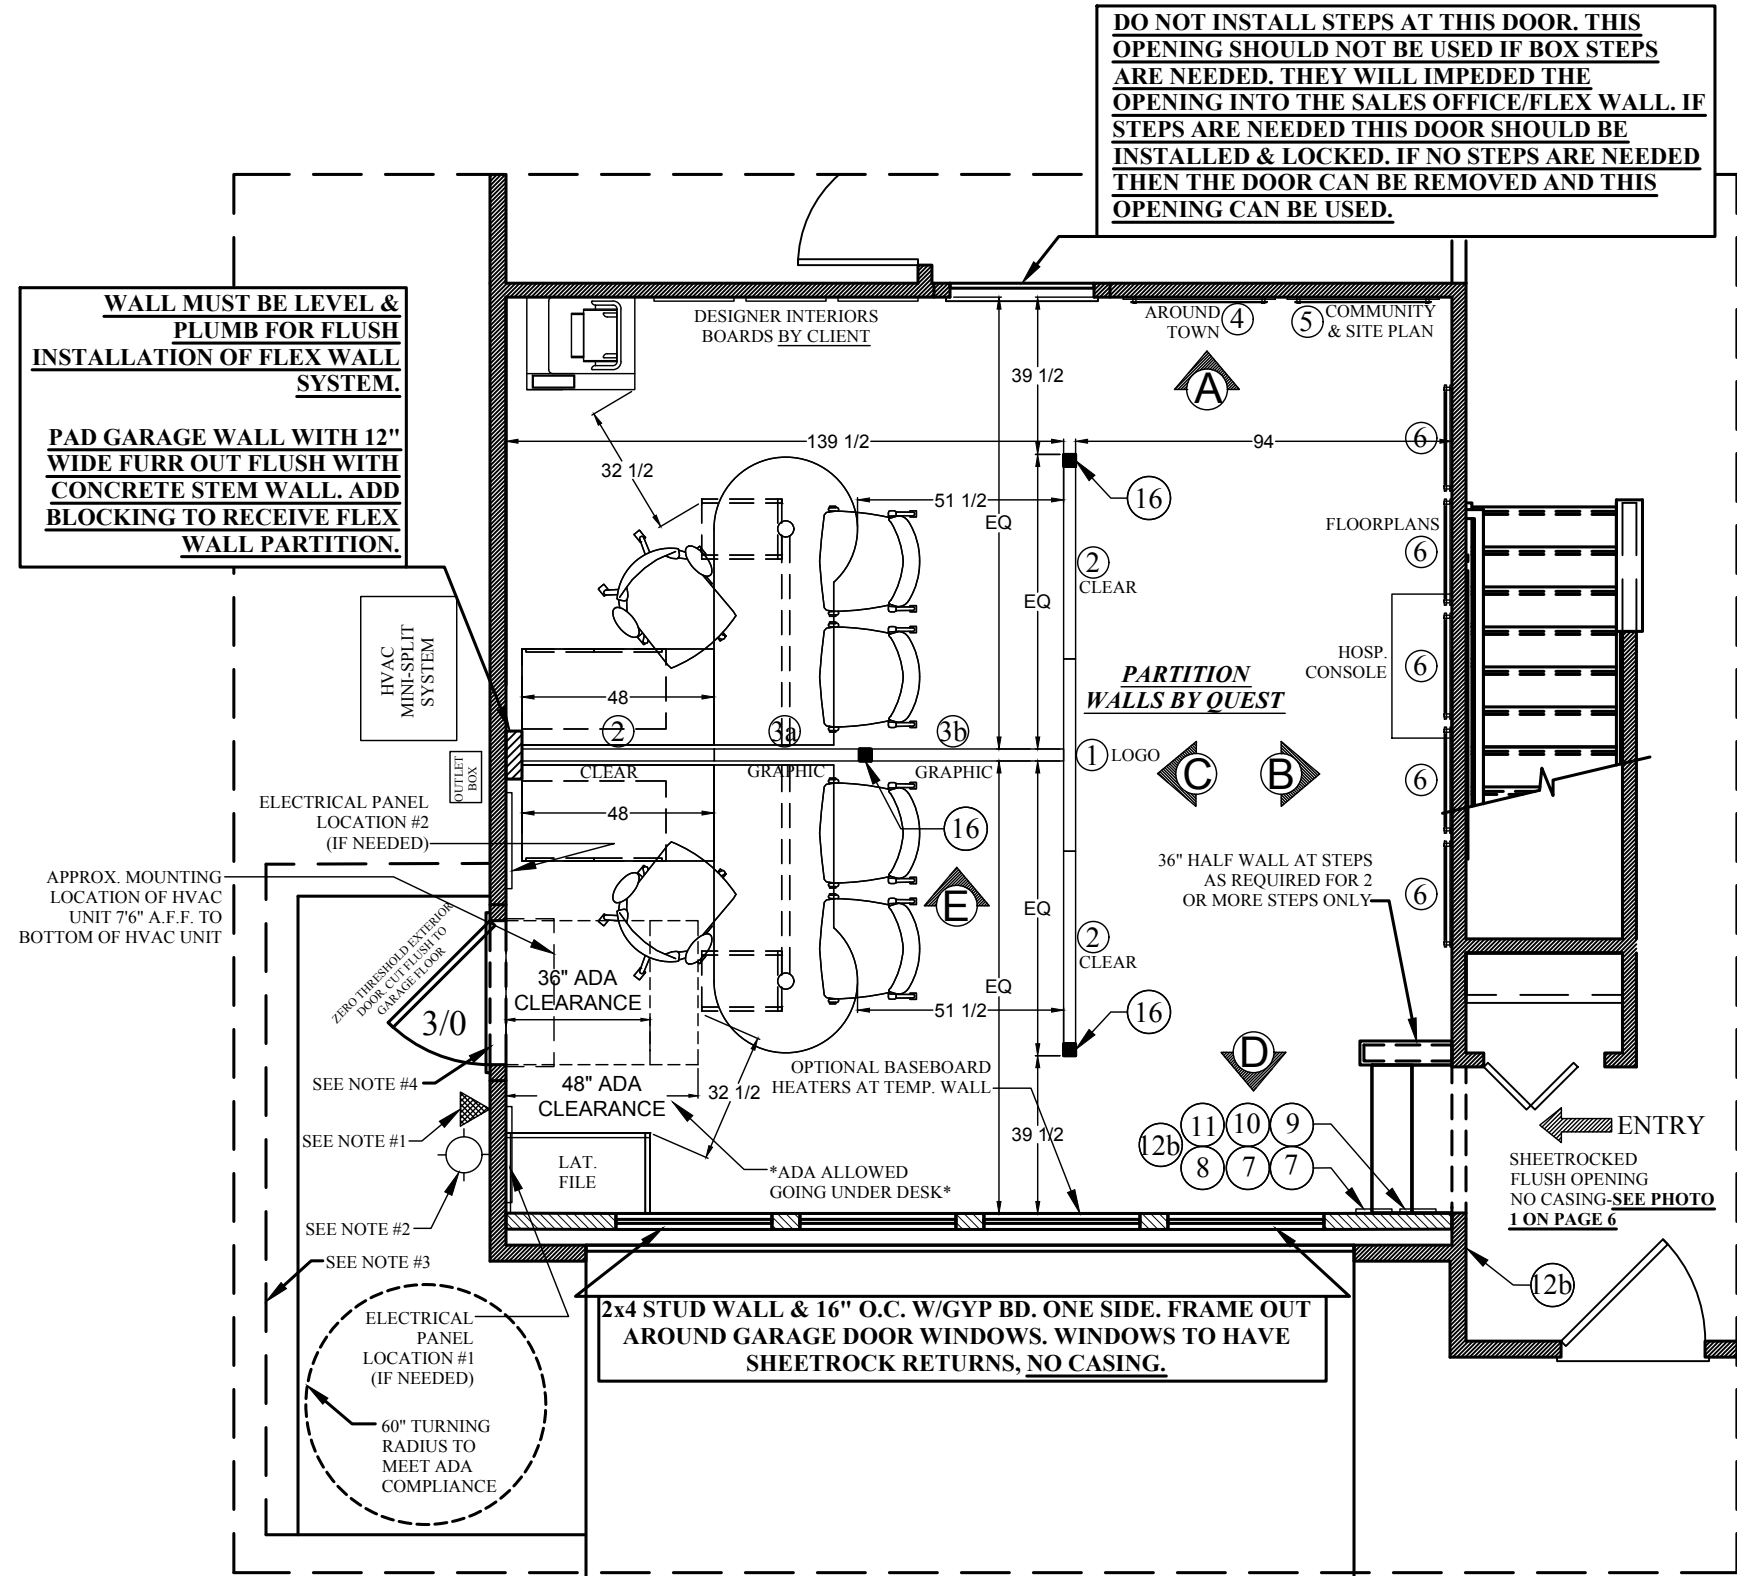

QUEST DESIGN & FABRICATION, LLC.
 13720 Stafford Rd., Ste 100
 Stafford, Texas 77477
 281-240-9416 (p)
 281-240-9385 (f)

VERSION: P1918-01	ENTRY TYPE: FOYER
FLOORPLAN: PLAN 1918	LOAD/HANDLING: FRONT/REVERSE
DESIGNER: Annie Maxey amaxe@questdisplays.com	DRAWING BY: T.B.L.
IND. DIVISION SPECIFIC	SCALE: 1/4"=1'
DISPLAY POSITION LAYOUT	PROJECT PIECE: IND. DIVISION SPECIFIC
© Quest Design & Fabrication, LLC	
BUILDER: Simply Ryan Homes Emp. Affordable. Simply Yours.	DATE OF LAST REVISION: 9/11/2018
1 OF 6 SHEETS	

LEGEND

MANUFACTURER: PROGRESS

- 7" LED WHITE FLUSH MOUNT
P8222-28/30K9-AC1-L10
- Ⓢ LIGHT SWITCH
Mount at 42" AFF
- ⊕ OUTLET

GENERAL NOTES:

1. ADA COMPLIANT DOORBELL (MOUNT 30" ABOVE FINISHED EXTERIOR SLAB) AND SIGNAGE LOCATION
2. EXTERIOR LIGHT LOCATION
3. LOCATION OF RETAINING WALL IF REQUIRED TO MAINTAIN LEVEL WALKWAY TO MEET ADA COMPLIANCE. PROVIDE ADDITIONAL RAILING IF REQUIRED.
4. 3/0 ZERO THRESHOLD EXTERIOR DOOR. CUT FLUSH TO GARAGE FLOOR.

Location A (see plan for placement)

- One single port patch panel white wired for voice labeled "Phone".
- One 2 [two] port power plug.

Location B (see plan for placement)


- See plan for location. Standard height.
- One data 2 [two] port data panel
 - Port 1- labeled "Sonic" (run from media center)
 - Port 2- labeled "Fax"
- 2 [two] port power plug [standard 100v 20 amp]. Dedicated outlet. Standard height.
- 2 [two] additional port power plug [standard 100v 15 amp]. Standard height.

From Media Center to Location B

One CAT5 for data [connecting to 4 port data patch panel to data outlet] to port labeled "Sonic". No Coax run.

CRITICAL NOTES:

1. FOLLOW LIGHTING LAYOUT EXACTLY TO ENSURE PROPER INSTALLATION OF QUEST FLEX WALLS & POSTS.
2. DO NOT PLACE ELEVATED OUTLETS OR SWITCHES IN ANY DISPLAY LOCATIONS SHOWN ON PAGE 1 AND/OR 6.
3. SWITCHES & HVAC UNIT TO BE PLACED AT SPECIFIED HEIGHT.
4. ANY OUTLETS PLACED PER LOCAL CODE TO BE AT STANDARD HEIGHT.
5. IF ELECTRICAL PANEL IS PRESENT IT IS TO BE PAINTED TO MATCH WALL COLOR
6. PROJECT MANAGER, NVR FIELD ENGINEER, AND WIRING INSTALLER MUST SET UP A PRE-WIRING CONFERENCE CALL/ MEETING TO REVIEW WIRING PLAN FOR PROPER PLACEMENT & WIRING METHOD.

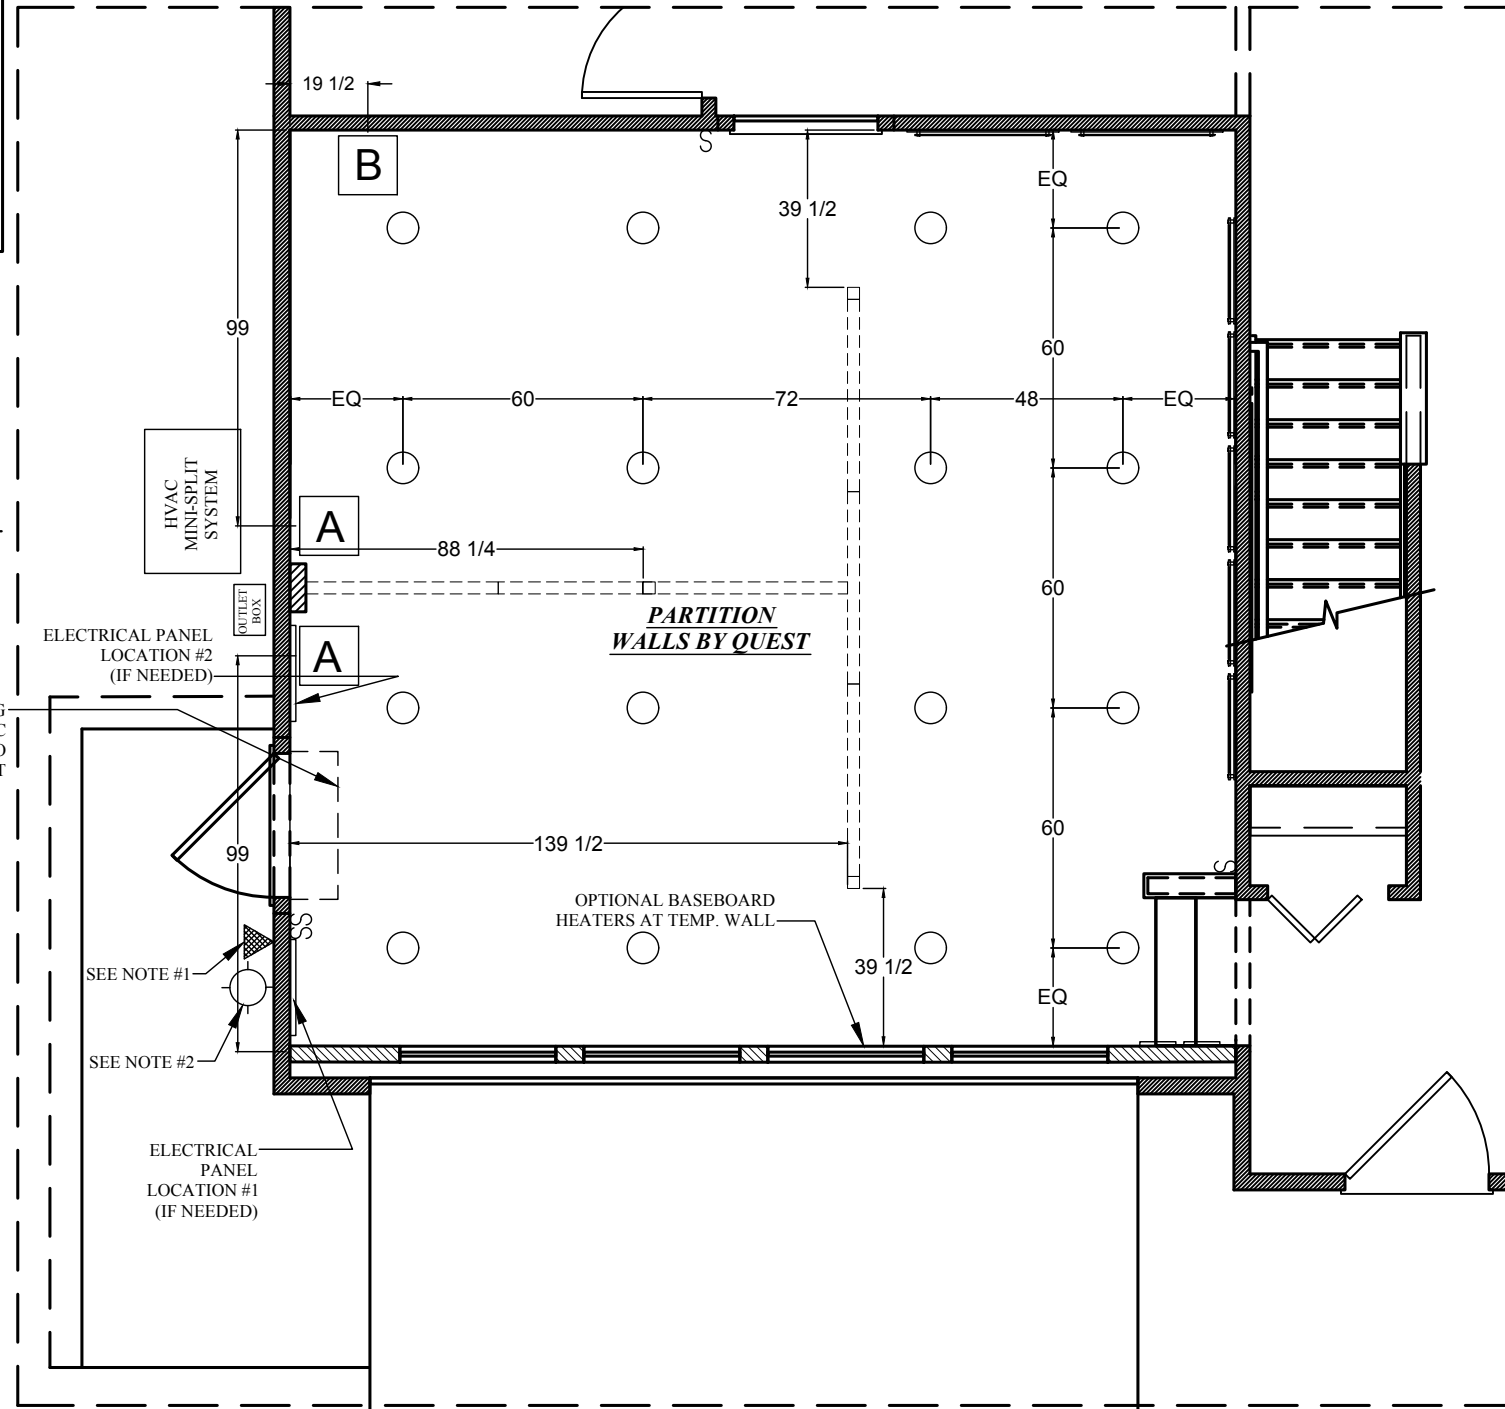

QUEST DESIGN & FABRICATION, LLC.
 13720 Stafford Rd., Ste 100
 Stafford, Texas 77477
 281-240-9416 (p)
 281-240-9385 (f)

BUILDER: Simply Ryan Homes <small>Design. Affordable. Simply Yours.</small>	FLOORPLAN:	PLAN 1918	VERSION:	P1918-01	
	LOAD/HANDING:	FRONT/REVERSE	ENTRY TYPE:	FOYER	
DATE OF LAST REVISION:	9/11/2018	SCALE:	1/4"=1'	DRAWING BY:	T.B.L
3 OF 6 SHEETS	PROJECT PIECE:	IND. DIVISION SPECIFIC			
	LIGHTING/ ELECTRICAL PLAN				
© Quest Design & Fabrication, LLC					

PAINT LEGEND

INSTALLATION:
 GYPSUM BOARD TO RECEIVE ONE COAT OF COMMERCIAL GRADE PRIMER PRIOR TO RECEIVING TWO COATS OF PAINT. PAINT ALL WIRES, RETURN AIR GRILLES, ELECTRICAL PANEL COVERS AND SUPPLY AIR GRILLS TO MATCH ADJACENT AREAS

P1 **BASE PAINT:**
 SW 7015 REPOSE GRAY
 LO SHEEN EGGSHELL LATEX

P2 **CEILING:**
 SW 7631 CITY LOFT
 FLAT LATEX
OR
 MATCH CEILING IN MODEL IF WHITE

NOTE: IF ELECTRICAL PANEL IS PRESENT IT IS TO BE PAINTED TO MATCH WALL COLOR


TRIM LEGEND

-INSTALLED BY CARPENTER, PAINTED BY PAINTER - COLOR TO MATCH TRIM IN MODEL


BASE BOARDS, DOORWAYS:
 1"x4"x16' PRIMED & PAINTED 1x4
 PART# A0035367 1"x4"x16'

-SHOE MOLDING: PAINT GRADE QUARTER ROUND


NOTE: REFER TO ASD DETAIL REGARDING FOUNDATION WALL CAP AT EXTERIOR FOUNDATION WALLS.

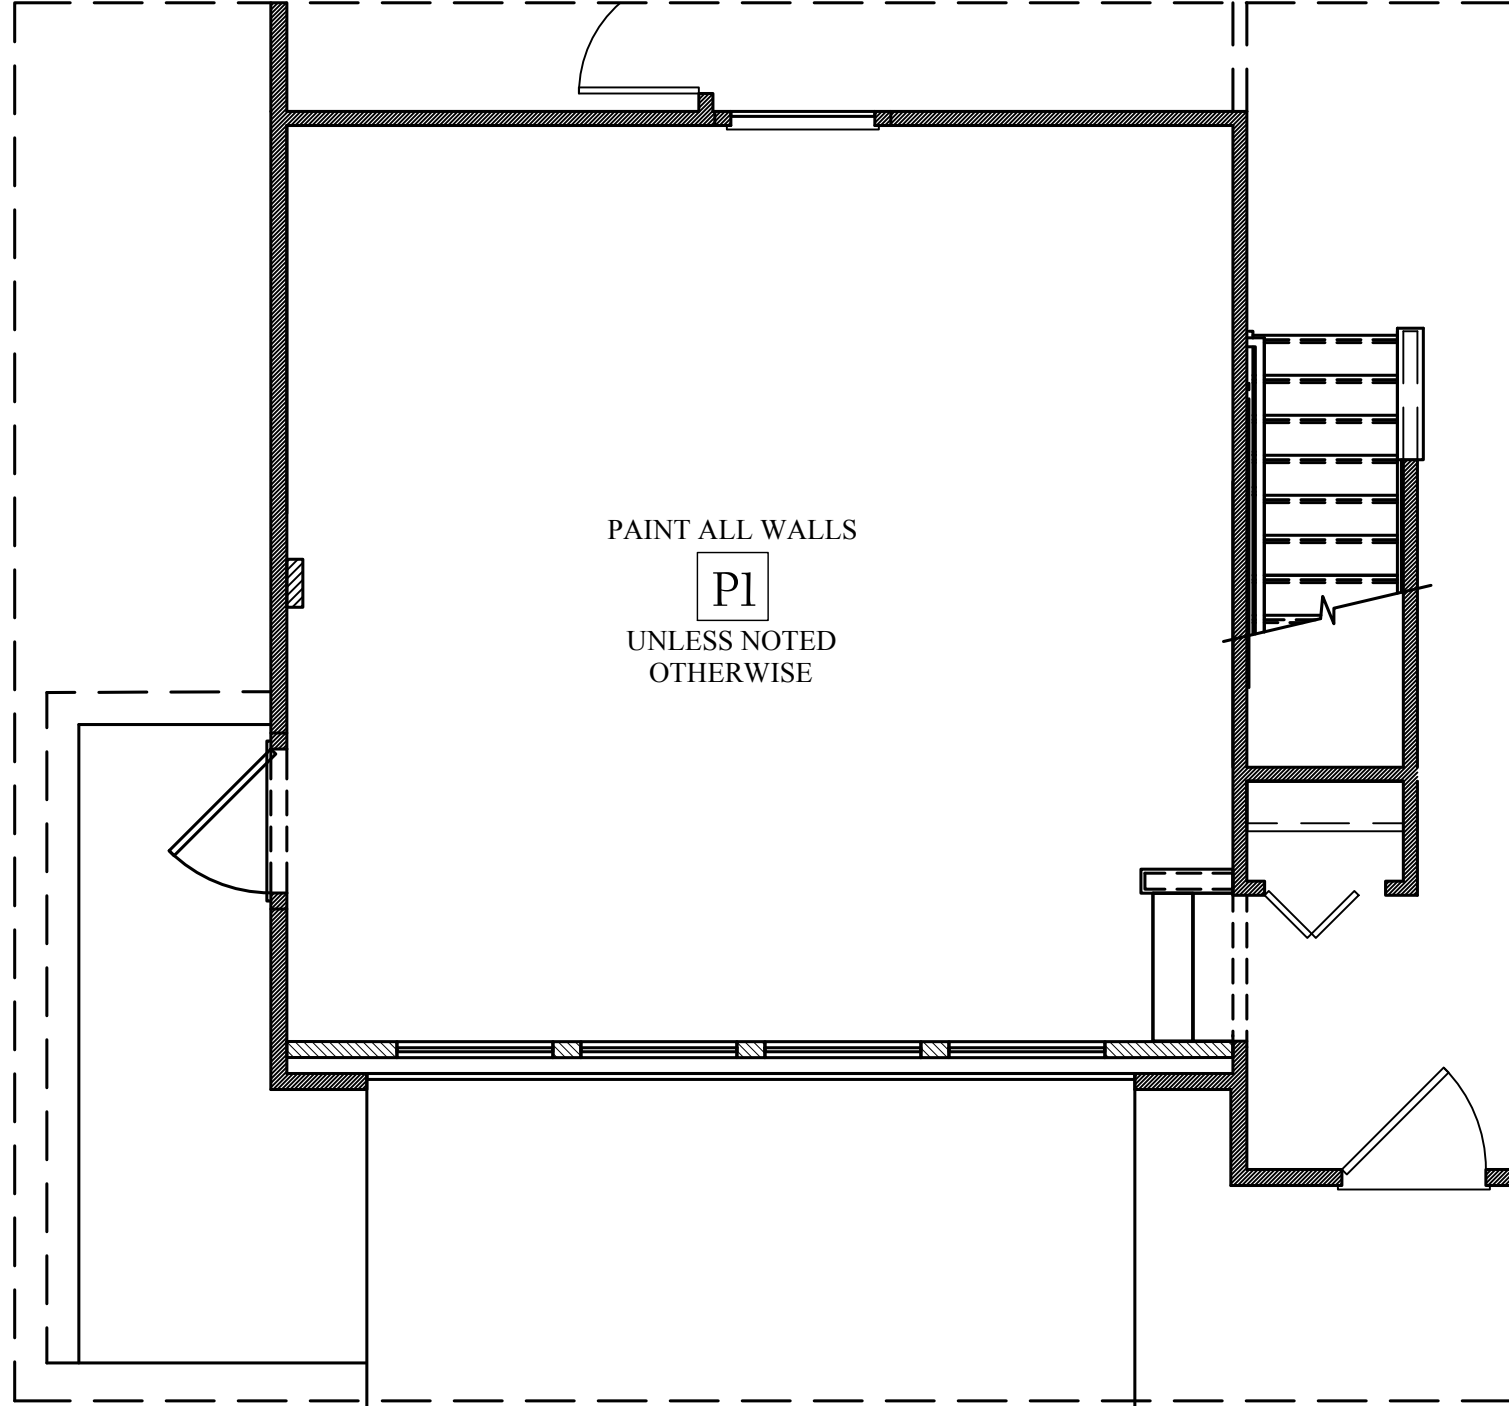

QUEST DESIGN & FABRICATION, LLC.
 13720 Stafford Rd., Ste 100
 Stafford, Texas 77477
 281-240-9416 (p)
 281-240-9385 (f)

BUILDER:  DATE OF LAST REVISION: 9/11/2018	FLOORPLAN: PLAN 1918	VERSION: P1918-01
	LOAD/HANDING: FRONT/REVERSE	ENTRY TYPE: FOYER
SCALE: 1/4"=1'	DRAWING BY: T.B.L	DESIGNER: Annie Maxey amaxey@questdisplays.com
PROJECT PIECE: IND. DIVISION SPECIFIC	PAINT PLAN	
4 OF 6 SHEETS		© Quest Design & Fabrication, LLC

FLOORING LEGEND

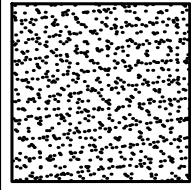

CARPET TILE:

Shaw
54734 Lucky Break
34510 Random Odds
24" squares




NOTES:

1. INCLUDE ADDITIONAL STAIR MATERIAL IF NEEDED.


2. OAK TREADS WITH WHITE RISERS.

3. STAIN OAK TREADS TO MATCH HOUSE HARDWOOD/LVP OR "DEEP JAVA" IF NO HWD/LVP PRESENT

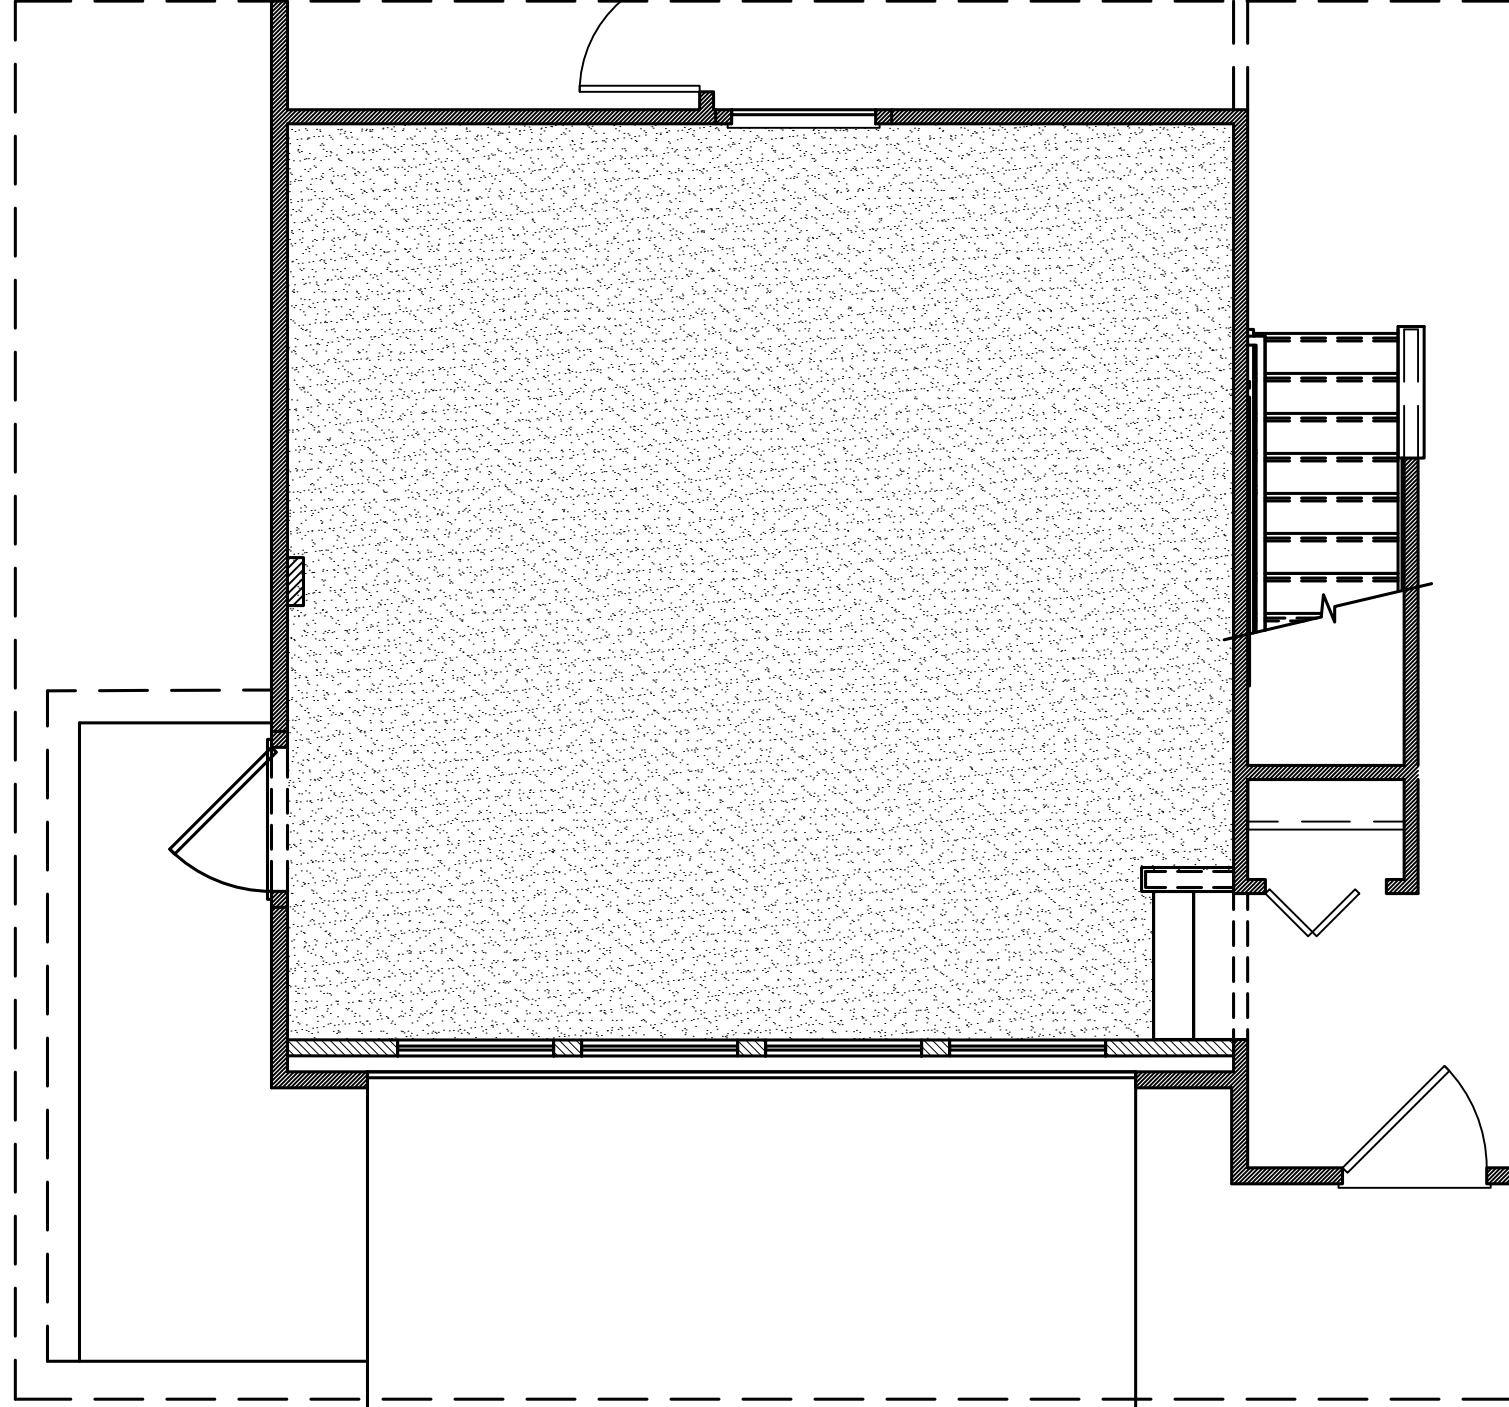


QUEST DESIGN & FABRICATION, LLC.
13720 Stafford Rd., Ste 100
Stafford, Texas 77477
281-240-9416 (p)
281-240-9385 (f)


BUILDER: 	FLOORPLAN:	PLAN 1918	VERSION:	P1918-01
	LOAD/HANDING:	FRONT/REVERSE	ENTRY TYPE:	FOYER
DATE OF LAST REVISION:	SCALE:	1/4"=1'	DRAWING BY:	T.B.L
9/11/2018	PROJECT PIECE:	IND. DIVISION SPECIFIC		
5 OF 6 SHEETS	FLOORING PLAN			
	© Quest Design & Fabrication, LLC			

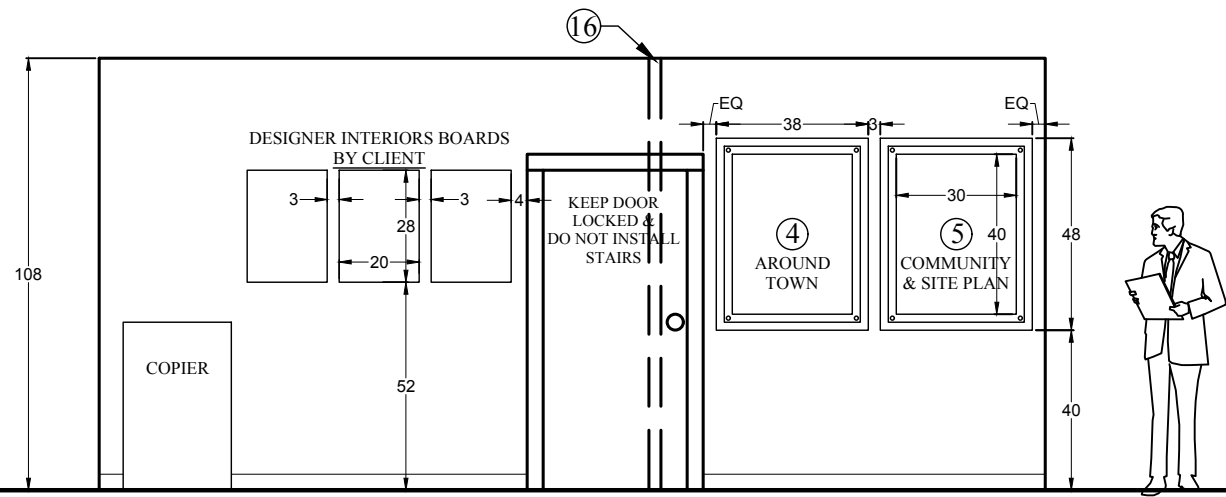


A Office/Gallery Elevation

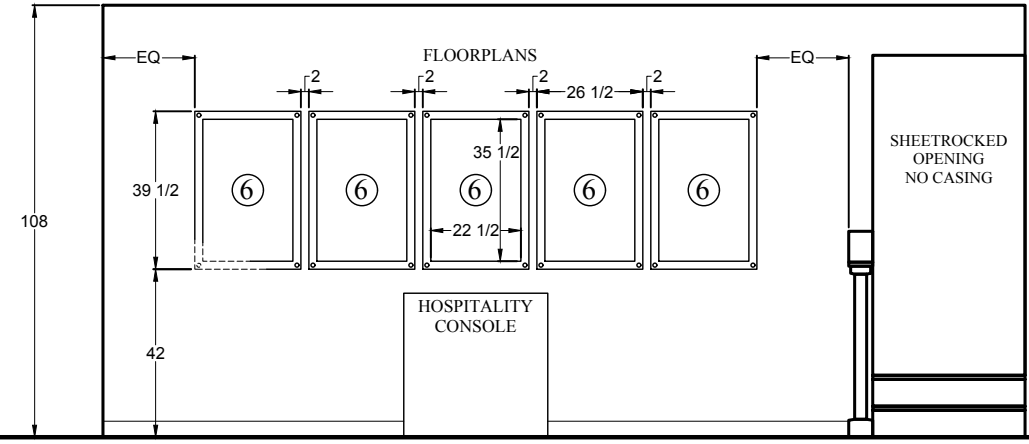


B Gallery Elevation

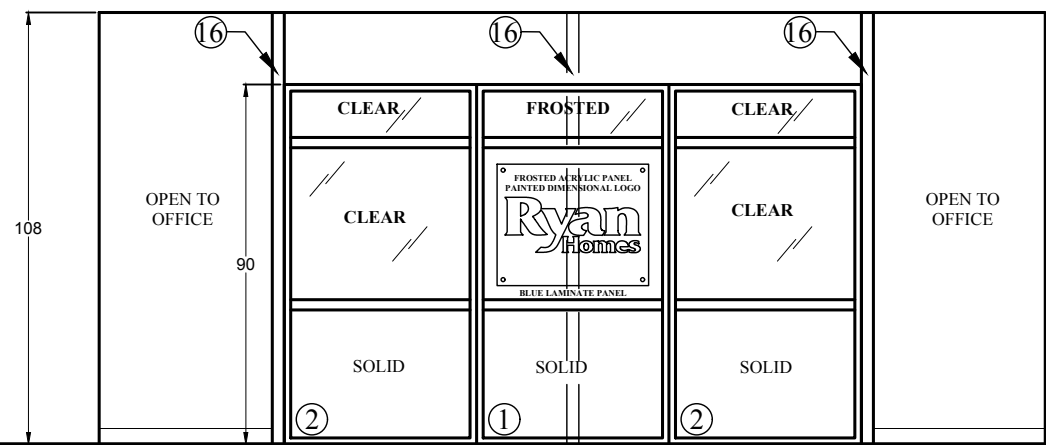


C Gallery/Office Elevation

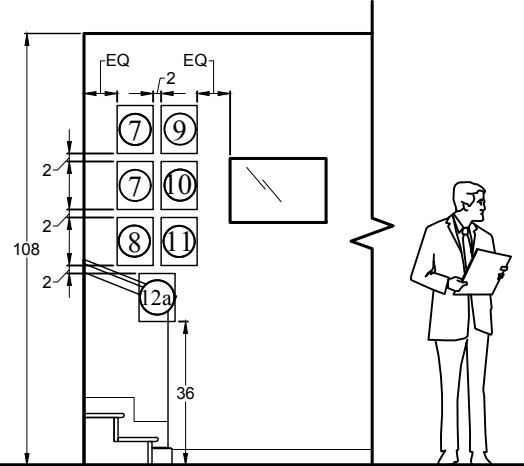

D Gallery Elevation

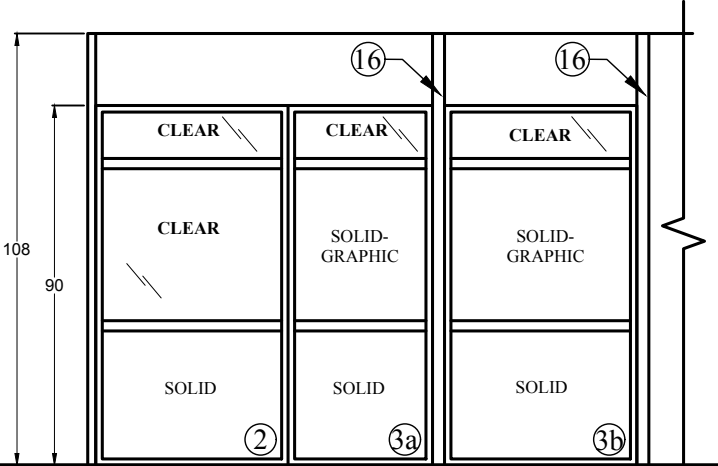

E Office Elevation

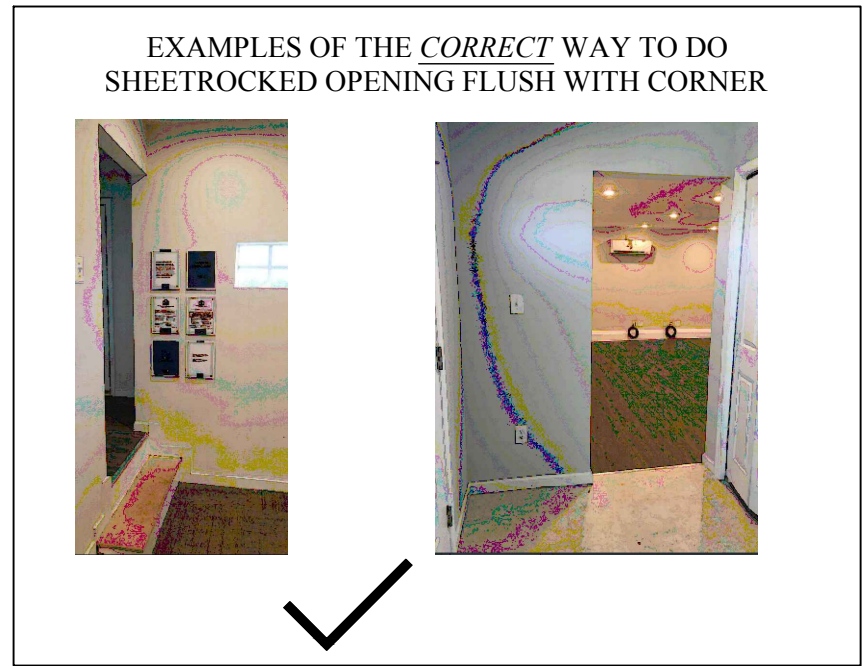

QUEST DESIGN & FABRICATION, LLC.
 13720 Stafford Rd., Ste 100
 Stafford, Texas 77477
 281-240-9416 (p)
 281-240-9385 (f)

BUILDER: Simply Ryan Homes <small>Design. Affordable. Simply Yours.</small>	FLOORPLAN: PLAN 1918	VERSION: P1918-01
	LOAD/HANDING: FRONT/REVERSE	ENTRY TYPE: FOYER
DATE OF LAST REVISION: 9/11/2018	SCALE: 1/4"=1'	DESIGNER: Annie Maxey <small>amaxey@questdisplays.com</small>
6 OF 6 SHEETS	PROJECT PIECE: IND. DIVISION SPECIFIC	
	WALL ELEVATIONS	
© Quest Design & Fabrication, LLC		