




**PRELIMINARY
NOT FOR
CONSTRUCTION**

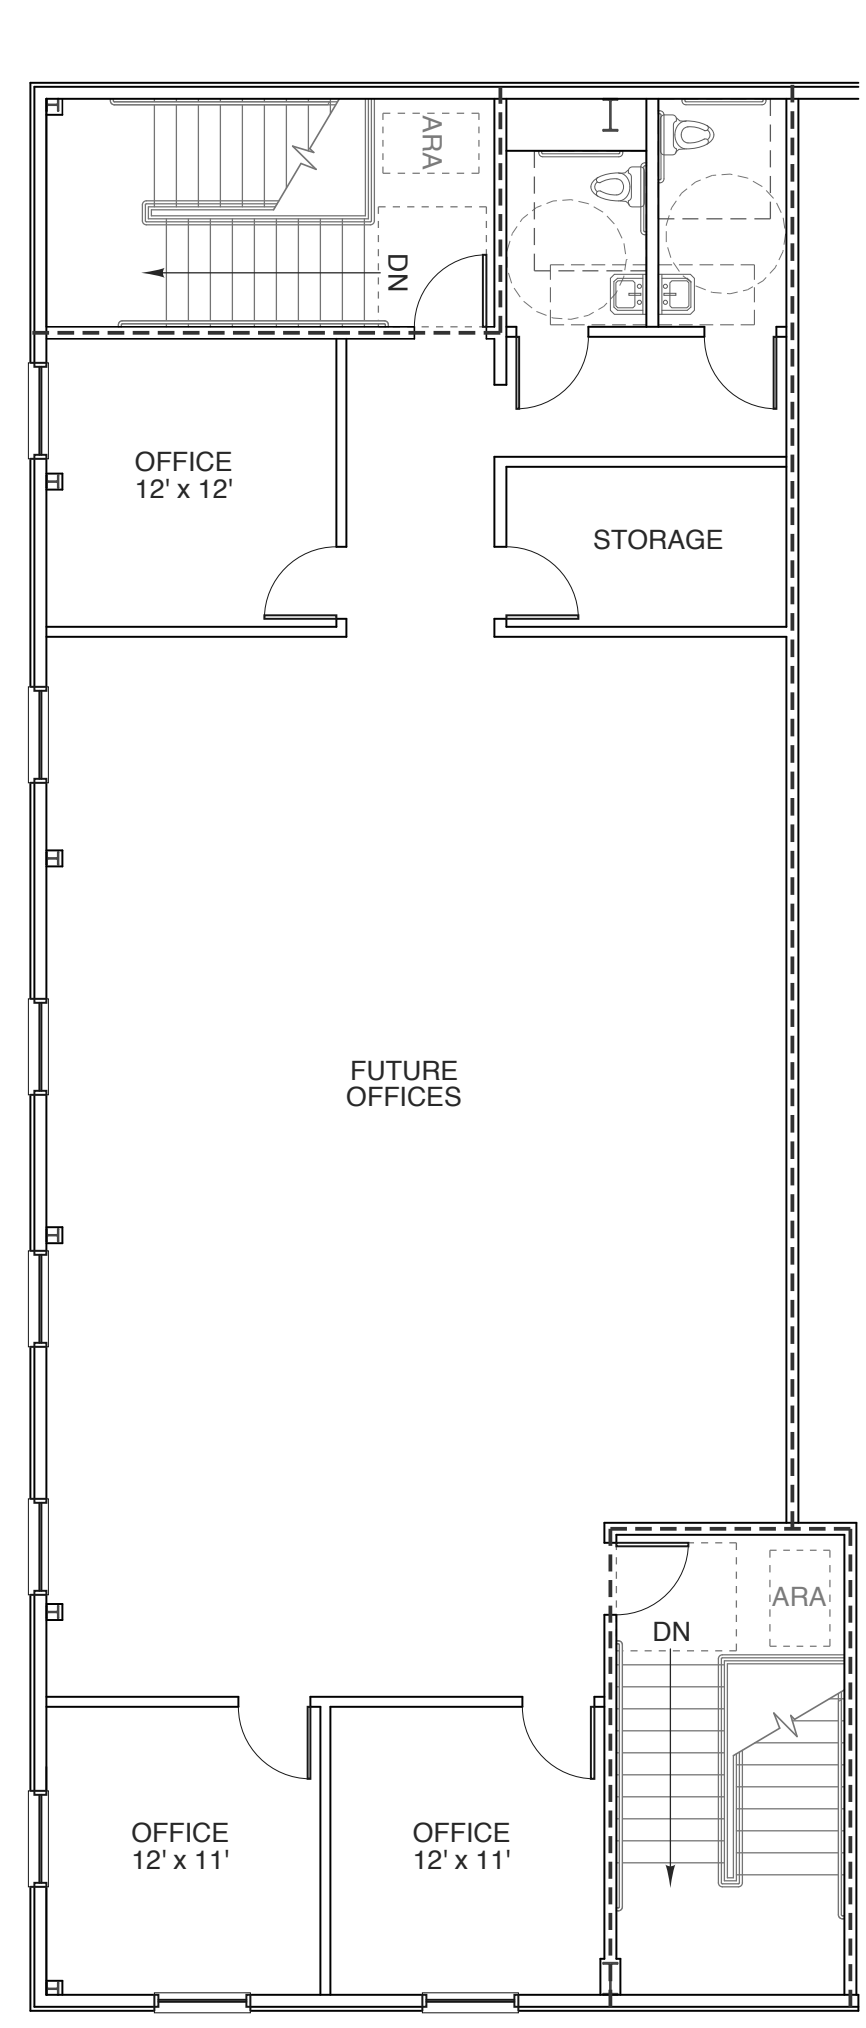


2 MEZZANINE
SCALE: 1/8" = 1'-0"

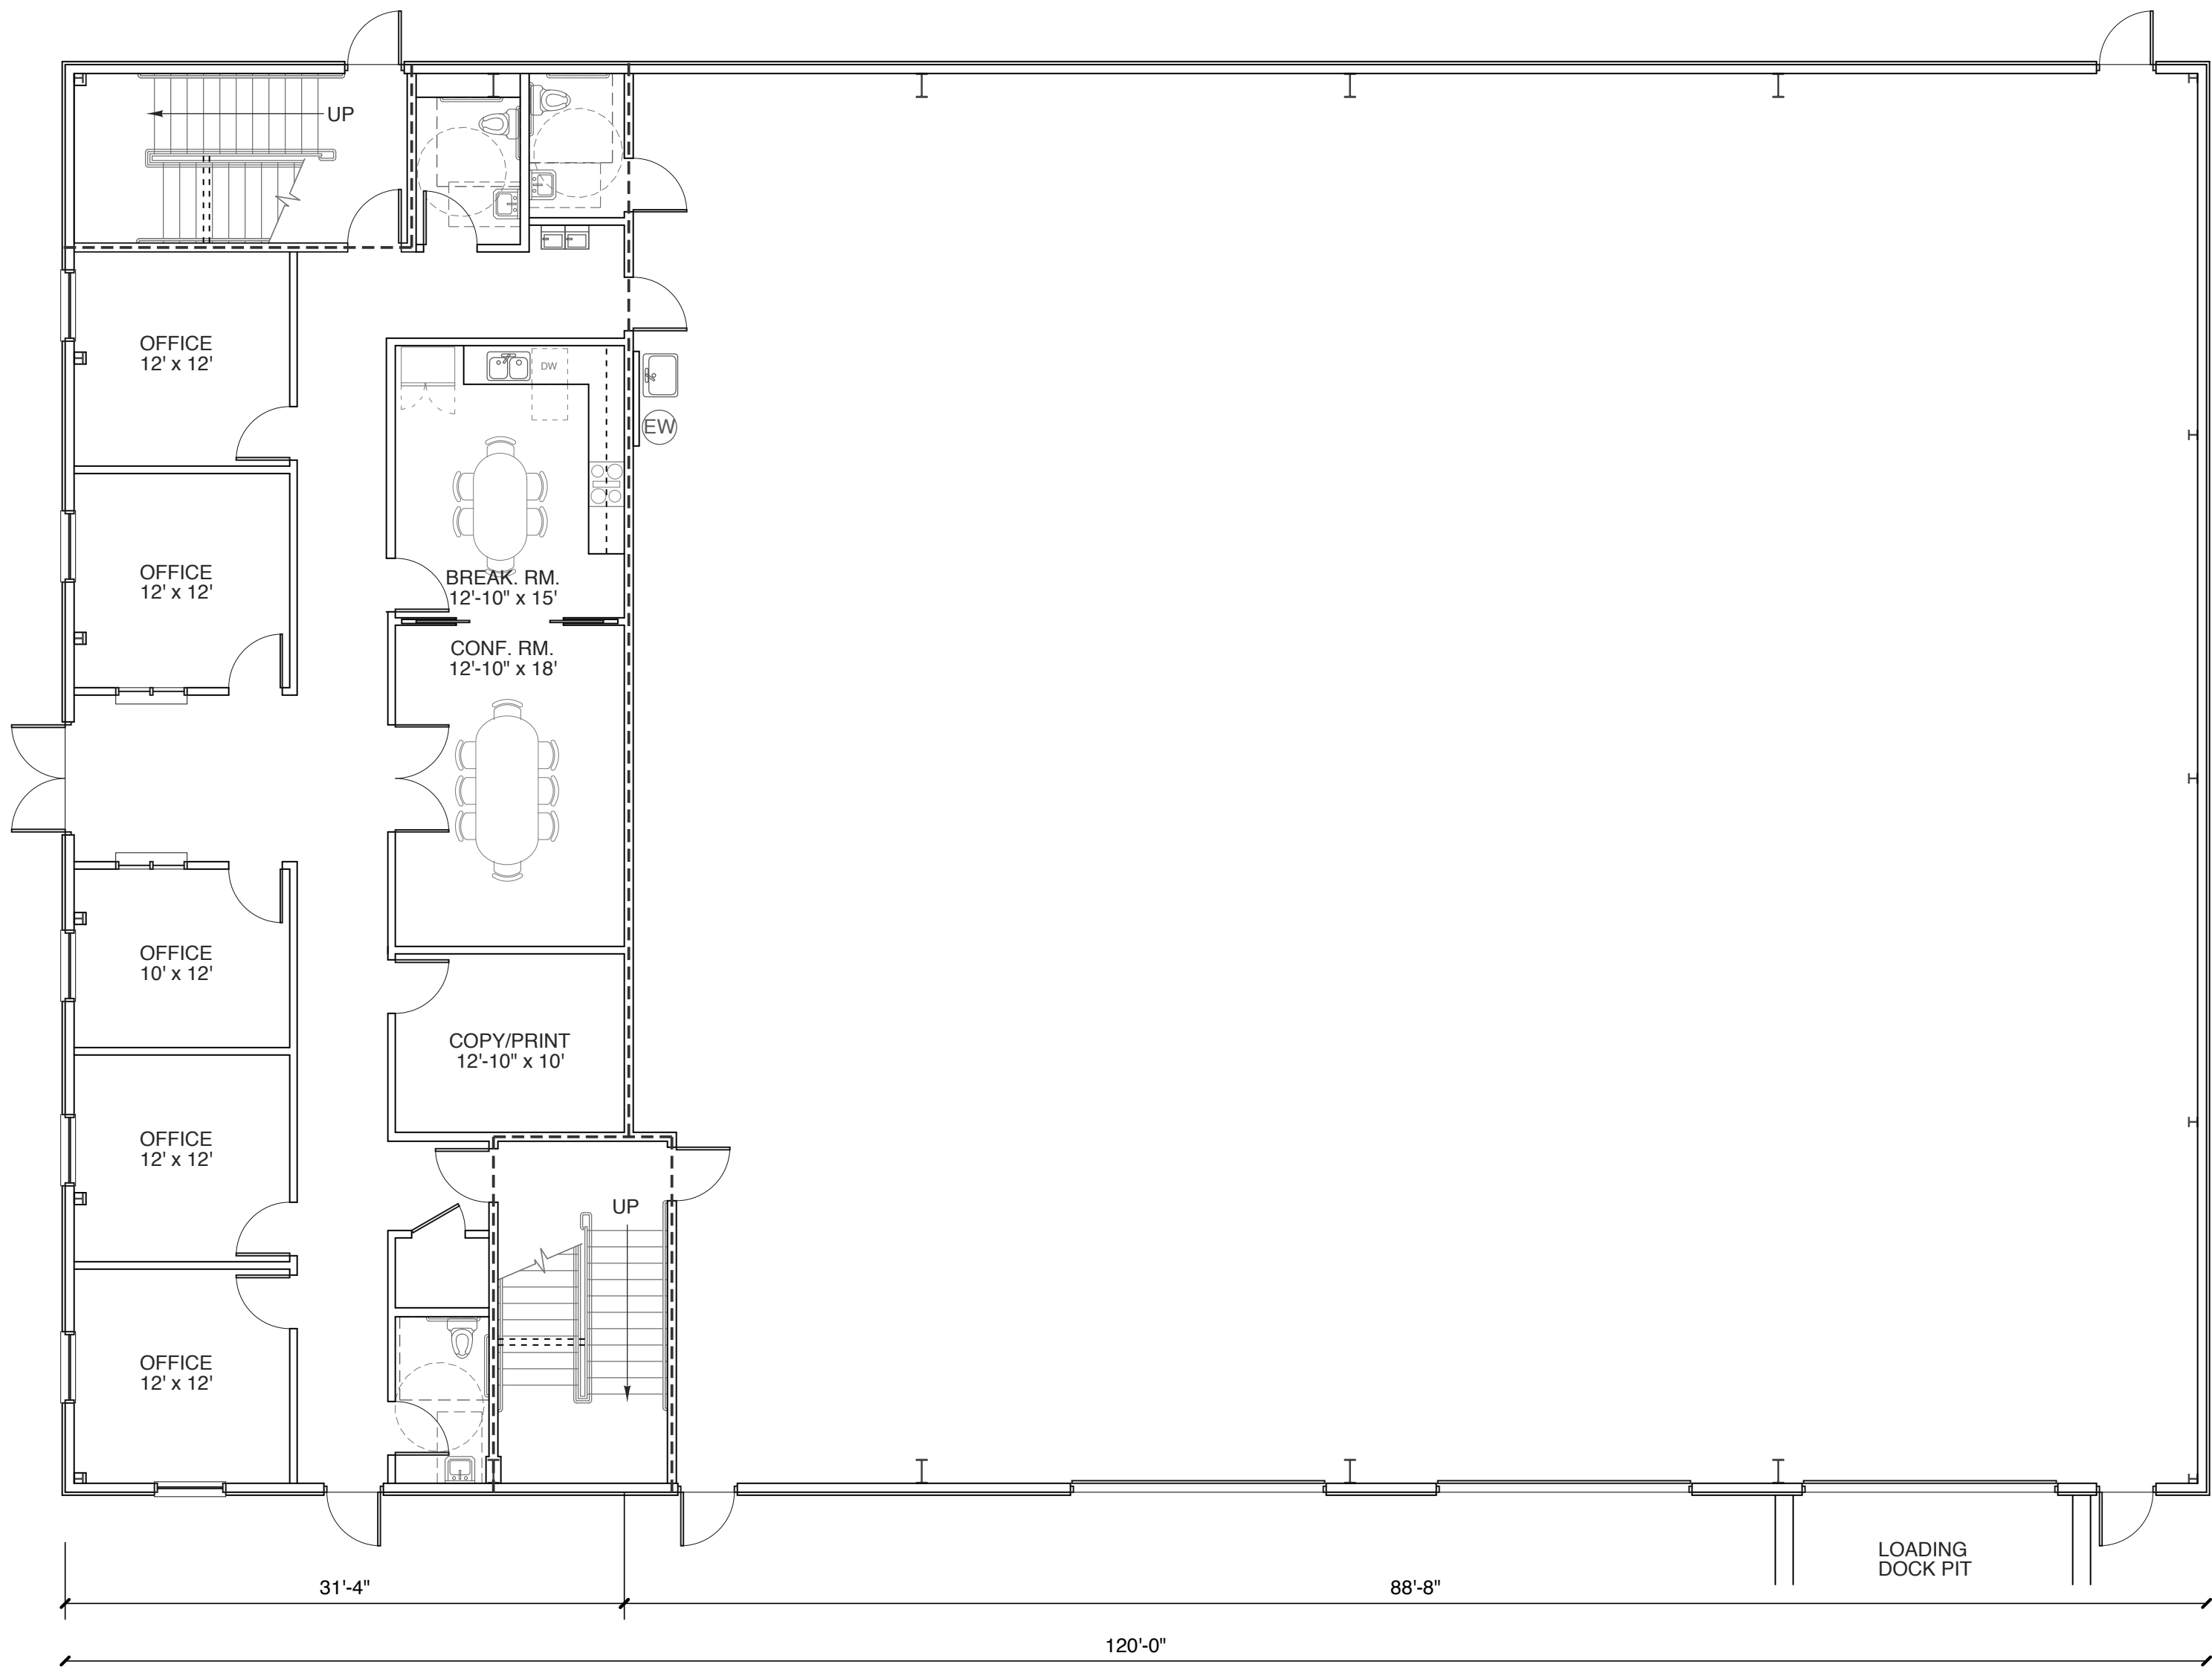

1 FLOOR PLAN
SCALE: 1/8" = 1'-0"

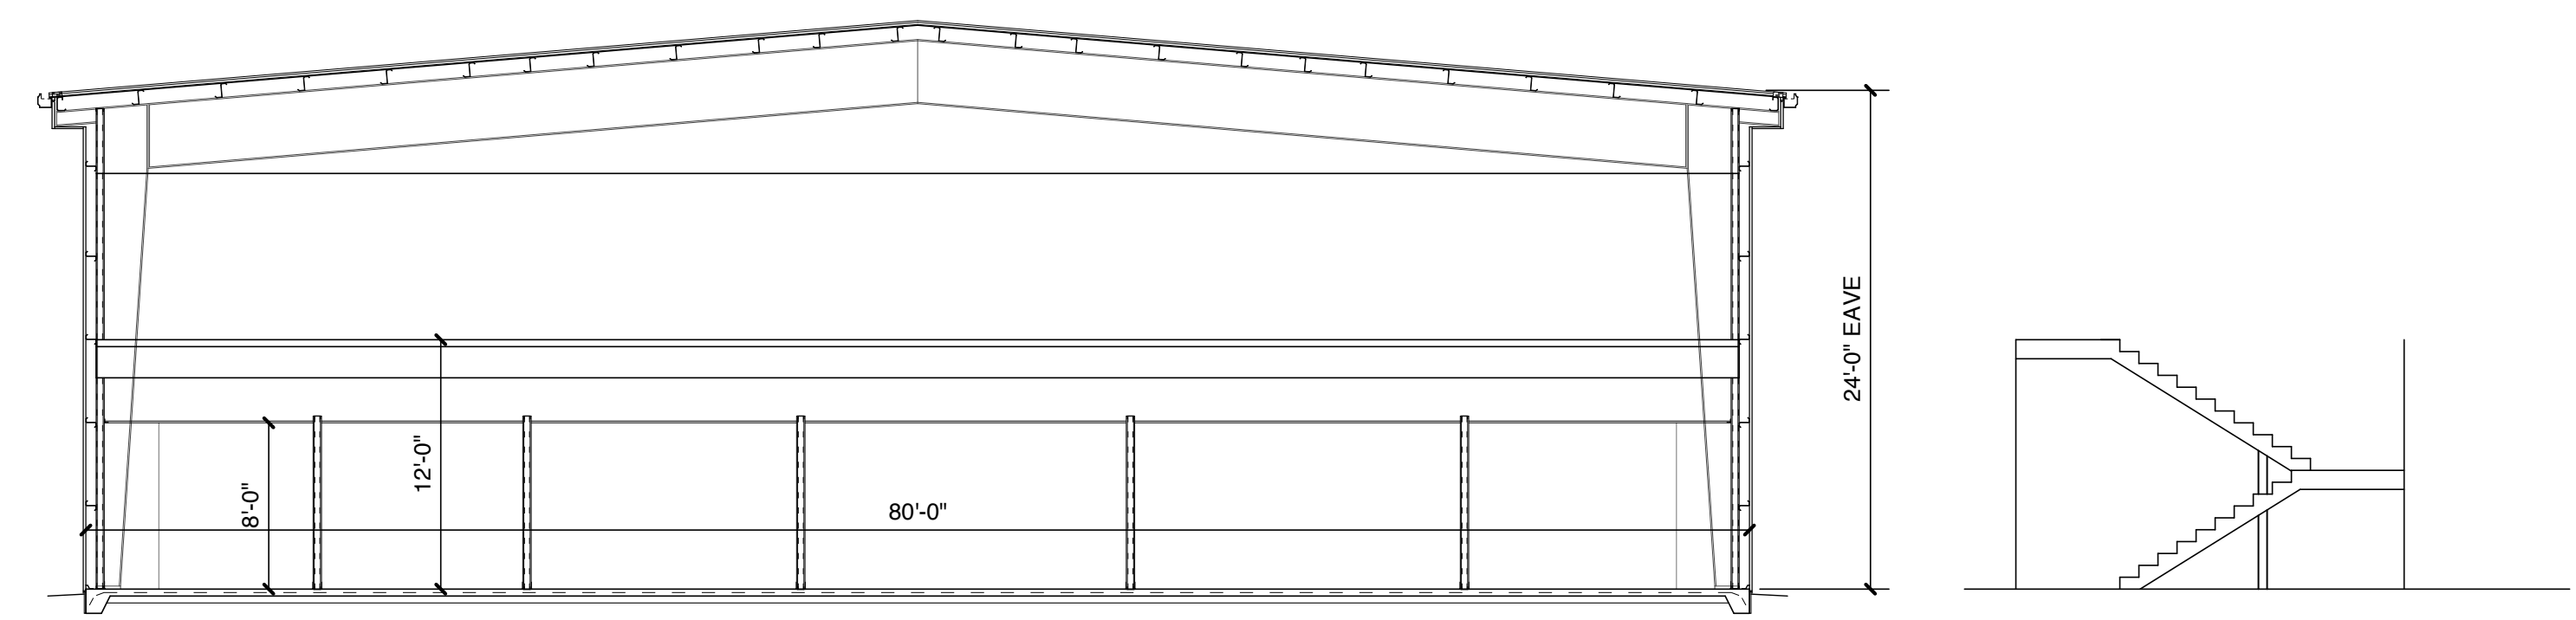

 3 PRELIMINARY BUILDING SECTION
SCALE: 1/8" = 1'-0"



Reviewed For Code Compliance By:
D. Banks Wallace
Chief Deputy Fire Marshal
02/11/2021 1:14:33 PM

**FOR PERMIT
PROCESS ONLY**

PROJECT TITLE
**POWERMASTER
ELECTRIC**
JARCO DRIVE
FUQUAY-VARINA, NORTH CAROLINA

PROJECT NO.
2019
DRAWING TITLE
FLOOR PLAN


SHEET 0 OF 0

AI


PLOT DATE
REVISION 00/00/19

This original sheet is 24" x 36"; other dimensions indicate it has been altered.
All information on this sheet is the property of Weeks Turner Architecture and may not be duplicated in whole or in part without written authorization from Weeks Turner Architecture. 2019 ©


PRELIMINARY
NOT FOR
CONSTRUCTION

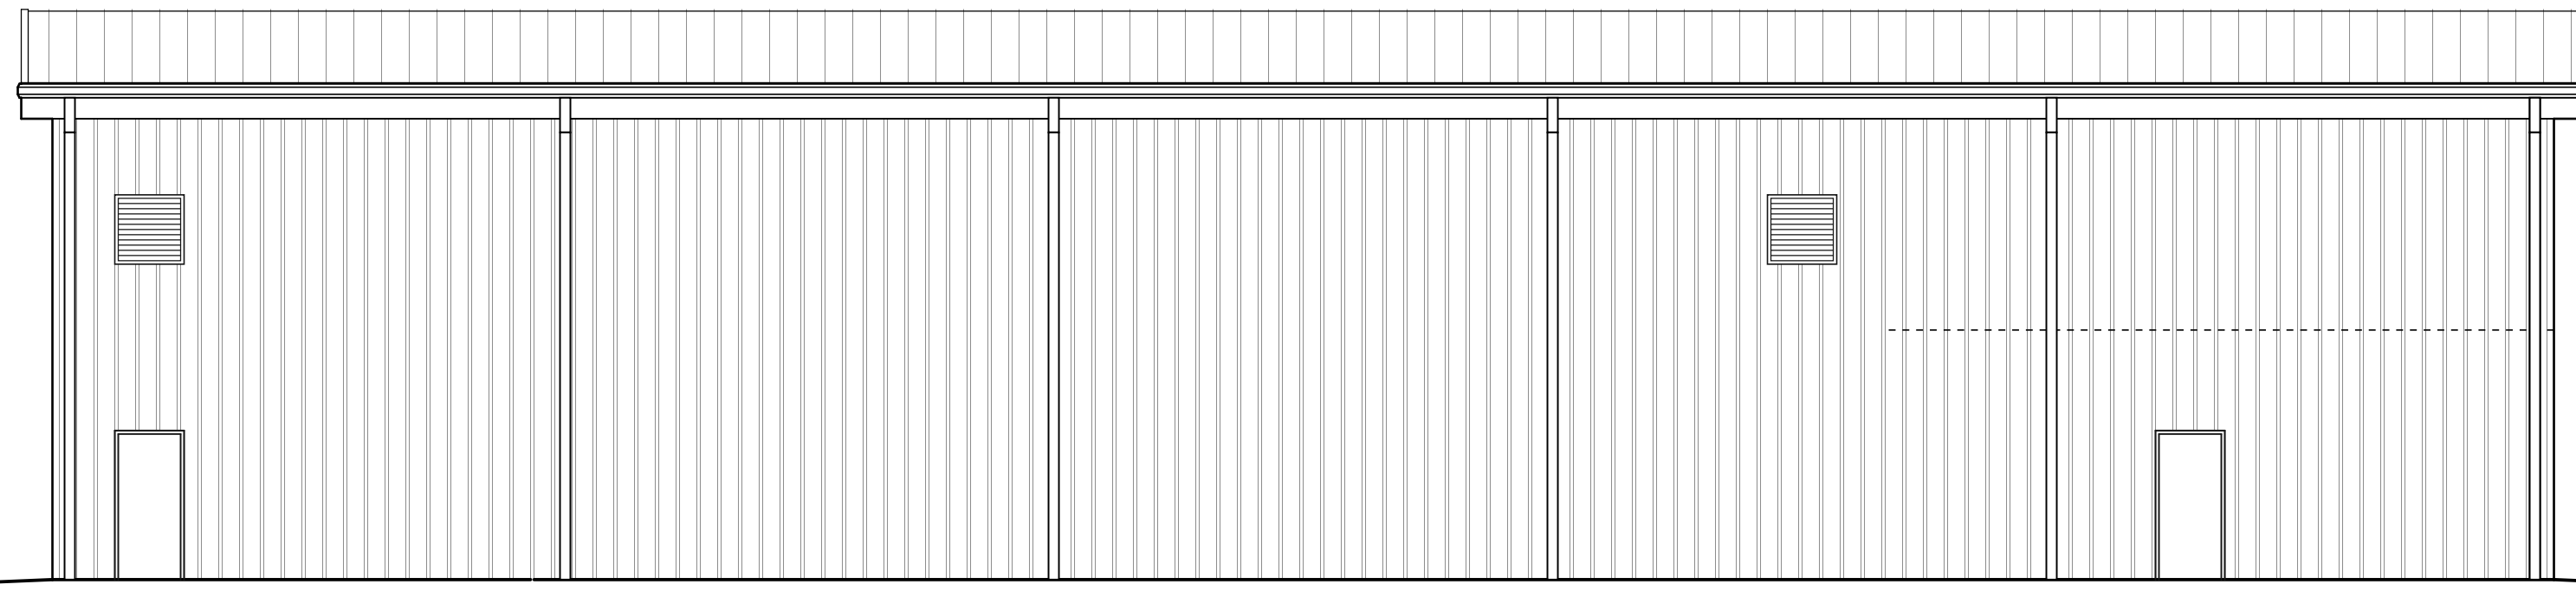


4 SIDE ELEVATION
SCALE: 1/8" = 1'-0"

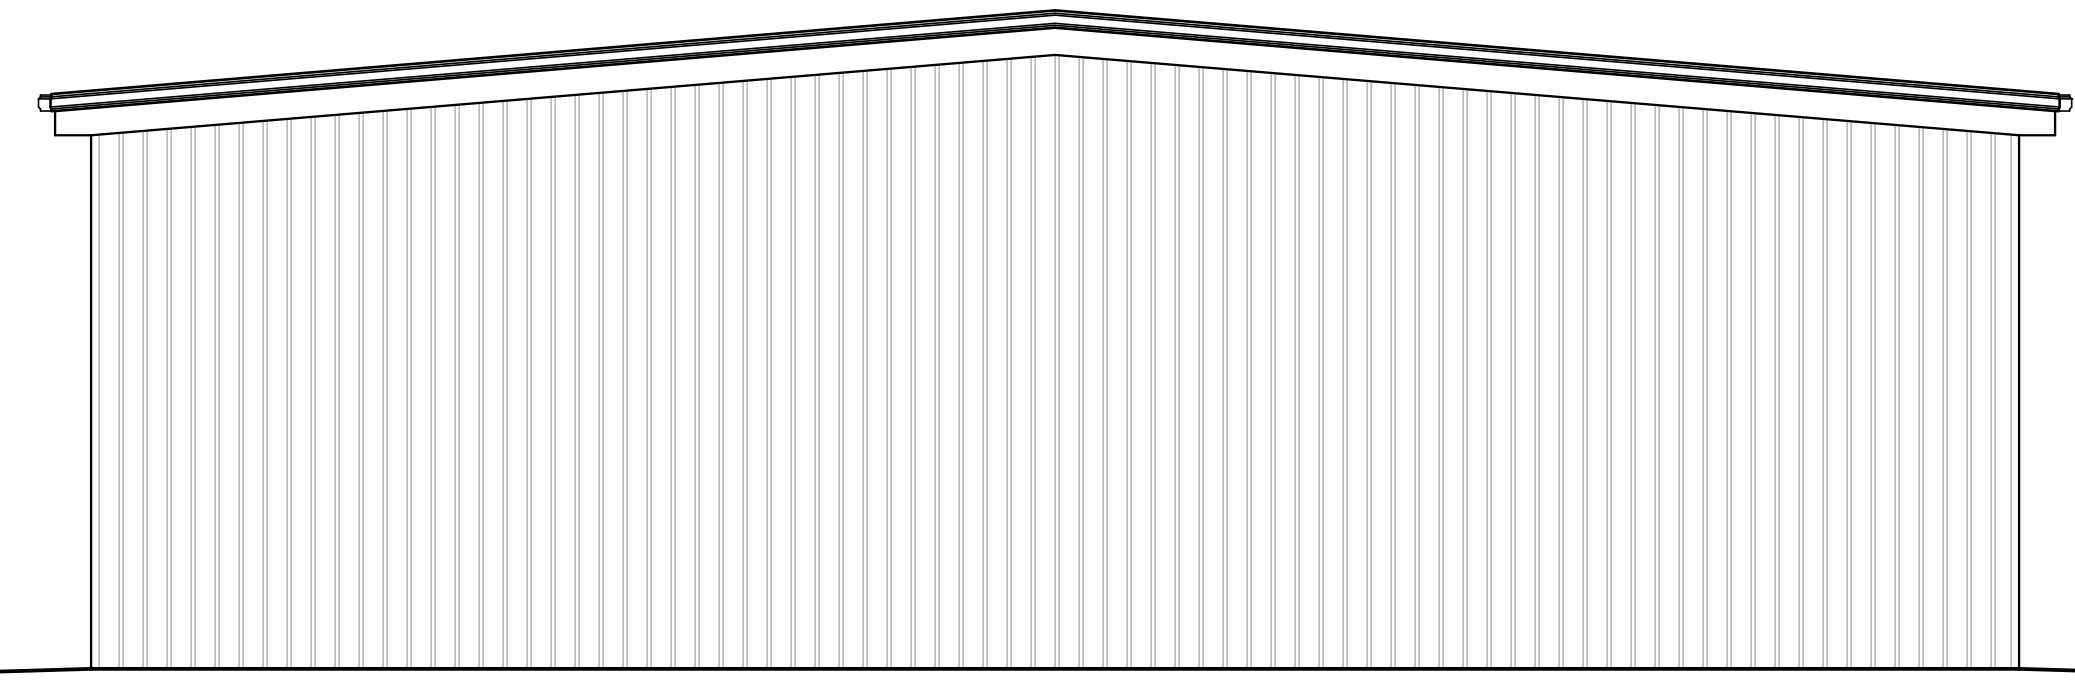

3 REAR ELEVATION
SCALE: 1/8" = 1'-0"

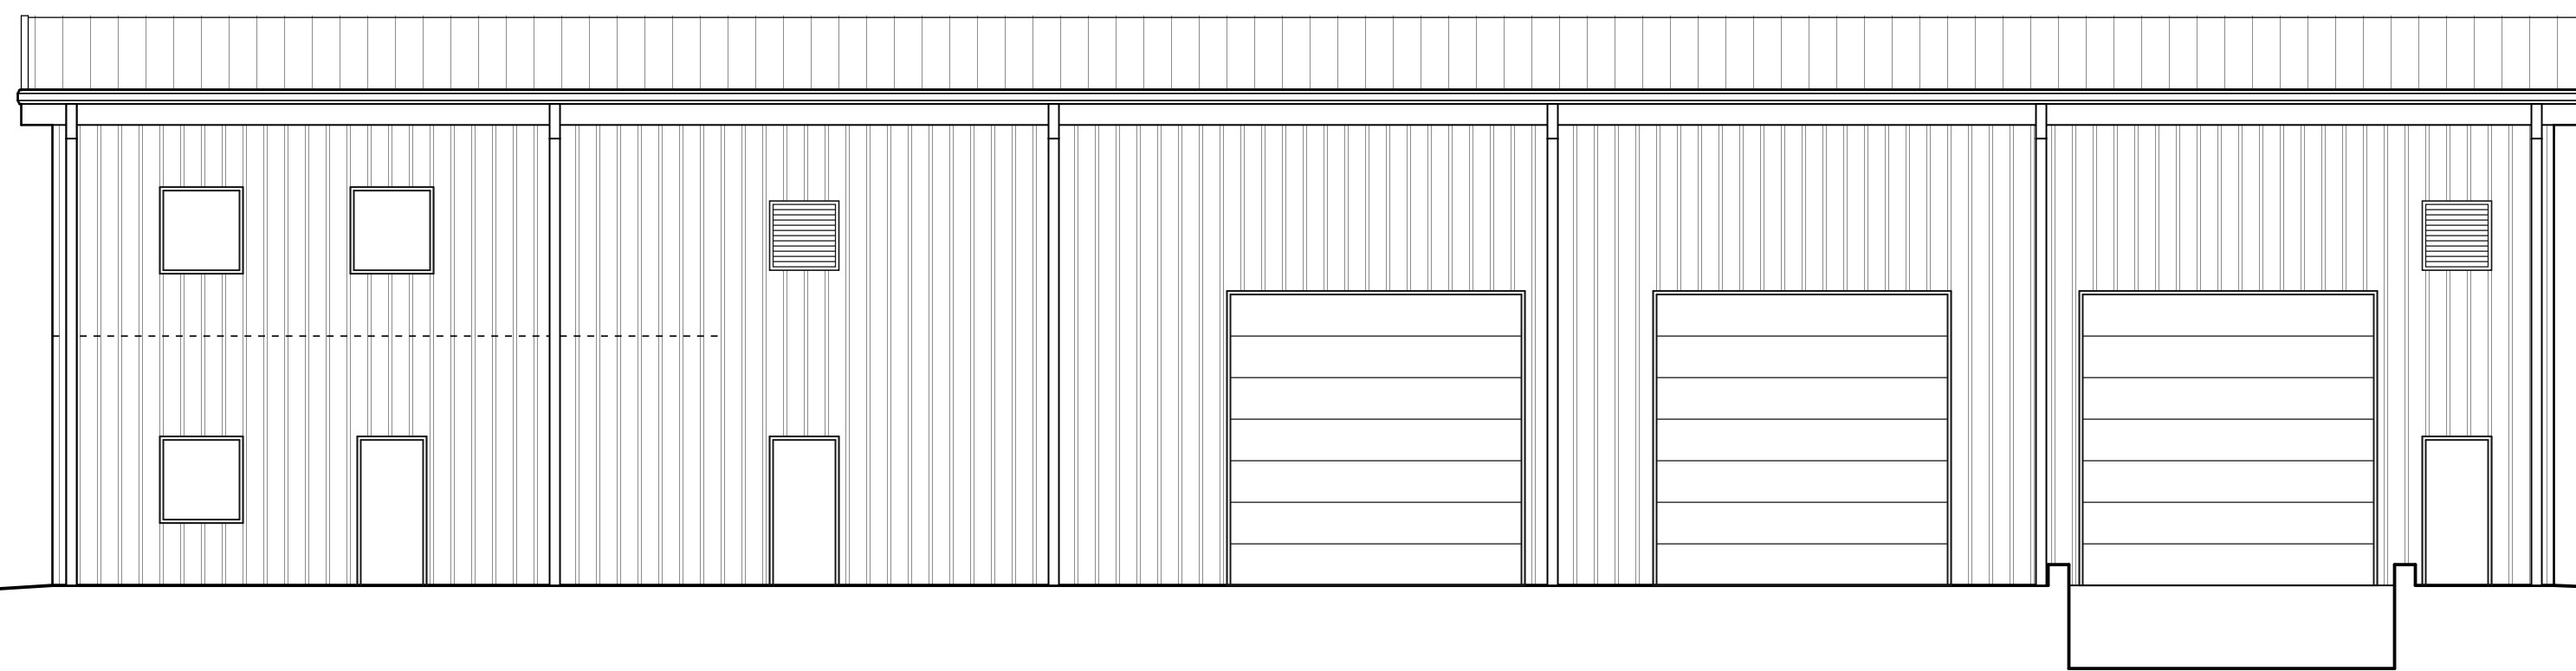

2 SIDE ELEVATION
SCALE: 1/8" = 1'-0"

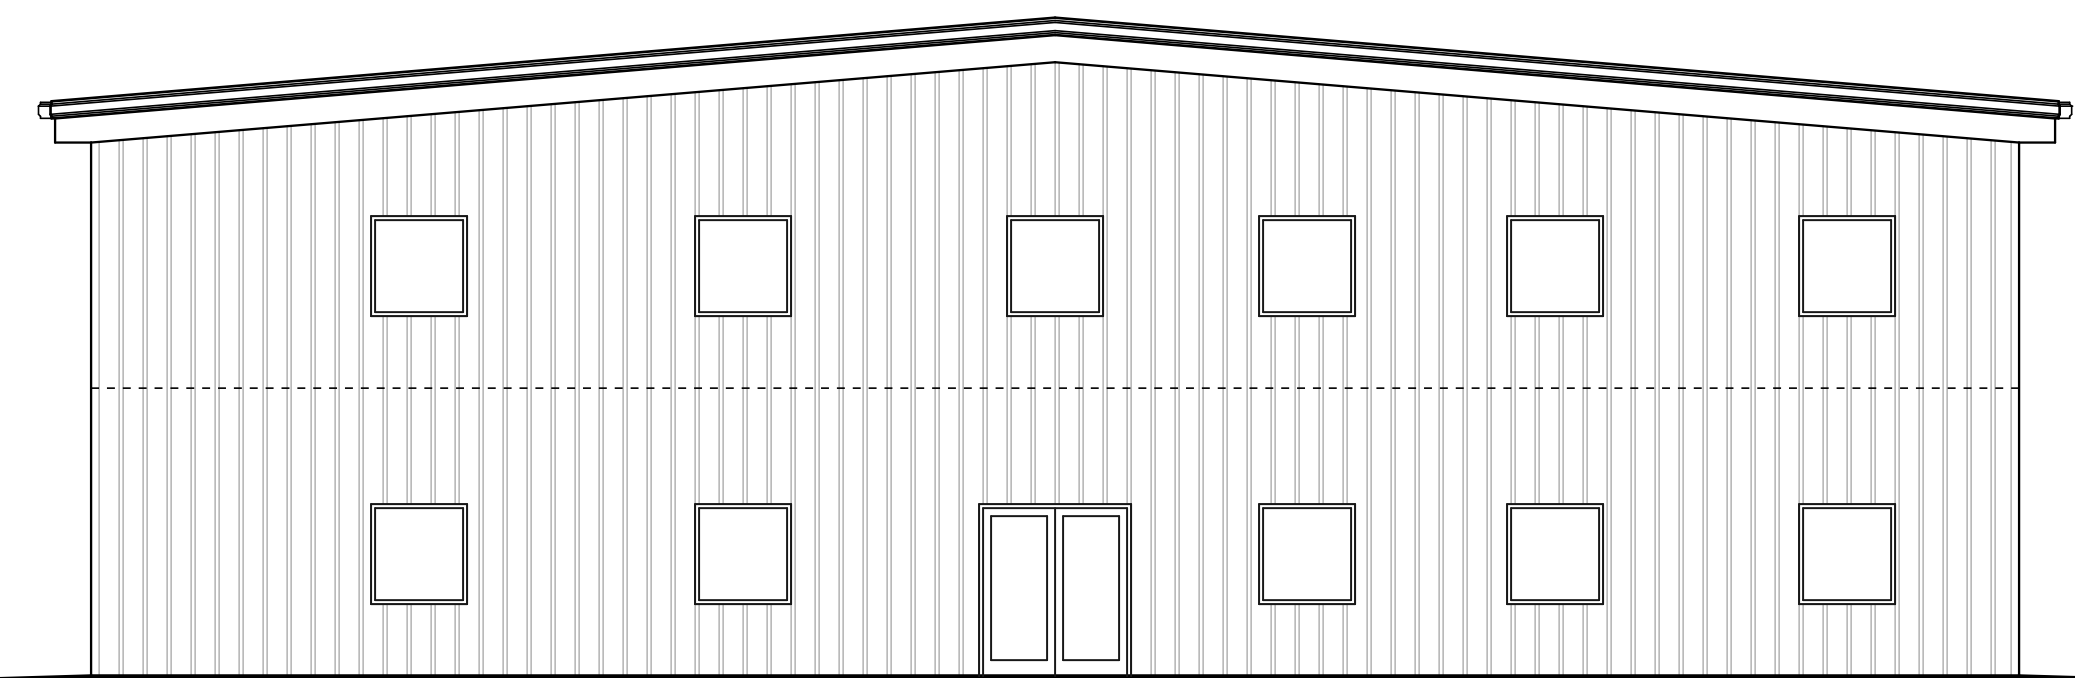

1 FRONT ELEVATION
SCALE: 1/8" = 1'-0"

FOR PERMIT
PROCESS ONLY

PROJECT TITLE
POWERMASTER
ELECTRIC
JARCO DRIVE
FUQUAY-VARINA, NORTH CAROLINA

PROJECT NO.
2019

DRAWING TITLE
ELEVATIONS

SHEET 0 OF 0

A2

PLOT DATE
REVISION 00/00/19

This original sheet is 24" x 36"; other dimensions indicate it has been altered.
All information on this sheet is the property of Weeks Turner Architecture and may not be duplicated in whole or in part without written authorization from Weeks Turner Architecture. 2019 ©