

# NORTHWEST HARNETT ELEMENTARY SCHOOL

736 ROLLINS ROAD,  
FUQUAY-VARINA, NC 27526

## ERRC

### PERMIT DRAWINGS

LEGEND LIST	
SYMBOL	DESCRIPTION
ANT	ANTENNA
2WAY	2WAY SPLITTER
4WAY	4WAY SPLITTER
REP	REPEATER
RISER	RISER

NORTH CAROLINA SOUND OF GOLDSBORO, LLC  
5413 HWY 117N  
PIKEVILLE, NC 27863  
PHONE: 919-709-4040  
WWW.NCSOUND.ORG



NORTH CAROLINA  
SOUND

- \* INTERCOM
- \* VOICE & DATA
- \* SECURITY
- \* CCTV
- \* MATV
- \* AV

Home Office:  
5413 Hwy 117N  
Pikeville, NC 27863  
919-709-4040 (Voice)  
919-709-4044 (Fax)

AUTHORIZED DEALER  
OF:

BOGEN  
COMMUNICATIONS,  
INC.

NAPCO  
SECURITY  
SYSTEMS

PANASONIC  
SURVEILLANCE  
SYSTEMS

NORTHWEST HARNETT ELEMENTARY SCHOOL  
736 ROLLINS ROAD  
FUQUAY-VARINA, NC 27526



Designed by: Adam Dutcher

DRAWN BY:



Rennie Brock

DATE: 5/22/2023

REVISIONS

REV #	DATE	DESCRIPTION

SYSTEM:  
ERRC  
PERMIT DRAWINGS

SHEET TITLE:  
COVER

SHEET NO.



COVER



LEGEND LIST	
SYMBOL	DESCRIPTION
ANT	ANTENNA
2WAY	2WAY SPLITTER
4WAY	4WAY SPLITTER
REP	REPEATER
RISER	RISER

01 PERMIT DRAWINGS - 1ST FLOOR ANTENNA LAYOUT  
 ERRRC01 SCALE: 1/32" = 1'-0"

02 1ST FLOOR KEY PLAN  
 ERRRC01 SCALE: NTS

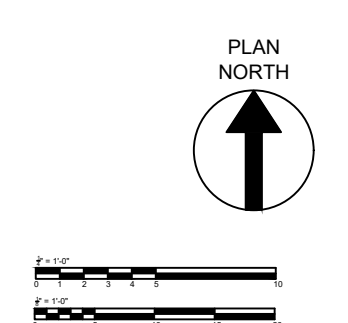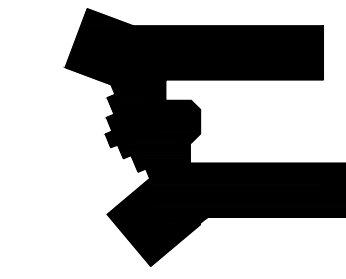



NORTH CAROLINA SOUND  
 \* INTERCOM  
 \* VOICE & DATA  
 \* SECURITY  
 \* CCTV  
 \* MATV  
 \* AV

Home Office:  
 5413 Hwy 177N  
 Pineville, NC 27863  
 919-709-4040 (Voice)  
 910-709-4044 (Fax)

AUTHORIZED DEALER OF:  
 BOGEN COMMUNICATIONS, INC.  
 NAPCO SECURITY SYSTEMS  
 PANASONIC SURVEILLANCE SYSTEMS

NORTHWEST HARNETT ELEMENTARY SCHOOL  
 736 ROLLINS ROAD  
 FUQUAY-VARINA, NC 27526

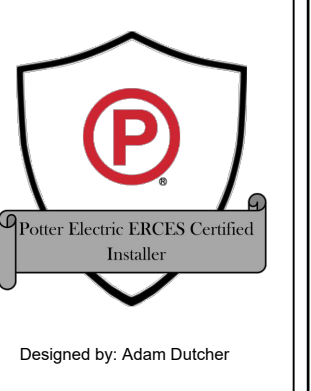

DRAWN BY:  
  
 Rennis Brock  
 DATE: 5/22/2023

REVISIONS		
REV #	DATE	DESCRIPTION

SYSTEM:  
 ERRC PERMIT DRAWINGS  
 SHEET TITLE:  
 1ST FLOOR ANTENNA LAYOUT  
 SHEET NO.  
**ERRC01**



NORTH CAROLINA SOUND

- \* INTERCOM
- \* VOICE & DATA
- \* SECURITY
- \* CCTV
- \* MATV
- \* AV

Home Office:  
 5413 Hwy 117N  
 Pineville, NC 27863  
 919-709-4040 (Voice)  
 910-709-4044 (Fax)


AUTHORIZED DEALER OF:

BOGEN COMMUNICATIONS, INC.

NAPCO SECURITY SYSTEMS


PANASONIC SURVEILLANCE SYSTEMS

NORTHWEST HARNETT ELEMENTARY SCHOOL  
 736 ROLLINS ROAD  
 FUQUAY-VARINA, NC 27526

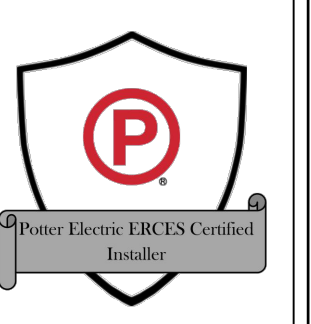

Designed by: Adam Dutcher

DRAWN BY:

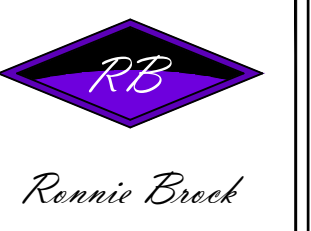

DATE: 5/22/2023

REVISIONS		
REV #	DATE	DESCRIPTION


SYSTEM: ERRC PERMIT DRAWINGS

SHEET TITLE: 2ND FLOOR ANTENNA LAYOUT

SHEET NO.


ERRC02


LEGEND LIST	
SYMBOL	DESCRIPTION
ANT	ANTENNA
2WAY	2WAY SPLITTER
4WAY	4WAY SPLITTER
REP	REPEATER
RISER	RISER

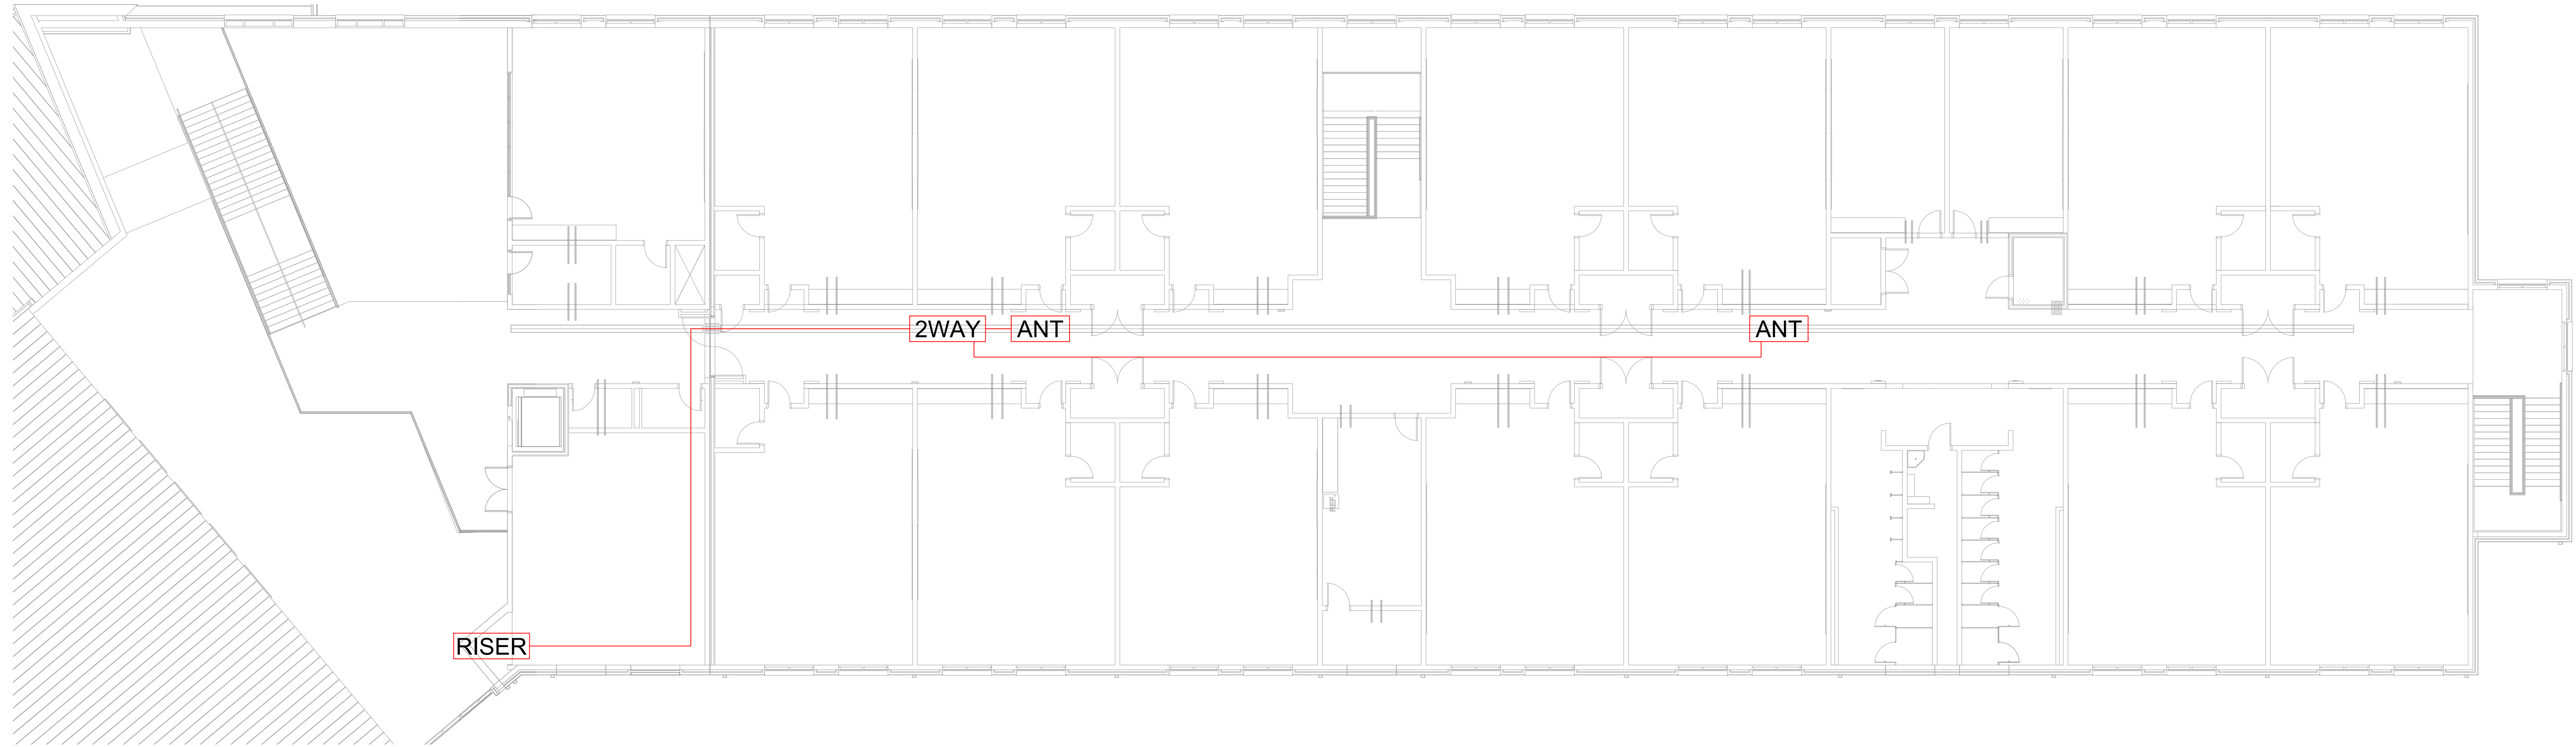


01 PERMIT DRAWINGS - 2ND FLOOR ANTENNA LAYOUT  
 ERRC02 SCALE: 3/32" = 1'-0"

02 2ND FLOOR KEY PLAN  
 ERRC02 SCALE: NTS

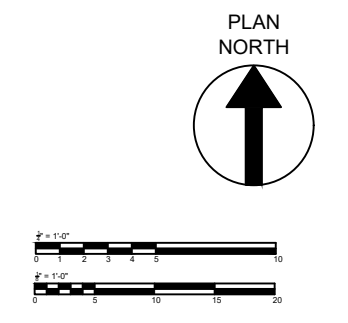

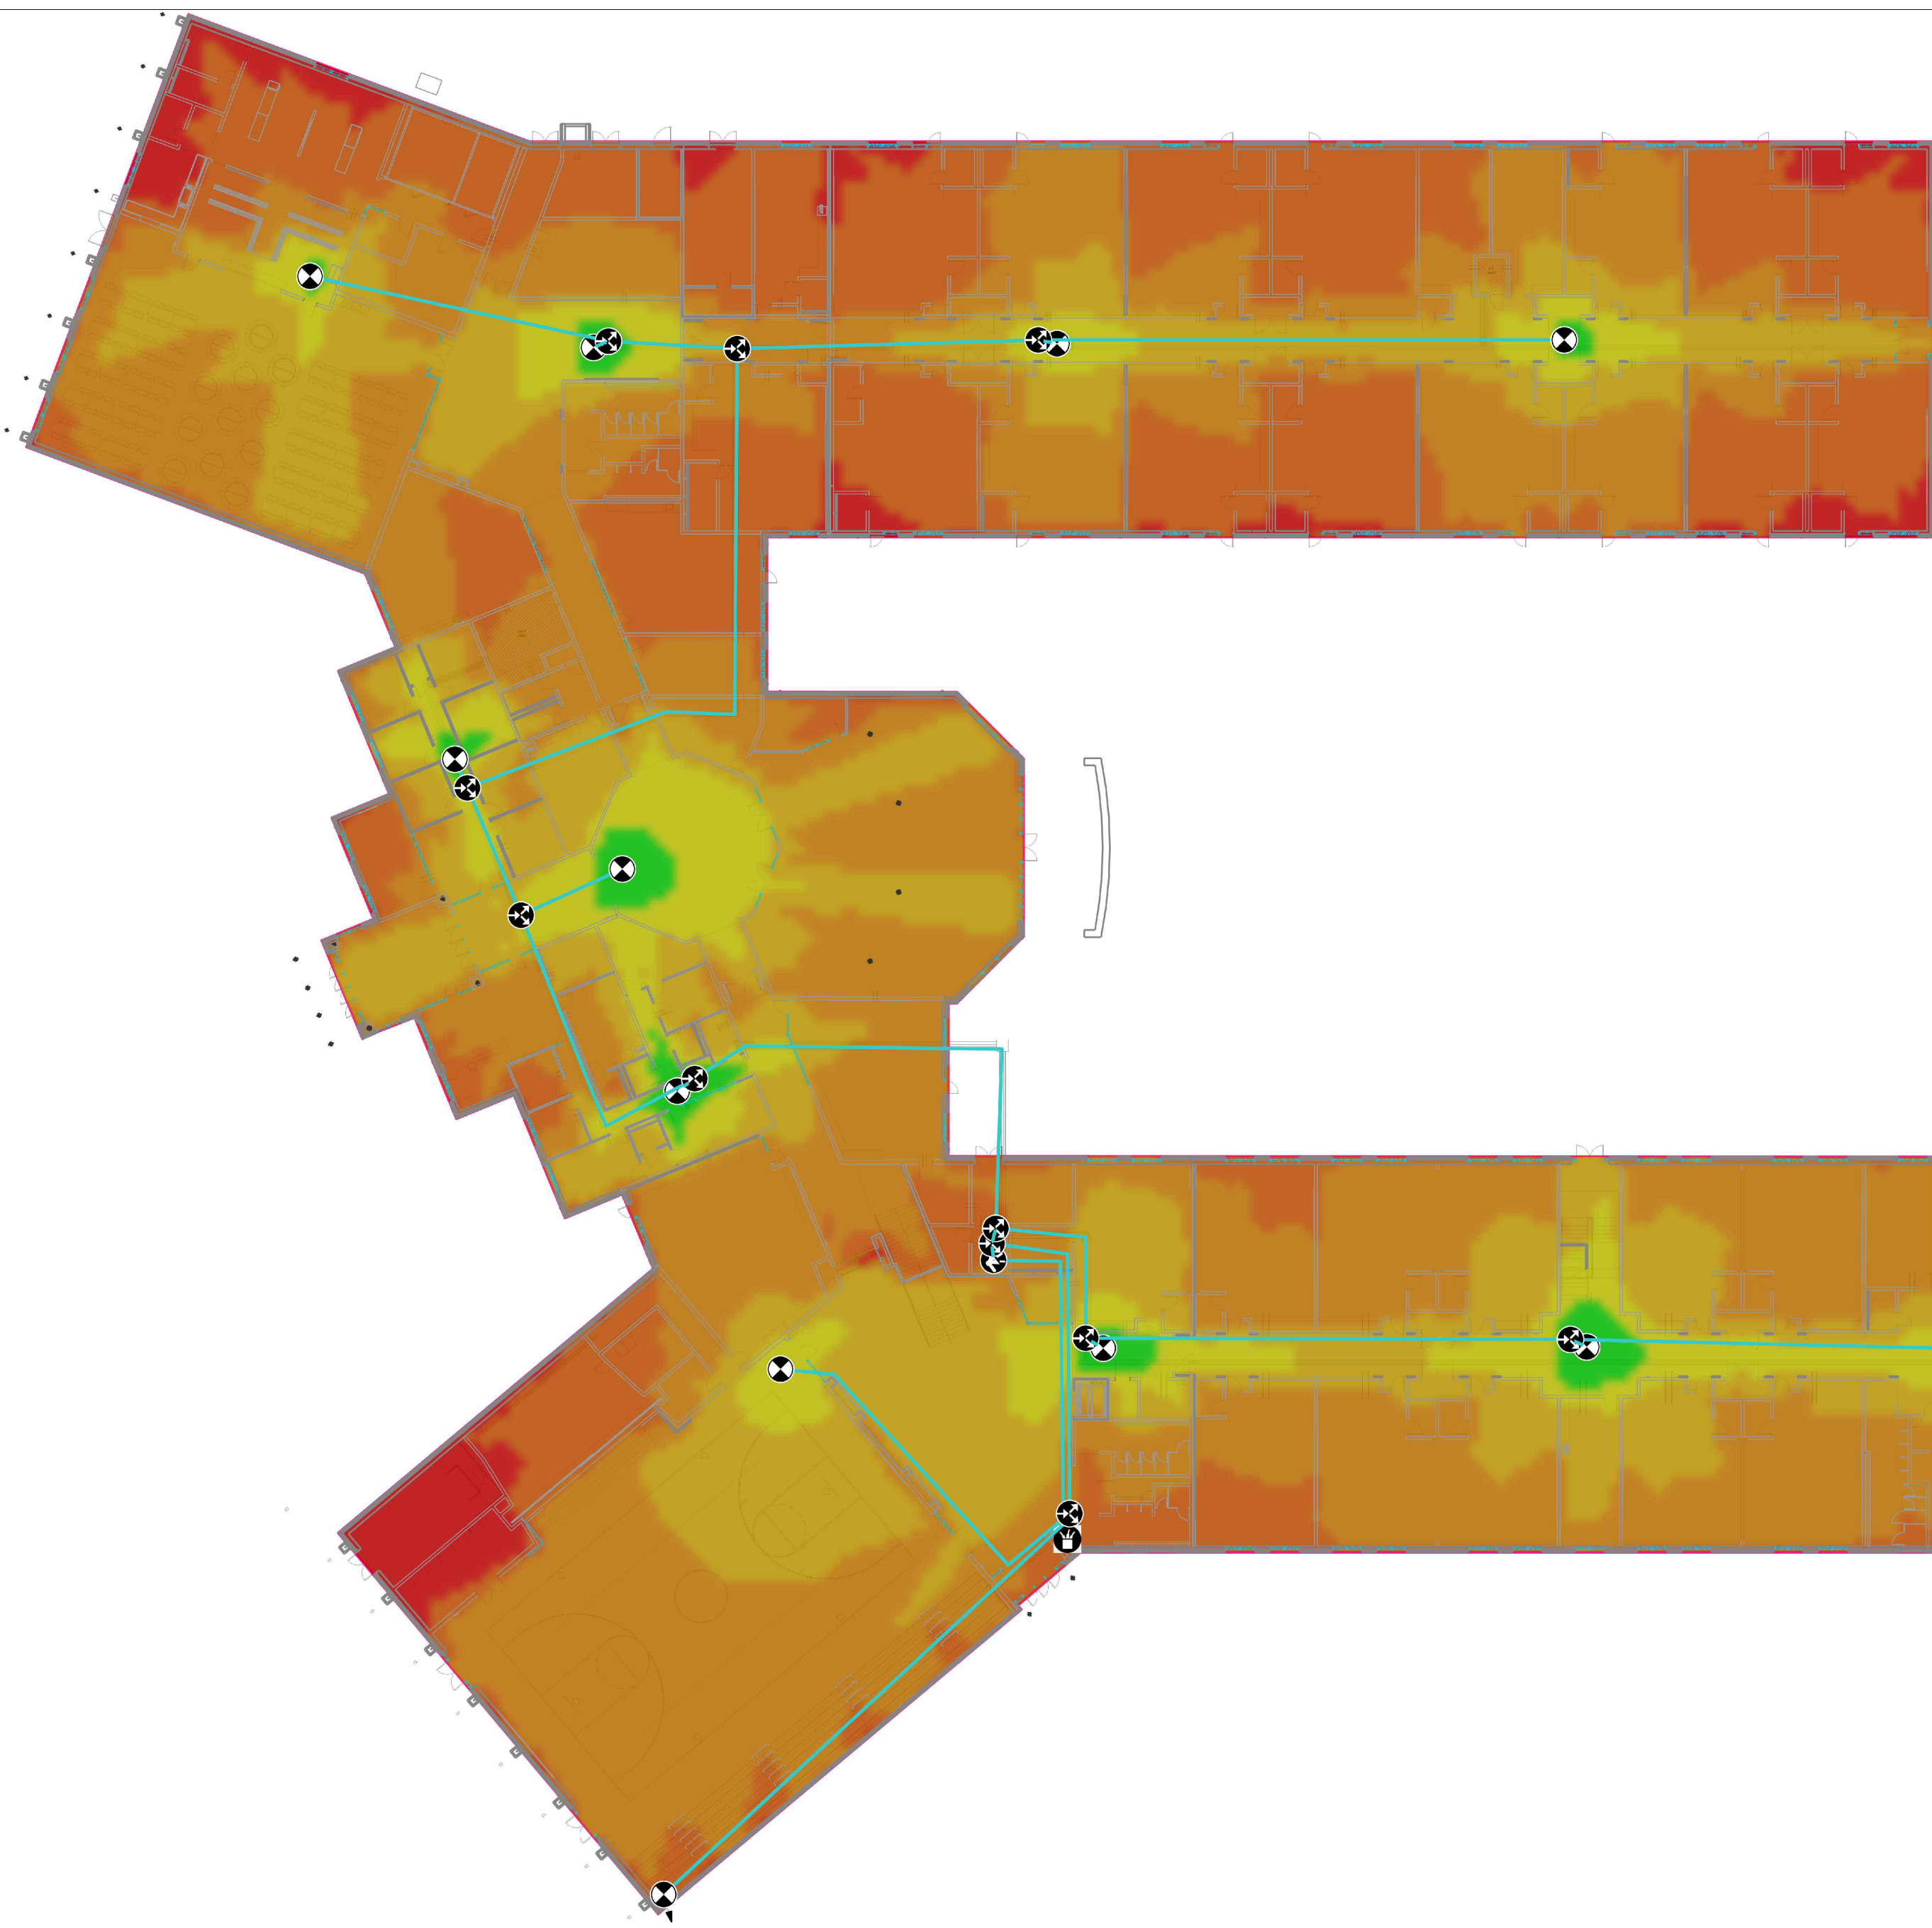

01 PERMIT DRAWINGS - 1ST FLOOR PLAN  
ERRC03 SCALE: 1/32" = 1'-0"

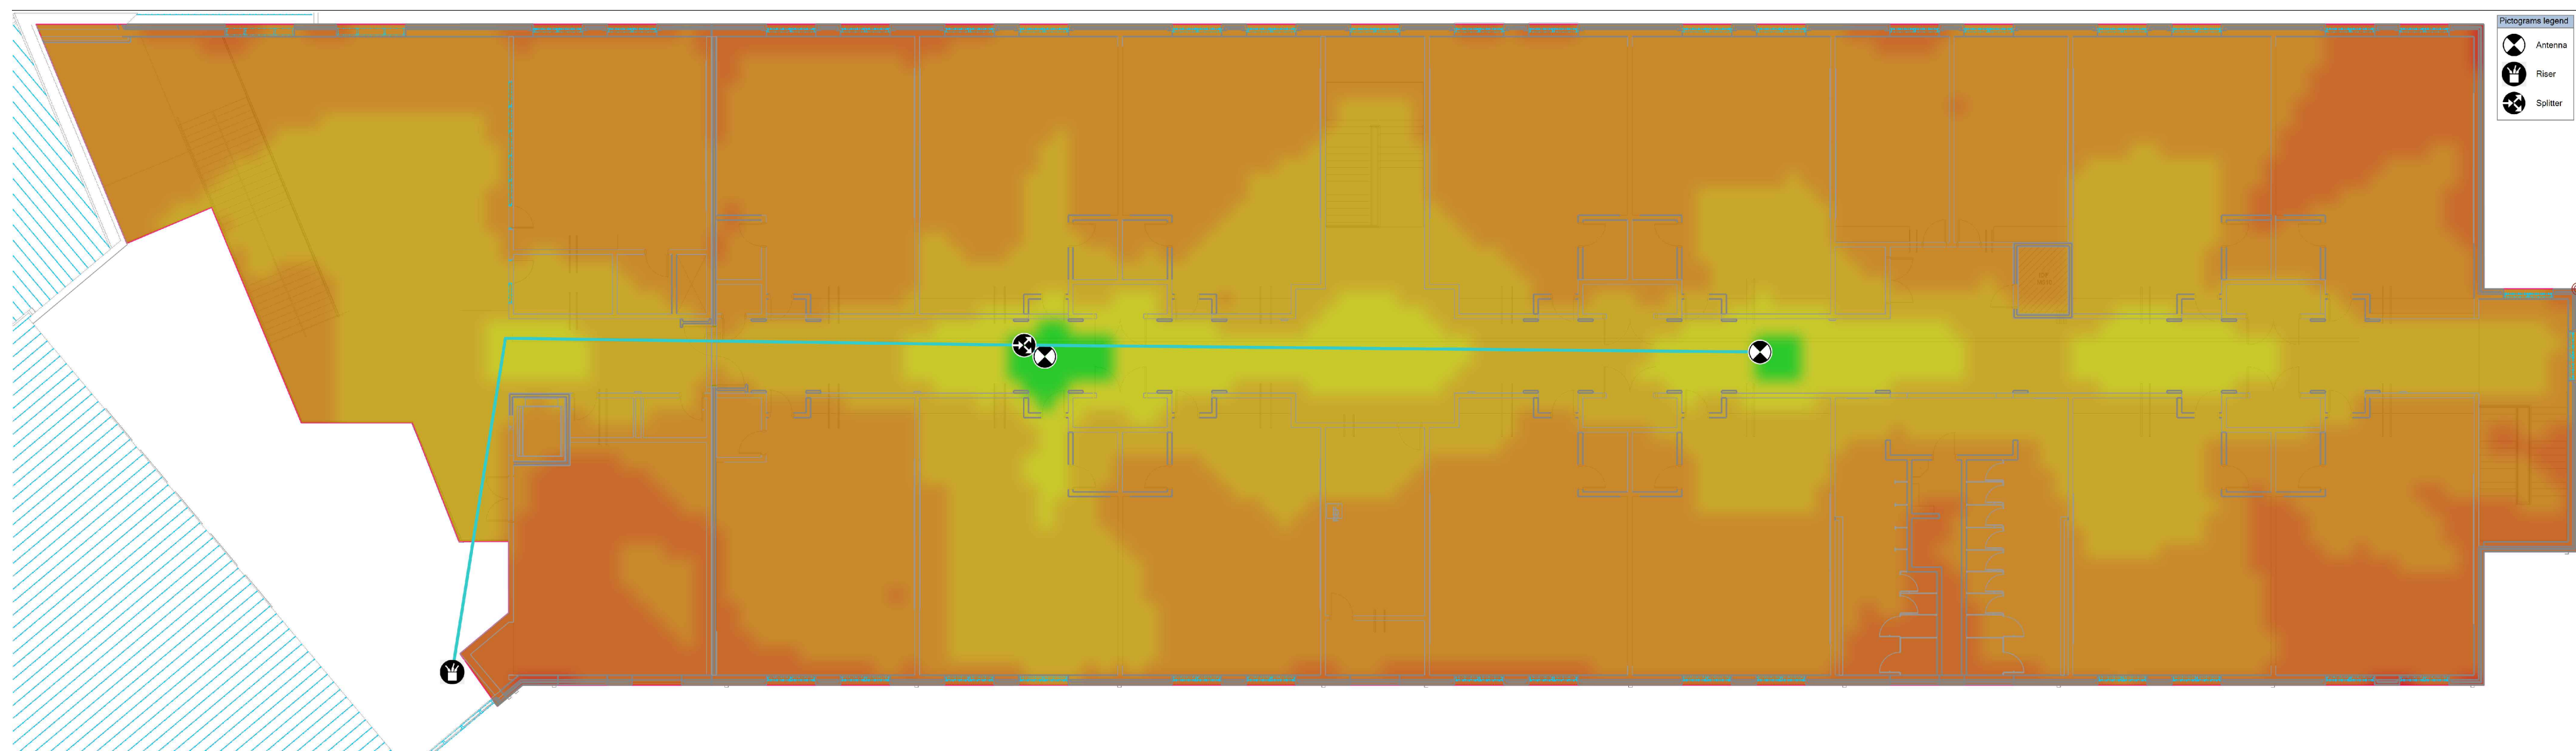

02 PERMIT DRAWINGS - 2ND FLOOR PLAN  
ERRC03 SCALE: 1/32" = 1'-0"



NORTH CAROLINA SOUND

- \* INTERCOM
- \* VOICE & DATA
- \* SECURITY
- \* CCTV
- \* MATV
- \* AV

Home Office:  
5413 Hwy 117N  
Pineville, NC 27863  
919-709-4040 (Voice)  
910-709-4044 (Fax)

AUTHORIZED DEALER OF:

BOGEN COMMUNICATIONS, INC.

NAPCO SECURITY SYSTEMS

PANASONIC SURVEILLANCE SYSTEMS

NORTHWEST HARNETT ELEMENTARY SCHOOL  
 736 ROLLINS ROAD  
 FUQUAY-VARINA, NC 27526



Designed by: Adam Dutcher

DRAWN BY:



DATE: 5/22/2023

REVISIONS		
REV #	DATE	DESCRIPTION

SYSTEM:  
ERRC PERMIT DRAWINGS

SHEET TITLE:  
FLOOR PLANS

SHEET NO.  
**ERRC03**

