

NORTHWEST HARNETT ELEMENTARY SCHOOL

736 ROLLINS ROAD,
FUQUAY-VARINA, NC 27526

ERRC

PERMIT DRAWINGS

LEGEND LIST	
SYMBOL	DESCRIPTION
ANT	ANTENNA
2WAY	2WAY SPLITTER
4WAY	4WAY SPLITTER
REP	REPEATER
RISER	RISER

NORTH CAROLINA SOUND OF GOLDSBORO, LLC
5413 HWY 117N
PIKEVILLE, NC 27863
PHONE: 919-709-4040
WWW.NCSOUND.ORG



NORTH CAROLINA
SOUND

- * INTERCOM
- * VOICE & DATA
- * SECURITY
- * CCTV
- * MATV
- * AV

Home Office:
5413 Hwy 117N
Pikeville, NC 27863
919-709-4040 (Voice)
919-709-4044 (Fax)

AUTHORIZED DEALER
OF:

BOGEN
COMMUNICATIONS,
INC.

NAPCO
SECURITY
SYSTEMS

PANASONIC
SURVEILLANCE
SYSTEMS

NORTHWEST HARNETT ELEMENTARY SCHOOL
736 ROLLINS ROAD
FUQUAY-VARINA, NC 27526



Designed by: Adam Dutcher

DRAWN BY:



Rennie Brock

DATE: 5/22/2023

REVISIONS


REV #	DATE	DESCRIPTION

SYSTEM:
ERRC
PERMIT DRAWINGS

SHEET TITLE:
COVER

SHEET NO.


COVER

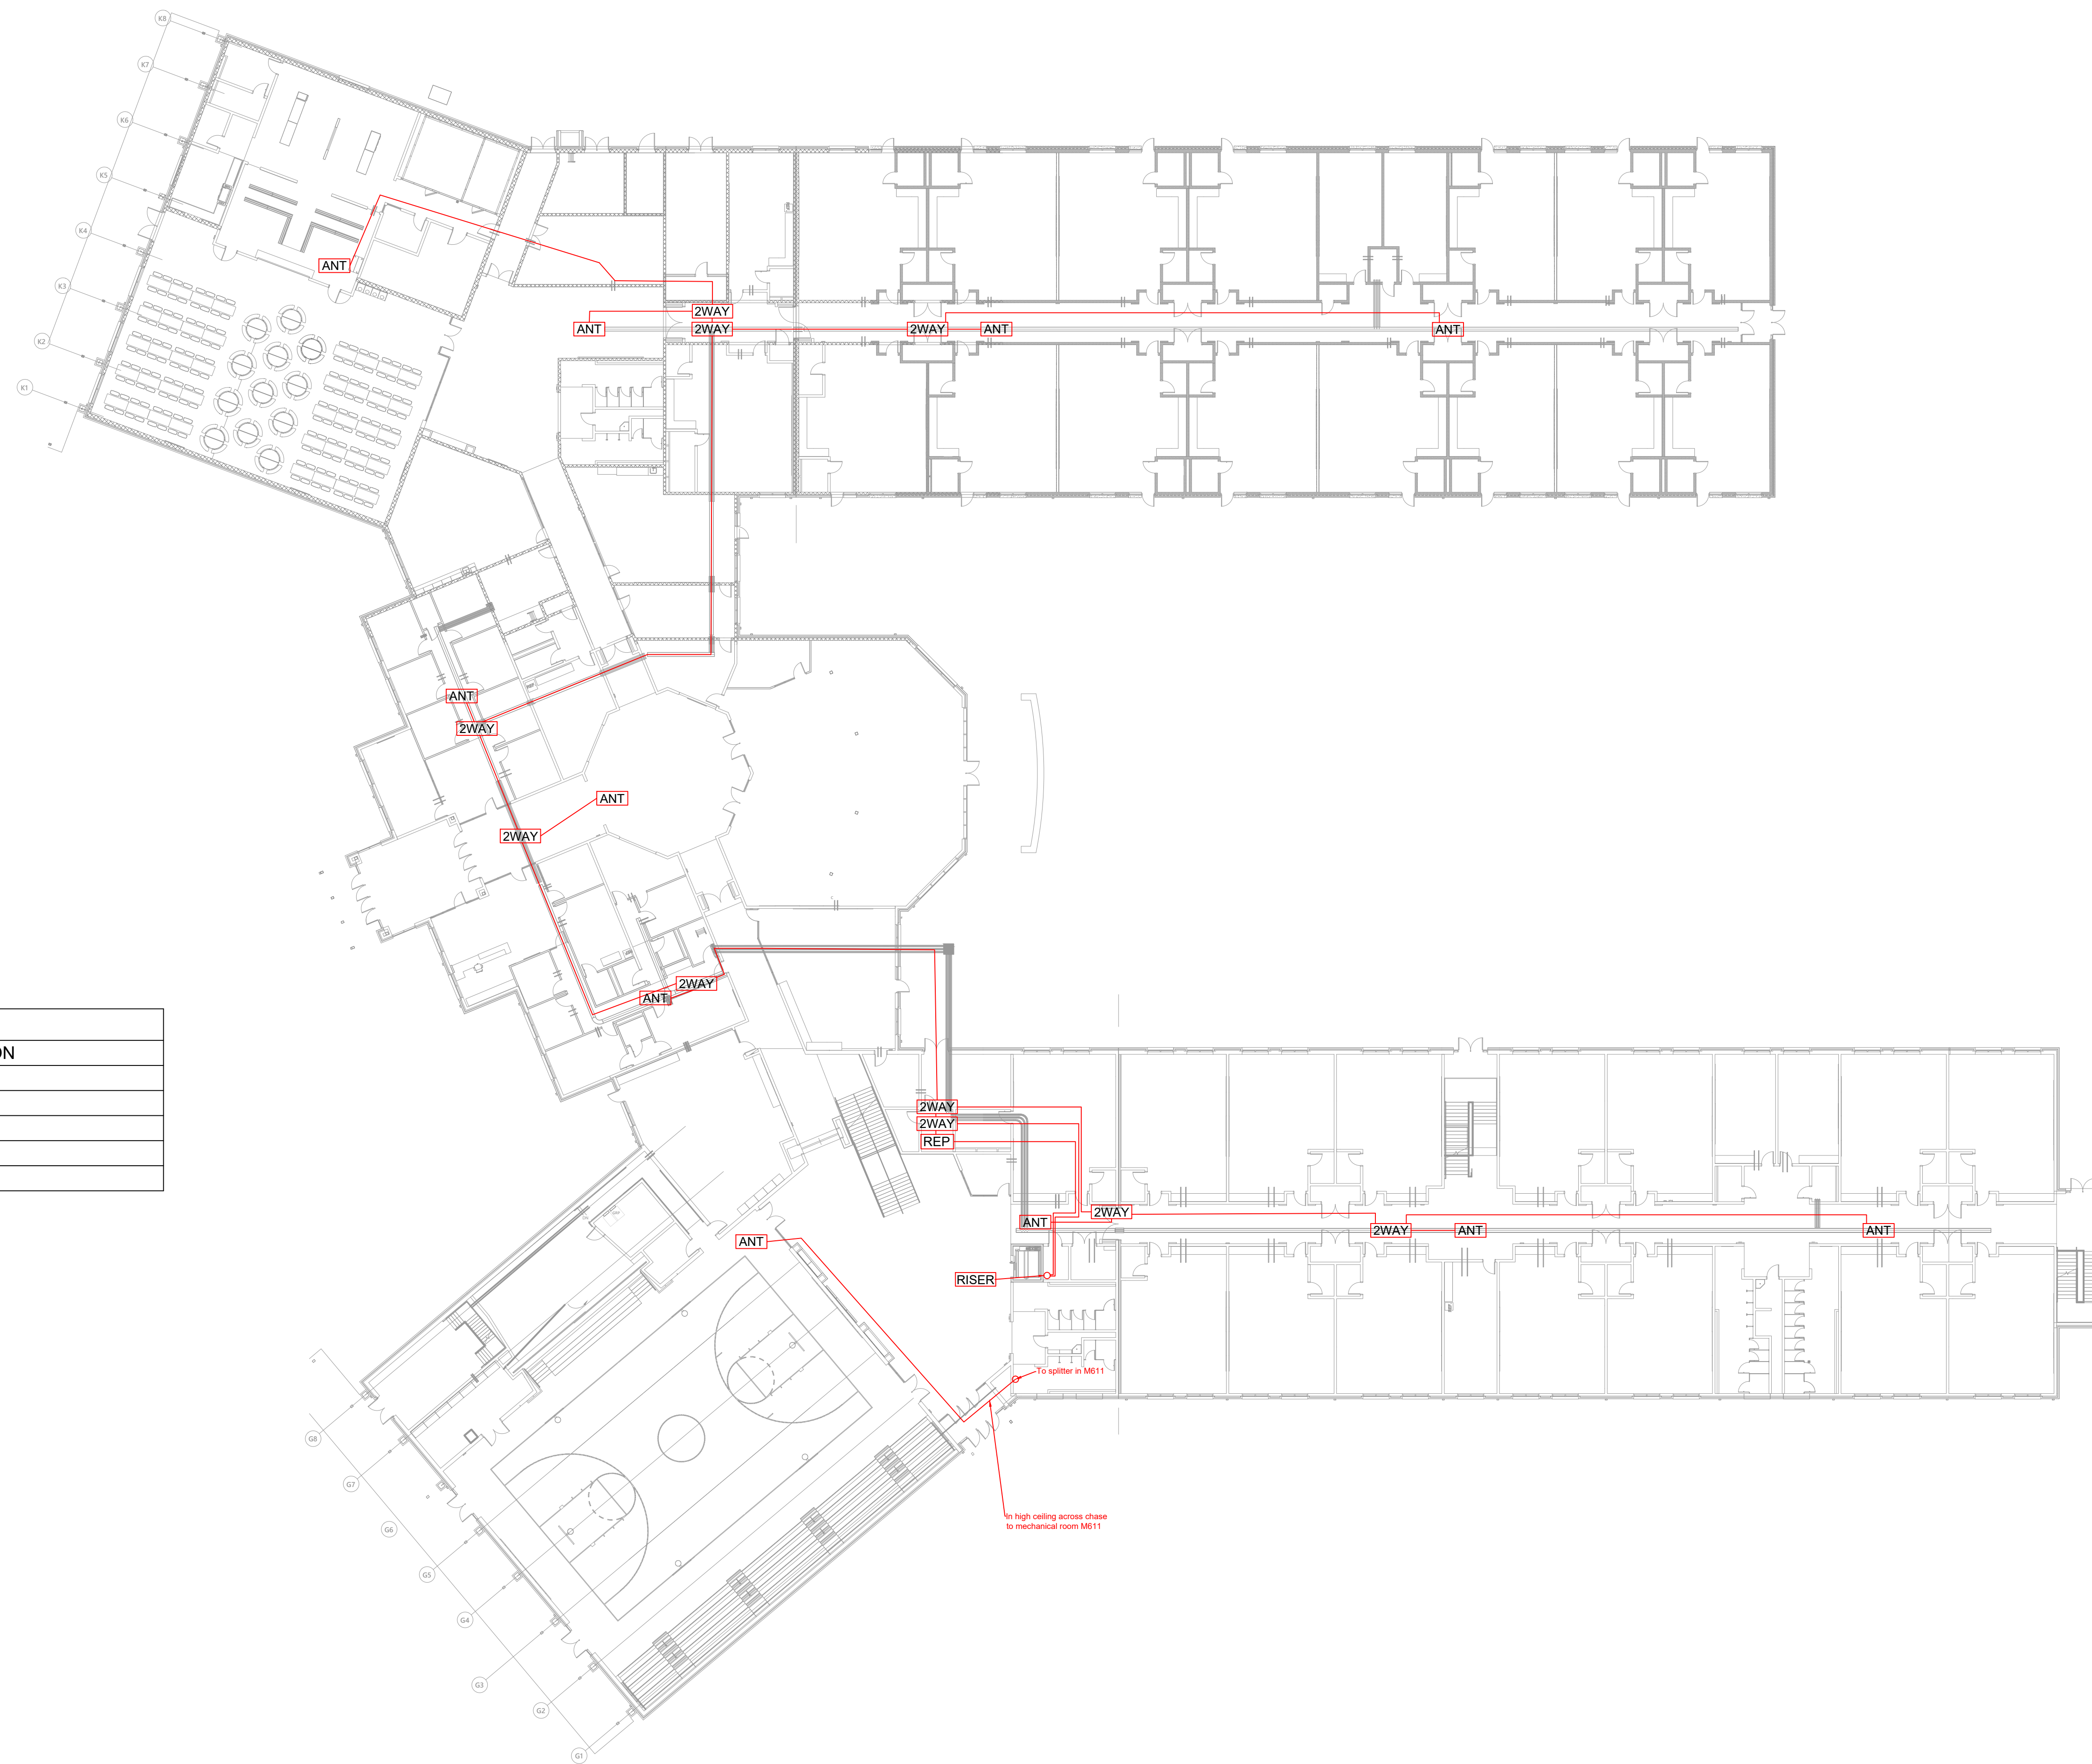

LEGEND LIST	
SYMBOL	DESCRIPTION
ANT	ANTENNA
2WAY	2WAY SPLITTER
4WAY	4WAY SPLITTER
REP	REPEATER
RISER	RISER

01 PERMIT DRAWINGS - 1ST FLOOR ANTENNA LAYOUT
 ERRC01 SCALE: 1/32" = 1'-0"

02 1ST FLOOR KEY PLAN
 ERRC01 SCALE: NTS

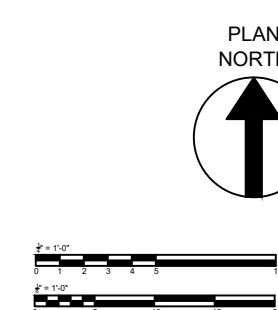

NORTH CAROLINA SOUND

- * INTERCOM
- * VOICE & DATA
- * SECURITY
- * CCTV
- * MATV
- * AV

Home Office:
 5413 Hwy 17N
 Pineville, NC 27863
 919-709-4040 (Voice)
 910-709-4044 (Fax)


AUTHORIZED DEALER OF:

BOGEN COMMUNICATIONS, INC.


NAPCO SECURITY SYSTEMS

PANASONIC SURVEILLANCE SYSTEMS

NORTHWEST HARNETT ELEMENTARY SCHOOL
 736 ROLLINS ROAD
 FUQUAY-VARINA, NC 27526

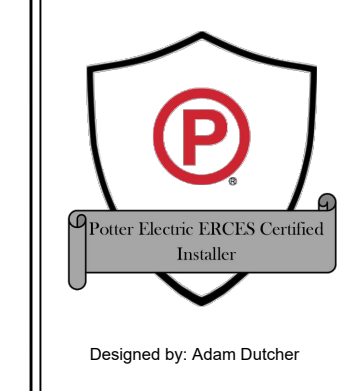

DRAWN BY:

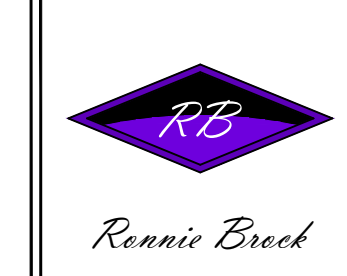

DATE: 5/22/2023

REVISIONS		
REV #	DATE	DESCRIPTION

SYSTEM:
 ERRC
 PERMIT DRAWINGS

SHEET TITLE:
 1ST FLOOR ANTENNA LAYOUT

SHEET NO.
ERRC01



NORTH CAROLINA SOUND

- * INTERCOM
- * VOICE & DATA
- * SECURITY
- * CCTV
- * MATV
- * AV

Home Office:
 5413 Hwy 117N
 Pineville, NC 27863
 919-709-4040 (Voice)
 910-709-4044 (Fax)


AUTHORIZED DEALER OF:

BOGEN COMMUNICATIONS, INC.

NAPCO SECURITY SYSTEMS


PANASONIC SURVEILLANCE SYSTEMS

NORTHWEST HARNETT ELEMENTARY SCHOOL
 736 ROLLINS ROAD
 FUQUAY-VARINA, NC 27526

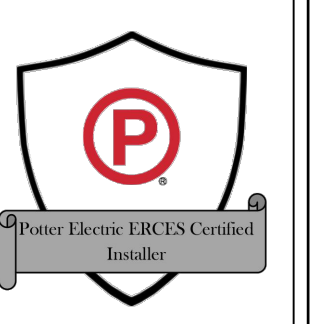

Designed by: Adam Dutcher

DRAWN BY:

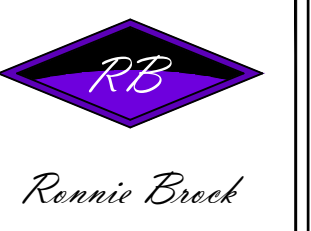

DATE: 5/22/2023

REV #	DATE	DESCRIPTION


SYSTEM: ERRC PERMIT DRAWINGS

SHEET TITLE: 2ND FLOOR ANTENNA LAYOUT

SHEET NO.


ERRC02


LEGEND LIST	
SYMBOL	DESCRIPTION
ANT	ANTENNA
2WAY	2WAY SPLITTER
4WAY	4WAY SPLITTER
REP	REPEATER
RISER	RISER

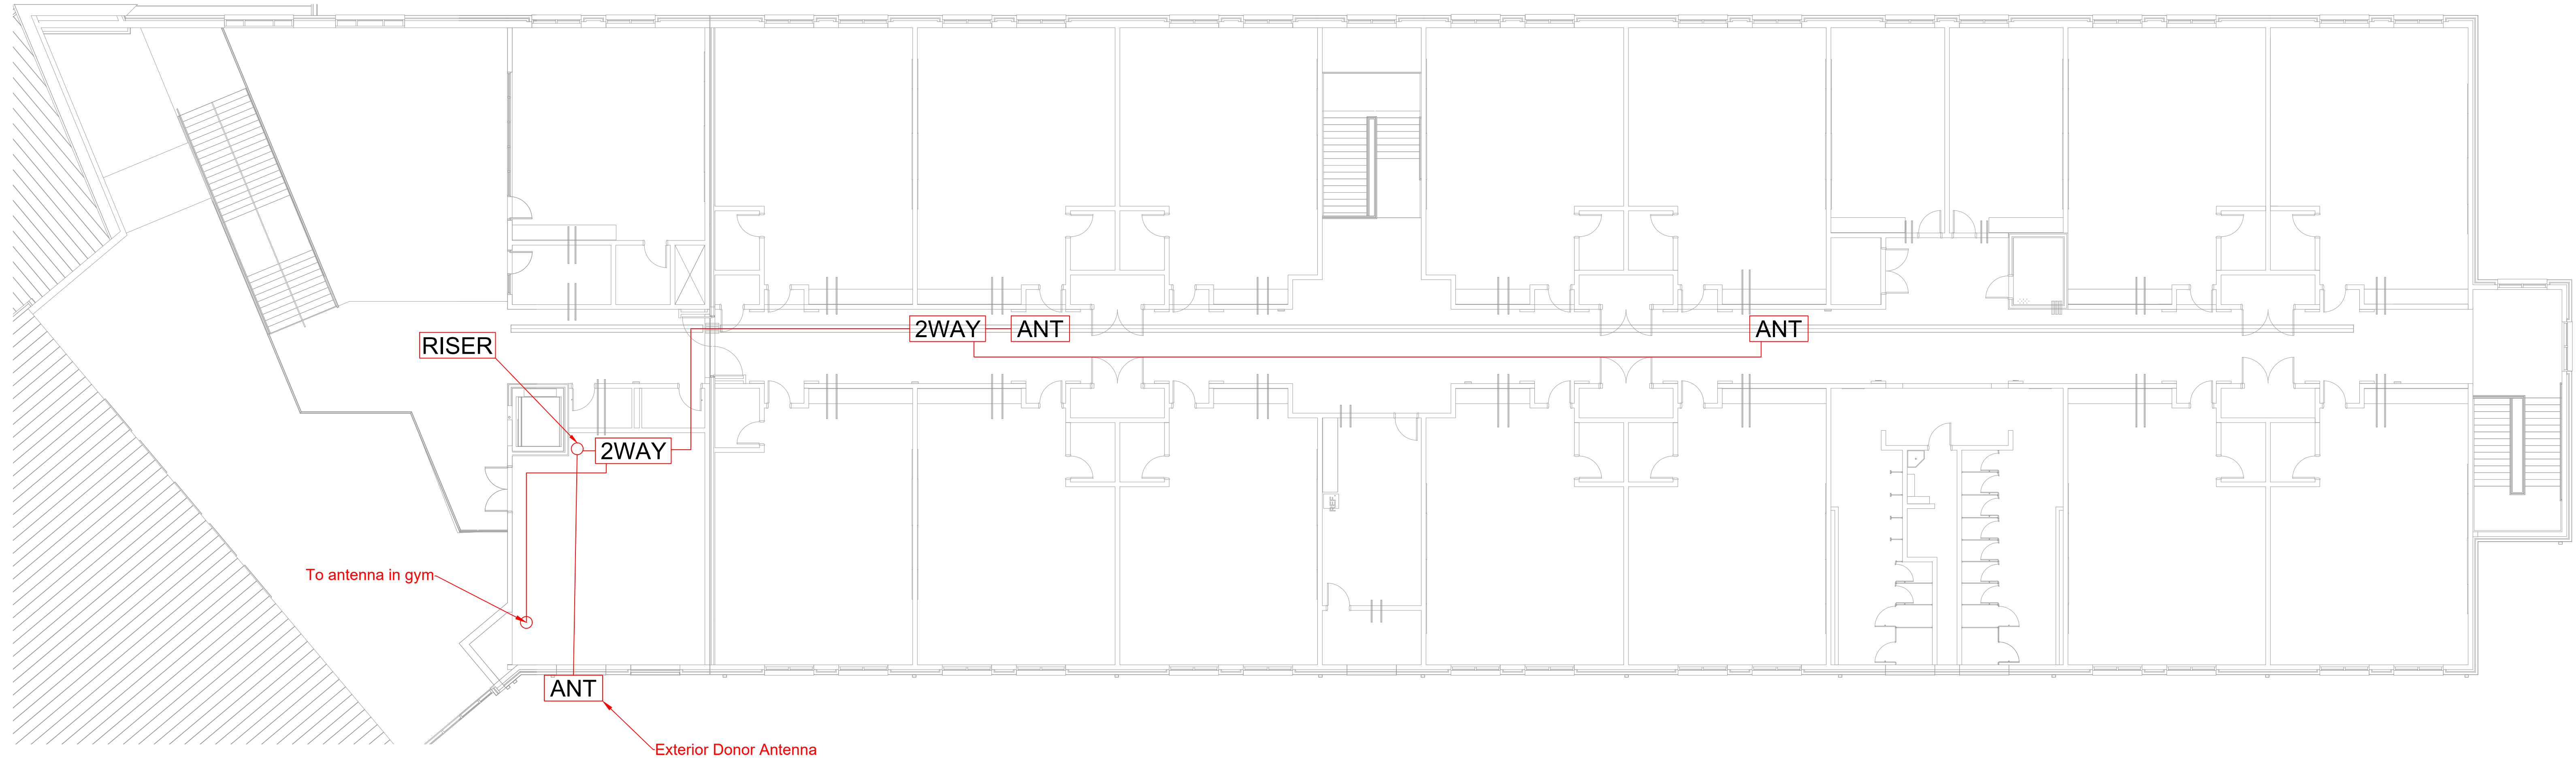


01 PERMIT DRAWINGS - 2ND FLOOR ANTENNA LAYOUT
 ERRC02 SCALE: 3/32" = 1'-0"

02 2ND FLOOR KEY PLAN
 ERRC02 SCALE: NTS

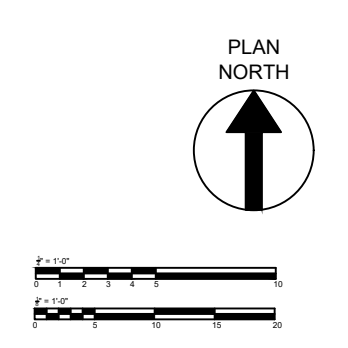

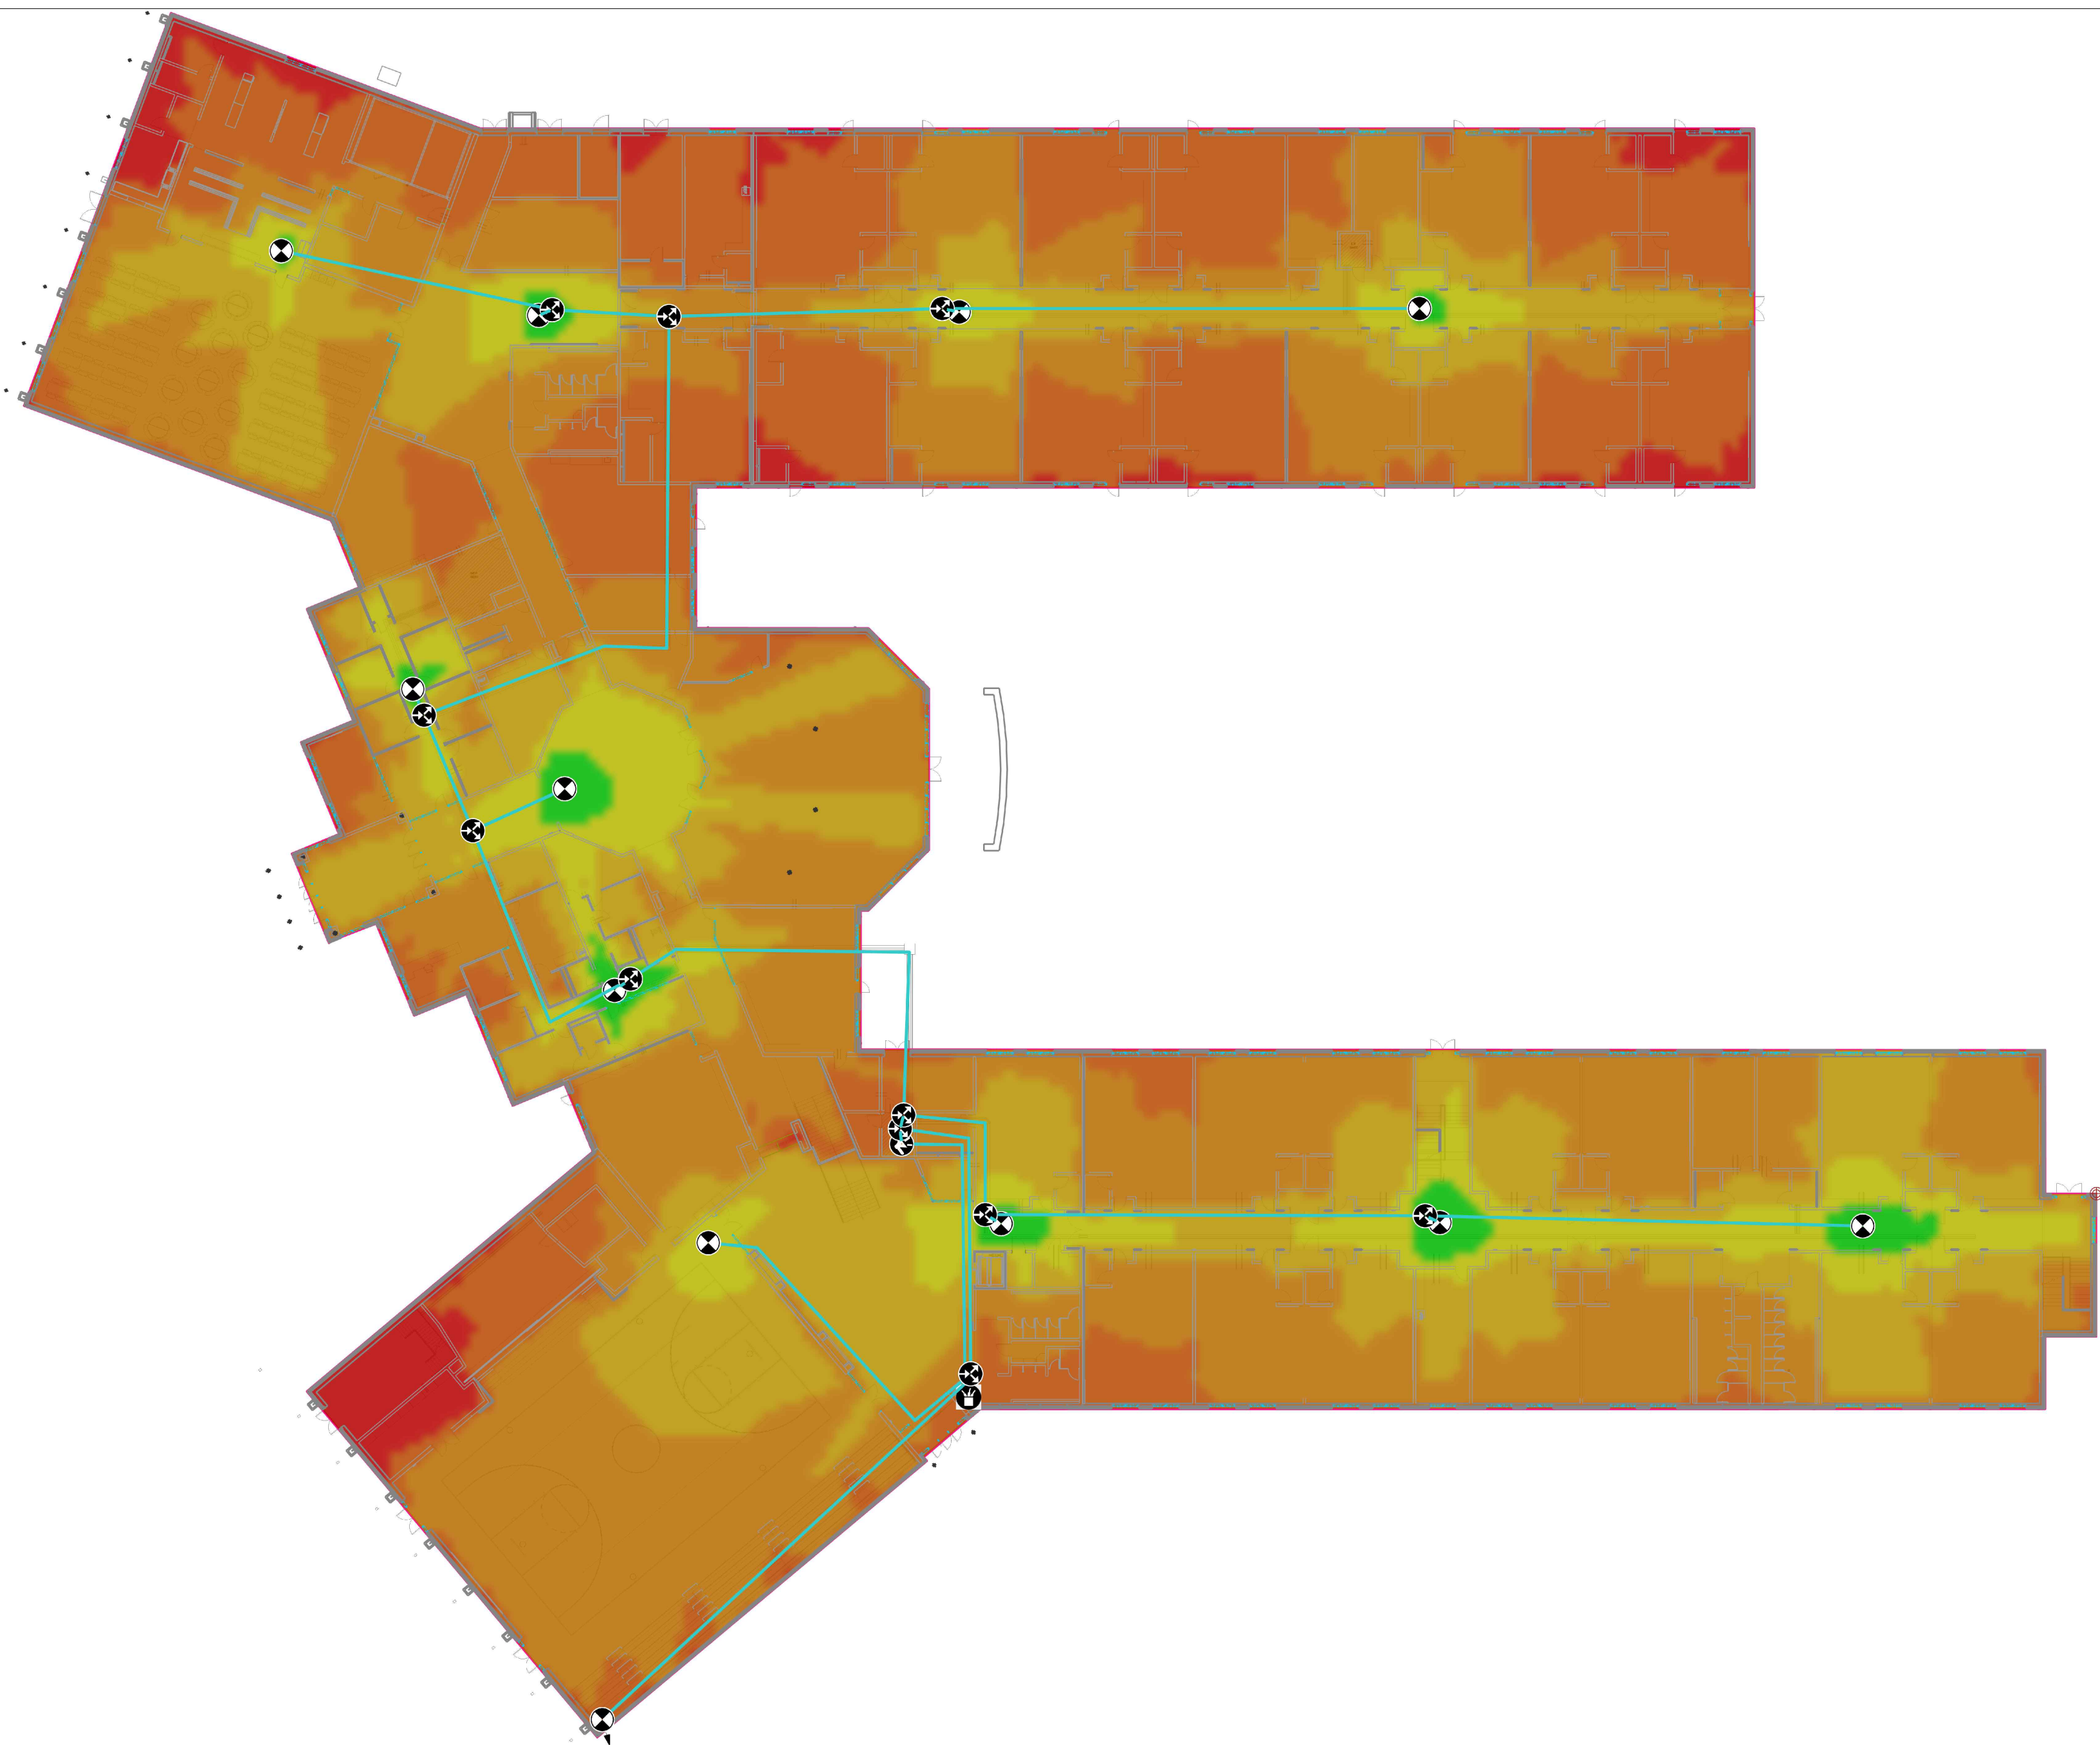

01 PERMIT DRAWINGS - 1ST FLOOR PLAN
ERRC03 SCALE: 1/32" = 1'-0"

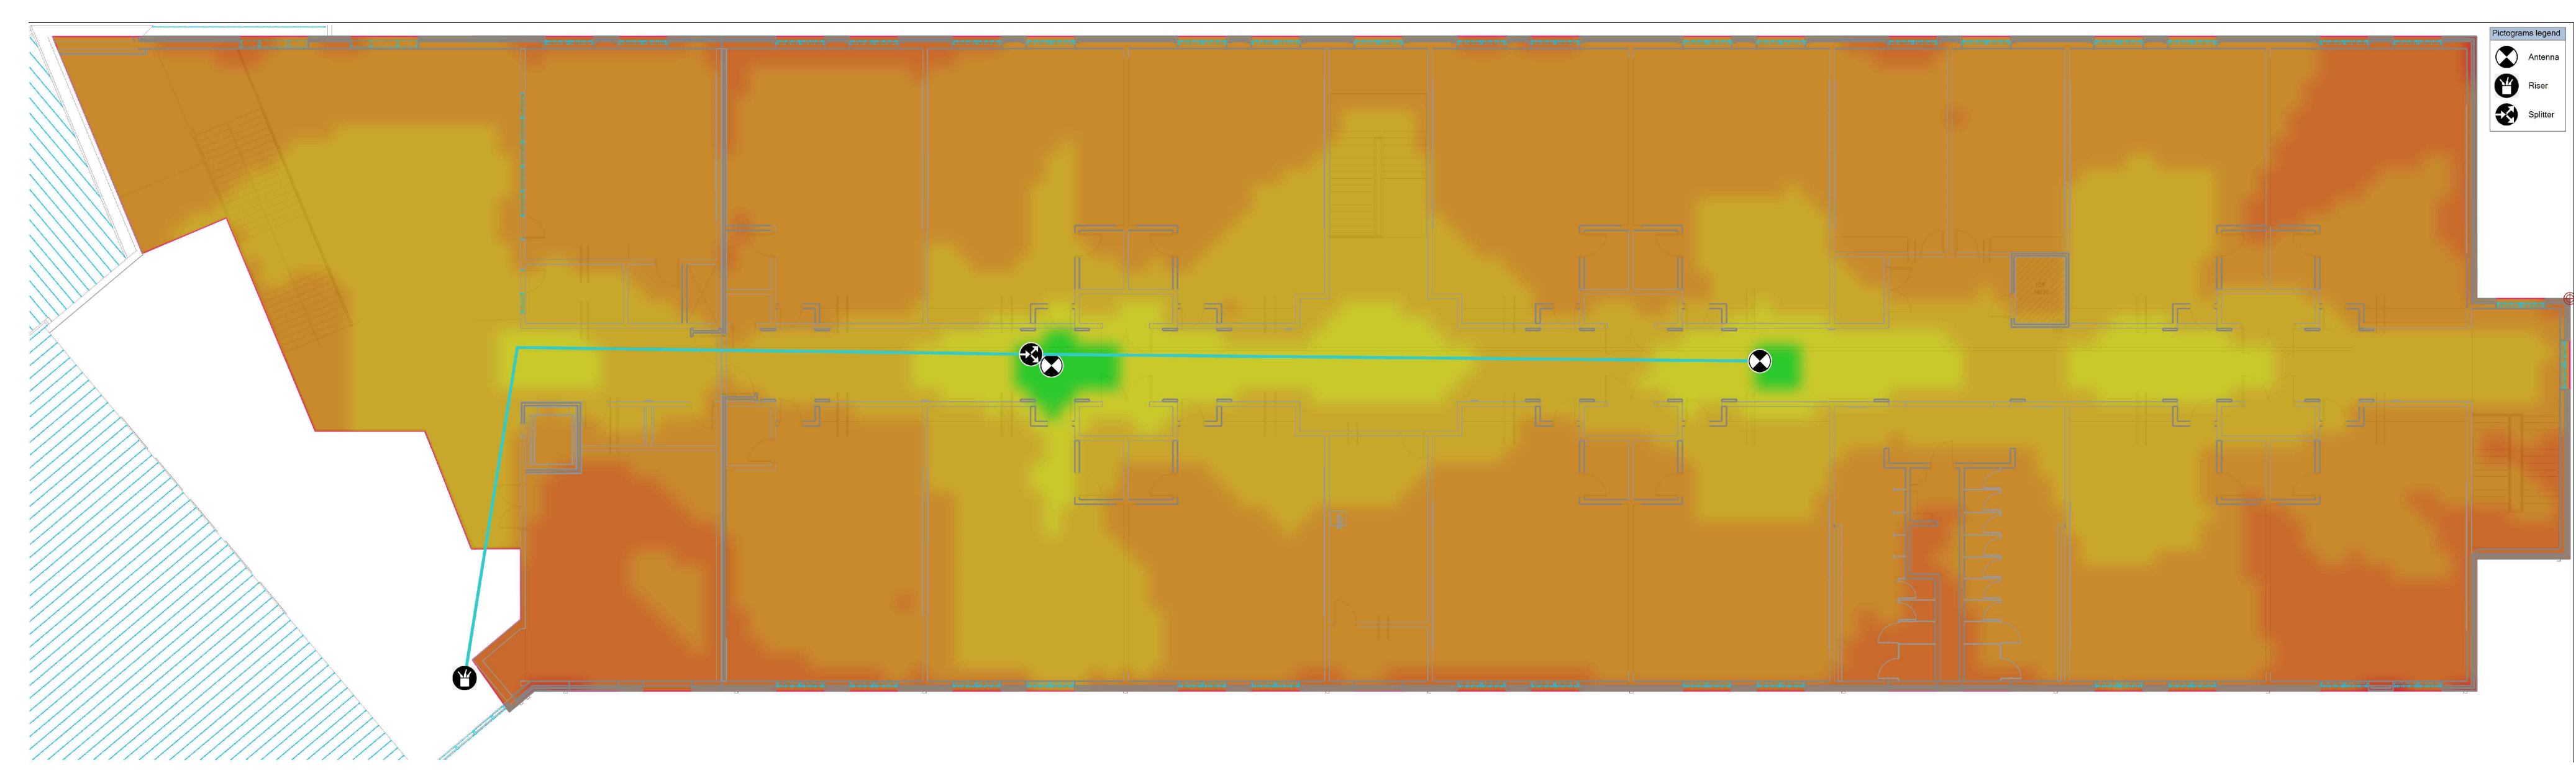

02 PERMIT DRAWINGS - 2ND FLOOR PLAN
ERRC03 SCALE: 1/32" = 1'-0"




NORTH CAROLINA SOUND
 * INTERCOM
 * VOICE & DATA
 * SECURITY
 * CCTV
 * MATV
 * AV

Home Office:
 5413 Hwy 117N
 Pineville, NC 27863
 919-709-4040 (Voice)
 910-709-4044 (Fax)

AUTHORIZED DEALER
 OF:
 BOGEN COMMUNICATIONS, INC.
 NAPCO SECURITY SYSTEMS
 PANASONIC SURVEILLANCE SYSTEMS

NORTHWEST HARNETT ELEMENTARY SCHOOL
 736 ROLLINS ROAD
 FUQUAY-VARINA, NC 27526

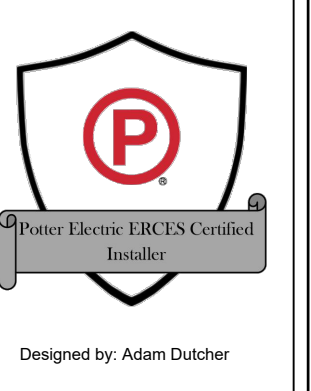

DRAWN BY:

 DATE: 5/22/2023

REVISIONS		
REV #	DATE	DESCRIPTION

SYSTEM:
 ERRC PERMIT DRAWINGS
 SHEET TITLE:
 FLOOR PLANS

SHEET NO.
ERRC03