



- NOTES:**
- G.C. SHALL PROVIDE ADA COMPLIANT UNDERSPACE SINK PROTECTIVE ENCLOSURES FOR ALL ADA SINKS.
 - WATER SUPPLY INLETS AND RISERS SHALL BE BRASS OR COPPER (CHROME PLATED WHERE EXPOSED TO VIEW).

DETAIL NO. 1
COUNTERTOP MOUNTED SINK
SCALE: NTS

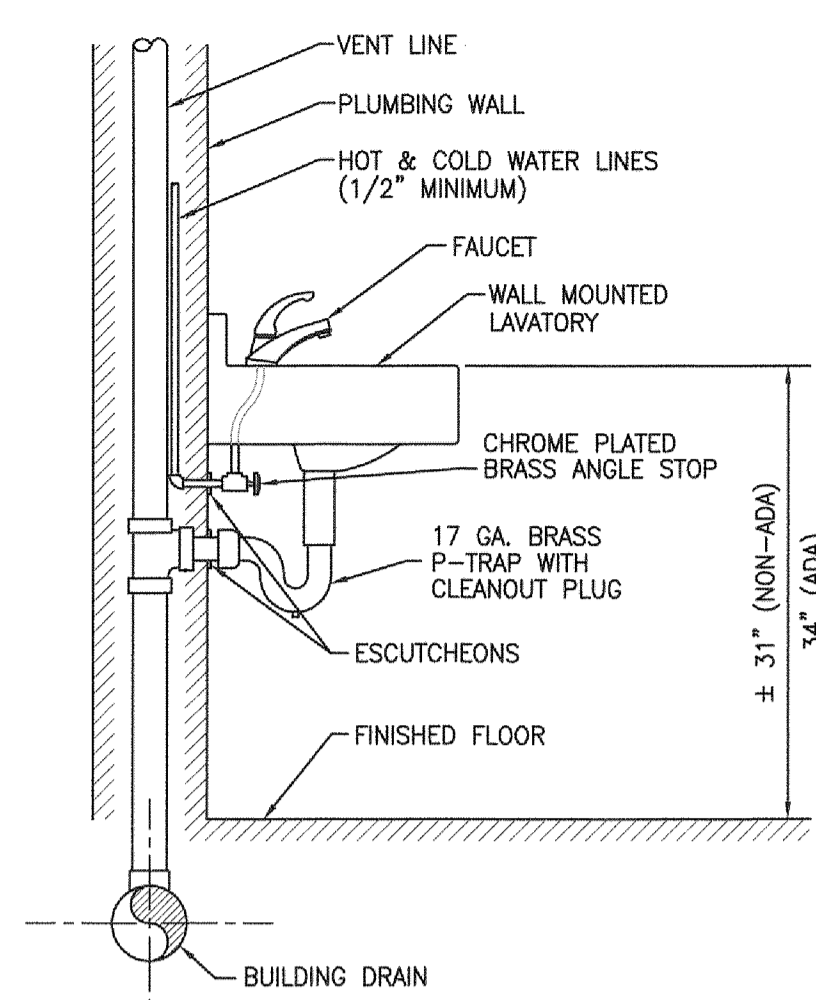


- NOTES:**
- PROVIDE ADA LAVATORIES WITH PRE-WRAPPED ANTI-MICROBIAL AND DRAIN LINES.
 - WATER SUPPLY INLETS AND RISERS SHALL BE BRASS OR COPPER (CHROME PLATED WHERE EXPOSED TO VIEW).

DETAIL NO. 2
WALL MOUNTED LAVATORY
SCALE: NTS

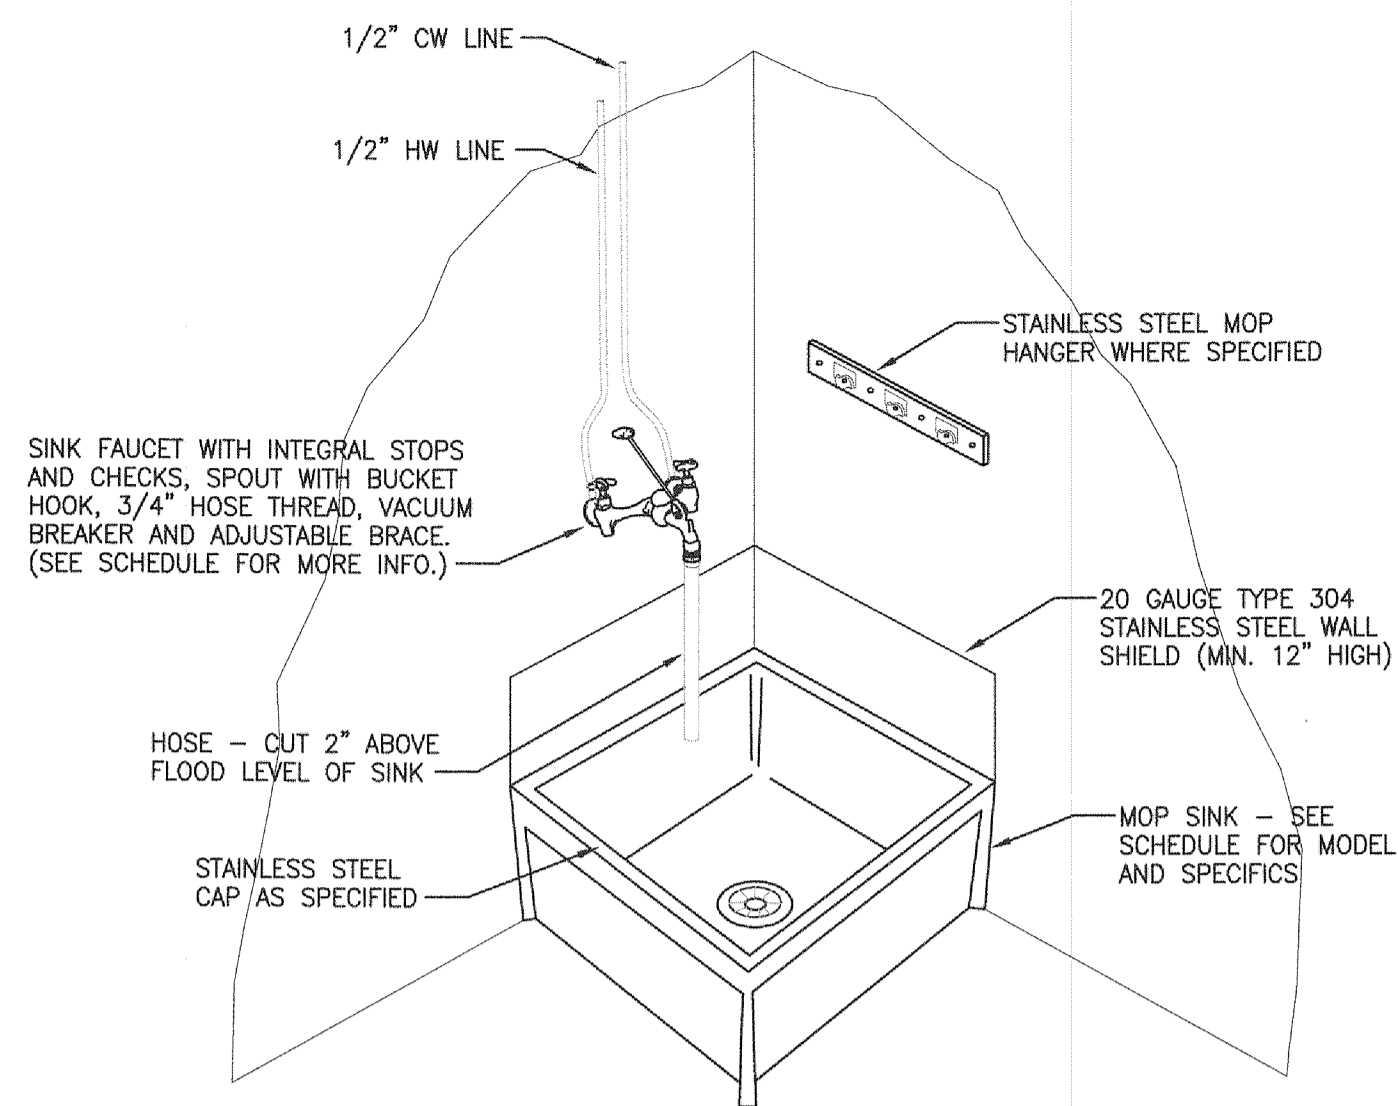


NOTE: GROUT BOTTOM AND CAULK ALL EDGES FOR COMPLETE SEAL TO FLOOR AND WALLS.

DETAIL NO. 3
FLOOR MOUNTED MOP SINK DETAIL
SCALE: NTS

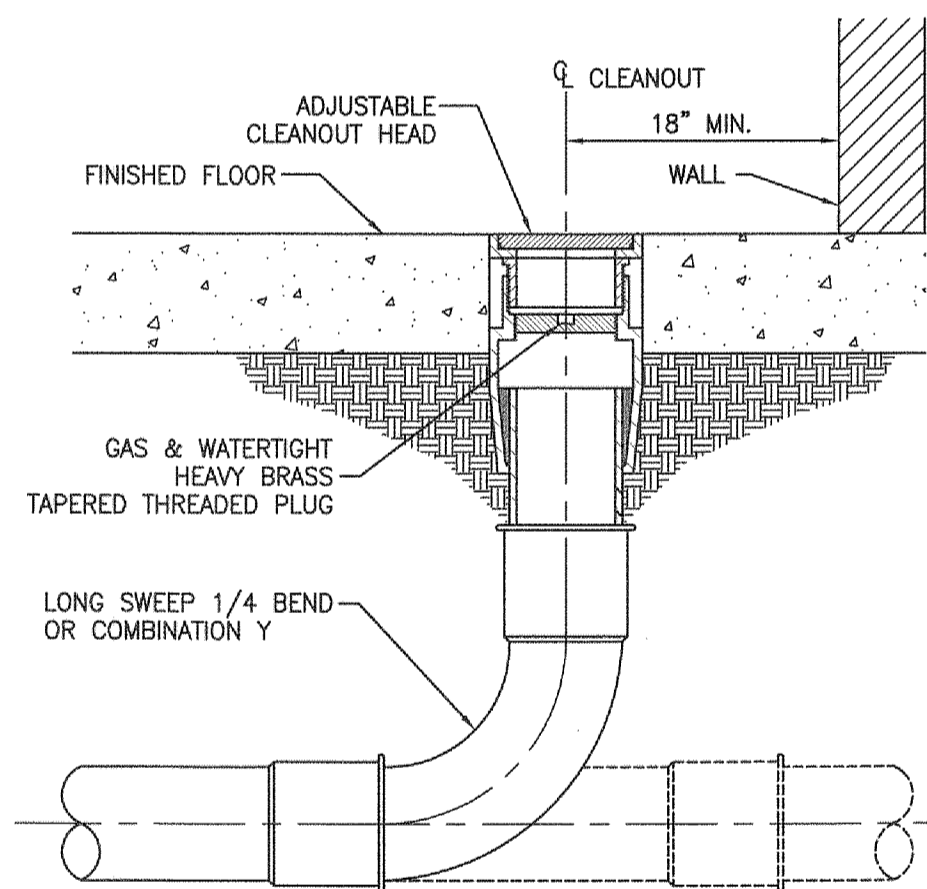


DETAIL NO. 4
FLOOR CLEANOUT WITH SWEEP BEND OR COMBINATION Y
SCALE: NTS

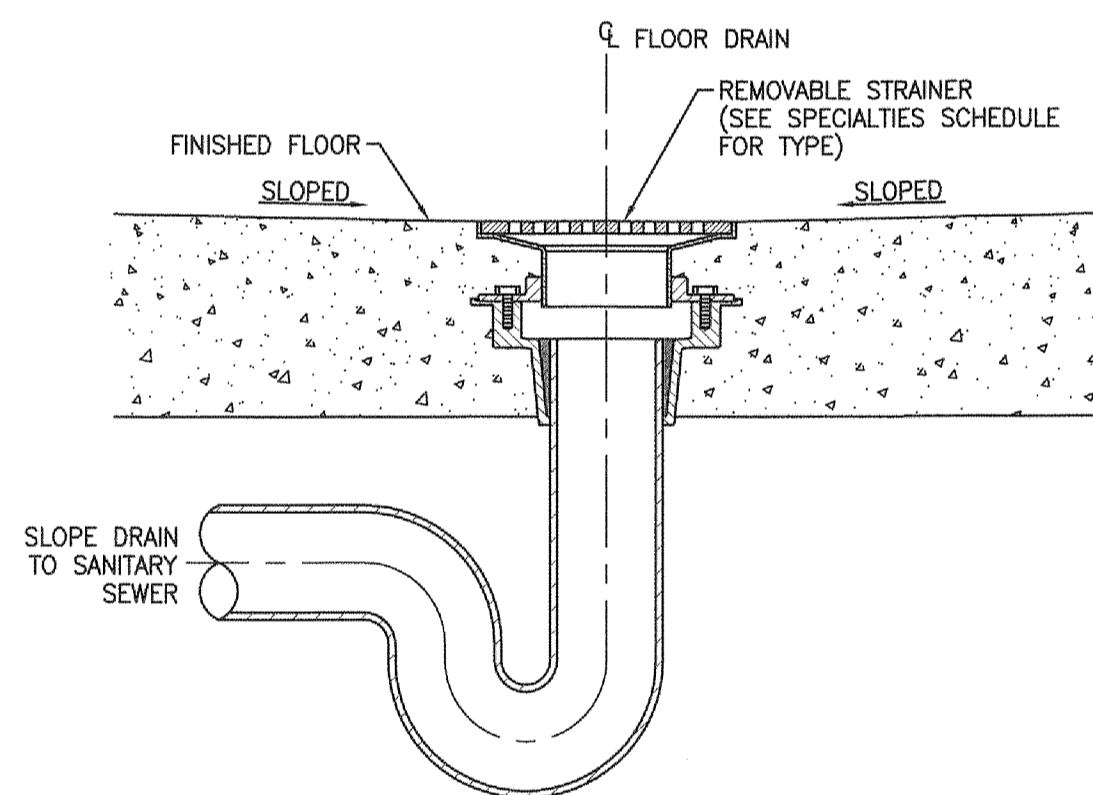


- NOTE:**
- FINISHED FLOOR SHALL BE SLOPED TO DRAIN FLUSH WITH STRAINER WHERE REQUIRED, COORDINATE WITH G.C.

DETAIL NO. 5
FLOOR DRAIN
SCALE: NTS

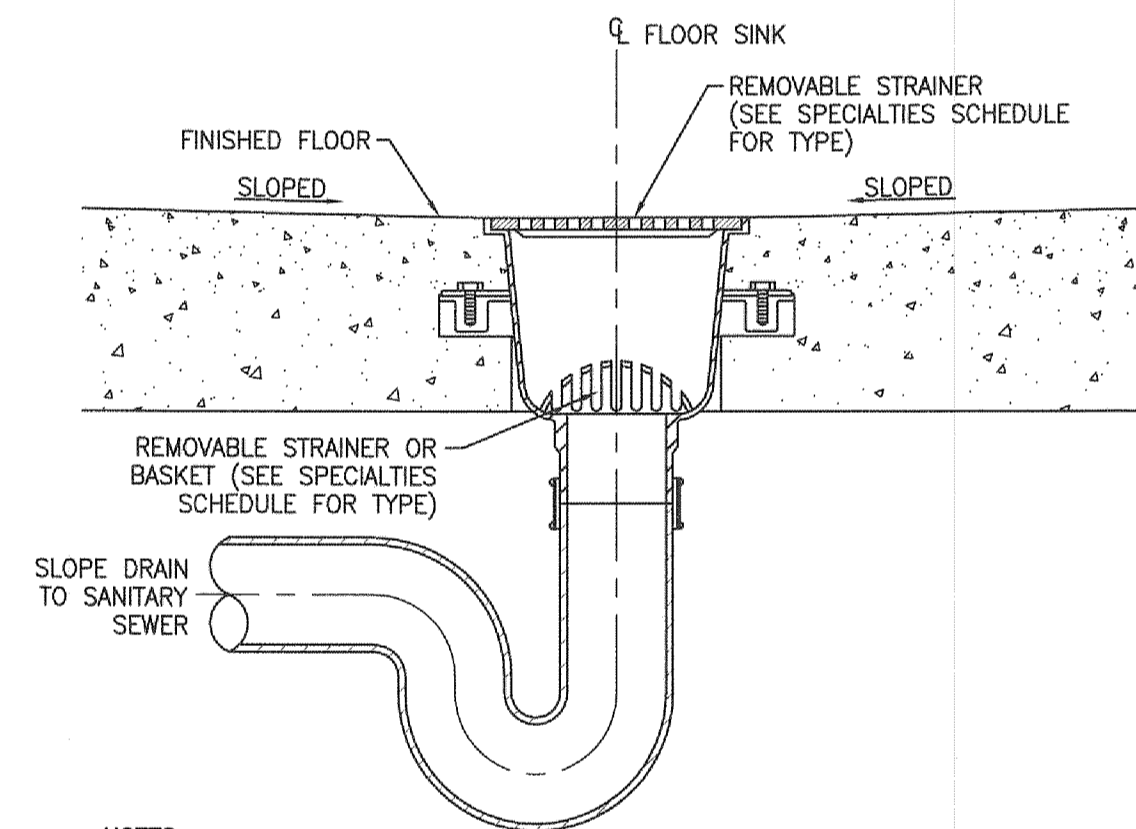

- NOTES:**
- FINISHED FLOOR SHALL BE SLOPED TO DRAIN FLUSH WITH GRATE WHERE REQUIRED, COORDINATE WITH G.C.
 - PROVIDE 2 INCH AIR GAP FOR INDIRECTLY CONNECTED APPLIANCES.


DETAIL NO. 6
FLOOR SINK WITH TRAP PRIMER
SCALE: NTS

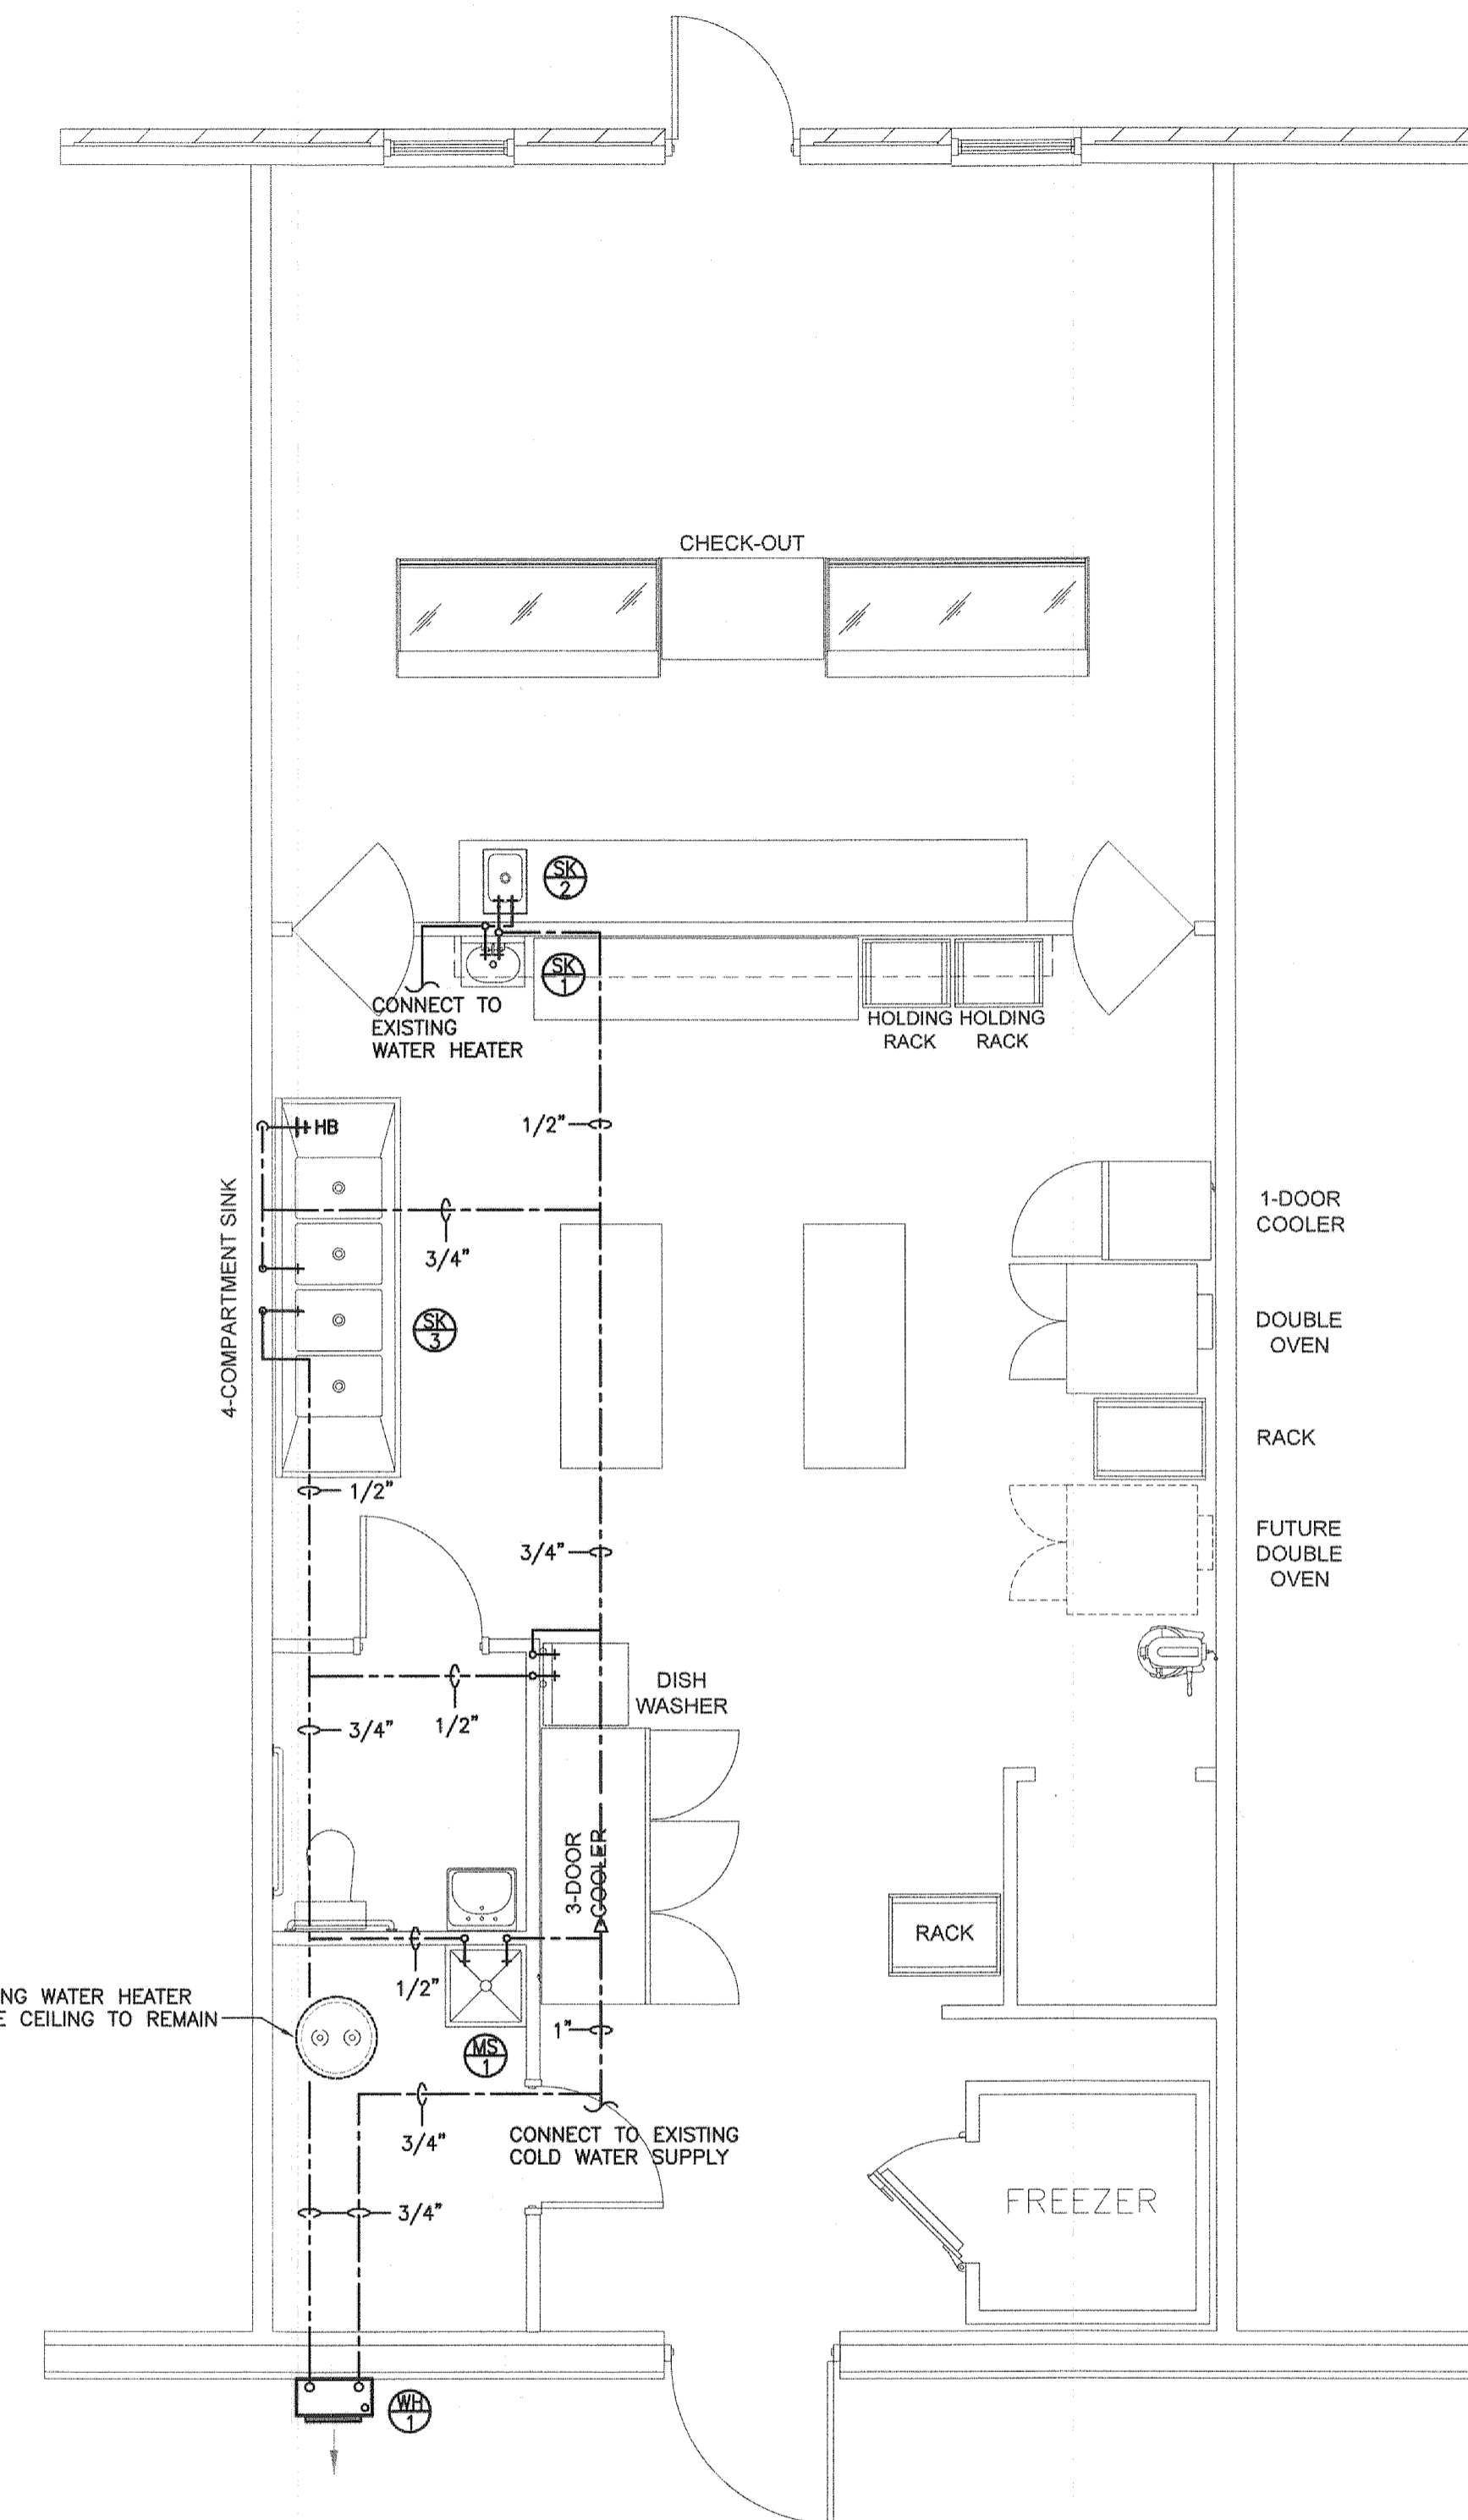

1
P-2

PLUMBING PLAN - HOT & COLD WATER PIPING LAYOUT

SCALE: 1/4"=1'-0"

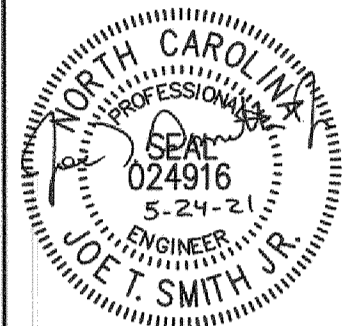

REV#	DATE	DESCRIPTION