



ELECTRICAL LEGEND	
MARK	DESCRIPTION
	QUAD RECEPTACLE
	DUPLEX RECEPTACLE
	TIMER WITH NO HOLD MECHANISM
	CEILING MOUNTED DUPLEX RECEPTACLE
	FLUORESCENT FIXTURE
	SWITCHED BRANCH CIRCUIT
	UNSWITCHED BRANCH CIRCUIT
	120/208 VOLT CIRCUIT
	MOTION DETECTING SINGLE-POLE SWITCH ON TIMER
	'EXIT' LIGHT FIXTURE, TYPE 'EX'
	BATTERY OPERATED EMERG. LT. (2-HEAD, WALL MTD.)
	MOTION DETECTING 3-WAY SWITCH (4-WAY SWITCH) WITH TIMER
	FUSED DISCONNECT SWITCH
	CEILING MOUNTED FUSED DISCONNECT SWITCH
	TELEPHONE
	JUNCTION BOX
	SINGLE POLE SWITCH OR TIMER AS APPLICABLE
	UNSWITCHED FIXTURE
	OCCUPANCY SENSING SINGLE-POLE SWITCH NOT ON TIMER
	DUPLEX RECEPTACLE
	EMERGENCY LIGHT REMOTE WEATHERHEAD(S)

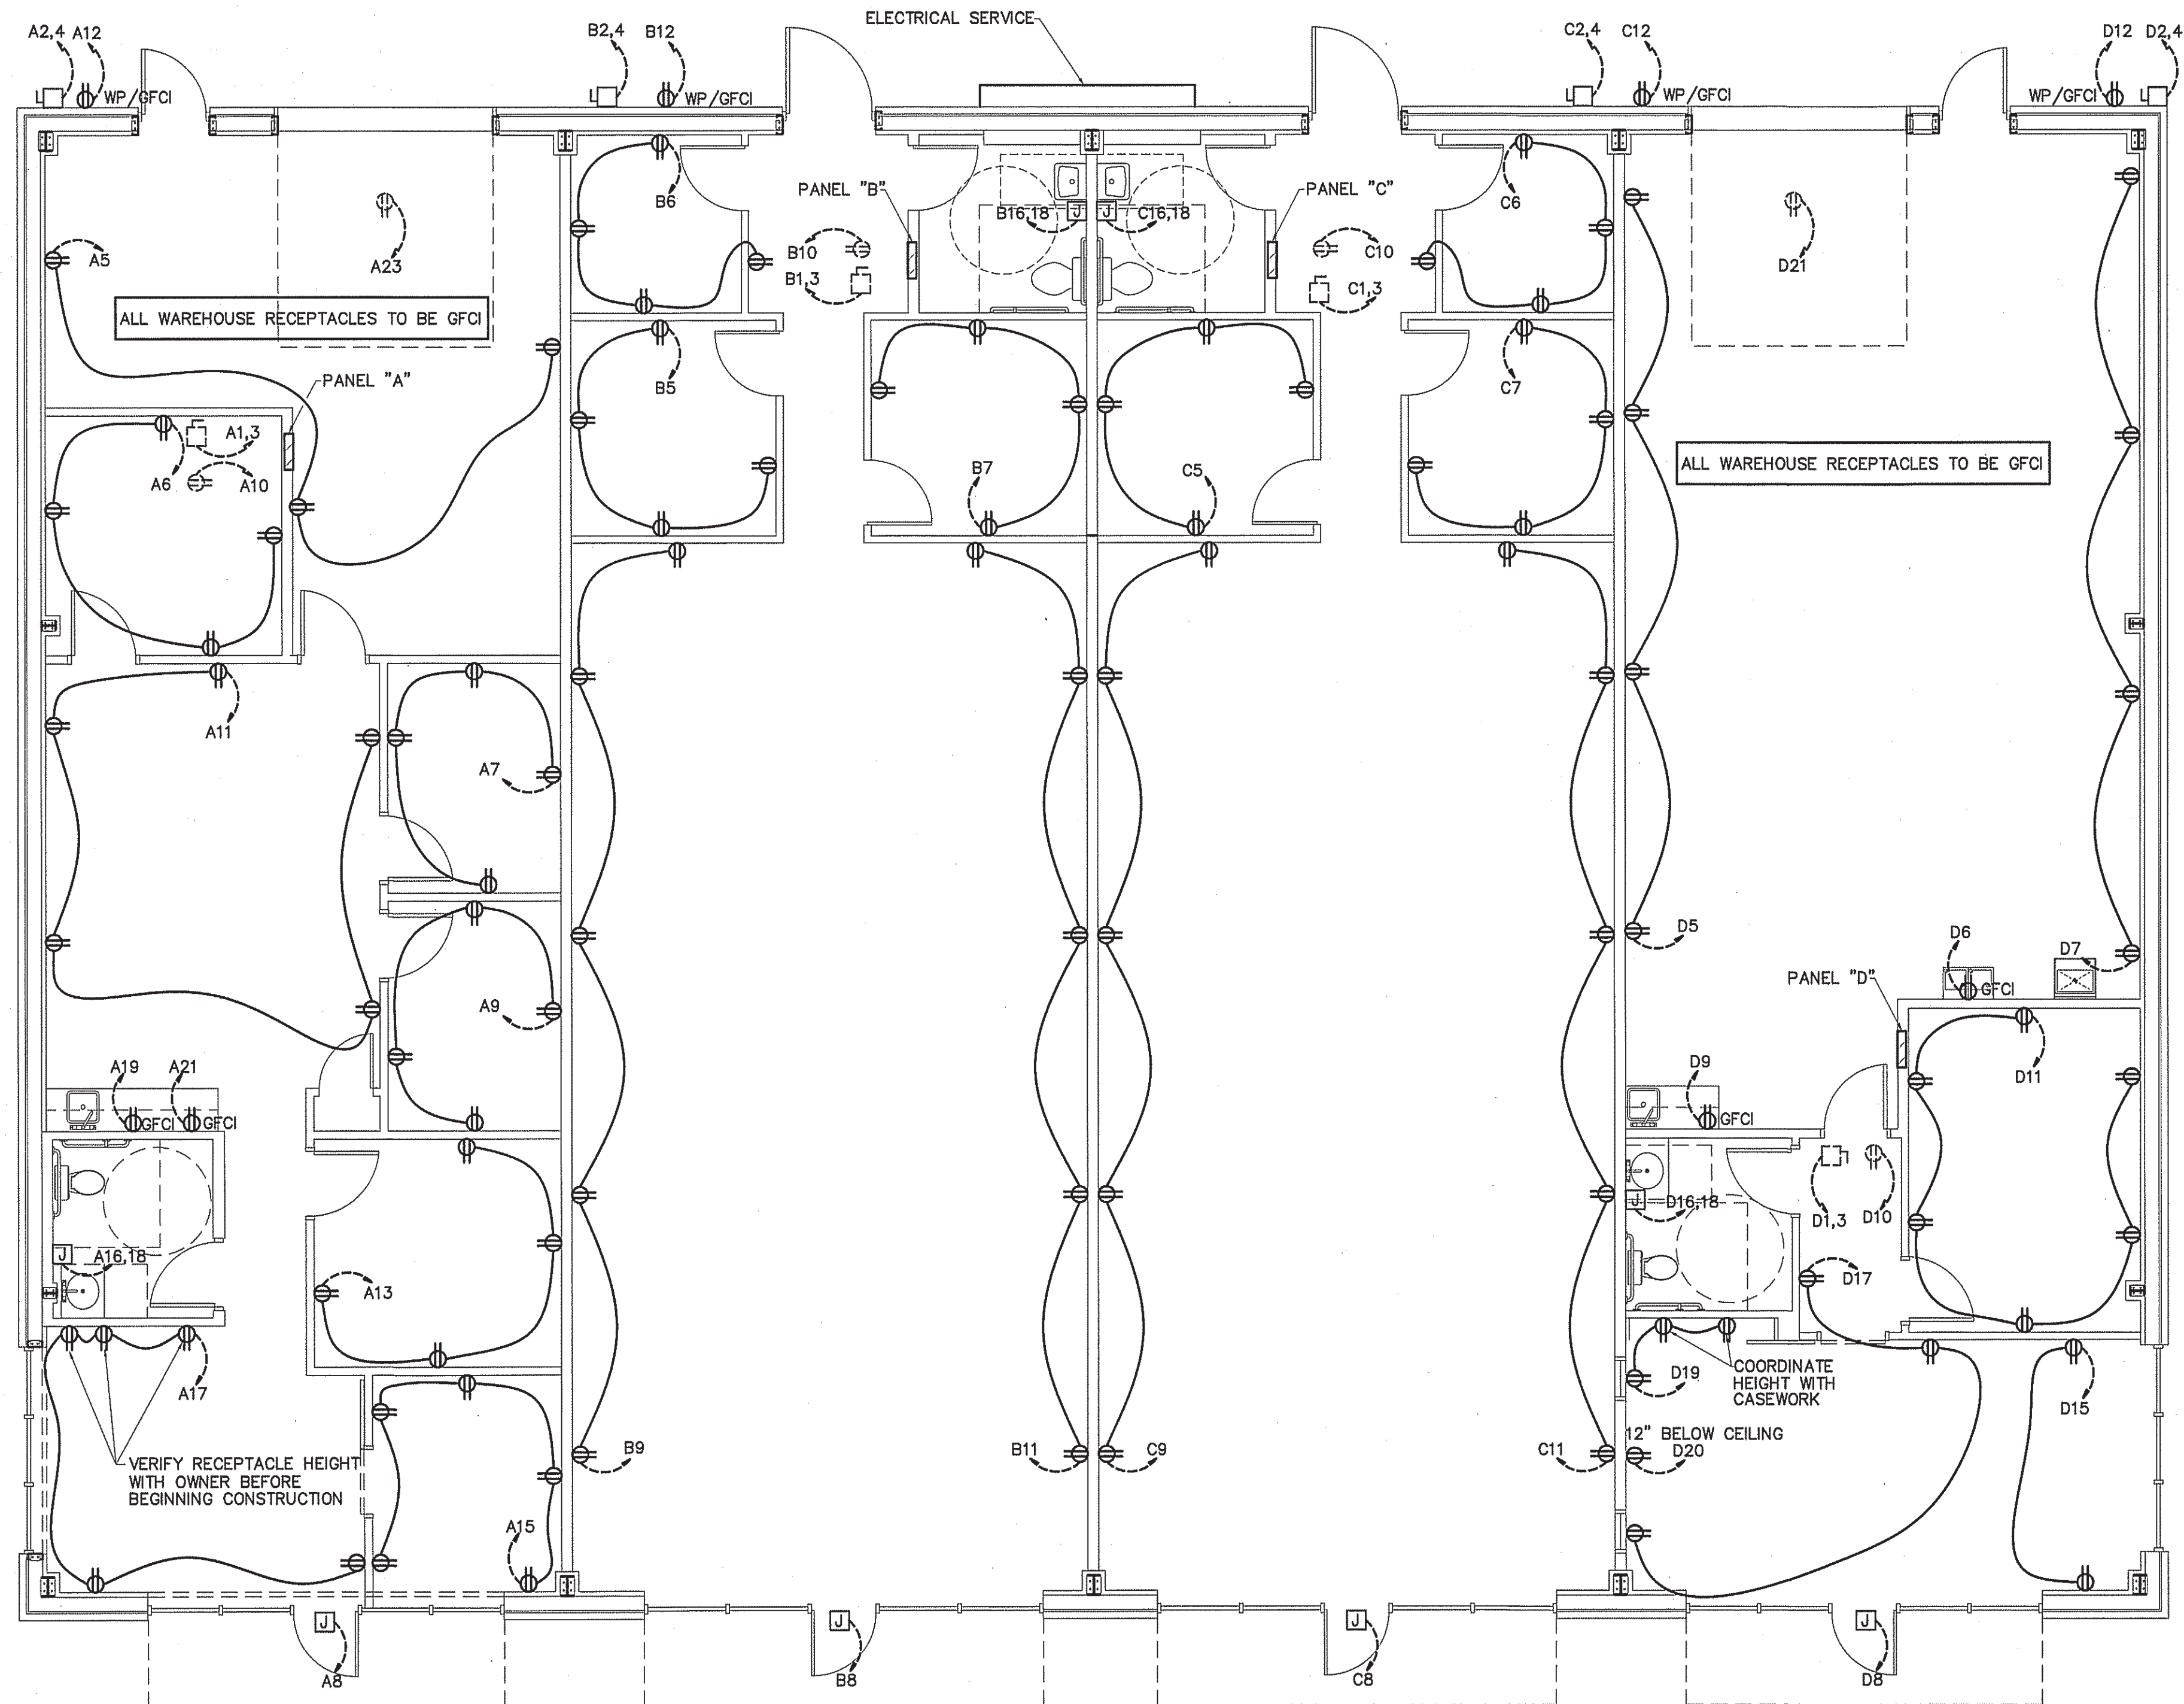


ELECTRICAL POWER PLAN
SCALE: 3/16" = 1'-0"

CONNECTION SCHEDULE

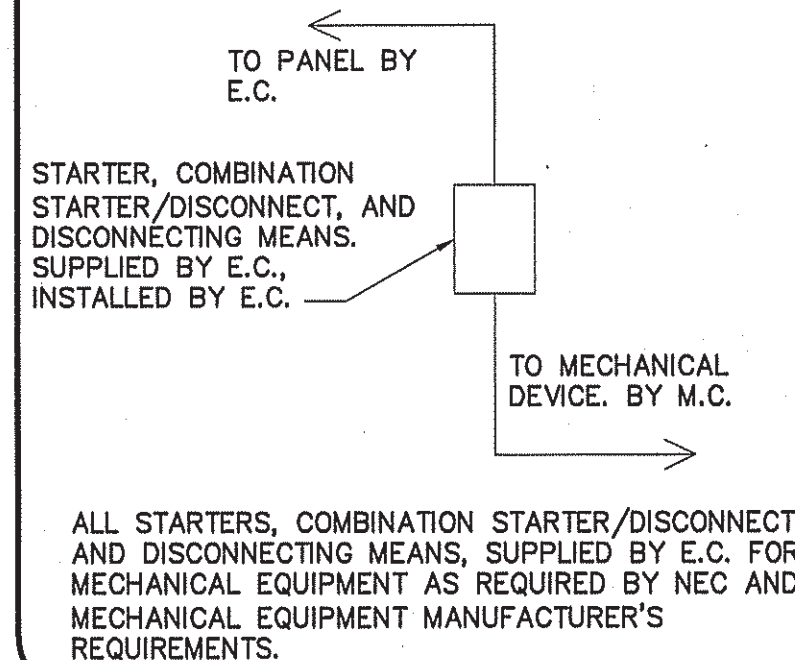


NOTE:
1. VERIFY DATA/PHONE JACK LOCATIONS, QUANTITY, AND CONFIGURATIONS WITH OWNER BEFORE BEGINNING CONSTRUCTION.

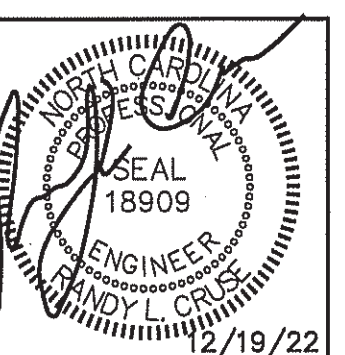

UP-FIT PLANS FOR:
T&L COATS
BUILDING #2
COATS, NORTH CAROLINA

REVISIONS	
NO.	

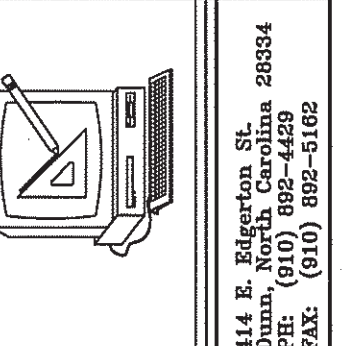

Cruse and Associates, P.A.
414 E. 24th Street
Raleigh, NC 27604
PHONE: (919) 892-4429
FAX: (919) 892-5162
LICENSE NO.: C-1721

THESE DOCUMENTS ARE INSTRUMENTS OF SERVICE AND AS SUCH THESE DRAWINGS, DESIGNS, AND DESIGN CONCEPTS PRESENTED REMAIN THE PROPERTY OF THE ENGINEER. PUBLISH OR DUPLICATE THE DRAWINGS OR DESIGNS ONLY WITH THE WRITTEN PERMISSION OF THE ENGINEER.
© COPY RIGHT

DATE 12-19-22
DRAWN BY BAM
JOB NO. 22-60

SHEET NO.
E-2 OF 4