



ARCHITECT/ENGINEER SEAL

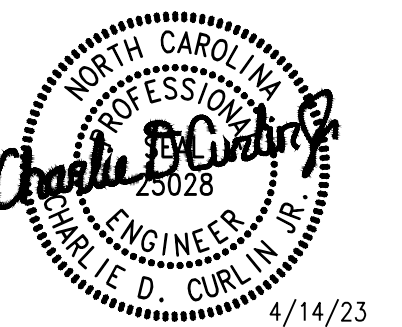

4/14/23

CONSULTANT

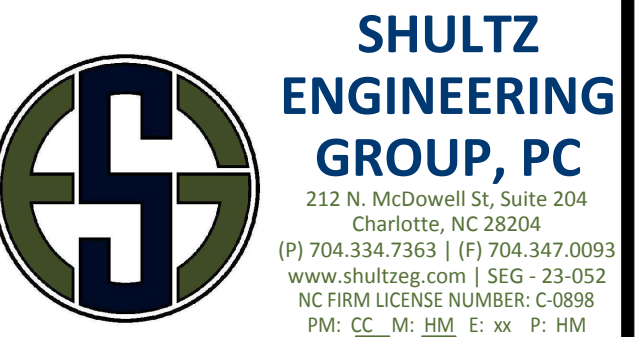

FOOD LION

2110 EXECUTIVE DRIVE
SALISBURY, NC 28145
PH: 704-633-8250 FX: 704-636-4940

REVISION / ISSUE HISTORY

REV	DATE	REVISION / ISSUE NAME
	04/14/2023	PERMIT

PROJECT NO 2220380	DRAWN BY HM
PERMIT SUB DATE 04/14/2023	CHECKED BY CC

PROJECT
FOOD LION STORE #2594


3260 RAY ROAD
SPRING LAKE, NC 28390
2594FLMK23

CLIENT
FOOD LION

2110 EXECUTIVE DRIVE
SALISBURY, NC 28145
PH: 704-633-8250 F: 704-636-5940

SHEET TITLE
FIRE PROTECTION INTENT PLAN

SHEET NO 2594FP1.01.00
FP1.01

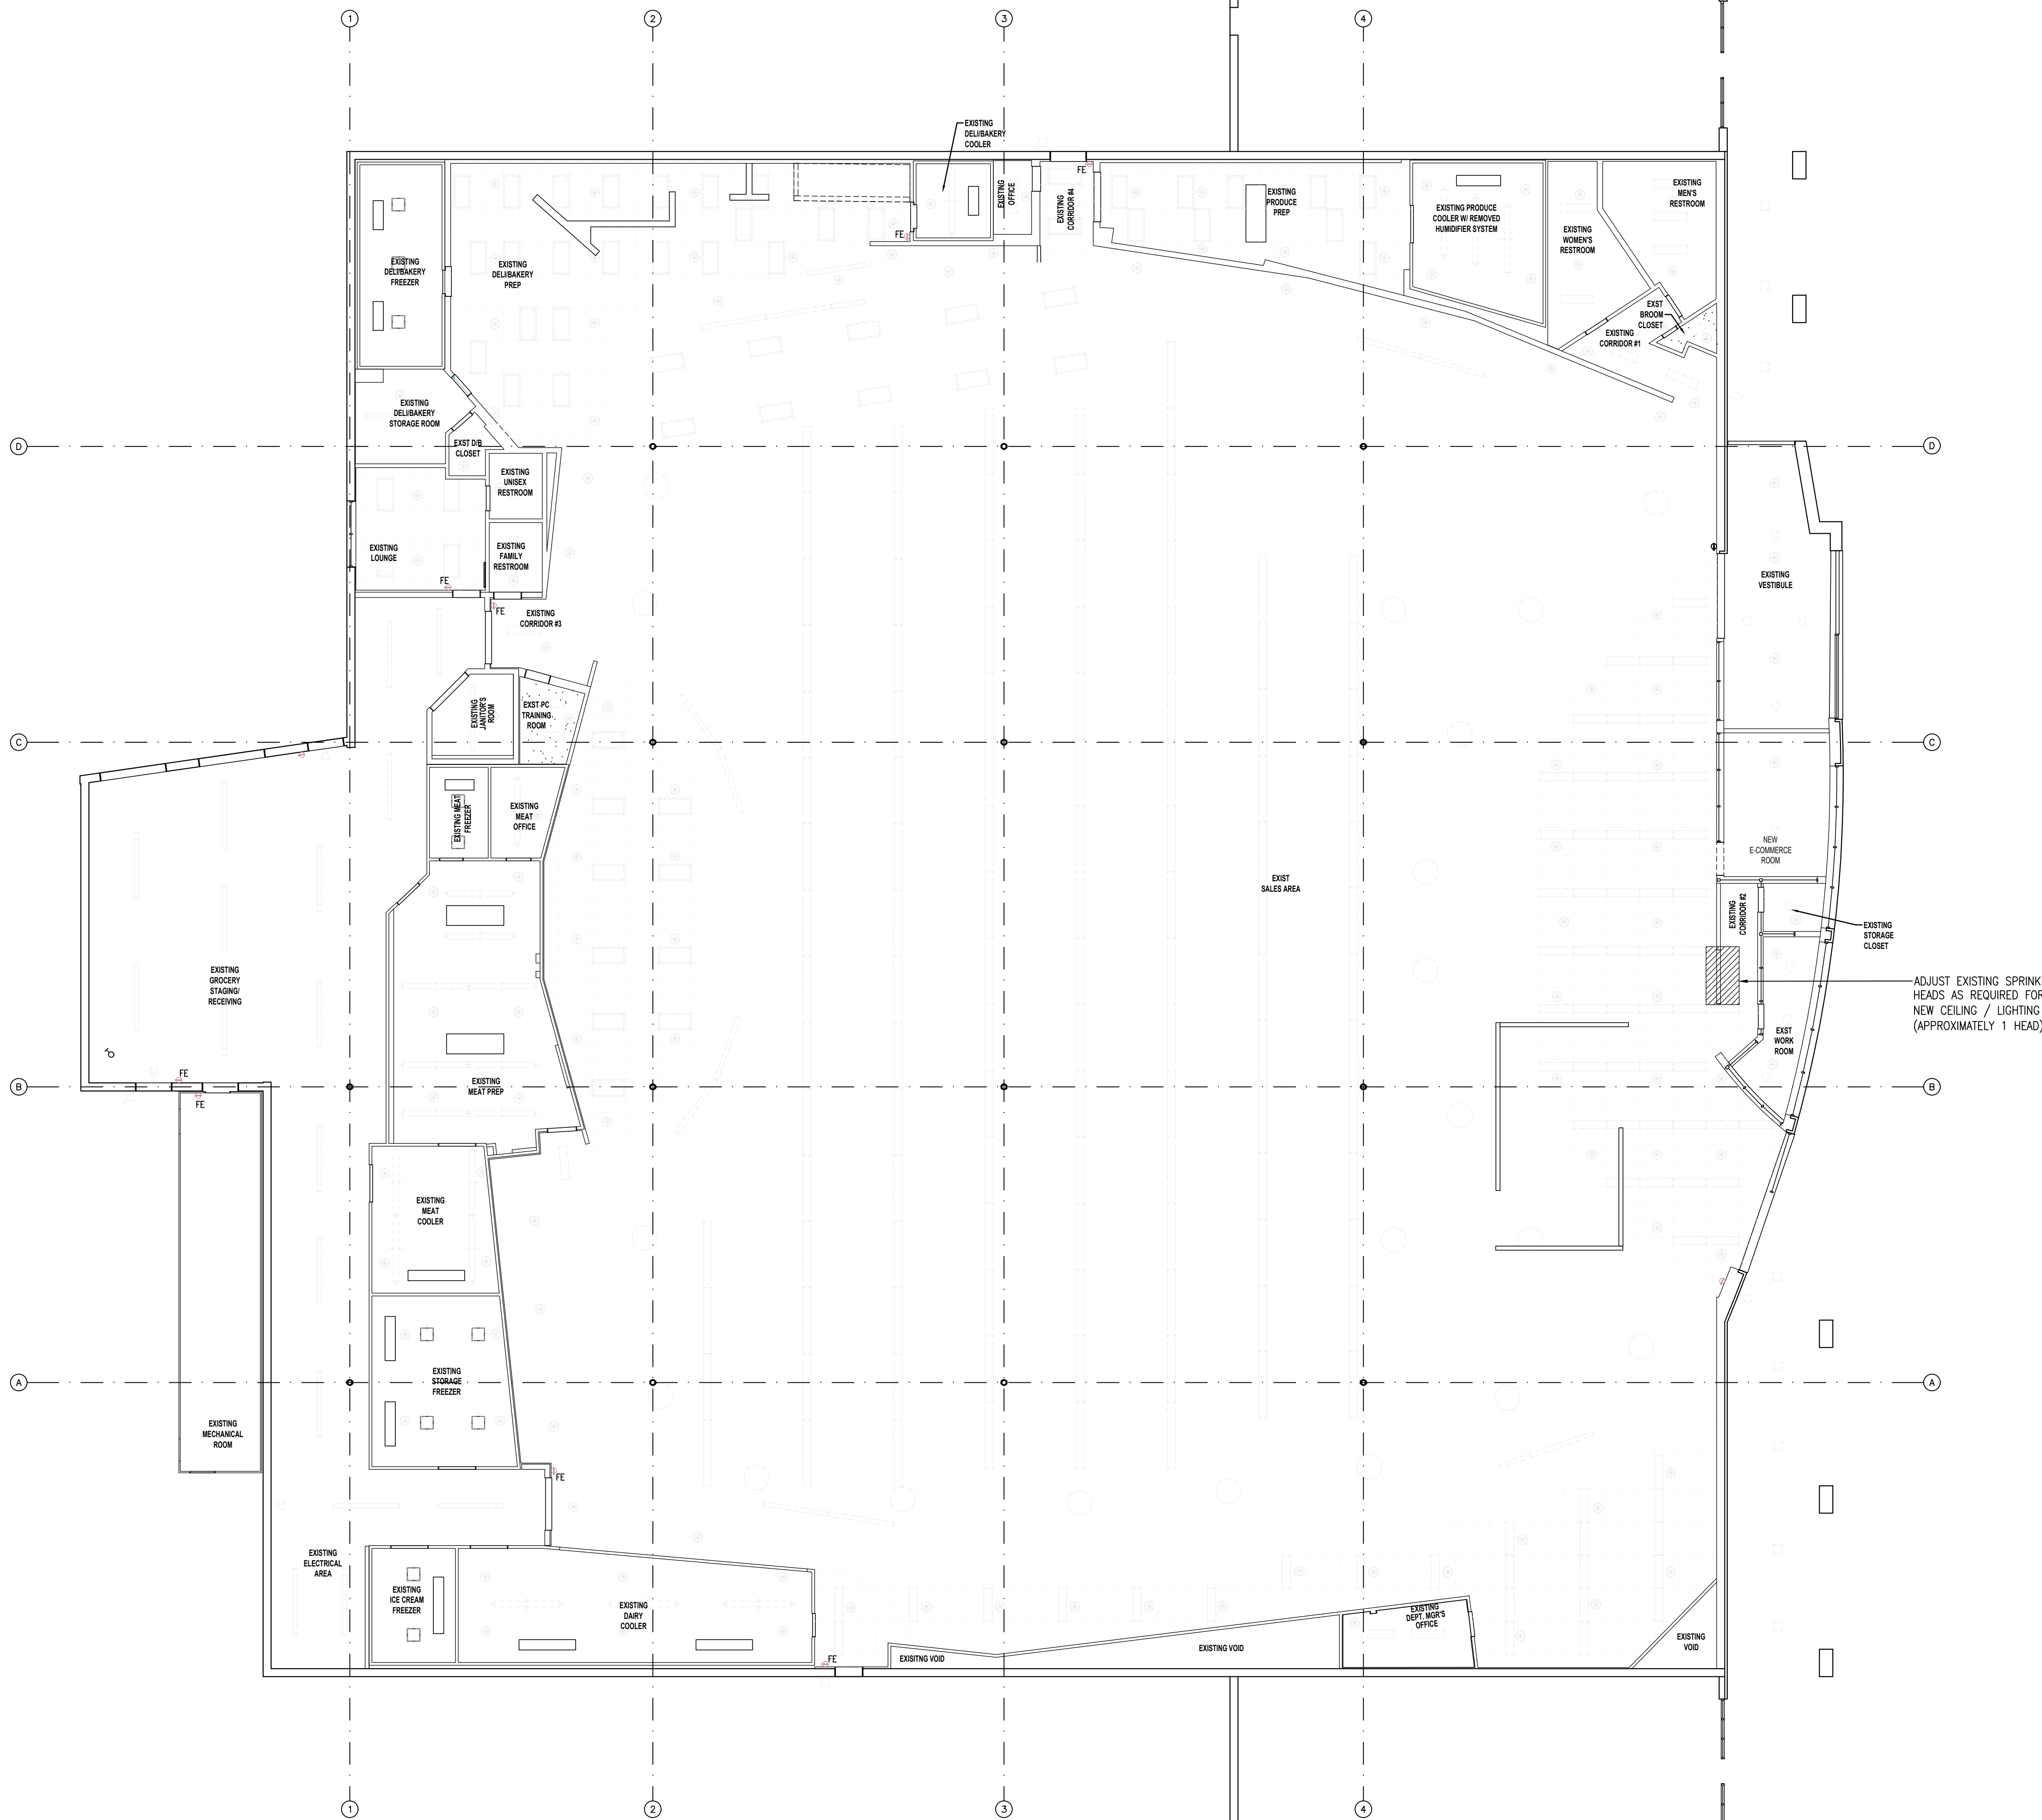

GENERAL NOTES:

- THIS DRAWING IS DIAGRAMMATIC AND CONVEYS GENERAL INTENT. SPRINKLER CONTRACTOR SHALL COMPLETE WORKING DRAWINGS, PER APPLICABLE CODES, FOR MODIFICATIONS TO THE SPRINKLER SYSTEMS.
- THIS DRAWING IS DIAGRAMMATIC AND CONVEYS GENERAL INTENT. FIRE ALARM CONTRACTOR SHALL PROVIDE COMPLETE WORKING DRAWINGS, PER APPLICABLE CODES, FOR MODIFICATIONS OR ADDITIONS TO THE FIRE ALARM SYSTEM.

SYMBOL LEGEND

	- SPRINKLER RISER
	- FIRE EXTINGUISHER
	- COOKING HOOD
	- POSSIBLE AREAS OF CHANGE

1 FIRE PROTECTION INTENT PLAN
FP1.01 3/32" = 1'-0"

