


POWER PLAN EXISTING/DEMOLITION

SCALE: 1/8" = 1 FT.

NO DEMOLITION REQUIRED. ONLY SERVICE, PANELS, AND EQUIPMENT SHOWN.

WALL LEGEND

- EXISTING WALL, UL U419; TWO HOUR RATED
- EXISTING UNRATED PARTITION WALL (NOT ON BLD. PERIMETER). 3 5/8" METAL STUD, 16" OC; ONE LAYER 5/8" DRYWALL EACH SIDE

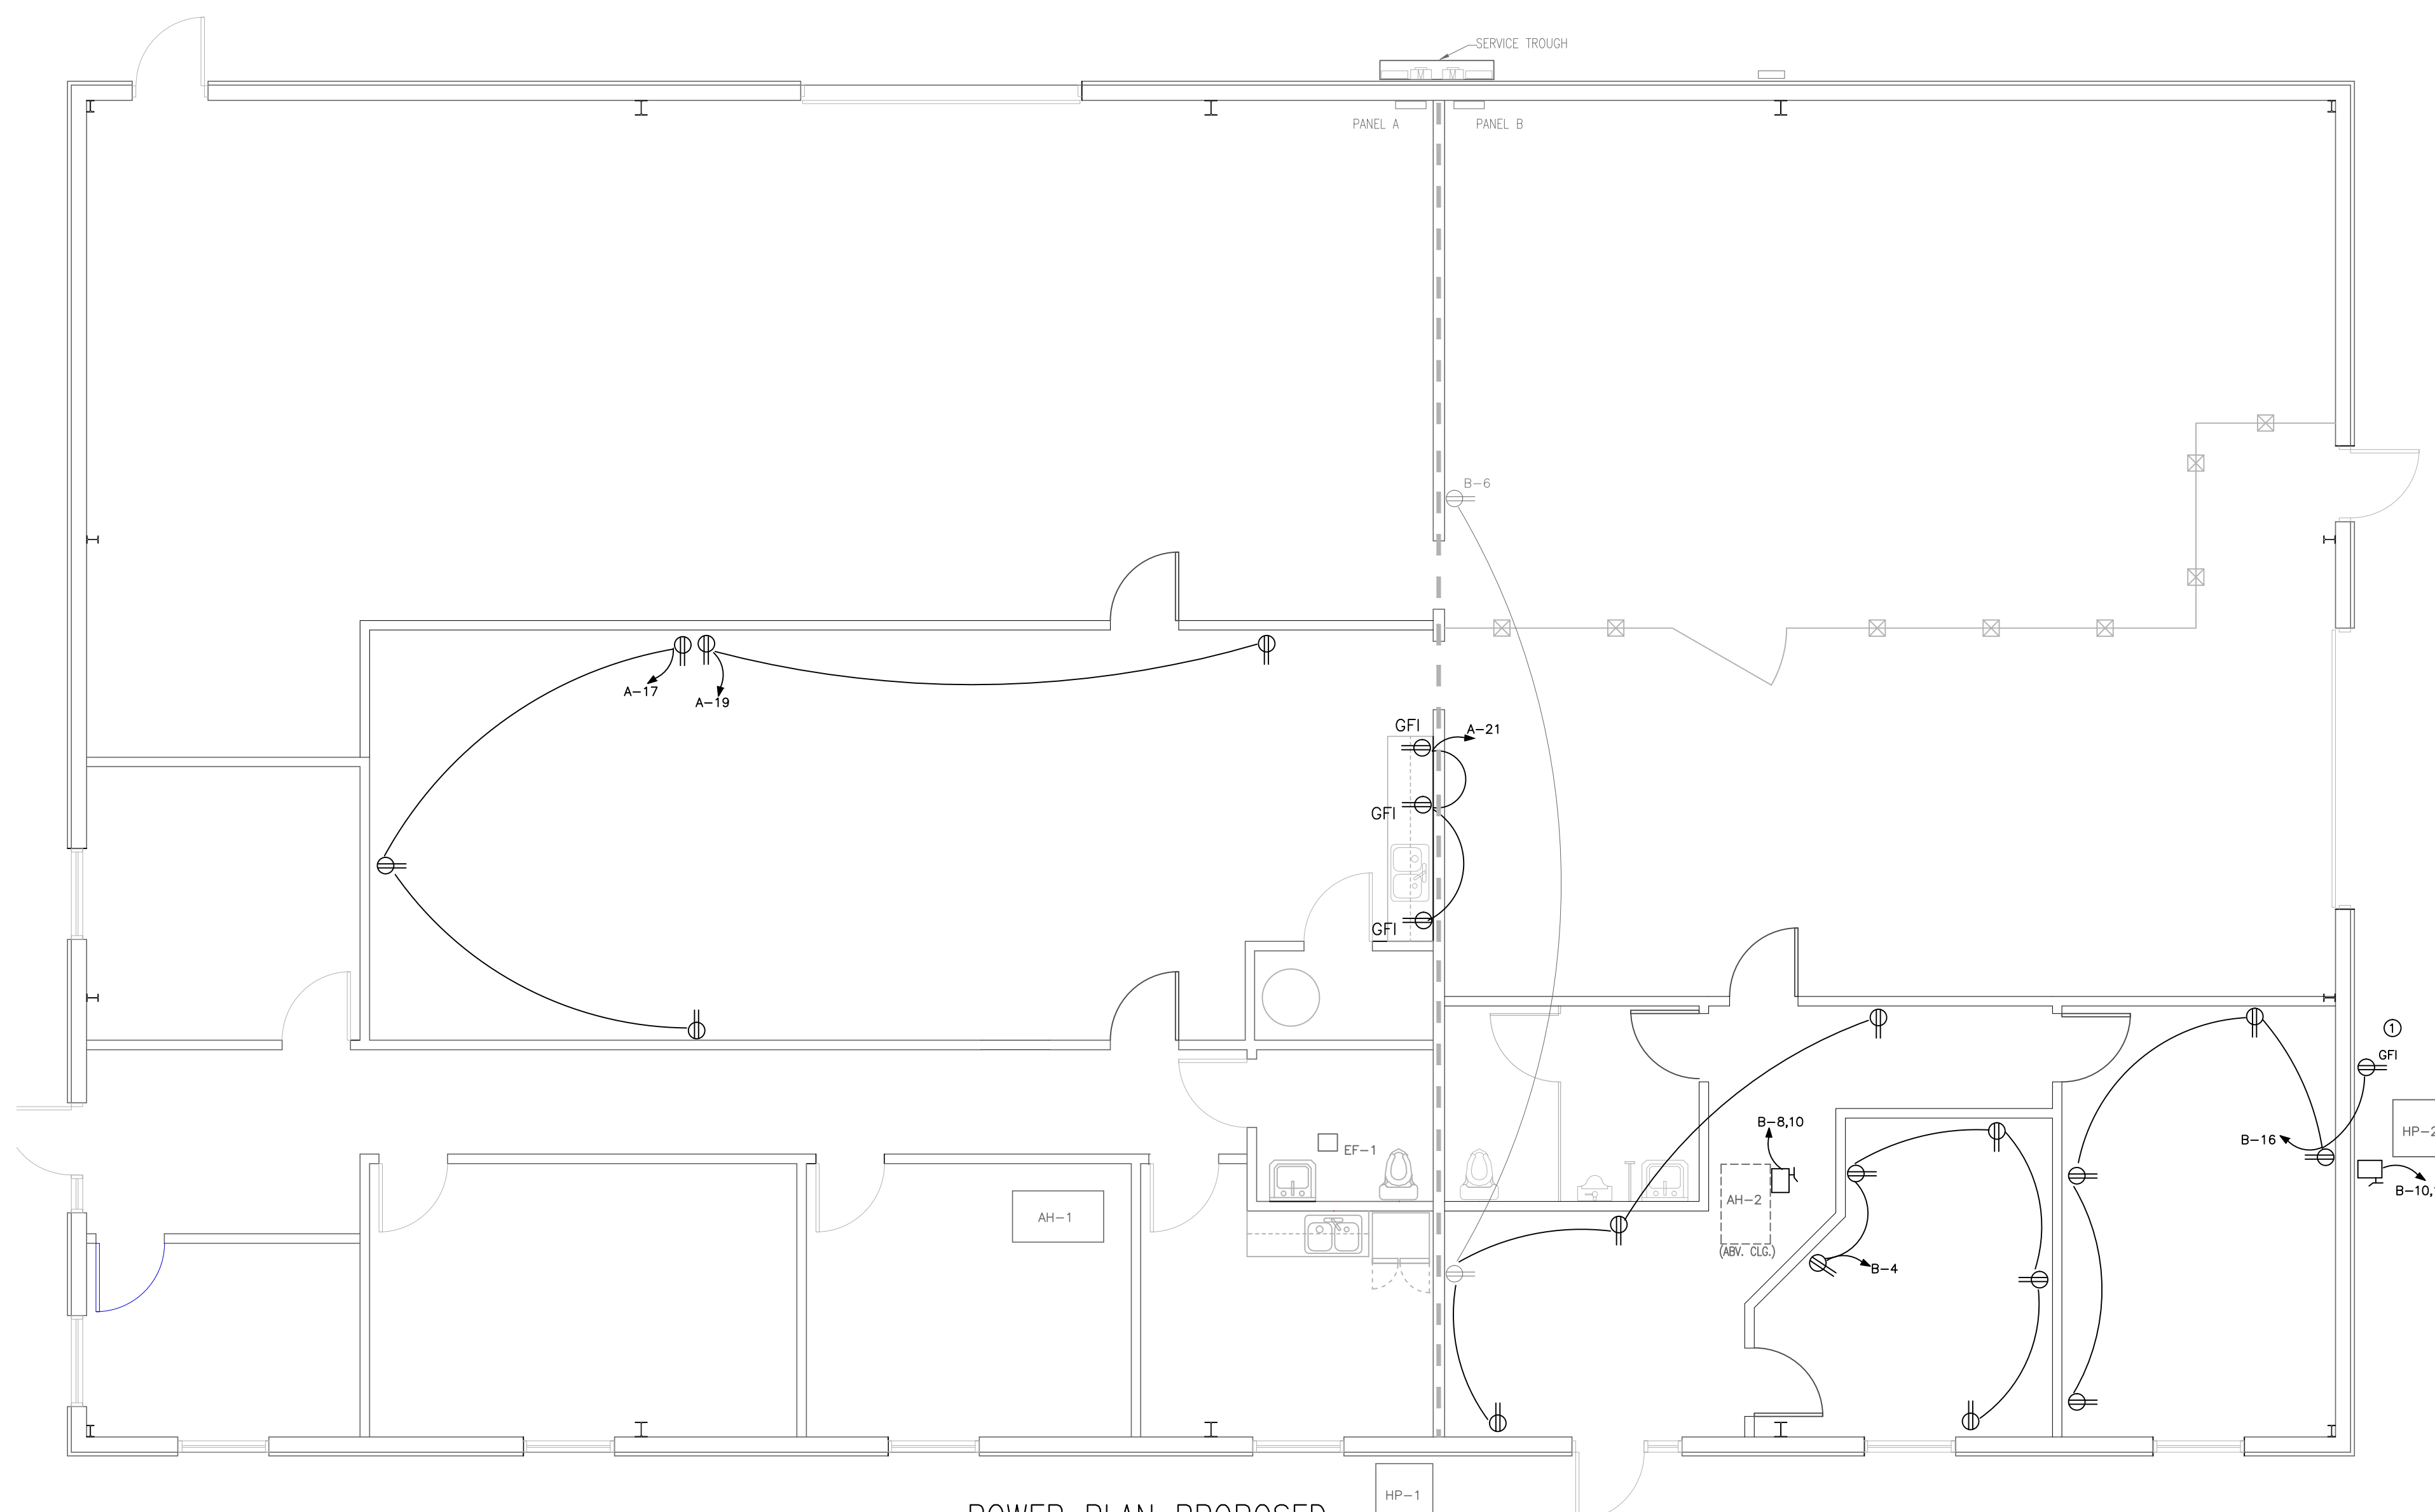

POWER PLAN PROPOSED

SCALE: 3/16" = 1 FT.

POWER KEY NOTES

- ① INSTALL EXTERIOR RECEPTACLE IF NONE EXISTING.

DAWSON'S ELECTRIC ALTERATION
280 JARCO DRIVE
FUQUAY-VARINA, NC

DRAWN BY: CBM

PLOT DATE: 4-16-2024

ISSUED FOR: CONSTRUCTION

REVISIONS:

POWER PLAN

E-2