

Building Plans
FOR
Harmony Baptist Church
NC HIGHWAY 210
BUNN LEVEL , NC 28523

PREPARED FOR


RODNEY GREGORY, CONSTRUCTION CHAIRMEN
HARMONY BAPTIST CHURCH
BUNN LEVEL, NORTH CAROLINA
TELEPHONE 910-984-6932


ENGINEER

C. GREGORY BAGLEY
805 COKESBURY ROAD
FUQUAY VARINA, NC 27526
PHONE: (919) 609-300

SHEET INDEX

COVER SHEET
CODE SHEET
LIFE SAFETY
ELEVATION
TOP VIEW
FLOOR PLAN
FOUNDATION
PLUMBING
MECHANICAL
ELECTRICAL

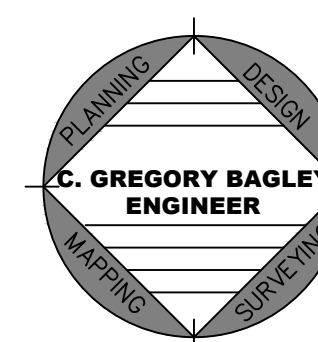

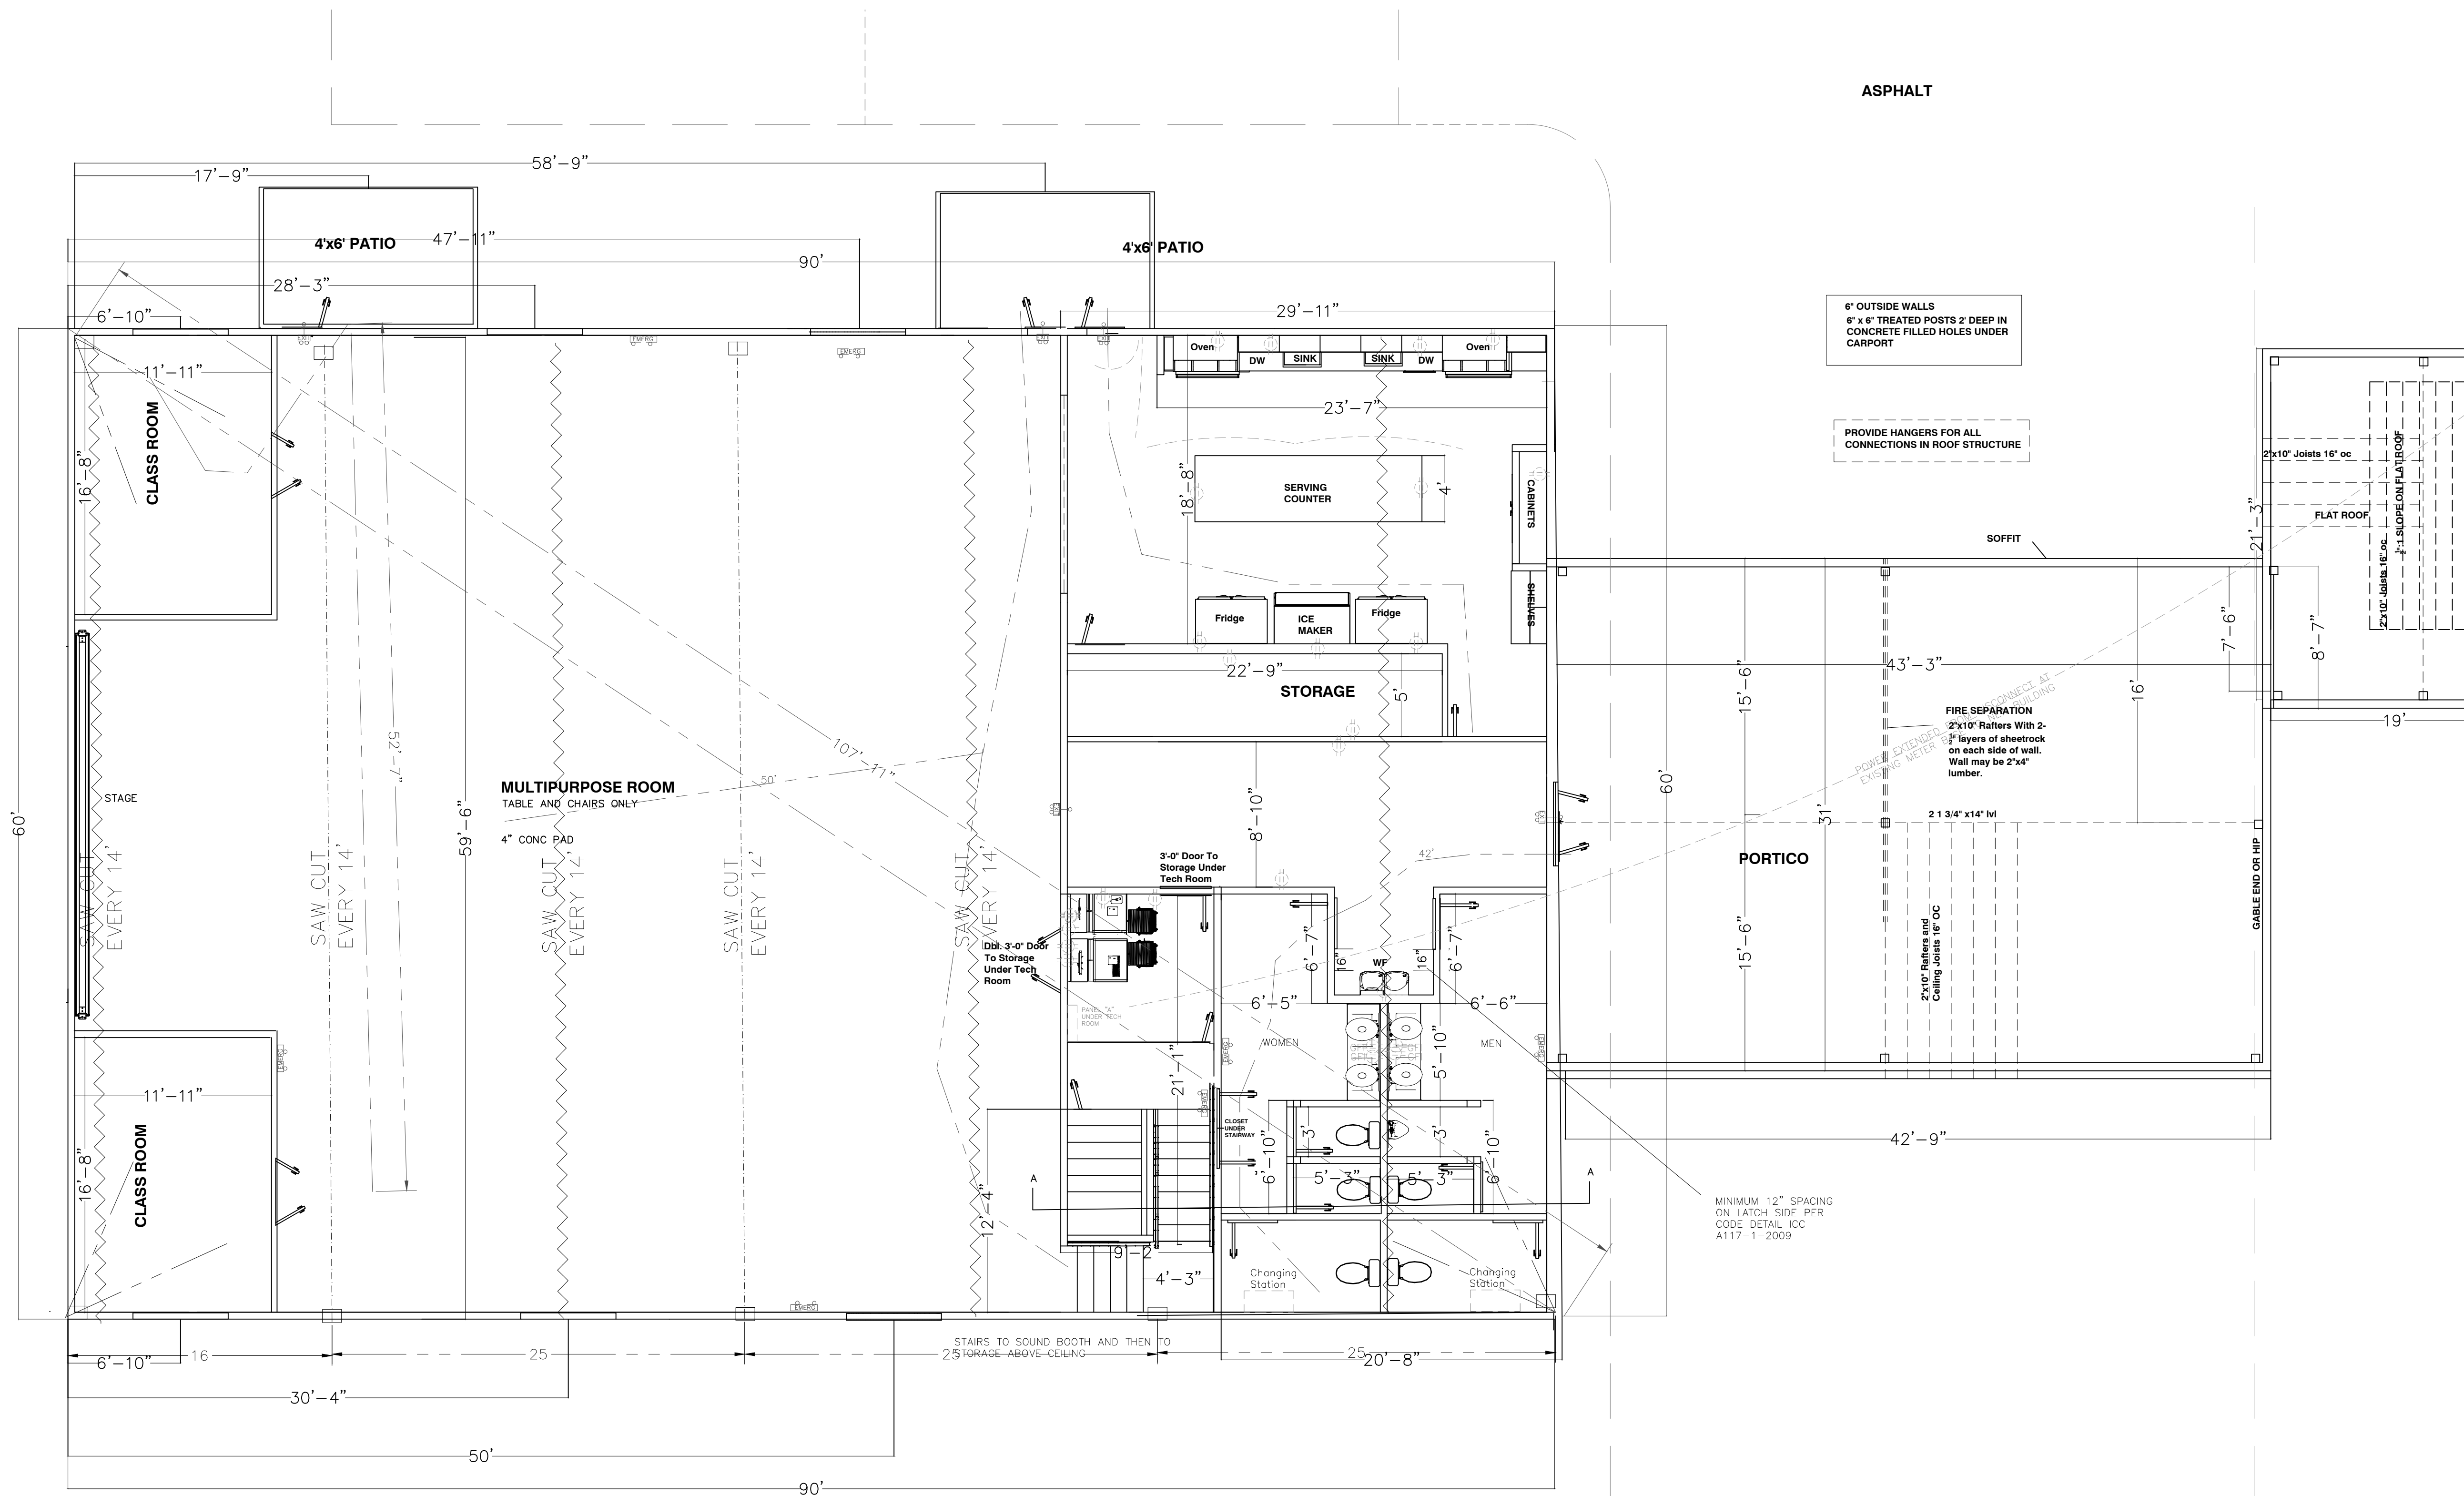

LIFE SAFETY PLAN REQUIREMENTS	
Life Safety Plan Sheet #:	
☐	Fire and/or smoke rated wall locations (Chapter 7)
☐	Assumed and real property line locations (if not on the site plan)
☐	Exterior wall opening area with respect to distance to assumed property lines (705.8)
☐	Occupancy Use for each area as it relates to occupant load calculation (Table 1004.1.2)
☐	Occupant loads for each area
☐	Exit access travel distances (1017)
☐	Common path of travel distances (Tables 1006.2.1 & 1006.3.2(1))
☐	Dead end lengths (1020.4)
☐	Clear exit widths for each exit door
☐	Maximum calculated occupant load capacity each exit door can accommodate based on egress width (1005.3)
☐	Actual occupant load for each exit door
☐	A separate schematic plan indicating where fire rated floor/ceiling and/or roof structure is provided for purposes of occupancy separation
☐	Location of doors with panic hardware (1010.1.10)
☐	Location of doors with delayed egress locks and the amount of delay (1010.1.9.7)
☐	Location of doors with electromagnetic egress locks (1010.1.9.9)
☐	Location of doors equipped with hold-open devices
☐	Location of emergency escape windows (1030)
☐	The square footage of each fire area (202)
☐	The square footage of each smoke compartment for Occupancy Classification I-2 (407.5)
☐	Note any code exceptions or table notes that may have been utilized regarding the items above

DIAGONAL IS 107'-11"
DISTANCE BETWEEN EXIT
MAX =54' OR 1/2 DIAGONAL
5 EXIT DOOR AT 35"/.32
= 546 OCCUPANTS CAN
BE EVACUATED.

OCCUPANT LOAD

LOCATION	TYPE	TABLE 1004.1	AREA	OCCUPANCY
MULTIPURPOSE	A2	15 NET	3660 SQ FT	244
	A2	200 GROSS	478 SQ FT	3
CLASS	A2	15 NET	352 SQ FT	20
	A2	200 GROSS	140 SQ FT	1
TOTAL				268

LIFE SAFETY

3/16" = 1'0"

Project #:
Date:
Drawn/Design By:
Scale:

REVISIONS		
No.	Date	Remarks
1		
2		
3		
4		

CAROLINA PROFESSIONAL SEAL 24720 NORTH HARRIS C. GREGORY

C. Gregory Bagley, Engineer
805 Cokesbury Road
Fuquay Varina, N.C. 27526
Office: (919)552-1600
Fax: (919) 552-6325


DESIGN
GREGORY BAGLEY
ENGINEER
PLANNING
CONSTRUCTION
MARKING

LIFE SAFETY

HARMONY
BAPTIST CHURCH
RODNEY GREGORY
Harnett County N.C.


Client Name:

Sheet Number
3
of 10

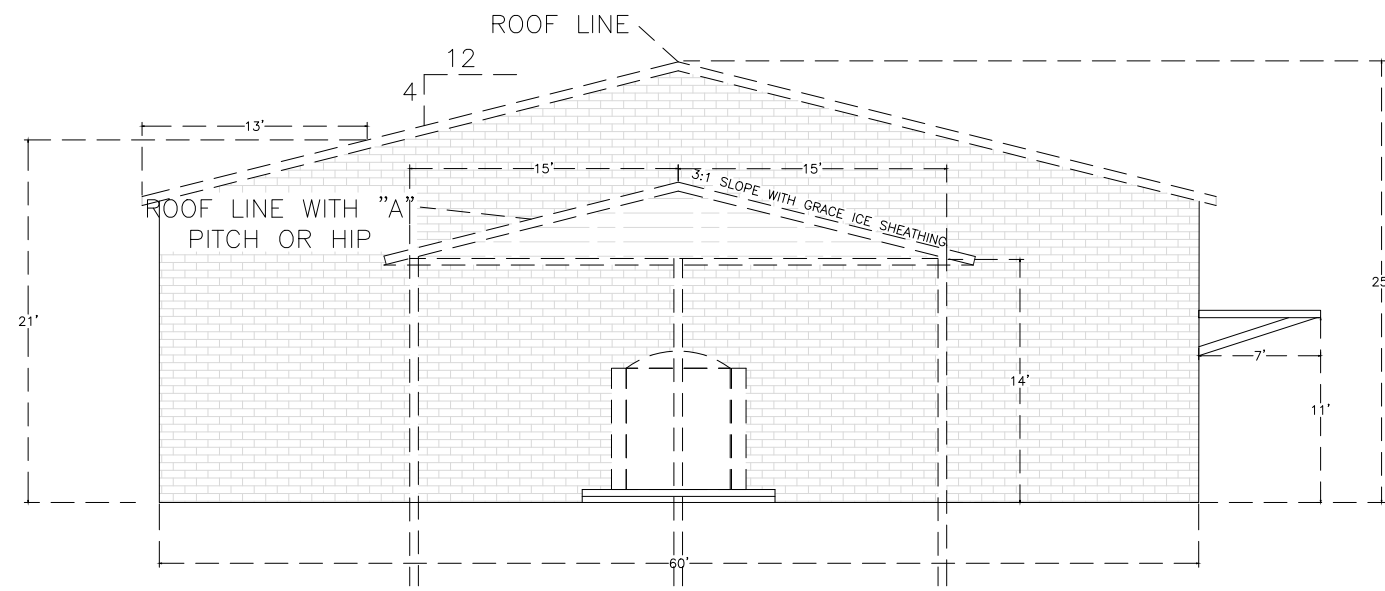


FRONT VIEW


BUILDING MATERIAL
METAL SIDING BUTTER CREAM .026 GAUGE
METAL ROOF .026 GALVALUME
BRICK STANDARD GRAY SHALE
WINDOWS BRONZE WITH GRAY TINT
DOOR BRONZE WITH GRAY TINT
DOWN SPOUT 6" DARK GRAY

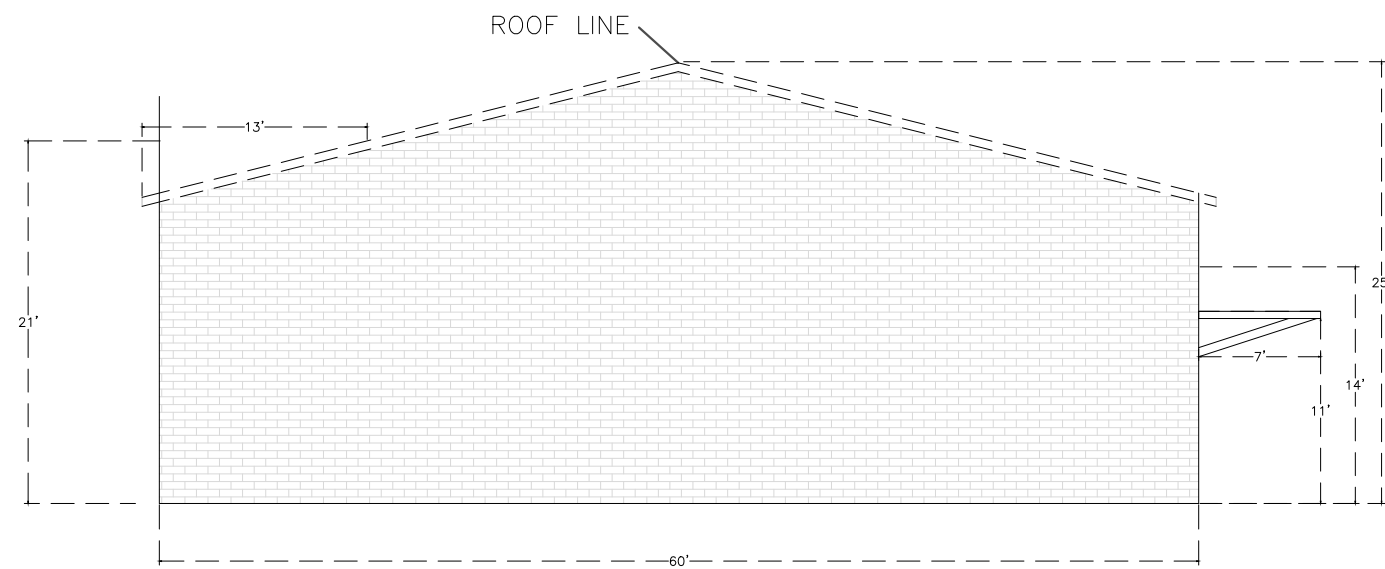


BACK VIEW

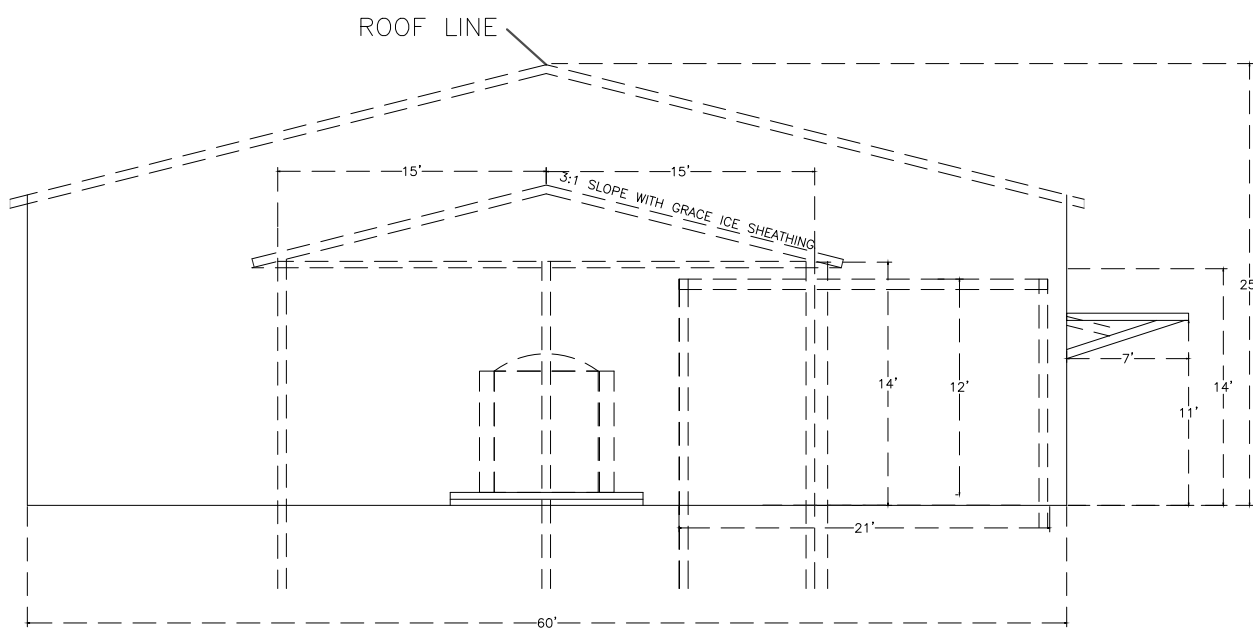

ROOF VIEW

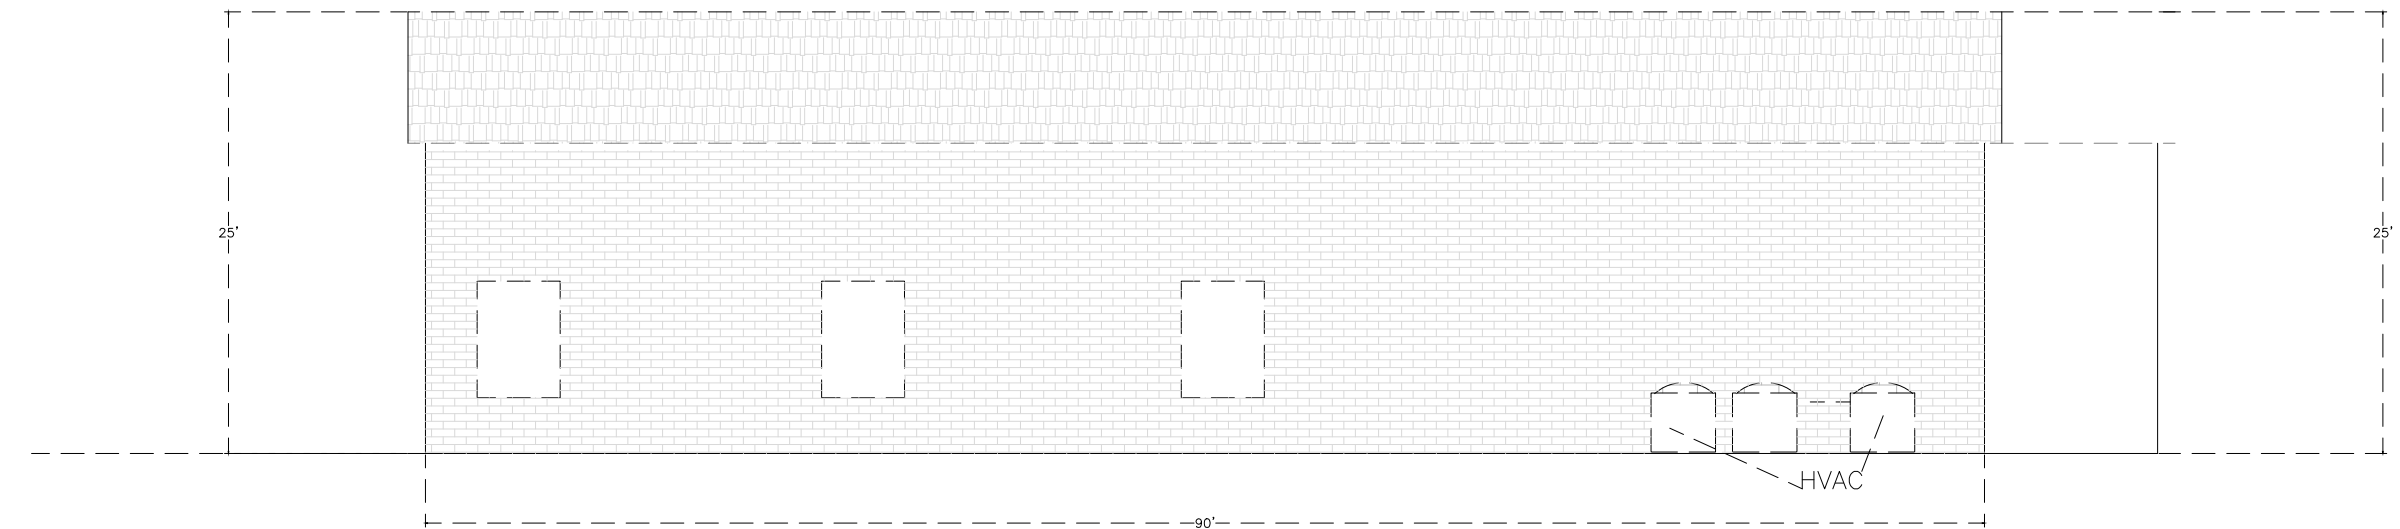

RIGHT VIEW

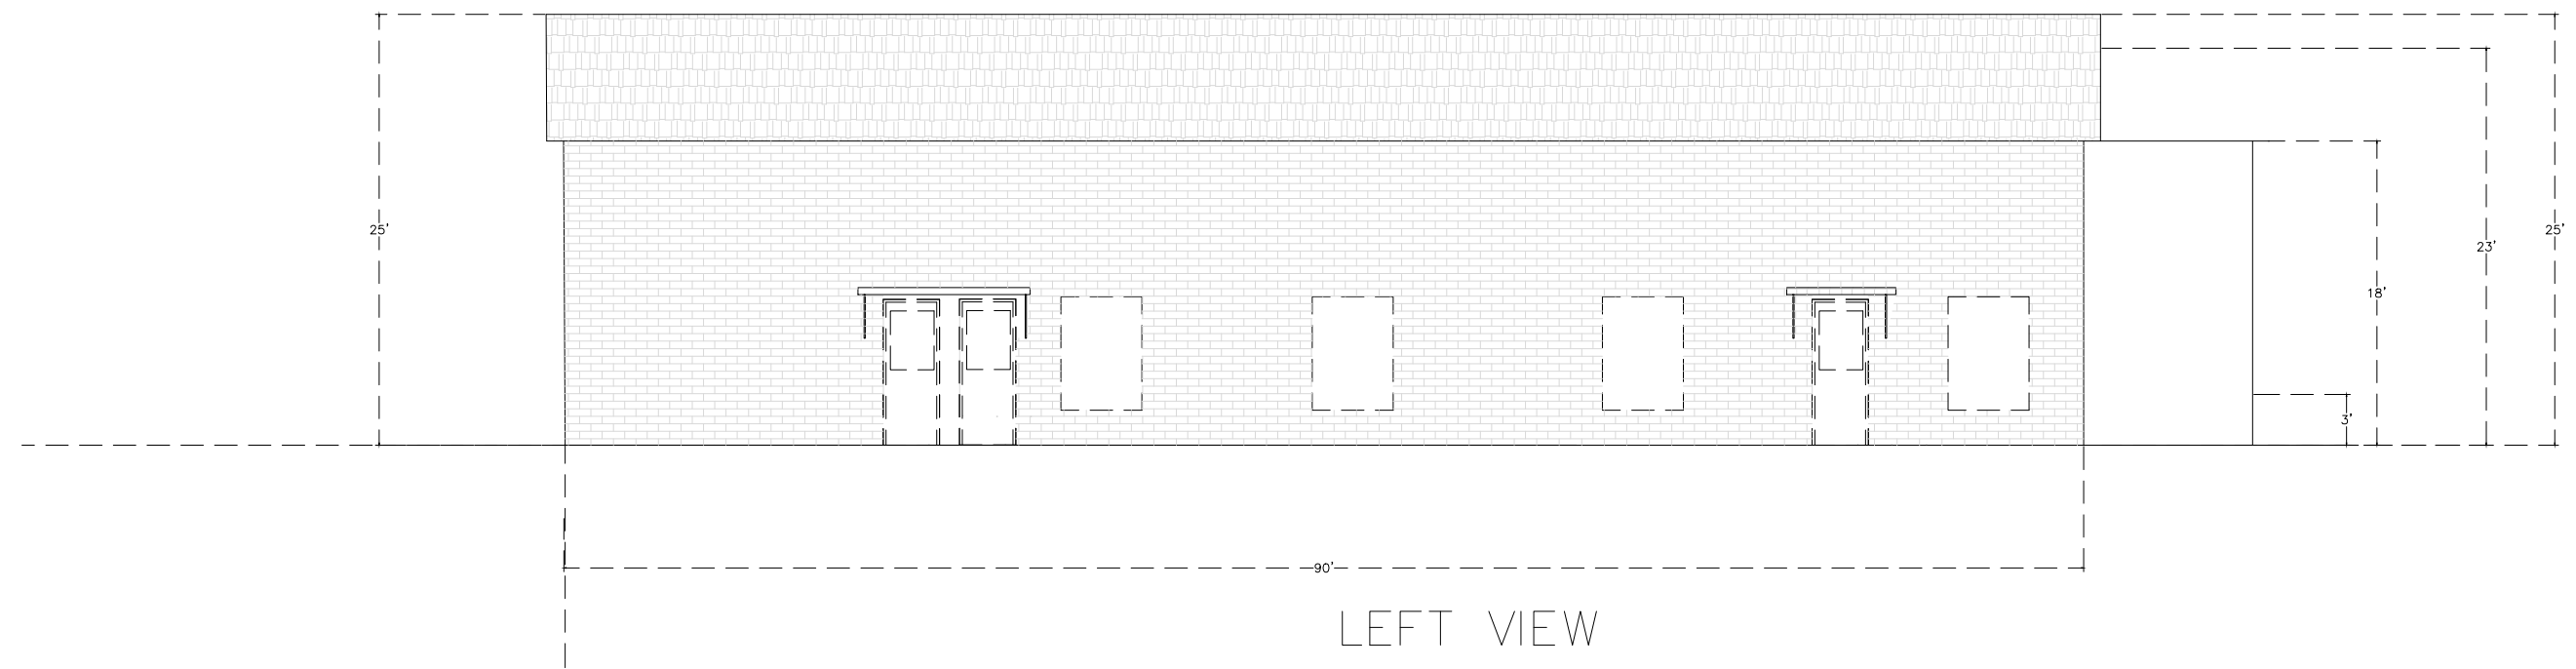

LEFT VIEW

ELEVATION

$\frac{3}{16}'' = 1'0''$

Project #:

Date:

Drawn/Design By:


Scale:

REVISIONS

No.	Date	Remarks
1		
2		
3		
4		



C. Gregory Bagley, Engineer
805 Cokesbury Road
Fuquay Varina, N.C. 27526
Office: (919) 552-1600
Fax: (919) 552-6325

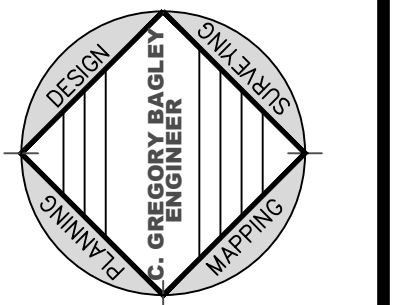

ELEVATION


HARMONY
BAPTIST CHURCH
RODNEY GREGORY
Harnett County N.C.

Client Name:

Sheet Number

4

of 10

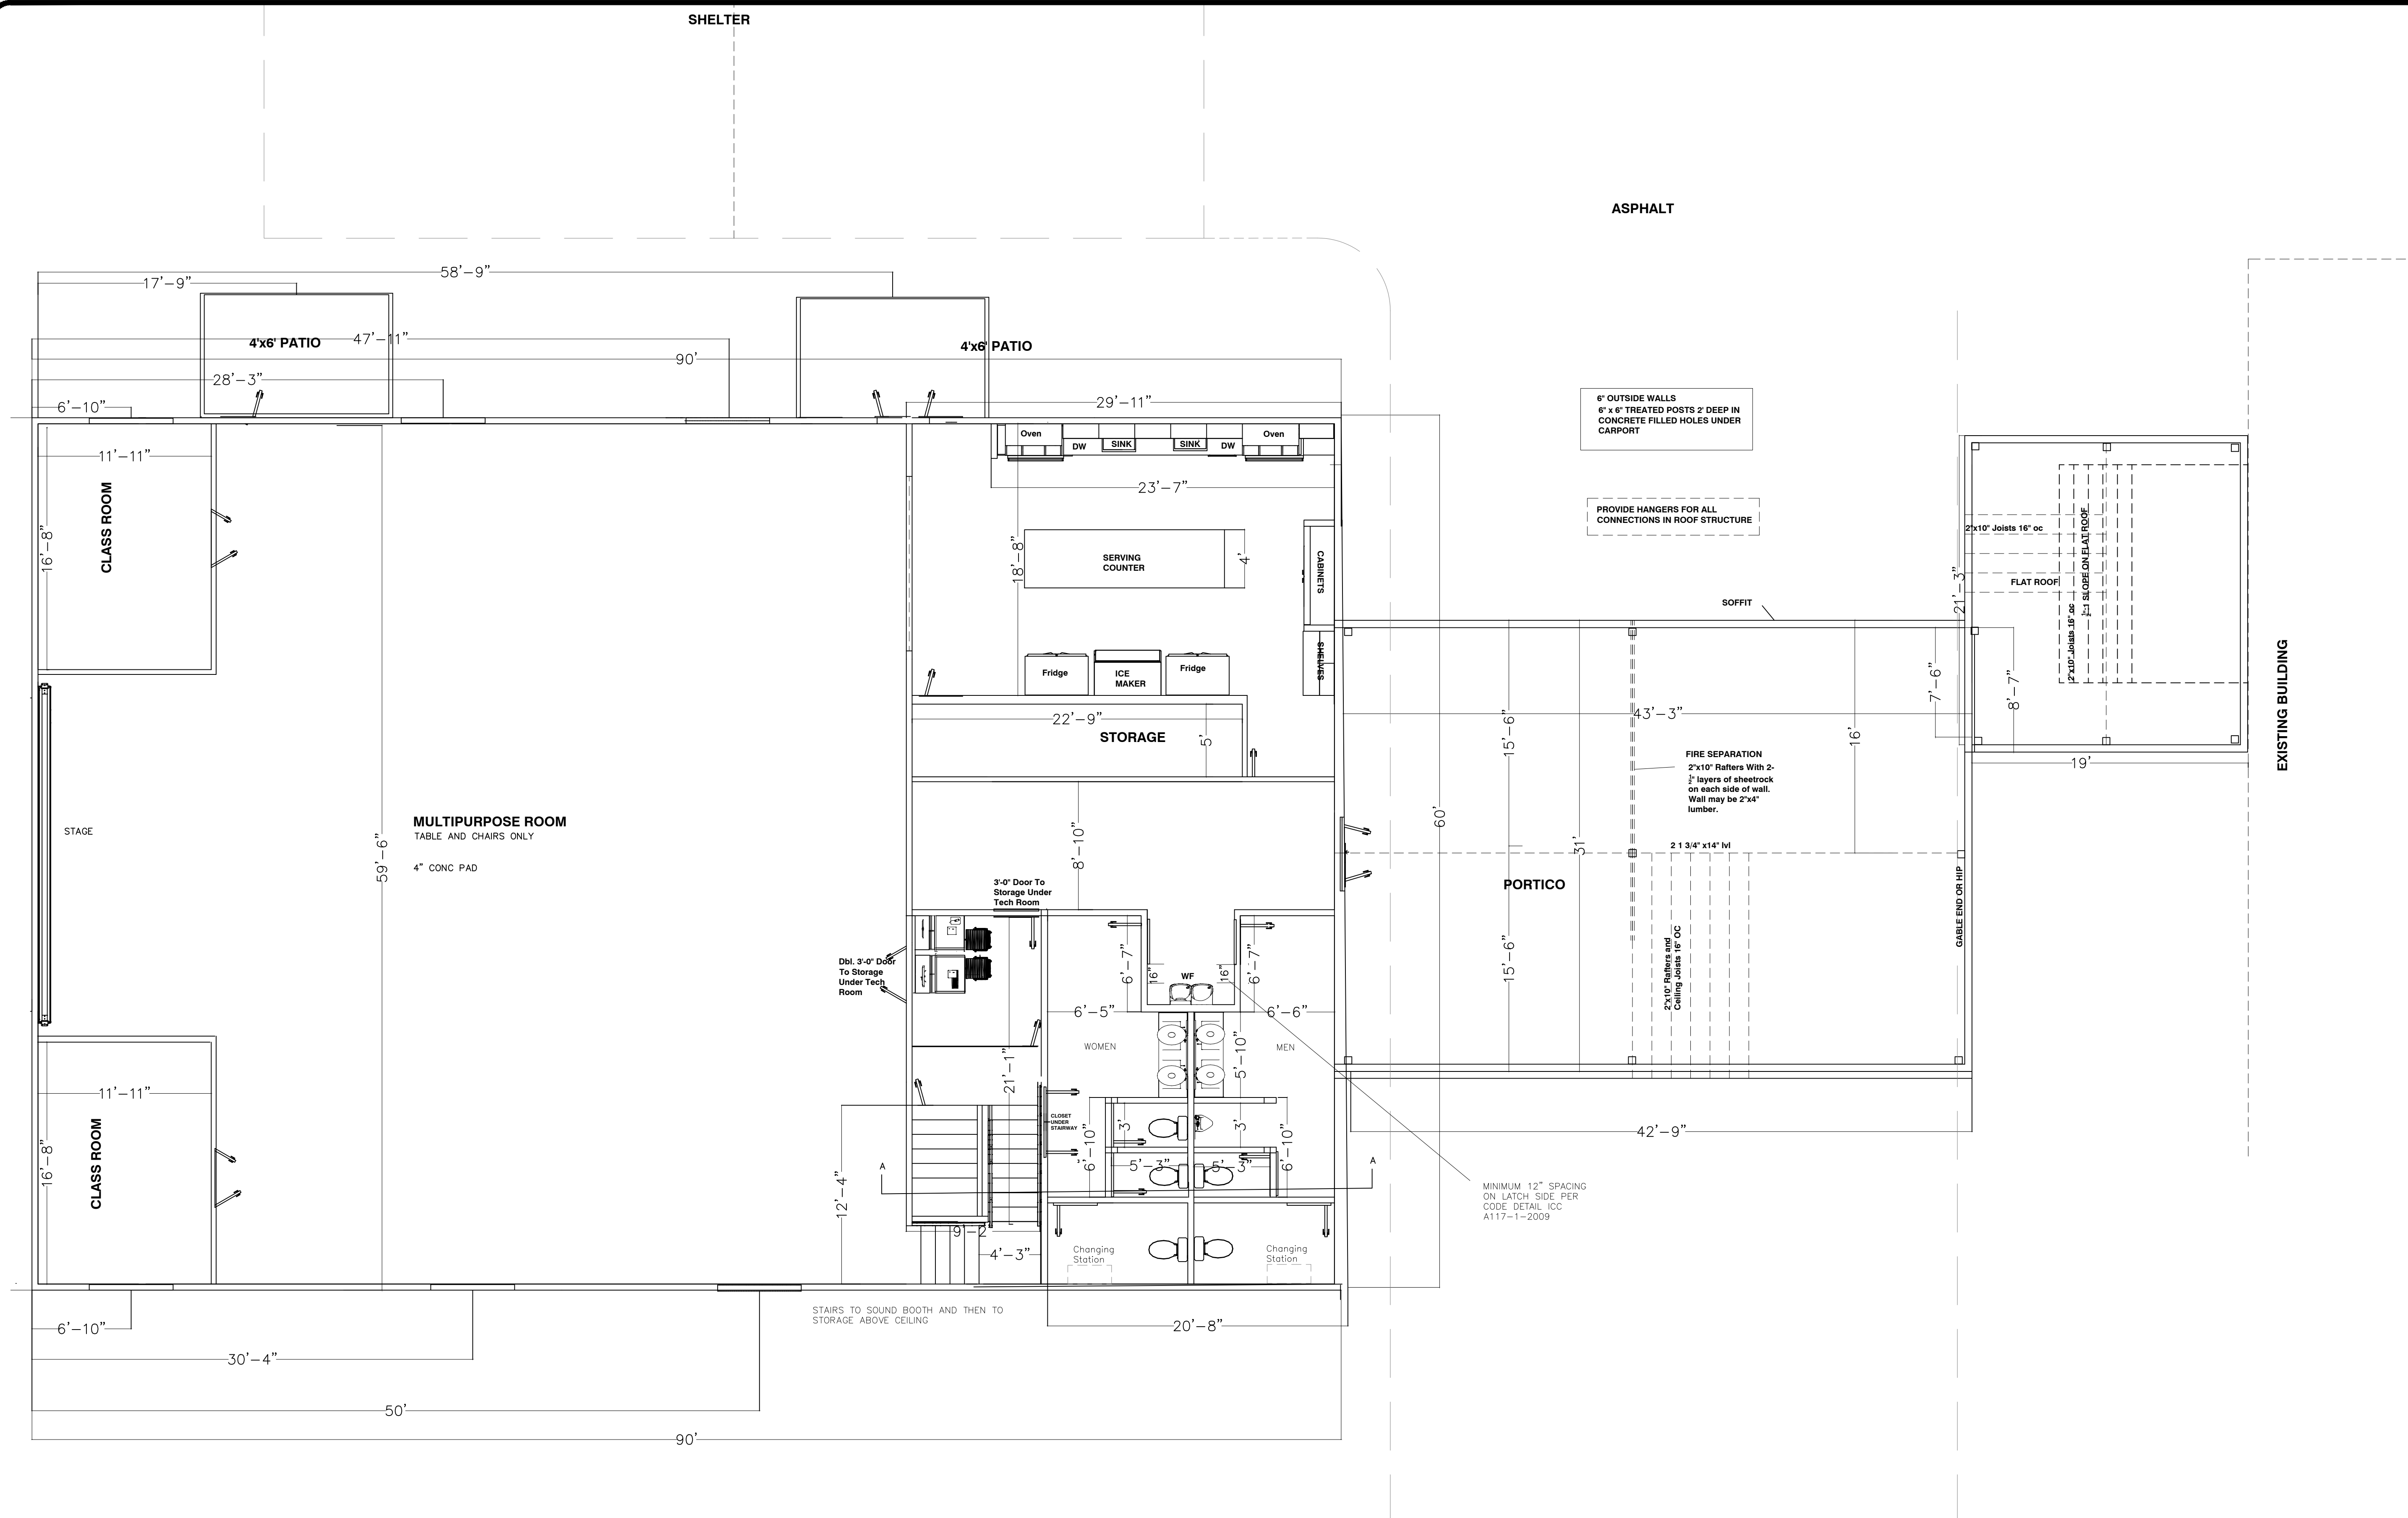


Project #:

Date:


Drawn/Design By:

Scale:

REVISIONS		
No.	Date:	Remarks
1		
2		
3		
4		

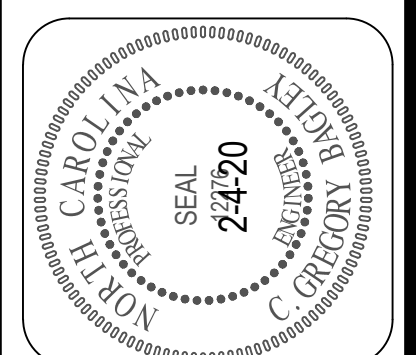

C. Gregory Bagley, Engineer
805 Cokesbury Road
Fuquay Varina, N.C. 27526
Office: (919) 552-1600
Fax: (919) 552-6325

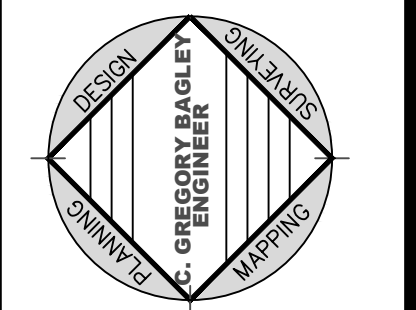


FLOOR
PLAN

Client Name: **HARMONY**
BAPTIST CHURCH
RODNEY GREGORY
Harnett County N.C.

Sheet Number

5

of 10

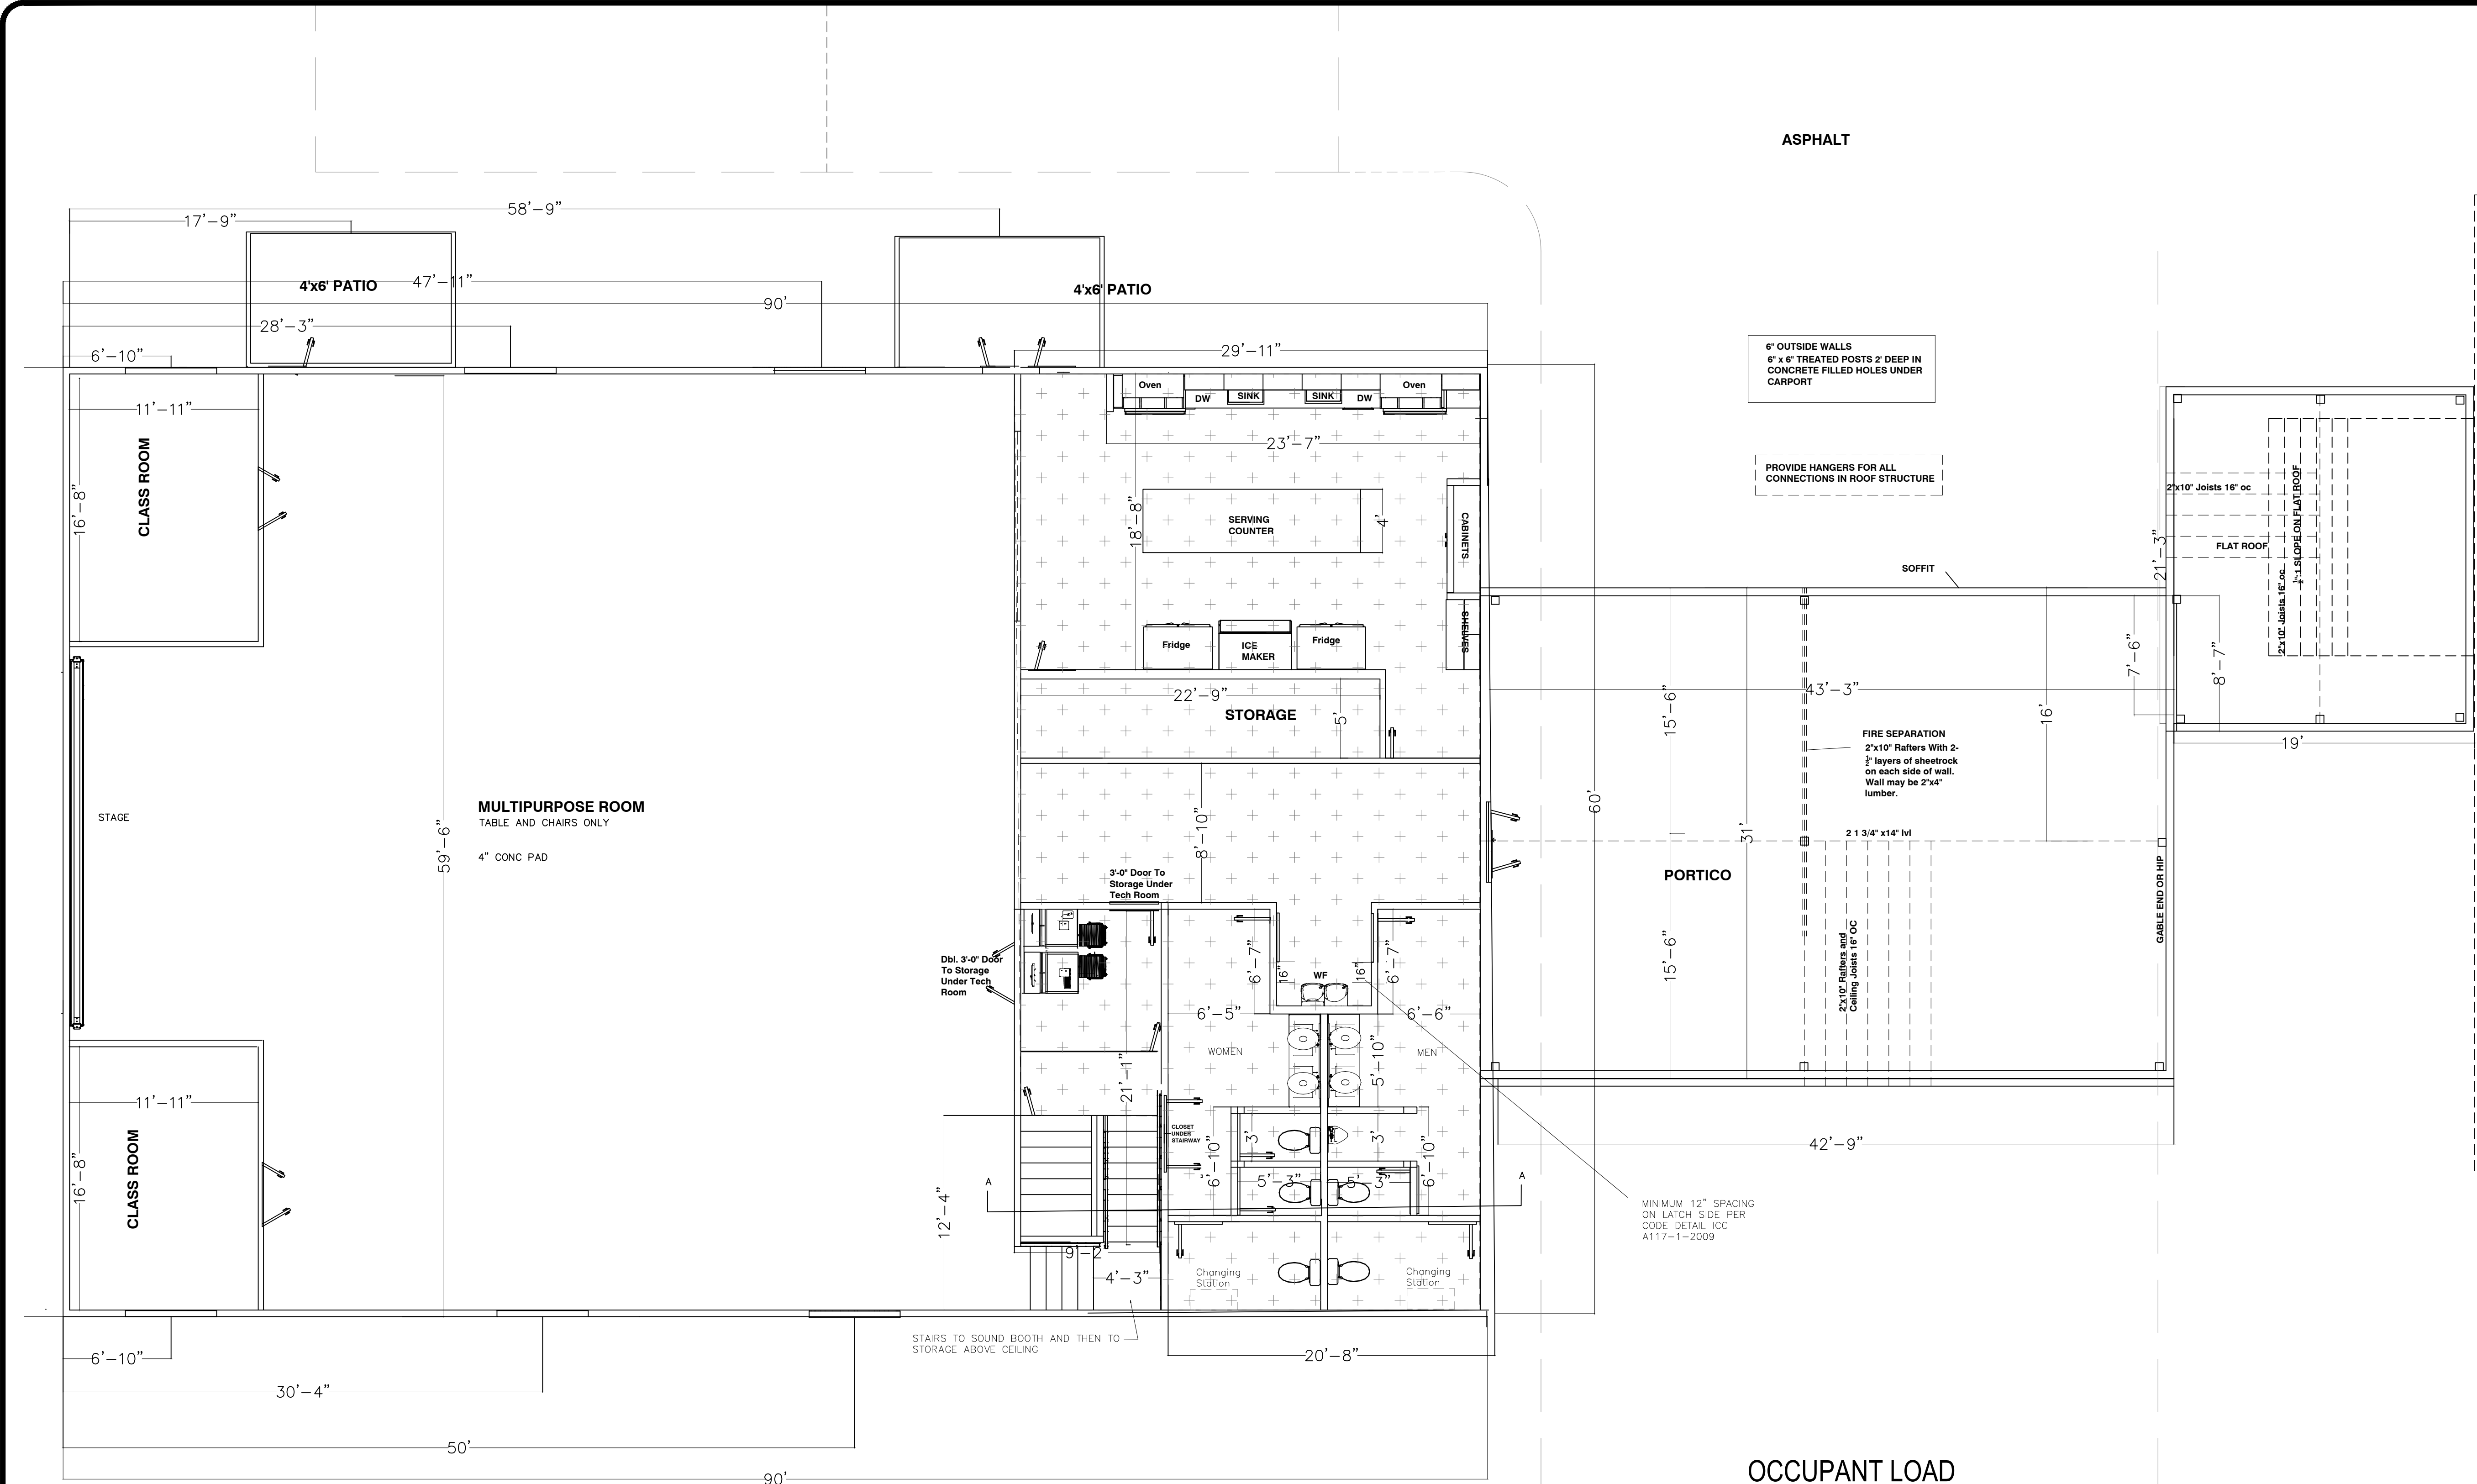

DOOR SCHEDULE			
LOCATION	TYPE	SIZE	KEY
1	EXTERIOR	H.M. FRAME AND METAL DOOR	36"x84" Y
1A	EXTERIOR	H.M. FRAME AND M.D. w PANIC HDWARE (4)	36"x84" Y
2	MEN	H.M. DOOR w/ WOOD PANEL	36"x84" Y
3	WOMEN	H.M. DOOR w/ WOOD PANEL	36"x84" Y
4	HALL DOOR	H.M. DOOR w/ 4" SITE GLASS	72"x84" Y
5	INTERIOR	H.M. FRAME AND METAL DOOR (5)	36"x84" Y

BUILDING SQ. FOOTAGE		
LOCATION	TYPE	AREA
MULTIPURPOSE	HEATED	3660 SQ FT
KITCHEN (No Commercial)	HEATED	558 SQ FT
CLASS	HEATED	384 SQ FT
STORAGE	HEATED	140 SQ FT
PORCHES	UN-HEATED	1750 SQ FT
UPPER STORAGE	UN-HEATED	1637 SQ FT

OCCUPANT LOAD				
LOCATION	TYPE	TABLE 1004.1	AREA	OCCUPANCY
MULTIPURPOSE	A2	15 NET	3660 SQ FT	244
KITCHEN	A2	200 GROSS	478 SQ FT	3
CLASS	A2	15 NET	352 SQ FT	20
STORAGE	A2	200 GROSS	140 SQ FT	1
TOTAL				268


Project #:

Date:


Drawn/Design By:

Scale:

REVISIONS		
No.	Date	Remarks
1		
2		
3		
4		

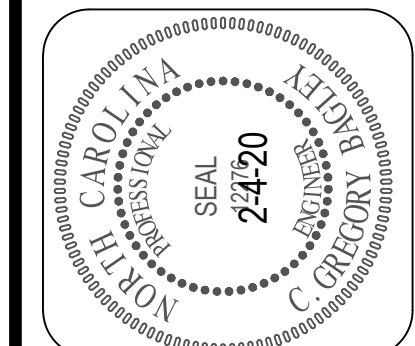

C. Gregory Bagley, Engineer
805 Cokesbury Road
Fuquay Varina, N.C. 27526
Office: (919)552-1600
Fax: (919) 552-6325

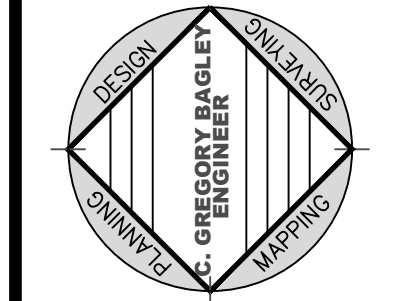


FLOOR PLAN


HARMONY
BAPTIST CHURCH
RODNEY GREGORY
Harnett County N.C.

FLOOR PLAN

3" = 1'0"

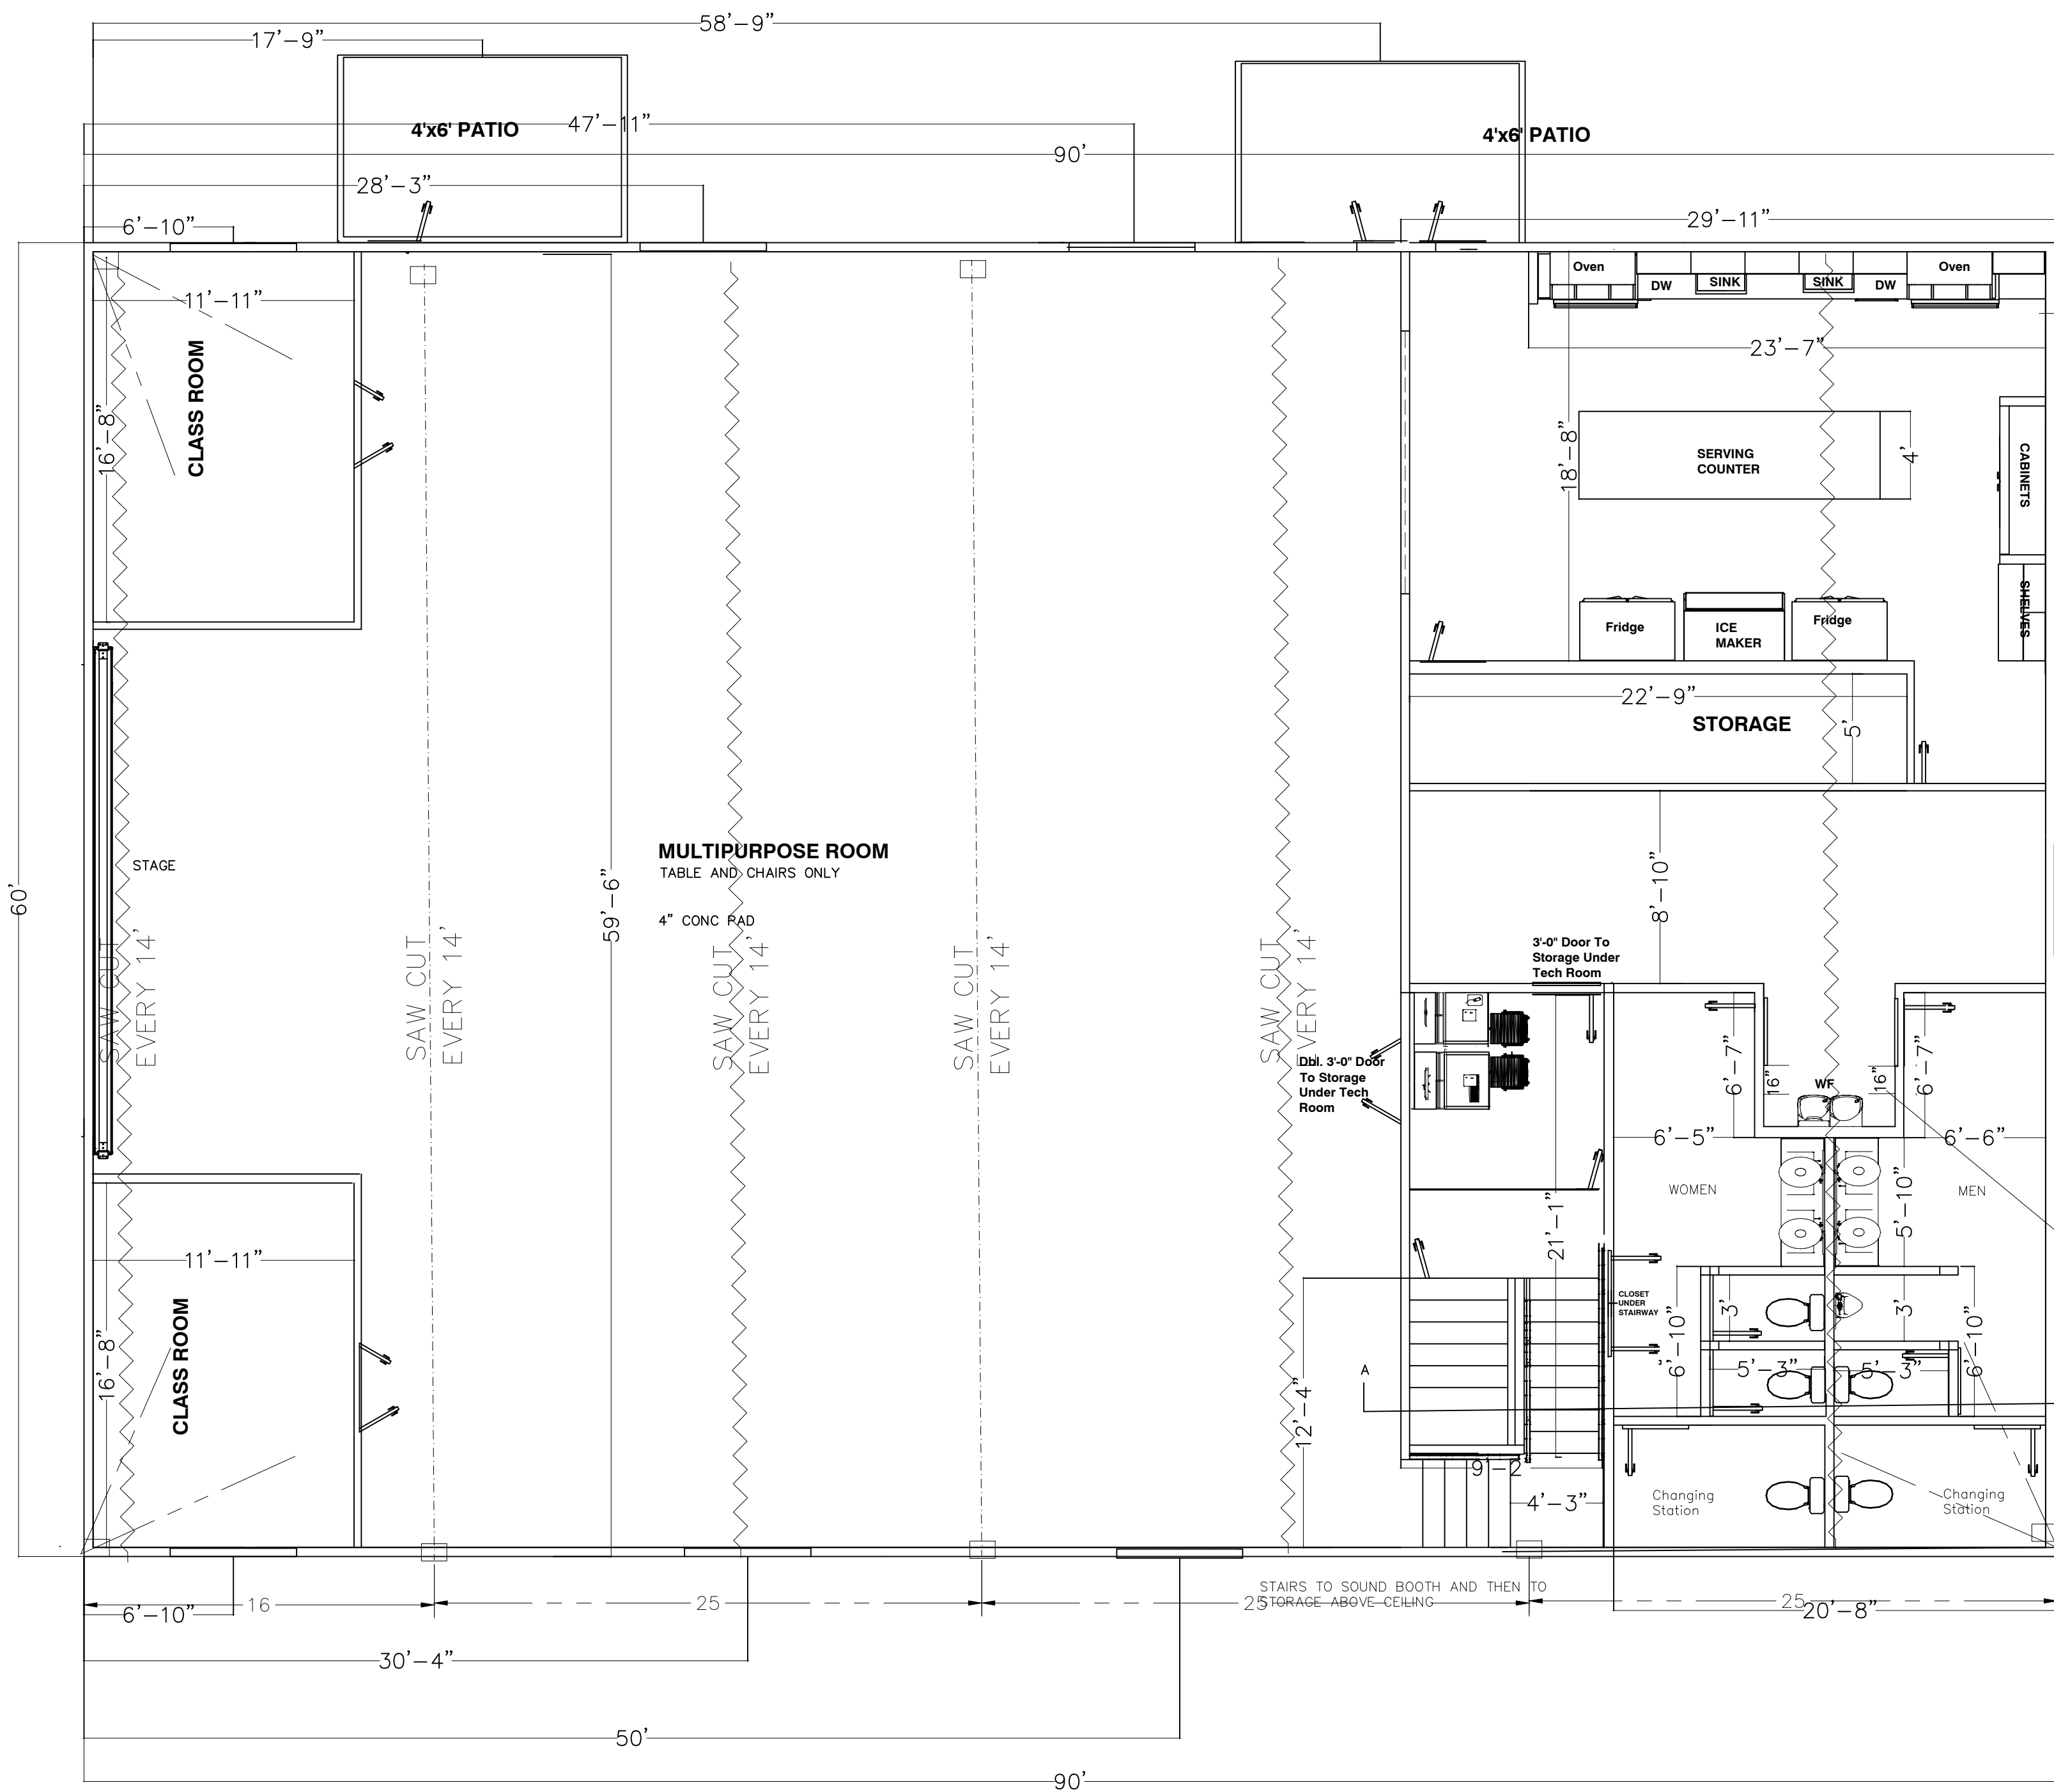

MINIMUM 12" SPACING
ON LATCH SIDE PER
CODE DETAIL ICC
A117-1-2009

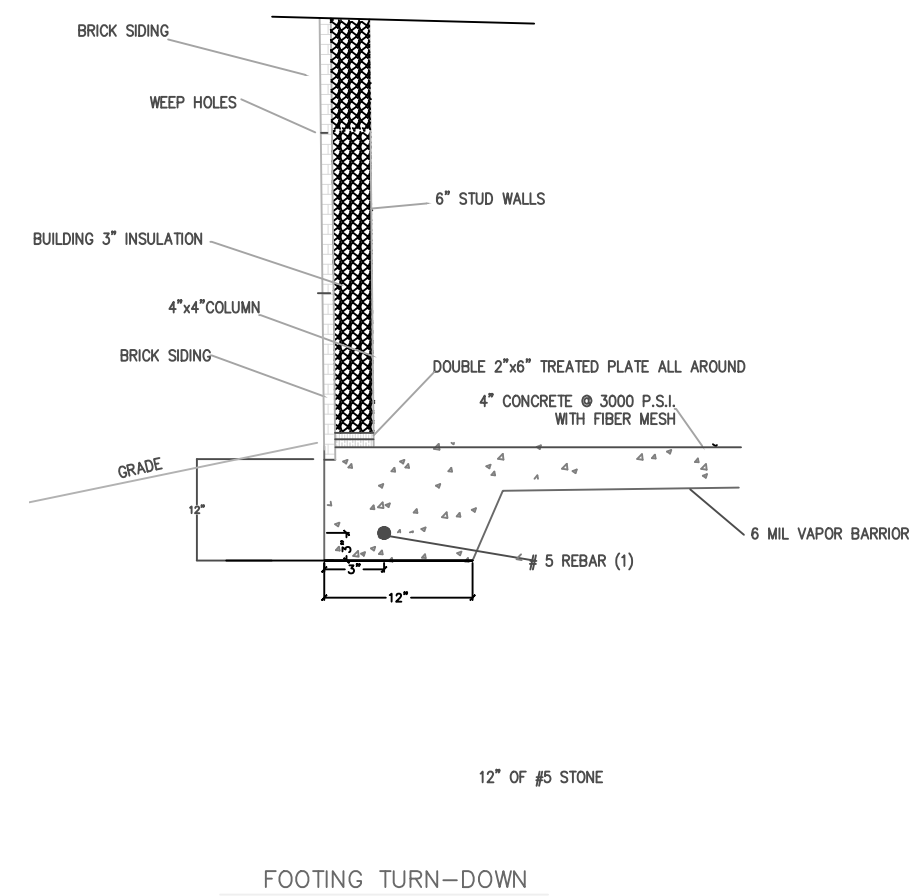


FOUNDATION


3/16" = 1'0"

Project #:
Date:
Drawn/Design By:
Scale:

REVISIONS		
No.	Date	Remarks
1		
2		
3		
4		

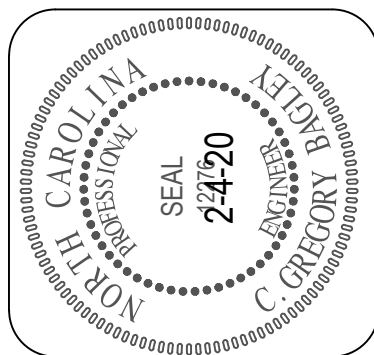


C. Gregory Bagley, Engineer
805 Cokesbury Road
Fuquay Varina, N.C. 27526
Office: (919)552-1600
Fax: (919) 552-6325

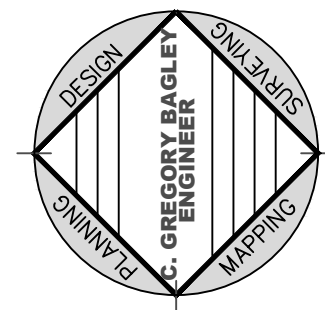

FOUNDATION

**HARMONY
BAPTIST CHURCH
RODNEY GREGORY**
Harnett County N.C.

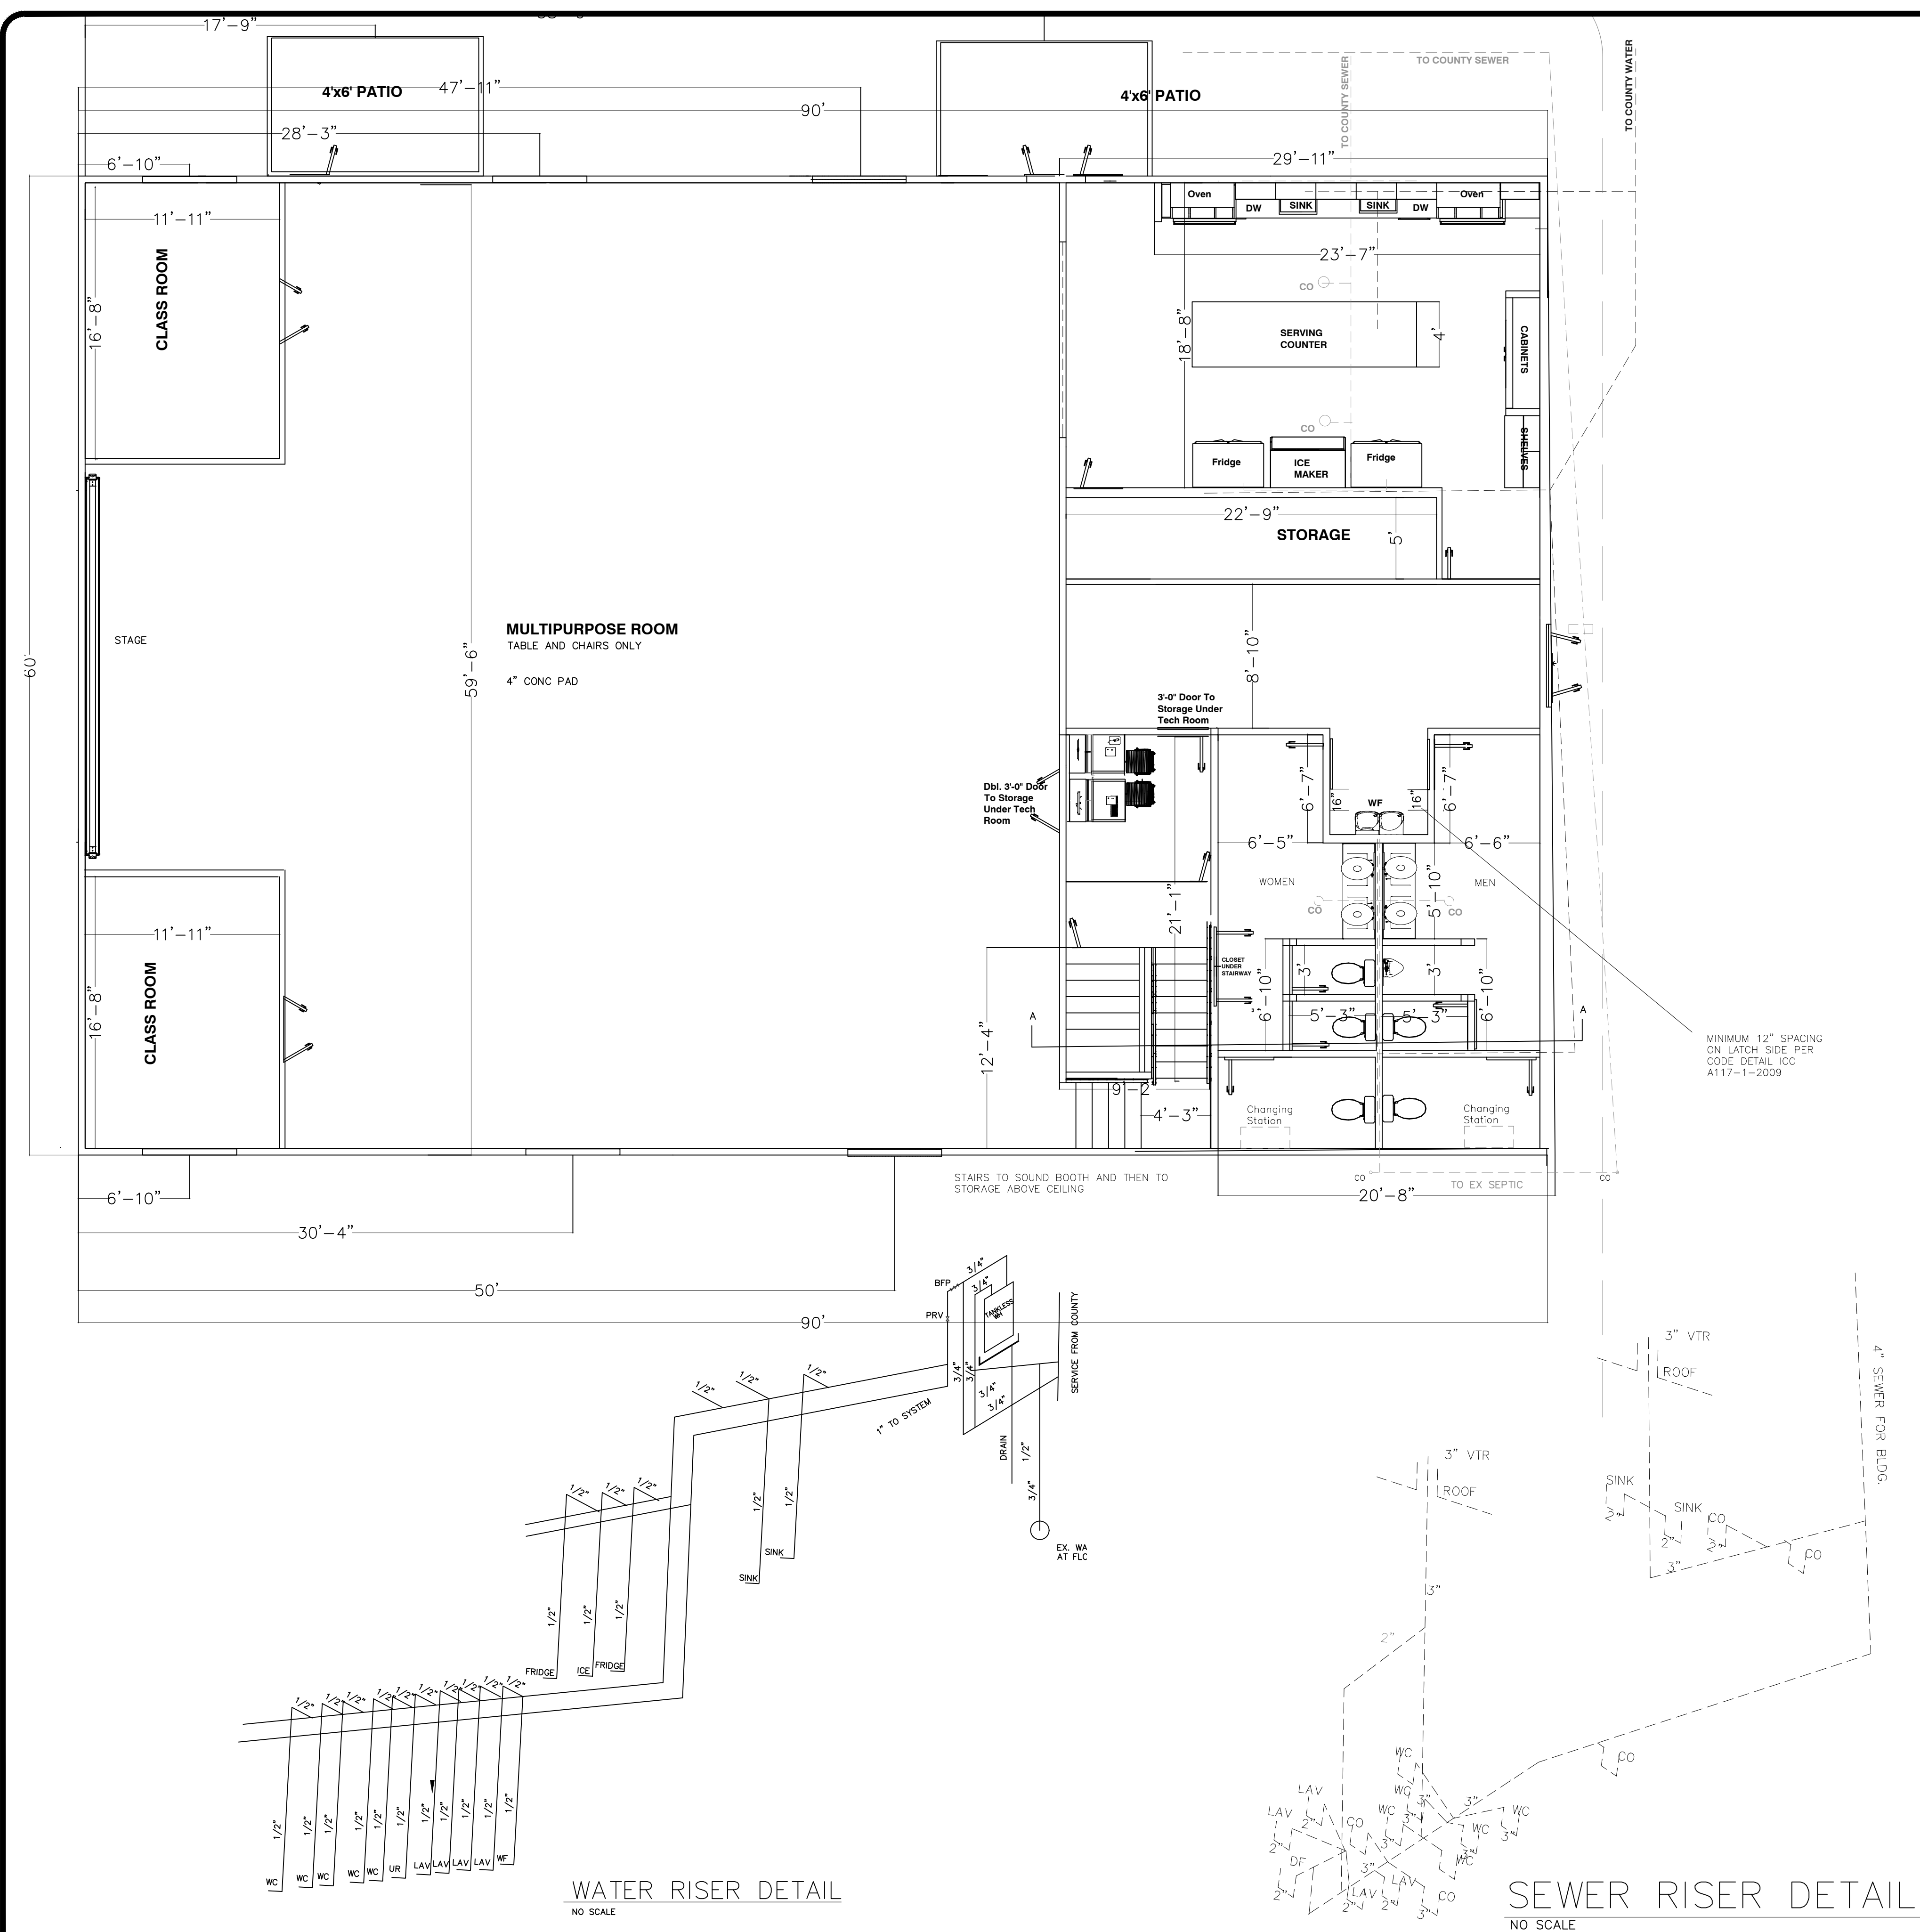

PLUMBING


3/16" = 1'0"

Project #:
Date:
Drawn/Design By:
Scale:

REVISIONS		
No.	Date	Remarks
1		
2		
3		
4		




C. Gregory Bagley, Engineer
805 Cokesbury Road
Fuquay Varina, N.C. 27526
Office: (919)552-1600
Fax: (919) 552-6325

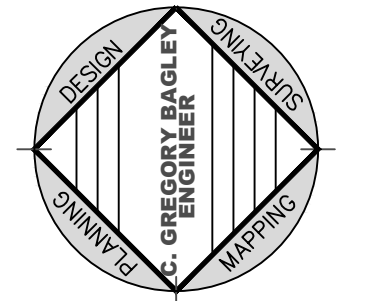

PLUMBING PLAN

HARMONY
BAPTIST CHURCH
RODNEY GREGORY
Harnett County N.C.

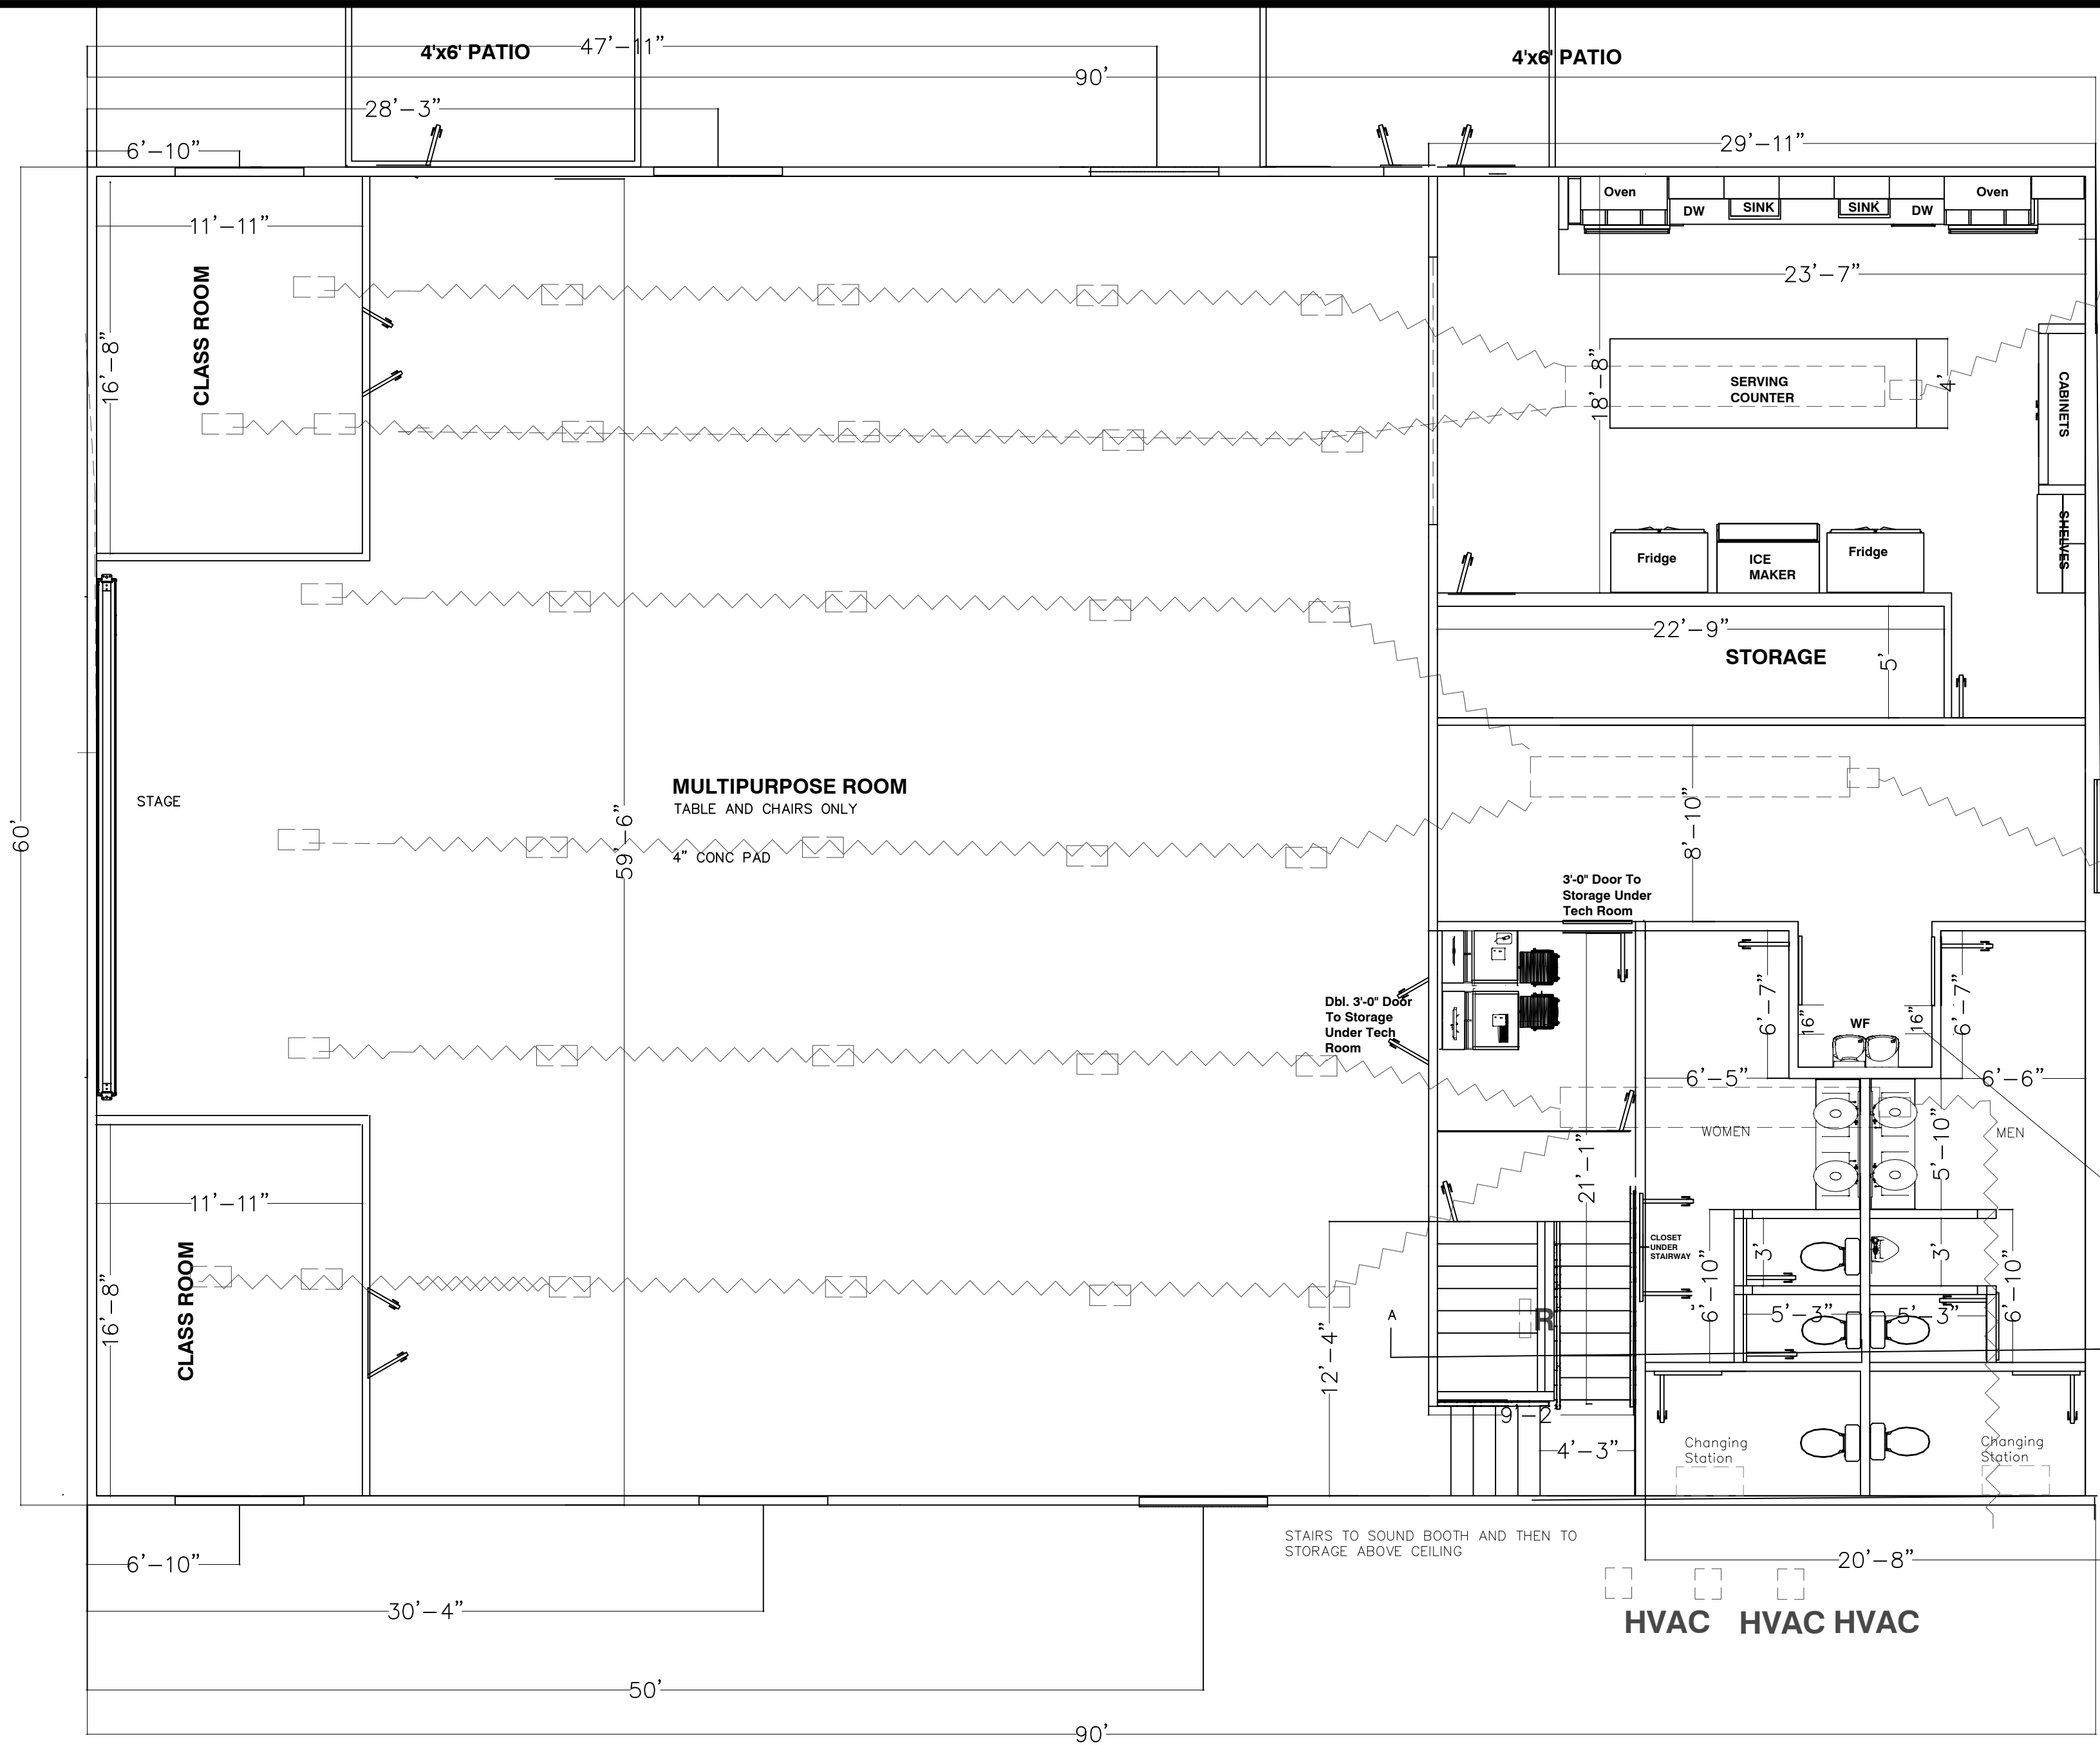

HVAC

MECHANICAL SYSTEMS, SERVICE SYSTEMS, AND EQUIPMENT

METHOD OF COMPLIANCE	PREScriptive
THERMAL ZONE	III
EXTERIOR DESIGN CONDITIONS	
winter dry bulb	18 F
summer dry bulb	82 F
INTERIOR DESIGN CONDITIONS	
winter dry bulb	70 F
summer dry bulb	74 F
relative humidity	50 %
BUILDING HEATING LOAD	75000/150000 BTU
BUILDING COOLING LOAD	123000 BTU
MECHANICAL SPACE CONDITIONING SYSTEMS	
Unitary	
description of unit	DX COOLING/HEAT
heating efficiency	12.2 IEER
cooling efficiency	12.2 IEER
heating output of units	60750 BTU
cooling output of units	119,000 BTU
LIST EQUIPMENT EFFICIENCIES	SEE SCHEDULE
EQUIPMENT SCHEDULES WITH MOTORS	SEE SCHEDULE

OUTSIDE AIR CALCULATION

CFM/PERSON	TOTAL CFM
50 CLIENTS	250
	USE 8" FLEX FOR OUTSIDE DUCT TO EACH UNIT

TOTAL CFM PRODUCED = 7200
(20) 8" VENTS
30 VENTS @ 220 CFM / VENT
= 6600 CFM OUTPUT
STATIC PRESSURE = 0.1in-wg

HVAC EQUIPMENT NOTES

USE (3) 14 SEER UNITS HEAT PUMP.
UNIT TO BE ON CONC SLAB OUTSIDE BUILDING.
3/4" CONDENSATE LINE WITH P-TRAP ROUTED TO OUTSIDE AND FASTENED TO WALL.
OUTSIDE AIR INTAKE TO BE ROUTED UP WALL FRAMING AND TERMINATED ABOVE ROOF.
INTAKE MUST BE A MINIMUM OF 10' FROM OUTLET OR EXHAUST.
MOUNT PROGRAMMABLE THERMOSTAT ON WALL 48" AFF. AS PER ADA REQUIREMENTS
BATHROOM FANS TO BE 125 CFM WITH 4" DUCT.
DISCHARGE EXHAUST OUTSIDE OF BUILDING.
USE 8" FLEX FOR OUTSIDE AIR INTAKE DUCT

GENERAL HVAC NOTES

PROVIDE ELECTRIC HEAT PUMP - SEE BELOW
MIN REQUIREMENTS TO BE MET AS NOTED ABOVE MET FROM NOTES ABOVE
LOCATE PROGRAMMABLE THERMOSTATS AS NEEDED FOR PROPER EFFECT
FANS SHALL RUN CONTINUOUSLY DURING OCCUPANCY TO PROVIDE OUTSIDE AIR.
DUCT DETECTORS REQUIRED ON ALL UNITS
REMOTE ALARM INDICATOR DEVICES (RAIDS) REQUIRED FOR EACH UNIT AND TO BE INSTALLED
NEAR UNIT NO MORE THAN 72" AFF
DUCT SMOKE DETECTORS TO OPERATE GLOBALLY, ie WHEN ONE DETECTOR ACTIVATES,
ALL AIR HANDLING UNITS SHUT DOWN.

HVAC EQUIPMENT SCHEDULE

3-5 TON UNITS ON GROUND	
1-5 TON MINI SPLIT MITSUBISHI	
BLUAD UNITS # 800L-B130CL15E	
GAS HEAT PACKAGE UNITS	
USE D 41-20 INDOOR SYSTEM	
SMOKE DETECTORS EACH UNIT	

CLIENT NAME: HARMONY BAPTIST CHURCH
PROJECT: MECHANICAL PLAN
DATE: 2/4/20
BY: C. GREGORY BAGLEY
SCALE: 3/16" = 1'-0"

MECHANICAL

3/16" = 1'-0"

Project #:

Date:

Drawn/Design By:


Scale:

REVISIONS

No.	Date	Remarks
1		
2		
3		
4		





C. Gregory Bagley, Engineer
805 Cokesbury Road
Fuquay Varina, N.C. 27526
Office: (919)552-1600
Fax: (919) 552-6325

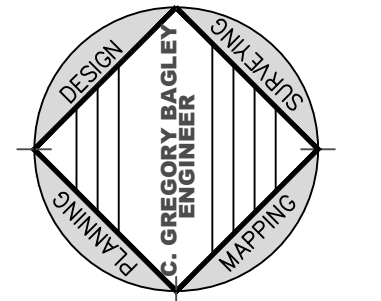

MECHANICAL PLAN

HARMONY BAPTIST CHURCH
RODNEY GREGORY
Harnett County N.C.

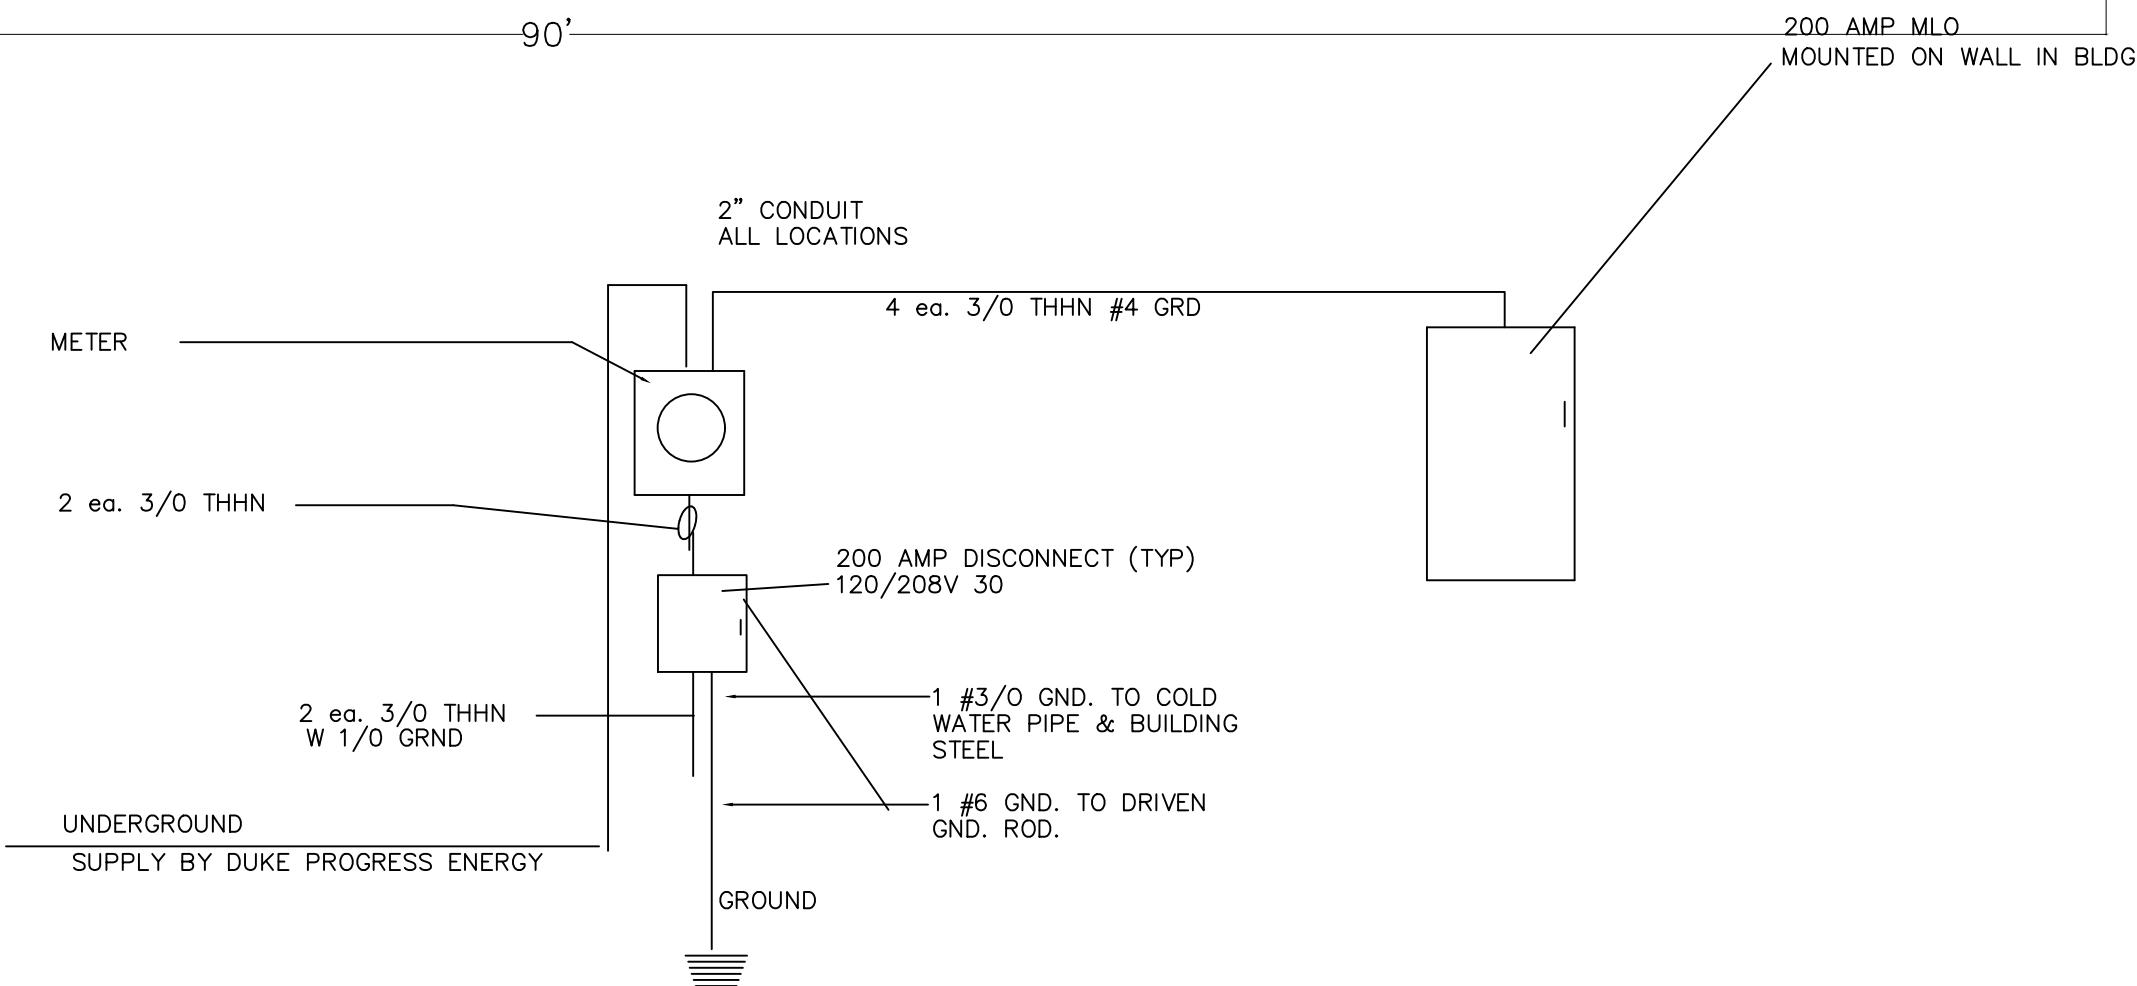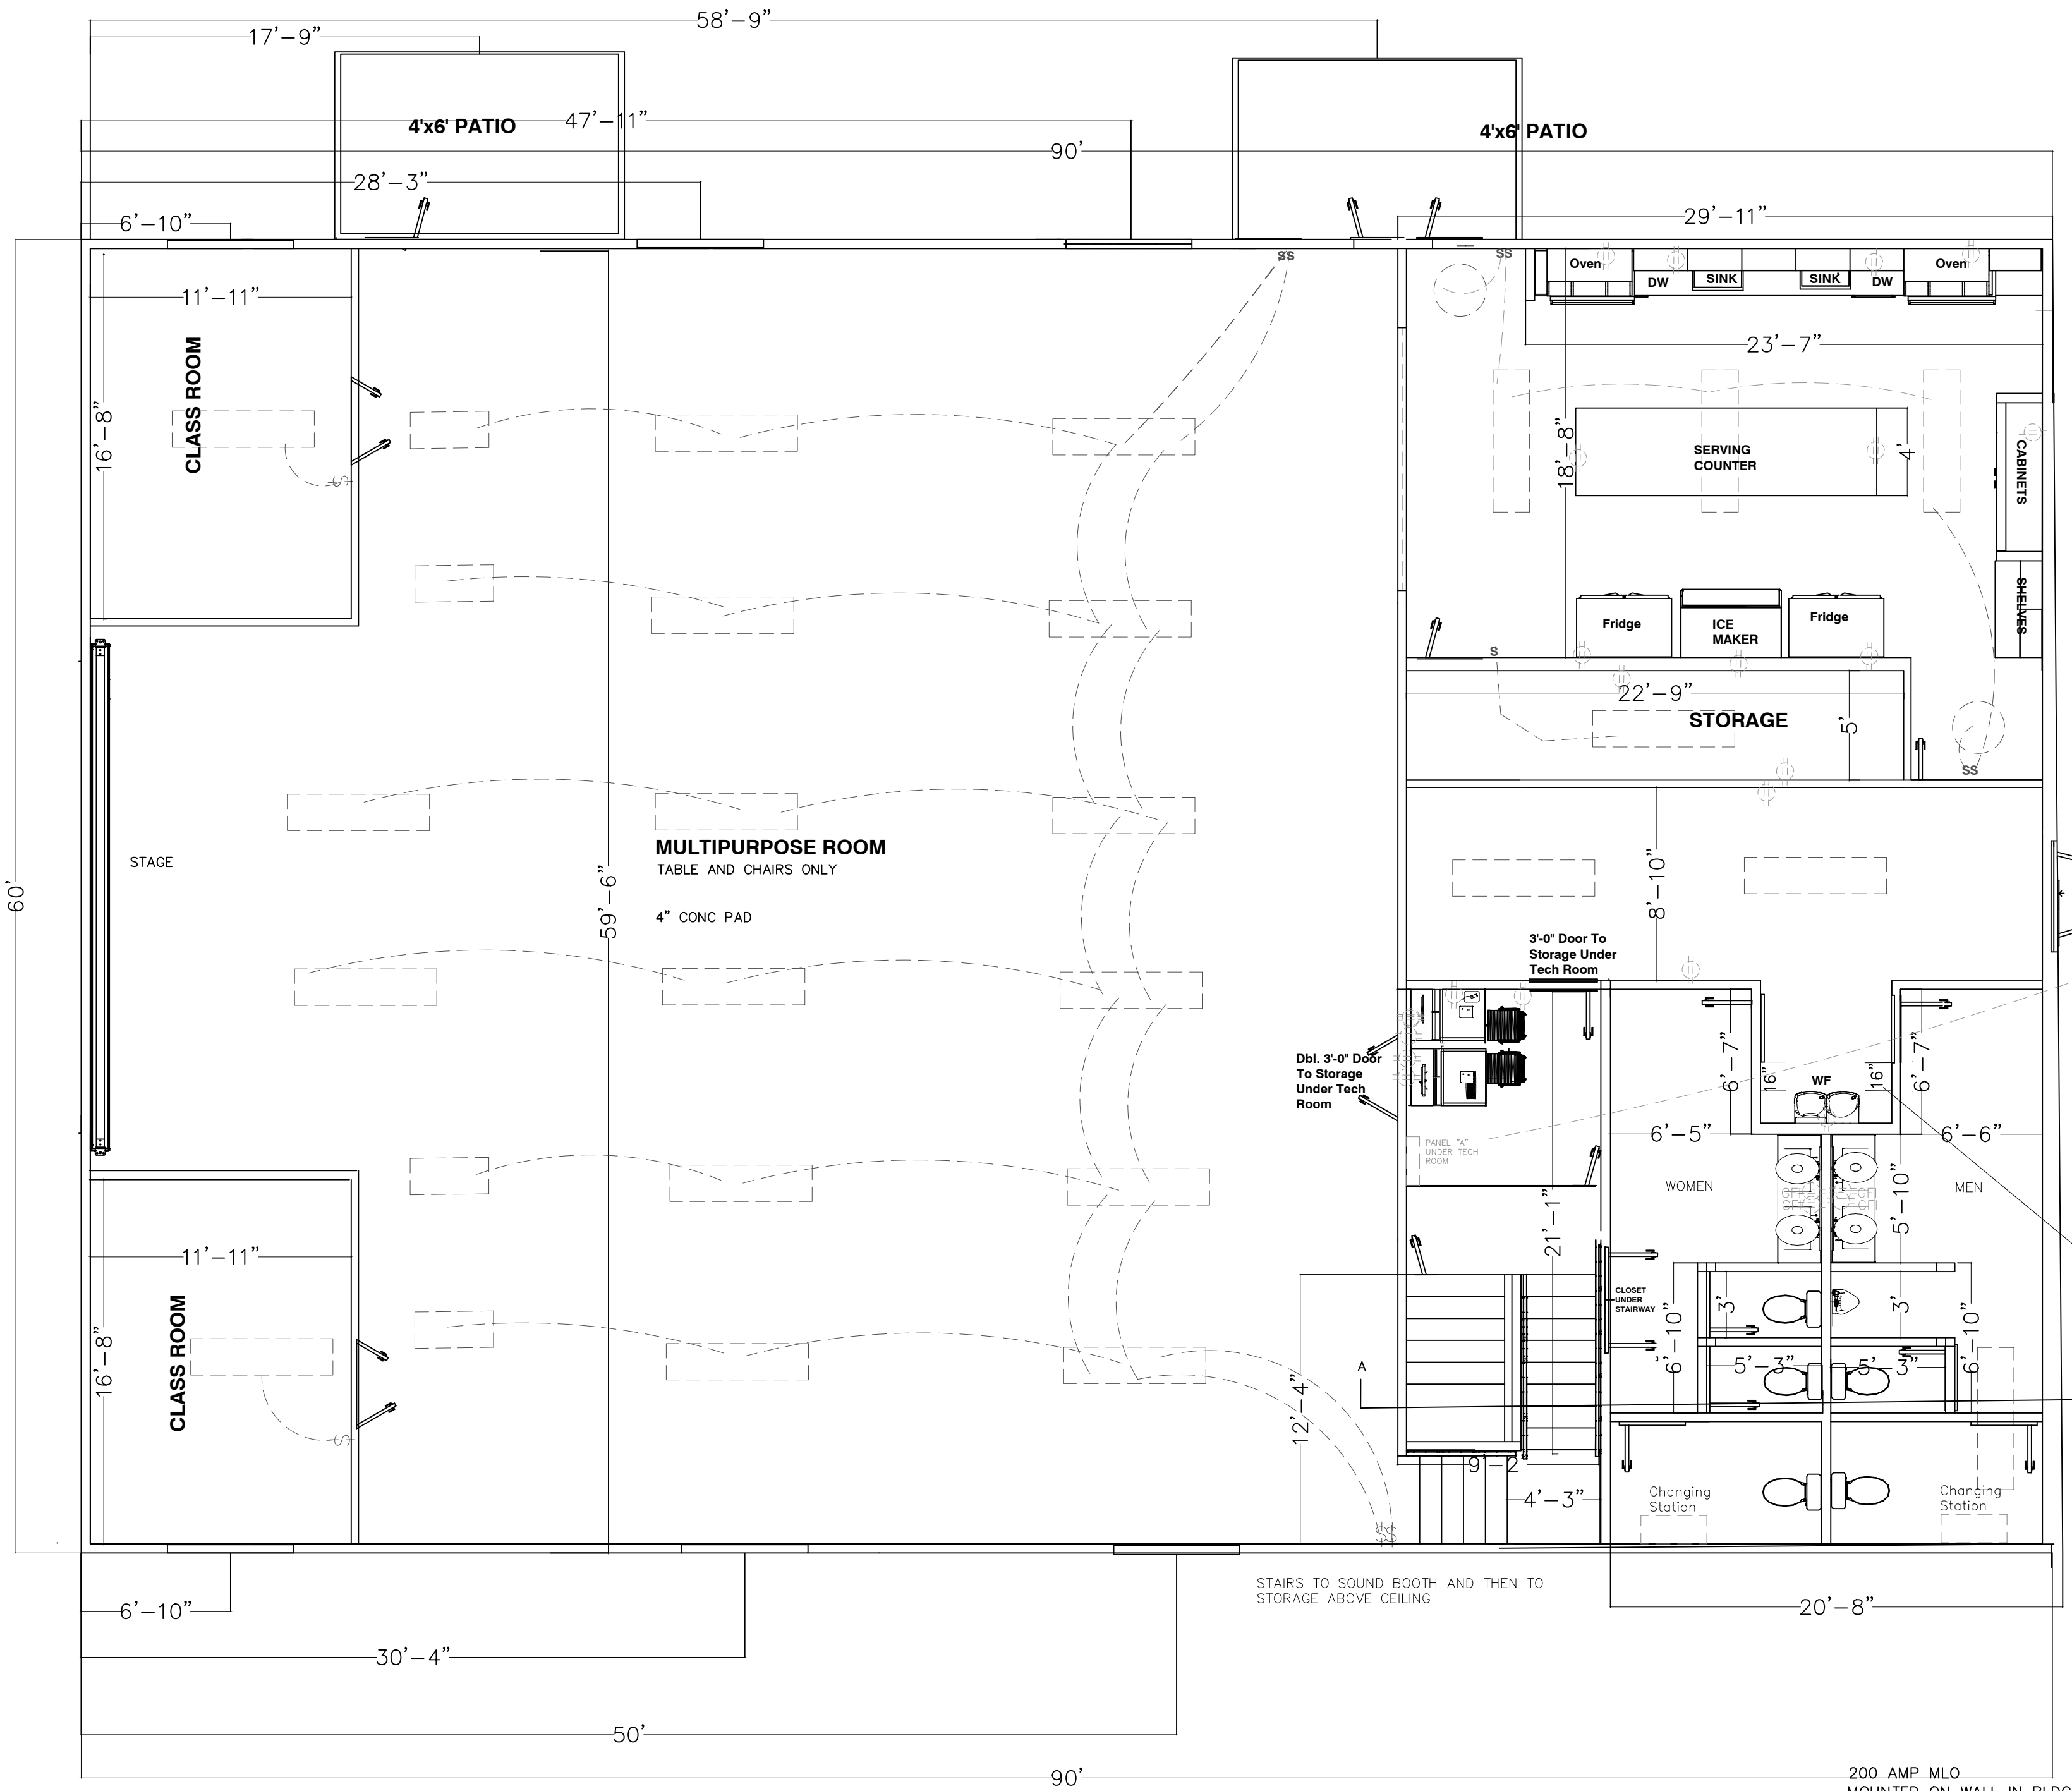

ELECTRICAL DIAGRAM

PANEL B

400 AMP SERVICE PANEL VOLTAGE 208/120V 3 PHASE : 4 WIRE																	
DEVICE			BRANCH CIRCUIT				BRANCH CIRCUIT				DEVICE						
SIZE	AMPS TRIP	POLES	DESCRIPTION	ØKT	PH A	PH B	PH C	PH A	PH B	PH C	ØKT	DESCRIPTION	POLES	AMPS TRIP	SIZE		
12	20	1	RECEPT	1							2	RECPT.	1	20	12		
12	20	1	RECEPT	3	11				11	4	4	RECPT.	1	20	12		
14	20	1	RECEPT	5		11				11	6	RECPT. BATH GFI	1	20	12		
12	20	1	RECEPT	7						11	8	RECEPT	1	40	10		
12	40	1	RANGE/OVEN	9		20					20	10	RANGE/OVEN	1	40	14	
10	40	2	HVAC	11	22						22	12		1	30	10	
10	30	1		13		11				22	14			1	30	10	
10	20	1	DW	15		11				22	16	DW		1	20	12	
14	20	1	LIGHTING	17			7	7			18	BATH FAN		1	20	14	
14	20	1	LIGHTING	19	7						7	20	LIGHTING		1	20	14
14	20	1	LIGHTING BATH	21		7				32	22	HVAC		2	40	10	
				23							32	24		2	40	10	
10	40	2	HVAC	25			32	22			26	WATER HTR.		1	30	12	
10	40	2		27	32						28						
				29							7	30					
14	20	1	SIGN	31	7				7	32	34	EXIT		1	20	14	
				33		16				21	36			1	20	10	
				35			16				21	36				10	
TOTAL				101 78 55 62 94 111													

LOAD CALCS.					LIGHTING LOAD CALCS.				
LOAD	CONN (KVA)	DEMAND FACTOR	DEMAND LOAD		AREA TYPE	MIN WATTS	SQ FT	REQUIRED	PROVIDED
LIGHTING	5	125% ***	6.25		BATH	3.5	64	224	240
RECEPT.	8.4	1ST 10 KV - 100% REM -50%	8.4		SANCTUARY	1.5	1400	2100	3000
HVAC	50	100%	50						
SIGN	1.2	125% ****	1.5						
		125%							
		125%							
		125%							
		125%							
		125%							
TOTAL 64.6				TOTAL 70.29					


ELECTRICAL

3" = 1'0"


200 AMP M.L.O. PANEL
120/208V 30

Project #:
Date:
Drawn/Design By:
Scale:

No.	Date	Remarks
1		
2		
3		
4		

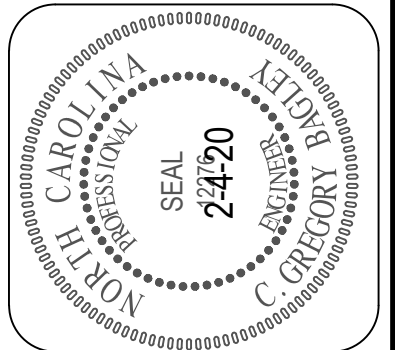

C. Gregory Bagley, Engineer
805 Cokesbury Road
Fuquay Varina, N.C. 27526
Office: (919)552-1600
Fax: (919) 552-6325

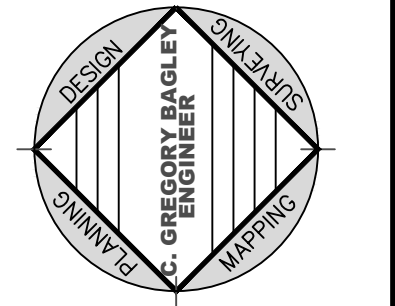

ELECTRICAL
PLAN

HARMONY
BAPTIST CHURCH
RODNEY GREGORY
Harnett County N.C.