


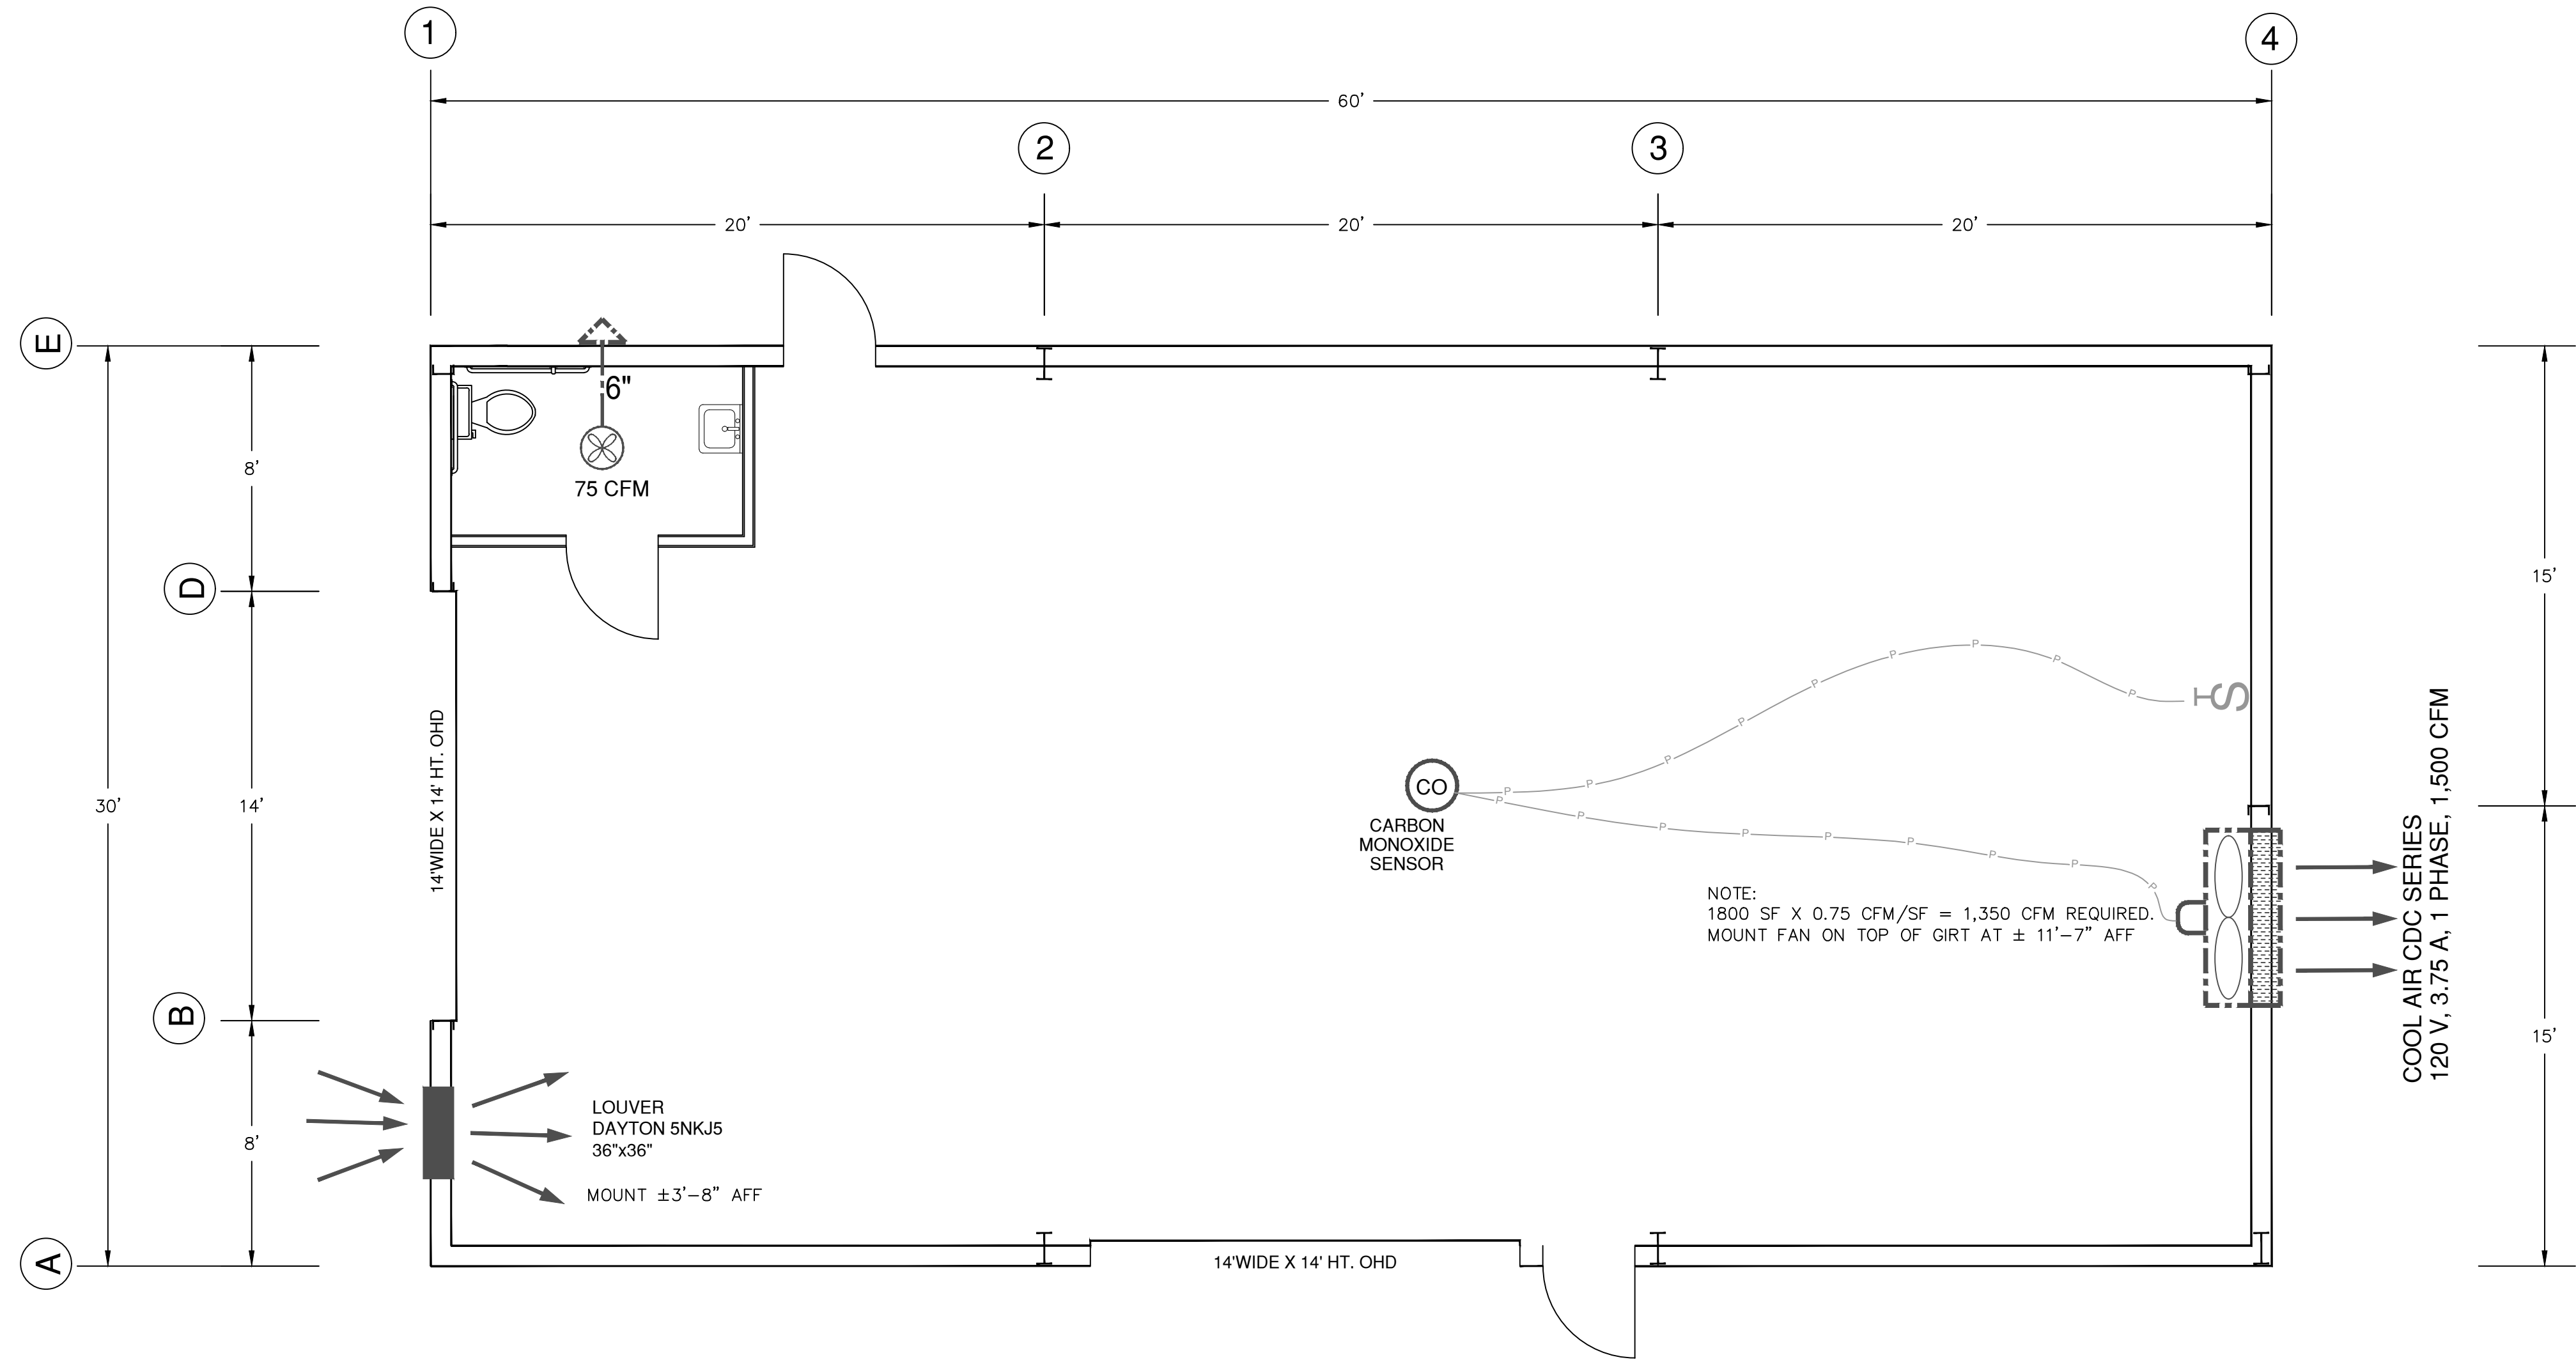

VENTILATION PLAN

(SCALE: 1/4" = 1'-0")

NO.	REVISION

SHEET


M-1

PAUL D WILLIAMS HAULING

2981 BUD HAWKINS ROAD, DUNN, NC

VENTILATION PLAN

DRAWING DATA			
DATE:	7/3/25	SCALE:	1/4" = 1'-0"
DRAWN BY:	RPA	DESIGNED BY:	RPA
CHECKED BY:	N/A	PLOT SCALE:	N/A
CAD FILE NO:	M-1		

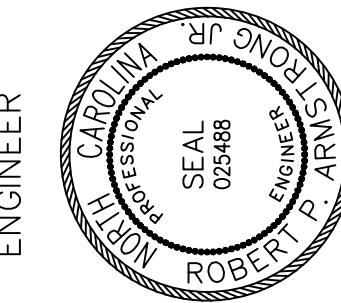

SUMMIT DESIGN GROUP, INC.

STRUCTURAL • CIVIL • MECHANICAL • ELECTRICAL

1720 PEARLIE COURT SW

OCEAN ISLE BEACH, NC 28469

910-876-0376

FIRM LICENSE: C-2585