


ELECTRICAL SYMBOLS	
	TYPICAL WALL RECEPTACLE
	110 V - 42" AFF
	HALF HOT AND HALF SWITCHED
	WATERPROOF RECEPTACLE
	110 V - GROUND FAULT
	220 V OUTLET
	110 V OUTLET - FLOOR MOUNT
	CEILING RECEPTACLE
	TOUCH - PAD
	TYPICAL SWITCH
	3 WAY OR MORE (SEE PLAN)
	DIMMER SWITCH
	LIGHT - WALL MOUNT
	LIGHT - CEILING MOUNT
	RECESSED LIGHT
	EXHAUST FAN
	LIGHT - FAN COMBINATION
	PENDANT LIGHTING
	FLOURESCENT TUBE
	FLOURESCENT LIGHT FIXTURE
	CLG. FAN
	PHONE JACK
	TV CABLE JACK

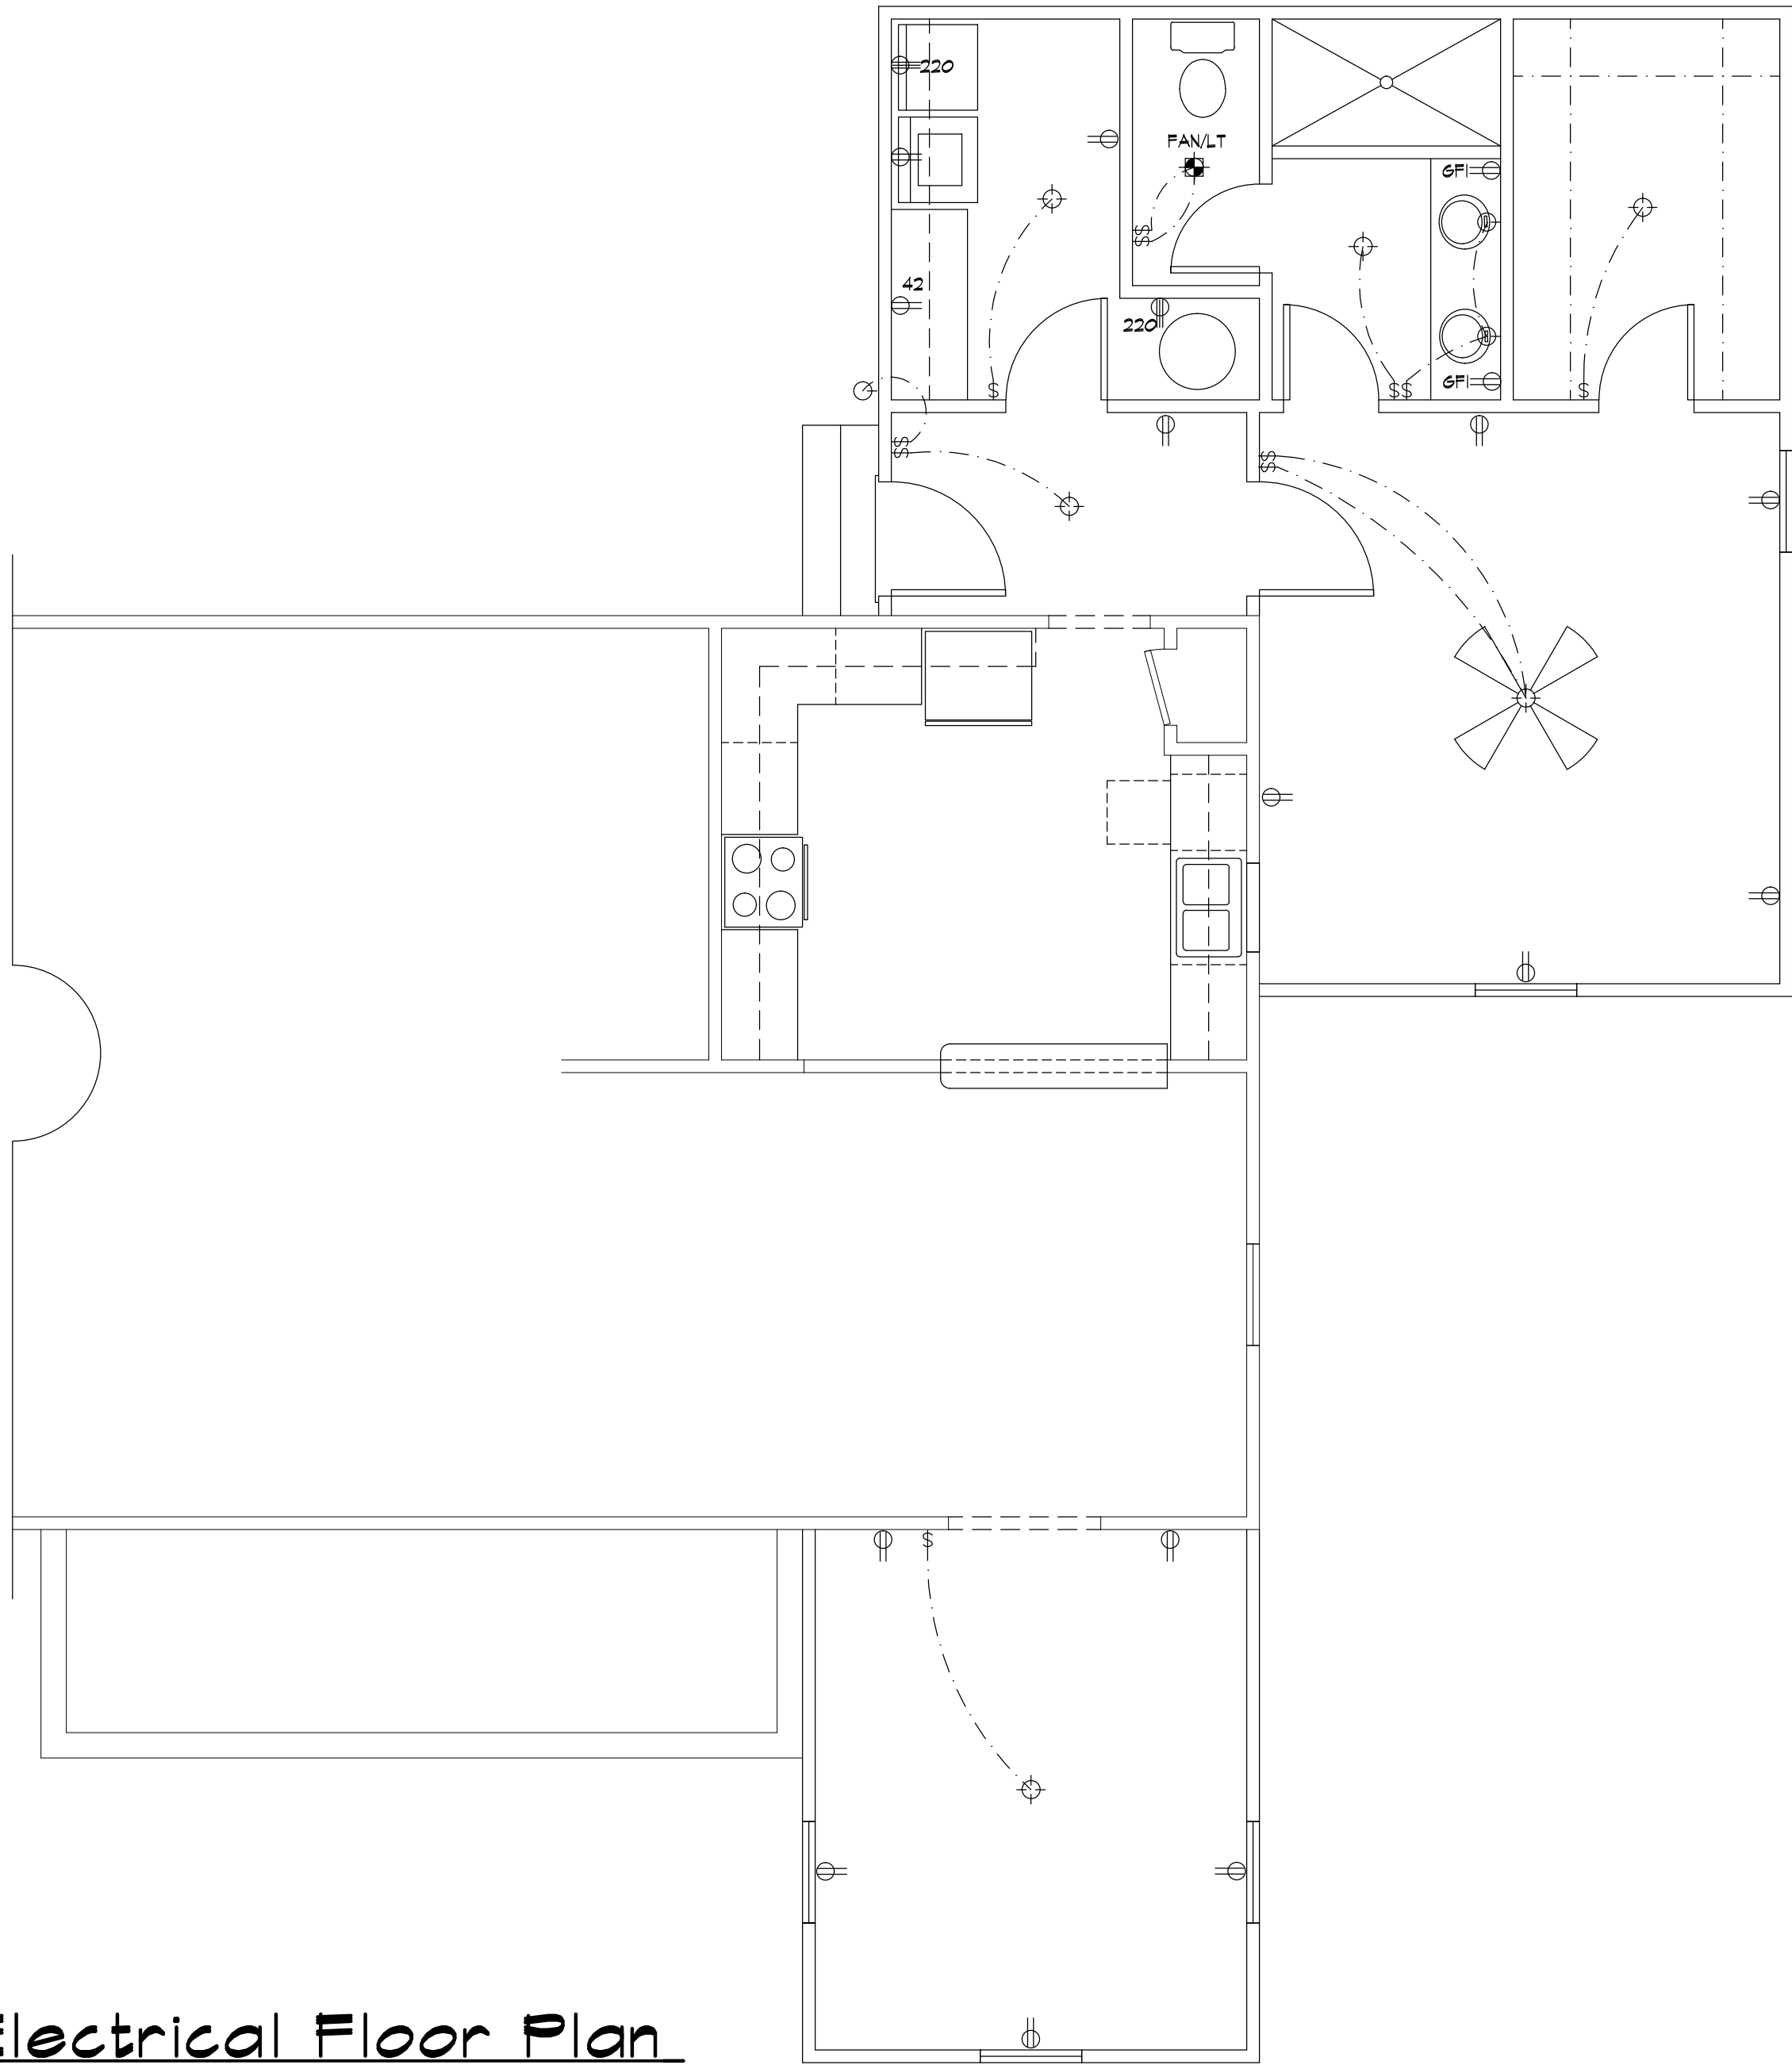

401 Electrical Floor Plan

Scale 1/4" = 1'-0"

An Addition to the
Ellis Residence
 823 Byrd's Pond Road, Erwin NC 28339
 Sheet Title
Electrical Floor Plan

Revisions

Scale:
 AS SHOWN
 Date:
 January 2020

Sheet No.
4

John E. Carroll
 Residential Design
 844 montclair road, fayetteville, nc 28314
 johncarroll.design@gmail.com
 910.850.9408