




**ROOF PLAN**  
SCALE: 1/8" = 1'-0"

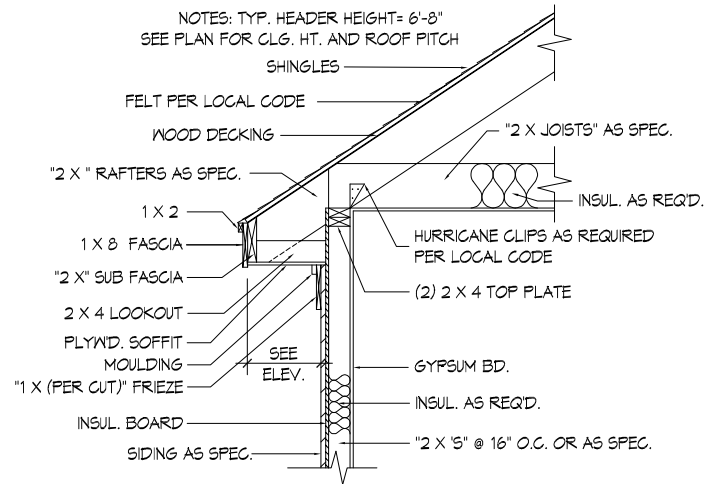


**TYPICAL CORNICE DETAIL W/ SIDING**  
NO SCALE

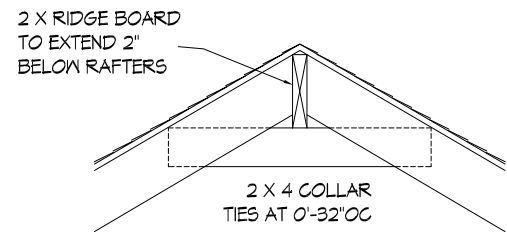


**TYPICAL RIDGE BOARD / BRACING**  
NO SCALE

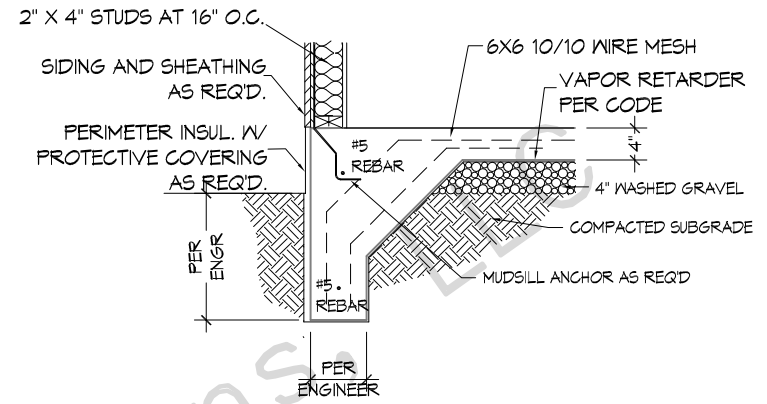

**SLAB W/ WOOD SIDING**  
NOT TO SCALE

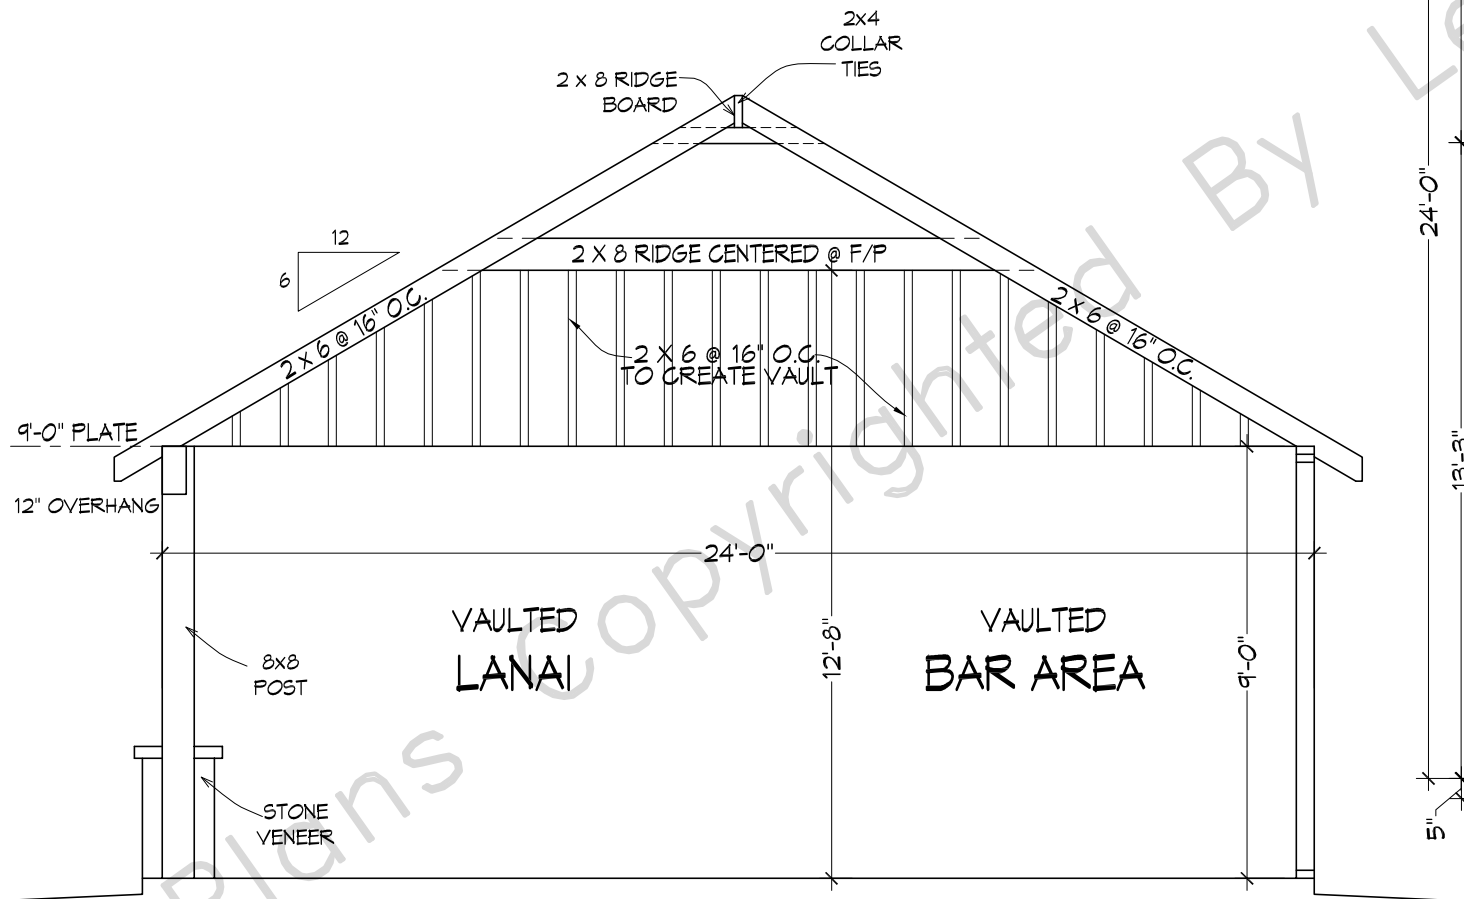

**MAIN BODY SECTION**  
SCALE: 1/4" = 1'-0"

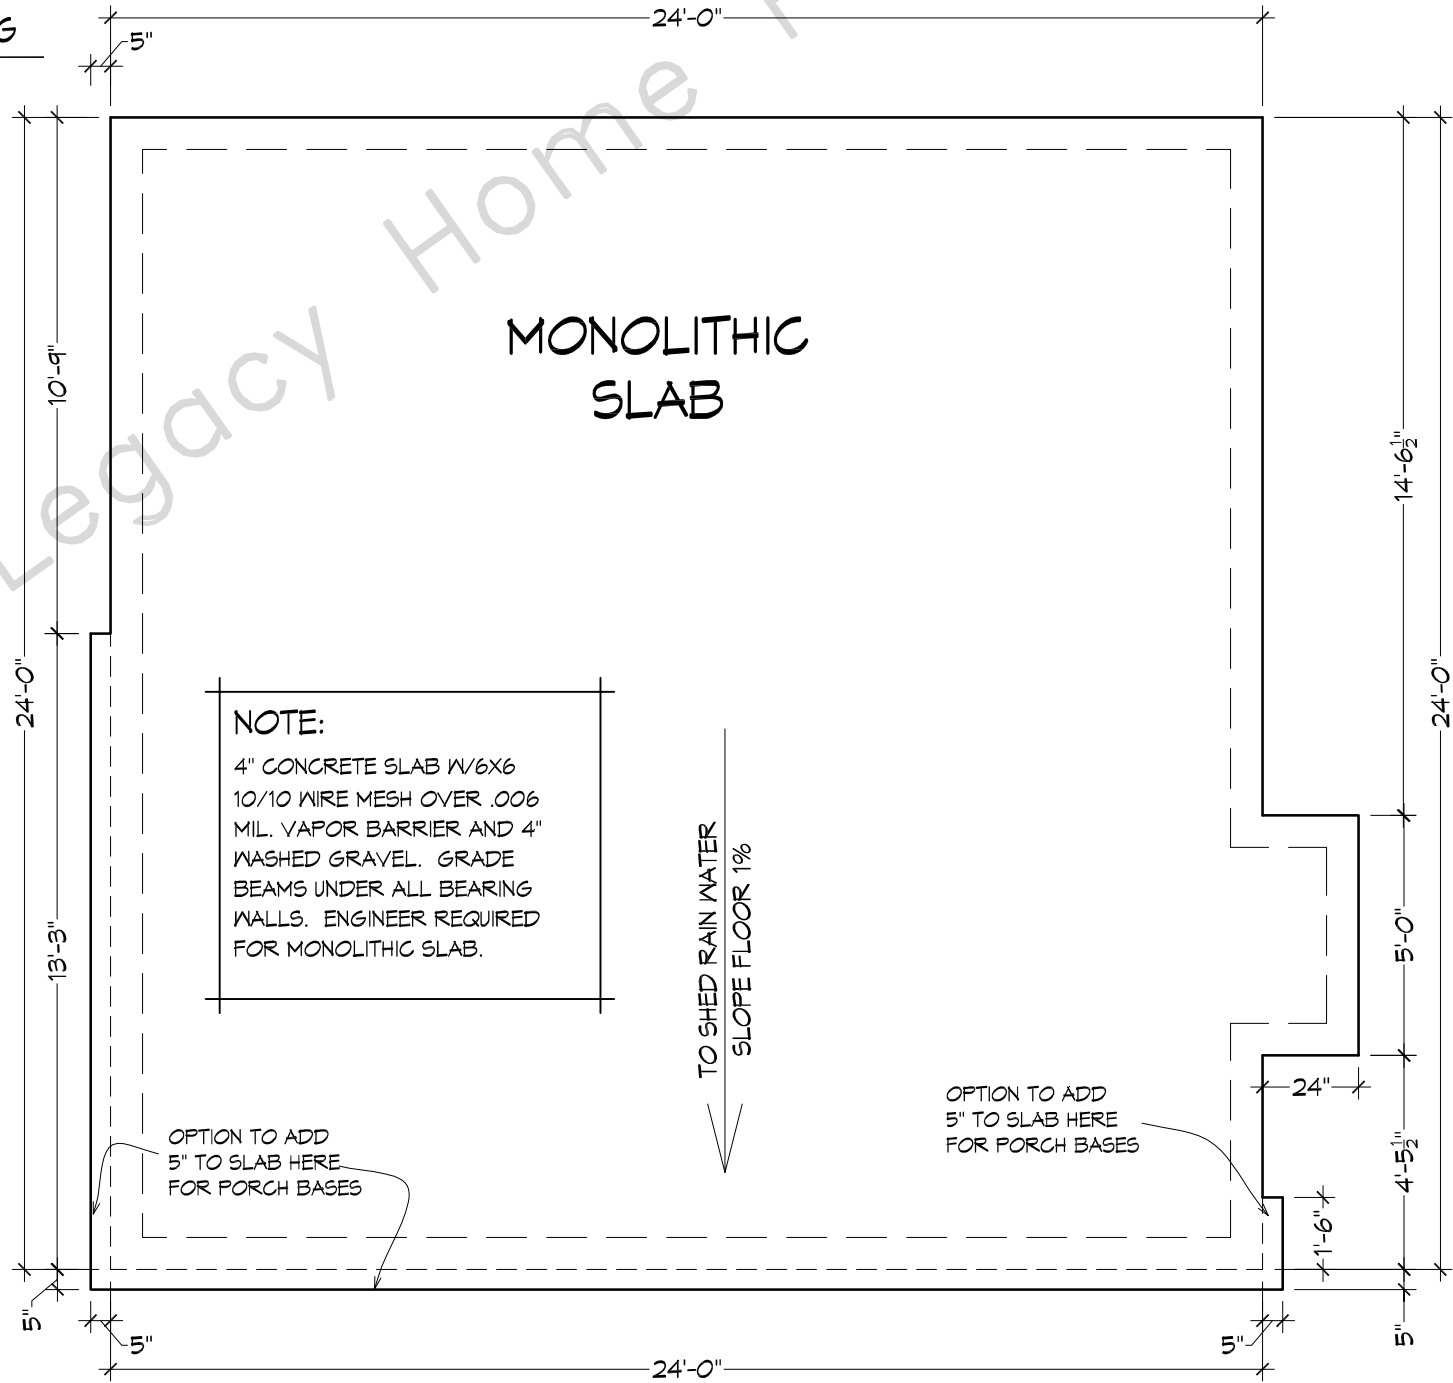


**FOUNDATION PLAN**  
SCALE: 1/4" = 1'-0"

FILE	DATE	SCALE	DRAWN BY	PLAN #	SHEET #
	9-21-18	As Shown	MIGUEL P. / STEVE V.		1
<b>0586-PH A Poolhouse</b>					

© Copyright by Legacy Home Plans LLC  
REPRODUCTION OF ANY PART OF THESE PLANS FOR ANY PURPOSE IS STRICTLY PROHIBITED. THESE PLANS ARE THE PROPERTY OF LEGACY HOME PLANS LLC. NO PART OF THESE PLANS MAY BE REPRODUCED OR TRANSMITTED IN ANY FORM OR BY ANY MEANS, ELECTRONIC OR MECHANICAL, INCLUDING PHOTOCOPYING, RECORDING, OR BY ANY INFORMATION STORAGE AND RETRIEVAL SYSTEM, WITHOUT THE WRITTEN PERMISSION OF LEGACY HOME PLANS LLC. THESE PLANS HAVE BEEN PREPARED TO MEET THE MINIMUM REQUIREMENTS AND ARE NOT TO BE USED FOR ANY OTHER PROJECTS WITHOUT THE WRITTEN PERMISSION OF LEGACY HOME PLANS LLC. BEFORE STARTING CONSTRUCTION, THE BUILDER MUST CONSULT WITH THE LOCAL BUILDING DEPARTMENT, ENGINEERS, AND OTHERS WHOSE SERVICES ARE REQUIRED FOR ALL CONSTRUCTION. AN ENGINEER IS REQUIRED FOR ALL CONSTRUCTION. TOTAL EXCEEDS THE COST OF ORIGINAL PLANS.


**Legacy HOME PLANS**  
PLANS YOU CAN BUILD YOUR LEGACY ON  
5600 SUMMER AVENUE MEMPHIS, TENNESSEE (901)754-8874

MEMBER  
**AIBD**  
AMERICAN INSTITUTE OF BUILDING DESIGN

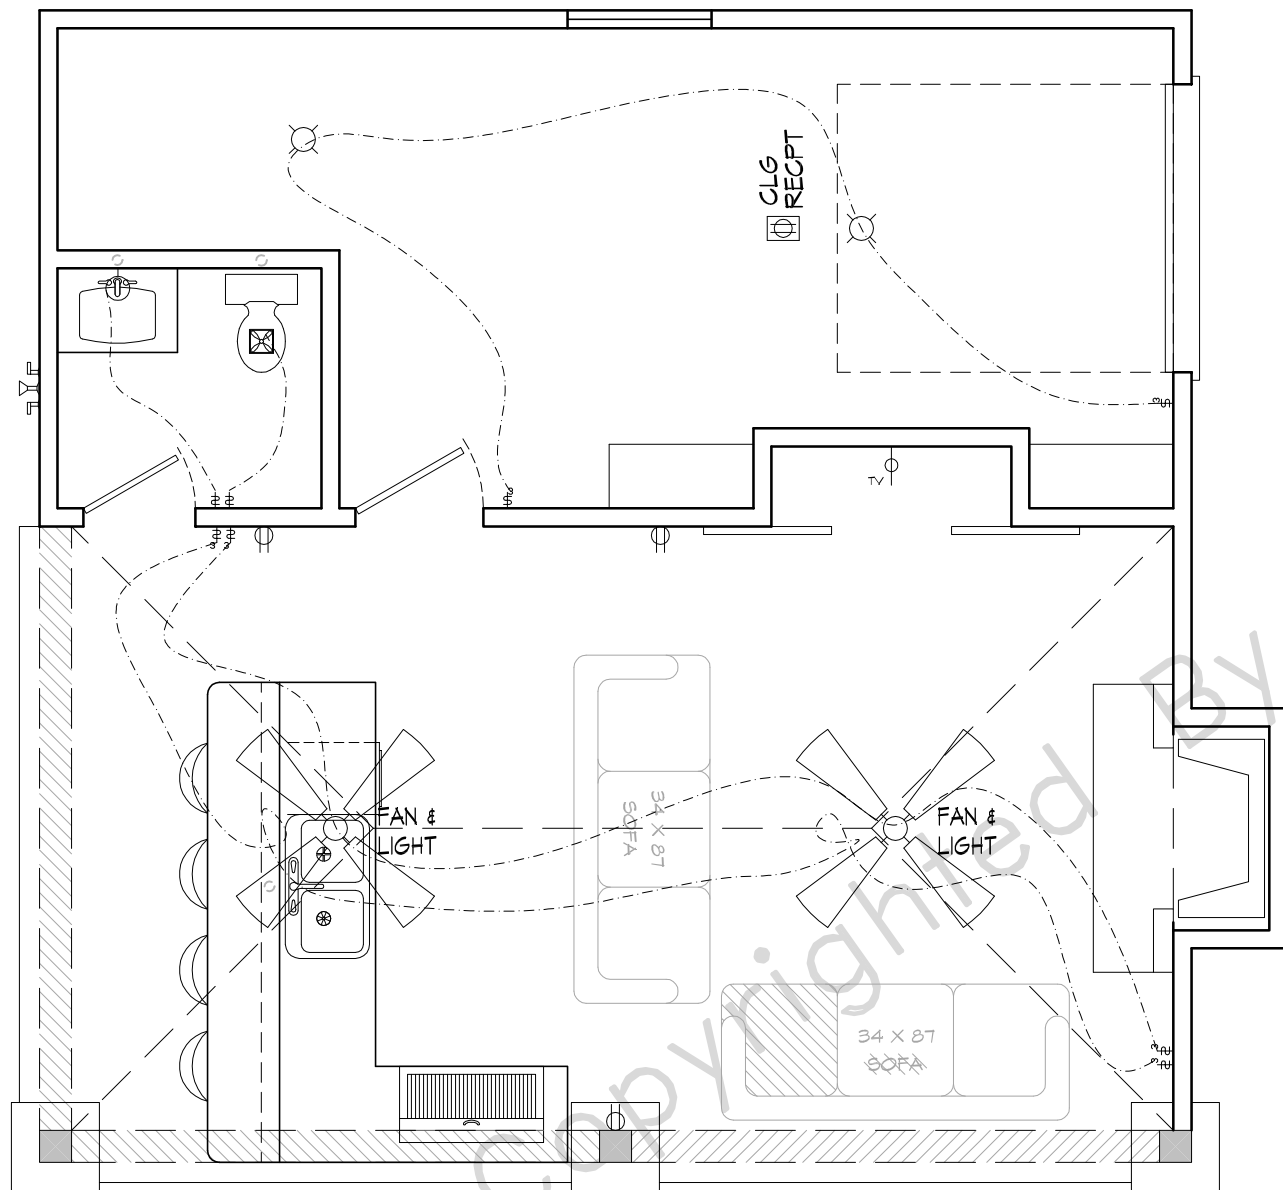

**ELECTRICAL PLAN**

SCALE: 1/4" = 1'-0"

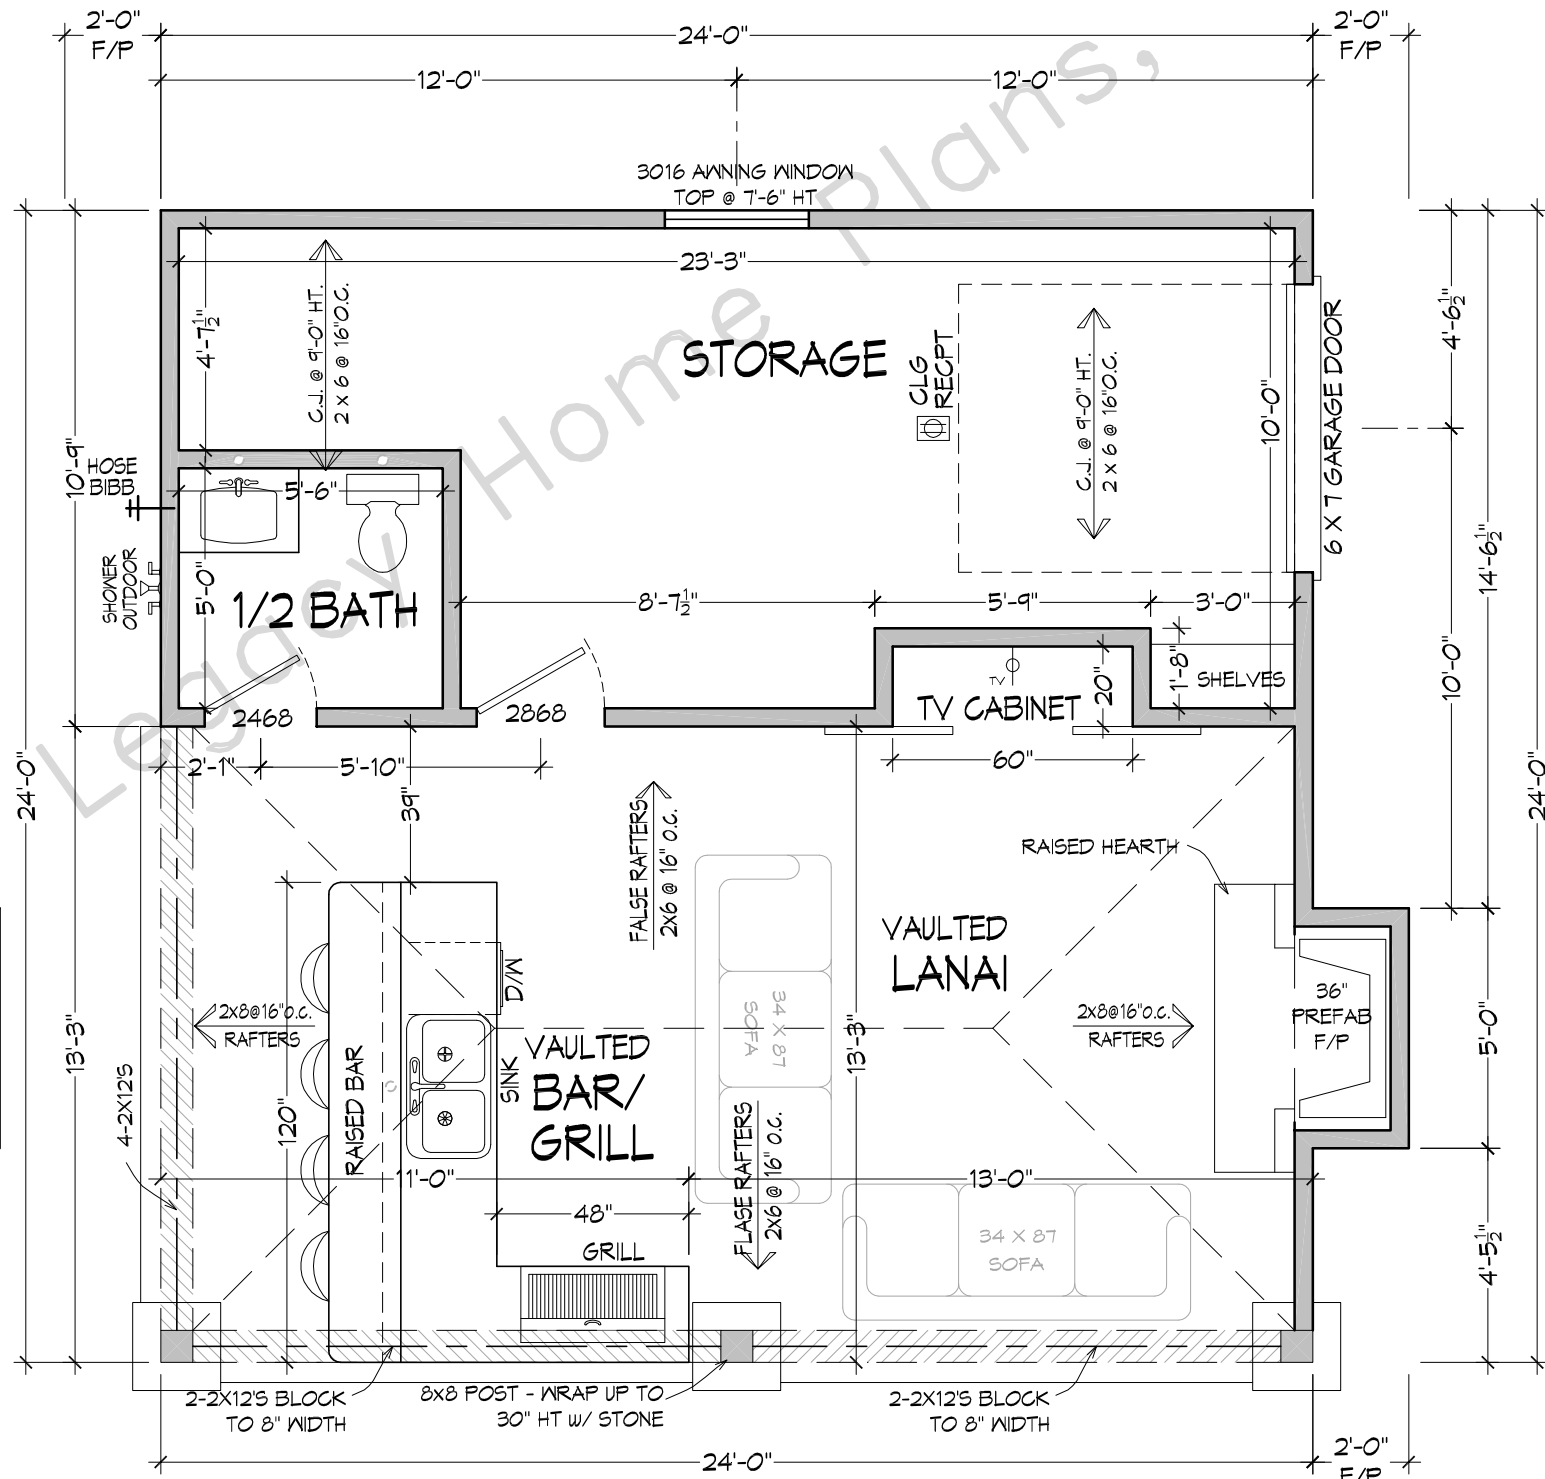

**FLOOR PLAN**

SCALE: 1/4" = 1'-0"


SQUARE FOOTAGE  
 347 OPEN COVERED AREA  
 36 BATH  
 203 STORAGE  
 586 TOTAL UNHEATED

FILE	DATE	SCALE	DATE
	9-21-18	As Shown	9-21-18
PLAN	DRAWN BY	PLAN	DATE
0586-PH A Poolhouse	MIGUEL P./ STEVE V.		
PLAN NO.		SHEET #	2


© Copyright by Legacy Home Plans LLC  
 REPRODUCTION OF ANY PART OF THESE PLANS FOR ANY PURPOSE IS STRICTLY PROHIBITED. THESE PLANS ARE THE PROPERTY OF LEGACY HOME PLANS LLC AND ARE TO BE USED ONLY FOR THE PROJECT AND SITE SPECIFICALLY IDENTIFIED IN THESE PLANS. ANY OTHER USE WITHOUT THE WRITTEN PERMISSION OF LEGACY HOME PLANS LLC IS PROHIBITED. THESE PLANS HAVE BEEN PREPARED BY A LICENSED ARCHITECT AND MEET ALL APPLICABLE LOCAL, STATE AND FEDERAL REQUIREMENTS. HOWEVER, THE USER MUST VERIFY ALL LOCAL, STATE AND FEDERAL REQUIREMENTS BEFORE STARTING CONSTRUCTION. THE USER MUST CONSULT WITH ALL APPLICABLE AGENCIES, ENGINEERS, AND OTHERS WHOSE SERVICES ARE REQUIRED FOR ALL CONSTRUCTION. AN ENGINEER IS REQUIRED FOR ALL CONSTRUCTION. TOTAL EXCEEDS THE COST OF ORIGINAL PLANS.

**Legacy HOME PLANS**  
 PLANS YOU CAN BUILD YOUR LEGACY ON  
 5600 SUMMER AVENUE MEMPHIS, TENNESSEE (901)754-8874

MEMBER  
**AIBD**  
 AMERICAN INSTITUTE OF BUILDING DESIGN

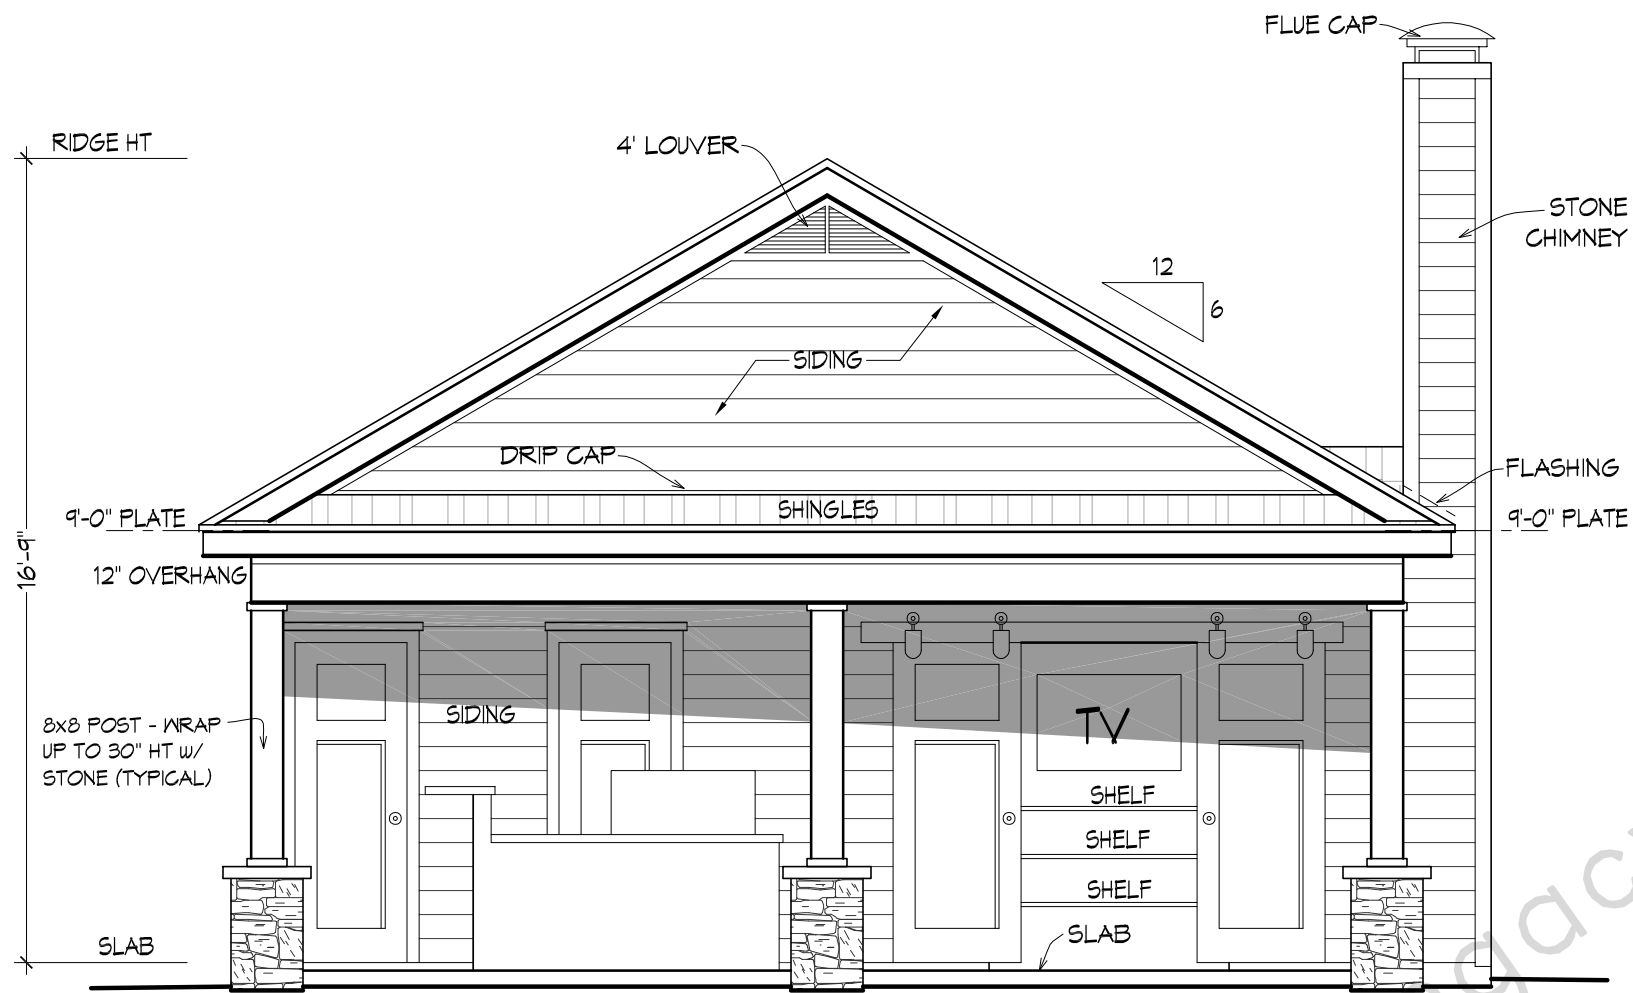

SCALE: 1/4" = 1'-0" FRONT ELEVATION

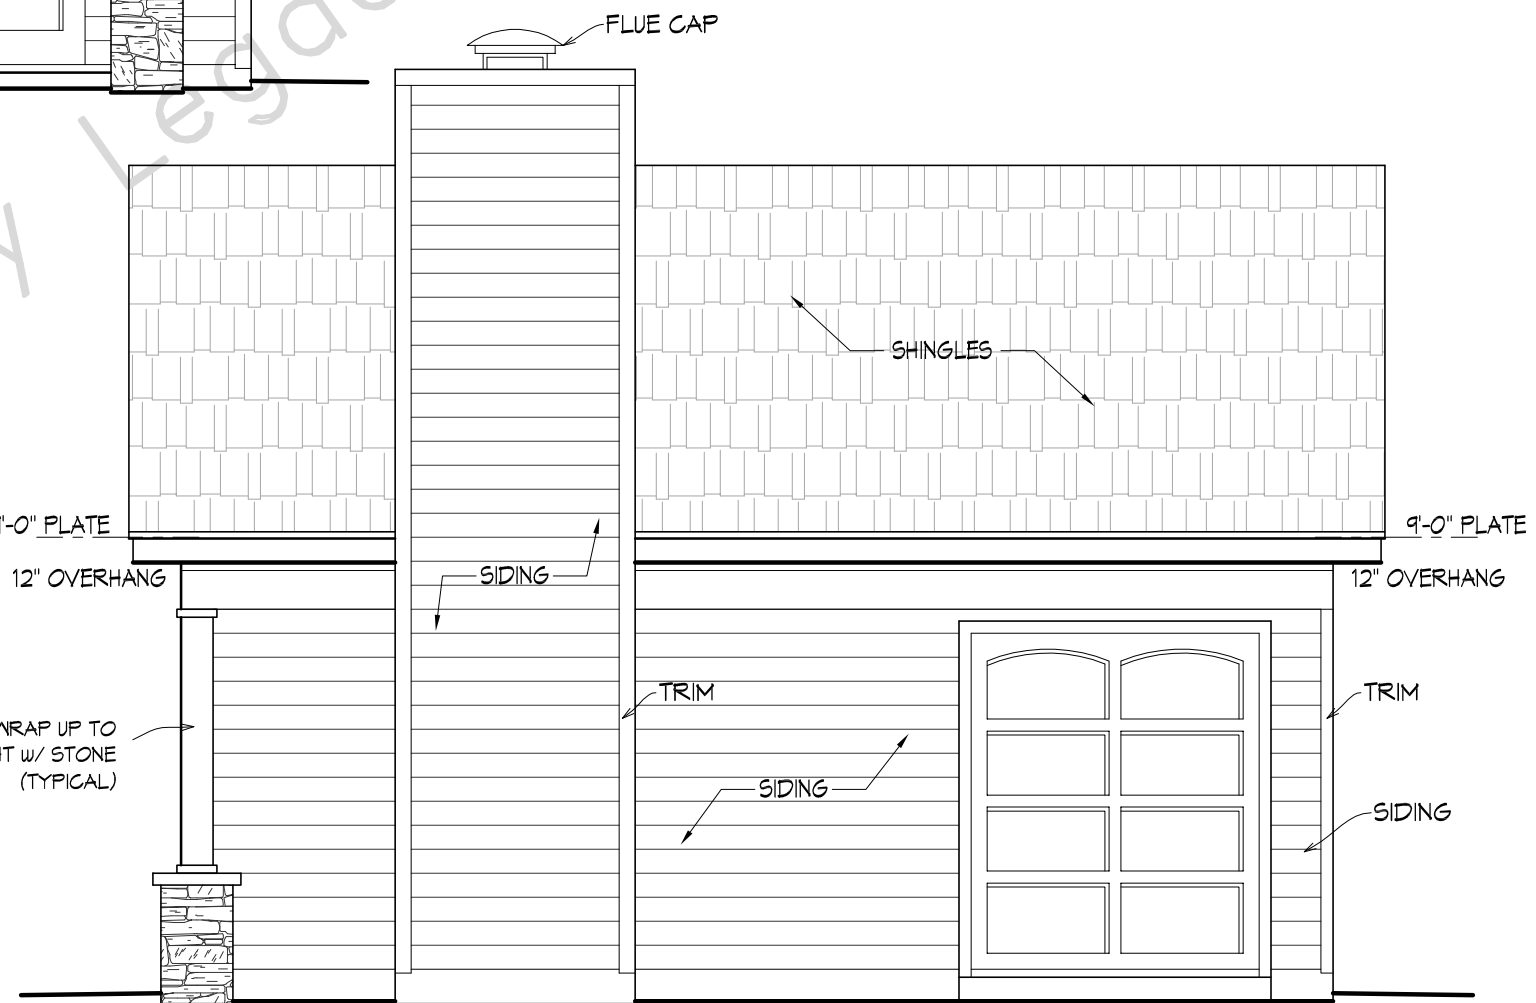

SCALE: 1/4" = 1'-0" RIGHT SIDE ELEVATION


FILE	DATE	SHEET #
0586-PH A Poolhouse	9-21-18	3
SCALE	DRAWN BY	
As Shown	MIGUEL P. / STEVE V.	
PLAN		
TABLE		

© Copyright by Legacy Home Plans LLC  
 REPRODUCTION OF ANY PORTION OF THESE DRAWINGS FOR ANY PURPOSE IS STRICTLY PROHIBITED. THESE DRAWINGS ARE TO BE USED ONLY FOR THE PROJECT AND SITE SPECIFICALLY IDENTIFIED ON THE DRAWING. ANY OTHER USE WITHOUT THE WRITTEN PERMISSION OF LEGACY HOME PLANS IS PROHIBITED. THESE DRAWINGS HAVE BEEN PREPARED TO MEET THE MINIMUM REQUIREMENTS AND ARE NOT TO BE USED FOR ANY OTHER PROJECTS OR FOR ANY OTHER PURPOSES. LEGACY HOME PLANS DOES NOT WARRANT OR GUARANTEE THE ACCURACY OF THESE DRAWINGS. THE USER MUST VERIFY ALL DIMENSIONS AND CONDITIONS BEFORE STARTING CONSTRUCTION. AN ENGINEER IS REQUIRED FOR ALL CONSTRUCTION. TOTAL EXCEED THE COST OF ORIGINAL PLANS.


**Legacy HOME PLANS**  
 PLANS YOU CAN BUILD YOUR LEGACY ON  
 5600 SUMMER AVENUE MEMPHIS, TENNESSEE (901)754-8874

MEMBER  
**AIBD**  
 AMERICAN INSTITUTE OF BUILDING DESIGN

Plans Copyrighted By Legacy Home Plans, LLC

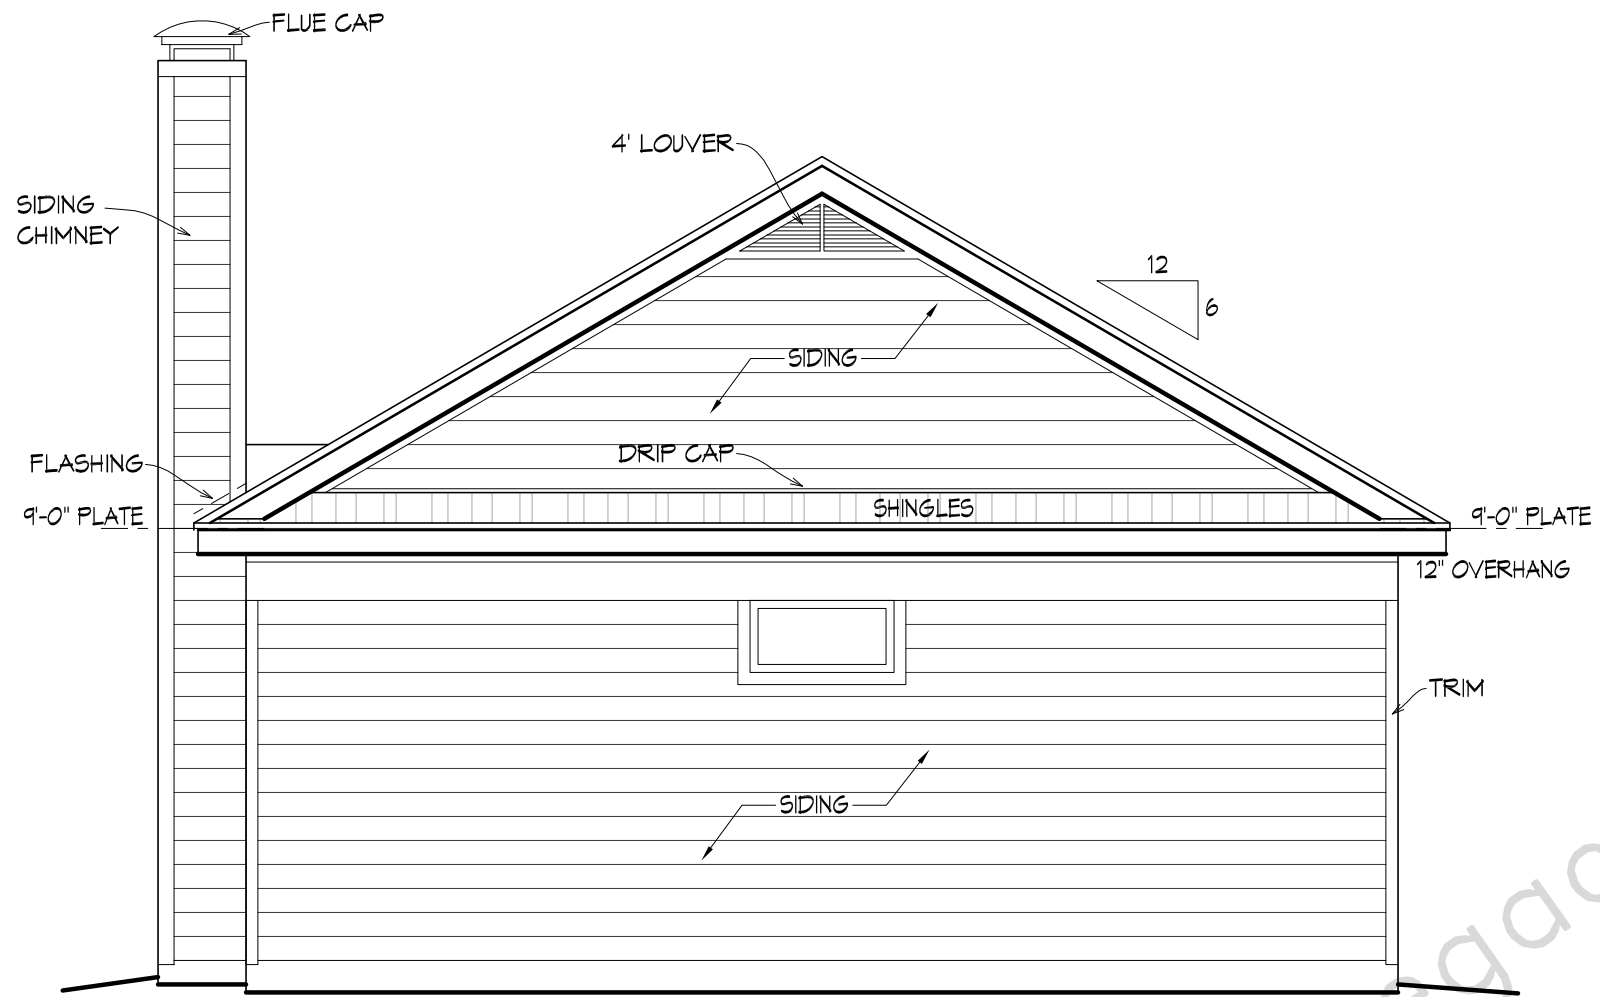

SCALE: 1/4" = 1'-0" REAR ELEVATION

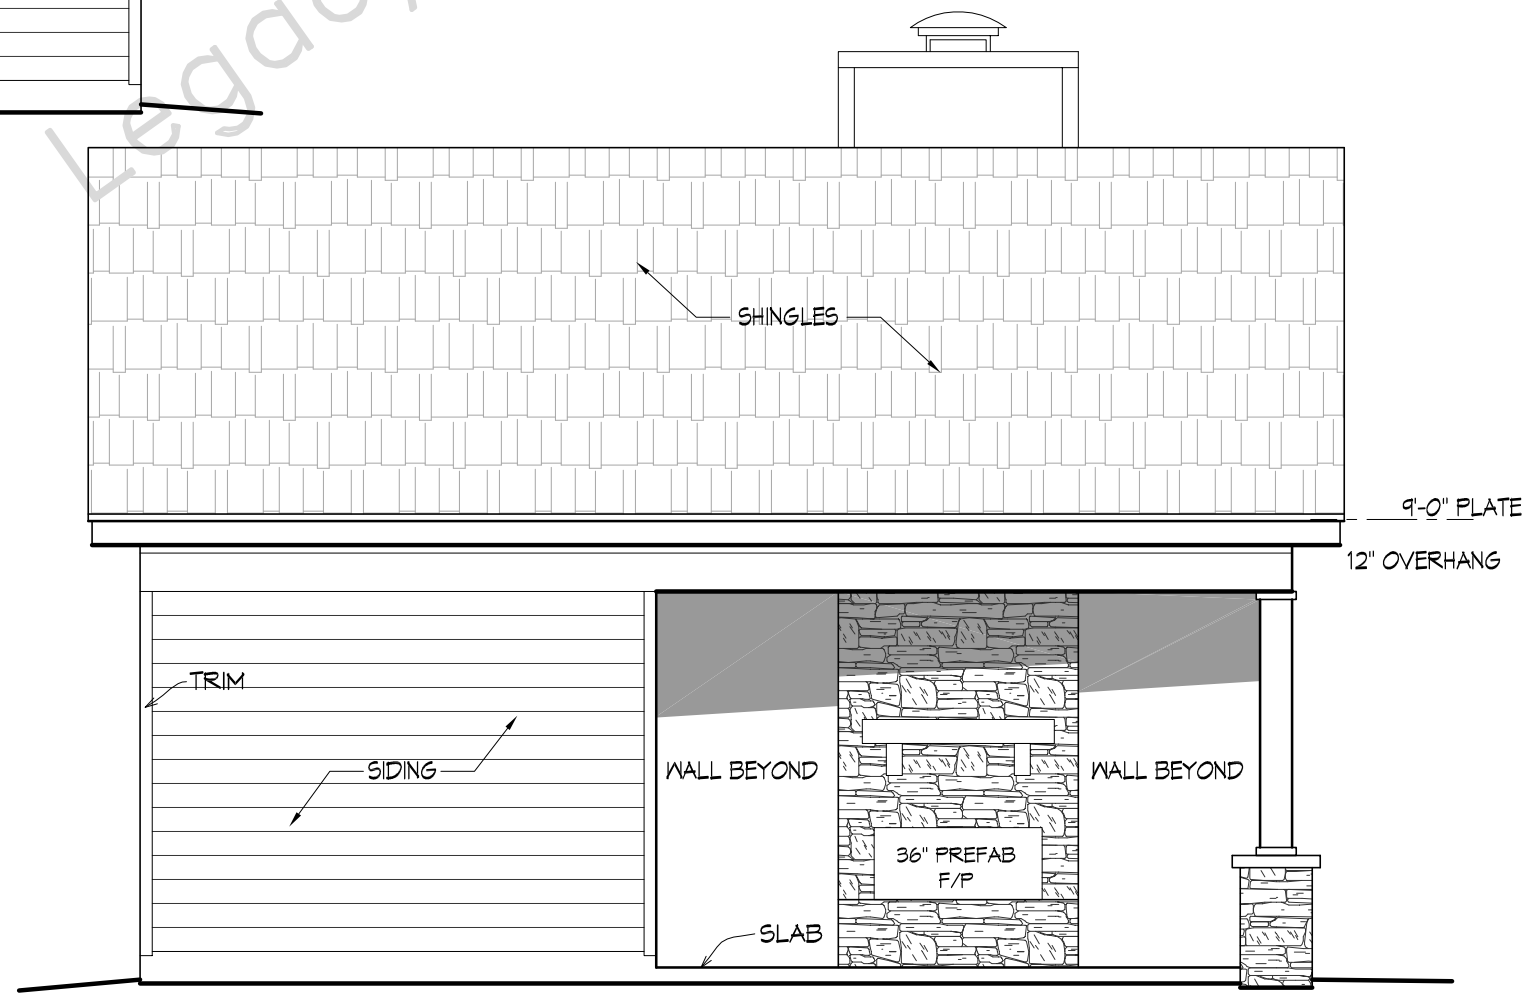

SCALE: 1/4" = 1'-0" LEFT SIDE ELEVATION

FILE	DATE	SCALE	DRAWN BY	SHEET #
	9-21-18	As Shown	MIGUEL P. / STEVE V.	4
PLAN	0586-PH A Poolhouse			
FILE				

© Copyright by Legacy Home Plans LLC  
 REPRODUCTION OF ANY PART OF THESE PLANS FOR ANY PURPOSE IS STRICTLY PROHIBITED. THESE PLANS ARE THE PROPERTY OF LEGACY HOME PLANS, LLC. NO PART OF THESE PLANS MAY BE REPRODUCED OR TRANSMITTED IN ANY FORM OR BY ANY MEANS, ELECTRONIC OR MECHANICAL, INCLUDING PHOTOCOPYING, RECORDING, OR BY ANY INFORMATION STORAGE AND RETRIEVAL SYSTEM, WITHOUT THE WRITTEN PERMISSION OF LEGACY HOME PLANS, LLC. THESE PLANS HAVE BEEN PREPARED BY A LICENSED ARCHITECT AND MEET ALL APPLICABLE LOCAL, STATE AND FEDERAL REQUIREMENTS. THE BUILDER MUST OBTAIN ALL NECESSARY PERMITS AND INSURE THAT THESE PLANS MEET ALL APPLICABLE REQUIREMENTS. AN ENGINEER IS REQUIRED FOR ALL CONSTRUCTION. TOTAL EXCEED THE COST OF ORIGINAL PLANS.

**Legacy HOME PLANS**  
 PLANS YOU CAN BUILD YOUR LEGACY ON  
 5600 SUMMER AVENUE MEMPHIS, TENNESSEE (901)754-9874

MEMBER  
**AIBD**  
 AMERICAN INSTITUTE OF BUILDING DESIGN