



NOTES:
 1. ALL FINAL MATERIALS ARE TO BE CHOSEN BY THE CONTRACTOR.
 2. FINAL NUMBER OF EXTERIOR STEPS WILL BE DETERMINED ON SITE BY GRADE.
 3. CONTRACTOR MUST MEET OR EXCEED ALL APPLICABLE LOCAL AND STATE REQUIREMENTS.
 4. DESIGNER ASSUMES NO RESPONSIBILITY FOR CHANGES TO DRAWINGS BY OTHERS DURING CONSTRUCTION.
 5. ALL STRUCTURAL INFO SHOWN ON PLANS ARE FOR INFORMATION ONLY. CONTRACTOR SHALL OBTAIN ALL NECESSARY PERMITS AND REVIEW AND DESIGN ALL STRUCTURAL ELEMENTS.

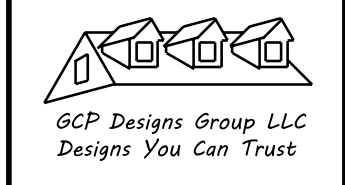

DATE: 12-11-2023
 SUBDIVISION:
 BUILDER:

**RESIDENCE OF
MR. HARGROVE J**

NOTE:
 BUILDING CONTRACTOR TO MEET LOCAL WIND LOADS PER LOCAL CODE AS IT PERTAINS TO LOCATION OF HOUSE
 ICC, IBC, IRC, IFC, IFBC, IFPC

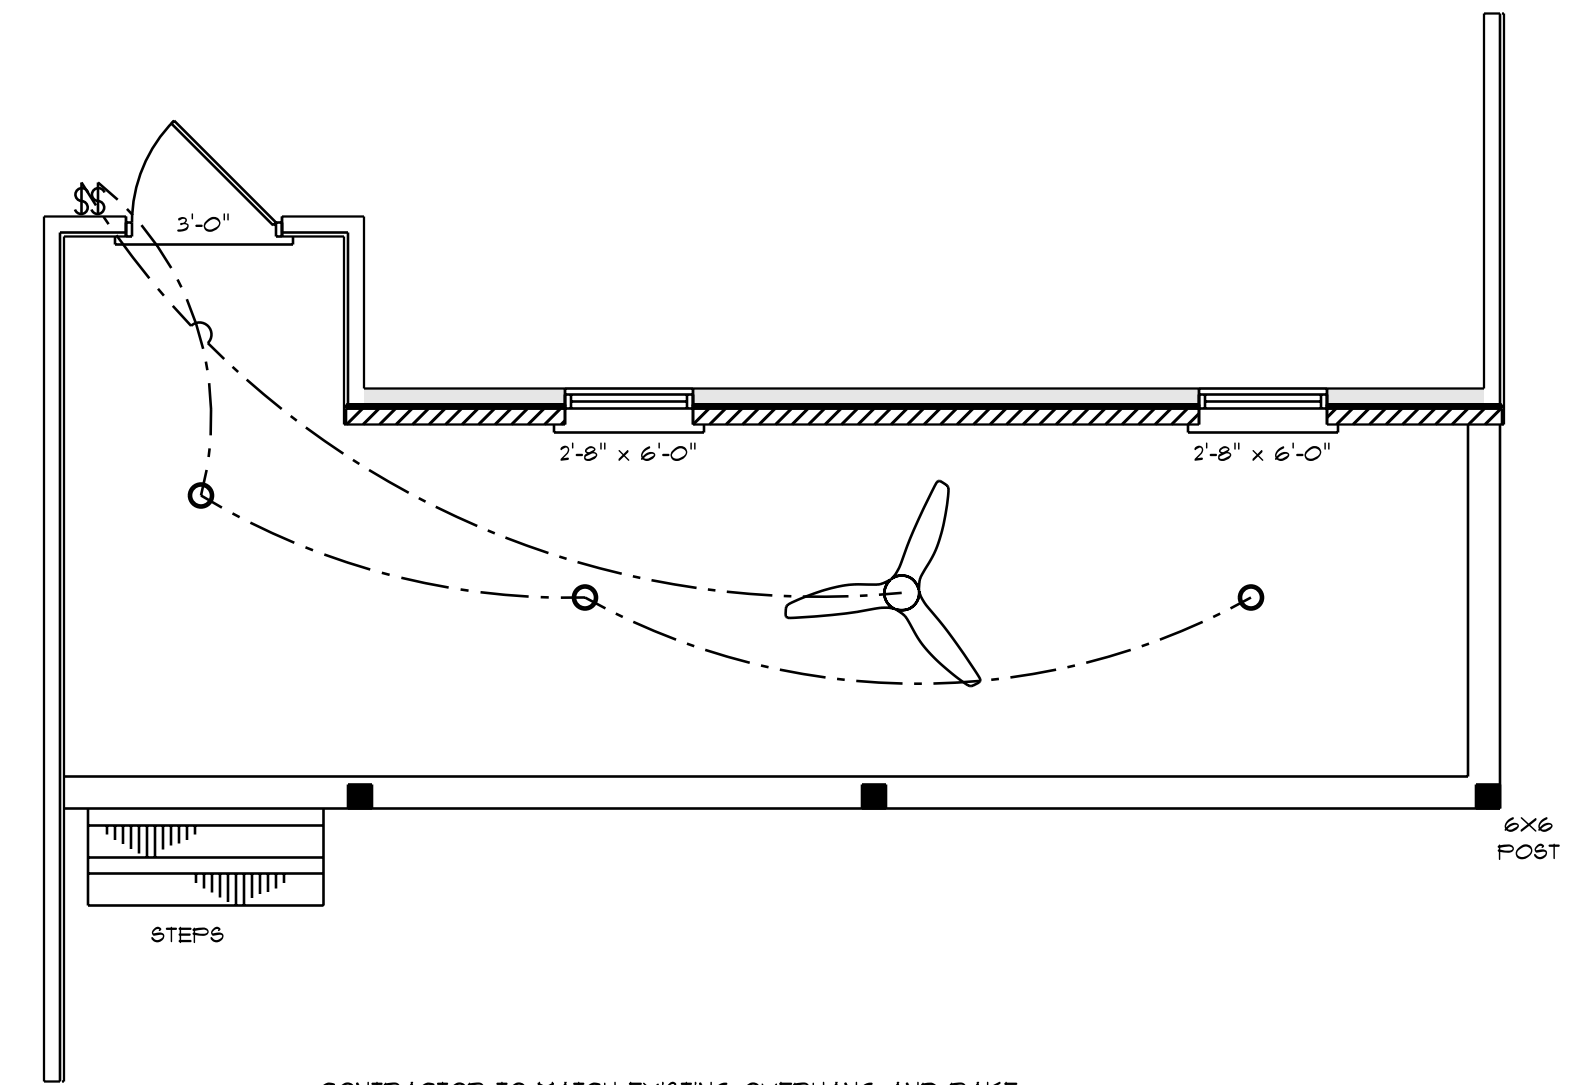

ELECTRICAL LEGEND		
ELECTRICAL	COUNT	SYMBOL
ceiling fan - haliku	1	
can light 6inch	3	
switch	2	

CONTRACTOR TO MATCH EXISTING OVERHANG AND RAKE
 CONFIRM ALL MEASUREMENT ON SITE AND ROOF HEIGHTS

SCALE: 1/4" = 1'0"

ELECTRICAL CONTRACTOR TO CONFIRM LOCATION
 OF OUTLET AND FIXTURES, SEE HOME OWNER FOR
 TYPE AND STYLE OF ELECTRICAL FIXTURES