



101 Front Elevation

Scale: 1/4" = 1'-0"

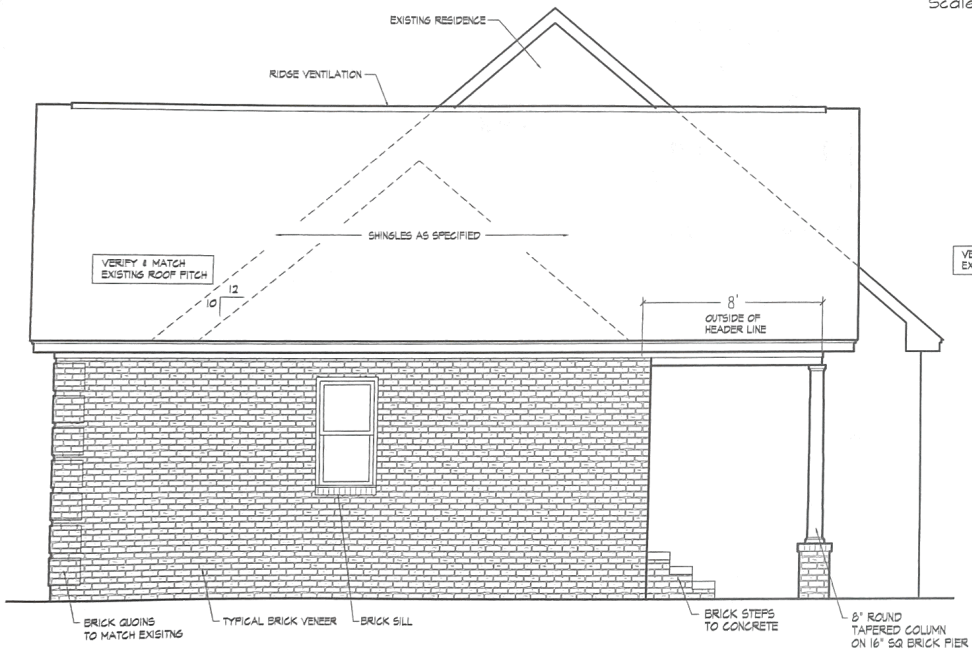

102 Right Elevation

Scale: 1/4" = 1'-0"

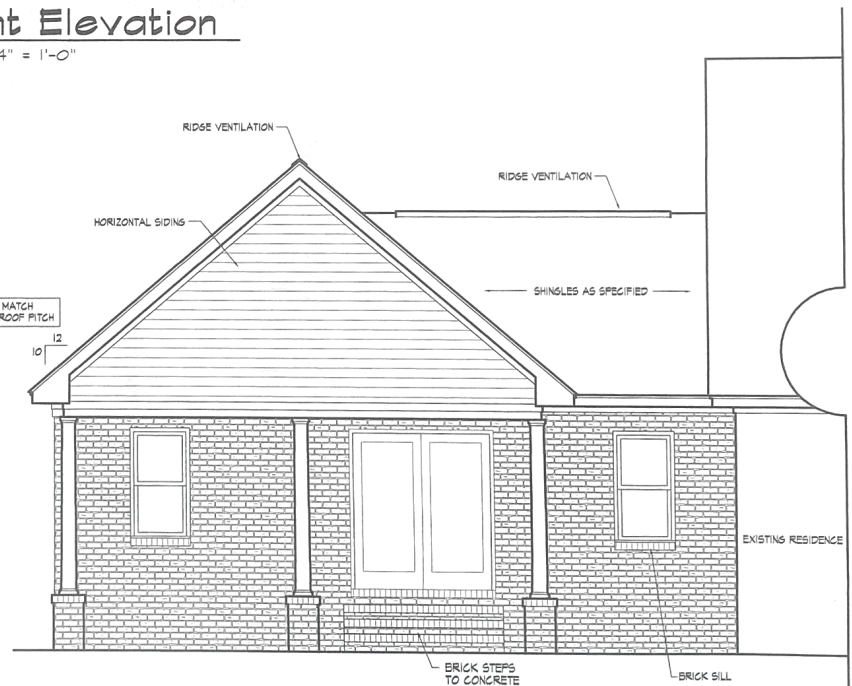

103 Rear Elevation


Scale: 1/4" = 1'-0"

Revisions

Scale:
 1/4" = 1'-0"
 Date:
 June 2023

Sheet No

Area Tabulations	
ADDITION FLOOR AREA	710 SQ. FT.
COVERED AREA	176 SQ. FT.

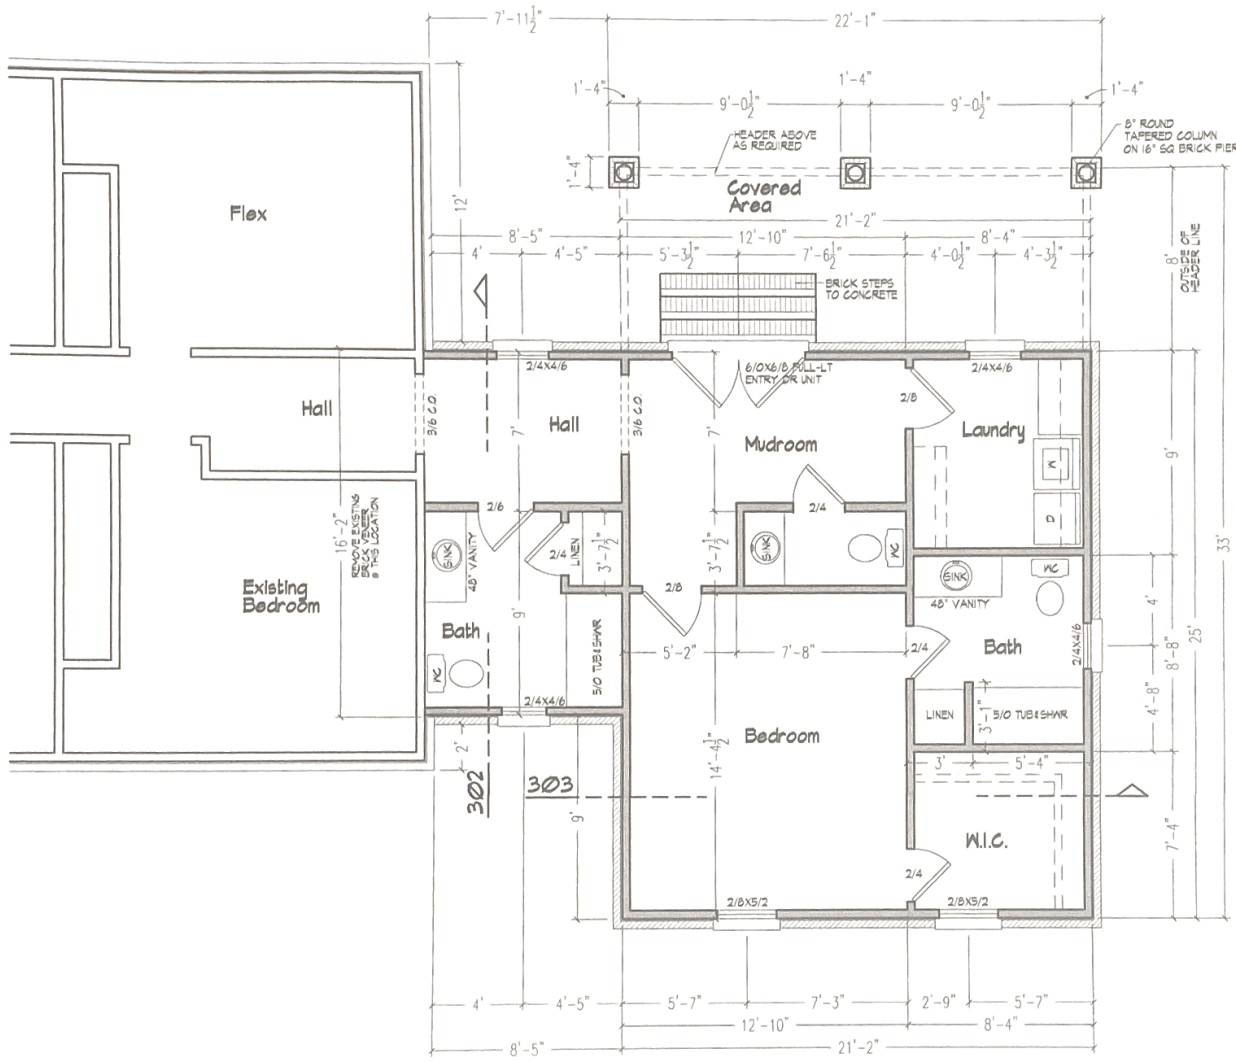

201 Floor Plan
 Scale: 1/4" = 1'-0"

A Project for
464 Lucas Rd
Dunn NC 28334
 Sheet Title
Floor Plan

Revisions

Scale:
 1/4" = 1'-0"
 Date:
 June 2023

Sheet No.

FOUNDATION VENTILATION CALC.

1 SF VENT/30 SF GRAVEL SPACE AREA


7.0 SF/30 = 4.74 SF
 4.74 SF/69 SQ. IN. = 1030 VENTS

= 11 VENTS REQUIRED


50% REDUCTION FOR VAPOR BARRIER

= 6 VENTS REQUIRED


= 8 VENTS PROVIDED

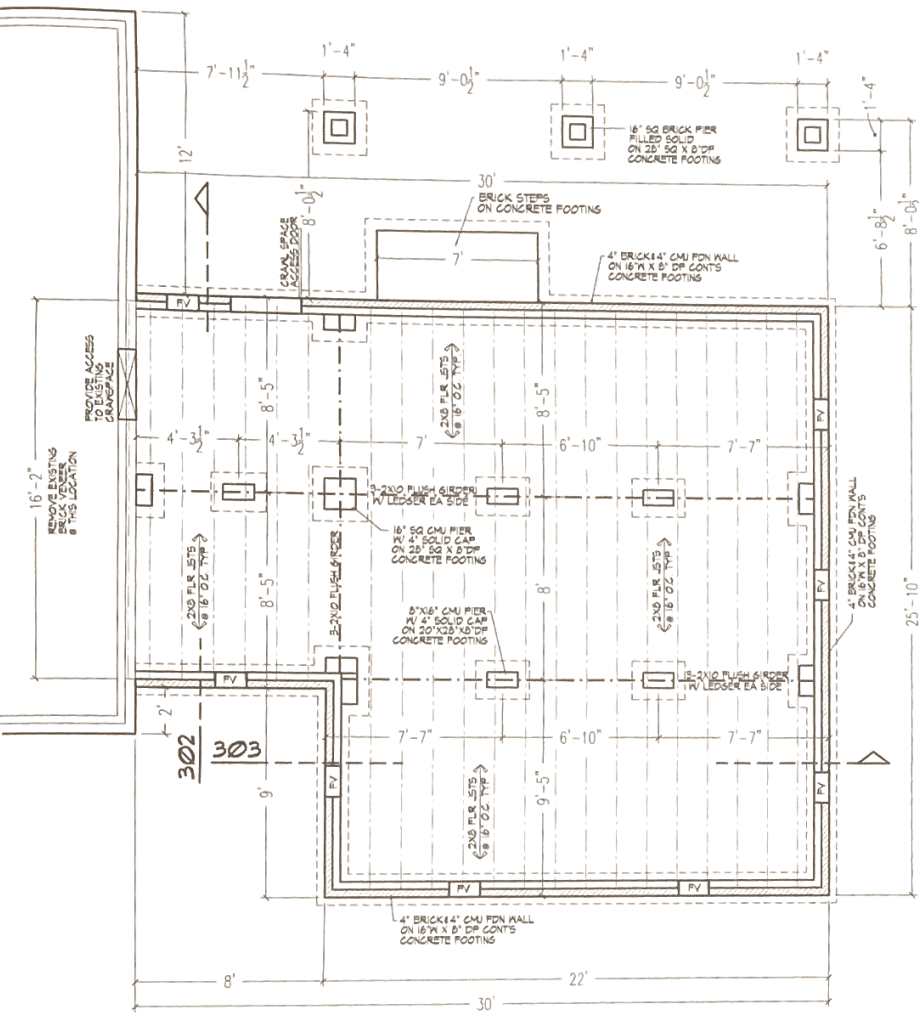

301 Foundation Plan
 Scale: 1/4" = 1'-0"

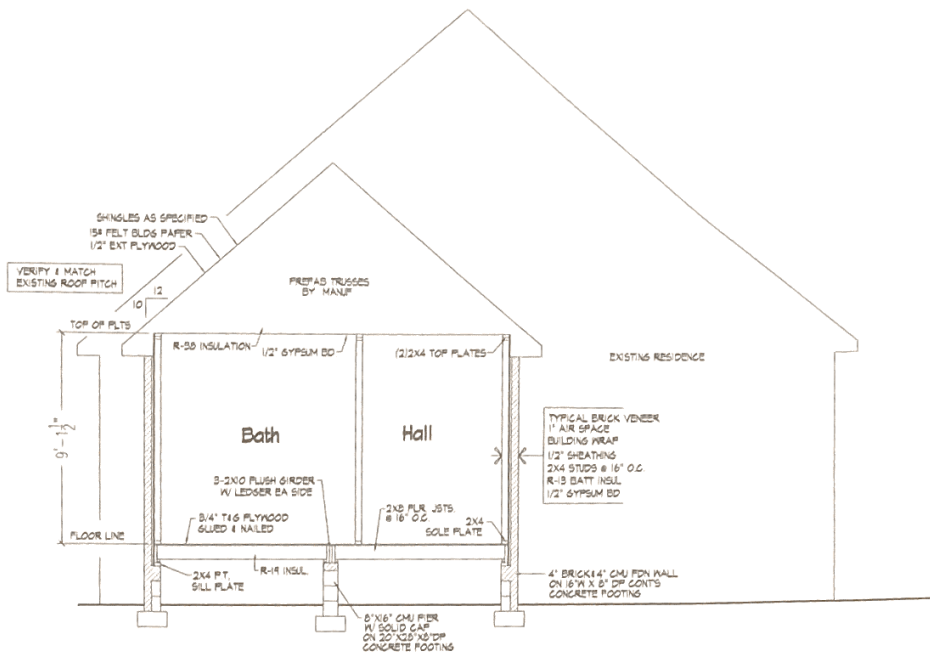

302 Building Section
 Scale 1/4" = 1'-0"

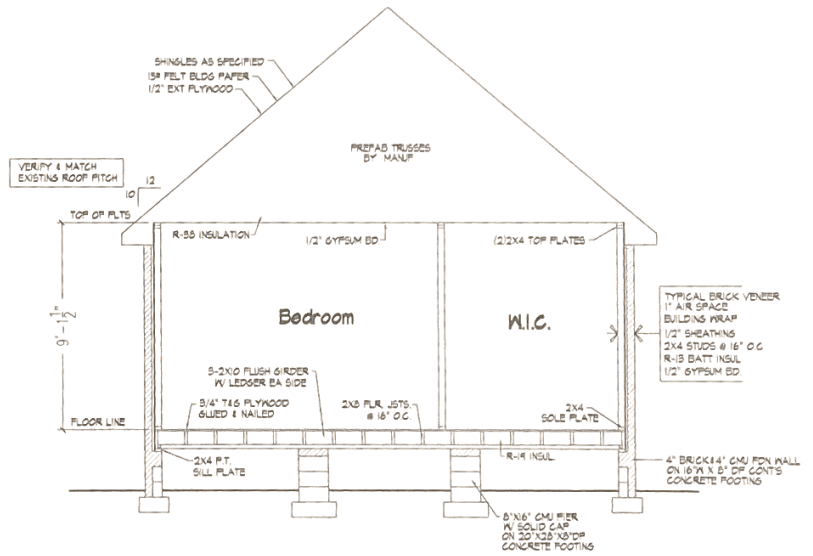


303 Building Section
 Scale: 1/4" = 1'-0"

Revisions

Scale:
 1/4" = 1'-0"
 Date:
 June 2023

Sheet No

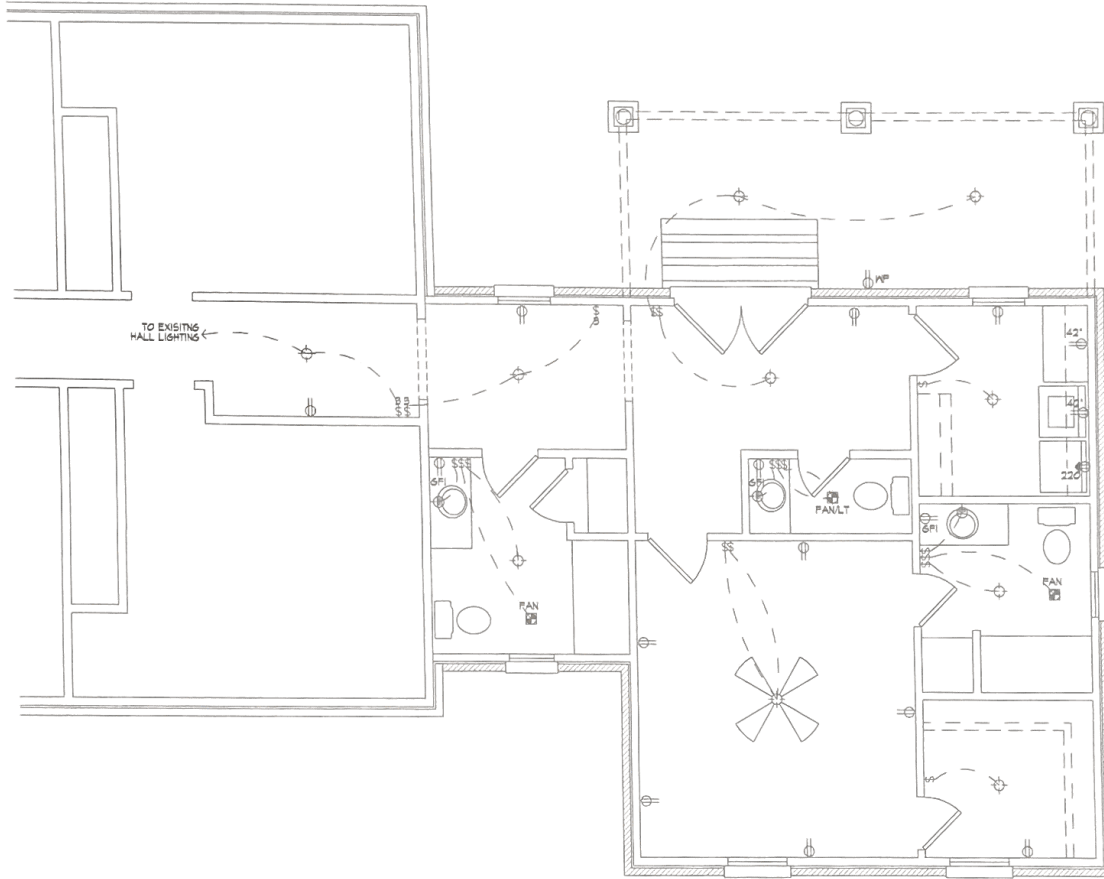

ELECTRICAL SYMBOLS	
	TYPICAL WALL RECEPTACLE
	110 V - 42" AFF
	HALF HOT AND HALF SWITCHED
	WATERPROOF RECEPTACLE
	110 V - GROUND FAULT
	220 V OUTLET
	110 V OUTLET - FLOOR MOUNT
	CEILING RECEPTACLE
	TOUCH - PAD
	TYPICAL SWITCH
	3 WAY OR MORE (SEE PLAN)
	DIMMER SWITCH
	LIGHT - WALL MOUNT
	LIGHT - CEILING MOUNT
	RECESSED LIGHT
	EXHAUST FAN
	LIGHT - FAN COMBINATION
	FLOOD LIGHTS
	FLUORESCENT TUBE
	FLUORESCENT LIGHT FIXTURE
	CLG. FAN
	PHONE JACK
	TV CABLE JACK
	MASTER FLOOD LIGHT SWITCH

401 Electrical Floor Plan
 Scale: 1/4" = 1'-0"

A Project for
 464 Lucas Rd
 Dunn NC 28334
 Sheet Title
Electrical Floor Plan

John E Carroll
 Residential Design
 20314
 0441 10/10/2013
 10/10/2013
 10/10/2013

Revisions

Scale:
 1/4" = 1'-0"
 Date:
 June 2023

Sheet No.

4