





101 Existing Conditions

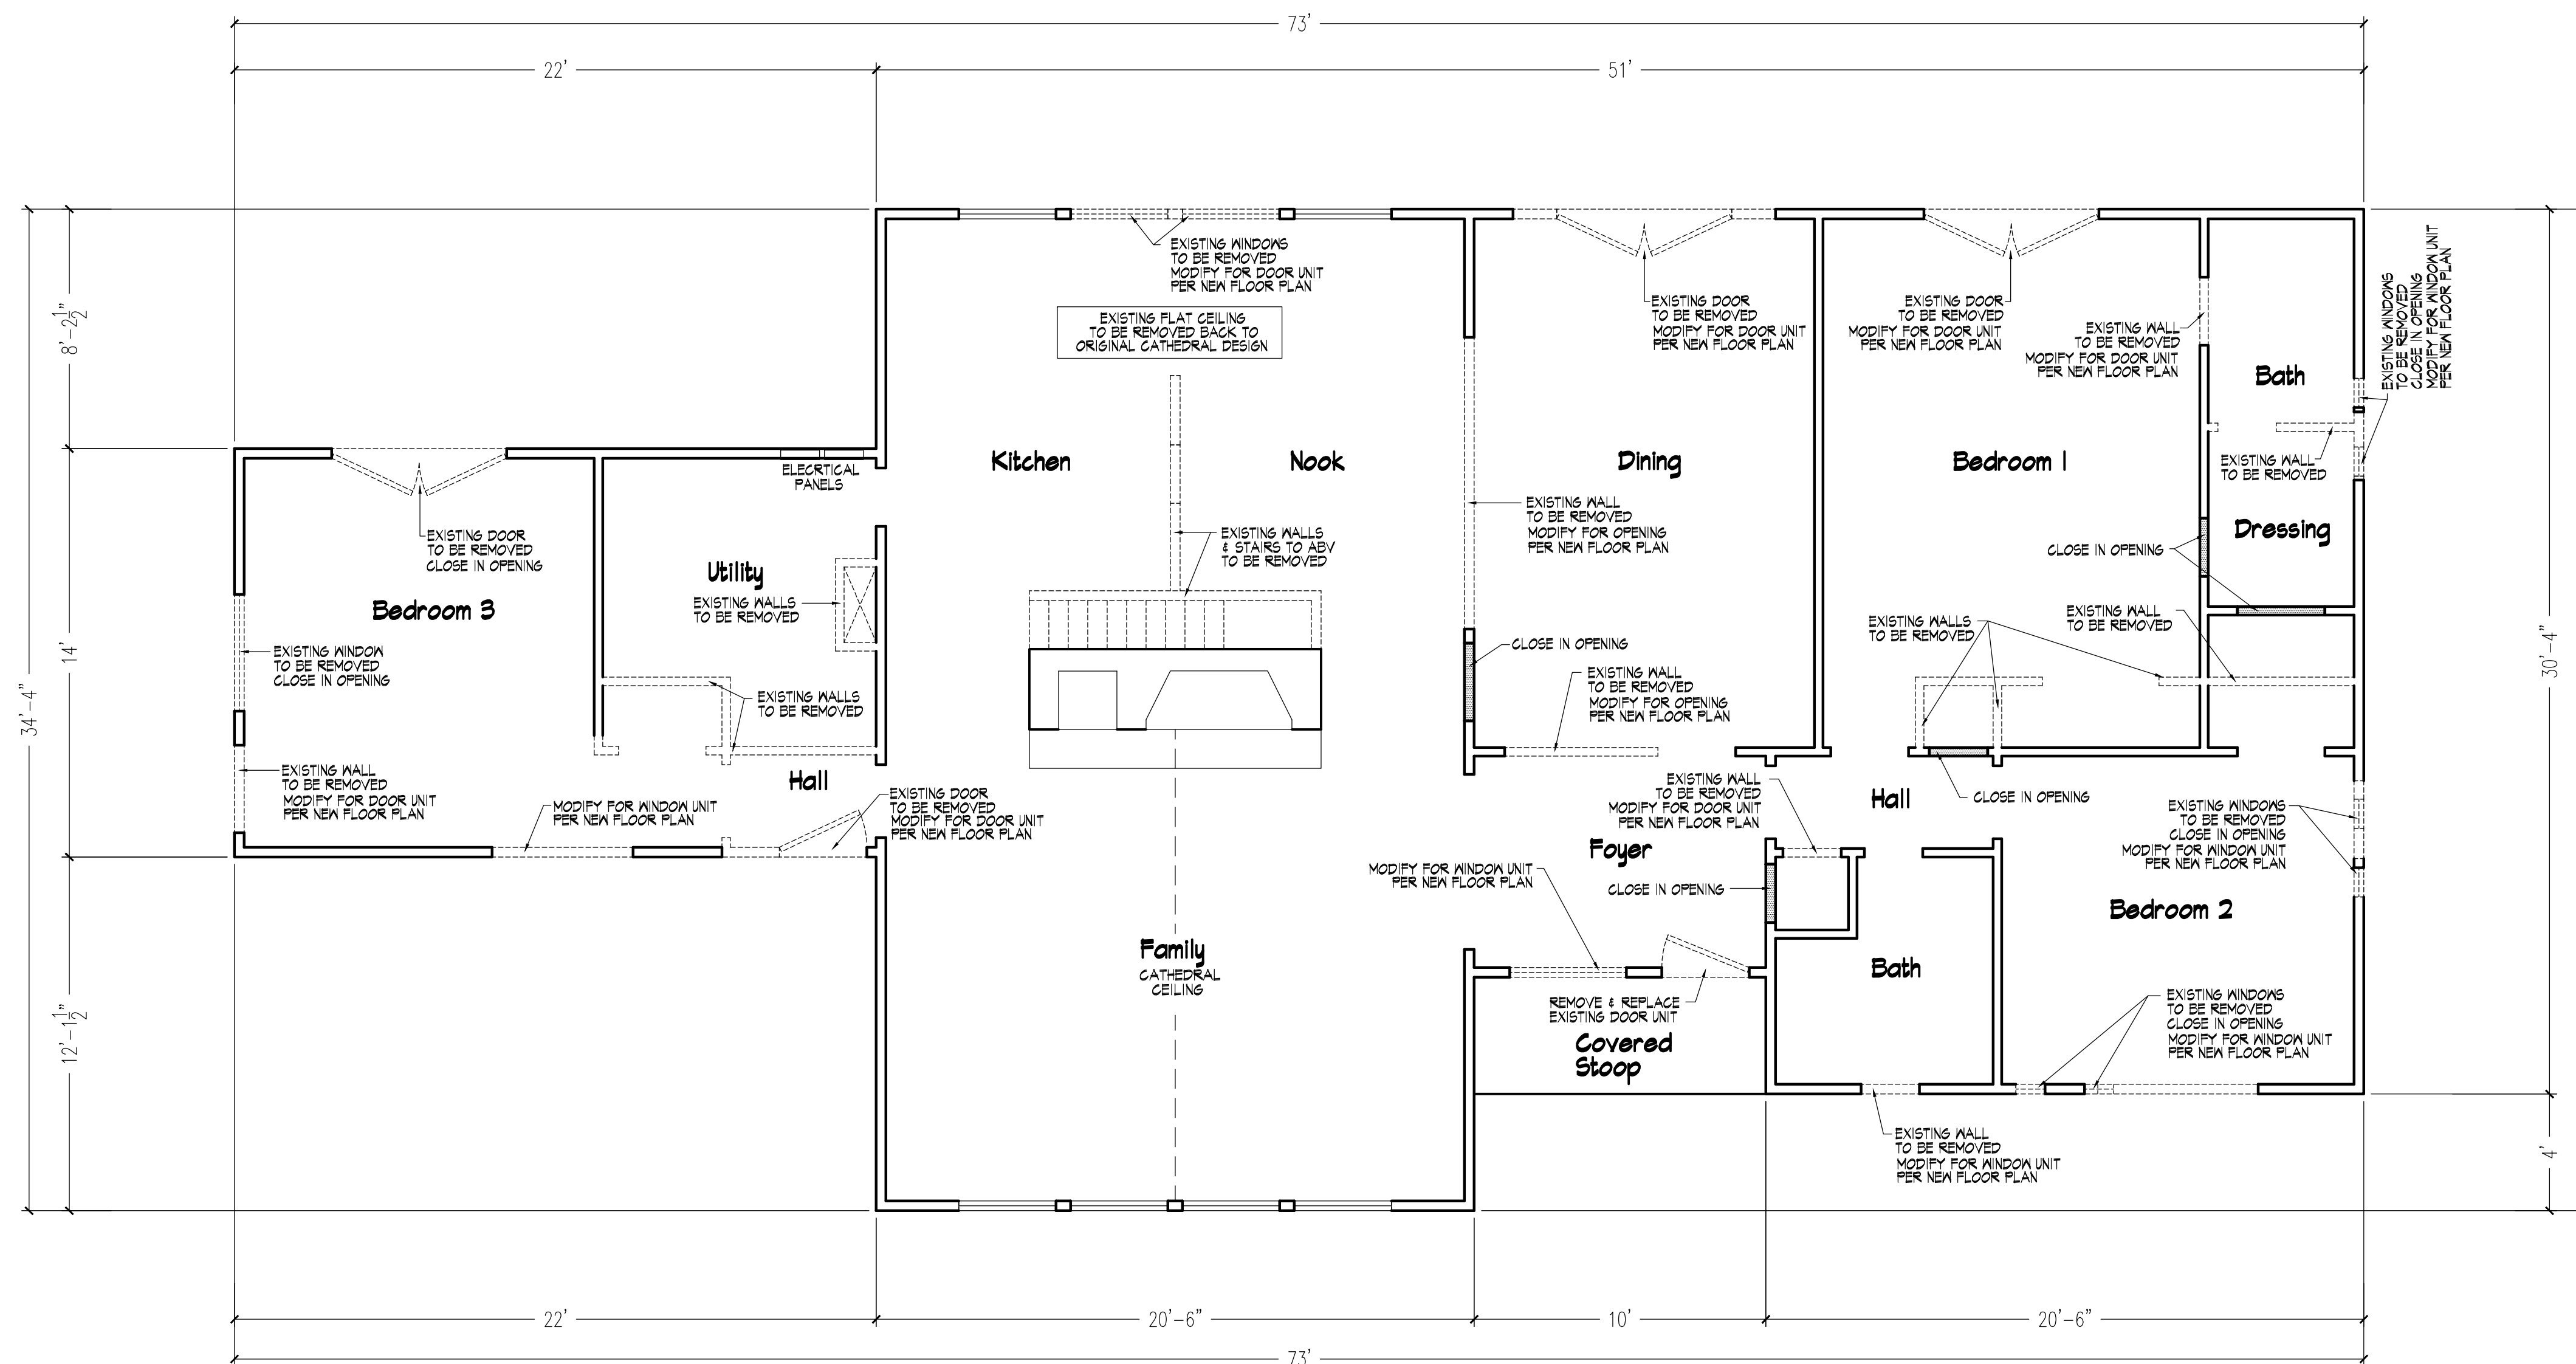

102 Existing Floor Plan
Scale: 1/4" = 1'-0"

Addition & Renovations to
The Turlington Residence

Sheet Title
Existing Conditions

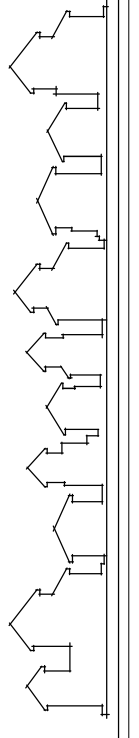
John E. Carroll
 Residential Design
 844 montclair road, Fayetteville, nc 28314
 johncarroll.design@gmail.com 910.850.9408


Revisions

NOTE TO CLIENT/CONTRACTOR
 THE DESIGNERS HAVE MADE EVERY ATTEMPT TO INSURE THAT THESE DRAWINGS MEET OR EXCEED ALL STATE AND LOCAL CODES. THE CLIENT/CONTRACTOR SHALL VERIFY ALL DIMENSIONS, AND SIZE ALL STRUCTURAL COMPONENTS. THE DESIGNERS WILL NOT ASSUME ANY LIABILITY FOR ERRORS ONCE CONSTRUCTION BEGINS.


Scale:
as shown
Date:
August 2023

Sheet No.
|

Area Tabulations	
EXISTING HTD FLOOR AREA	1897 SQ. FT.
NEW HTD FLOOR AREA	616 SQ. FT.
TOTAL HTD FLOOR AREA	2513 SQ. FT.
COVERED PORCH AREA-FRONT	190 SQ. FT.
COVERED PORCH AREA-MSTR BD	128 SQ. FT.
COVERED PORCH AREA-KITCHEN	246 SQ. FT.
GARAGE AREA	726 SQ. FT.
UN-HEATED BONUS ROOM AREA	326 SQ. FT.
TOTAL UNHTD FLOOR AREA	1616 SQ. FT.
WOOD DECK	280 SQ. FT.

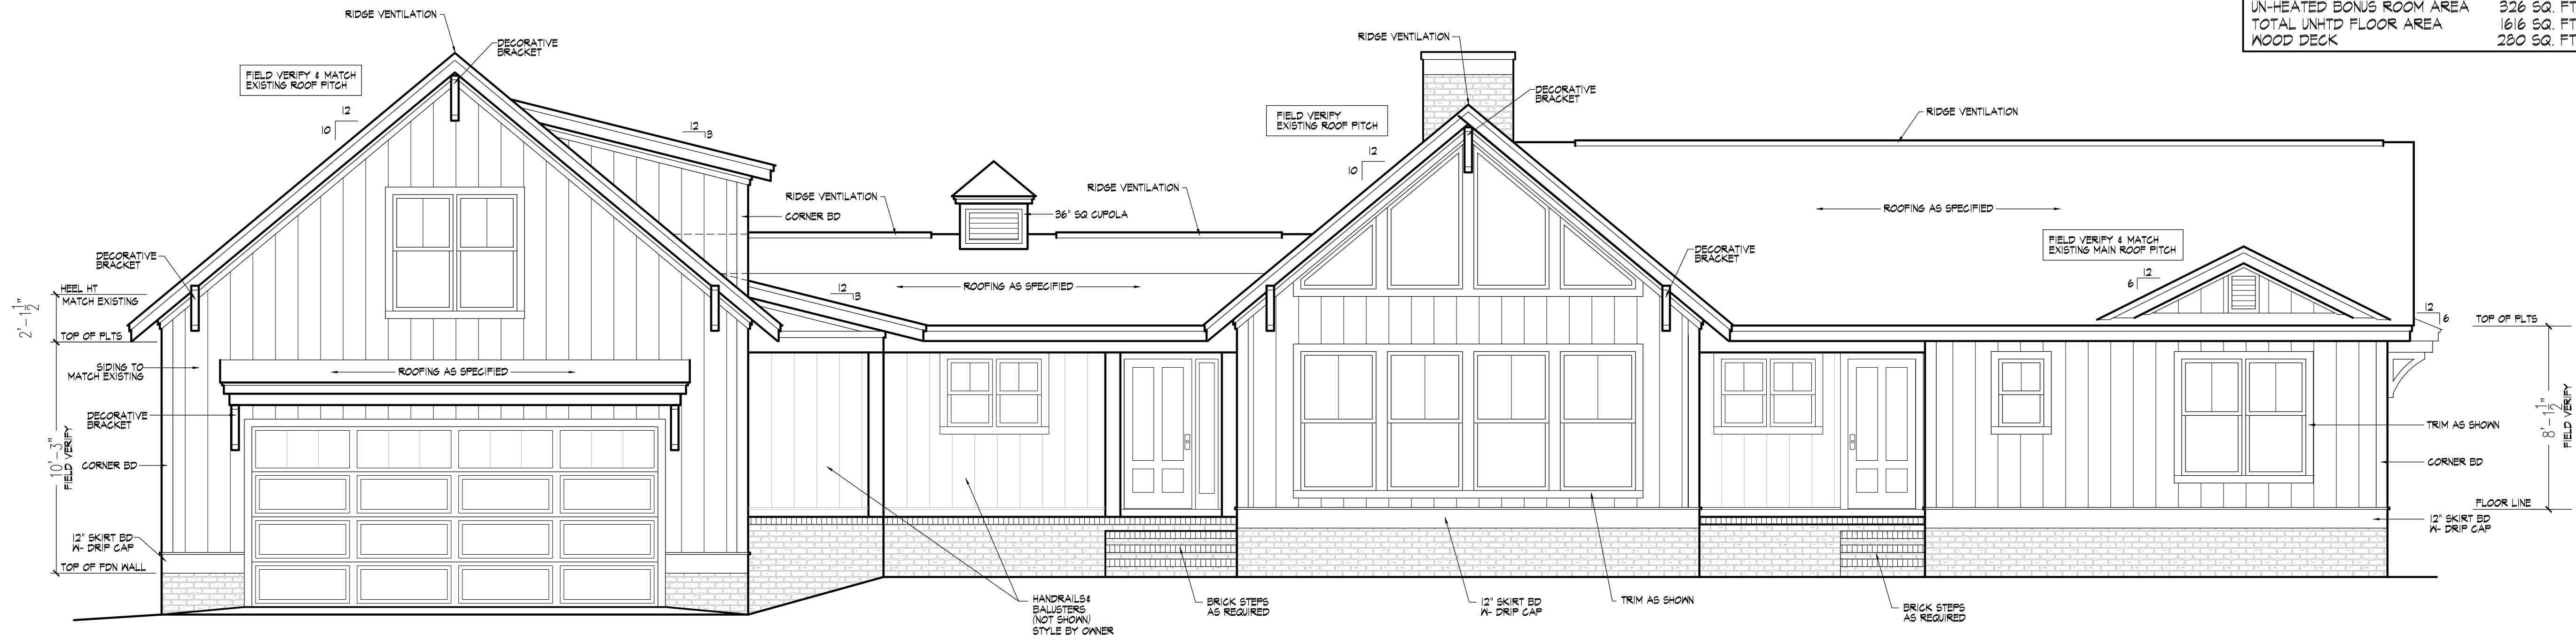

201 Front Elevation
Scale: 1/4" = 1'-0"

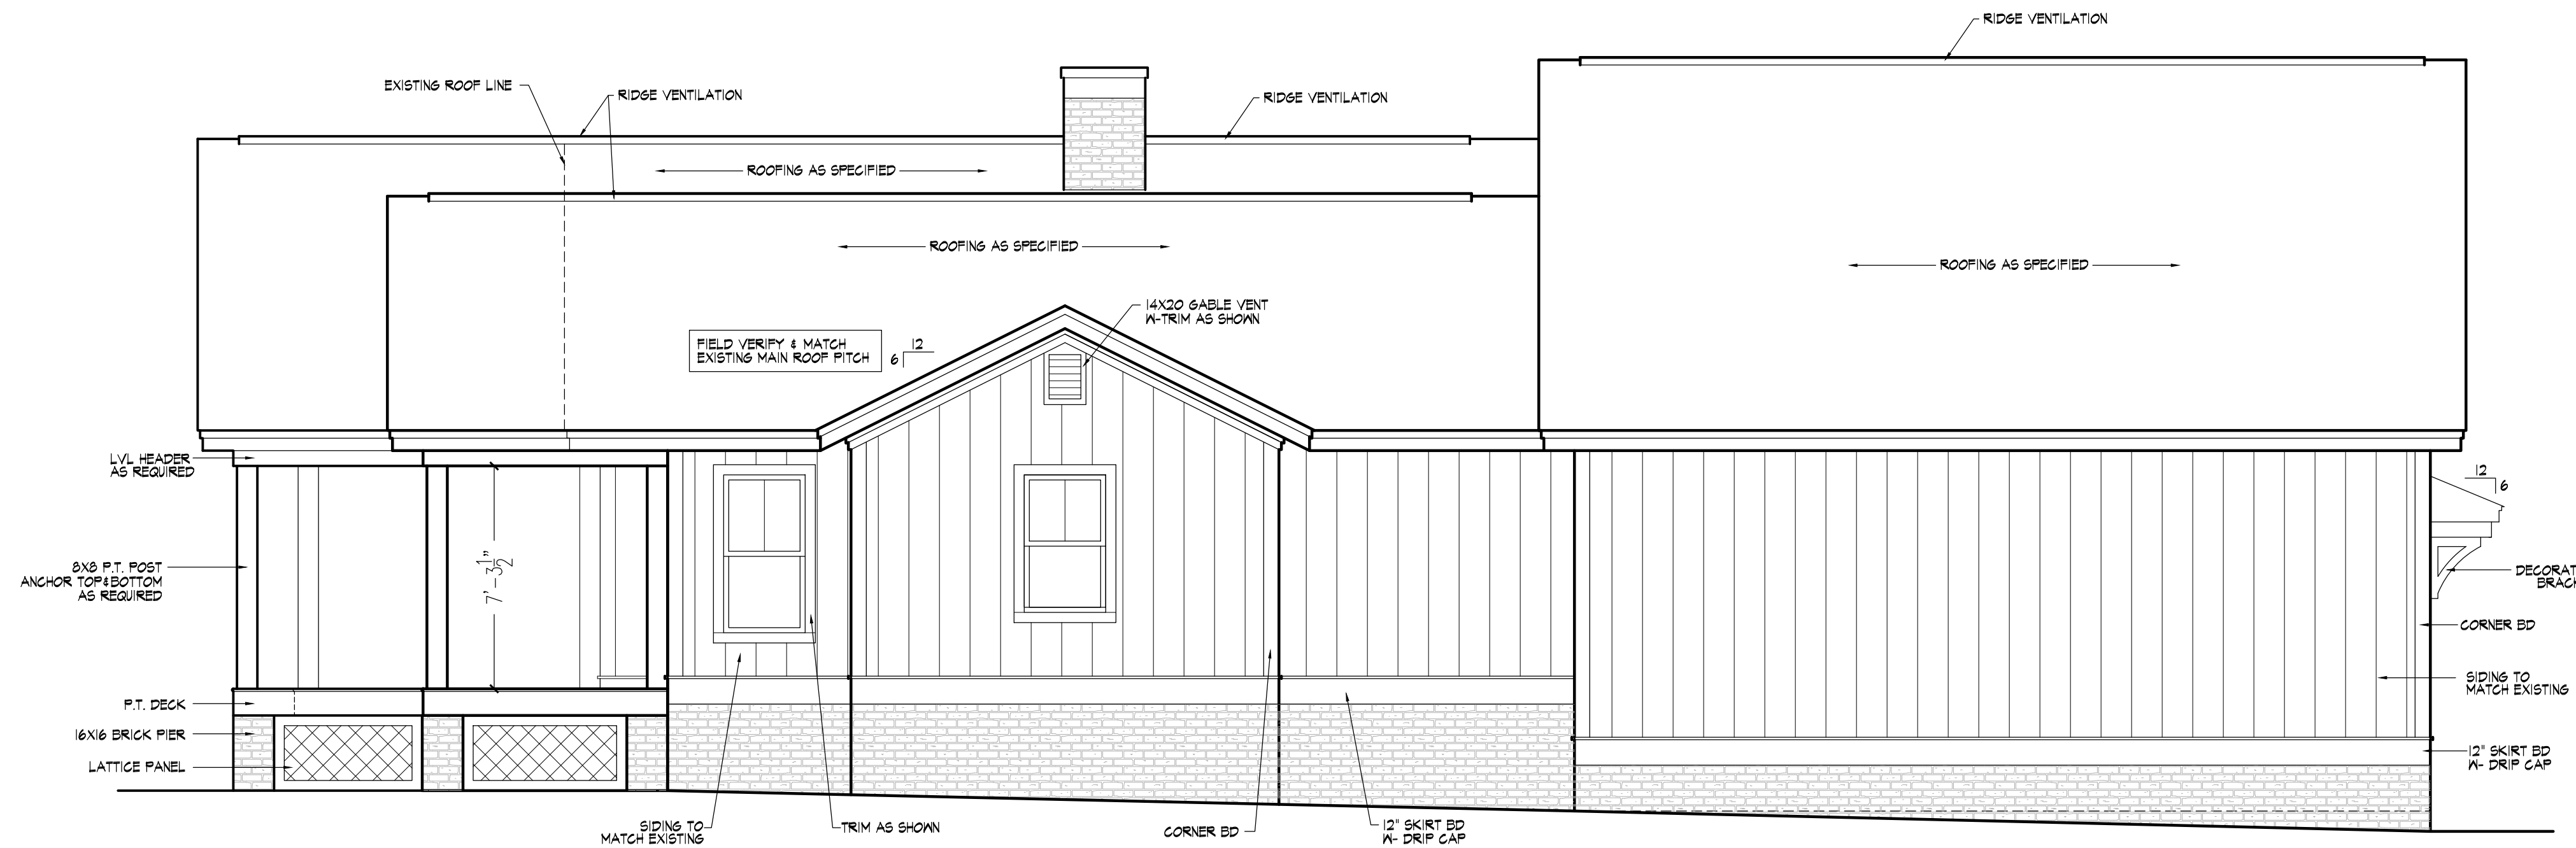

202 Left Elevation
Scale: 1/4" = 1'-0"

Addition & Renovations to
The Turlington Residence
 Sheet Title
Exterior Elevations

John E. Carroll
 Residential Design
 844 montclair road, Fayetteville, nc 28314
 johncarroll.design@gmail.com
 910.850.9408

Revisions


NOTE TO CLIENT/CONTRACTOR
 THE DESIGNERS HAVE MADE EVERY ATTEMPT TO INSURE THAT THESE DRAWINGS MEET OR EXCEED ALL STATE AND LOCAL CODES. THE CLIENT/CONTRACTOR SHALL VERIFY ALL DIMENSIONS, AND SIZE ALL STRUCTURAL COMPONENTS. THE DESIGNERS WILL NOT ASSUME ANY LIABILITY FOR ERRORS ONCE CONSTRUCTION BEGINS.

Scale:
as shown
Date:
August 2023


Sheet No.

2

Addition & Renovations to
The Turlington Residence
 Sheet Title
Exterior Elevations

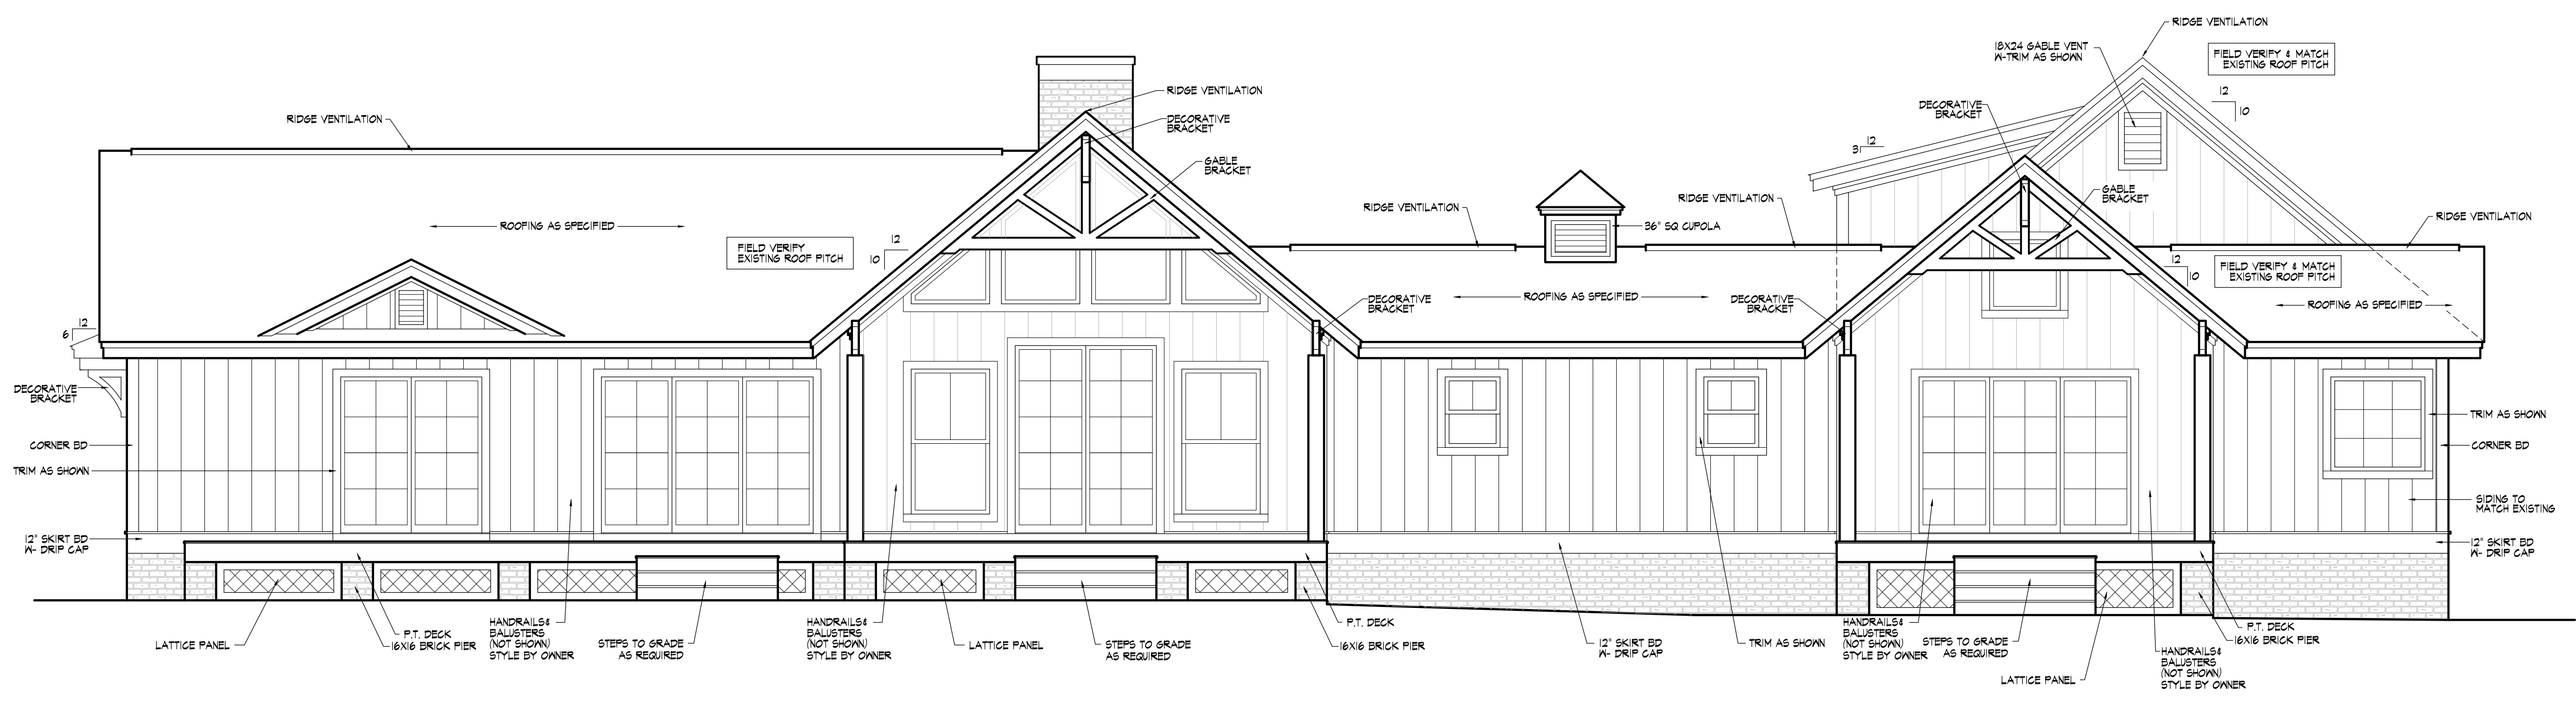

301 Rear Elevation
 Scale: 1/4" = 1'-0"

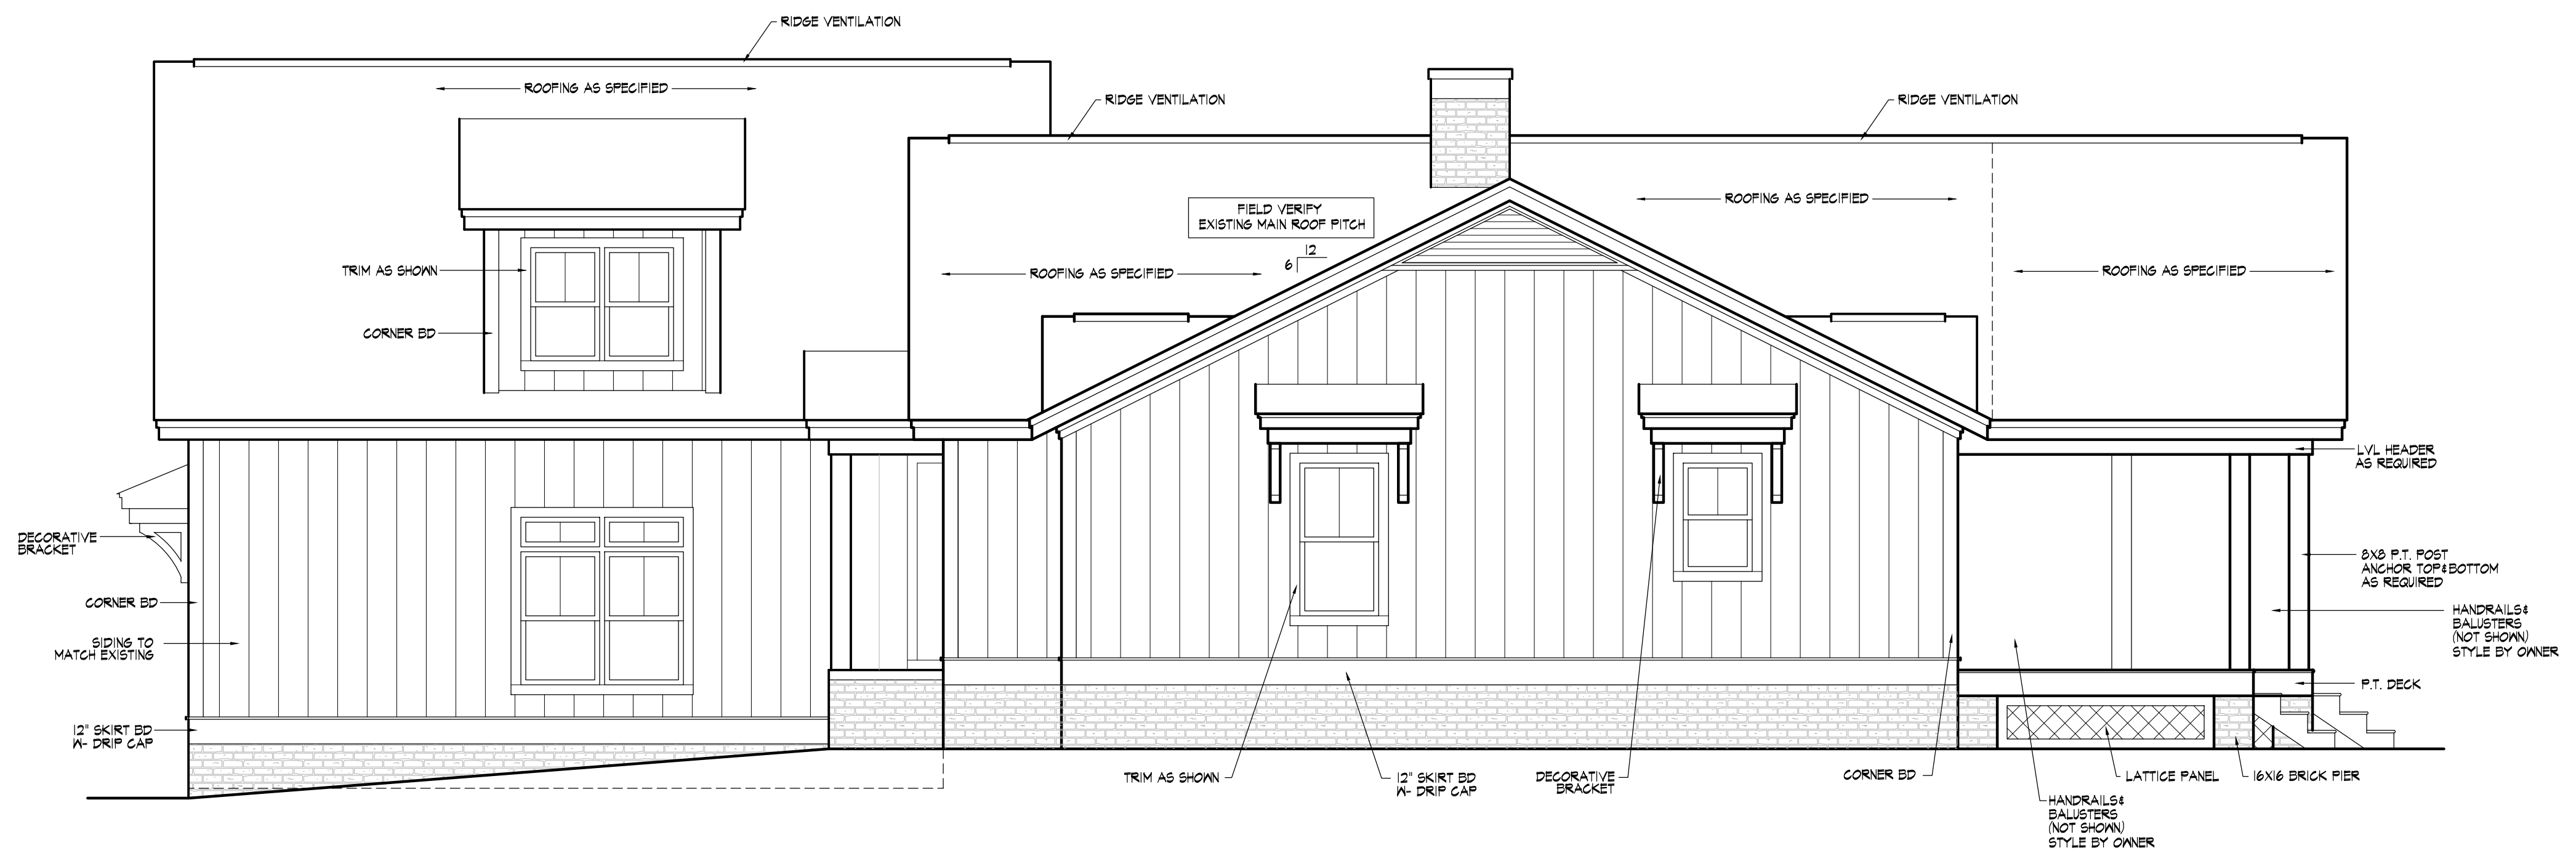


302 Right Elevation
 Scale: 1/4" = 1'-0"

Revisions

NOTE TO CLIENT/CONTRACTOR
 THE DESIGNERS HAVE MADE EVERY ATTEMPT TO INSURE THAT THESE DRAWINGS MEET OR EXCEED ALL STATE AND LOCAL CODES. THE CLIENT/CONTRACTOR SHALL VERIFY ALL DIMENSIONS, AND SIZE ALL STRUCTURAL COMPONENTS. THE DESIGNERS WILL NOT ASSUME ANY LIABILITY FOR ERRORS ONCE CONSTRUCTION BEGINS.

Scale:
 as shown
 Date:
 August 2023

Sheet No.
3

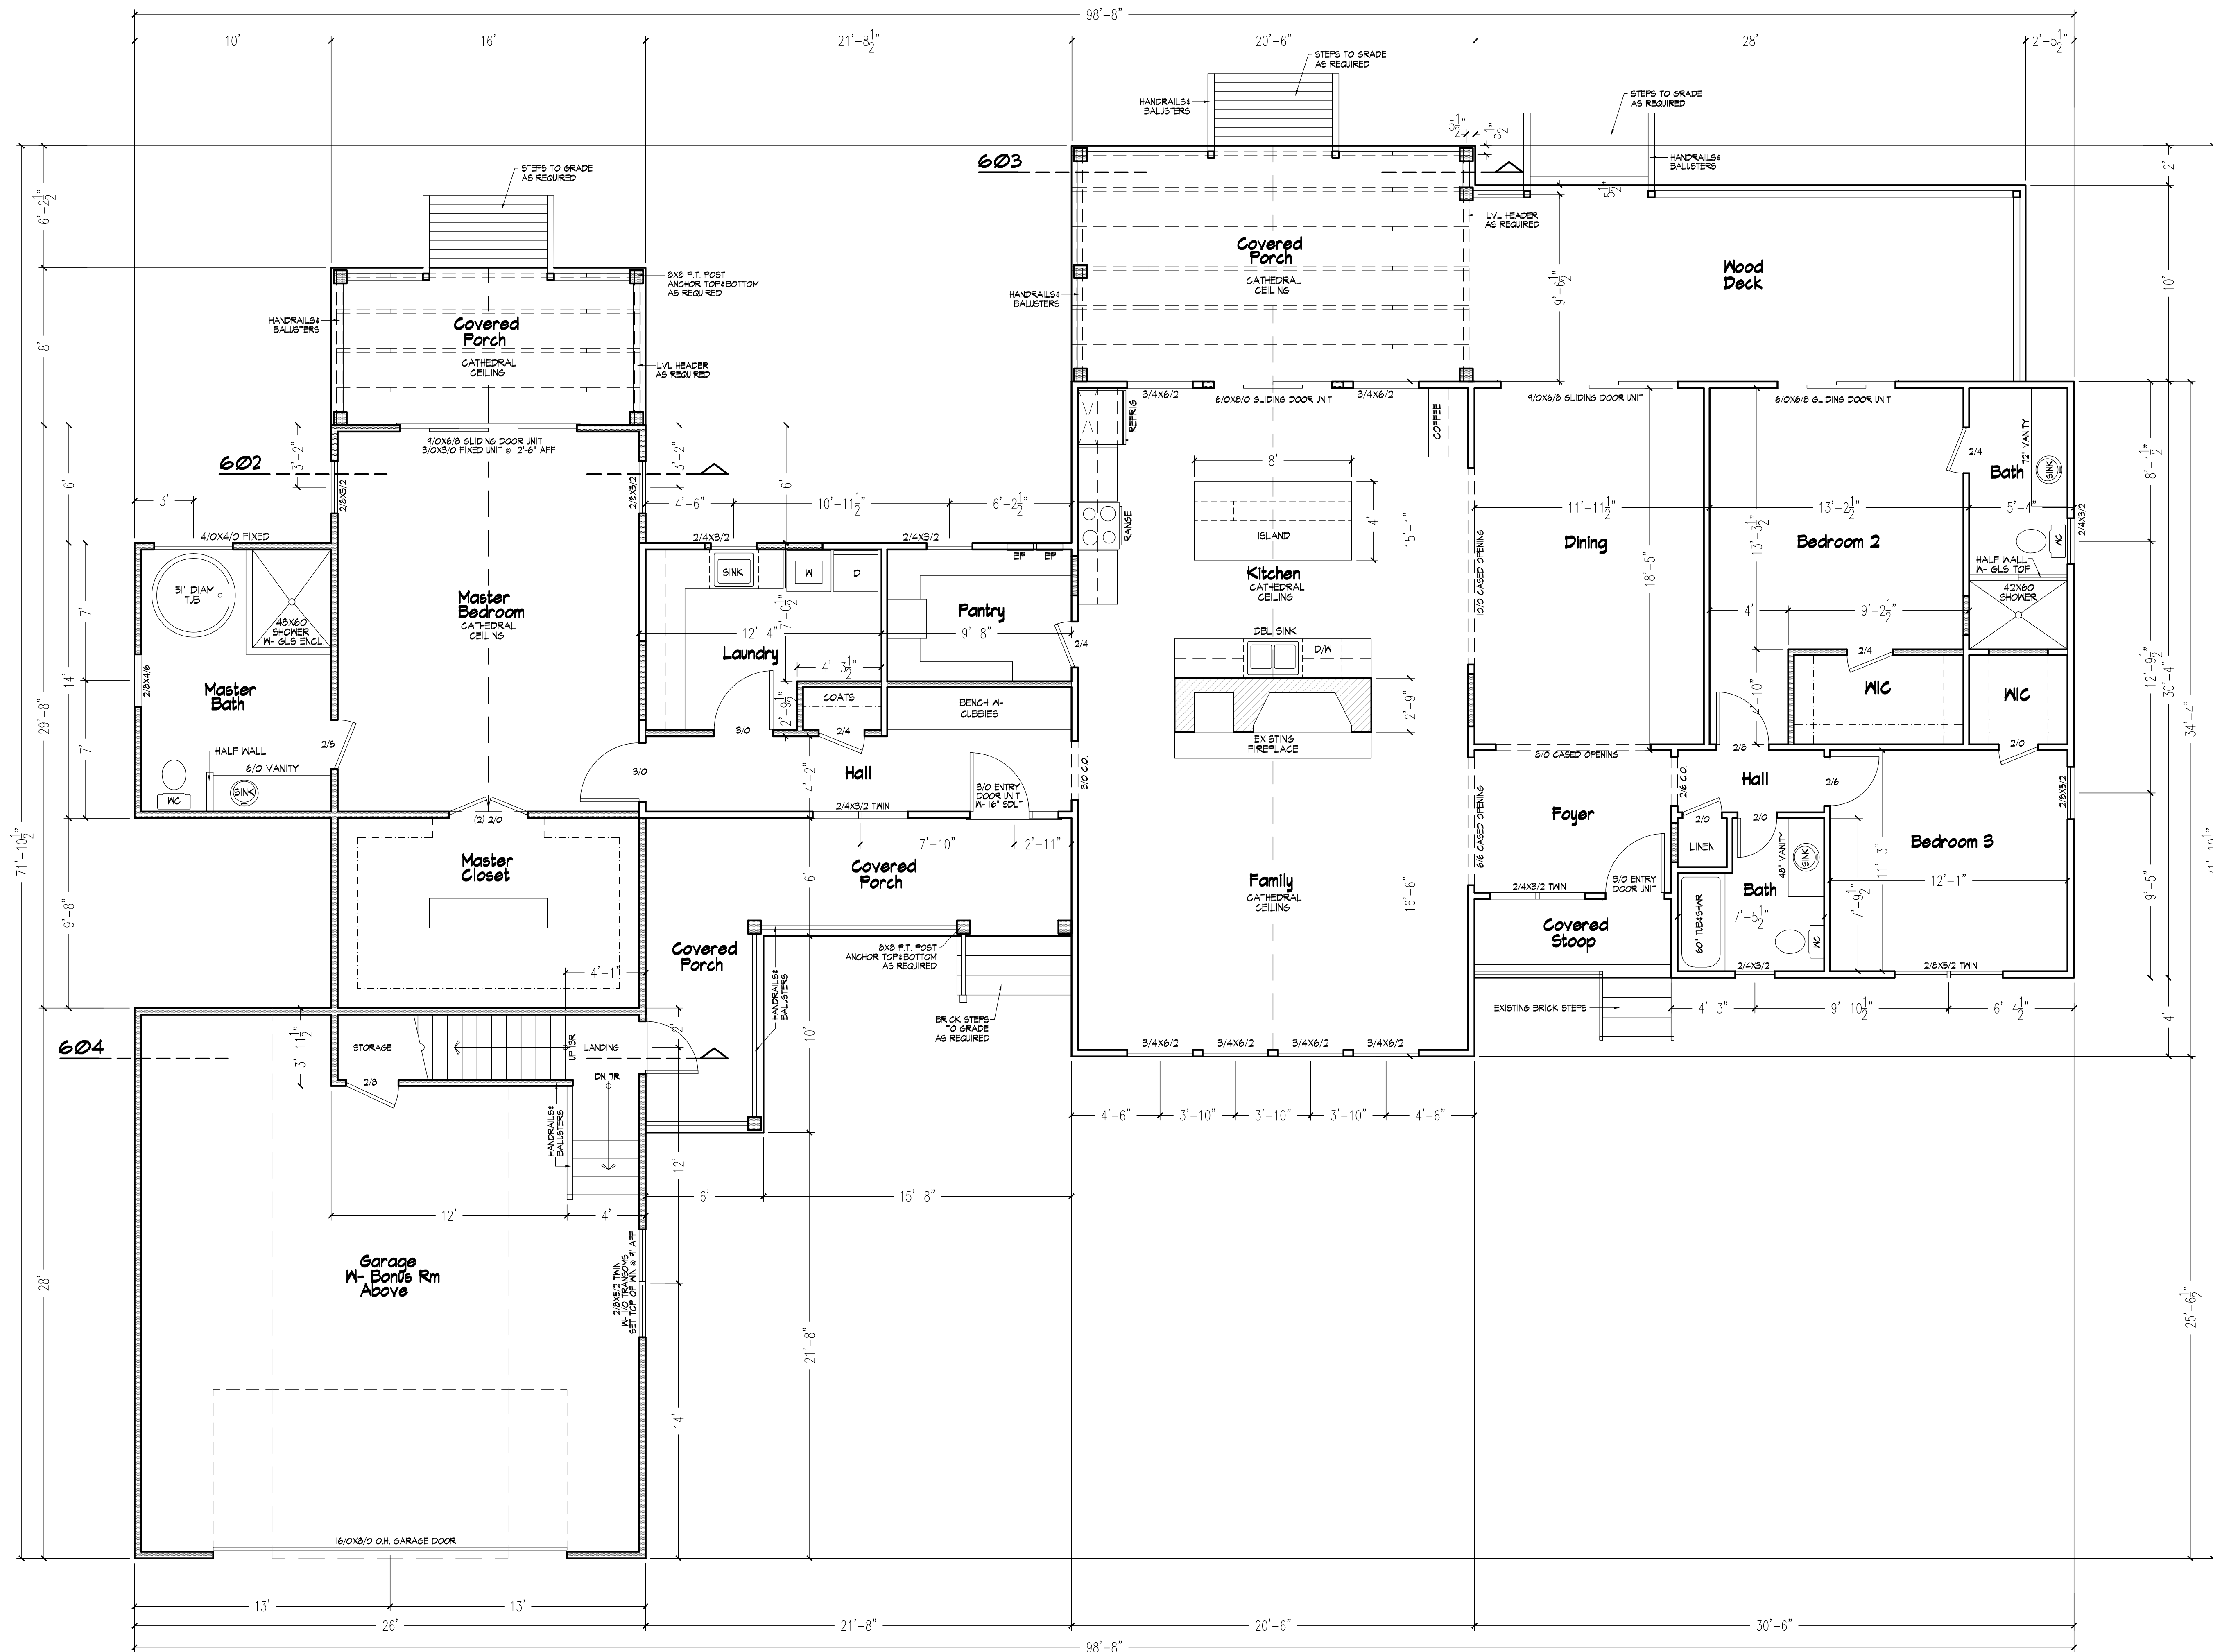

401 New Floor Plan
Scale: 1/4" = 1'-0"

Addition & Renovations to
The Turlington Residence
Sheet Title
New Floor Plan

John E Carroll
Residential Design
844 montclair road, Fayetteville, nc 28314
johnecarroll.design@gmail.com
910.850.9408



Revisions

NOTE TO CLIENT/CONTRACTOR
THE DESIGNERS HAVE MADE EVERY ATTEMPT TO INSURE THAT THESE DRAWINGS MEET OR EXCEED ALL STATE AND LOCAL CODES. THE CLIENT/CONTRACTOR SHALL VERIFY ALL DIMENSIONS, AND SIZE ALL STRUCTURAL COMPONENTS. THE DESIGNERS WILL NOT ASSUME ANY LIABILITY FOR ERRORS ONCE CONSTRUCTION BEGINS.


Scale:
as shown
Date:
August 2023

Sheet No.
4

Addition & Renovations to
The Turlington Residence
Sheet Title
Bonus Room Floor Plan
Building Sections/Roof Plan

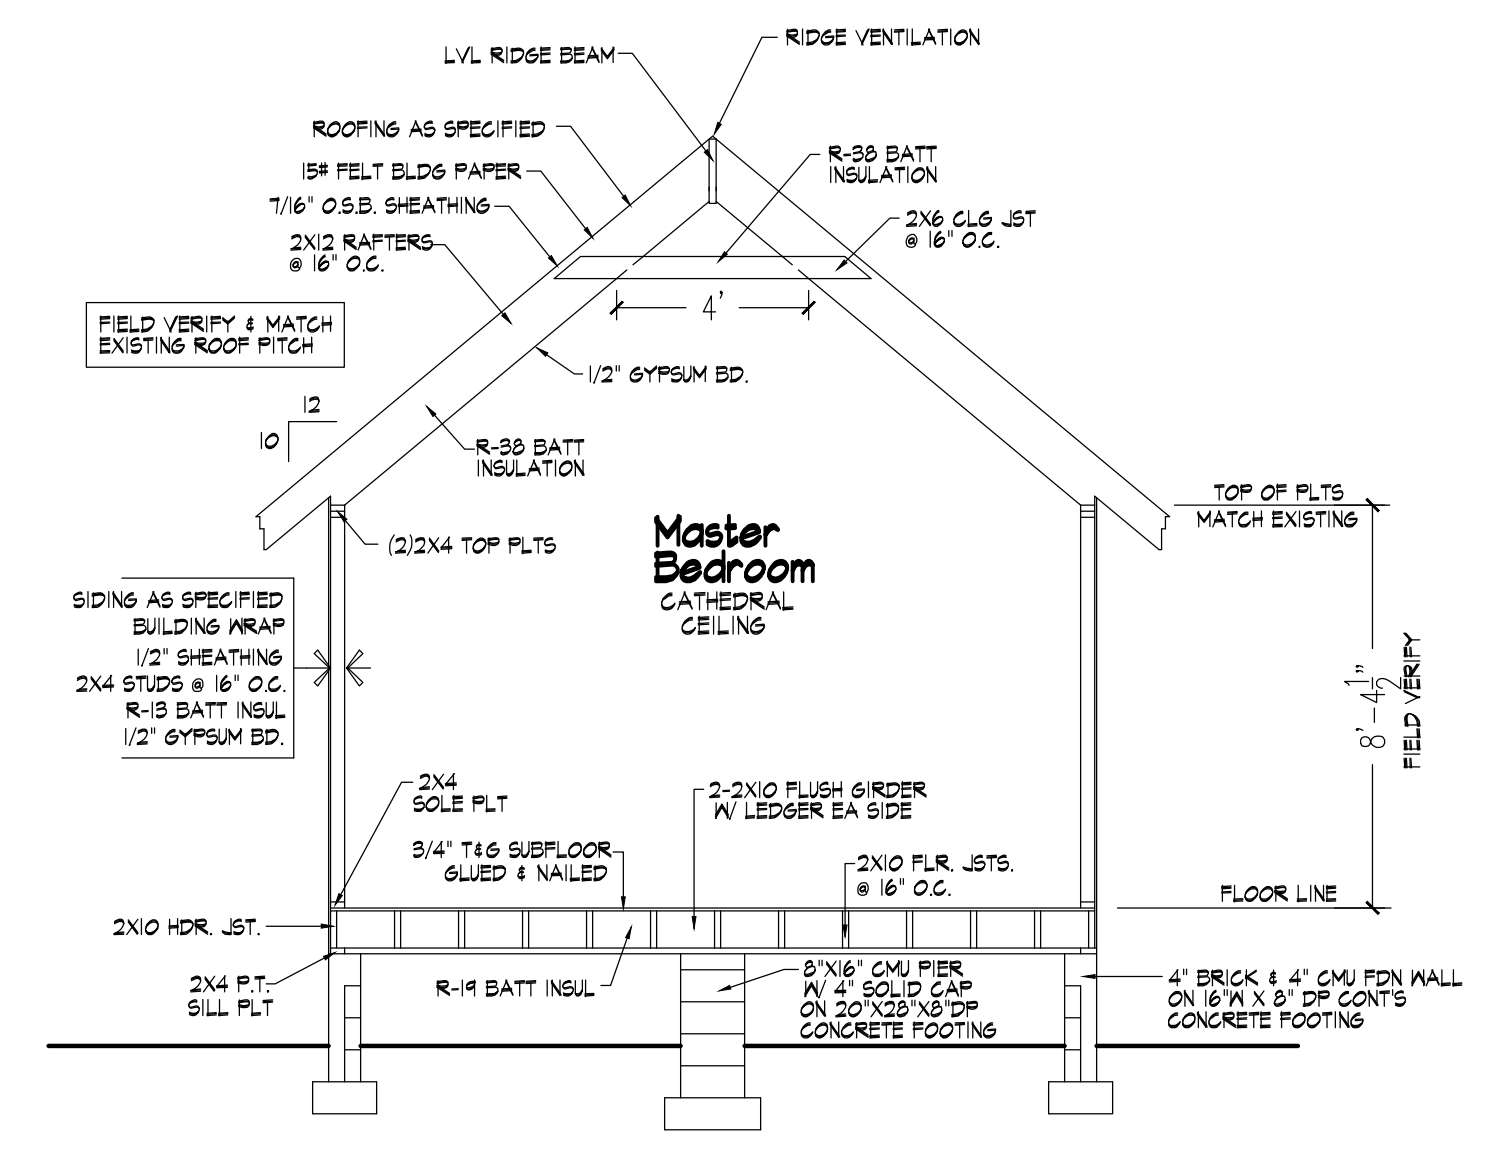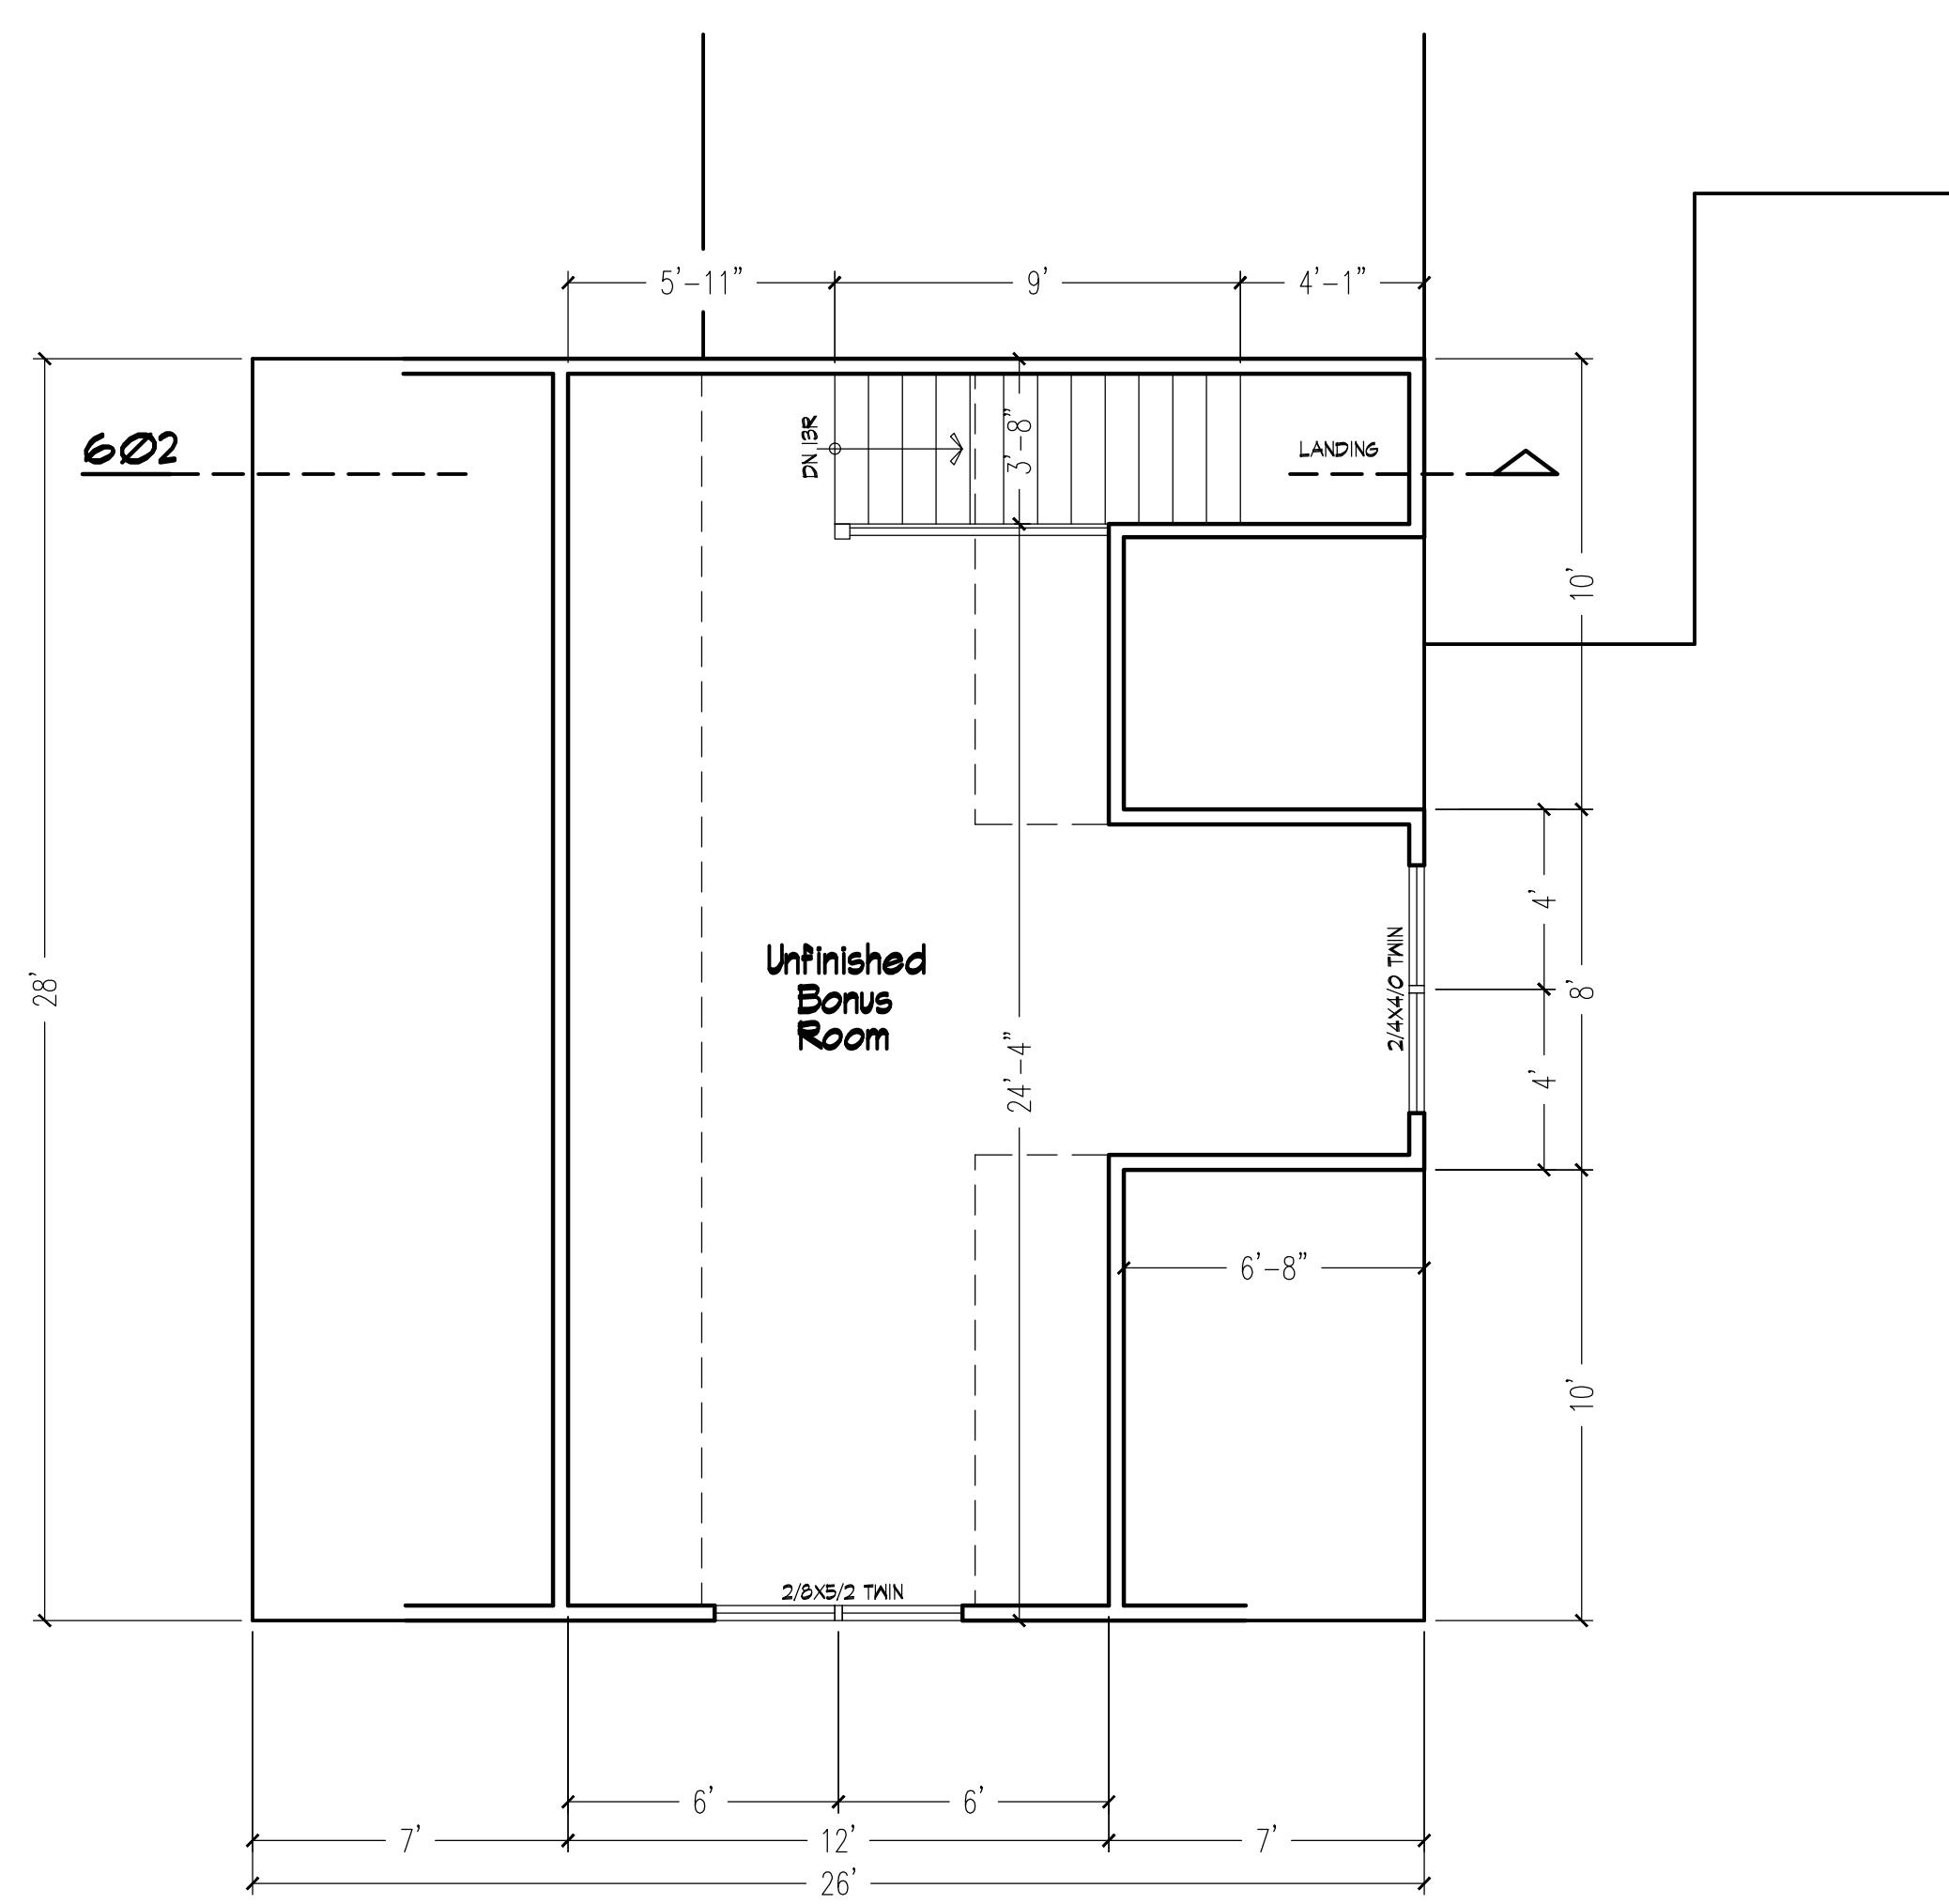


602 Building Section
Scale: 1/4" = 1'-0"

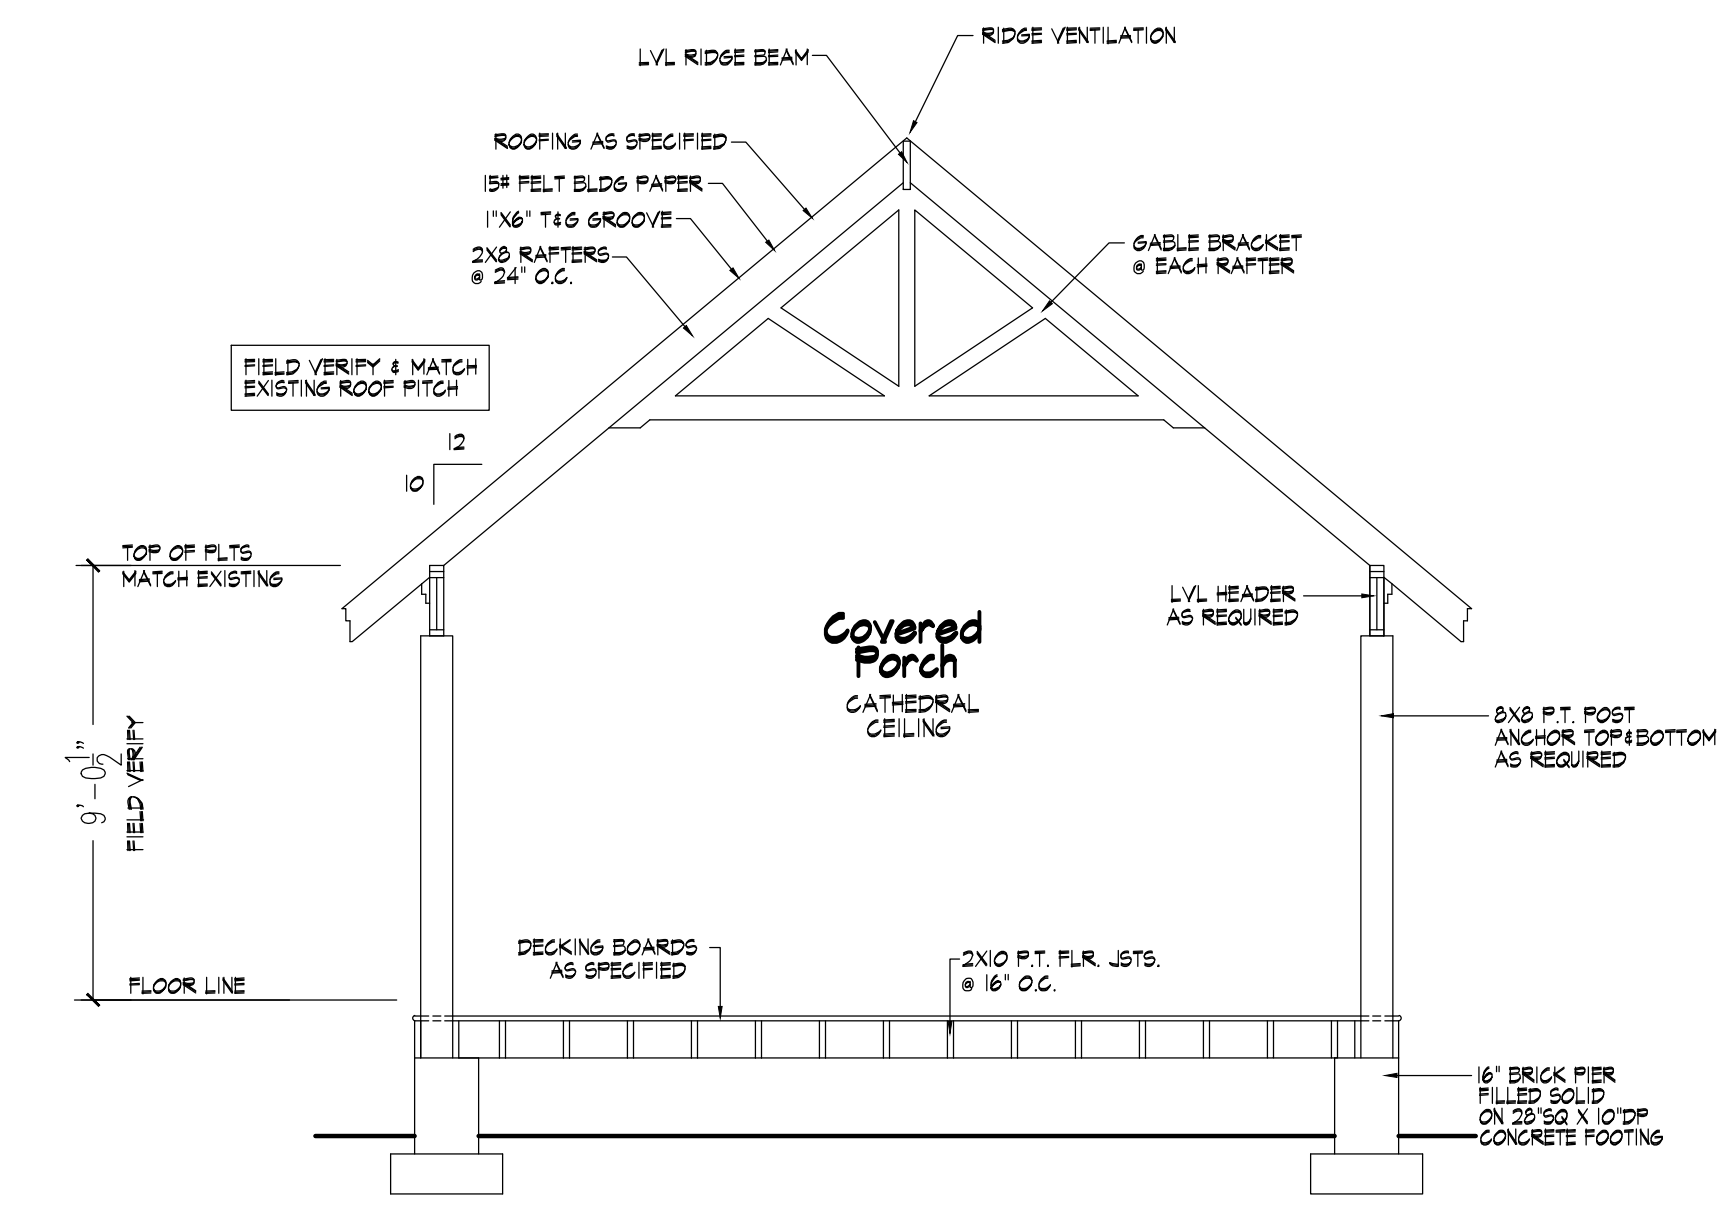


603 Building Section
Scale: 1/4" = 1'-0"

601 Bonus Room Floor Plan
Scale: 1/4" = 1'-0"

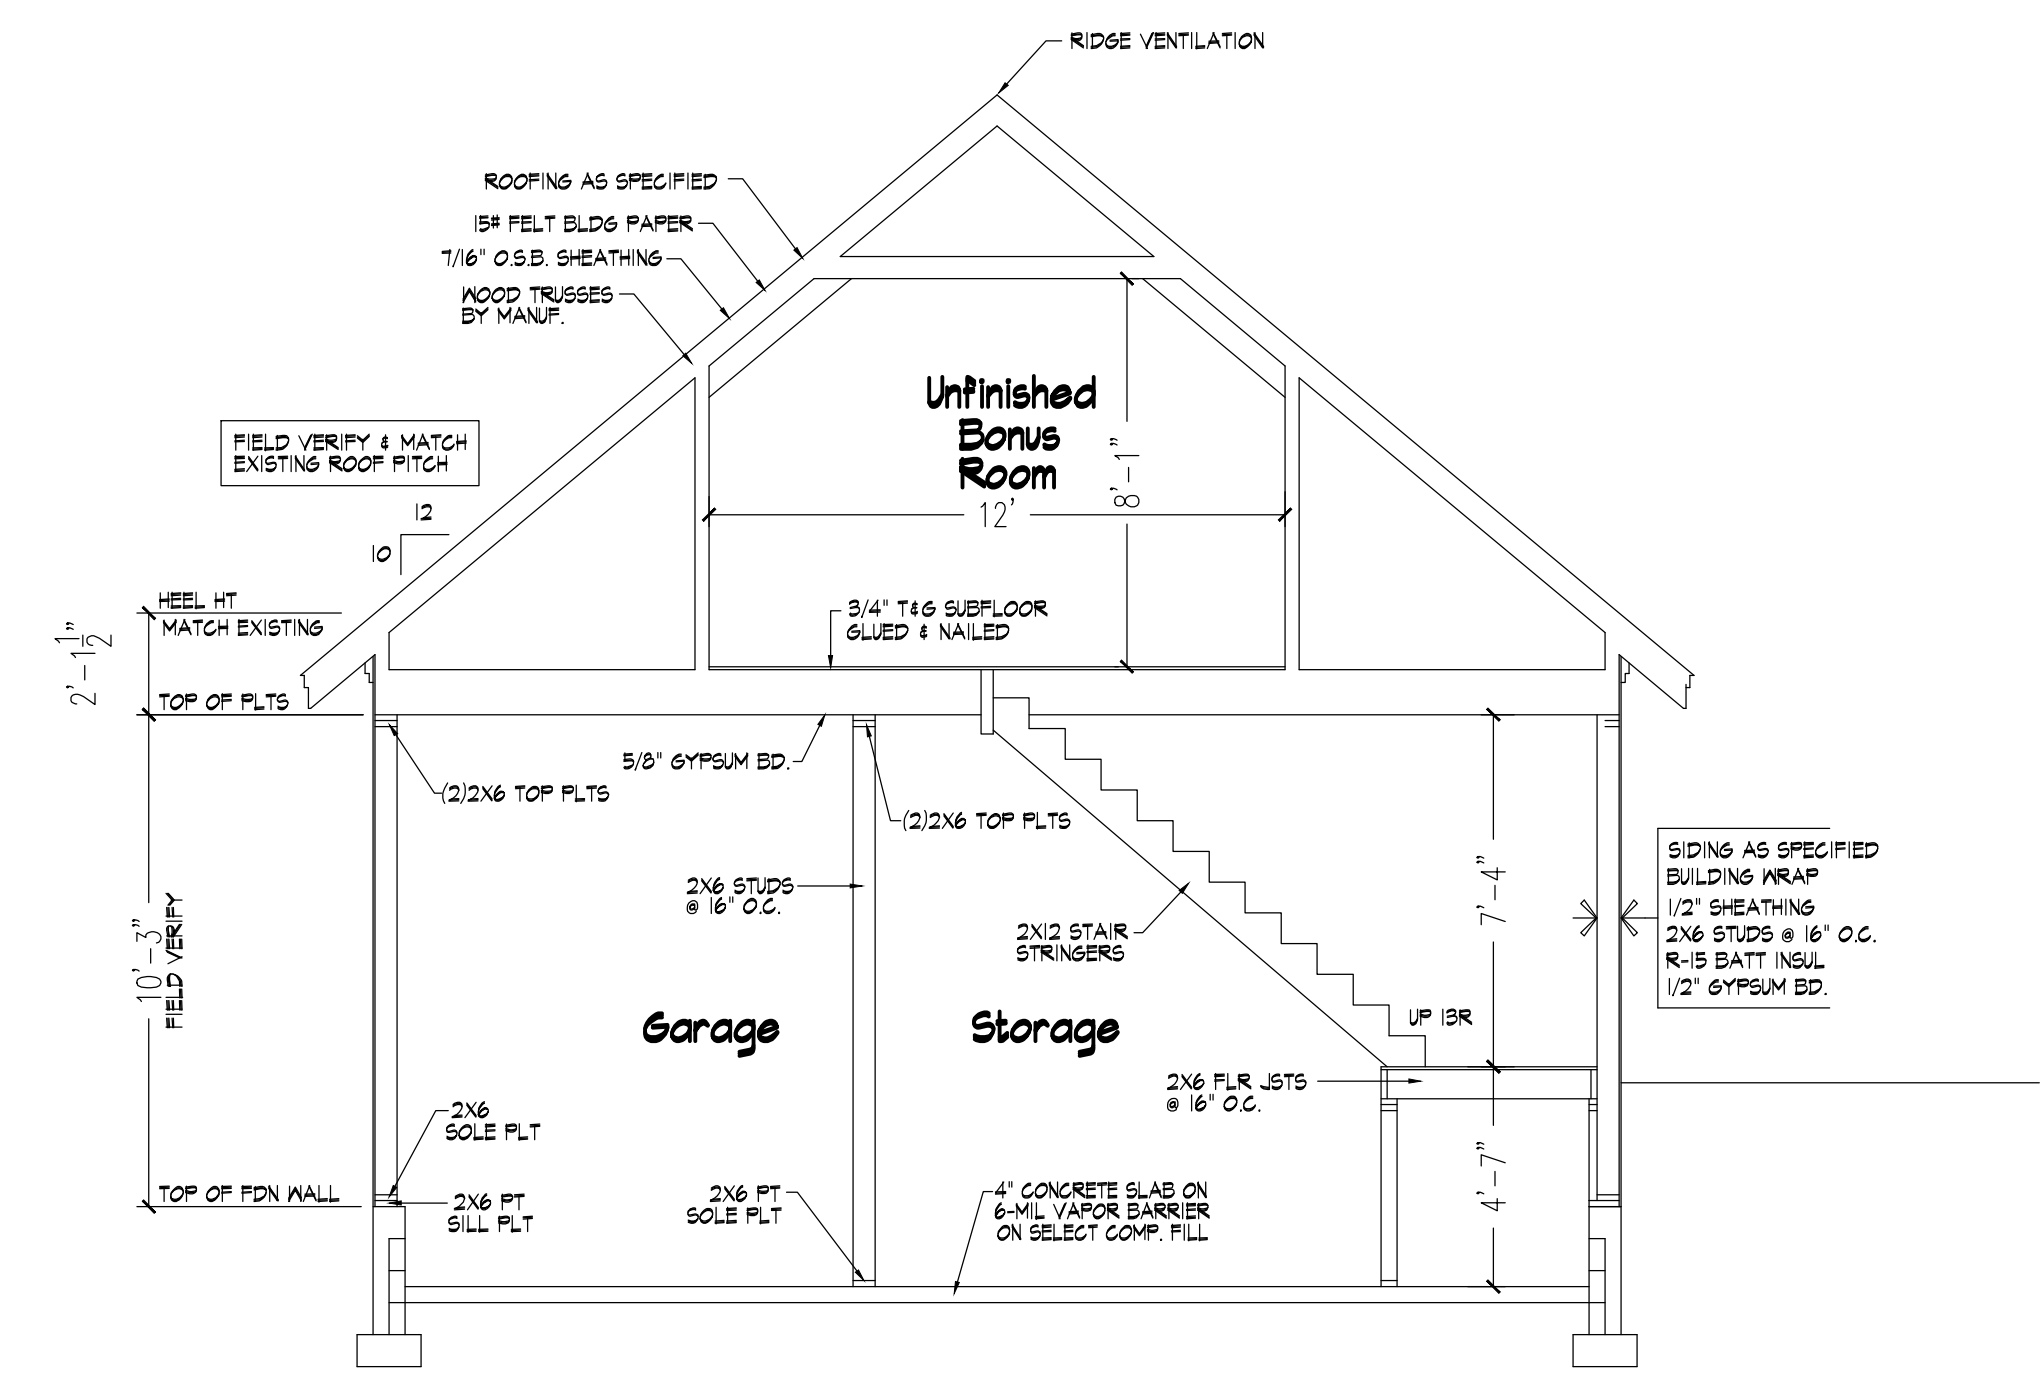

604 Building Section
Scale: 1/4" = 1'-0"

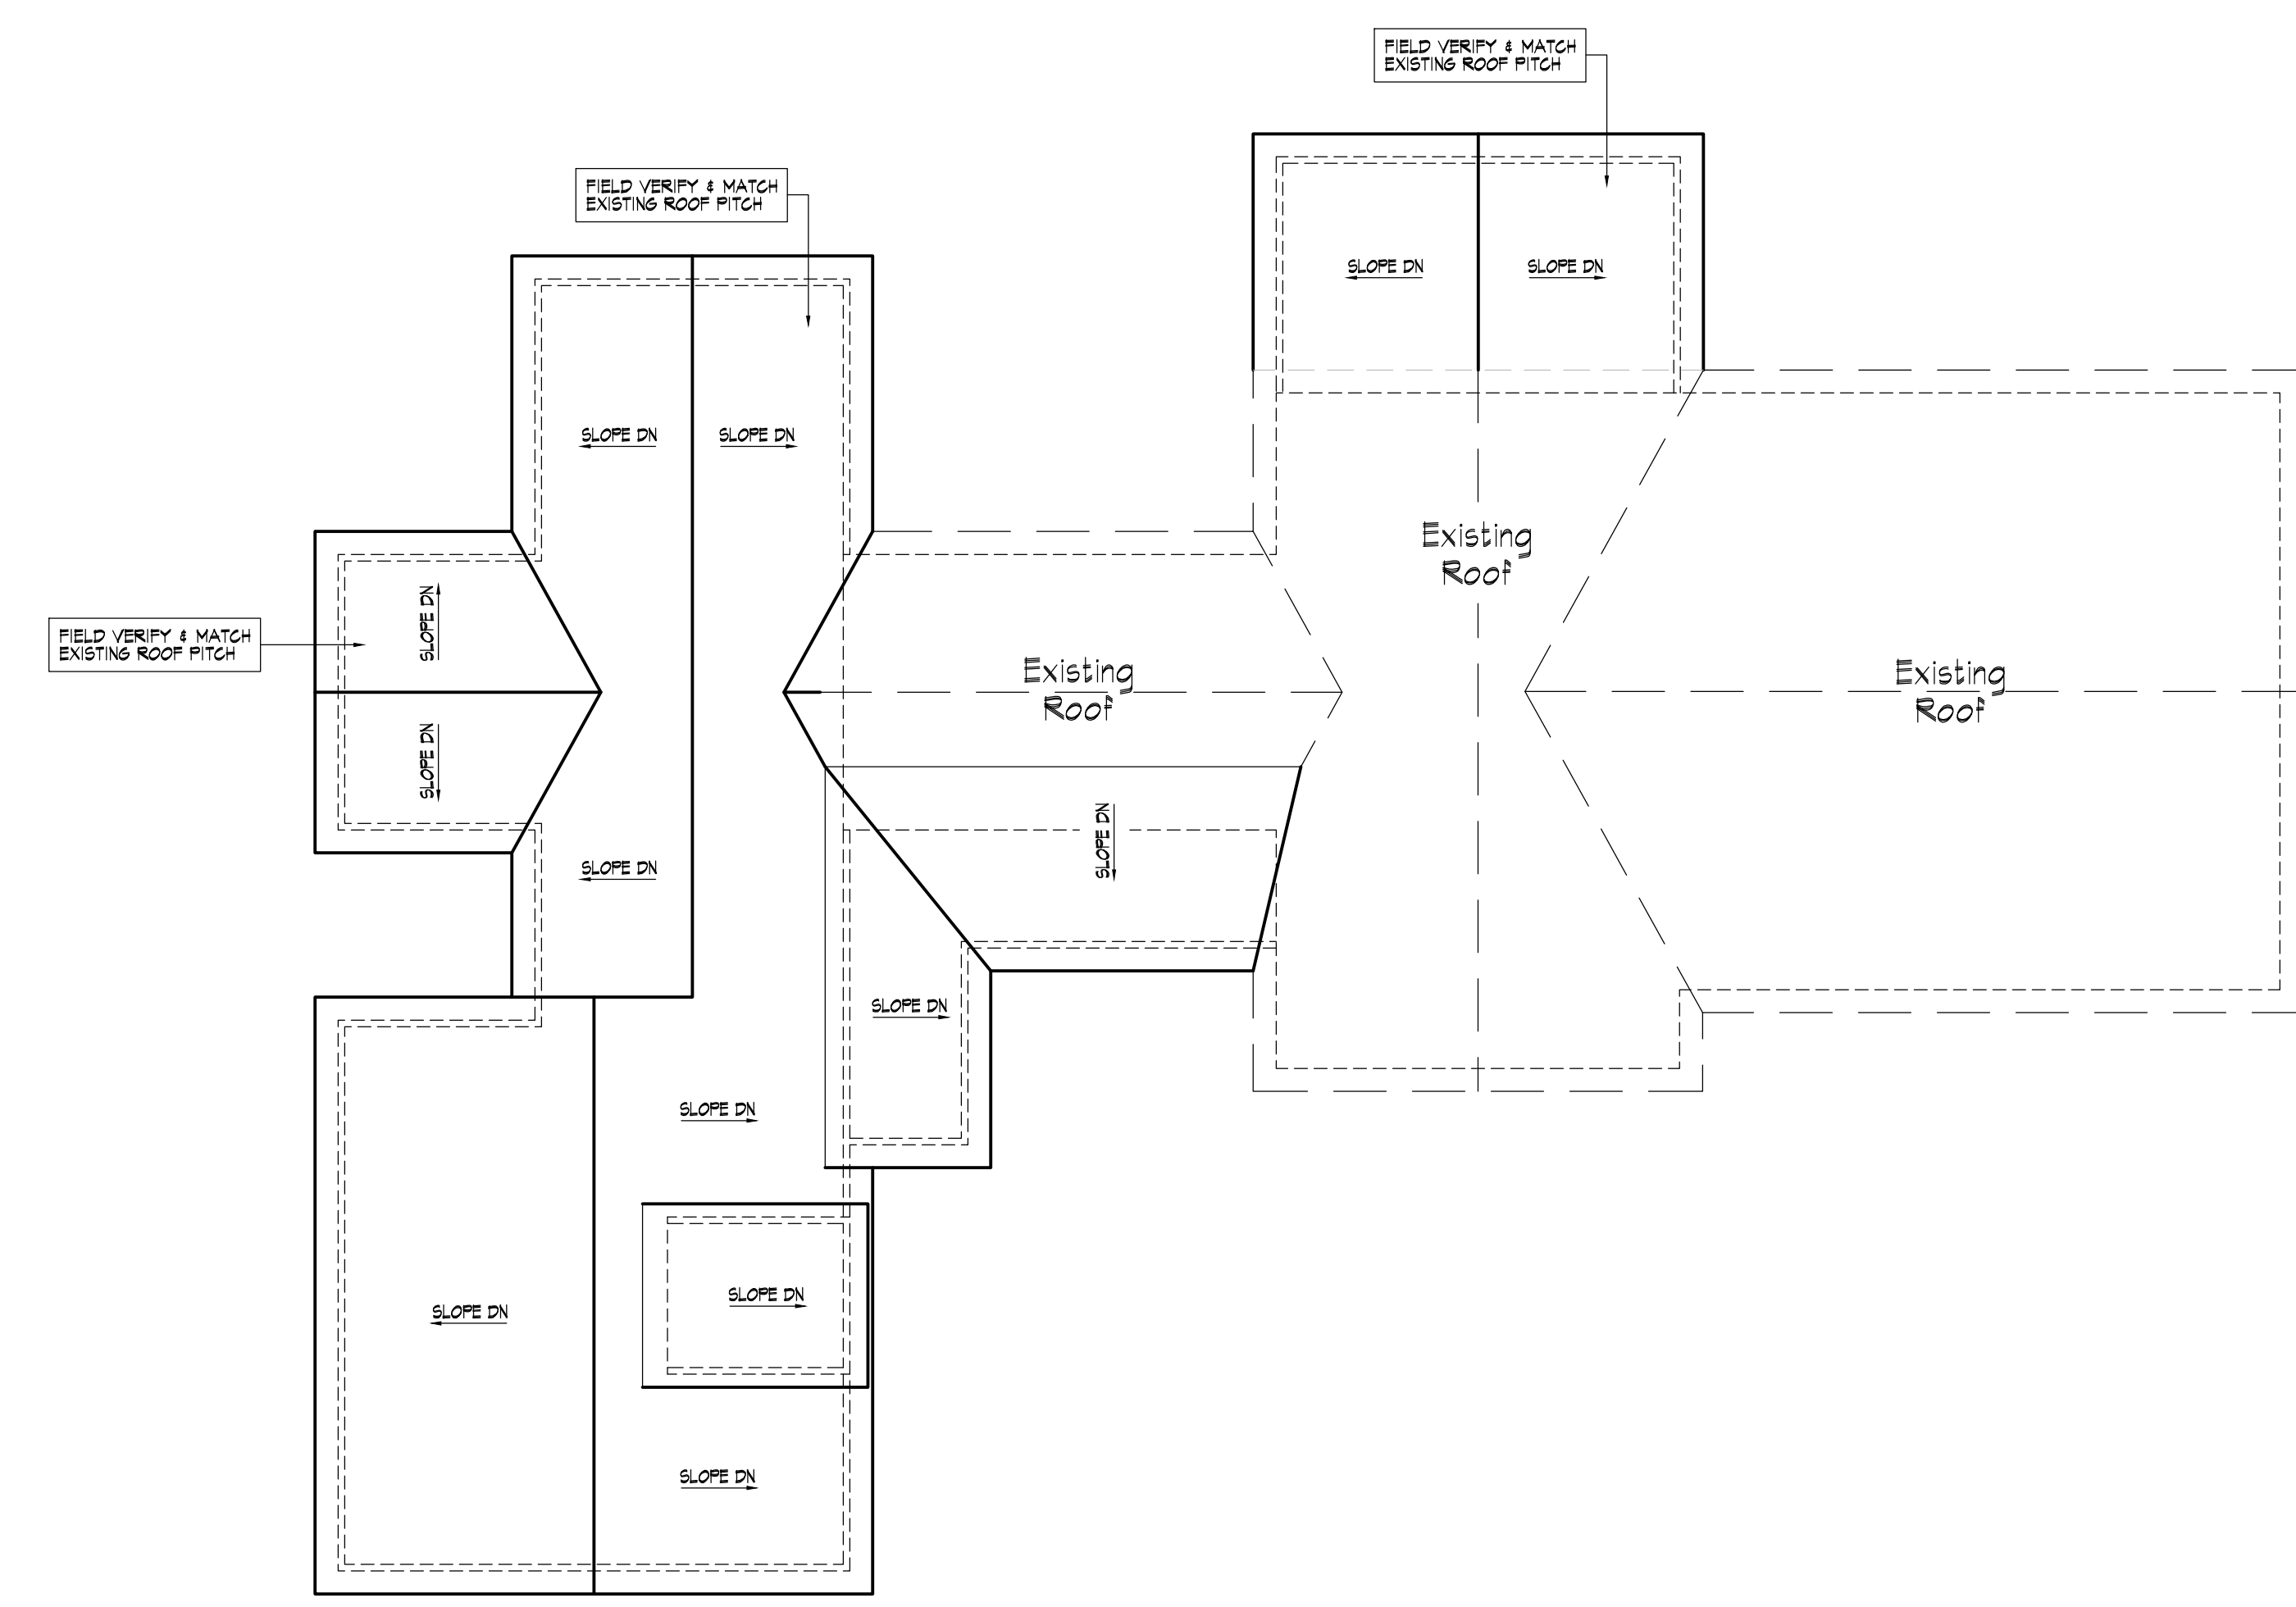


605 Roof Plan
Scale: 1/8" = 1'-0"

Revisions

NOTE TO CLIENT/CONTRACTOR
THE DESIGNERS HAVE MADE EVERY ATTEMPT TO INSURE THAT THESE DRAWINGS MEET OR EXCEED ALL STATE AND LOCAL CODES. THE CLIENT/CONTRACTOR SHALL VERIFY ALL DIMENSIONS, AND SIZE ALL STRUCTURAL COMPONENTS. THE DESIGNERS WILL NOT ASSUME ANY LIABILITY FOR ERRORS ONCE CONSTRUCTION BEGINS.

Scale:
as shown
Date:
August 2023

Sheet No.

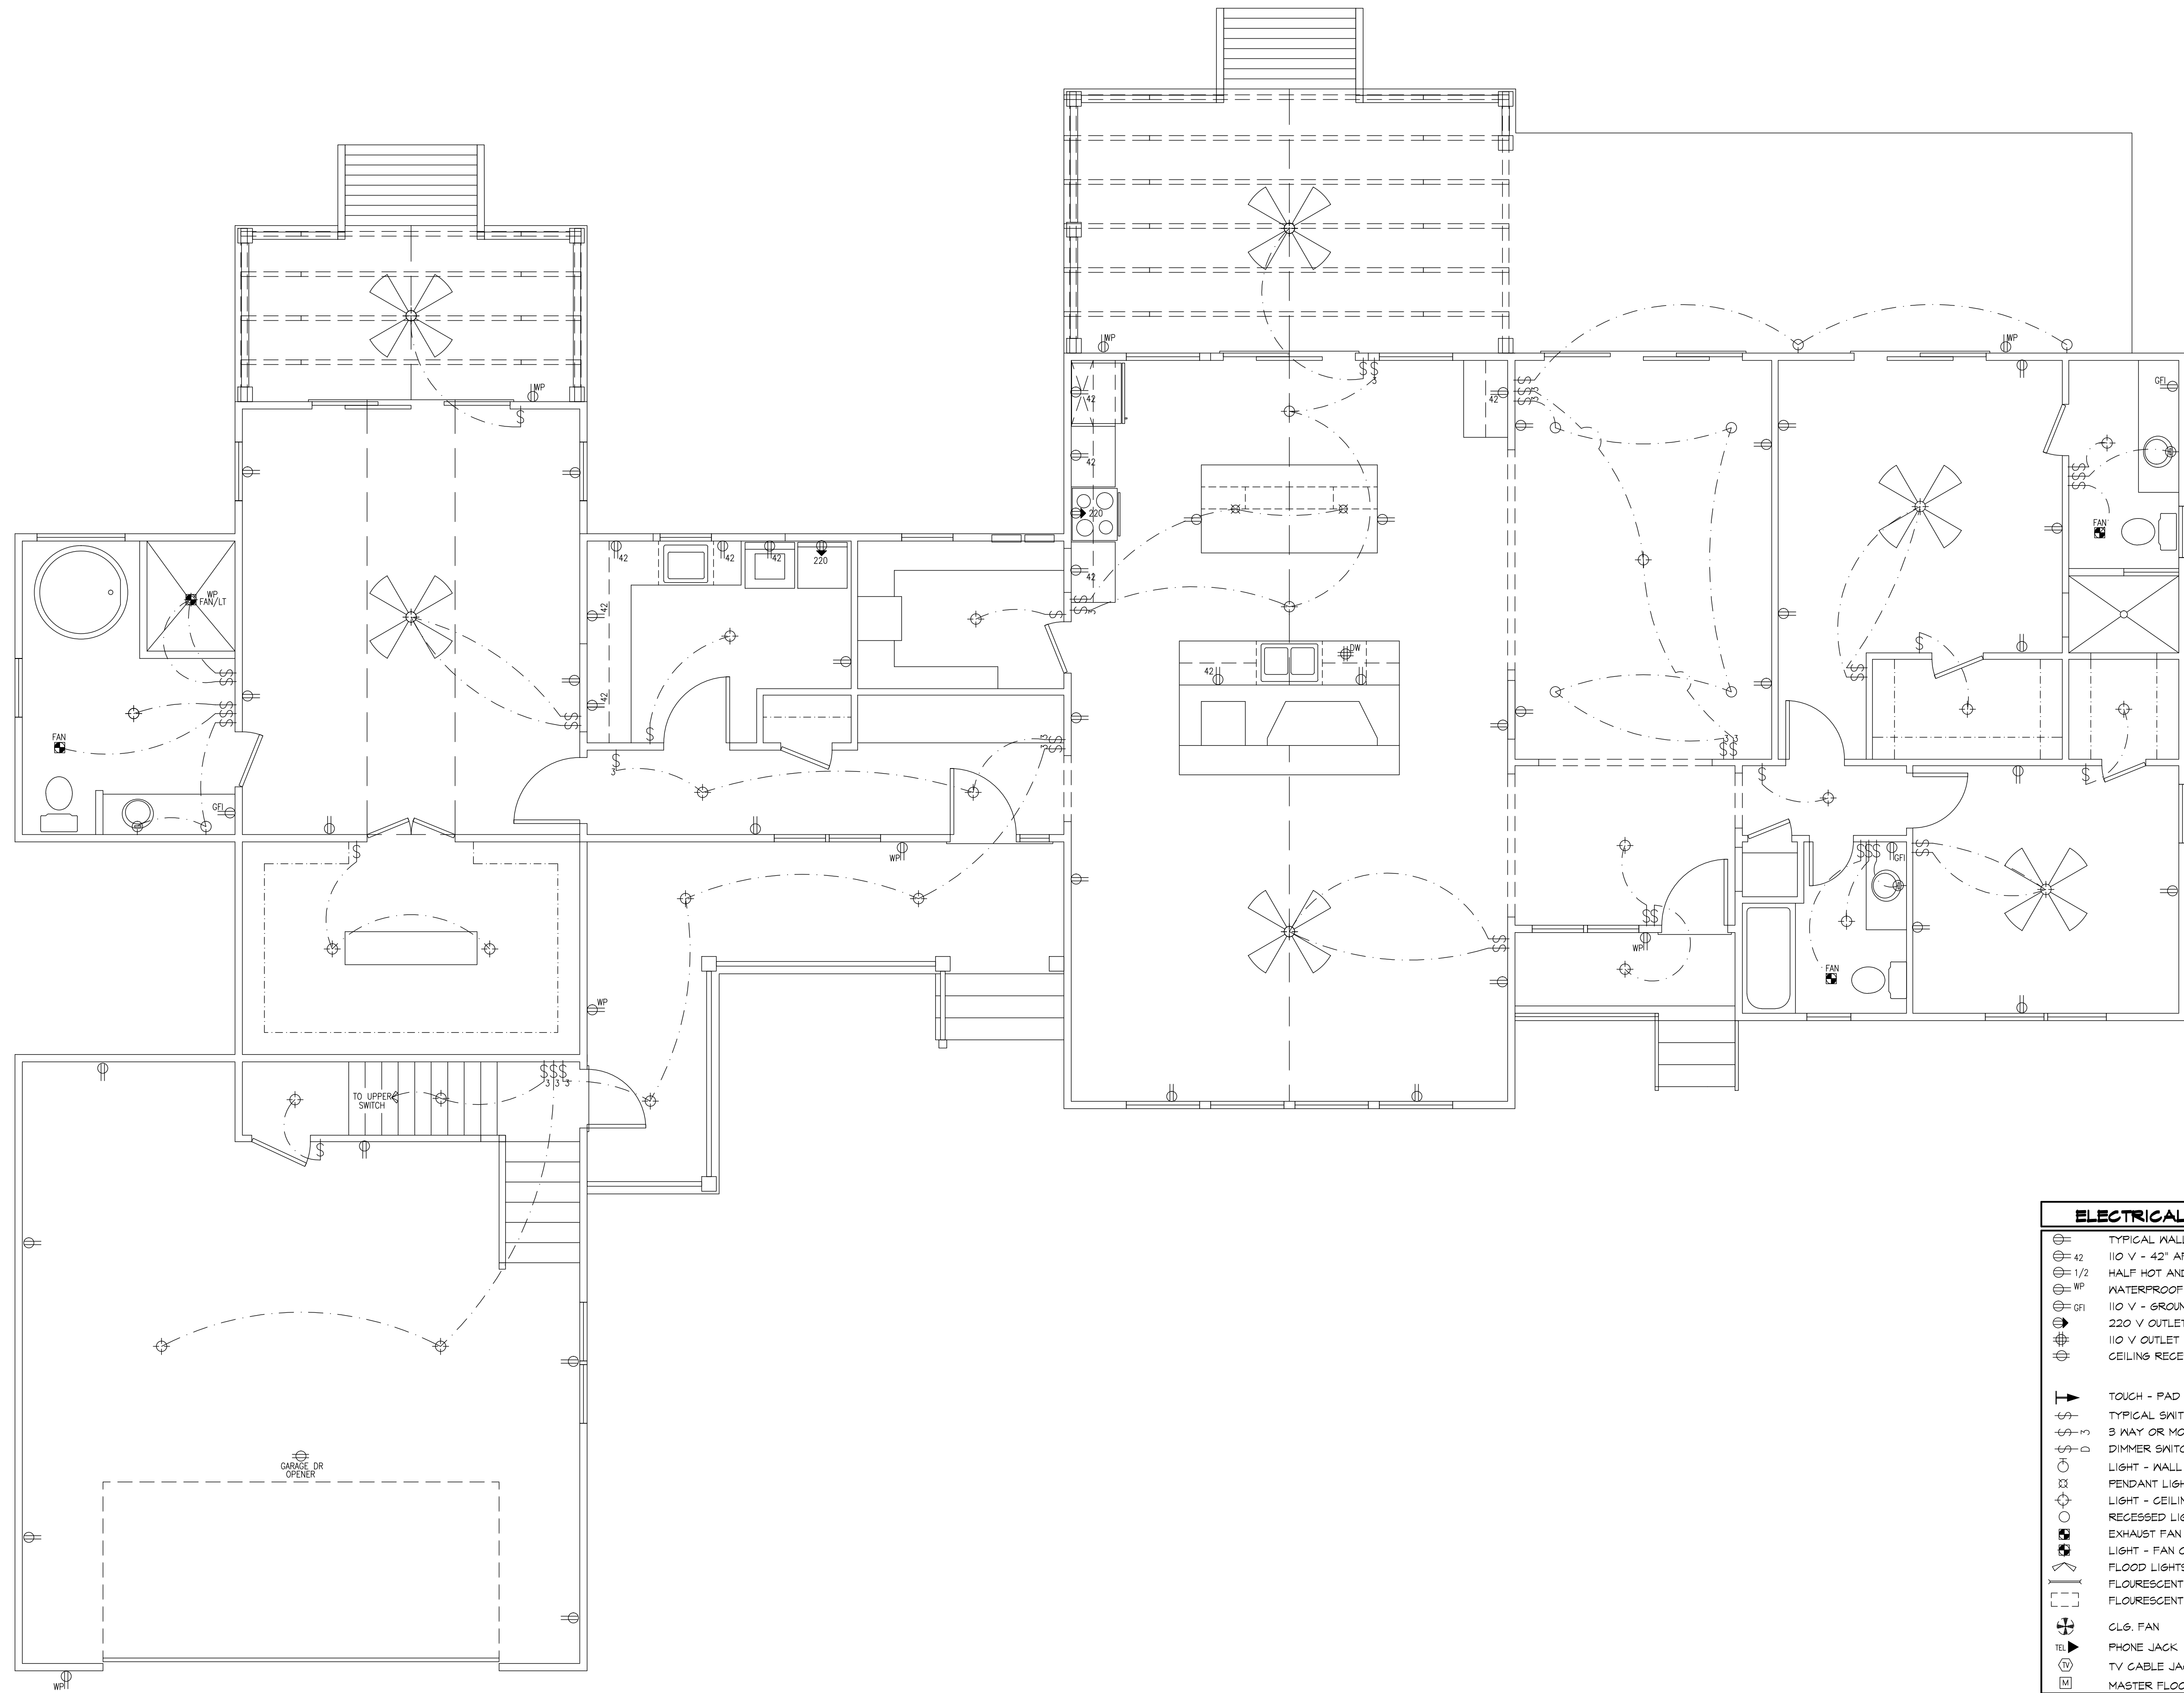

101 Electrical Floor Plan
 Scale: 1/4" = 1'-0"

ELECTRICAL SYMBOLS	
	TYPICAL WALL RECEPTACLE
	110 V - 42" AFF
	HALF HOT AND HALF SWITCHED
	WATERPROOF RECEPTACLE
	110 V - GROUND FAULT
	220 V OUTLET
	110 V OUTLET - FLOOR MOUNT
	CEILING RECEPTACLE
	TOUCH - PAD
	TYPICAL SWITCH
	3 WAY OR MORE (SEE PLAN)
	DIMMER SWITCH
	LIGHT - WALL MOUNT
	PENDANT LIGHT - CEILING MOUNT
	LIGHT - CEILING MOUNT
	RECESSED LIGHT
	EXHAUST FAN
	LIGHT - FAN COMBINATION
	FLOOD LIGHTS
	FLOURESCENT TUBE
	FLOURESCENT LIGHT FIXTURE
	CL6. FAN
	PHONE JACK
	TV CABLE JACK
	MASTER FLOOD LIGHT SWITCH

Revisions

NOTE TO CLIENT/CONTRACTOR
 THE DESIGNERS HAVE MADE EVERY ATTEMPT TO INSURE THAT THESE DRAWINGS MEET OR EXCEED ALL STATE AND LOCAL CODES. THE CLIENT/CONTRACTOR SHALL VERIFY ALL DIMENSIONS, AND SIZE ALL STRUCTURAL COMPONENTS. THE DESIGNERS WILL NOT ASSUME ANY LIABILITY FOR ERRORS ONCE CONSTRUCTION BEGINS.

Scale:
 as shown
 Date:
 August 2023

Sheet No.