






FRONT ELEVATION
SCALE: 1/4" = 1'

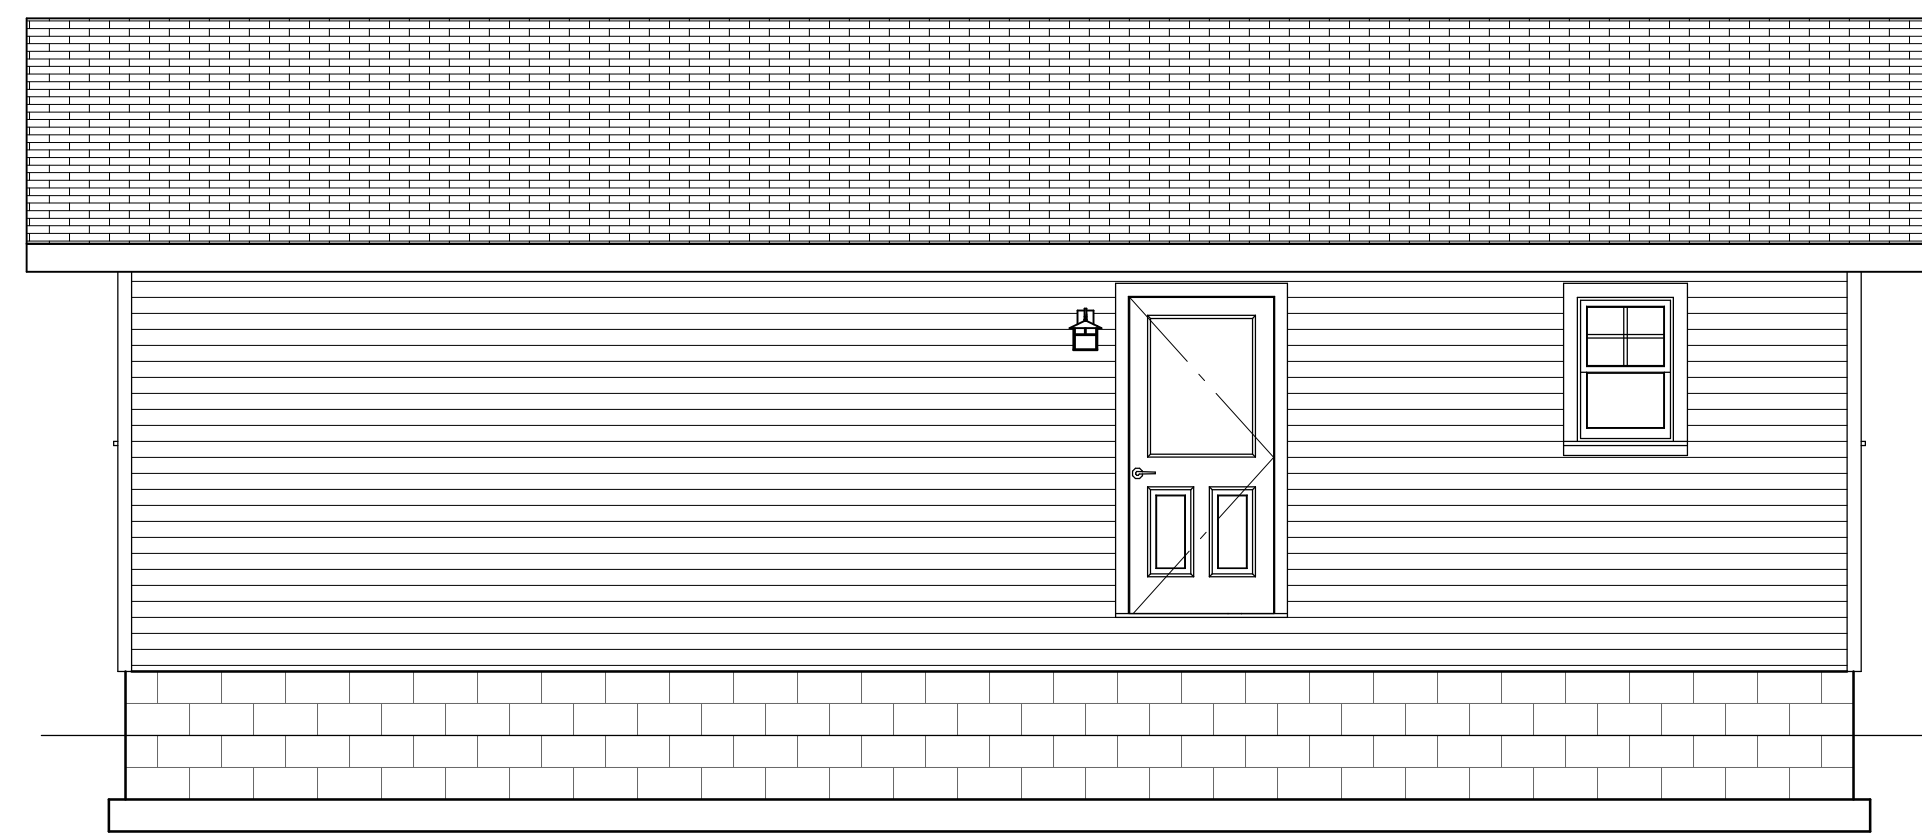


REAR ELEVATION
SCALE: 1/4" = 1'

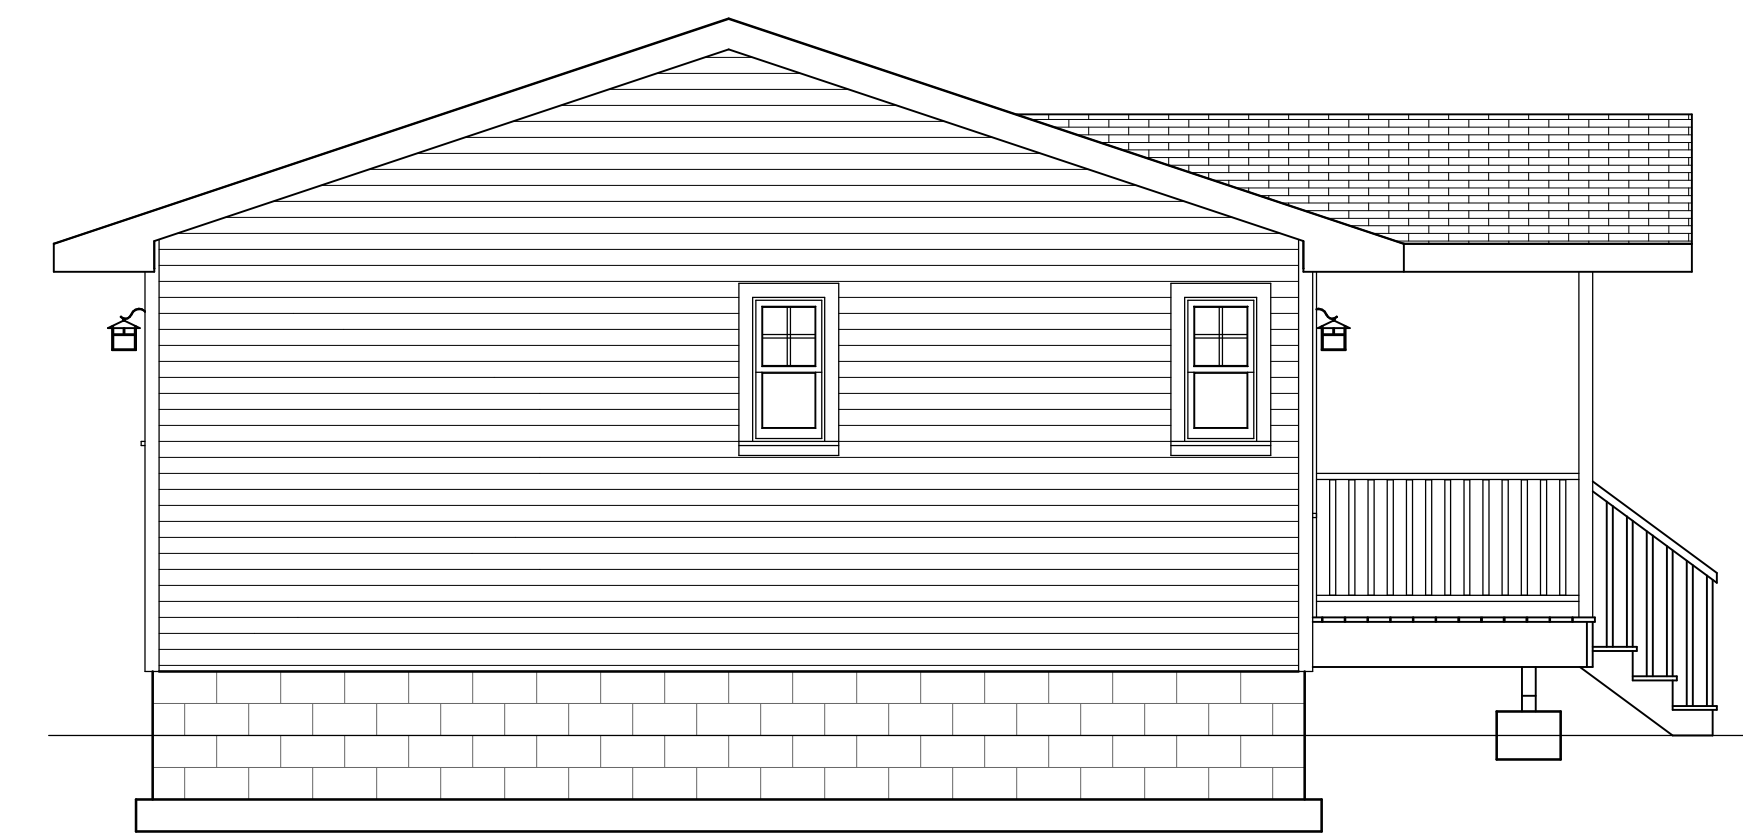


LEFT ELEVATION
SCALE: 1/4" = 1'

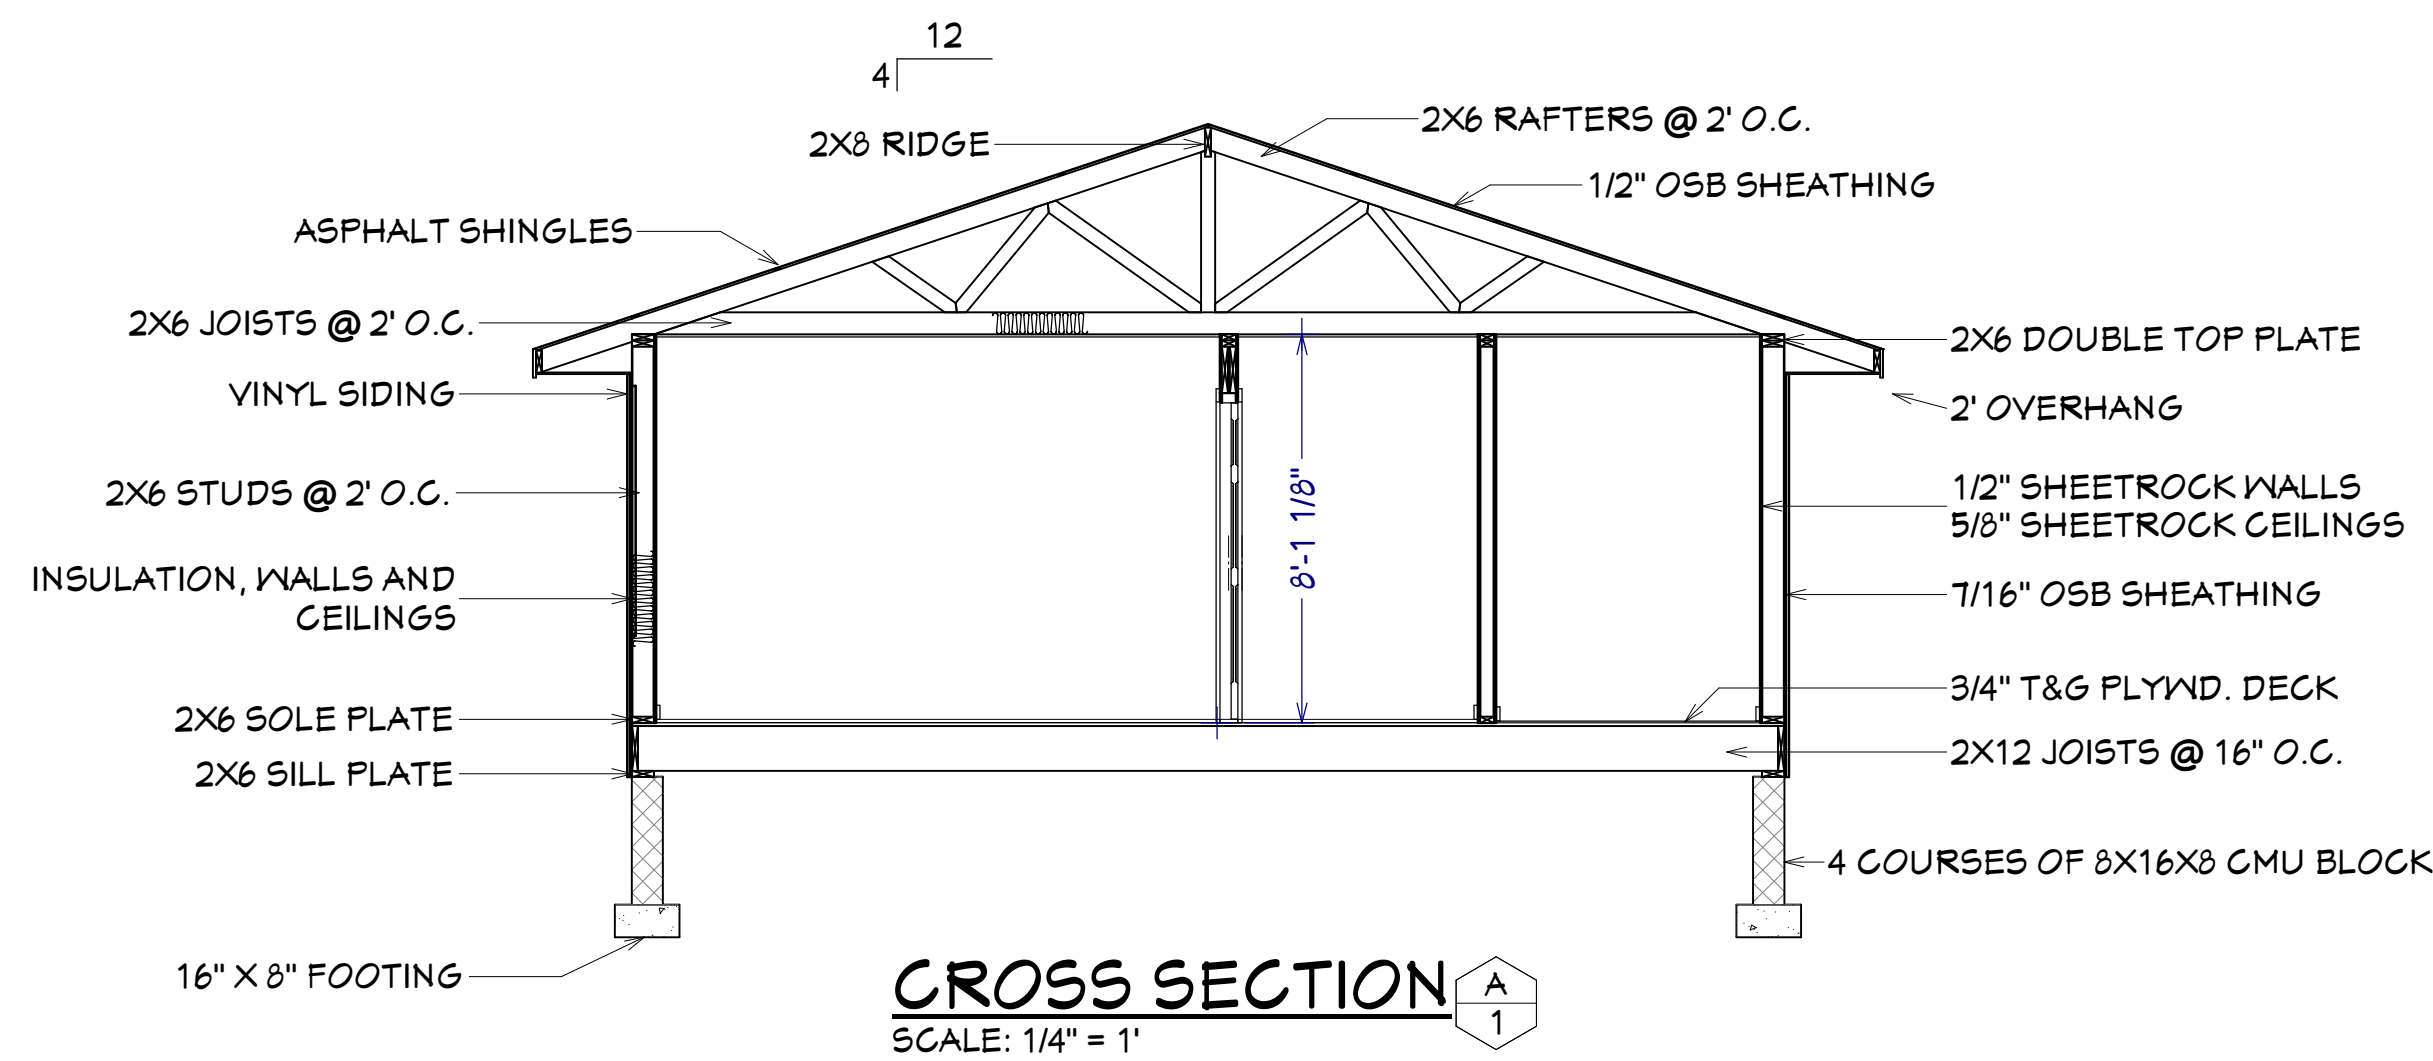

CROSS SECTION
SCALE: 1/4" = 1'

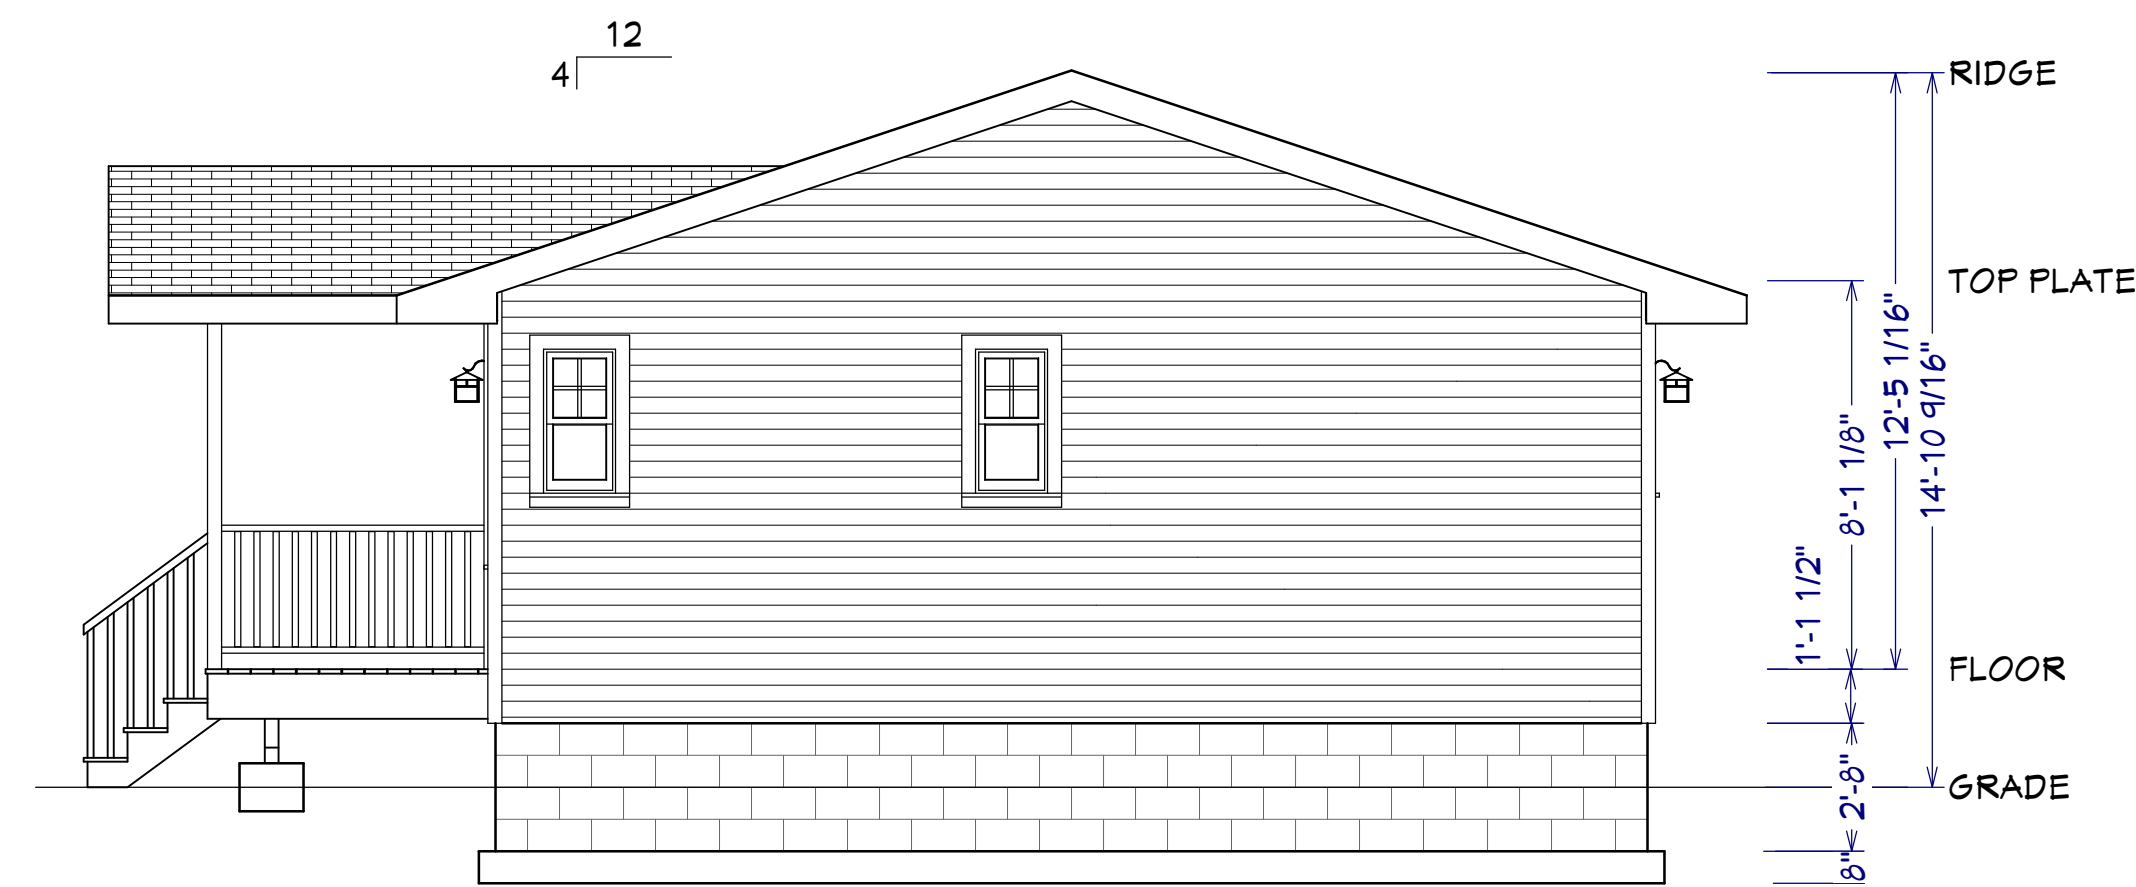

RIGHT ELEVATION
SCALE: 1/4" = 1'

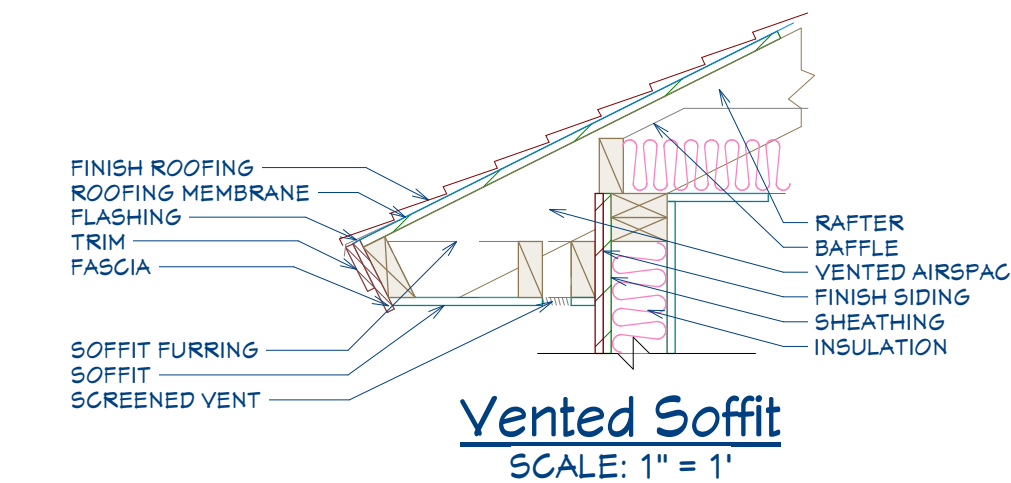

Vented Soffit
SCALE: 1" = 1'

36x24 House #36X24H1D

SQUARE FEET: 864
WIDTH: 36'
DEPTH: 32'-6" (including porch and steps)
EXTERIOR WALL STRUCTURE: 2X6 STUDS

BUILDING CONTRACTOR/HOME OWNER TO REVIEW AND VERIFY ALL DIMENSIONS, AND SPECS BEFORE CONSTRUCTION BEGINS. BUILDING TO BE BUILT AS PER LOCAL CODE REQUIREMENTS.

To the best of my knowledge these plans are drawn to comply with owner's and/ or builder's specifications and any changes made on them after prints are made will be done at the owner's and / or builder's expense and responsibility. The contractor shall verify all dimensions and enclosed drawing. E.F.P. is not liable for errors. While every effort has been made in the preparation of this plan to avoid mistakes, the maker cannot guarantee against human error. The contractor of the job must check all dimensions and other details prior to construction and be solely responsible thereafter. All calculations and member sizing should be verified for your building by a certified building official.





These plans were not prepared by nor checked by a licensed architect and/or engineer. E.F.P. does not represent or imply itself to be a licensed architect and/or licensed engineer. Enjoy these plans but use them at your own risk. Resale of these plans, in whole or part, is strictly prohibited.


Excellent Floor Plans
<https://sites.google.com/excellentfloorplans>
<https://www.ebay.com/str/excellentfloorplans>
<https://excellentfloorplans.etsy.com>

DOOR SCHEDULE					
NUMBER	LABEL	QTY	FLOOR	SIZE	COMMENTS
D01	D01-4068	1	1	4068	
D02	D02-2668	6	1	2668	
D03	D03-3068	2	1	3068	

WINDOW SCHEDULE						
NUMBER	LABEL	QTY	FLOOR	SIZE	DESCRIPTION	COMMENTS
W01	W01-1630	4	1	1630	DOUBLE HUNG	
W02	W02-2030	1	1	2030	DOUBLE HUNG	
W03	W03-2646	6	1	2646	DOUBLE HUNG	

 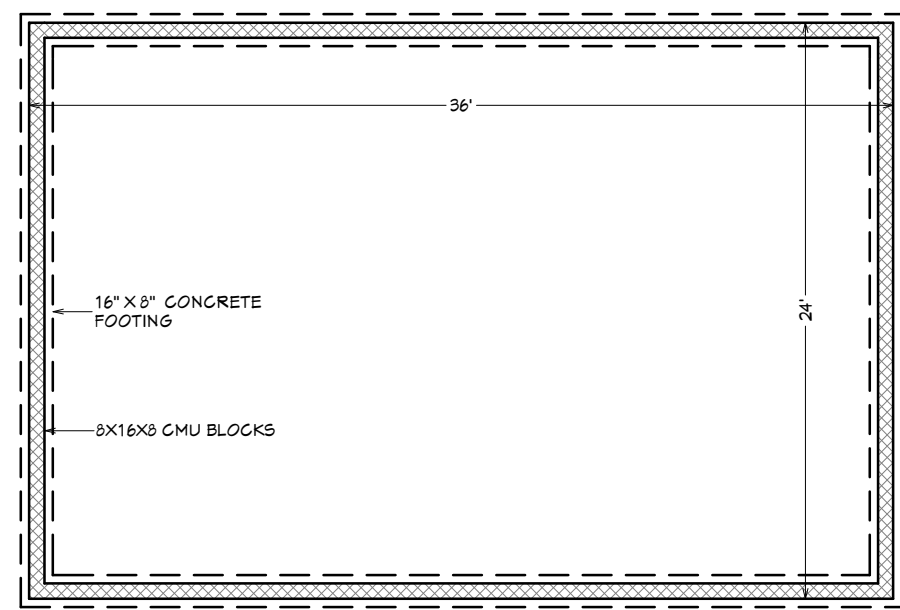


FOUNDATION PLAN
SCALE: 1/8" = 1'

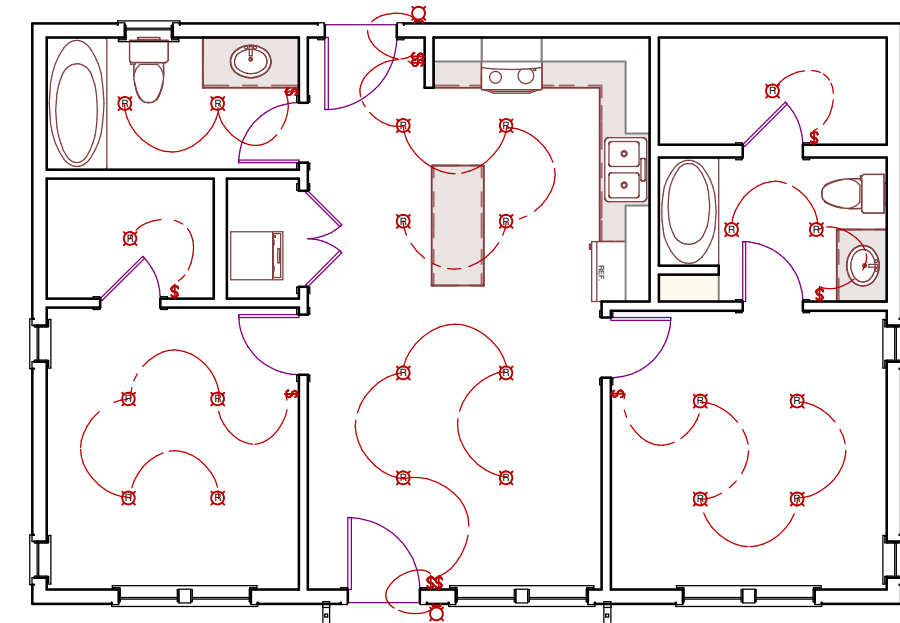


LIGHTING PLAN
SCALE: 1/8" = 1'

ALL WIRING TO BE INSTALLED AS PER ACTUAL JOBSITE CONDITIONS, ELECTRICAL CODE AND HOME OWNER OR INTERIOR LIGHTING CONSULTANT. SHOWN IS SUGGESTED PLACEMENT OF LIGHTING AND SWITCHING AND MUST BE APPROVED BY HOMEOWNER PRIOR TO WORK.

- Ⓜ RECESSED DOWN LIGHT
- Ⓞ PORCH LANTERN

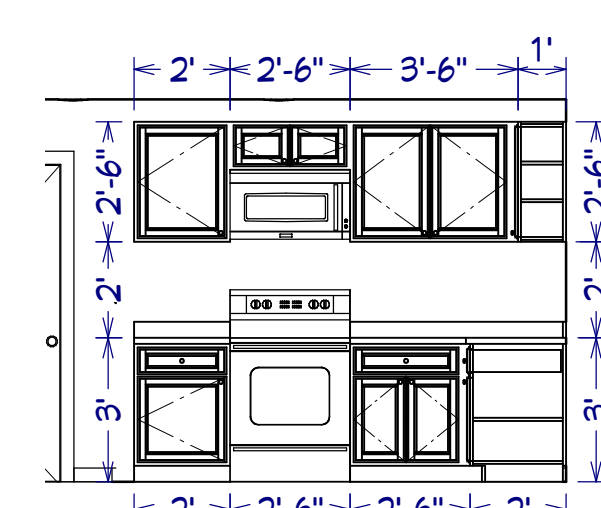


CABINET ELEVATION A
SCALE: 1/4" = 1'

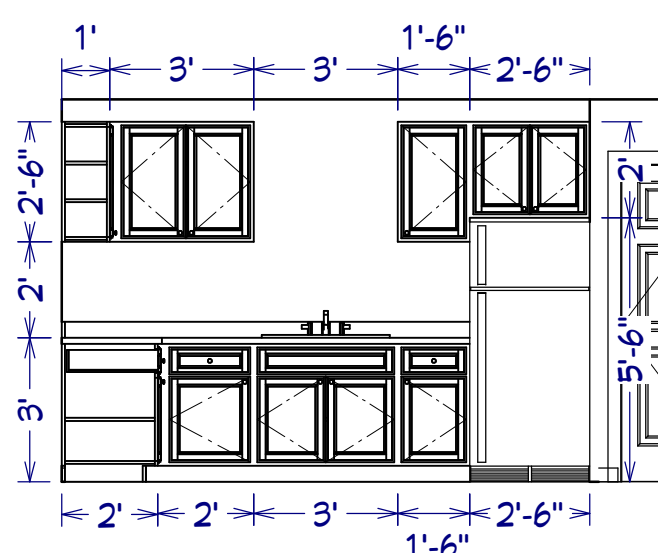


CABINET ELEVATION B
SCALE: 1/4" = 1'




CABINET ELEVATION C
SCALE: 1/4" = 1'

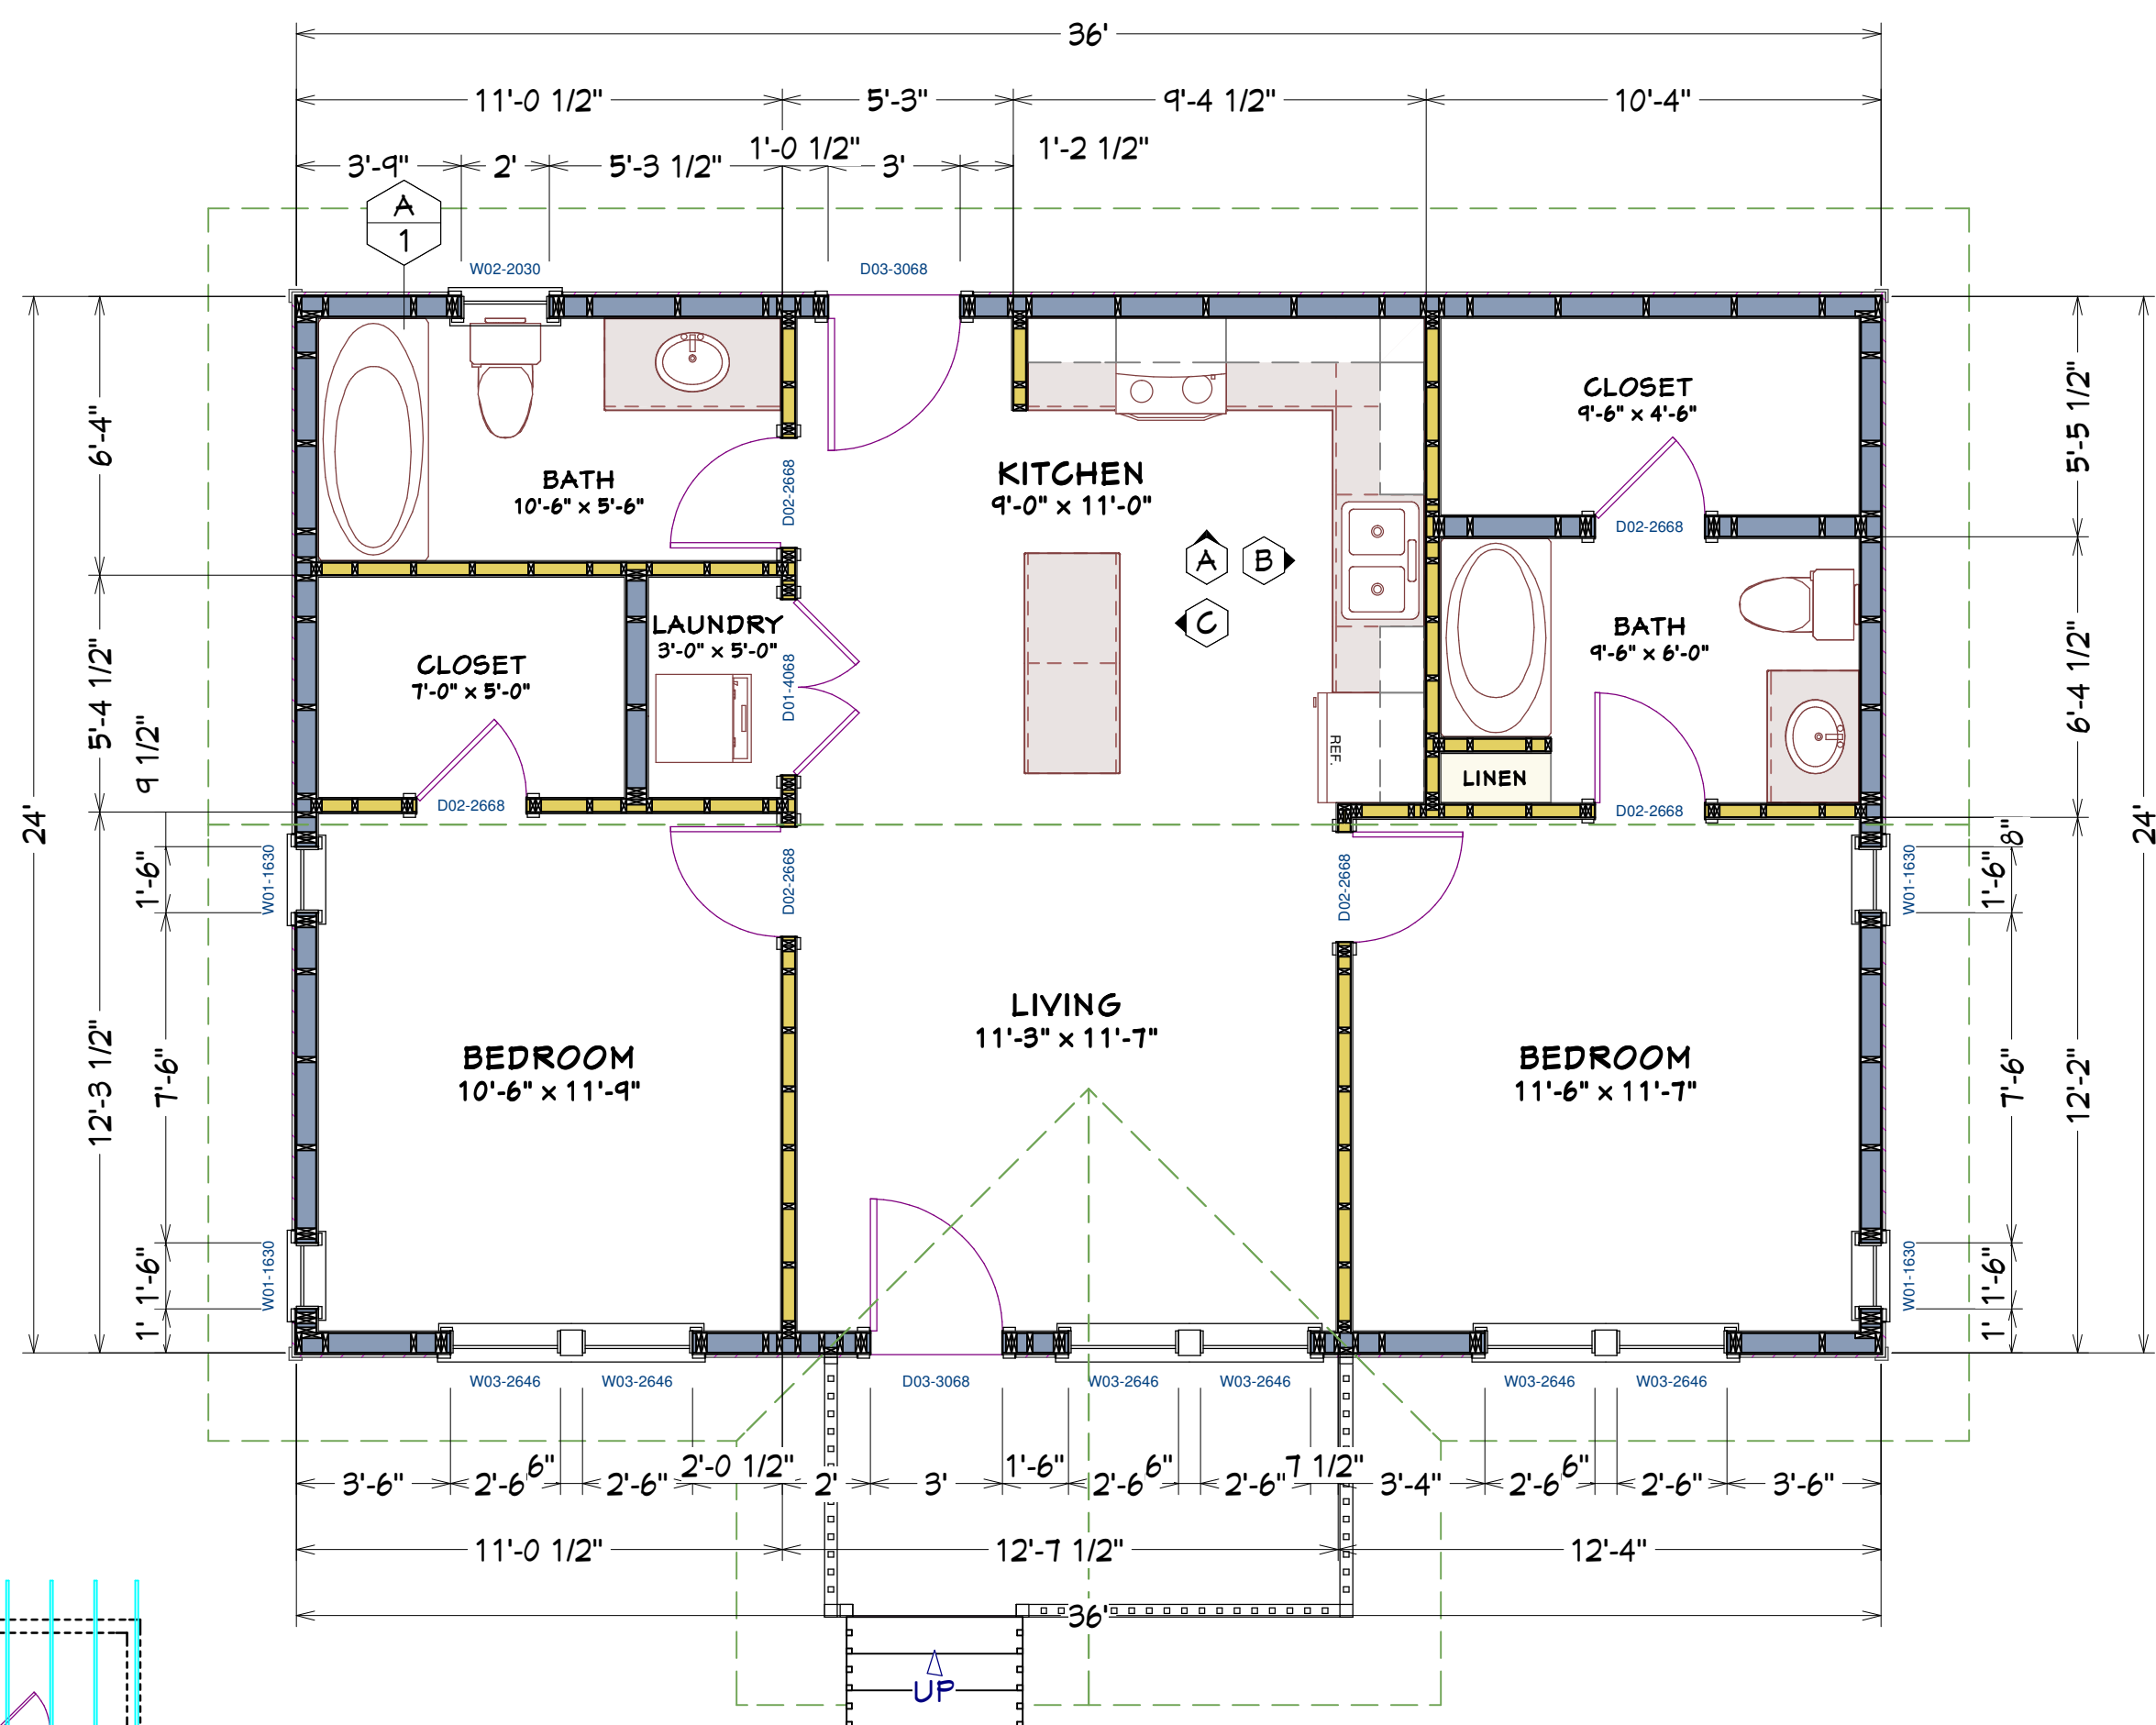


MAIN FLOOR PLAN
SCALE: 1/4" = 1'

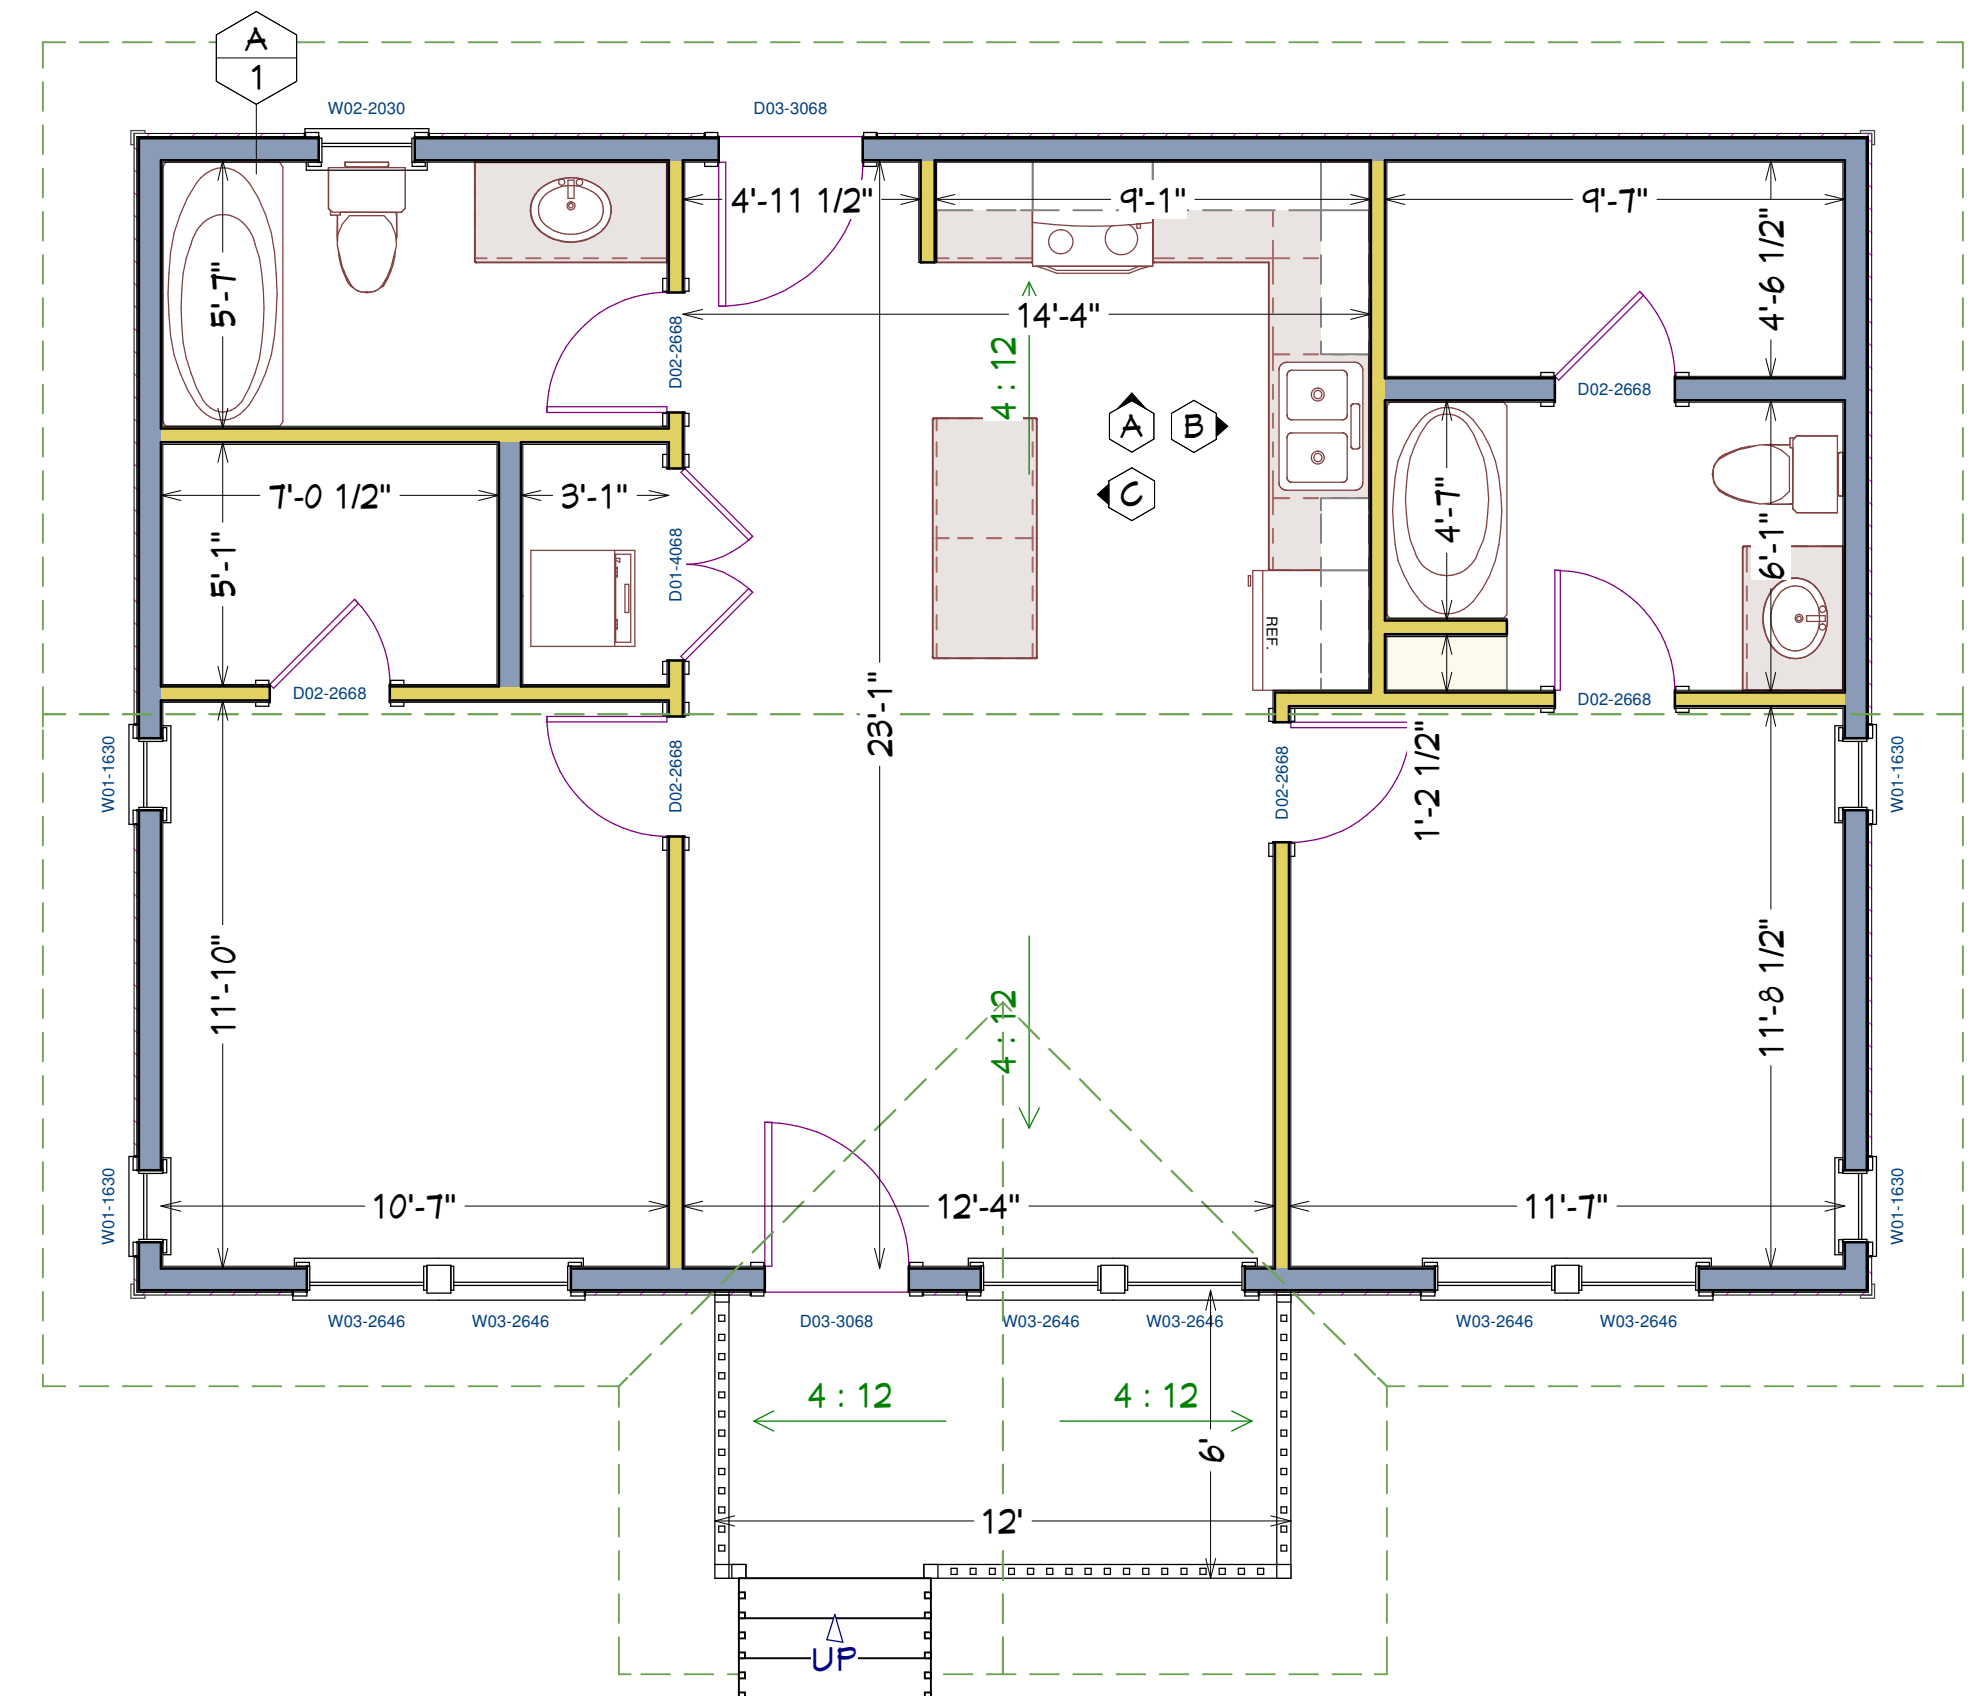

MAIN FLOOR PLAN
SCALE: 1/4" = 1'

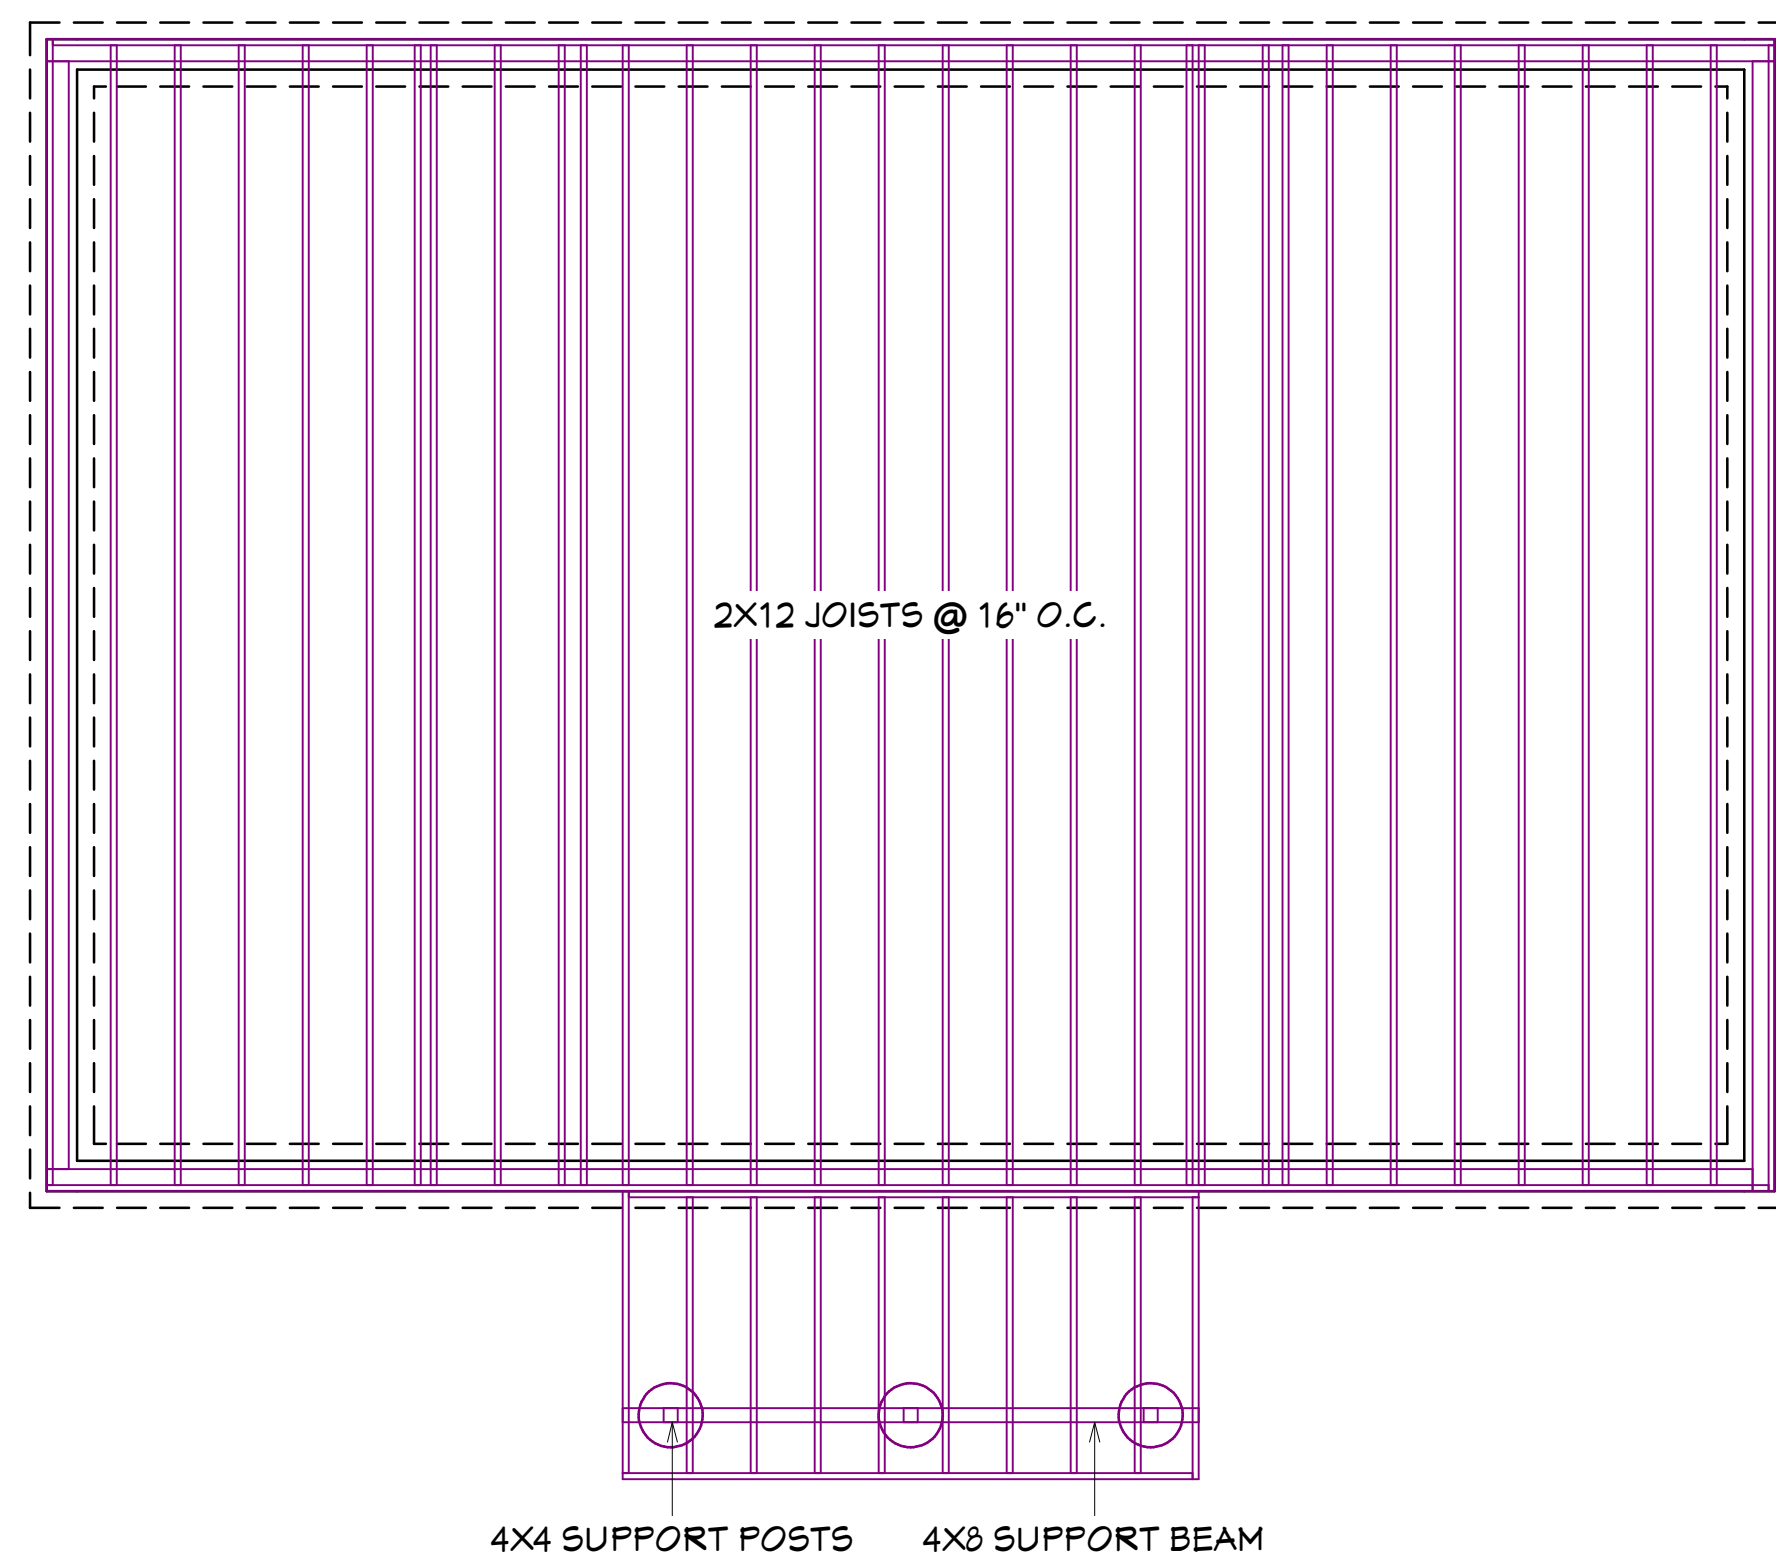

FLOOR FRAMING PLAN
SCALE: 1/4" = 1'

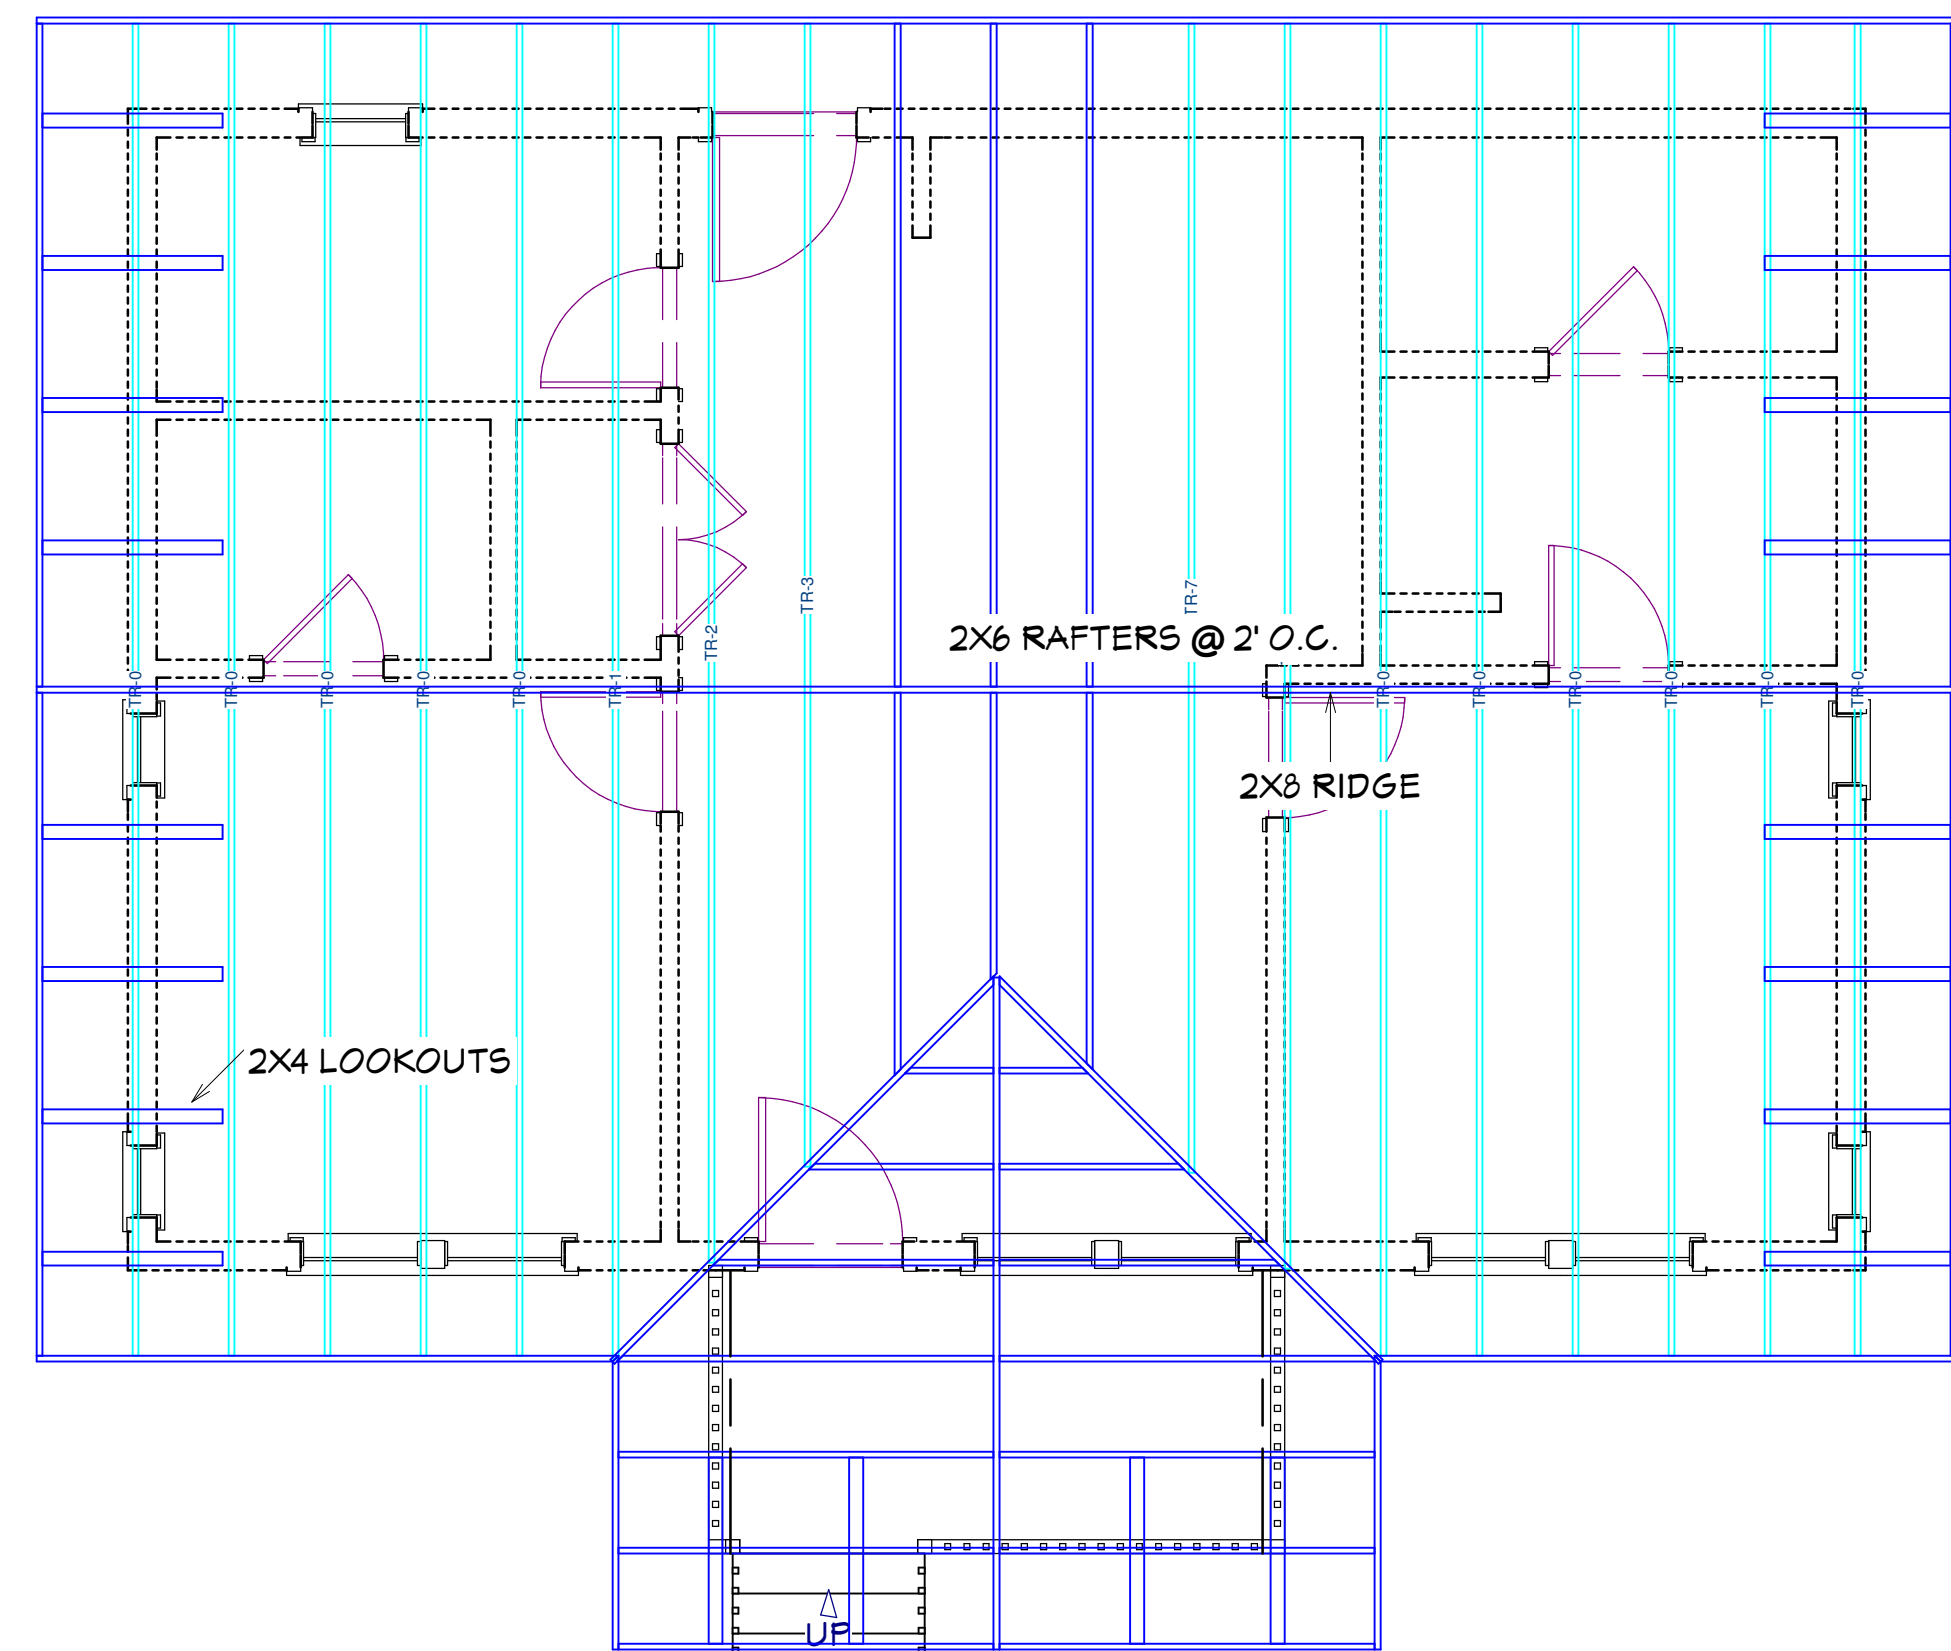

ROOF FRAMING PLAN
SCALE: 1/4" = 1'


36x24 House
#36X24H1D

These plans were not prepared by nor checked by a licensed architect and/or engineer. E. F. P. does not represent or imply itself to be a licensed architect and/or licensed engineer. Enjoy these plans but use them at your own risk. Resale of these plans, in whole or part, is strictly prohibited.


Excellent Floor Plans
<https://sites.google.com/excellentfloorplans>
<https://www.ebay.com/str/excellentfloorplans>
<https://excellentfloorplans.etsy.com>

IDEAS

36x24 House
#36X24H1D

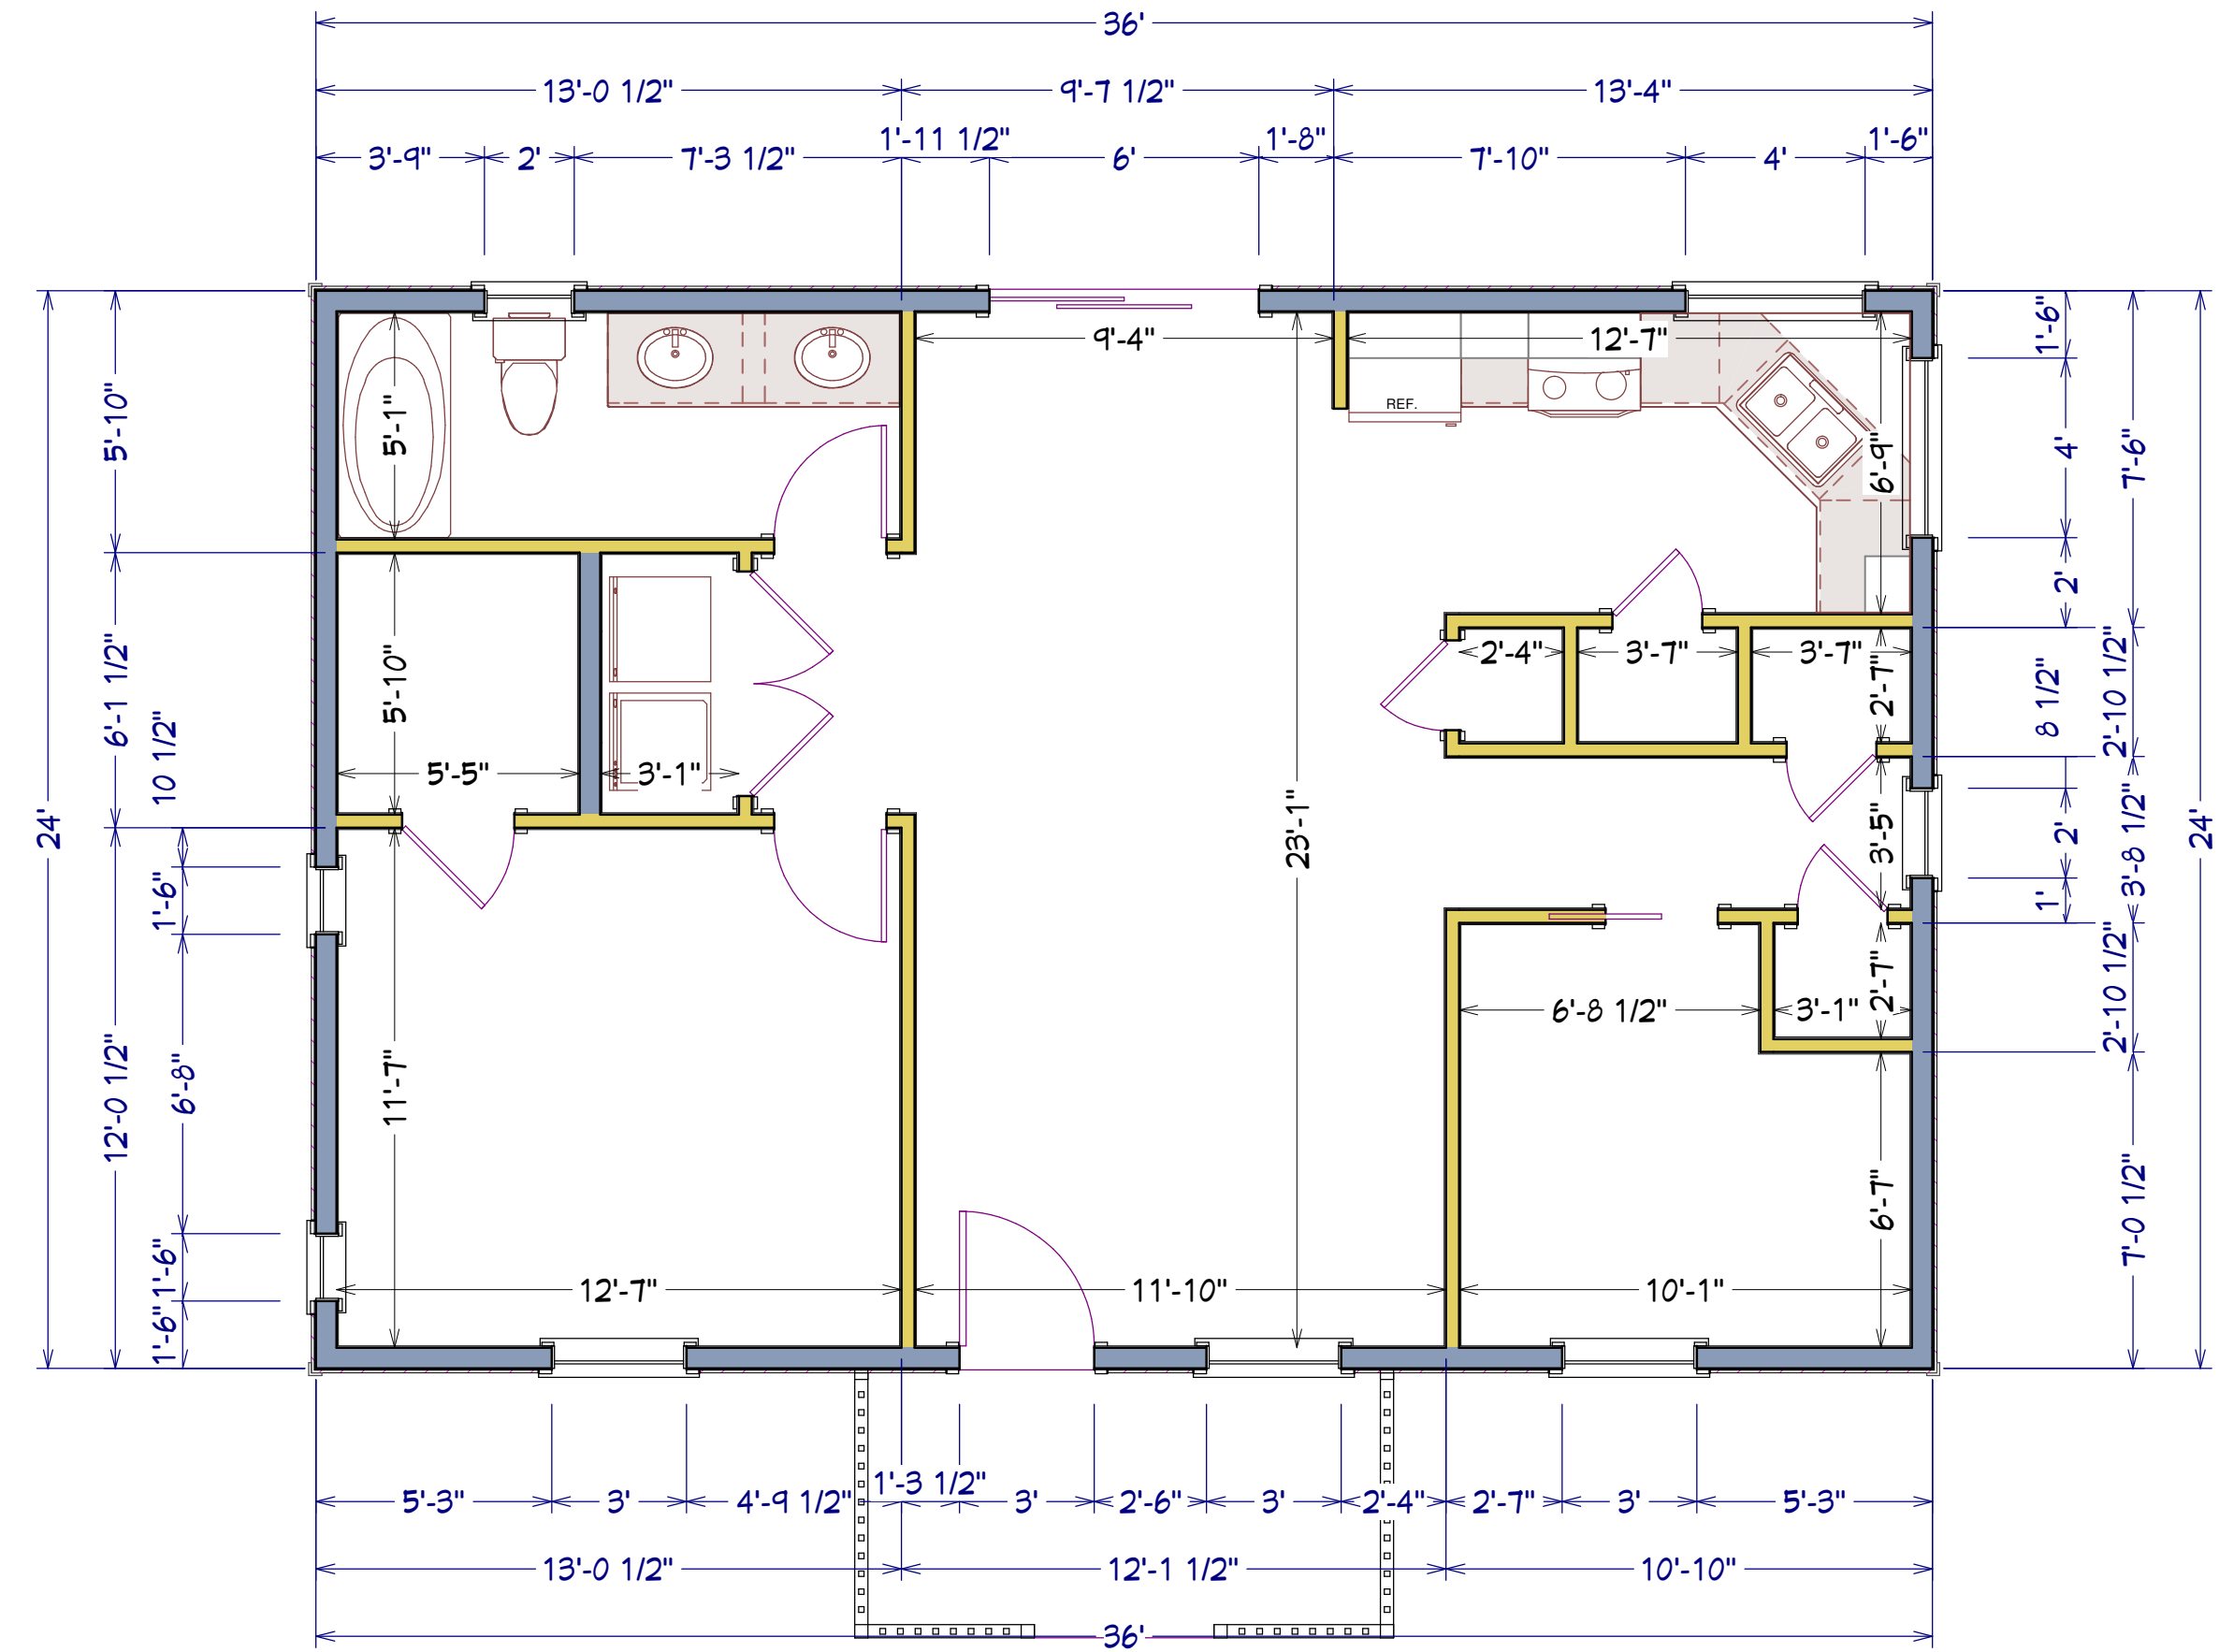

MAIN FLOOR PLAN
SCALE: 1/4" = 1'

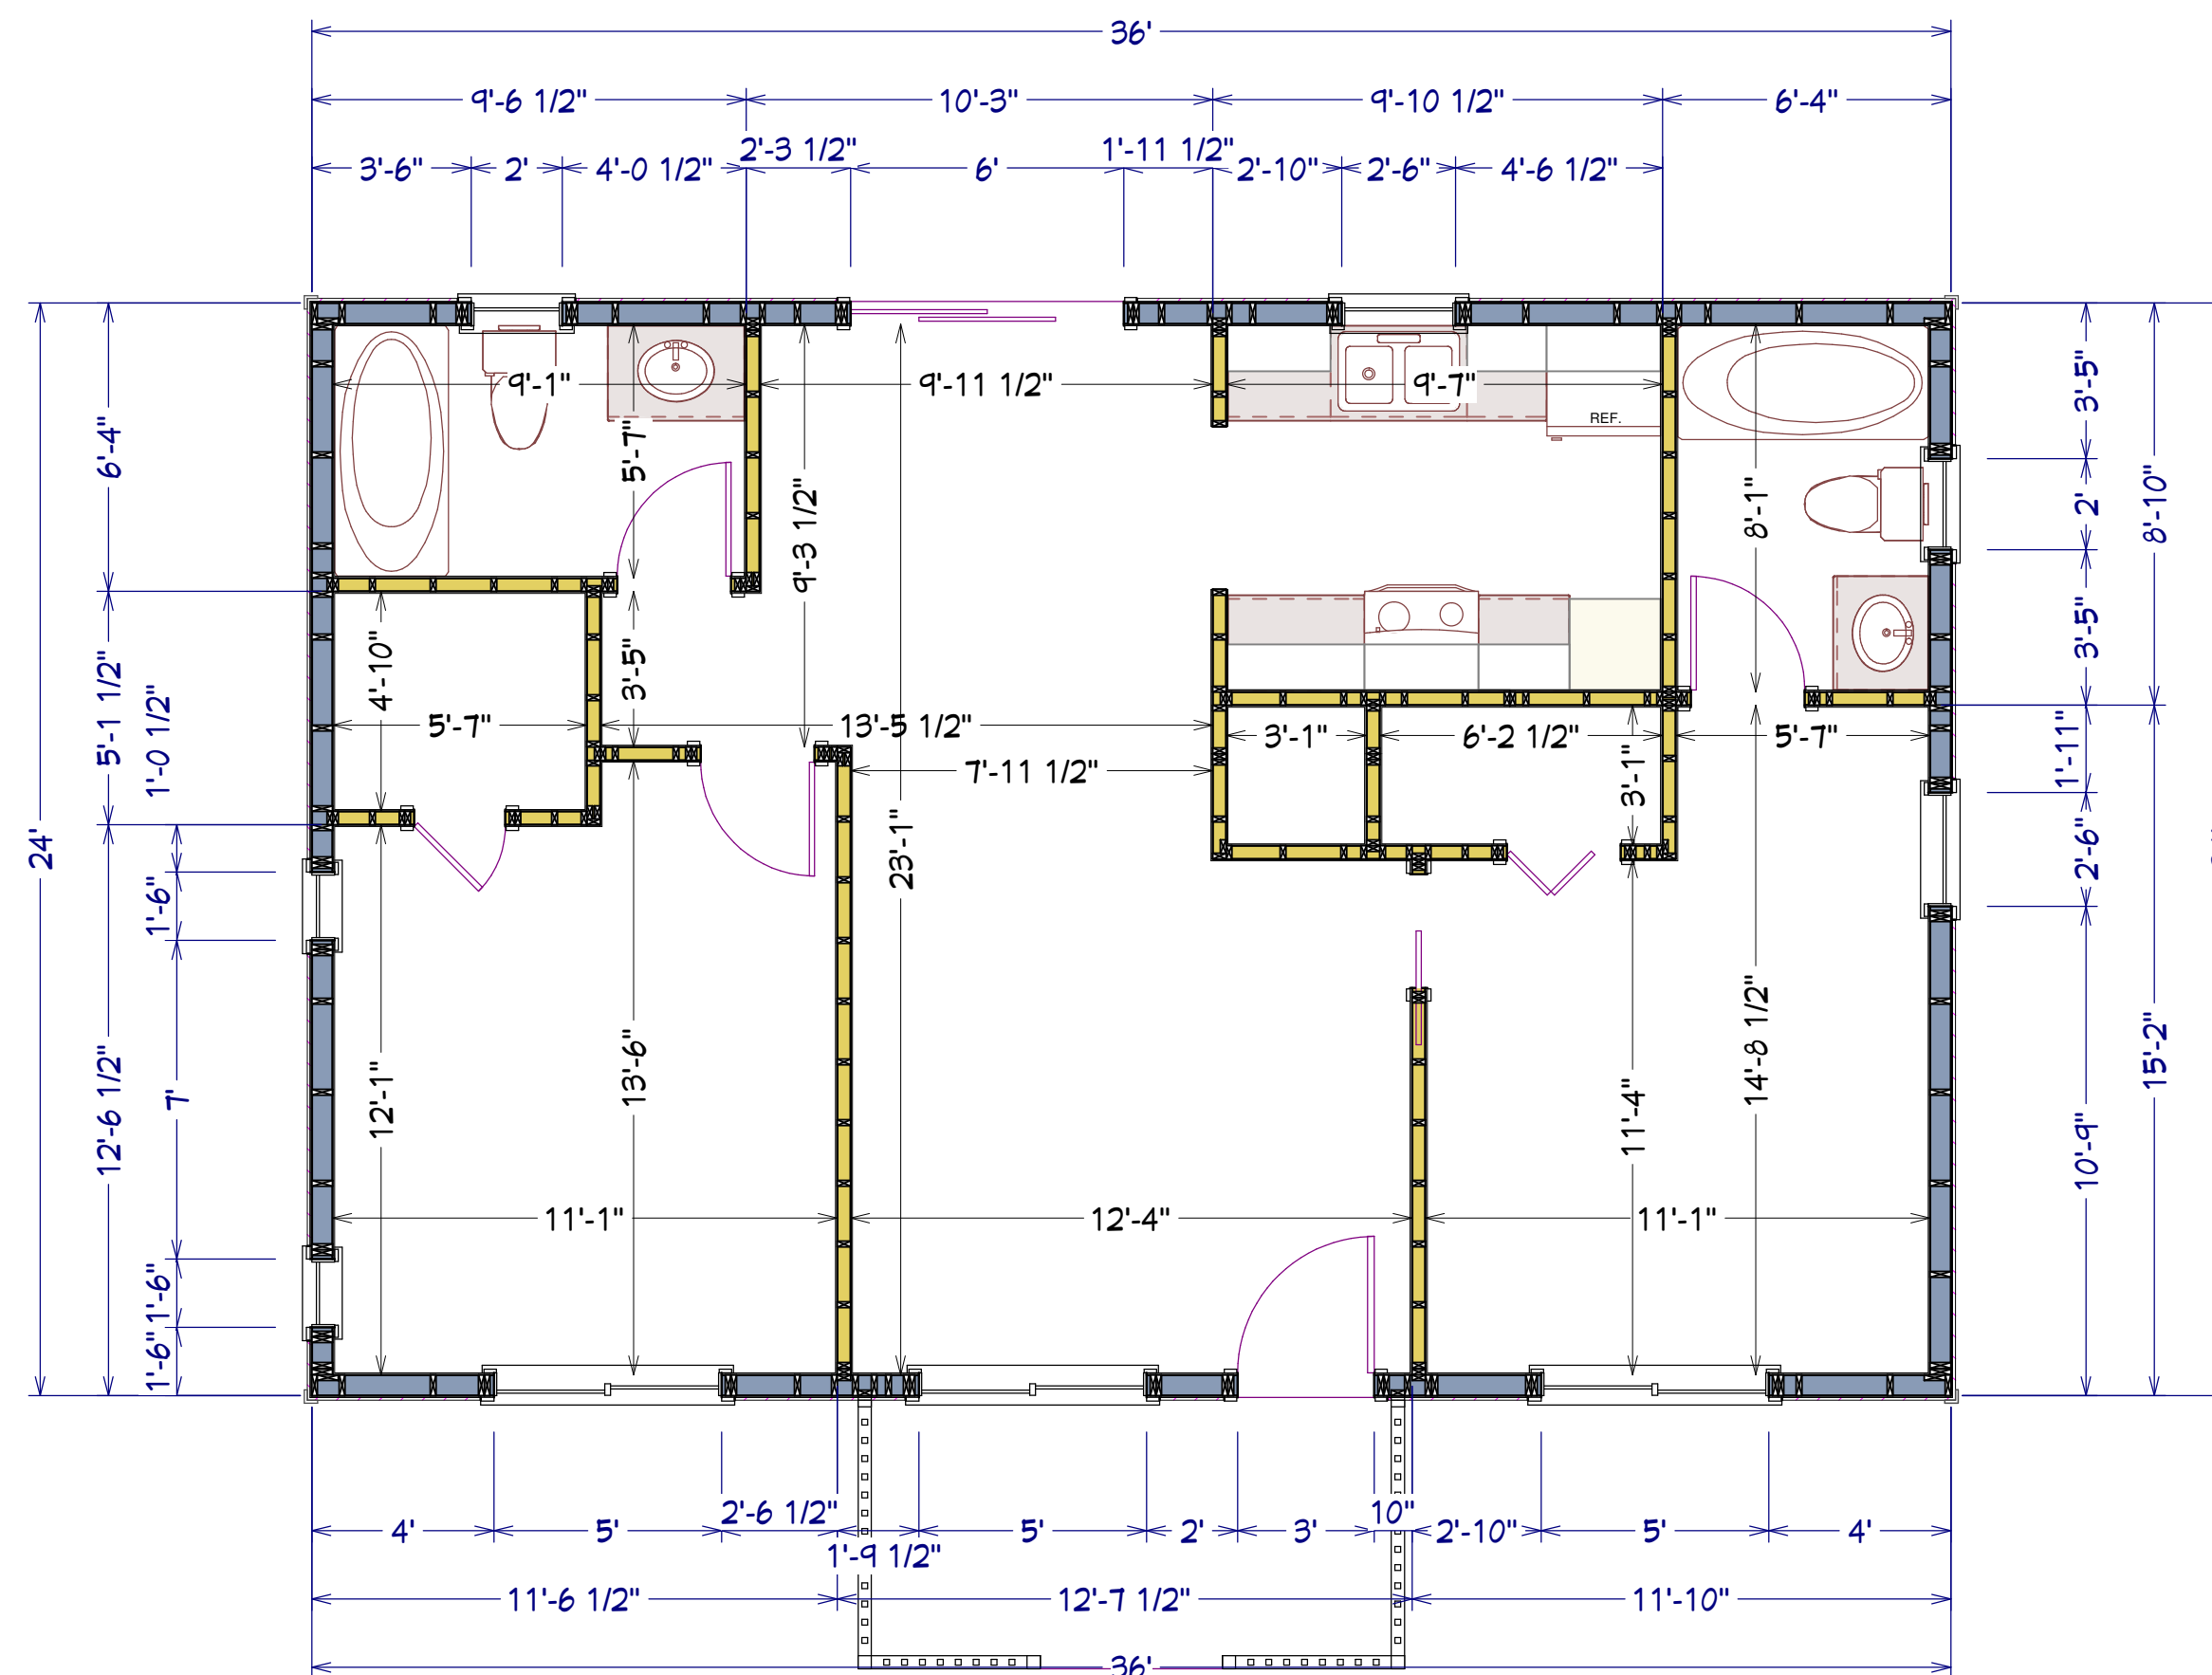

MAIN FLOOR PLAN
SCALE: 1/4" = 1'

These plans were not prepared by nor checked by a licensed architect and/or engineer.
E. F. P. does not represent or imply itself to be a licensed architect and/or licensed engineer.
Enjoy these plans but use them at your own risk.
Resale of these plans, in whole or part, is strictly prohibited.

Excellent Floor Plans
<https://sites.google.com/excellentfloorplans>
<https://www.ebay.com/str/excellentfloorplans>
<https://excellentfloorplans.etsy.com>