


## 24x32 House #24X32H3A

SQUARE FEET: 768  
WIDTH: 24'  
DEPTH: 40'-6"  
EXTERIOR WALL STRUCTURE: 2X6 STUDS


**BUILDING CONTRACTOR/HOME OWNER TO REVIEW AND VERIFY ALL DIMENSIONS, AND SPECS BEFORE CONSTRUCTION BEGINS. BUILDING TO BE BUILT AS PER LOCAL CODE REQUIREMENTS.**

To the best of my knowledge these plans are drawn to comply with owner's and/ or builder's specifications and any changes made on them after prints are made will be done at the owner's and / or builder's expense and responsibility. The contractor shall verify all dimensions and enclosed drawing. E.F.P. is not liable for errors. While every effort has been made in the preparation of this plan to avoid mistakes, the maker cannot guarantee against human error. The contractor of the job must check all dimensions and other details prior to construction and be solely responsible thereafter. All calculations and member sizing should be verified for your building by a certified building official.




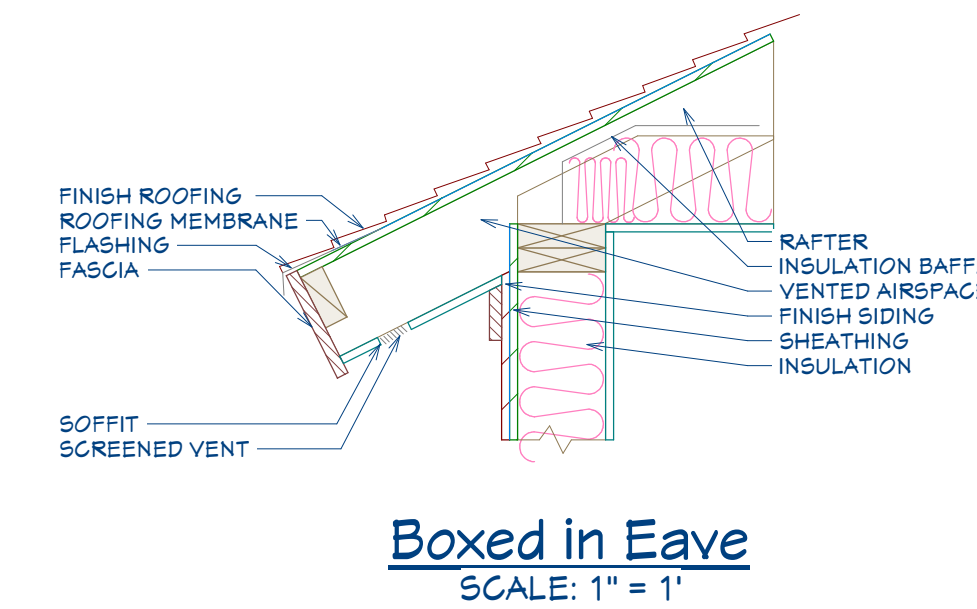


These plans were not prepared by nor checked by a licensed architect and/or engineer. E.F.P. does not represent or imply itself to be a licensed architect and/or licensed engineer. Enjoy these plans but use them at your own risk. Resale of these plans, in whole or part, is strictly prohibited.

**Excellent Floor Plans**  
<https://sites.google.com/excellentfloorplans>  
<https://www.ebay.com/str/excellentfloorplans>  
<https://excellentfloorplans.etsy.com>

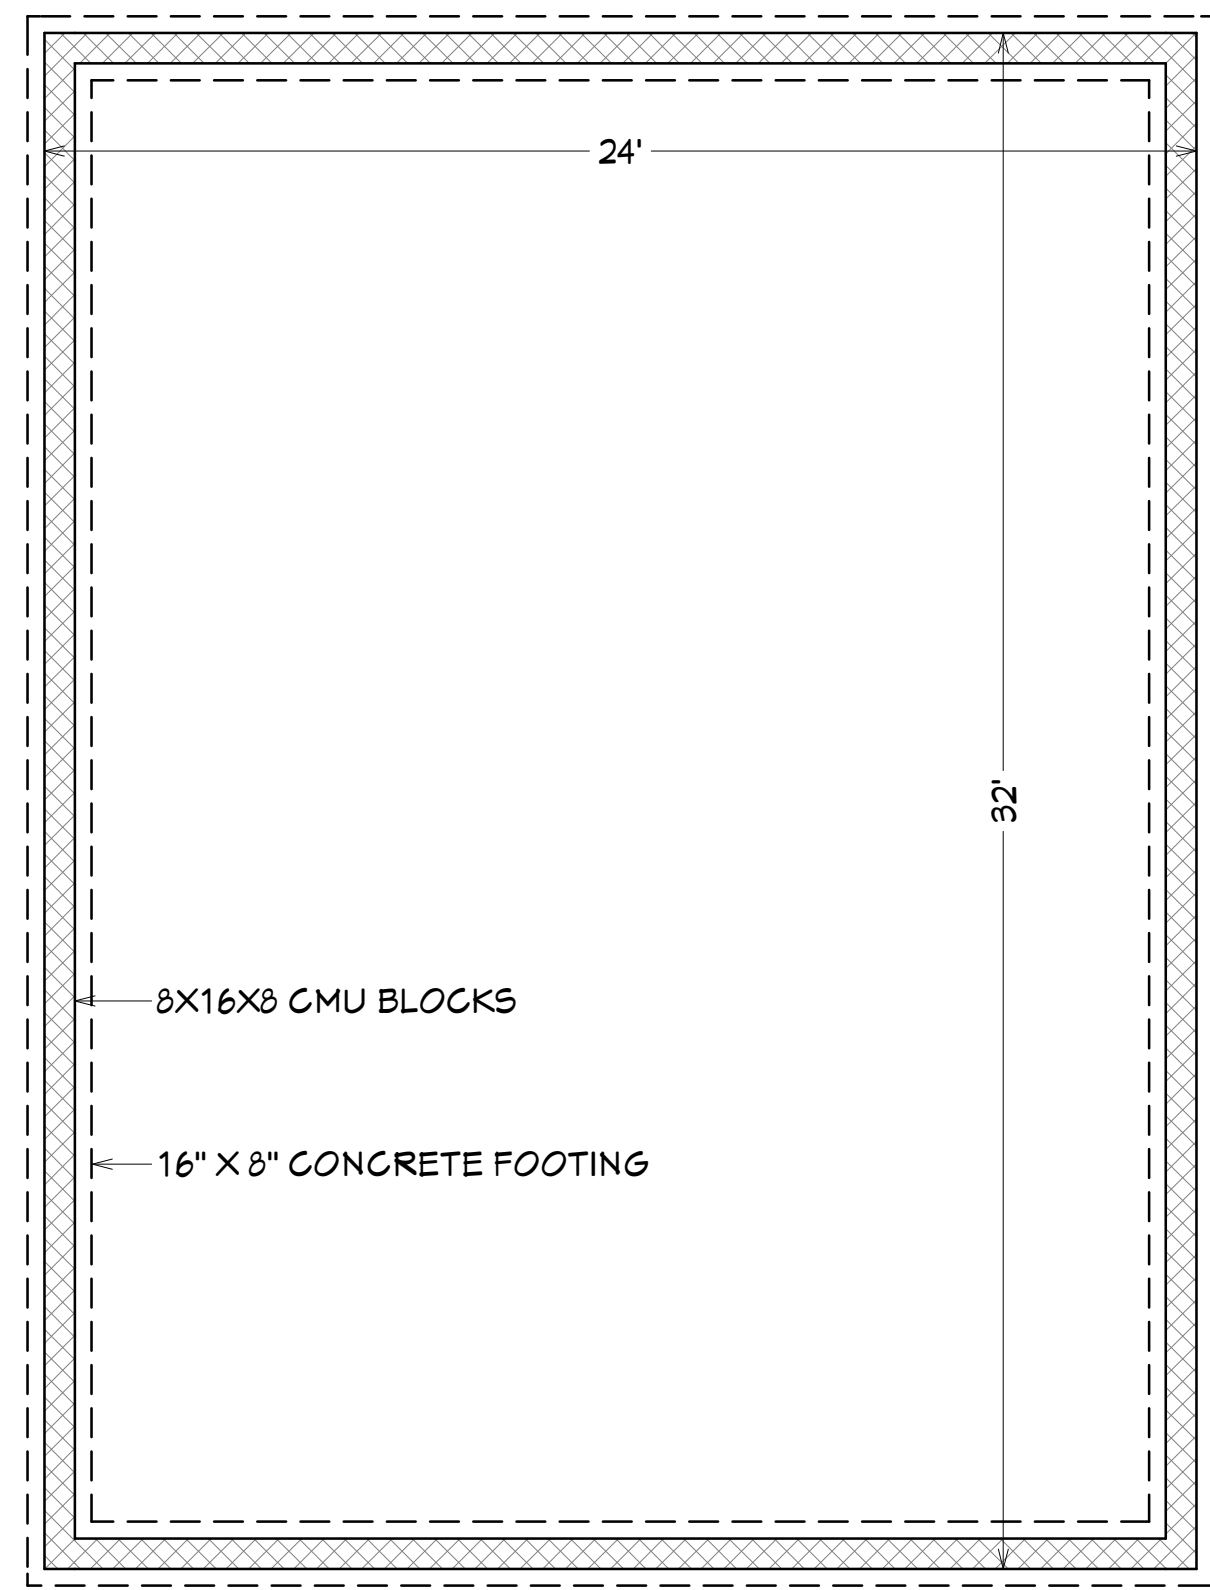


**FOUNDATION PLAN**  
SCALE: 1/4" = 1'

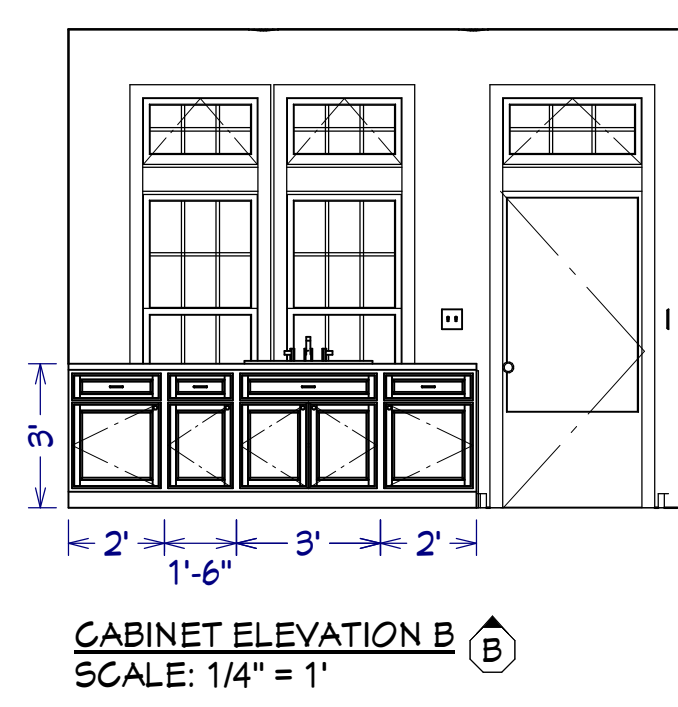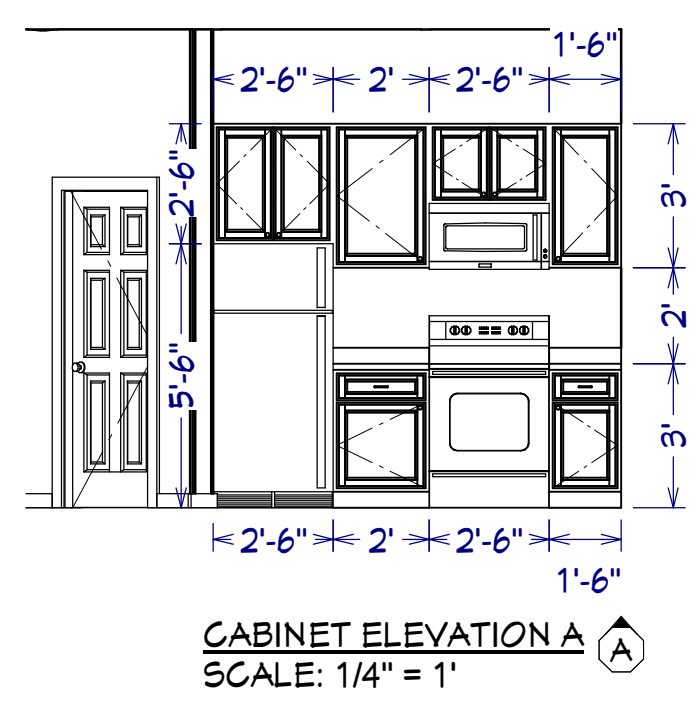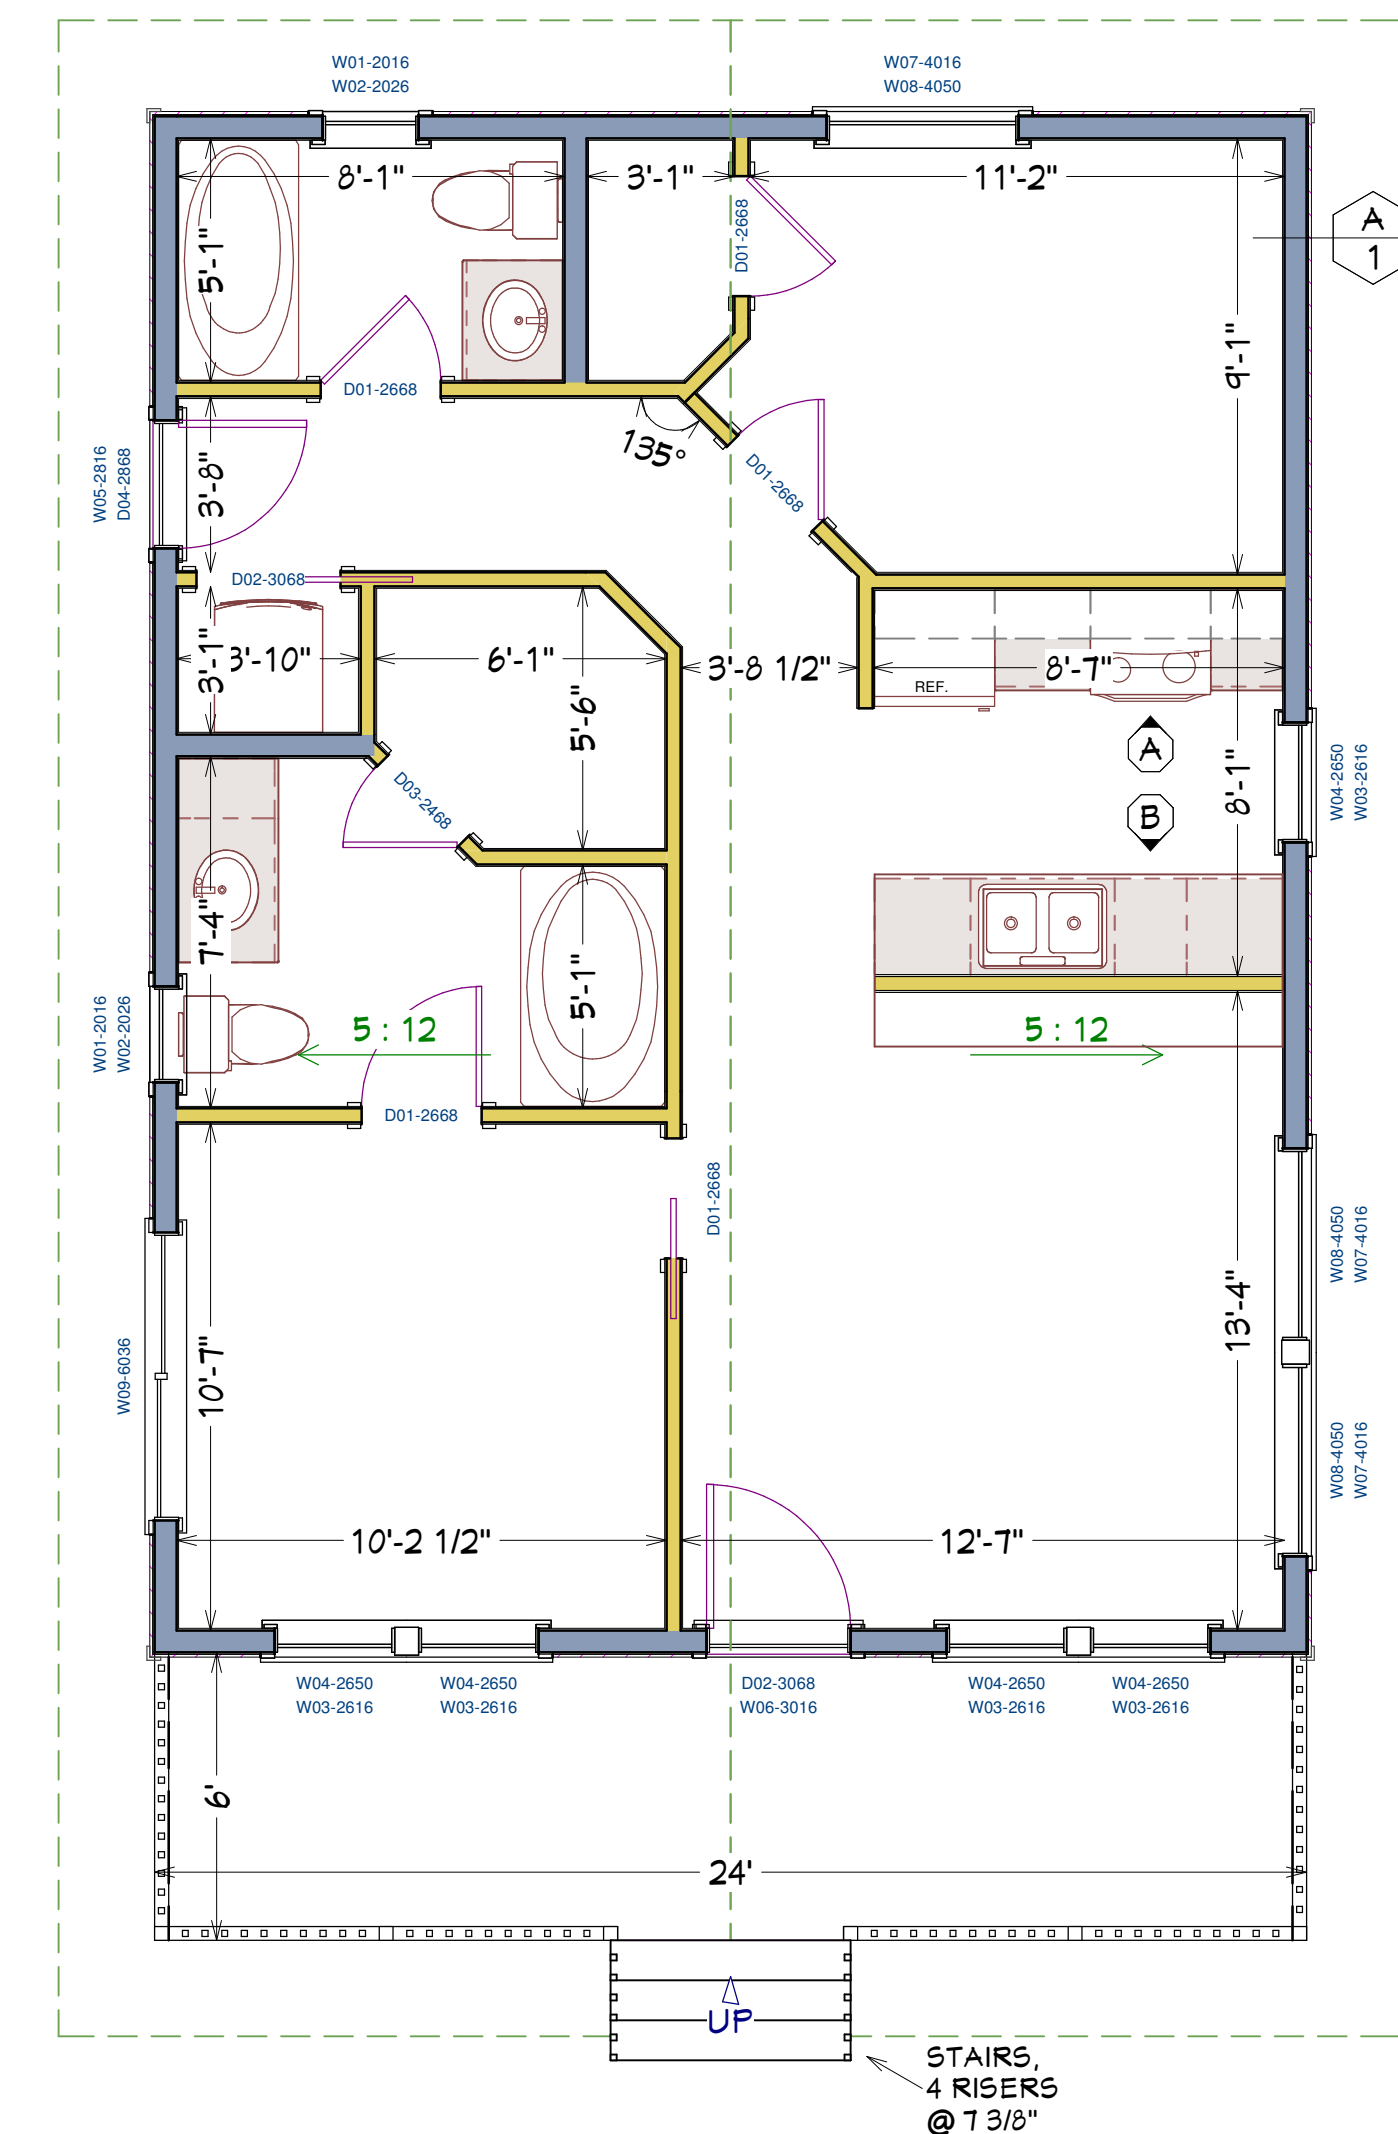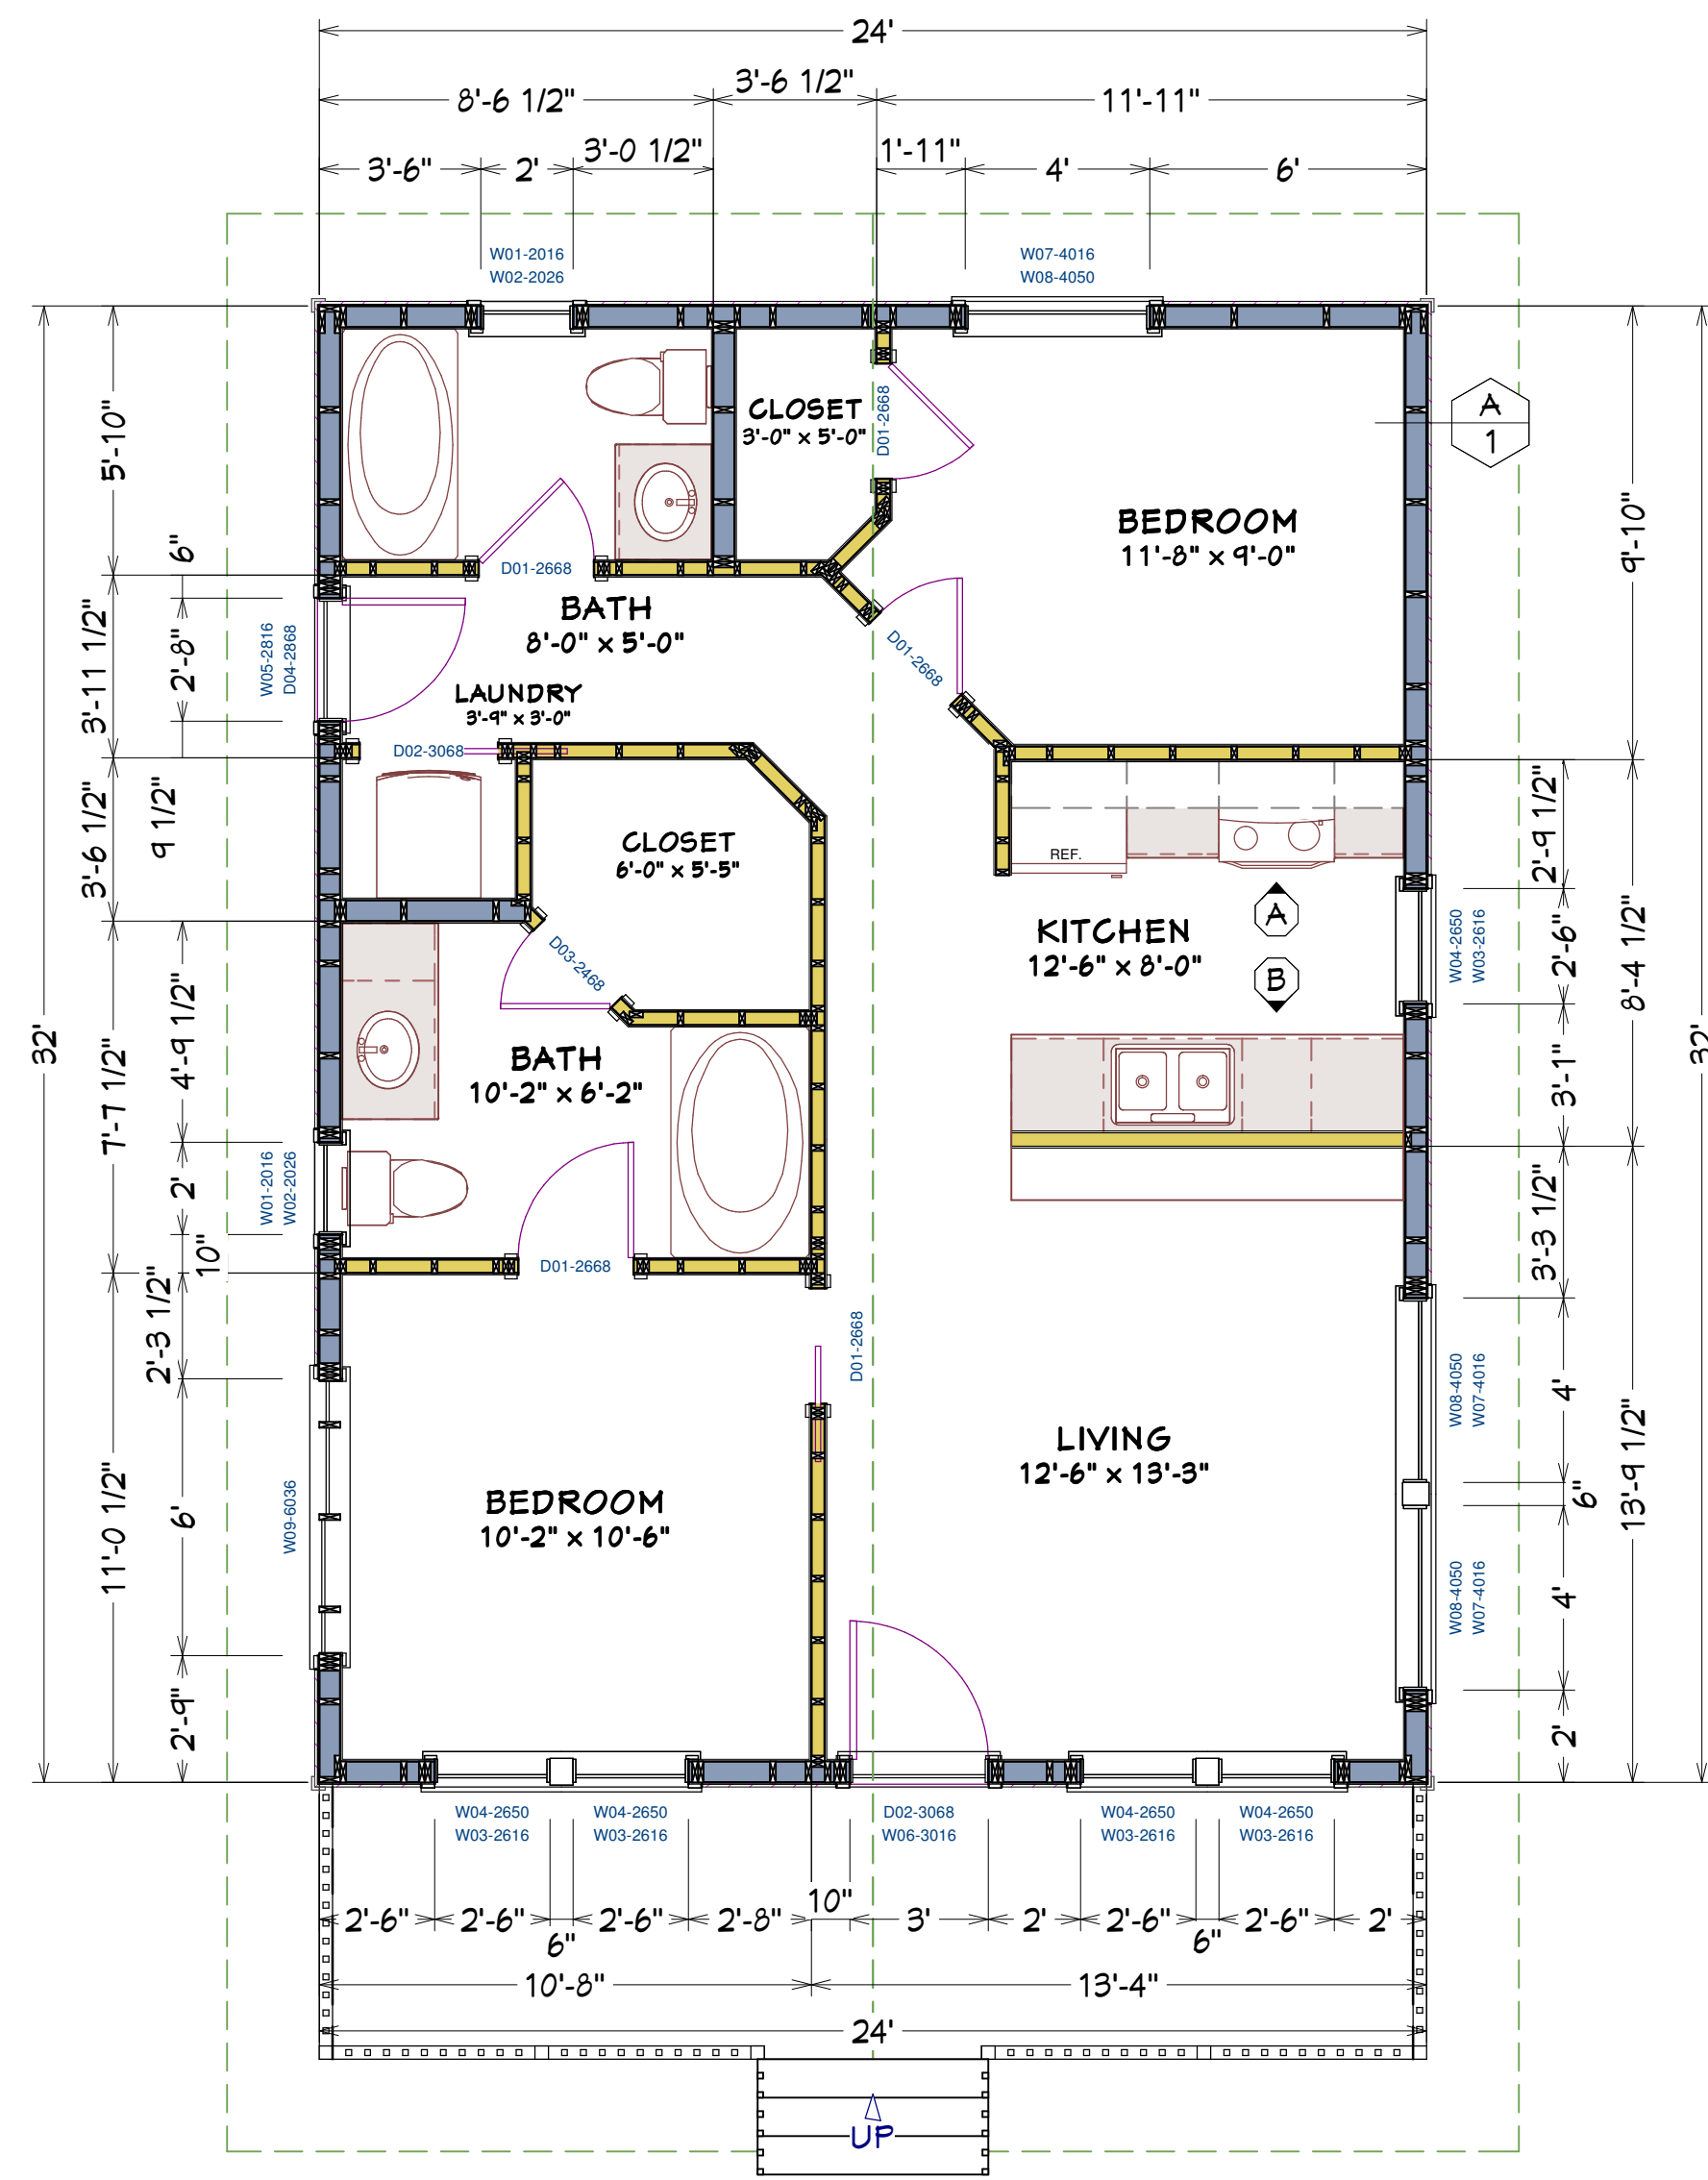

DOOR SCHEDULE				
NUMBER	LABEL	QTY	FLOOR	SIZE COMMENTS
D01	D01-2668	5	1	2668
D02	D02-3068	2	1	3068
D03	D03-2468	1	1	2468
D04	D04-2868	1	1	2868


WINDOW SCHEDULE						
NUMBER	LABEL	QTY	FLOOR	SIZE	DESCRIPTION	COMMENTS
W01	W01-2016	2	1	2016	ANNING	
W02	W02-2026	2	1	2026	DOUBLE HUNG	
W03	W03-2616	5	1	2616	ANNING	
W04	W04-2650	5	1	2650	DOUBLE HUNG	
W05	W05-2816	1	1	2816	ANNING	
W06	W06-3016	1	1	3016	ANNING	
W07	W07-4016	3	1	4016	ANNING	
W08	W08-4050	3	1	4050	DOUBLE HUNG	
W09	W09-6036	1	1	6036	RIGHT SLIDING	

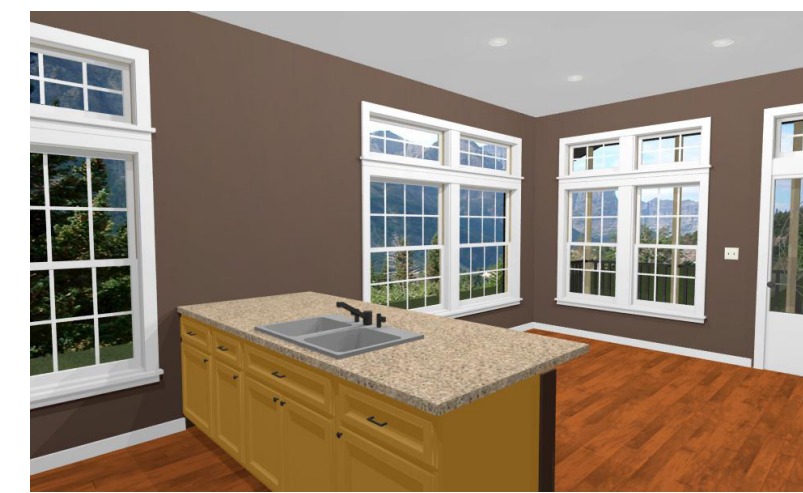

24x32 House  
#24X32H3A

These plans were not prepared by nor checked by a licensed architect and/or engineer. E. F. P. does not represent or imply itself to be a licensed architect and/or licensed engineer. Enjoy these plans but use them at your own risk. Resale of these plans, in whole or part, is strictly prohibited.


**Excellent Floor Plans**  
<https://sites.google.com/excellentfloorplans>  
<https://www.ebay.com/str/excellentfloorplans>  
<https://excellentfloorplans.etsy.com>

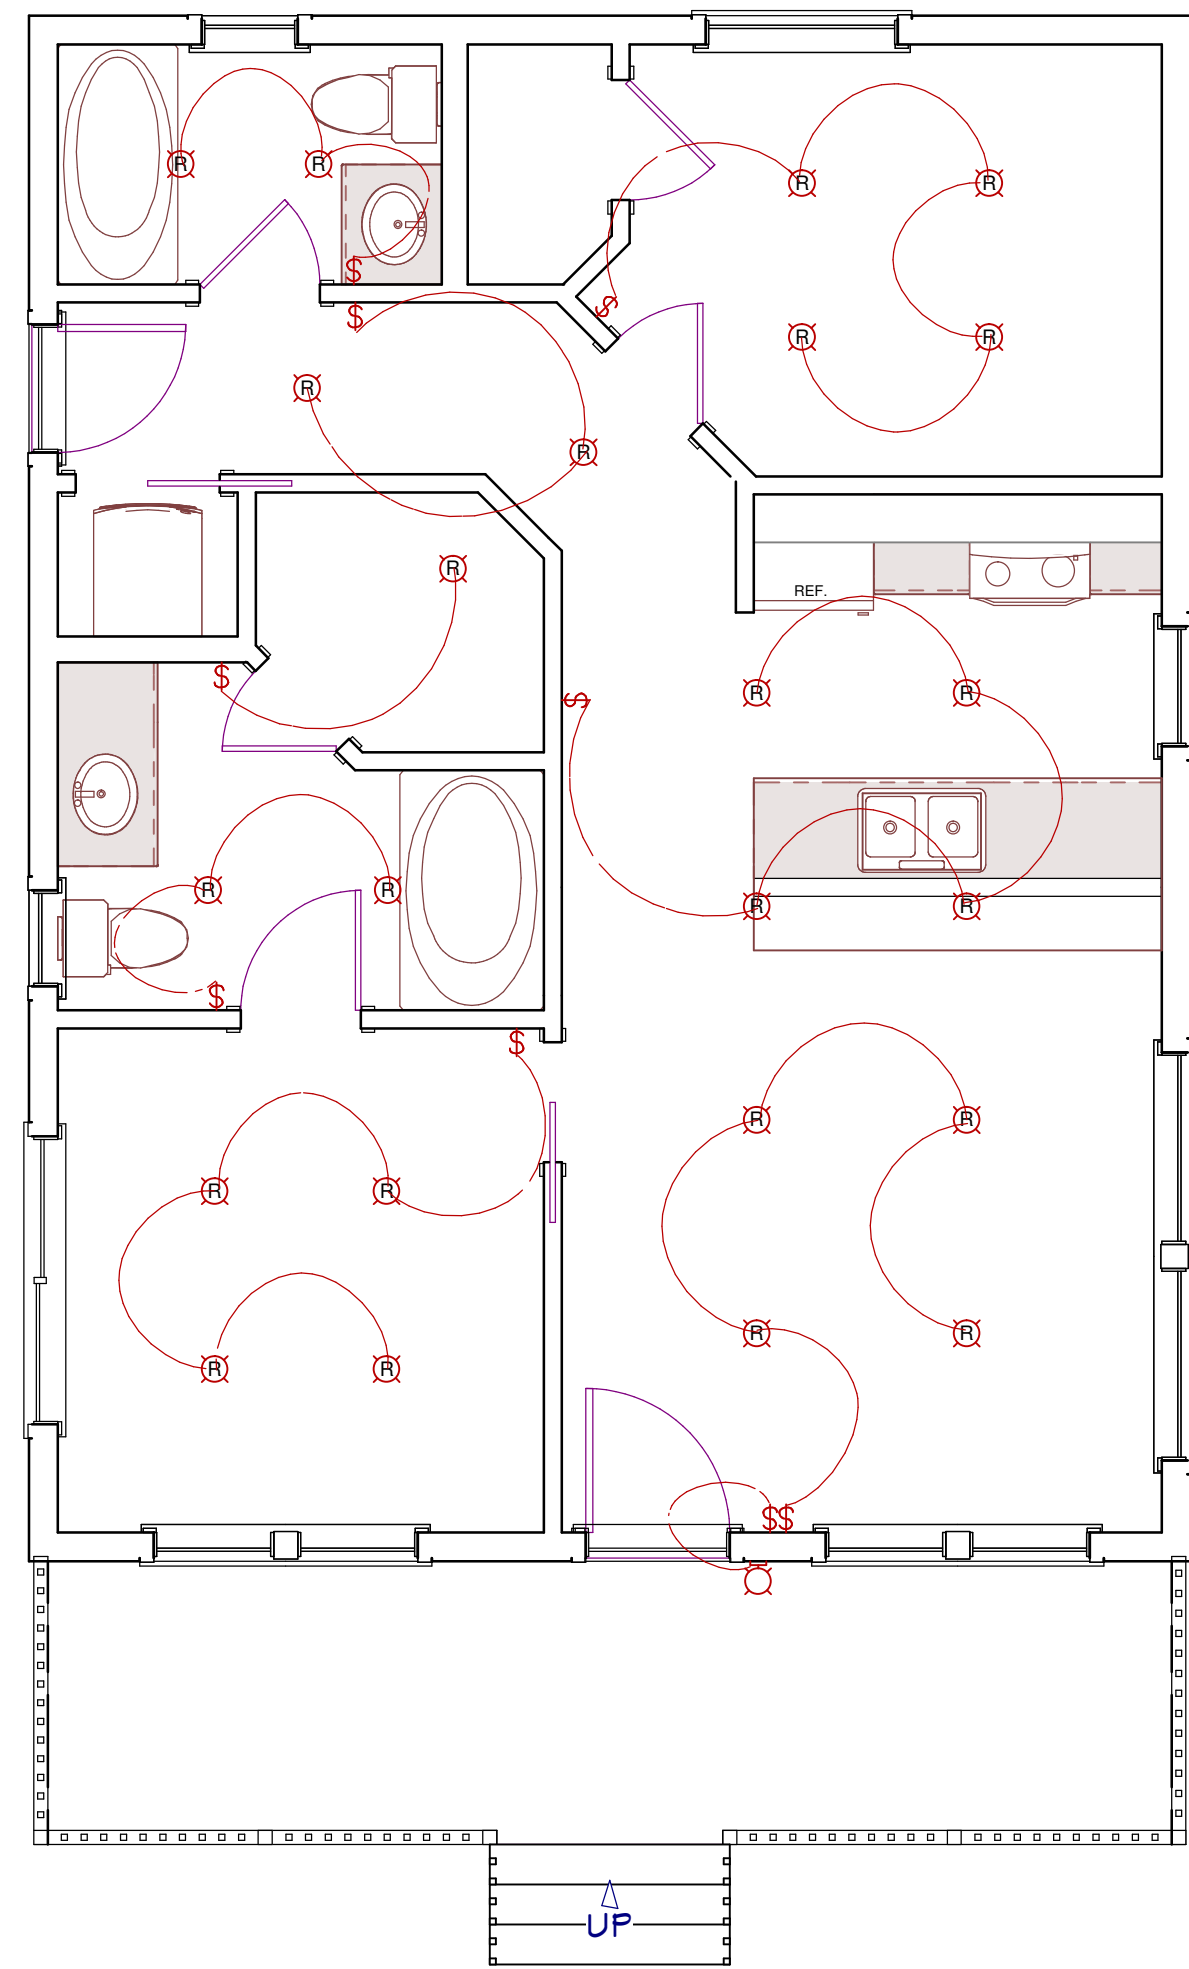


**LIGHTING PLAN**  
SCALE: 1/4" = 1'



**FLOOR FRAMING PLAN**  
SCALE: 1/4" = 1'

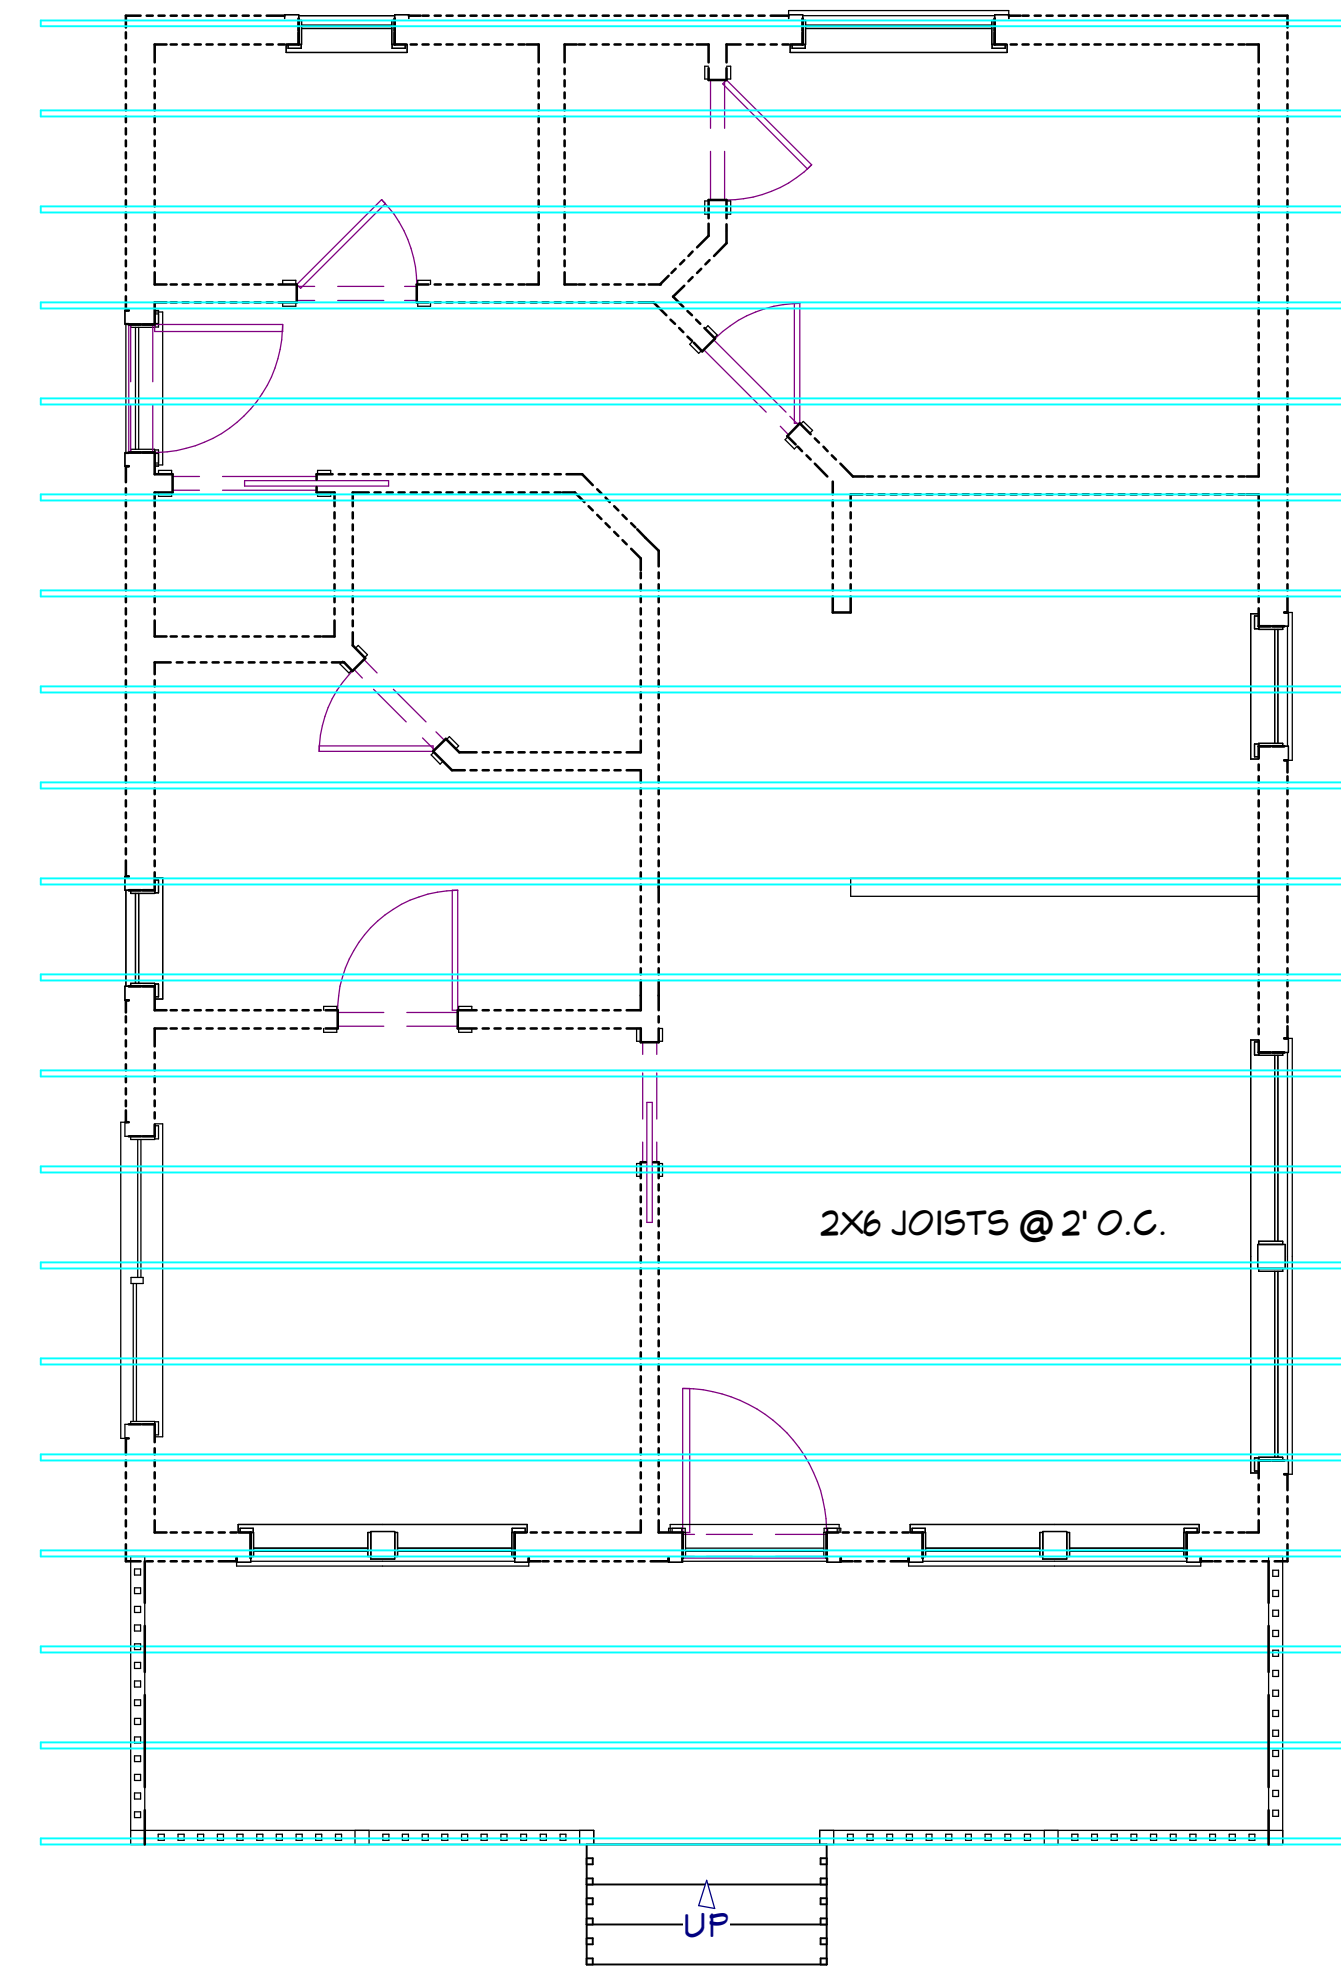

**CEILING FRAMING PLAN**  
SCALE: 1/4" = 1'

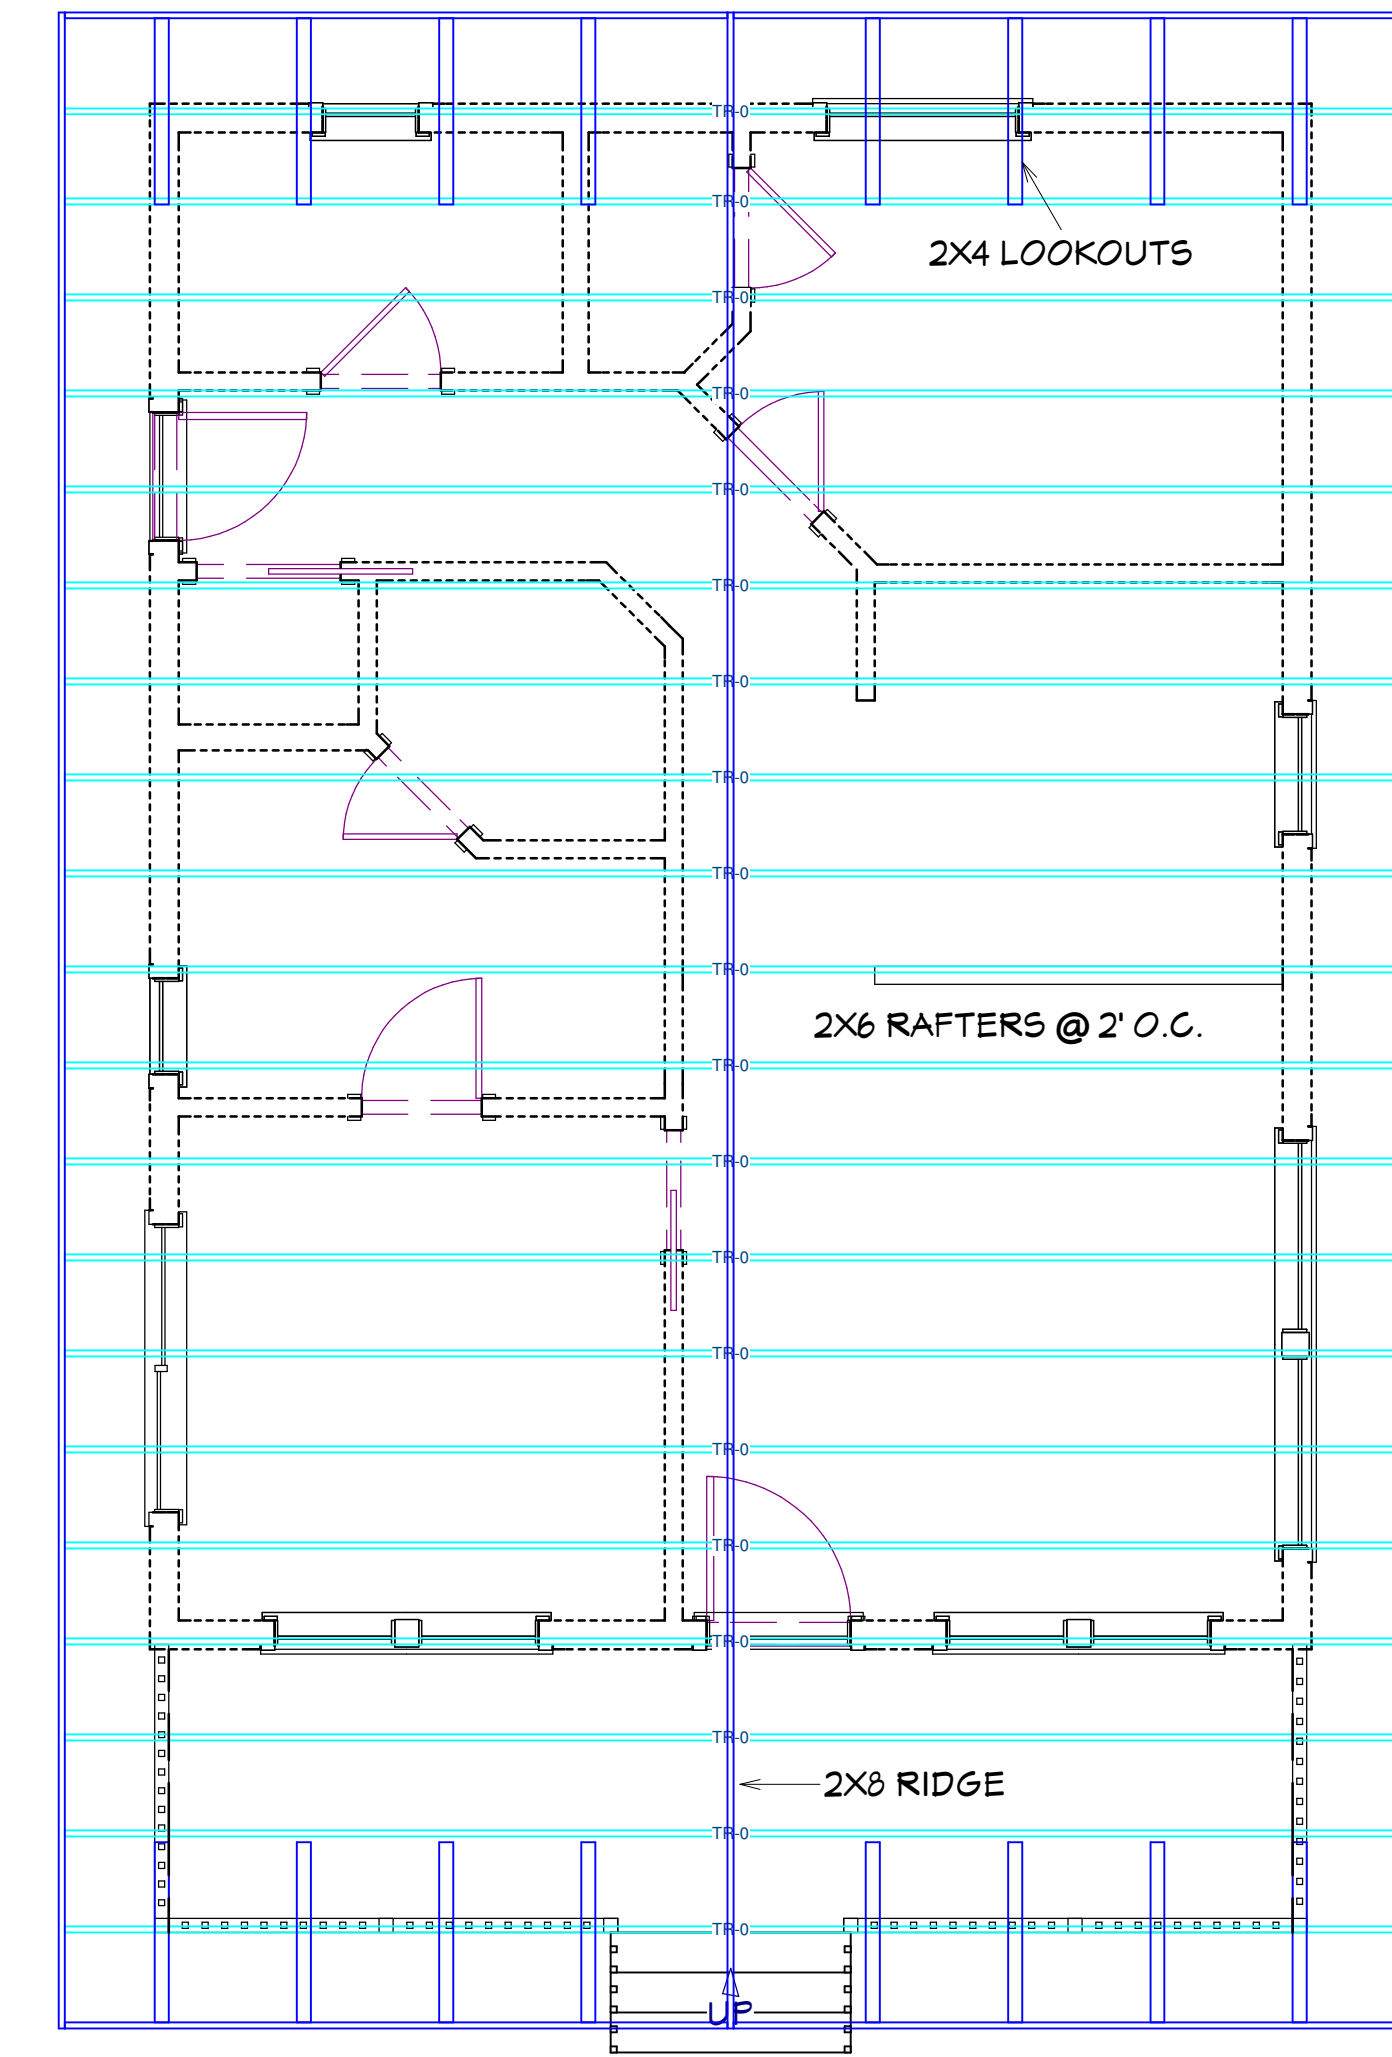

**ROOF FRAMING PLAN**  
SCALE: 1/4" = 1'

ALL WIRING TO BE INSTALLED AS PER ACTUAL JOBSITE CONDITIONS, ELECTRICAL CODE AND HOME OWNER OR INTERIOR LIGHTING CONSULTANT. SHOWN IS SUGGESTED PLACEMENT OF LIGHTING AND SWITCHING AND MUST BE APPROVED BY HOMEOWNER PRIOR TO WORK.

- Ⓜ RECESSED DOWN LIGHT
- Ⓛ PORCH LANTERN


24x32 House  
#24X32H3A

These plans were not prepared by nor checked by a licensed architect and/or engineer.  
 E. F. P. does not represent or imply itself to be a licensed architect and/or licensed engineer.  
 Enjoy these plans but use them at your own risk.  
 Resale of these plans, in whole or part, is strictly prohibited.


**Excellent Floor Plans**  
<https://sites.google.com/excellentfloorplans>  
<https://www.ebay.com/str/excellentfloorplans>  
<https://excellentfloorplans.etsy.com>

# IDEAS

24x32 House  
#24X32H3A

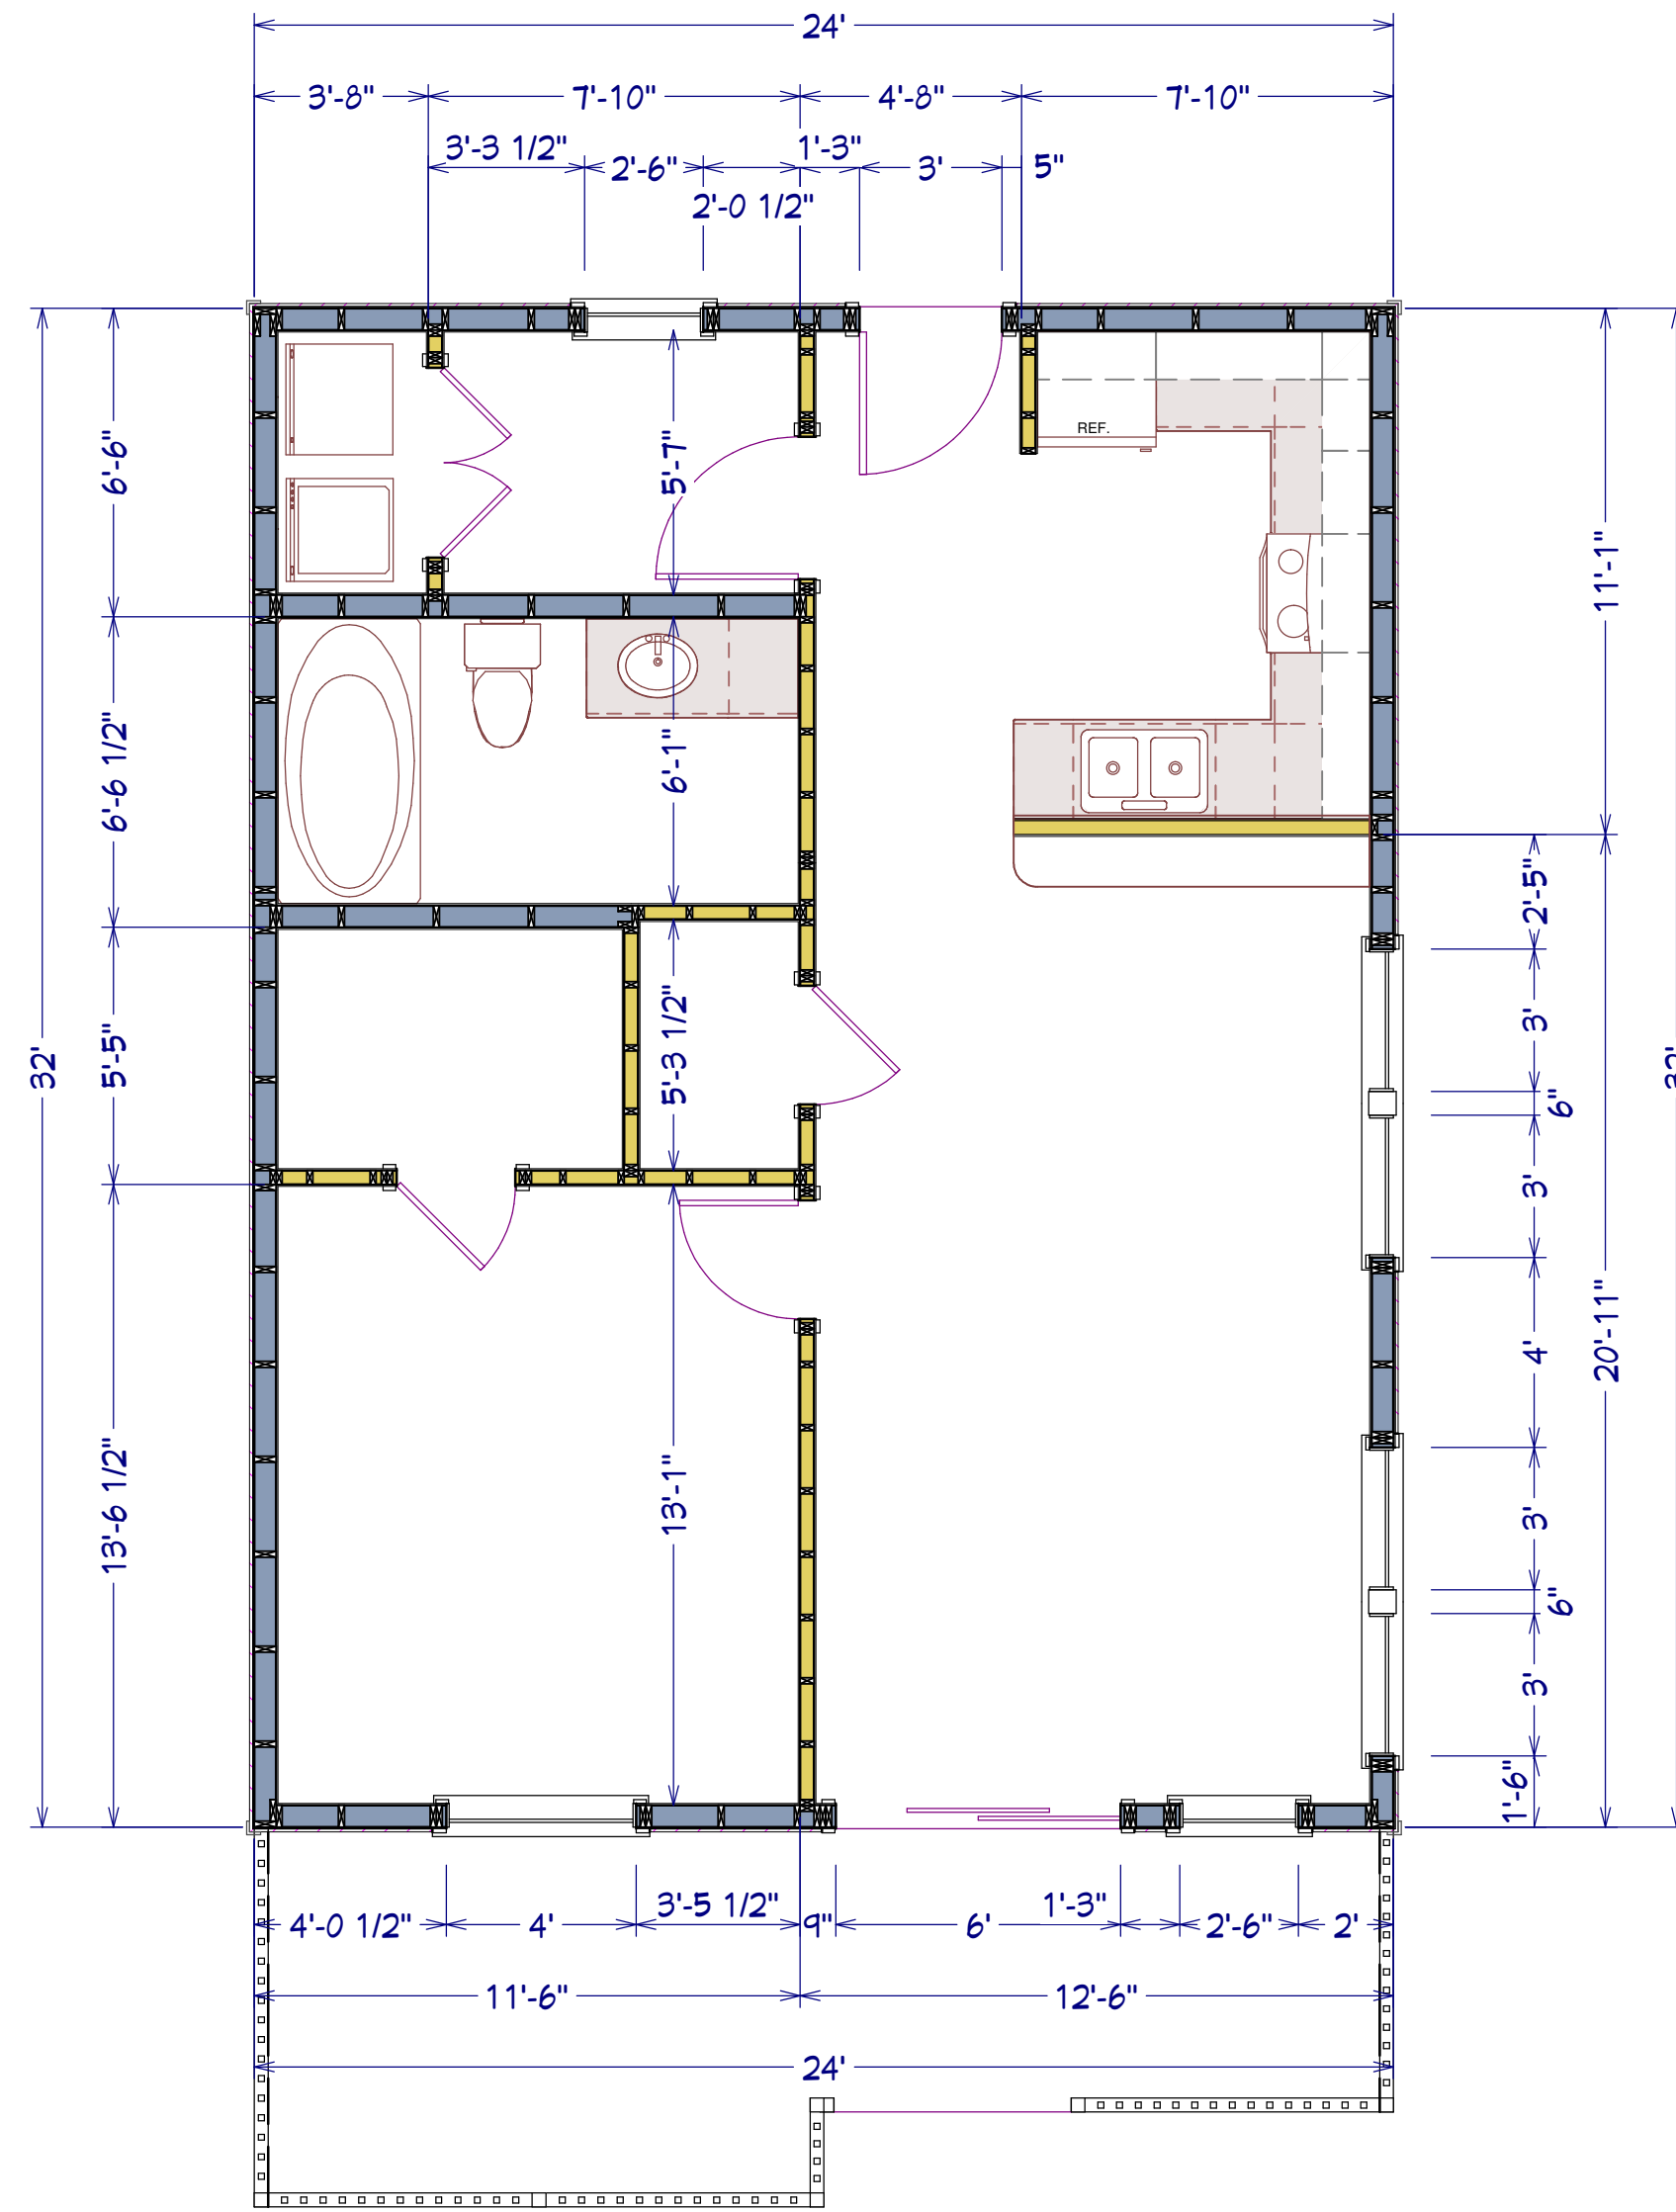

**MAIN FLOOR PLAN**  
SCALE: 1/4" = 1'

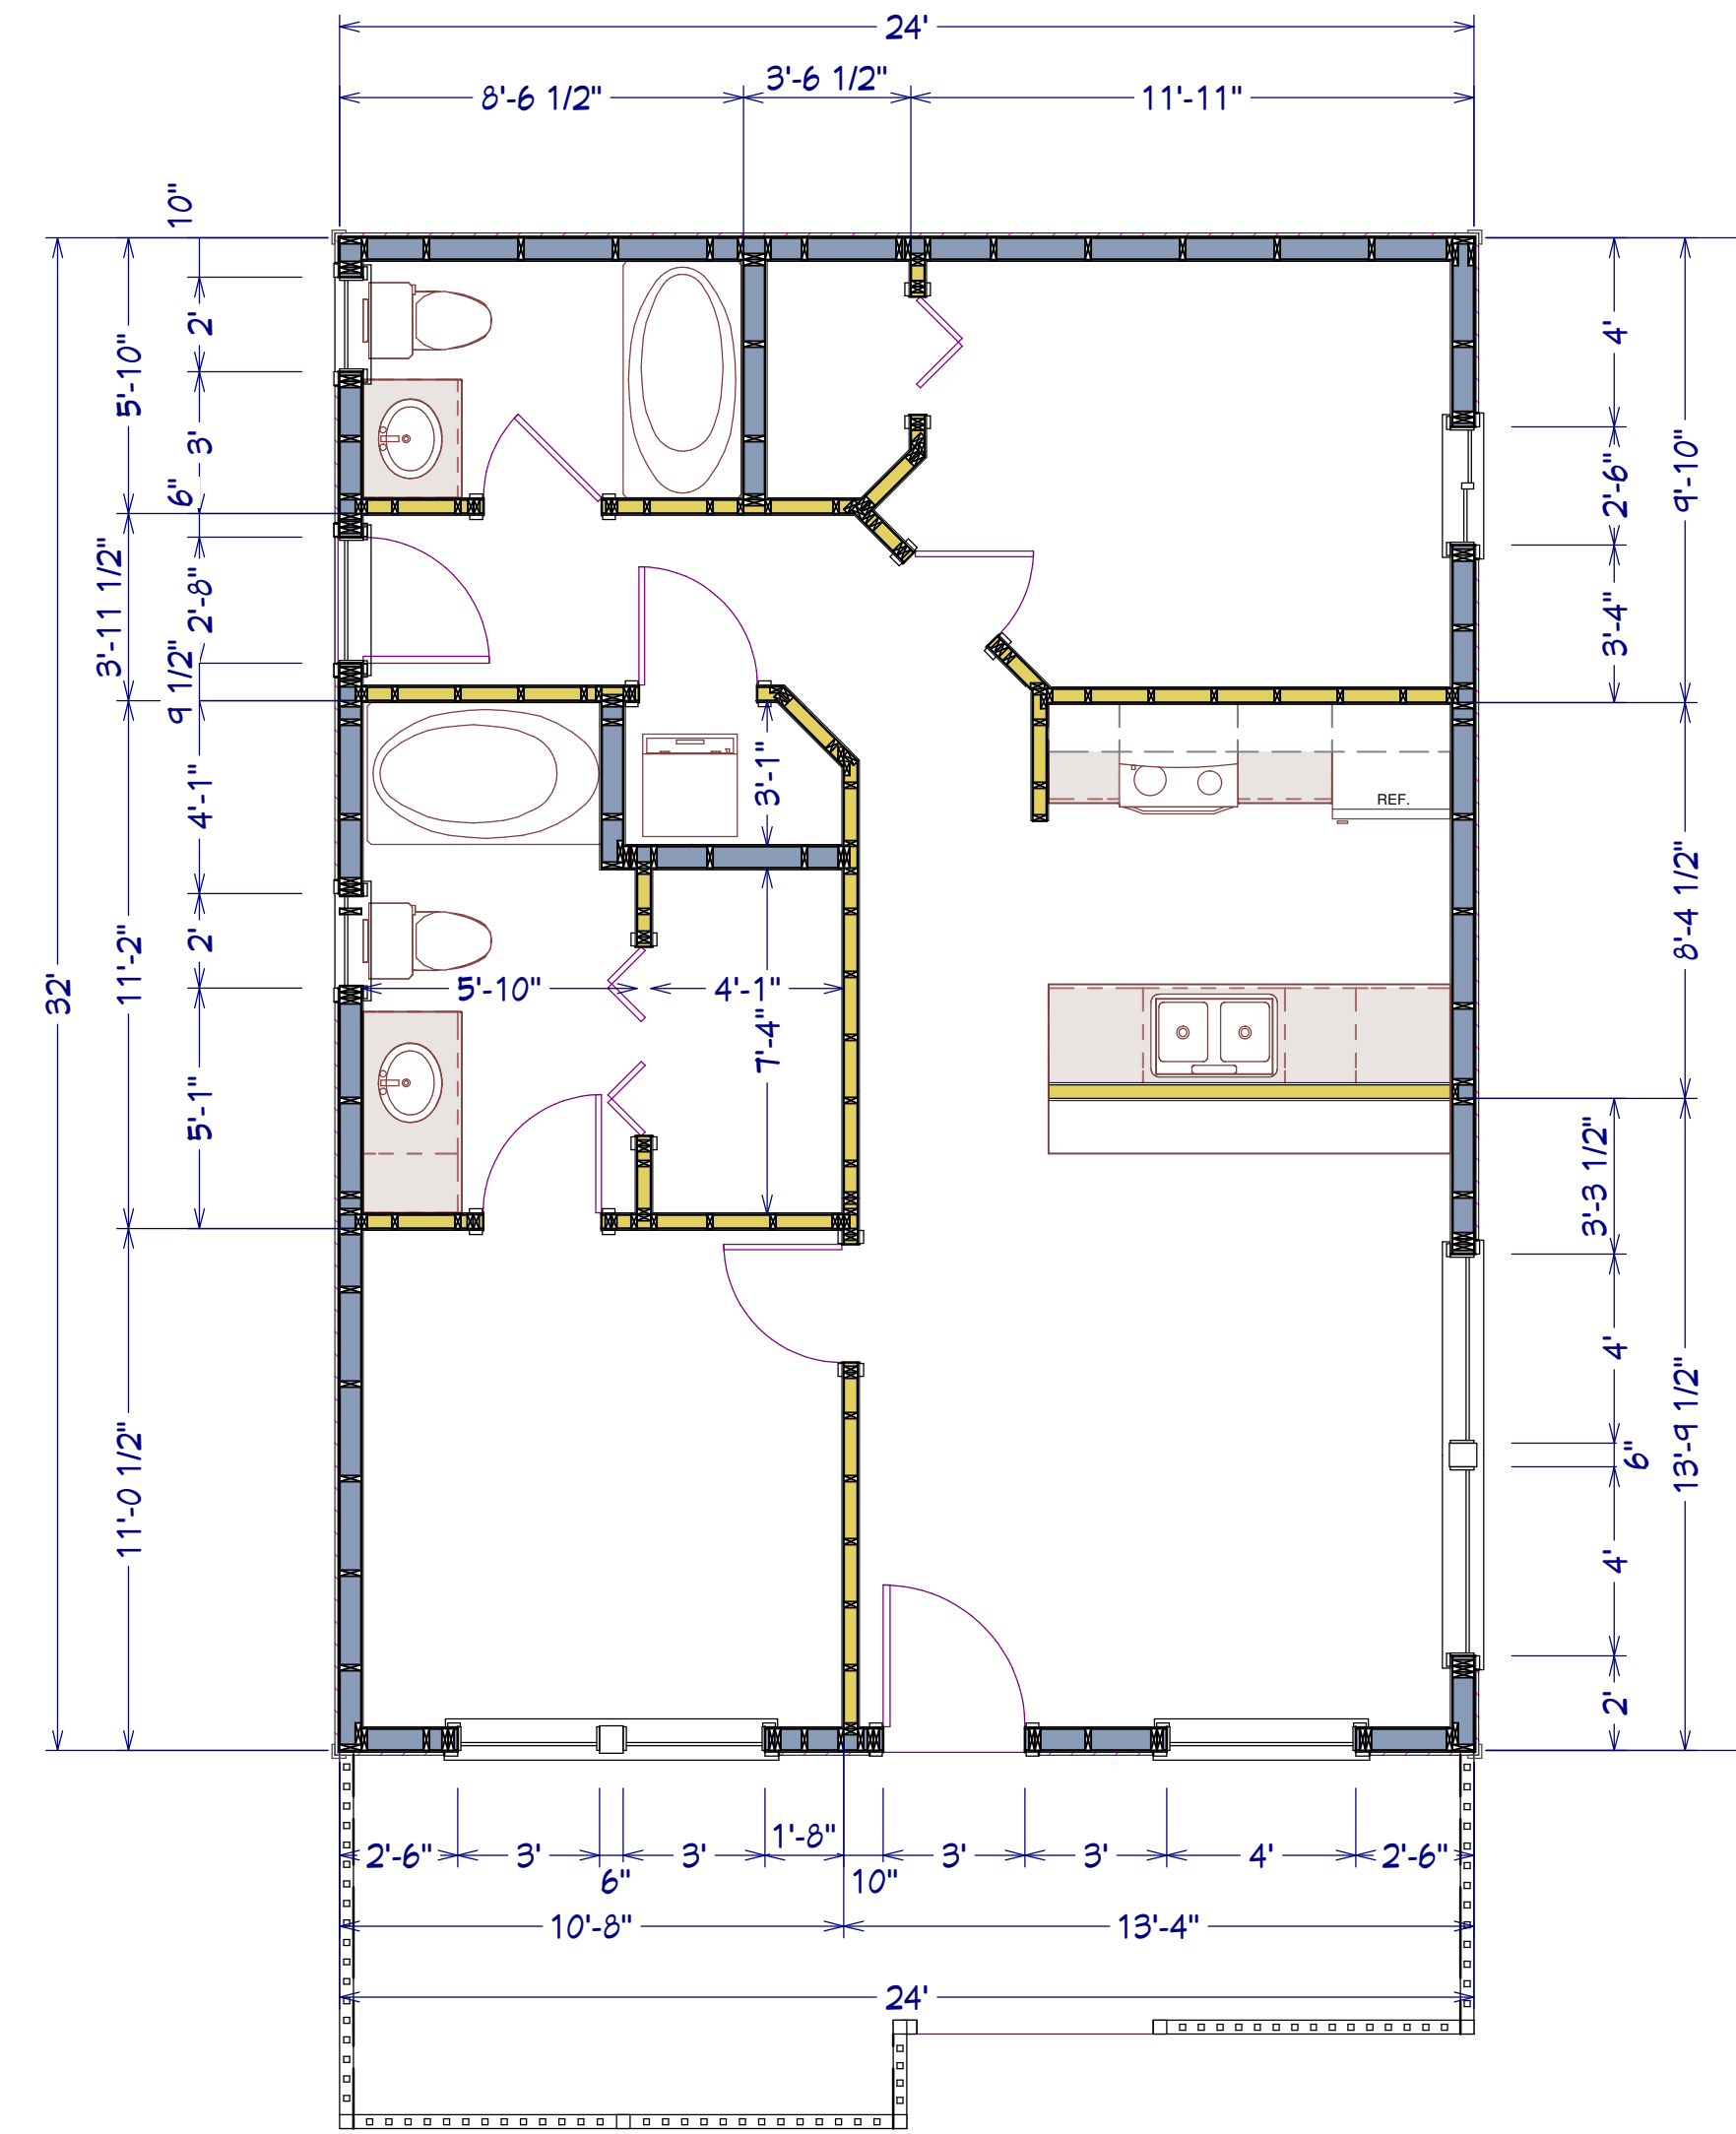

**MAIN FLOOR PLAN**  
SCALE: 1/4" = 1'

These plans were not prepared by nor checked by a licensed architect and/or engineer.  
E. F. P. does not represent or imply itself to be a licensed architect and/or licensed engineer.  
Enjoy these plans but use them at your own risk.  
Resale of these plans, in whole or part, is strictly prohibited.

**Excellent Floor Plans**  
<https://sites.google.com/excellentfloorplans>  
<https://www.ebay.com/str/excellentfloorplans>  
<https://excellentfloorplans.etsy.com>