





101 Existing Conditions

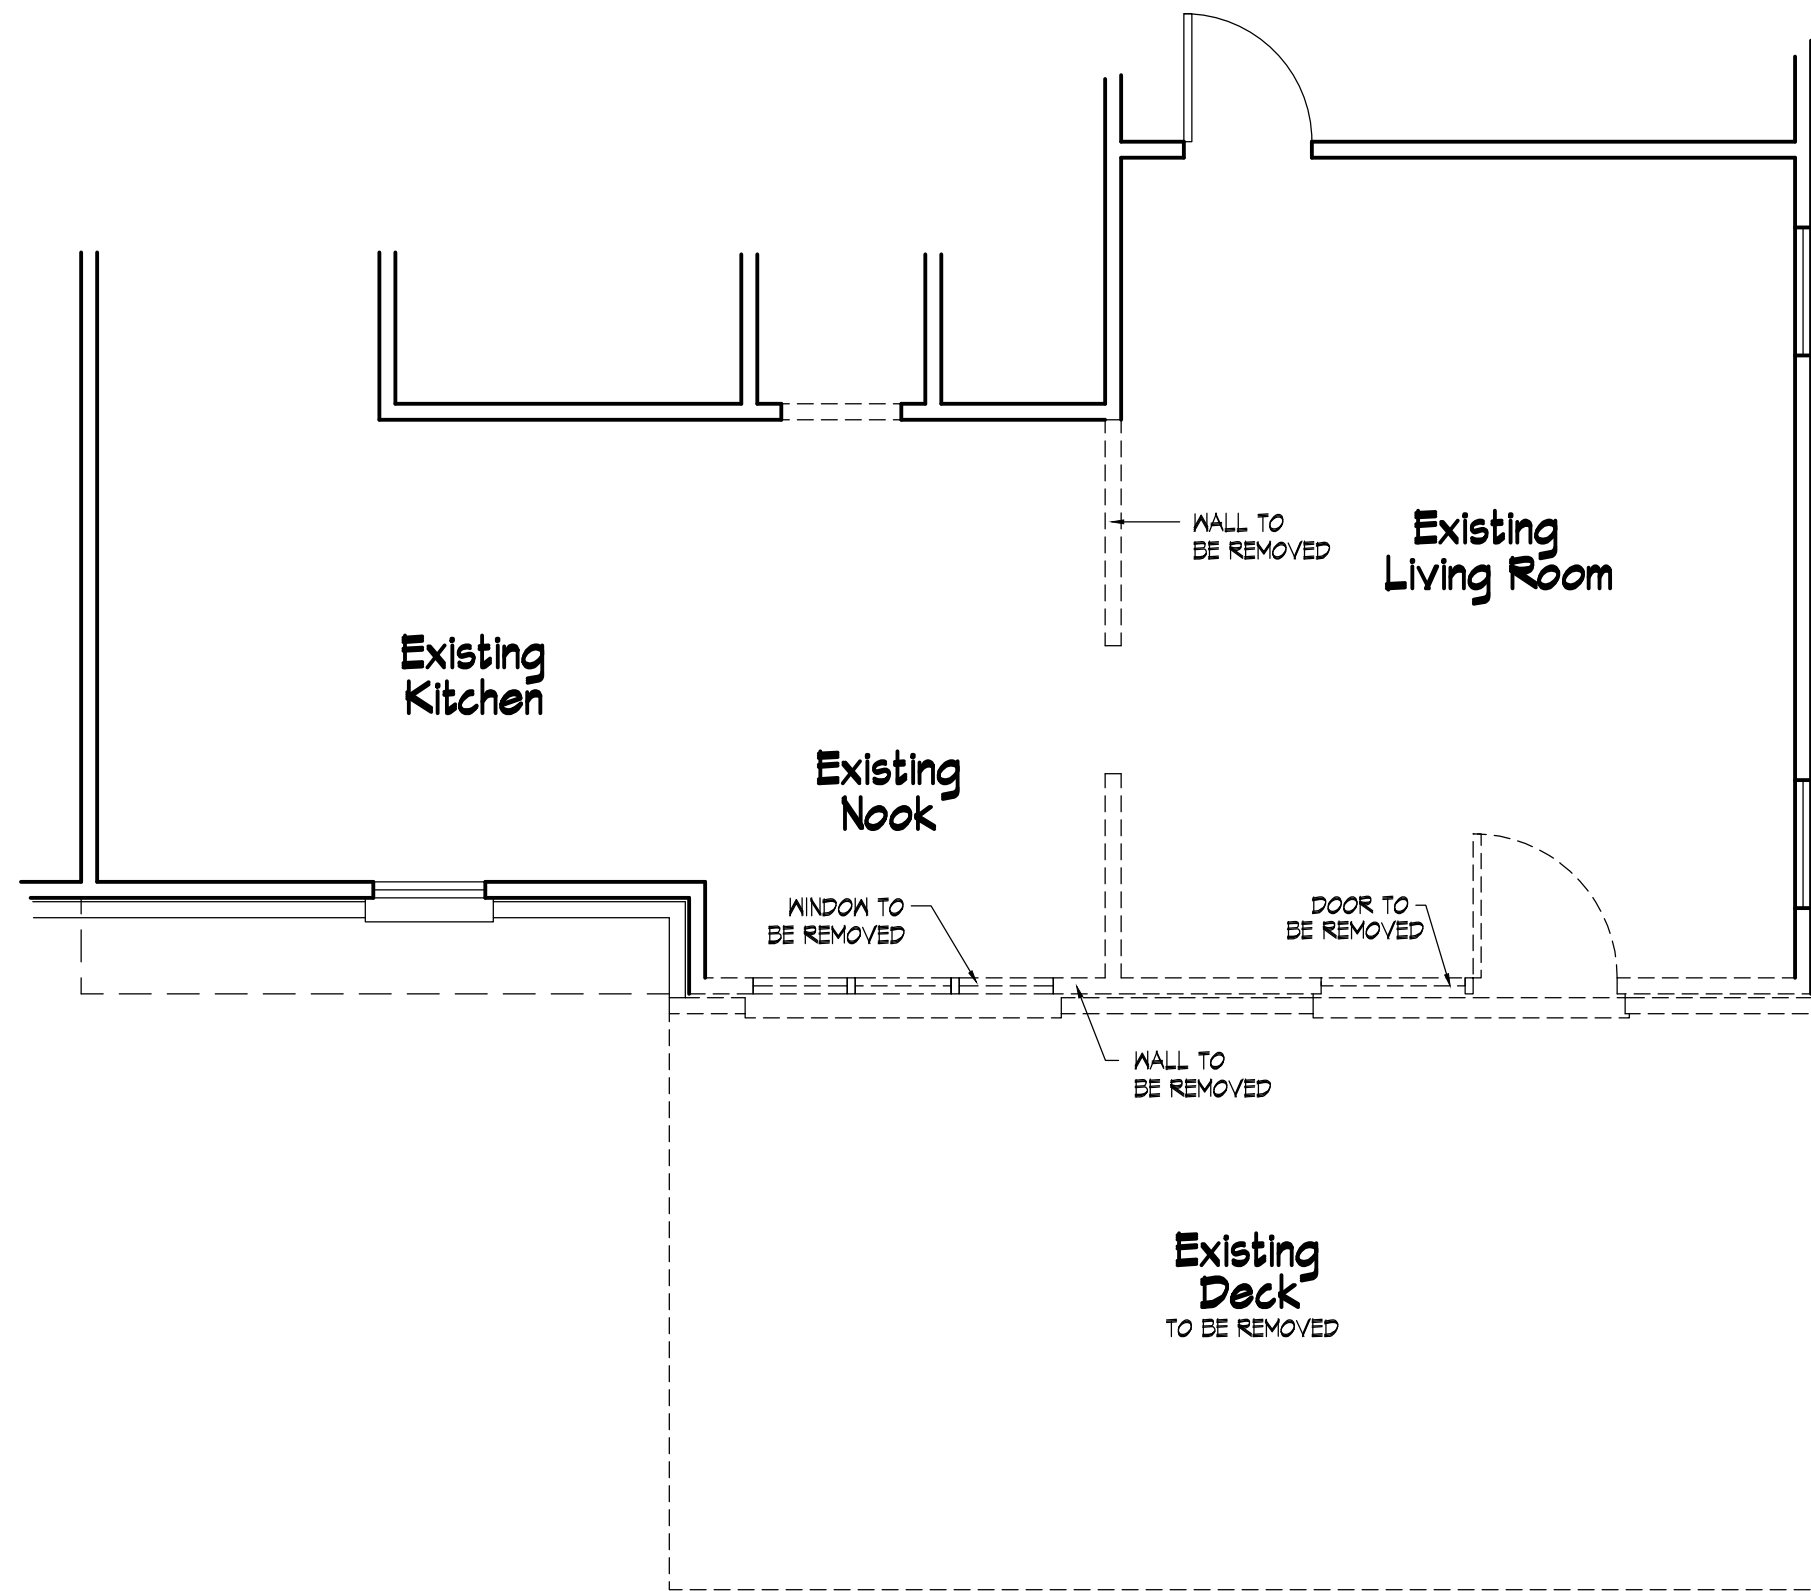

SEE NOTES

102 Existing Floor Plan

 Scale: 1/4" = 1'-0"


  
**John E. Carroll**  
 Residential Design  
 844 montclair road, fayetteville, nc 28314  
 johncarroll.design@gmail.com  
 910.850.9408

Additions to  
**654 Keith Hills Rd**  
**Lillington NC 27546**  
 Sheet Title  
**Existing Conditions**

Revisions

Scale:  
 As Shown  
 Date:  
 April 2024


Sheet No.  
 |

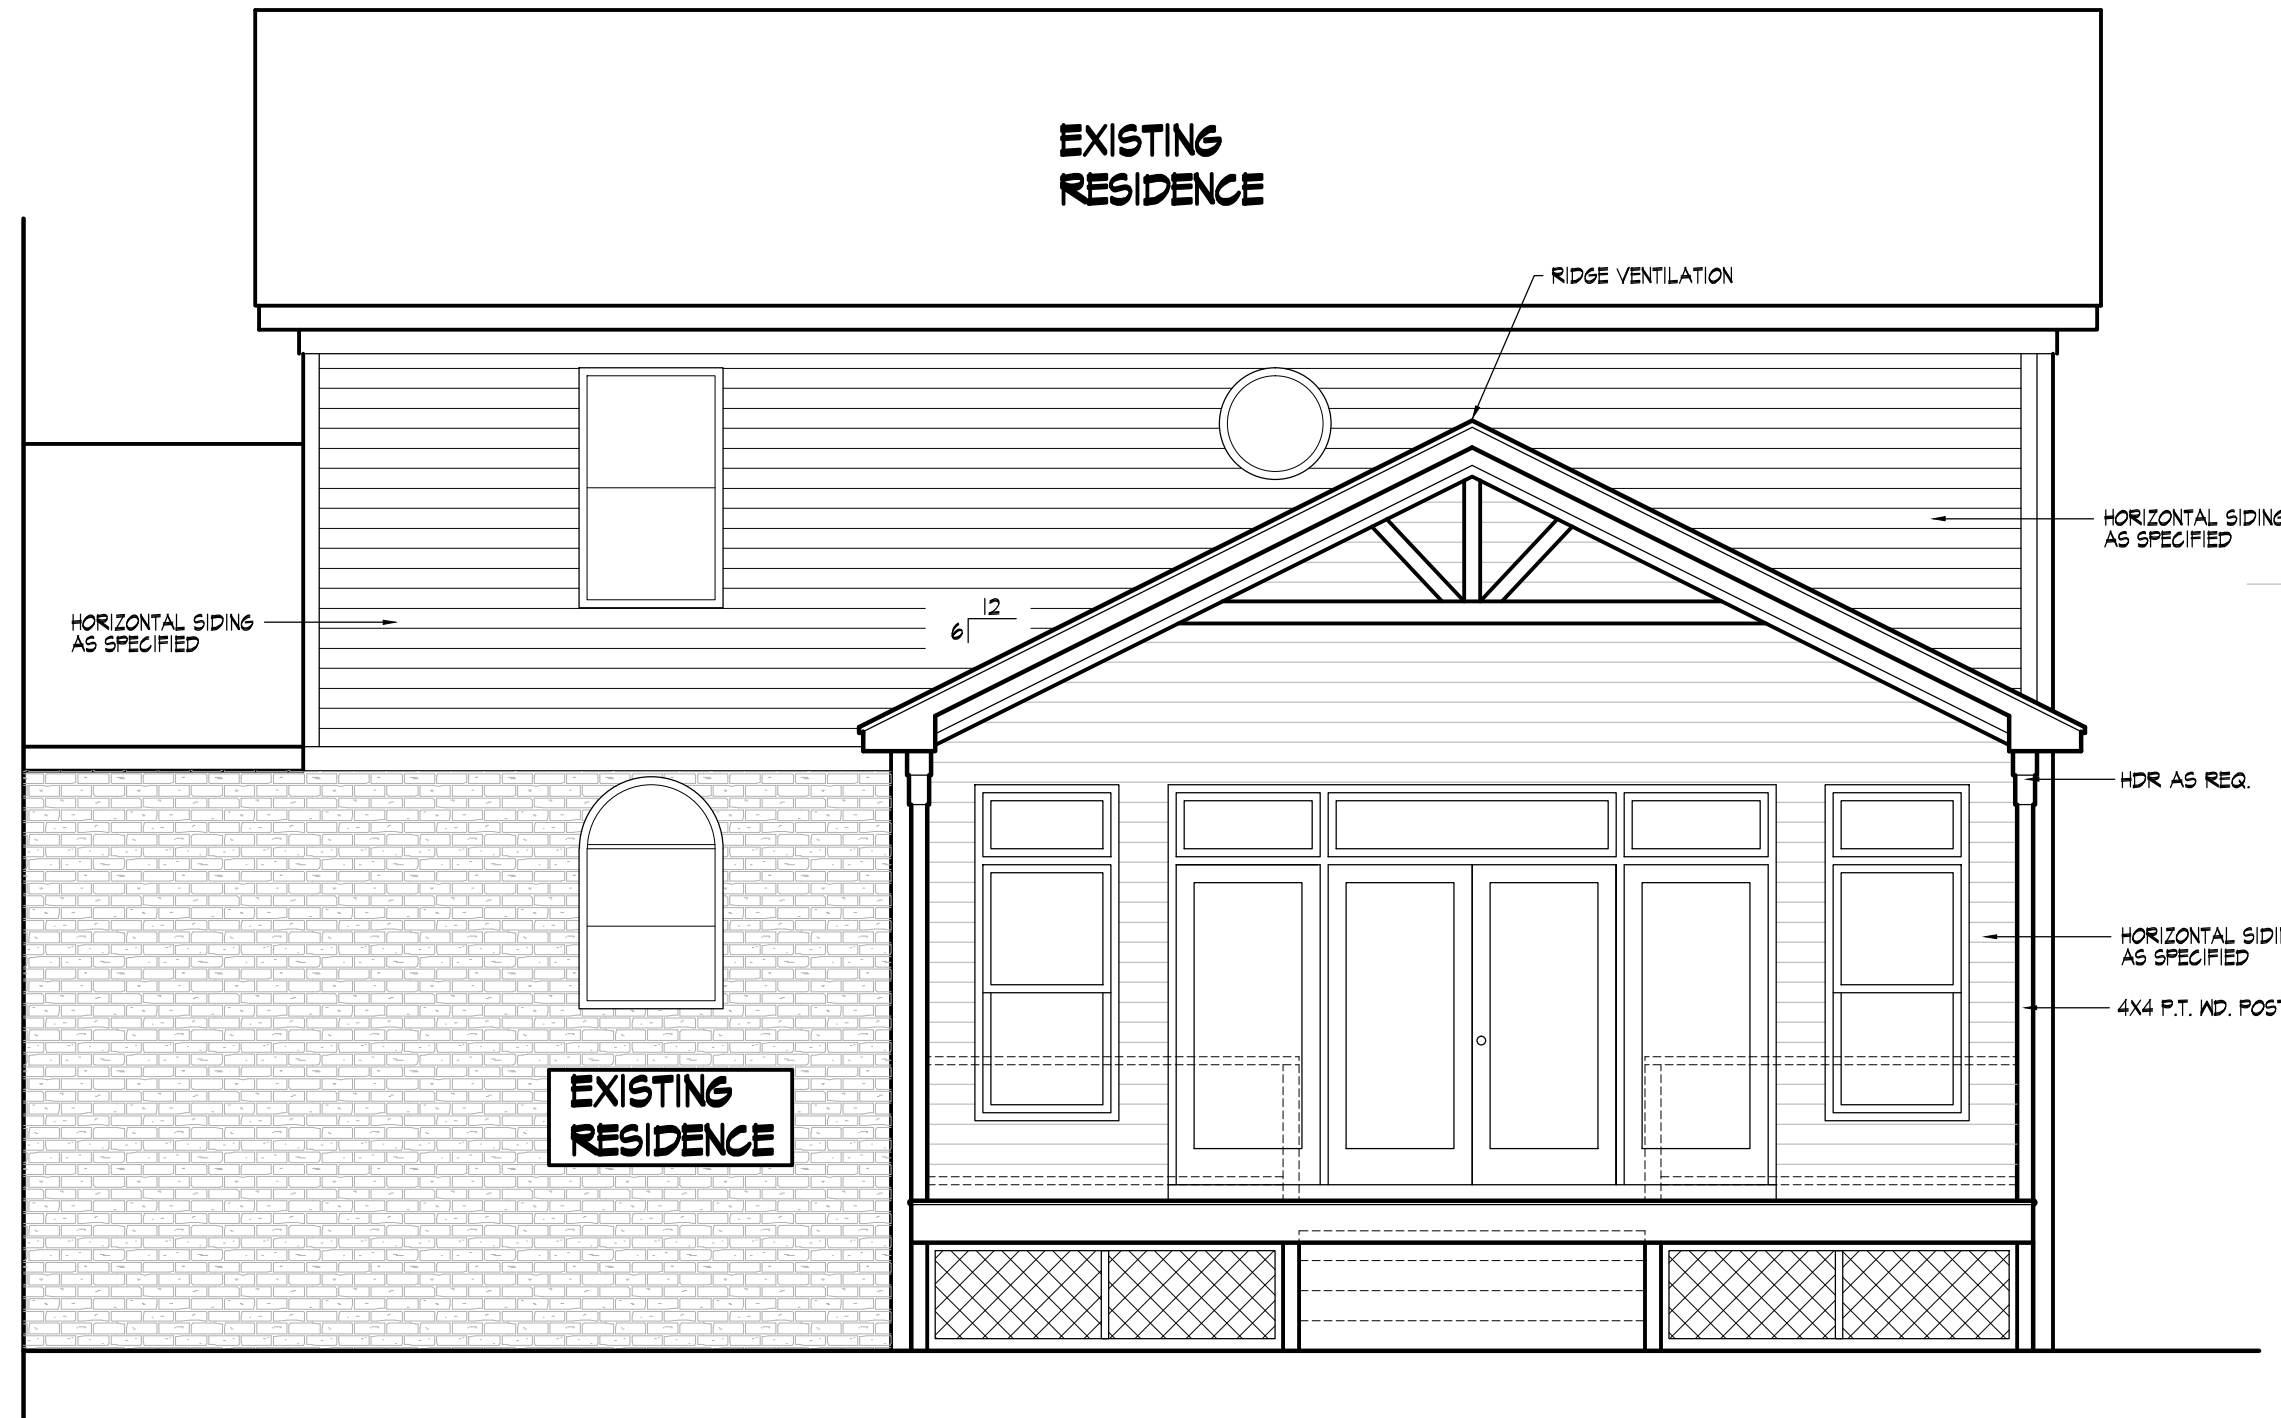

Area Tabulations	
Great Room Addition	370 SQ. FT.
Wooden Deck	234 SQ. FT.


**201 Rear Elevation**

Scale: 1/4" = 1'-0"

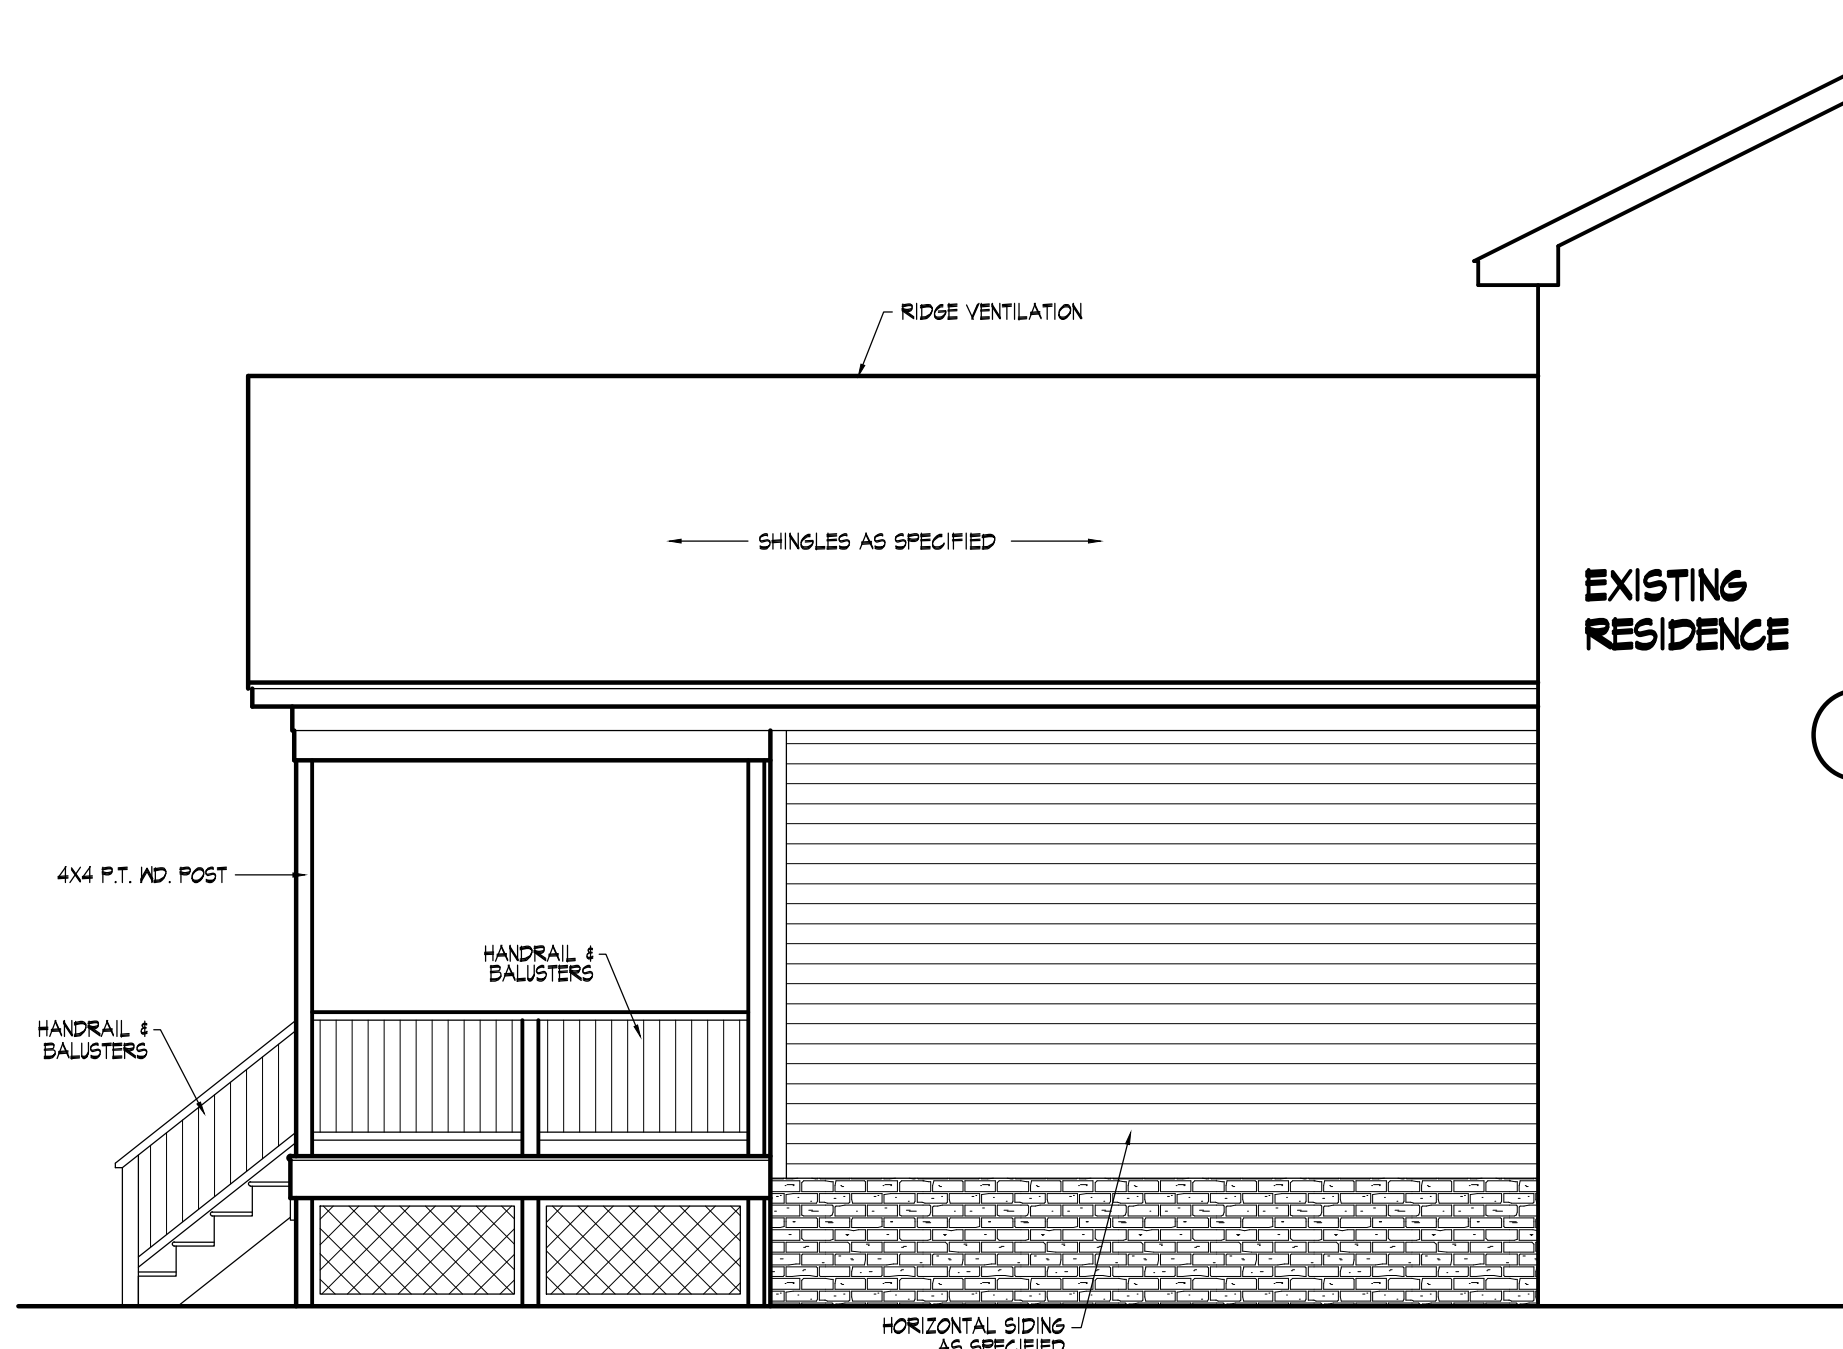

**202 Left Elevation**

Scale: 1/4" = 1'-0"

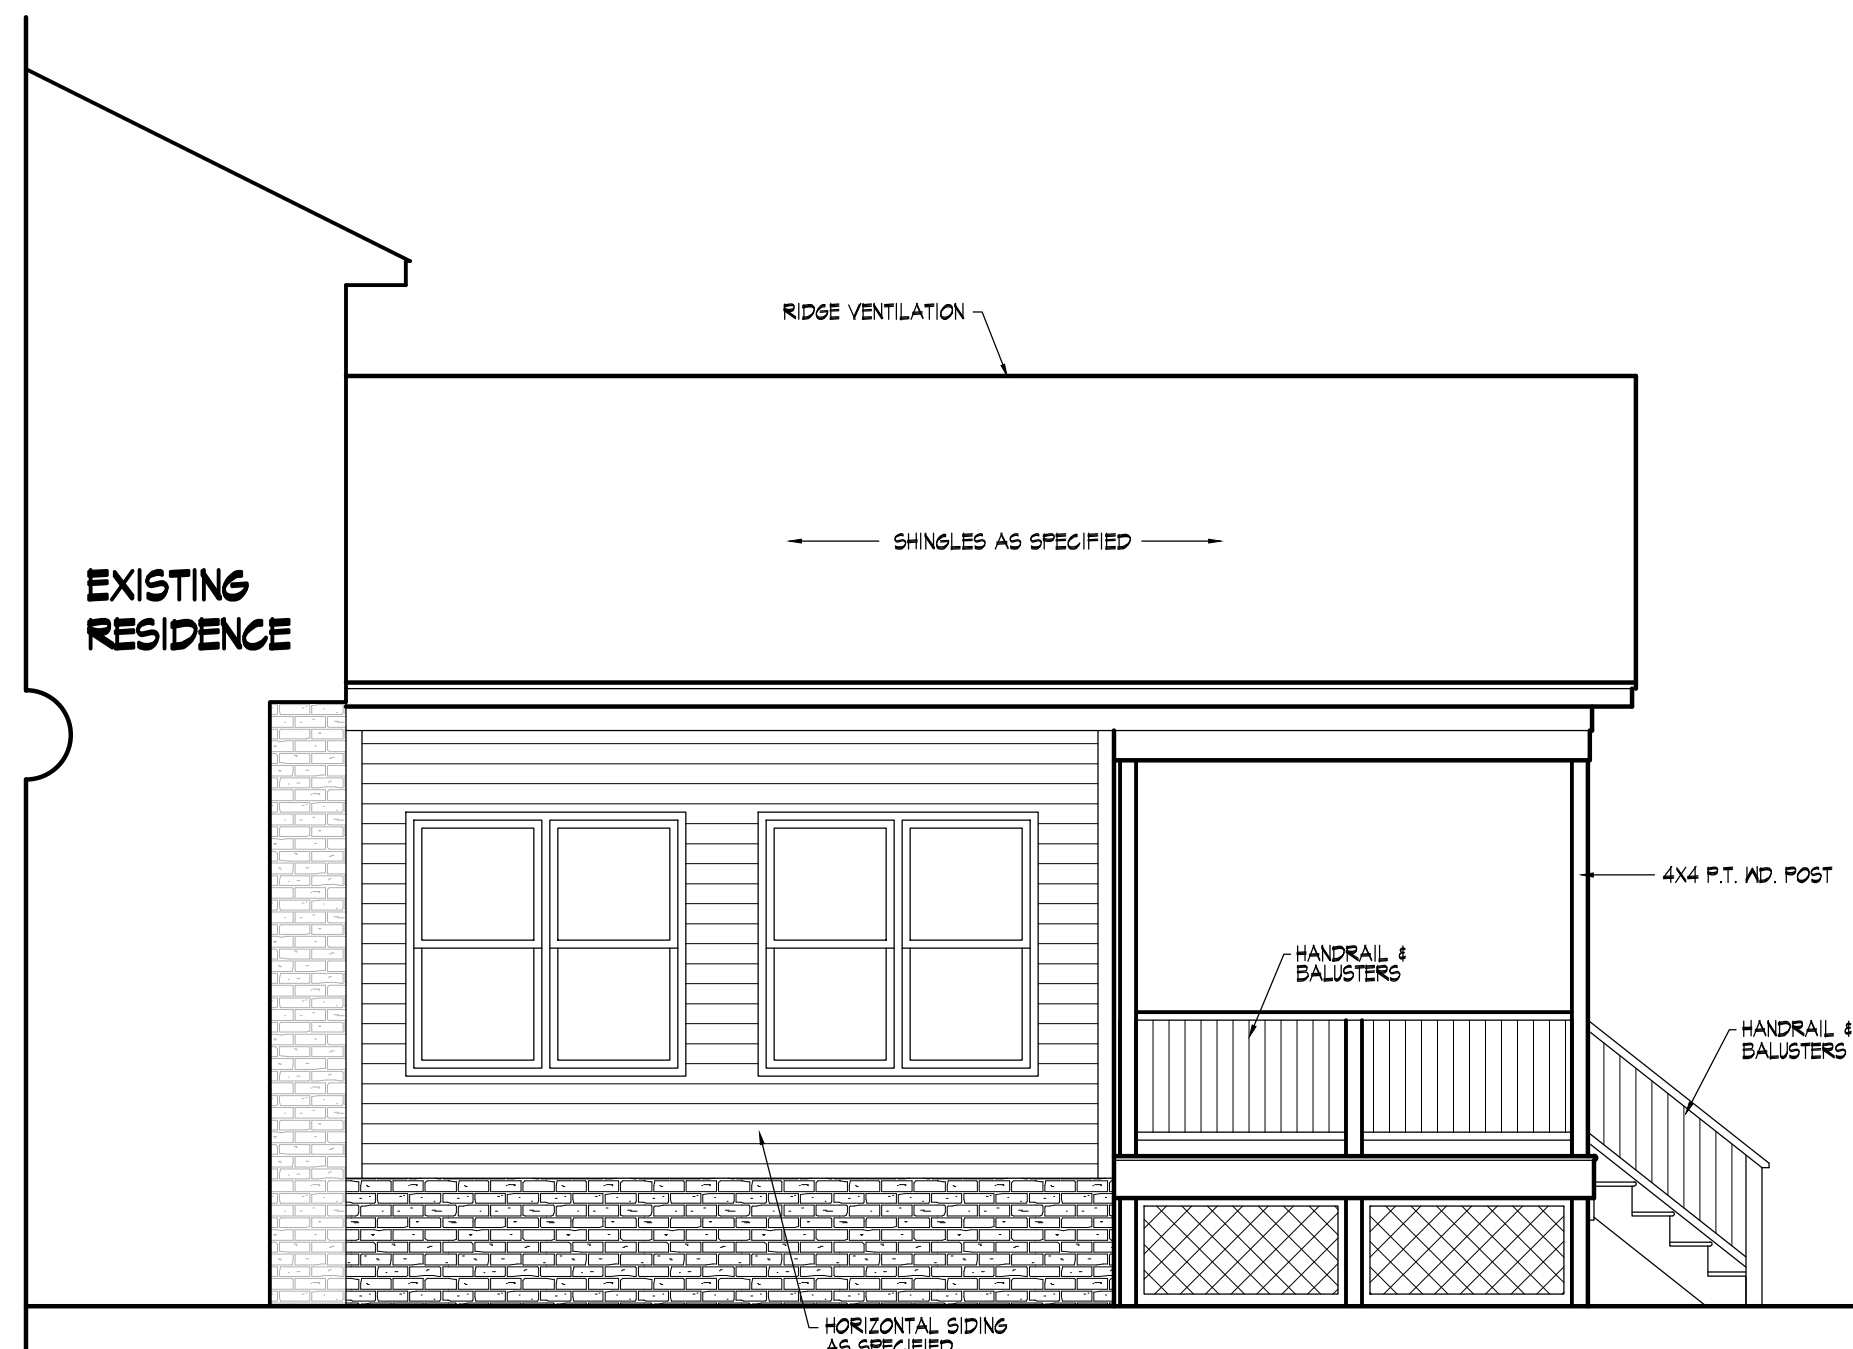


**203 Right Elevation**

Scale: 1/4" = 1'-0"


Revisions

Scale:  
 As Shown  
 Date:  
 April 2024

Sheet No.  
**2**

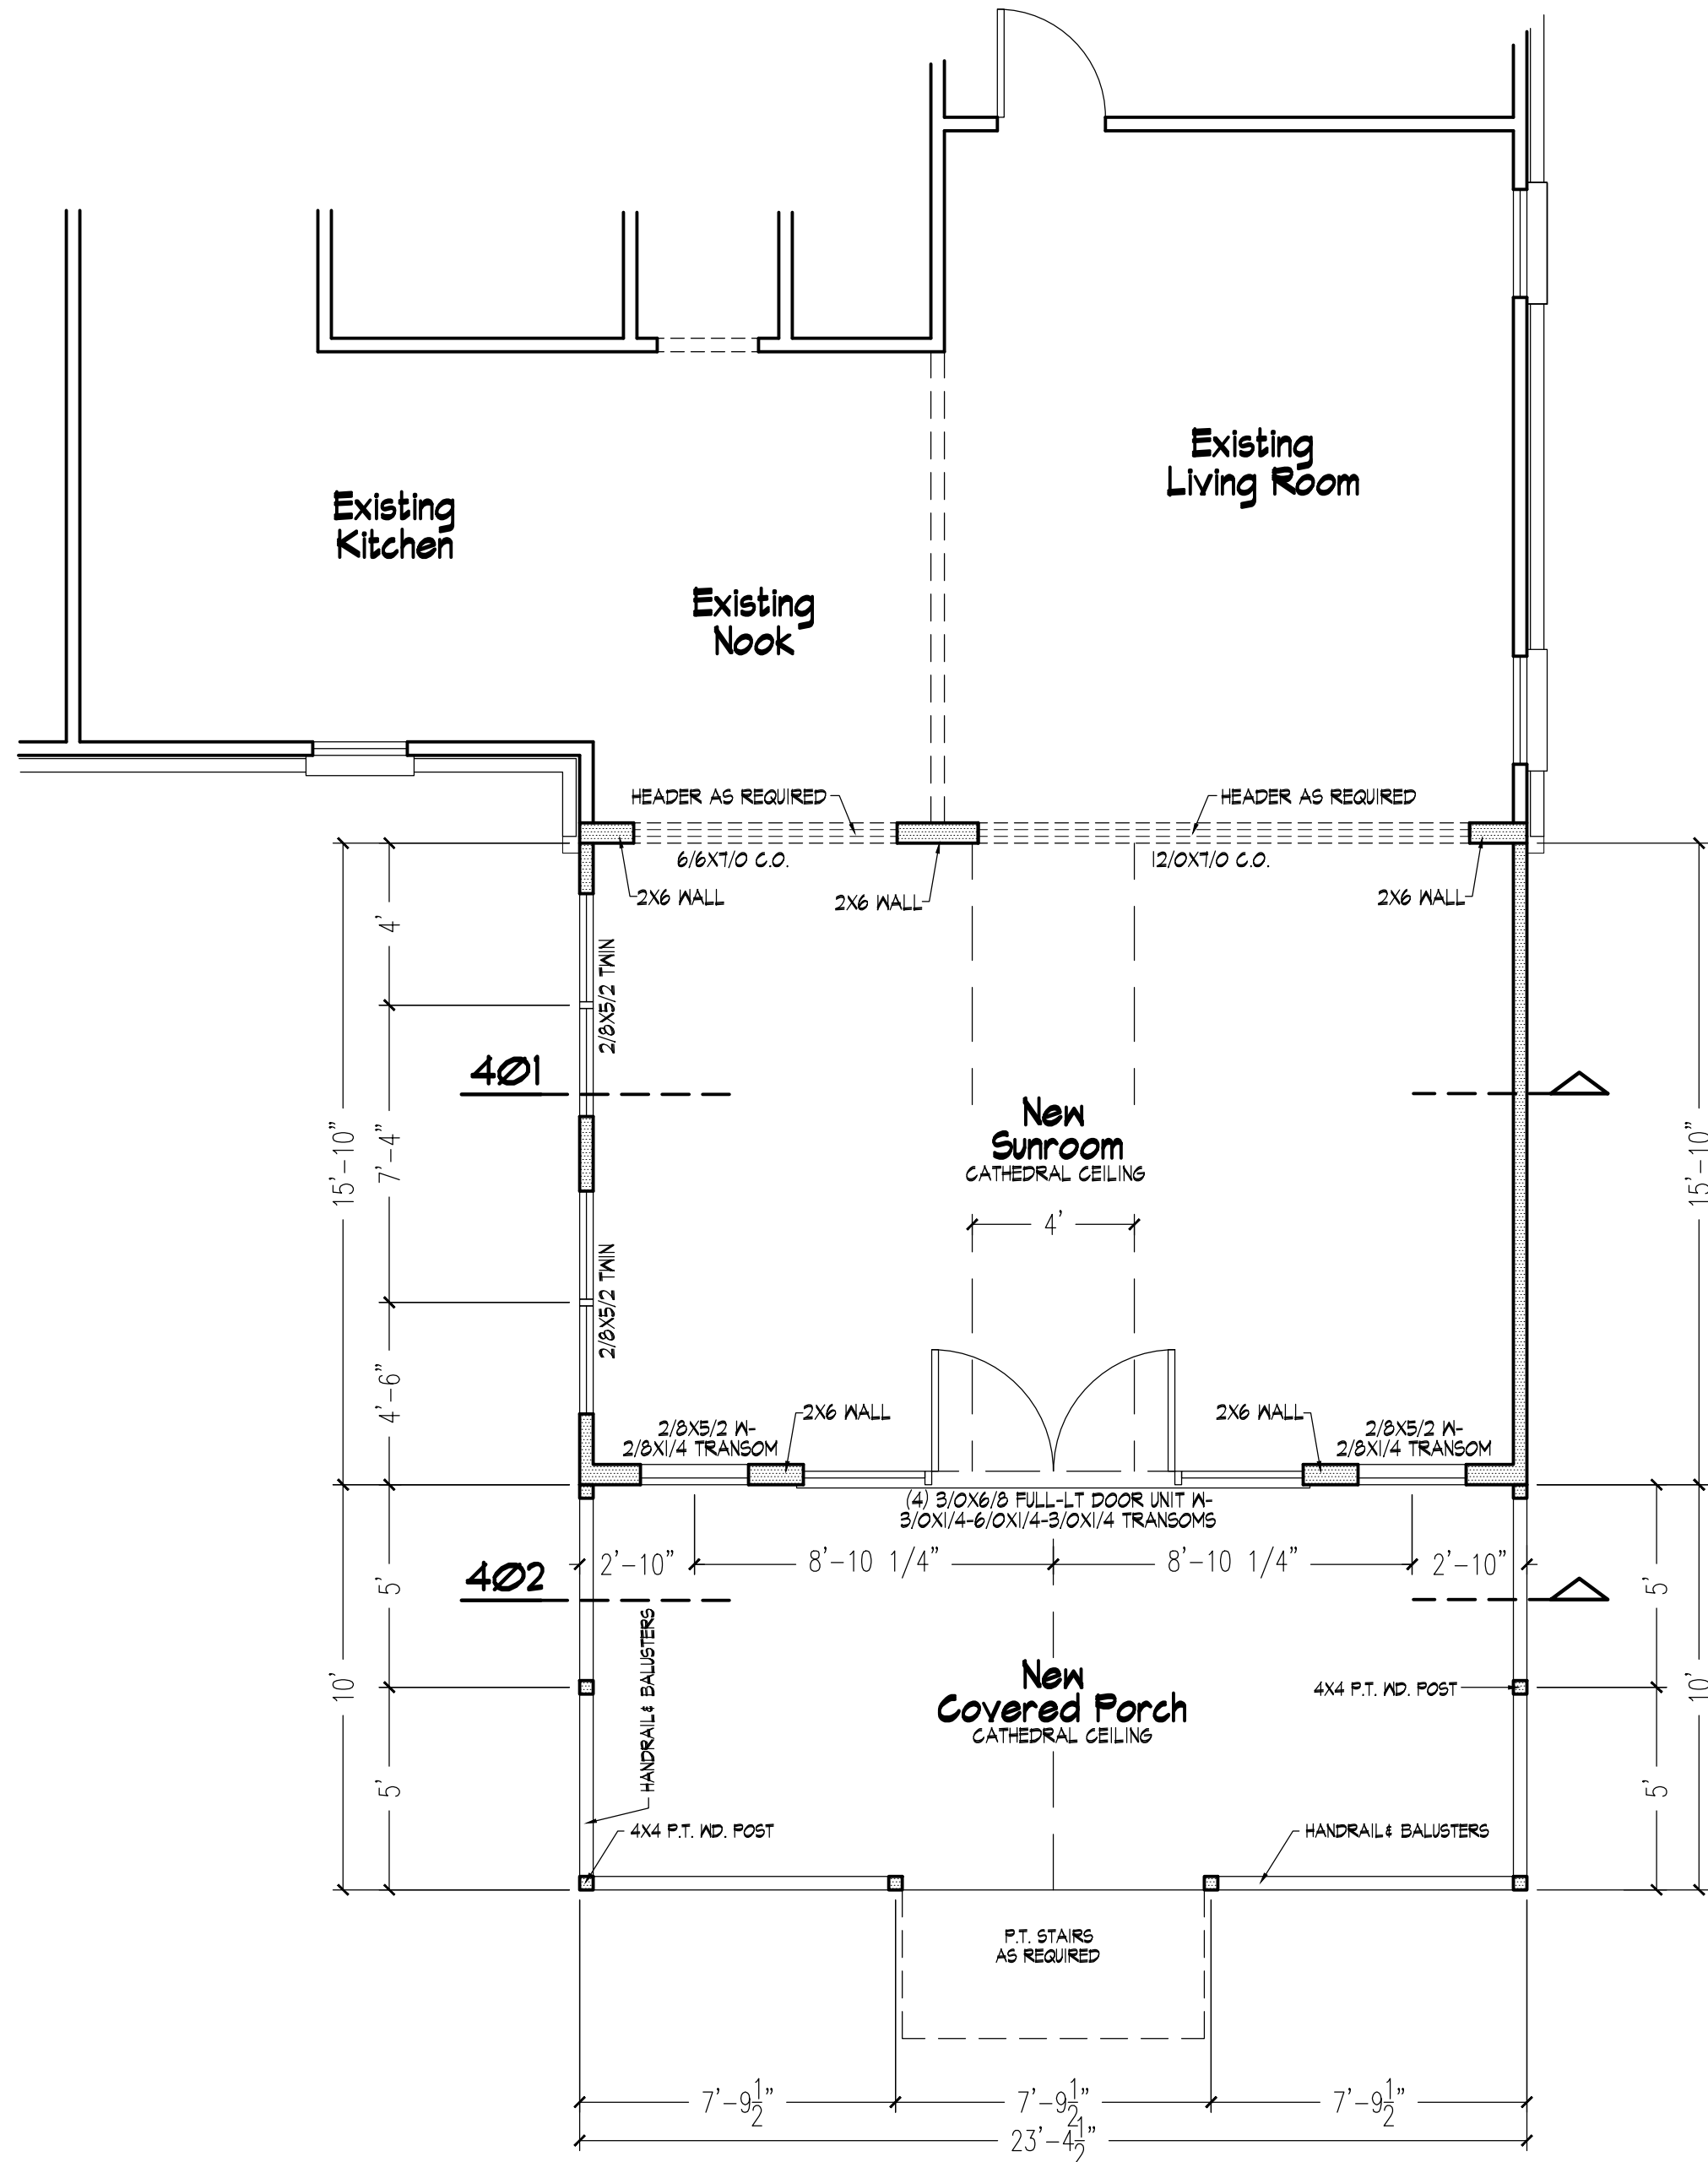

**301 Floor Plan**  
Scale: 1/4" = 1'-0"

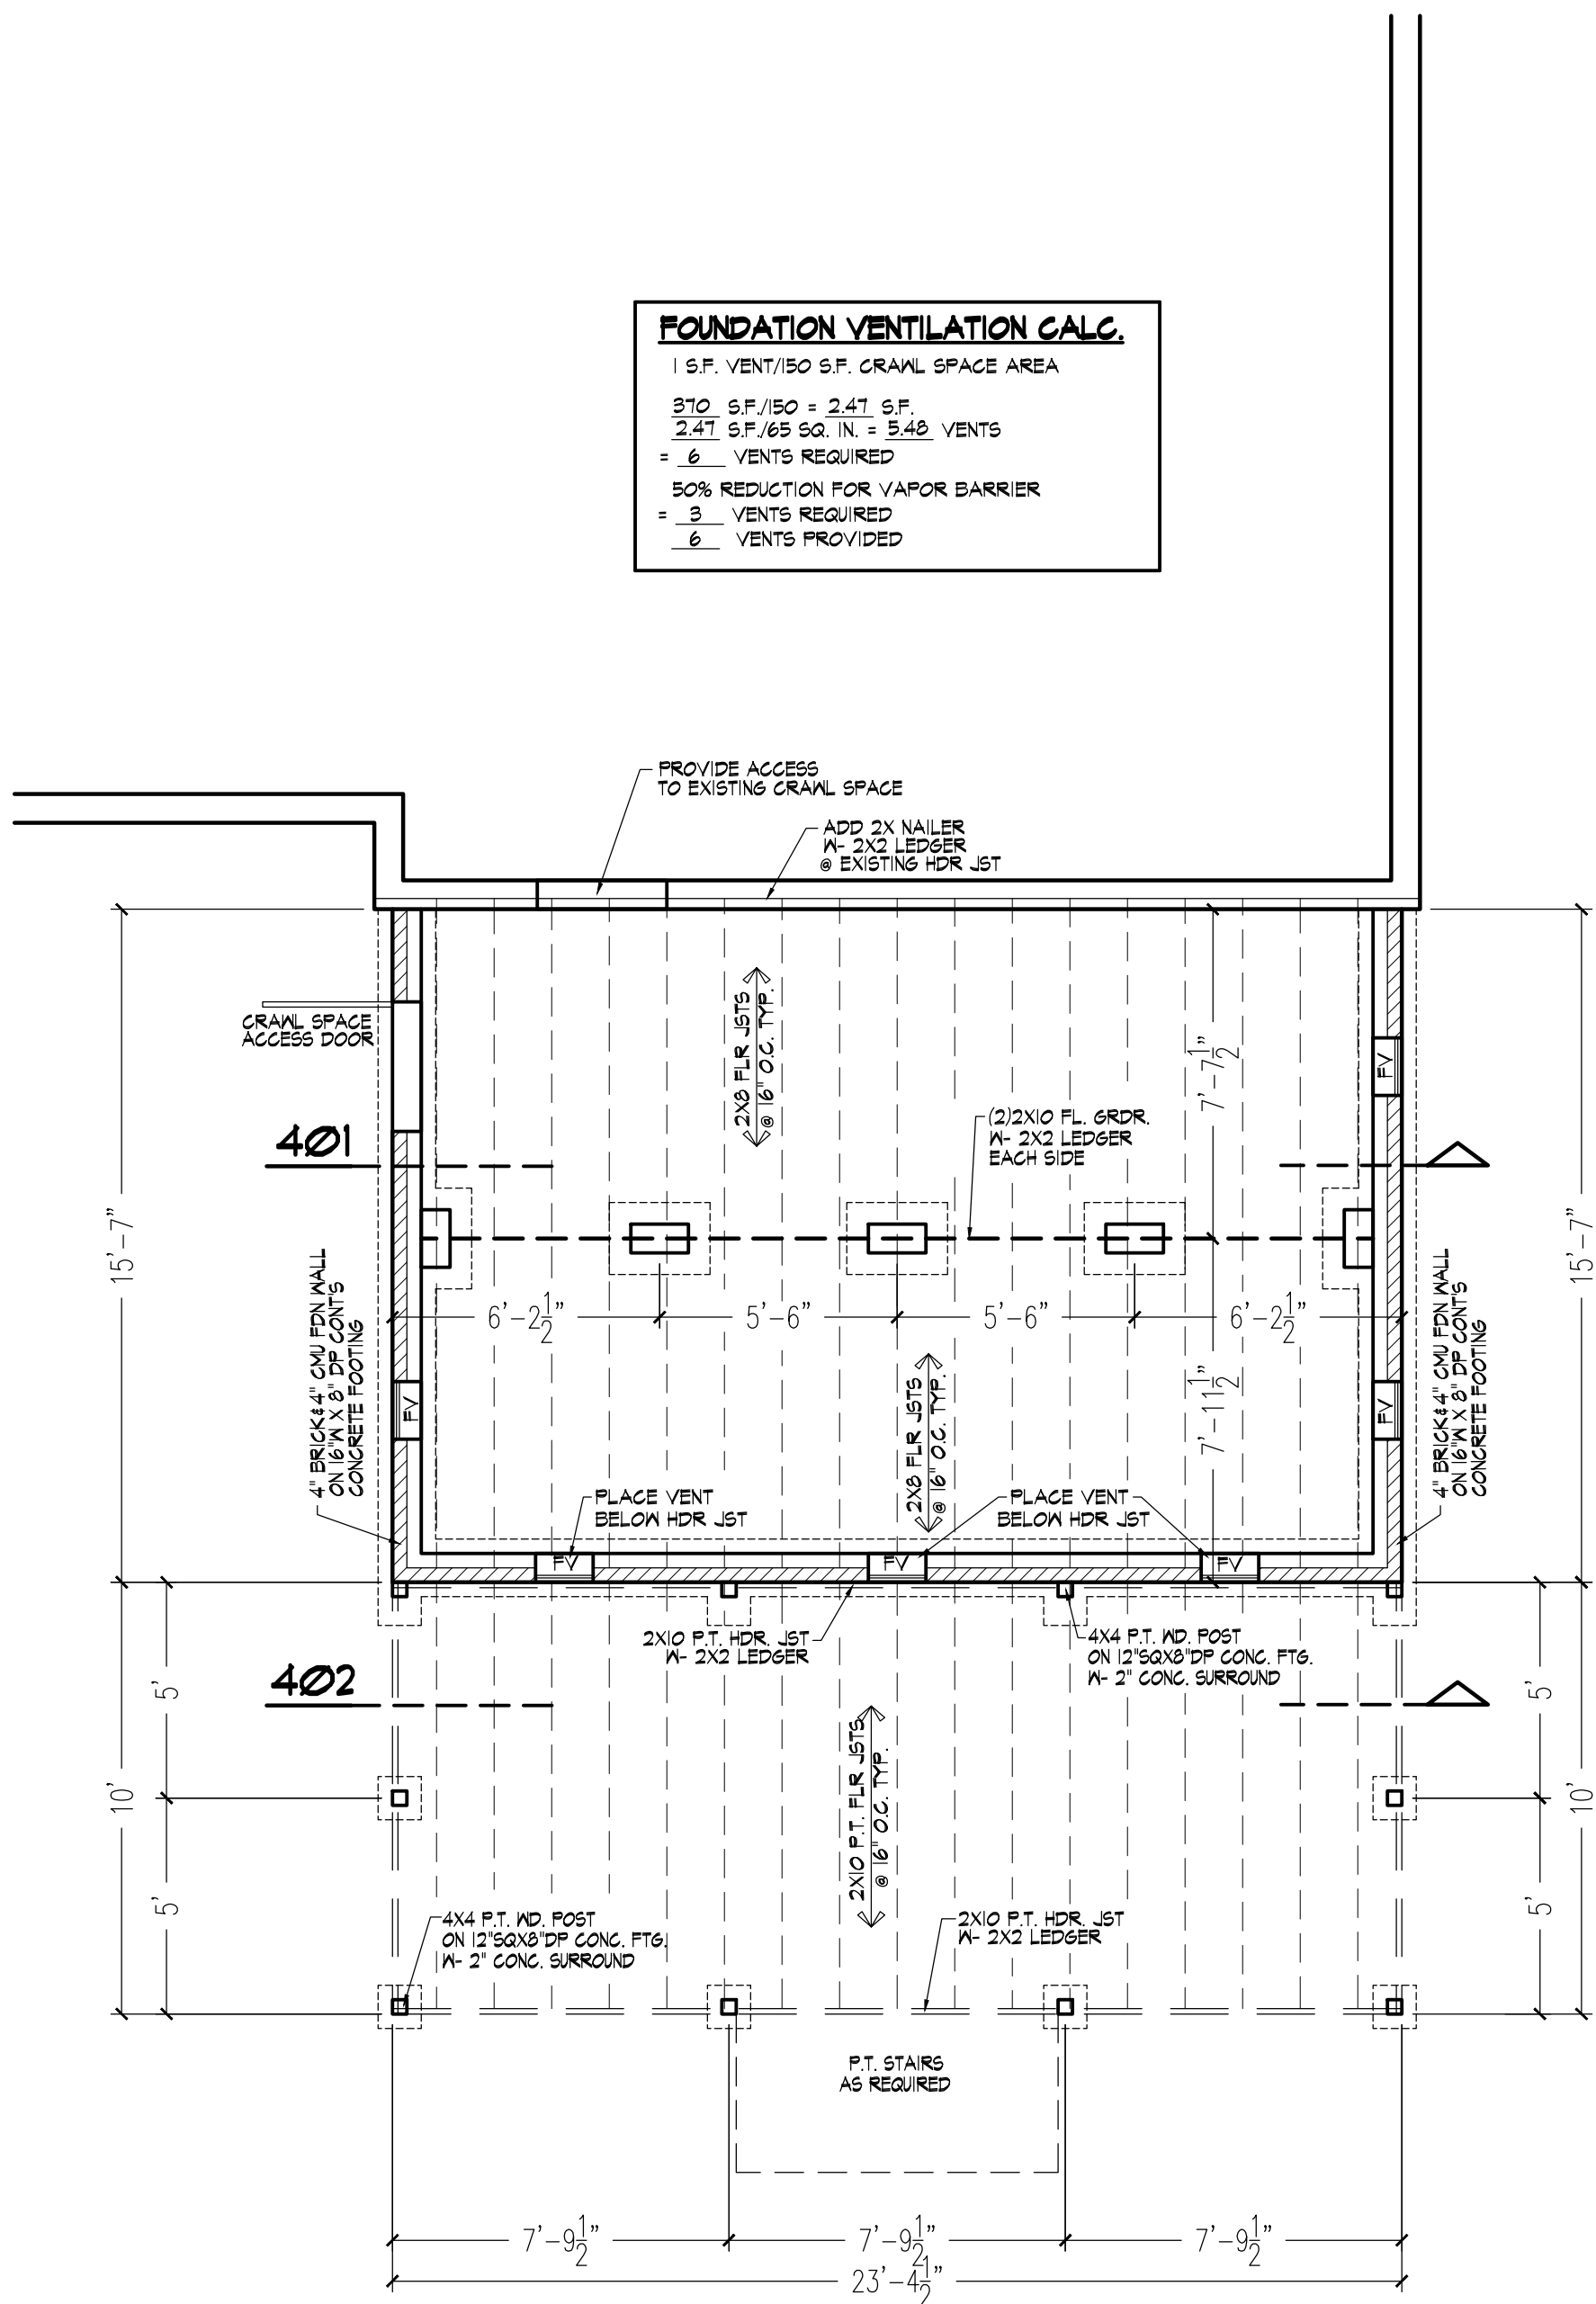

**302 Foundation Plan**  
Scale: 1/4" = 1'-0"

Revisions

Scale:  
As Shown  
Date:  
April 2024


Sheet No.  
**3**

Revisions


Scale:  
 As Shown  
 Date:  
 April 2024

Sheet No.


**4**

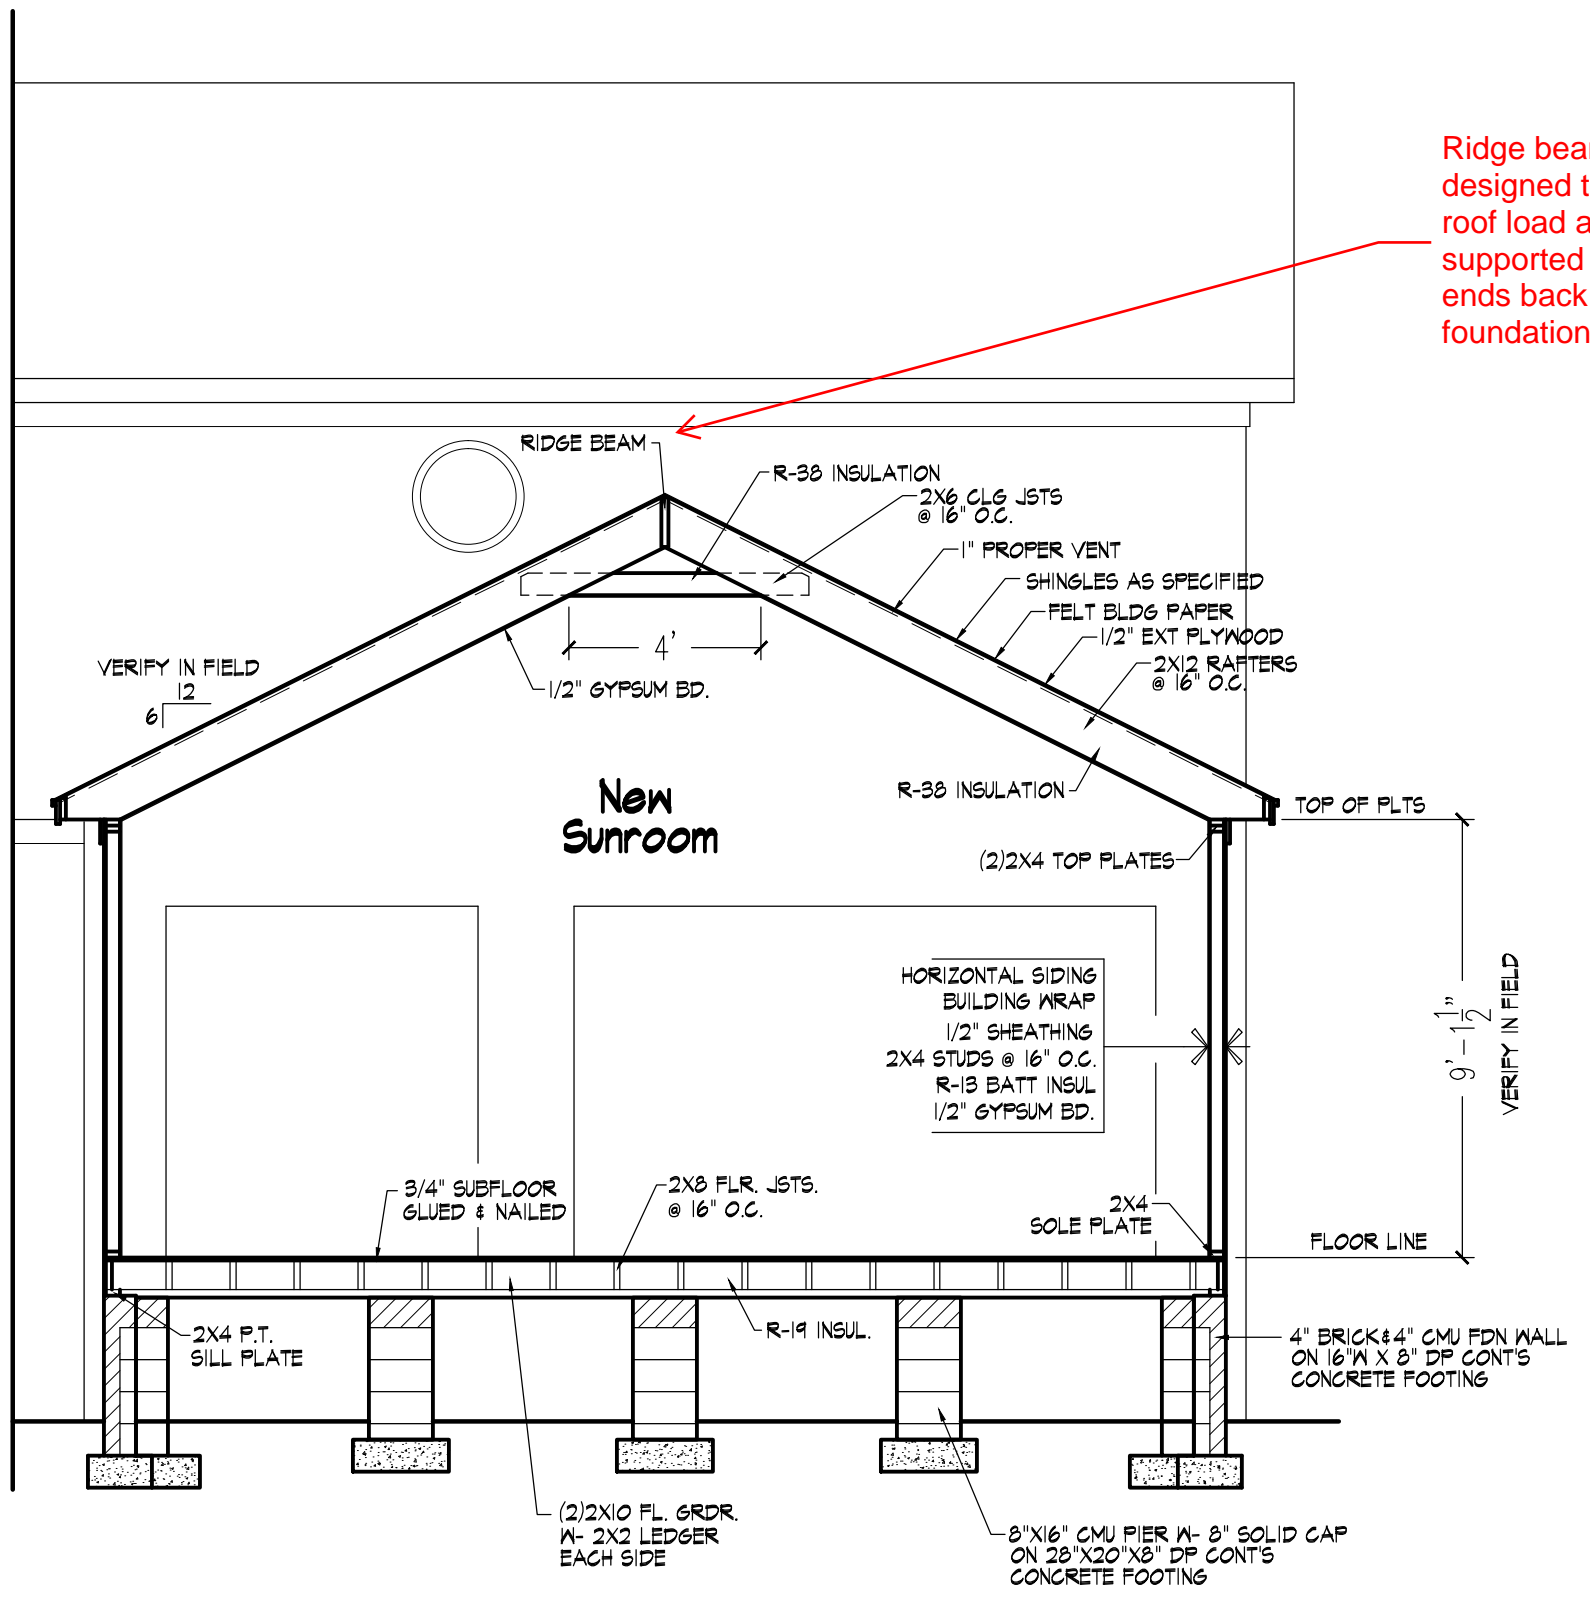


**401 Building Section**  
 Scale: 1/4" = 1'-0"

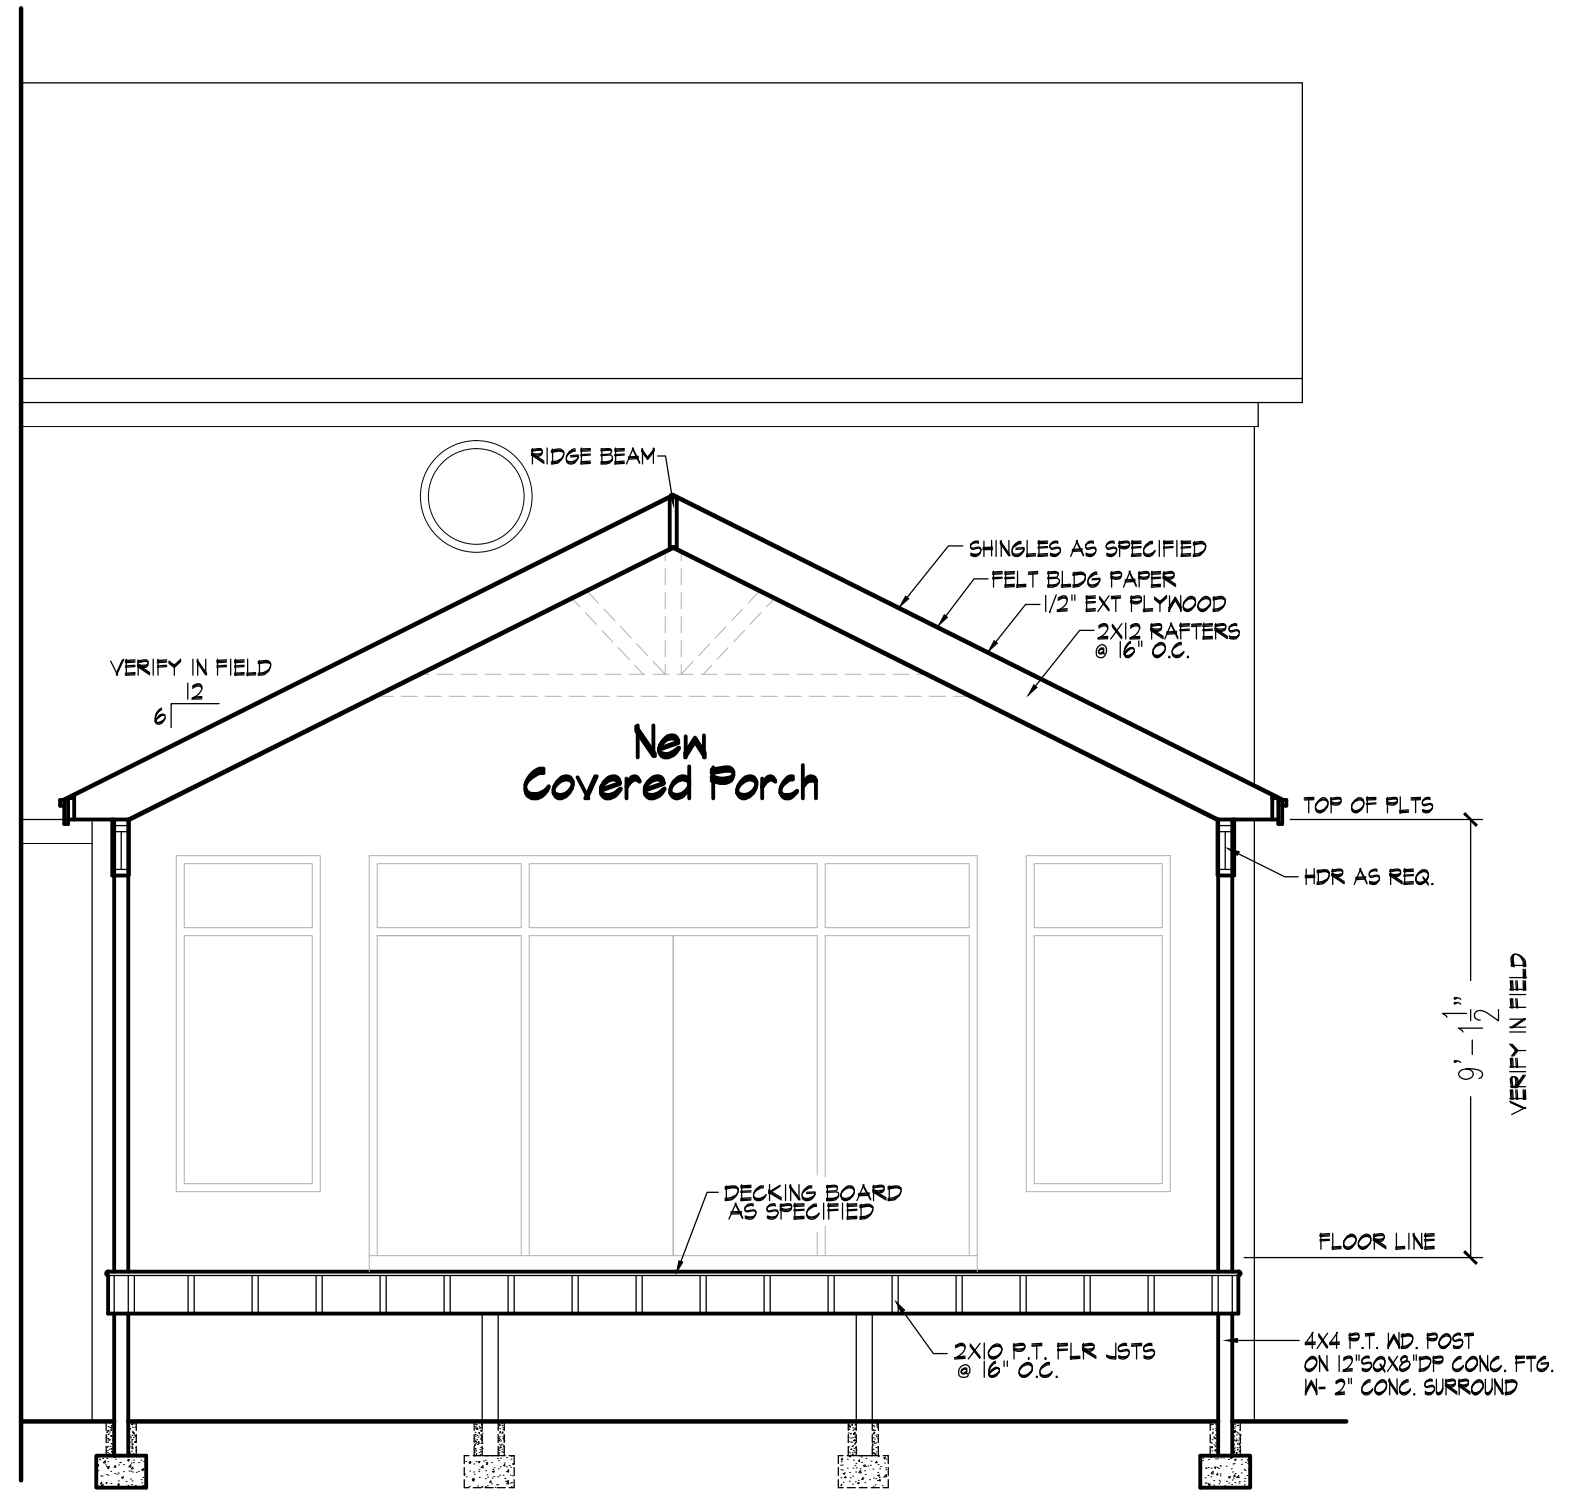

**402 Building Section**  
 Scale: 1/4" = 1'-0"

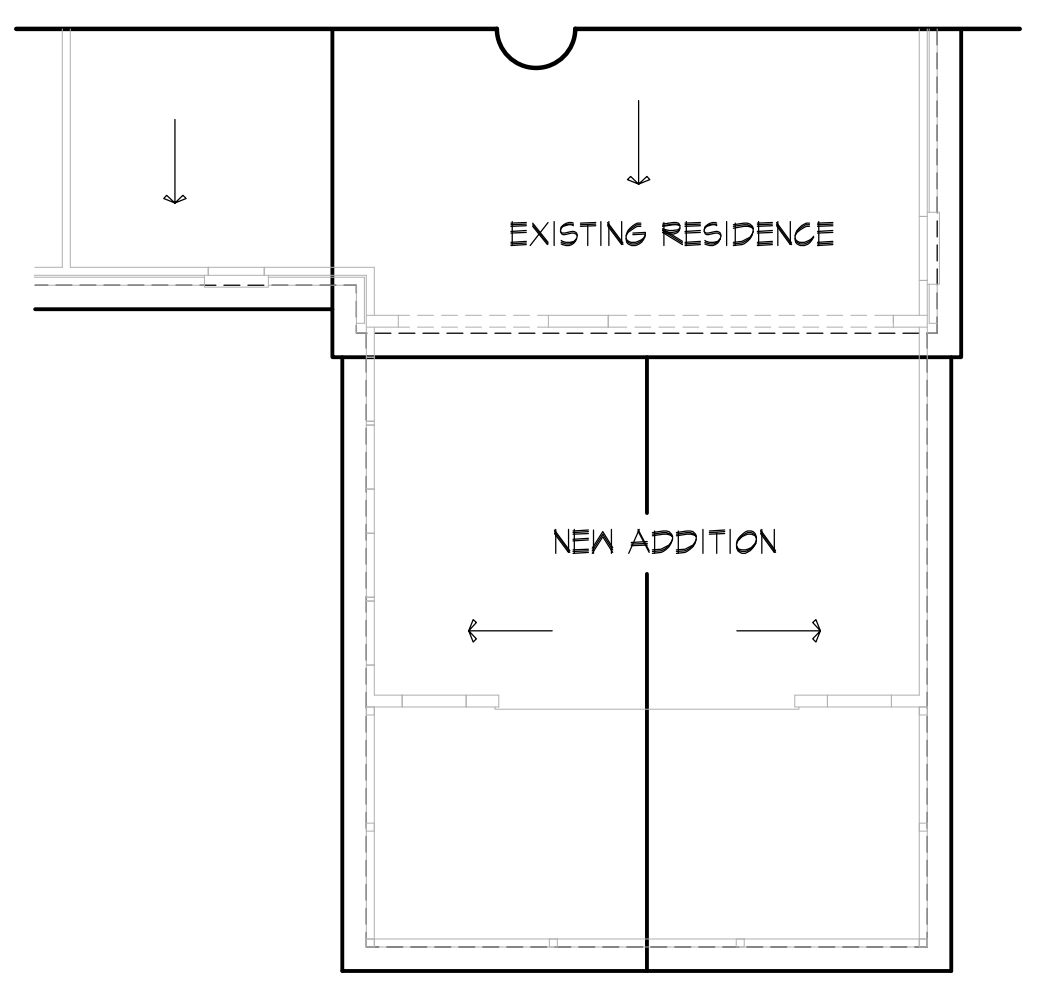

**403 Roof Plan**  
 Scale: 1/8" = 1'-0"

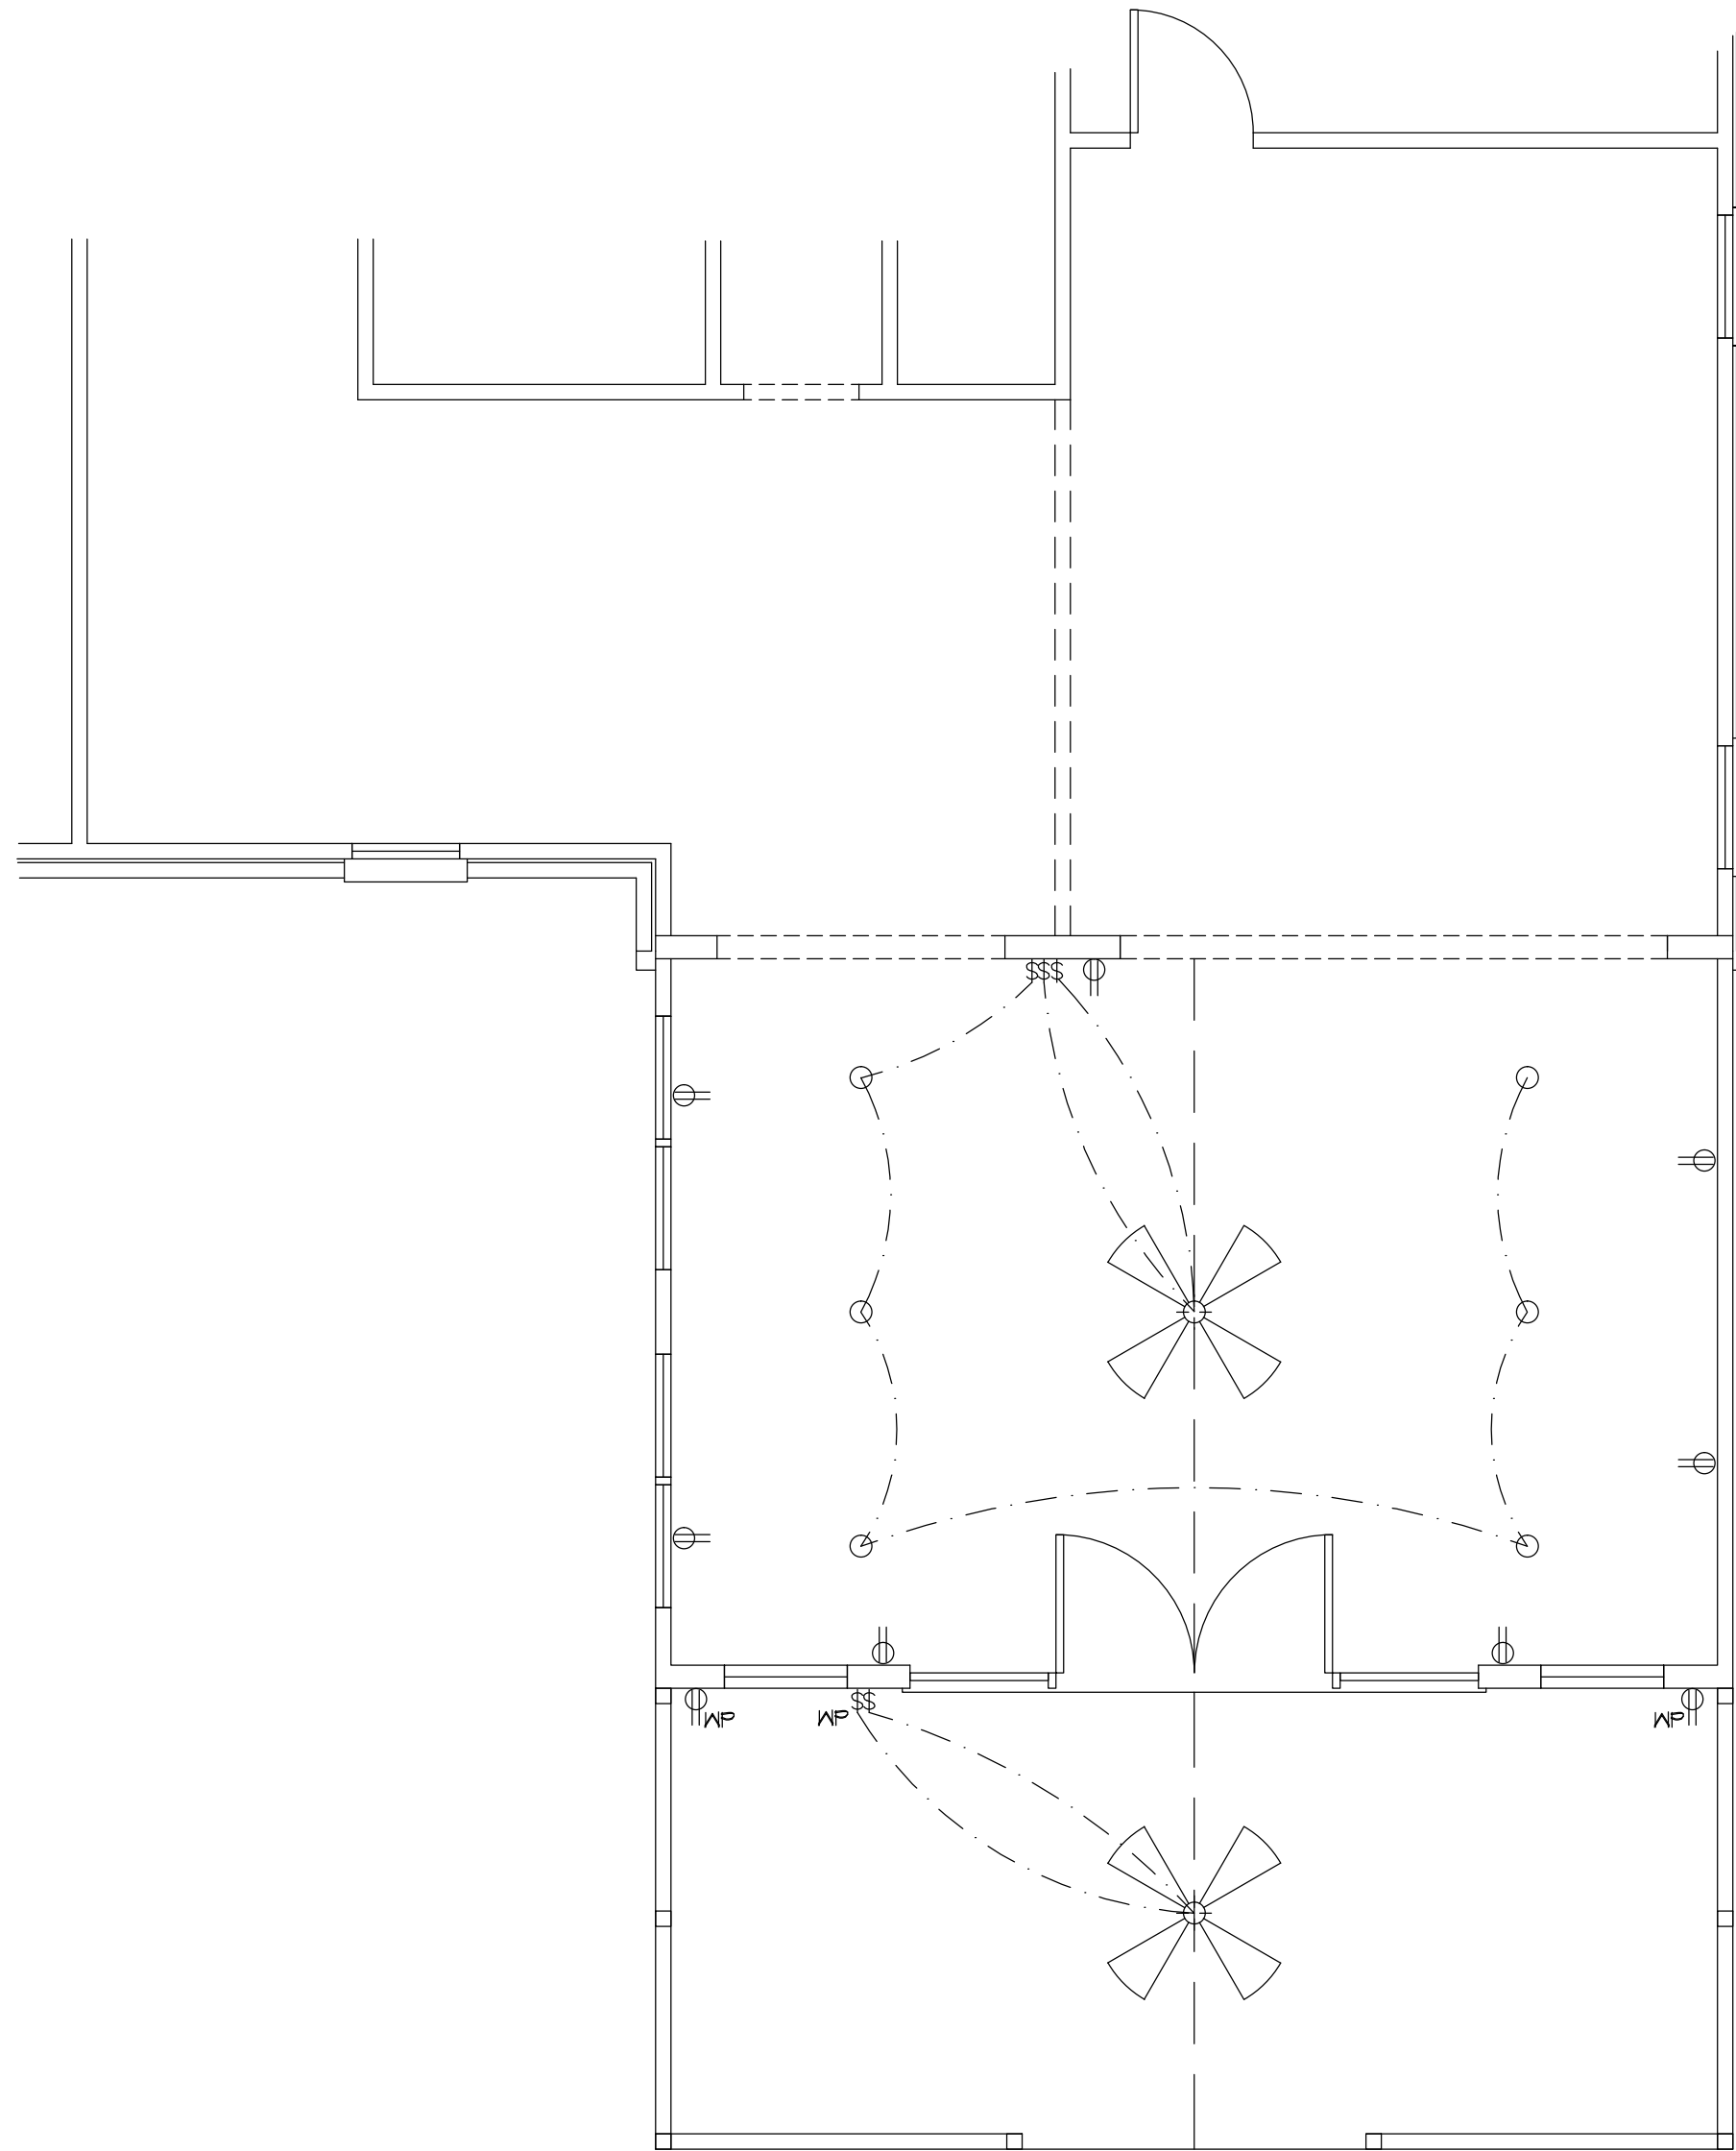

# 501 Electrical Floor Plan

Scale: 1/4" = 1'-0"

ELECTRICAL SYMBOLS	
	TYPICAL WALL RECEPTACLE
	110 V - 42" AFF
	HALF HOT AND HALF SWITCHED
	WATERPROOF RECEPTACLE
	110 V - GROUND FAULT
	220 V OUTLET
	110 V OUTLET - FLOOR MOUNT
	CEILING RECEPTACLE
	TOUCH - PAD
	TYPICAL SWITCH
	3 WAY OR MORE (SEE PLAN)
	DIMMER SWITCH
	LIGHT - RECESSED
	LIGHT - WALL MOUNT
	LIGHT - CEILING MOUNT
	PENDANT LIGHT
	EXHAUST FAN
	FAN - LIGHT COMBINATION
	FLOOD LIGHTS
	FLOURESCENT TUBE
	FLOURESCENT LIGHT FIXTURE
	CLG. FAN

Revisions

Scale:  
As Shown  
Date:  
April 2024

Sheet No.

**JT**