



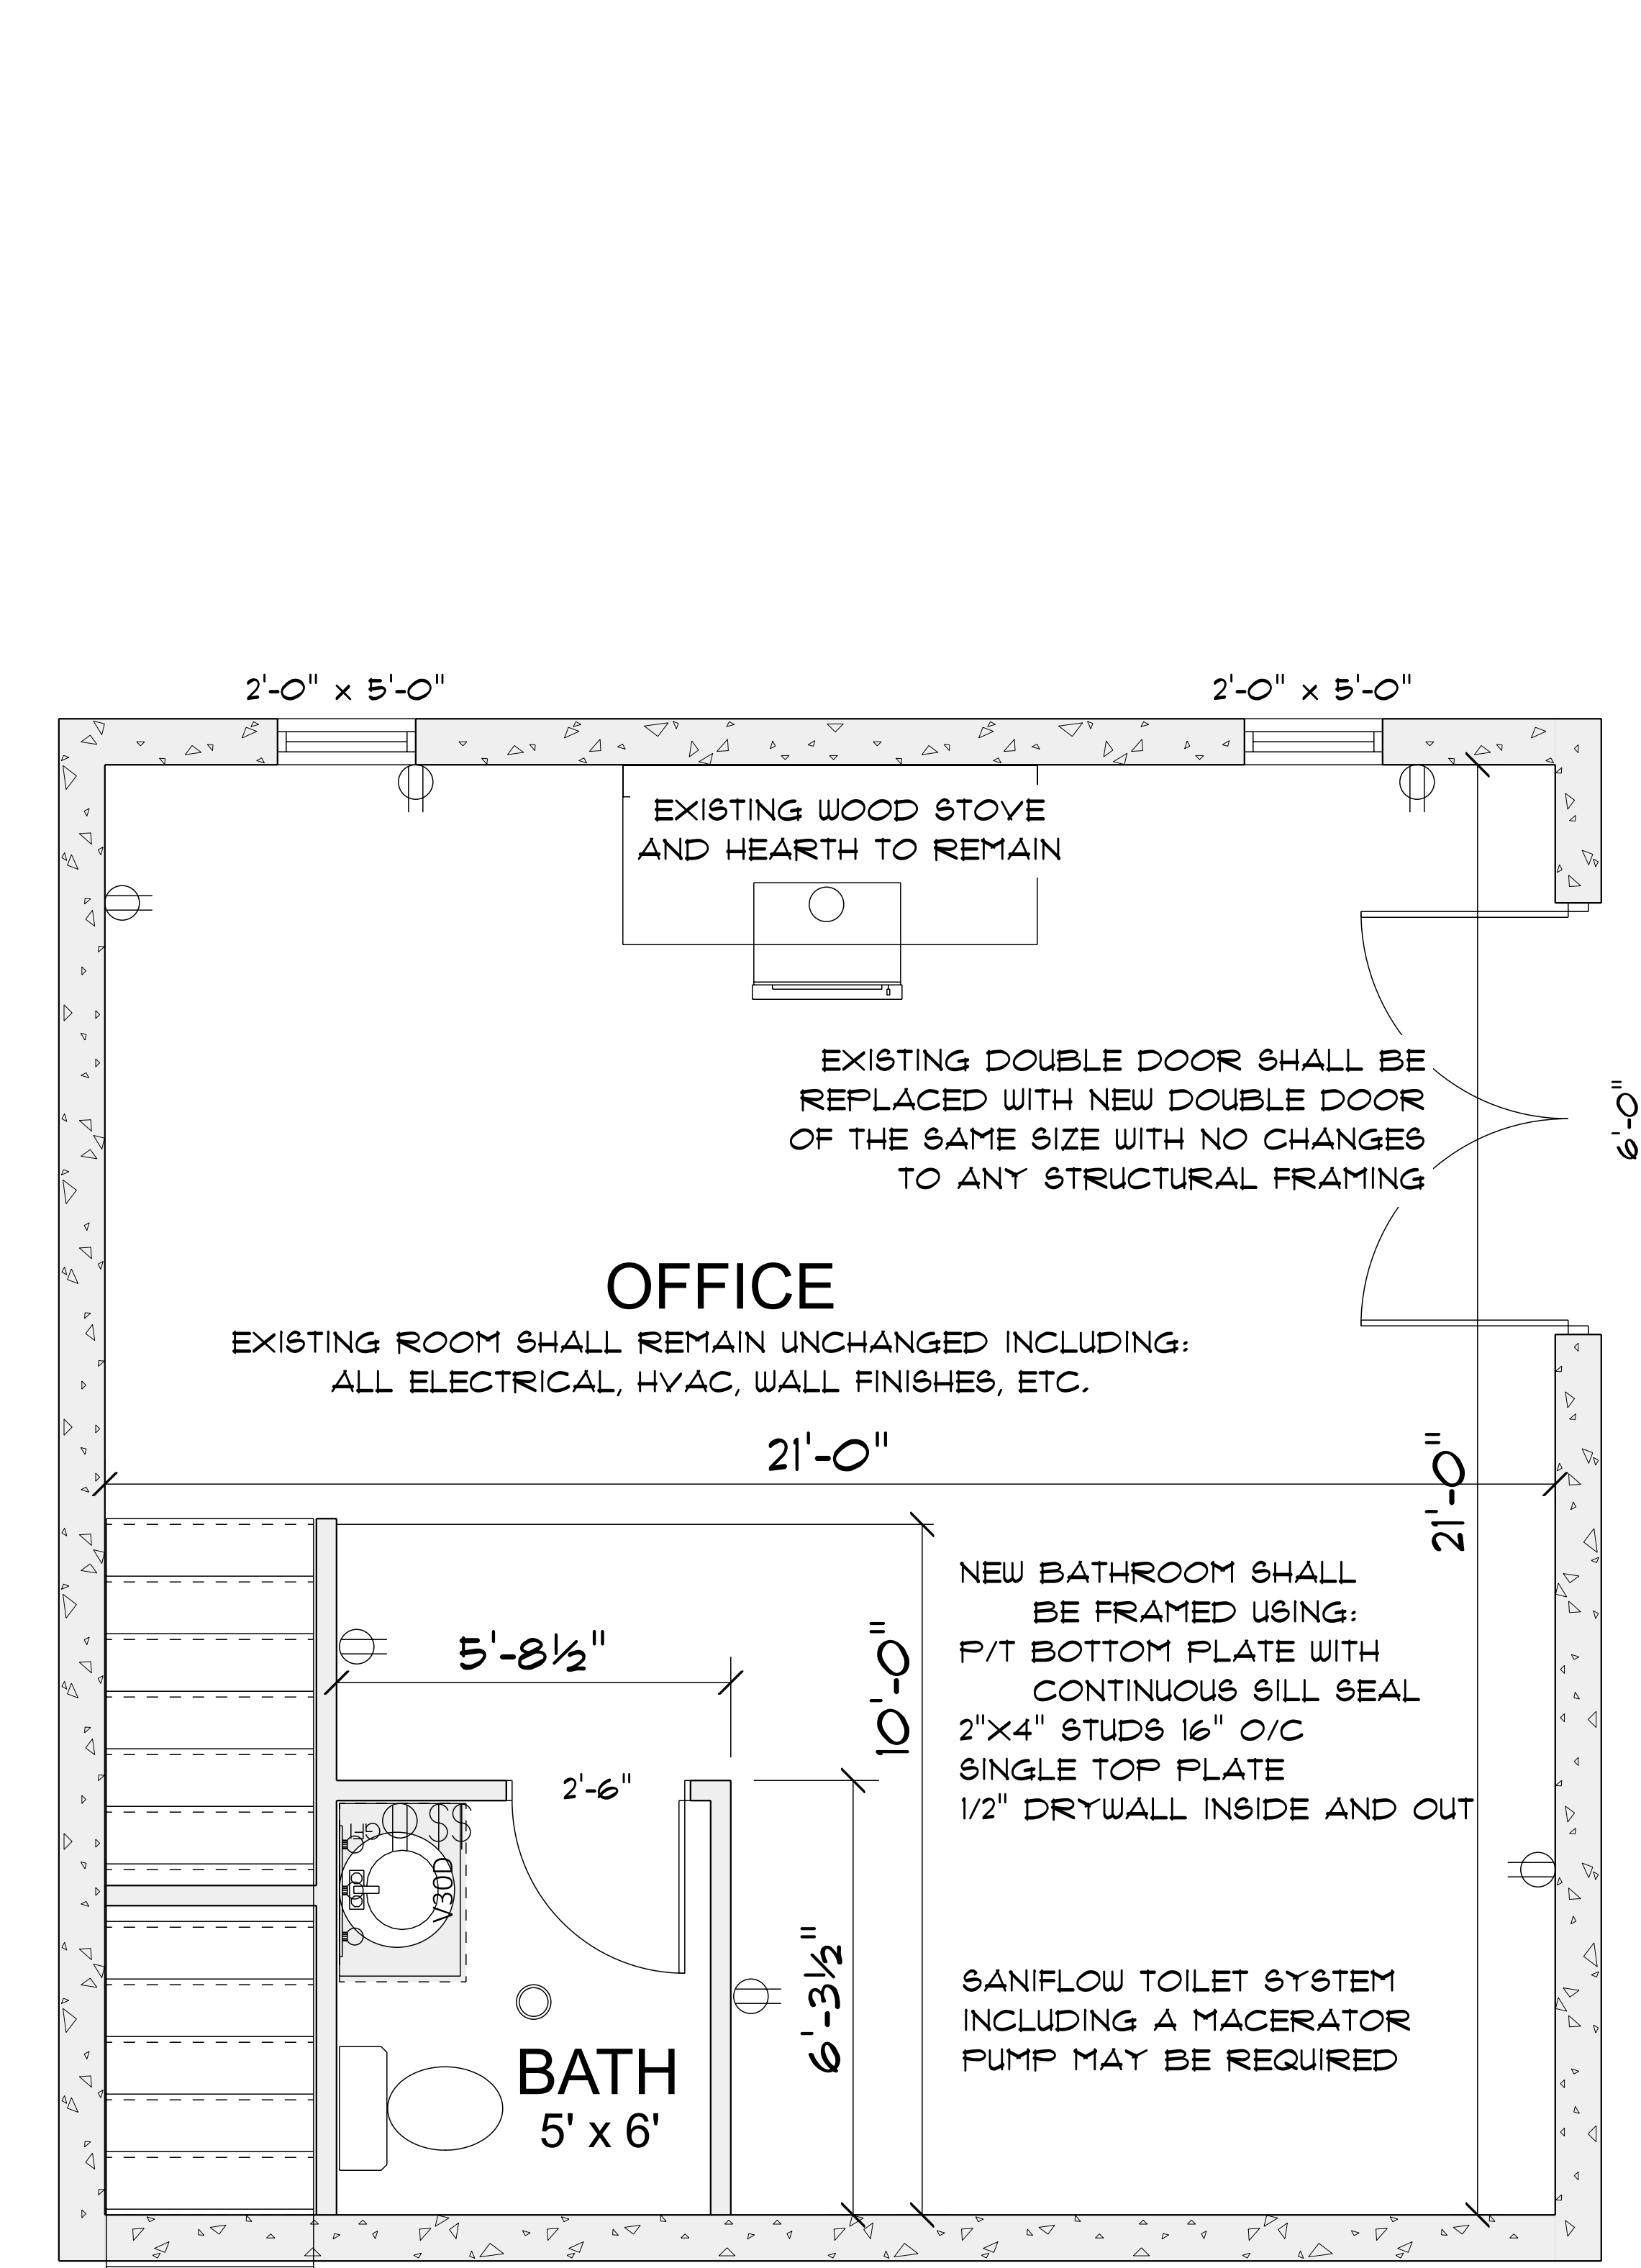

LAYOUT
SCALE: 1/2" = 1'-0"

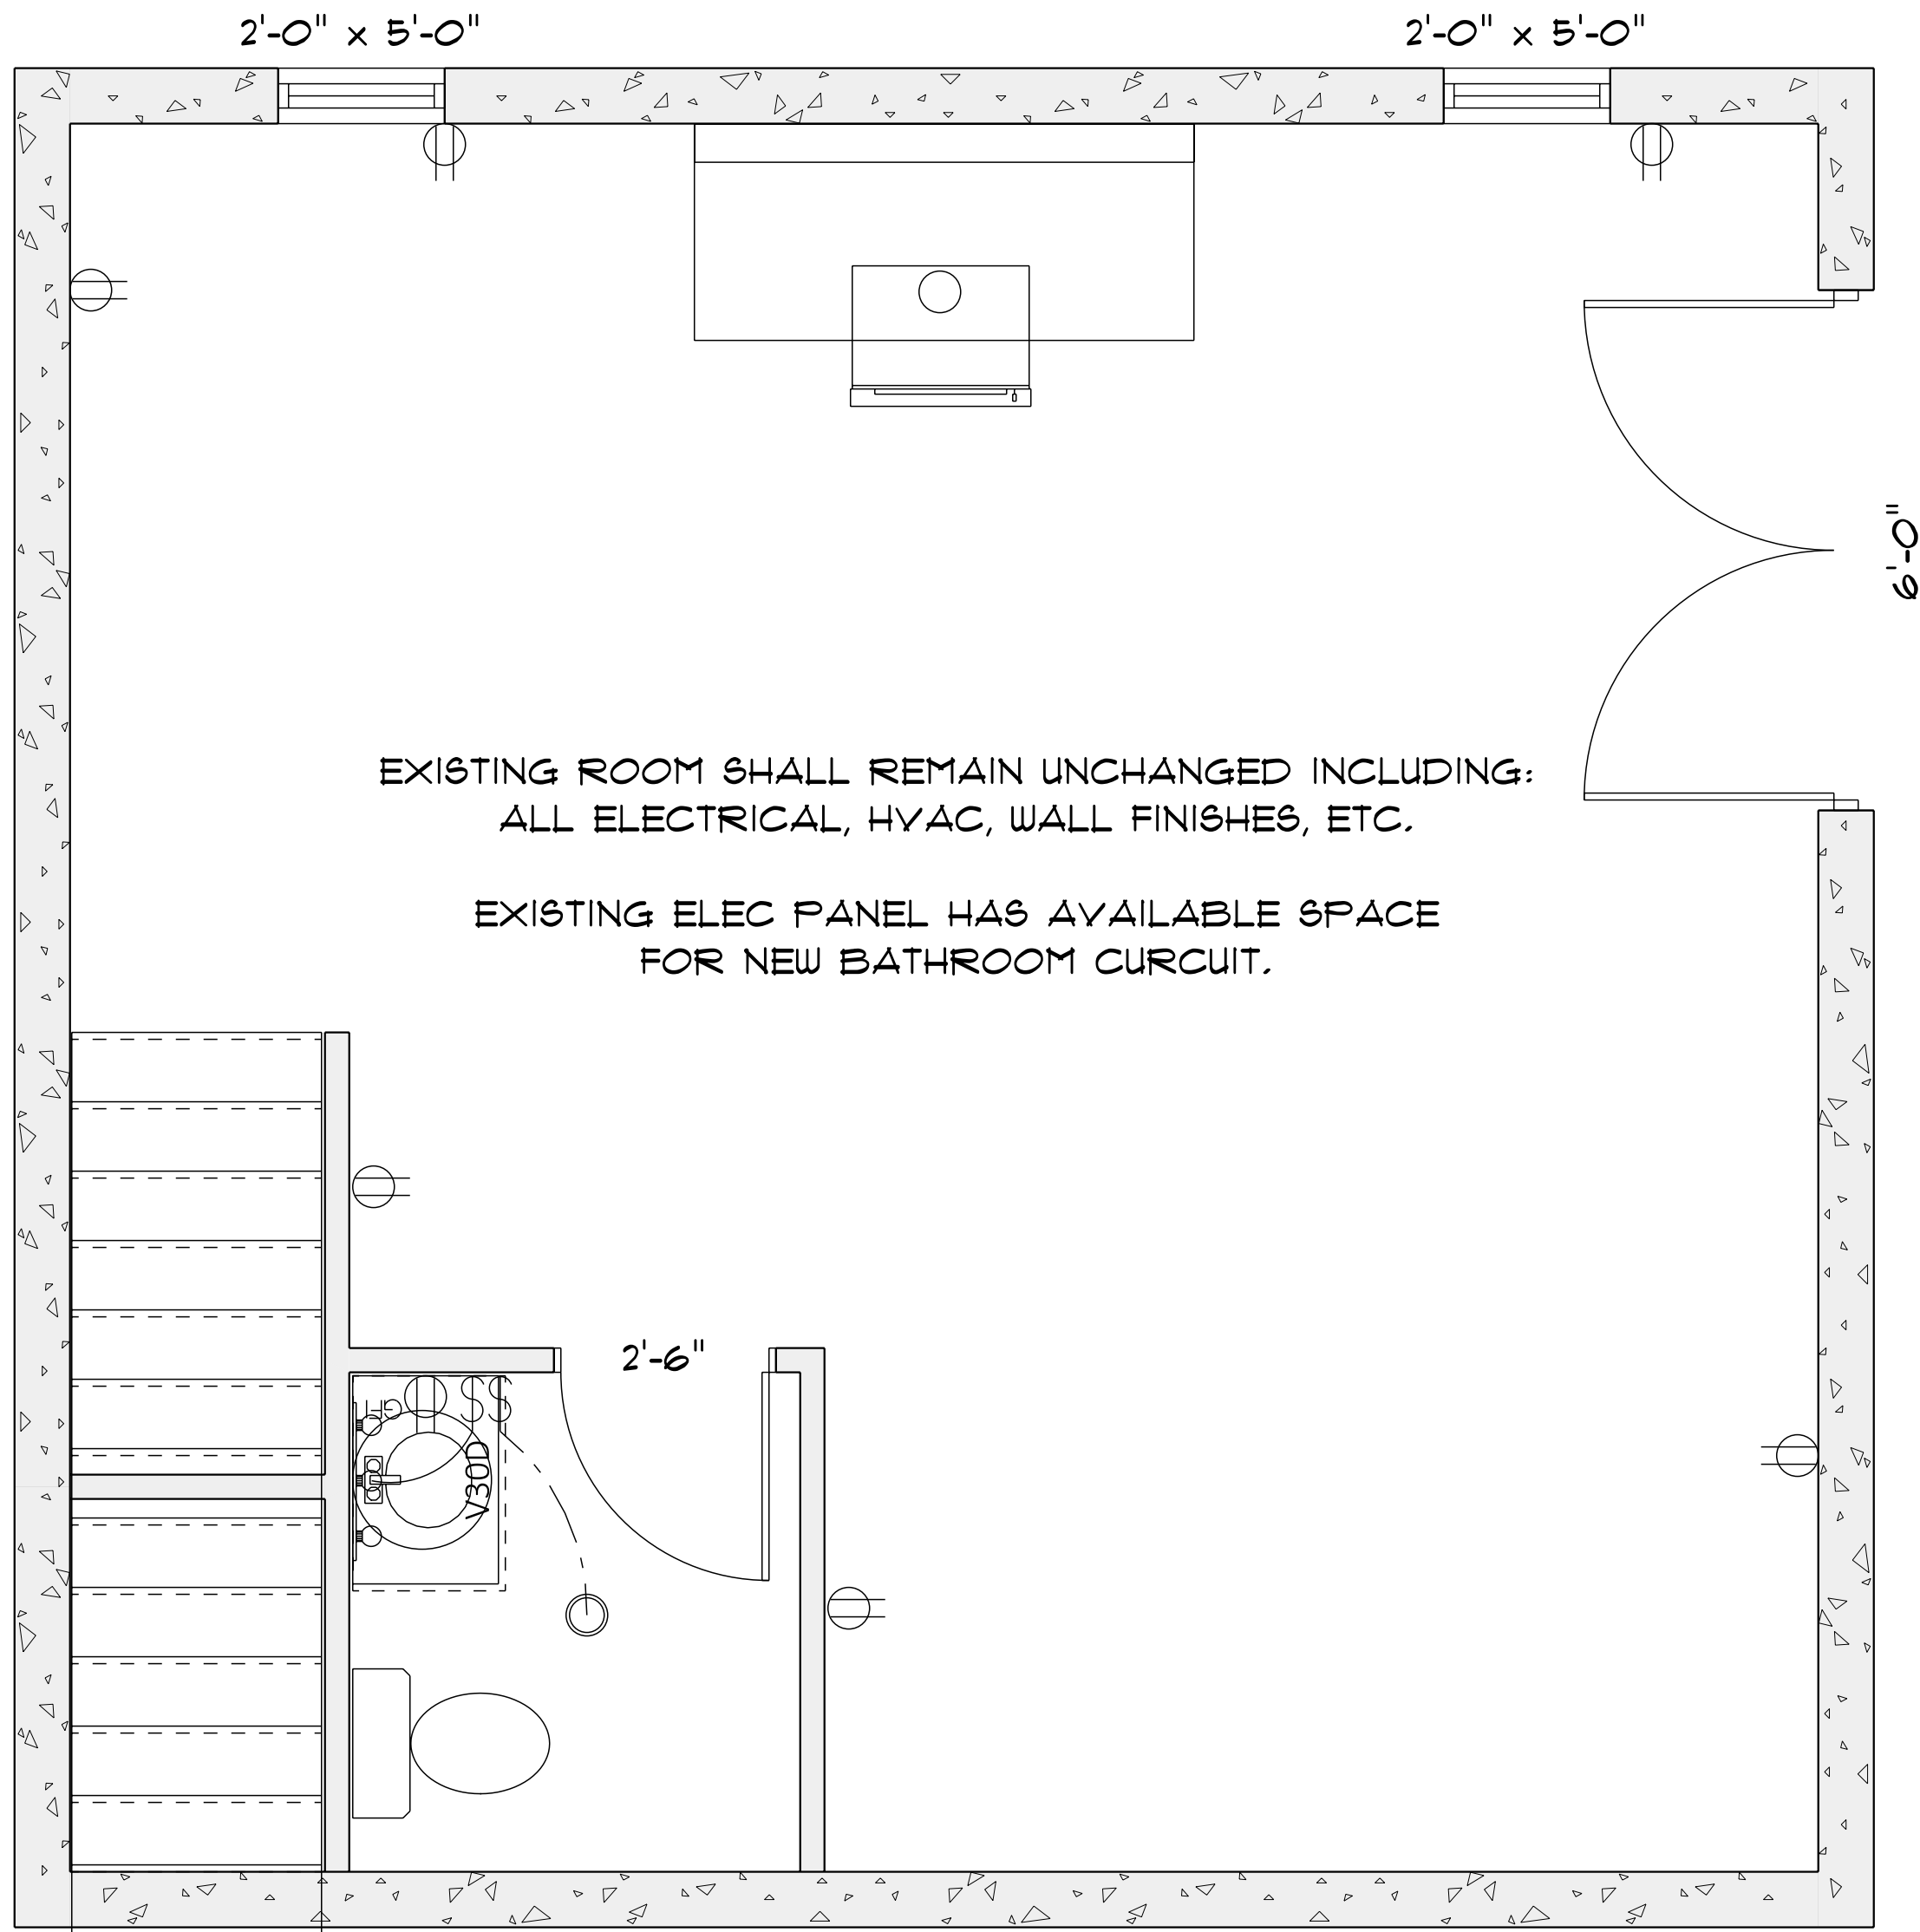

ELECTRICAL / LIGHTING
SCALE: 1/2" = 1'-0"

ELECTRICAL LEGEND		
ELECTRICAL	COUNT	SYMBOL
can light 6inch	1	o
outlet gfi	1	⏏
switch - rocker style	2	⏏
vanity bar light O2	1	⏏