




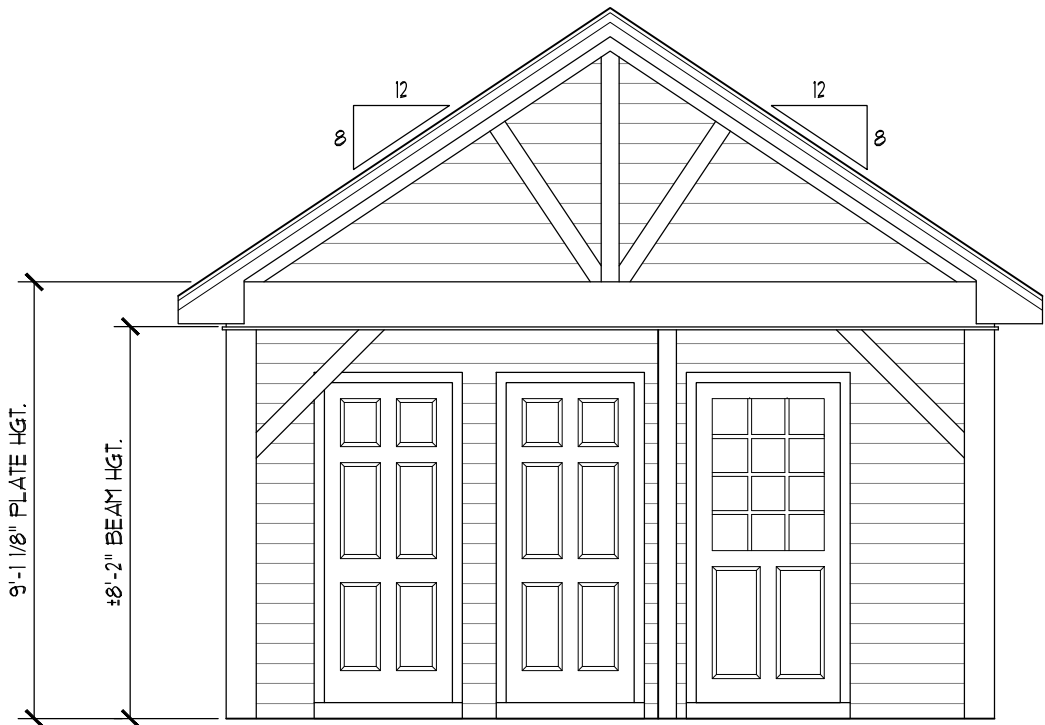


FRONT ELEVATION

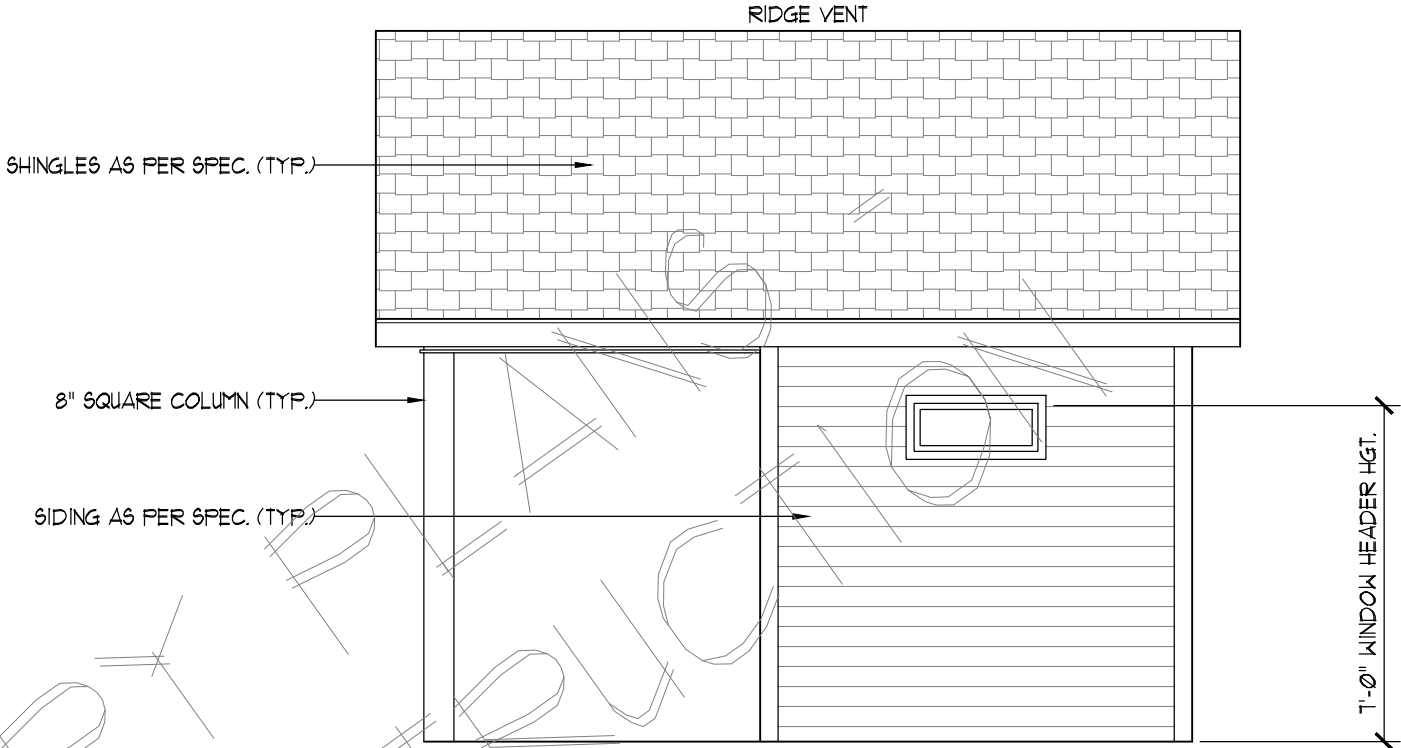

RIGHT ELEVATION

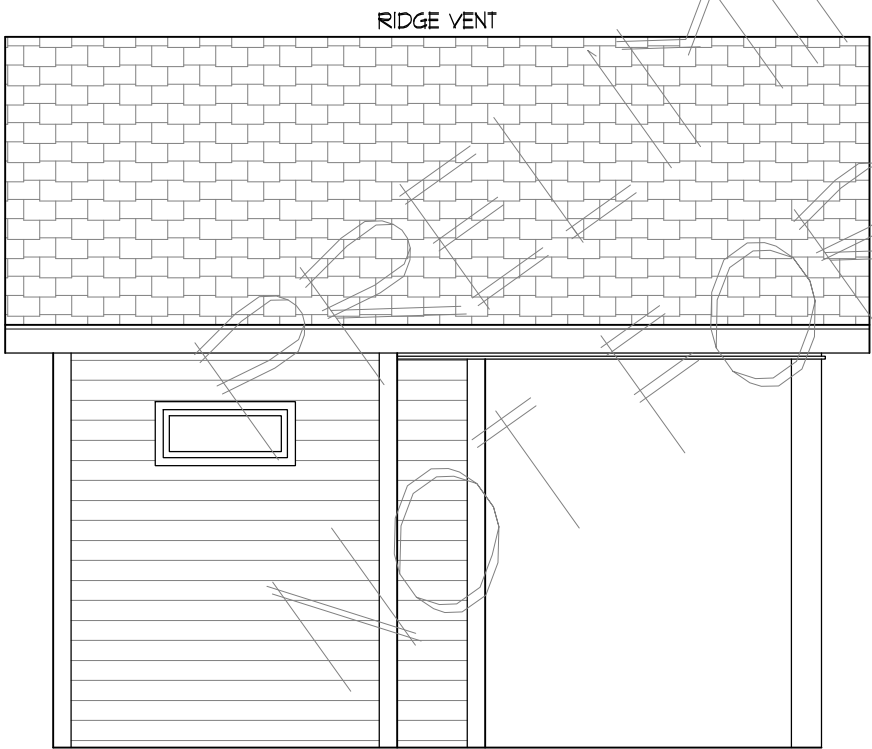

LEFT ELEVATION

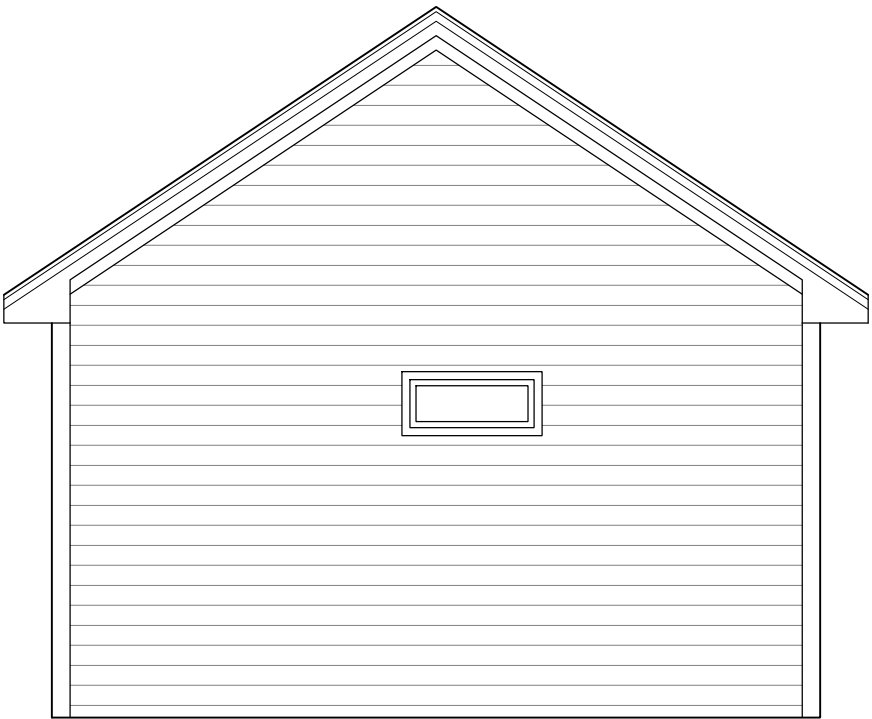

REAR ELEVATION




SPECTRA ENGINEERING AND
DESIGN, PLLC
P.O. BOX 31625
RALEIGH, NORTH CAROLINA 27621
TEL.: (919) 228-2841
LICENSE NO. NC: P-0946 VA: 000462

DATE: JUNE 06, 2025
SCALE: 1/4" = 1'-0"
DRAWN BY: MDW
ENGINEERED BY: MDW
REVIEWED BY: T9Z

MORALES POOL HOUSE
987 CARSON GREGORY ROAD
ANGIER, NORTH CAROLINA

ELEVATIONS

A=1
SHEET 1 OF 3

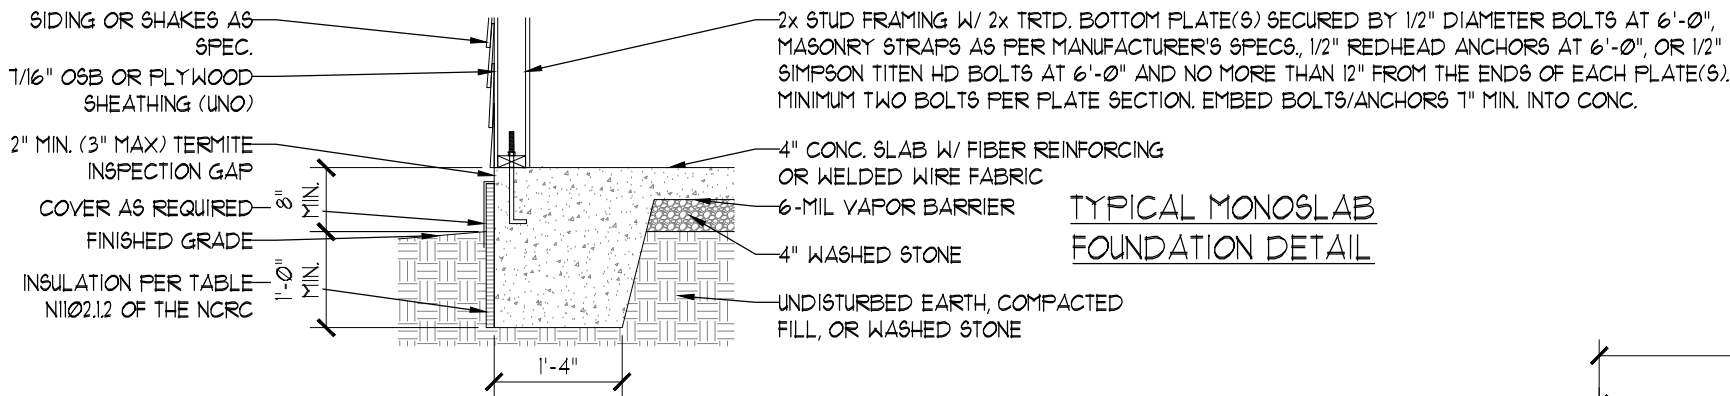


TYPICAL MONOSLAB FOUNDATION DETAIL


SQUARE FOOTAGE:

POOL HOUSE: 128 SQ. FT.
COVERED PORCH: 128 SQ. FT.

*NOTE: EXTERIOR DIMENSIONS ARE TO OUTSIDE FACE OF SHEATHING. INTERIOR DIMENSIONS ARE TO OUTSIDE FACE OF STUD/PLATE.

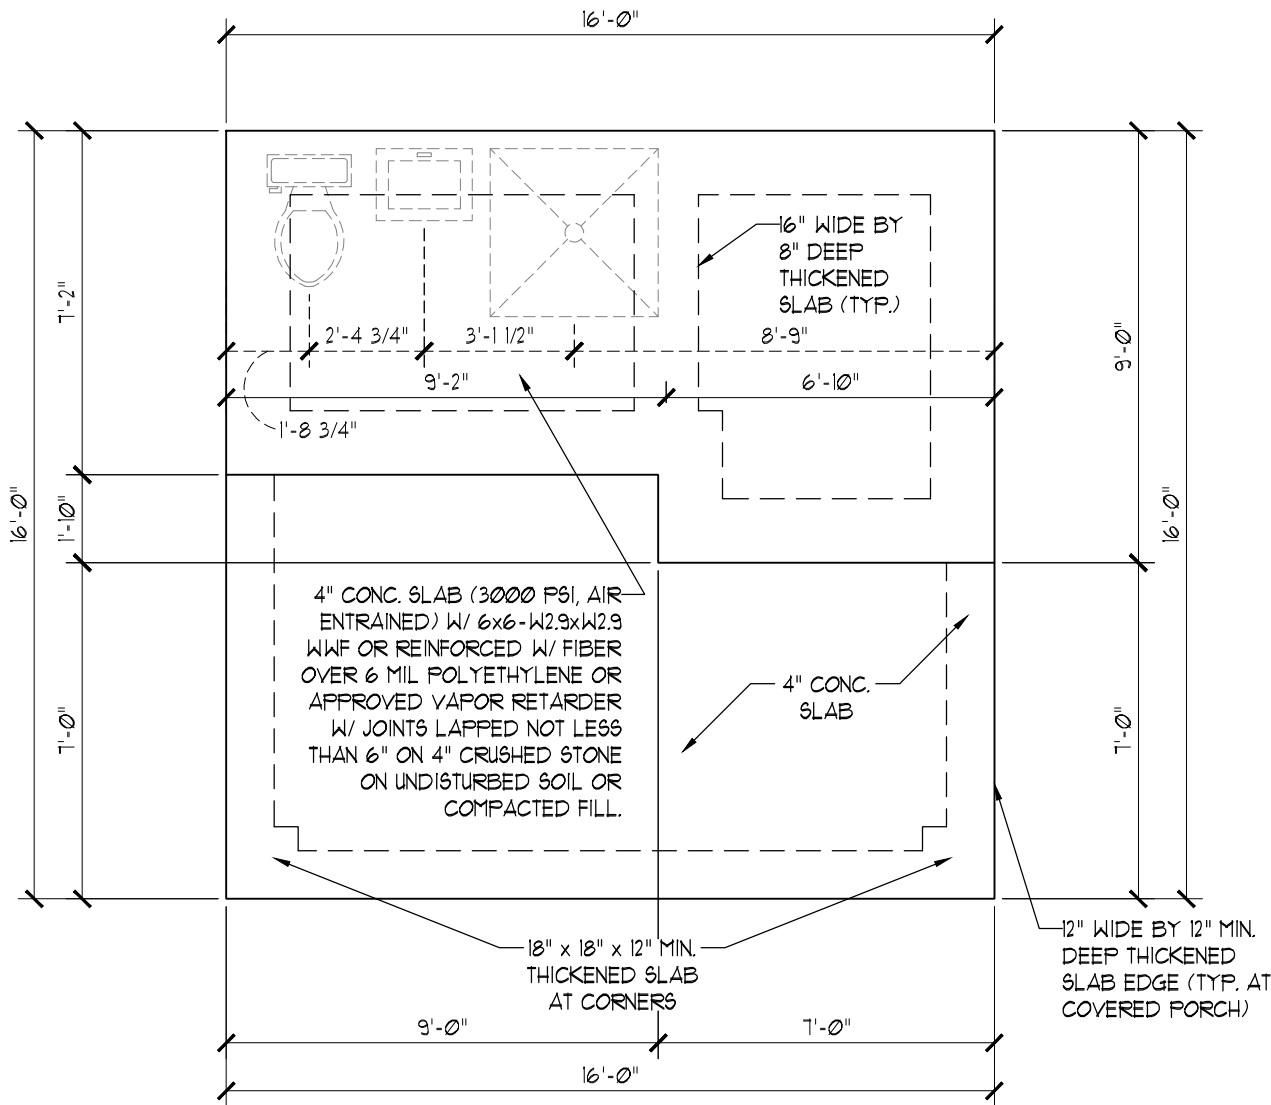

MONOSLAB FOUNDATION PLAN

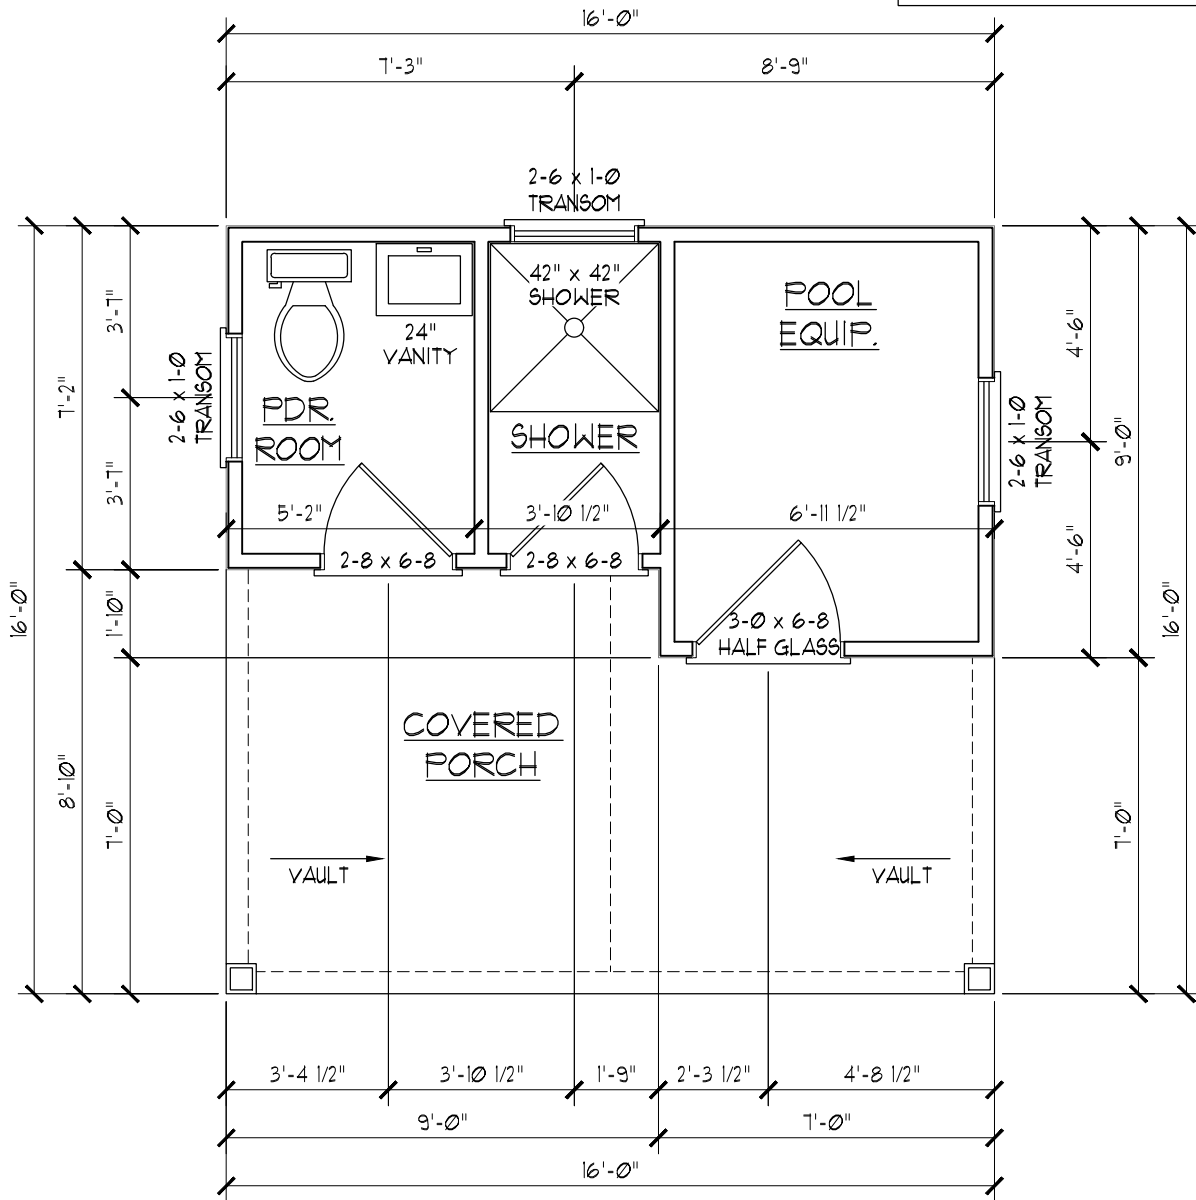

FLOOR PLAN

STRUCTURAL NOTES:

- 1) REFER TO STANDARD STRUCTURAL NOTES AND WALL BRACING DETAILS PAGES FOR ADDITIONAL STRUCTURAL INFORMATION.
- 2) WALL BRACING DESIGN AS PER THE INTERNATIONAL RESIDENTIAL CODE, 2015 EDITION.



SPECTRA ENGINEERING AND DESIGN, PLLC

P.O. BOX 31625
RALEIGH, NORTH CAROLINA 27621
TEL.: (919) 228-2841
LICENSE NO. NC: P-0946 VA: 000462

DATE: JUNE 06, 2025


SCALE: 1/4" = 1'-0"

DRAWN BY: MDW

ENGINEERED BY: MDW

REVIEWED BY: TSG

MORALES POOL HOUSE
987 CARSON GREGORY ROAD
ANGIER, NORTH CAROLINA

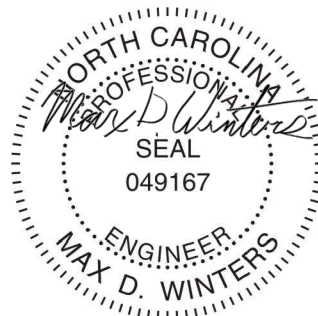


6/6/2025

FOUNDATION & FLOOR PLAN

S = 1

SHEET 2 OF 3

ENGINEER'S SEAL IS VALID UP TO ONE YEAR OF SEAL DATE.

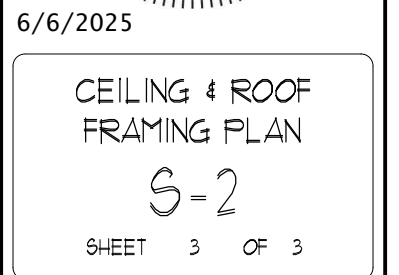

ROOF PLAN

ENGINEER'S SEAL IS VALID UP TO ONE YEAR OF SEAL DATE.



SPECTRA ENGINEERING AND
DESIGN, PLLC
P.O. BOX 37625
RALEIGH, NORTH CAROLINA 27621
TEL: (919) 228-2841
LICENSE NO. NC: P-09346 VA: 000462

DATE: JUNE 23, 2021

DRAWN BY: T5Z

ENGINEERED BY: T5Z

REVIEWED BY: T5Z

WALL BRACING DETAILS




6/6/2025

DETAILS


BW-1

SHEET X OF X

ENGINEER'S SEAL IS VALID UP TO ONE YEAR OF SEAL DATE.

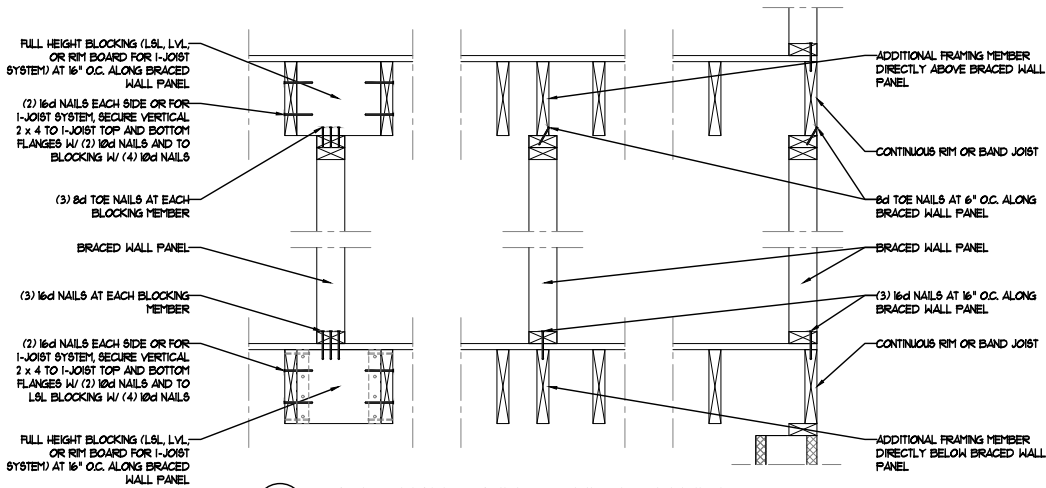


1 BRACED WALL PANEL CONNECTION WHEN
PARALLEL TO FLOOR/CEILING FRAMING

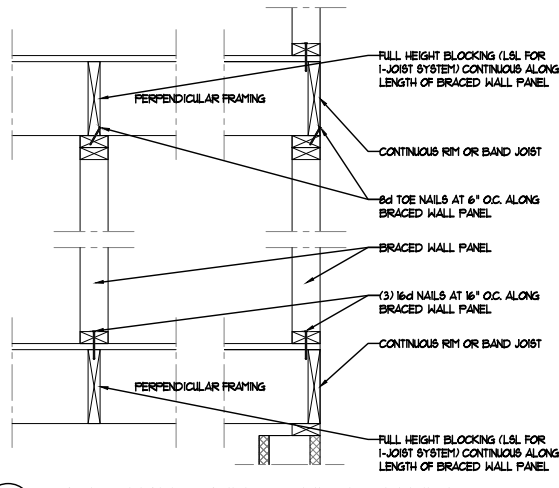


2 BRACED WALL PANEL CONNECTION WHEN
PERPENDICULAR TO FLOOR/CEILING FRAMING

BRACED WALL PANEL SCHEDULE			
ABBREVIATIONS	PANEL TYPE	MATERIAL	FASTENERS
WSP	INTERMITTENT WOOD STRUCTURAL PANEL	1/6" OSB/PLYWOOD (INO)	6d OR 8d COMMON NAILS AT 6" O.C. AT PANEL EDGES AND 12" O.C. AT INTERMEDIATE SUPPORTS OR 16 GA x 1 3/4" STAPLES AT 3" O.C. AT PANEL EDGES AND 6" O.C. AT INTERMEDIATE SUPPORTS
GB (1)	INTERMITTENT GYPSUM BOARD (SHEATHING ON ONE FACE OF WALL)	1/2" GYPSUM	1 1/2" GALV. ROOFING NAILS, 6d COMMON NAILS, OR 1 1/4" TYPE W DRYWALL SCREWS AT 1" O.C. AT PANEL EDGES INCLUDING TOP AND BOTTOM PLATES AND INTERMEDIATE SUPPORTS
GB (2)	INTERMITTENT GYPSUM BOARD (SHEATHING ON BOTH FACES OF WALL)	1/2" GYPSUM	1 1/2" GALV. ROOFING NAILS, 6d COMMON NAILS, OR 1 1/4" TYPE W DRYWALL SCREWS AT 1" O.C. AT PANEL EDGES INCLUDING TOP AND BOTTOM PLATES AND INTERMEDIATE SUPPORTS
GB (3)	INTERMITTENT GYPSUM BOARD (SHEATHING ON BOTH FACES OF WALL)	1/2" GYPSUM	1 1/2" GALV. ROOFING NAILS, 6d COMMON NAILS, OR 1 1/4" TYPE W DRYWALL SCREWS AT 4" O.C. AT PANEL EDGES INCLUDING TOP AND BOTTOM PLATES AND INTERMEDIATE SUPPORTS
LIB	LET-IN-BRACING	1 x 4 WOOD OR SIMPSON CS16 STRAP	WOOD: (2) 8d NAILS PER STUD INCLUDING TOP AND BOTTOM PLATE. METAL: (1) STRAP EACH DIRECTION, (2) 16d NAILS PER STUD INCLUDING TOP AND BOTTOM PLATE, (20) 16d NAILS MIN. PER STRAP
CS-WSP	CONTINUOUS SHEATHED WOOD STRUCTURAL PANEL	1/6" OSB/PLYWOOD (INO)	6d OR 8d COMMON NAILS AT 6" O.C. AT PANEL EDGES AND 12" O.C. AT INTERMEDIATE SUPPORTS OR 16 GA x 1 3/4" STAPLES AT 3" O.C. AT PANEL EDGES AND 6" O.C. AT INTERMEDIATE SUPPORTS
CS-G	CONT. SHEATHED WOOD STRUCTURAL PANEL ADJACENT TO GARAGE	1/6" OSB/PLYWOOD (INO)	6d OR 8d COMMON NAILS AT 6" O.C. AT PANEL EDGES AND 12" O.C. AT INTERMEDIATE SUPPORTS OR 16 GA x 1 3/4" STAPLES AT 3" O.C. AT PANEL EDGES AND 6" O.C. AT INTERMEDIATE SUPPORTS
CS-FF	CONTINUOUS PORTAL FRAME	1/6" OSB/PLYWOOD (INO)	SEE METHOD CS-FF ON PAGE BW-3
CS-EBW1	CONTINUOUS SHEATHED WOOD STRUCTURAL PANEL	1/6" OSB/PLYWOOD (INO)	6d OR 8d COMMON NAILS AT 4" O.C. AT PANEL EDGES AND 8" O.C. AT INTERMEDIATE SUPPORTS
CS-EBW2	CONTINUOUS SHEATHED WOOD STRUCTURAL PANEL	1/6" OSB/PLYWOOD (INO)	6d OR 8d COMMON NAILS AT 3" O.C. AT PANEL EDGES AND 6" O.C. AT INTERMEDIATE SUPPORTS


NOTES:
1) ALL BRACED WALL PANELS SHALL HAVE 2x BLOCKING BETWEEN WALL STUDS AT ALL HORIZONTAL SHEET EDGES.
2) PROVIDE NAILING/BLOCKING ABOVE AND BELOW ALL BRACED WALL PANELS PER DETAIL 1/BW-1 AND 2/BW-1.
3) ALL EXTERIOR WALLS OF THE HOUSE ARE TO BE SHEATHED W/ 1/6" OSB OR 5/8" PLYWOOD SECURED PER NIRC TABLE R6-02.3(1). WALL CORNER SHEATHING IS TO BE SECURED AS PER DETAIL 3/BW-1.
4) GB (1) AND GB (2) WALL PANELS SHALL BE SECURED AS PER DETAIL 4/BW-1.
5) BRACED WALL PANELS ARE PROVIDED AS PER THE INTERNATIONAL RESIDENTIAL CODE, 2018 EDITION, SECTION R6-02.10. PANEL LENGTHS SHOWN ON PLANS ARE THE MIN. LENGTH REQUIRED.
6) ALL METHODS SHALL HAVE A GYPSUM BOARD FINISH (OR EQUIVALENT) APPLIED TO THE INSIDE FACE OF THE BRACED WALL PANEL.

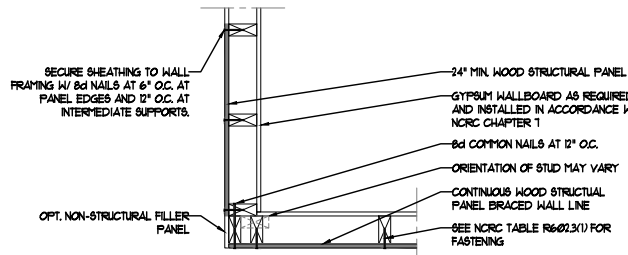

OUTSIDE CORNER DETAIL

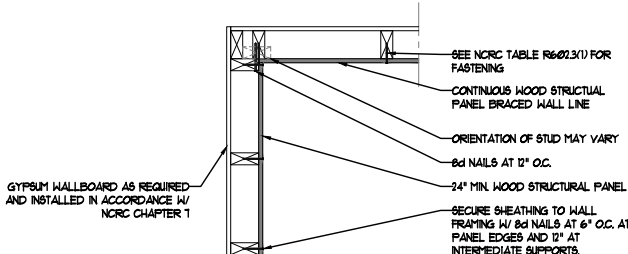


INSIDE CORNER DETAIL

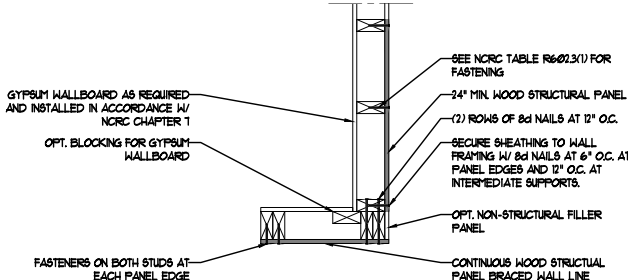


GARAGE CORNER DETAIL

3 TYPICAL EXTERIOR CORNER FRAMING
FOR CONTINUOUS SHEATHING

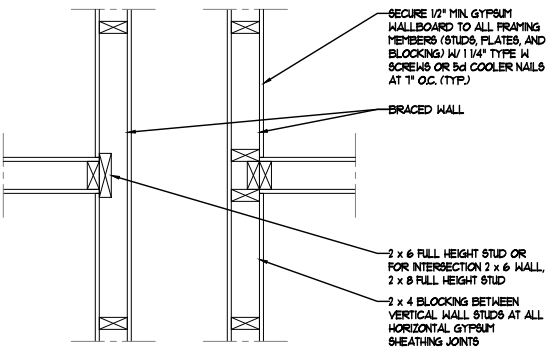


T-PLATE WALL
INTERSECTION

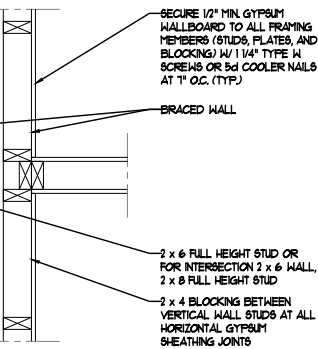


3-STUD WALL
INTERSECTION


4 METHOD GB (1) AND GB (2)
INTERSECTION DETAILS

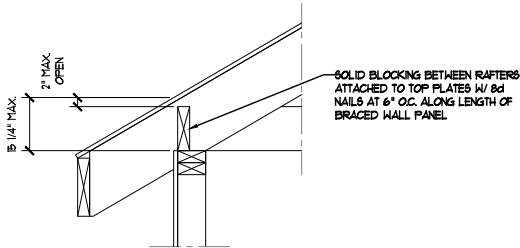


1 BRACED WALL PANEL CONNECTION TO PERPENDICULAR RAFTERS

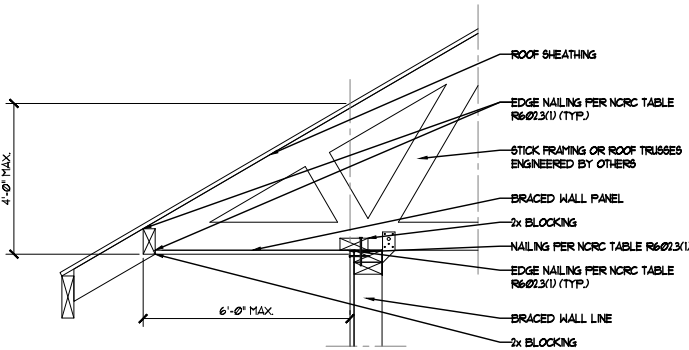


2 BRACED WALL PANEL CONNECTION OPTION TO PERPENDICULAR RAFTERS OR ROOF TRUSSES
PROVIDE VENTING PER NRC SECTION R806 (NOT SHOWN)

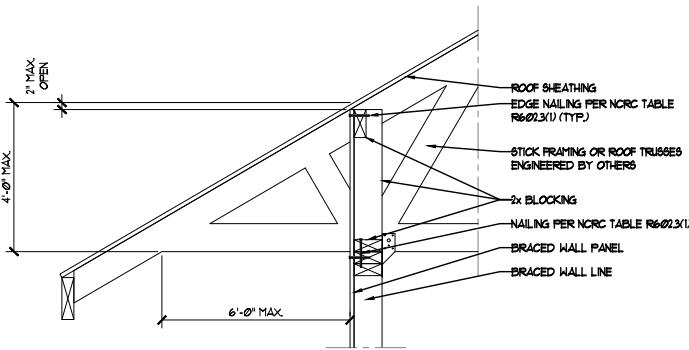


3 BRACED WALL PANEL CONNECTION OPTION TO PERPENDICULAR RAFTERS OR ROOF TRUSSES
PROVIDE VENTING PER NRC SECTION R806 (NOT SHOWN)

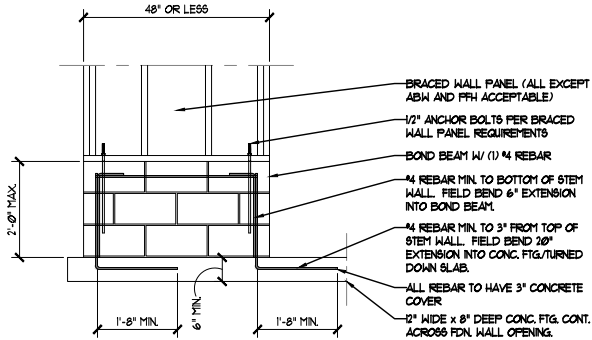

SHORT STEM WALL REINFORCEMENT

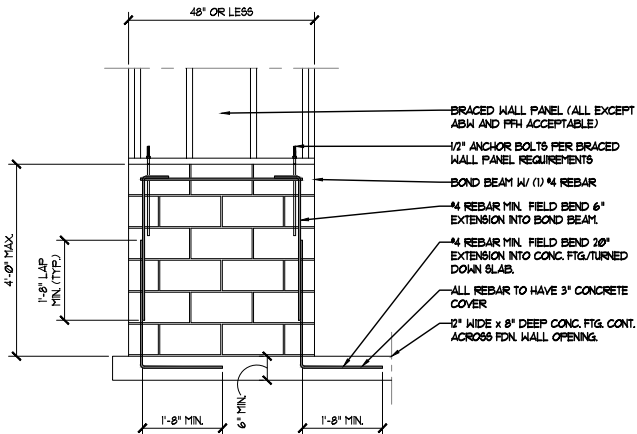

TALL STEM WALL REINFORCEMENT

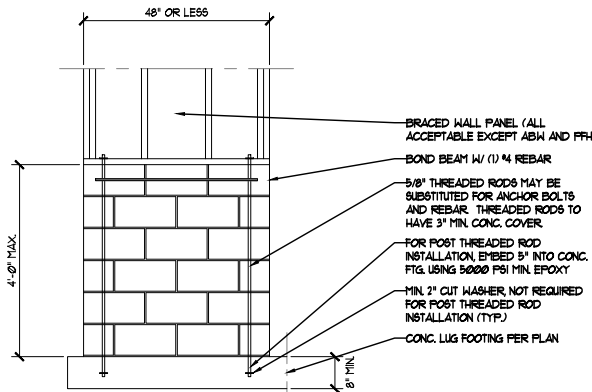

OPT. STEM WALL REINFORCEMENT CONFIGURATION

4 MASONRY STEM WALLS SUPPORTING BRACED WALL PANELS



SPECTRA ENGINEERING AND DESIGN, PLLC
P.O. BOX 31625
RALEIGH, NORTH CAROLINA 27621
TEL.: (919) 228-2841
LICENSE NO. NC: P-09346 VA: 0000462

DATE: JUNE 23, 2021

DRAWN BY: T5Z

ENGINEERED BY: T5Z

REVIEWED BY: T5Z

WALL BRACING DETAILS







6/6/2025

DETAILS

BW-2

SHEET X OF X

ENGINEER'S SEAL IS VALID UP TO ONE YEAR OF SEAL DATE.

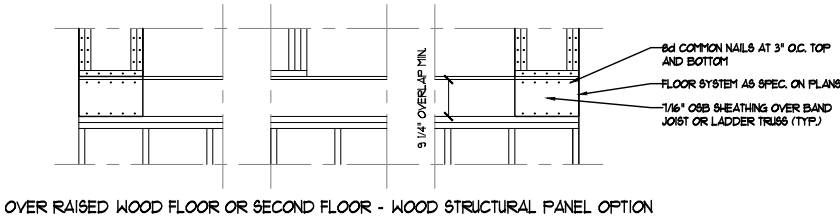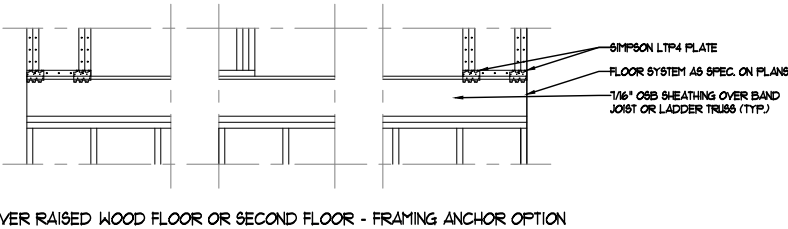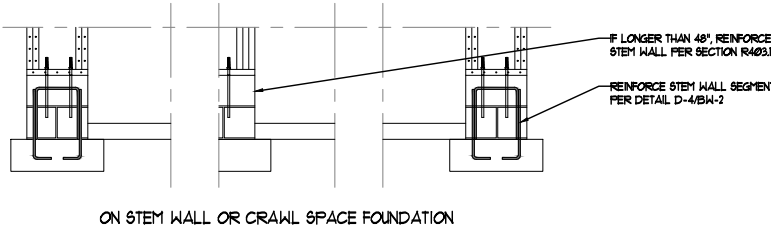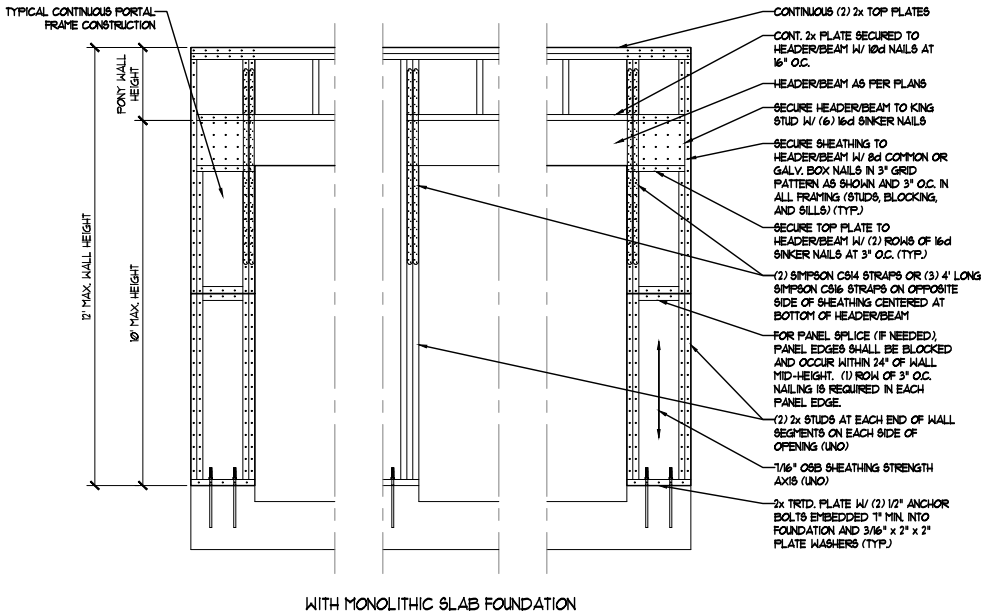

1 METHOD C3-FF: CONTINUOUS PORTAL FRAME PANEL CONSTRUCTION



SPECTRA ENGINEERING AND DESIGN, PLLC
P.O. BOX 31625
RALEIGH, NORTH CAROLINA 27621
TEL.: (919) 228-2841
LICENSE NO. NC: P-09346 VA: 000462

DATE: JUNE 23, 2021
DRAIN BY: T5Z
ENGINEERED BY: T5Z
REVIEWED BY: T5Z

WALL BRACING DETAILS




6/6/2025

DETAILS


BW-3

SHEET X OF X


ENGINEER'S SEAL IS VALID UP TO ONE YEAR OF SEAL DATE.

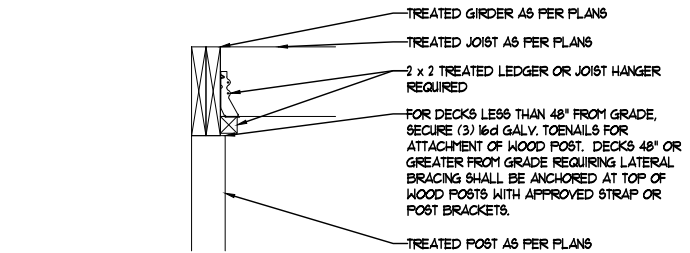


1 TOP MOUNT/FLUSH GIRDER DETAIL
(FIGURE A1103.1(1) OF THE 2018 NCRC)

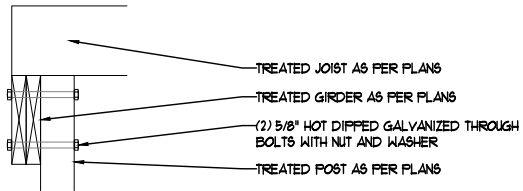


2 SIDE MOUNT DROPPED GIRDER DETAIL
(FIGURE A1103.1(2) OF THE 2018 NCRC)

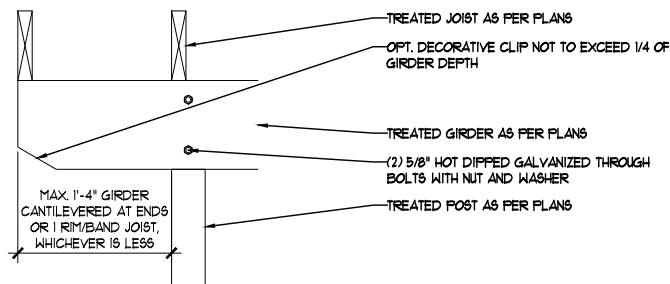

3 CANTILEVERED DROPPED GIRDER DETAIL
(FIGURE A1103.1(4) OF THE 2018 NCRC)
-CANTILEVERED GIRDER LIMITED TO FLOOR LOADS ONLY. ROOF LOADS PROHIBITED ON CANTILEVERED GIRDER APPLICATION

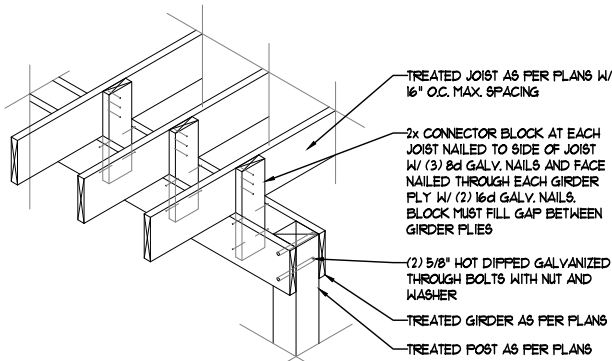


4 SPLIT GIRDER DETAIL
(FIGURE A1103.1(3) OF THE 2018 NCRC)
-SPLIT GIRDER LIMITED TO FLOOR LOADS ONLY AND CANTILEVER GIRDER ENDS ALLOWED PER FIGURE A1103.1(4)

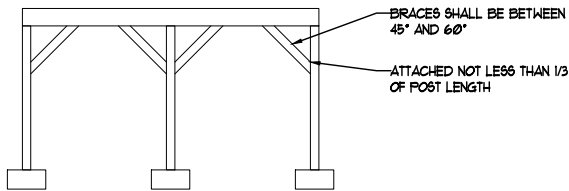


5 WOOD KNEE BRACING DETAIL
(FIGURE A1103.1(2) OF THE 2018 NCRC)


- 1) FREE STANDING DECKS REQUIRING BRACING SHALL BE INSTALLED IN BOTH DIRECTIONS OF EACH POST.
- 2) DECKS ATTACHED TO STRUCTURE REQUIRE DIAGONAL BRACING ONLY AT OUTSIDE GIRDER LINE PARALLEL WITH STRUCTURE.

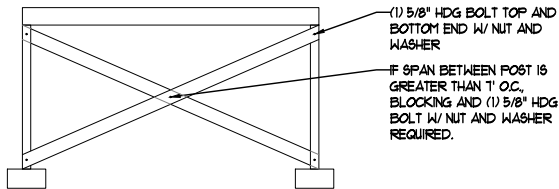

6 DIAGONAL VERTICAL CROSS BRACING DETAIL
(FIGURE A1103.1(4) OF THE 2018 NCRC)

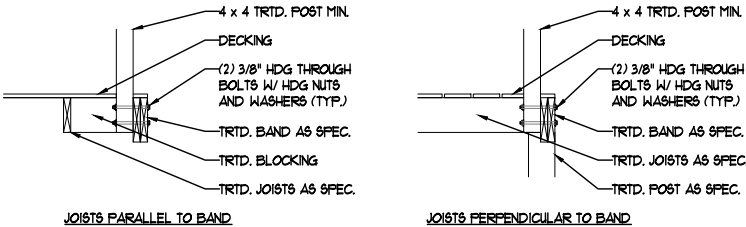

7 DECK GUARDRAIL POST ATTACHMENT TO INSIDE OF BAND DETAIL

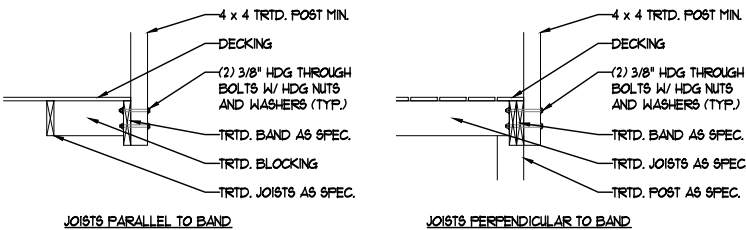

8 DECK GUARDRAIL POST ATTACHMENT TO OUTSIDE OF BAND DETAIL

RAIL POSTS - CANNOT EXCEED 8' O.C. SPACING AND SHALL BE ATTACHED W/ (2) 3/8" GALV. BOLTS W/ NUT AND WASHER TO OUTER BANDS AS PER DETAILS 7 OR 8 OR AS PER MANUFACTURER'S SPECIFICATIONS.

STAIR HANDRAIL - HEIGHT BETWEEN 34"-38" IN ACCORDANCE W/ R311.1(1) AND R312.1. OPENINGS ON SIDE OF STAIRS REQUIRING GUARDS SHALL NOT ALLOW A SPHERE W/ 4 3/8" DIAMETER TO PASS IN ACCORDANCE W/ R312.13, EXCEPTION 2.

STAIR TREADS AND RISERS - PER R311.1(1) (8 1/4" MAX. RISER) AND R311.1(2) (9" MIN. TREAD DEPTH). STAIRWAYS 36" MIN. WIDTH PER R311.1 (RAIL PROJECTIONS ALLOWED).

RISER OPENINGS - STAIRS W/ A 30° OR MORE VERTICAL RISE MUST HAVE SOLID RISERS OR OPENING RESTRICTED TO PREVENT A 4" DIAMETER SPHERE FROM PASSING PER R311.1(1).

GUARDS - AT A 36" MIN. HEIGHT REQUIRED IN ACCORDANCE W/ R312.12 W/ 30° DROP AND OPENING LIMITS PER R312.13. TOP RAIL AND POST TO SUPPORT 200 LBS W/ INFILL TO MEET 50 LBS IN ACCORDANCE W/ TABLE R301.5 AND FOOTNOTES.

DECKING - PER A1101 FOR 2 SYP AND ATTACHED W/ (2) 8d GALV. NAILS AT EACH JOIST OR APPROVED SCREWS. OTHER MATERIALS PER MANUFACTURER'S INSTALLATION BASED UPON JOISTS O.C. SPACING. ALTERNATE MATERIAL ATTACHED PER MANUFACTURER'S INSTALLATION INSTRUCTIONS.

DECKS ARE TO BE CONSTRUCTED AS PER APPENDIX M OF THE 2018 NORTH CAROLINA RESIDENTIAL CODE (NCRC)

DECK ATTACHMENT - AS PER SECTION A1104 OF THE 2018 NCRC, WHEN A DECK SHALL BE SUPPORTED AT THE STRUCTURE BY ATTACHING THE DECK TO THE STRUCTURE, SECURE DECK TO STRUCTURE AS PER TABLE A1104.1(1), TABLE A1104.1(2), METHOD 3 OR METHOD 4 BELOW:

TABLE A1104.1(1)
ALL STRUCTURES EXCEPT BRICK VENEER STRUCTURES

FASTENERS	8' MAX. JOIST SPAN ^a	16' MAX. JOIST SPAN ^a
5/8" HDG BOLTS W/ NUT AND WASHER ^b	1 @ 3'-6" O.C.	1 @ 1'-8" O.C.
AND	AND	AND
12d COMMON HDG NAILS ^c	2 @ 8" O.C.	3 @ 6" O.C.
OR		
SELF-DRILLING SCREW FASTENER ^d	12" O.C. STAGGERED	6" O.C. STAGGERED

- a. ATTACHMENT INTERPOLATION BETWEEN 8' AND 16' JOISTS SPAN IS ALLOWED.
- b. MIN. EDGE DISTANCE FOR BOLTS IS 2 1/2".
- c. NAILS MUST PENETRATE THE SUPPORTING STRUCTURE BAND A MIN. OF 1 1/2".
- d. SELF-DRILLING SCREW FASTENER HAVING A MINIMUM SHANK DIAMETER OF 0.195" AND A LENGTH LONG ENOUGH TO PENETRATE THROUGH THE SUPPORTING STRUCTURE BAND. THE STRUCTURE BAND SHALL HAVE A MINIMUM DEPTH OF 1 1/8". SCREW SHALL BE EVALUATED BY AN APPROVED TESTING AGENCY FOR ALLOWABLE SHEAR LOAD FOR SYP TO SYP LUMBER OF 250 LBS. AND SHALL HAVE A CORROSION-RESISTANT FINISH EQUIVALENT TO HOT DIP GALVANIZED. MINIMUM EDGE DISTANCE FOR SCREWS IS 1 1/16". A MAXIMUM OF 1/2" THICK WOOD STRUCTURAL PANEL IS PERMITTED TO BE LOCATED BETWEEN THE DECK LEDGER AND THE STRUCTURE BAND.

TABLE A1104.1(2)
BRICK VENEER STRUCTURES

FASTENERS	8' MAX. JOIST SPAN ^a	16' MAX. JOIST SPAN ^a
5/8" HDG BOLTS W/ NUT AND WASHER ^b	1 @ 2'-4" O.C.	1 @ 1'-4" O.C.

- a. ATTACHMENT INTERPOLATION BETWEEN 8' AND 16' JOISTS SPAN IS ALLOWED
- b. MIN. EDGE DISTANCE FOR BOLTS IS 2 1/2"

METHOD 3) IF THE DECK BAND IS SUPPORTED BY A MIN. OF 1/2" MASONRY LEDGE ALONG THE FOUNDATION WALL, SECURE DECK TO STRUCTURE W/ 5/8" HDG BOLTS W/ WASHERS SPACED AT 48" O.C.

METHOD 4) JOIST HANGERS OR OTHER MEANS OF ATTACHMENT MAY BE CONNECTED TO HOUSE BAND AND SHALL BE PROPERLY FLASHED.

DECK BRACING - AS PER SECTION A1103 OF THE 2018 NCRC, THE DECK SHALL BE Laterally Braced AS PER ONE OF THE FOLLOWING:

1) WHEN THE DISTANCE FROM THE TOP OF THE DECK FLOOR TO THE FINISHED GRADE IS LESS THAN 4'-0" AND THE DECK IS ATTACHED TO THE STRUCTURE IN ACCORDANCE WITH SECTION A1104 LISTED ABOVE, LATERAL BRACING IS NOT REQUIRED. LATERAL BRACING IS NOT REQUIRED FOR FREE STANDING DECKS WITH A DECK FLOOR HEIGHT OF 30" OR LESS ABOVE FINISHED GRADE.

2) 4 x 4 TREATED WOOD KNEE BRACES MAY BE PROVIDED ON EACH COLUMN IN BOTH DIRECTIONS. THE KNEE BRACES SHALL ATTACH TO EACH POST AT A POINT NOT LESS THAN 1/3 OF THE POST LENGTH FROM THE TOP OF THE POST, AND THE BRACES SHALL BE ANGLED BETWEEN 45° AND 60° FROM THE HORIZONTAL. KNEE BRACES SHALL BE BOLTED TO THE POST AND THE GIRDER/DOUBLE BAND W/ (1) 5/8" HDG BOLT WITH NUT AND WASHER AT BOTH ENDS OF THE BRACE PER DETAIL 5.

3) FOR FREE STANDING DECKS WITHOUT KNEE BRACES OR DIAGONAL BRACING, LATERAL STABILITY MAY BE PROVIDED BY EMBEDDING THE POST IN ACCORDANCE WITH TABLE A1103.13. DECKS ATTACHED TO STRUCTURE CAN ALSO BE BRACED ON EXTERIOR GIRDER LINE W/ EMBEDMENT OPTION.

TABLE A1103.13

POST SIZE	MAX. TRIBUTARY AREA	MAX. POST HEIGHT ^a	EMBEDMENT DEPTH	CONCRETE DIAMETER
4 x 4	48 SQ. FT.	4'-0"	2'-6"	1'-0"
6 x 6	120 SQ. FT.	6'-0"	3'-6"	1'-8"

- a. FROM TOP OF FOOTING TO TOP OF DECKING

4) 2 x 6 DIAGONAL VERTICAL CROSS BRACING MAY BE PROVIDED IN TWO PERPENDICULAR DIRECTIONS FOR FREE STANDING DECKS OR PARALLEL TO THE STRUCTURE AT THE EXTERIOR COLUMN LINE FOR ATTACHED DECKS. THE 2 x 6'S SHALL BE ATTACHED TO THE POSTS W/ (1) 5/8" HDG BOLT W/ NUT AND WASHER AT EACH END OF EACH BRACING MEMBER PER DETAIL 6.

5) FOR EMBEDMENT OF PILES IN COASTAL REGIONS, SEE CHAPTER 46.



SPECTRA ENGINEERING AND DESIGN, PLLC
P.O. BOX 31625
RALEIGH, NORTH CAROLINA 27621
TEL.: (919) 228-2841
LICENSE NO. NC: P-0946 VA: 0000462

DATE: SEPTEMBER 13, 2022
SCALE:
DRAWN BY: T5Z
ENGINEERED BY: T5Z
REVIEWED BY: T5Z

STANDARD STRUCTURAL NOTES



6/6/2025

DECK DETAILS

SN=2
SHEET ---- OF ----