


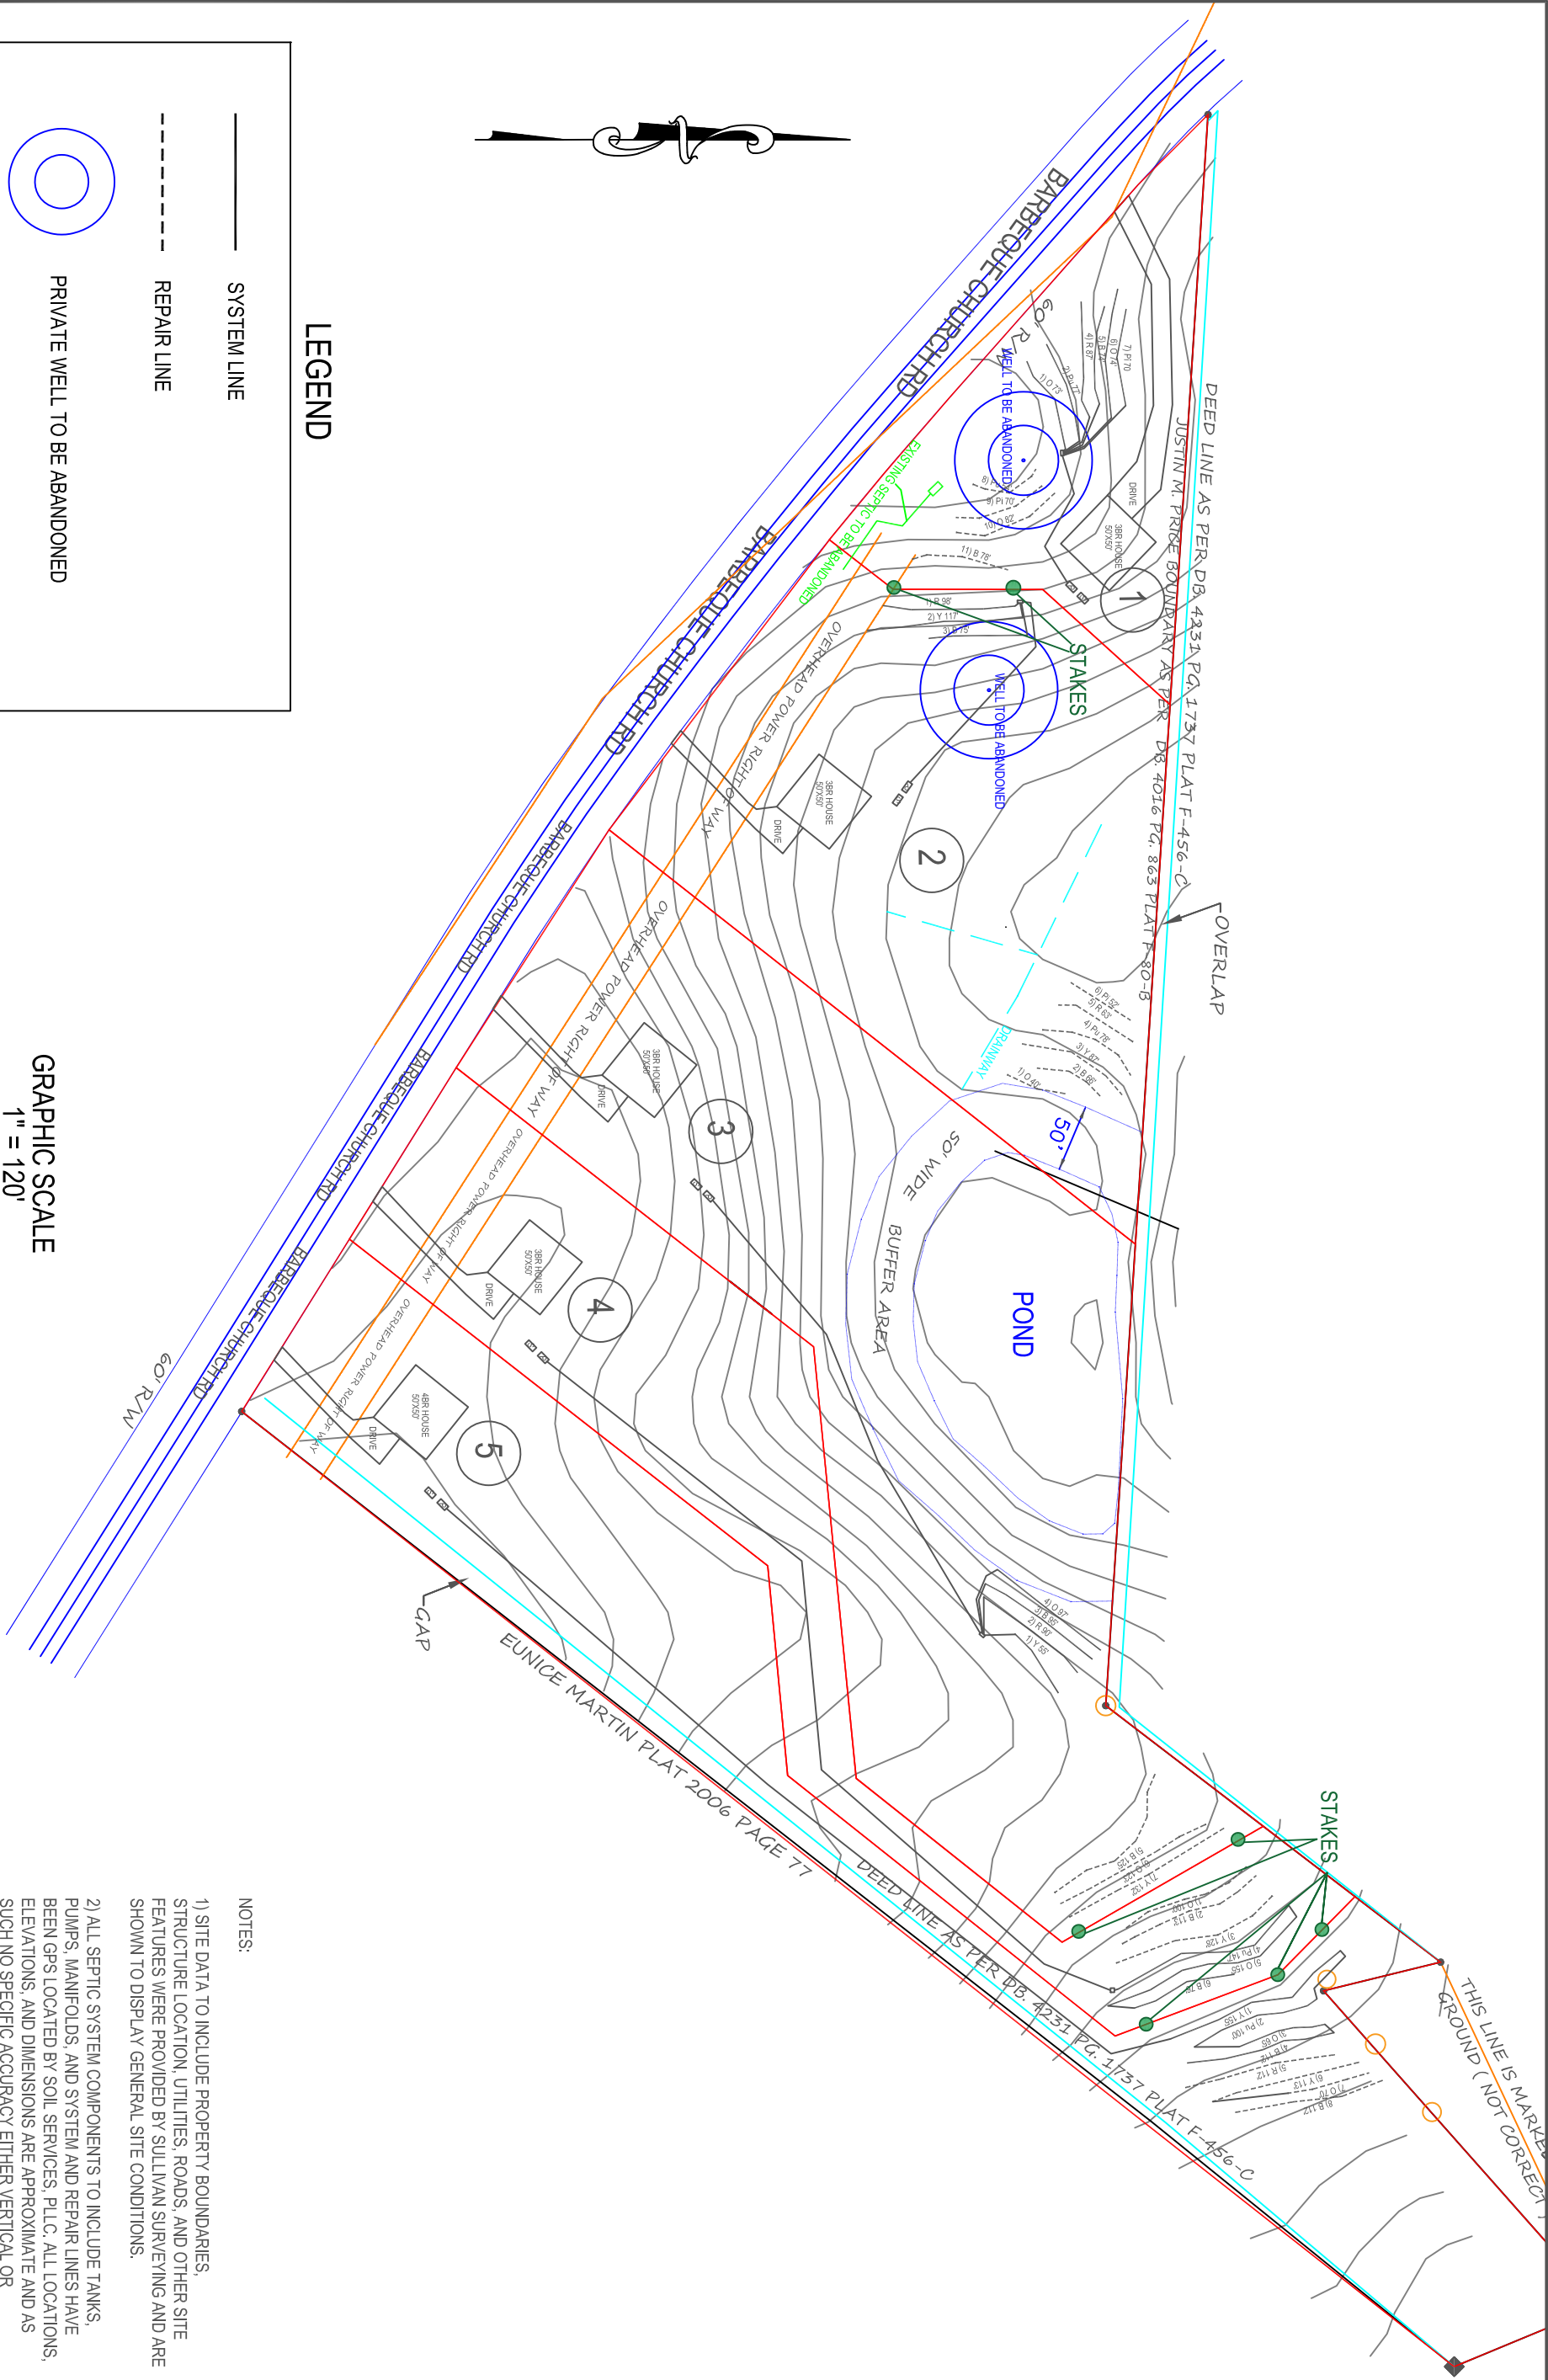

LEGEND

- SYSTEM LINE
- REPAIR LINE
- PRIVATE WELL TO BE ABANDONED
- SEPTIC TANK
- PUMP TANK

GRAPHIC SCALE

1" = 120'



NOTES:

- 1) SITE DATA TO INCLUDE PROPERTY BOUNDARIES, STRUCTURE LOCATION, UTILITIES, ROADS, AND OTHER SITE FEATURES WERE PROVIDED BY SULLIVAN SURVEYING AND ARE SHOWN TO DISPLAY GENERAL SITE CONDITIONS.
- 2) ALL SEPTIC SYSTEM COMPONENTS TO INCLUDE TANKS, PUMPS, MANIFOLDS, AND SYSTEM AND REPAIR LINES HAVE BEEN GPS LOCATED BY SOIL SERVICES, PLLC. ALL LOCATIONS, ELEVATIONS, AND DIMENSIONS ARE APPROXIMATE AND AS SUCH NO SPECIFIC ACCURACY EITHER VERTICAL OR HORIZONTAL IS IMPLIED.
- 3) PROPERTY AND EASEMENT BOUNDARIES SHOWN ON THIS SITE SKETCH ARE APPROXIMATE AND ARE NOT INTENDED FOR LOCATING PROPERTY OR IDENTIFYING PROPERTY OR EASEMENT CORNERS. THIS IS NOT A SURVEY.

SOIL SERVICES, PLLC

PO BOX 91115, RALEIGH, NC 27675
OFFICE: (919) 745-1928 FAX: (919) 375-3969
WWW.SOILSERVICES.US

Sheet Title:

SEPTIC SYSTEM SITE PLAN - MASTER

Project:

4824 BARBEQUE CHURCH RD

Location:

HARNETT CO., NC

Client:

REDD SOLUTIONS LLC

Project No.: 2119-1

Project Manager:
SM

Drawn:
SM

Scale:
2119-1

Field Work:
SM,JK

Sheet No.:

1 of 1

