



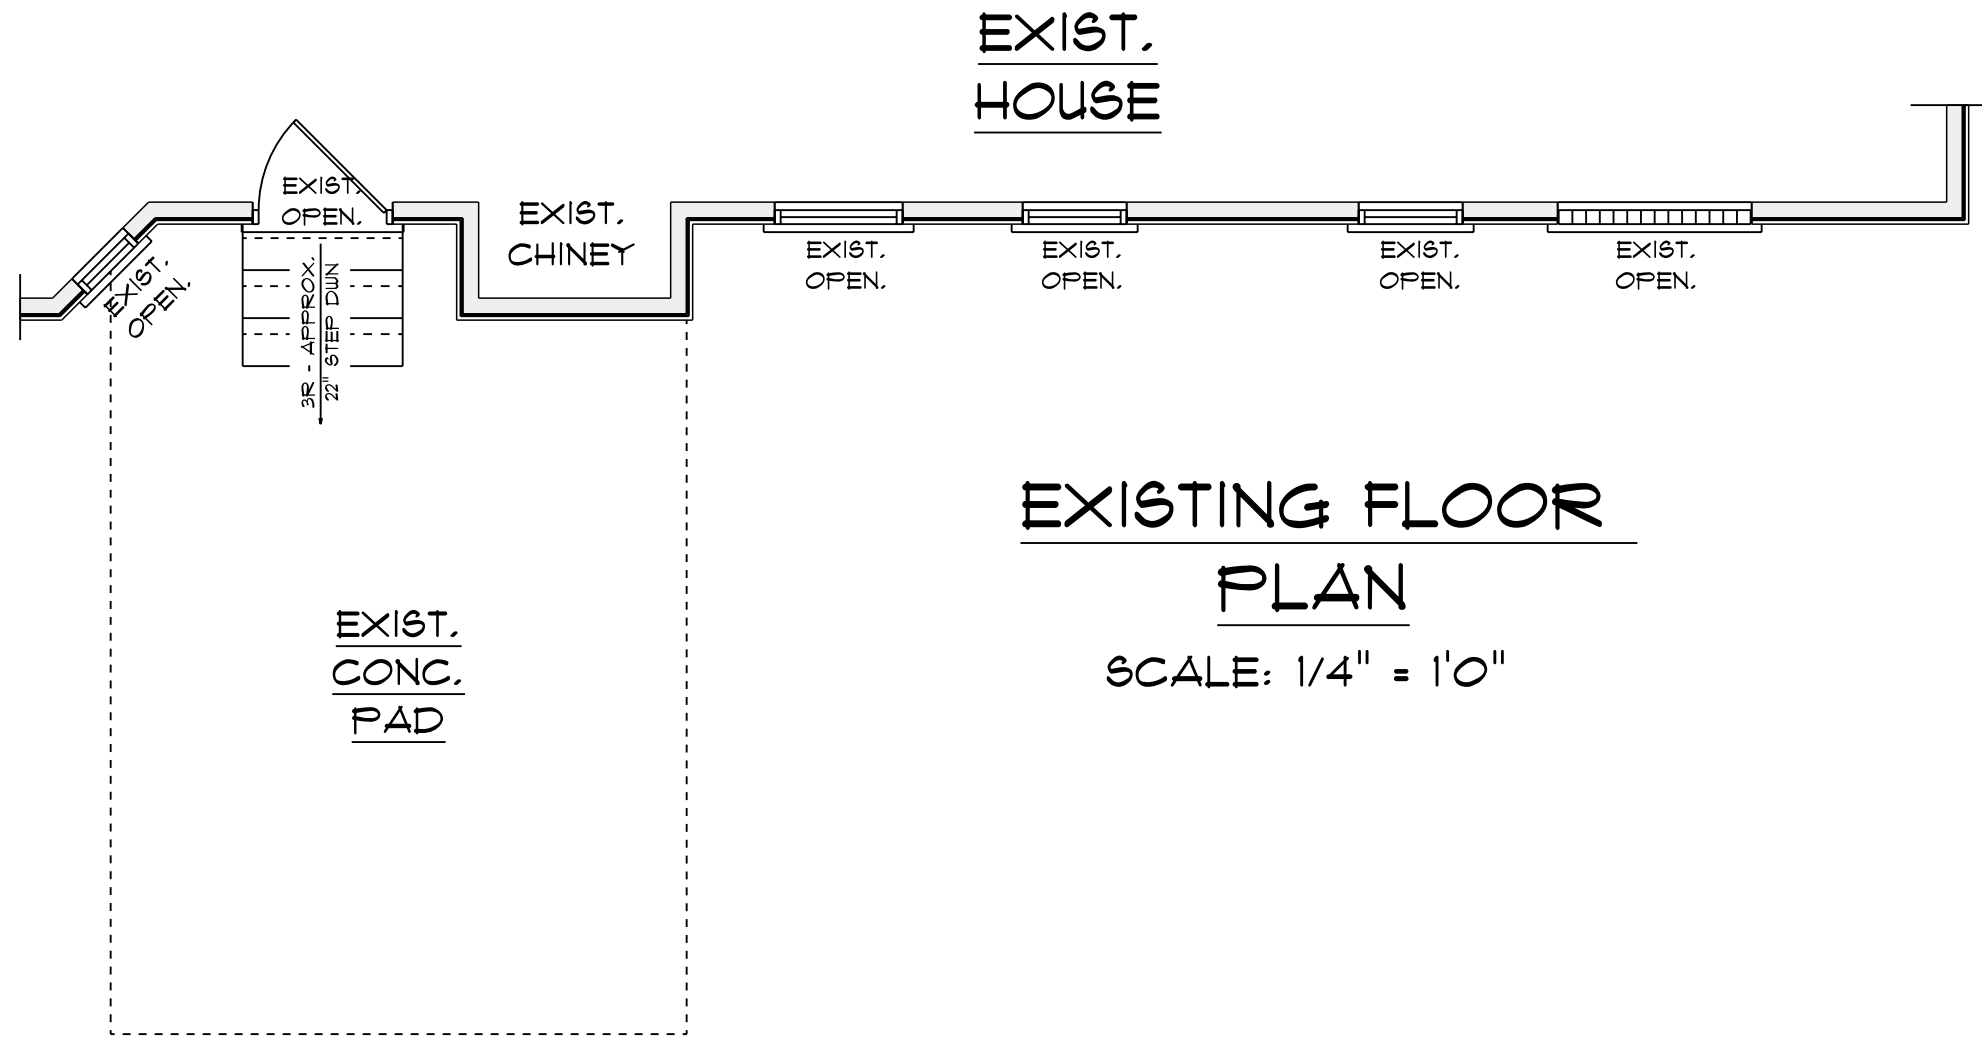

EXISTING FLOOR PLAN

SCALE: 1/4" = 1'0"

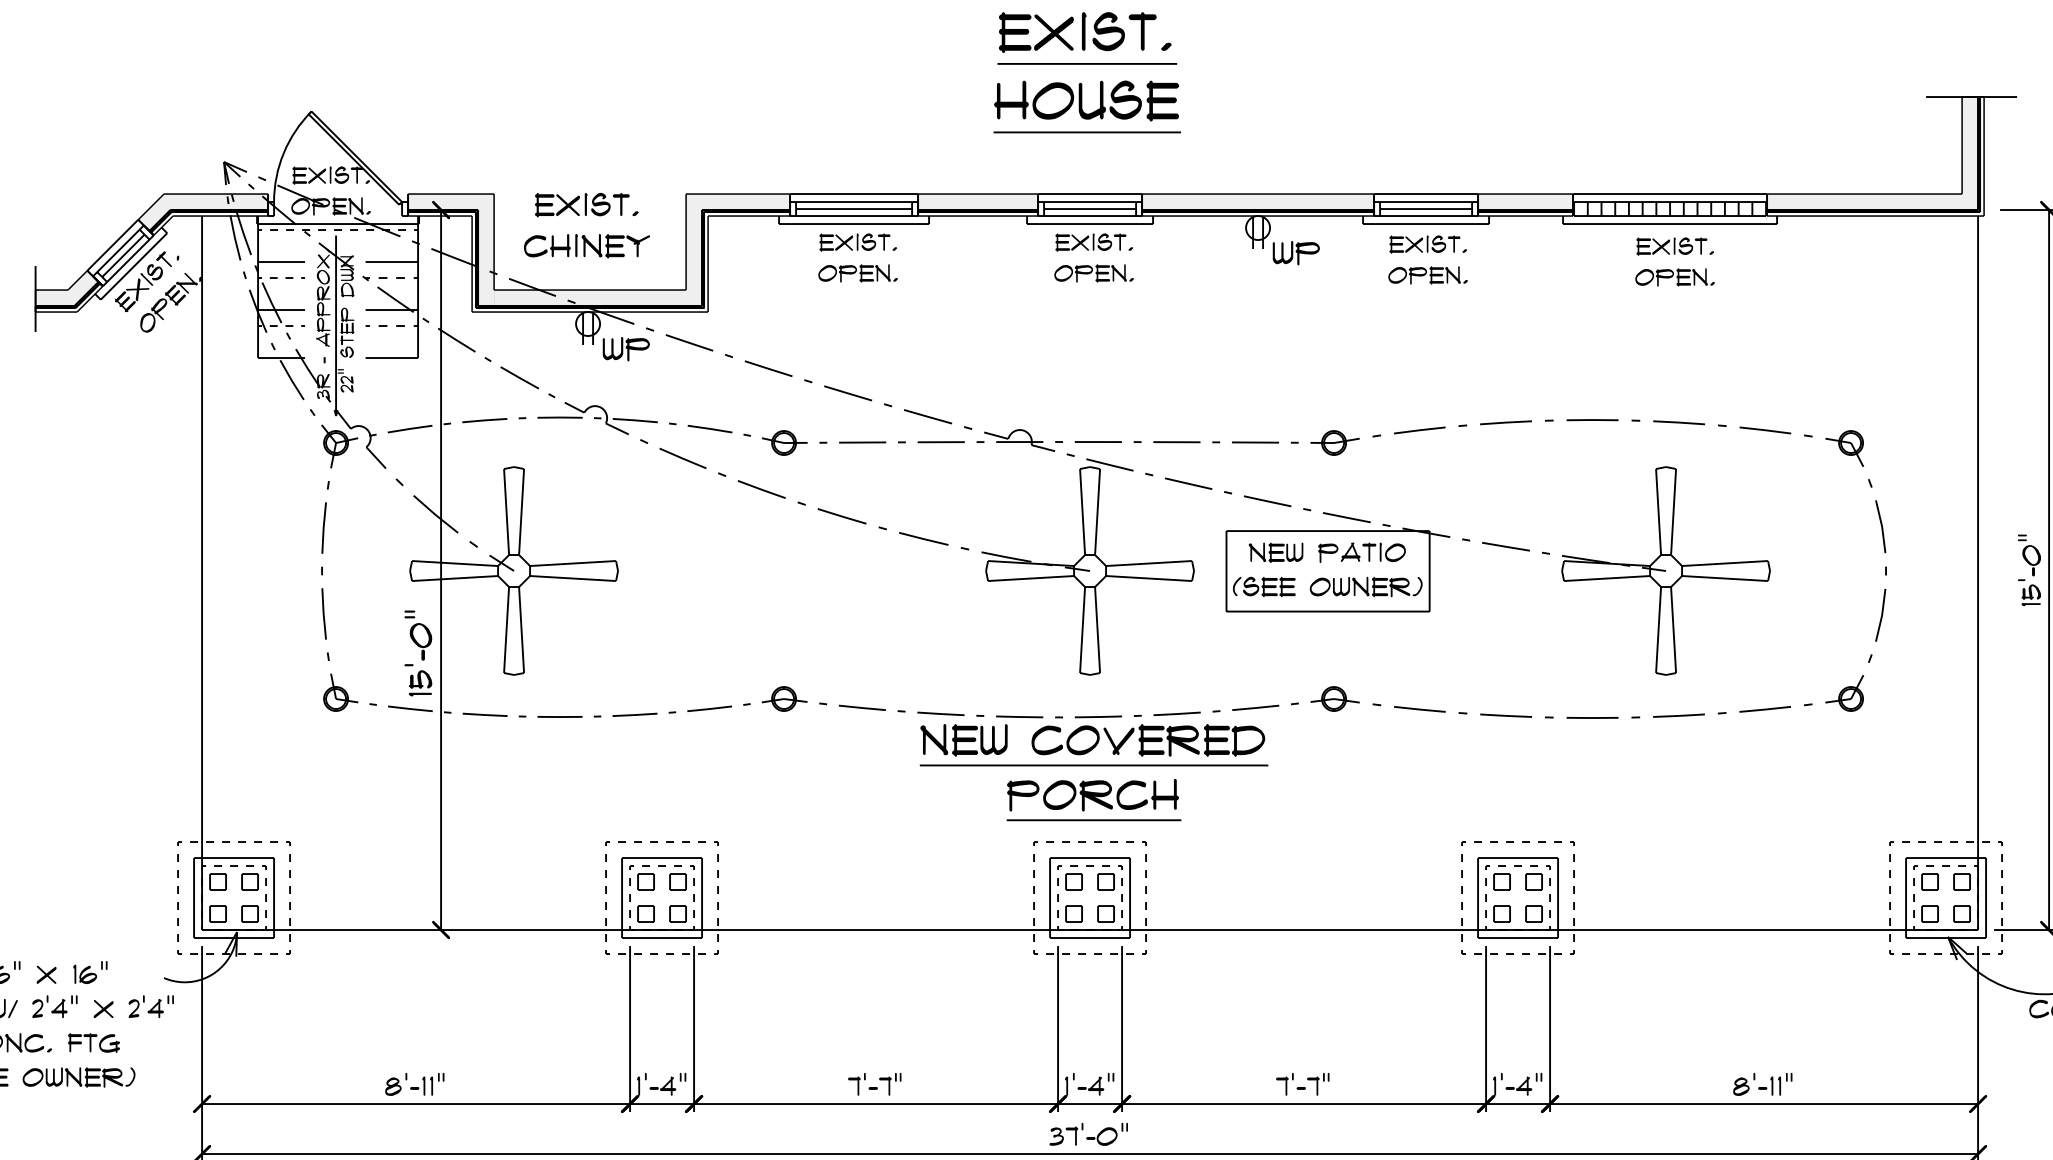

NEW CONSTRUCTION PLAN

SCALE: 1/4" = 1'0"

ELECTRICAL LEGEND		
ELECTRICAL	COUNT	SYMBOL
can light 6inch	8	
ceiling fan 4 bladed 01	3	
outlet	2	

ELECTICAL CONTRACTOR TO CONFIRM LOCATION OF OUTLETS AND STYLE OF LIGHTS WITH OWNER

ALL EXTERIOR FLOODLIGHTS TO BE DETERMINED ON SITE BY OWNER.

16" X 16" COL. W/ 2'4" X 2'4" CONC. FTG (SEE OWNER)

16" X 16" COL. W/ 2'4" X 2'4" CONC. FTG (SEE OWNER)

555 S/F - TOTAL ADDED AREA (NEW COVERED PORCH)

"I DO HEREBY CERTIFY THAT THIS DRAWING OR PLAN AND RELATED SPECIFICAT MEET ALL LOCAL REQUIREMENTS AND ARE IN SUBSTANTIAL CONFORMITY WITH VA MINIMUM PROPERTY REQUIREMENTS INCLUDING THE ENERGY CONSERVATION STAND OF THE 1992 COUNCIL OF AMERICAN BUILDING OFFICIALS (CABO) MODEL ENERGY

CHARLES SMITH ASSOCIATES © copyright 2025

SCALE: AS NOTED
DATE: OCT. 2025
DRAWN BY: ECL

CHARLES SMITH ASSOC.
RESIDENTIAL DESIGNER
FAYETTEVILLE, NC
PHONE: (910) - 484 - 5924
WWW.CSAPLANS.COM

THE BAKER PROPERTY
PRESERVATION CO.
PHONE NUMBER: (910) 745 - 7122

BP-555