


1 PARITAL PLAN - MECHANICAL
M4 SCALE:NTS

GENERAL NOTES:

- 1 EXISTING SPLIT SYSTEM TO REMAIN. ROUTE NEW DUCTWORK AS SHOWN.
- 2 SPLIT SYSTEM AIR HANDLER TO BE RELOCATED TO THIS LOCATION. SEE M2 FOR ORIGINAL LOCATION. EXTEND ALL SERVICES AS REQUIRED.
- 3 ROUTE 10" EXHAUST TO WALL OR ROOF CAP FOR NEW EXHAUST FAN.
- 4 SEE M3 FOR DETAILS OF THIS AREA.
- 5 END WALL SECTION OF DUCTWORK TO BE DOUBLE WALL SPIRAL.
- 6 EXPOSED ROUND DUCT, UNLESS NOTED OTHERWISE TO BE FABRIC EQUAL TO DUCTSOX SEDONA-XM. COORDINATE WITH OWNER AND MANUFACTURER FOR EXACT SIZING, COLOR, AND PERFORATION PATTERN. PROVIDE MULTIPOINT HANGING SYSTEM.

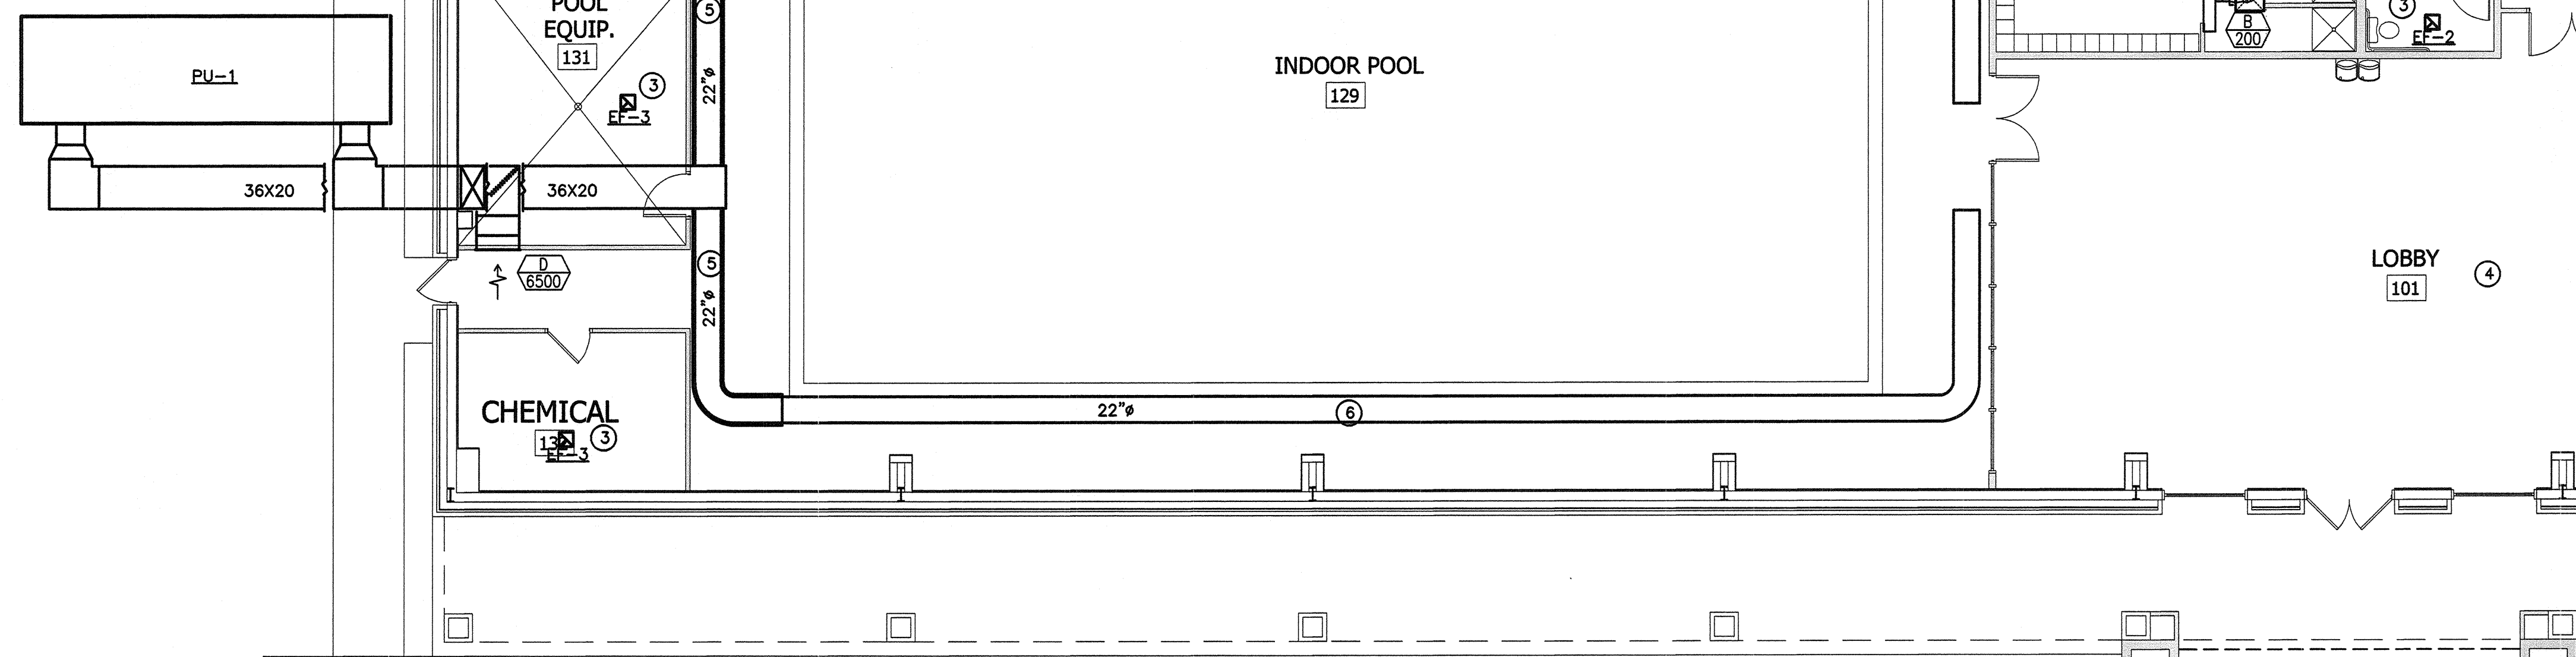

1 PARITAL PLAN - MECHANICAL
M4 SCALE:1/8"=1'-0"

PROJECT NO. 10800
McDowell Consulting Engineers
P.O. BOX 367 HAMPSTEAD, NC 28443
TEL: (910) 270-3747 FAX: (910) 270-3779
NC LICENSE NO. C-2546

GOODRICH
ARCHITECTURE, P.A.

3142 WRIGHTSVILLE AVENUE
WILMINGTON NC 28403

OFFICE: 910.343.1065
FAX: 910.343.1067
EMAIL: BGOODRICH@AOL.COM

YMCA OF HARNETT COUNTY
107 GARLETTA CABLE DRIVE
CAMERON, NORTH CAROLINA

PROJECT # 18123

PARTIAL PLAN - MECHANICAL

CAPD
H. HARRIS
259333
2/25/19
REVIEW

DATE: 29 MARCH, 2019

REVISION:

M4