



FOR CONTINUATION SEE SHEET C-5

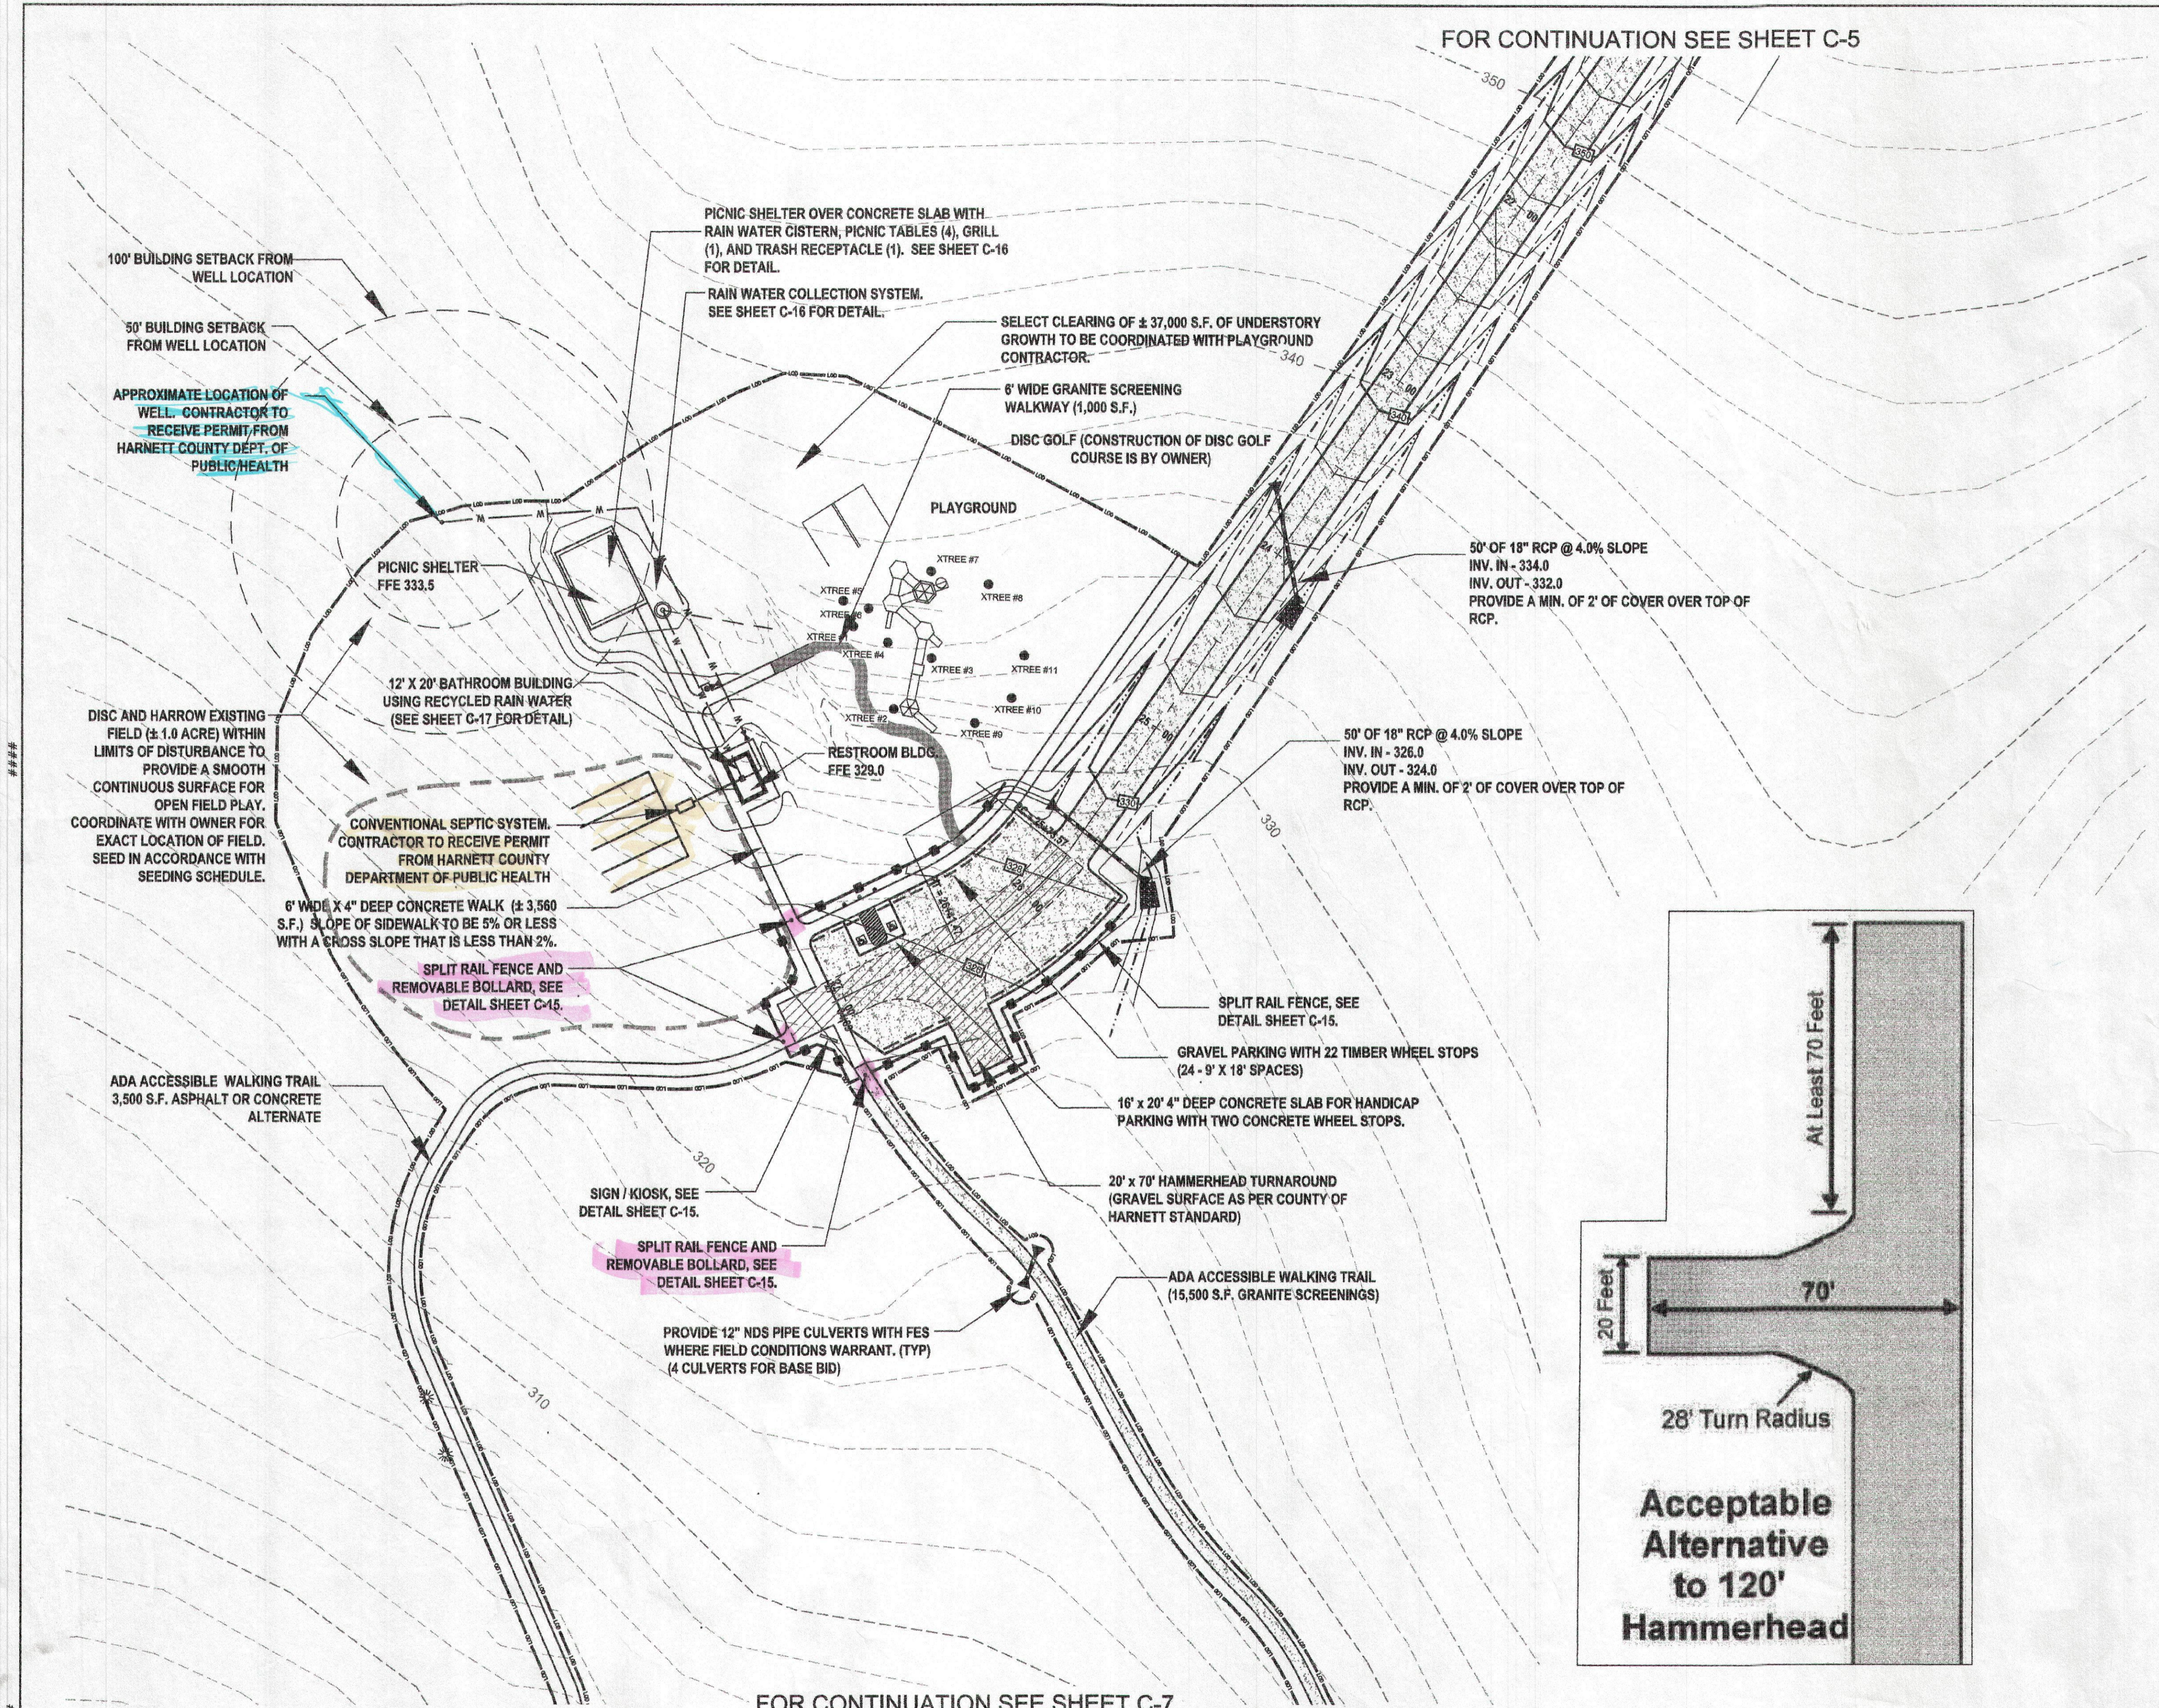

FOR CONTINUATION SEE SHEET C-7

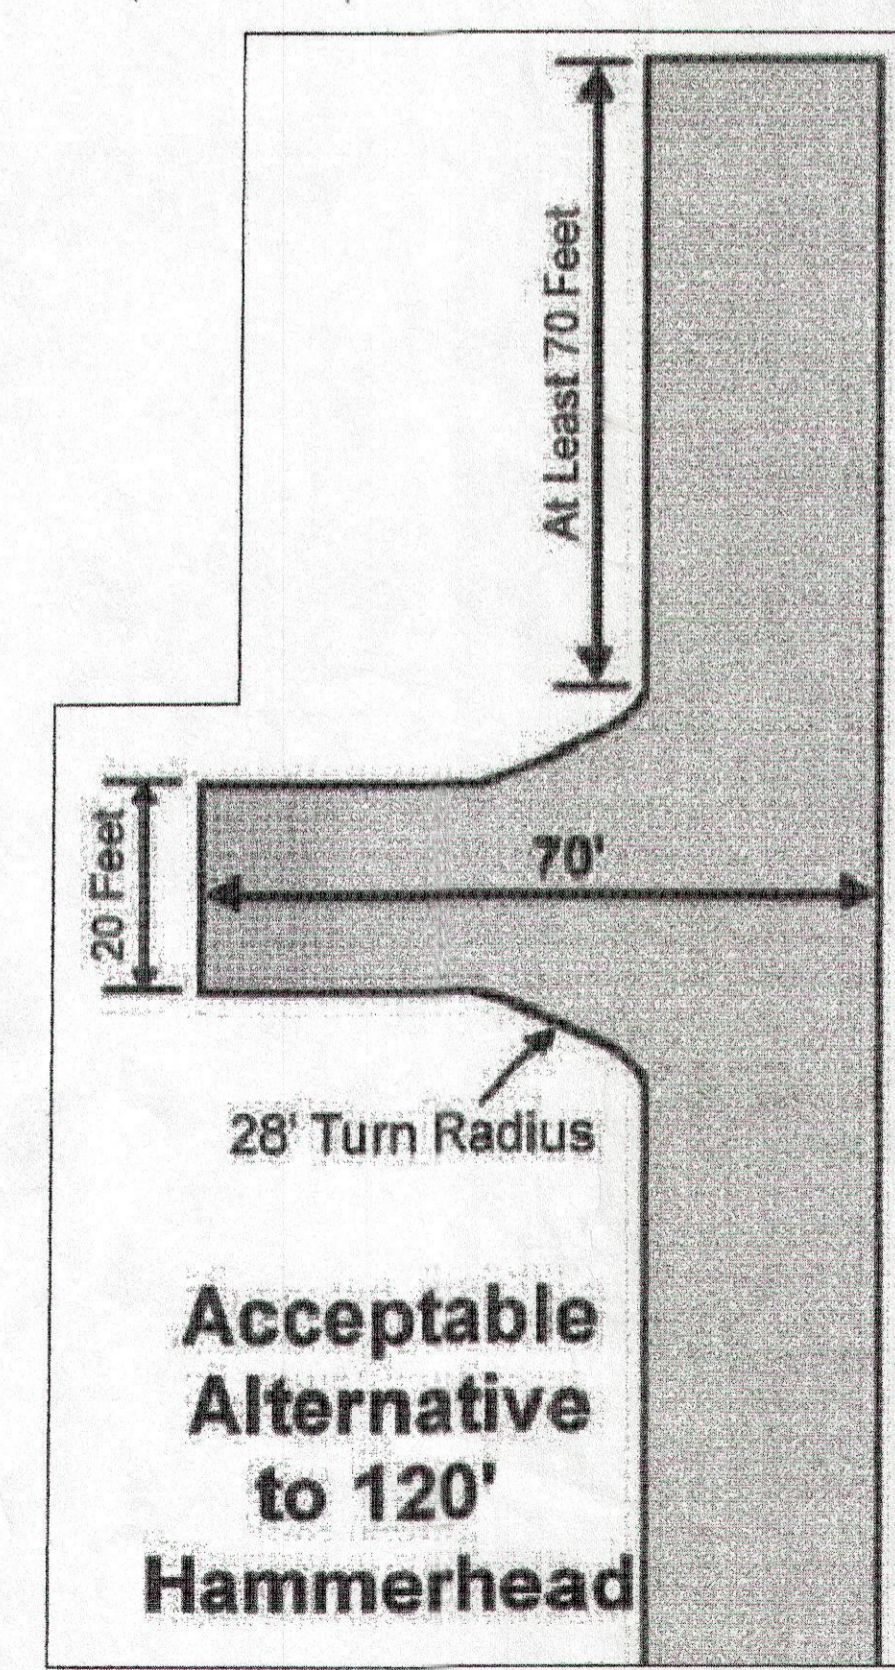

WK DICKSON
community infrastructure consultants
Transportation + Water Resources
Urban Development + Geomatics
720 Corporate Center Drive
Raleigh, NC 27607
(919) 782-0485
www.wkdickson.com
NC LICENSE NO. P-0074



NORTH
FULL SCALE: 1" = 40'
2" = FULL SCALE
1" = HALF SCALE

MARK	DATE	DESCRIPTION	RELEASED FOR:
			CONSTRUCTION
			PLLOT DATE: 4/10/2013

PROJECT NAME: ANDERSON CREEK PARK
HARNETT COUNTY
LILLINGTON, NORTH CAROLINA
DRAWING TITLE: SITE PLAN
OWNER / 24 HR CONTACT: Carl Davis - Park and Recreation Director
ADDRESS: 1100 E. McNeill Street, Lillington, NC 27546
PHONE: 910-883-7518
MOBILE: 910-880-0131

PROJ. DATE: APRIL 17, 2013
Q.C.: QC
Q.C. DATE: QC DATE
DRAWING NUMBER:
C-6
PROJ. NO.: 20110206.00.RA