


Floor Plan

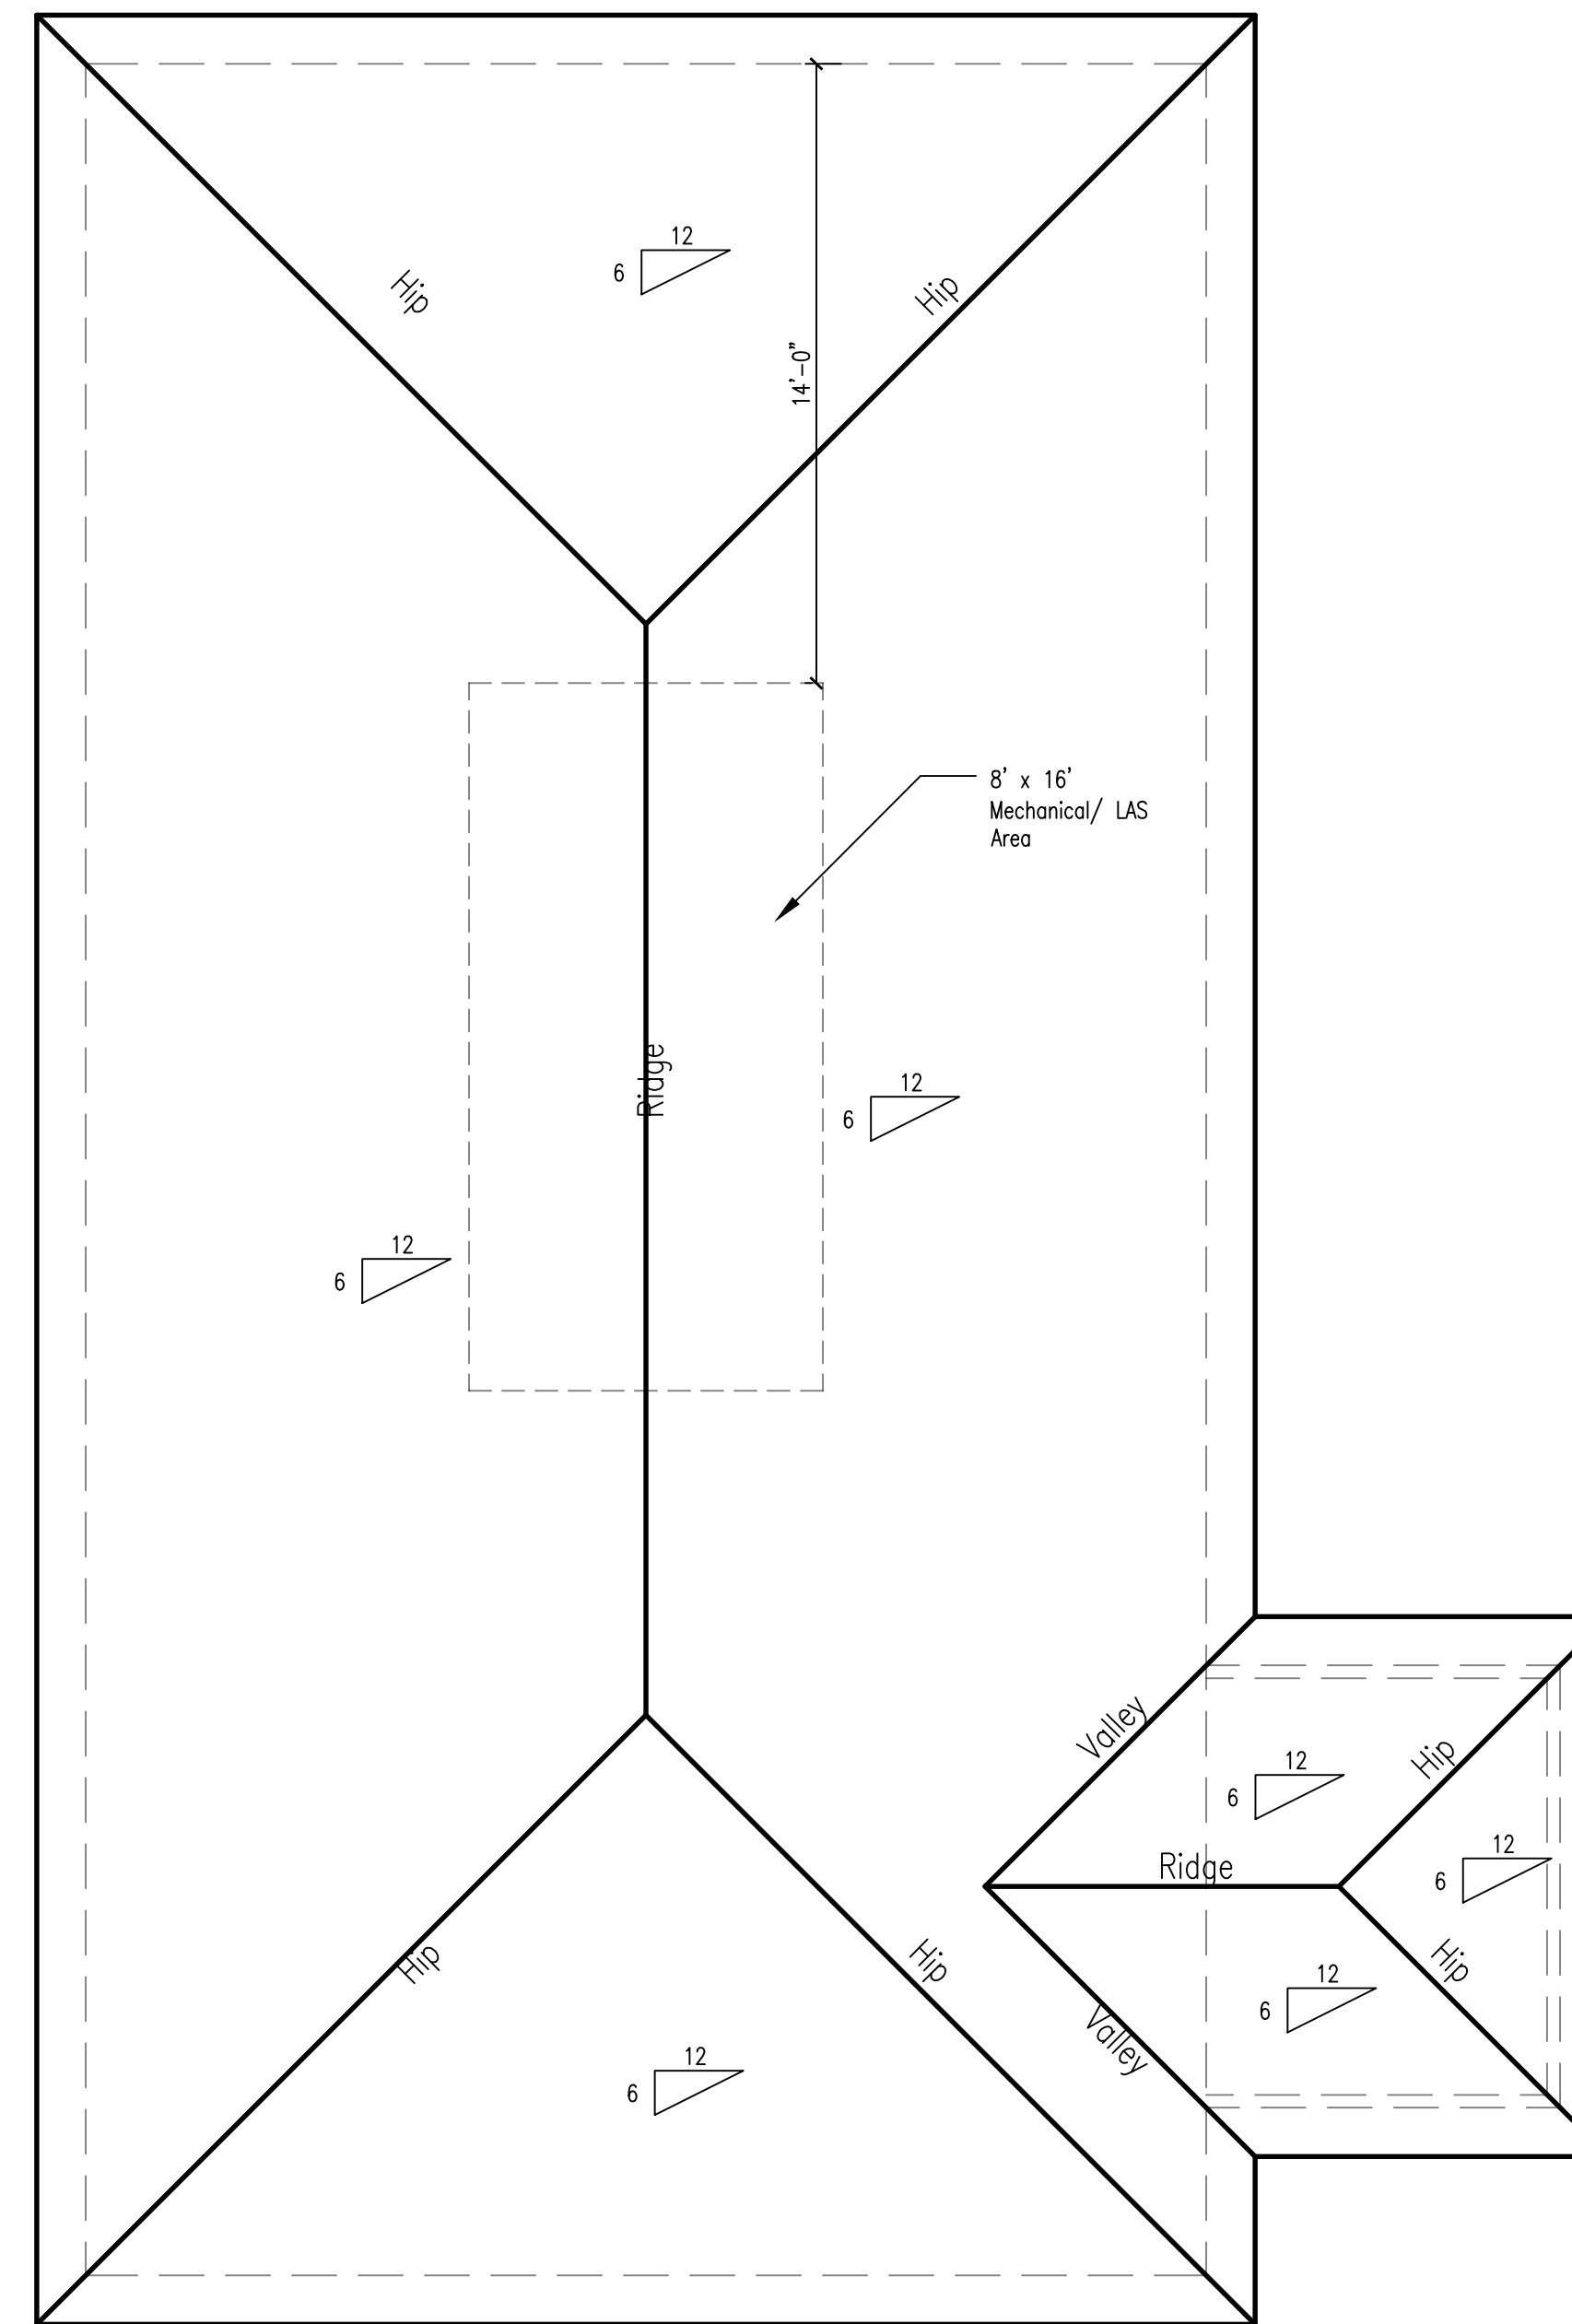

Roof Plan

Total Heated	1,267
Covered Porch	80
Total Under Roof	1,347

PROJECT REF.
Concrete Supply


DRAWING STATUS/ DATE
 Construction 3/9/18
 Revised 4/3/18

DRAWING
Floor Plan/
Roof Plan


Scale: 1/4" = 1'-0"

Page #


1

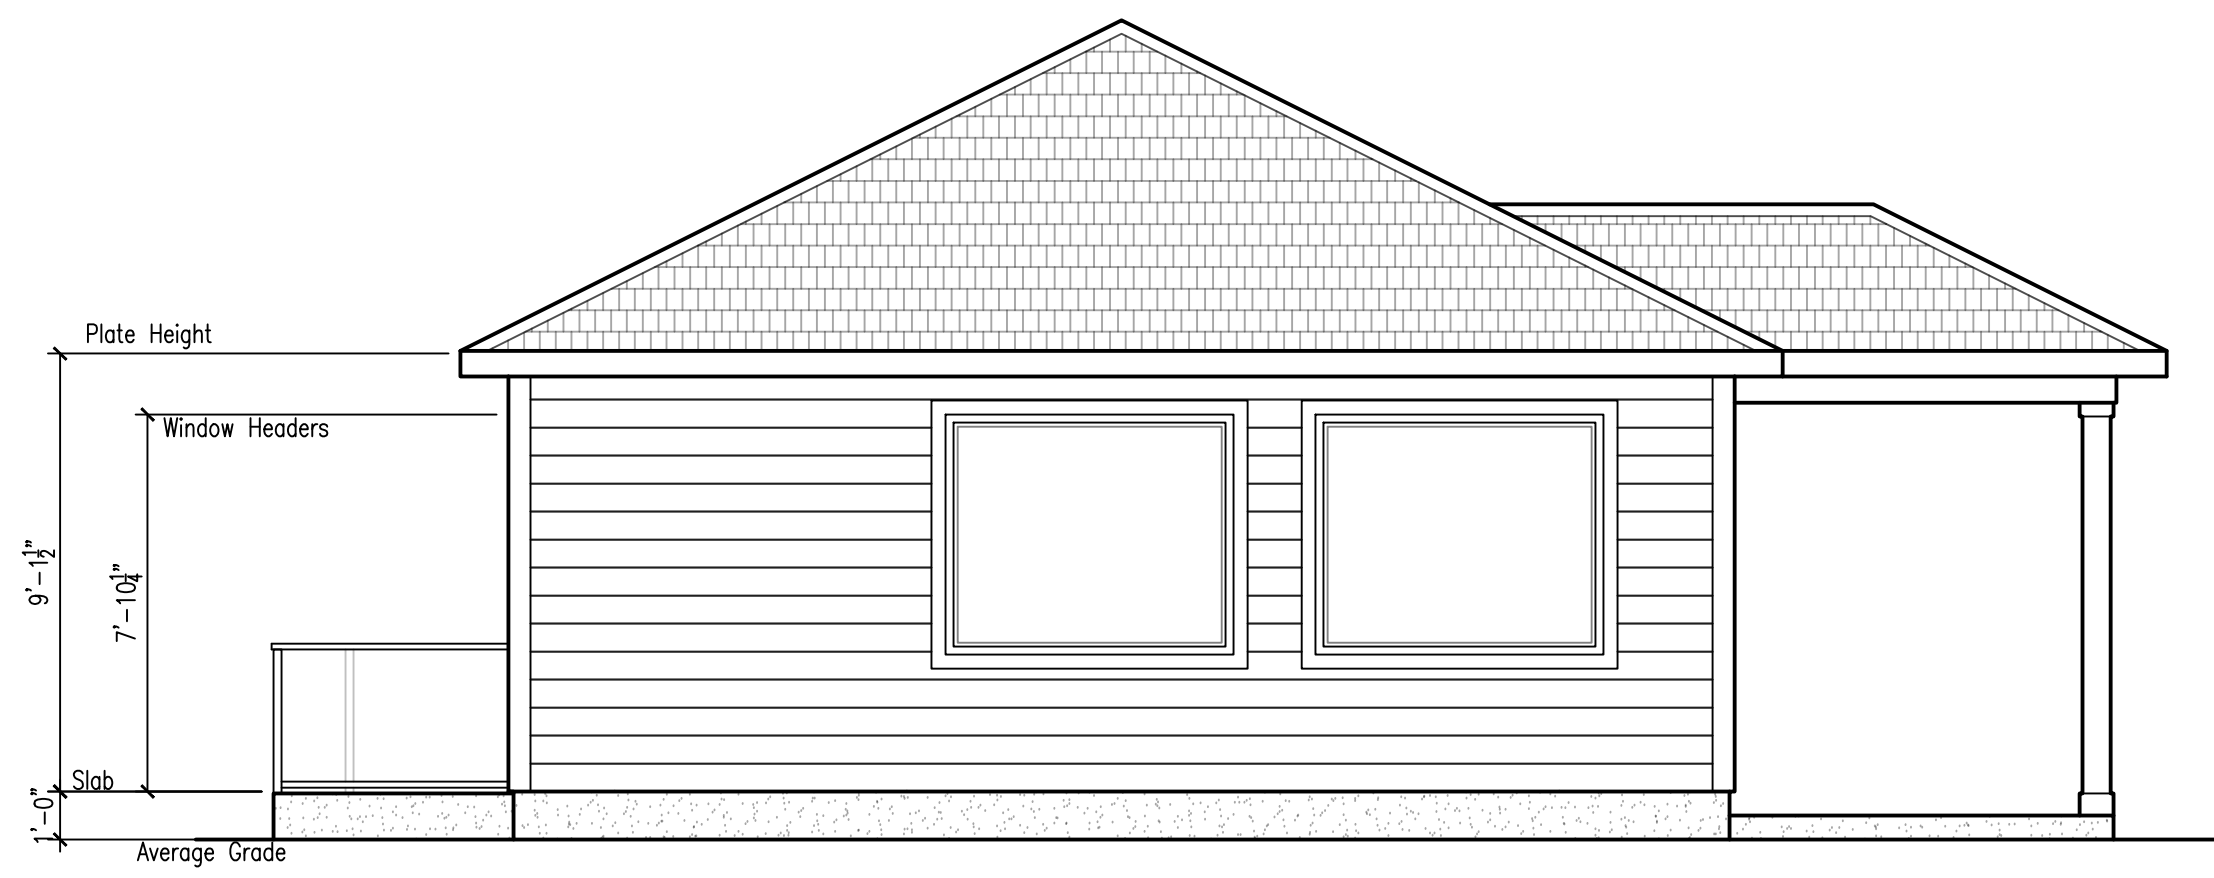


Front Elevation

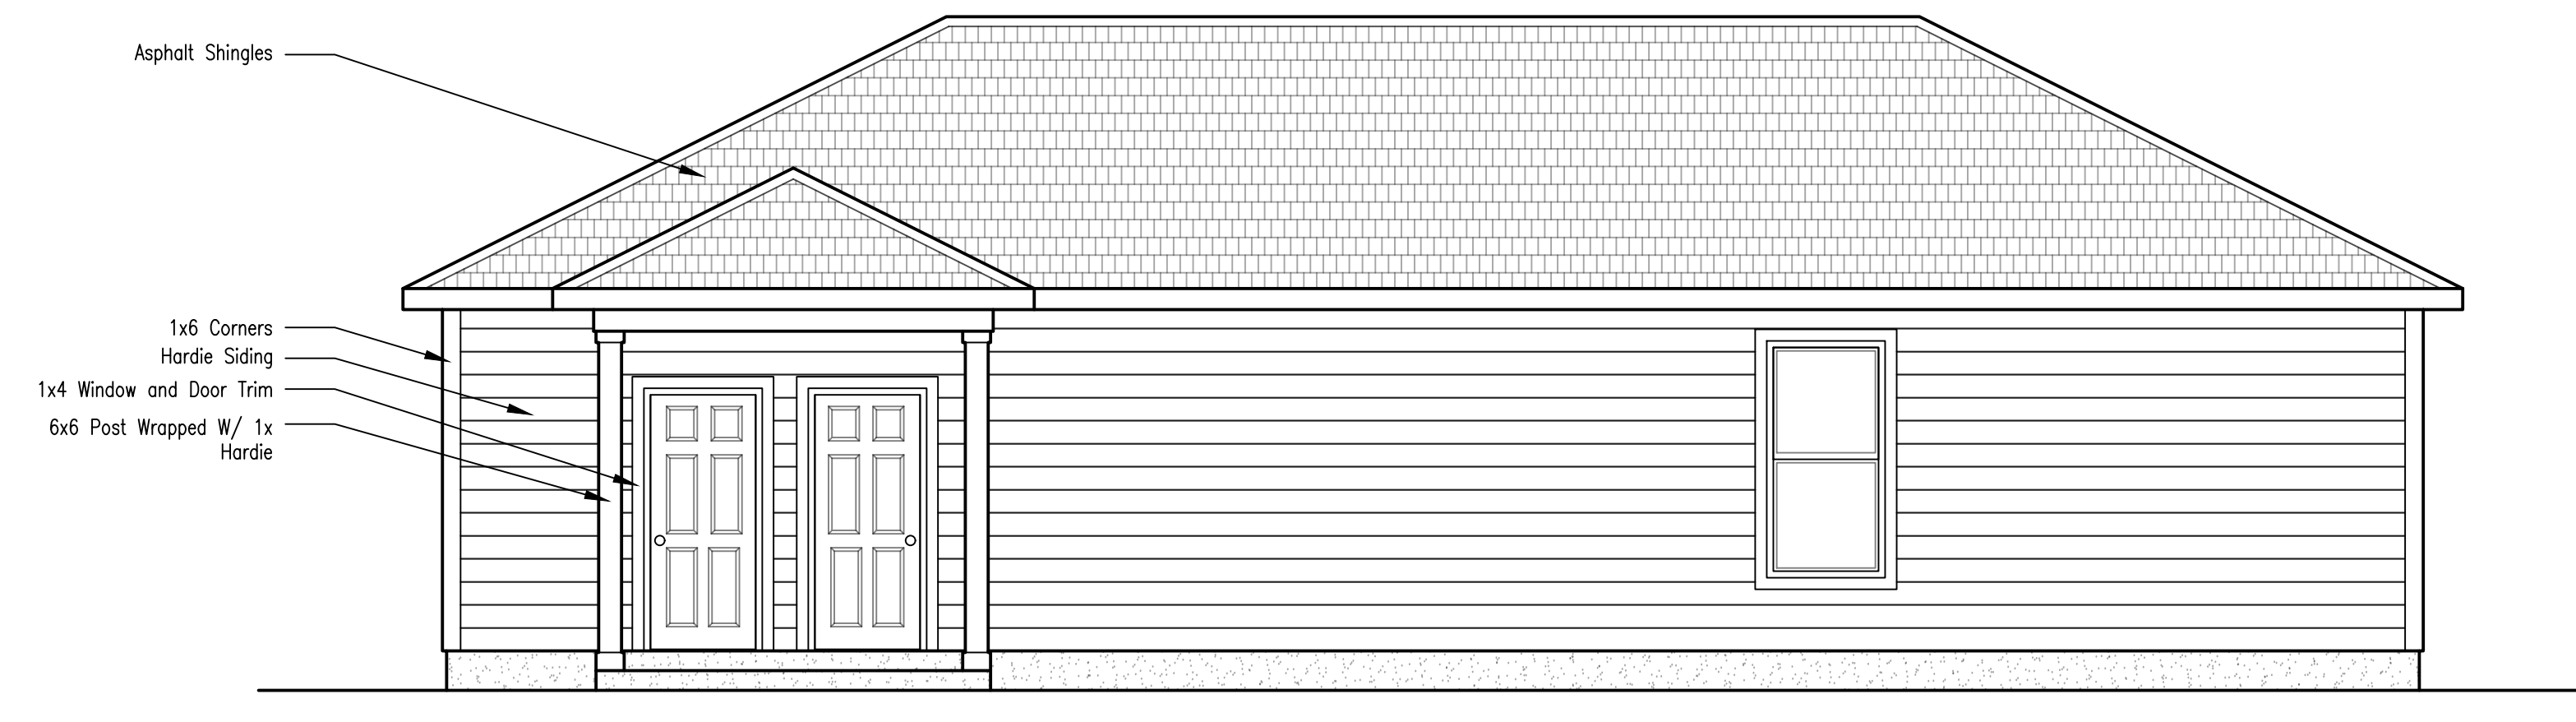

Right Elevation

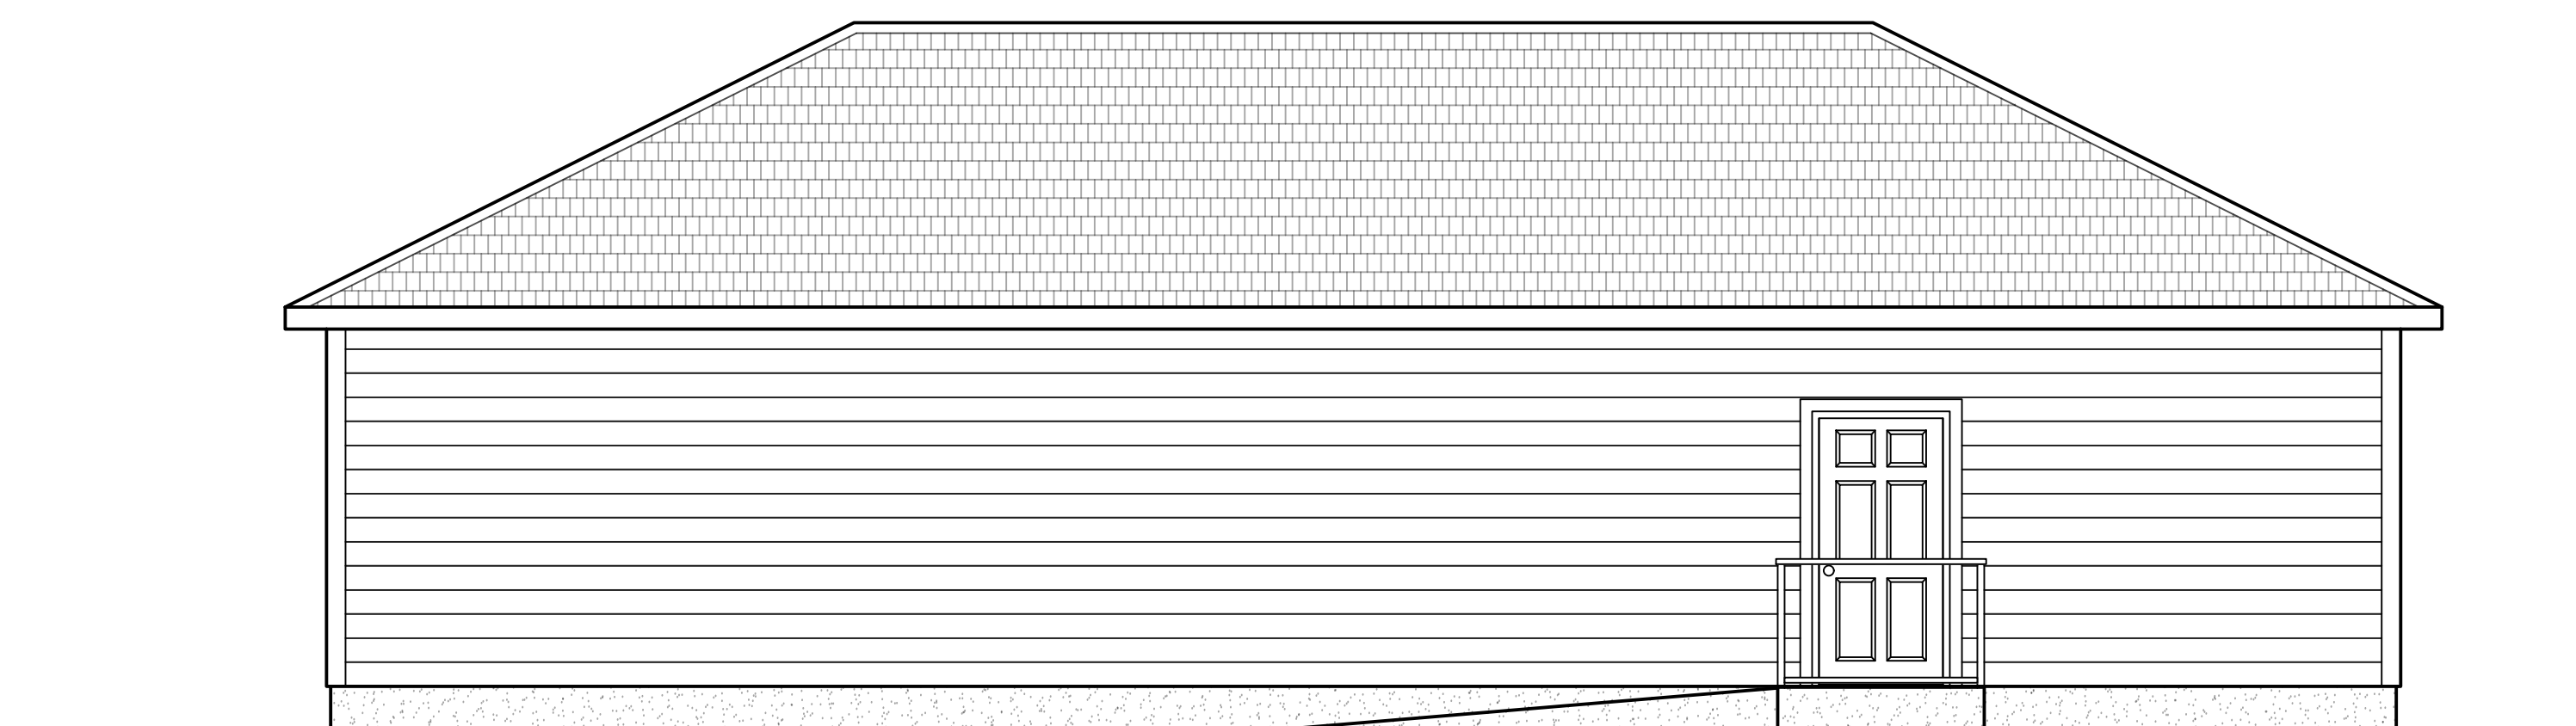

Left Elevation

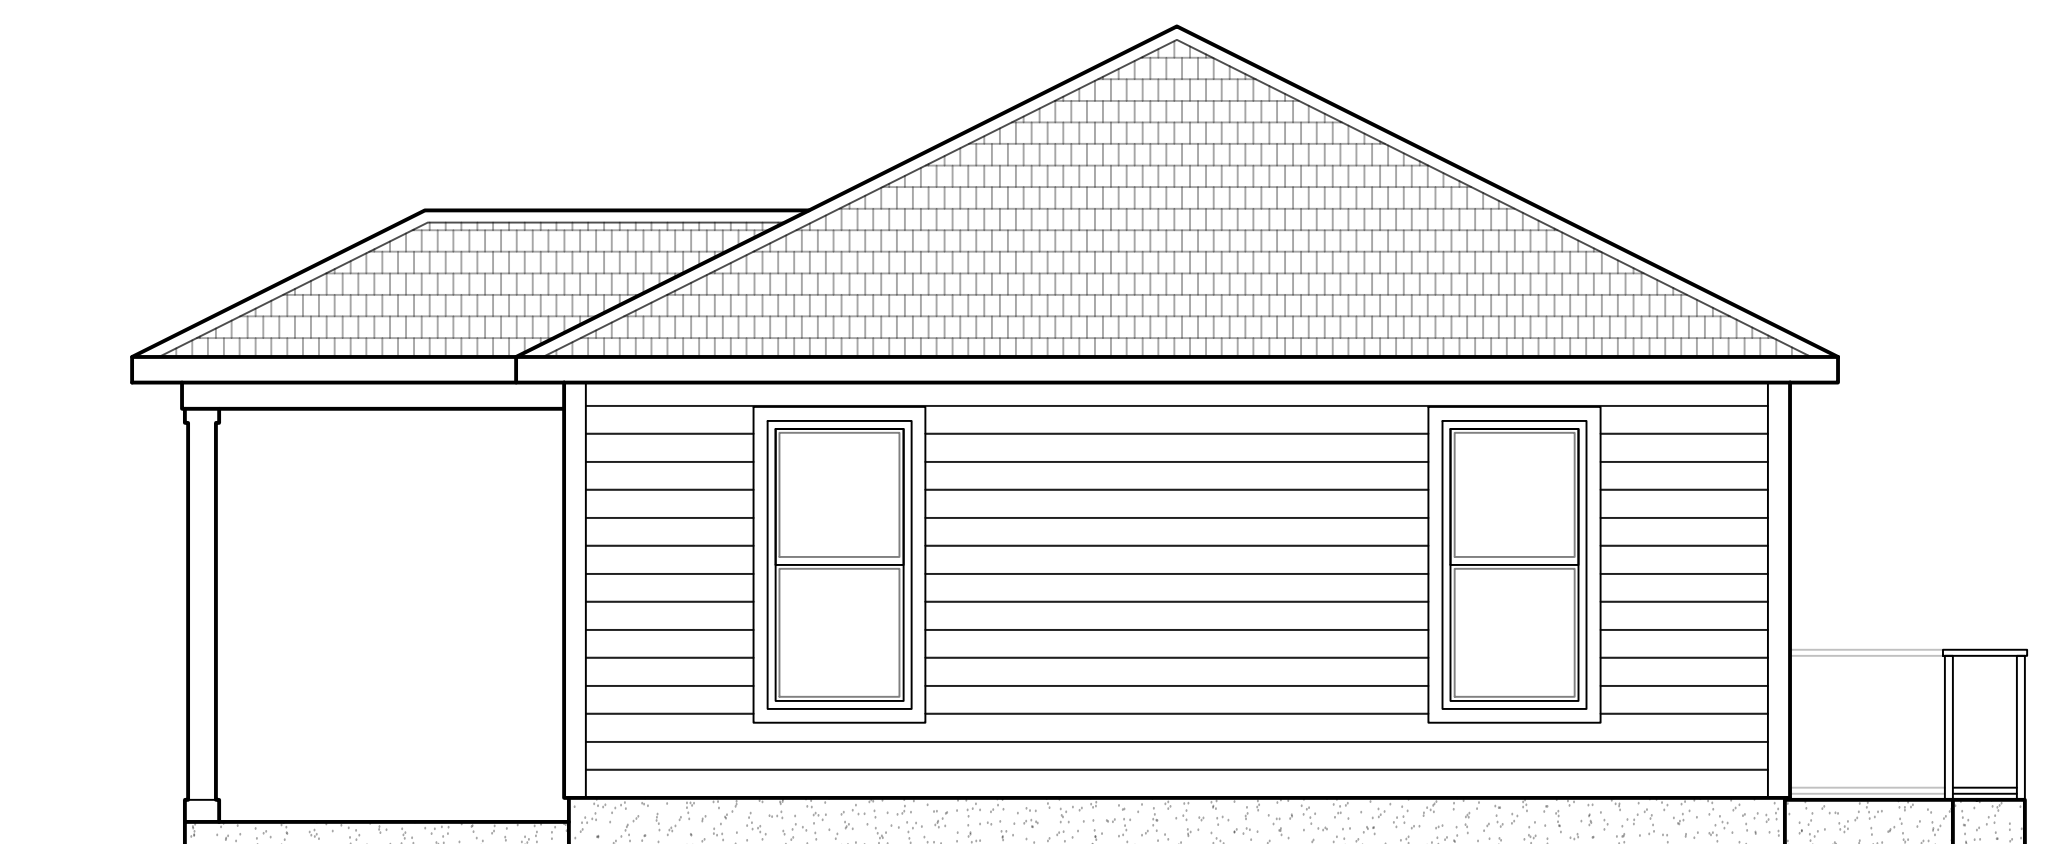

Rear Elevation

CONCRETE SUPPLY
NEW DISPATCH OFFICE

DESIGNS
DANIEL
3700 Tramonto Pointe Blvd
Myrtle Beach, SC (843) 222-2995


 

 
 
 
 
 

 

 

PROJECT REF.
Concrete Supply


DRAWING STATUS/ DATE
 Construction 3/9/18

DRAWING
Elevations

Scale: 1/4" = 1'-0"

Page #
2

Legend				
DESCRIPTION/SYMBOL	LAMP	MOUNTING	MANUFACTURER	CATALOG #
 2' x 2' Fluorescent Fixture W/ 1350 Lumen FBPS0 Emergency Ballast	(2)F32T8U6	T-Bar	LIGHTOLIER	XT2GV12U6-UNV-SO-FBP50
 2' x 2' Fluorescent Fixture	(2)F32T8U6	T-Bar	LIGHTOLIER	XT2GV12U6-UNV-SO
 2' x 4' Fluorescent Fixture W/ 1350 Lumen FBPS0 Emergency Ballast	(3)F32T8	T-Bar	LIGHTOLIER	XP2GVA332-UNV-SO-FBP50
 2' x 4' Fluorescent Fixture	(3)F32T8	T-Bar	LIGHTOLIER	XP2GVA332-UNV-SO
 Exit Light With Batteries Green Letters	LED (Included)	Surface	LIGHTOLIER	E118LT9W
 Lensed Type 3 Exterior Wall Bracket	(1)70MP PS	Wall	VISIONAIRE	SIL-2-T3-70PS-MT-DL-BK
 Hand Dryer	NA			
 GFCI Ground Fault Circuit Interrupted Receptacle	NA			
 Duplex Receptacle	NA			
 Wall Switch	NA			
 Cable TV/ Outlet Combination	NA			
 Smoke/CO Detector	NA			
 Exit Path				

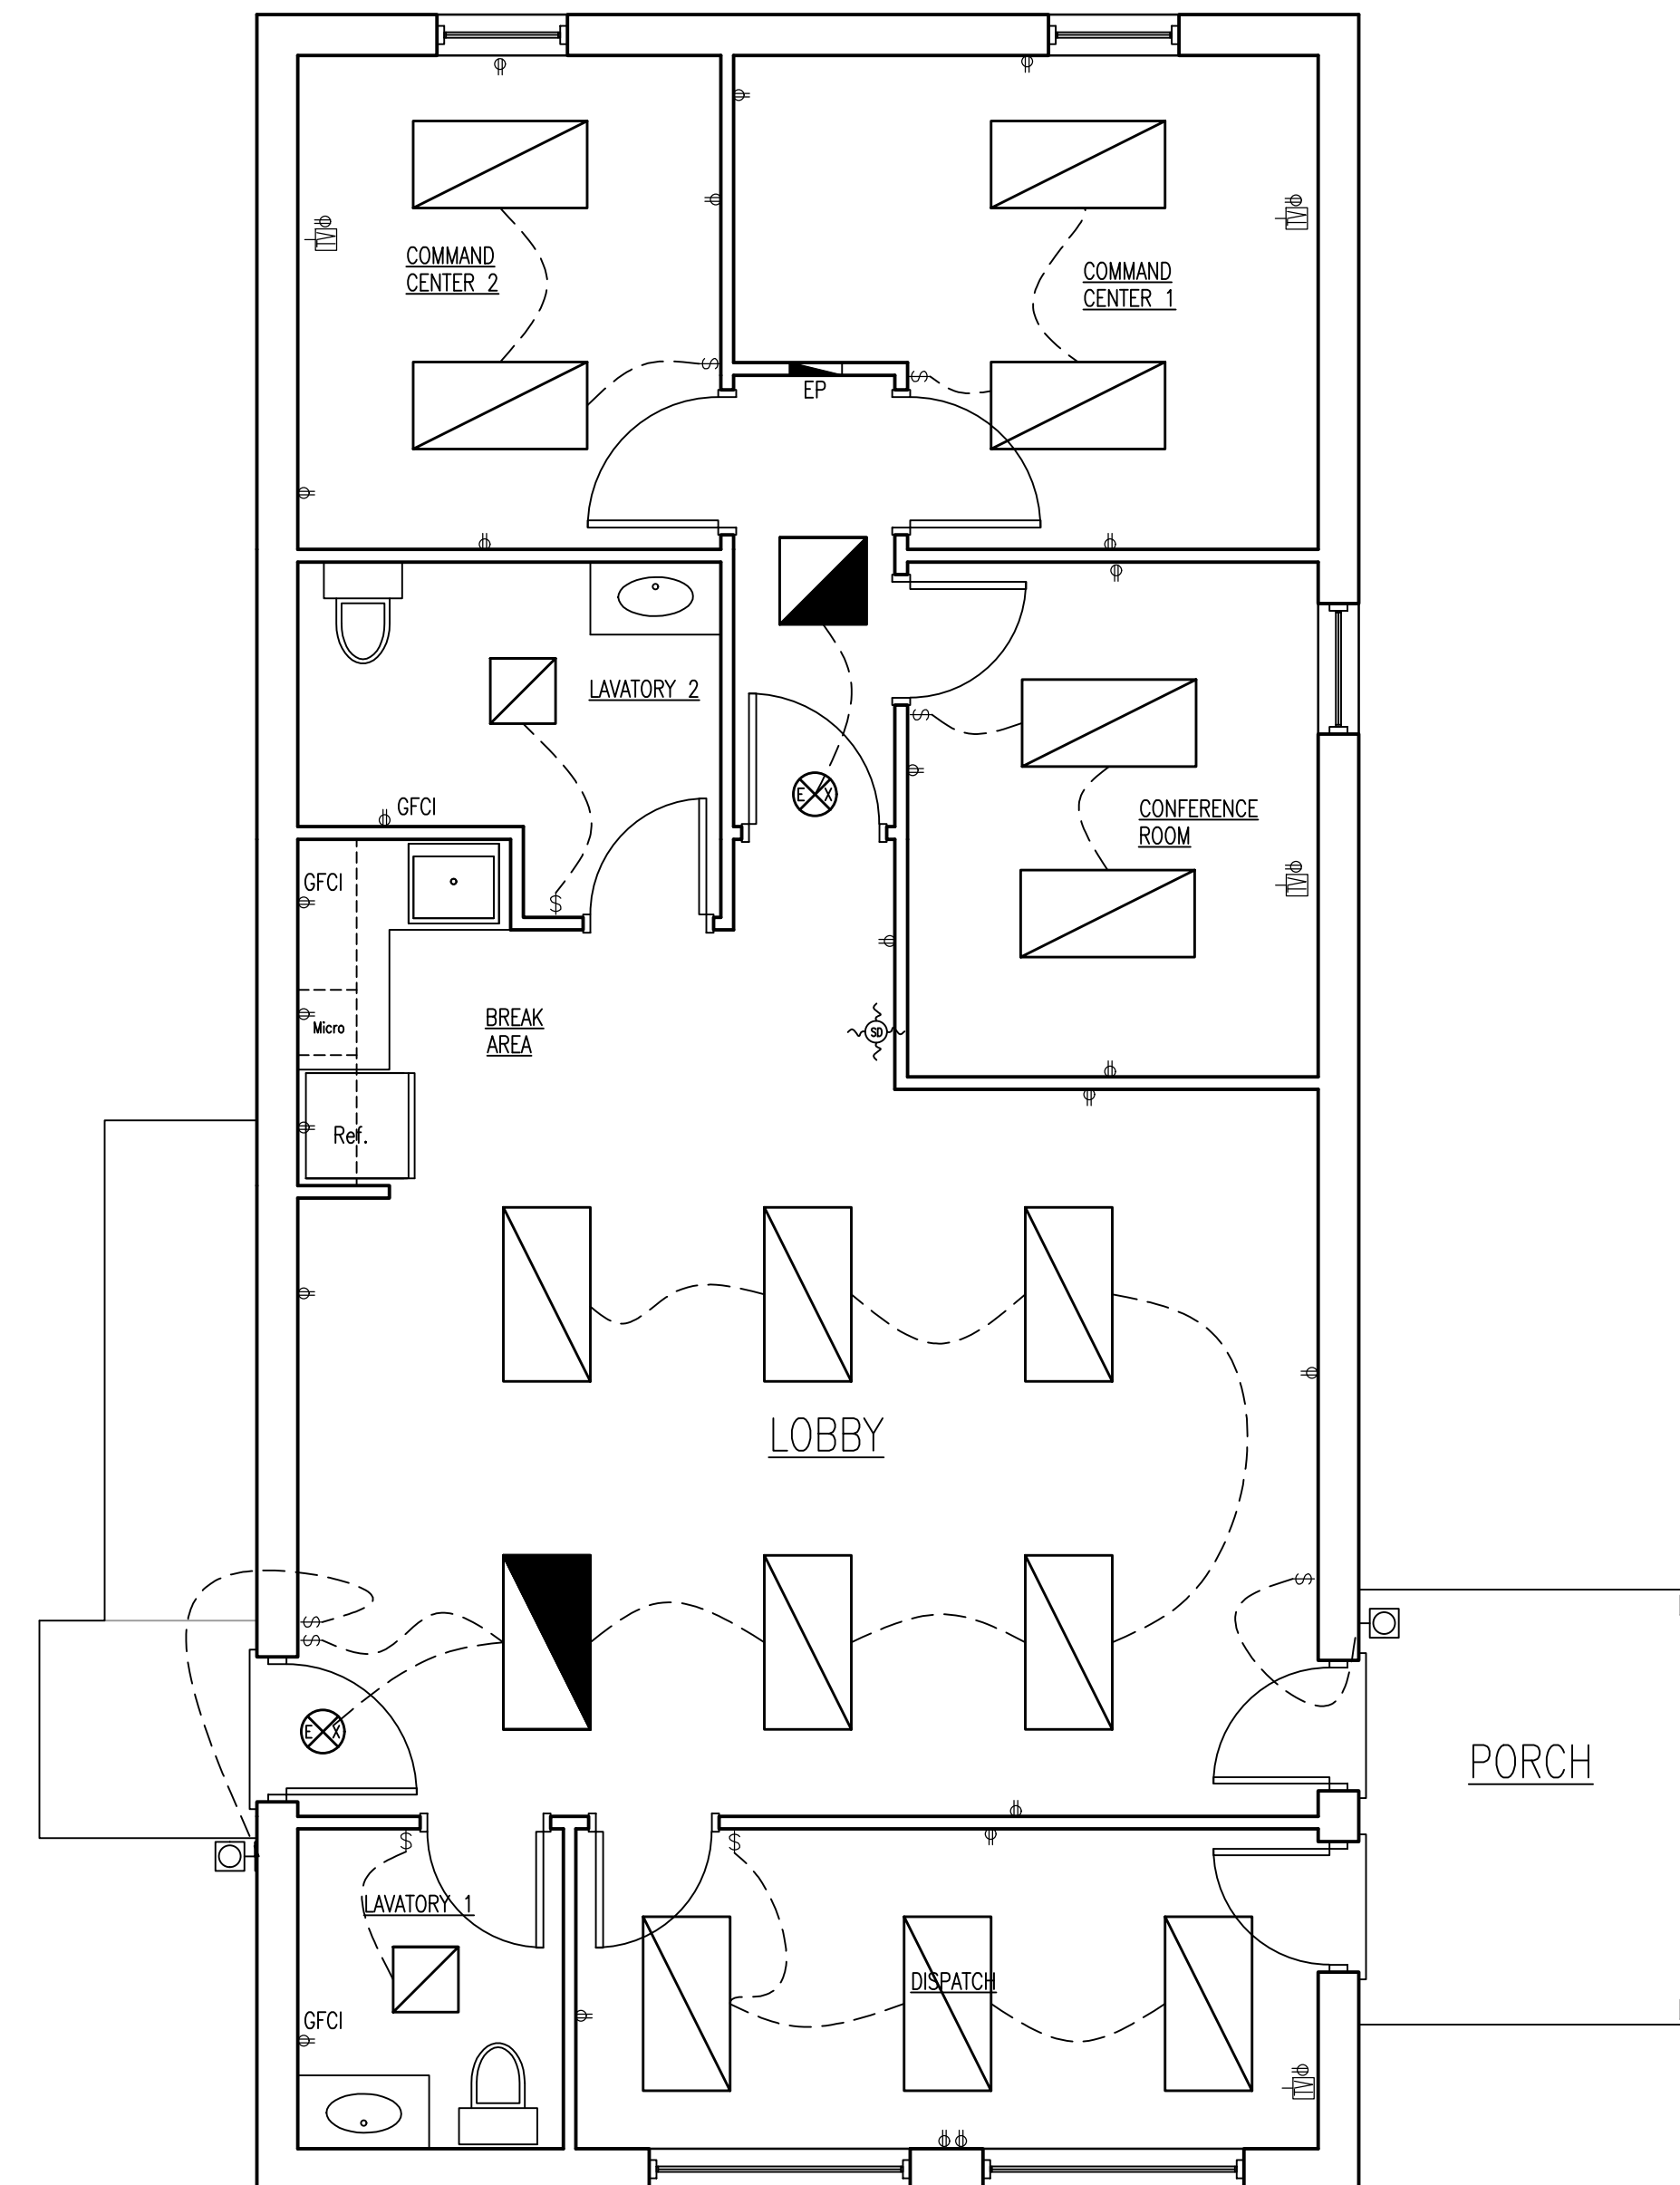

CONCRETE SUPPLY
NEW DISPATCH OFFICE



**DESIGNS
BY
DANIEL**
3700 Trimmitt Pointe Blvd
Myrtle Beach, SC (843) 222-2995

PROJECT REF.
Concrete Supply

DRAWING STATUS/ DATE
 Construction 3/9/18
 Revised 4/3/18

DRAWING
Electrical
Plan
Scale: 1/4" = 1'-0"

Page #
E1

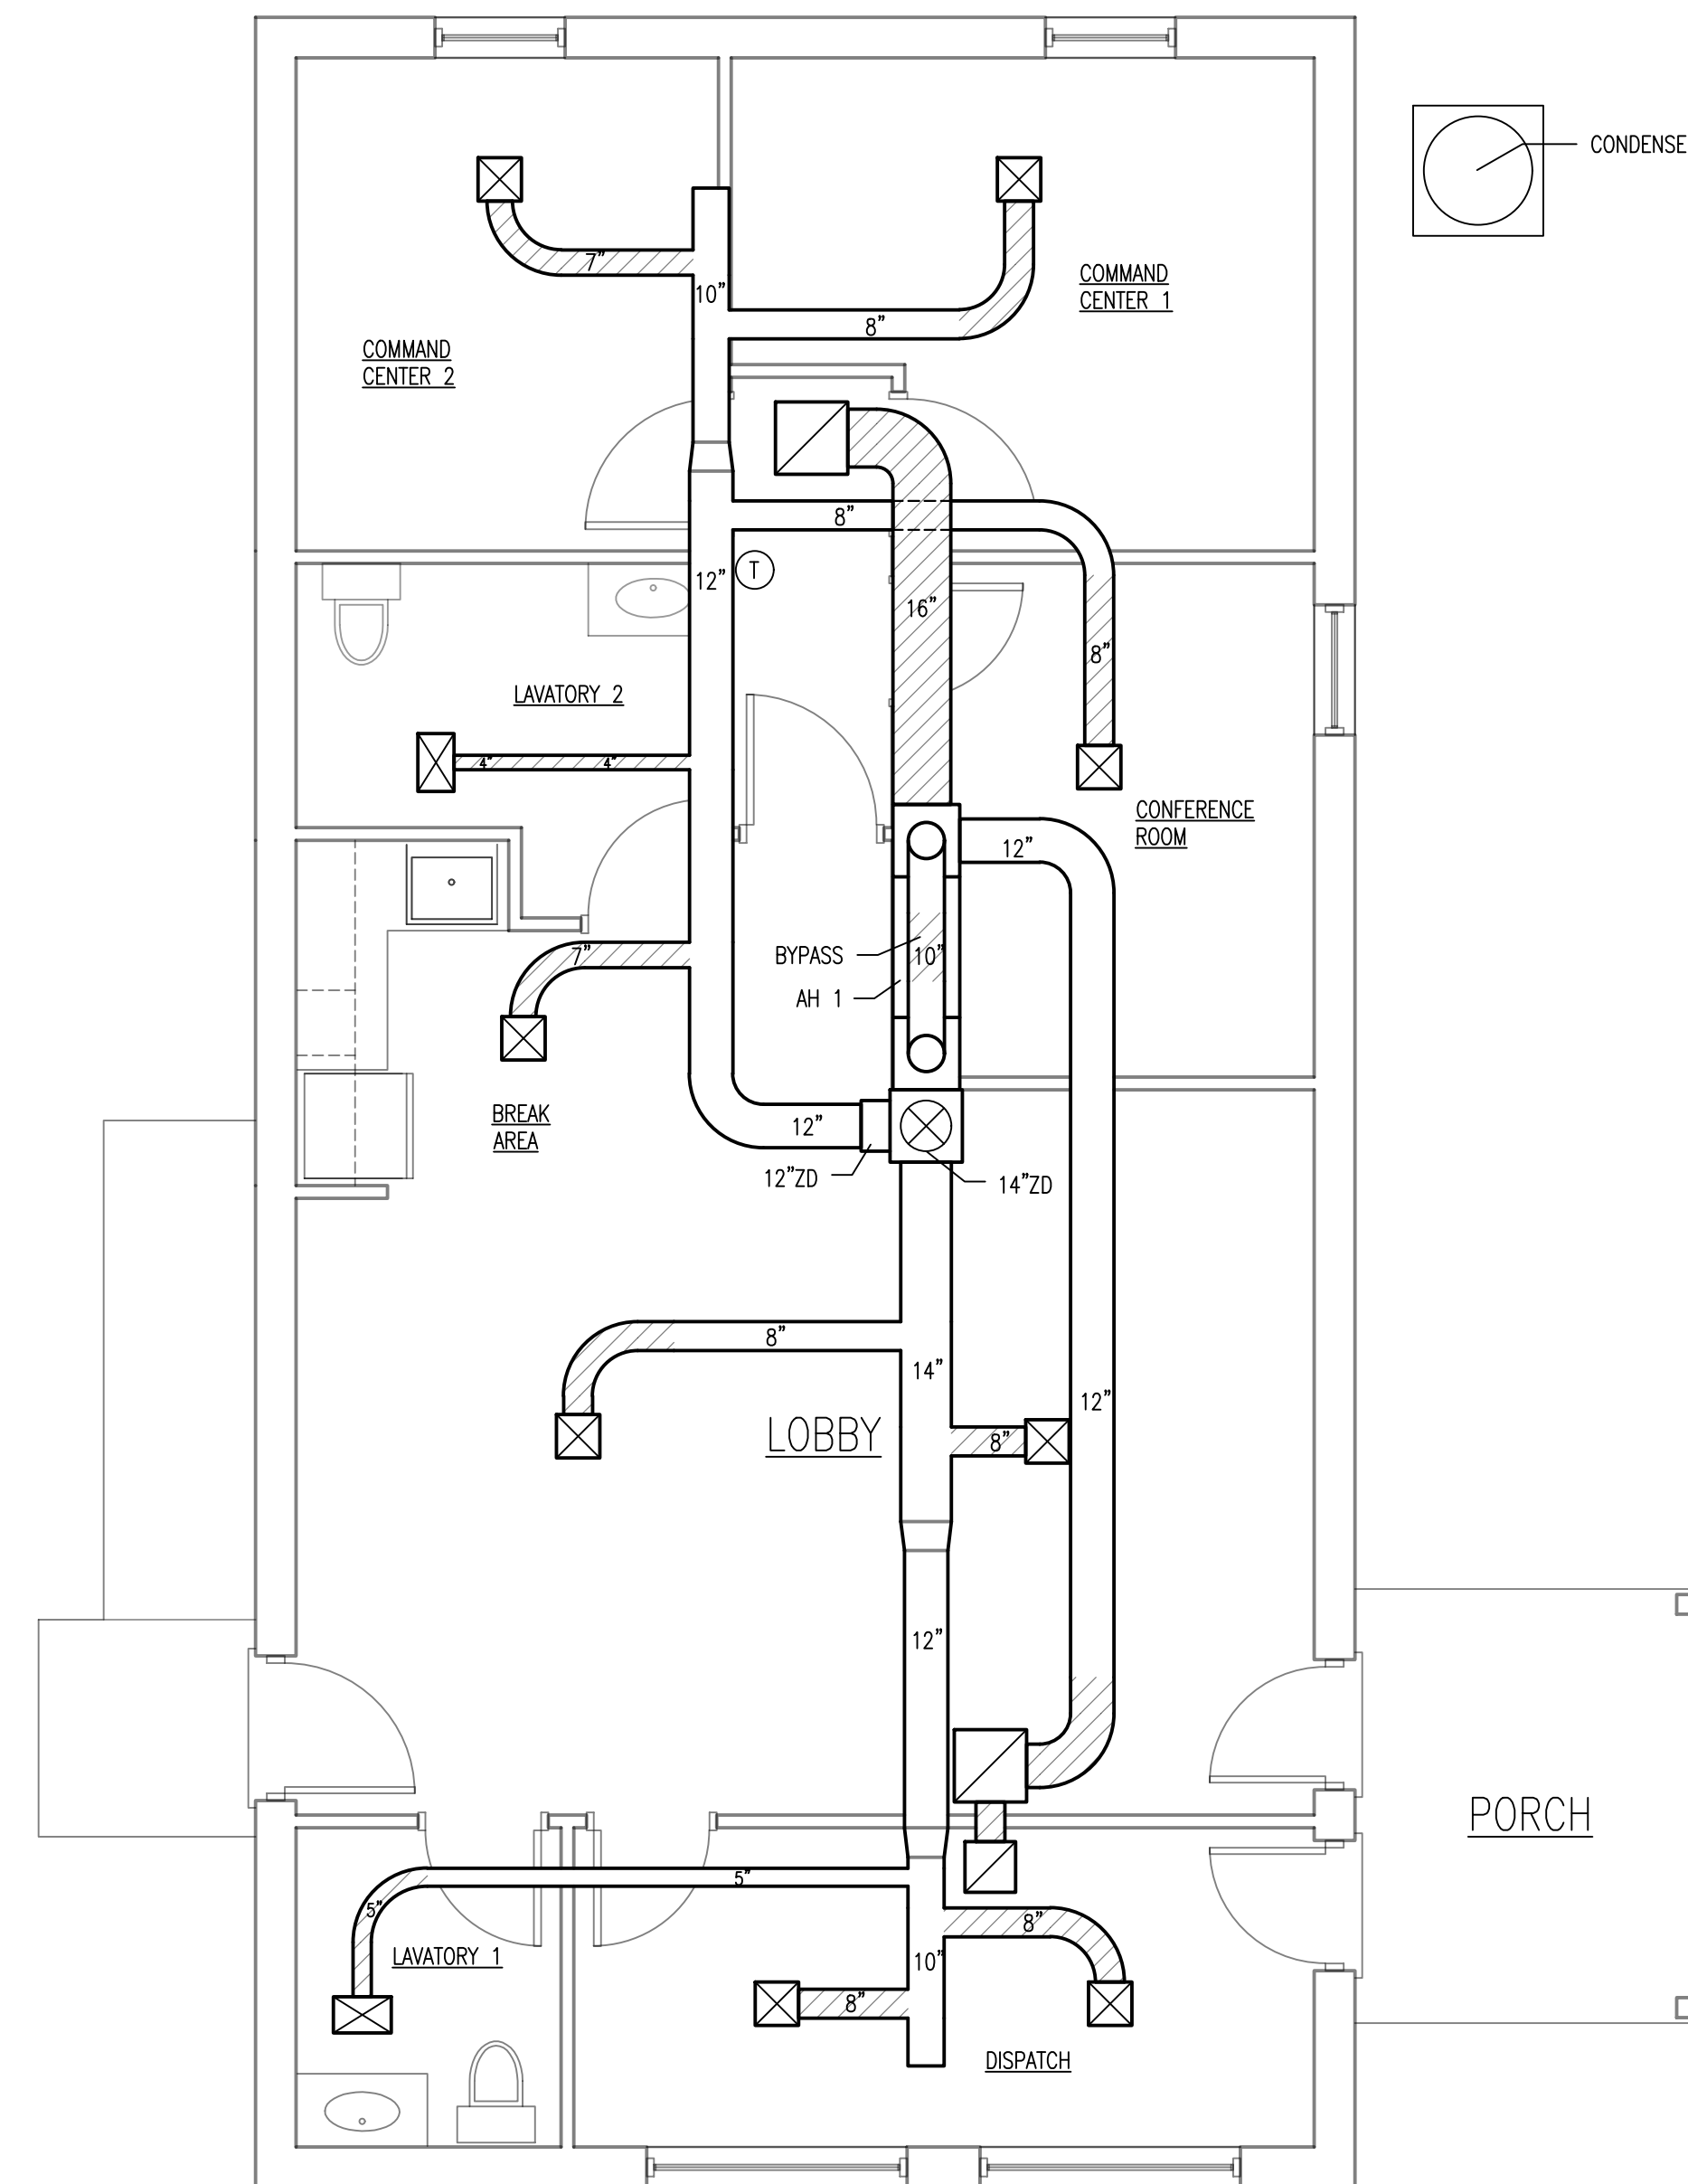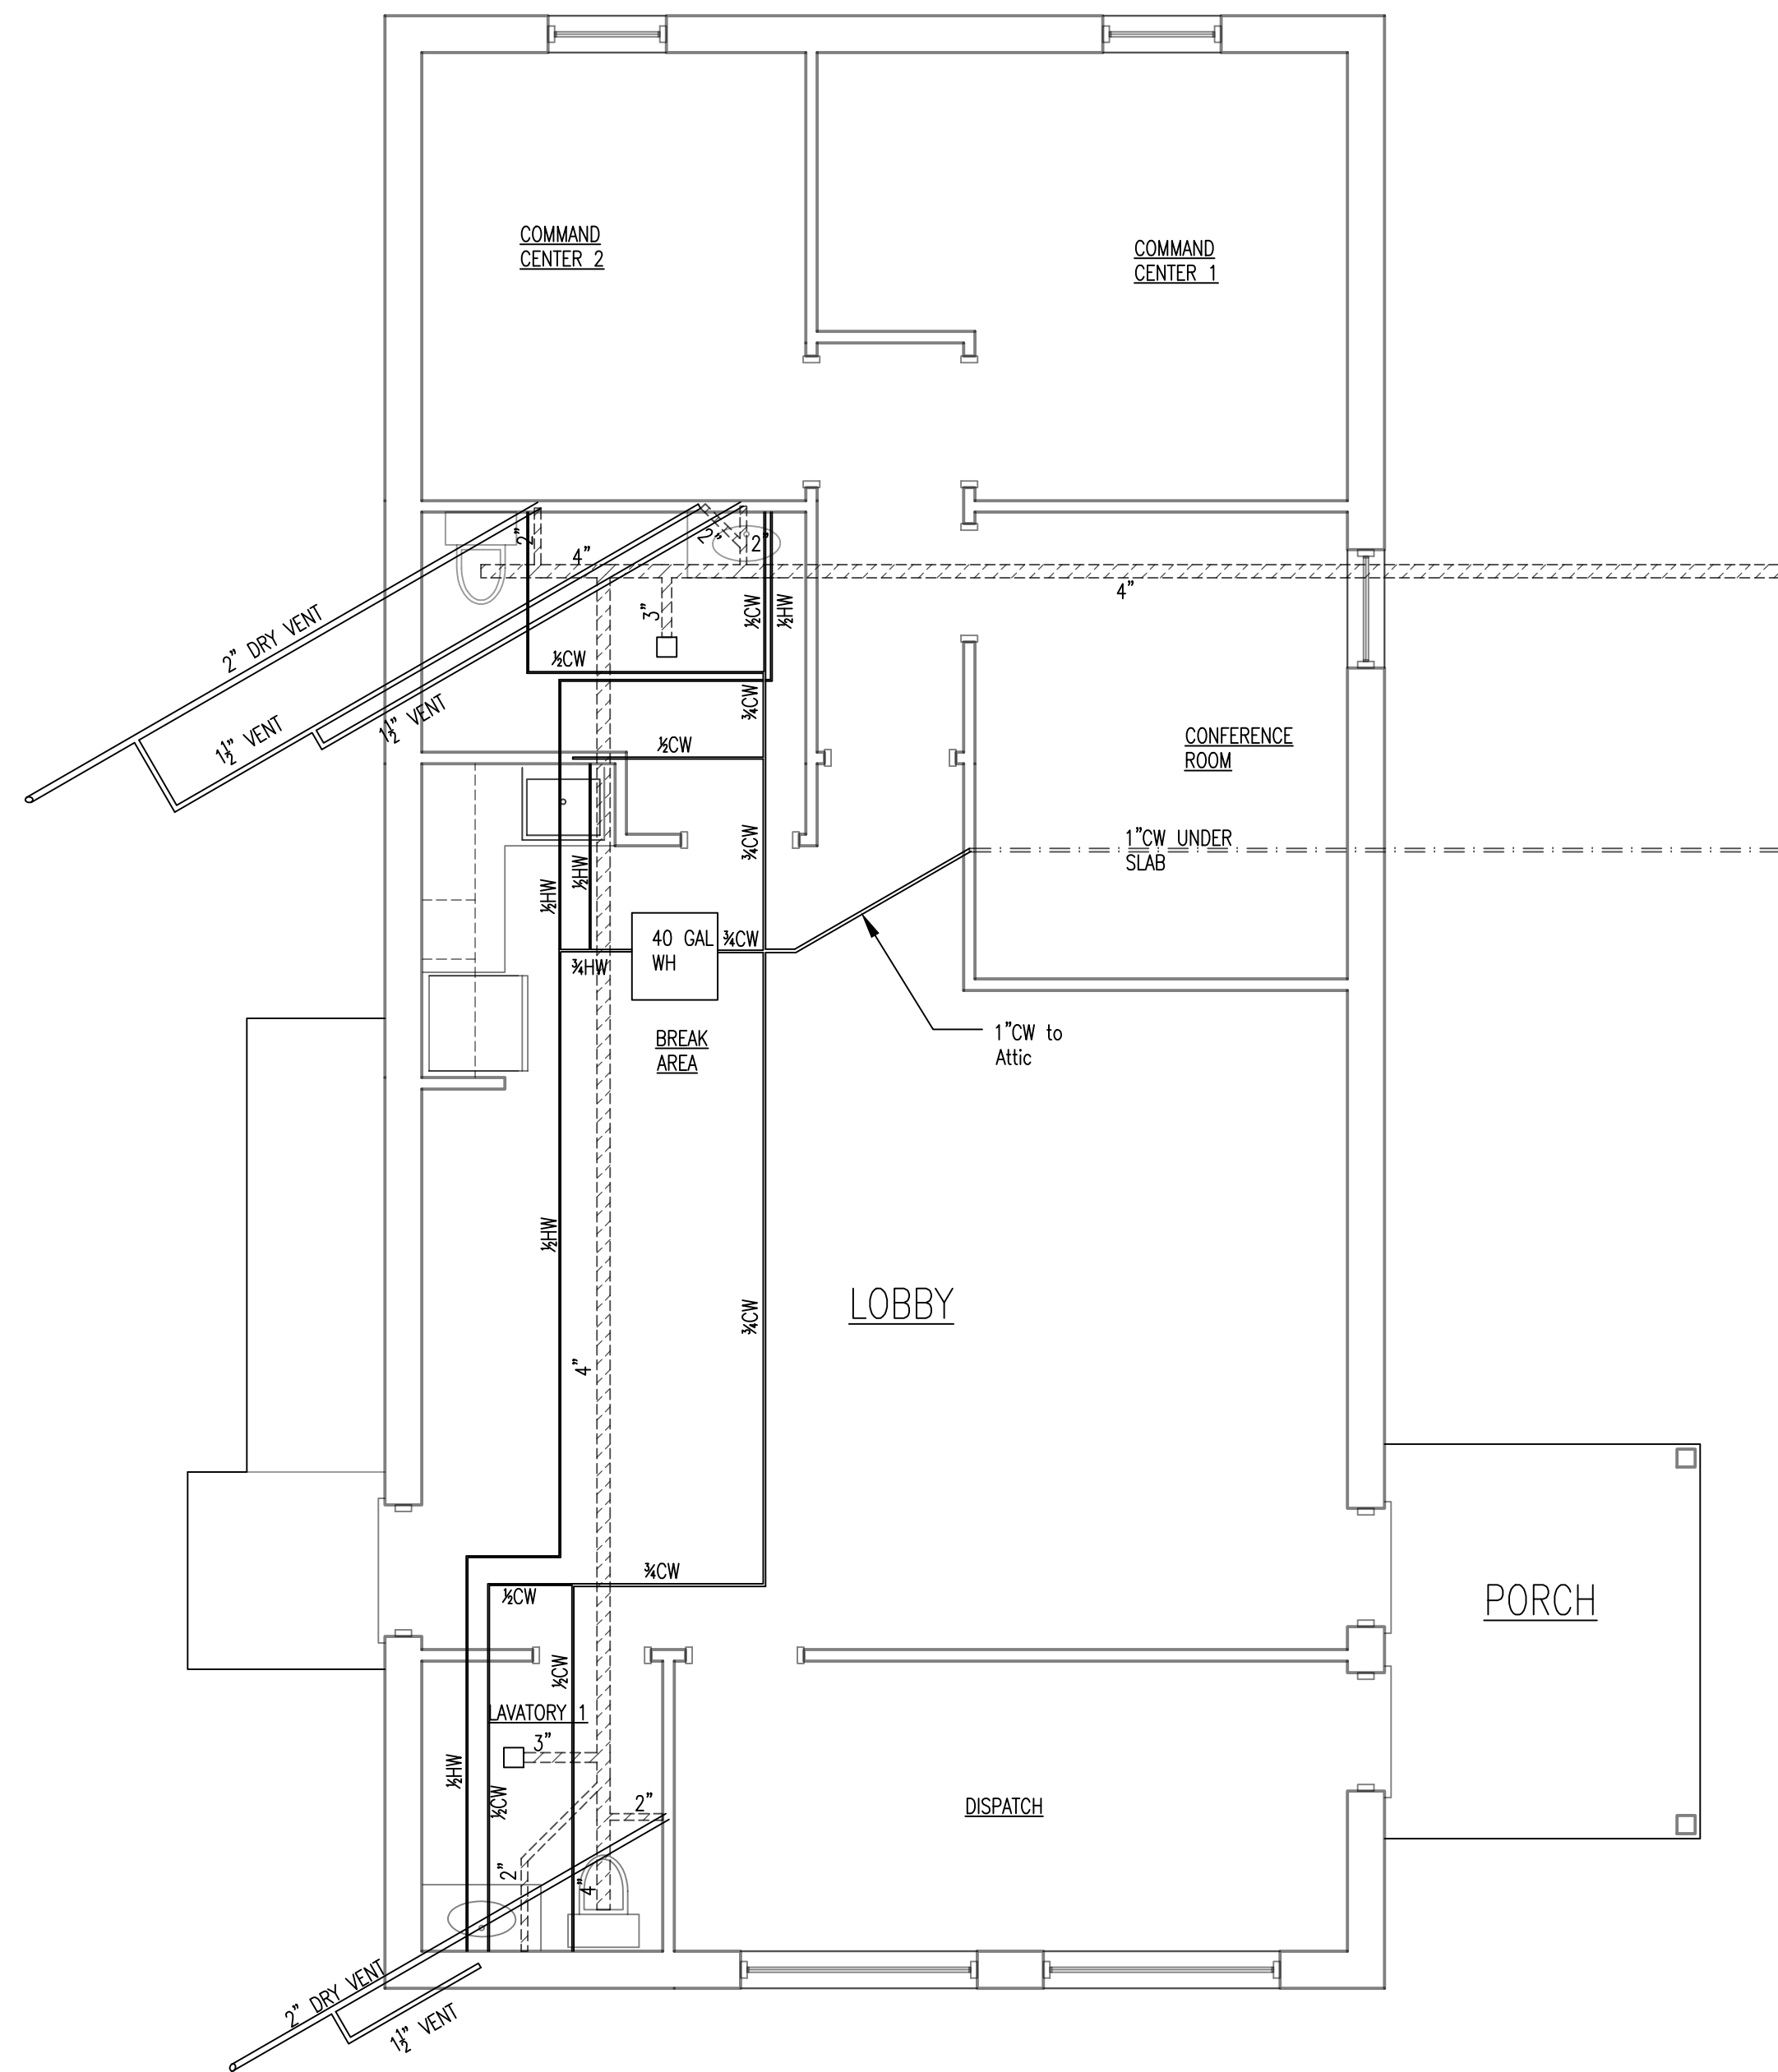

HVAC Legend	
	12x12 4WAY VENT
	10x16 VENT
	20x20 FILTER GRILLE
	14x14 FILTER GRILLE
	FLEX DUCT
	ROUND METAL DUCT
	THERMOSTAT

CONCRETE SUPPLY
NEW DISPATCH OFFICE

DESIGNS BY DANIEL
3700 Trimmatto Pointe Blvd
Myrtle Beach, SC (843) 222-2995

PROJECT REF. Concrete Supply
DRAWING STATUS/ DATE <input checked="" type="checkbox"/> Construction 3/9/18 <input checked="" type="checkbox"/> Revised 4/3/18
DRAWING Plumbing/ Mechanical Plan Scale: 1/4" = 1'-0"
Page # MP1