


1 SITE PLAN

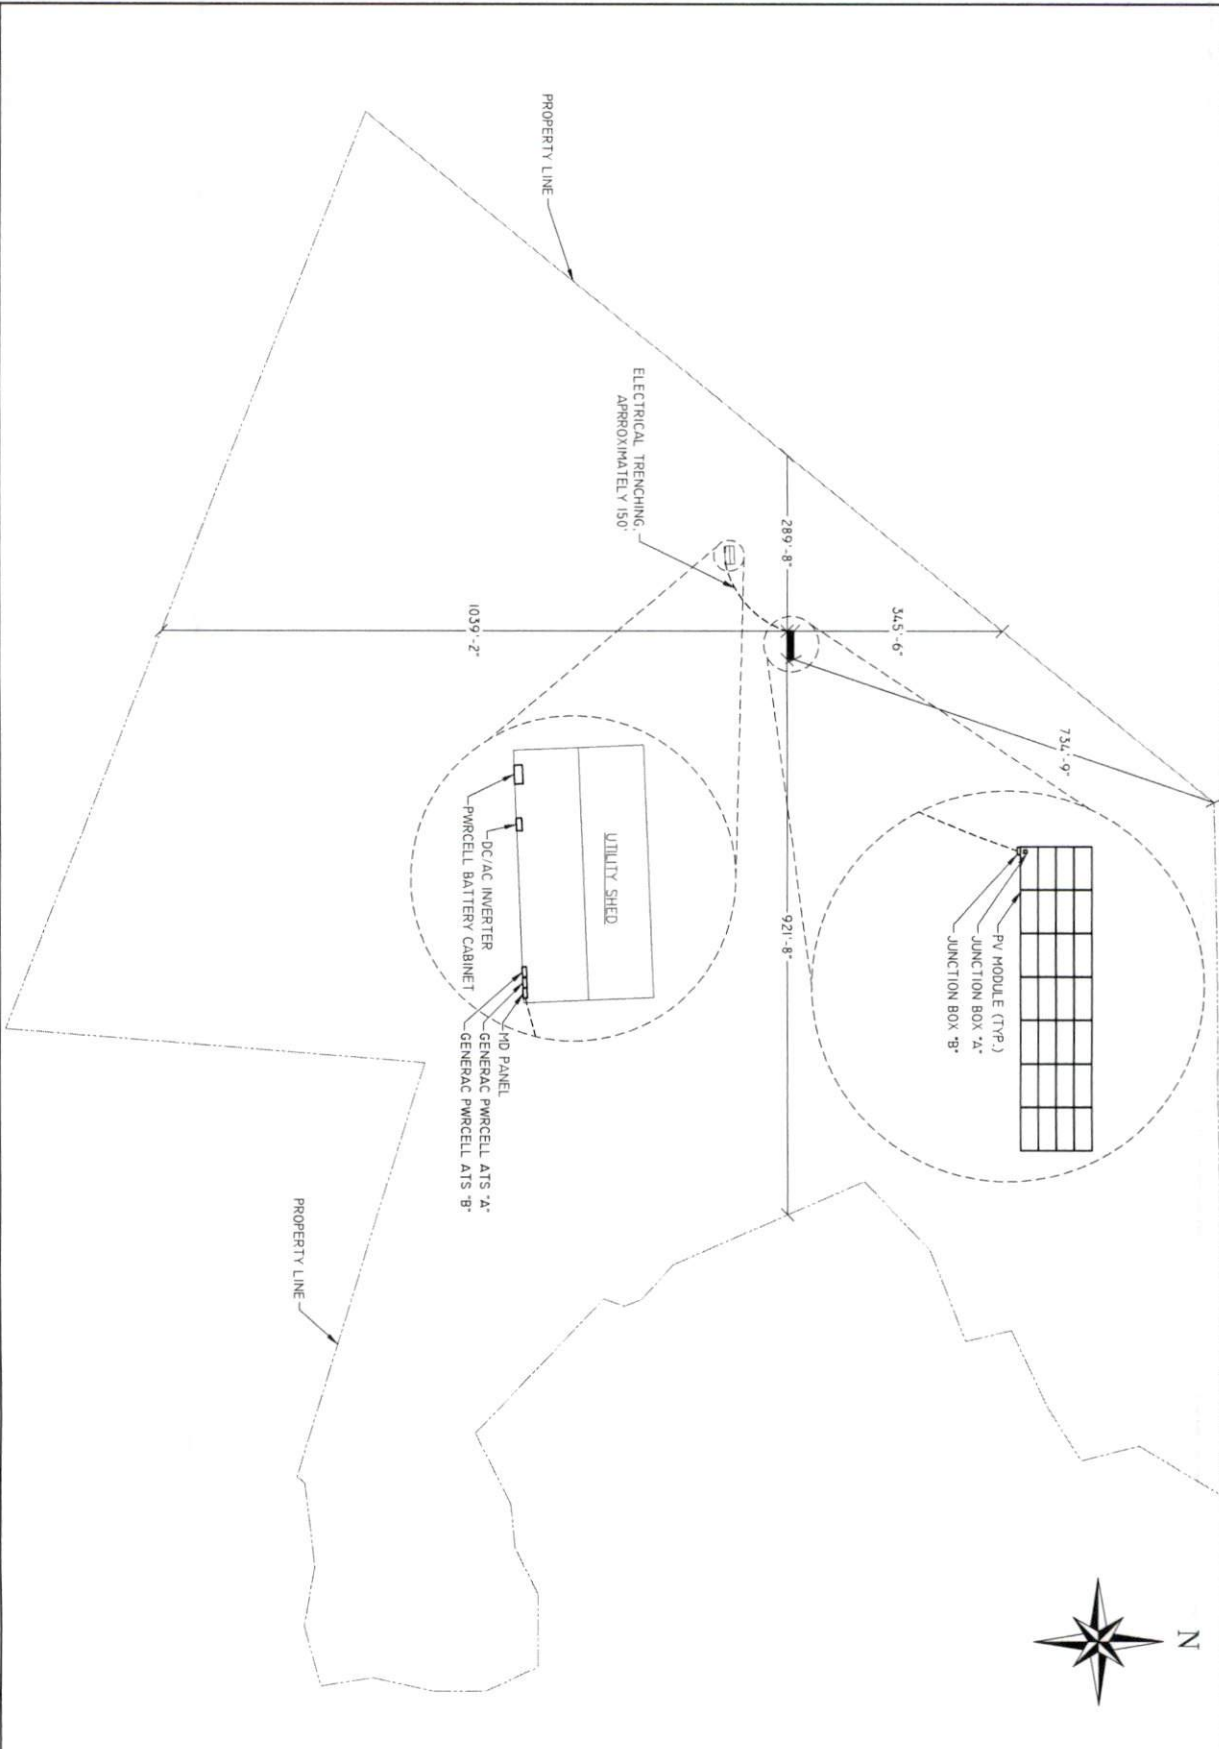

SCALE: 1" = 200'-0"

<p>SITE INFORMATION</p> <p>PV2.1</p>	<p>ISSUED FOR: DATE:</p>	 <p>SOUTHERN ENERGY MANAGEMENT ENERGY EFFICIENCY & SOLAR POWER</p>	<p>CLIENT:</p> <p>NEW SOLAR PV SYSTEM 11.92 kW DC INPUT 7.60 kW AC EXPORT</p> <p>David Krakowski 2248 Buckhorn Rd. Sanford, NC 27730</p>	<p>ENGINEER:</p>  <p>MODEL ENERGY 300 FAYETTEVILLE ST. #1730 RALEIGH, NC 27602 919.274.9905 MODELENERGY.COM P-1194</p>
	<p>CONSTRUCTION: 07/23/21</p>			