



VICINITY MAP



AMERICAN TOWER®

ATC SITE NAME: SPOUT SPRINGS NC
ATC SITE NUMBER: 280251
AT&T MOBILITY SITE ID: SINC001601
AT&T MOBILITY FA LOCATION CODE: 12626511
AT&T MOBILITY SITE NAME: 368-389
AT&T MOBILITY USID: 135237
SITE ADDRESS: 641 NC HWY 24-87
CAMERON, NC 27332-6191



LOCATION MAP


AT&T MOBILITY
ANTENNA AMENDMENT PLAN

AT&T MOBILITY IWM JOB NUMBER(S): **WSVWN0054969**, WSVWN0055285, WSVWN0056420, WSVWN0057530, WSVWN0056136, WSVWN0055668.
AT&T MOBILITY PACE JOB NUMBER(S): **MRVWN045043**, MRVWN044637, MRVWN044754, MRVWN044933, MRVWN044420, MRVWN044489.

COMPLIANCE CODE	PROJECT SUMMARY	PROJECT DESCRIPTION	SHEET INDEX				
ALL WORK SHALL BE PERFORMED AND MATERIALS INSTALLED IN ACCORDANCE WITH THE CURRENT EDITIONS OF THE FOLLOWING CODES AS ADOPTED BY THE LOCAL GOVERNMENT AUTHORITIES. NOTHING IN THESE PLANS IS TO BE CONSTRUED TO PERMIT WORK NOT CONFORMING TO THESE CODES. 1. 2018 NORTH CAROLINA BUILDING CODE (NCBC) 2. 2020 NATIONAL ELECTRIC CODE (NEC) WITH NC AMENDMENTS 3. LOCAL BUILDING CODE 4. CITY/COUNTY ORDINANCES	<div><div><div><div><div><div>SITE ADDRESS:</div><div>641 NC HWY 24-87</div><div>CAMERON, NC 27332-6191</div><div>COUNTY: HARNETT</div></div><div><div>GEOGRAPHIC COORDINATES:</div><div>LATITUDE: 35.26477</div><div>LONGITUDE: -79.04823</div><div>GROUND ELEVATION: 334' AMSL</div></div><div><div>ZONING INFORMATION:</div><div>JURISDICTION: HARNETT COUNTY</div><div>PARCEL ID: 9585-62-8794.000</div></div></div></div></div></div>	THE PROPOSED PROJECT INCLUDES MODIFYING GROUND BASED AND TOWER MOUNTED EQUIPMENT AS INDICATED PER BELOW: TOWER WORK: REMOVE (6) ANTENNA(S) AND (12) RRU(s). INSTALL (15) MOUNT PIPE(S), (18) U-BOLT(S), (6) CROSSOVER PLATE KIT(S), (6) BACK TO BACK RRU BRACKET(S), (9) ANTENNA(S), AND (9) RRU(s). EXISTING (3) RRU(s), (3) SQUID(S), (2) 0.39" FIBER TRUNK(S), (4) 0.78" 8 AWG 6 DC POWER TRUNK(S), (1) 0.92" 6 AWG 6 DC POWER TRUNK(S), (1) 3/8" RET CONTROL CABLE(S), AND (2) 2" CONDUIT(S) TO REMAIN. TOWER WORK: REMOVE (1) ALPHA TE45 INDOOR POWER PLANT(S). INSTALL (1) VERTIV 7100 POWER PLANT(S), (8) VERTIV -58V CONVERTER(S), (10) VERTIV -48V RECTIFIER(S), (1) 6672 BBU(s) (12) VERTIV 50A DC BREAKER(S), AND (3) VERTIV 30A DC BREAKER(S).	SHEET NO:	DESCRIPTION:	REV:	DATE:	BY:
	G-001		TITLE SHEET	1	04/22/25	SSP	
	G-002		GENERAL NOTES	1	04/22/25	SSP	
	G-003 - G-007		APPENDIX B	1	04/22/25	SSP	
C-001	OVERALL SITE PLAN		1	04/22/25	SSP		
C-101	DETAILED SITE PLAN		1	04/22/25	SSP		
C-102	DETAILED EQUIPMENT LAYOUT		1	04/22/25	SSP		
C-201	TOWER ELEVATION		1	04/22/25	SSP		
C-401	ANTENNA INSTALLATION		1	04/22/25	SSP		
C-402	ANTENNA SCHEDULE		1	04/22/25	SSP		
C-501	CONSTRUCTION DETAILS		1	04/22/25	SSP		
E-101	ELECTRICAL DETAILS		1	04/22/25	SSP		
E-101	ELECTRICAL DETAILS	1	04/22/25	SSP			
E-103	GROUNDING PLAN	1	04/22/25	SSP			
E-501	GROUNDING DETAILS	1	04/22/25	SSP			
		R-601 - R-609	SUPPLEMENTAL				



PLANS PREPARED BY:



TEP ENGINEERING, PLLC
326 TRYON ROAD
RALEIGH, NC 27603-3530
OFFICE: (919) 661-6351
www.tepgroup.net
N.C. LICENSE #P-1403

TEP IS A FAMILY OF COMPANIES LICENSED TO PROVIDE DIFFERENT SERVICES IN DIFFERENT JURISDICTIONS. DEPENDING ON THE JURISDICTION, PROFESSIONAL ENGINEERING AND LAND SURVEYING SERVICES ARE PROVIDED BY TEP OPCO LLC, A DELAWARE LIMITED LIABILITY COMPANY, TEP ENGINEERING, LLC, A NORTH CAROLINA PROFESSIONAL LIMITED LIABILITY COMPANY, OR M&H ENGINEERING, LLC, A NEW YORK PROFESSIONAL LIMITED LIABILITY COMPANY. GENERAL CONTRACTOR SERVICES ARE PROVIDED BY TEP OPCO LLC, A DELAWARE LIMITED LIABILITY COMPANY. WE ACQUIRE THE REQUISITE LICENSES IN EACH STATE. ADDITIONAL INFORMATION CAN BE OBTAINED FROM THE COMPANY.

REV.	DESCRIPTION	BY	DATE
A	PRELIMINARY	APM	03/12/25
B	100% CONSTRUCTION	APM	03/20/25
1	100% CONSTRUCTION	SSP	04/22/25

ATC SITE NUMBER: 280251

ATC SITE NAME: SPOUT SPRINGS NC

AT&T MOBILITY SITE NUMBER:

SINC001601

AT&T MOBILITY SITE NAME:


368-389

SITE ADDRESS:


641 NC HWY 24-87
CAMERON, NC 27332-6191

TEP Engineering, PLLC

P-1403



SEAL: 04/22/25



DATE DRAWN:	04/22/25
ATC JOB NO:	14884017
CUSTOMER NAME:	368-389
CUSTOMER ID:	SINC001601

TITLE SHEET

SHEET NUMBER:	REVISION:
G-001	1

Copyright © 2025 ATC IP LLC. All Rights Reserved.

GENERAL CONSTRUCTION NOTES:

1. OWNER FURNISHED MATERIALS, AT&T MOBILITY "THE COMPANY" WILL PROVIDE AND THE CONTRACTOR WILL INSTALL

A. BTS EQUIPMENT FRAME (PLATFORM) AND ICEBRIDGE SHELTER (GROUND BUILD/CO-LOCATE ONLY)

B. AC/TELCO INTERFACE BOX (PPC)

C. ICE BRIDGE (CABLE TRAY WITH COVER) (GROUND BUILD/CO-LOCATE ONLY, GC TO FURNISH AND INSTALL FOR ROOFTOP INSTALLATION)

D. TOWERS, MONOPOLES

E. TOWER LIGHTING

F. GENERATORS & LIQUID PROPANE TANK

G. ANTENNA STANDARD BRACKETS, FRAMES AND PIPES FOR MOUNTING

H. ANTENNAS (INSTALLED BY OTHERS)

I. TRANSMISSION LINE

J. TRANSMISSION LINE JUMPERS

K. TRANSMISSION LINE CONNECTORS WITH WEATHERPROOFING KITS

L. TRANSMISSION LINE GROUND KITS

M. HANGERS

N. HOISTING GRIPS

O. BTS EQUIPMENT
2. THE CONTRACTOR IS RESPONSIBLE TO PROVIDE ALL OTHER MATERIALS FOR THE COMPLETE INSTALLATION OF THE SITE INCLUDING, BUT NOT LIMITED TO, SUCH MATERIALS AS FENCING, STRUCTURAL STEEL SUPPORTING SUB-FRAME FOR PLATFORM, ROOFING LABOR AND MATERIALS, GROUNDING RINGS, GROUNDING WIRES, COPPER-CLAD OR XIT CHEMICAL GROUND ROD(S), BUSS BARS, TRANSFORMERS AND DISCONNECT SWITCHES WHERE APPLICABLE, TEMPORARY ELECTRICAL POWER, CONDUIT, LANDSCAPING COMPOUND STONE, CRANES, CORE DRILLING, SLEEPERS AND RUBBER MATTING, REBAR, CONCRETE CAISSONS, PADS AND/OR AUGER MOUNTS, MISCELLANEOUS FASTENERS, CABLE TRAYS, NON-STANDARD ANTENNA FRAMES AND ALL OTHER MATERIAL AND LABOR REQUIRED TO COMPLETE THE JOB ACCORDING TO THE DRAWINGS AND SPECIFICATIONS. IT IS THE POSITION OF AT&T MOBILITY TO APPLY FOR PERMITTING AND CONTRACTOR RESPONSIBLE FOR PICKUP AND PAYMENT OF REQUIRED PERMITS.
3. ALL WORK SHALL CONFORM TO ALL CURRENT APPLICABLE FEDERAL, STATE, AND LOCAL CODES, INCLUDING ANSI/EIA/TIA-222, AND COMPLY WITH ATC CONSTRUCTION SPECIFICATIONS.
4. CONTRACTOR SHALL CONTACT LOCAL 811 FOR IDENTIFICATION OF UNDERGROUND UTILITIES PRIOR TO START OF CONSTRUCTION.
5. CONTRACTOR SHALL BE RESPONSIBLE FOR COORDINATING ALL REQUIRED INSPECTIONS.
6. ALL DIMENSIONS TO, OF, AND ON EXISTING BUILDINGS, DRAINAGE STRUCTURES, AND SITE IMPROVEMENTS SHALL BE VERIFIED IN FIELD BY CONTRACTOR WITH ALL DISCREPANCIES REPORTED TO THE ENGINEER.
7. DO NOT CHANGE SIZE OR SPACING OF STRUCTURAL ELEMENTS.
8. DETAILS SHOWN ARE TYPICAL; SIMILAR DETAILS APPLY TO SIMILAR CONDITIONS UNLESS OTHERWISE NOTED.
9. THESE DRAWINGS DO NOT INCLUDE NECESSARY COMPONENTS FOR CONSTRUCTION SAFETY WHICH SHALL BE THE SOLE RESPONSIBILITY OF THE CONTRACTOR.
10. CONTRACTOR SHALL BRACE STRUCTURES UNTIL ALL STRUCTURAL ELEMENTS NEEDED FOR STABILITY ARE INSTALLED. THESE ELEMENTS ARE AS FOLLOWS: LATERAL BRACING, ANCHOR BOLTS, ETC.
11. CONTRACTOR SHALL DETERMINE EXACT LOCATION OF EXISTING UTILITIES, GROUNDS DRAINS, DRAIN PIPES, VENTS, ETC. BEFORE COMMENCING WORK.
12. INCORRECTLY FABRICATED, DAMAGED, OR OTHERWISE MISFITTING OR NONCONFORMING MATERIALS OR CONDITIONS SHALL BE REPORTED TO THE AT&T MOBILITY REP PRIOR TO REMEDIAL OR CORRECTIVE ACTION. ANY SUCH REMEDIAL ACTION SHALL REQUIRE WRITTEN APPROVAL BY THE AT&T MOBILITY REP PRIOR TO PROCEEDING.
13. EACH CONTRACTOR SHALL COOPERATE WITH THE AT&T MOBILITY REP, AND COORDINATE HIS WORK WITH THE WORK OF OTHERS.
14. CONTRACTOR SHALL REPAIR ANY DAMAGE CAUSED BY CONSTRUCTION OF THIS PROJECT TO MATCH EXISTING PRE-CONSTRUCTION CONDITIONS TO THE SATISFACTION OF THE AT&T MOBILITY CONSTRUCTION MANAGER.
15. ALL CABLE/CONDUIT ENTRY/EXIT PORTS SHALL BE WEATHERPROOFED DURING INSTALLATION USING A SILICONE SEALANT.
16. WHERE EXISTING CONDITIONS DO NOT MATCH THOSE SHOWN IN THIS PLAN SET, CONTRACTOR SHALL NOTIFY THE AT&T MOBILITY REP AND ENGINEER OF RECORD IMMEDIATELY.
17. CONTRACTOR SHALL ENSURE ALL SUBCONTRACTORS ARE PROVIDED WITH A COMPLETE AND CURRENT SET OF DRAWINGS AND SPECIFICATIONS FOR THIS PROJECT.
18. CONTRACTOR SHALL REMOVE ALL RUBBISH AND DEBRIS FROM THE SITE AT THE END OF EACH DAY.
19. CONTRACTOR SHALL COORDINATE WORK SCHEDULE WITH AMERICAN TOWER CORPORATION (ATC) AND TAKE PRECAUTIONS TO MINIMIZE IMPACT AND DISRUPTION OF OTHER OCCUPANTS OF THE FACILITY.
20. CONTRACTOR SHALL FURNISH AT&T MOBILITY AND AMERICAN TOWER CORPORATION (ATC) WITH A PDF MARKED UP AS-BUILT SET OF DRAWINGS UPON COMPLETION OF WORK.
21. PRIOR TO SUBMISSION OF BID, CONTRACTOR SHALL COORDINATE WITH AT&T MOBILITY REP TO DETERMINE WHAT, IF ANY, ITEMS WILL BE PROVIDED. ALL ITEMS NOT PROVIDED SHALL BE PROVIDED AND INSTALLED BY THE CONTRACTOR. CONTRACTOR WILL INSTALL ALL ITEMS

PROVIDED.

22. PRIOR TO SUBMISSION OF BID, CONTRACTOR SHALL COORDINATE WITH AT&T MOBILITY REP TO DETERMINE IF ANY PERMITS WILL BE OBTAINED BY CONTRACTOR. ALL REQUIRED PERMITS NOT OBTAINED BY AT&T MOBILITY MUST BE OBTAINED, AND PAID FOR, BY THE CONTRACTOR.
23. CONTRACTOR SHALL INSTALL ALL SITE SIGNAGE IN ACCORDANCE WITH AT&T MOBILITY SPECIFICATIONS AND REQUIREMENTS.
24. CONTRACTOR SHALL SUBMIT ALL SHOP DRAWINGS TO AT&T MOBILITY FOR REVIEW AND APPROVAL PRIOR TO FABRICATION.
25. ALL EQUIPMENT SHALL BE INSTALLED ACCORDING TO MANUFACTURER'S SPECIFICATIONS AND LOCATED ACCORDING TO AT&T MOBILITY SPECIFICATIONS, AND AS SHOWN IN THESE PLANS.
26. THE CONTRACTOR SHALL SUPERVISE AND DIRECT THE PROJECT DESCRIBED HEREIN. THE CONTRACTOR SHALL BE SOLELY RESPONSIBLE FOR ALL THE CONSTRUCTION MEANS, METHODS, TECHNIQUES, SEQUENCES AND PROCEDURES AND FOR COORDINATING ALL PORTIONS OF THE WORK UNDER THE CONTRACT.
27. CONTRACTOR SHALL NOTIFY AT&T MOBILITY REP A MINIMUM OF 48 HOURS IN ADVANCE OF POURING CONCRETE OR BACKFILLING ANY UNDERGROUND UTILITIES, FOUNDATIONS OR SEALING ANY WALL, FLOOR OR ROOF PENETRATIONS FOR ENGINEERING REVIEW AND APPROVAL.
28. WHEN THE PROJECT SCOPE REQUIRES THE USE OF THE SAFETY CLIMB, THE GENERAL CONTRACTOR SHALL ENSURE THE SAFETY CLIMB IS FREE OF OBSTRUCTIONS, NOT RUBBING ON OR TRAPPED BY ANY INSTALLED CUSTOMER EQUIPMENT, IS VISUALLY TAUT, MEETS MANUFACTURER INSTALLATION SPECIFICATIONS, AND IS FIRMLY SECURED AT ALL CABLE GUIDE LOCATIONS UPON PROJECT COMPLETION.
29. COMPLETION OF PROJECT SHALL NOT OBSTRUCT, TRAP, LOOSEN, OR OTHERWISE CAUSE FAILURE TO MEET MANUFACTURER INSTALLATION REQUIREMENTS FOR THE SAFETY CLIMB.
30. CONTRACTOR SHALL BE RESPONSIBLE FOR SITE SAFETY INCLUDING COMPLIANCE WITH ALL APPLICABLE OSHA STANDARDS AND RECOMMENDATIONS AND SHALL PROVIDE ALL NECESSARY SAFETY DEVICES INCLUDING PPE AND PPM AND CONSTRUCTION DEVICES SUCH AS WELDING AND FIRE PREVENTION, TEMPORARY SHORING, SCAFFOLDING, TRENCH BOXES/SLOPING, BARRIERS, ETC.
31. THE CONTRACTOR SHALL PROTECT AT HIS OWN EXPENSE, ALL EXISTING FACILITIES AND SUCH OF HIS NEW WORK LIABLE TO INJURY DURING THE CONSTRUCTION PERIOD. ANY DAMAGE CAUSED BY NEGLECT ON THE PART OF THIS CONTRACTOR OR HIS REPRESENTATIVES, OR BY THE ELEMENTS DUE TO NEGLECT ON THE PART OF THIS CONTRACTOR OR HIS REPRESENTATIVES, EITHER TO THE EXISTING WORK, OR TO HIS WORK OR THE WORK OF ANY OTHER CONTRACTOR, SHALL BE REPAIRED AT HIS EXPENSE TO THE OWNER'S SATISFACTION.
32. ALL WORK SHALL BE INSTALLED IN A FIRST CLASS, NEAT AND WORKMANLIKE MANNER BY MECHANICS SKILLED IN THE TRADE INVOLVED. THE QUALITY OF WORKMANSHIP SHALL BE SUBJECT TO THE APPROVAL OF THE AT&T MOBILITY REP. ANY WORK FOUND BY THE AT&T MOBILITY REP TO BE OF INFERIOR QUALITY AND/OR WORKMANSHIP SHALL BE REPLACED AND/OR REWORKED AT CONTRACTOR EXPENSE UNTIL APPROVAL IS OBTAINED.
33. IN ORDER TO ESTABLISH STANDARDS OF QUALITY AND PERFORMANCE, ALL TYPES OF MATERIALS LISTED HEREINAFTER BY MANUFACTURER'S NAMES AND/OR MANUFACTURER'S CATALOG NUMBER SHALL BE PROVIDED BY THESE MANUFACTURERS AS SPECIFIED.
34. AT&T MOBILITY FURNISHED EQUIPMENT SHALL BE PICKED-UP AT THE AT&T MOBILITY WAREHOUSE, NO LATER THAN 48HR AFTER BEING NOTIFIED INSURED, STORED, UNCRATE, PROTECTED AND INSTALLED BY THE CONTRACTOR WITH ALL APPURTENANCES REQUIRED TO PLACE THE EQUIPMENT IN OPERATION, READY FOR USE. THE CONTRACTOR SHALL BE RESPONSIBLE FOR THE EQUIPMENT AFTER PICKING IT UP.
35. AT&T MOBILITY OR HIS ARCHITECT/ENGINEER RESERVES THE RIGHT TO REJECT ANY EQUIPMENT OR MATERIALS WHICH, IN HIS OWN OPINION ARE NOT IN COMPLIANCE WITH THE CONTRACT DOCUMENTS, EITHER BEFORE OR AFTER INSTALLATION AND THE EQUIPMENT SHALL BE REPLACED WITH EQUIPMENT CONFORMING TO THE REQUIREMENTS OF THE CONTRACT DOCUMENTS BY THE CONTRACTOR AT NO COST TO AT&T MOBILITY OR THEIR ARCHITECT/ENGINEER.

SPECIAL CONSTRUCTION

ANTENNA INSTALLATION NOTES:

1. WORK INCLUDED:

A. ANTENNA AND COAXIAL CABLES ARE FURNISHED BY AT&T MOBILITY UNDER A SEPARATE CONTRACT. THE CONTRACTOR SHALL ASSIST ANTENNA INSTALLATION CONTRACTOR IN TERMS OF COORDINATION AND SITE ACCESS. ERECTION SUBCONTRACTOR SHALL BE RESPONSIBLE FOR THE PROTECTION OF PERSONNEL.

B. INSTALL ANTENNAS AS INDICATED ON DRAWINGS AND AT&T MOBILITY SPECIFICATIONS.

C. INSTALL GALVANIZED STEEL ANTENNA MOUNTS AS INDICATED ON DRAWINGS.

D. INSTALL FURNISHED GALVANIZED STEEL OR ALUMINUM WAVEGUIDE.

E. CONTRACTOR SHALL PROVIDE FOUR (4) SETS OF SWEEP TESTS USING ANRITZU-PACKARD 8713B RF SCALAR NETWORK ANALYZER. SUBMIT FREQUENCY DOMAIN REFLECTOMETER(FDR) TESTS RESULTS TO THE PROJECT MANAGER. SWEEP TESTS SHALL BE AS PER ATTACHED RFS "MINIMUM FIELD TESTING RECOMMENDED FOR ANTENNA AND HELIAX COAXIAL CABLE SYSTEMS" DATED 10/5/93. TESTING SHALL BE PERFORMED BY AN INDEPENDENT TESTING SERVICE AND BE BOUND AND SUBMITTED WITHIN ONE WEEK OF WORK COMPLETION.

F. INSTALL COAXIAL CABLES AND TERMINATING BETWEEN ANTENNAS AND EQUIPMENT PER MANUFACTURER'S RECOMMENDATIONS. WEATHERPROOF ALL CONNECTIONS BETWEEN THE

ANTENNA AND EQUIPMENT PER MANUFACTURER'S REQUIREMENTS. TERMINATE ALL COAXIAL CABLE THREE (3) FEET IN EXCESS OF ENTRY PORT LOCATION UNLESS OTHERWISE STATED.

- G. ANTENNA AND COAXIAL CABLE GROUNDING:
2. ALL EXTERIOR #6 GREEN GROUND WIRE "DAISY CHAIN" CONNECTIONS ARE TO BE WEATHER SEALED WITH RFS CONNECTORS/SPLICE WEATHERPROOFING KIT #221213 OR EQUAL.
3. ALL COAXIAL CABLE GROUNDING KITS ARE TO BE INSTALLED ON STRAIGHT RUNS OF COAXIAL CABLE (NOT WITHIN BENDS)

ALL DISCREPANCIES FROM WHAT IS SHOWN ON THESE CONSTRUCTION DRAWINGS SHALL BE COMMUNICATED TO ATC ENGINEERING IMMEDIATELY FOR CORRECTION OR RE-DESIGN. FAILURE TO COMMUNICATE DIRECTLY WITH ATC ENGINEERING OR ANY CHANGES FROM THE DESIGN CONDUCTED WITHOUT PRIOR APPROVAL FROM ATC ENGINEERING SHALL BE THE SOLE RESPONSIBILITY OF THE GENERAL CONTRACTOR.



PLANS PREPARED BY:



TEP ENGINEERING, PLLC
326 TRYON ROAD
RALEIGH, NC 27603-3530
OFFICE: (919) 661-6351
www.tepgroup.net
N.C. LICENSE #P-1403

TEP IS A FAMILY OF COMPANIES LICENSED TO PROVIDE DIFFERENT SERVICES IN DIFFERENT JURISDICTIONS. DEPENDING ON THE JURISDICTION, PROFESSIONAL ENGINEERING AND LAND SURVEYING SERVICES ARE PROVIDED BY TEP OPCO LLC, A DELAWARE LIMITED LIABILITY COMPANY, TEP ENGINEERING, LLC, A NORTH CAROLINA PROFESSIONAL LIMITED LIABILITY COMPANY, OR MMH ENGINEERING, LLC, A NEW YORK PROFESSIONAL LIMITED LIABILITY COMPANY. GENERAL CONTRACTOR SERVICES ARE PROVIDED BY TEP OPCO LLC, A DELAWARE LIMITED LIABILITY COMPANY. WE ACQUIRE THE REQUISITE LICENSES IN EACH STATE. ADDITIONAL INFORMATION CAN BE OBTAINED FROM THE COMPANY.

REV.	DESCRIPTION	BY	DATE
A	PRELIMINARY	APM	03/12/25
B	100% CONSTRUCTION	APM	03/20/25
1	100% CONSTRUCTION	SSP	04/22/25

ATC SITE NUMBER: 280251

ATC SITE NAME: SPOUT SPRINGS NC

AT&T MOBILITY SITE NUMBER:

SINC001601

AT&T MOBILITY SITE NAME:

368-389

SITE ADDRESS:

641 NC HWY 24-87

CAMERON, NC 27332-6191

TEP Engineering, PLLC

P-1403



SEAL:

04/22/25



DATE DRAWN:	04/22/25
ATC JOB NO:	14884017
CUSTOMER NAME:	368-389
CUSTOMER ID:	SINC001601

GENERAL NOTES

SHEET NUMBER:

G-002

REVISION:

1

2018 APPENDIX B
BUILDING CODE SUMMARY FOR ALL COMMERCIAL PROJECTS
(EXCEPT 1 AND 2-FAMILY DWELLINGS AND TOWNHOUSES)
(Reproduce the following data on the building plans sheet 1 or 2)

Name of Project: SPOUT SPRINGS NC
Address: 641 NC HWY 24-87, CAMERON, NC Zip Code 27332-6191
Owner/Authorized Agent: AARON DIAL Phone # (919) 466 - 5383 E-Mail AaronDial@AmericanTower.com
Owned By: City/County Private State
Code Enforcement Jurisdiction: City County HARNETT State

CONTACT:
Table with 6 columns: DESIGNER, FIRM, NAME, LICENSE #, TELEPHONE #, E-MAIL. Rows include Architectural, Civil, Electrical, Fire Alarm, Plumbing, Mechanical, Sprinkler-Standpipe, Structural, Retaining Walls >5' High, and Other.

2018 NC BUILDING CODE: New Building Addition Renovation
1st Time Interior Completion
Shell/Core - Contact the local inspection jurisdiction for possible additional procedures and requirements
Phased Construction - Shell/Core- Contact the local inspection jurisdiction for possible additional procedures and requirements

2018 NC EXISTING BUILDING CODE: EXISTING: Prescriptive Repair Chapter 14
Alteration: Level I Level II Level III
Historic Property Change of Use
CONSTRUCTED: (date) CURRENT OCCUPANCY(S) (Ch. 3):
RENOVATED: (date) PROPOSED OCCUPANCY(S) (Ch. 3):

OCCUPANCY CATEGORY (Table 1604.5): Current: I II III IV
Proposed: I II III IV

BASIC BUILDING DATA
Construction Type: I-A II-A III-A IV V-A
I-B II-B III-B V-B
Sprinklers: No Partial Yes NFPA 13 NFPA 13R NFPA 13D
Standpipes: No Yes Class I II III Wet Dry
Fire District: No Yes Flood Hazard Area: No Yes
Special Inspections Required: No Yes (Contact the local inspection jurisdiction for additional procedures and requirements.)

Gross Building Area Table
Table with 4 columns: FLOOR, EXISTING (SQ FT), NEW (SQ FT), SUB-TOTAL. Rows include 3rd Floor, 2nd Floor, Mezzanine, 1st Floor, Basement, and TOTAL.

ALLOWABLE AREA
Primary Occupancy Classification(s): Select one Select one Select one Select one Select one Select one
Assembly A-1 A-2 A-3 A-4 A-5
Business
Educational
Factory F-1 Moderate F-2 Low
Hazardous H-1 Detonate H-2 Deflagrate H-3 Combust H-4 Health H-5 HPM
Institutional I-1 Condition 1 2
I-2 Condition 1 2
I-3 Condition 1 2 3 4 5
I-4
Mercantile
Residential R-1 R-2 R-3 R-4
Storage S-1 Moderate S-2 Low High-piled
Parking Garage Open Enclosed Repair Garage
Utility and Miscellaneous

Accessory Occupancy Classification(s): N/A
Incidental Uses (Table 509): N/A
Special Uses (Chapter 4 – List Code Sections): N/A
Special Provisions: (Chapter 5 – List Code Sections): N/A
Mixed Occupancy: No Yes Separation: Hr. Exception:
Non-Separated Use (508.3) - The required type of construction for the building shall be determined by applying the height and area limitations for each of the applicable occupancies to the entire building. The most restrictive type of construction, so determined, shall apply to the entire building.
Separated Use (508.4) - See below for area calculation. If the area of the occupancy shall be such that the sum of the actual floor area of each use divided by the allowable floor area shall not exceed 1.
Actual Area of Occupancy A + Allowable Area of Occupancy B ≤ 1
+ + = ≤ 1.00

AMERICAN TOWER
PLANS PREPARED BY:
TEP
TEP ENGINEERING, PLLC
326 TRYON ROAD
RALEIGH, NC 27603-3530
OFFICE: (919) 661-6351
www.tepgroup.net
N.C. LICENSE #P-1403
TEP IS A FAMILY OF COMPANIES LICENSED TO PROVIDE DIFFERENT SERVICES IN DIFFERENT JURISDICTIONS.
REV. DESCRIPTION BY DATE
PRELIMINARY APM 03/12/25
100% CONSTRUCTION APM 03/20/25
100% CONSTRUCTION SSP 04/22/25
ATC SITE NUMBER: 280251
ATC SITE NAME: SPOUT SPRINGS NC
AT&T MOBILITY SITE NUMBER:
SINC001601
AT&T MOBILITY SITE NAME:
368-389
SITE ADDRESS:
641 NC HWY 24-87
CAMERON, NC 27332-6191
NORTH CAROLINA PROFESSIONAL SEAL
048226
SCOTT C. BRANTLEY
SEAL: 04/22/25
AT&T
DATE DRAWN: 04/22/25
ATC JOB NO: 14884017
CUSTOMER NAME: 368-389
CUSTOMER ID: SINC001601
APPENDIX B
SHEET NUMBER: G-003
REVISION: 1

STORY NO.	DESCRIPTION AND USE	(A) BLDG AREA PER STORY (ACTUAL)	(B) TABLE 507.2.1 AREA FOR FRONTAGE INCREASE ^{1,5}	(C) AREA FOR FRONTAGE INCREASE ^{1,5}	(D) ALLOWABLE AREA PER STORY OR UNLIMITED ^{2,3}

- ¹ Frontage area increases from Section 507.2.1 as:
- a. Perimeter which fronts a public way having 20 feet minimum width = _____ (F)
 - b. Total Building Perimeter = _____ (P)
 - c. Ratio (F/P) = _____ (F/P)
 - d. W = Minimum width of public way = _____ (W)
 - e. Percent of frontage increase $I_f = 100[F/P - 0.25] \times W/30 =$ _____ (%)

² Unlimited area applicable under conditions of Section 507.

³ Maximum Building Area = total number of stories in the building x D (maximum3 stories) (506.2).

⁴ The maximum area of open parking garages must comply with Table 406.5.4. The maximum area of air traffic control towers must comply with Table 412.3.1.

⁵ Frontage increase is based on the unsprinklered area value in Table 507.2.1.

ALLOWED BUILDING AREA		SHOWN ON PLANS	CODE REFERENCE
Building Height in Feet (Table 504.3)			
Building Height in Stories (Table 504.4)			

¹ Provide code reference if the “Shown on Plans” quantity is not shown on Table 504.3 or 504.4.

FIRE PROTECTION REQUIREMENTS

BUILDING ELEMENT	FIRE SEPARATION DISTANCE (FEET)	RATING		DETAIL # AND DETAIL #	DESIGN # FOR RATED ASSEMBLY	SHEET # FOR RATED PENETRATION	SHEET # FOR RATED JOINTS
		REQ'D	PROVIDED (W/ REF.)				
Structural Frame, including columns, girders, trusses							
Bearing Walls							
Exterior							
North							
East							
West							
South							
Interior							
Nonbearing Walls and Partitions							
Exterior walls							
North							
East							
West							
South							
Interior walls and partitions							
Floor Construction							
Including supporting beams and joists							
Floor Ceiling Assembly							
Columns Supporting Floors							
Roof Construction, including supporting beams and joists							
Roof Ceiling Assembly							
Columns Supporting Roof							
Shaft Enclosures - Exit							
Shaft Enclosures - Other							
Corridor Separation							
Occupancy/Fire Barrier Separation							
Party/Fire Wall Separation							
Smoke Barrier Separation							
Smoke Partition							
Tenant/Dwelling Unit/ Sleeping Unit Separation							
Incidental Use Separation							

* Indicate section number permitting reduction



PLANS PREPARED BY:



TEP ENGINEERING, PLLC
326 TRYON ROAD
RALEIGH, NC 27603-3530
OFFICE: (919) 661-6351
www.tepgroup.net
N.C. LICENSE #P-1403

TEP IS A FAMILY OF COMPANIES LICENSED TO PROVIDE DIFFERENT SERVICES IN DIFFERENT JURISDICTIONS. DEPENDING ON THE JURISDICTION, PROFESSIONAL ENGINEERING AND LAND SURVEYING SERVICES ARE PROVIDED BY TEP OPCO LLC, A DELAWARE LIMITED LIABILITY COMPANY, TEP ENGINEERING, LLC, A NORTH CAROLINA PROFESSIONAL LIMITED LIABILITY COMPANY, OR M&H ENGINEERING, LLC, A NEW YORK PROFESSIONAL LIMITED LIABILITY COMPANY. GENERAL CONTRACTOR SERVICES ARE PROVIDED BY TEP OPCO LLC, A DELAWARE LIMITED LIABILITY COMPANY. WE ACQUIRE THE REQUISITE LICENSES IN EACH STATE. ADDITIONAL INFORMATION CAN BE OBTAINED FROM THE COMPANY.

REV.	DESCRIPTION	BY	DATE
A	PRELIMINARY	APM	03/12/25
B	100% CONSTRUCTION	APM	03/20/25
C	100% CONSTRUCTION	SSP	04/22/25

ATC SITE NUMBER: 280251

ATC SITE NAME: SPOUT SPRINGS NC

AT&T MOBILITY SITE NUMBER:

SINC001601

AT&T MOBILITY SITE NAME:

368-389

SITE ADDRESS:

641 NC HWY 24-87
CAMERON, NC 27332-6191

TEP Engineering, PLLC P-1403



SEAL: 04/22/25



DATE DRAWN:	04/22/25
ATC JOB NO:	14884017
CUSTOMER NAME:	368-389
CUSTOMER ID:	SINC001601

APPENDIX B

SHEET NUMBER:	REVISION:
G-004	1

2018 APPENDIX B
BUILDING CODE SUMMARY FOR ALL COMMERCIAL PROJECTS
MECHANICAL DESIGN
(PROVIDE ON THE MECHANICAL SHEETS IF APPLICABLE)

MECHANICAL SUMMARY

MECHANICAL SYSTEMS, SERVICE SYSTEMS AND EQUIPMENT

Thermal Zone

winter dry bulb: _____
summer dry bulb: _____

Interior design conditions

winter dry bulb: _____
summer dry bulb: _____
relative humidity: _____

Building heating load:

Building cooling load:

Mechanical Spacing Conditioning System

Unitary

description of unit: _____
heating efficiency: _____
cooling efficiency: _____
size category of unit: _____

Boiler

Size category. If oversized, state reason.: _____

Chiller

Size category. If oversized, state reason.: _____

List equipment efficiencies:

2018 APPENDIX B
BUILDING CODE SUMMARY FOR ALL COMMERCIAL PROJECTS
ELECTRICAL DESIGN
(PROVIDE ON THE ELECTRICAL SHEETS IF APPLICABLE)

ELECTRICAL SUMMARY

ELECTRICAL SYSTEM AND EQUIPMENT


Method of Compliance: Energy Code ☐ Performance ☐ Prescriptive
ASHRAE 90.1 ☐ Performance ☐ Prescriptive

Lighting schedule (each fixture type)

lamp type required in fixture _____
number of lamps in fixture _____
ballast type used in the fixture _____
number of ballasts in fixture _____
total wattage per fixture _____
total interior wattage _____ allowed (whole building or space by space)
total exterior wattage _____ allowed


Additional Efficiency Package Options
(When using the 2018 NCECC; not required for ASHRAE 90.1)

- ☐ C406.2 More Efficient HVAC Equipment Performance
☐ C406.3 Reduced Lighting Power Density
☐ C406.4 Enhanced Digital Lighting Controls
☐ C406.5 On-Site Renewable Energy
☐ C406.6 Dedicated Outdoor Air System
☐ C406.7 Reduced Energy Use in Service Water Heating



AMERICAN TOWER®

PLANS PREPARED BY:



TEP ENGINEERING, PLLC
326 TRYON ROAD
RALEIGH, NC 27603-3530
OFFICE: (919) 661-6351
www.tepgroup.net
N.C. LICENSE #P-1403

TEP IS A FAMILY OF COMPANIES LICENSED TO PROVIDE DIFFERENT SERVICES IN DIFFERENT JURISDICTIONS. DEPENDING ON THE JURISDICTION, PROFESSIONAL ENGINEERING AND LAND SURVEYING SERVICES ARE PROVIDED BY TEP OP CO LLC, A DELAWARE LIMITED LIABILITY COMPANY, TEP ENGINEERING, LLC, A NORTH CAROLINA PROFESSIONAL LIMITED LIABILITY COMPANY, OR M&H ENGINEERING, LLC, A NEW YORK PROFESSIONAL LIMITED LIABILITY COMPANY. GENERAL CONTRACTOR SERVICES ARE PROVIDED BY TEP OP CO LLC, A DELAWARE LIMITED LIABILITY COMPANY. WE ACQUIRE THE REQUISITE LICENSES IN EACH STATE. ADDITIONAL INFORMATION CAN BE OBTAINED FROM THE COMPANY.

REV.	DESCRIPTION	BY	DATE
A	PRELIMINARY	APM	03/12/25
B	100% CONSTRUCTION	APM	03/20/25
1	100% CONSTRUCTION	SSP	04/22/25

ATC SITE NUMBER: 280251

ATC SITE NAME: SPOUT SPRINGS NC

AT&T MOBILITY SITE NUMBER:

SINC001601

AT&T MOBILITY SITE NAME:


368-389

SITE ADDRESS:


641 NC HWY 24-87
CAMERON, NC 27332-6191

TEP Engineering, PLLC

P-1403



SEAL: 04/22/25



DATE DRAWN:	04/22/25
ATC JOB NO:	14884017
CUSTOMER NAME:	368-389
CUSTOMER ID:	SINC001601

APPENDIX B

SHEET NUMBER:	REVISION:
G-007	1

NOTES:

- BOUNDARY LINES OBTAINED FROM HARNETT COUNTY ONLINE GIS.
- ZONING INFORMATION OBTAINED FROM HARNETT COUNTY.
- THE TOWER IS LOCATED IN ZONE "X," AREAS DETERMINED TO BE OUTSIDE THE 0.2% ANNUAL CHANCE FLOODPLAIN ACCORDING TO FEMA COMMUNITY PANEL #3710958400J, DATED OCTOBER 03, 2006.



PLANS PREPARED BY:



TEP ENGINEERING, PLLC
326 TRYON ROAD
RALEIGH, NC 27603-3530
OFFICE: (919) 661-6351
www.tepgroup.net
N.C. LICENSE #P-1403

TEP IS A FAMILY OF COMPANIES LICENSED TO PROVIDE DIFFERENT SERVICES IN DIFFERENT JURISDICTIONS. DEPENDING ON THE JURISDICTION, PROFESSIONAL ENGINEERING AND LAND SURVEYING SERVICES ARE PROVIDED BY TEP OPCO LLC, A DELAWARE LIMITED LIABILITY COMPANY, TEP ENGINEERING, LLC, A NORTH CAROLINA PROFESSIONAL LIMITED LIABILITY COMPANY, OR M&H ENGINEERING, LLC, A NEW YORK PROFESSIONAL LIMITED LIABILITY COMPANY. GENERAL CONTRACTOR SERVICES ARE PROVIDED BY TEP OPCO LLC, A DELAWARE LIMITED LIABILITY COMPANY. WE ACQUIRE THE REQUISITE LICENSES IN EACH STATE. ADDITIONAL INFORMATION CAN BE OBTAINED FROM THE COMPANY.

REV.	DESCRIPTION	BY	DATE
A	PRELIMINARY	APM	03/12/25
0	100% CONSTRUCTION	APM	03/20/25
1	100% CONSTRUCTION	SSP	04/22/25

ATC SITE NUMBER: 280251
ATC SITE NAME: SPOUT SPRINGS NC
AT&T MOBILITY SITE NUMBER:
SINC001601
AT&T MOBILITY SITE NAME:
368-389
SITE ADDRESS:
641 NC HWY 24-87
CAMERON, NC 27332-6191

TEP Engineering, PLLC P-1403



SEAL: 04/22/25



DATE DRAWN:	04/22/25
ATC JOB NO:	14884017
CUSTOMER NAME:	368-389
CUSTOMER ID:	SINC001601


OVERALL SITE PLAN

SHEET NUMBER:
C-001


REVISION:
1

1. THIS SITE PLAN REPRESENTS THE BEST PRESENT KNOWLEDGE AVAILABLE TO THE ENGINEER AT THE TIME OF THIS DESIGN. THE CONTRACTOR SHALL VISIT THE SITE PRIOR TO CONSTRUCTION AND VERIFY ALL EXISTING CONDITIONS RELATED TO THE SCOPE OF WORK FOR THIS PROJECT.
2. ICE BRIDGE, CABLE LADDER, COAX PORT, AND COAX CABLE ARE SHOWN FOR REFERENCE ONLY. CONTRACTOR SHALL CONFIRM THE EXACT LOCATION OF ALL PROPOSED AND EXISTING EQUIPMENT AND STRUCTURES DEPICTED ON THIS PLAN. BEFORE UTILIZING EXISTING CABLE SUPPORTS, COAX PORTS, INSTALLING NEW PORTS OR ANY OTHER EQUIPMENT, CONTRACTOR SHALL VERIFY ALL ASPECTS OF THE COMPONENTS MEET THE ATC SPECIFICATIONS.
3. IT IS THE RESPONSIBILITY OF THE CONTRACTOR TO COORDINATE WITH THE T-MOBILE REPRESENTATIVE AND LOCAL UTILITY COMPANY FOR THE INSTALLATION OF CONDUITS, CONDUCTORS, BREAKERS, DISCONNECTS, OR ANY OTHER EQUIPMENT REQUIRED FOR ELECTRICAL SERVICE. ALL ELECTRICAL WORK SHALL BE PERFORMED IN ACCORDANCE WITH LATEST EDITION OF THE STATE AND NATIONAL CODES, ORDINANCES AND REGULATIONS APPLICABLE TO THIS PROJECT.

	<u>LEGEND</u>
⊗	GROUNDING TEST WELL
ATS	AUTOMATIC TRANSFER SWITCH
B	BOLLARD
CSC	CELL SITE CABINET
D	DISCONNECT
E	ELECTRICAL
F	FIBER
GEN	GENERATOR
G	GENERATOR RECEPTACLE
HH, V	HAND HOLE, VAULT
IB	ICE BRIDGE
K	KENTROX BOX
LC	LIGHTING CONTROL
M	METER
PB	PULL BOX
PP	POWER POLE
T	TELCO
TRN	TRANSFORMER
×	CHAINLINK FENCE


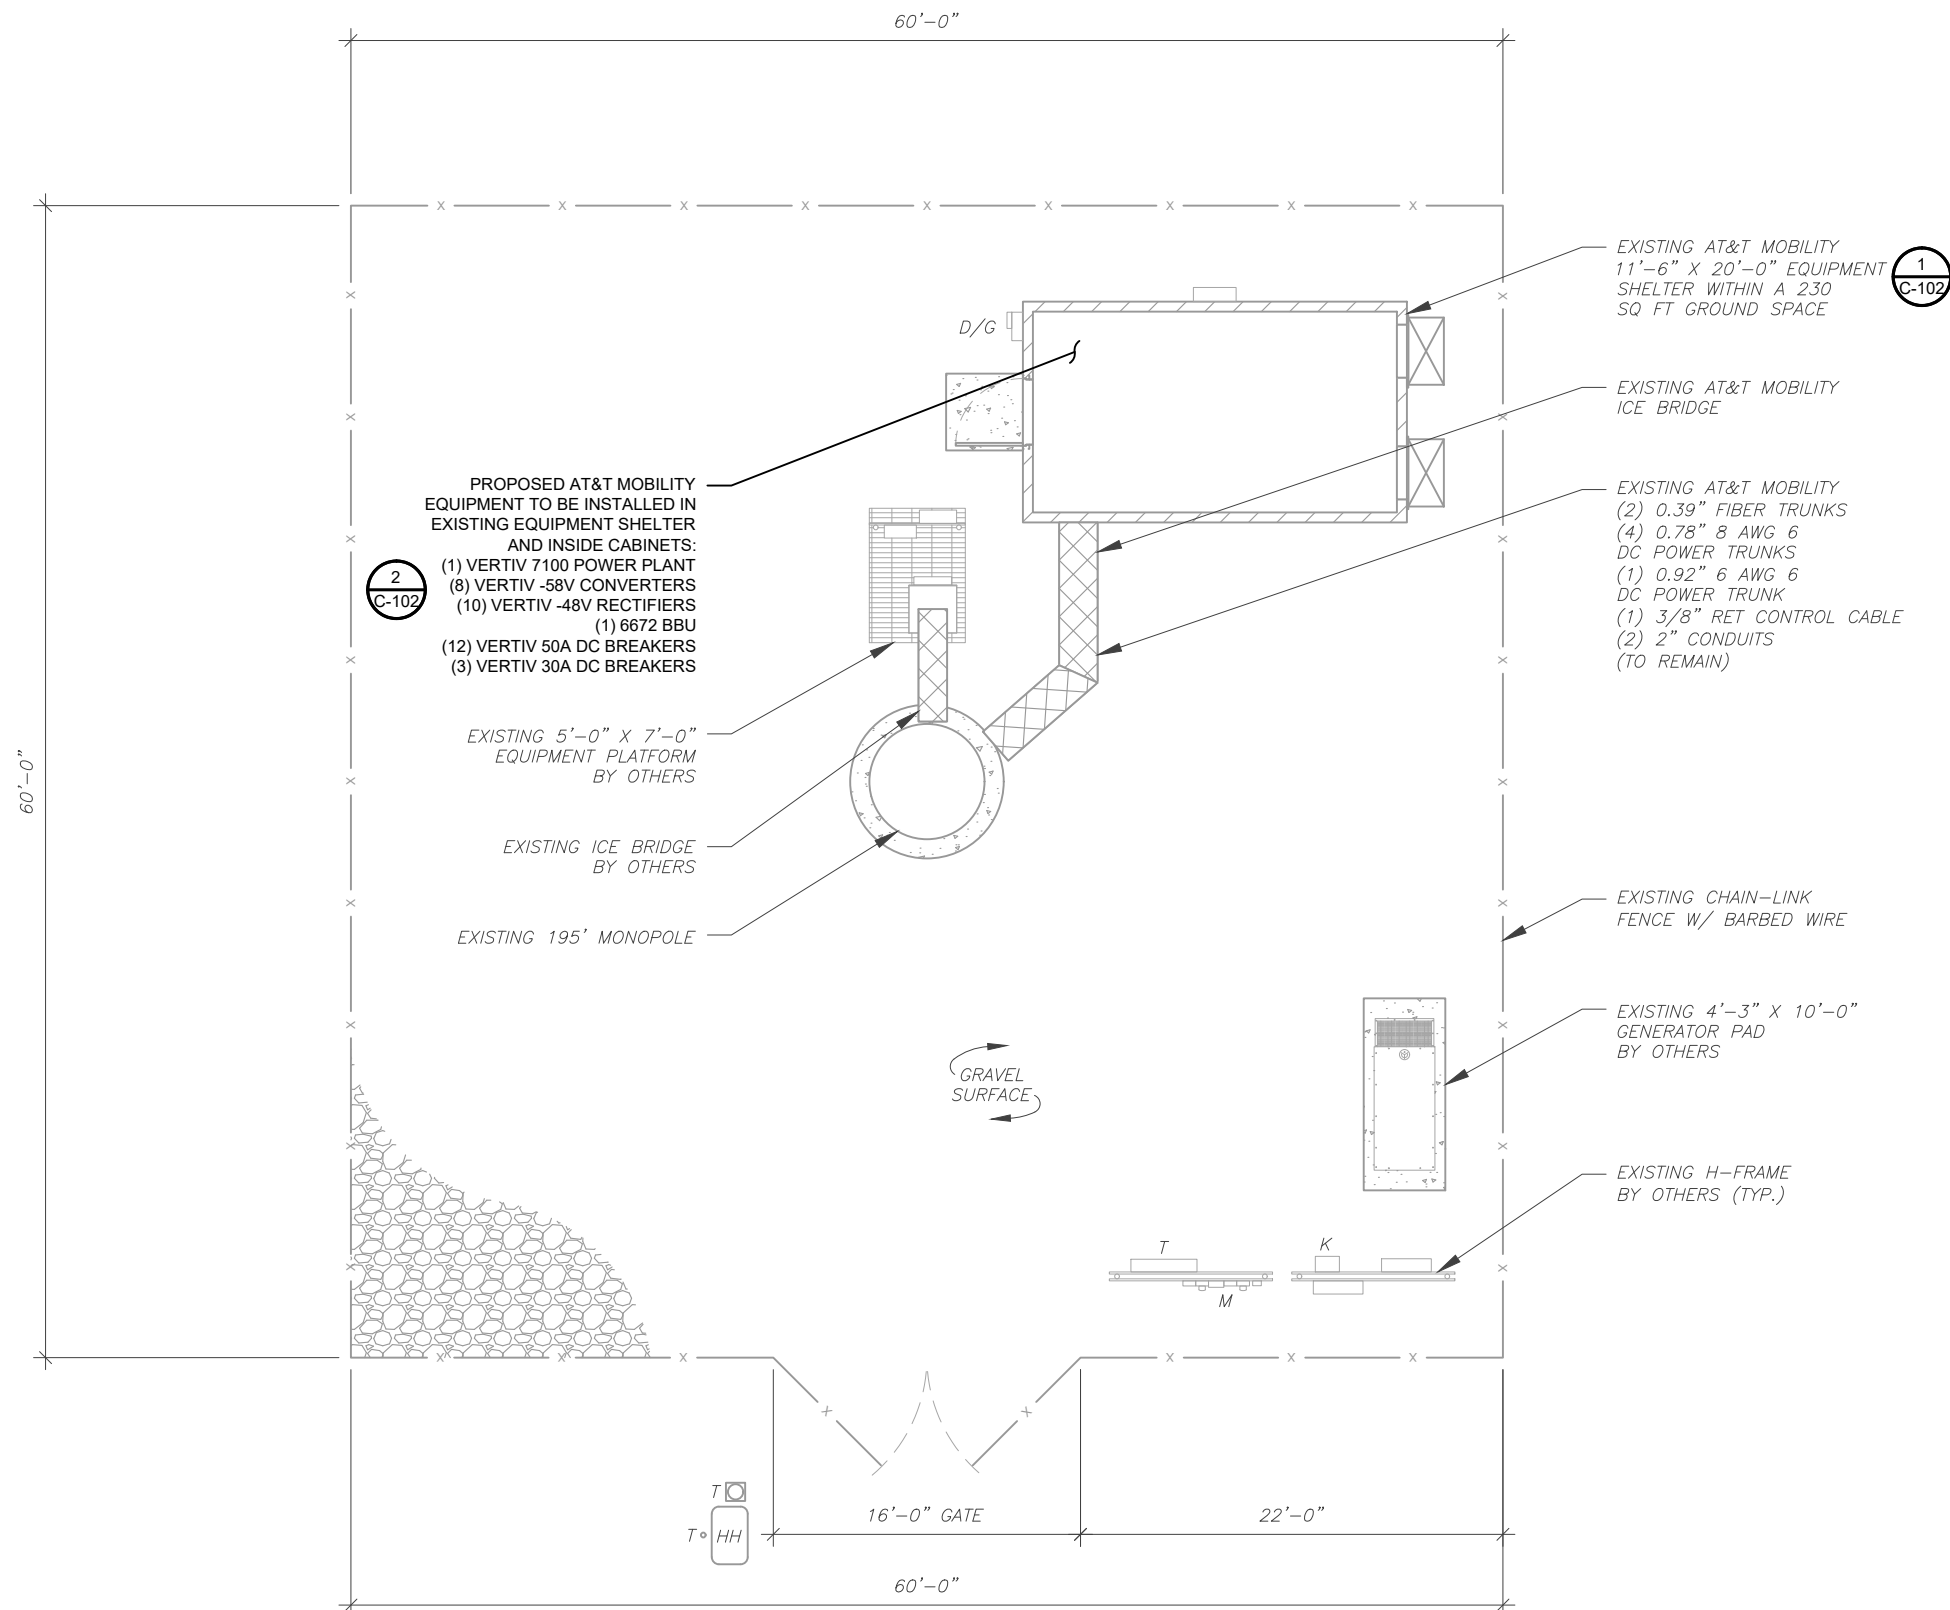


1 DETAILED SITE PLAN

 

SCALE: 1"=10' (11X17)
1"=5' (22X34)



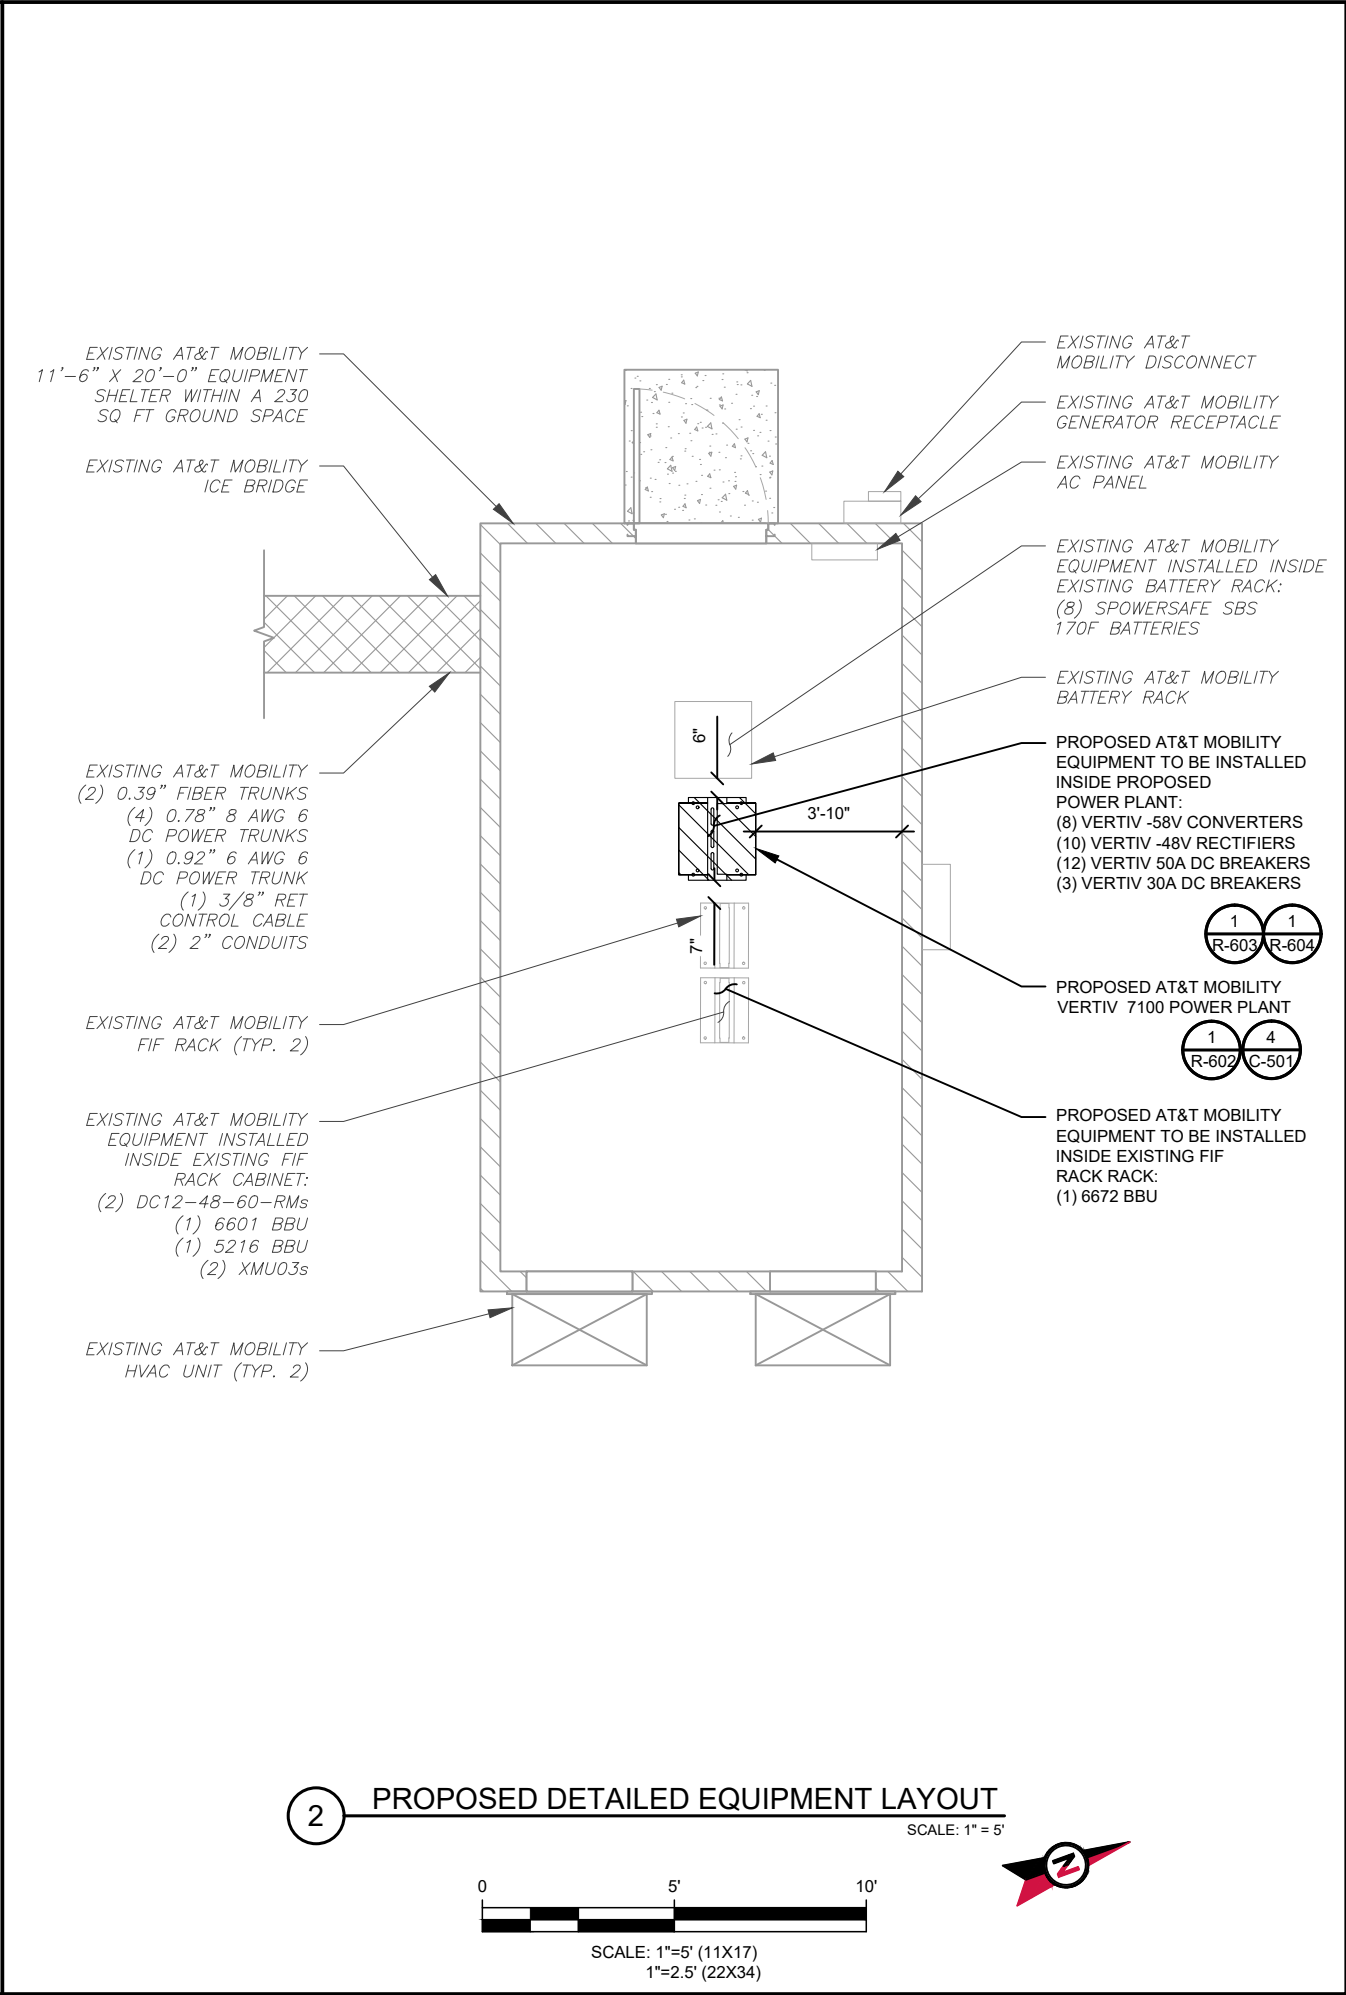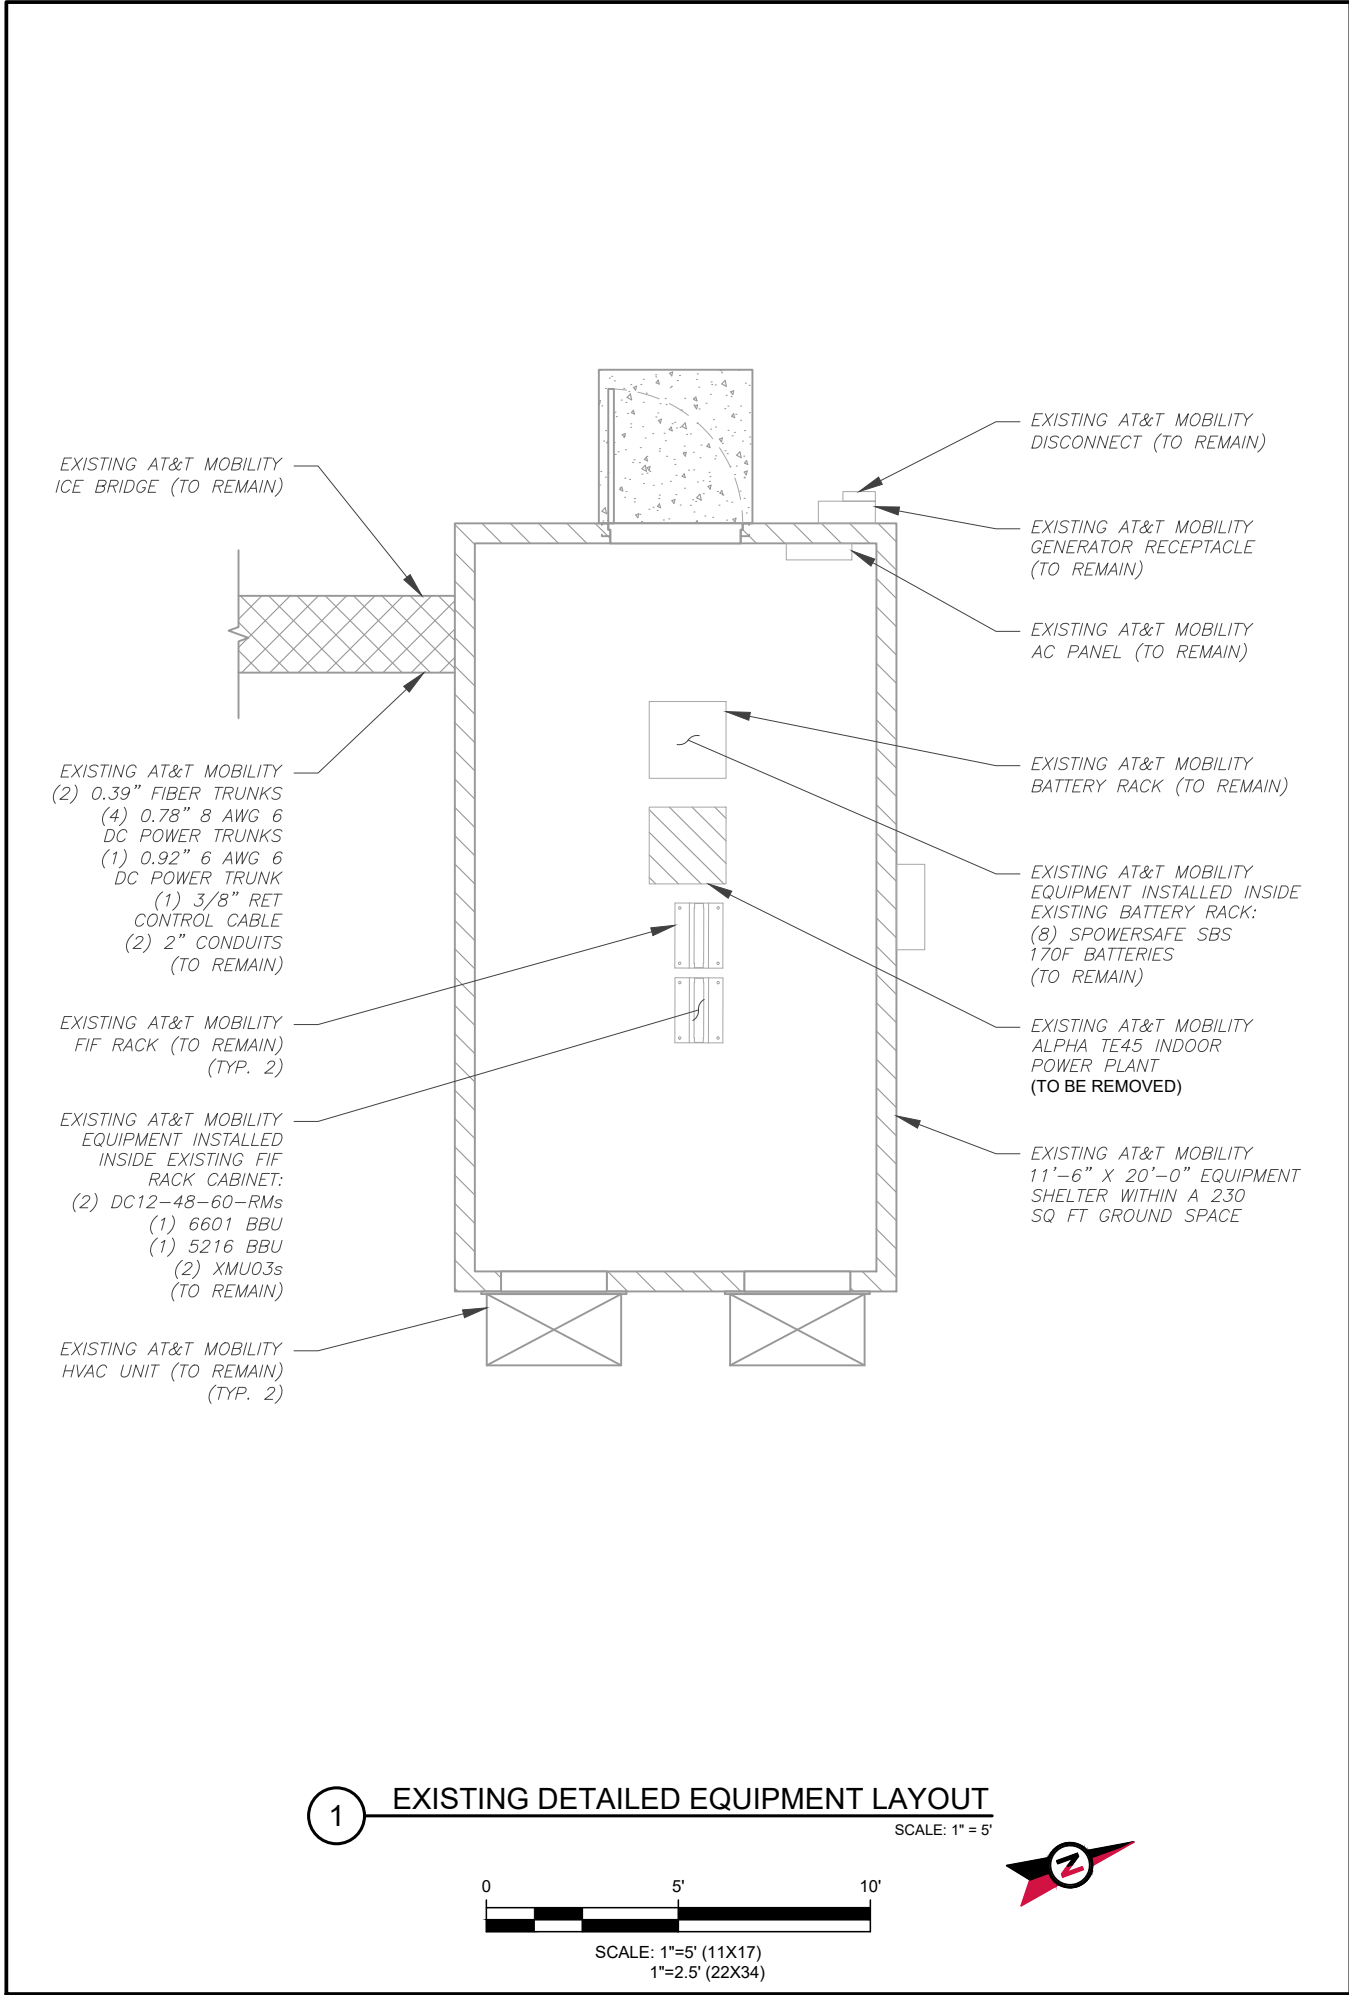

AMERICAN TOWER®

PLANS PREPARED BY:

TEP ENGINEERING, PLLC
326 TRYON ROAD
RALEIGH, NC 27603-3530
OFFICE: (919) 661-6351
www.tepgroup.net
N.C. LICENSE #P-1403

TEP IS A FAMILY OF COMPANIES LICENSED TO PROVIDE DIFFERENT SERVICES IN DIFFERENT JURISDICTIONS. DEPENDING ON THE JURISDICTION, PROFESSIONAL ENGINEERING AND LAND SURVEYING SERVICES ARE PROVIDED BY TEP OPO LLC, A DELAWARE LIMITED LIABILITY COMPANY, TEP ENGINEERING, LLC, A NORTH CAROLINA PROFESSIONAL LIMITED LIABILITY COMPANY, OR M&H ENGINEERING, LLC, A NEW YORK PROFESSIONAL LIMITED LIABILITY COMPANY. GENERAL CONTRACTOR SERVICES ARE PROVIDED BY TEP OPO LLC, A DELAWARE LIMITED LIABILITY COMPANY. WE ACQUIRE THE REQUISITE LICENSES IN EACH STATE. ADDITIONAL INFORMATION CAN BE OBTAINED FROM THE COMPANY.

REV.	DESCRIPTION	BY	DATE
A	PRELIMINARY	APM	03/12/25
B	100% CONSTRUCTION	APM	03/20/25
1	100% CONSTRUCTION	SSP	04/22/25

ATC SITE NUMBER: 280251

ATC SITE NAME: SPOUT SPRINGS NC

AT&T MOBILITY SITE NUMBER:

SINC001601

AT&T MOBILITY SITE NAME:

368-389

SITE ADDRESS:
641 NC HWY 24-87
CAMERON, NC 27332-6191

TEP Engineering, PLLC P-1403

SEAL: 04/22/25

DATE DRAWN: 04/22/25



ATC JOB NO: 14884017

CUSTOMER NAME: 368-389

CUSTOMER ID: SINC001601


DETAILED EQUIPMENT LAYOUT

SHEET NUMBER: C-102	REVISION: 1
-------------------------------	-----------------------

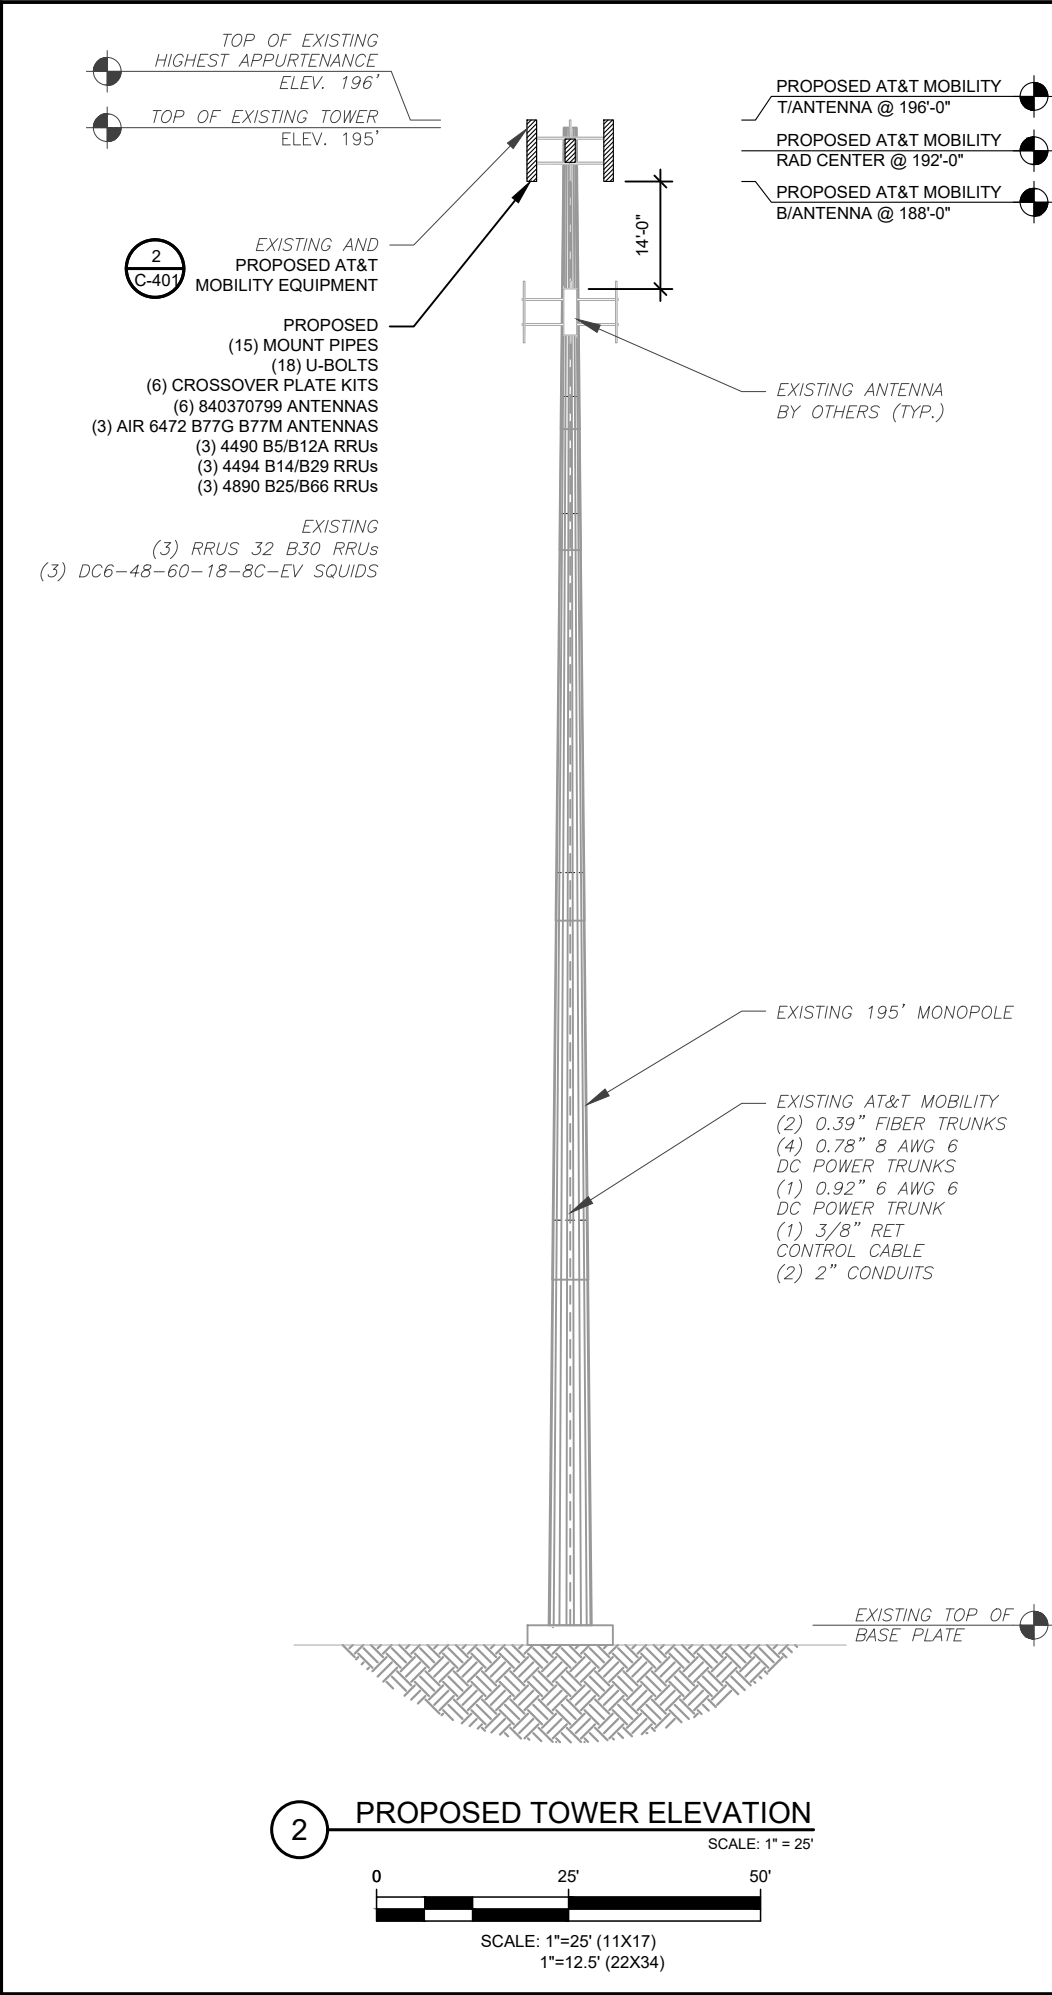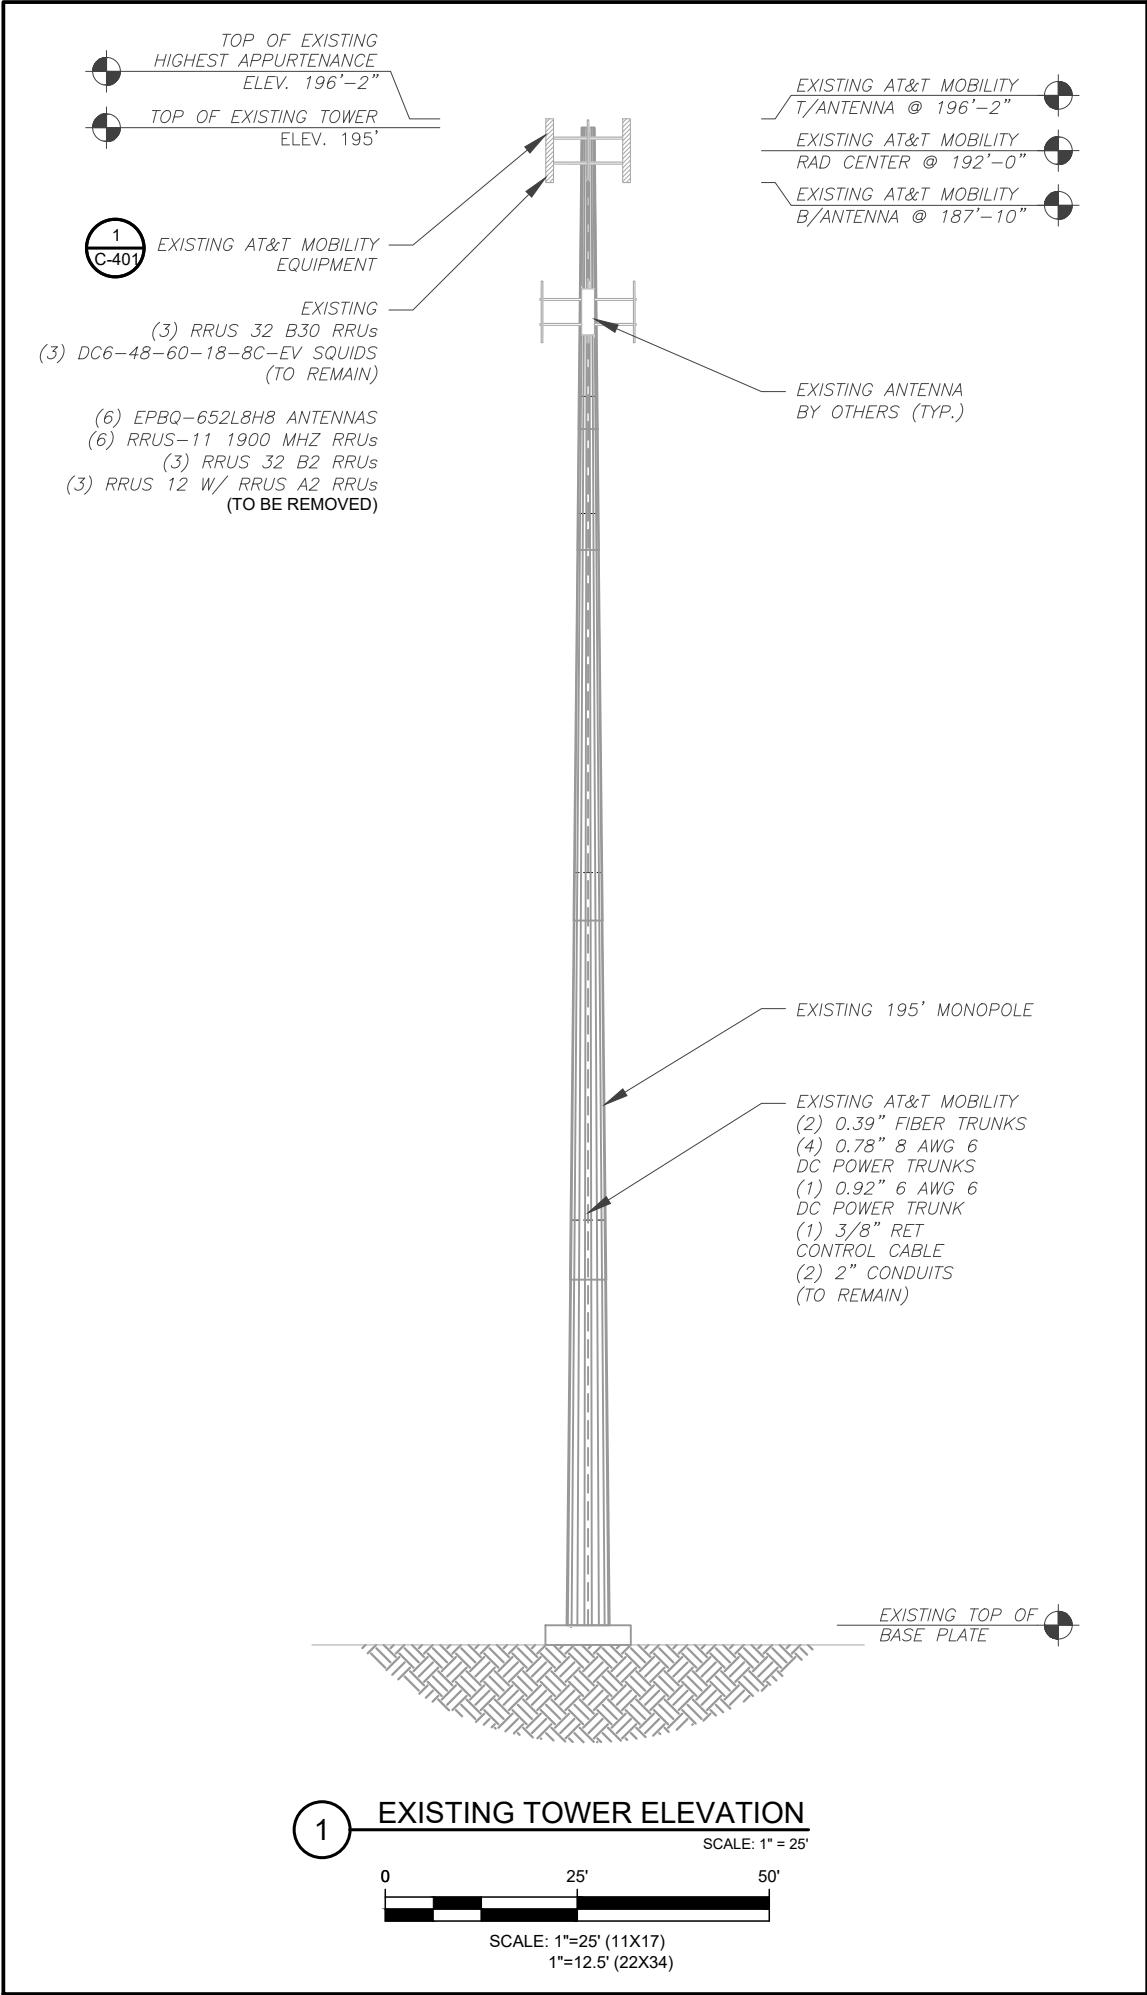

PER MOUNT ANALYSIS COMPLETED BY AMERICAN TOWER CORPORATION, DATED MARCH 05, 2025, THE EXISTING MOUNT MUST BE MODIFIED TO ADEQUATELY SUPPORT THE PROPOSED LOADING. THE MOUNT MODIFICATION PROPOSED IN THE MOUNT ANALYSIS, INCLUDED AT THE END OF THIS PLAN SET, MUST BE INSTALLED PRIOR TO THE INSTALLATION OF THE PROPOSED ANTENNAS AND OTHER EQUIPMENT.

- TOWER NOTES:
- IT IS THE CONTRACTOR'S RESPONSIBILITY TO CONFIRM WITH THE PROJECT MANAGER THAT THEY HAVE THE MOST RECENT VERSION OF THE STRUCTURAL ANALYSIS BEFORE COMMENCING WORK. EXISTING AND PROPOSED TOWER APPURTENANCES, MOUNTS, AND ANTENNAS ARE SHOWN BASED ON THE STRUCTURAL ANALYSIS.
 - WHERE APPLICABLE, ALL NEW ANTENNAS, EQUIPMENT, MOUNTS, CABLING, ETC. SHALL BE PAINTED/SOCKED TO MATCH EXISTING EQUIPMENT IN ACCORDANCE WITH FAA, JURISDICTION, AND/OR OTHER LOCAL REQUIREMENTS.
 - TOWER ELEVATION DEPICTION MAY NOT REFLECT ALL EQUIPMENT INCLUDED IN STRUCTURAL ANALYSIS. REFER TO STRUCTURAL ANALYSIS FOR FULL TOWER LOADING.



AMERICAN TOWER®

PLANS PREPARED BY:



TEP ENGINEERING, PLLC
326 TRYON ROAD
RALEIGH, NC 27603-3530
OFFICE: (919) 661-6351
www.tepgroup.net
N.C. LICENSE #P-1403

TEP IS A FAMILY OF COMPANIES LICENSED TO PROVIDE DIFFERENT SERVICES IN DIFFERENT JURISDICTIONS. DEPENDING ON THE JURISDICTION, PROFESSIONAL ENGINEERING AND LAND SURVEYING SERVICES ARE PROVIDED BY TEP OPCO LLC, A DELAWARE LIMITED LIABILITY COMPANY, TEP ENGINEERING, LLC, A NORTH CAROLINA PROFESSIONAL LIMITED LIABILITY COMPANY, OR M&H ENGINEERING, LLC, A NEW YORK PROFESSIONAL LIMITED LIABILITY COMPANY. GENERAL CONTRACTOR SERVICES ARE PROVIDED BY TEP OPCO LLC, A DELAWARE LIMITED LIABILITY COMPANY. WE ACQUIRE THE REQUISITE LICENSES IN EACH STATE. ADDITIONAL INFORMATION CAN BE OBTAINED FROM THE COMPANY.

REV.	DESCRIPTION	BY	DATE
A	PRELIMINARY	APM	03/12/25
0	100% CONSTRUCTION	APM	03/20/25
1	100% CONSTRUCTION	SSP	04/22/25

ATC SITE NUMBER: 280251

ATC SITE NAME: SPOUT SPRINGS NC

AT&T MOBILITY SITE NUMBER:

SINC001601


AT&T MOBILITY SITE NAME:

368-389


SITE ADDRESS:

641 NC HWY 24-87
CAMERON, NC 27332-6191

TEP Engineering, PLLC P-1403



SEAL: 04/22/25




DATE DRAWN:	04/22/25
ATC JOB NO:	14884017
CUSTOMER NAME:	368-389
CUSTOMER ID:	SINC001601

TOWER ELEVATION


SHEET NUMBER:	REVISION:
C-201	1

EXISTING CONFIGURATIONS ARE BASED ON RFDS.
CONTRACTOR TO VERIFY EXISTING CONDITIONS.

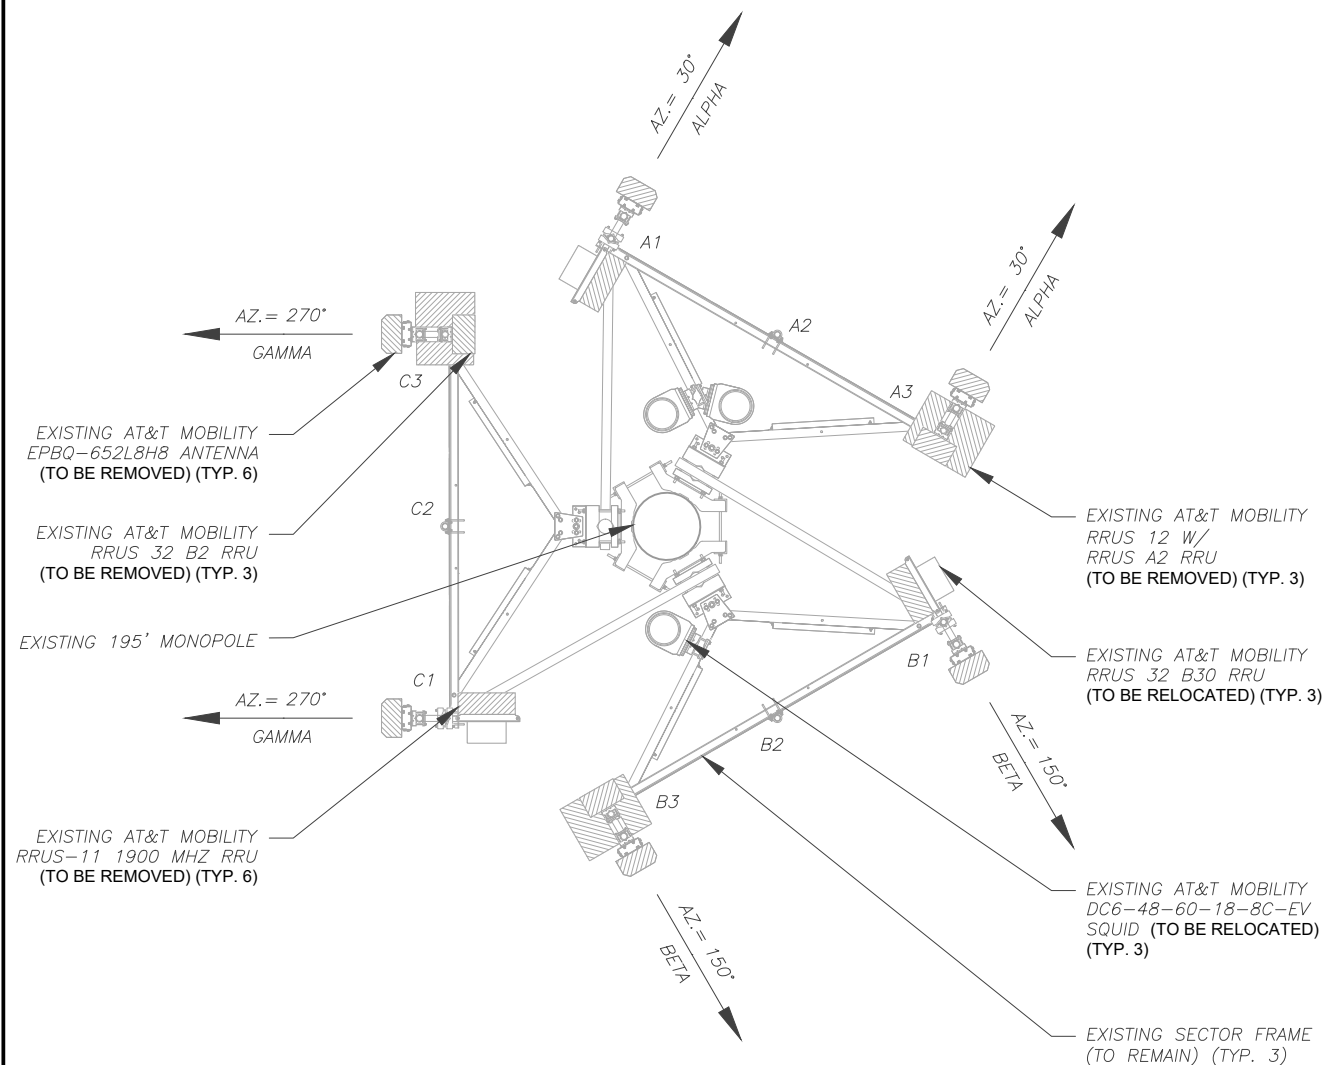


1 EXISTING ANTENNA PLAN

 
SCALE: 1" = 5'



PER MOUNT ANALYSIS COMPLETED BY AMERICAN TOWER CORPORATION, DATED MARCH 05, 2025, THE EXISTING MOUNT MUST BE MODIFIED TO ADEQUATELY SUPPORT THE PROPOSED LOADING. THE MOUNT MODIFICATION PROPOSED IN THE MOUNT ANALYSIS, INCLUDED AT THE END OF THIS PLAN SET, MUST BE INSTALLED PRIOR TO THE INSTALLATION OF THE PROPOSED ANTENNAS AND OTHER EQUIPMENT.

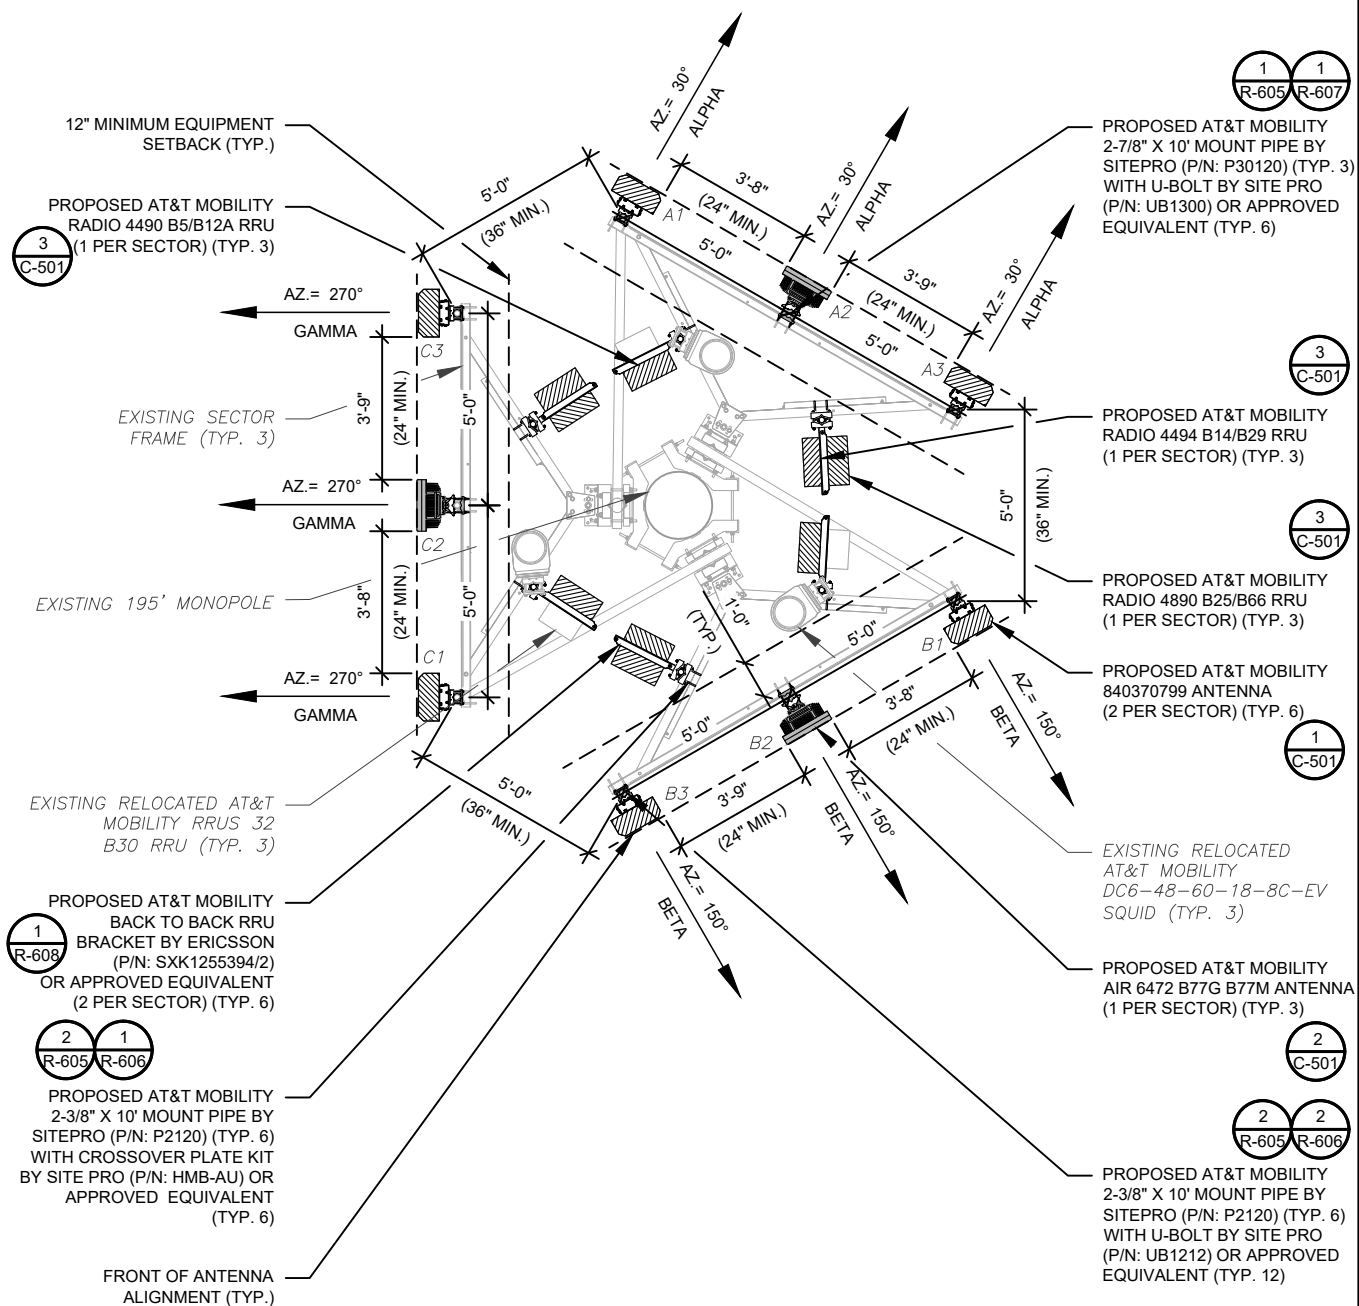

2 FINAL ANTENNA PLAN

 

PROPOSED RRU_s MUST BE
INSTALLED A MINIMUM OF 12" AWAY
FROM HORIZONTAL MOUNTING PIPE



PLANS PREPARED BY:



TEP ENGINEERING, PLLC
326 TRYON ROAD
RALEIGH, NC 27603-3530
OFFICE: (919) 661-6351
www.tepgroup.net
N.C. LICENSE #P-1403

TEP IS A FAMILY OF COMPANIES LICENSED TO PROVIDE DIFFERENT SERVICES IN DIFFERENT JURISDICTIONS. DEPENDING ON THE JURISDICTION, PROFESSIONAL ENGINEERING AND LAND SURVEYING SERVICES ARE PROVIDED BY TEP OPCO LLC, A DELAWARE LIMITED LIABILITY COMPANY, TEP ENGINEERING, LLC, A NORTH CAROLINA PROFESSIONAL LIMITED LIABILITY COMPANY, OR M&H ENGINEERING, LLC, A NEW YORK PROFESSIONAL LIMITED LIABILITY COMPANY. GENERAL SERVICES ARE PROVIDED BY TEP OPCO LLC, A DELAWARE LIMITED LIABILITY COMPANY. WE ACQUIRE THE REQUISITE LICENSES IN EACH STATE. ADDITIONAL INFORMATION CAN BE OBTAINED FROM THE COMPANY.

REV.	DESCRIPTION	BY	DATE
<u>A</u>	PRELIMINARY	APM	03/12/25
<u>0</u>	100% CONSTRUCTION	APM	03/20/25
<u>1</u>	100% CONSTRUCTION	SSP	04/22/25
<u> </u>			
<u> </u>			

ATC SITE NUMBER: 280251

ATC SITE NAME: SPOUT SPRINGS NC

AT&T MOBILITY SITE NUMBER:

SINC001601


AT&T MOBILITY SITE NAME:

368-389

SITE ADDRESS:
641 NC HWY 24-87
AMERON, NC 27332-6191

TEP Engineering, PLLC

2-1403

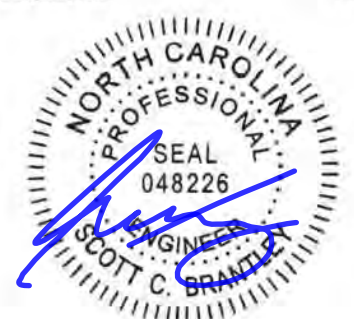

SEAL:

04/22/25



DATE DRAWN:	04/22/25
ATC JOB NO:	14884017
CUSTOMER NAME:	368-389
CUSTOMER ID:	SINC001601

ANTENNA INSTALLATION

SHEET NUMBER:


C-401

REVISION:


1

Copyright © 2025 ATC IP LLC, All Rights Reserved


EXISTING ANTENNA SCHEDULE									<div>NOTES</div> <div>1. GC TO VERIFY THE FINAL RFDS MATCHES THE FINAL CONSTRUCTION DRAWINGS. GC TO NOTIFY ATC PM OF ANY DISCREPANCY PRIOR TO INSTALLING THE EQUIPMENT.</div> <div>2. GC TO CAP ALL UNUSED PORTS.</div> <div>3. CONFIRM SPACING OF PROPOSED EQUIP DOES NOT CAUSE TOWER CONFLICTS NOR IMPEDE TOWER CLIMBING PEGS.</div> <div>4. THE ANTENNA ORIENTATION PLAN IS A SCHEMATIC. ATC DID NOT CONFIRM EXISTING SITE CONDITIONS INCLUDING, BUT NOT LIMITED TO, ANTENNA AZIMUTHS, MOUNT CONFIGURATIONS AND TOWER ORIENTATION. SCALES SHOWN ARE FOR REFERENCE ONLY AND EXISTING DIMENSIONS ARE APPROXIMATE. THE CONTRACTOR SHALL VERIFY ALL EXISTING CONDITIONS PRIOR TO INSTALLATION AND NOTIFY ATC OF ANY DISCREPANCIES.</div> <div>5. CONTRACTOR TO ENSURE PROPER SEPARATION IN ACCORDANCE WITH AT&T'S FIRSTNET REQUIREMENTS.</div> <div>STATUS ABBREVIATIONS</div> <div>RMV: TO BE REMOVED</div> <div>RMN: TO REMAIN</div> <div>REL: TO BE RELOCATED</div> <div>ADD: TO BE ADDED</div> <div>CABLE LENGTHS FOR JUMPERS</div> <div>JUNCTION BOX TO RRU: 15'</div> <div>RRU TO ANTENNA: 10'</div>
LOCATION			ANTENNA SUMMARY				NON ANTENNA SUMMARY		
SECTOR	RAD	AZ	POS	ANTENNA	BAND	STATUS	ADDITIONAL TOWER MOUNTED EQUIPMENT	STATUS	
ALPHA	192'	30°	A1	EPBQ-652L8H8	—	RMV	(1) RRUS 32 B30 (1) RRUS-11 1900 MHZ	REL RMV	
			A2	—	—	—	—		
			A3	EPBQ-652L8H8	—	RMV	(1) RRUS 32 B2 (1) RRUS 12 W/ RRUS A2 (1) RRUS-11 1900 MHZ	RMV RMV RMV	
BETA	192'	150°	B1	EPBQ-652L8H8	—	RMV	(1) RRUS 32 B30 (1) RRUS-11 1900 MHZ	REL RMV	
			B2	—	—	—	—		
			B3	EPBQ-652L8H8	—	RMV	(1) RRUS 32 B2 (1) RRUS 12 W/ RRUS A2 (1) RRUS-11 1900 MHZ	RMV RMV RMV	
GAMMA	192'	270°	C1	EPBQ-652L8H8	—	RMV	(1) RRUS 32 B30 (1) RRUS-11 1900 MHZ	REL RMV	
			C2	—	—	—	—		
			C3	EPBQ-652L8H8	—	RMV	(1) RRUS 32 B2 (1) RRUS 12 W/ RRUS A2 (1) RRUS-11 1900 MHZ	RMV RMV RMV	

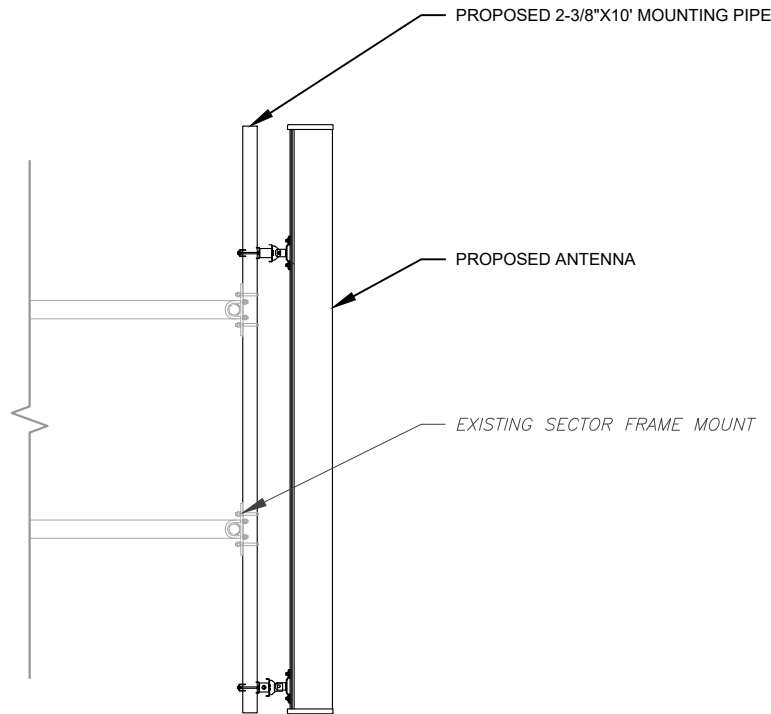


1 PROPOSED ANTENNA MOUNTING DETAIL
SCALE: N.T.S.

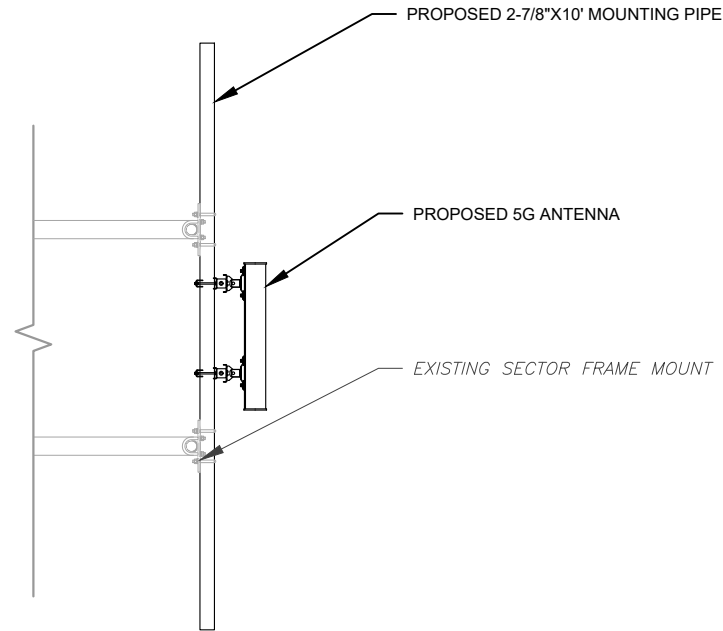

2 PROPOSED 5G ANTENNA MOUNTING DETAIL
SCALE: N.T.S.

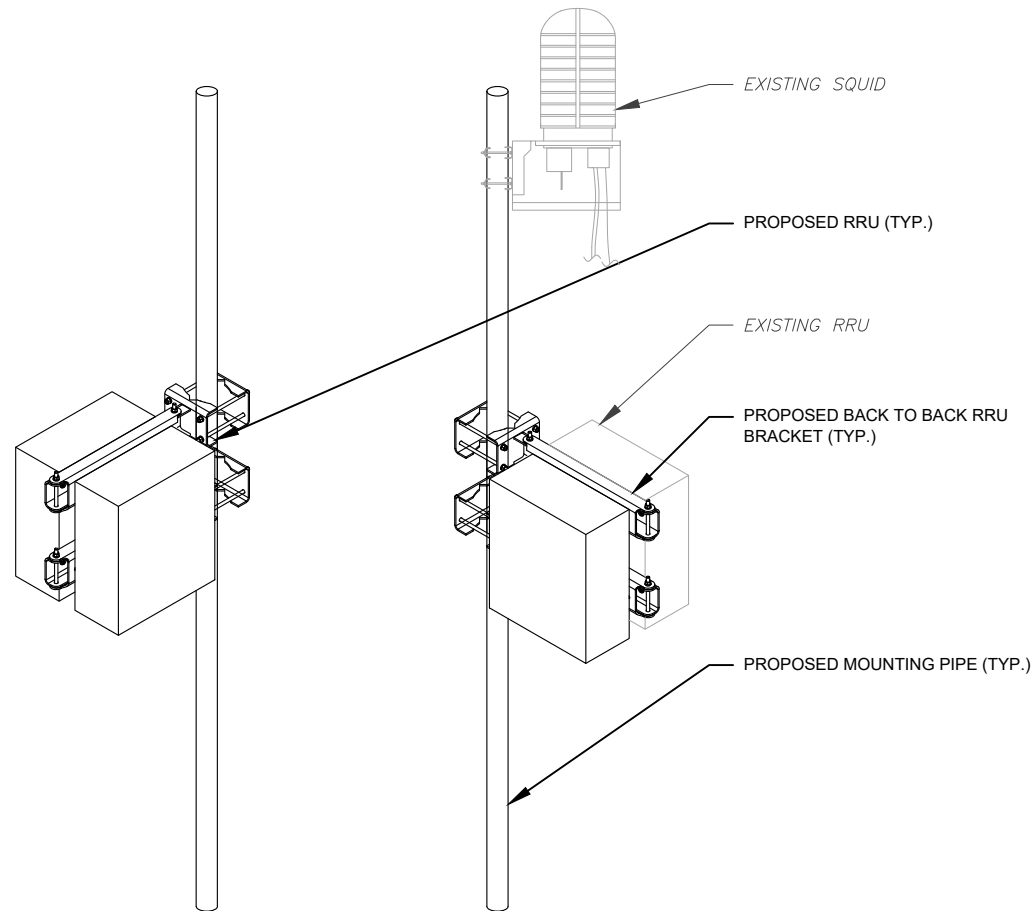


3 PROPOSED RRU & EXISTING SQUID MOUNTING DETAIL
SCALE: N.T.S.

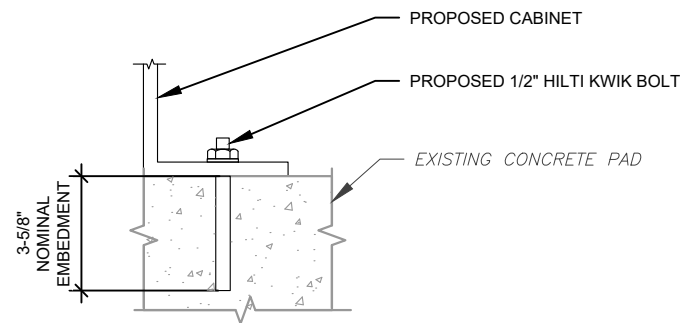


NOTE:
INSTALL HILTI KWIK BOLT ANCHORS STRICTLY PER
INSTALLATION INSTRUCTIONS INCLUDED WITH PRODUCT OR
FOUND ONLINE AT WWW.US.HILTI.COM. PROPER
INSTALLATION IS CRITICAL FOR FULL PERFORMANCE.

4 CABINET ATTACHMENT DETAIL
SCALE: N.T.S.



AMERICAN TOWER®

PLANS PREPARED BY:



TEP ENGINEERING, PLLC
326 TRYON ROAD
RALEIGH, NC 27603-3530
OFFICE: (919) 661-6351
www.tepgroup.net
N.C. LICENSE #P-1403

TEP IS A FAMILY OF COMPANIES LICENSED TO PROVIDE DIFFERENT SERVICES IN DIFFERENT JURISDICTIONS. DEPENDING ON THE JURISDICTION, PROFESSIONAL ENGINEERING AND LAND SURVEYING SERVICES ARE PROVIDED BY TEP OPKO LLC, A DELAWARE LIMITED LIABILITY COMPANY, TEP ENGINEERING, LLC, A NORTH CAROLINA PROFESSIONAL LIMITED LIABILITY COMPANY, OR M&H ENGINEERING, LLC, A NEW YORK PROFESSIONAL LIMITED LIABILITY COMPANY. GENERAL CONTRACTOR SERVICES ARE PROVIDED BY TEP OPKO LLC, A DELAWARE LIMITED LIABILITY COMPANY. WE ACQUIRE THE REQUISITE LICENSES IN EACH STATE. ADDITIONAL INFORMATION CAN BE OBTAINED FROM THE COMPANY.

REV.	DESCRIPTION	BY	DATE
A	PRELIMINARY	APM	03/12/25
0	100% CONSTRUCTION	APM	03/20/25
1	100% CONSTRUCTION	SSP	04/22/25

ATC SITE NUMBER: 280251

ATC SITE NAME: SPOUT SPRINGS NC

AT&T MOBILITY SITE NUMBER:

SINC001601


AT&T MOBILITY SITE NAME:

368-389


SITE ADDRESS:

641 NC HWY 24-87
CAMERON, NC 27332-6191

TEP Engineering, PLLC

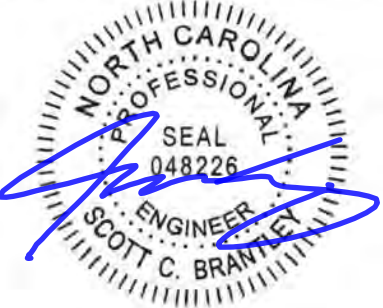

SEAL: 04/22/25



DATE DRAWN: 04/22/25

ATC JOB NO: 14884017

CUSTOMER NAME: 368-389

CUSTOMER ID: SINC001601

CONSTRUCTION
DETAILS

SHEET NUMBER:

C-501

REVISION:

1

Copyright © 2025 ATC IP LLC. All Rights Reserved.

AC POWER PANEL A (EXISTING)													
120/240 VOLTS, 1-PHASE, 3-WIRE, 200A													
MAIN BREAKER RATING (A) :					200		SYSTEM VOLTAGE (V) :					240	
DESCRIPTION	VA	c/nc	BKR	POSN	L1	L2	POSN	BKR	c/nc	VA	DESCRIPTION		
CONTROLLER	520	nc	30/2	1	3030		2	50/2	c	2510	HVAC #1		
	520	nc		3		3030	4		c	2510			
RECTIFIER #1	520	c	30/2	5	3030		6	50/2	c	2510	HVAC #2		
	520	c		7		3030	8		c	2510			
RECTIFIER #2	520	c	30/2	9	1420		10	20/1	nc	900	INTERIOR LIGHTS		
	520	c		11		820	12	20/1	nc	300	EXTERIOR LIGHTS		
RECTIFIER #5 / OFF	0	c	30/2	13	720		14	20/1	nc	720	RECEPTACLES		
	0	c		15		0	16				BLANK		
RECTIFIER #4	520	c	30/2	17	520		18				BLANK		
	520	c		19		520	20				BLANK		
RECTIFIER #3	520	c	30/2	21	520		22				BLANK		
	520	c		23		520	24				BLANK		
RECTIFIER #6 / OFF	0	c	30/2	25	0		26				BLANK		
	0	c		27		0	28				BLANK		
RECTIFIER #7 / OFF	0	c	30/2	29	0		30				BLANK		
	0	c		31		0	32				BLANK		
RECTIFIER #8 / OFF	0	c	30/2	33	0		34				BLANK		
	0	c		35		0	36				BLANK		
BLANK				37	0		38				BLANK		
BLANK				39		0	40				BLANK		
GFCI	720	nc	20/1	41	720		42				BLANK		
PHASE TOTALS (VA):					9960	7920							
PHASE TOTALS (A):					83	66							
CURRENT PER PHASE W/ 125% Continuous Loads(A):					98	81	Amperes/phase cannot exceed main breaker rating						
PANEL TOTAL (VA):					17880	Legend: c = continuous, nc = non-continuous							
PANEL TOTAL W/ 125% Continuous Loads (VA):					21430								

1 EXISTING PANEL SCHEDULE

SCALE: N.T.S.

AC POWER PANEL A (PROPOSED)												
120/240 VOLTS, 1-PHASE, 3-WIRE, 200A												
MAIN BREAKER RATING (A) :					200		SYSTEM VOLTAGE (V) :					240
DESCRIPTION	VA	c/nc	BKR	POSN	L1	L2	POSN	BKR	c/nc	VA	DESCRIPTION	
CONTROLLER	520	nc	30/2	1	3030		2	50/2	c	2510	HVAC #1	
	520	nc		3		3030	4		c	2510		
VERTIV RECTIFIER 1 & 2	1245	c	30/2	5	3755		6	50/2	c	2510	HVAC #2	
	1245	c		7		3755	8		c	2510		
VERTIV RECTIFIER 3 & 4	1245	c	30/2	9	2145		10	20/1	nc	900	INTERIOR LIGHTS	
	1245	c		11		1545	12	20/1	nc	300	EXTERIOR LIGHTS	
VERTIV RECTIFIER 5 & 6	1245	c	30/2	13	1965		14	20/1	nc	720	RECEPTACLES	
	1245	c		15		1245	16				BLANK	
VERTIV RECTIFIER 7 & 8	1245	c	30/2	17	1245		18				BLANK	
	1245	c		19		1245	20				BLANK	
VERTIV RECTIFIER 9 & 10	1245	c	30/2	21	1245		22				BLANK	
	1245	c		23		1245	24				BLANK	
SPARE / OFF	0	c	30/2	25	0		26				BLANK	
	0	c		27		0	28				BLANK	
SPARE / OFF	0	c	30/2	29	0		30				BLANK	
	0	c		31		0	32				BLANK	
SPARE / OFF	0	c	30/2	33	0		34				BLANK	
	0	c		35		0	36				BLANK	
BLANK				37	0		38				BLANK	
BLANK				39		0	40				BLANK	
GFCI	720	nc	20/1	41	720		42				BLANK	
PHASE TOTALS (VA):					14105	12065						
PHASE TOTALS (A):					118	101						
CURRENT PER PHASE W/ 125% Continuous Loads(A):					141	124	Amperes/phase cannot exceed main breaker rating					
PANEL TOTAL (VA):					26170	Legend: c = continuous, nc = non-continuous						
PANEL TOTAL W/ 125% Continuous Loads (VA):					31793							

2 PROPOSED PANEL SCHEDULE

SCALE: N.T.S.



PLANS PREPARED BY:



TEP ENGINEERING, PLLC
326 TRYON ROAD
RALEIGH, NC 27603-3530
OFFICE: (919) 661-6351
www.tepgroup.net
N.C. LICENSE #P-1403

TEP IS A FAMILY OF COMPANIES LICENSED TO PROVIDE DIFFERENT SERVICES IN DIFFERENT JURISDICTIONS. DEPENDING ON THE JURISDICTION, PROFESSIONAL ENGINEERING AND LAND SURVEYING SERVICES ARE PROVIDED BY TEP OPO LLC, A DELAWARE LIMITED LIABILITY COMPANY, TEP ENGINEERING, LLC, A NORTH CAROLINA PROFESSIONAL LIMITED LIABILITY COMPANY, OR MMH ENGINEERING, LLC, A NEW YORK PROFESSIONAL LIMITED LIABILITY COMPANY. GENERAL CONTRACTOR SERVICES ARE PROVIDED BY TEP OPO LLC, A DELAWARE LIMITED LIABILITY COMPANY. WE ACQUIRE THE REQUISITE LICENSES IN EACH STATE. ADDITIONAL INFORMATION CAN BE OBTAINED FROM THE COMPANY.

REV.	DESCRIPTION	BY	DATE
A	PRELIMINARY	APM	03/12/25
B	100% CONSTRUCTION	APM	03/20/25
1	100% CONSTRUCTION	SSP	04/22/25

ATC SITE NUMBER: 280251
ATC SITE NAME: SPOUT SPRINGS NC
AT&T MOBILITY SITE NUMBER:
SINC001601
AT&T MOBILITY SITE NAME:
368-389
SITE ADDRESS:
641 NC HWY 24-87
CAMERON, NC 27332-6191




SEAL: 04/22/25




DATE DRAWN:	04/22/25
ATC JOB NO:	14884017
CUSTOMER NAME:	368-389
CUSTOMER ID:	SINC001601

ELECTRICAL DETAILS


SHEET NUMBER:	REVISION:
E-101	1

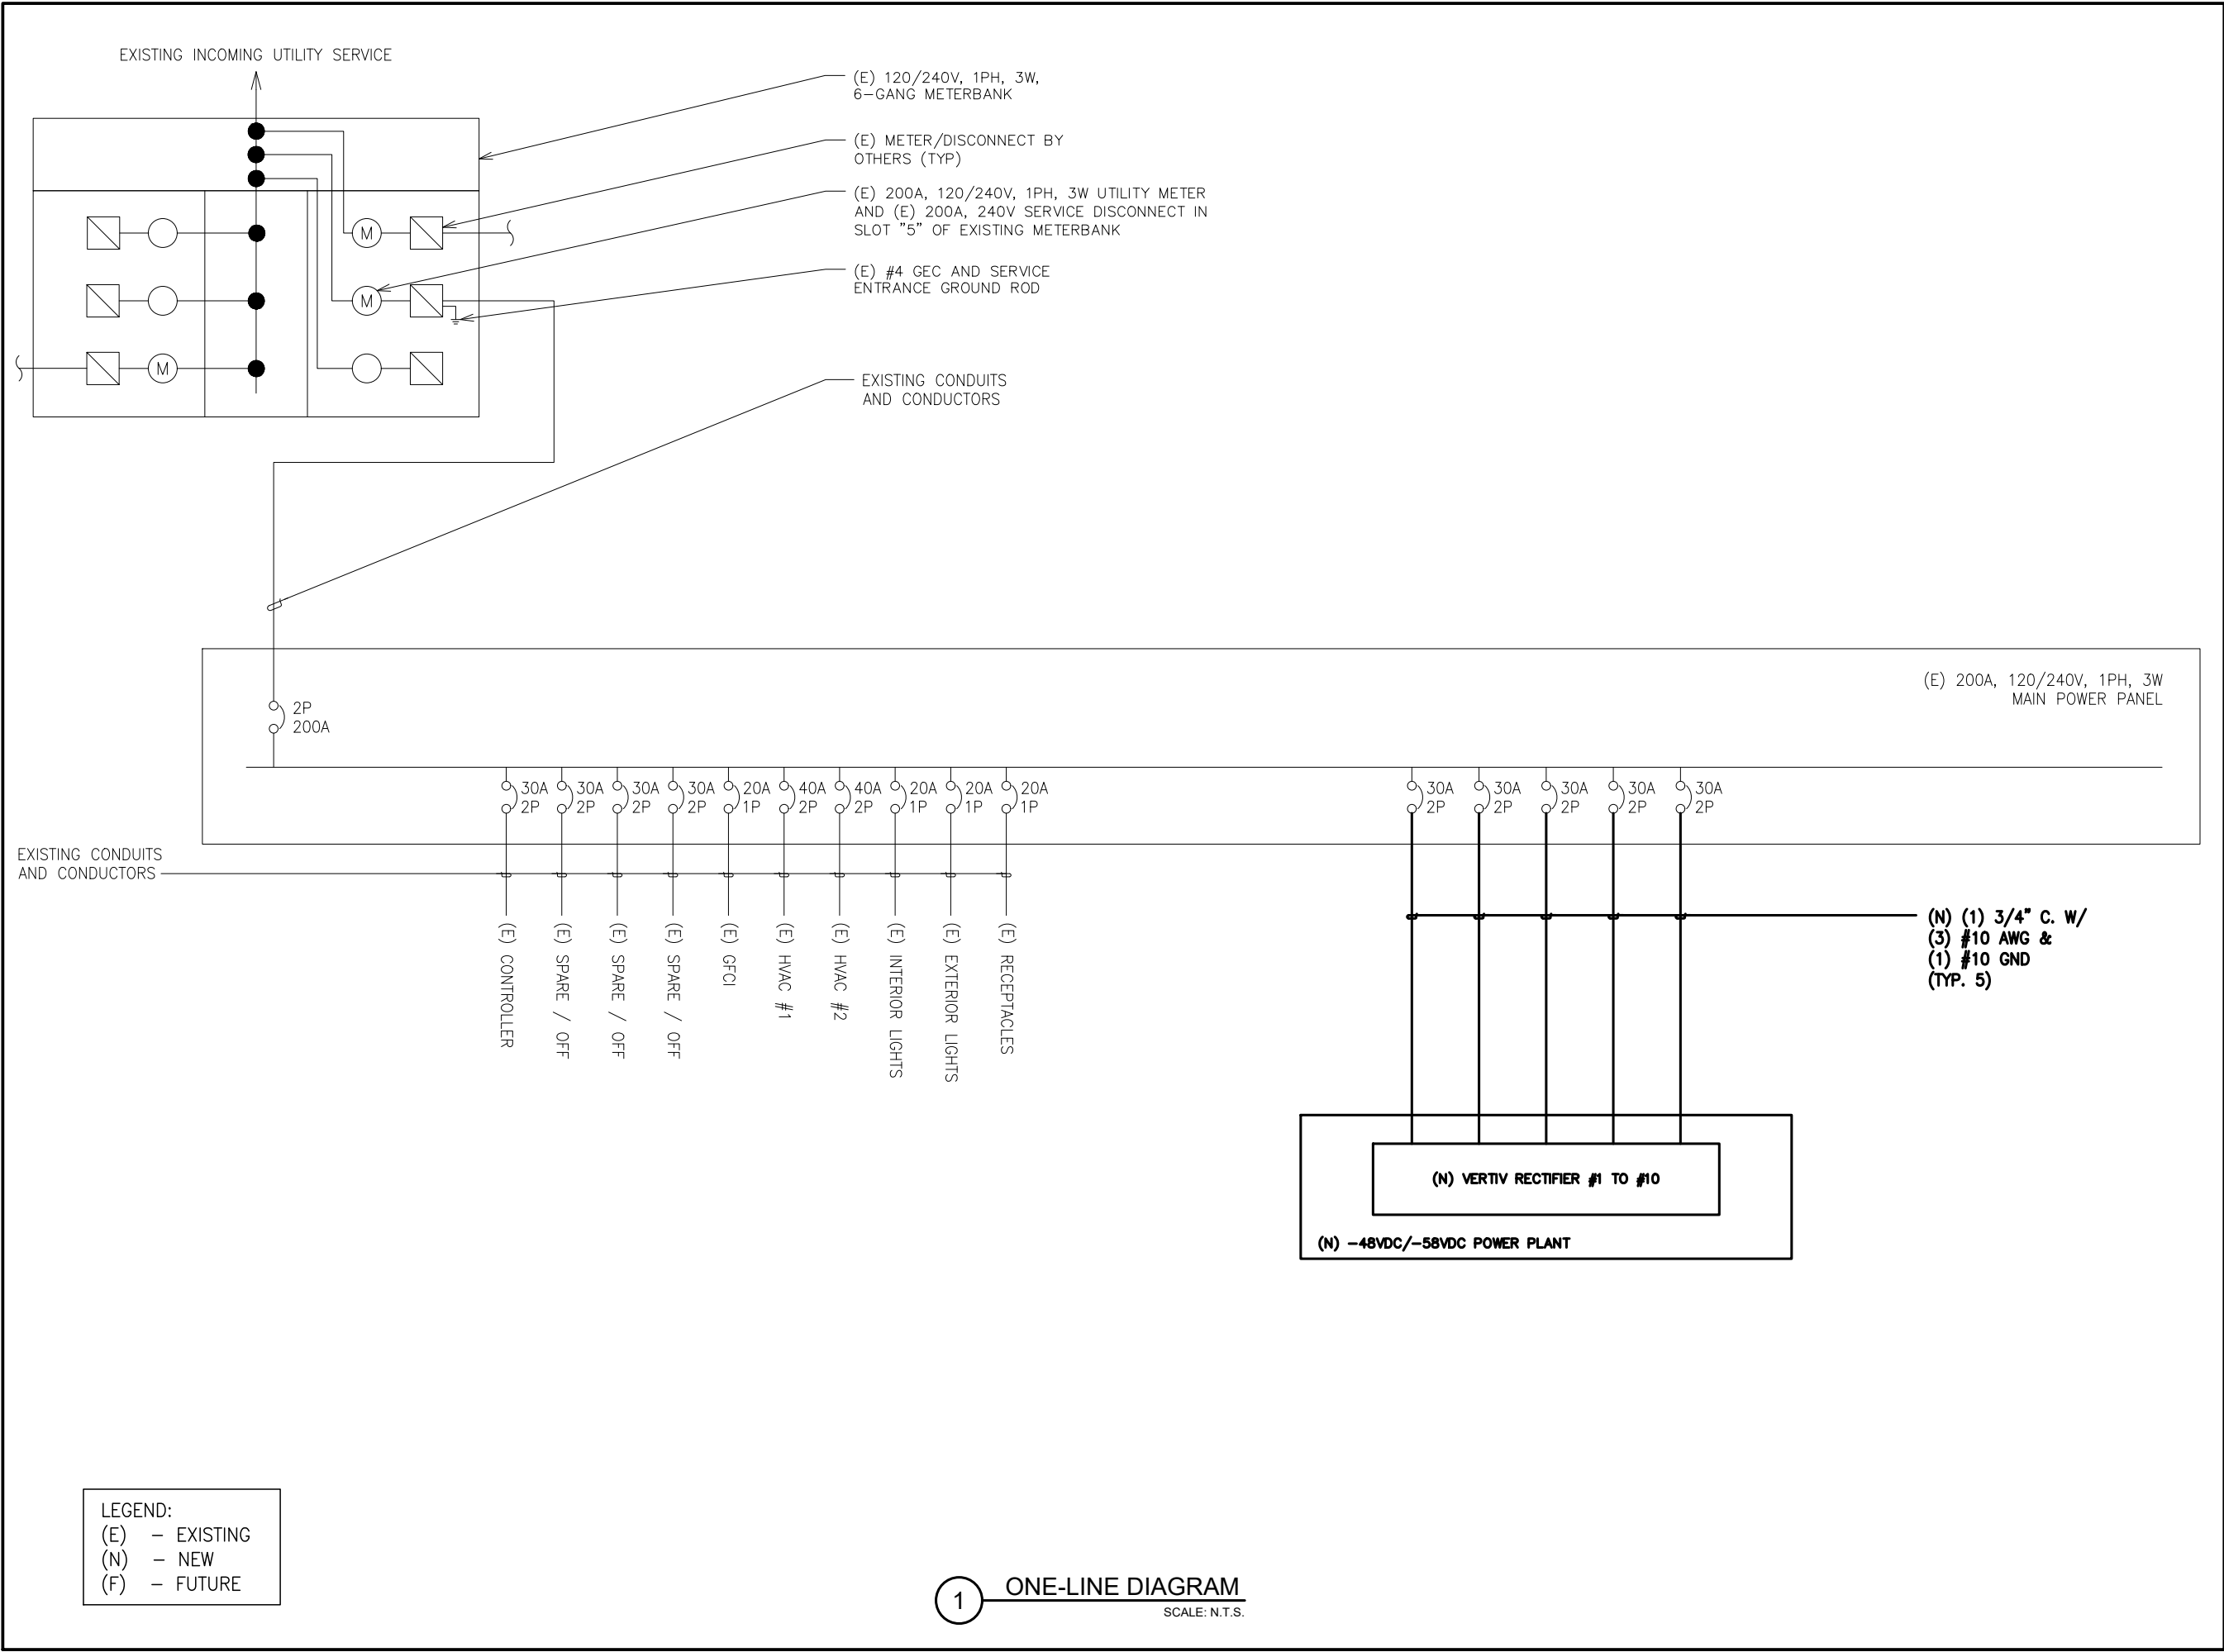



AMERICAN TOWER®

PLANS PREPARED BY:



TEP ENGINEERING, PLLC
326 TRYON ROAD
RALEIGH, NC 27603-3530
OFFICE: (919) 661-6351
www.tepgroup.net
N.C. LICENSE #P-1403

TEP IS A FAMILY OF COMPANIES LICENSED TO PROVIDE DIFFERENT SERVICES IN DIFFERENT JURISDICTIONS. DEPENDING ON THE JURISDICTION, PROFESSIONAL ENGINEERING AND LAND SURVEYING SERVICES ARE PROVIDED BY TEP OPCO LLC, A DELAWARE LIMITED LIABILITY COMPANY, TEP ENGINEERING, LLC, A NORTH CAROLINA PROFESSIONAL LIMITED LIABILITY COMPANY, OR M&H ENGINEERING, LLC, A NEW YORK PROFESSIONAL LIMITED LIABILITY COMPANY. GENERAL CONTRACTOR SERVICES ARE PROVIDED BY TEP OPCO LLC, A DELAWARE LIMITED LIABILITY COMPANY. WE ACQUIRE THE REQUISITE LICENSES IN EACH STATE. ADDITIONAL INFORMATION CAN BE OBTAINED FROM THE COMPANY.

REV.	DESCRIPTION	BY	DATE
A	PRELIMINARY	APM	03/12/25
0	100% CONSTRUCTION	APM	03/20/25
1	100% CONSTRUCTION	SSP	04/22/25

ATC SITE NUMBER: 280251

ATC SITE NAME: SPOUT SPRINGS NC

AT&T MOBILITY SITE NUMBER:

SINC001601

AT&T MOBILITY SITE NAME:

368-389

SITE ADDRESS:
641 NC HWY 24-87
CAMERON, NC 27332-6191



SEAL: 04/22/25




AT&T

DATE DRAWN:	04/22/25
ATC JOB NO:	14884017
CUSTOMER NAME:	368-389
CUSTOMER ID:	SINC001601

ELECTRICAL DETAILS

SHEET NUMBER: E-102	REVISION: 1
-------------------------------	-----------------------


Copyright © 2025 ATC IP LLC. All Rights Reserved.

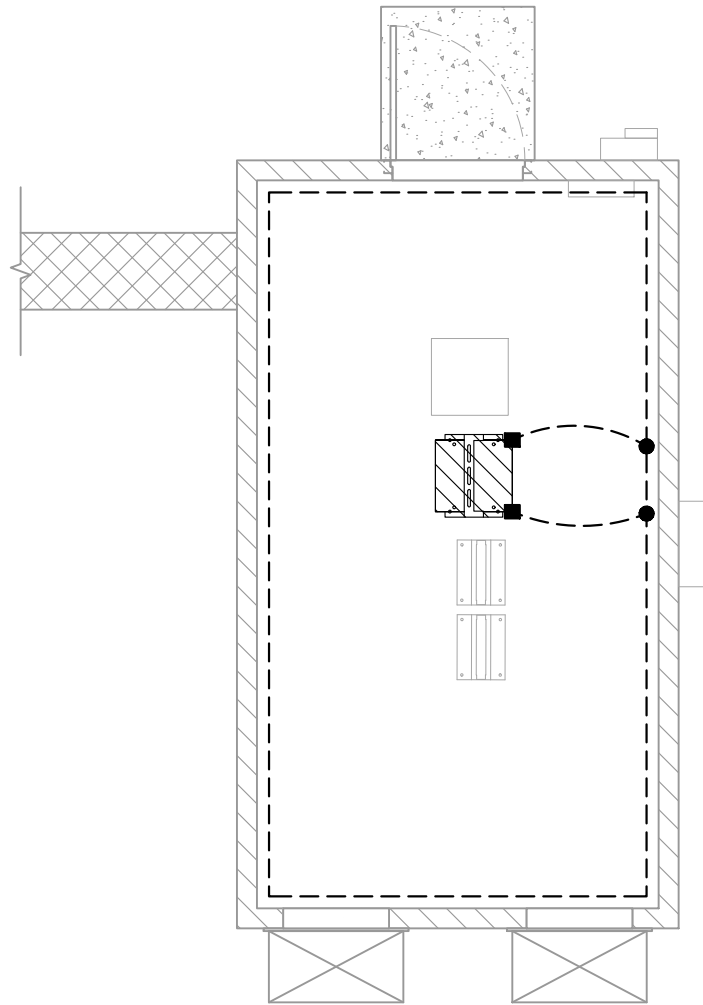

LEGEND	
■	EXOTHERMIC CONNECTION
●	MECHANICAL CONNECTION
▬	ANTENNA GROUND BAR
⌈MGB⌋	MASTER GROUND BAR

1

EQUIPMENT GROUNDING PLAN
SCALE: N.T.S.

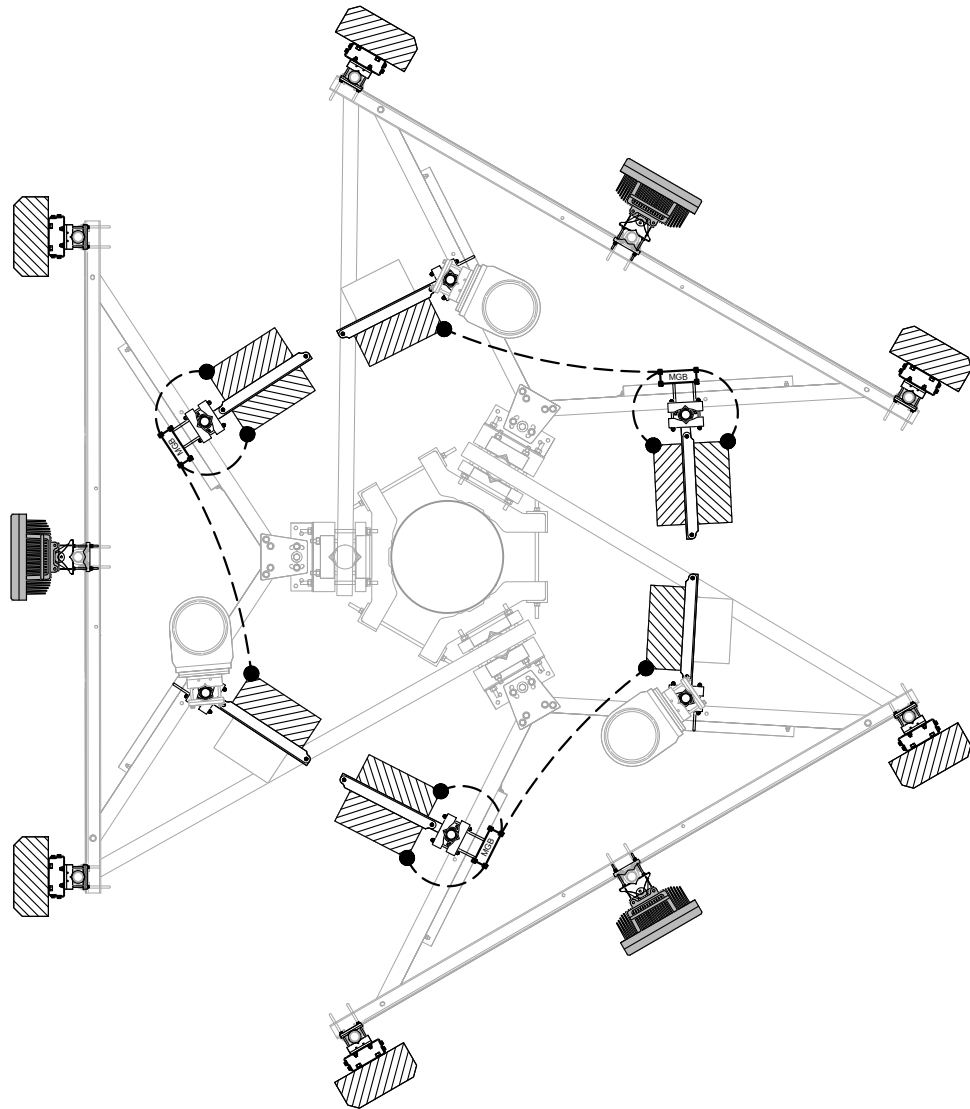

LEGEND	
■	EXOTHERMIC CONNECTION
●	MECHANICAL CONNECTION
▬	ANTENNA GROUND BAR
⌈MGB⌋	MASTER GROUND BAR

2

ANTENNA GROUNDING PLAN
SCALE: N.T.S.



PLANS PREPARED BY:



TEP ENGINEERING, PLLC
326 TRYON ROAD
RALEIGH, NC 27603-3530
OFFICE: (919) 661-6351
www.tepgroup.net
N.C. LICENSE #P-1403

TEP IS A FAMILY OF COMPANIES LICENSED TO PROVIDE DIFFERENT SERVICES IN DIFFERENT JURISDICTIONS. DEPENDING ON THE JURISDICTION, PROFESSIONAL ENGINEERING AND LAND SURVEYING SERVICES ARE PROVIDED BY TEP OPO LLC, A DELAWARE LIMITED LIABILITY COMPANY, TEP ENGINEERING, LLC, A NORTH CAROLINA PROFESSIONAL LIMITED LIABILITY COMPANY, OR M&H ENGINEERING, LLC, A NEW YORK PROFESSIONAL LIMITED LIABILITY COMPANY. GENERAL CONTRACTOR SERVICES ARE PROVIDED BY TEP OPO LLC, A DELAWARE LIMITED LIABILITY COMPANY. WE ACQUIRE THE REQUISITE LICENSES IN EACH STATE. ADDITIONAL INFORMATION CAN BE OBTAINED FROM THE COMPANY.

REV.	DESCRIPTION	BY	DATE
A	PRELIMINARY	APM	03/12/25
0	100% CONSTRUCTION	APM	03/20/25
1	100% CONSTRUCTION	SSP	04/22/25

ATC SITE NUMBER: 280251

ATC SITE NAME: SPOUT SPRINGS NC

AT&T MOBILITY SITE NUMBER:

SINC001601

AT&T MOBILITY SITE NAME:

368-389

SITE ADDRESS:

641 NC HWY 24-87

CAMERON, NC 27332-6191



SEAL:

04/22/25



DATE DRAWN:	04/22/25
ATC JOB NO:	14884017
CUSTOMER NAME:	368-389
CUSTOMER ID:	SINC001601


GROUNDING PLAN

SHEET NUMBER:

E-103

REVISION:


1

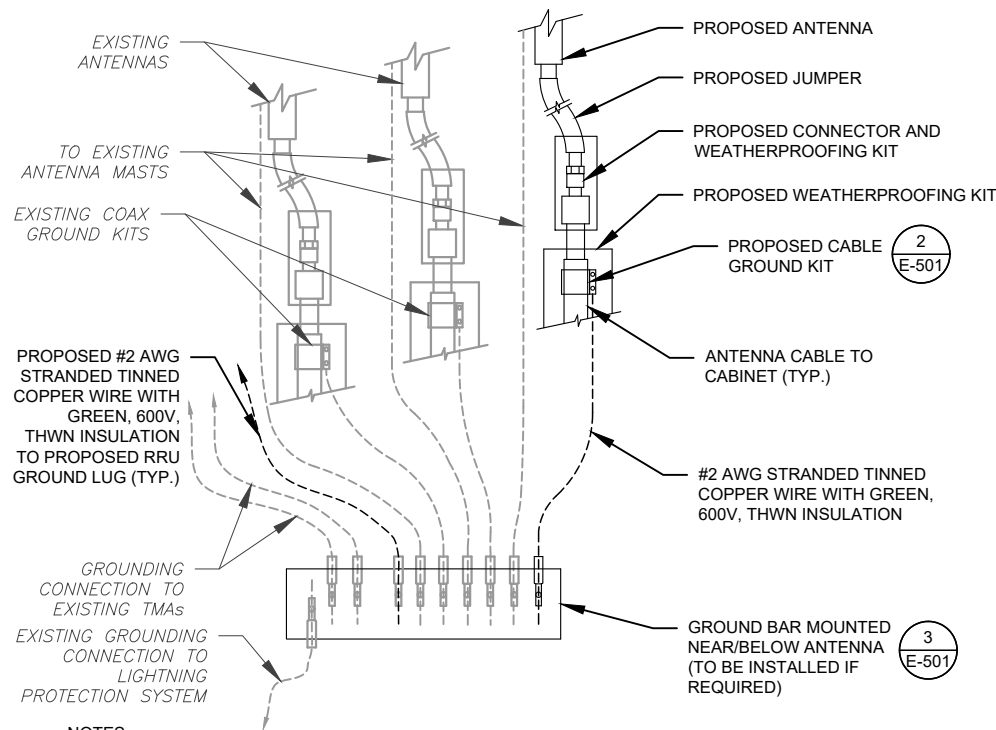

NOTES:

- THIS DETAIL IS INTENDED TO SHOW THE GENERAL GROUNDING REQUIREMENTS. SLIGHT ADJUSTMENTS MAY BE REQUIRED BASED ON EXISTING SITE CONDITIONS. THE CONTRACTOR SHALL MAKE FIELD ADJUSTMENTS AS NEEDED AND INFORM THE CONSTRUCTION MANAGER OF ANY CONFLICTS.
- SITE GROUNDING SHALL COMPLY WITH AT&T MOBILITY GROUNDING STANDARDS, LATEST EDITION, AND COMPLY WITH AT&T MOBILITY GROUNDING CHECKLIST, LATEST VERSION. WHEN NATIONAL AND LOCAL GROUNDING CODES ARE MORE STRINGENT THEY SHALL GOVERN.


1 TYPICAL ANTENNA GROUNDING DIAGRAM
SCALE: N.T.S.

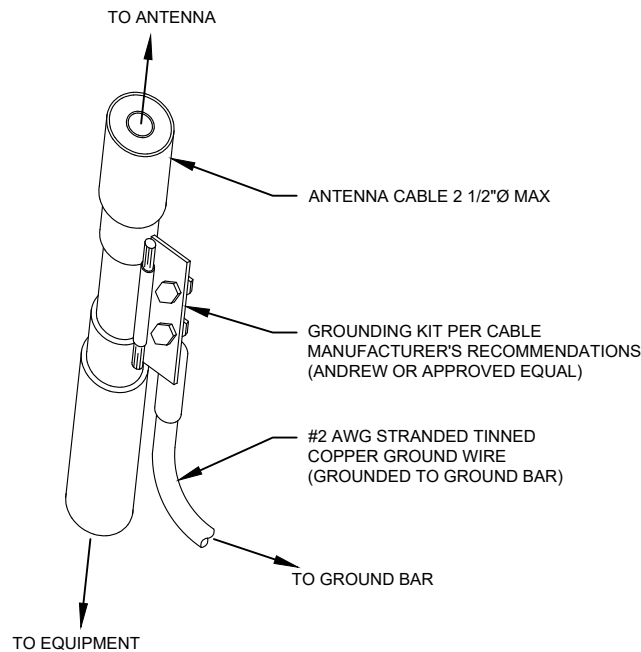

GROUND KIT NOTES:

- DO NOT INSTALL CABLE GROUND KIT AT A BEND AND ALWAYS DIRECT GROUND WIRE DOWN TO GROUND BAR.
- CONTRACTOR SHALL PROVIDE WEATHERPROOFING KIT (ANDREW PART NUMBER 221213) AND INSTALL/TAPE PER MANUFACTURER'S SPECIFICATIONS.


2 CABLE GROUND KIT CONNECTION DETAIL
SCALE: N.T.S.

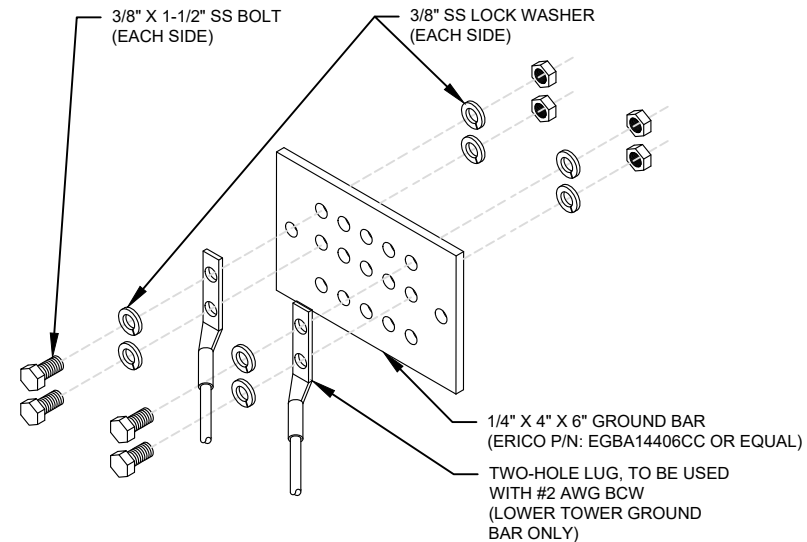

GROUND BAR NOTES:

- GROUND BAR KITS COME WITH ALL HARDWARE, NUTS, BOLTS, WASHERS, ETC. EXCEPT THE STRUCTURAL MOUNTING MEMBER(S).
- GROUND BAR TO BE BONDED DIRECTLY TO TOWER.


3 TOWER GROUND BAR DETAIL
SCALE: N.T.S.

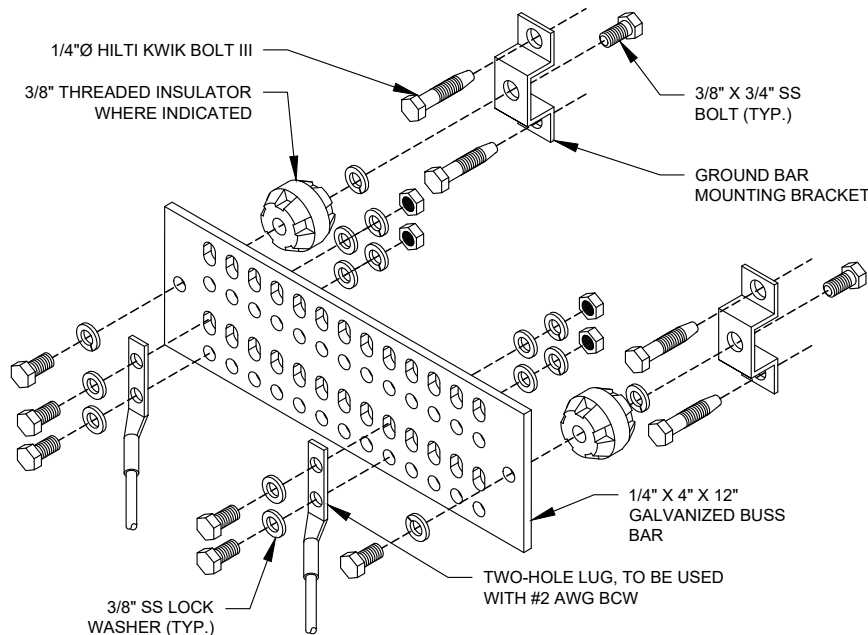


GROUND BAR NOTES

- GROUND KITS COME WITH ALL HARDWARE, NUTS, BOLTS, WASHERS, ETC. EXCEPT THE STRUCTURAL MOUNTING MEMBER(S).
- GROUND BAR SHALL BE BOLTED TO STRUCTURAL MEMBER OR ANCHORED TO CONCRETE SLAB W/ HILTI KWIK BOLT III.

4 MAIN GROUND BAR DETAIL
SCALE: N.T.S.

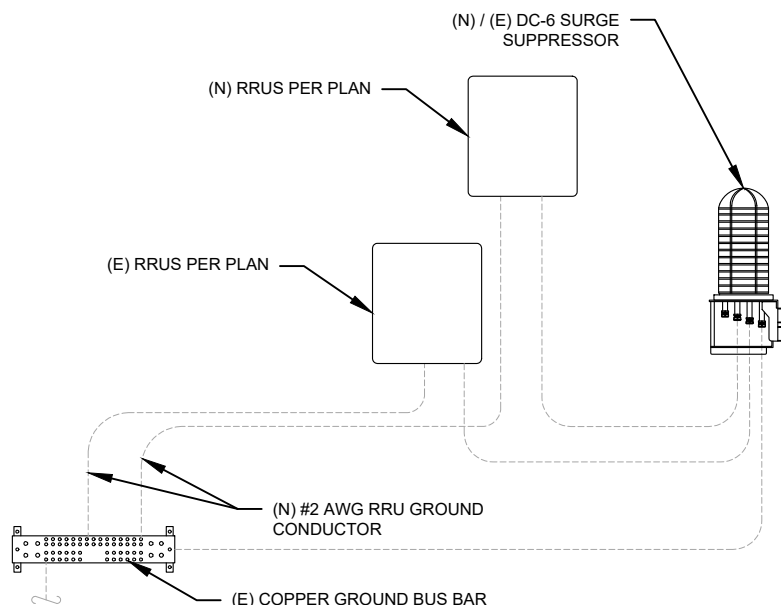

5 RRU GROUNDING
SCALE: N.T.S.

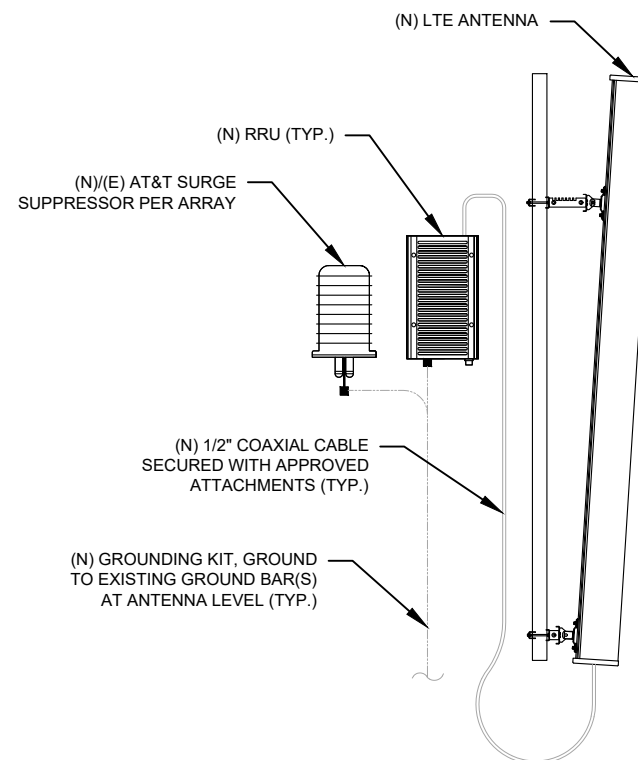

6 ANTENNA/RRU GROUNDING
SCALE: N.T.S.




TEP ENGINEERING, PLLC
326 TRYON ROAD
RALEIGH, NC 27603-3530
OFFICE: (919) 661-6351
www.tepgroup.net
N.C. LICENSE #P-1403

TEP IS A FAMILY OF COMPANIES LICENSED TO PROVIDE DIFFERENT SERVICES IN DIFFERENT JURISDICTIONS. DEPENDING ON THE JURISDICTION, PROFESSIONAL ENGINEERING AND LAND SURVEYING SERVICES ARE PROVIDED BY TEP OPCO LLC, A DELAWARE LIMITED LIABILITY COMPANY, TEP ENGINEERING, LLC, A NORTH CAROLINA PROFESSIONAL LIMITED LIABILITY COMPANY, OR M&H ENGINEERING, LLC, A NEW YORK PROFESSIONAL LIMITED LIABILITY COMPANY. GENERAL CONTRACTOR SERVICES ARE PROVIDED BY TEP OPCO LLC, A DELAWARE LIMITED LIABILITY COMPANY. WE ACQUIRE THE REQUISITE LICENSES IN EACH STATE. ADDITIONAL INFORMATION CAN BE OBTAINED FROM THE COMPANY.

REV.	DESCRIPTION	BY	DATE
A	PRELIMINARY	APM	03/12/25
B	100% CONSTRUCTION	APM	03/20/25
C	100% CONSTRUCTION	SSP	04/22/25

ATC SITE NUMBER: 280251
ATC SITE NAME: SPOUT SPRINGS NC
AT&T MOBILITY SITE NUMBER:
SINC001601
AT&T MOBILITY SITE NAME:
368-389
SITE ADDRESS:
641 NC HWY 24-87
CAMERON, NC 27332-6191

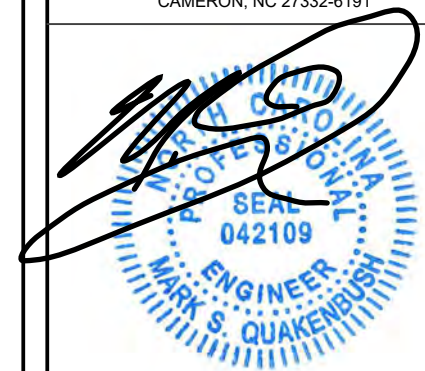


SEAL: 04/22/25




DATE DRAWN:	04/22/25
ATC JOB NO:	14884017
CUSTOMER NAME:	368-389
CUSTOMER ID:	SINC001601

GROUNDING DETAILS	
SHEET NUMBER: E-501	REVISION: 1

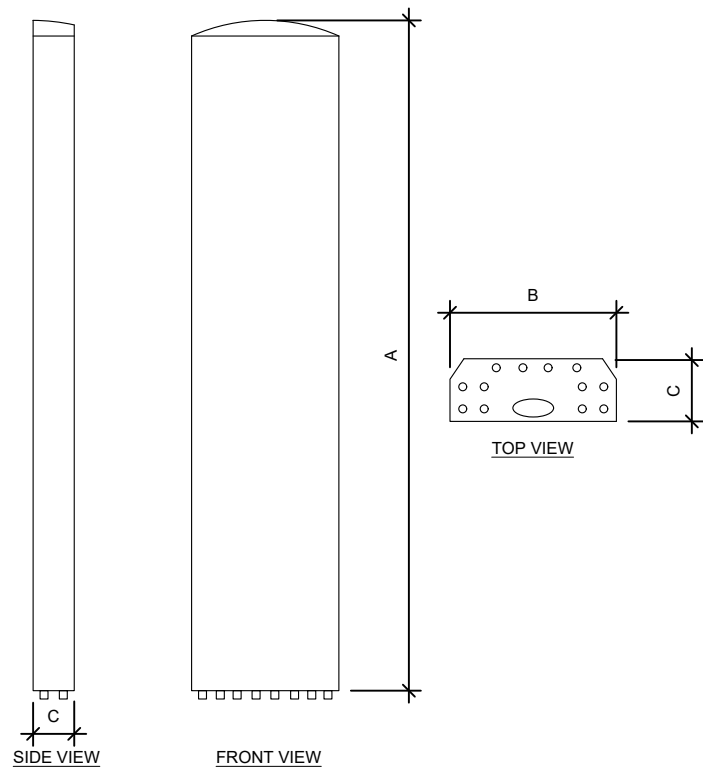

ANTENNA SPECIFICATIONS				
ANTENNA MODEL	A	B	C	WEIGHT (LBS)
840370799	96.0"	14.9"	6.5"	105.8
AIR 6472 B77G B77M	36.3"	15.8"	7.4"	67.2

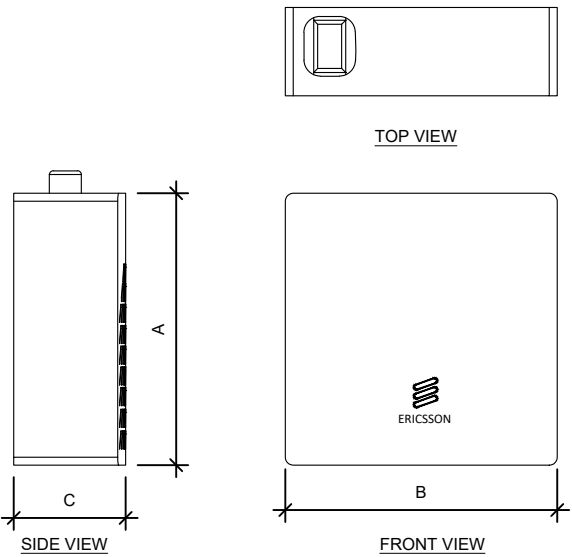

RRU SPECIFICATIONS				
RRU MODEL	A	B	C	WEIGHT (LBS)
RADIO 4490 B5/B12A	20.6"	15.6"	7.0"	65.0
RADIO 4890 B25/B66	17.5"	15.2"	6.9"	68.0
RADIO 4494 B14/B29	17.5"	15.1"	5.6"	57.3

Vertiv™ NetSure™ 7100 Series

-48V DC Power System – 20 kW to 600 kW



Vertiv™ NetSure™ 7100 Series



Key Benefits

- Effectively power a variety of equipment types with -48VDC rectifiers, -58VDC or +24VDC converters and 120VAC inverters, all from one power system.
- Actively manage and monitor system performance, battery health, and generator operation using the NetSure controller platform across your entire network.
- Minimize upfront cost by incrementally increasing capacity as needed.
- Easily migrate from -48V to -58V or +24V DC equipment or vice-versa with multi-purpose rectifier/converter slots and field adjustable split bus dual voltage breaker panels.
- Lower energy consumption and reduce cost of ownership with high-efficiency eSure rectifiers and converters.
- Securely manage your site power with optional HTTPS and SNMPv3 encryption, as well as RADIUS User Authentication.
- Easily monitor and adjust system parameters with a simple, graphic user interface accessed through an on-board color display or web pages supported by all major browsers.

Versatile DC power solution with high efficiency eSure™ rectifiers, converters and inverters, modular distribution, and advanced control and monitoring accepts single or three-phase input up to 277/480 VAC.

Description

Vertiv™ NetSure™ 7100 Series DC power systems with high efficiency eSure™ rectifiers, converters and inverters, modular distribution, and advanced control and monitoring are designed to accept single or three-phase input up to 277/480 VAC for a wide range of access, edge and core network applications. Available with 3500 or 2000 watt rectifiers, 2000 watt peak -48V to -58V DC to DC converters or 1500 watt -48V to +24V DC to DC converters, 1000 watt inverters, and a NetSure controller, these systems deliver up to 12,000 amps of current at -48V, up to 520 amps at -58V DC or +24V DC and up to 12kVA at 120VAC. Modular distribution panels, mounting shelves for rectifiers, converters and inverters, batteries and battery trays can be housed in an indoor enclosure or relay rack.

Each shelf can accommodate up to six plug'n'play rectifiers, which are controlled by the NCU. Additional shelves can be added as load requirements increase. The rectifiers, DC to DC converters and inverters are housed in shelves that occupy 1 RU. Each shelf accommodates rectifiers in all six positions and converters in three positions. Inverters are housed in separate shelves that accommodate six inverters each.

The NetSure 7100 can be expanded to up to six distribution bays for a total capacity of 12,000 amps and up to 24 distribution panels. Each NetSure 7100 distribution cabinet is modular by row and position.



High-Efficiency eSure™ Rectifiers & Inverter
R48-3500e3 (left), 1120-1000 (center)
& R48-2000e3 (right)



NetSure™ 7100

Four distinct distribution cabinet sizes are available to accommodate from one to four distribution panels. This allows the system to be configured in relay racks of various heights for installation in low-profile sites or atop batteries or other equipment to make more effective use of floor space. Several distribution panels are available offering different combinations of distribution positions, low voltage disconnect and battery disconnect options.

Distribution device options include 1 amp to 300 amp bullet-style circuit breakers, 3 amp to 125 amp TPS-style fuses in plug-in bullet-style holders, 100 amp to 800 amp GJ/218-style circuit breakers, and 70 amp to 600 amp TPH-style fuses. These devices can be configured for both -48V load and battery disconnect and -58V or +24V load (bullet devices only). A GMT fuse module is also available.

The 120VAC inverter option is available at 6kVA (2RU total) or 12kVA (4RU total). Output is provided as either bulk via 70 amp breakers or NEMA receptacles at 15 amps each.

Application

The NetSure 7100 system is ideal for wireless, and wireline applications, including cell sites, MTSOs, small COs, datacenters, co-locations, huts, vaults and enclosures.

Technical Specifications (System)

System Features

System Voltage, Nominal	-48 VDC (-42.0 VDC to -58.0 VDC range)
Output Voltage, Secondary	-58 VDC (-56.0 VDC to -58.0 VDC range) or +24 VDC (+24.0 VDC to +28.0 VDC range)
Output Voltage, Inverter	120VAC nominal
Input Voltage	Single Phase: 208/240/277 VAC (277 VAC for 3500 W rectifiers only) Three Phase: 208 VAC or 277/480 VAC (277/480 VAC for 3500 W rectifiers only)
Control	Microprocessor (NCU)

Rated Output Capacity

Bay - Rectifier, Converter, Inverter	2500 amps (-48VDC), 520 amps (-58VDC or +24VDC), 6kVA or 12kVA (120VAC)
Bay, Distribution	2000 amps (-48 VDC) and 520 amps (-58 VDC or +24 VDC), 6kVA or 12kVA (120VAC)
Rectifier	3500 W (R48-3500e3 or R48-3500) or 2000 W (R48-2000e3)
Shelf	438 amps (3500W rectifiers) or 250 amps (2000W rectifiers)
Distribution Panel	600 amps

Physical Characteristics


Framework Type	Rail-mount (can be mounted in an enclosure or relay rack)
Mounting Width	23 inches
Mounting Depth	20 inches, 9 inch front projection
Access	Front access for installation, operation and maintenance

Environmental

Operating Temperature	-40 °F to 104 °F (-40 °C to 40 °C) continuous operation
Storage	-40 °F to 185 °F (-40 °C to 85 °C)
Humidity	0% to 95% relative humidity, non-condensing
Ventilation	Rectifiers and converters are fan-cooled front to rear
EMI/RFI Suppression	Conforms to FCC rules Part 15, Subpart B, Class B and EN55022 Class B, radiated and conducted
Safety Compliance	UL Listed 1801, cUL, NEBS Level 3

Ordering Information

Part Number	Description
582127000	NetSure™ 7100 DC power system
1M830DNA	NCU controller
1R483500E3	3500 W eSure rectifier, 1RU height
1R483500E	3500 W eSure™ rectifier, 3RU height
588705400	Power shelf for 1 RU 3500 W rectifiers
1R482000E3	2000 W eSure rectifier, 1RU height
1C48582000P3	2000 W peak, 1600 W average -48 VDC to -58 VDC converter
1C48241500	1500 W -48 VDC to +24 VDC converter
588705300	Power shelf for 1 RU (2000 W) rectifiers and converters
11201000	1000VA Inverter, 1RU height

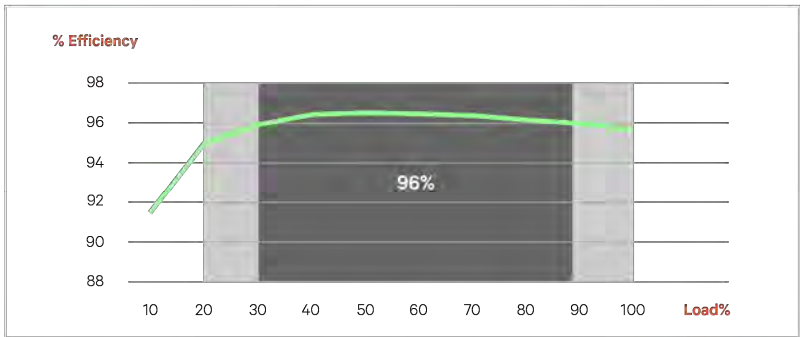

R48-3500e3 Efficiency Curve at 230 VAC Nominal

System Elements



-48 VDC NetSure™ 7100

1. AC Connection Panel (both sides)
2. DC Distribution Cabinet
3. NetSure Control Unit
4. Rectifiers/Converters
5. Relay Rack or Enclosure
6. Inverters

Vertiv.com | Vertiv Headquarters, 505 N Cleveland Ave, Westerville, OH 43082, USA

© 2024 Vertiv Group Corp. All rights reserved. Vertiv™ and the Vertiv logo are trademarks or registered trademarks of Vertiv Group Corp. All other names and logos referred to are trade names, trademarks or registered trademarks of their respective owners. While every precaution has been taken to ensure accuracy and completeness here, Vertiv Group Corp. assumes no responsibility, and disclaims all liability, for damages resulting from use of this information or for any errors or omissions. Specifications, rebates and other promotional offers are subject to change at Vertiv's sole discretion upon notice.

DC-00169 Rev.1-03/24

eSure™ Rectifier

R48-2000e3



eSure™ Rectifier



Benefits


- Optimize the amount of energy delivered and reduce power consumption with over 96% efficiency.
- Increase space for revenue generating equipment with modules that pack more power in a small space with high power density.
- Facilitate easy maintenance, expansion and system changes with hot swappable capabilities.
- Enjoy increased reliability and active load sharing with Digital Signal Processing (DSP) which translates into fewer components and optimized operation.
- Appreciate the flexibility to utilize in a variety of applications with a wide input voltage range of 85 VAC to 300 VAC and full power output at temperatures from -40°C to +65°C.

In addition to reducing power consumption and lowering operating cost, eSure™ high-efficiency rectifiers offer superior performance and uncompromised reliability.

Description

The 2000 watt high-efficiency eSure rectifier (model R48-2000e3) converts standard AC supply voltages into stable nominal -48 VDC voltage that is adjustable to application needs. This constant power rectifier designed with the latest patented switch-mode technology, uses DSP (Digital Signal Processing) for efficient operation.

The R48-2000e3 can be connected in parallel with other rectifiers and converters to support a variety of telecom applications. Unified remote management and control of the power system is enabled when combined with a Vertiv™ controller.

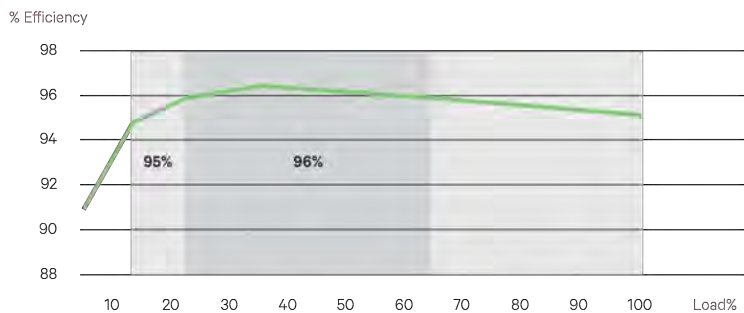

R48-2000e3 Efficiency Curve at 250 VAC Nominal

Technical Specifications

AC Input		R48-2000E3
Voltage		85 VAC to 300 VAC (see figure 1), 187 VAC to 264 VAC (nominal)
Frequency		45 Hz to 65 Hz
Maximum Current		12 A
Power Factor		>0.99 from 50 to 100% load
Protection		High and low voltage protection, surge and lightning protection Adapts to poor quality grid (voltage dip, weak mains) Disconnection at 415 VAC Mains fuses in both lines
DC Output		
Voltage		-42 VDC to -58 VDC
Maximum Power		2000 W
Maximum Current		42 A @ -48 VDC, limit set point 0 to 42 A (see figure 2)
Peak Efficiency		96.2%
Protection		Fuse for reverse connection and back feeding protection High voltage shutdown High temperature protection
Control and Monitoring		
Converter Alarm and Signaling		Alarm and status reported via CAN bus to system controller
Visual Indications		Green LED: Normal Operation Yellow LED: Alarm Red LED: Failure
Environmental		
Operating		-40°C to 80°C / -40°F to +176°F (see figure 3 for derating)
Temperature Derating		Full output power up to +65°C at input voltage range 200 to 250 VAC (see figure 3)
Storage		-40°C to +70°C / -40°F to +158°F
Relative Humidity		0 to 95%
Altitude		Full output power up to +65°C at input voltage range @200~ 250 VAC
Standards Compliance		
Safety		60950-1 (EN, IEC and UL)
EMC		EN55022, CISPR22, ETSI EN300 286: 2005, FCC CFR 47 Part 15, Telcordia GR-1089-CORE Issue 6 (Class B conducted and radiated)
Environment		REACH, RoHS, WEEE
Mechanics		
Dimensions (H x W x D)		41 x 84.5 x 252.5 (mm) / 1.61 x 3.33 x 9.94 (inches)
Weight		1.13 kg / 2.49 lbs

Ordering Information

Model Number	Description
1R482000E3	eSure™ rectifier, -48 VDC, 2000 W

Vertiv.com | Vertiv Headquarters, 1050 Dearborn Drive, Columbus, OH, 43085, USA

© 2020 Vertiv Group Corp. All rights reserved. Vertiv™ and the Vertiv logo are trademarks or registered trademarks of Vertiv Group Corp. All other names and logos referred to are trade names, trademarks or registered trademarks of their respective owners. While every precaution has been taken to ensure accuracy and completeness here, Vertiv Group Corp. assumes no responsibility, and disclaims all liability, for damages resulting from use of this information or for any errors or omissions. Specifications, rebates and other promotional offers are subject to change at Vertiv's sole discretion upon notice.

R48-2000E3 (R06/20)

Figures

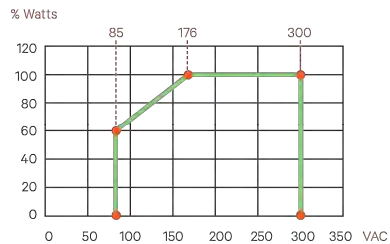


Figure 1: Output Power vs. Input Voltage and Vo > 48 V at Tamb < 55°C

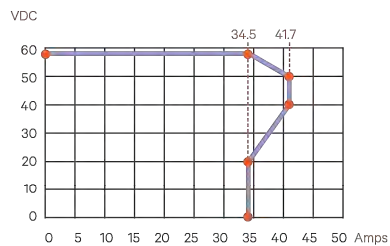


Figure 2: Output Voltage vs. Output Current at Maximum Output Power 2000 W

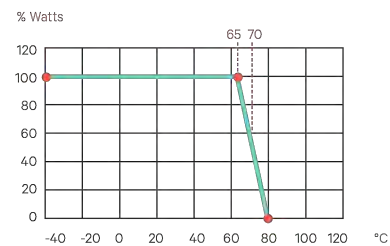


Figure 3: Output Power vs. Temperature at Uin > 200VAC

SUPPLEMENTAL

SHEET NUMBER:

R-603

REVISION:

-

Vertiv™ eSure™ Converter
C48/58 -2000P3



Vertiv™ eSure™ Converter



Key Benefits

Converter, 48 to 58 VDC,
2000 W Peak / 1600 W Average


- Reduce power consumption and lower operating costs with 95% peak efficiency.
- Easily add capacity with hot pluggable interchangeable components.
- Ensure high availability with wide input voltage range from 41 VDC to 58 VDC.
- Power your 5G sites in the harsh environments with operation from -40°C to +65°C.
- Enjoy peace of mind with high quality UL recognized design.

Easily support higher power 5G remote radios on cell towers with modular 2000 watt eSure™ power extend converters.

Description

The Vertiv™ eSure™ C48/58-2000P3 high-efficiency converter is designed to operate from a nominal -48 VDC source to provide nominal -58 VDC load power, which is adjustable to application needs up to 2000 watts peak, 1600 watts average. This constant power converter designed with the latest patented switchmode technology, uses digital signal processing (DSP) for efficient operation.

The eSure C48/58-2000P3 DC to DC converter is ideal for feeding high power remote radio heads (RRHs). 58 VDC is regulated over a wide input range to minimize voltage drop in the cable feeding the RRH and sustain operation to end of battery discharge. When redundancy is critical or loads are high, multiple eSure C48/58-2000P3 converters can be connected in parallel to support a variety of telecom applications. Unified remote management and control of the power system is enabled when combined with a Vertiv™ NetSure™ controller.

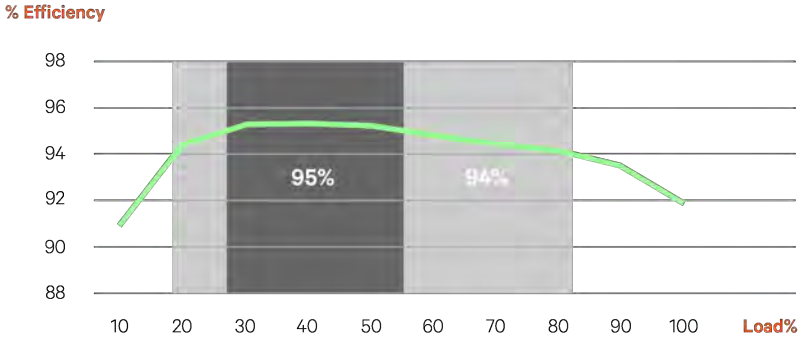

C48/58-2000P3 Efficiency Curve at 53.5 VDC Nominal Input

Technical Specifications

DC Input	C48/58-2000P3
Voltage	41 VDC to 58.5 VDC, 48 VDC (nominal)
Maximum Current	53 A
DC Output	
Voltage	56 VDC to 58 VDC
Maximum Power	2000 W peak, 1600 W average at 40°C, 1280 W average at 65°C
Maximum Current	35.7 A at 2000 W peak (see figure 1), 28.6 A at 1600 W average, 22.9 A at 1280 W average, all at 56 VDC
Peak Efficiency	>95%
Noise	< 250mV pk-pk; < 20mV rms; <38 dBmC
Control and Monitoring	
Alarms and Signaling	Alarm and status reported via CAN bus to system controller
Visual Indications	Green LED: Normal Operation Yellow LED: Alarm Red LED: Failure Flashing Red LED: Fan Failure
Environmental	
Operating Temperature	-40°C to +80°C / -40°F to +176°F (see figure 2)
Storage Temperature	-40°C to +85°C / -40°F to +185°F
Relative Humidity	0 to 90%
Altitude	2000 m / 6560 ft at full power
Standards Compliance	
Safety	UL62368-1, EN62368-1, IEC62368-1
EMC	FCC CFR 47 Part 15 Class A conducted and Class B radiated
Environment	REACH, RoHS
Mechanics	
Dimensions (H x W x D)	41 x 84.5 x 252.5 mm / 1.61 x 3.33 x 9.94 inches
Weight	113 kg / 249 lbs

Ordering Information

Part Number	Description
1C48582000P3	eSure™ converter, -48 to -58 VDC, 2000 W peak / 1600 W average

Vertiv.com | Vertiv Headquarters, 1050 Dearborn Drive, Columbus, OH, 43085, USA

© 2024 Vertiv Group Corp. All rights reserved. Vertiv™ and the Vertiv logo are trademarks or registered trademarks of Vertiv Group Corp. All other names and logos referred to are trade names, trademarks or registered trademarks of their respective owners. While every precaution has been taken to ensure accuracy and completeness here, Vertiv Group Corp. assumes no responsibility, and disclaims all liability, for damages resulting from use of this information or for any errors or omissions. Specifications, rebates and other promotional offers are subject to change at Vertiv's sole discretion upon notice.

C48/58-2000P3 (02/2024)

Figures

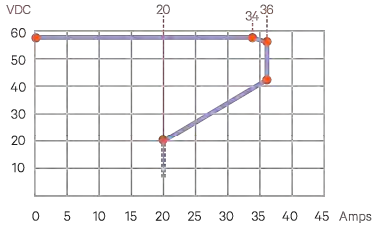


Figure 1: Output Voltage vs. Output Current at Maximum peak Power 2000 W

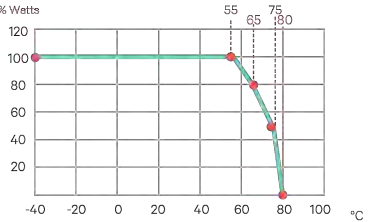


Figure 2: Output Power vs. Temperature at -41VDC ≤ Vin ≤ -58VDC

Pxxx: Bulk Pipe



Part #	Length	OD x Length (in)
Schedule 40		
P260	5'-0"	2-3/8" x 60"
P263	5'-3"	2-3/8" x 63"
P272	6'-0"	2-3/8" x 72"
P284	7'-0"	2-3/8" x 84"
P296	8'-0"	2-3/8" x 96"
P2108	9'-0"	2-3/8" x 108"
P2120	10'-0"	2-3/8" x 120"
P2126	10'-6"	2-3/8" x 126"
P2150	12'-6"	2-3/8" x 150"
P2174	14'-6"	2-3/8" x 174"
P2252	21'-0"	2-3/8" x 252"
P3072	6'-0"	2-7/8" x 72"
P3084	7'-0"	2-7/8" x 84"
P3096	8'-0"	2-7/8" x 96"
P30108	9'-0"	2-7/8" x 108"
P30120	10'-0"	2-7/8" x 120"
P30126	10'-6"	2-7/8" x 126"
P30150	12'-6"	2-7/8" x 150"
P30174	14'-6"	2-7/8" x 174"
P30252	21'-0"	2-7/8" x 252"
P360	5'-0"	3-1/2" x 60"
P372	6'-0"	3-1/2" x 72"
P384	7'-0"	3-1/2" x 84"
P396	8'-0"	3-1/2" x 96"
P3150	12'-6"	3-1/2" x 150"
P3160	13'-4"	3-1/2" x 160"
P3174	14'-6"	3-1/2" x 174"
P3216	18'-0"	3-1/2" x 216"
P3252	21'-0"	3-1/2" x 252"
P472	6'-0"	4-1/2" x 72"
P4126	10'-6"	4-1/2" x 126"
P4252	21'-0"	4-1/2" x 252"



- Features:**
- Factory cut end, hot-dip galvanized pipe
- Construction:**
- ASTM A53 Grade B
 - Schedule 40 or Schedule 80
- Design Criteria:**
- ASTM A53 Grade B (Yield Fy = 35 ksi [240 MPa]/ Tensile Fu = 60 ksi [415 MPa])
 - Hot dip galvanized in accordance with ASTM A123 requirements

Part #	Length	OD x Length (in)
Schedule 80		
P2252-80	21'	2-1/2" x 252"
P30126-80	10'-6"	2-7/8" x 126"
P30252-80	21'	2-7/8" x 252"
P3252-80	21'	3-1/2" x 252"

created on: 03/09/2023

SitePro1.com

888-438-7761


1

PROPOSED PIPE MOUNT DETAIL
SCALE: N.T.S.

Pxxx: Bulk Pipe



Part #	Length	OD x Length (in)
Schedule 40		
P260	5'-0"	2-3/8" x 60"
P263	5'-3"	2-3/8" x 63"
P272	6'-0"	2-3/8" x 72"
P284	7'-0"	2-3/8" x 84"
P296	8'-0"	2-3/8" x 96"
P2108	9'-0"	2-3/8" x 108"
P2120	10'-0"	2-3/8" x 120"
P2126	10'-6"	2-3/8" x 126"
P2150	12'-6"	2-3/8" x 150"
P2174	14'-6"	2-3/8" x 174"
P2252	21'-0"	2-3/8" x 252"
P3072	6'-0"	2-7/8" x 72"
P3084	7'-0"	2-7/8" x 84"
P3096	8'-0"	2-7/8" x 96"
P30108	9'-0"	2-7/8" x 108"
P30120	10'-0"	2-7/8" x 120"
P30126	10'-6"	2-7/8" x 126"
P30150	12'-6"	2-7/8" x 150"
P30174	14'-6"	2-7/8" x 174"
P30252	21'-0"	2-7/8" x 252"
P360	5'-0"	3-1/2" x 60"
P372	6'-0"	3-1/2" x 72"
P384	7'-0"	3-1/2" x 84"
P396	8'-0"	3-1/2" x 96"
P3150	12'-6"	3-1/2" x 150"
P3160	13'-4"	3-1/2" x 160"
P3174	14'-6"	3-1/2" x 174"
P3216	18'-0"	3-1/2" x 216"
P3252	21'-0"	3-1/2" x 252"
P472	6'-0"	4-1/2" x 72"
P4126	10'-6"	4-1/2" x 126"
P4252	21'-0"	4-1/2" x 252"

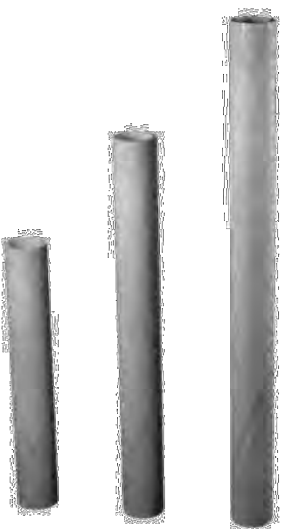

- Features:**
- Factory cut end, hot-dip galvanized pipe
- Construction:**
- ASTM A53 Grade B
 - Schedule 40 or Schedule 80
- Design Criteria:**
- ASTM A53 Grade B (Yield Fy = 35 ksi [240 MPa]/ Tensile Fu = 60 ksi [415 MPa])
 - Hot dip galvanized in accordance with ASTM A123 requirements

Part #	Length	OD x Length (in)
Schedule 80		
P2252-80	21'	2-1/2" x 252"
P30126-80	10'-6"	2-7/8" x 126"
P30252-80	21'	2-7/8" x 252"
P3252-80	21'	3-1/2" x 252"

created on: 03/09/2023

SitePro1.com

888-438-7761

2

PROPOSED PIPE MOUNT DETAIL
SCALE: N.T.S.

NOTE: THIS SHEET WAS CREATED BY OTHERS AND PROVIDED AT THE REQUEST OF THE CUSTOMER WITHOUT EDIT.

SUPPLEMENTAL


SHEET NUMBER:

R-605

REVISION:

1

U-bolts

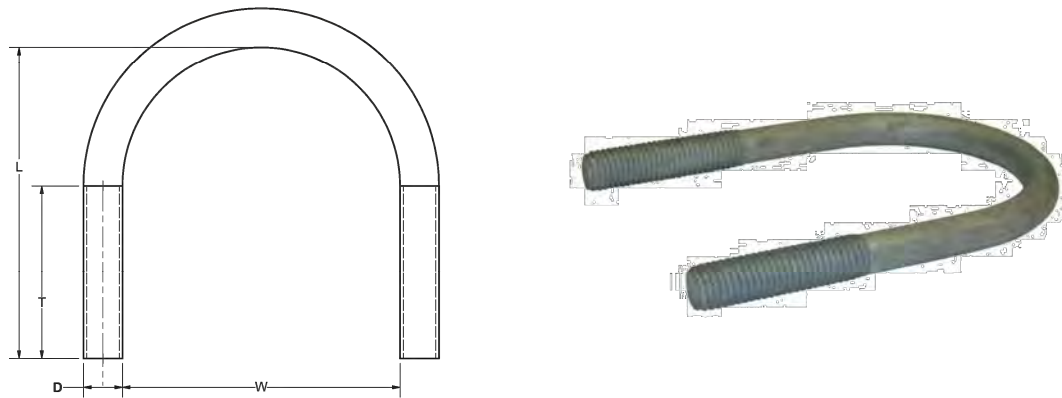

Features: Includes nuts, locks, and flat washers, long thread lengths. Hot-dip galvanized.

Construction: SAE J429 Gr. 2. Coarse threads.

Design Criteria: Conforms to the minimum requirements as stated in SAE J429 (Latest Revision) Grade 2 Stud, Rolled or Cut CNC threads. SAE J429 Grade 2 (Yield Fy = 57 ksi / Tensile Fu = 74 ksi). All finished goods are Hot Dip Galvanized in accordance with ASTM A123 requirements.

Part #	Diameter (D)	Width (W)	Length (L)	Thread (T)	Weight
UB3200	3/8"	2"	3"	1-1/4"	0.40 lb.
UB3212	3/8"	2-1/2"	3-5/8"	1-3/4"	0.45 lb.
UB3300	3/8"	3"	4-1/4"	2"	0.50 lb.
UB3312	3/8"	3-1/2"	4-3/4"	2"	0.50 lb.
UB3418	3/8"	4"	5-3/4"	2-1/2"	0.60 lb.
UB1400	1/2"	2"	4"	2"	0.65 lb.
UB1212	1/2"	2-1/2"	4-1/2"	2"	0.65 lb.
UB1300	1/2"	3"	5"	2"	0.70 lb.
UB1358	1/2"	3-5/8"	5-1/2"	3"	0.75 lb.
UB1306	1/2"	3-5/8"	6"	3"	0.80 lb.
UB1418	1/2"	4-1/8"	6"	3"	0.90 lb.
UB1458	1/2"	4-5/8"	7"	3"	0.90 lb.
UB5258	5/8"	2-5/8"	4-1/2"	2"	1.20 lb.
UB5358	5/8"	3-5/8"	6"	3"	1.45 lb.
UB5458	5/8"	4-5/8"	7"	3"	1.60 lb.



New York, NY
888-438-7761

Los Angeles, CA
888-776-1937

Salem, OR
888-880-9191

Atlanta, GA
866-901-0603

Plymouth, IN
888-753-7446

Dallas, TX
888-809-5151

1 PROPOSED U-BOLT DETAIL


SCALE: N.T.S.

NOTE: THIS SHEET WAS CREATED BY OTHERS AND PROVIDED AT THE REQUEST OF THE CUSTOMER WITHOUT EDIT.

SUPPLEMENTAL

SHEET NUMBER:
R-607

REVISION:
-

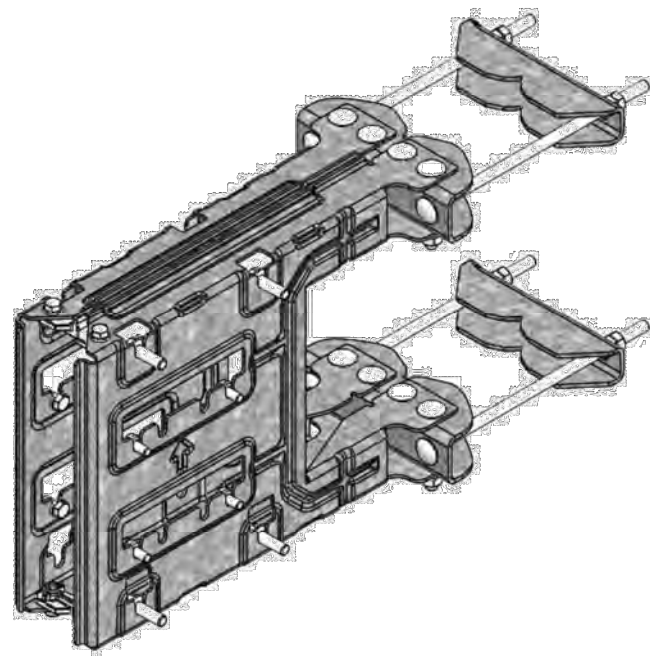

SXK 125 5394/2

Universal B2B Bracket CC110


Universal B2B Bracket CC110 is designed for installation of back to back ERS on any supporting structure i.e. pole, mast, tower leg etc. It is Low PIM bracket. When installed properly, it meets the requirements of installation in High Risk PIM Zones. Static and dynamic testing was conducted as per IEC 61000-4-3: 2020 PRV and ITU-R SM-329.

Robustness

The Universal B2B Bracket CC110 kit supports for installation of back to back ERS weight upto 50 kg on each side simultaneously. It supports the ERS mounting on pole, mast, tower leg or square tube. Easy installation due to use of carriage bolts for mounting on the supporting structure and key holes for ERS in the bracket. Bush separators has been provided to avoid any contact of arms with each other.

Quality

All components of the assembly are made of galvanized High Tensile Steel, which supports corrosion resistance.

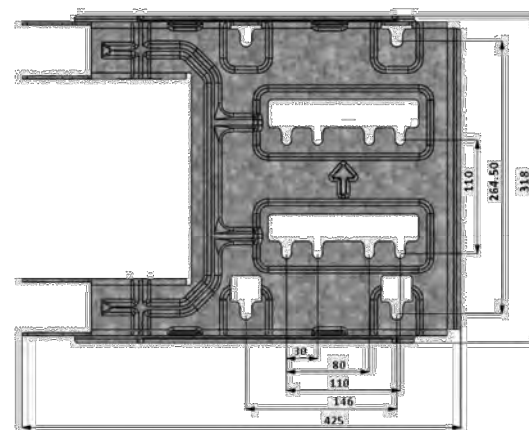

Technical specification

Functional Description

SXK 125 5394/2

Universal B2B Bracket CC110 kit supports installation of ERS back to back with Centre to Centre distance of 30mm x 110mm, 80mm x 110mm and 110mm x 110mm. It also supports two RRUs (back to back) with Centre to Centre distance of 146mm x 264.5 mm (old generation ERS). ERS or RRU are mounted back to back in portrait position on any supporting structure with ERS or RRU weight up to 50kg on each side.



Product	Universal B2B Bracket CC110				
Product number	SXK 125 5394/2				
Mounting range	Profile	Minimum		Maximum	
	Circular tube	Ø25 mm (1 inch)		Ø120 mm (4.7 inch)	
	60° Angle	35 mm Opening (1.4 inch)		115 mm Opening (4.5 inch)	
	90° Angle	35 x 35 mm (1.4 X 1.4 inch)		112 x 112 mm (4.4 X 4.4 inch)	
	Square tube	35 x 35 mm (1.4 X 1.4 inch)		80 x 80 mm (3.1 X 3.1 inch)	
Mechanical specification	Brackets	High Tensile Steel, Galvanized			
	Fasteners	Grade 8.8 Galvanized & A4			
	Bush Separators	Composite material(PBT+PET)-GF30			
Recommended tools	M8 ISO, 13mm torque wrench (10-22 Nm)				
	M10 ISO, 16mm & 17mm torque wrench (15-25 Nm)				
Performance	Maximum wind speed		67 m/s (240 km/h, 149 mph)		
	Survival wind speed		90 m/s (324 Km/h, 201 mph)		
	Maximum equipment weight		2 x 50 Kg (2 x 110.2 lbs)		
Packaging dimension	Length	Width	Height	Package Weight	Product Weight
Universal B2B Bracket CC110 (SXK 125 5394/2)	480 mm (18.9 in)	360 mm (14.2 in)	80 mm (3.2 in)	10.4 Kg (22.9 lbs)	10.0 Kg (22.0 lbs)



Mount Analysis Report

Mount Type : 10.5 ft Sector Frame
ATC Asset Name : SPOUT SPRINGS NC
ATC Asset Number : 280251
Engineering Number : 14884017_C8_02
Mount Elevation : 190.5 ft
Proposed Carrier : AT&T Mobility
Carrier Site Name : 368-389
Carrier Site Number : WSVWN0054969
Site Location : 641 NC Hwy 24-87
Cameron, NC 27332-6191
35.264775, -79.048239
County : Harnett
Date : March 5, 2025
Max Usage : 100%
Analysis Result : Contingent Pass

Prepared By:
Zach Stoll
Structural Engineer I



Isaac
Dodson

Digitally signed
by Isaac Dodson
Date: 2025.03.05
15:57:15 -05'00'

Introduction

The purpose of this report is to summarize results of the mount analysis performed for AT&T Mobility at 190.5 ft.

Supporting Documents

Specifications Sheet:	Kenwood T1672KT10, dated April 6, 2016
Radio Frequency Data Sheet:	RFDS ID #12626511, dated October 4, 2024
Reference Photos:	Site photos from 2022

Analysis

This mount was analyzed using American Tower Corporation’s Mount Analysis Program and RISA-3D

Basic Wind Speed:	118 mph (3-Second Gust)
Basic Wind Speed w/ Ice:	37 mph (3-Second Gust) w/ 0.62" radial ice concurrent
Codes:	ANSI/TIA-222-I
Exposure Category:	C
Risk Category:	II
Topographic Factor Procedure:	Method 1
Feature:	Flat
Crest Height (H):	0 ft
Crest Length (L):	0 ft
Spectral Response:	Sds = 0.18, Sd1 = 0.11
Site Class:	D - Stiff Soil
Live Loads:	Lm = 500 lbs, Lv = 250 lbs

*Live Load(s) reduction is confirmed to either not govern or not be applicable

Conclusion

Based on the analysis results, the antenna mount meets the requirements per the applicable codes listed above provided the modifications listed below are completed:

- Install P2 (2.375" x 120") in mount pipe position MA1 and MA2. Connect with Site Pro 1 HMB-AU (or approved equivalent) U-Bolts.
- Replace mount pipe in positions 1 and 3 with P2 (2.375" x 120"). Connect with Site Pro 1 UB1212 (or approved equivalent) U-Bolts.
- Replace mount pipe in position 2 with P2.5 (2.875" x 120"). Connect with Site Pro 1 UB1300 (or approved equivalent) U-Bolts.
- No structural failures were addressed with the noted contingencies. Contingencies address Carrier's antenna spacing requirements.
- The rough cost estimate, pre-MOD design, is estimated to be ≤\$10k.

If you have any questions or require additional information, please reach out to your American Tower contact. If you do not have an American Tower contact and have an Engineering question, please contact MountAnalysis@americantower.com. Please include the American Tower site name, site number, and engineering number in the subject line for any questions.

COA: P-1177

SUPPLEMENTAL

SHEET NUMBER:	REVISION:
R-609	-