


ENGINEER:

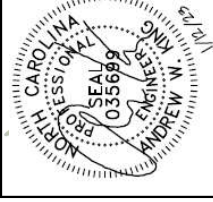

MODEL ENERGY
 300 FAYETTEVILLE ST.
 #11430
 RALEIGH, NC 27602
 919-274-9905
 MODELENERGY.COM
 P1194

JOB TITLE:
 NEW SOLAR PV SYSTEM
 13,800 KW DC INPUT
 WES CARVER
 2104 PONDEROSA ROAD
 CAMERON, NC 28326



CLIENT:



ISSUED FOR: CONSTRUCTION
DATE: 01/12/23

SITE INFORMATION

PV2.1

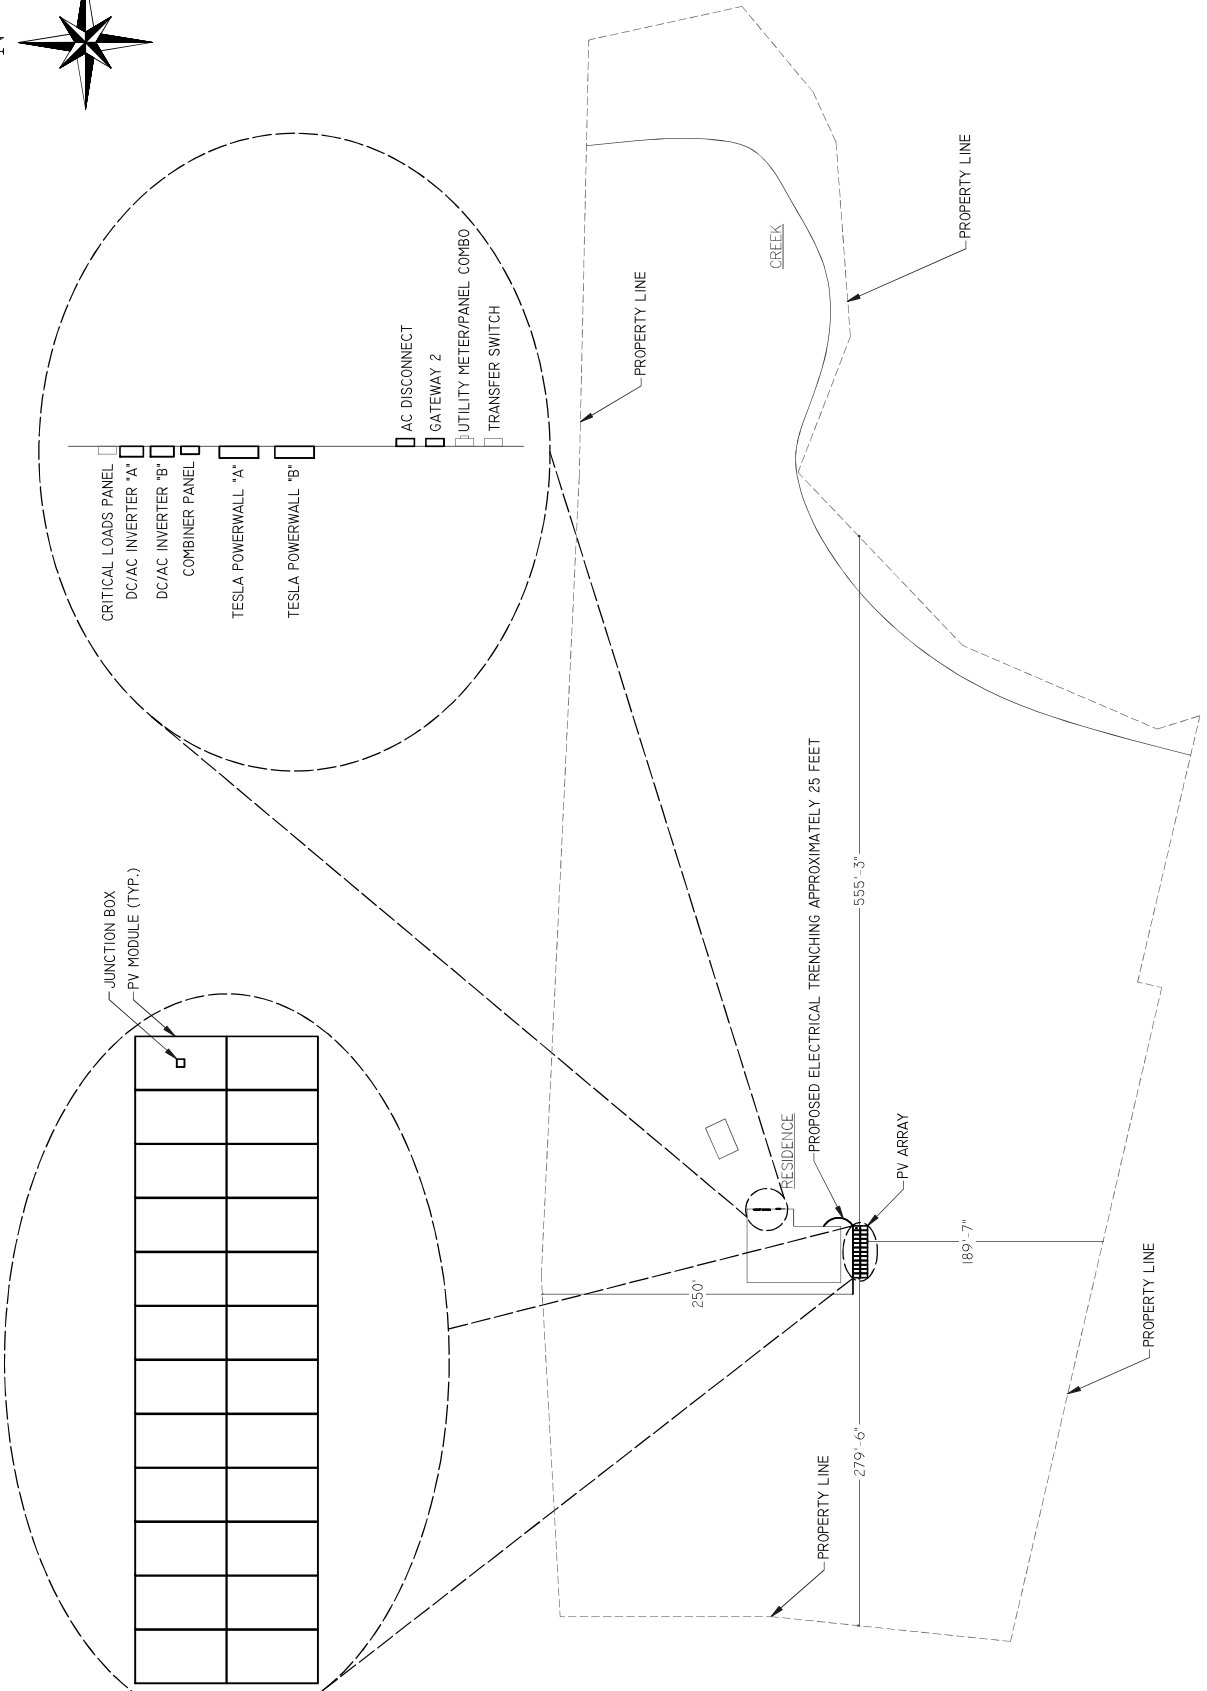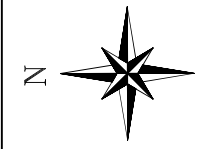

SCALE: 1" = 100'

1 SITE PLAN