

CAMPBELL, MICHAEL PV SYSTEM
141 BREEZEWOOD DRIVE .
LILLINGTON, NC, 27546
APN: 01053604 0028 17
JURISDICTION: HARNETT COUNTY (NC)
GENERAL INFORMATION

SYSTEM SIZE:	12.000 kW-DC-STC 10.000 kW-AC
ROOF PITCHED:	43 DEGREES
INVERTER:	(1) SOLAREGE SE10000H-US W/ S440 OPTIMIZERS
MODULES:	(30) HY-DH108P8-400B
STRINGS:	(2) x 15 MODULE SERIES STRINGS
ELECTRICAL SERVICE RATING:	200A
PV SYSTEM OVERCURRENT RATING:	60A
PV SYSTEM DISCONNECT SWITCH:	EATON DG222URB (60A / 2P)
ROOF TYPE:	COMP SHINGLE
ROOF FRAMING:	ENGINEERED TRUSS
RACKING/RAILING:	K2 SYSTEMS / K2RAIL
ATTACHMENT METHOD:	SPLICE FOOT
ROOF ATTACHMENT :	M5 x 60 S.S SELF DRILLING WOOD SCREWS


TABLE OF CONTENTS

<u>REQUIRED INFORMATION</u>	<u>SHEET NAME</u>	<u>SHEET NUMBER</u>
SITE INFORMATION	COVER PAGE	PV 1
MODULE AND EQUIPMENT LAYOUT	SITE PLAN	PV 2
LOCATION & QUANTITY OF PACKING & STANDOFFS	PV LAYOUT	PV 3
RACKING LOAD & UPLIFT CALCULATIONS	PV LAYOUT	PV 3
ROOF ATTACHMENT DETAILS	DETAILS	PV 4
ELECTRICAL 1 LINE DIAGRAM	ONE LINE	PV 5
ELECTRICAL 3 LINE DIAGRAM	THREE LINE	PV 6
OCP & WIRE SIZING CALCULATIONS	1 & 3 LINE	PV 5 & 6
ARRAY & INVERTER ELECTRICAL SPECIFICATIONS	1 & 3 LINE	PV 5 & 6
EQUIPMENT SPECIFICATIONS	1 & 3 LINE	PV 5 & 6
LABEL NOTES	LABELS	PV 7
PV EQUIPMENT LABELING DETAIL	LABELS	PV 7
DIRECTORY LABEL	PLACARD	PV 8
JOB SAFETY PLAN	SAFETY PLAN	PV 9
PV EQUIPMENT SPECIFICATIONS	EQUIPMENT SPEC.	PV 10 - 16
DATA SHEETS & ADDITIONAL INFORMATION	SUPPLEMENTAL MATERIAL	




VICINITY MAP

SCALE: NTS

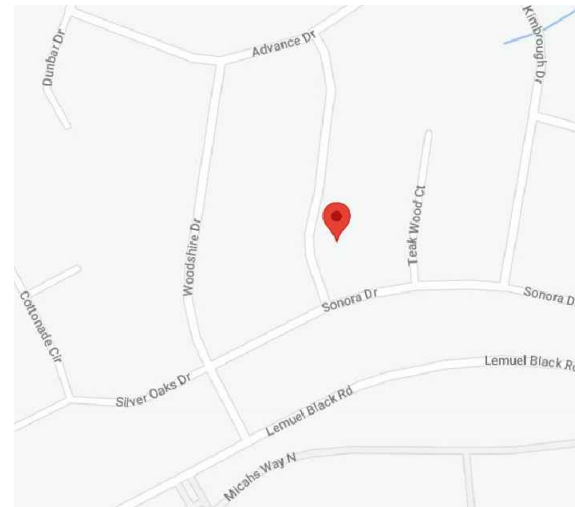

AERIAL MAP

SCALE: NTS

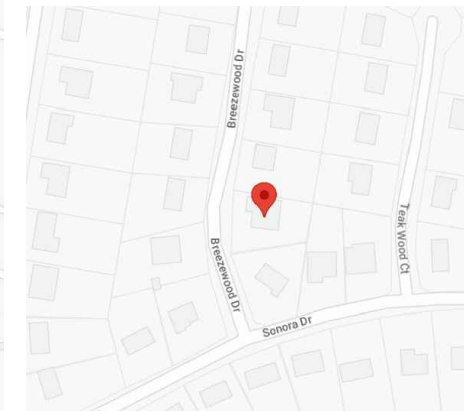

Wyssling Consulting, PLLC
 76 N Meadowbrook Drive Alpine UT 84004
 North Carolina COA # P-2308
 Signed 4/17/2023

THIS PLAN HAS BEEN ELECTRONICALLY SIGNED AND SEALED BY SCOTT WYSSLING, PE USING A DIGITAL SIGNATURE AND DATE. PRINTED COPIES OF THIS DOCUMENT ARE NOT CONSIDERED SIGNED AND SEALED AND THE SIGNATURE MUST BE VERIFIED ON ANY ELECTRONIC COPIES

NOTES

EQUIPMENT LOCATION


- ALL EQUIPMENT SHALL MEET MINIMUM SETBACKS AS REQUIRED BY NEC 110.26.
- WIRING SYSTEMS INSTALLED IN DIRECT SUNLIGHT MUST BE RATED FOR EXPECTED OPERATING TEMPERATURE AS SPECIFIED BY NEC 690.31(A),(C) AND NEC TABLES 310.15(B)(2)(A) AND 310.15(B)(3)(C).
- JUNCTION AND PULL BOXES PERMITTED INSTALLED UNDER PV MODULES ACCORDING TO NEC 690.34.
- ADDITIONAL AC DISCONNECT(S) SHALL BE PROVIDED WHERE THE INVERTER IS NOT WITHIN SIGHT OF THE AC SERVICING DISCONNECT.
- ALL EQUIPMENT SHALL BE INSTALLED ACCESSIBLE TO QUALIFIED PERSONNEL ACCORDING TO NEC APPLICABLE CODES.
- ALL COMPONENTS ARE LISTED FOR THEIR PURPOSE AND RATED FOR OUTDOOR USAGE WHEN APPROPRIATE.

WIRING & CONDUIT NOTES

- ALL CONDUITS AND WIRE WILL BE LISTED AND APPROVED FOR THEIR PURPOSE. CONDUIT AND WIRE SPECIFICATIONS ARE BASED ON MINIMUM CODE REQUIREMENTS AND ARE NOT MEANT TO LIMIT UP-SIZING.
- CONDUCTORS SIZED ACCORDING TO NEC 690.8, NEC 690.7.
- DC WIRING LIMITED TO MODULE FOOTPRINT. MICRO INVERTER WIRING SYSTEMS SHALL BE LOCATED AND SECURED UNDER THE ARRAY WITH SUITABLE WIRING CLIPS.
- AC CONDUCTORS COLORED OR MARKED AS FOLLOWS: PHASE A OR L1- BLACK, PHASE B OR L-2 RED, OR OTHER CONVENTION IF THREE PHASE, PHASE C OR L3-BLUE, YELLOW, ORANGE, OR OTHER CONVENTION NEUTRAL- WHITE OR GREY IN 4-WIRE DELTA CONNECTED SYSTEMS THE PHASE WITH THE HIGHER VOLTAGE TO BE MARKED ORANGE NEC 110.15.

GENERAL NOTES

- MODULES ARE LISTED UNDER UL 1703 AND CONFORM TO THE STANDARDS.
- INVERTERS ARE LISTED UNDER UL 1741 AND CONFORM TO THE STANDARDS.
- DRAWINGS ARE DIAGRAMMATIC, INDICATING GENERAL ARRANGEMENT OF THE PV SYSTEM AND THE ACTUAL SITE CONDITION MIGHT VARY.
- WORKING CLEARANCES AROUND THE NEW PV ELECTRICAL EQUIPMENT WILL BE MAINTAINED IN ACCORDANCE WITH NEC 110.26.
- ALL GROUND WIRING CONNECTED TO THE MAIN SERVICE GROUNDING IN MAIN SERVICE PANEL/SERVICE COMPONENT.
- ALL CONDUCTORS SHALL BE 600V, 75° C STANDARD COPPER UNLESS OTHERWISE NOTED.
- WHEN REQUIRED, A LADDER SHALL BE IN PLACE FOR INSPECTION IN COMPLIANCE WITH OSHA REGULATIONS.
- THE SYSTEM WILL NOT BE INTERCONNECTED BY THE CONTRACTOR UNTIL APPROVAL FROM THE LOCAL JURISDICTION AND/OR THE UTILITY.
- ROOF ACCESS POINT SHALL BE LOCATED IN AREAS THAT DO NOT REQUIRE THE PLACEMENT OF GROUND LADDERS OVER OPENINGS SUCH AS WINDOWS WHERE THE ACCESS POINT DOES NOT CONFLICT WITH OVERHEAD OBSTRUCTIONS SUCH AS TREES, WIRES OR SIGNS.
- PV ARRAY COMBINER/JUNCTION BOX PROVIDES TRANSITION FROM ARRAY WIRING TO CONDUIT WIRING.

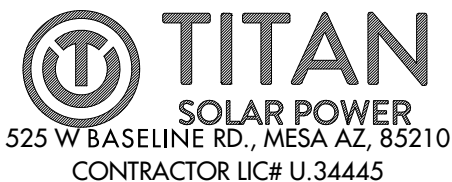


CAMPBELL, MICHAEL RESIDENCE
 141 BREEZEWOOD DRIVE , LILLINGTON, NC, 27546
 LAT:35.301118, LON:-78.973852
 TSP156877

(30) HY-DH108P8-400B
 (1) SOLAREGE SE10000H-US
 12.000 kW DC SYSTEM SIZE
 10.000 kW AC SYSTEM SIZE

DATE: 4/13/2023
 REV:A
 DRAWN BY: HM

SEAL:

COVER PAGE
PV 1

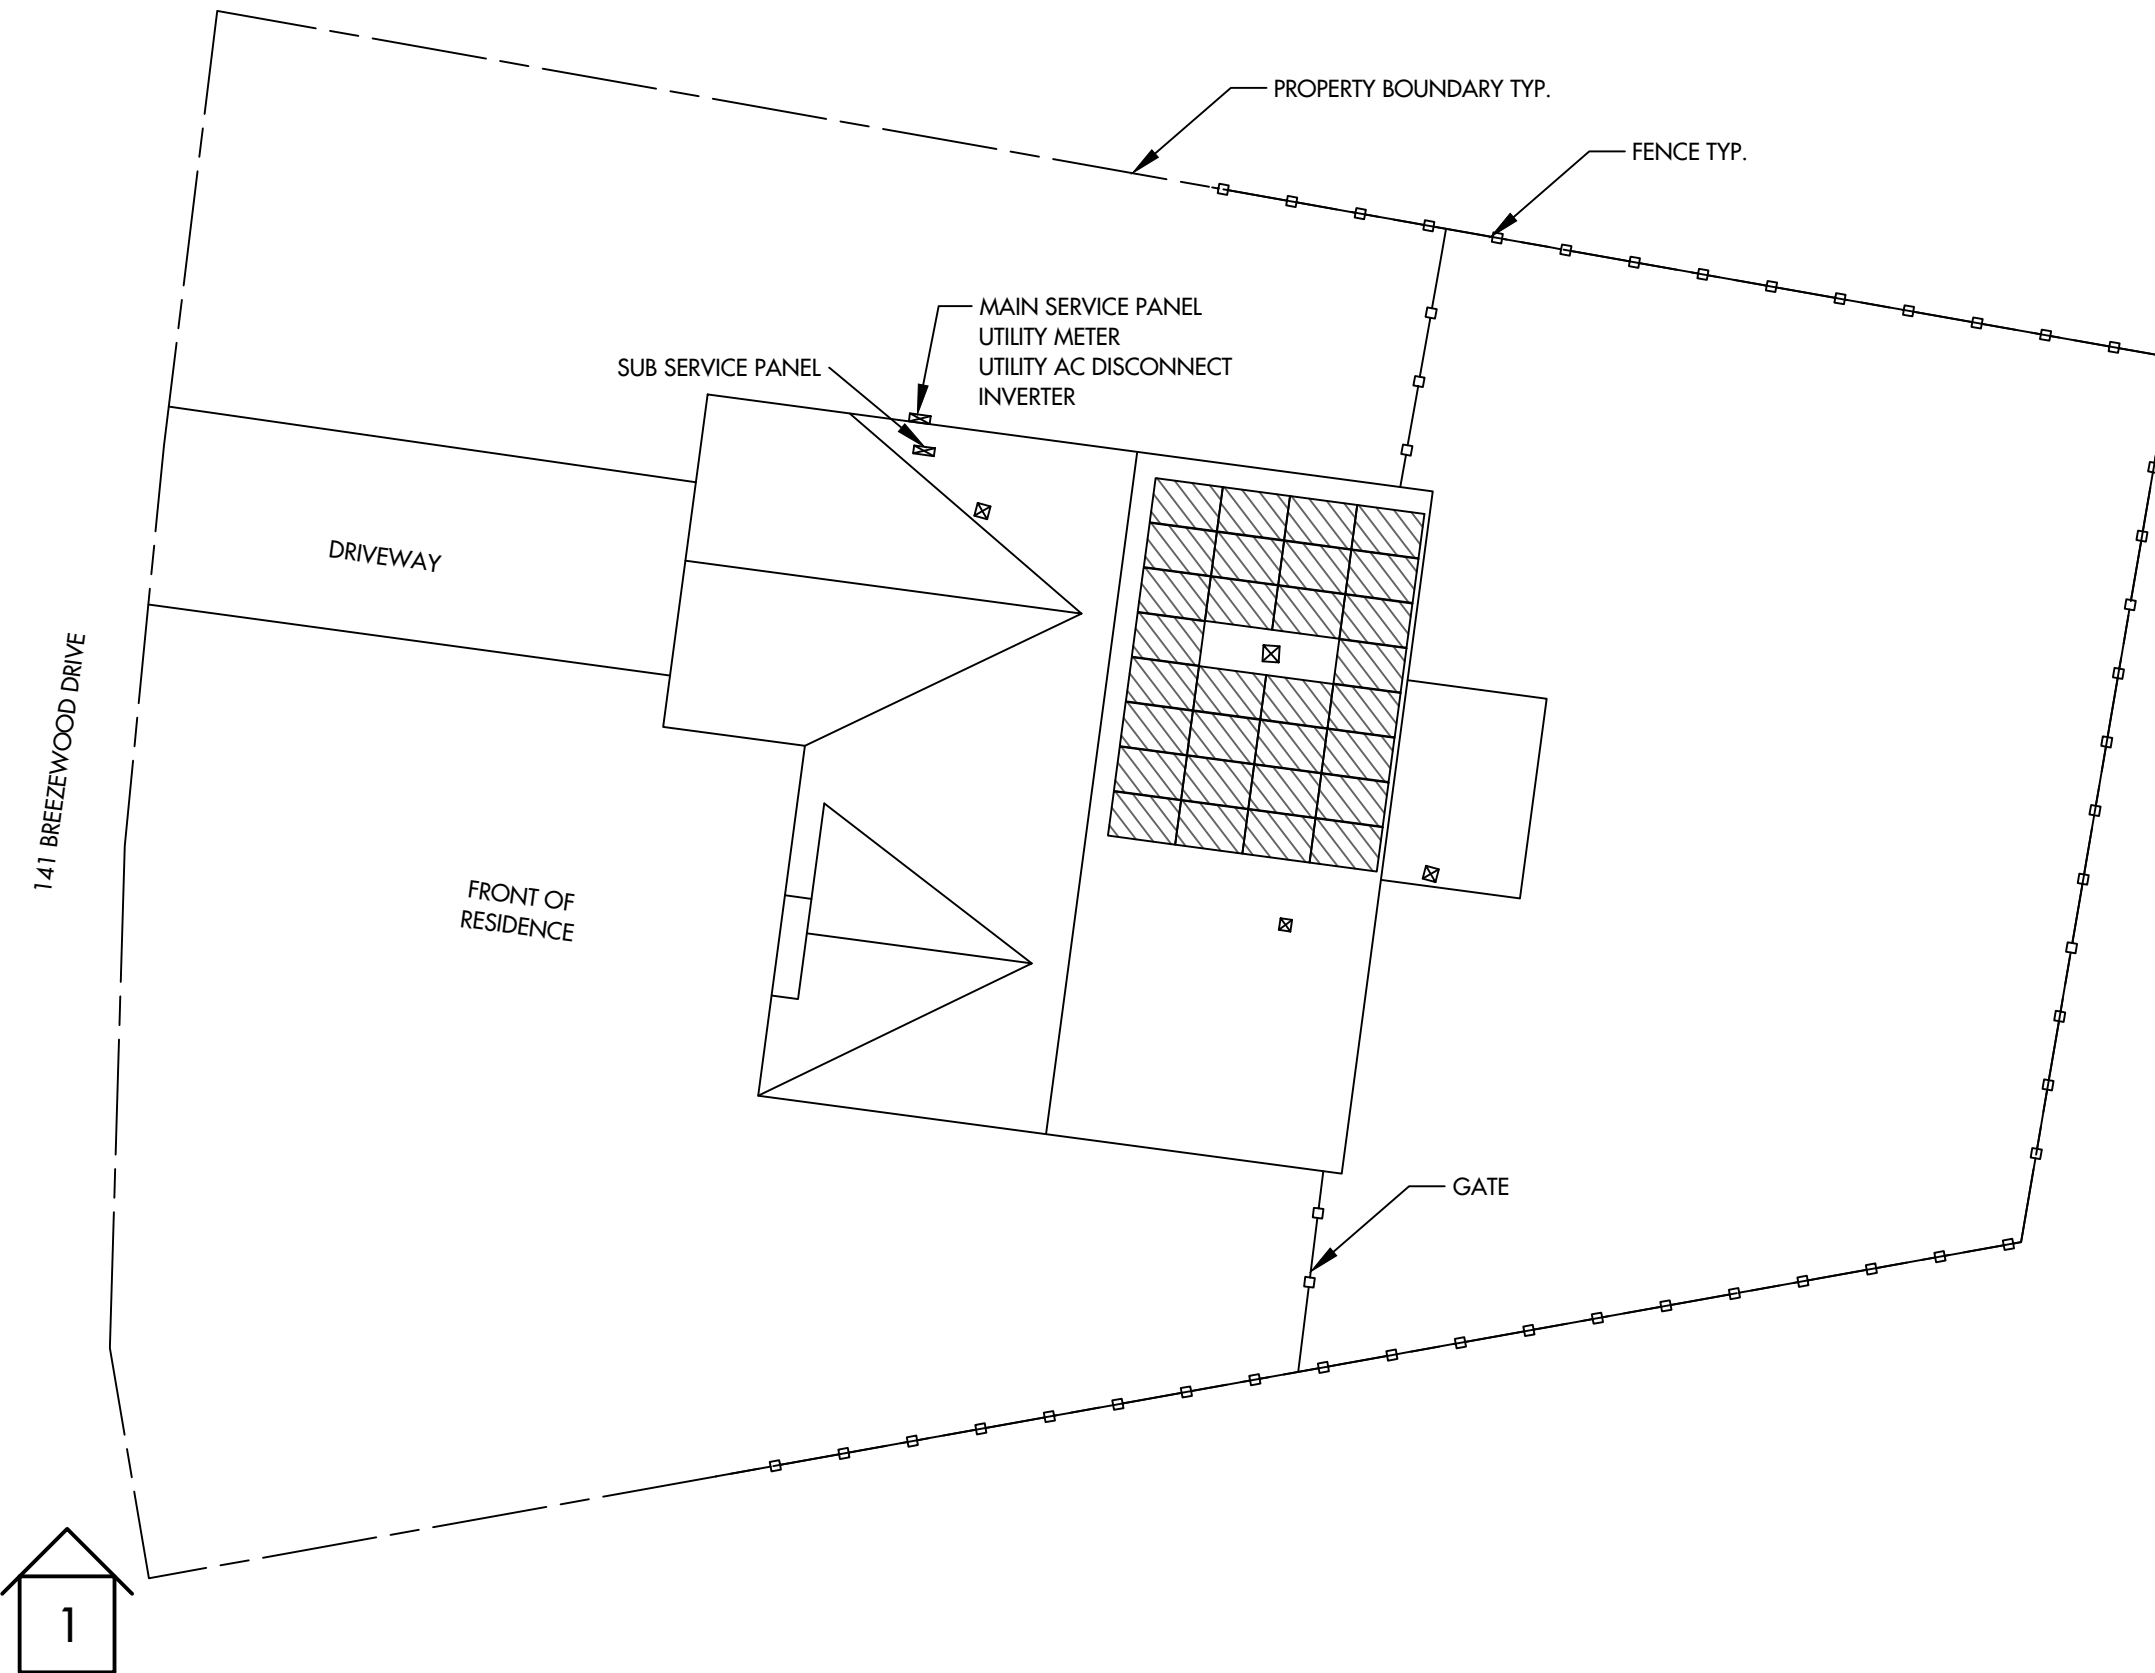

PROJECT NOTES

1. UTILITY SHALL HAVE 24HR UNRESTRICTED ACCESS TO ALL PHOTOVOLTAIC COMPONENTS LOCATED AT SES EQUIPMENT
2. NO LOCKED GATES, DOGS, ETC SHALL IMPEDE ACCESS TO SES EQUIPMENT
3. WORKSPACE IN FRONT OF AC ELECTRICAL SYSTEM COMPONENTS SHALL BE IN ACCORDANCE WITH SOUTH RIVER ELECTRIC MEMBERSHIP CORPORATION AND NEC REQUIREMENTS.
- 4.



Wyssling Consulting, PLLC
 76 N Meadowbrook Drive Alpine UT 84004
 North Carolina COA # P-2308
 Signed 4/17/2023

THIS PLAN HAS BEEN ELECTRONICALLY SIGNED AND SEALED BY SCOTT WYSSLING, PE USING A DIGITAL SIGNATURE AND DATE. PRINTED COPIES OF THIS DOCUMENT ARE NOT CONSIDERED SIGNED AND SEALED AND THE SIGNATURE MUST BE VERIFIED ON ANY ELECTRONIC COPIES

TITAN
 SOLAR POWER
 525 W BASELINE RD., MESA AZ, 85210
 CONTRACTOR LIC# U.34445

CAMPBELL, MICHAEL RESIDENCE
 141 BREEZEWOOD DRIVE , LILLINGTON, NC, 27546
 LAT:35.301118, LON:-78.973852
 TSP156877

(30) HY-DH108P8-400B
 (1) SOLAREEDGE SE10000H-US
 12.000 kW DC SYSTEM SIZE
 10.000 kW AC SYSTEM SIZE


SCALE: 1/16" = 1'-0"
 DATE: 4/13/2023
 REV: A
 DRAWN BY: HM

SEAL:

SITE PLAN
PV 2

ARRAY INFORMATION

AR-01
QUANTITY: 30
MOUNTING TYPE: FLUSH
ARRAY TILT: 43°
AZIMUTH: 97.5°
ATTACHMENT SPACING: 4'
ROOF TYPE: COMP SHINGLE

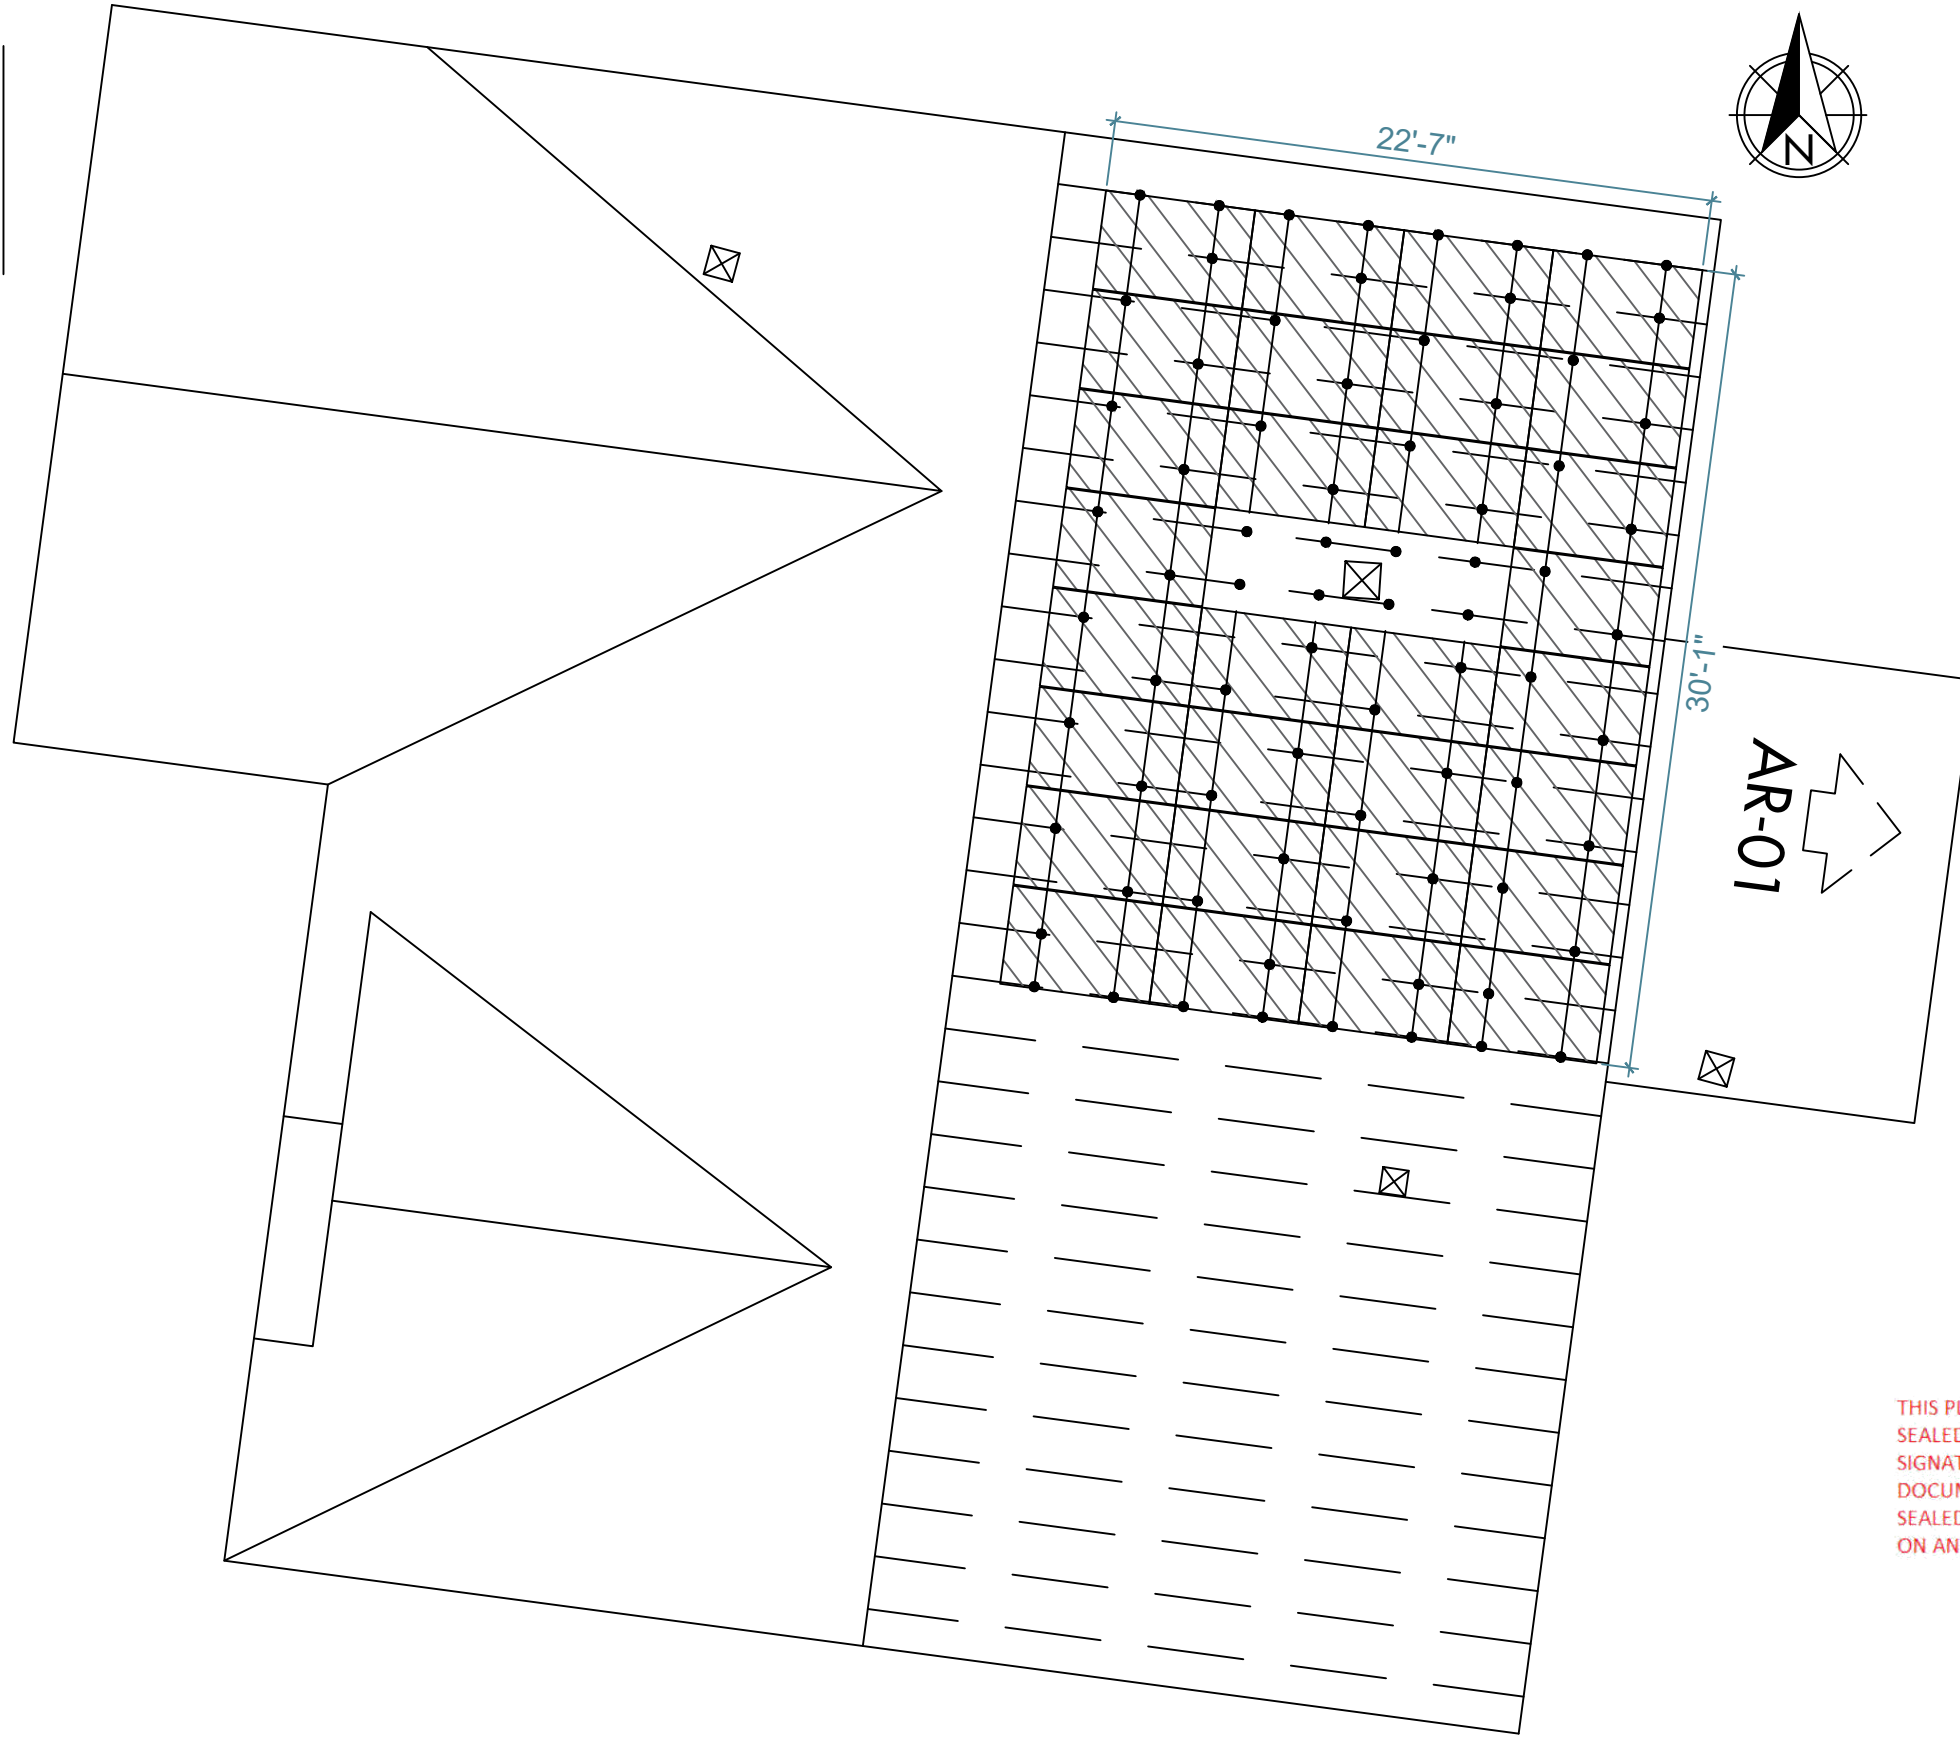

NOTES


- ROOF VENTS, SKYLIGHTS, WILL NOT BE COVERED UPON PV INSTALLATION
- TOTAL ROOF AREA = 3343.005 SQ-FT
- TOTAL ARRAY AREA = 630.68 SQ-FT
- ARRAY COVERAGE = 18.87%



Wyssling Consulting, PLLC
76 N Meadowbrook Drive Alpine UT 84004
North Carolina COA # P-2308

Signed 4/17/2023

THIS PLAN HAS BEEN ELECTRONICALLY SIGNED AND SEALED BY SCOTT WYSSLING, PE USING A DIGITAL SIGNATURE AND DATE. PRINTED COPIES OF THIS DOCUMENT ARE NOT CONSIDERED SIGNED AND SEALED AND THE SIGNATURE MUST BE VERIFIED ON ANY ELECTRONIC COPIES

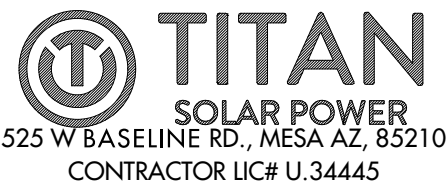

CAMPBELL, MICHAEL RESIDENCE
141 BREEZEWOOD DRIVE , LILLINGTON, NC, 27546
LAT:35.301118, LON:-78.973852
TSP156877

(30) HY-DH108P8-400B
(1) SOLAREEDGE SE10000H-US
12.000 kW DC SYSTEM SIZE
10.000 kW AC SYSTEM SIZE

SCALE: 35/256" = 1'-0"
DATE: 4/13/2023
REV:A
DRAWN BY: HM

SEAL:

PV LAYOUT
PV 3

MODULE & RACKING INFORMATION


MODULE: HY-DH108P8-400B
MODULE WEIGHT: 49.80 LBS
MODULE DIMENSIONS: 67.8" x 44.65" x 1.5"
RACKING/RAIL: K2 SYSTEMS / K2RAIL
ROOF ATTACHMENT : M5 x 60 S.S SELF DRILLING WOOD SCREWS

ARRAY 01: 30 MODULES

UPLIFT = 18920.44 LBS.
POINT LOAD = 21.04 LBS. PER MOUNTING POINT
PULLOUT STRENGTH = 39900.00 LBS.
DISTRIBUTED LOAD = 2.54 PSF
MODULE & RACKING WEIGHT = 1599.00 LBS

ROOF & FRAMING INFORMATION


MATERIAL: COMP SHINGLE
RAFTER/TRUSS SIZE: 2" x 4"
RAFTER/TRUSS SPACING: 2'

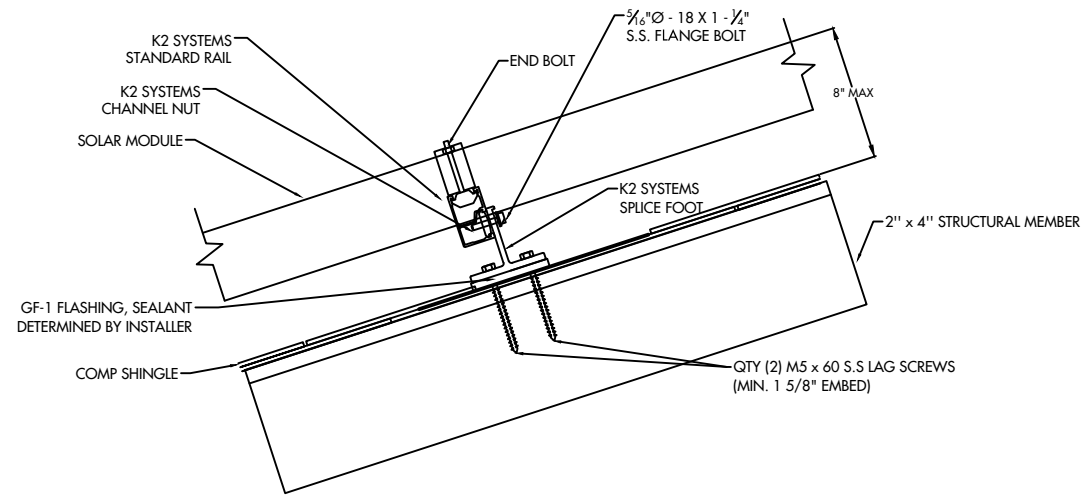

Wyssling Consulting, PLLC
76 N Meadowbrook Drive Alpine UT 84004
North Carolina COA # P-2308

Signed 4/17/2023

THIS PLAN HAS BEEN ELECTRONICALLY SIGNED AND SEALED BY SCOTT WYSSLING, PE USING A DIGITAL SIGNATURE AND DATE. PRINTED COPIES OF THIS DOCUMENT ARE NOT CONSIDERED SIGNED AND SEALED AND THE SIGNATURE MUST BE VERIFIED ON ANY ELECTRONIC COPIES

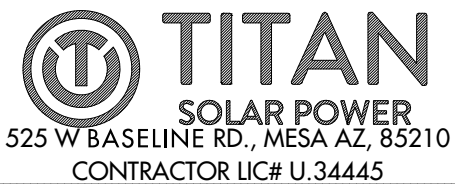

CAMPBELL, MICHAEL RESIDENCE
141 BREEZEWOOD DRIVE , LILLINGTON, NC, 27546
LAT:35.301118, LON:-78.973852
TSP156877

(30) HY-DH108P8-400B
(1) SOLAREdge SE10000H-US
12.000 kW DC SYSTEM SIZE
10.000 kW AC SYSTEM SIZE

DATE: 4/13/2023
REV:A
DRAWN BY: HM

SEAL:

DETAILS
PV 4

PV MODULE

HY-DH108P8-400B
 W = 400 W
 ISC = 13.79 ADC
 VOC = 37.07 VDC
 IMP = 12.90 ADC
 VMP = 31.21 VDC
 TVOC = -0.304% / °C


WIRE SCHEDULE

A - (4) #10 AWG-CU PV WIRE (HR)
 (1) #10 AWG-CU BARE COPPER WIRE (GND)
 IN FREE AIR
 B - (4) #10 AWG-CU THWN-2 WIRE (HR)
 (1) #10 AWG-CU THWN-2 WIRE (GND)
 3/4" EMT

C - (3) #6 AWG-CU THWN-2 WIRE (HR)
 (1) #8 AWG-CU THWN-2 WIRE (GND)
 3/4" EMT

NOTE:

SUM OF ALL BREAKERS: NEC (705.12(B)(2)(3)(C))
 THE SUM OF THE AMPERE RATING OF ALL OVERCURRENT DEVICES ON
 PANELBOARDS, BOTH LOAD AND SUPPLY DEVICES, EXCLUDING THE RATING
 OF THE OVERCURRENT DEVICE PROTECTING THE BUSBAR, SHALL NOT
 EXCEED THE AMPACITY OF THE BUSBAR. THE RATING OF THE OVERCURRENT
 DEVICE PROTECTING THE BUS BAR SHALL NOT EXCEED THE RATING OF THE
 BUSBAR. PERMANENT WARNING LABELS SHALL BE APPLIED TO DISTRIBUTION
 EQUIPMENT DISPLAYING THE FOLLOWING OR EQUIVALENT WORDING:
 WARNING: THIS EQUIPMENT FED BY MULTIPLE SOURCES. TOTAL RATING OF
 ALL OVERCURRENT DEVICES EXCLUDING MAIN SUPPLY OVERCURRENT
 DEVICE SHALL NOT EXCEED AMPACITY OF BUSBAR
 THE WARNING SIGN(S) OR LABEL(S) SHALL COMPLY WITH 110.21(B)

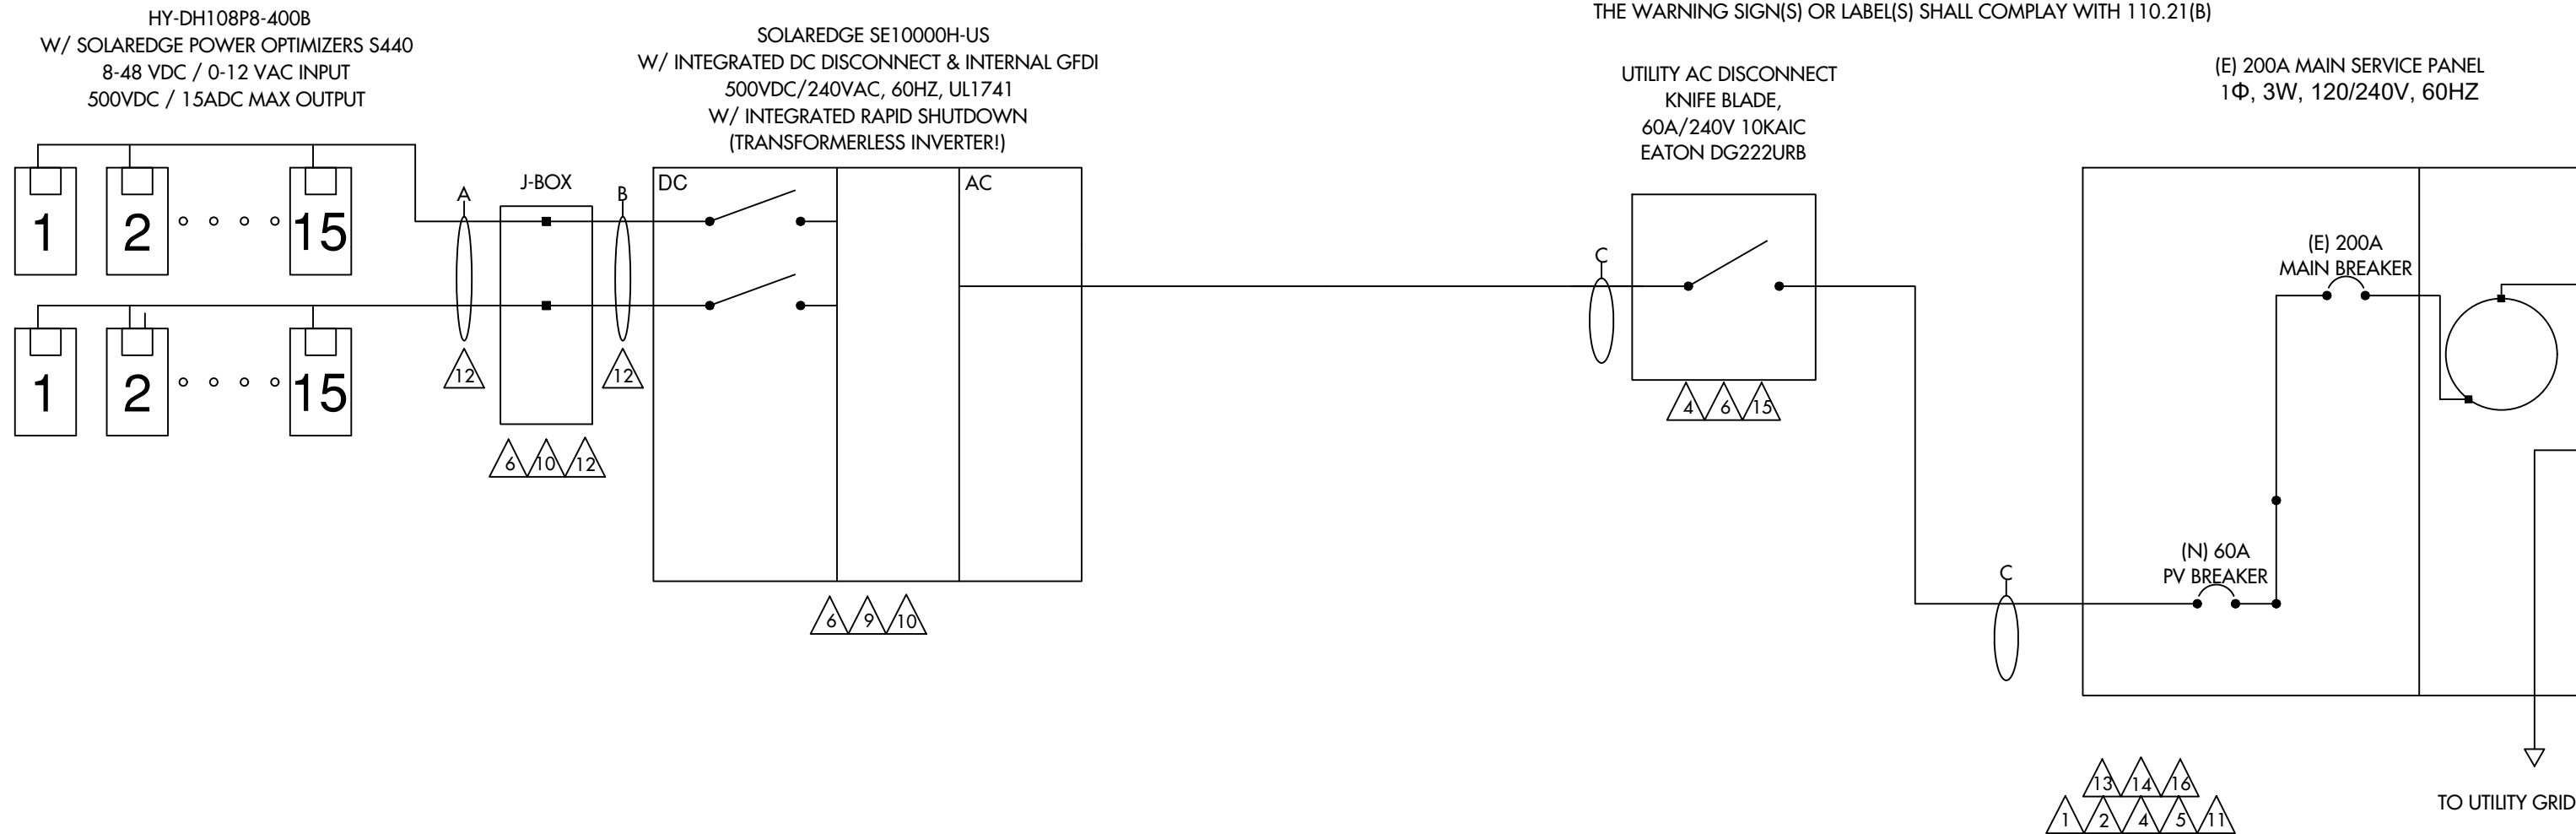


WIRE SIZE CALCULATIONS

TEMP CORRECTION FACTOR: 0.87 (43° AMBIENT)
 ROOFTOP TEMP CORRECTION FACTOR: 1.00 (43° ADJUSTED)
 (2" ABOVE ROOFTOP / 0° TEMP ADDERS - AS OCCURS)
 (TEMP DATA TAKEN FROM ASHRAE 2% AVG HIGH TEMP)

DC WIRING
 CONDUIT FILL FACTOR = 0.80
 OPTIMIZER MAX. CURRENT = 18.75A DC (15.00A X 1 X 1.25)
 #10- AWG CU. AMPACITY = 47.85A (55A X 0.87)
 FREE AIR
 #10 - AWG CU. AMPACITY = 27.84A (40A X 0.87 X 0.80)
 ROOFTOP CONDUIT

AC WIRING
 CONDUIT FILL FACTOR = 1 (3) CONDUCTORS
 MAX. INVERTER CURRENT = 42A (PER INVERTER SPECS)
 MIN. INVERTER OCP = 52.5A (42A X 1.25)
 INVERTER OCP = 60A
 #6 - AWG CU AMPACITY = 65.25A (75A X 1 X 0.87)

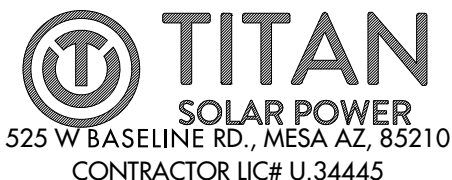

CAMPBELL, MICHAEL RESIDENCE
 141 BREEZEWOOD DRIVE, LILLINGTON, NC, 27546
 LAT:35.301118, LON:-78.973852
 TSP156877

(30) HY-DH108P8-400B
 (1) SOLAREEDGE SE10000H-US
 12.000 kW DC SYSTEM SIZE
 10.000 kW AC SYSTEM SIZE

DATE: 4/13/2023
 REV:A
 DRAWN BY: HM

SEAL:

ONE LINE
PV 5

PV MODULE


HY-DH108P8-400B
 W = 400 W
 ISC = 13.79 ADC
 VOC = 37.07 VDC
 IMP = 12.90 ADC
 VMP = 31.21 VDC
 TVOC = -0.304% / °C

WIRE SCHEDULE

A - (4) #10 AWG-CU PV WIRE (HR)
 (1) #10 AWG-CU BARE COPPER WIRE (GND)
 IN FREE AIR
 B - (4) #10 AWG-CU THWN-2 WIRE (HR)
 (1) #10 AWG-CU THWN-2 WIRE (GND)
 3/4" EMT

C - (3) #6 AWG-CU THWN-2 WIRE (HR)
 (1) #8 AWG-CU THWN-2 WIRE (GND)
 3/4" EMT

NOTE:
 SUM OF ALL BREAKERS: NEC (705.12(B)(2)(3)(C))
 THE SUM OF THE AMPERE RATING OF ALL OVERCURRENT DEVICES ON PANELBOARDS, BOTH LOAD AND SUPPLY DEVICES, EXCLUDING THE RATING OF THE OVERCURRENT DEVICE PROTECTING THE BUSBAR, SHALL NOT EXCEED THE AMPACITY OF THE BUSBAR. THE RATING OF THE OVERCURRENT DEVICE PROTECTING THE BUS BAR SHALL NOT EXCEED THE RATING OF THE BUSBAR. PERMANENT WARNING LABELS SHALL BE APPLIED TO DISTRIBUTION EQUIPMENT DISPLAYING THE FOLLOWING OR EQUIVALENT WORDING:
 WARNING: THIS EQUIPMENT FED BY MULTIPLE SOURCES. TOTAL RATING OF ALL OVERCURRENT DEVICES EXCLUDING MAIN SUPPLY OVERCURRENT DEVICE SHALL NOT EXCEED AMPACITY OF BUSBAR
 THE WARNING SIGN(S) OR LABEL(S) SHALL COMPLY WITH 110.21(B)

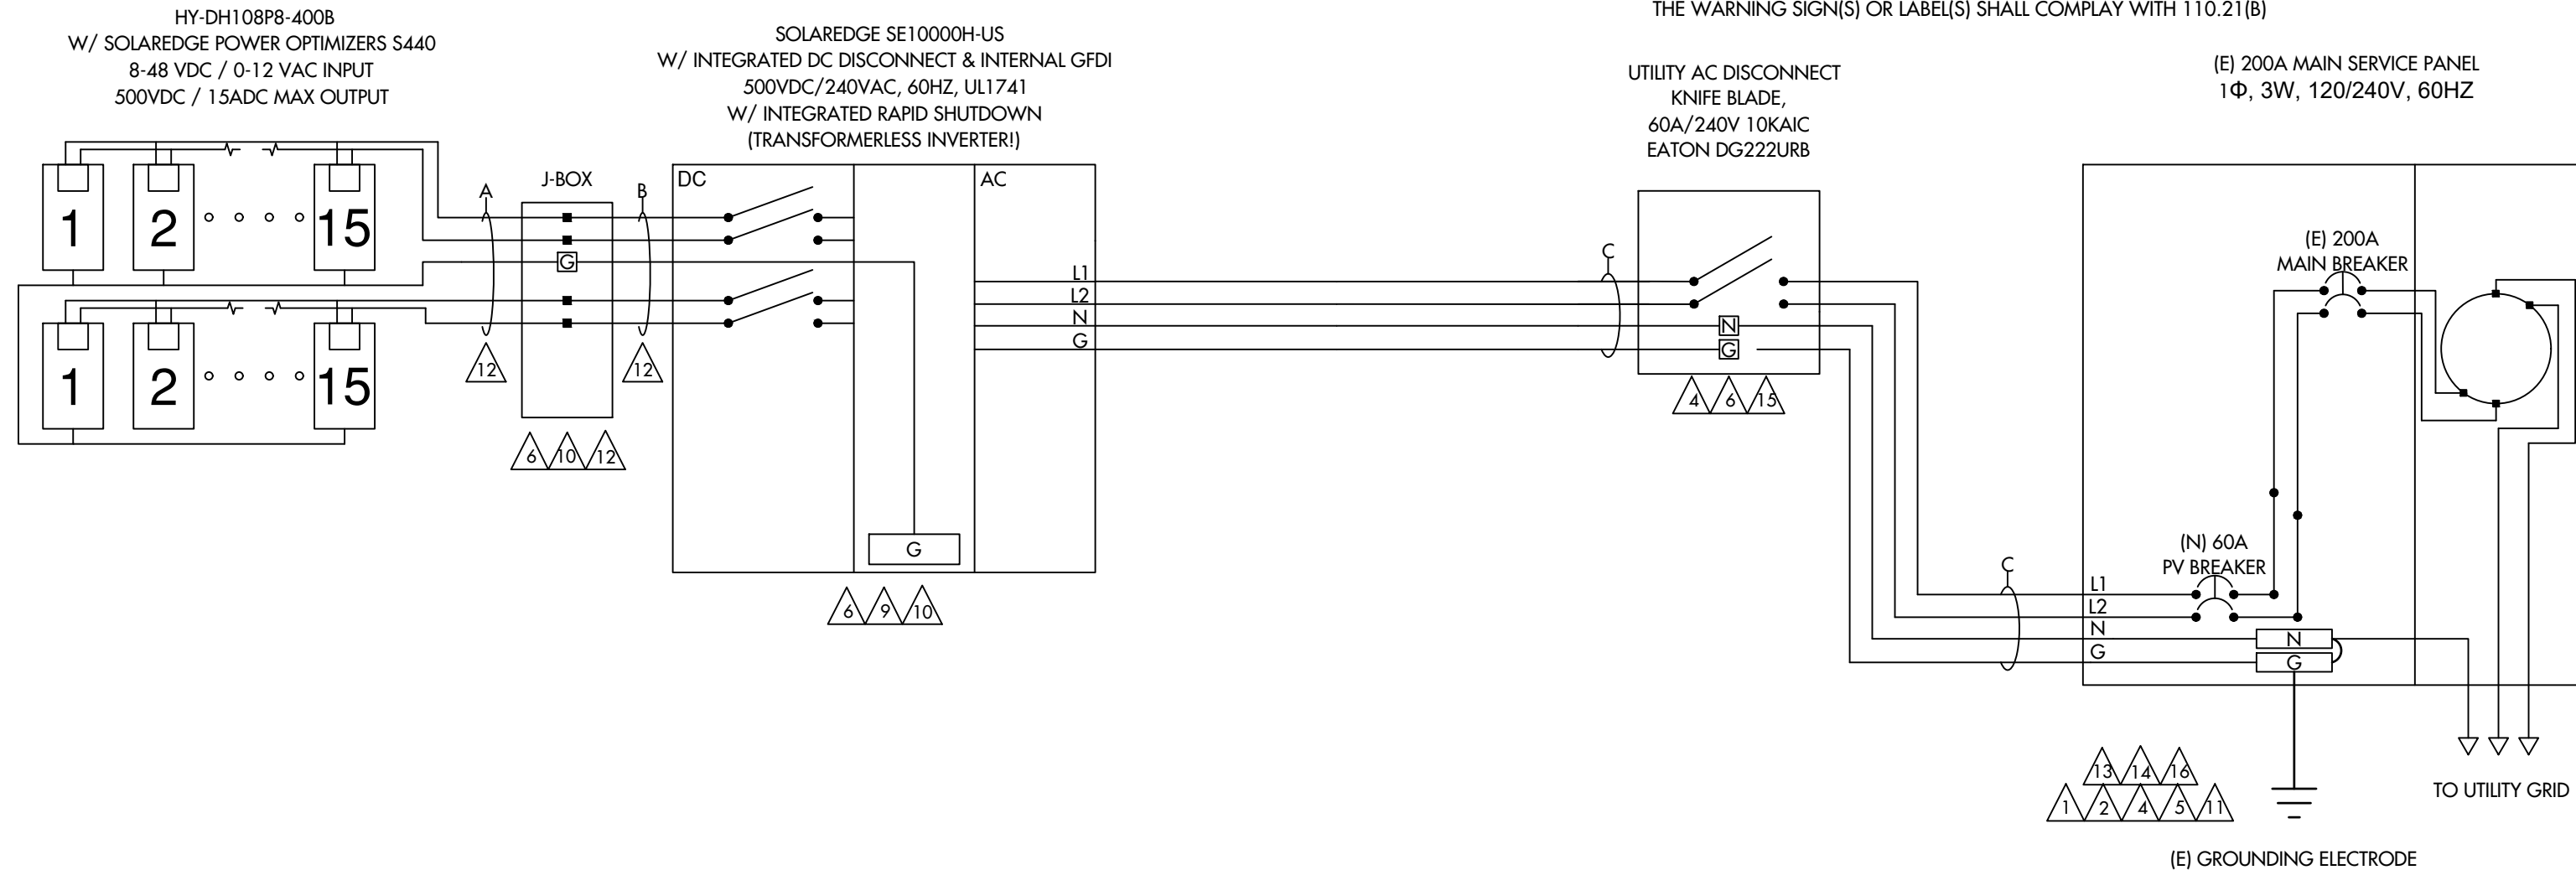


WIRE SIZE CALCULATIONS

TEMP CORRECTION FACTOR: 0.87 (43° AMBIENT)
 ROOFTOP TEMP CORRECTION FACTOR: 1.00 (43° ADJUSTED)
 (2" ABOVE ROOFTOP / 0° TEMP ADDERS - AS OCCURS)
 (TEMP DATA TAKEN FROM ASHRAE 2% AVG HIGH TEMP)

DC WIRING
 CONDUIT FILL FACTOR = 0.80
 OPTIMIZER MAX. CURRENT = 18.75A DC (15.00A X 1 X 1.25)
 #10- AWG CU. AMPACITY = 47.85A (55A X 0.87)
 FREE AIR
 #10 - AWG CU. AMPACITY = 27.84A (40A X 0.87 X 0.80)
 ROOFTOP CONDUIT

AC WIRING
 CONDUIT FILL FACTOR = 1 (3) CONDUCTORS
 MAX. INVERTER CURRENT = 42A (PER INVERTER SPECS)
 MIN. INVERTER OCP = 52.5A (42A X 1.25)
 INVERTER OCP = 60A
 #6 - AWG CU AMPACITY = 65.25A (75A X 1 X 0.87)

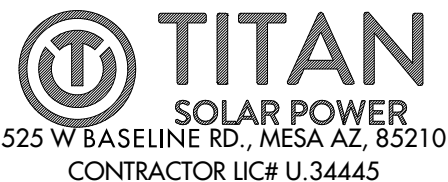

CAMPBELL, MICHAEL RESIDENCE
 141 BREEZEWOOD DRIVE, LILLINGTON, NC, 27546
 LAT:35.301118, LON:-78.973852
 TSP156877

(30) HY-DH108P8-400B
 (1) SOLAREEDGE SE10000H-US
 12.000 kW DC SYSTEM SIZE
 10.000 kW AC SYSTEM SIZE

DATE: 4/13/2023
 REV:A
 DRAWN BY: HM

SEAL:

THREE LINE
PV 6

1

CAUTION
PHOTOVOLTAIC SYSTEM CIRCUIT IS BACKFED

LOCATION: BACKFED BREAKER
CODE REF: NEC 705.12(4)

2

WARNING
INVERTER OUTPUT CONNECTION:
DO NOT RELOCATE THIS
OVERCURRENT DEVICE

LOCATION: BACKFED BREAKER
CODE REF: 2017 NEC 705.12(2)(3)(b)

3

WARNING
A GENERATION SOURCE IS CONNECTED TO THE SUPPLY
(UTILITY) SIDE OF THE MAIN SERVICE DISCONNECT. FOLLOW
THE PROPER LOCK-OUT/TAG-OUT PROCEDURES TO ENSURE
THE PHOTOVOLTAIC SYSTEM UTILITY DISCONNECT SWITCH IS
OPENED PRIOR TO PERFORMING WORK ON THIS DEVICE

LOCATION: (IF APPLICABLE)
SUPPLY SIDE TAP
LOAD PANEL
CODE REF: UTILITY

4

PHOTOVOLTAIC AC DISCONNECT
RATED AC OPERATING CURRENT: 42A AC
NOMINAL OPERATING AC VOLTAGE: 240VAC

LOCATION: MAIN PANEL
AC DISCONNECT(S)
CODE REF: NEC 690.54

5

**RAPID SHUTDOWN
SWITCH FOR
SOLAR PV SYSTEM**

LOCATION: MAIN PANEL (EXTERIOR)
PV BREAKER (INTERIOR)
CODE REF: NEC 690.56(C)(3)

6

WARNING
ELECTRICAL SHOCK HAZARD
TERMINALS ON BOTH LINE AND
LOAD SIDES MAY BE ENERGIZED
IN THE OPEN POSITION

LOCATION: COMBINER PANEL
AC DISCONNECT
JUNCTION BOX
INVERTER(S)
CODE REF: NEC 690.13(B)

7

**PHOTOVOLTAIC
SYSTEM METER**

LOCATION: DEDICATED KWH METER
CODE REF: NEC 690.4(B) UTILITY

8

WARNING
PHOTOVOLTAIC SYSTEM
COMBINER PANEL
DO NOT ADD LOADS

LOCATION: AC COMBINER PANEL
CODE REF: NEC 690.13(B)

9

PHOTOVOLTAIC SYSTEM DC DISCONNECT
MAXIMUM VOLTAGE: 480VDC
MAXIMUM CIRCUIT CURRENT: 15.0ADC
MAX. RATED OUTPUT CURRENT OF
THE CHARGE CONTROLLER OR DC-
TO-DC- CONVERTER (IF INSTALLED) 15.0ADC

LOCATION: DC DISCONNECT
INVERTER
CODE REF: UTILITY


10

WARNING
ELECTRICAL SHOCK HAZARD
TERMINALS ON BOTH LINE AND
LOAD SIDES MAY BE ENERGIZED
IN THE OPEN POSITION
DC VOLTAGE IS ALWAYS PRESENT
WHEN SOLAR MODULES ARE
EXPOSED TO SUNLIGHT

LOCATION: DC DISCONNECT, COMBINE BOX
CODE REF: NEC 690.13(B)

11

**SOLAR PV SYSTEM EQUIPPED
WITH RAPID SHUTDOWN**
TURN RAPID SHUTDOWN
SWITCH TO THE "OFF"
POSITION TO SHUT DOWN
PV SYSTEM AND REDUCE
SHOCK HAZARD IN THE
ARRAY.

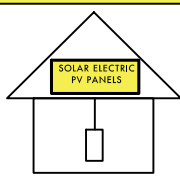

LOCATION: MAIN SERVICE (OUTSIDE COVER)
CODE REF: NEC 690.12
NEC 690.56(C)(1)(a)
YELLOW STICKER

12

WARNING PHOTOVOLTAIC POWER SOURCE

LOCATION: DC CONDUIT
JUNCTION BOX
NO MORE THAN 10FT
CODE REF: NEC 690.31(G)(3)
NEC 690.31(G)(4)
REFLECTIVE AND WEATHER RESISTANT

LABEL REQUIRES CAPITALIZED LETTERS WITH A MINIMUM HEIGHT OF 3/8 INCH, WHITE LETTERS ON RED BACKGROUND
LABELS SHALL BE PLACED ON INTERIOR AND EXTERIOR DC CONDUIT, RACEWAYS, ENCLOSURES, AND CABLE ASSEMBLIES
EVERY 10 FEET, WITHIN 1 FOOT OF TURNS OR BENDS AND WITHIN 1 FOOT ABOVE AND BELOW PENETRATIONS OF
ROOF/CEILING ASSEMBLIES, WALLS OR BARRIERS.

13

CAUTION
DUAL POWER SOURCE
SECOND SOURCE IS
PHOTOVOLTAIC

LOCATION: SERVICE METER
MAIN PANEL

14

WARNING
INVERTER OUTPUT CONNECTION
DO NOT RELOCATE THIS
OVERCURRENT DEVICE

LOCATION: (IF APPLICABLE)
SERVICE PANEL
CODE REF: NEC 705.12(7)

15

**PHOTOVOLTAIC SYSTEM
UTILITY DISCONNECT SYSTEM**

LOCATION: AC DISCONNECT
CODE REF: UTILITY

16

PV SOLAR BREAKER
DO NOT RELOCATE THIS
OVERCURRENT DEVICE

LOCATION: MAIN PANEL:(EXTERIOR)
PV BREAKER: (INTERIOR)
CODE REF: NEC 705.12(B)(2)(3)(B)



CAMPBELL, MICHAEL RESIDENCE
141 BREEZEWOOD DRIVE , LILLINGTON, NC, 27546
LAT:35.301118, LON:-78.973852
TSP156877

(30) HY-DH108P8-400B
(1) SOLAREdge SE10000H-US
12.000 kW DC SYSTEM SIZE
10.000 kW AC SYSTEM SIZE


DATE: 4/13/2023
REV: A
DRAWN BY: HM

SEAL:


LABELS
PV 7

CAUTION

POWER TO THIS BUILDING IS
SUPPLIED FROM THE FOLLOWING
SOURCES WITH DISCONNECTS AS
SHOWN:

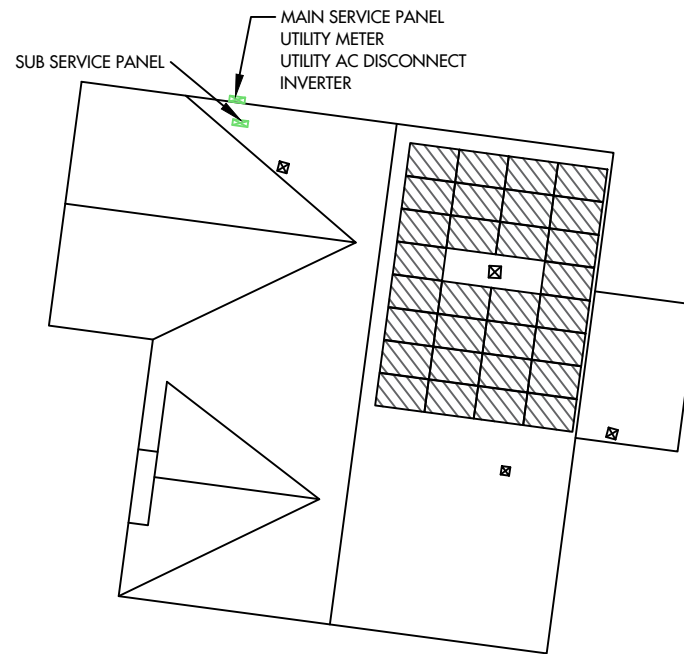

DIRECTORY PLAQUE IN
ACCORDANCE WITH
NEC690.56(A)(B), 705.10

 **TITAN**
SOLAR POWER
525 W BASELINE RD., MESA AZ, 85210
CONTRACTOR LIC# U.34445

CAMPBELL, MICHAEL RESIDENCE
141 BREEZEWOOD DRIVE , LILLINGTON, NC, 27546
LAT:35.301118, LON:-78.973852
TSP156877


(30) HY-DH108P8-400B
(1) SOLAREEDGE SE10000H-US
12.000 kW DC SYSTEM SIZE
10.000 kW AC SYSTEM SIZE

DATE: 4/13/2023
REV: A
DRAWN BY: HM

SEAL:

PLACARD
PV 8

JOB SAFETY PLAN

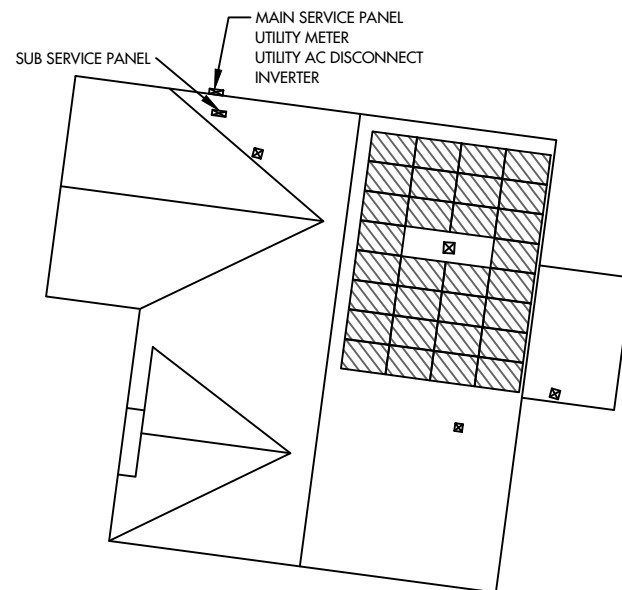

LOCATION OF NEAREST URGENT CARE FACILITY

NAME:

ADDRESS:

PHONE NUMBER:

NOTES:

- INSTALLER SHALL DRAW IN DESIGNATED SAFETY AREA AROUND HOME
- INSTALLER SHALL UPDATE NAME, ADDRESS, AND PHONE NUMBER OF NEAREST URGENT CARE FACILITY RELATIVE TO THE JOB SITE BEFORE STARTING WORK.

PRINT NAME	INITIAL	YES	NO

Single Phase Inverter with HD-Wave Technology for North America

SE3000H-US / SE3800H-US / SE5000H-US / SE6000H-US / SE7600H-US / SE10000H-US / SE11400H-US

12-25 YEAR WARRANTY



INVERTERS

Optimized installation with HD-Wave technology

- Specifically designed to work with power optimizers
- Record-breaking 99% weighted efficiency
- Quick and easy inverter commissioning directly from a smartphone using the SolarEdge SetApp
- Fixed voltage inverter for longer strings
- Integrated arc fault protection and rapid shutdown for NEC 2014, NEC 2017 and NEC 2020 per article 690.11 and 690.12
- UL1741 SA certified, for CPUC Rule 21 grid compliance
- Small, lightweight, and easy to install both outdoors or indoors
- Built-in module-level monitoring
- Optional: Faster installations with built-in consumption metering (1% accuracy) and production revenue grade metering (0.5% accuracy, ANSI C12.20)

solaredge.com



Single Phase Inverter with HD-Wave Technology for North America

SE3000H-US / SE3800H-US / SE5000H-US / SE6000H-US / SE7600H-US / SE10000H-US / SE11400H-US

MODEL NUMBER	SE3000H-US	SE3800H-US	SE5000H-US	SE6000H-US	SE7600H-US	SE10000H-US	SE11400H-US	
APPLICABLE TO INVERTERS WITH PART NUMBER	SEXXXXH-XXXXXBXX4							
OUTPUT								
Rated AC Power Output	3000	3800 @ 240V 3300 @ 208V	5000	6000 @ 240V 5000 @ 208V	7600	10000	11400 @ 240V 10000 @ 208V	VA
Maximum AC Power Output	3000	3800 @ 240V 3300 @ 208V	5000	6000 @ 240V 5000 @ 208V	7600	10000	11400 @ 240V 10000 @ 208V	VA
AC Output Voltage Min.-Nom.-Max. (211 - 240 - 264)	✓	✓	✓	✓	✓	✓	✓	Vac
AC Output Voltage Min.-Nom.-Max. (183 - 208 - 229)	-	✓	-	✓	-	-	✓	Vac
AC Frequency (Nominal)	59.3 - 60 - 60.5 ⁽¹⁾							Hz
Maximum Continuous Output Current @240V	12.5	16	21	25	32	42	47.5	A
Maximum Continuous Output Current @208V	-	16	-	24	-	-	48.5	A
Power Factor	1, Adjustable - 0.85 to 0.85							
GFDI Threshold	1							A
Utility Monitoring, Islanding Protection, Country Configurable Thresholds	Yes							
INPUT								
Maximum DC Power @240V	4650	5900	7750	9300	11800	15500	17650	W
Maximum DC Power @208V	-	5100	-	7750	-	-	15500	W
Transformer-less, Ungrounded	Yes							
Maximum Input Voltage	480							Vdc
Nominal DC Input Voltage	380							Vdc
Maximum Input Current @240V ⁽²⁾	8.5	10.5	13.5	16.5	20	27	30.5	A
Maximum Input Current @208V ⁽²⁾	-	9	-	13.5	-	-	27	A
Max. Input Short Circuit Current	45							A
Reverse-Polarity Protection	Yes							
Ground-Fault Isolation Detection	600ka Sensitivity							
Maximum Inverter Efficiency	99	99.2						%
CEC Weighted Efficiency	99 @ 240V 98.5 @ 208V							%
Nighttime Power Consumption	< 2.5							W

(1) For other regional settings please contact SolarEdge support
(2) A higher current source may be used; the inverter will limit its input current to the values stated

Single Phase Inverter with HD-Wave Technology for North America


SE3000H-US / SE3800H-US / SE5000H-US / SE6000H-US / SE7600H-US / SE10000H-US / SE11400H-US

MODEL NUMBER	SE3000H-US	SE3800H-US	SE5000H-US	SE6000H-US	SE7600H-US	SE10000H-US	SE11400H-US
ADDITIONAL FEATURES							
Supported Communication Interfaces	RS485, Ethernet, ZigBee (optional), Cellular (optional)						
Revenue Grade Metering, ANSI C12.20	Optional ⁽³⁾						
Consumption metering	Optional ⁽³⁾						
Inverter Commissioning	With the SetApp mobile application using Built-in Wi-Fi Access Point for Local Connection						
Rapid Shutdown - NEC 2014, NEC 2017 and NEC 2020, 690.12	Automatic Rapid Shutdown upon AC Grid Disconnect						
STANDARD COMPLIANCE							
Safety	UL1741, UL1741 SA, UL1699B, CSA C22.2, Canadian AFCI according to T.L.L. M-07						
Grid Connection Standards	IEEE1547, Rule 21, Rule 14 (H)						
Emissions	FCC Part 15 Class B						
INSTALLATION SPECIFICATIONS							
AC Output Conduit Size / AWG Range	1" Maximum / 14-6 AWG			1" Maximum / 14-4 AWG			
DC Input Conduit Size / # of Strings / AWG Range	1" Maximum / 1-2 strings / 14-6 AWG			1" Maximum / 1-3 strings / 14-6 AWG			
Dimensions with Safety Switch (HxWxD)	17.7 x 14.6 x 6.8 / 450 x 370 x 174		21.3 x 14.6 x 7.3 / 540 x 370 x 185		in / mm		
Weight with Safety Switch	22 / 10	25.1 / 11.4	26.2 / 11.9	38.8 / 17.6	lb / kg		
Noise	< 25			< 50			
Cooling	Natural Convection						
Operating Temperature Range	-40 to +140 / -40 to +60 ⁽⁴⁾						
Protection Rating	NEMA 4X (Inverter with Safety Switch)						

(3) Inverter with Revenue Grade Meter P/N: SExxxxH-US000BNC4; Inverter with Revenue Grade Production and Consumption Meter P/N: SExxxxH-US000BN4. For consumption metering, current transformers should be ordered separately: SEACT0750-200NA-20 or SEACT0750-400NA-20. 20 units per box
(4) Full power up to at least 50°C / 122°F; for power de-rating information refer to: <https://www.solaredge.com/sites/default/files/se-temperature-de-rating-note-na.pdf>

How to Enable Consumption Monitoring

By simply wiring current transformers through the inverter's existing AC conduits and connecting them to the service panel, homeowners will gain full insight into their household energy usage helping them to avoid high electricity bills

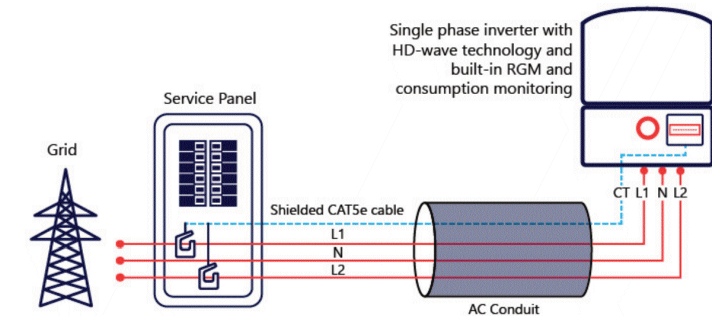

© SolarEdge Technologies, Inc. All rights reserved. SOLAREGE, the SolarEdge logo, OPTIMIZED BY SOLAREGE are trademarks or registered trademarks of SolarEdge Technologies, Inc. All other trademarks mentioned herein are trademarks of their respective owners. Date: 12/2020/V01/ENG NAM. Subject to change without notice.

RoHS

TITAN
SOLAR POWER
525 W BASELINE RD., MESA AZ, 85210
CONTRACTOR LIC# U.34445

CAMPBELL, MICHAEL RESIDENCE
141 BREEZEWOOD DRIVE, LILLINGTON, NC, 27546
LAT:35.301118, LON:-78.973852
TSP156877

(30) HY-DH108P8-400B
(1) SOLAREGE SE10000H-US
12.000 kW DC SYSTEM SIZE
10.000 kW AC SYSTEM SIZE

DATE: 4/13/2023
REV: A
DRAWN BY: HM

SEAL:

EQUIPMENT SPECIFICATIONS
PV 10



Intertek
3933 US Route 11
Cortland, NY 13045
Telephone: 607-753-7311
www.intertek.com

Subject: ETL Evaluation of SolarEdge Products to Rapid Shutdown Requirements

To, whom it may concern

This letter represents the testing results of the below listed products to the requirements contained in the following standards:

The evaluation was done on the PV Rapid Shutdown System (PVRSS), and covers installations consisting of optimizers and inverters with part numbers listed below.

The testing done has verified that controlled conductors are limited to:

- Not more than 30 volts and 240 voltamperes within 30 seconds of rapid shutdown initiation outside the array.
- Not more than 80 volts and 240 voltamperes within 30 seconds of rapid shutdown initiation inside the array.

The rapid shutdown initiation is performed by either disconnecting the AC feed to the inverter, or – if the inverter DC Safety switch is readily accessible – by turning off the DC Safety switch.

Applicable products:

(1) Power optimizers:

PB followed by 001 to 350; followed by -AOB or -TFI.
OP followed by 001 to 500; followed by -LV, -MV, -IV or -EV.
P followed by 001 to 1100.
SP followed by 001 to 350.

When optimizers are connected to 2 or more modules in series, the max input voltage may exceed 80V. Following the implementation of the NEC 2017 rapid shutdown value of 80V max inside of the array at the beginning of 2019, modules exceeding this combined input max voltage will be required to use optimizers with parallel inputs. Also meeting NEC 2020 rapid shutdown requirement.

(2) 1 -PH Inverters

SE3000A-US / SE3800A-US / SE5000A-US / SE6000A-US / SE7600A-US / SE10000A-US / SE11400A-US / SE3000H-US / SE3800H-US / SE5000H-US / SE6000H-US / SE7600H-US / SE10000H-US / SE11400H-US when the following label is labeled on the side of the inverter:

Inverter part number may be followed by a suffix.

(3) 3 -PH Inverters



Intertek
3933 US Route 11
Cortland, NY 13045
Telephone: 607-753-7311
www.intertek.com

SE9KUS / SE10KUS / SE14.4KUS/ SE16.7kUS / SE17.3KUS / SE20KUS/ SE24KUS / SE30KUS / SE33.3KUS / SE40KUS / SE43.2KUS / SE50KUS / SE66.6KUS / SE80KUS / SE85KUS / SE100KUS / SE120KUS; when the following label is labeled on the side of the inverter:

Please note, this Letter Report does not represent authorization for the use of any Intertek certification marks.

Brand Name(s) SolarEdge
Relevant Standard(s) UL 1741, UL 1741 CRD for rapid shutdown
Verification Issuing Office National Electric Code, 2020, Section 690.12 requirement for rapid shutdown
3933 US Route 11, Cortland, NY 13045

NRTL Disclaimer, Different for each NRTL – Example: "This Verification is for the exclusive use of NRTL's Client and is provided pursuant to the agreement between NRTL and its Client. NRTL's responsibility and liability are limited to the terms and conditions of the agreement. NRTL assumes no liability to any party, other than to the Client in accordance with the agreement, for any loss, expense or damage occasioned by the use of this Verification. Only the Client is authorized to copy or distribute this Verification. Any use of the NRTL name or one of its marks for the sale or advertisement of the tested material, product or service must first be approved in writing by NRTL. The observations and test results referenced from this Verification are relevant only to the sample tested. This Verification by itself does not imply that the material, product, or service is or has ever been under an NRTL certification program."


Signature:

Name: Mukund Rana
Position: Staff Engineer
Date: 5/17/2021



Intertek
3933 US Route 11
Cortland, NY 13045
Telephone: 607-753-7311
www.intertek.com

Date	Engineer / Reviewer	Description
5/17/2021 G104683664CRT	Dishant Patel	Added New 3-PH Inverter model SE50KUS, SE80KUS, SE85KUS and SE120KUS.
	Mukund Rana	Updated Power optimizers from "P followed by 001 to 960" to "P followed by 001 to 1100" Updated NEC standard from "National Electric Code, 2017, Section 690.12 requirement for rapid shutdown" To "National Electric Code, 2020, Section 690.12 requirement for rapid shutdown"

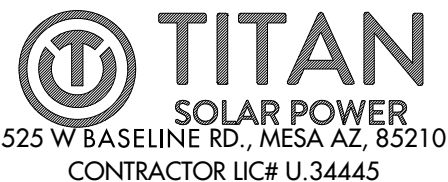

CAMPBELL, MICHAEL RESIDENCE
141 BREEZEWOOD DRIVE , LILLINGTON, NC, 27546
LAT:35.301118, LON:-78.973852
TSP156877

(30) HY-DH108P8-400B
(1) SOLAREEDGE SE10000H-US
12.000 kW DC SYSTEM SIZE
10.000 kW AC SYSTEM SIZE

DATE: 4/13/2023
REV: A
DRAWN BY: HM

SEAL:

EQUIPMENT SPECIFICATIONS
PV 11

Power Optimizer For Residential Installations

S440 / S500 / S500B



POWER OPTIMIZER

Enabling PV power optimization at the module level

- Specifically designed to work with SolarEdge residential inverters
- Detects abnormal PV connector behavior, preventing potential safety issues*
- Module-level voltage shutdown for installer and firefighter safety
- Superior efficiency (99.5%)
- Mitigates all types of module mismatch loss, from manufacturing tolerance to partial shading
- Faster installations with simplified cable management and easy assembly using a single bolt
- Flexible system design for maximum space utilization
- Compatible with bifacial PV modules

*Functionality subject to inverter model and firmware version

solaredge.com



/ Power Optimizer For Residential Installations S440 / S500 / S500B

	S440	S500	S500B	UNIT
INPUT				
Rated Input DC Power ⁽¹⁾	440		500	W
Absolute Maximum Input Voltage (Voc)		60	125	Vdc
MPPT Operating Range		8 – 60	12.5 – 105	Vdc
Maximum Short Circuit Current (Isc) of Connected PV Module	14.5		15	Adc
Maximum Efficiency		99.5		%
Weighted Efficiency		98.6		%
Overvoltage Category		II		
OUTPUT DURING OPERATION				
Maximum Output Current		15		Adc
Maximum Output Voltage		60	80	Vdc
OUTPUT DURING STANDBY (POWER OPTIMIZER DISCONNECTED FROM INVERTER OR INVERTER OFF)				
Safety Output Voltage per Power Optimizer		1 ± 0.1		Vdc
STANDARD COMPLIANCE⁽²⁾				
EMC	FCC Part 15 Class B, IEC61000-6-2, IEC61000-6-3, CISPR11, EN-55011			
Safety	IEC62109-1 (class II safety), UL1741			
Material	UL94 V-0, UV Resistant			
RoHS	Yes			
Fire Safety	VDE-AR-E 2100-712:2018-12			
INSTALLATION SPECIFICATIONS				
Maximum Allowed System Voltage		1000		Vdc
Dimensions (W x L x H)		129 x 155 x 30	129 x 155 x 45	mm
Weight (including cables)		655		gf
Input Connector		MC4 ⁽³⁾		
Input Wire Length		0.1		m
Output Connector		MC4		
Output Wire Length		(+) 2.3, (-) 0.10		m
Operating Temperature Range ⁽⁴⁾		-40 to +85		°C
Protection Rating		IP68		
Relative Humidity		0 – 100		%

⁽¹⁾ Rated power of the module at STC will not exceed the Power Optimizer Rated Input DC Power. Modules with up to +5% power tolerance are allowed.

⁽²⁾ For details about CE compliance, see [Declaration of Conformity – CE](#).

⁽³⁾ For other connector types please contact SolarEdge.


⁽⁴⁾ For ambient temperatures above +70°C power de-rating is applied. Refer to [Power Optimizers Temperature De-Rating Technical Note](#) for details.

PV System Design Using a SolarEdge Inverter ⁽⁵⁾	SolarEdge Home Wave Inverter Single Phase	SolarEdge Home Short String Inverter Three Phase	Three Phase for 230/400V Grid	Three Phase for 277/480V Grid	
Minimum String Length (Power Optimizers)	S440, S500: 8 S500B: 6	9	16	18	
Maximum String Length (Power Optimizers)	25	20	50		
Maximum Continuous Power per String	5700	5625	11250	12750	W
Maximum Allowed Connected Power per String (Permitted only when the power difference between strings is less than 2,000W)	See ⁽⁶⁾	See ⁽⁶⁾	13500	15000	W
Parallel Strings of Different Lengths or Orientations	Yes				

⁽⁵⁾ It is not allowed to mix S-series and P-series Power Optimizers in new installations.

⁽⁶⁾ If the inverter's rated AC power < maximum nominal power per string, then the maximum power per string will be able to reach up to the inverters maximum input DC power.

Refer to [Application Note: Single String Design Guidelines](#).

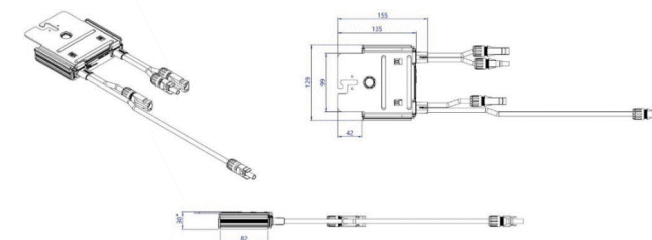

*45mm for S500B

© SolarEdge Technologies, Ltd. All rights reserved. SOLAREGE, the SolarEdge logo, OPTIMIZED BY SOLAREGE are trademarks or registered trademarks of SolarEdge Technologies, Inc. All other trademarks mentioned herein are trademarks of their respective owners. Date: November 8, 2022 DS-000091-ENG. Subject to change without notice.

CE RoHS

TITAN
SOLAR POWER
525 W BASELINE RD., MESA AZ, 85210
CONTRACTOR LIC# U.34445

CAMPBELL, MICHAEL RESIDENCE
141 BREEZEWOOD DRIVE, LILLINGTON, NC, 27546
LAT:35.301118, LON:-78.973852
TSP156877

(30) HY-DH108P8-400B
(1) SOLAREGE SE10000H-US
12.000 kW DC SYSTEM SIZE
10.000 kW AC SYSTEM SIZE

DATE: 4/13/2023
REV: A
DRAWN BY: HM

SEAL:

EQUIPMENT
SPECIFICATIONS
PV 12



TITAN SOLAR POWER
 525 W BASELINE RD
 MESA, AZ 85210
 TEL 855 SAY-SOLAR
 INFO@TITANSOLARPOWER
 TITANSOLARPOWER.COM

390-410W

HIGH CONVERSION EFFICIENCY
 Module efficiency up to 21.0% through advanced cell technology and manufacturing process


EXCELLENT WEAK LIGHT PERFORMANCE
 More power output in weak light condition, such as cloudy days, morning and sunset

EXTENDED MECHANICAL PERFORMANCE
 Module certified to withstand extreme wind (2400 Pa) and snow loading (5400 Pa)

QUALITY GUARANTEE
 High module quality ensures long-term reliability

INFO@HYPERION-USA.COM
 7/559 MOO.6, MAPYANGPHON SUBDISTRICT,
 PLUAK DAENG DISTRICT, RAYONG PROVINCE,
 21140, THAILAND

HY-DH108P8
 108 HALF-CELL BIFACIAL MODULE

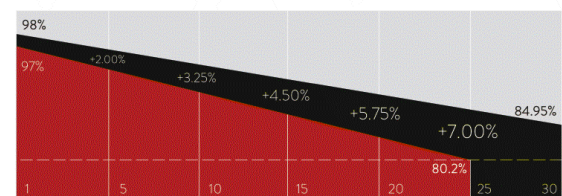

■ Conventional Module ■ Hyperion Performance
 25 Years warranty for materials and workmanship
 30 Years warranty for extra linear power output



IEC61215 / IEC61730 / UL61730
 IEC61701 / IEC62716
 ISO9001: Quality Management System

12/22

BLACK DH108P8

Mechanical Parameters


Solar Cell	Mono PERC 182mm
No. of Cells	108 (6 × 18)
Dimensions	1722 × 1134 × 30mm (67.08 × 44.65 × 1.18in.)
Weight	25.2kg (55.55lbs)
Junction Box	IP68 rated (3 bypass diodes)
Output Cables	4mm ² (IEC), 12 AWG (UL) (-/+1200mm (47.24in.) or customized)
Connector	EVO2 or customized
Front Cover	2.0mm (0.079in.) semi-tempered AR glass
Back Cover	2.0mm (0.079in.) semi-tempered glass
Container	36 pcs/Pallet, 792 pcs/40' HC

Operating Parameters

Max. System Voltage	DC 1500V (IEC/UL)
Operating Temperature	-40°C ~ +85°C (-40°F ~ +185°F)
Max. Fuse Rating	30A
Frontside Max. Loading	5400Pa (112lb/ft ²)
Backside Max. Loading	2400Pa (50lb/ft ²)
Bifaciality	70%±10%
Fire Resistance	IEC Class A, UL Type 29

HY-DH108P8-390/410B

Engineering Drawing

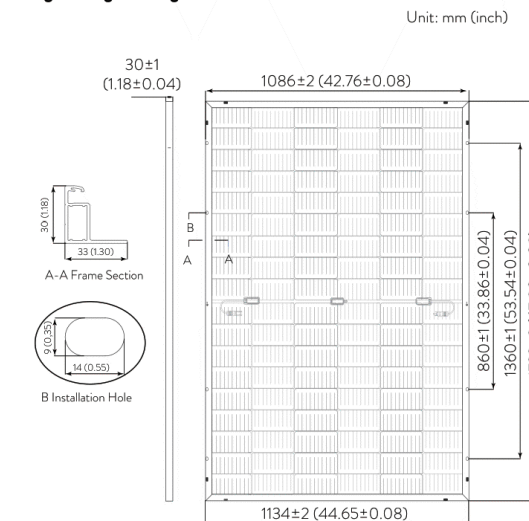

Electrical Characteristics - STC

	Irradiance 1000 W/m ² , ambient temperature 25 °C, AM1.5				
Maximum Power at STC (Pmax/W)	410	405	400	395	390
Power Tolerance (W)	0 ~ +5				
Optimum Operating Voltage (Vmp/V)	31.45	31.21	31.01	30.84	30.64
Optimum Operating Current (Imp/A)	13.04	12.98	12.90	12.81	12.73
Open Circuit Voltage (Voc/V)	37.32	37.23	37.07	36.98	36.85
Short Circuit Current (Isc/A)	13.95	13.87	13.79	13.70	13.61
Module Efficiency	21.0%	20.7%	20.5%	20.2%	20.0%

Electrical Characteristics - NMOT

	Irradiance 800 W/m ² , ambient temperature 20 °C, AM1.5, wind speed 1 m/s.				
Maximum Power at NMOT (Pmax/W)	310.2	306.4	302.5	298.8	295.0
Optimum Operating Voltage (Vmp/V)	29.82	29.60	29.41	29.25	29.15
Optimum Operating Current (Imp/A)	10.40	10.35	10.29	10.22	10.15
Open Circuit Voltage (Voc/V)	35.39	35.31	35.15	35.07	34.95
Short Circuit Current (Isc/A)	11.25	11.19	11.13	11.05	10.98


Rearside Power Gain (Reference to 410W Front)

	5%	15%	25%
Rearside Power Gain	5%	15%	25%
Maximum Power (Pmax/W)	431.4	472.3	514.8
Optimum Operating Voltage (Vmp/V)	31.57	31.57	31.65
Optimum Operating Current (Imp/A)	13.66	14.96	16.27
Open Circuit Voltage (Voc/V)	37.46	37.46	37.46
Short Circuit Current (Isc/A)	14.57	15.96	17.35
Module Efficiency	22.1%	24.2%	26.4%

Temperature Characteristics

Nominal Module Operating Temperature	42 ± 2 °C
Nominal Cell Operating Temperature	45 ± 2 °C
Temperature Coefficient of Pmax	-0.35%/°C
Temperature Coefficient of Voc	-0.27%/°C
Temperature Coefficient of Isc	0.05%/°C

Current-Voltage & Power-Voltage Curve (410W)

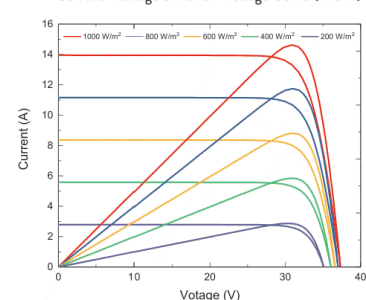

©Copyright 2022 HYPERION
 HY-DH108P8-EN-V1.4 US
 www.hyperion-usa.com



CAMPBELL, MICHAEL RESIDENCE
 141 BREEZEWOOD DRIVE, LILLINGTON, NC, 27546
 LAT:35.301118, LON:-78.973852
 TSP156877


(30) HY-DH108P8-400B
 (1) SOLAREdge SE10000H-US
 12.000 kW DC SYSTEM SIZE
 10.000 kW AC SYSTEM SIZE

DATE: 4/13/2023
 REV: A
 DRAWN BY: HM

SEAL:

EQUIPMENT SPECIFICATIONS
PV 13

We support PV systems
Formerly Everest Solar Systems

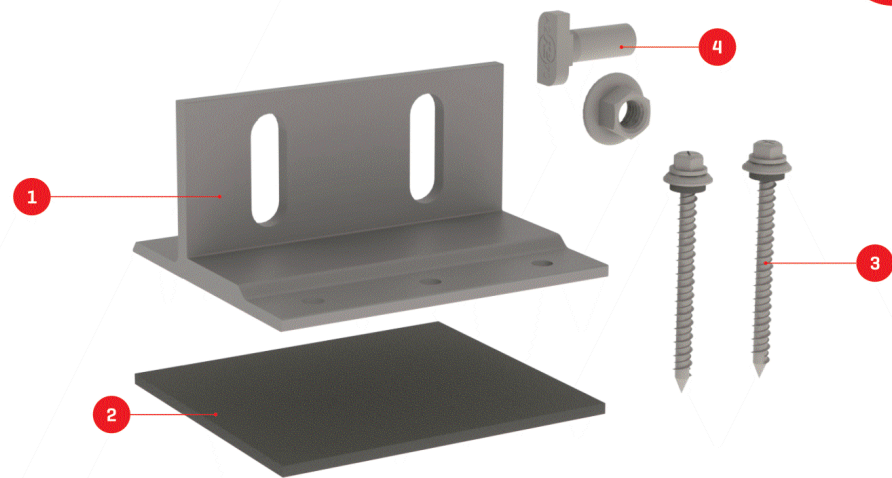

Splice Foot X

Patent Pending

TECHNICAL SHEET

Item Number	Description	Part Number
1	Splice Foot X	4000113 Splice Foot X Kit, Mill
2	K2 FlexFlash Butyl	
3	M5 x 60 lag screws	
4	T-Bolt & Hex Nut Set	

Technical Data





Splice Foot X	
Roof Type	Composition shingle
Material	Aluminum with stainless steel hardware
Finish	Mill
Roof Connection	M5 x 60 lag screws
Code Compliance	UL 2703
Compatibility	CrossRail 44-X, 48-X, 48-XL, 80

k2-systems.com

We support PV systems
Formerly Everest Solar Systems




Units: [in] mm

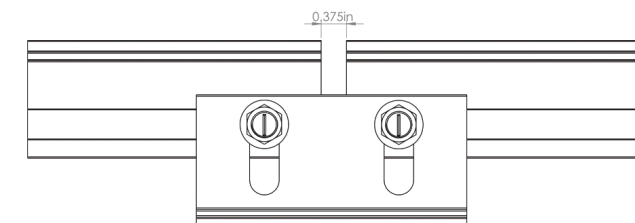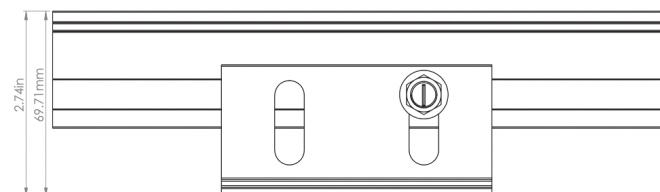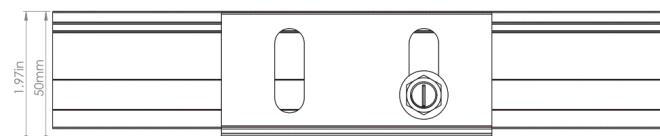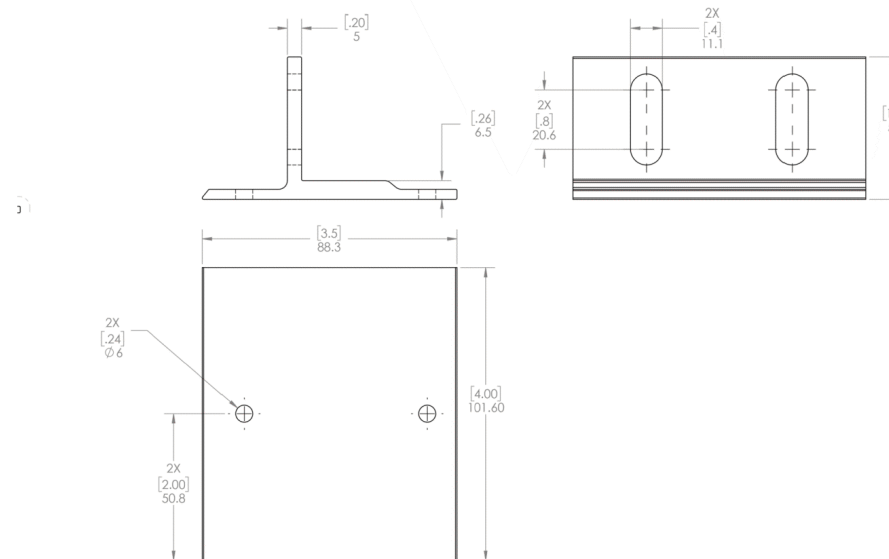

k2-systems.com




NEW!

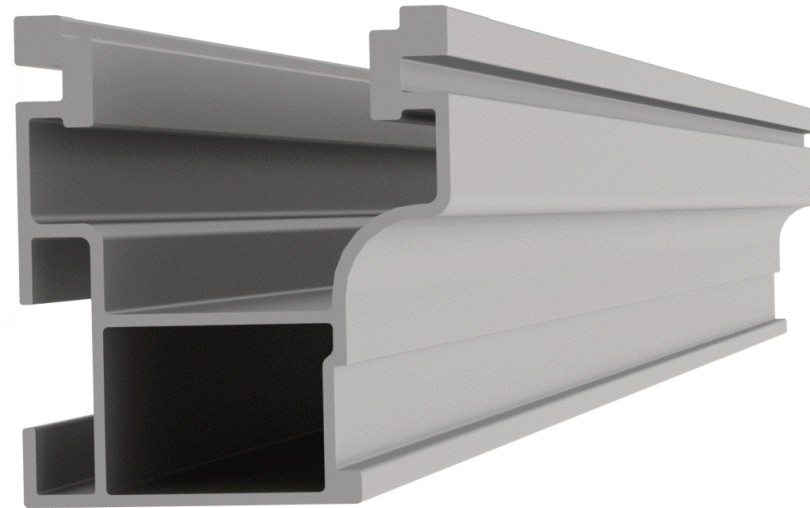


NEW PRODUCT

CrossRail 44-X

 - ▶ Optimized rail profile
- ▶ One rail for all markets
- ▶ Built-in wire management
- ▶ Maintains same structural integrity as 48-X
- ▶ Tested up to 200 mph winds
- ▶ Tested up to 100 PSF snow loads



Part Number	Description
4000019	CrossRail 44-X 166", Mill
4000020	CrossRail 44-X 166", Dark
4000021	CrossRail 44-X 180", Mill
4000022	CrossRail 44-X 180", Dark
4000051	RailConn Set, CR 44-X, Mill
4000052	RailConn Set, CR 44-X, Dark
4000067	End Cap, Black, CR 44-X

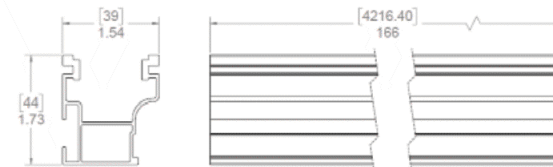

www.everest-solarsystems.com
 CrossRail 44-X Product Sheet US01 | 0520 · Subject to change · Product illustrations are exemplary and may differ from the original.

Recommended OCPD Size per Grid

Inverter	Maximum Output Current (A)	Minimum Fuse Rating (A)	Maximum Fuse Rating (A)
SE3000H-US	12.5	20	50
SE3800H-US	16	20	50
SE5000H-US	24 @ 208V 21 @ 240V	30	50
SE6000H-US	24 @ 208V 25 @ 240V	30 @ 208V 35 @ 240V	50
SE7600H-US	32	40	50
SE10000H-US	42	60	80
SE11400H-US	48.5 @ 208V 47.5 @ 240V	70 @ 208V 60 @ 240V	80

SolarEdge Single Phase Inverter with HD-Wave Technology Installation MAN-01-00541-1.1