


**THE PYROCADD COMPANY**  
 A FIRE SYSTEM DESIGN FIRM  
 A NICET CERTIFIED COMPANY  
 PO BOX 103  
 OAK ISLAND, NC 28465  
 910-933-1084  
 dave@pyrocadd.com  
 WWW.PYROCADD.COM

**DIVERSIFIED CONSULTING GROUP, PLLC**  
 PLUMBING  
 MECHANICAL  
 ELECTRICAL  
 FIRE ALARM

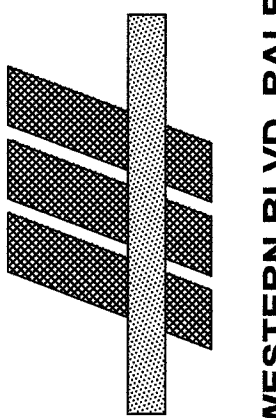


4671 WESTERN BLVD, RALEIGH, NC 27606  
 PHONE: 919-859-8183 FAX: 919-859-8991  
 EMAIL: INFO@DCGRALEIGH.COM



This drawing and the design shown are the property of DCG. This reproduction, copying or other use of this drawing without the written consent is prohibited.  
 © 2019  
 Diversified Consulting Group, PLLC

**NEW FIRE ALARM SYSTEM FOR:**  
**CAROLINA CHARTER ACADEMY**  
 8529 HIGHWAY 55  
 ANGLIER, NORTH CAROLINA 27501

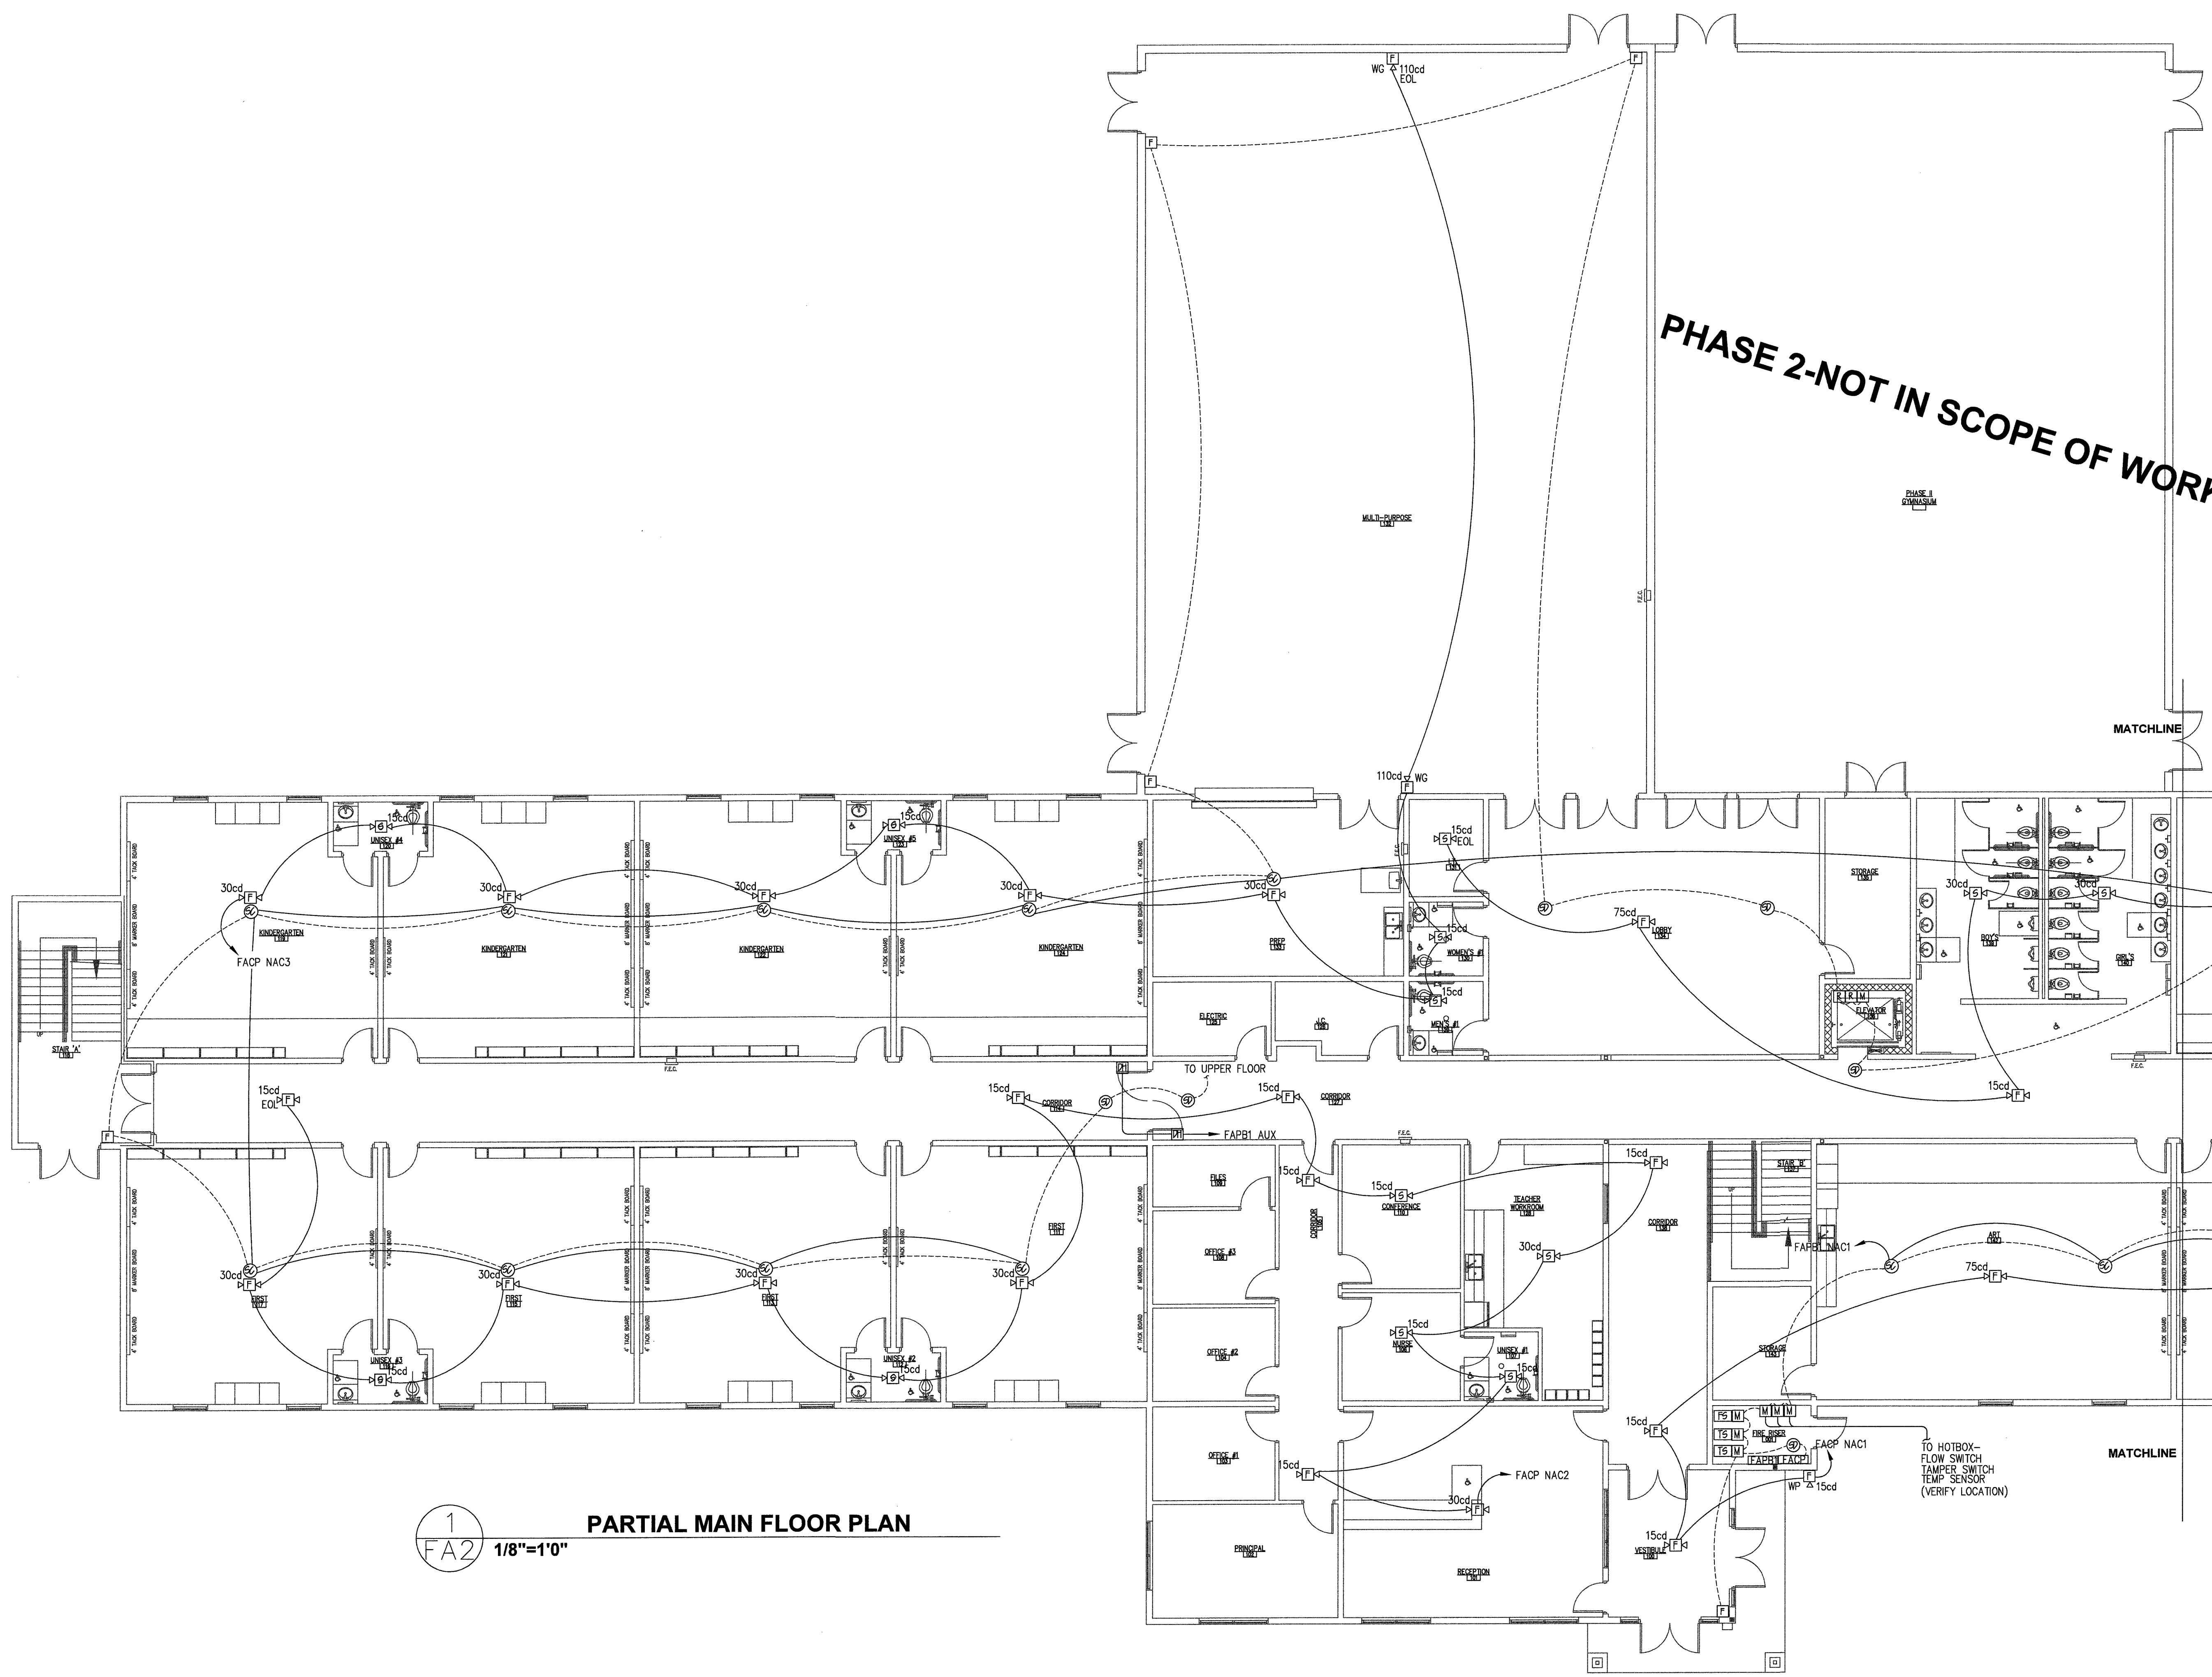

**1**  
**FA2** PARTIAL MAIN FLOOR PLAN  
 1/8"=1'0"

|               |           |
|---------------|-----------|
| PROJECT NO:   | 18-103-33 |
| DATE:         | 3/21/19   |
| CAD DWG FILE: | FA1.dwg   |
| DRWN BY:      | DWR       |
| CHKD BY:      | WHC       |

**FIRE ALARM PLAN**  
**FA2**