

Pyrocadd



THE PYROCADD COMPANY
A FIRE SYSTEM DESIGN FIRM
A NICET CERTIFIED COMPANY
PO BOX 103
OAK ISLAND, NC 28465
910-933-1084
dave@pyrocadd.com
WWW.PYROCADD.COM

DIVERSIFIED CONSULTING GROUP, PLLC
PLUMBING
MECHANICAL
ELECTRICAL
FIRE ALARM
4671 WESTERN BLVD., RALEIGH, NC 27606
PHONE: 919-858-8183 FAX: 919-858-8991
EMAIL: INFO@DCGRALEIGH.COM




This drawing and the design shown are the property of DCG. The reproduction, copying or other use of this drawing without their written consent is prohibited.
© 2019 Diversified Consulting Group, PLLC


NEW FIRE ALARM SYSTEM FOR:
CAROLINA CHARTER ACADEMY
8529 HIGHWAY 55
ANGIER, NORTH CAROLINA 27501

PROJECT NO: 18-103-33
DATE: 3/21/19
CAD DWG FILE: FA1.dwg
DRWN BY: DWR CHKD BY: WHC

FIRE ALARM PLAN
FA3

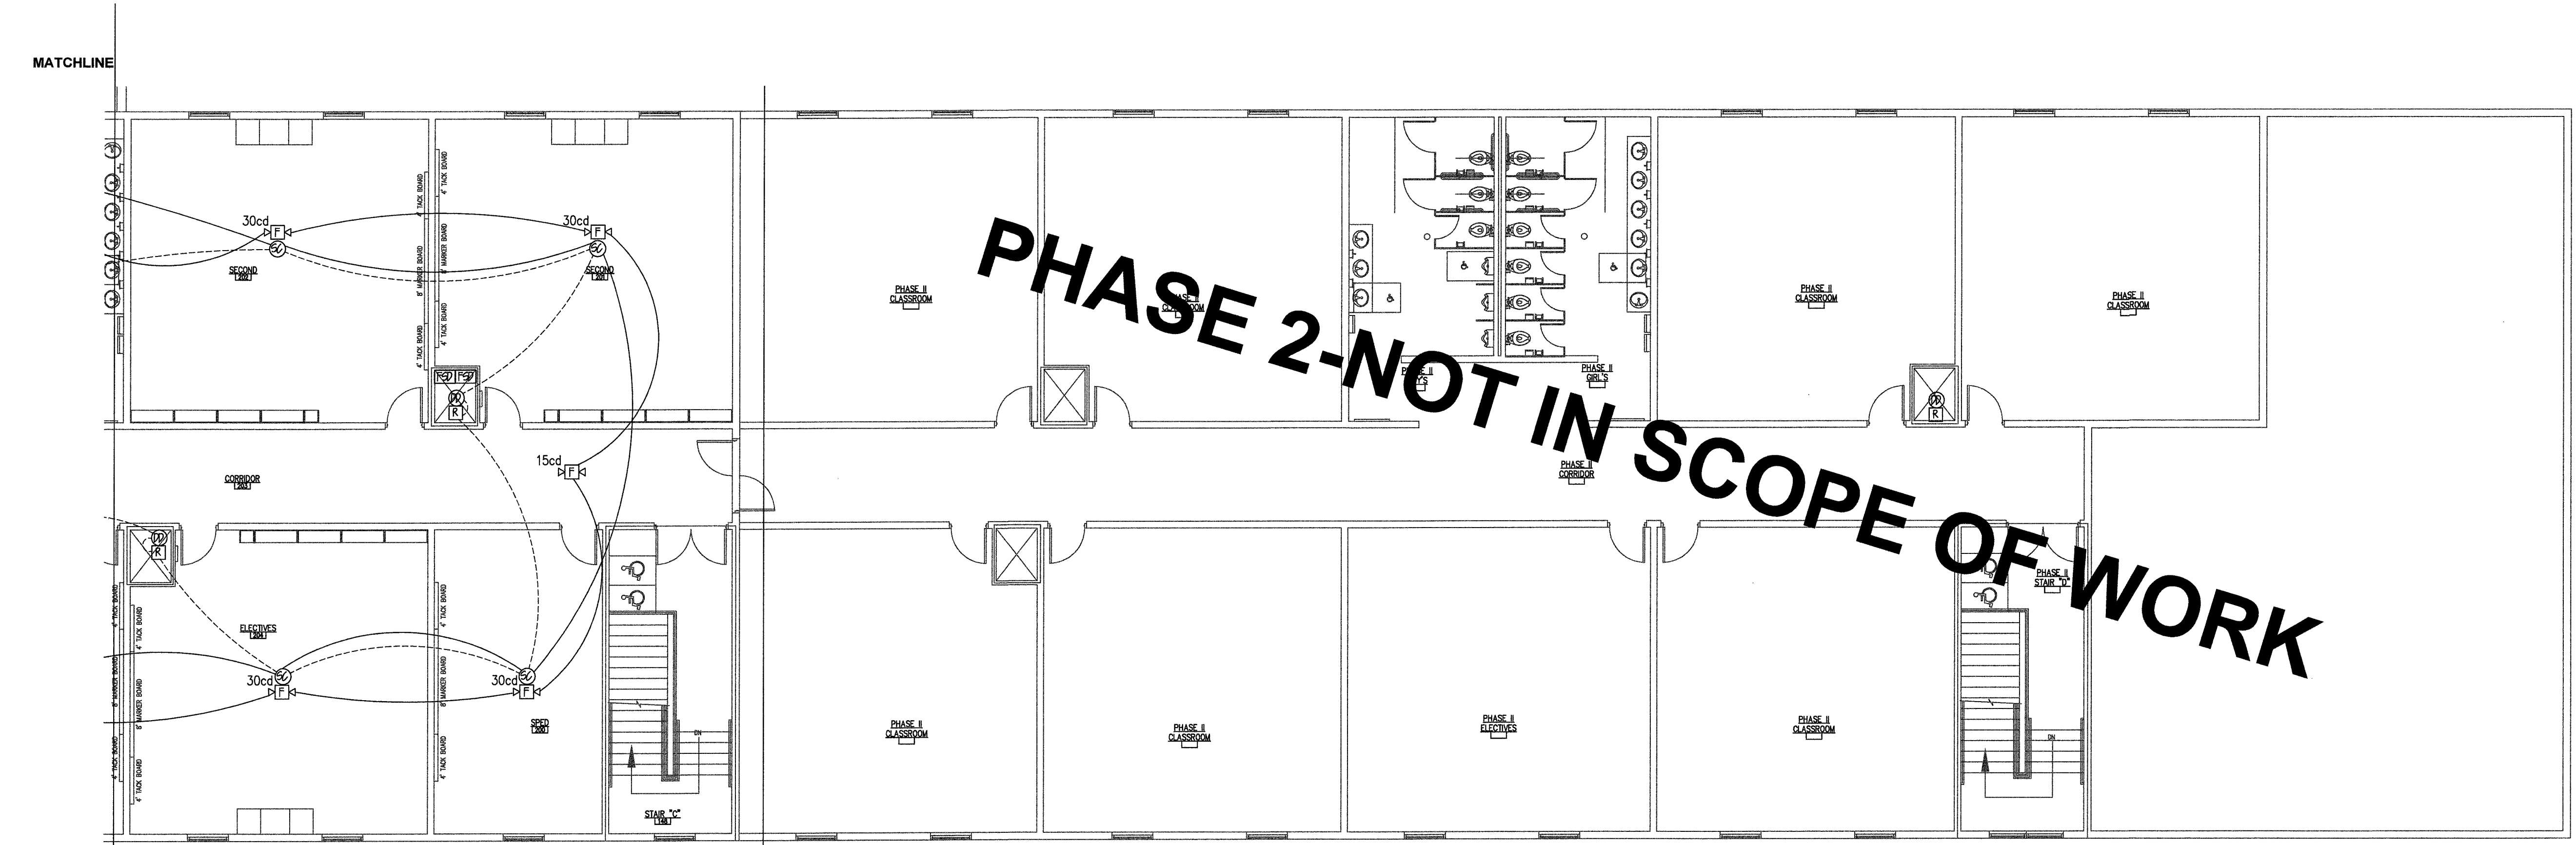

1
FA3 1/8"=1'0"
UPPER FLOOR PLAN (CONT.)

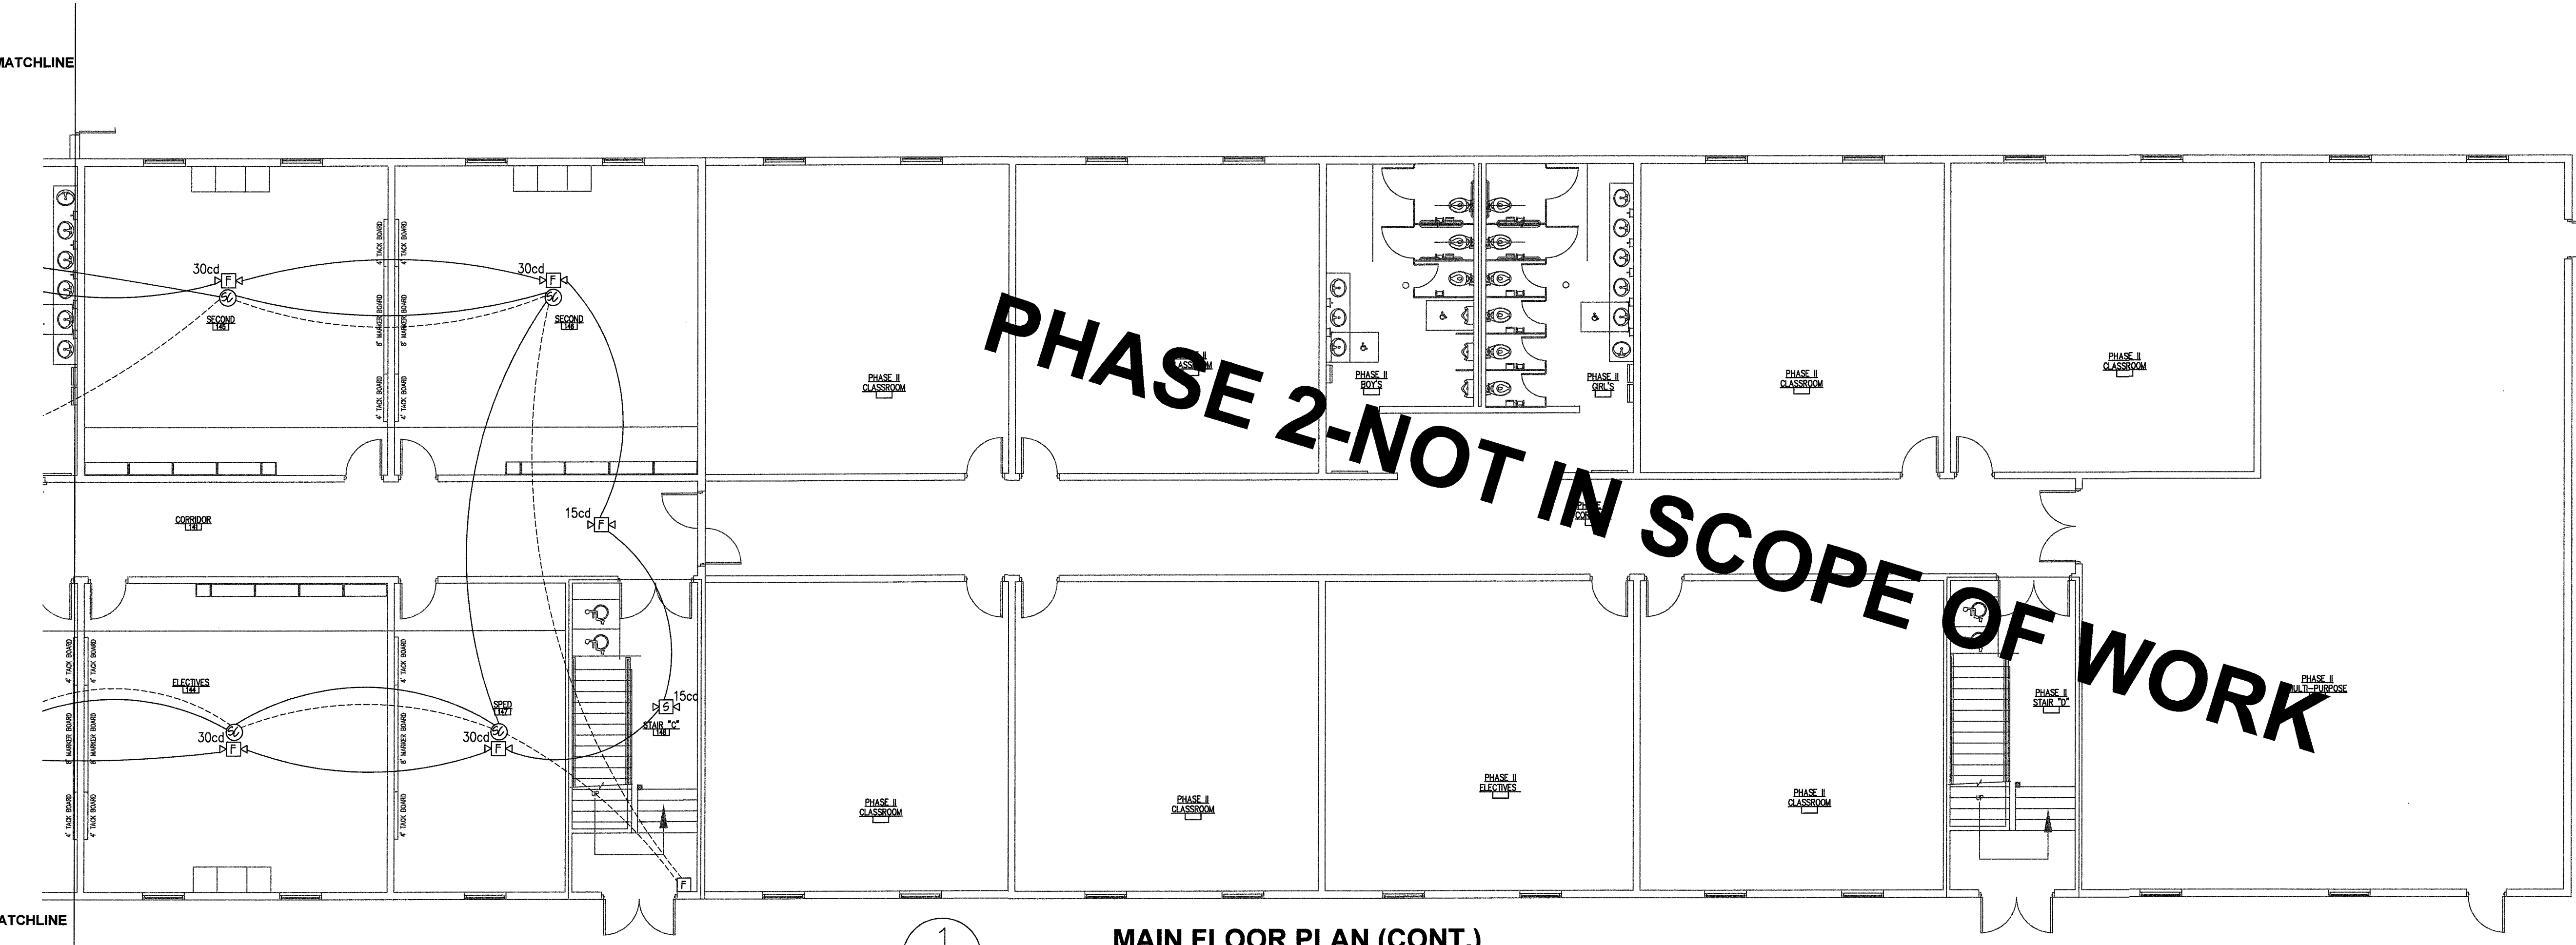

1
FA3 1/8"=1'0"
MAIN FLOOR PLAN (CONT.)