


Pyrocadd
 THE
PYROCADD
 COMPANY
 A FIRE SYSTEM DESIGN FIRM
 A NICET CERTIFIED COMPANY
 PO BOX 103
 OAK ISLAND, NC 28465
 910-933-1084
 dave@pyrocadd.com
 WWW.PYROCADD.COM

DIVERSIFIED CONSULTING GROUP, PLLC
 PLUMBING
 MECHANICAL
 ELECTRICAL
 FIRE ALARM
 4671 WESTERN BLVD, RALEIGH, NC 27606
 PHONE: 919-899-8183 FAX: 919-899-8991
 EMAIL: INFO@DCGRALEIGH.COM

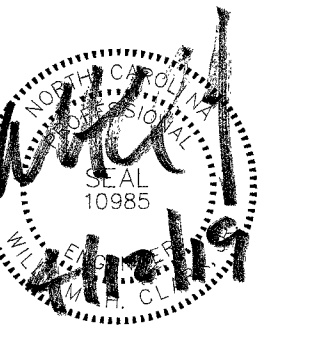


This drawing and the design shown are the property of DCG. The reproduction, copying or other use of this drawing without prior written consent is prohibited.
 © 2019
 Diversified Consulting Group, PLLC

NEW FIRE ALARM SYSTEM FOR:
CAROLINA CHARTER ACADEMY
 8529 HIGHWAY 55
 ANGLIER, NORTH CAROLINA 27501

PROJECT NO: 18-103-33
 DATE: 3/21/19
 CAD DWG FILE: FA1.dwg
 DRWN BY: DWR CHKD BY: WHC

**FIRE ALARM
 PLAN**

FA4

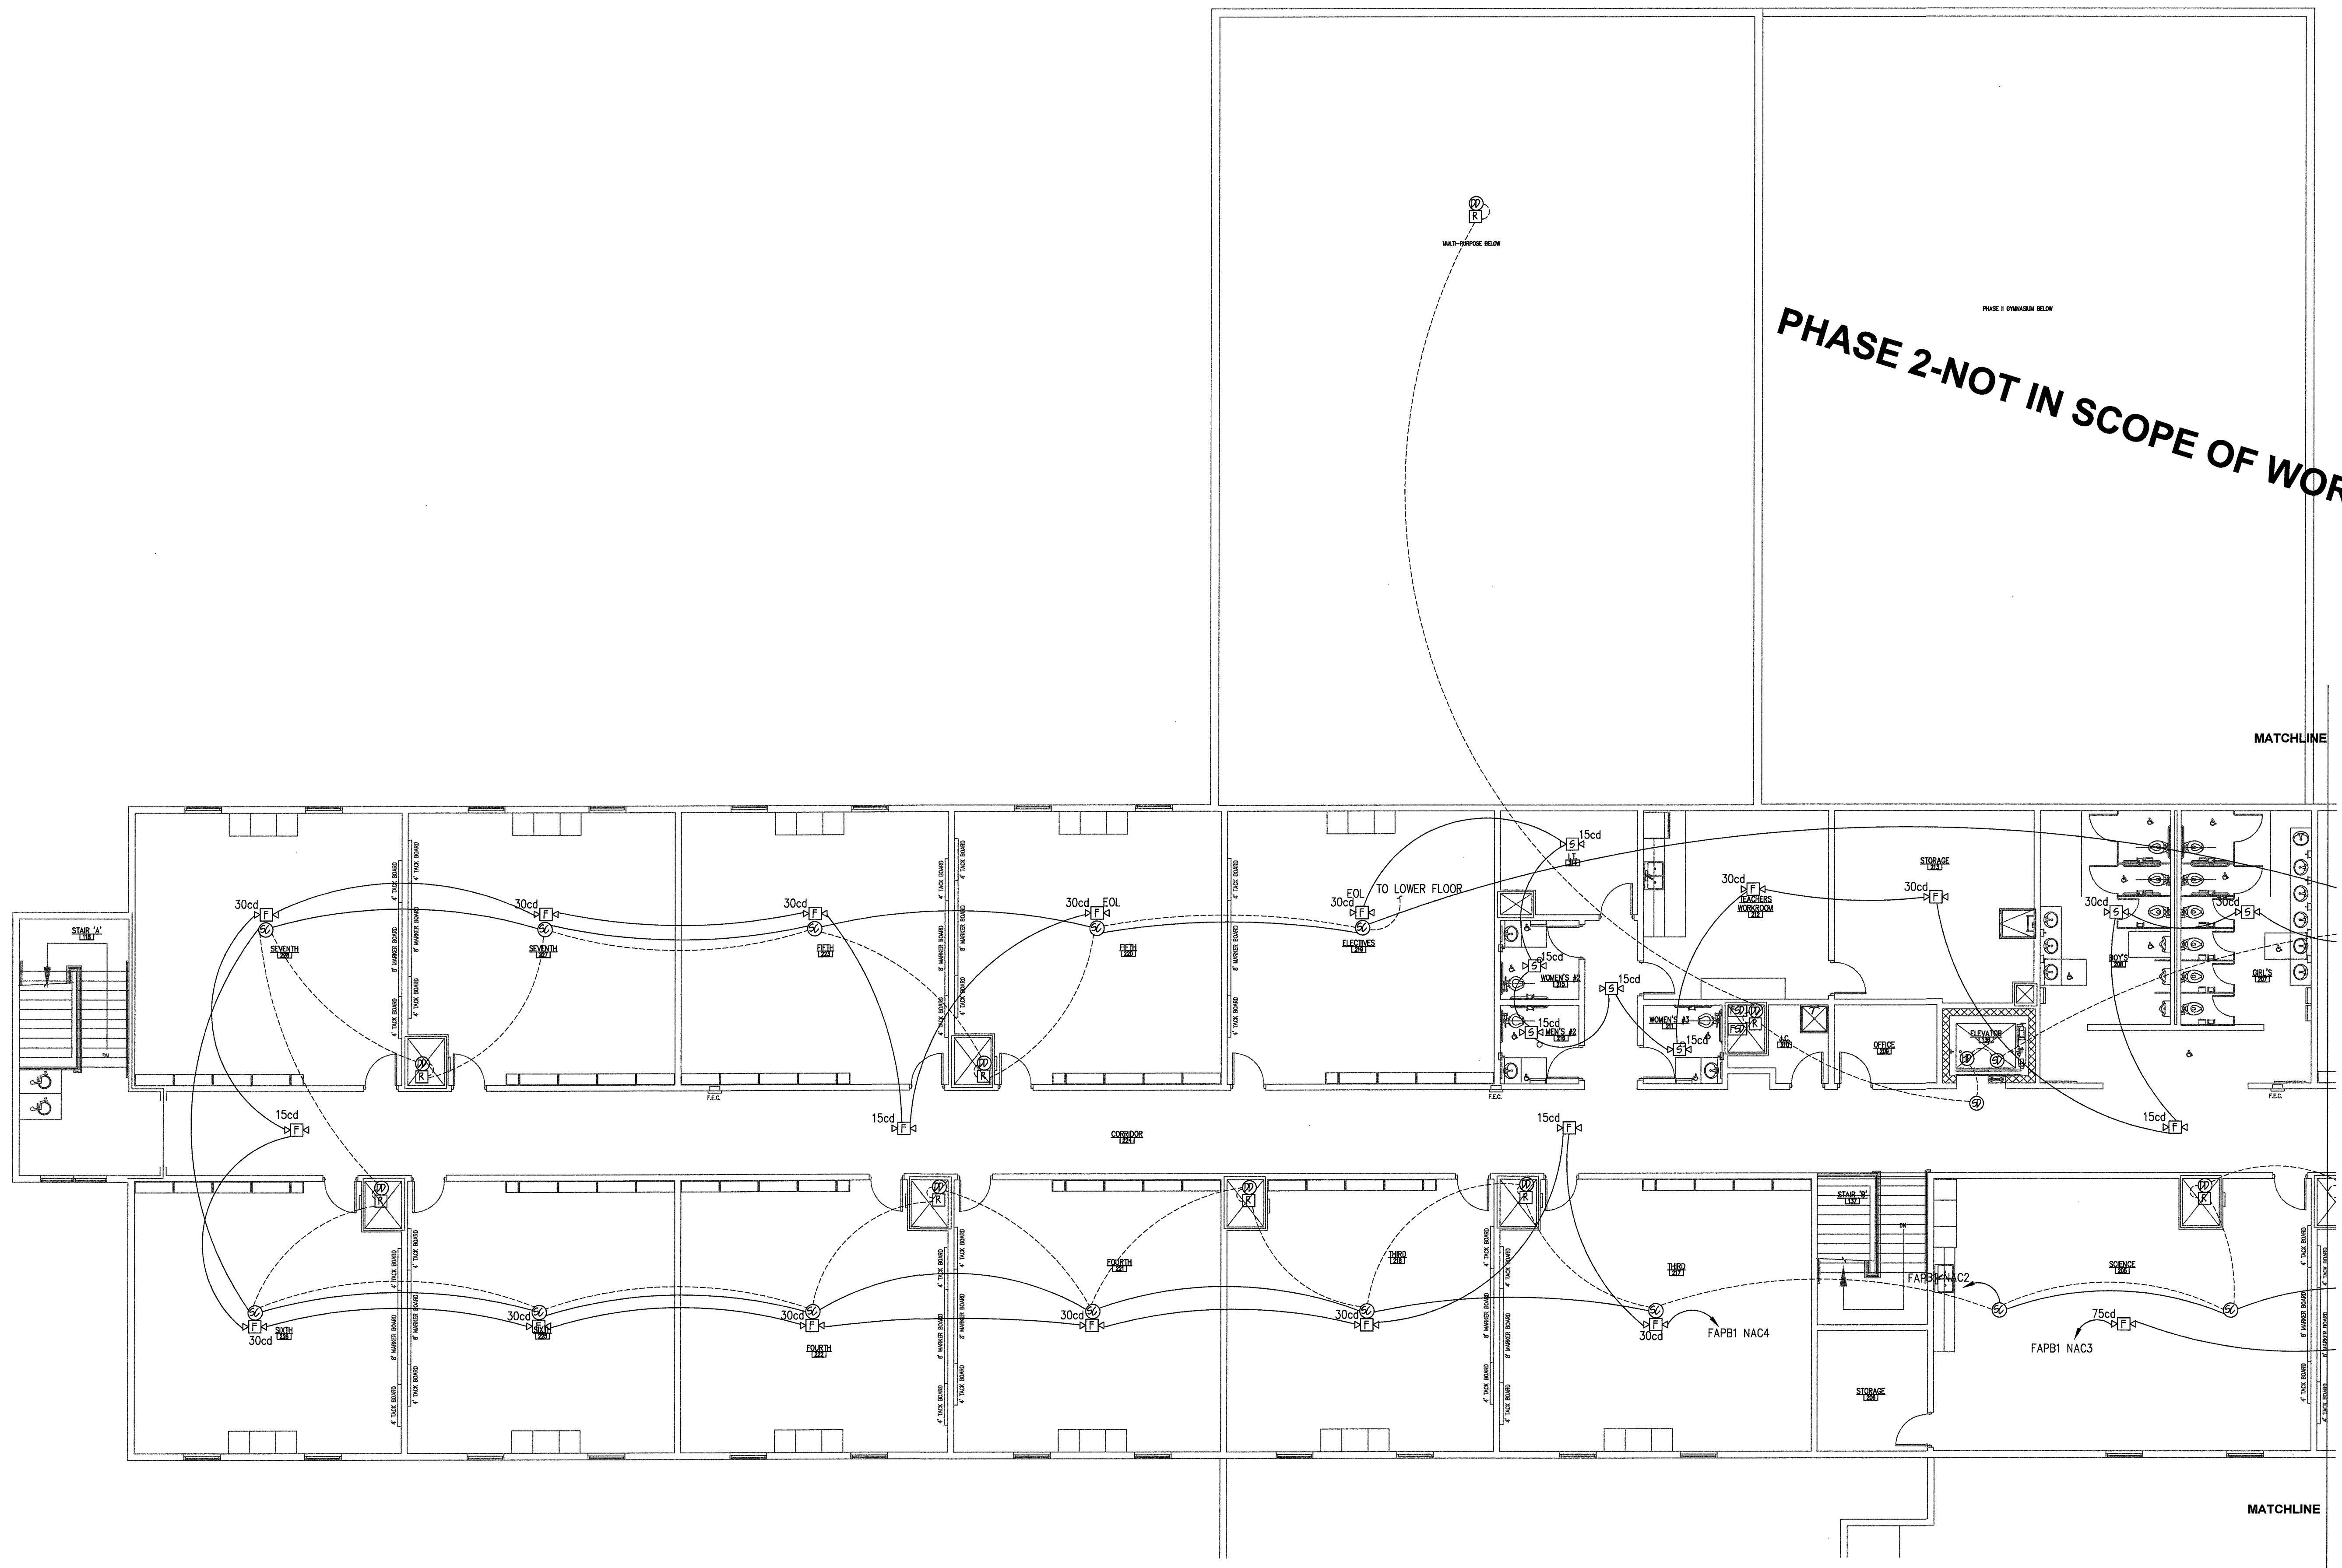

1
 FA4 1/8"=1'0"
PARTIAL UPPER FLOOR PLAN