

C

AMBASSADOR SERIES FIRE EXTINGUISHER CABINET.
5 LBS. ABC FIRE EXTINGUISHER W/ MOUNTING
BRACKET. (PROVIDED RATED CABINET ON RATED
WALL)

SURFACE MOUNTED

EXIT WIDTH

PROVIDED EXIT WIDTH
DOORS 2 @ 34" EACH & 6 DOORS @ 70"
TOTAL PROVIDED 488"

KEYNOTE

1 1016.2 EGRESS THROUGH INTERVENING SPACES - 2.) EXCEPTION: MEANS OF EGRESS ARE NOT PROHIBITED THROUGH ADJOINING OR INTERVENING SPACES IN GROUP H, S, OR F OCCUPANCY WHERE ADJOINING SPACES ARE THE SAME OR LESSER HAZARD OCCUPANCY GROUP.

GENERAL NOTES


NOTES:

- 1. TRAVEL PATHS SHOWN ARE ILLUSTRATIVE OF MAXIMUM TRAVEL DISTANCE ONLY AND DO NOT DESIGNATE ALL EGRESS PATHS.
- 2. DOORS MARKED 'REQUIRED EIT' ARE REQUIRED EXTERIOR EIT DOORS AND SHALL COMPLY WITH REQUIREMENTS OF 2018 CBC SECTION 1005.1.
- 3. DOORS MARKED 'FIRE DEPT ACCESS' ARE REQUIRED FIRE DEPARTMENT ACCESS DOORS AND SHALL COMPLY WITH REQUIREMENTS OF 2018 NCCO CODE SECTION 3206.8.1.
- 4. LIFE SAFETY ITEMS REQUIRED BY CODE BUT NOT SHOWN ON DRAWINGS SHALL BE PROVIDED BY GC AT NO ADDITIONAL COST.
- 5. ALL FIRE RATED OR SMOKE PROOF WALLS AND PARTITIONS SHALL BE IDENTIFIED AT CEILING AS PER NCCBC SECTION 712.5 'FIRE AND SMOKE BARRIER PROTECTIVE CEILING CONFINEMENT'.
- 6. 1/2" MAX. THRESHOLD @ ALL EGRESS DOORS, SEE DETAIL.
- 7. FIRE EXTINGUISHER SHALL BE PLACED AS REQ. THROUGHOUT BUILDING, ENSURE ALL SURFACE ARE COVERED BY EXTINGUISHER, THEN 20% OF THE FLOOR AREA MEASURED FROM THE BOTTOM EDGE OF THE CABINET, FIRE PROTECTION SUBCONTRACTOR SHALL SUBMIT VIA SHOP DRAWING PROPOSED TYPE AND LAYOUT FOR APPROVAL BY FIRE EXTINGUISHERS MEETING ALL REQUIREMENTS OF NFPA 10, NFPA 101 AND THE CBC.

LIFE SAFETY LEGEND

*OCCUPANCY CLASSIFICATION: S-1 AND B: STORAGE / WAREHOUSE - FULLY SPRINKLERED

*CONSTRUCTION TYPE: TYPE II-B CONSTRUCTION

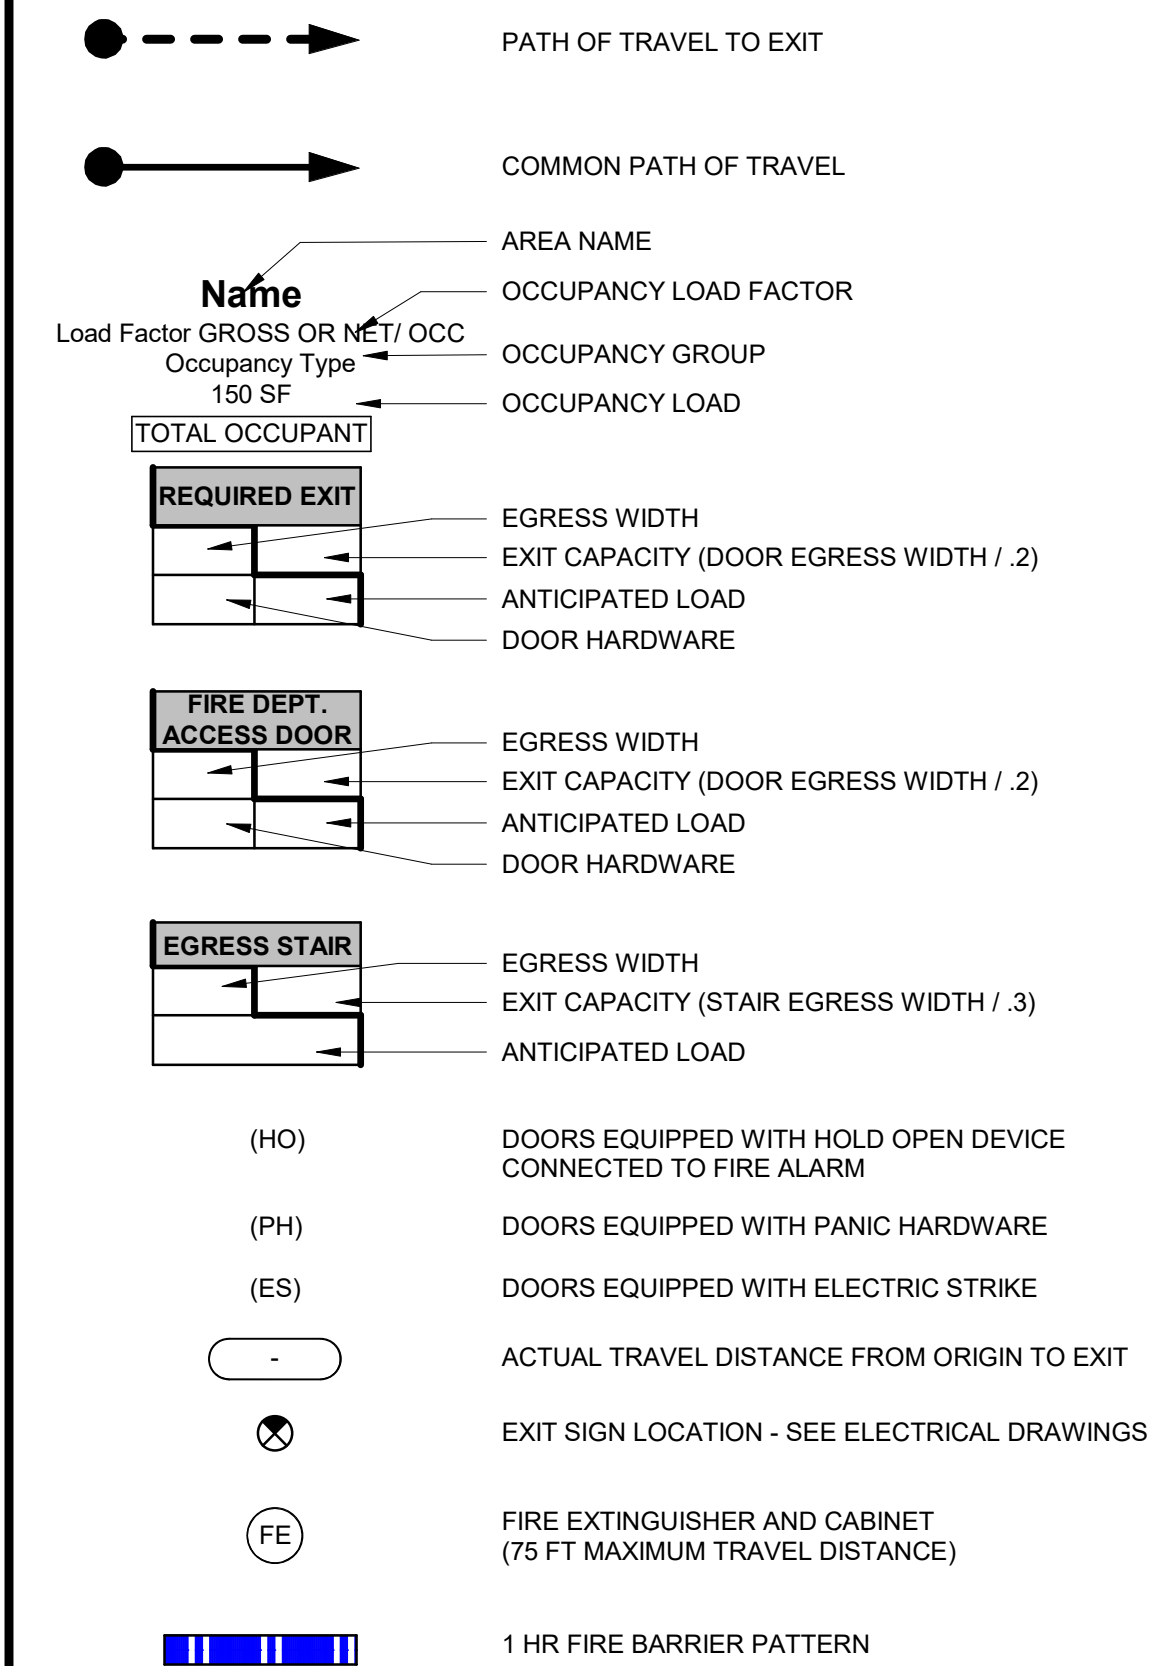

triad**design**group
Architecture | Engineering | Interior Design

4807 Koger Boulevard Suite C
Greensboro, NC 27407
Telephone 336-218-8282

8430 University Executive
Park Drive Suite 650
Charlotte, NC 28262
Telephone 704-312-0140
www.triad-designgroup.com

NC Architecture Reg. 50709
NC Engineering Lic. C-1108



August 13, 2025

This drawing, and the details herein, as an instrument of service, is the property of Triad Design Group, PC. It is to be used only for this specific project, and shall not be loaned, copied, or reproduced in any form without expressed written consent from Triad Design Group, PC. Copyright 2025, Triad Design Group, PC. All rights reserved.

Triad Design Group, PC, shall not be responsible for construction means, methods, techniques, or procedures utilized by the contractor, nor for the safety of public or contractors' employees; nor for the failure of the contractor to carry out the work in accordance with the contract documents.



Left 95 Industrial Center
SPEC BUILDING 1
2983 Arrowhead Road
Dunn, North Carolina 28334


SUBMITTALS:	
DATE	DESCRIPTION
2025-05-23	90% REVIEW
2025-07-25	FOR CONSTRUCTION

REVISIONS:		
NO	DATE	DESCRIPTION

SHEET TITLE:
LIFE SAFETY PLAN

DATE: DATE	
DRAWN: LWM	CHECKED: MTM
JOB NUMBER: 25-009	
SHEET:	

 LS101




triad design group
Architecture | Engineering | Interior Design

4807 Koger Boulevard Suite 650
Greensboro, NC 27407
Telephone 336-218-8282

8430 University Executive
Park Drive Suite 650
Charlotte, NC 28262
Telephone 704-312-0140
www.triad-designgroup.com

 NC Architecture Reg. 5070
NC Engineering Lic. C-110



TRIAD DESIGN GROUP, P.C.
NORTH CAROLINA
1994



MARK T. MICHALAK
REGISTERED ARCHITECT
1368
NORTH CAROLINA
1994

August 13, 2025

This drawing, and the details herein, are an extension of service to the property of Triad Design Group. It may be used only for this specific project, and not be loaned, copied, or reproduced in any form without expressed written consent from Triad Design Group, P.C. Copyright 2025. Triad Design Group. All rights reserved.

Triad Design Group, P.C. shall not be responsible for construction means, methods, techniques, or procedures utilized by the contractor, nor for the use of public or contractor's employees, nor for the use of the contractor to carry out the work in accordance with the contract documents.



S SAME

Harnett 95 Industrial Center

SPEC BUILDING 1

2983 Arrowhead Road
Dunn, North Carolina 28324

SUBMITTALS:	
DATE	DESCRIPTION
2025-05-23	90% REVIEW
2025-07-25	FOR CONSTRUCTION

REVISIONS:

NO	DATE	DESCRIPTION
----	------	-------------

SHEET TITLE: UL ASSEMBLIES

DATE: _____

DRAWN: LVM CHECKED: M

JOB NUMBER: 25-009



SHEET: III 100

8/13/2025 8:03:02 AM


INTERIOR HEADER & JAMB STUD KEY

NOTE:


1. THE METAL STUD SUPPLIER SHALL PROVIDE CALCULATIONS FOR OPENINGS MORE THAN 6 FEET WIDE.
2. INCREASE STUD WIDTHS TO 600 OR 800 PER WALL TYPES IF/AS REQUIRED

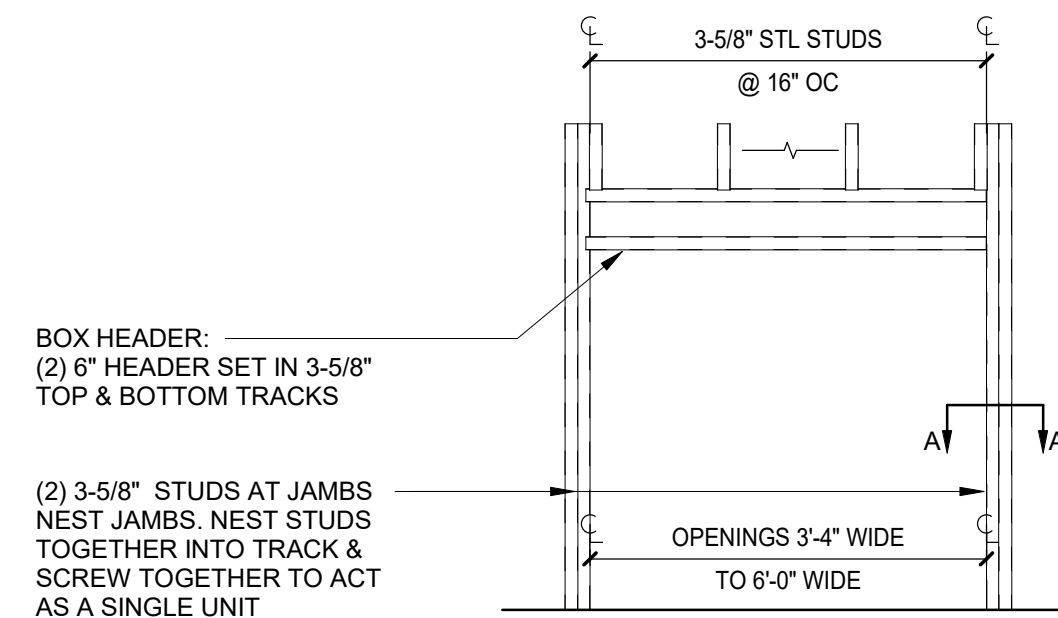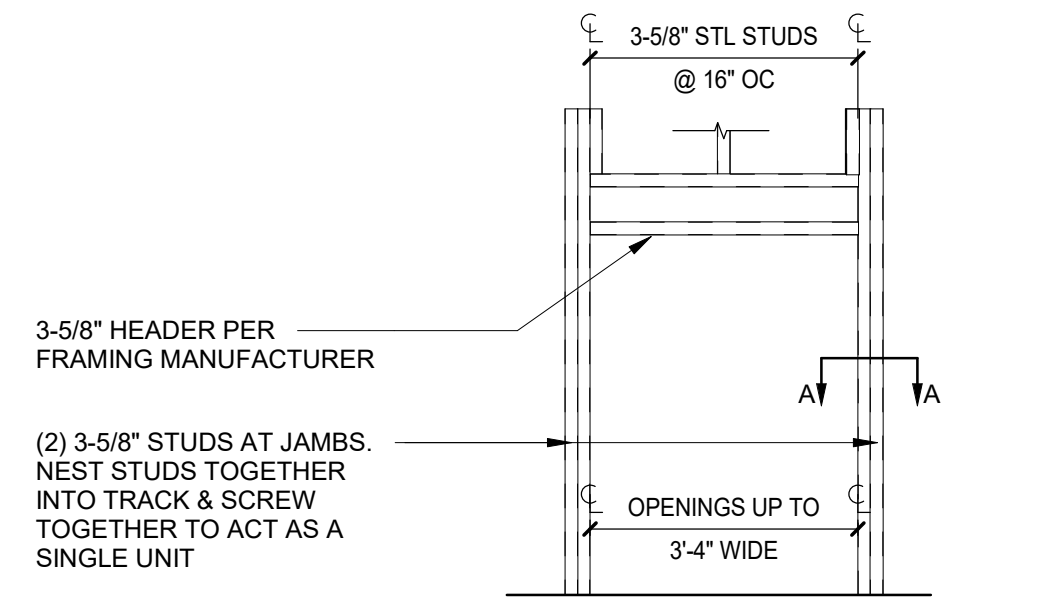


NOTE: WHERE PARTITION USED TO SUPPORT SHELVING OR OTHER NONSTRUCTURAL ITEMS, BRACING DETAILS MUST BE ADEQUATE TO RESIST IMPOSED LOADS

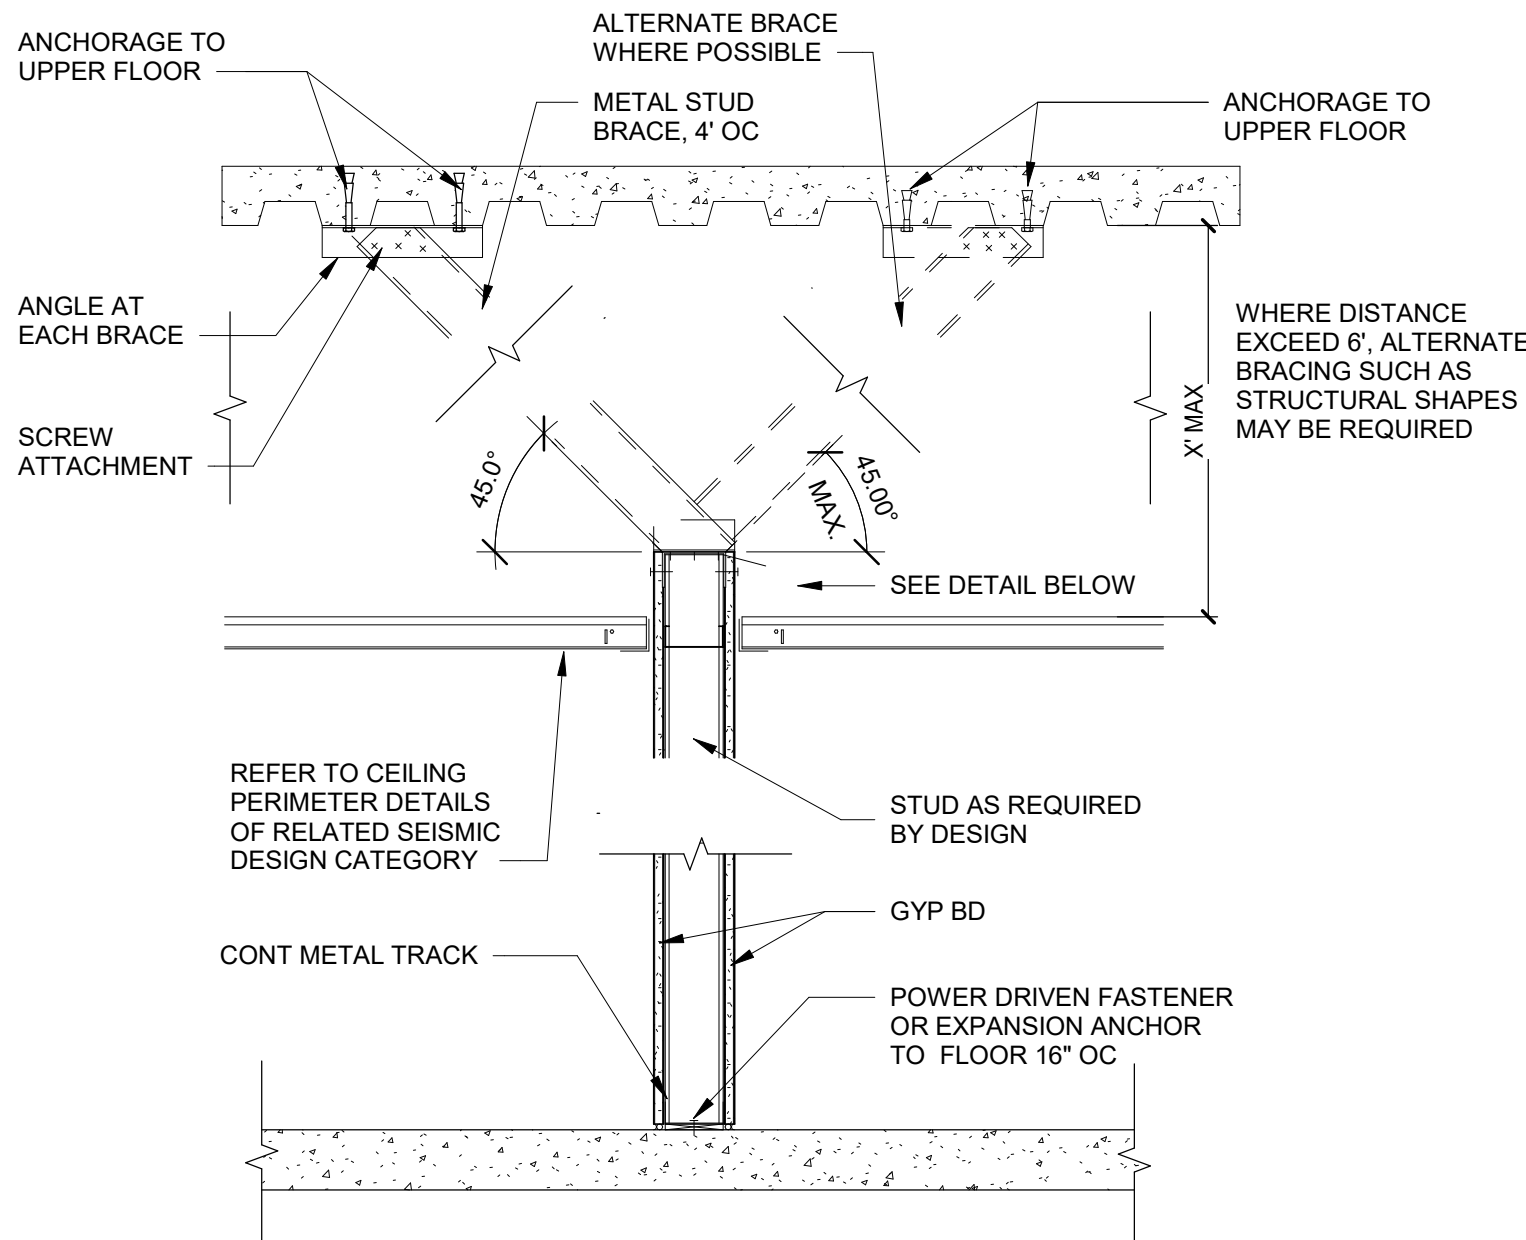

NON-BEARING STUD WALL BRACING

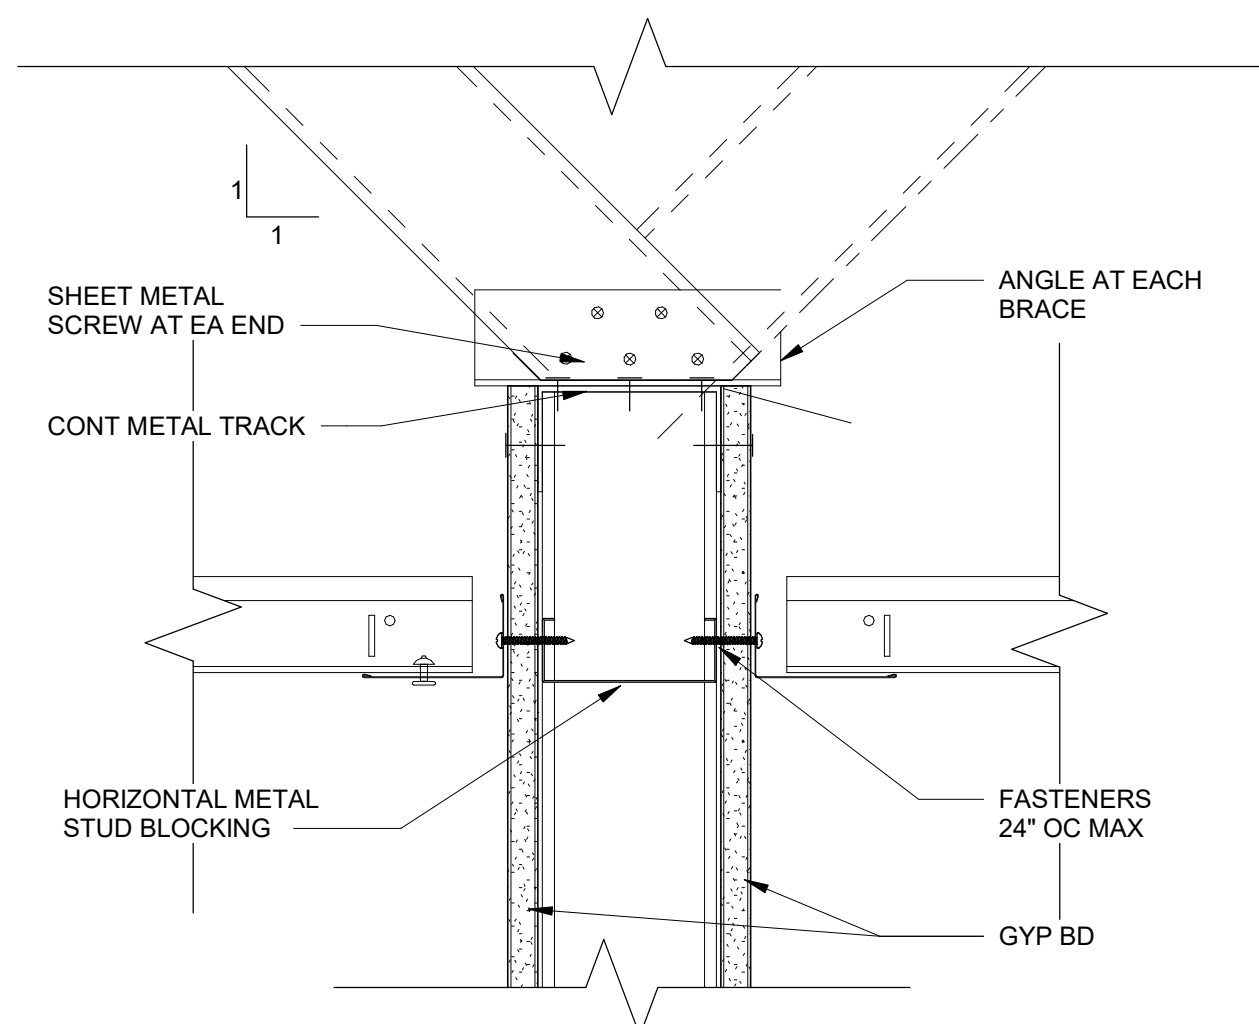

NON-BEARING STUD WALL BRACING DETAIL

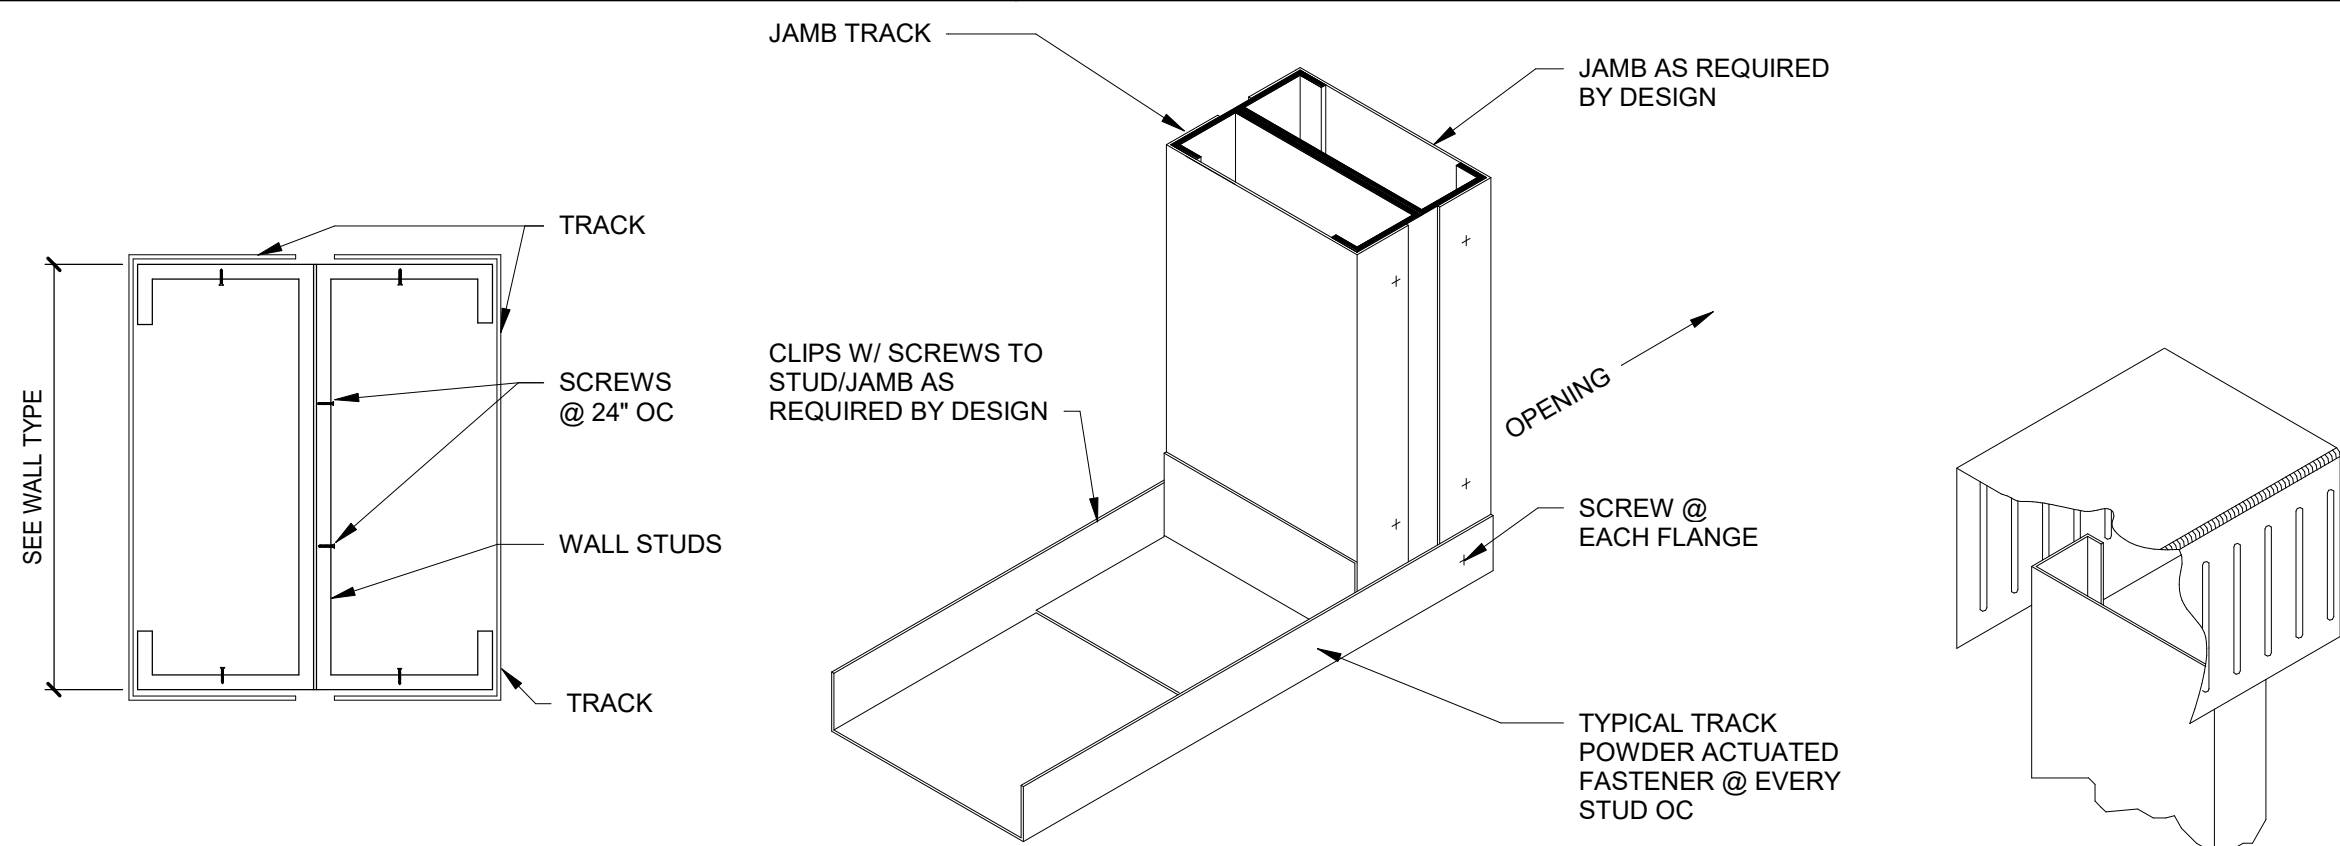


DETAIL A

METAL STUDS

NTS

DETAIL B

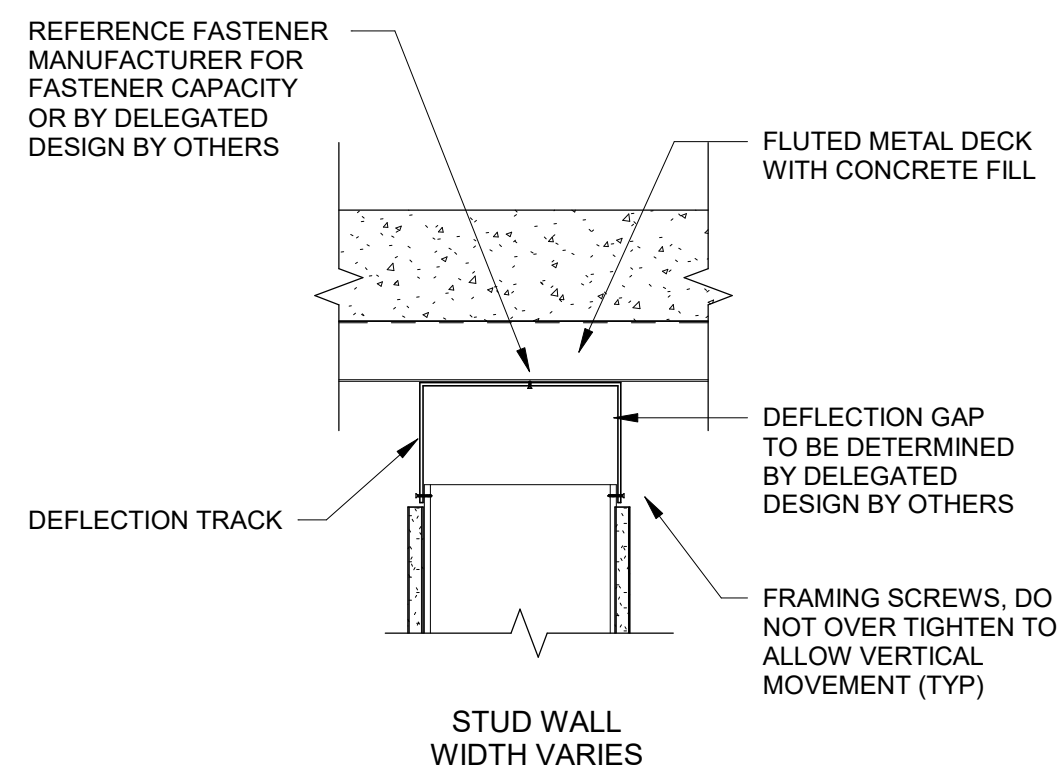


HEAD OF WALL BELOW CONCRETE FLOOR

NTS


DEFLECTION TRACK ISOMETRIC

NTS

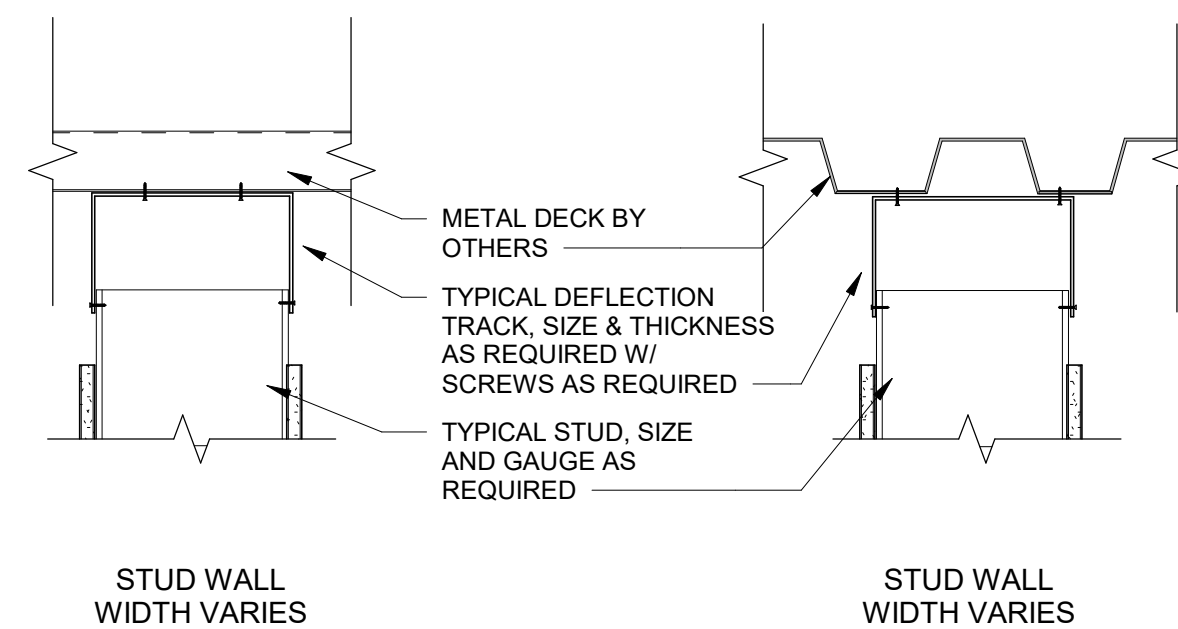


HEAD OF WALL BELOW METAL DECK WALL

NTS

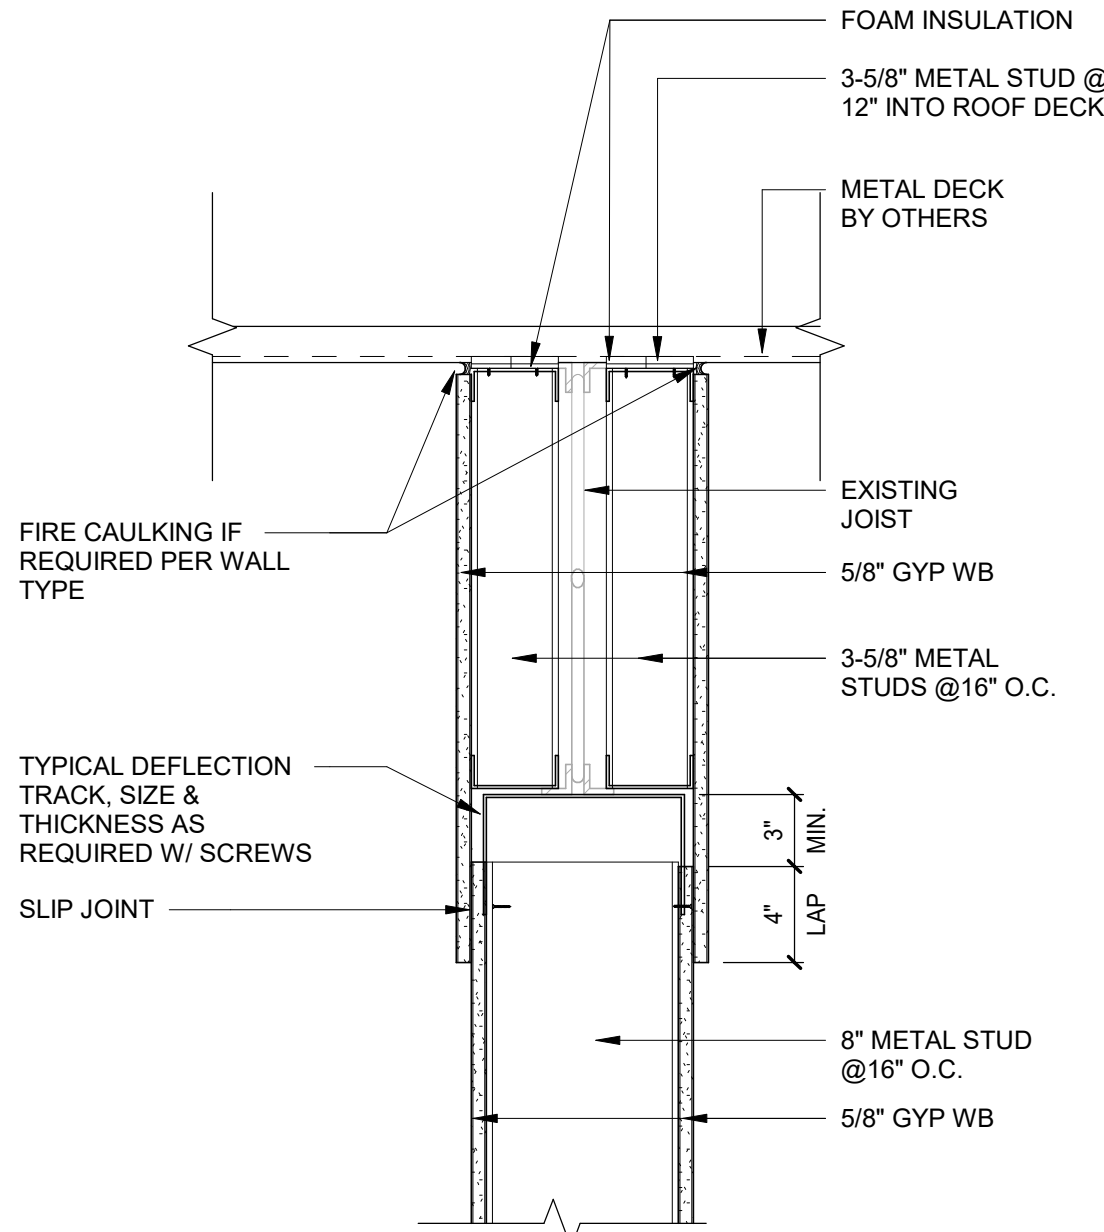


HEAD OF WALL BELOW METAL ROOF DECK @ JOIST

NTS

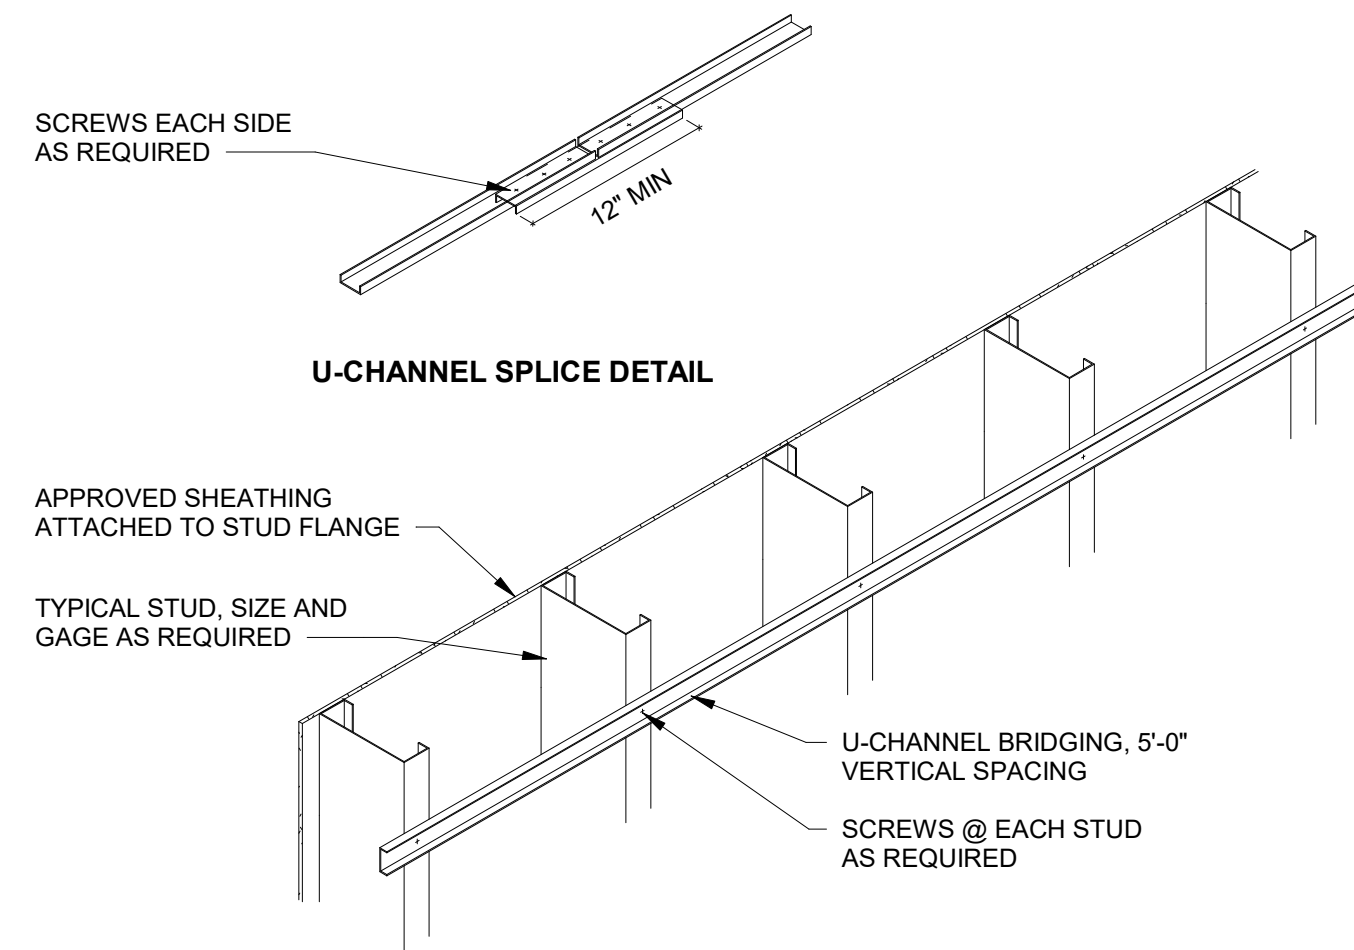

REAR FLANGE BRACING DETAIL FOR WALLS WITH SHEATHING ON ONLY ONE SIDE

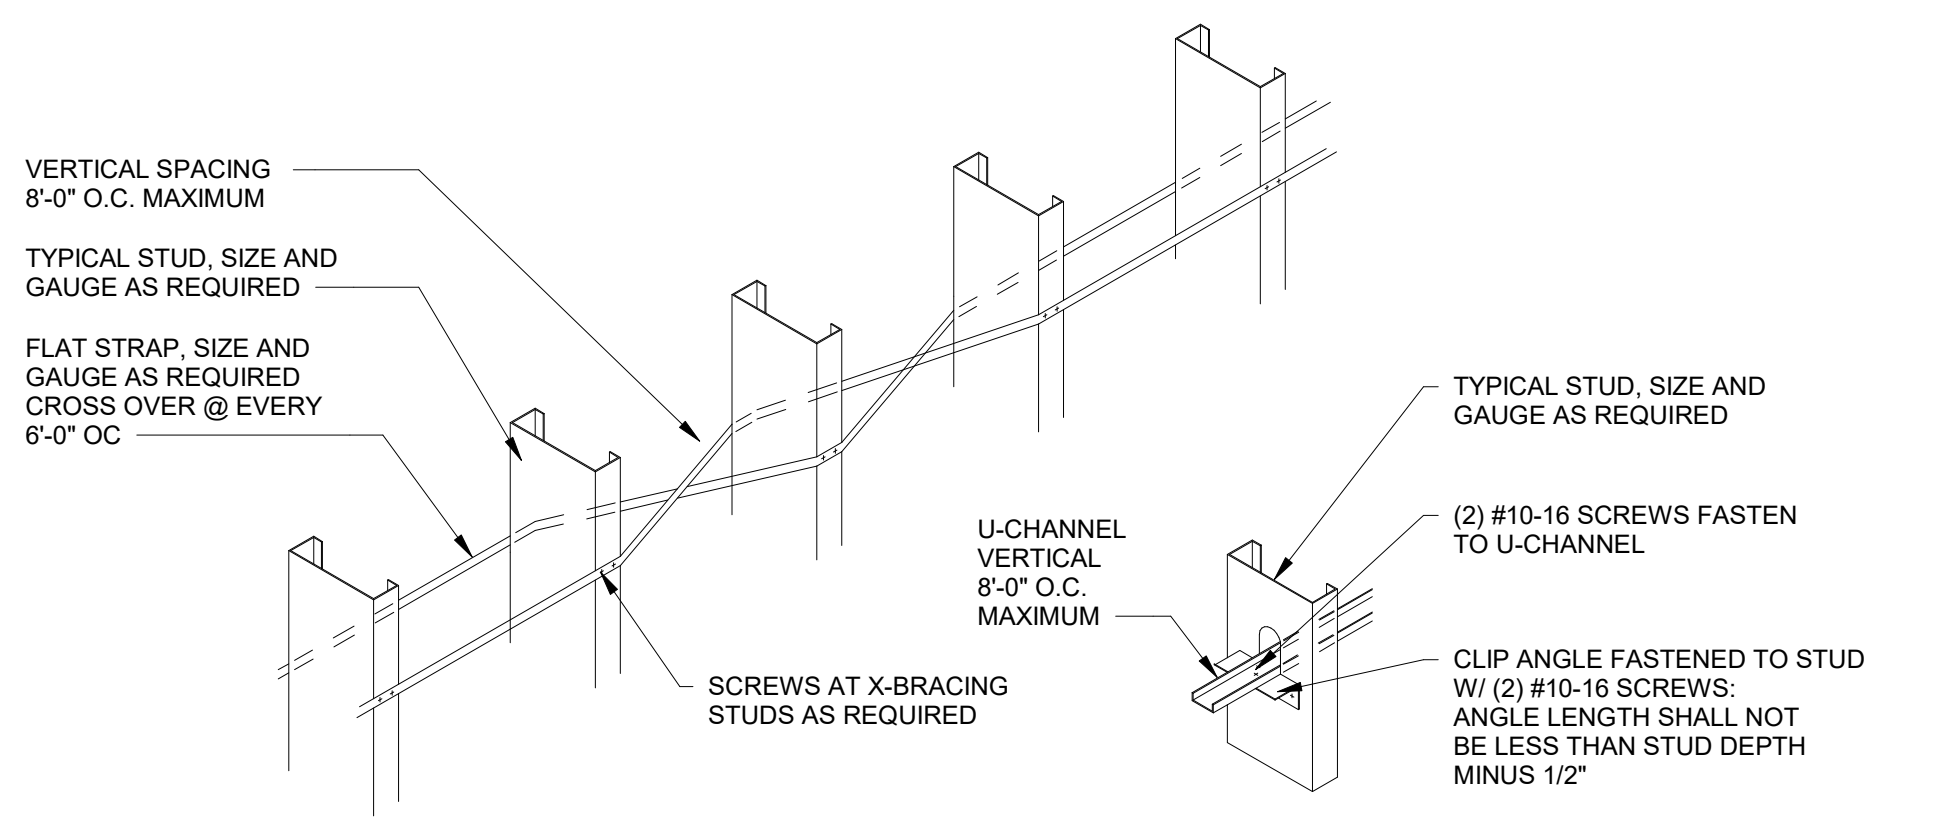


CONTINUOUS CROSS-BRACING DETAIL FOR 8" STUD OR LARGER WITH SHEATHING ON ONE SIDE


CONTINUOUS BRACING DETAIL FOR 6" STUD OR SMALLER WITH SHEATHING ON ONE SIDE

CONTINUOUS BRACING DETAILS


NTS

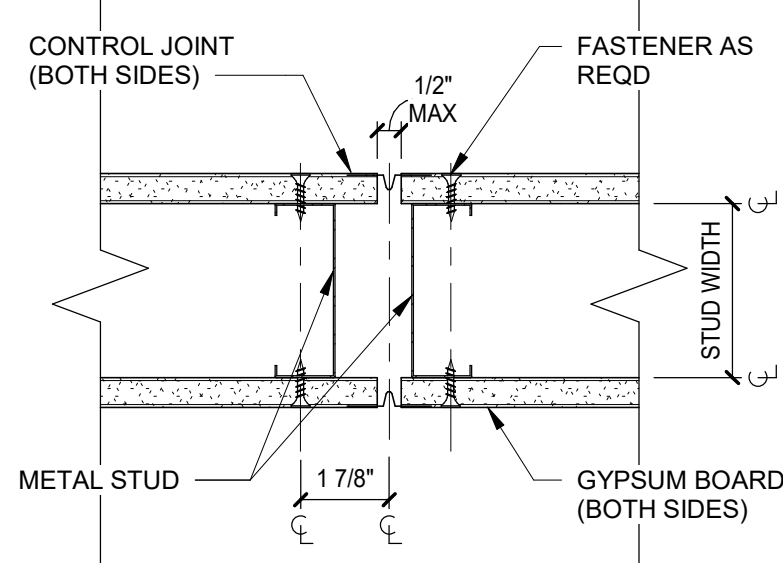


GYP BD CONTROL JOINT DETAIL

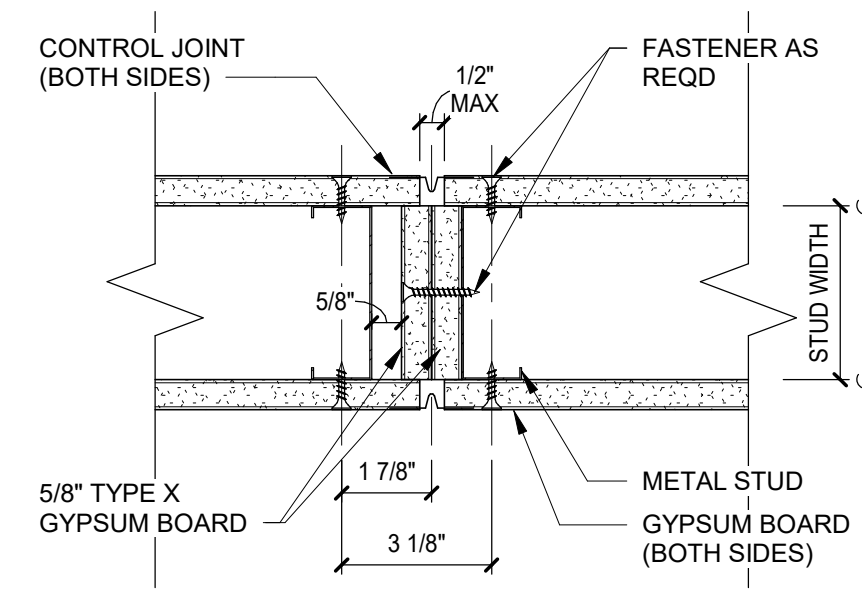

1-HR FIRE RATED CONTROL JOINT

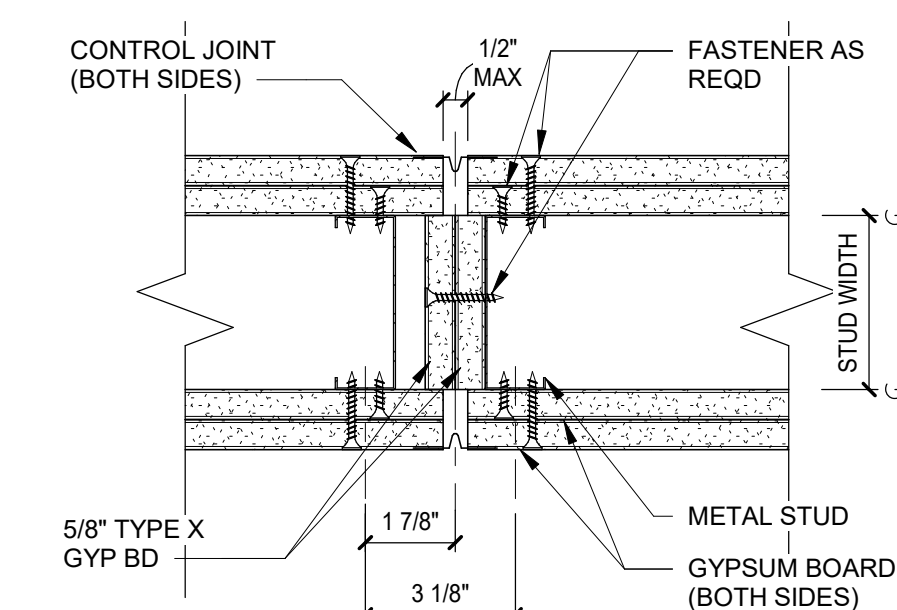

2-HR FIRE RATED CONTROL JOINT

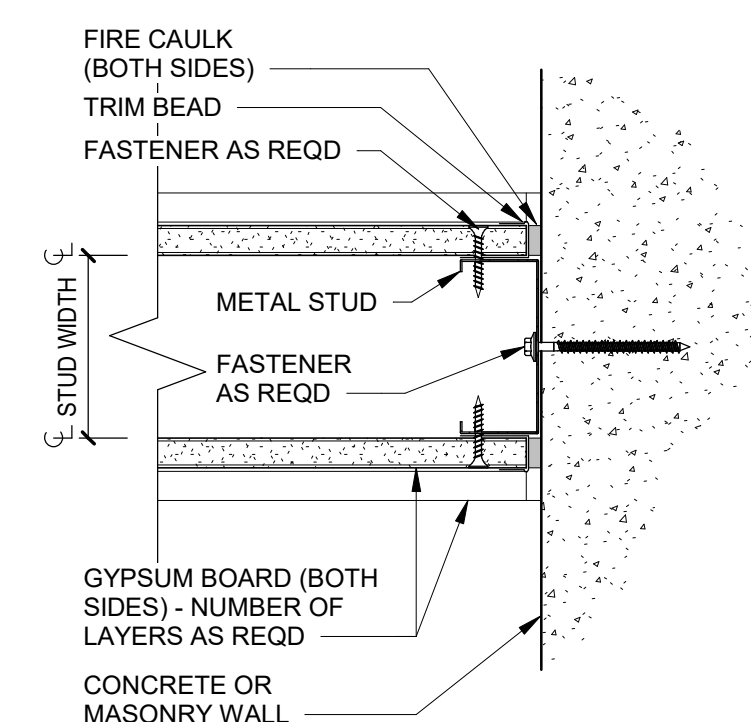

FIRE RATED JOINT @ CONC WALL

August 13, 2025

This drawing, and the details herein, are an instrument of service, in the property of Triad Design Group, PC. It may be used only for this specific project, and shall not be loaned, copied, or reproduced in any form without express written consent from Triad Design Group, PC. Copyright 2025, Triad Design Group, PC. All rights reserved.

SUBMITTALS:	
DATE	DESCRIPTION
2025-05-23	90% REVIEW
2025-07-25	FOR CONSTRUCTION

REVISIONS:	
NO	DATE DESCRIPTION

SHEET TITLE:
METAL STUD
TYPICAL DETAILS

DATE:	DATE
DRAWN: LWM	CHECKED: MTM
JOB NUMBER:	25-009
SHEET:	

A002

8/13/2025 8:03:04 AM

D

C

B

A

1

2


3

4

5


SIGNAGE NOTES

1. **ACCESSIBILITY DIRECTIONS:** DIRECTIONAL SIGNAGE INDICATING ROUTE TO NEAREST ACCESSIBLE ELEMENT. THESE DIRECTIONAL SIGNS ARE ALSO TO INCLUDE THE INTERNATIONAL SYMBOL OF ACCESSIBILITY. TO BE PROVIDED AT THE FOLLOWING LOCATIONS:
- INACCESSIBLE BUILDING ENTRANCES
 - INACCESSIBLE PUBLIC TOILETS AND BATHING FACILITIES
 - ELEVATORS NOT SERVING AN ACCESSIBLE ROUTE •EXITS SERVING REQUIRED ACCESSIBLE SPACES THAT DO NOT HAVE APPROVED MEANS OF EGRESS
2. **AREA OF REFUGE:** EACH DOOR PROVIDING ACCESS TO AN AREA OF REFUGE FROM THE ADJACENT FLOOR IS TO BE IDENTIFIED BY A SIGN, WHERE EXIT SIGN ILLUMINATION IS REQUIRED THE SIGN IS TO BE ILLUMINATED.
3. **DELAYED EMERGENCY EXIT DOORS:** "PUSH UNTIL ALARM SOUNDS. DOOR CAN BE OPENED IN SECONDS" APPROVED DELAYED EGRESS LOCKS ARE PERMITTED TO BE INSTALLED IN BUILDINGS EQUIPPED WITH APPROVED FIRE PROTECTION SYSTEMS.
4. **ELECTRICAL CONTROL:** DOORS INTO ELECTRICAL CONTROL PANEL ROOMS SHALL BE MARKED WITH A PLAINLY VISIBLE AND LEGIBLE SIGN STATING ELECTRICAL ROOM OR SIMILAR APPROVED WORDING. THE DISCONNECTING MEANS FOR EACH SERVICE, FEEDER OR BRANCH CIRCUIT ORIGINATING ON A SWITCHBOARD OR PANELBOARD SHALL BE LEGIBLY AND DURABLY MARKED TO INDICATE ITS PURPOSE.
5. **ELEVATOR EMERGENCY SIGNS:** "IN FIRE EMERGENCY, DO NOT USE ELEVATOR. USE STAIRS" STANDARDIZED DESIGN OF APPROVED PICTURE AND TEXT IS TO BE POSTED NEXT TO EVERY ELEVATOR CALL STATION.
6. **EXITS:** ARE TO BE MARKED BY AN APPROVED EXIT SIGN VISIBLE FROM ANY DIRECTION OF EGRESS TRAVEL. INTERVENING MEANS OF EGRESS DOORS WITHIN EXITS SHALL BE MARKED BY EXIT SIGNS. EXIT SIGN PLACEMENT SHALL BE SUCH THAT NO POINT IN AN EXIT ACCESS CORRIDOR OR EXIT PASSAGEWAY IS MORE THAN 100 FEET FROM THE NEAREST VISIBLE EXIT SIGN. SEE LIFESAFETY SHEETS FOR LOCATION.
7. **"AUTOMATIC SPRINKLERS" OR "STANDPIPES" OR "TEST CONNECTION":** A METAL SIGN WITH RAISED LETTERS IS TO BE MOUNTED ON ALL BUILDING FIRE DEPARTMENT CONNECTIONS
8. **FIRE CABINET EQUIPMENT:** IDENTIFIED BY APPROVED SIGNAGE. SIGN IS TO BE PERMANENTLY ATTACHED WITH LETTERS NOT LESS THAN 2 INCHES HIGH IN A COLOR THAT CONTRASTS WITH THE BACKGROUND COLOR.
9. **FIRE PROTECTION EQUIPMENT:** SHALL BE IDENTIFIED IN AN APPROVED MANNER. ROOMS CONTAINING CONTROLS FOR AIR-CONDITIONING SYSTEMS, SPRINKLER RISERS AND VALVES, OR OTHER FIRE DETECTION, SUPPRESSION OR CONTROL ELEMENTS SHALL BE IDENTIFIED FOR THE USE OF THE FIRE DEPARTMENT. APPROVED SIGNS REQUIRED TO IDENTIFY FIRE PROTECTION EQUIPMENT AND EQUIPMENT LOCATION SHALL BE CONSTRUCTED OF DURABLE MATERIALS, PERMANENTLY INSTALLED AND READILY VISIBLE.
10. **FLOOR LEVEL IDENTIFICATION:** STORY OF EXIT DISCHARGE, ROOF ACCESS FROM EXIT ENCLOSURE. SIGNS ARE TO BE PROVIDED ON EACH FLOOR LANDING WHERE EXIT ENCLOSURES CONNECT MORE THAN 3 FLOORS. THE SIGN IS TO BE LOCATED 5 FEET ABOVE THE FLOOR LANDING.
11. **HAZARD IDENTIFICATION:** NUMBERED AND COLOR-CODED "FIRE DIAMOND" IDENTIFIES THE RISK OF HAZARDOUS MATERIALS, AS SPECIFIED IN NFPA 704.
12. **KEY LOCKS ON EGRESS SIDE OF DOORS:** "THIS DOOR TO REMAIN UNLOCKED WHEN BUILDING IS OCCUPIED" SIGN IS TO BE POSTED ON THE EGRESS SIDE ON OR ADJACENT TO THE DOOR AND HAVE LETTERS AT LEAST 1 INCH.
13. **NO SMOKING:** "NO SMOKING" SIGNS ARE TO BE POSTED IN CONSPICUOUS LOCATIONS IN EACH LOCATION IN WHICH SMOKING IS PROHIBITED.
14. **OCCUPANT LOAD:** EVERY ROOM OR SPACE THAT IS AN ASSEMBLY OCCUPANCY SHALL HAVE THE OCCUPANT LOAD OF THE ROOM OR SPACE POSTED IN A CONSPICUOUS PLACE, NEAR THE MAIN EXIT OR EXIT ACCESS DOORWAY FROM THE ROOM OR SPACE. POSTED SIGNS SHALL BE OF AN APPROVED DESIGN.
15. **PREMISES IDENTIFICATION:** NEW AND EXISTING BUILDINGS SHALL BE PROVIDED WITH APPROVED ADDRESS IDENTIFICATION. THE ADDRESS IDENTIFICATION SHALL BE LEGIBLE AND PLACED IN A POSITION THAT IS VISIBLE FROM THE STREET OR ROAD FRONTING THE PROPERTY. ADDRESS IDENTIFICATION CHARACTERS SHALL CONTRAST WITH THEIR BACKGROUND. ADDRESS NUMBERS SHALL BE ARABIC NUMBERS OR ALPHABETICAL LETTERS. NUMBERS SHALL NOT BE SPELLED OUT. EACH CHARACTER SHALL BE A MINIMUM OF 6 INCHES HIGH WITH A MINIMUM STROKE WIDTH OF 3/4 INCH. WHERE REQUIRED BY THE FIRE CODE OFFICIAL, ADDRESS IDENTIFICATION SHALL BE PROVIDED IN ADDITIONAL APPROVED LOCATIONS TO FACILITATE EMERGENCY RESPONSE. WHERE ACCESS IS BY MEANS OF A PRIVATE ROAD AND THE BUILDING ADDRESS CANNOT BE VIEWED FROM THE PUBLIC WAY, A MONUMENT, POLE OR OTHER APPROVED SIGN OR MEANS SHALL BE USED TO IDENTIFY THE STRUCTURE. ADDRESS IDENTIFICATION SHALL BE MAINTAINED.
16. **RATED BARRIERS:** "FIRE AND/OR SMOKE BARRIER PROTECT ALL OPENINGS" ANY WALL REQUIRED TO HAVE PROTECTED OPENINGS OR PENETRATIONS IS TO BE PERMANENTLY IDENTIFIED WITH STENCIL.
17. **TWO-WAY COMM. SYSTEM:** DIRECTIONS FOR SUMMONING ASSISTANCE AND WRITTEN IDENTIFICATION OF THE LOCATION TO BE POSTED NEXT TO ANY TWO-WAY COMMUNICATION SYSTEMS.
18. **ADDITIONAL SIGNAGE REQUIRED BY CODE SHALL BE PROVIDED BY GC.**
19. **NOT ALL SIGNAGE MAY BE APPLICABLE TO THE PROJECT.**

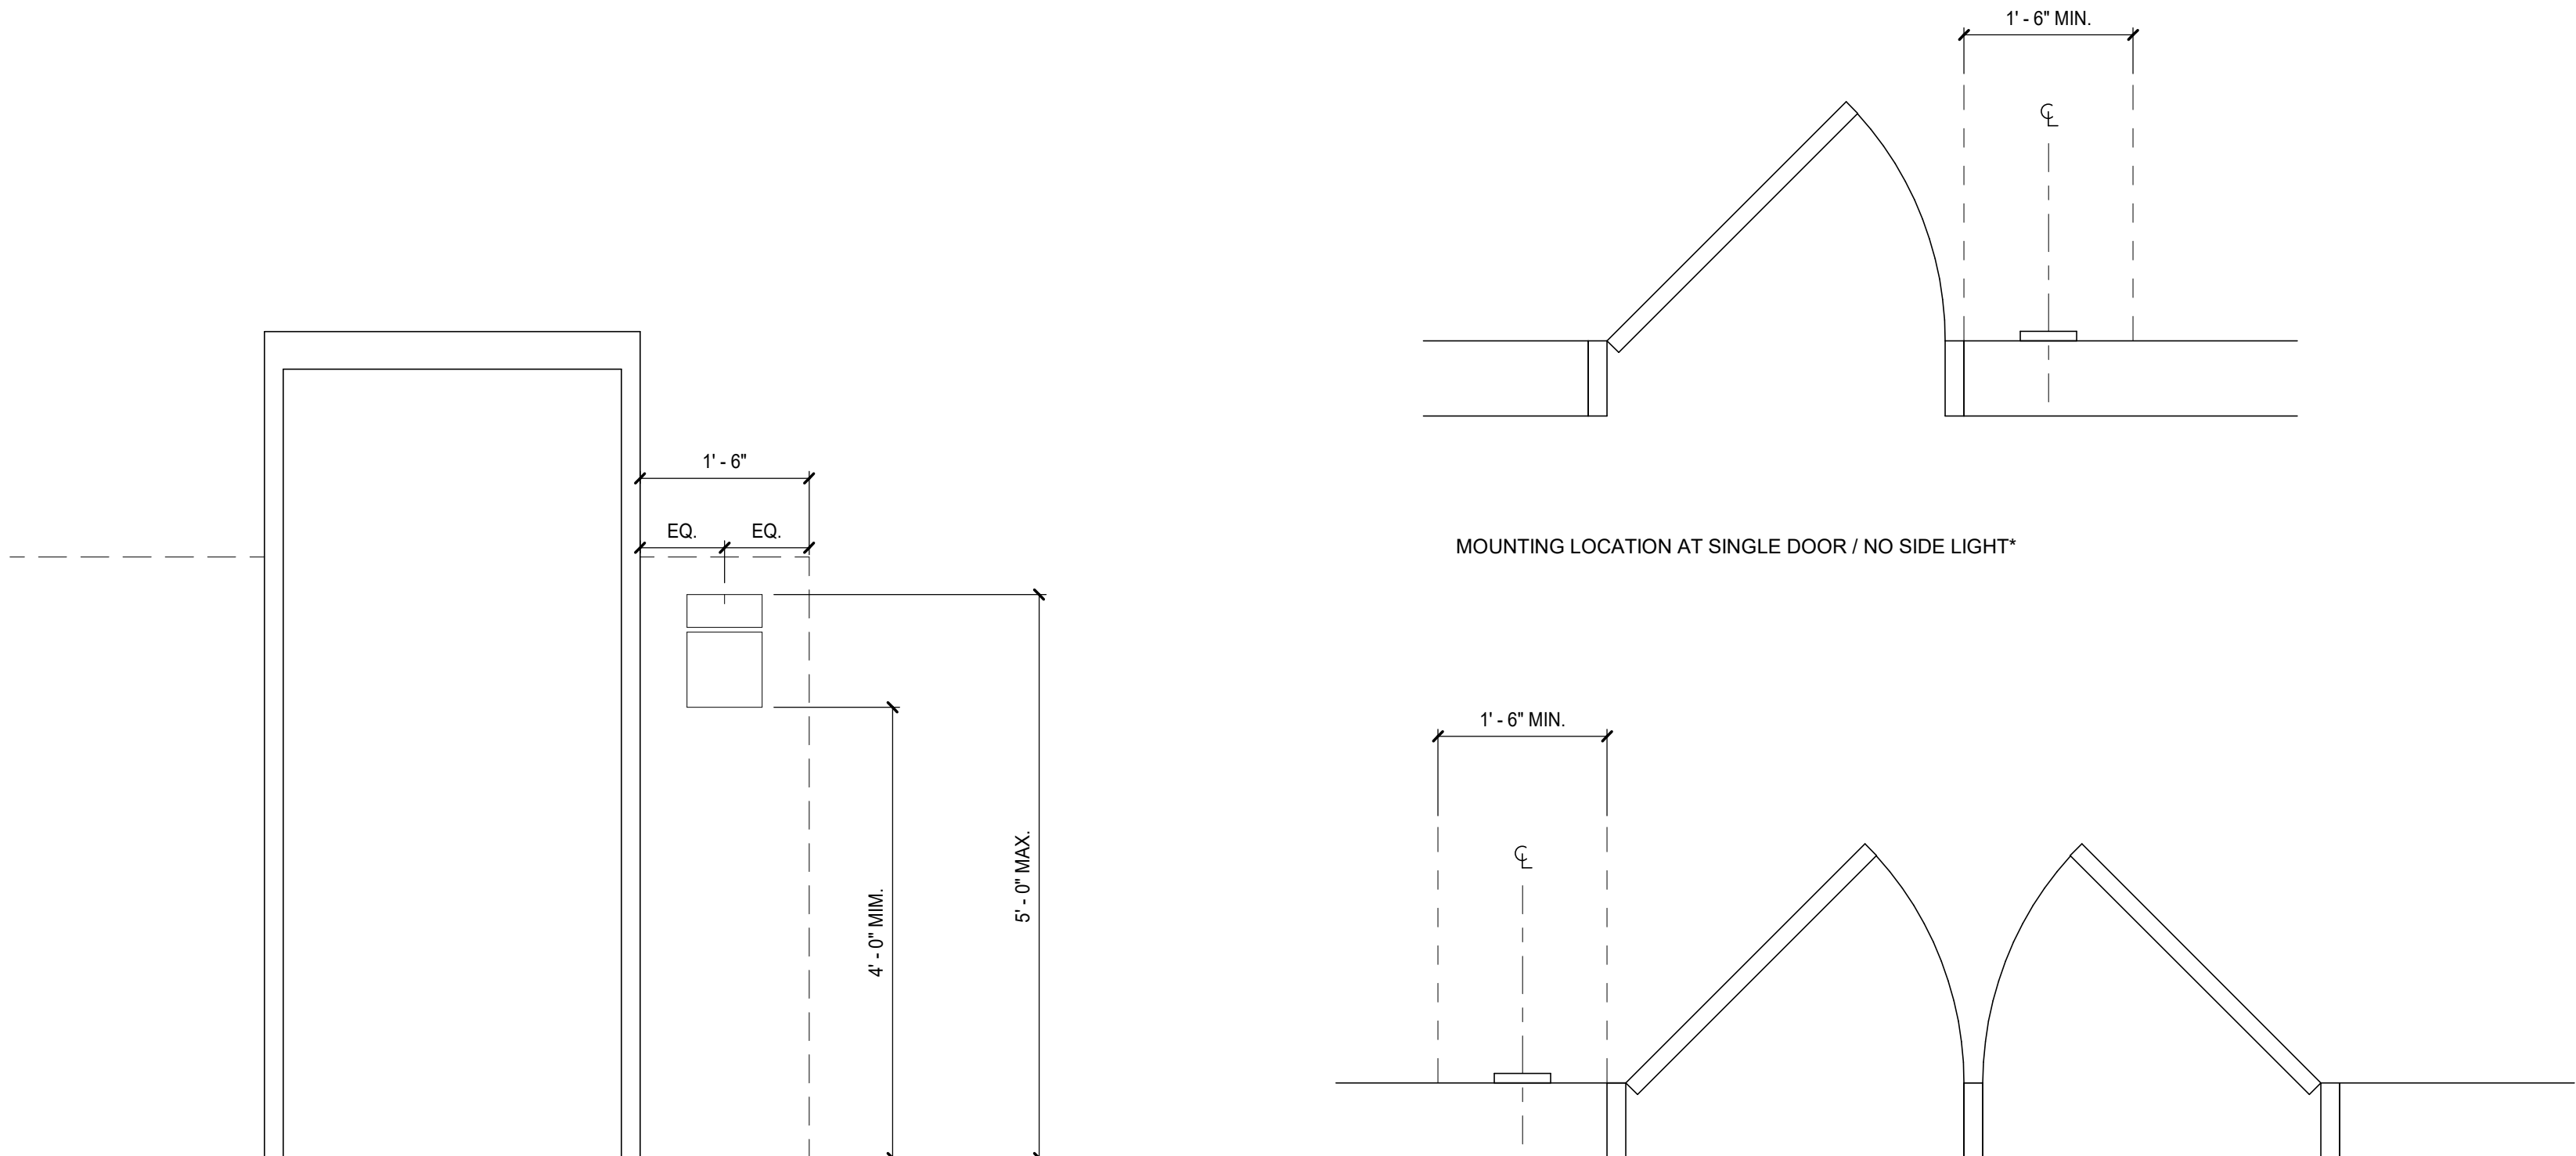


MOUNTING LOCATION AT DOUBLE DOORS / NO SIDE LIGHT*


*COORDINATE SIGN MOUNTING LOCATION WITH OWNER AND ARCHITECT AT DOORS WITH SIDE LIGHTS

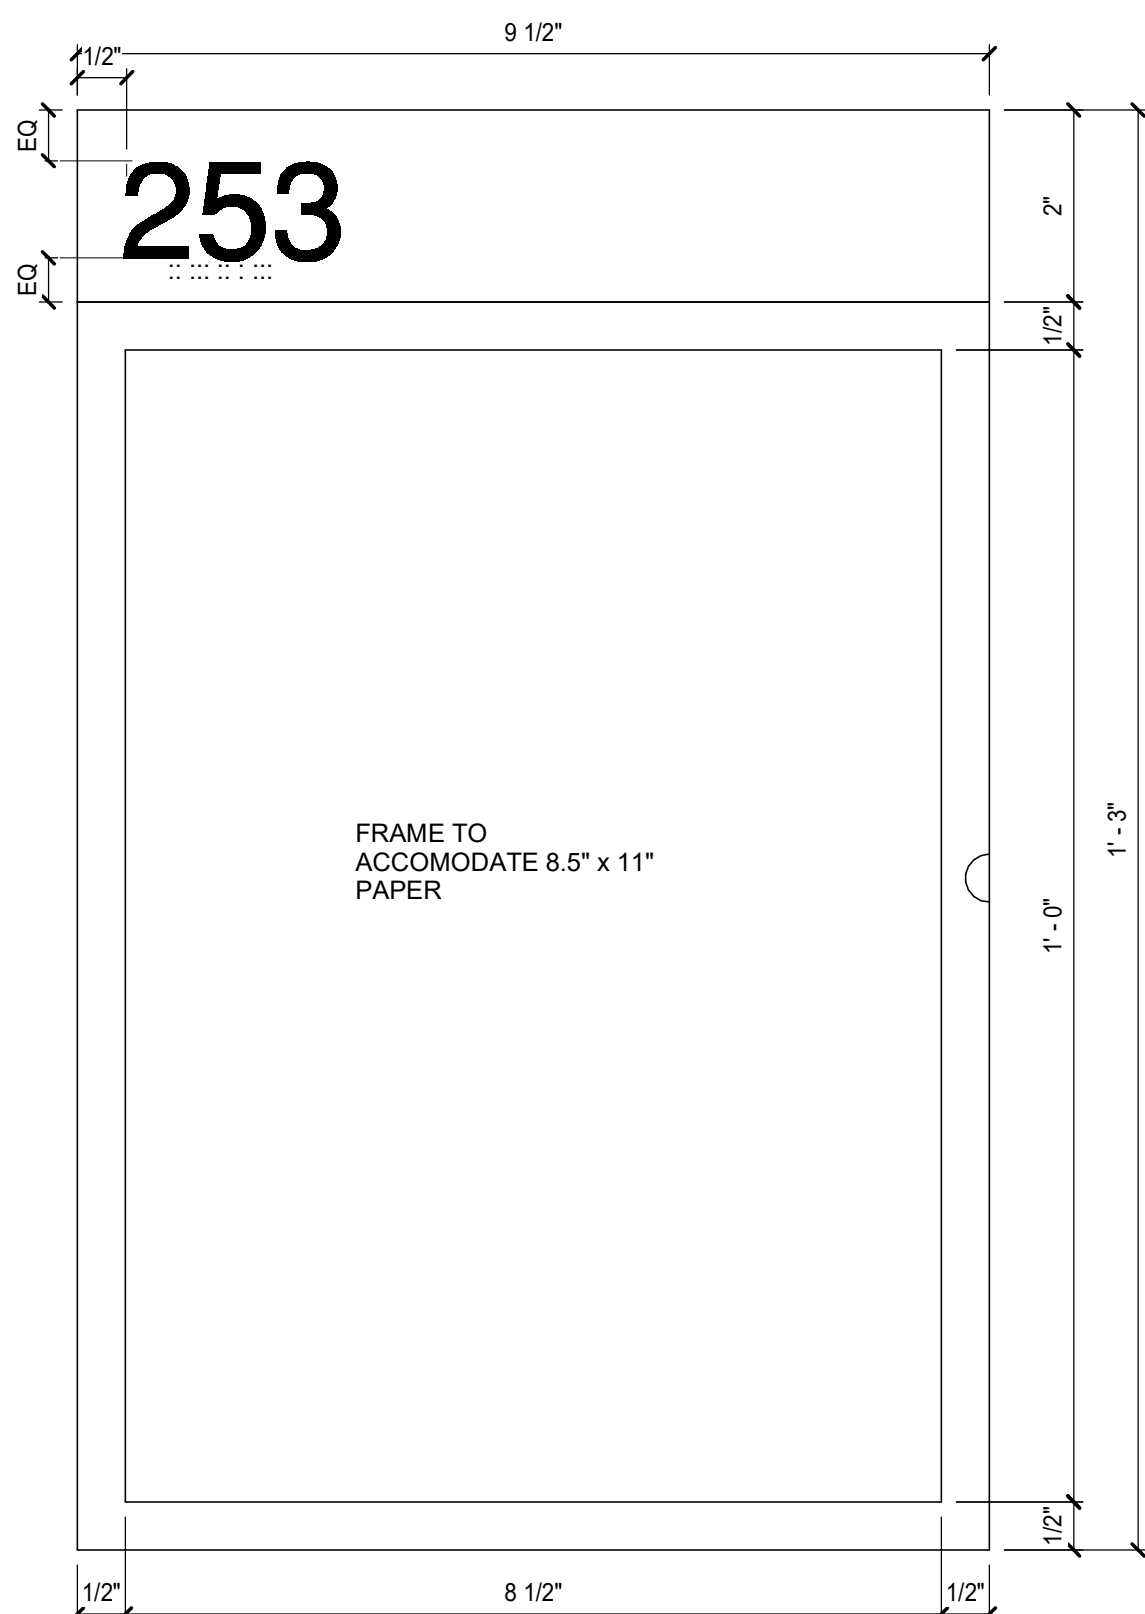


TYPE A

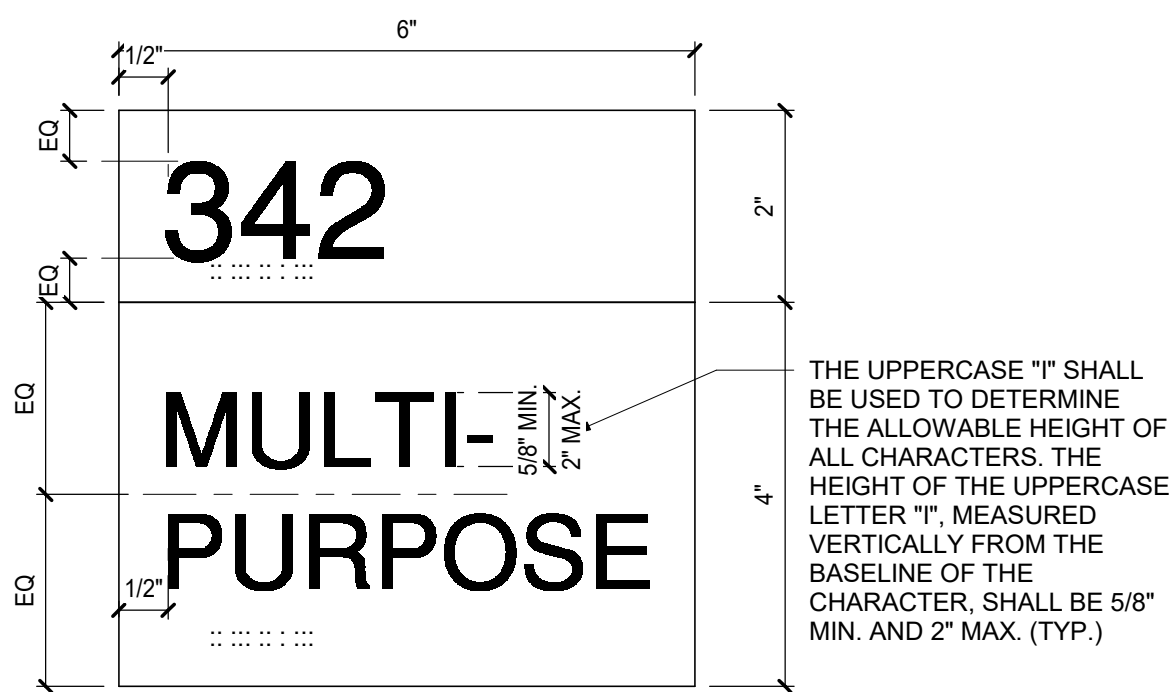


TYPE B

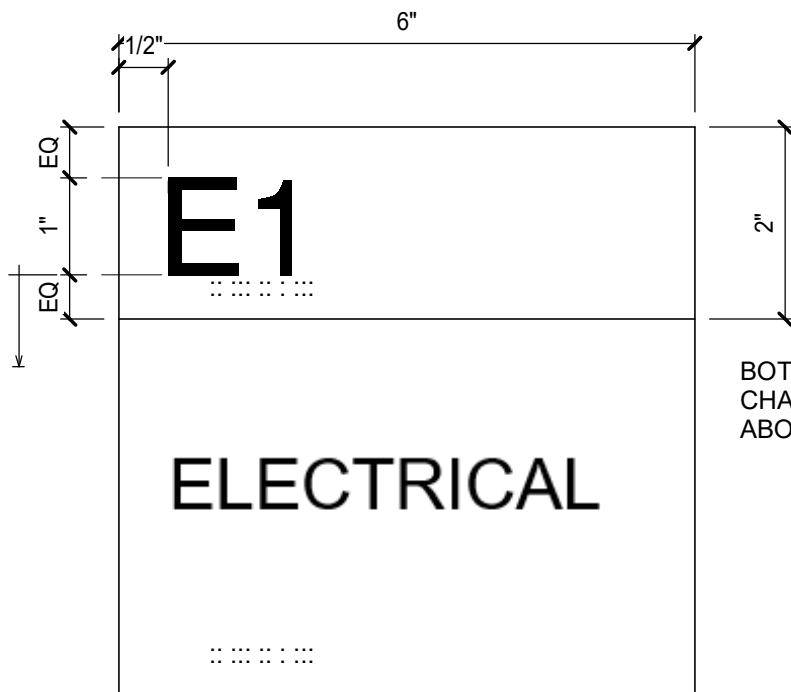

TYPE C

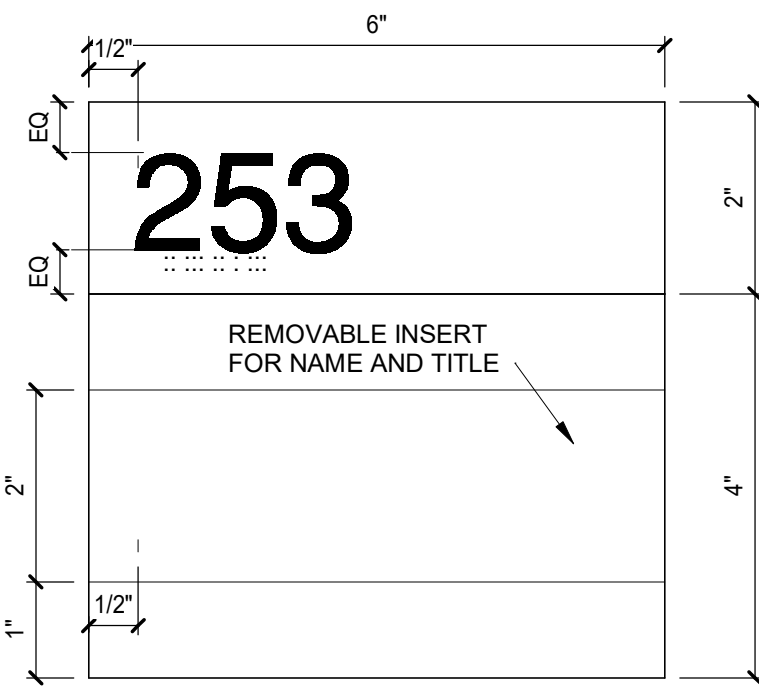


TYPE D

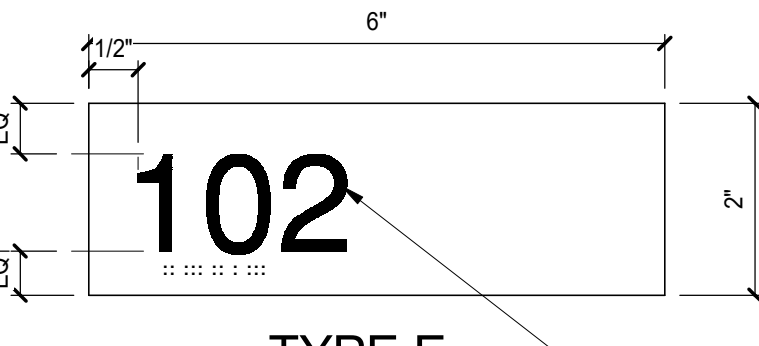

TYPE E



TYPE F-1

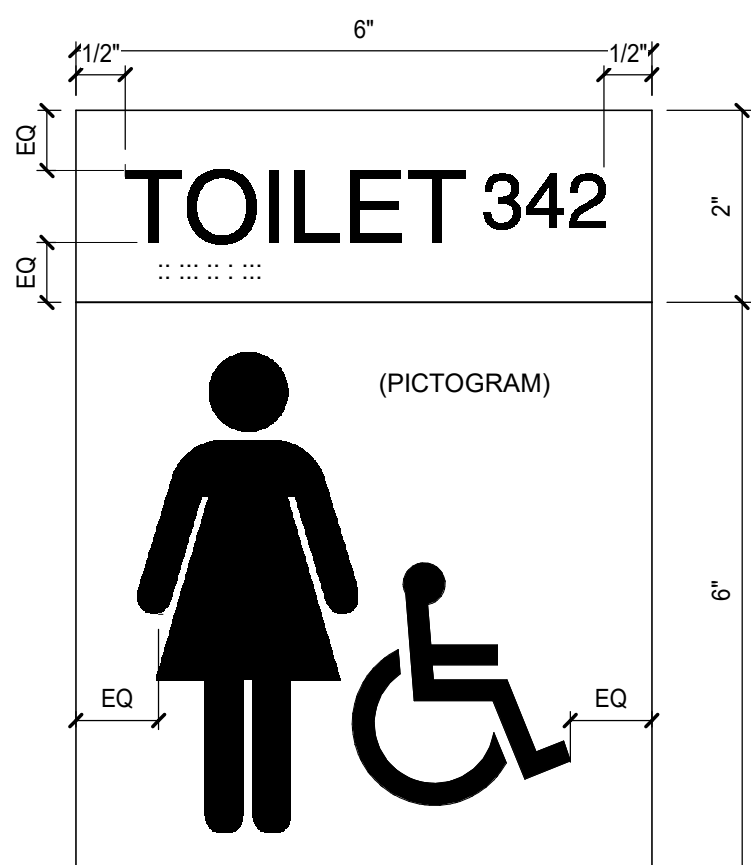

TYPE F-2



TYPE F-3




triad design group
Architecture | Engineering | Interior Design

4807 Koger Boulevard Suite C
Greensboro, NC 27407
Telephone 336-218-8282

8430 University Executive
Park Drive Suite 650
Charlotte, NC 28262
Telephone 704-312-0140
www.triad-designgroup.com

NC Architecture Reg. 50709
NC Engineering Lic. C-108

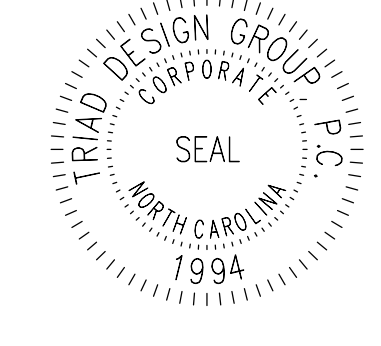

August 13, 2025

This drawing, and the details herein, as an instrument of service, is the property of Triad Design Group, PC. It may be used only for this specific project, and shall not be loaned, copied, or reproduced in any form without the written consent of Triad Design Group, PC. Copyright 2025, Triad Design Group, PC. All rights reserved.

Triad Design Group, PC, shall not be responsible for construction means, methods, techniques, or procedures utilized by the contractor, nor for the safety of public or contractor employees, nor for the failure of the contractor to carry out the work in accordance with the contract documents.



Harnett 95 Industrial Center
SPEC BUILDING 1
2983 Arrowhead Road
Dunn, North Carolina 28334


SUBMITTALS:	
DATE	DESCRIPTION
2025-05-23	90% REVIEW
2025-07-25	FOR CONSTRUCTION

REVISIONS:	
NO	DATE DESCRIPTION


SHEET TITLE:
SIGNAGE

DATE: DATE
DRAWN: LWM CHECKED: MTM
JOB NUMBER: 25-009
SHEET:

 A003



- triad**
designgroup
Architecture | Engineering | Interior Design
- 4807 Koger Boulevard Suite
Greensboro, NC 27407
Telephone 336-218-8282
- 8430 University Executive
Park Drive Suite 650
Charlotte, NC 28262
Telephone 704-312-0140
www.triad-designgroup.com
- NC Architecture Reg. 50705
NC Engineering Lic. C-1108

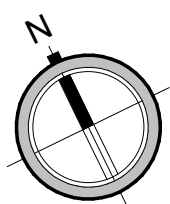


SAME

Plant 95 Industrial Center
SPEC BUILDING 1
2983 Arrowhead Road
Dunn, North Carolina 28334

REVISIONS:		
NO	DATE	DESCRIPTION
1	07/14/25	OWNER COMME

DATE: DATE	
DRAWN: LWM	CHECKED: MT
JOB NUMBER: 25-009	
SHEET:	



A100 R1

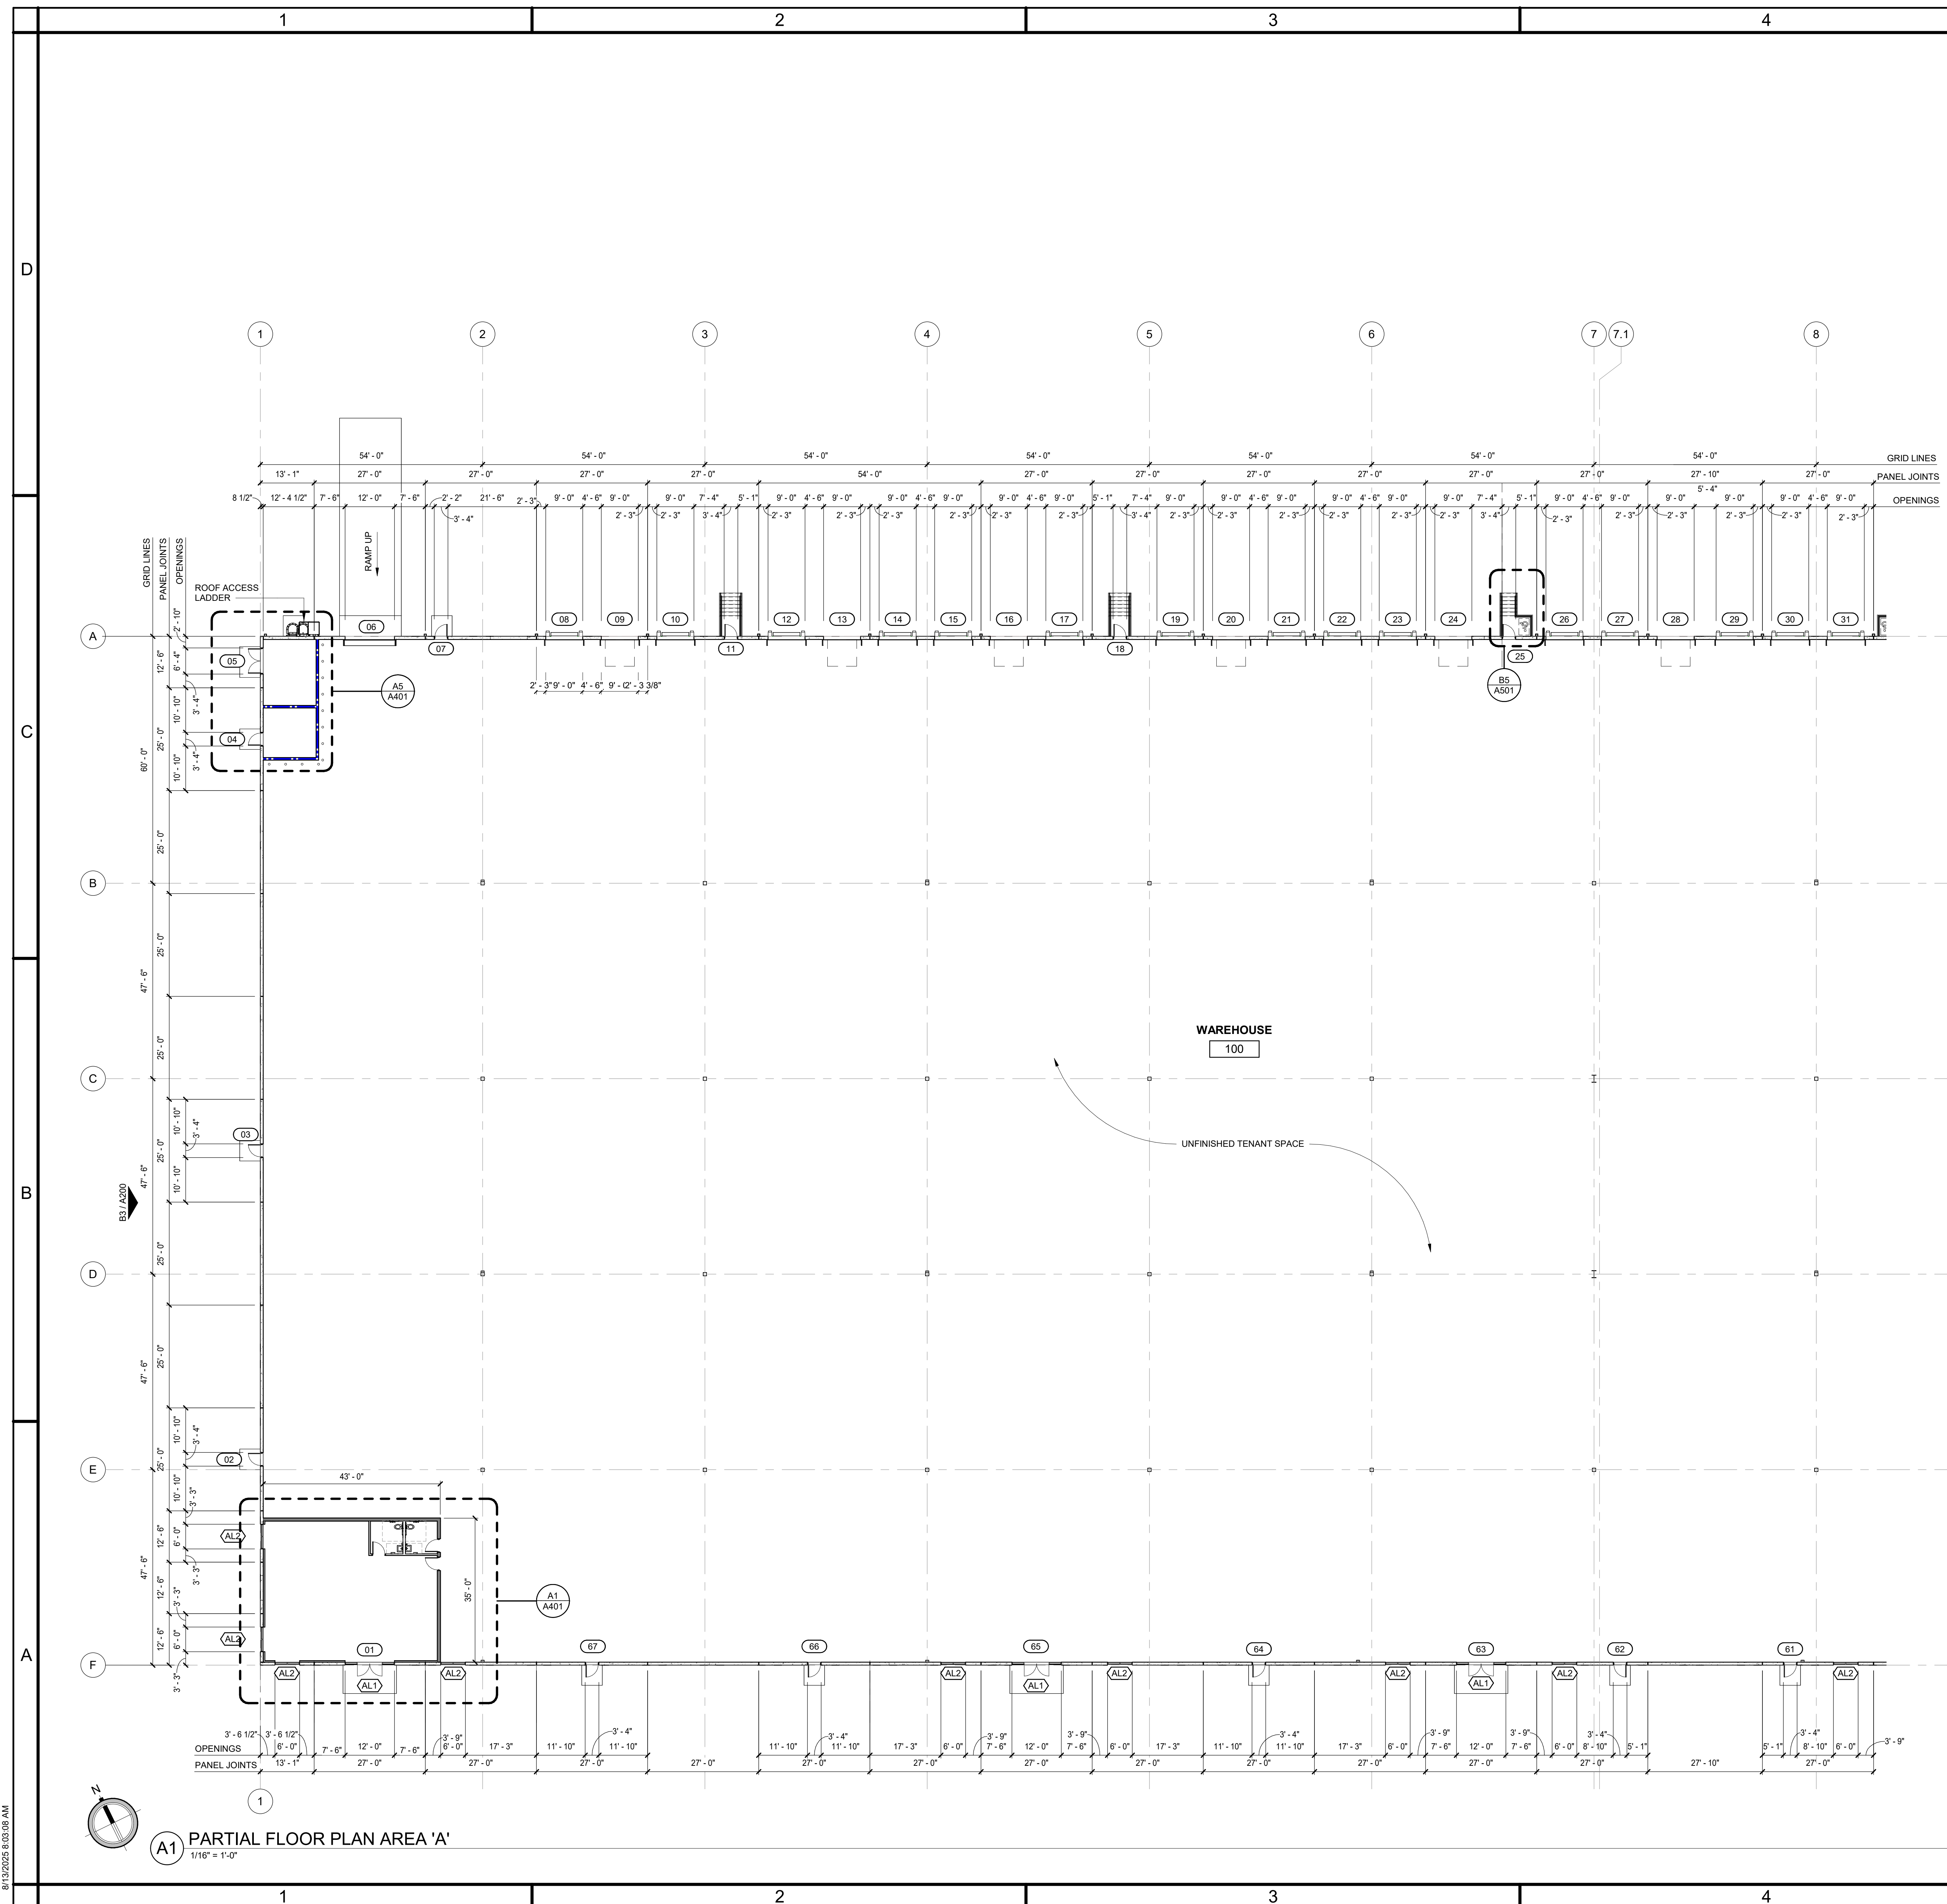


FLOOR PLAN GENERAL NOTES

1. DIMENSIONS AT TILT/ PRE-CAST CONCRETE WALLS ARE TO THE FACE OF CONCRETE U.N.O.
2. REFER TO LIFESAFETY PLANS FOR WALL FIRE RATING
3. REFER TO A001 FOR WALL TYPES.
4. DOOR JAMBS SHALL BE 4" OFF ADJACENT WALL UNLESS OTHERWISE NOTED.
5. FIRE SUPPRESSION SYSTEM TO BE A DEFERRED SUBMITTAL. SYSTEM TO MEET ALL APPLICABLE CODES. SUBMIT AND OBTAIN ALL STATE AND LOCAL APPROVALS PRIOR TO INSTALLATION.
6. COORDINATE ALL MECH. ELEC. PLUMB. PENETRATIONS WITH THEIR RELATED DISCIPLINES. INSTALLER TO VERIFY ALL LOCATIONS AT CONCRETE SLAB.
7. WORK NOTED "BY OTHERS" OR "NIC" SHALL BE PROVIDED BY OWNER OR UNDER SEPARATE CONTRACT.
8. COORDINATE AND PROVIDE METAL OR RATED SOLID WOOD BLOCKING (FIRE TREATED) IN PARTITIONS AND CEILING FOR MILLWORK, WALL AND CEILING ATTACHED ITEMS AS SPECIFIED.
9. DO NOT SCALE DRAWINGS. WRITTEN DIMENSIONS GOVERN. ALL PARTITION LOCATIONS, DIMENSIONS

  PLAN LEGEND

- | | |
|---|-----------------------------|
|  | NON RATED PARTITION |
|  | NON RATED PARTITION TO DECK |
|  | CONCRETE TILT PANEL |
|  | 1 HR FIRE BARRIER PATTERN |
|  | 2 HR FIRE BARRIER PATTERN |
|  | STORE FRONT / WINDOW TAG |
|  | DOOR TAG |
|  | WALL TAG |
|  | ROOM NAME
ROOM NUMBER |

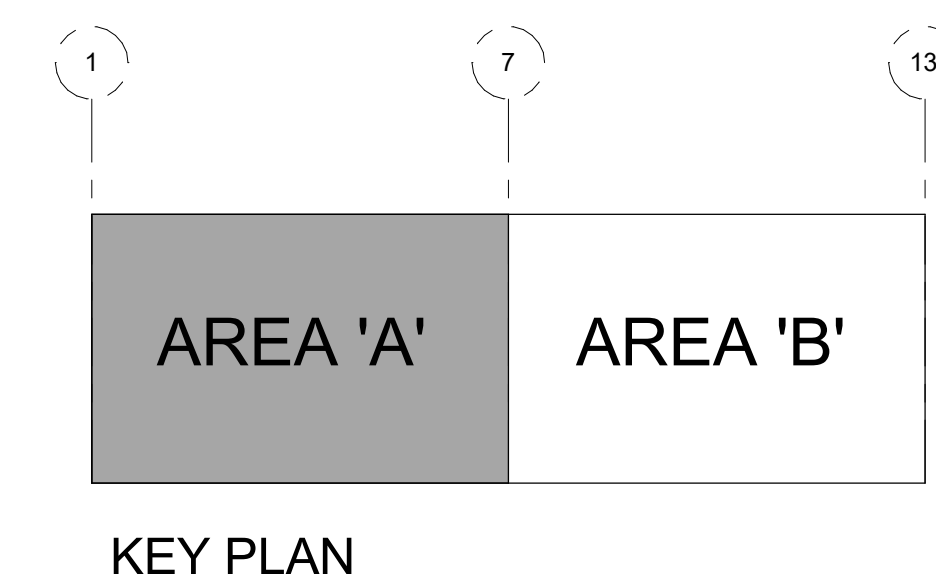


triad design group
Architecture | Engineering | Interior Design

4807 Koger Boulevard Suite C
Greensboro, NC 27407
Telephone 336-218-8282

8430 University Executive
Park Drive Suite 650
Charlotte, NC 28262
Telephone 704-312-0140
www.triad-designgroup.com

NC Architecture Reg. 50709
NC Engineering Lic. C-1108

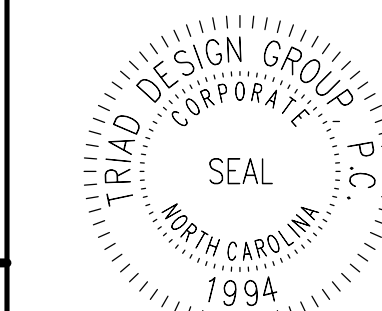

August 13, 2025

This drawing, and the details herein, as an instrument of service, is the property of Triad Design Group, PC. It may be used only for this specific project, and shall not be loaned, copied, or reproduced in any form without expressed written consent from Triad Design Group, PC. Copyright 2025. Triad Design Group, PC. All rights reserved.

Triad Design Group, PC, shall not be responsible for construction means, methods, techniques, or procedures utilized by the contractor, nor for the safety of public or contractors' employees; nor for the failure of the contractor to carry out the work in accordance with the contract documents.



Harnett 95 Industrial Center
SPEC BUILDING 1
2983 Arrowhead Road
Dunn, North Carolina 28334

SUBMITTALS:

DATE	DESCRIPTION
2025-05-23	90% REVIEW
2025-07-25	FOR CONSTRUCTION

REVISIONS:


NO	DATE	DESCRIPTION
----	------	-------------

SHEET TITLE:


PARTIAL FLOOR
PLAN 'A'


DATE: DATE	
DRAWN: LWM	CHECKED: MTM
JOB NUMBER: 25-009	
SHEET:	

A101

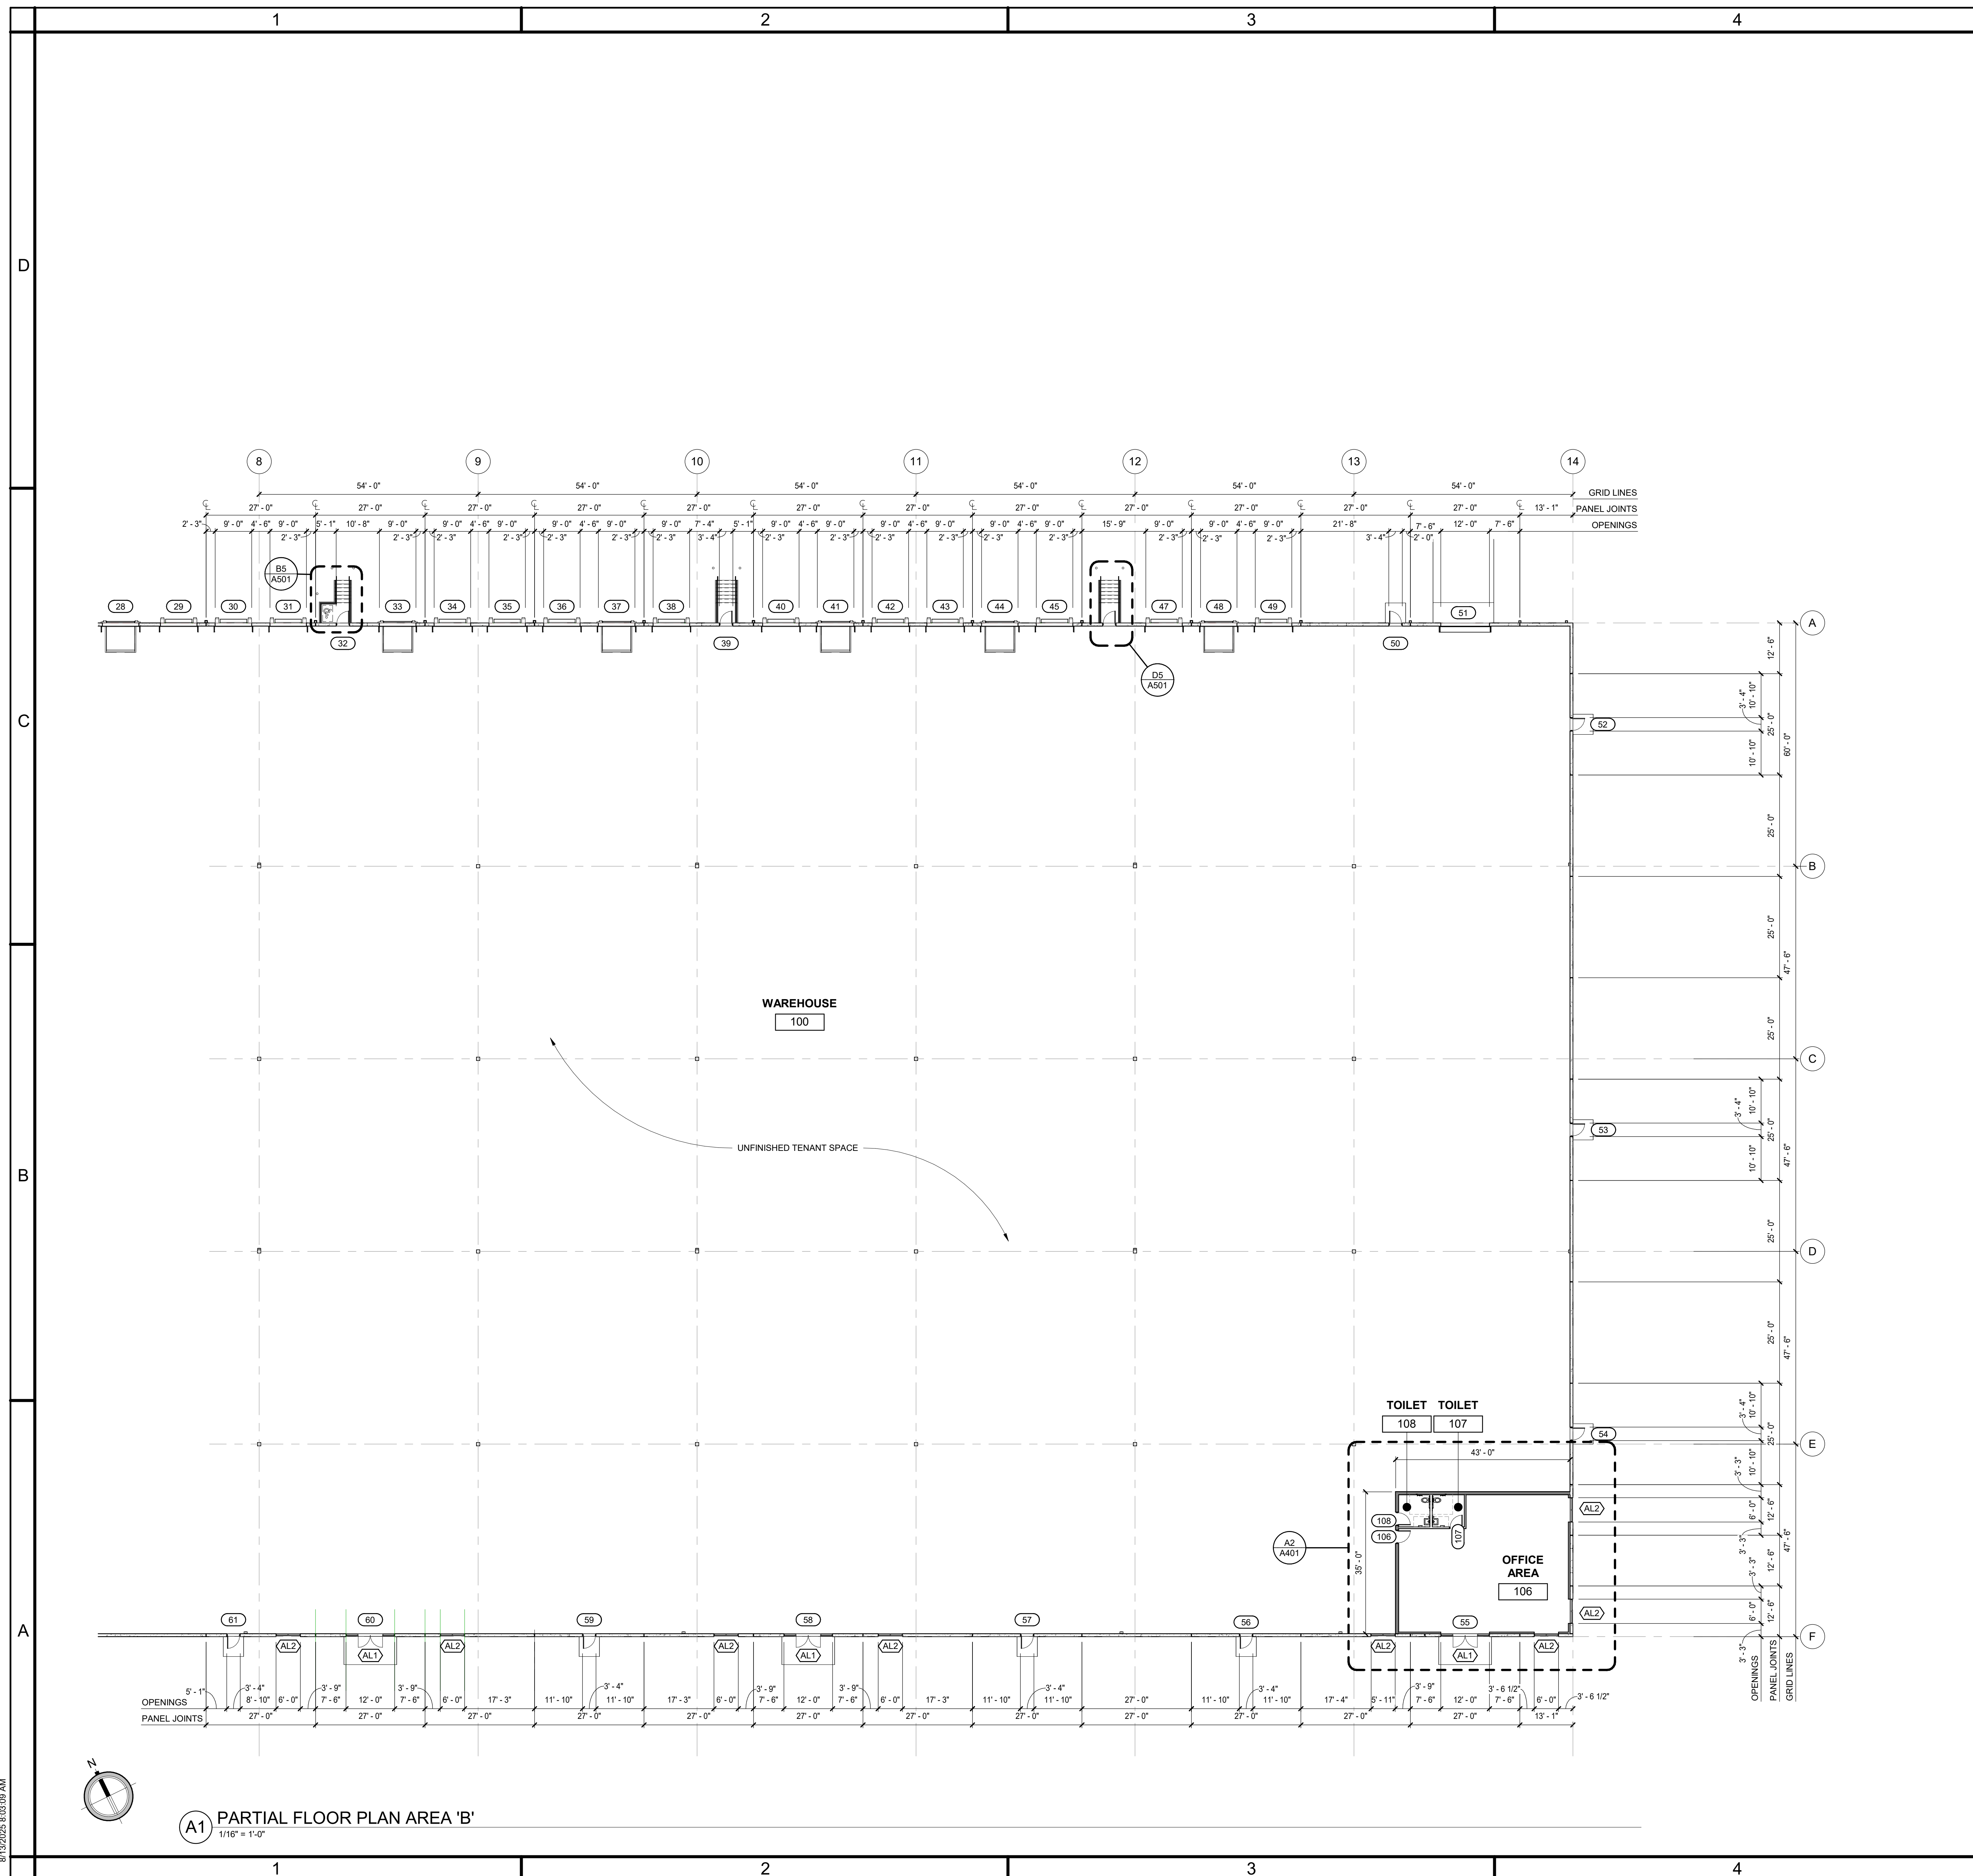


- | FLOOR PLAN GENERAL NOTES | |
|--------------------------|--|
| 1. | DIMENSIONS AT TILT/ PRE-CAST CONCRETE WALLS ARE TO THE FACE OF CONCRETE U.N.O. |
| 2. | REFER TO LIFESAFETY PLANS FOR WALL FIRE RATING |
| 3. | REFER TO A001 FOR WALL TYPES. |
| 4. | DOOR JAMBS SHALL BE 4" OFF ADJACENT WALL UNLESS OTHERWISE NOTED. |
| 5. | FIRE SUPPRESSION SYSTEM TO BE A DEFERRED SUBMITTAL. SYSTEM TO MEET ALL APPLICABLE CODES. SUBMIT AND OBTAIN ALL STATE AND LOCAL APPROVALS PRIOR TO INSTALLATION. |
| 6. | COORDINATE ALL MECH. ELEC. PLUMB. PENETRATIONS WITH THEIR RELATED DISCIPLINES. INSTALLER TO VERIFY ALL LOCATIONS AT CONCRETE SLAB. |
| 7. | WORK NOTED "BY OTHERS" OR "N/C" SHALL BE PROVIDED BY OWNER OR UNDER SEPARATE CONTRACT. |
| 8. | COORDINATE AND PROVIDE METAL OR RATED SOLID WOOD BLOCKING (IF FIRE TREATED) IN PARTITIONS AND CEILING FOR M/L WORK. WALL AND CEILING ATTACHED ITEMS AS SPECIFIED. |
| 9. | DO NOT SCALE DRAWINGS. WRITTEN DIMENSIONS GOVERN. ALL PARTITION LOCATIONS, DIMENSIONS AND TYPES, DOOR AND WINDOW LOCATIONS SHALL BE AS SHOWN ON PARTITION PLAN. IN CASE OF CONFLICT, NOTIFY ARCHITECT. |

 - ## PLAN LEGEND
- | | |
|---|-----------------------------|
|  | NON RATED PARTITION |
|  | NON RATED PARTITION TO DECK |
|  | CONCRETE TILT PANEL |
|  | 1 HR FIRE BARRIER PATTERN |
|  | 2 HR FIRE BARRIER PATTERN |
|  | STORE FRONT / WINDOW TAG |
|  | DOOR TAG |
|  | WALL TAG |
| Name  | ROOM NAME |
|   | ROOM NUMBER |

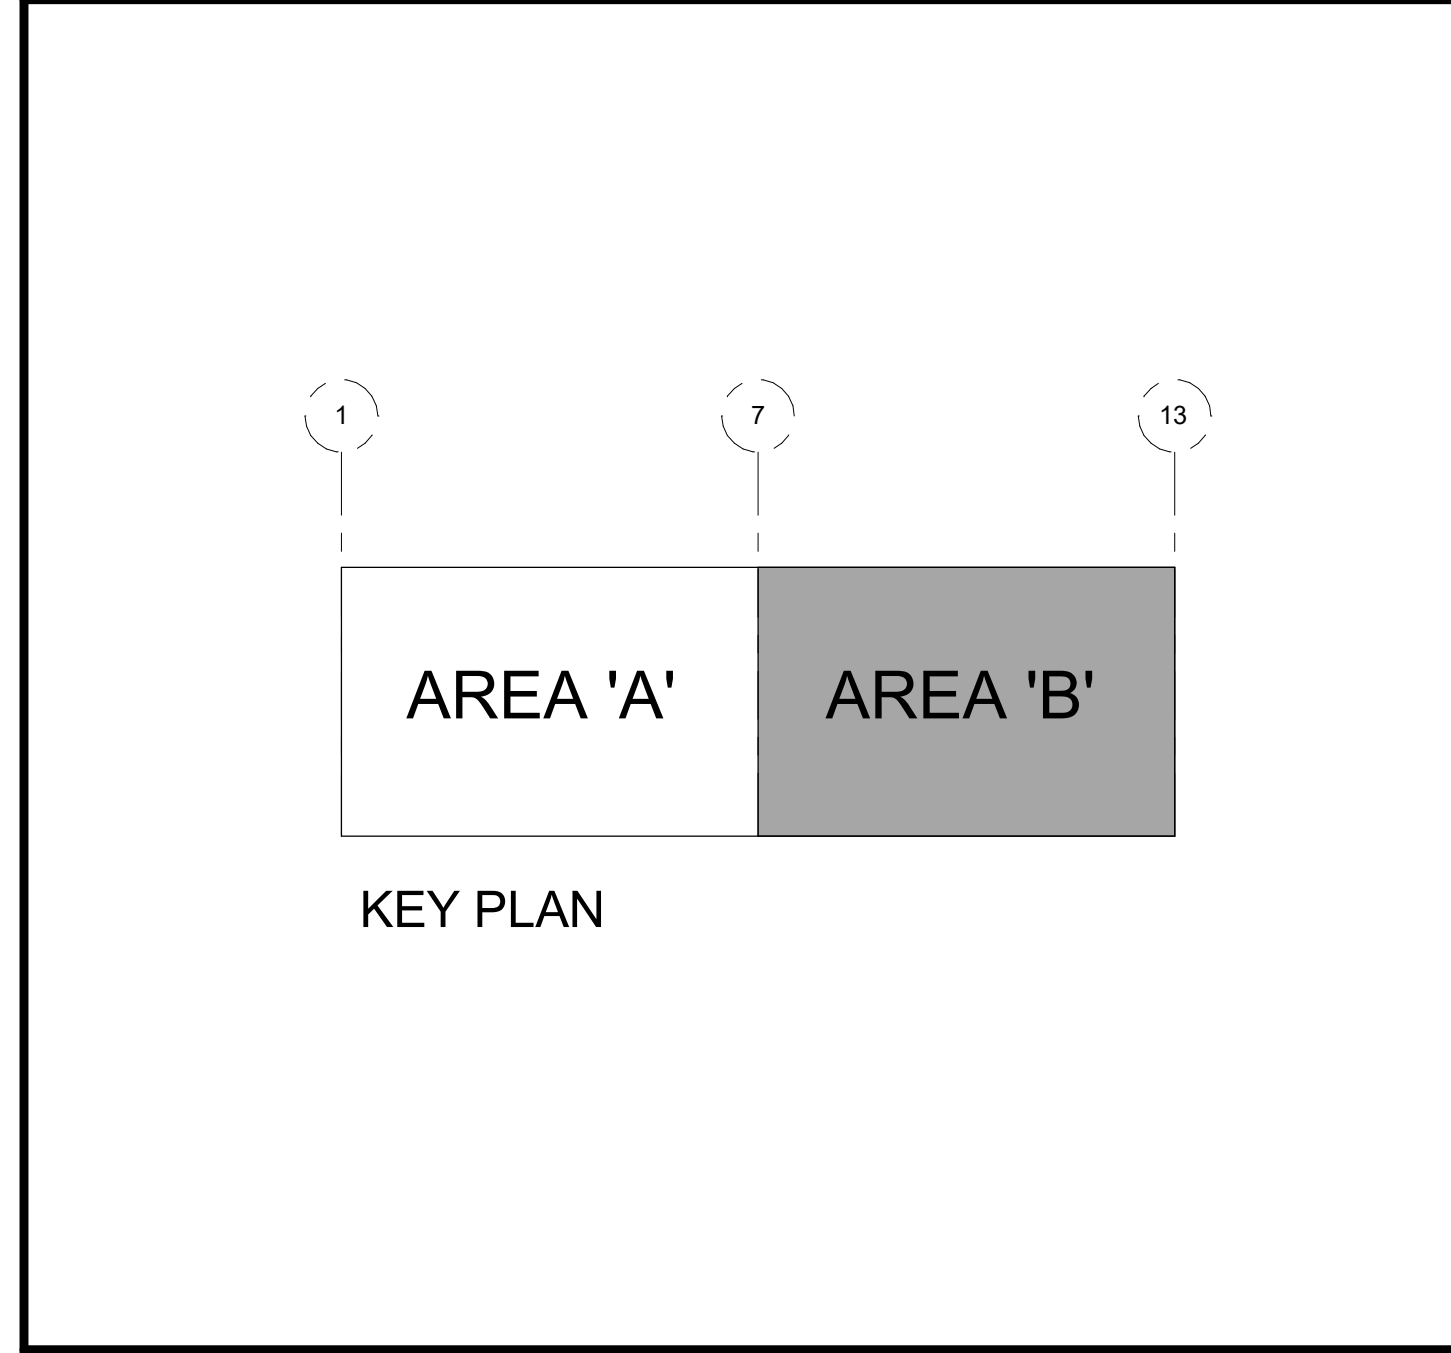

Date	Time	Location	Description

A blank coordinate plane with x and y axes. The x-axis is labeled with the number 5 at a point.

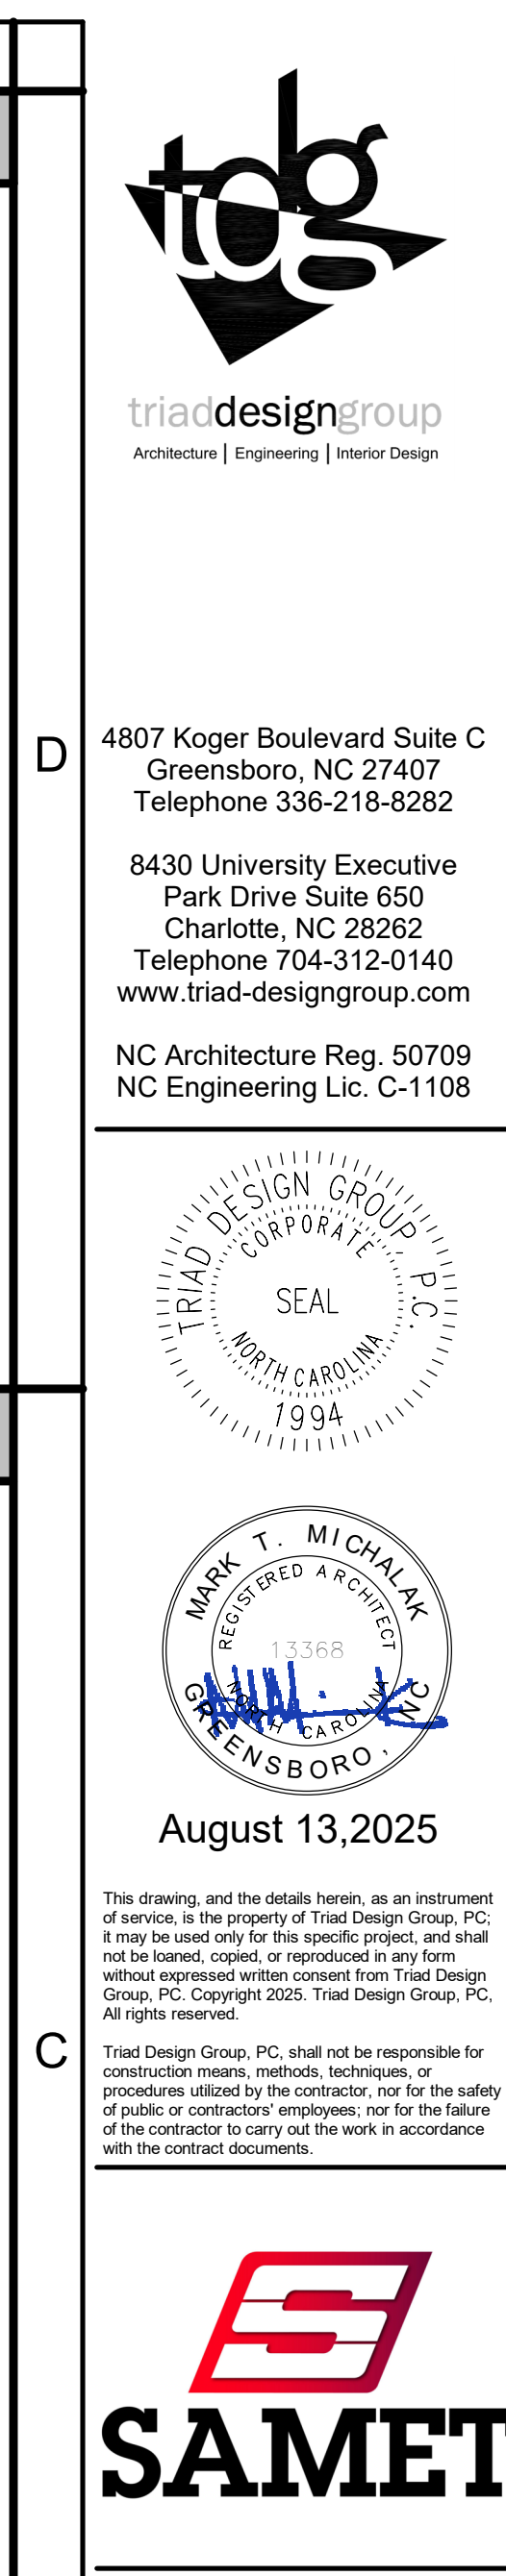

tdg
triad design group
 Architecture | Engineering | Interior Design

4807 Koger Boulevard Suite C
 Greensboro, NC 27407
 Telephone 336-218-8282

8430 University Executive
 Park Drive Suite 650
 Charlotte, NC 28262
 Telephone 704-312-0140
 www.triad-designgroup.com


NC Architecture Reg. 50709
 NC Engineering Lic. C-1108



August 13, 2025

This drawing, and the details herein, as an instrument of service, is the property of Triad Design Group, PC. It may be used only for this specific project, and shall not be loaned, copied, or reproduced in any form without expressed written consent from Triad Design Group, PC. Copyright 2025. Triad Design Group, PC. All Rights reserved.

Triad Design Group, PC, shall not be responsible for contractor mistakes, methods, techniques, or

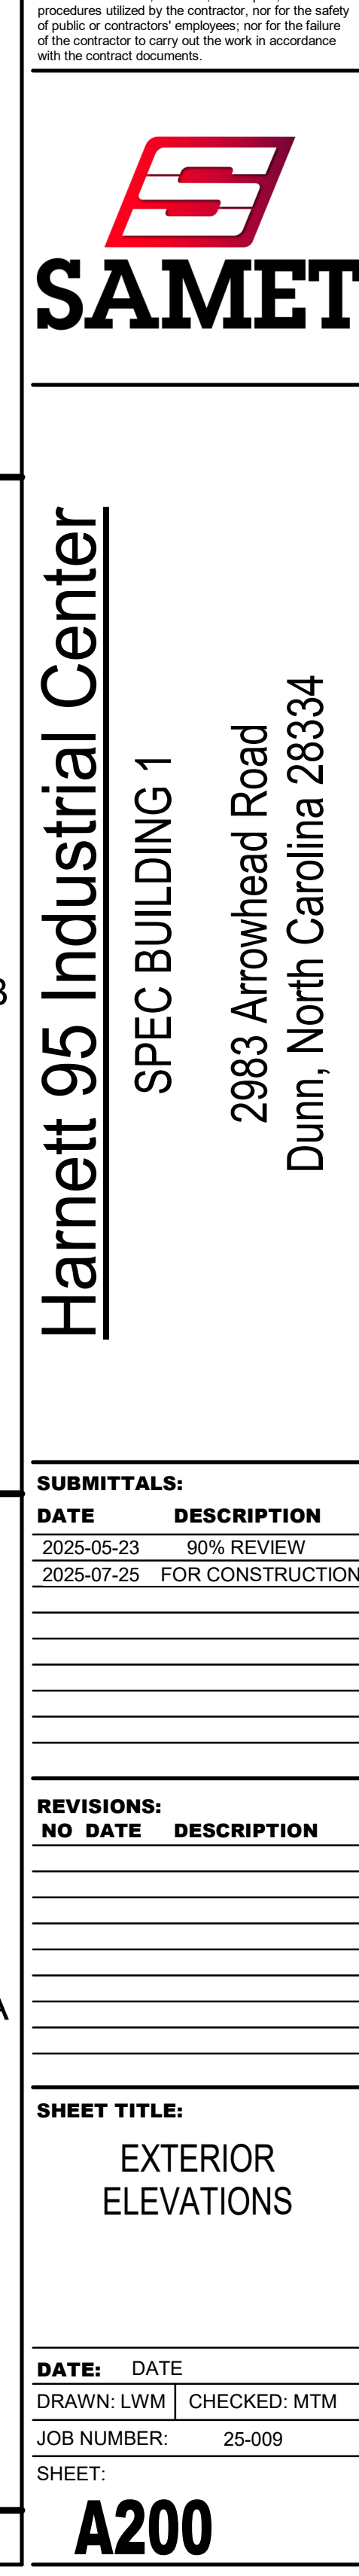



4807 Koger Boulevard Suite C
Greensboro, NC 27407
Telephone 336-218-8282

8430 University Executive
Park Drive Suite 650
Charlotte, NC 28262
Telephone 704-312-0140
www.triad-designgroup.com

NC Architecture Reg. 50709
NC Engineering Lic. C-1108



August 13, 2025

This drawing, and the details herein, as an instrument of service, is the property of Triad Design Group, P.C. It may be used only for the specific project, and shall not be loaned, copied, or reproduced in any form without the prior written consent of Triad Design Group, P.C. Copyright 2025, Triad Design Group, P.C. All rights reserved.



Harnett 95 Industrial Center
SPEC BUILDING 1
2983 Arrowhead Road
Dunn, North Carolina 28334

SUBMITTALS:
DATE DESCRIPTION
2025-05-23 90% REVIEW
2025-07-25 FOR CONSTRUCTION

REVISIONS:
NO DATE DESCRIPTION

SHEET TITLE:
PARTIAL
ELEVATIONS

DATE: DATE
DRAWN: LWM CHECKED: MTM
JOB NUMBER: 25-009
SHEET:

A201



4	5
PAINT SCHEDULE	ELEVATION KEYNOTES
EXTERIOR EXTERIOR GALVANIZED - METAL SUBSTRATES: LATEX SYSTEM CLEAN: DEGREASE SUBSTRATE PRIOR TO PRIMER APPLICATION PRIME COAT: DTM ACRYLIC PRIMER / FINISH INTERMEDIATE COAT: DTM ACRYLIC COATING (GLOSS) FINAL COAT: DTM ACRYLIC COATING (GLOSS) EXTERIOR STRUCTURAL / MISCELLANEOUS STEEL/ HOLLOW METAL ITEMS (HOLLOW METAL DOOR AND WINDOW FRAMES, BOLLARDS, RAILINGS, LINTELS, EXPOSEDE GAS PIPING, WELD CONNECTIONS, STEEL EMBEDS, ETC.) ALKYD SYSTEM CLEAN/ SPOT PRIME, WHERE REQUIRED: UNIVERSAL METAL PRIMER FIRST COAT: INDUSTRIAL ALKYD ENAMEL FINAL COAT: INDUSTRIAL ALKYD ENAMEL (GLOSS) EXTERIOR CONCRETE WALL PANELS: "ULTRA-CRETE" OR "ELASTOMERIC" SYSTEM PRESSURE WASH: COMPLETE EXTERIOR OF BUILDING TO BE PRESSURE WASHED PRIO TO APPLICATION OF PRIMER PRIME COAT: COMPATIBLE WITH FINAL FINISH COAT (LOXON PRIMER) FINAL COAT: MEDIUM TEXTURE INTERIOR STRUCTURAL / MISCELLANEOUS/ HOLLOW METAL STEEL ITEMS: (HOLLOW METAL DOOR AND WINDOW FRAMES, BOLLARDS, LINTELS, WELD CONNECTIONS AND EMBEDS, ETC.) GALVANIZED - METAL SUBSTRATES: (INCLUDES GALVANIZED STEEL ITEMS AND EXPOSED GALVANIZED METAL DUCT) LATEX SYSTEM CLEAN: DEGREASE SUBSTRATE PRIOR TO PRIMER APPLICATION PRIME COAT: DTM ACRYLIC PRIMER / FINISH INTERMEDIATE COAT: DTM ACRYLIC COATING (GLOSS) FINAL COAT: DTM ACRYLIC COATING (GLOSS) CONCRETE BLOCK: LATEX SYSTEM PRIME COAT: HEAVY DITY BLOCK FILLER INTERMEDIATE COAT: INTERIOR ALKYD MATCHING FINALCOAT FINAL COAT: INTERIOR ALKYD (SEMI-GLOSS) WOOD SUBSTRATES: (PLYWOOD, TRIM, WOOD / COMPOSITE paneled doors, WHERE SCHEDULED, SHELVEING, ETC.) ALKYD SYSTEM PRIME COAT: INTERIOR ALKYD PRIMER / SEALER INTERMEDIATE COAT: INTERIOR ALKYD MATCHING FINAL COAT FINAL COAT: INTERIOR ALKYD (SEMI-GLOSS) GYPSUM BOARD SUBSTRATES: LATEX SYSTEM PRIME COAT: INTERIOR LATEX PRIMER/ SEALER INTERMEDIATE COAT: INTERIOR LATEX MATCHING FINAL COAT FINAL COAT: INTERIOR LATEX (FLAT) FOR CEILINGS, SOFFITS OR BULKHEADS, EGGSHELL FOR VERITCAL SURFACES.	1 TILT-UP CONCRETE WALL PANEL (PAINT) 2 ALUMINUM ENTRY WITH INSULATED GLASS - SEE SHEET A600 3 ALUMINUM STOREFRONT WITH INSULATED GLASS - SEE SHEET A600 4 PRE-ENGINEERED AND PREFINISHED METAL CANOPY 5 6'-0" x 5'-0" HIGH ALUM. FRAME CLEARSTORY WINDOW @ 21'-0" A.F.F. 6 6'-0" x 5'-0" KNOCK-OUT PANEL @ 21'-0" A.F.F. 7 6'-0" x 7'-0" HIGH KNOCK-OUT PANEL 8 6'-0" x 8'-11" HIGH KNOCK-OUT PANEL 10 HOLLOW METAL DOOR AND FRAME (PAINT) 11 24 GA. PREFINISHED METAL COPING 12 PREFINISHED 8" W. x 6" H. METAL GUTTER" 13 PREFINISHED 5" x 5" METAL DOWNSPOUT" 14 DOWNSPOUT GUARD - SEE A1/A501 & B1/A501 NO PAINT IF GALVANIZED, IF NOT, MATCH ADJACENT WALL FINISH. 15 GALVANIZED STEEL STAIR 16 GALVANIZED STEEL STAIR WITH AREA OF ASSISTED RESCUE 18 STEEL PIPE BOLLARD (PAINT) 17 NOT A REVEAL INSULATED OVERHEAD SECTIONAL DOOR (FACTORY FINISH). SEE DOOR SCHEDULE 20 PIT LEVELER (REFER TO SAMET STANDARDS) 21 9'-0" x 12'-2" HIGH KNOCK-OUT PANEL 22 14' x 16' INSULATED OVERHEAD SECTIONAL DOOR (FACTORY FINISH). SEE DOOR SCHEDULE 23 14'-0" x 16'-0" HIGH KNOCK-OUT PANEL 24 GALVANIZED METAL ROOF ACCESS LADDER TO COMPLY WITH 2018 NCBC, OSHA # 1910.28 & IMC SEC. 306.5 (SEE DET. C1/A500) 25 EDGE OF DOCK LEVELER (REFER TO SAMET STANDARDS) 26 6'-0" x 5'-0" HIGH ALUM. FRAME CLERESTORY WINDOW @ 25'-10" A.F.F.
PAINT SPECIFICATIONS	
INTERIOR PROVIDE SHERWIN WILLIAMS OR APPROVED EQUAL WALLS - GWB: 1 COAT: SHERWIN WILLIAMS: PRO MAR 200 ZERO VOC INTERIOR LATEX PRIMER (WHITE) 2 COATS: SHERWIN WILLIAMS: PRO MAR 200 ZERO VOC INTERIOR LATEX (EGGSHELL) WALLS - CMU: 1 COAT: SHERWIN WILLIAMS: PREPRITE INTERIOR / EXTERIOR BLOCK FILLER 2 COATS: SHERWIN WILLIAMS: PRO MAR 200 ZERO VOC INTERIOR LATEX (EGGSHELL) CEILINGS - GWB: 1 COAT: SHERWIN WILLIAMS: PRO MAR 200 ZERO VOC INTERIOR LATEX PRIMER (WHITE) 2 COATS: SHERWIN WILLIAMS: PRO MAR 200 ZERO VOC INTERIOR LATEX (FLAT) HM DOORS / HM FRAMES: PRIMER: SHERWIN WILLIAMS: PRO INDUSTRIAL PRO-CRYL UNIVERSAL PRIMER (PRIME AS NEEDED) 2 COATS: SHERWIN WILLIAMS: PRO INDUSTRIAL WATERBASED ALKYD URETHANE (SEMI-GLOSS)	
EXTERIOR PRE-CAST PANELS: 1 COAT: SHERWIN WILLIAMS: LOXON CONCRETE & MASONRY PRIMER 2 COATS: SHERWIN WILLIAMS: MEDIUM TEXTURE ACCENTS: 2 COATS: SHERWIN WILLIAMS: A-100 EXTERIOR ACRYLIC LATEX (SATIN) BOLLARDS: PRIMER: SHERWIN WILLIAMS: PRO INDUSTRIAL PRO-CRYL UNIVERSAL PRIMER (PRIME AS NEEDED) 2 COATS: SHERWIN WILLIAMS: PRO INDUSTRIAL WATERBASED ALKYD URETHANE (SEMI-GLOSS)	
	NOTES: 1. ALL REVEALS TO BE PAINTED SAME AS ADJACENT FIELD COLOR (ABOVE OR BELOW) - MAINTAIN CONSISTENCY AROUND BUILDING.

4807 Koger Boulevard Suite C
Greensboro, NC 27407
Telephone 336-218-8282

8430 University Executive
Park Drive Suite 650
Charlotte, NC 28262
Telephone 704-312-0140
www.triad-designgroup.com

NC Architecture Reg. 50709
NC Engineering Lic. C-1108

August 13, 2025

This drawing, and the details herein, are an instrument of service, in the project of Triad Design Group, PC. It may be used only for this specific project, and shall not be loaned, copied, or reproduced in any form without the prior written consent of Triad Design Group, PC. Copyright 2025, Triad Design Group, PC. All rights reserved.

Triad Design Group, PC, shall not be responsible for construction means, methods, techniques, or procedures utilized by the contractor, nor for the safety of public or contractor's employees, nor for the failure of the contractor to carry out the work in accordance with the contract documents.


Harnett 95 Industrial Center
SPEC BUILDING 1
2993 Arrowhead Road
Dunn, North Carolina 28334

SUBMITTALS:

DATE	DESCRIPTION
2025-05-23	90% REVIEW
2025-07-25	FOR CONSTRUCTION

REVISIONS:

NO	DATE	DESCRIPTION
1	07/14/25	OWNER COMMENTS

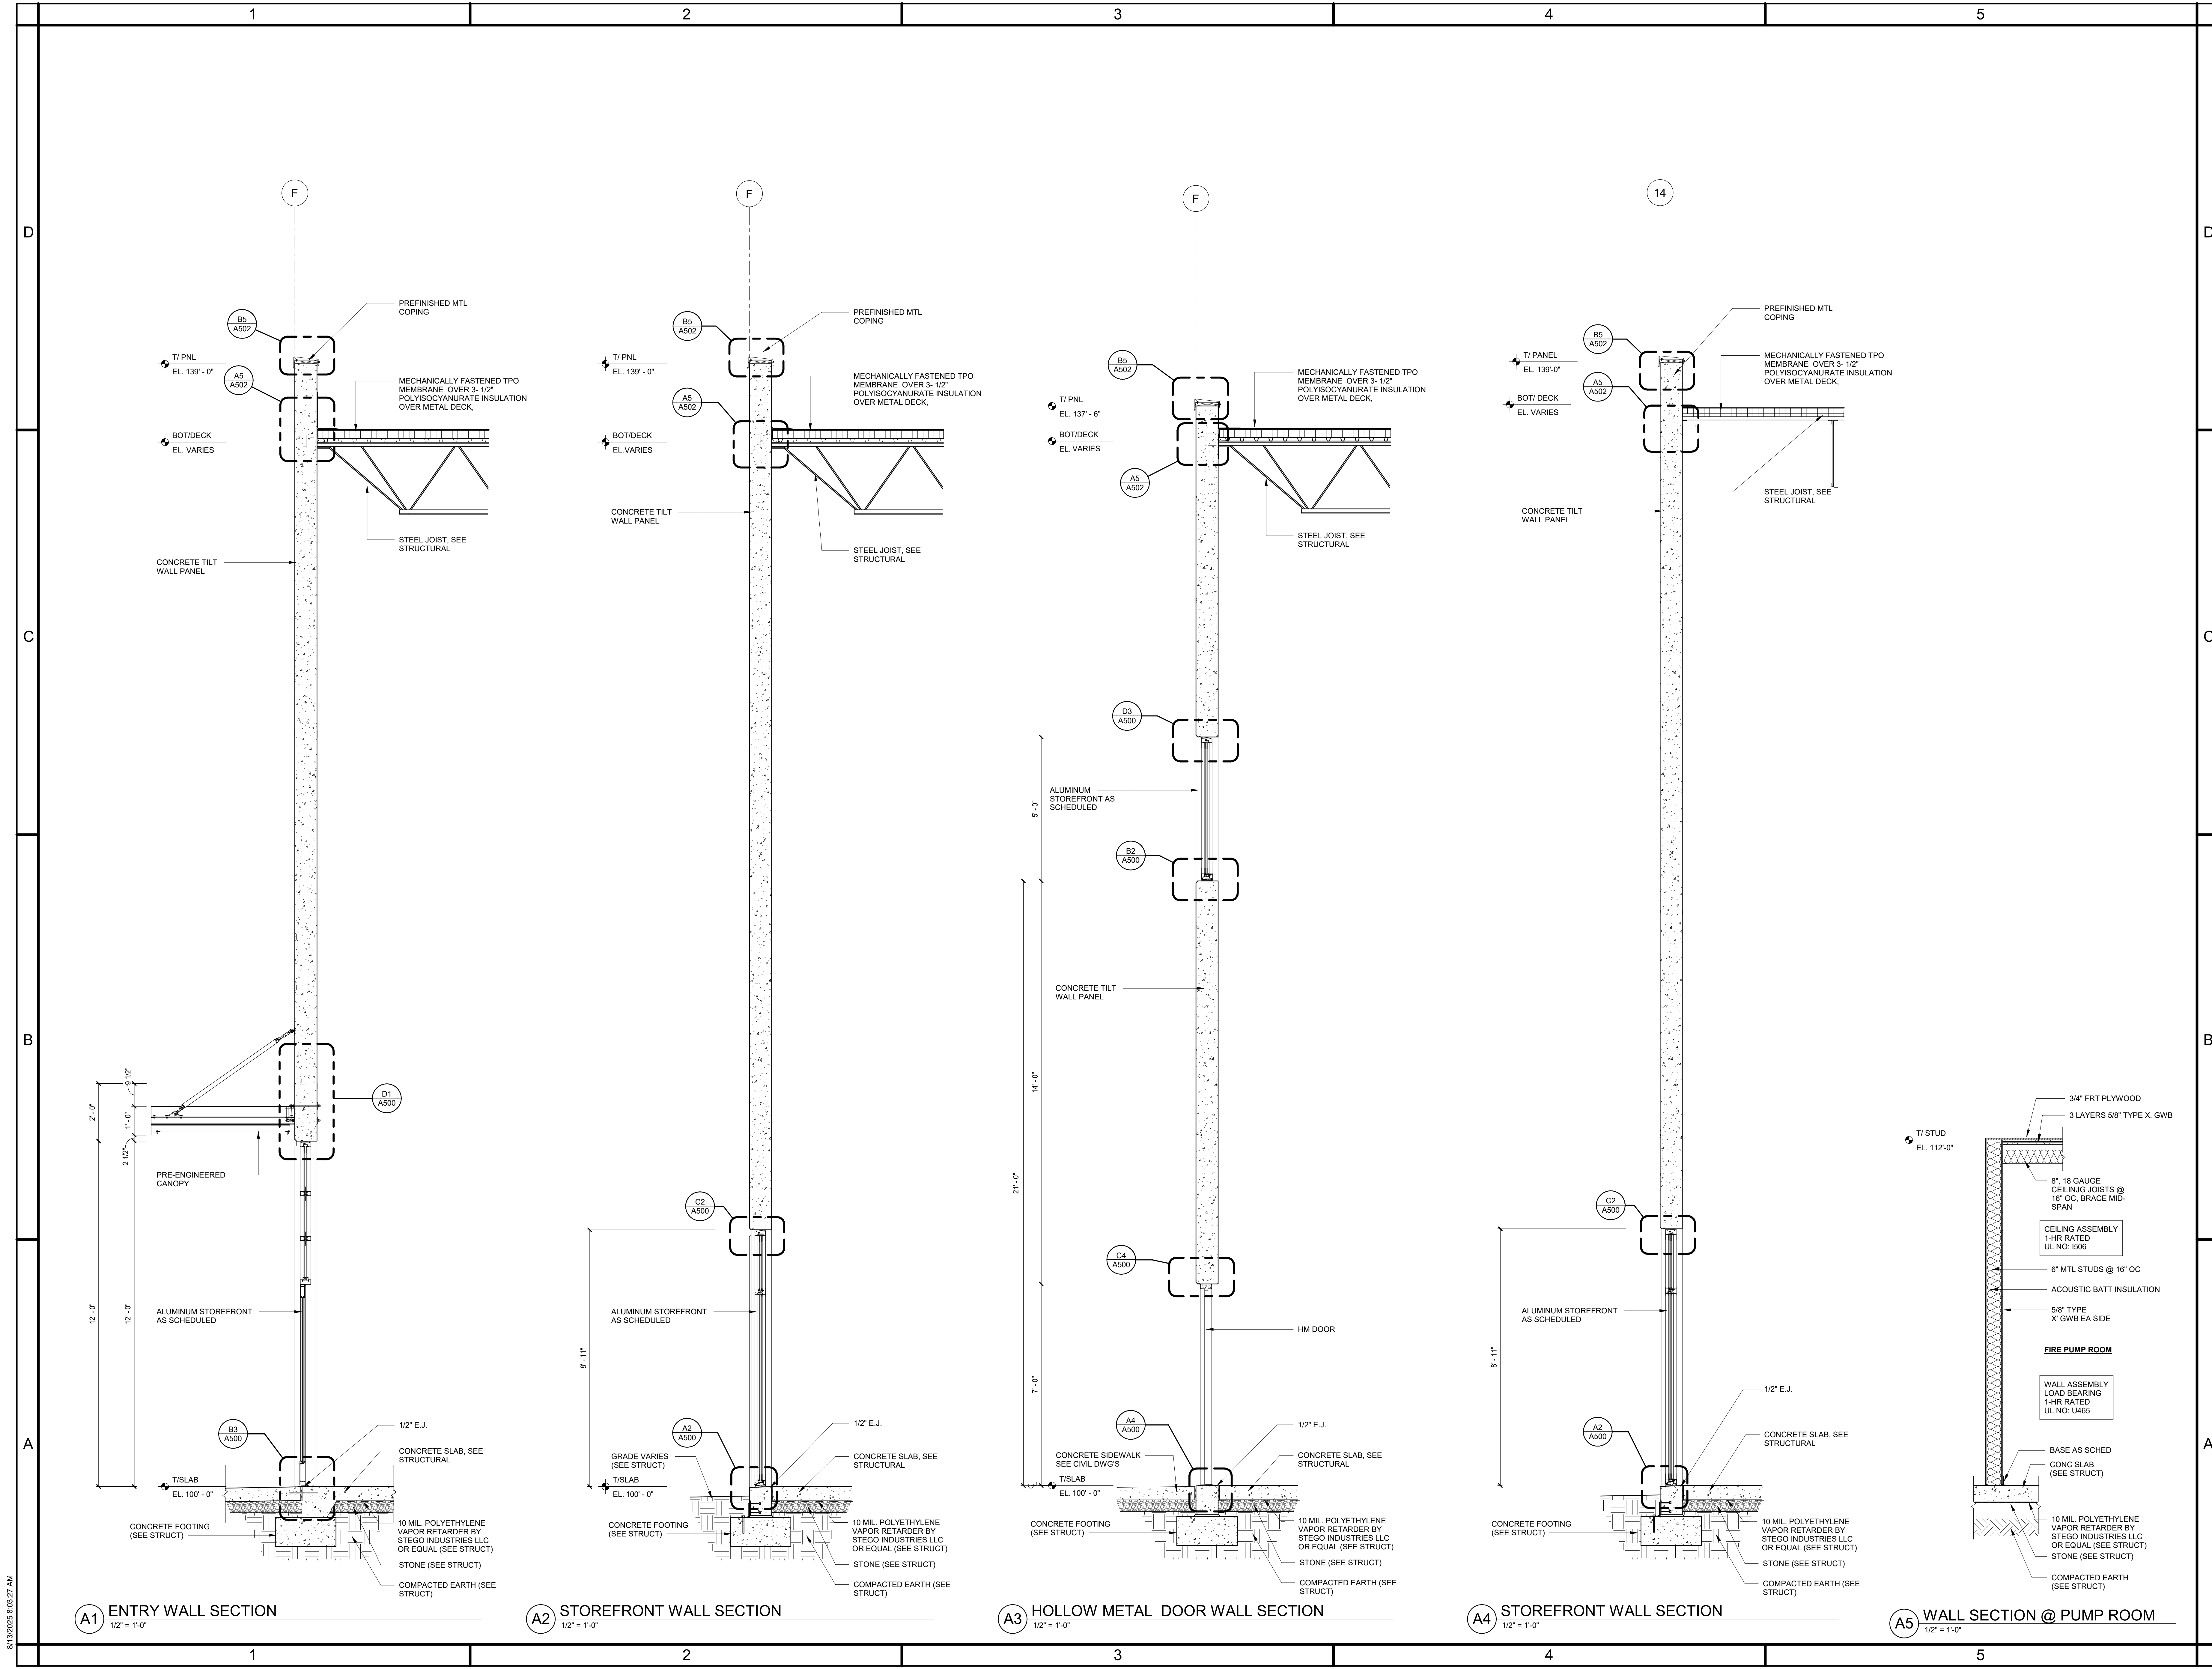




triad design group
Architecture | Engineering | Interior Design

4807 Koger Boulevard Suite C
Greensboro, NC 27407
Telephone 336-218-8282

8430 University Executive
Park Drive Suite 650
Charlotte, NC 28262
Telephone 704-312-0140
www.triad-designgroup.com

NC Architecture Reg. 50709
NC Engineering Lic. C-108

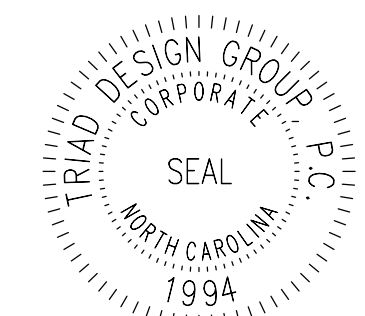

August 13, 2025

This drawing, and the details herein, as an instrument of service, is the property of Triad Design Group, P.C. It may be used only for this specific project, and shall not be loaned, copied, or reproduced in any form without express written consent from Triad Design Group, P.C. Copyright 2025. Triad Design Group, P.C. All rights reserved.

Triad Design Group, P.C. shall not be responsible for construction means, methods, techniques, or procedures utilized by the contractor, nor for the safety of public or contractor's employees, nor for the failure of the contractor to carry out the work in accordance with the contract documents.



Harnett 95 Industrial Center
SPEC BUILDING 1
2983 Arrowhead Road
Dunn, North Carolina 28334

SUBMITTALS:	
DATE	DESCRIPTION
2025-05-23	90% REVIEW
2025-07-25	FOR CONSTRUCTION

REVISIONS:		
NO	DATE	DESCRIPTION
1	07/14/25	OWNER COMMENTS

SHEET TITLE:
TYPICAL WALL SECTIONS

DATE: DATE
DRAWN: LWM
CHECKED: MTM
JOB NUMBER: 25-009
SHEET:

A301 R1



8430 University Executive
Park Drive Suite 650
Charlotte, NC 28262
Telephone 704-312-0140
www.triad-designgroup.com

NC Architecture Reg. 50709
NC Engineering Lic. C-1108



August 13.202.

This drawing, and the details herein, as an instrument of service, is the property of Triad Design Group, PC; it may be used only for this specific project, and shall not be loaned, copied, or reproduced in any form without expressed written consent from Triad Design Group, PC. Copyright 2025. Triad Design Group, PC. All rights reserved.

Triad Design Group, PC, shall not be responsible for construction means, methods, techniques, or procedures utilized by the contractor, nor for the safety of public or contractors' employees; nor for the failure of the contractor to carry out the work in accordance with the contract documents.



Plot 95 Industrial Center
SPEC BUILDING 1
2983 Arrowhead Road
Dunn, North Carolina 28334


SUBMITTALS:	
DATE	DESCRIPTION
2025-05-23	90% REVIEW
2025-07-25	FOR CONSTRUCTION


REVISIONS:		
NO	DATE	DESCRIPTION
1	07/14/25	OWNER COMMENT

SHEET TITLE:
TYPICAL WALL
SECTIONS


DATE: DATE	
DRAWN: LWM	CHECKED: MTM
JOB NUMBER: 25-009	
SHEET:	

A302 R

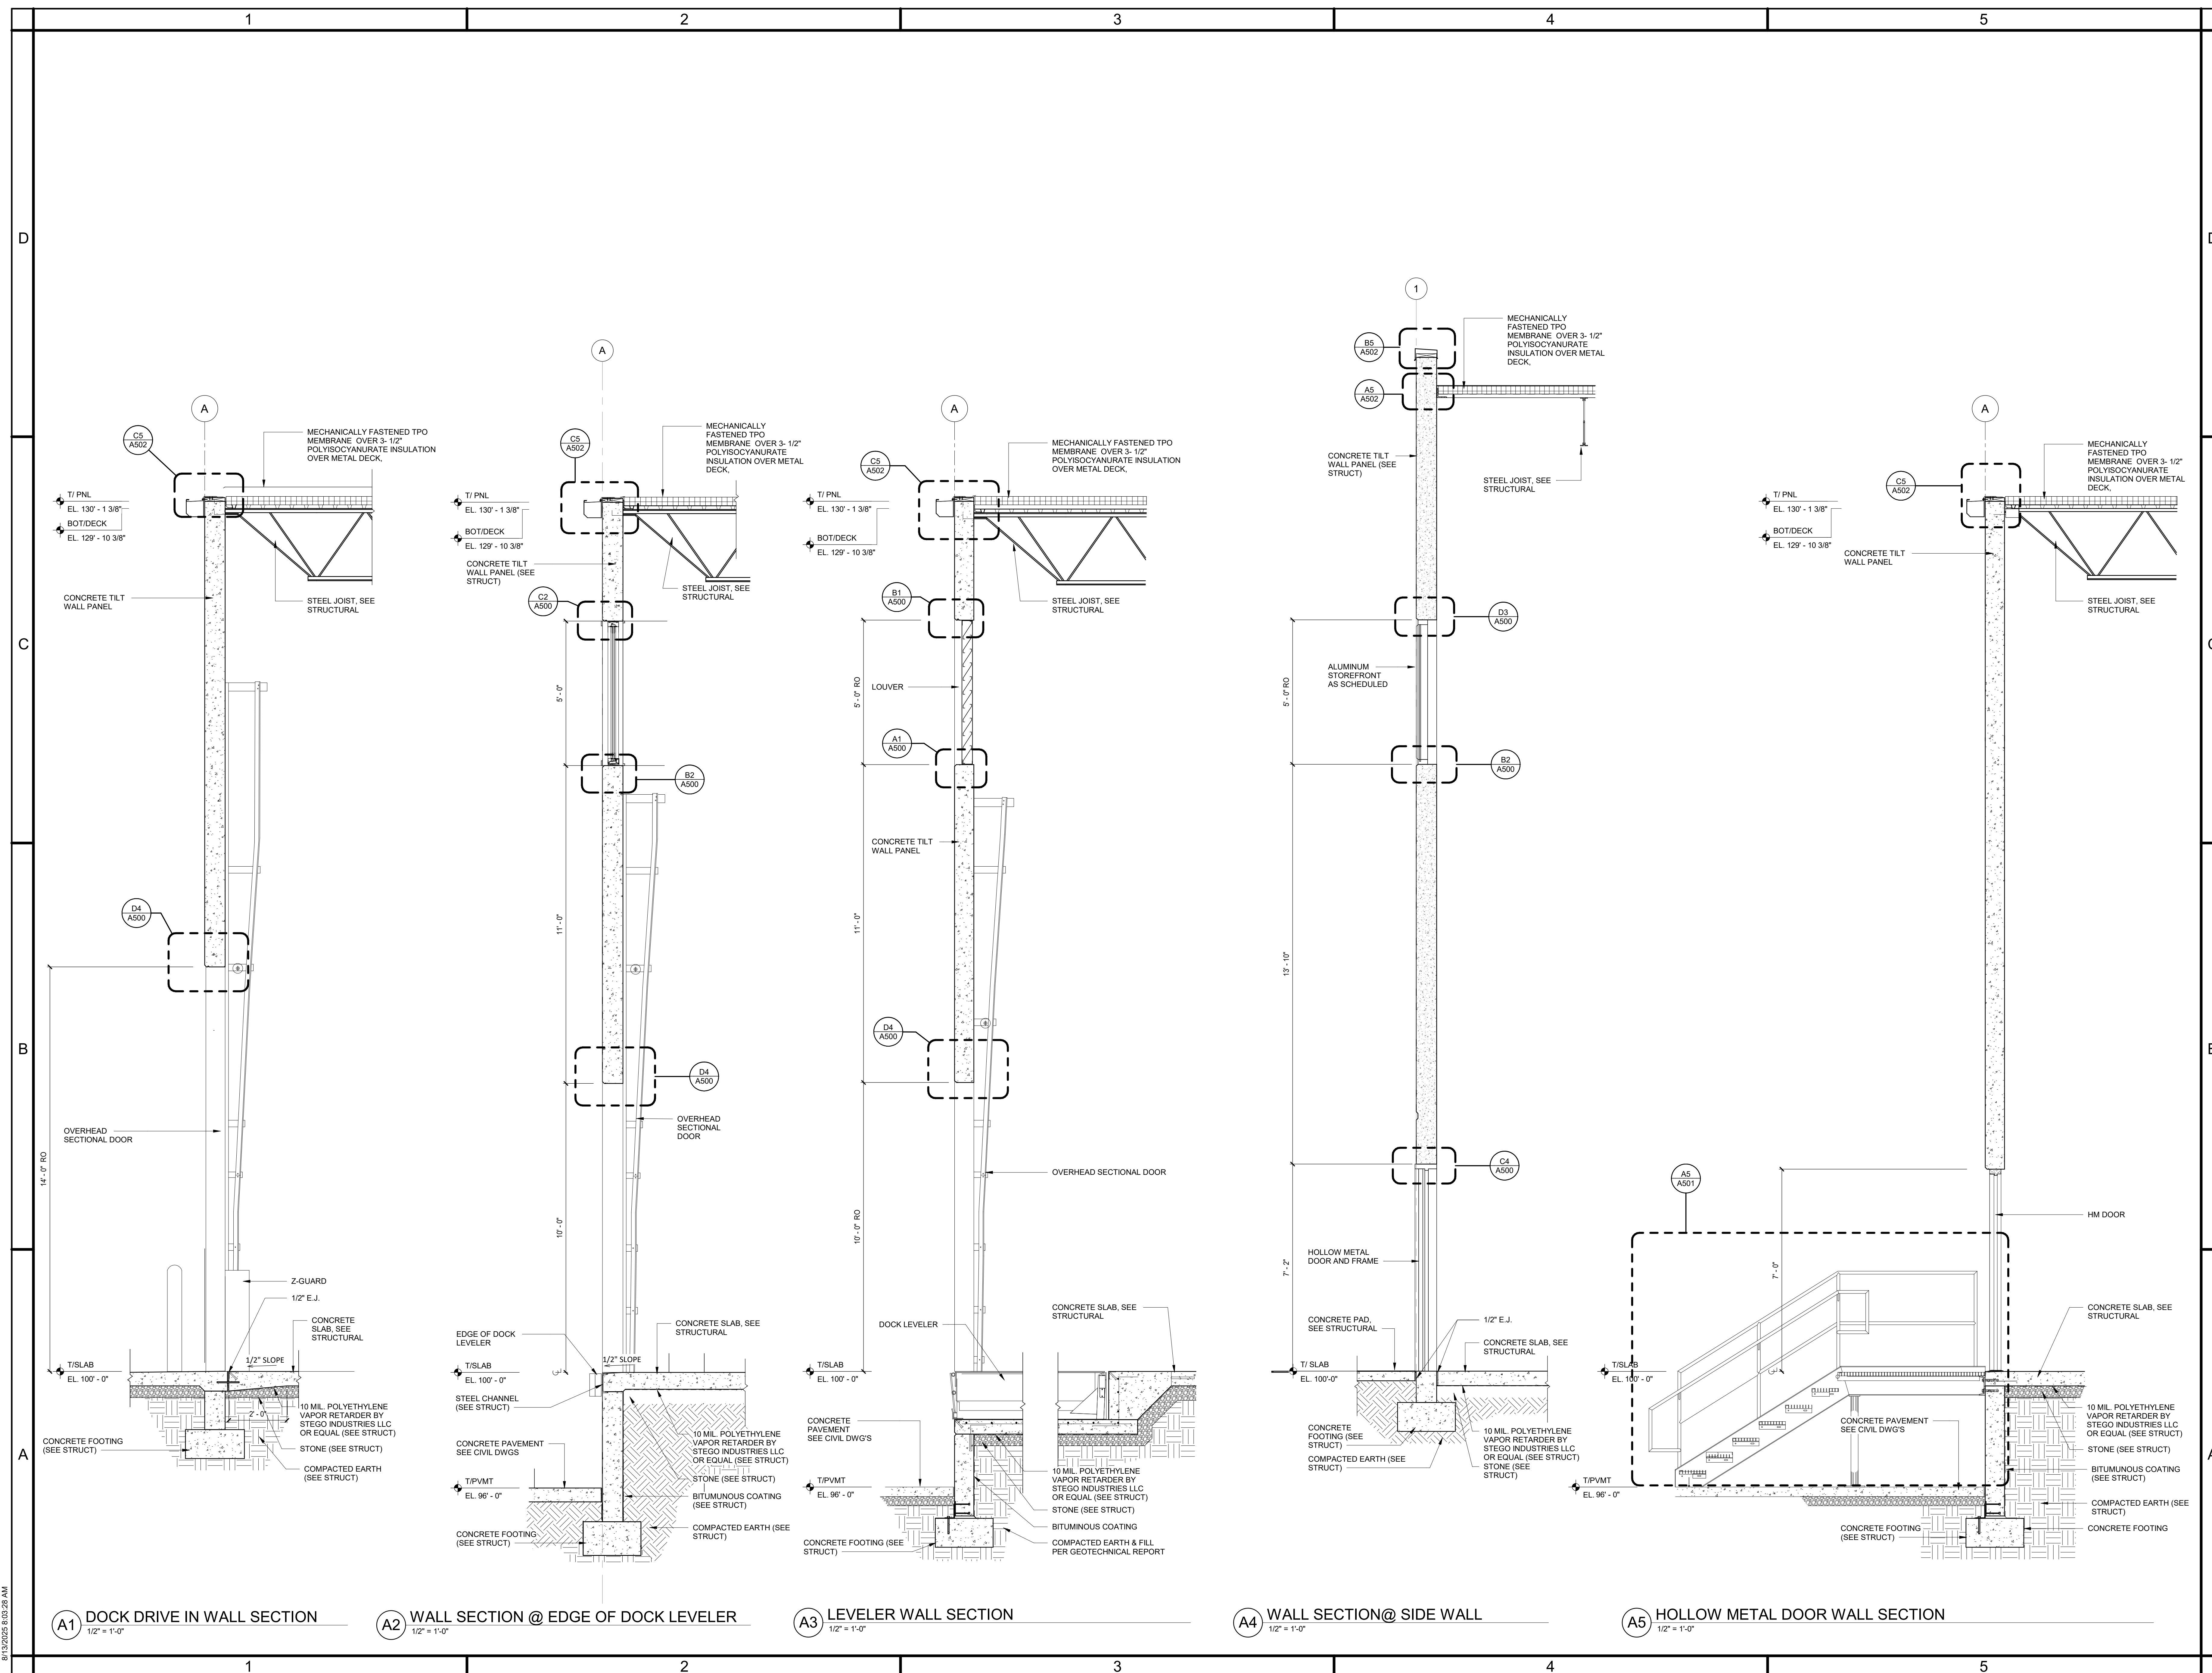


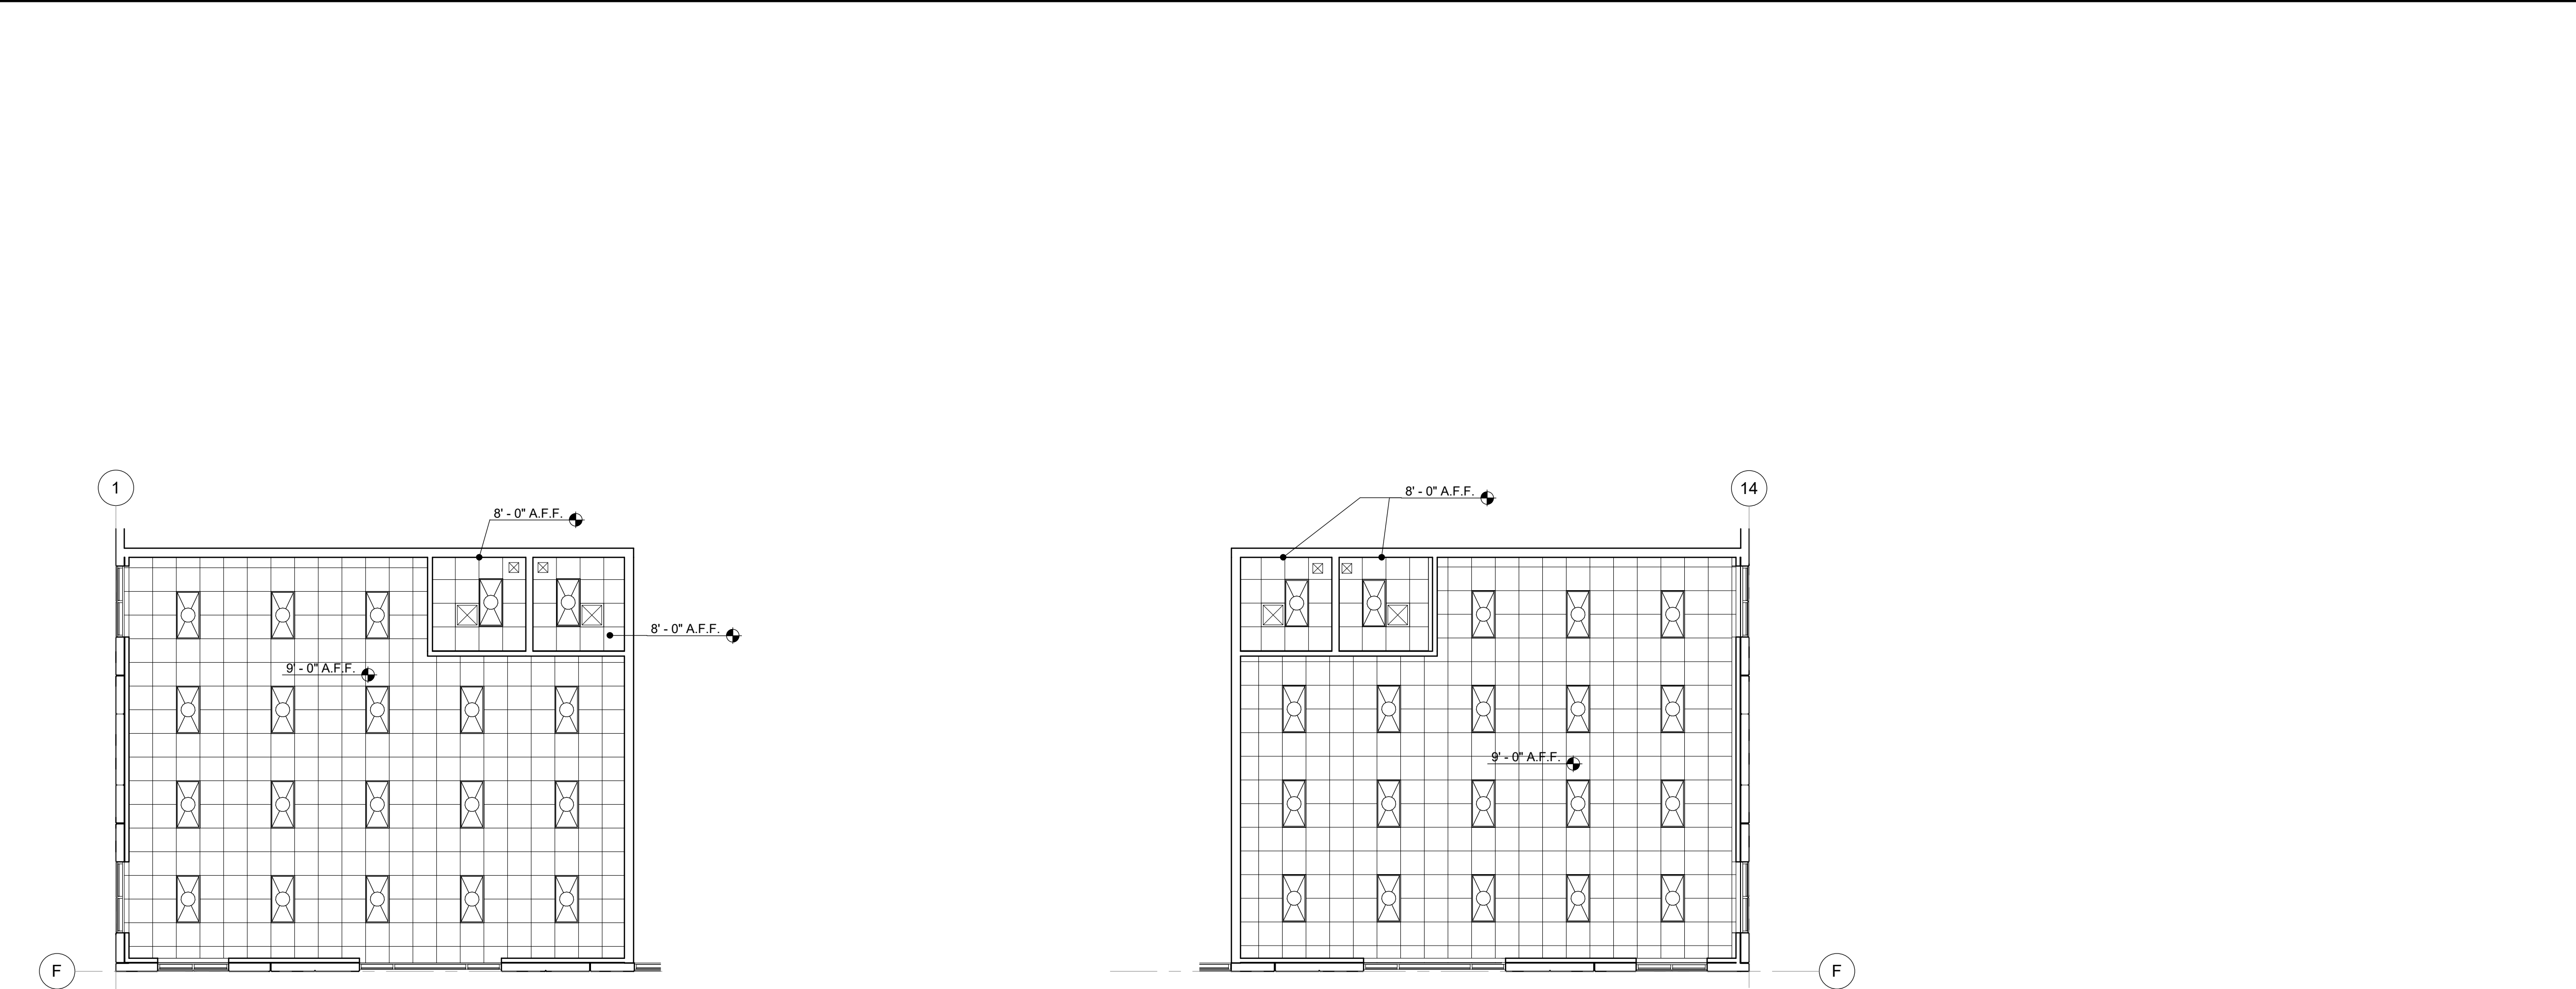

(B2) OFFICE REFLECTED CEILING PLAN
1/8" = 1'-0"

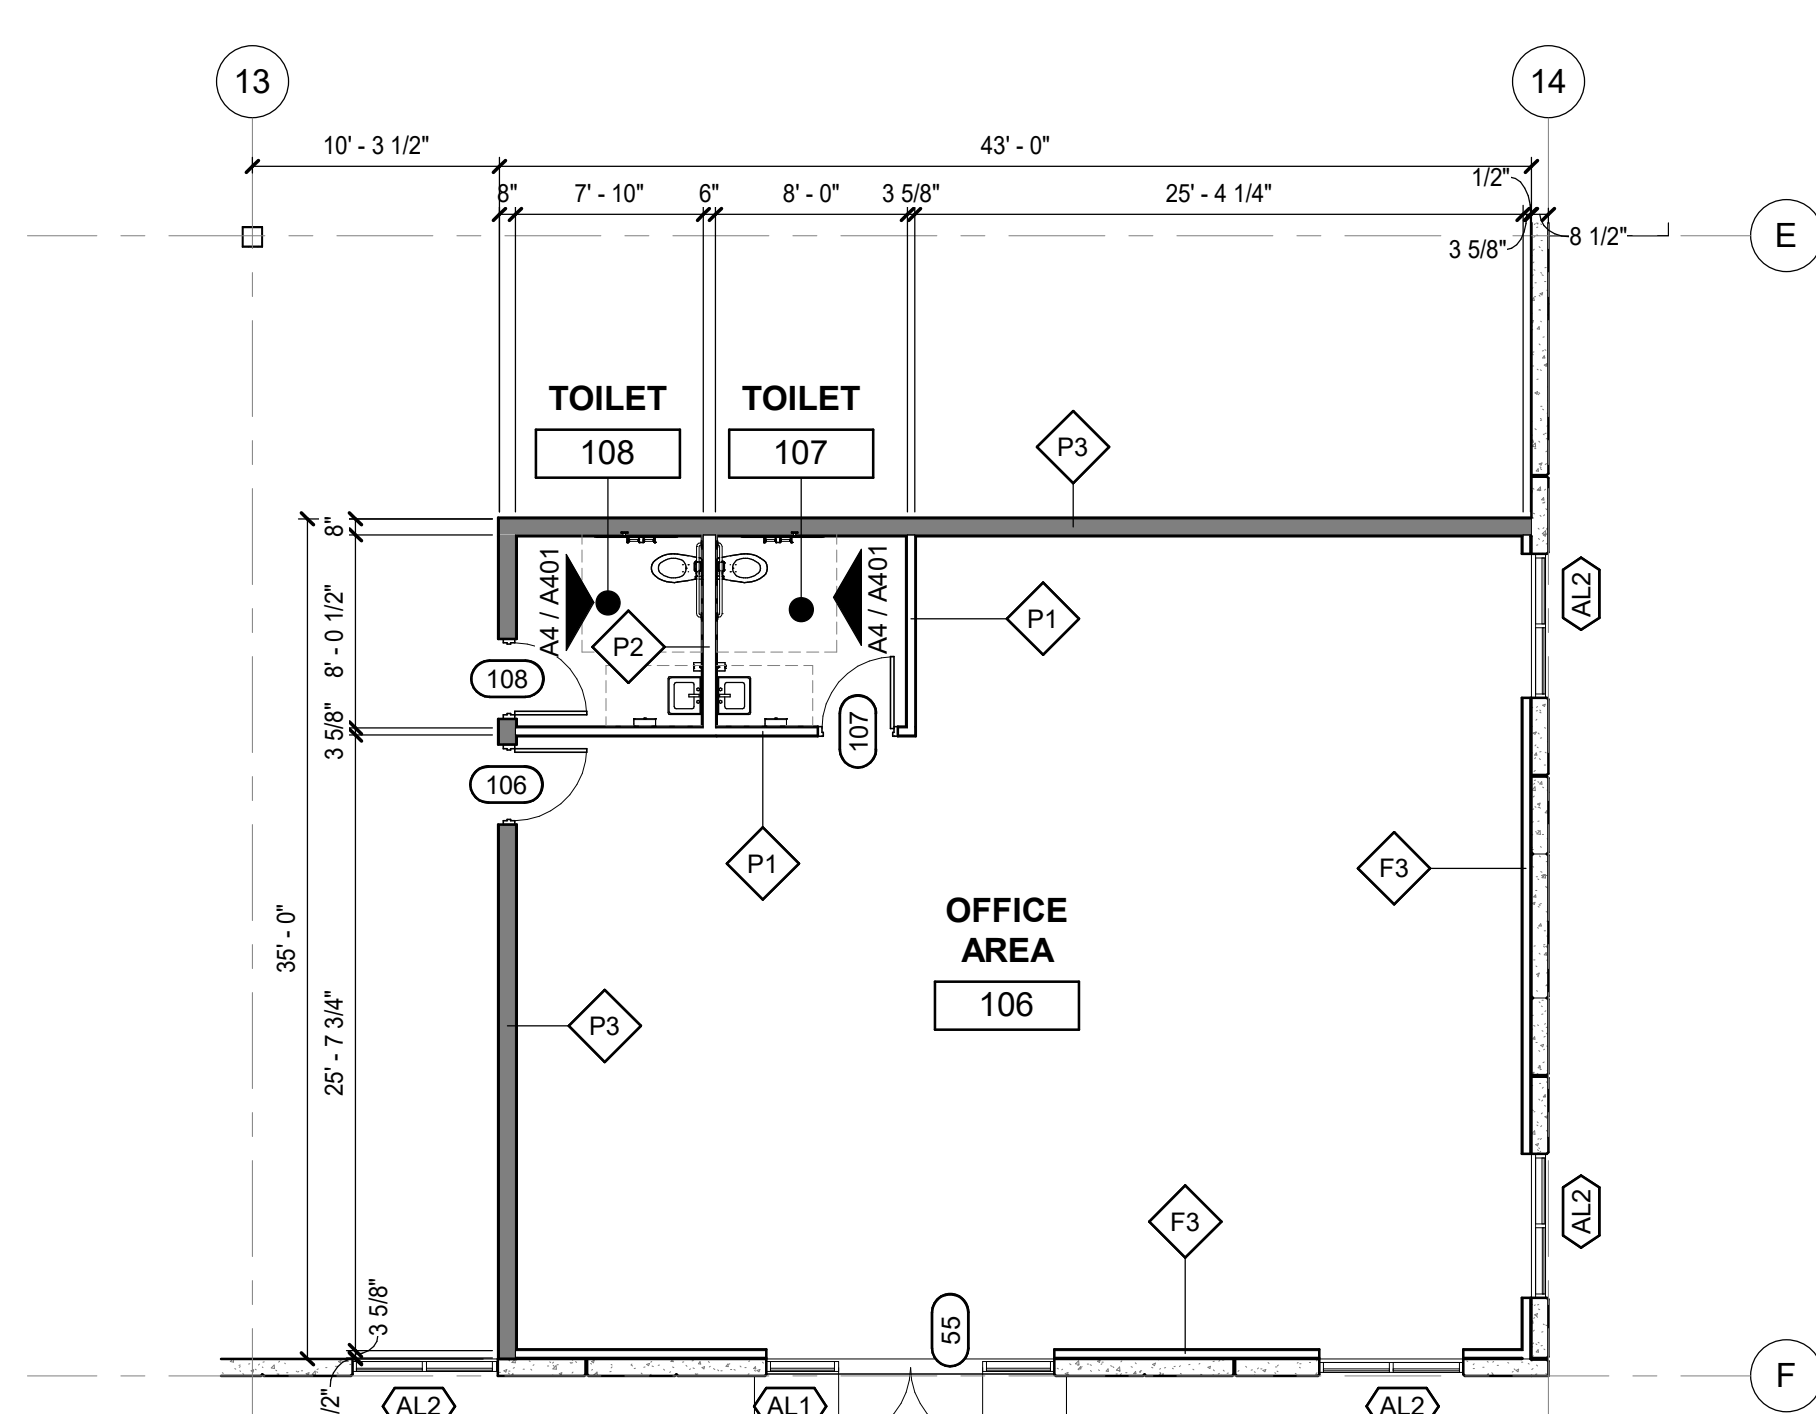

A2 OFFICE FLOOR PLAN
1/8" = 1'-0"

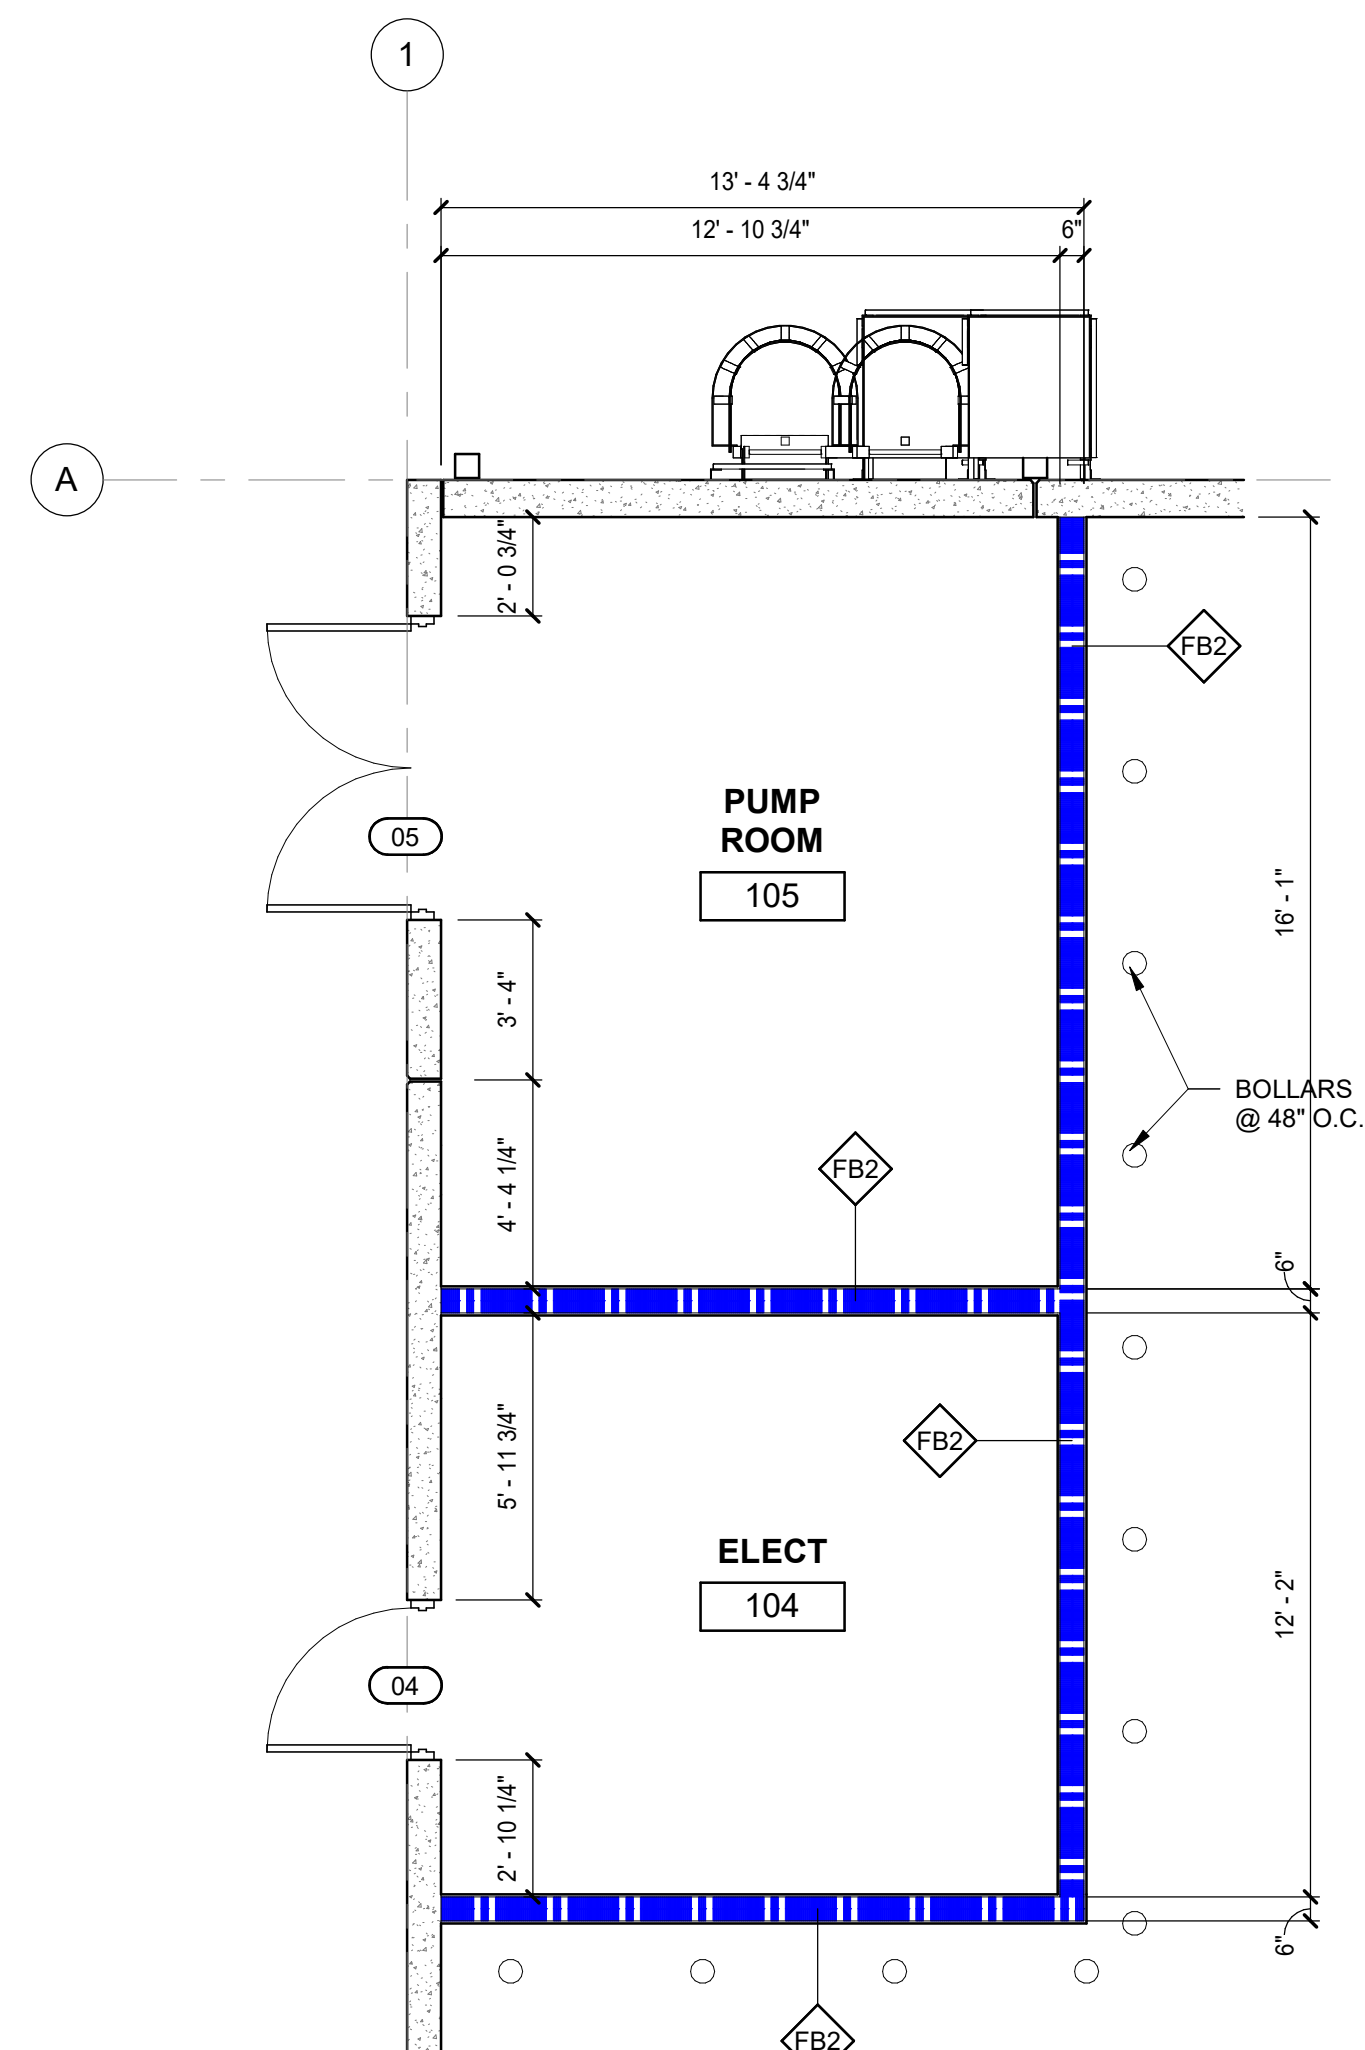

A5 PUMP ROOM & ELECTRICAL FLOOR PLAN
1/4" = 1'-0"

RCP NOTES

1. THIS DRAWING IS FOR LOCATION PURPOSES ONLY. REFER TO ENGINEER'S ELECTRICAL DRAWINGS AND SPECIFICATIONS FOR CIRCUITING AND DEVICE TYPES.
2. REFER TO ENGINEER'S ELECTRICAL DRAWINGS FOR EXT GITS AND EMERGENCY LIGHT LOCATIONS.
3. INSTALL CEILING GRID AS REQUIRED TO ACCOMMODATE LIGHTING LAYOUT AS SHOWN. MAIN "T" SPLINES ARE 48" O.C. RUNNING NORTH TO SOUTH WHERE POSSIBLE. DO NOT BREAK MAIN "T" TO ACCOMMODATE LIGHTING UNLESS OTHERWISE NOTED. NOTIFY ARCHITECT OF ANY DISCREPANCIES.
4. CEILING HEIGHT IS 9'-0" AFF UNLESS OTHERWISE NOTED.
5. TO ACCOMMODATE BATT INSULATION CONTINUOUS ABOVE TOILET ROOM CEILINGS.
6. REFER TO ELECTRICAL DRAWINGS FOR LIGHTING SPECIFICATIONS.
7. ALL LIGHTING FIXTURES ON THIS PLAN ARE SHOWN FOR LOCATION REFERENCE ONLY. PROVIDE COORDINATE WITH ELECTRICAL DRAWING FOR FIXTURE TYPE AND WIRING DATA.
8. FOLLOWING COMPLETION OF ACOUSTICAL CEILING INSTALLATION, ALL JOINTS SHALL BE STRAIGHT AND TRUE TO LINE, WITH EXPOSED SURFACES FLUSH AND LEVEL.
9. SPRINKLER HEADS SHALL BE CENTERED IN MONITOR OF THE TILE INDICATED. SPRINKLER HEAD SELECTIONS IN COLOR GYP BOARD PLANS SHALL BE WHITE FINISHED BY MANUFACTURER TO MATCH CEILING COLOR AS SCHEDULED.
10. IF CEILING DIFFUSER, LIGHT FIXTURES OR OTHER ELEMENTS ON OR ABOVE THE CEILING CAN NOT BE LOCATED AS SHOWN ON THE DRAWINGS, SUCH INTERFERENCE SHALL BE REPORTED IMMEDIATELY TO ARCHITECT FOR RELOCATION.
11. PROVIDE EMERGENCY BATTERY PACKS OR EMERGENCY CIRCUITS AS REQUIRED BY CODE. SEE ELECTRICAL DRAWINGS FOR CIRCUITRY AND EMERGENCY LIGHT FIXTURES.
12. PROVIDE FINAL QUANTITY AND LOCATION OF EMERGENCY DEVICES, (INCLUDING BUT NOT LIMITED TO: BATTERY PACKS, EXIT SIGNS, FIRE ALARMS, ETC.) IN COMPLIANCE WITH MUNICIPAL AGENCY HAVING JURISDICTION.
13. MATERIALS PLACED IN CEILING SHALL BE REQUIRED TO HAVE A PLENUM RATING.
14. STENCIL RATED WALLS ABOVE CEILING.
15. PROVIDE CONTROL JOINTS ON GYP BD. ASSEMBLIES PER SPECIFICATION'S CONSTRAINTS. LOCATE AS SHOWN ON RCP (AS APPLICABLE).




SUBMITTALS:	
DATE	DESCRIPTION
2025-05-23	90% REVIEW
2025-07-25	FOR CONSTRUCTION


REVISIONS:	
NO DATE	DESCRIPTION

SHEET TITLE:
ENLARGED PLANS


DATE: DATE	
DRAWN: LWM	CHECKED: MTM
JOB NUMBER: 25-009	
SHEET:	

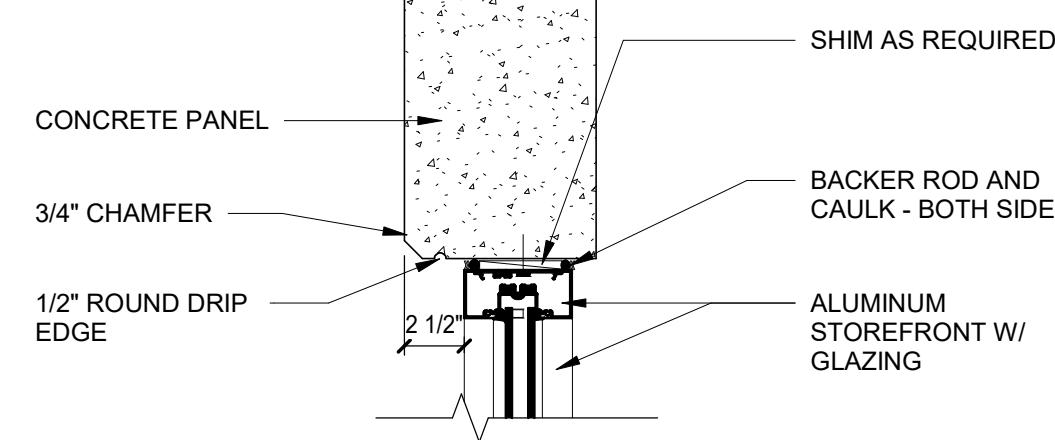


(D3) TILT PANEL_STOREFRONT HEAD DETAIL
1 1/2" = 1'-0"

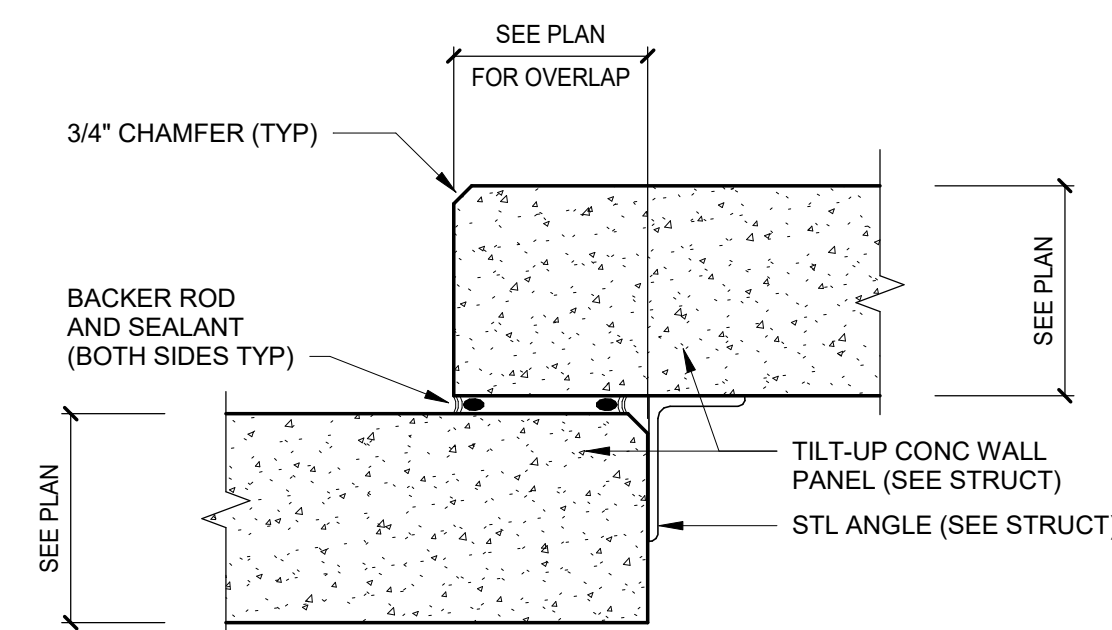


D5 PANEL OVERLAP DETAIL
1 1/2" = 1'-0"

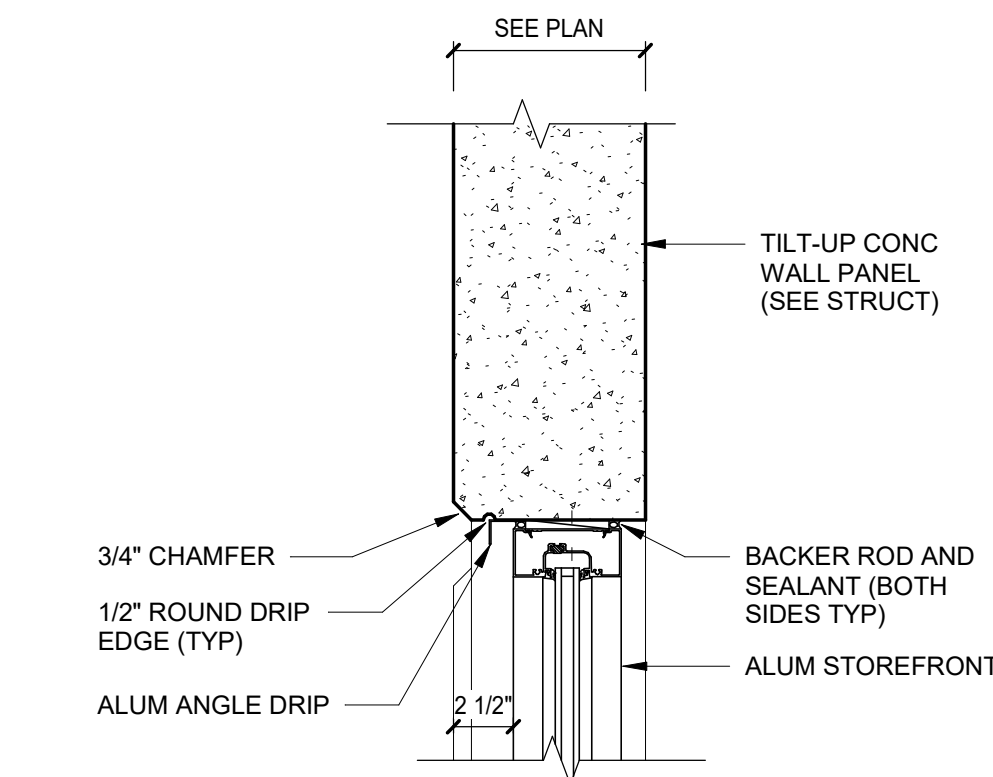


C2 WINDOW HEAD DETAIL
1 1/2" = 1'-0"

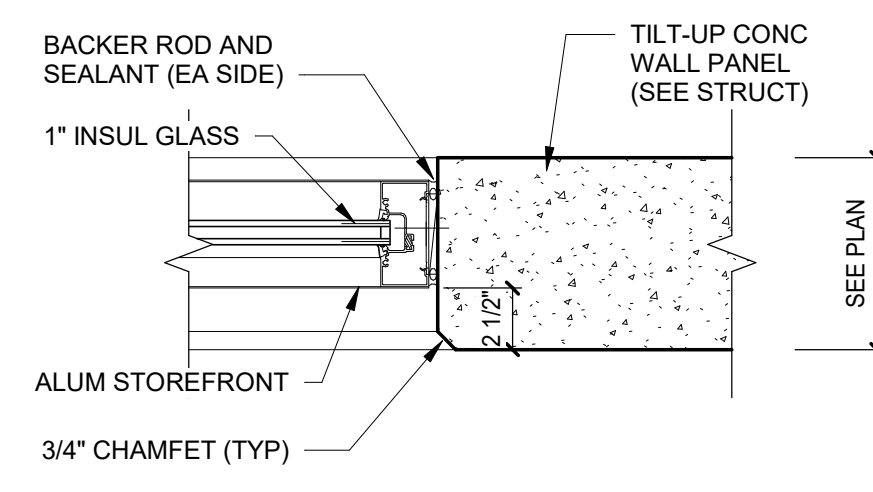


C3 STOREFRONT JAMB DETAIL
1 1/2" = 1'-0"

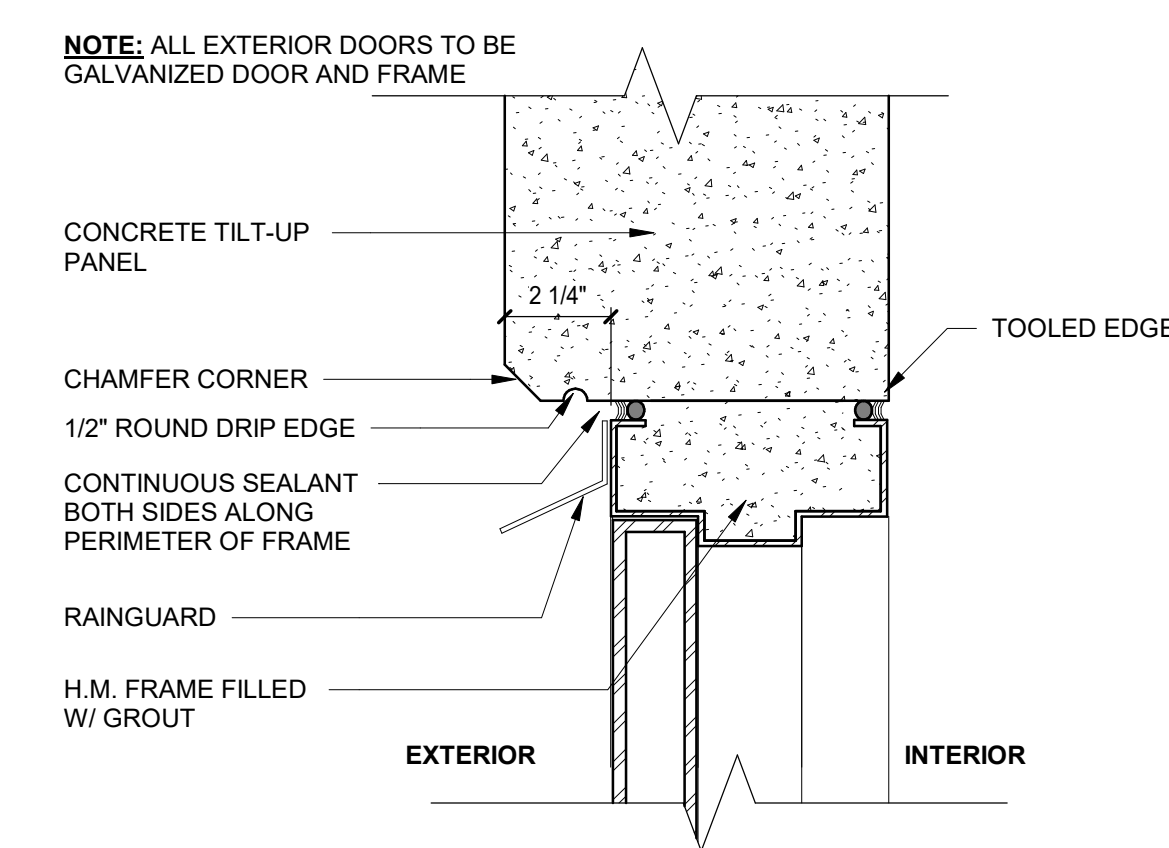


C4 H.M. DOOR HEAD
3" = 1'-0"

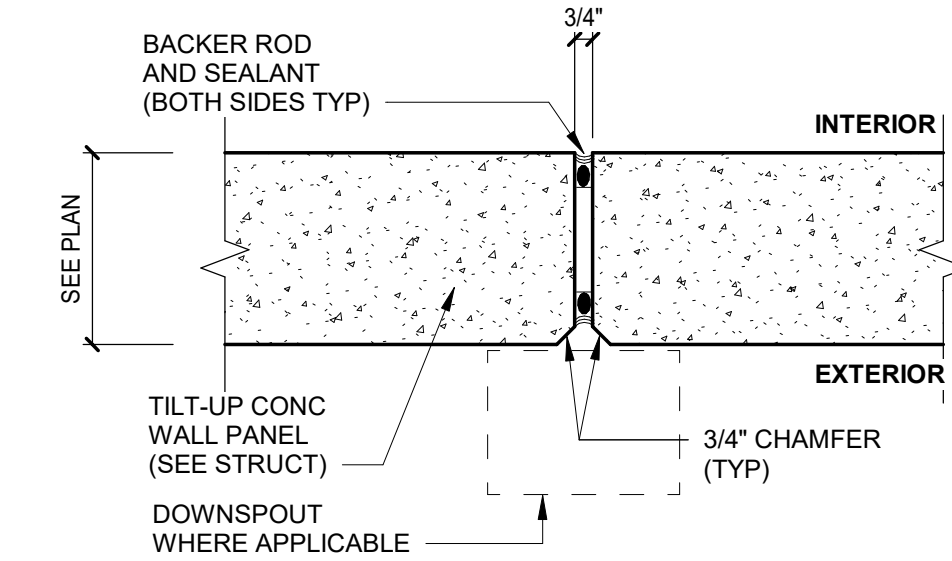


C5 TYPICAL PANEL JOINT DETAIL
1 1/2" = 1'-0"

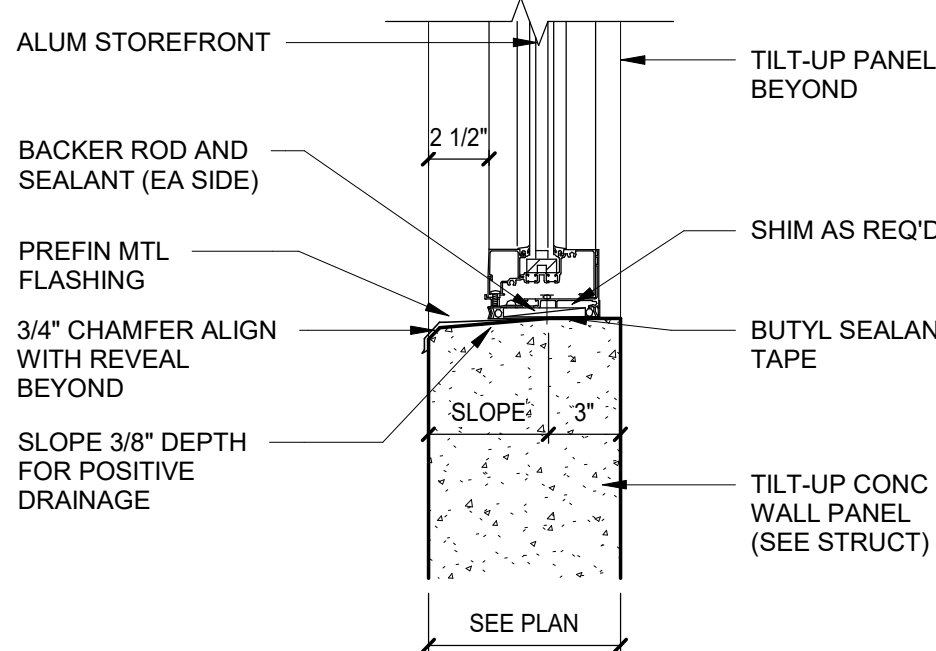


B2 TILT PANEL WINDOW SILL DETAIL
1 1/2" = 1'-0"

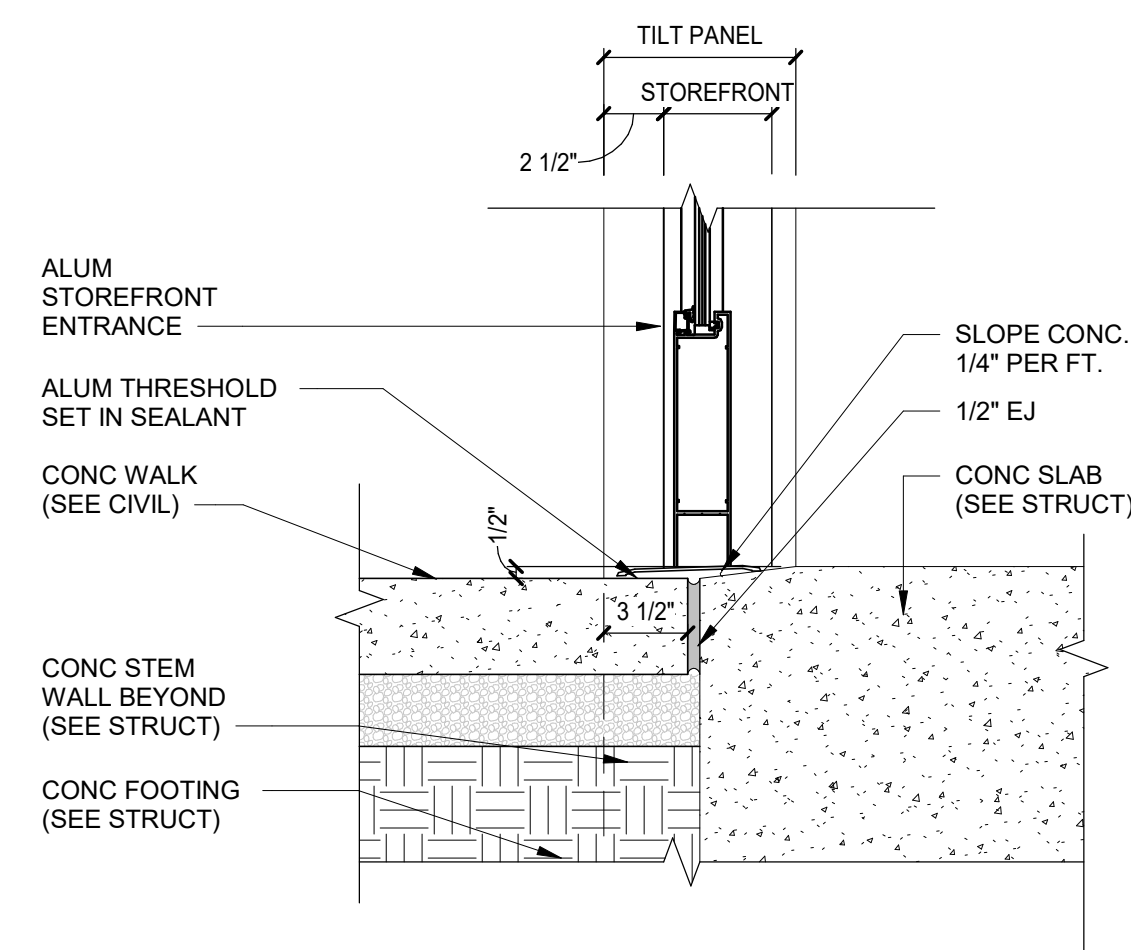


B3 STOREFRONT
ENTRANCE DETAIL
1 1/2" = 1'-0"

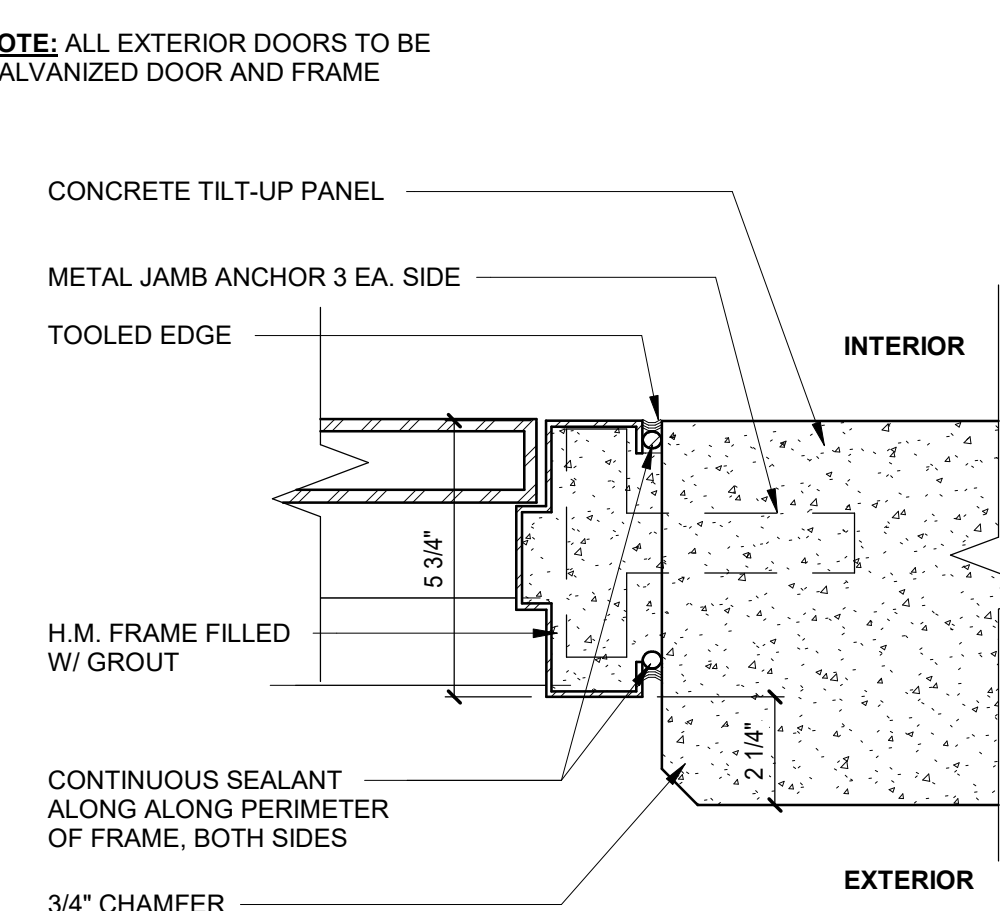


B4 H.M. DOOR JAMB DETAIL
3" = 1'-0"

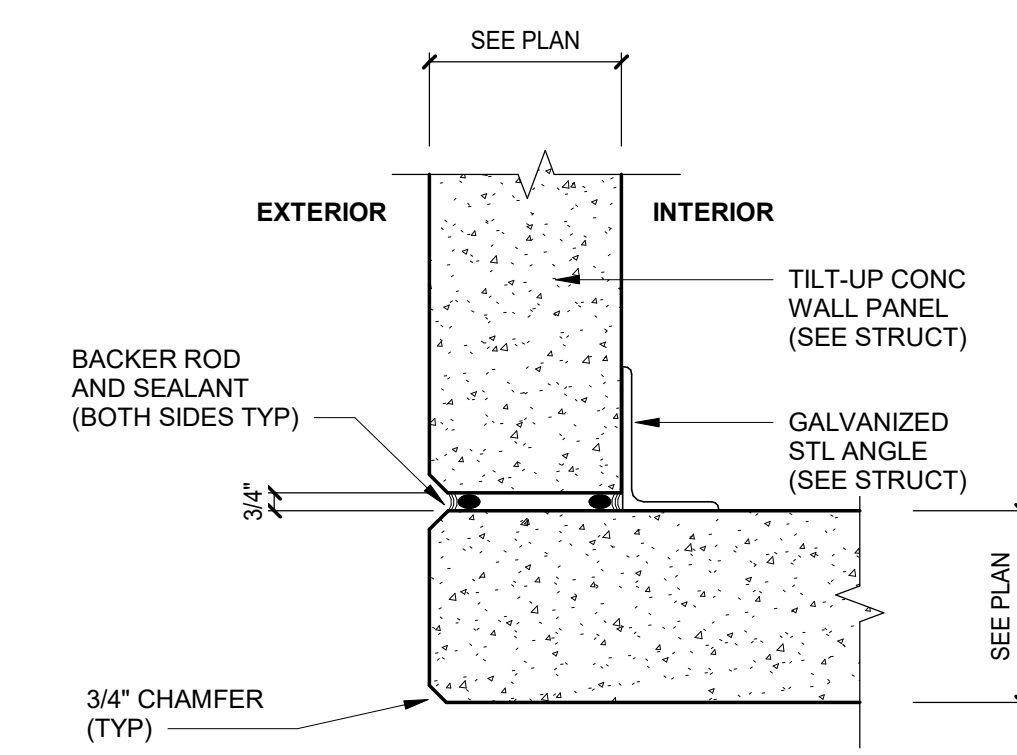


B5 TYPICAL CORNER PANEL JOINT DETAIL
1 1/2" = 1'-0"

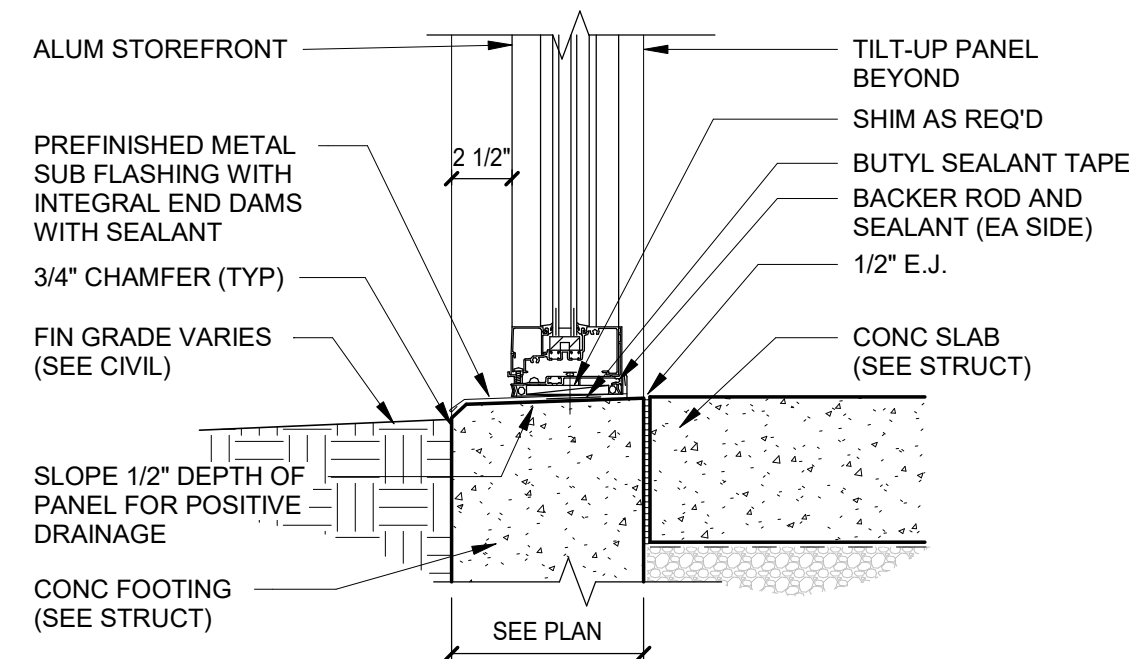


A2 STOREFRONT SILL DETAIL FLOOR
1 1/2" = 1'-0"

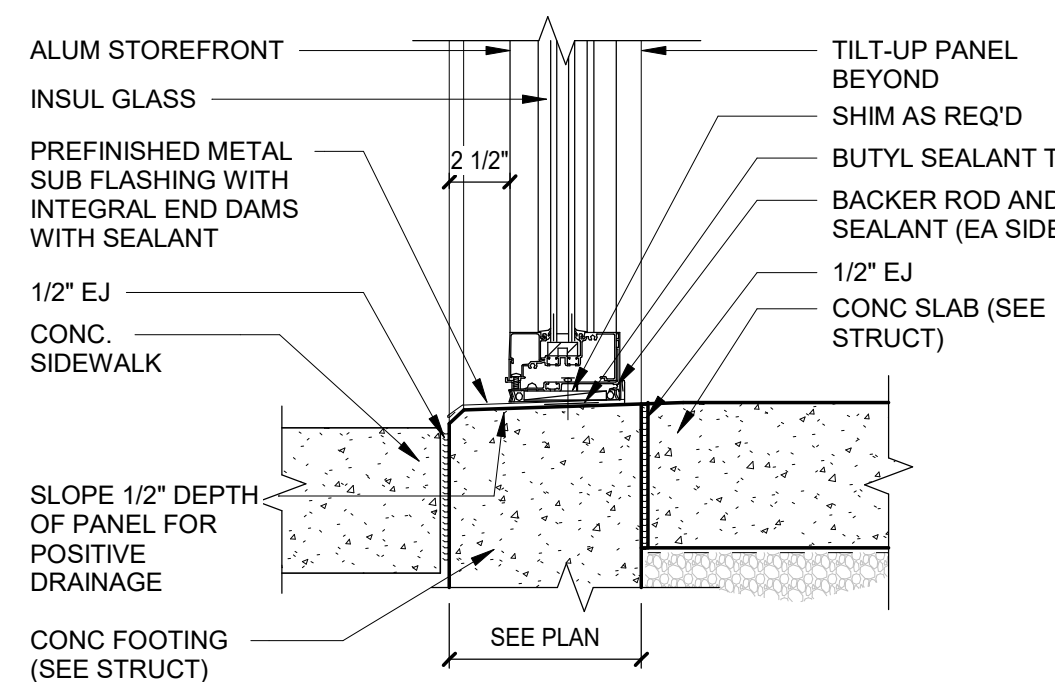

A3 STOREFRONT SILL DETAIL FLOOR
1 1/2" = 1'-0"

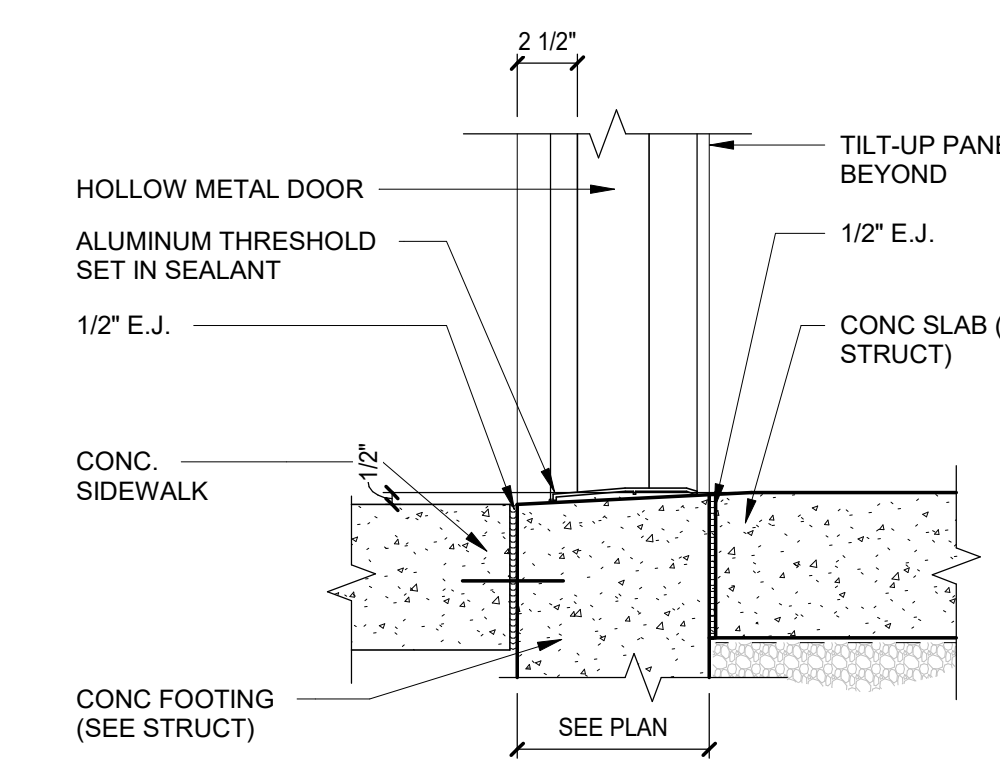

A4 TILT PANEL_HM DOOR THRESHOLD
1 1/2" = 1'-0"

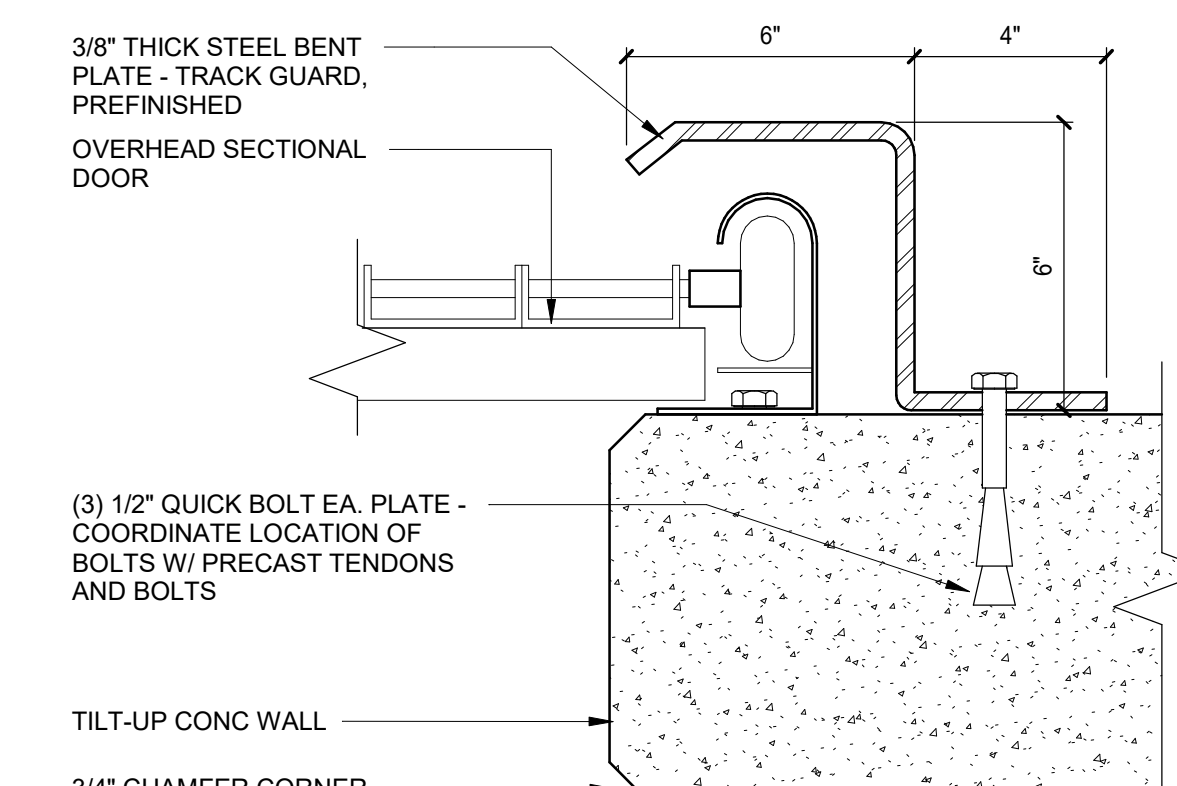

A5 DOCK / DRIVE-THRU DOOR Z - GUARD
3" = 1'-0"



Att 95 Industrial Center
SPEC BUILDING 1
2983 Arrowhead Road
Dunn, North Carolina 28334

DATE: DATE	
DRAWN: LWM	CHECKED: MTM
JOB NUMBER: 25-009	
SHEET:	

A500

8/13/2025 9:03:25 AM

D

C

B

A


1

2

3


4

5

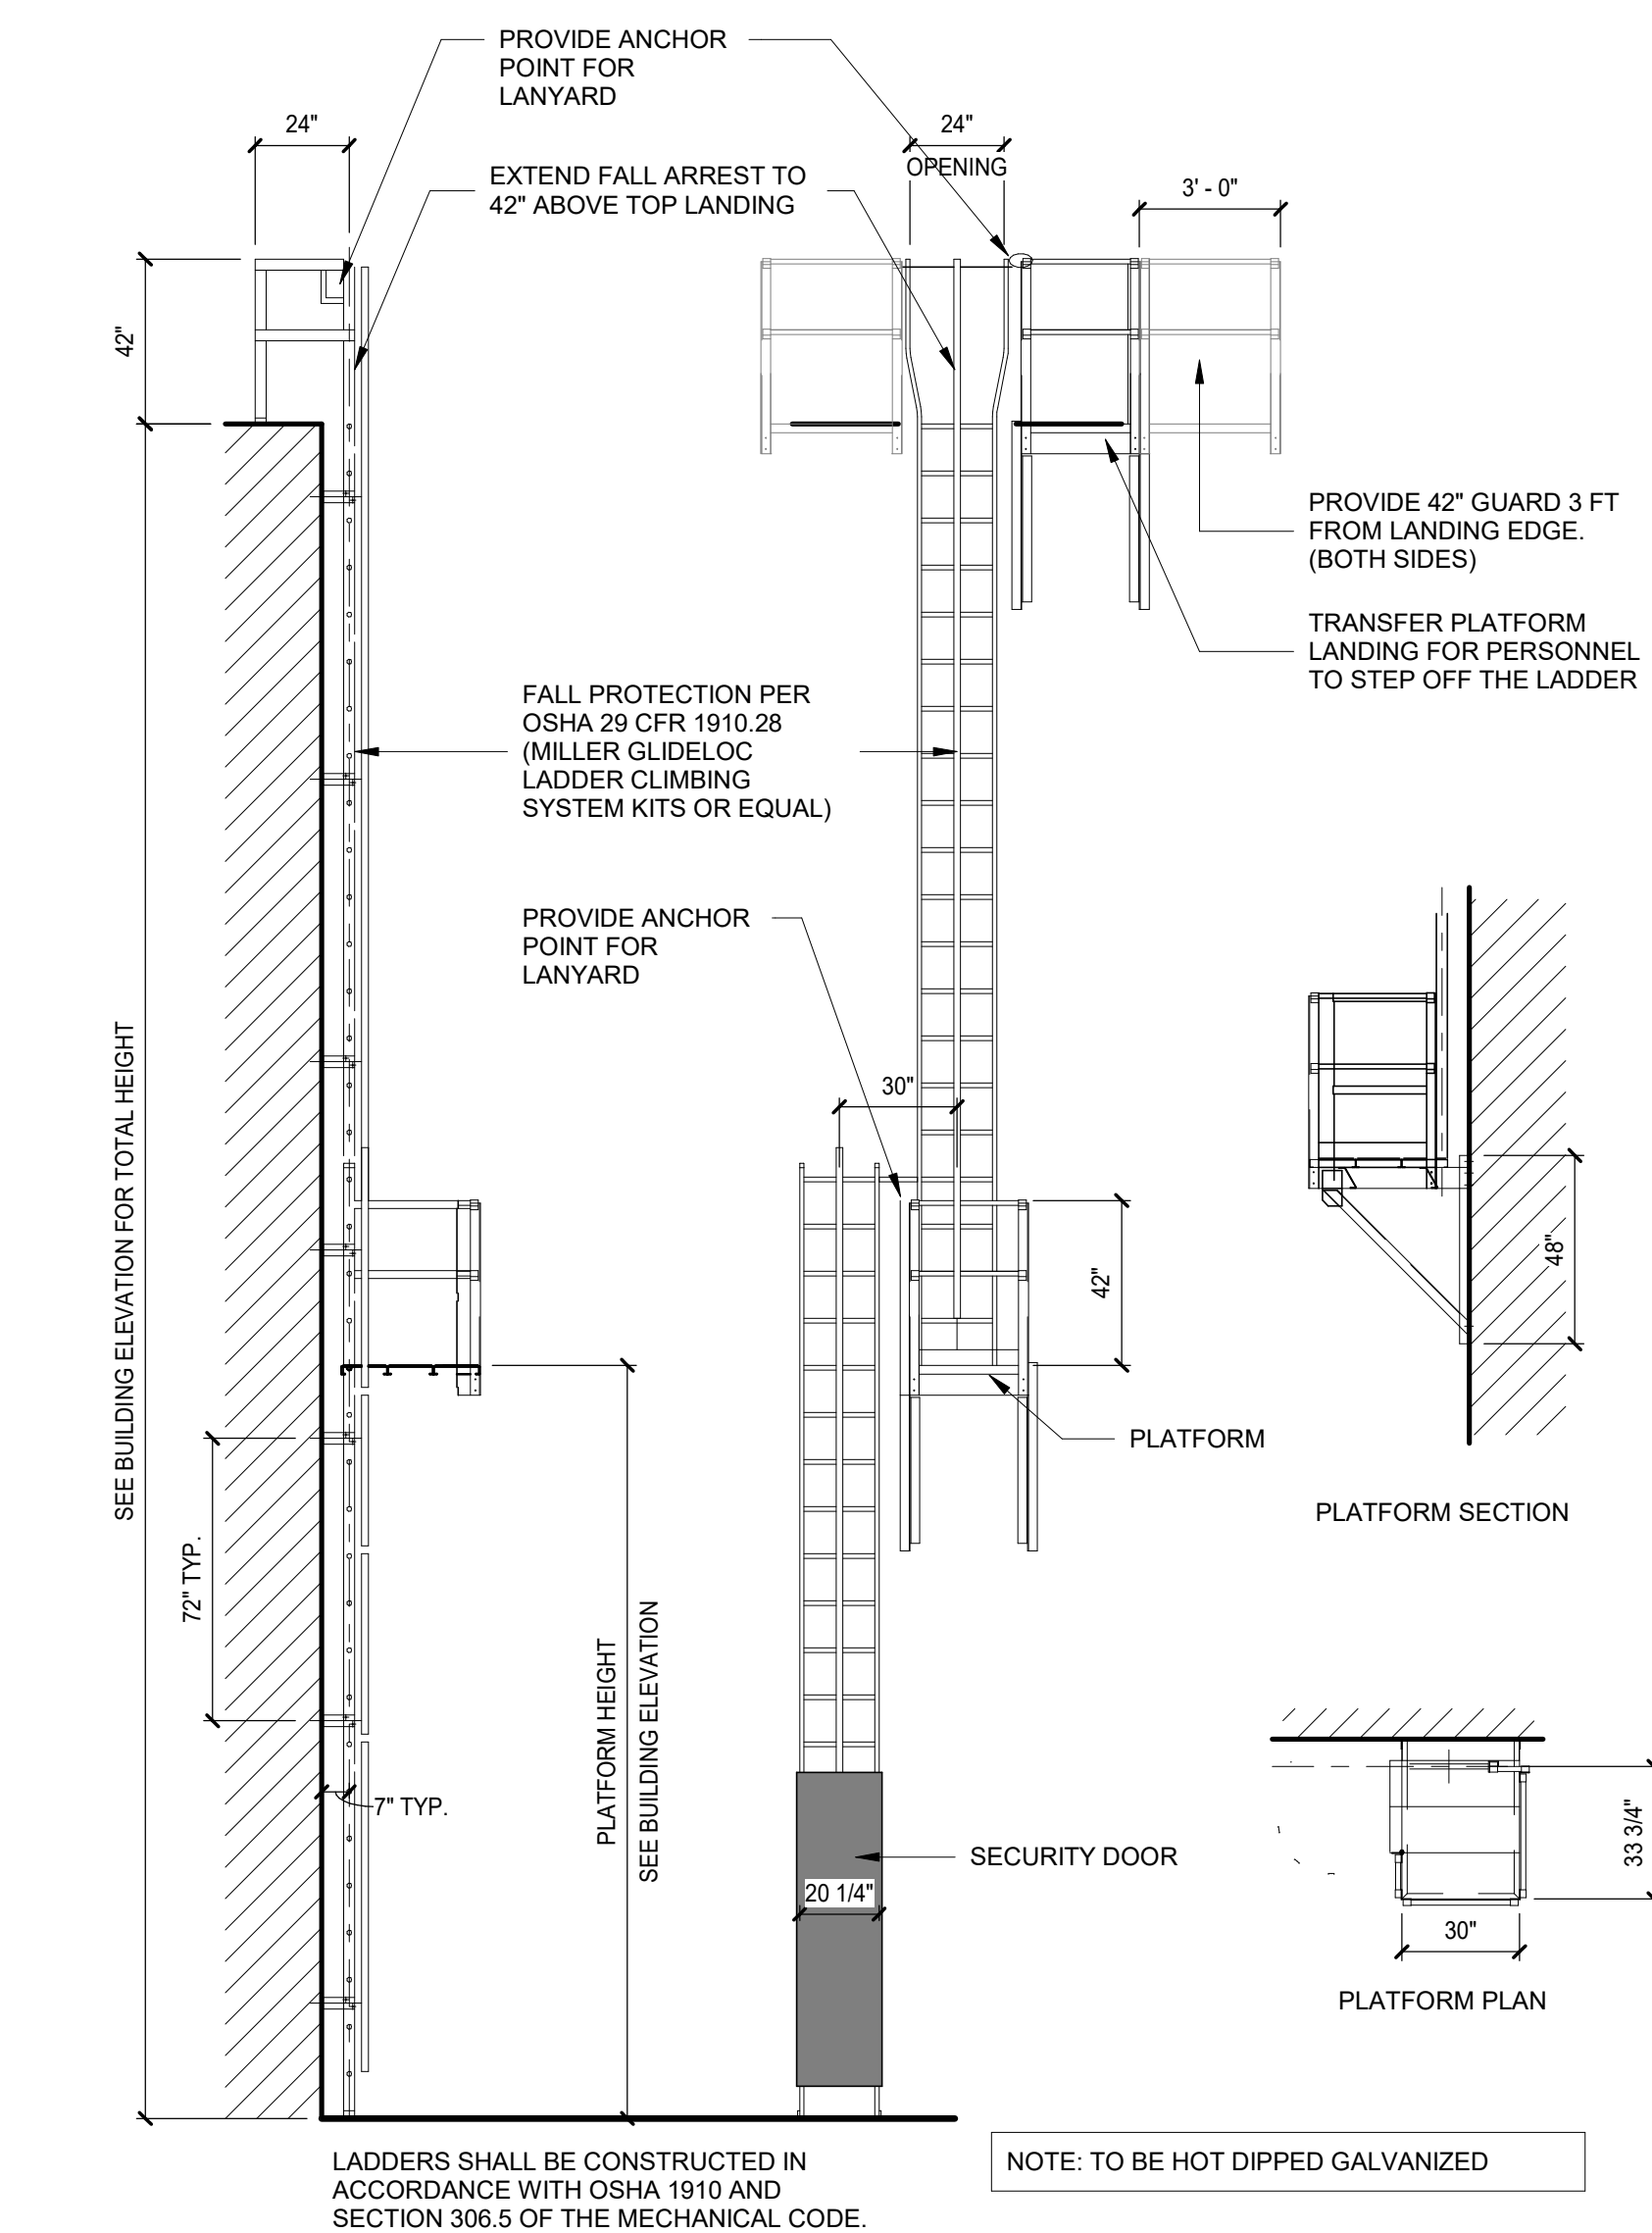


A2 LADDER DETAIL (ABOVE 30FT)

1/4" = 1'-0"

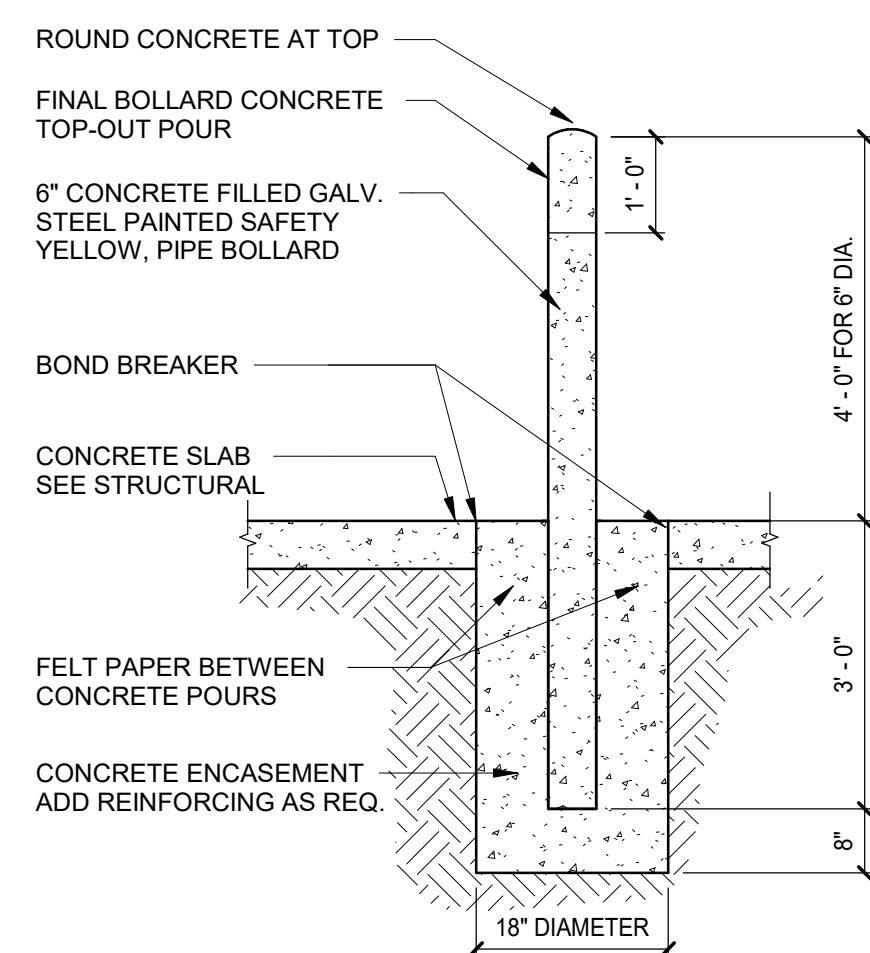


B4 6" BOLLARD DETAIL

1/2" = 1'-0"

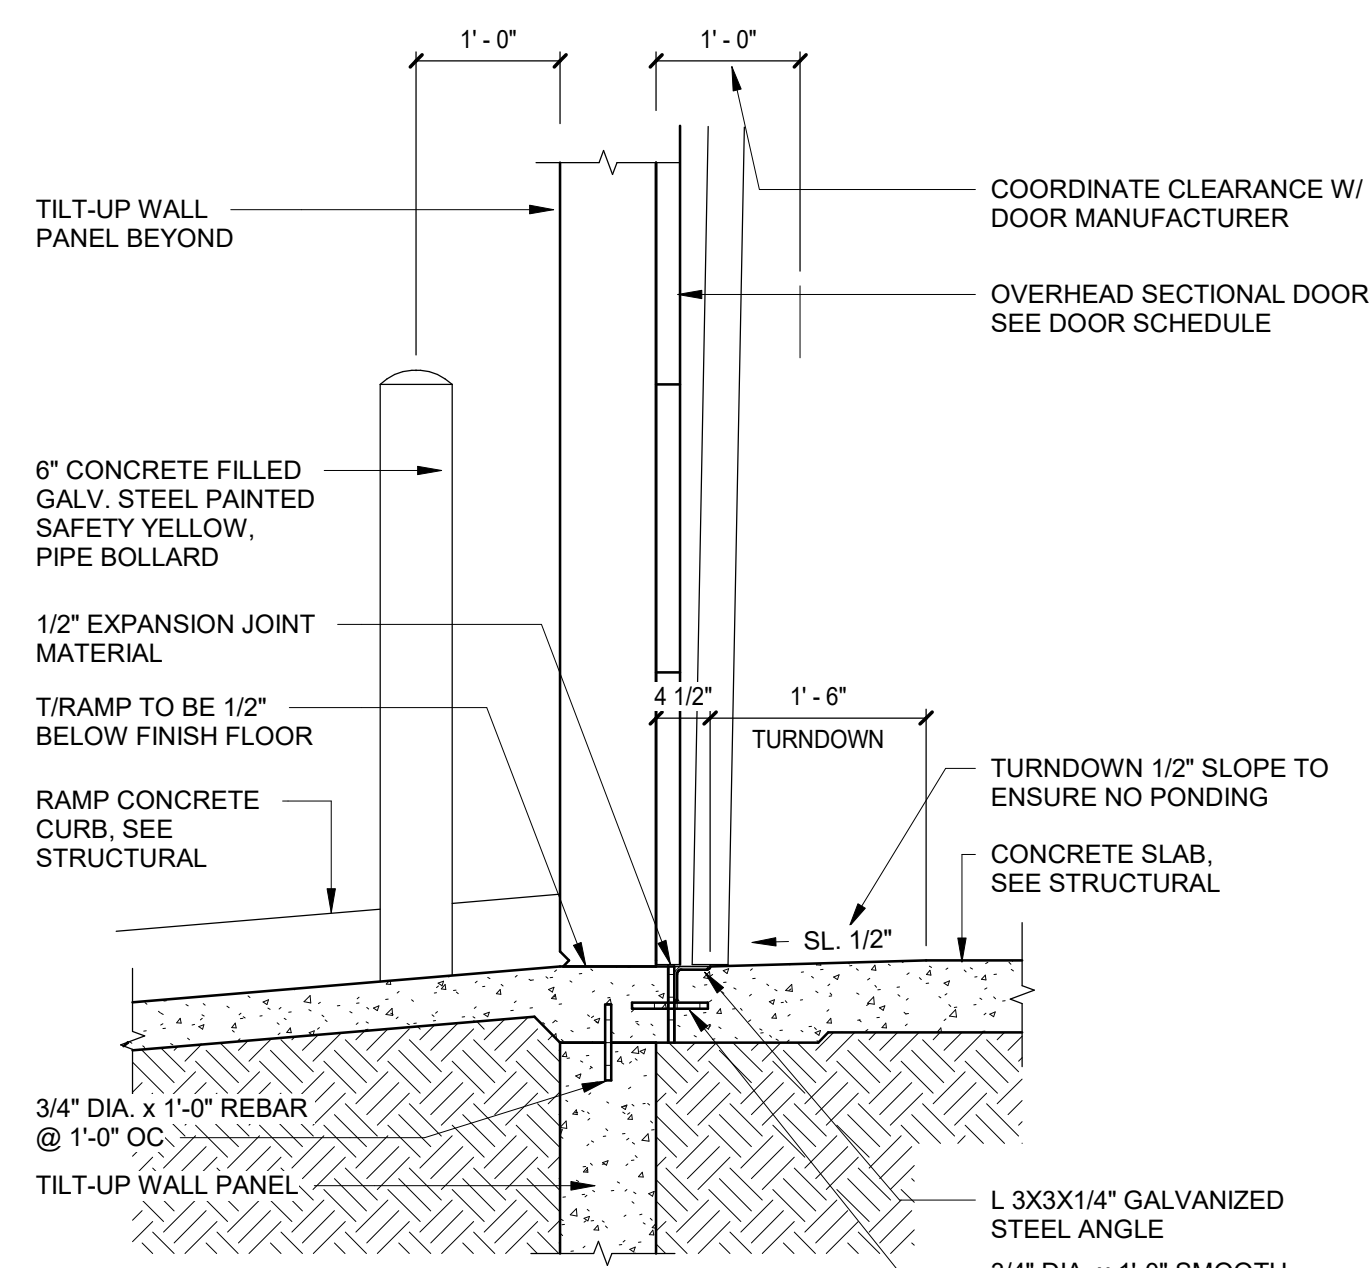


A4 SECTION - DRIVE-IN DOOR W/ SLOPED SLAB

3/4" = 1'-0"

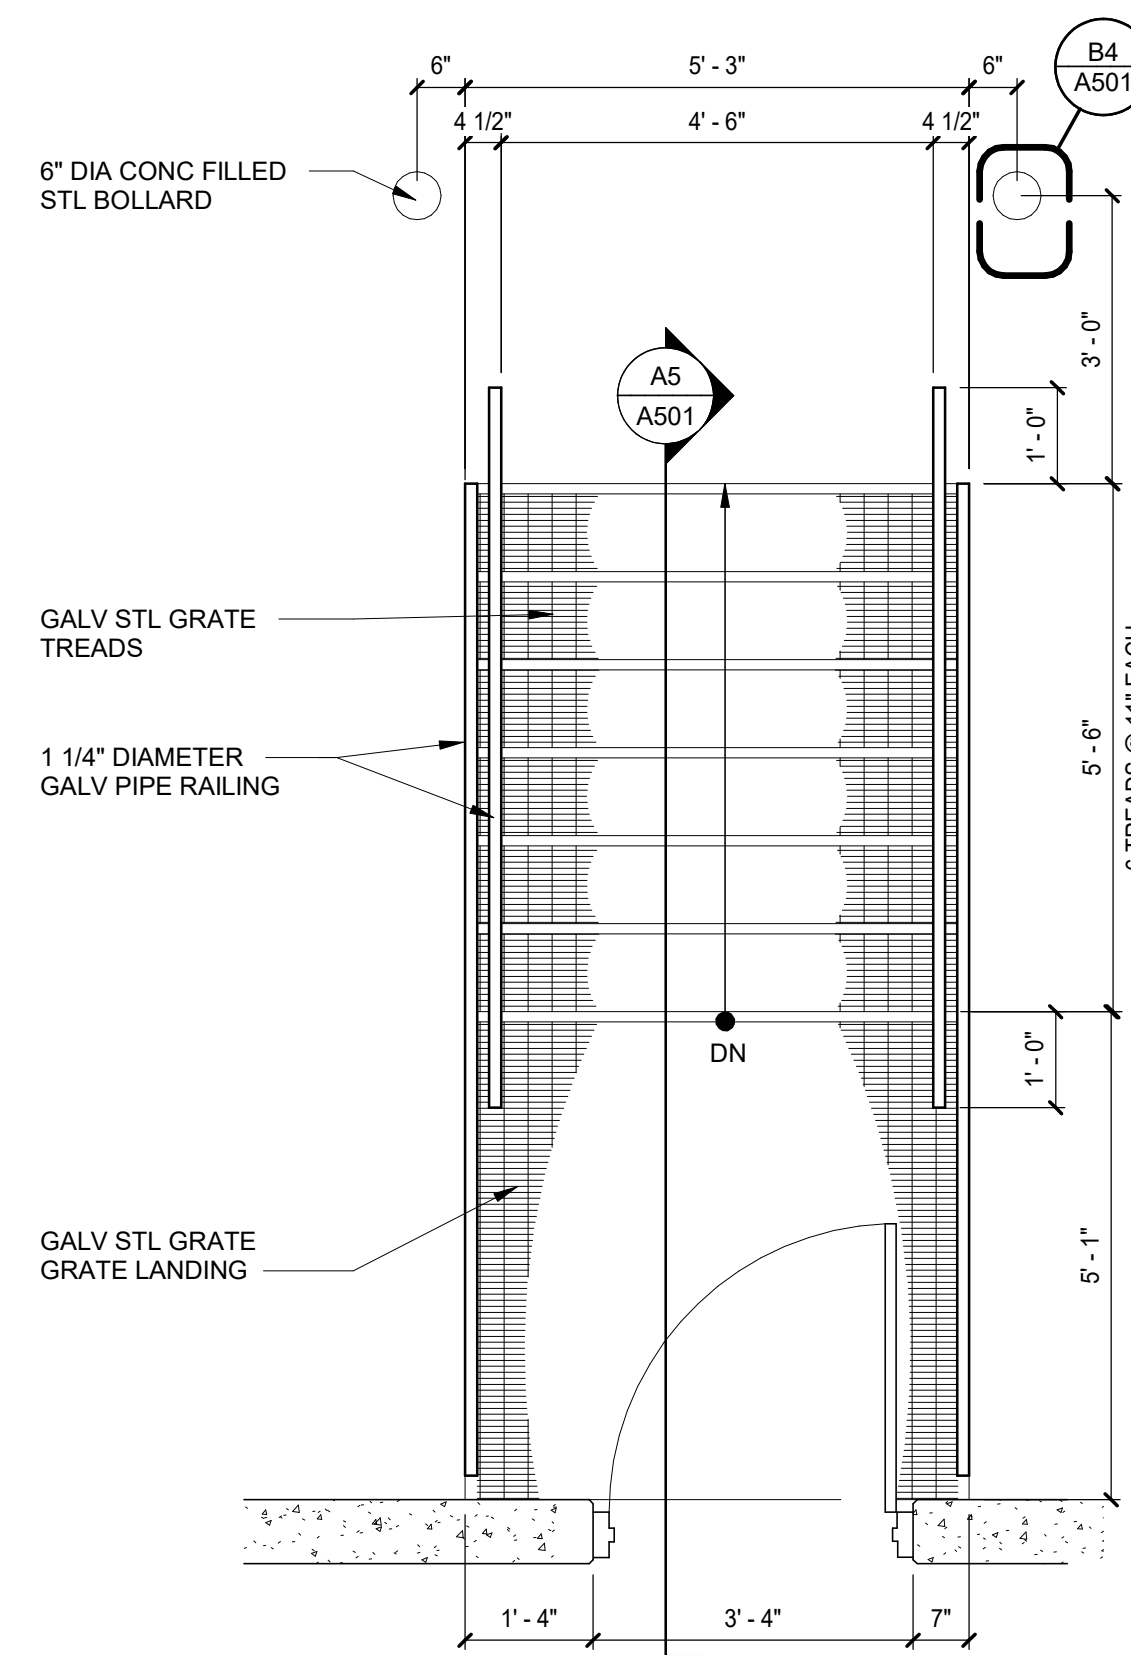


D5 STAIR PLAN

1/2" = 1'-0"

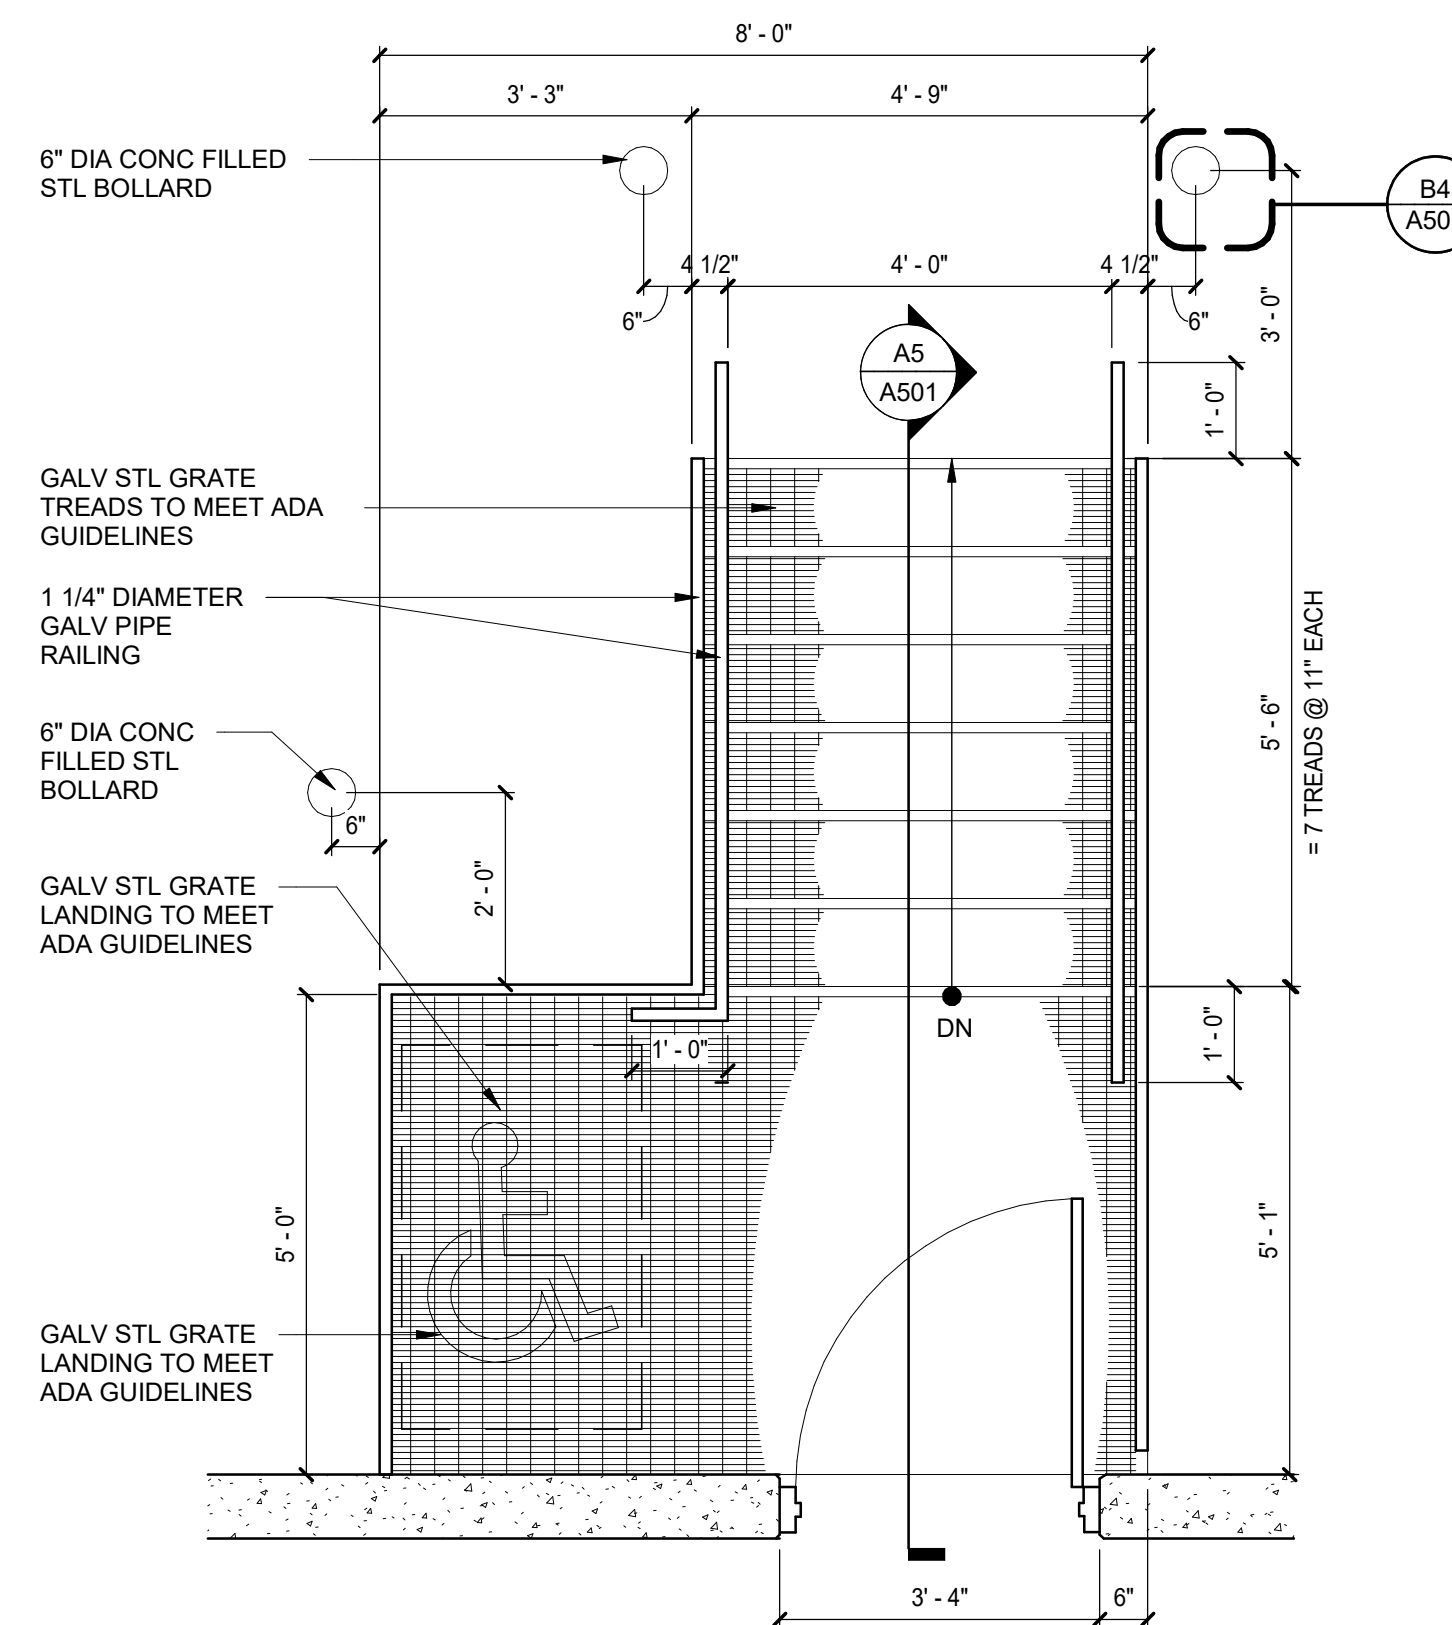

B5 ADA STAIR PLAN

1/2" = 1'-0"

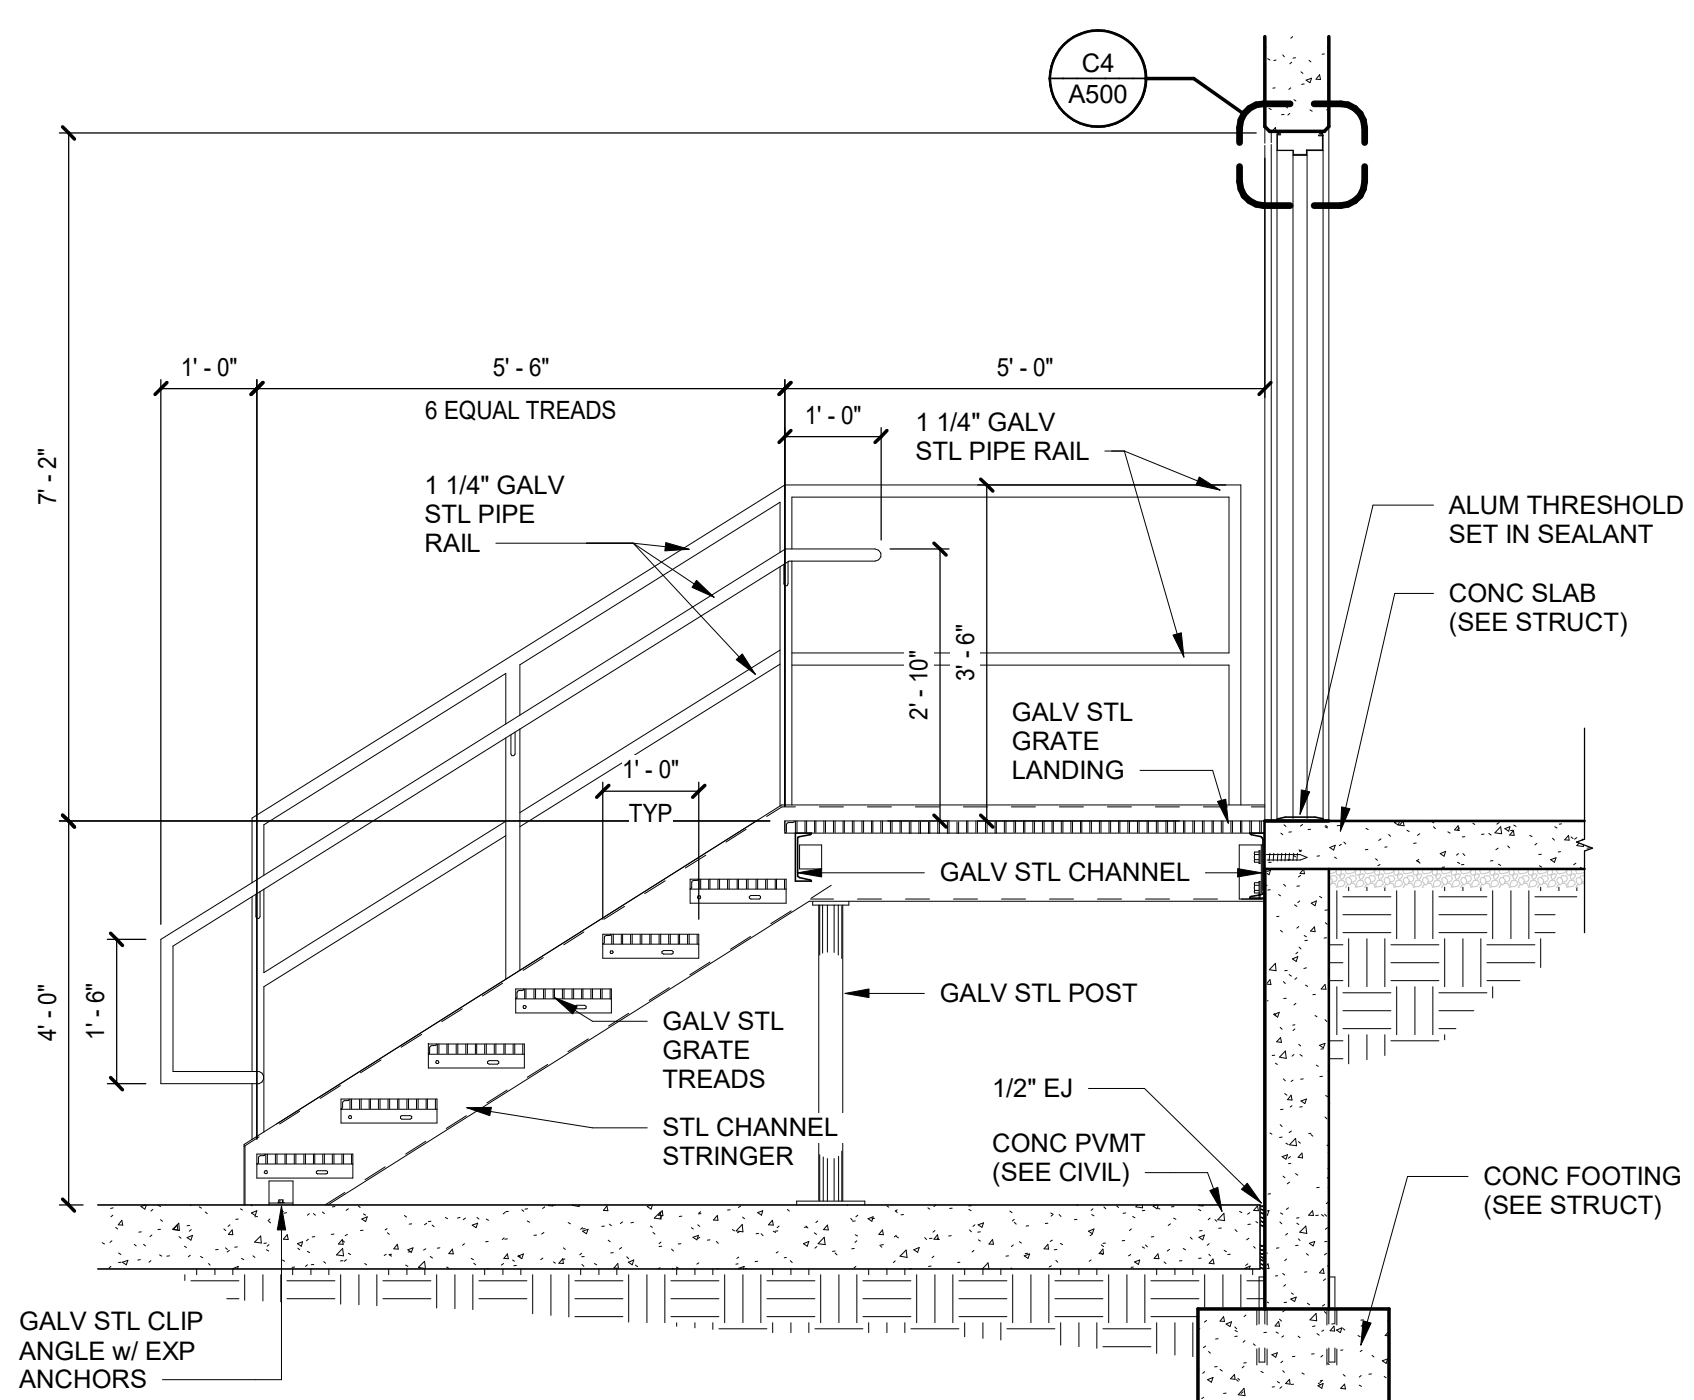

A5 STAIR SECTION

1/2" = 1'-0"




triad design group
Architecture | Engineering | Interior Design

4807 Koger Boulevard Suite C
Greensboro, NC 27407
Telephone 336-218-8282

8430 University Executive
Park Drive Suite 650
Charlotte, NC 28262
Telephone 704-312-0140
www.triad-designgroup.com

NC Architecture Reg. 50709
NC Engineering Lic. C-1108

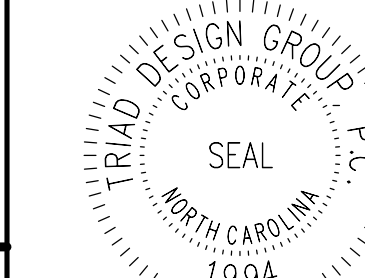

August 13, 2025

This drawing, and the details herein, as an instrument of service, is the property of Triad Design Group, P.C. It may be used only for this specific project, and shall not be loaned, copied, or reproduced in any form without express written consent from Triad Design Group, P.C. Copyright 2025, Triad Design Group, P.C. All rights reserved.

Triad Design Group, P.C. shall not be responsible for construction means, methods, techniques, or procedures utilized by the contractor, nor for the safety of public or contractor's employees, nor for the failure of the contractor to carry out the work in accordance with the contract documents.



Harnett 95 Industrial Center

SPEC BUILDING 1

2983 Arrowhead Road
Dunn, North Carolina 28334

SUBMITTALS:

DATE	DESCRIPTION
2025-05-23	90% REVIEW
2025-07-25	FOR CONSTRUCTION

REVISIONS:


NO	DATE	DESCRIPTION
----	------	-------------

SHEET TITLE:


TILT PANEL
DETAILS

DATE: DATE
DRAWN: LWM | CHECKED: MTM
JOB NUMBER: 25-009
SHEET:


A501

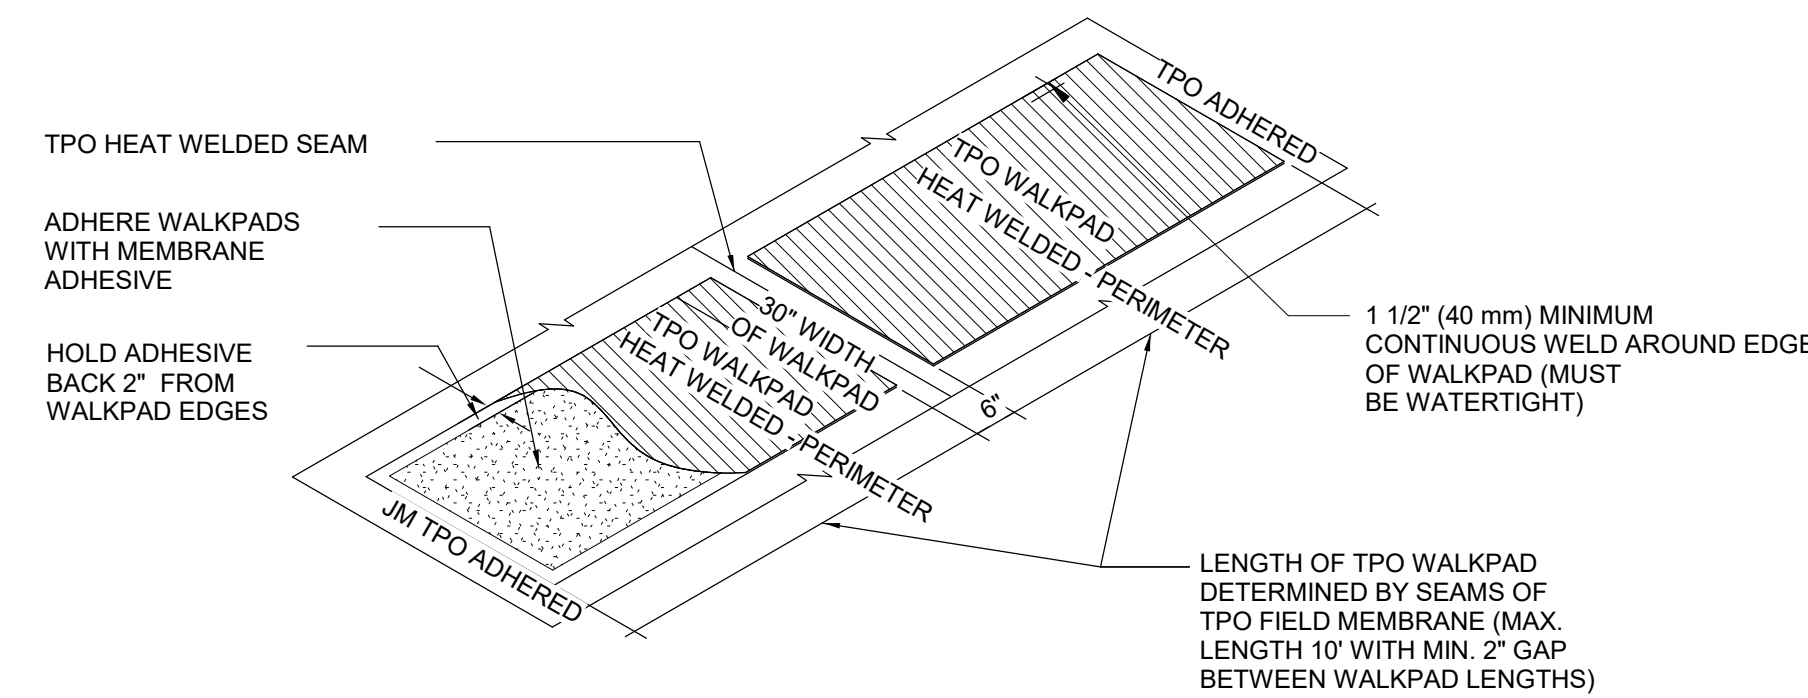


D5 TPO WALK PAD
12" = 1'-0"

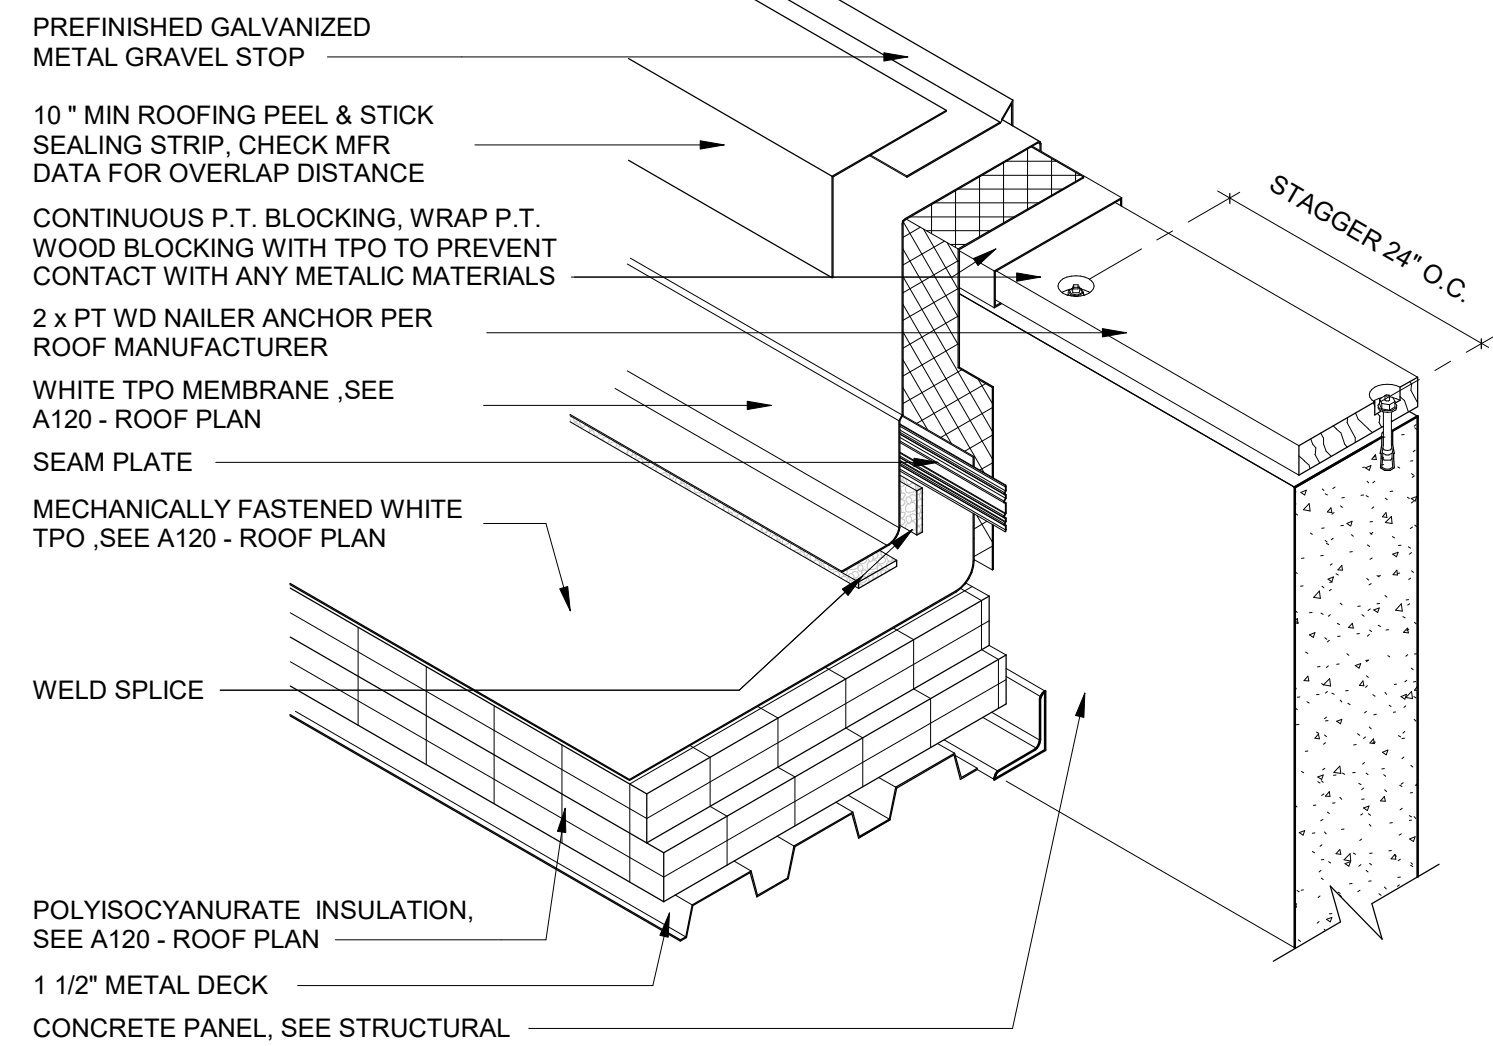


C2 GRAVEL STOP ISO
1 1/2" = 1'-0"

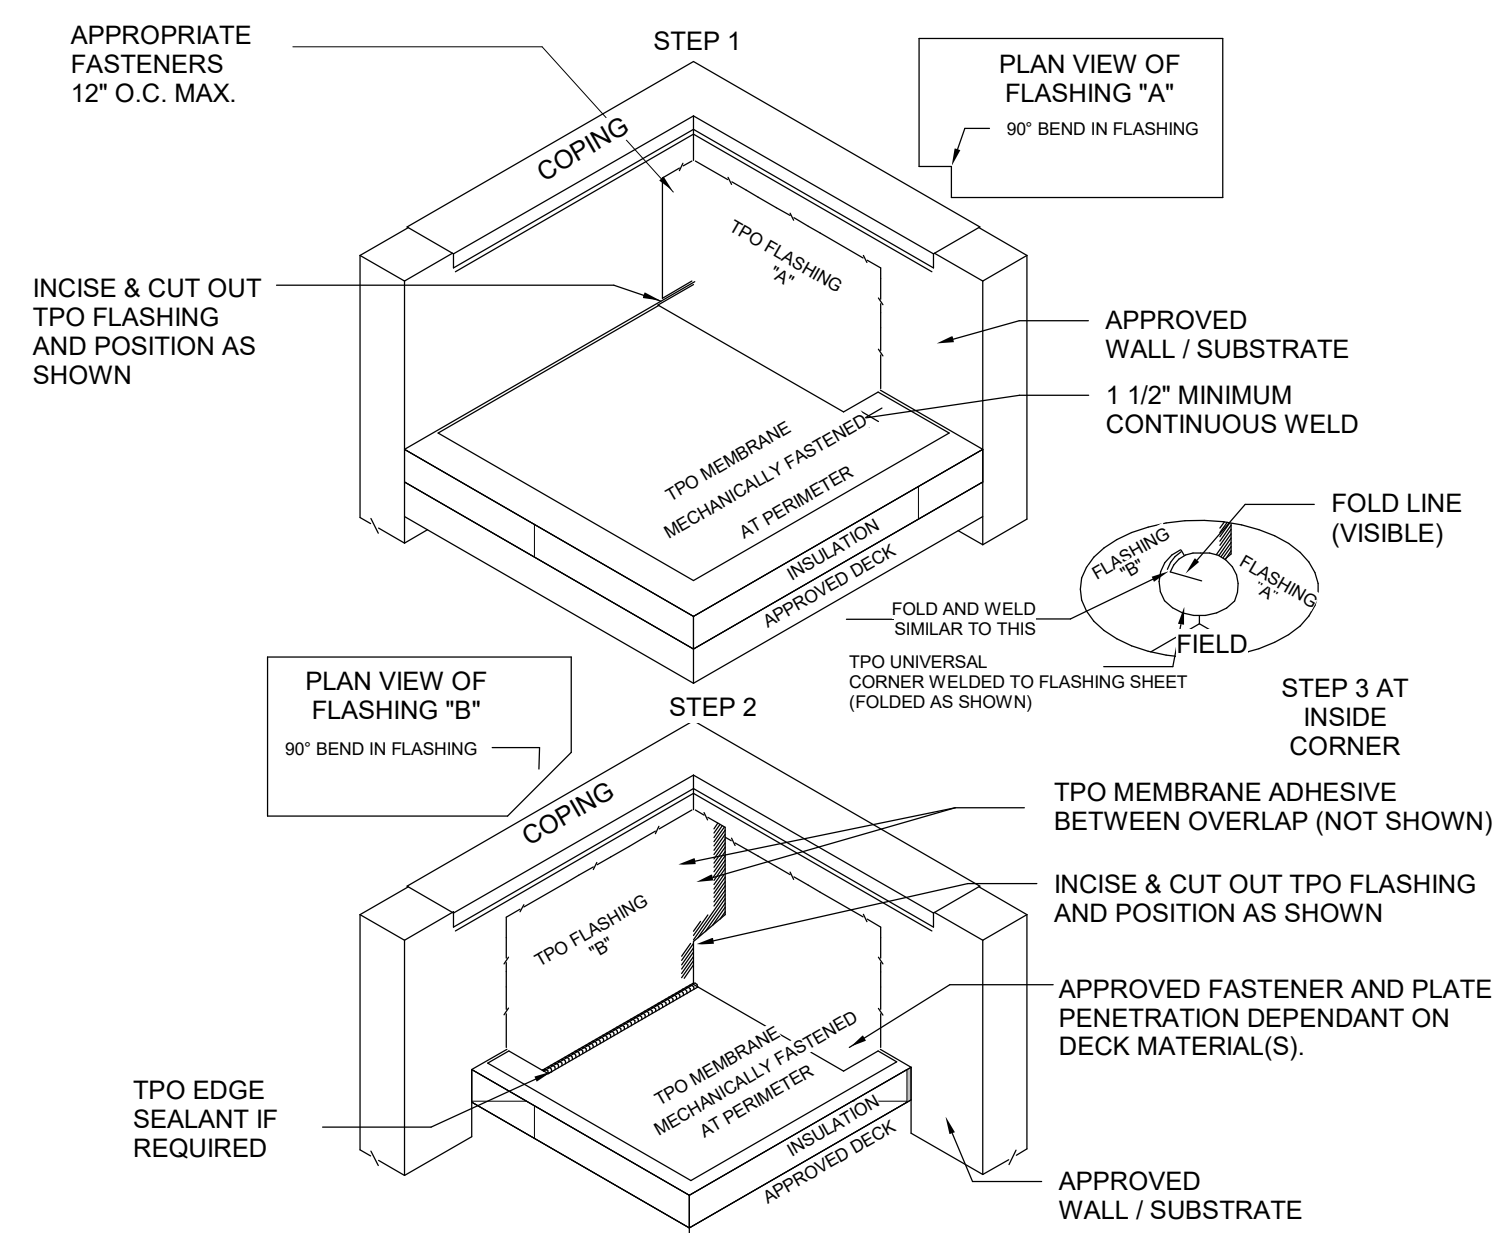


B2 TPO INSIDE CORNER
12" = 1'-0"

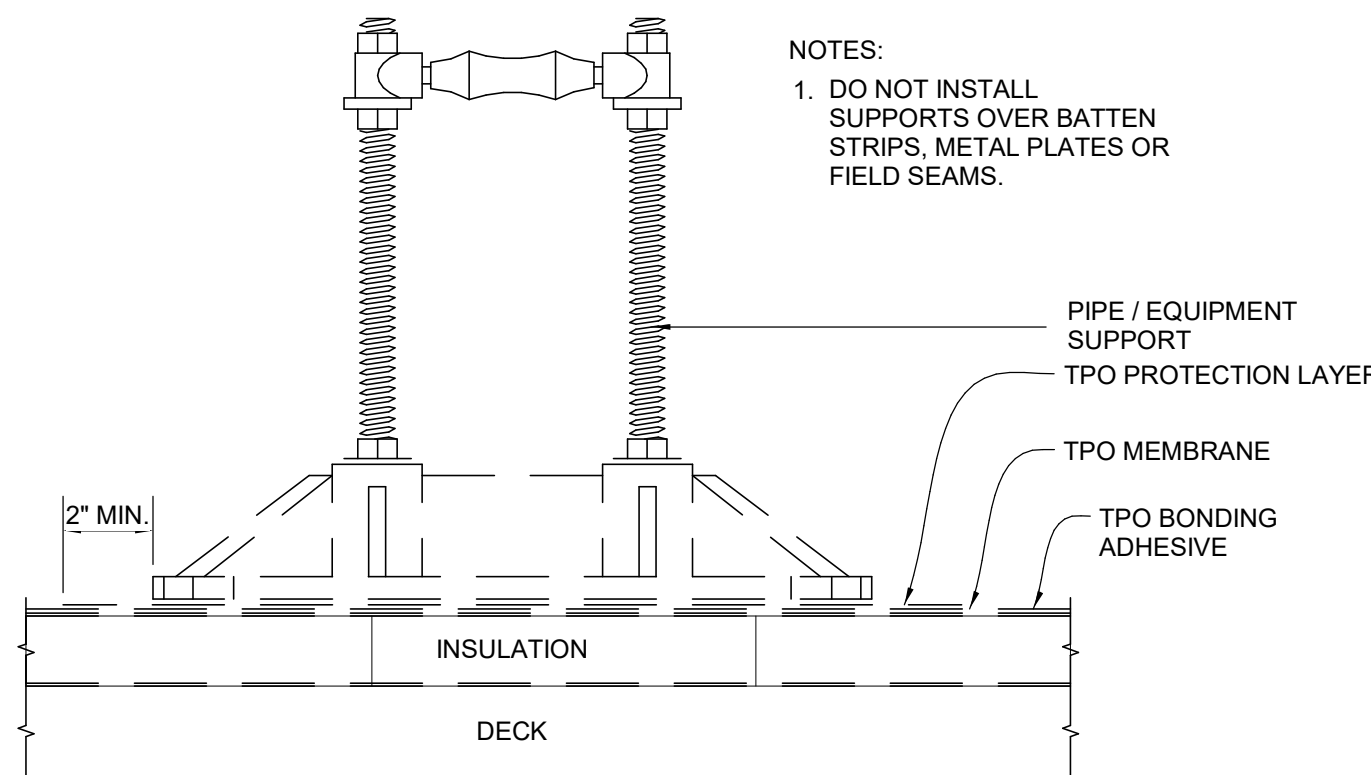


C3 TPO PIPE SUPPORT DETAIL
12" = 1'-0"

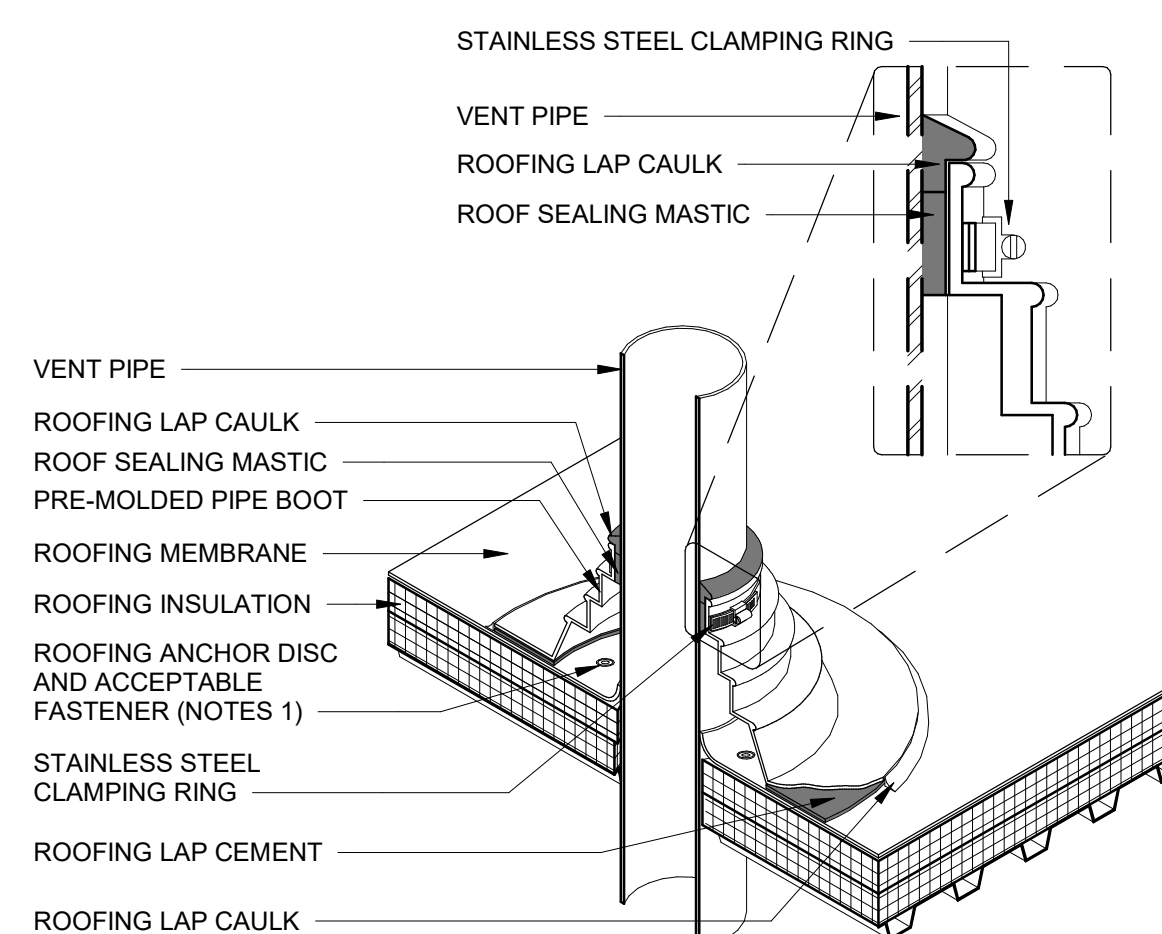


B3 PIPE VENT
1" = 1'-0"

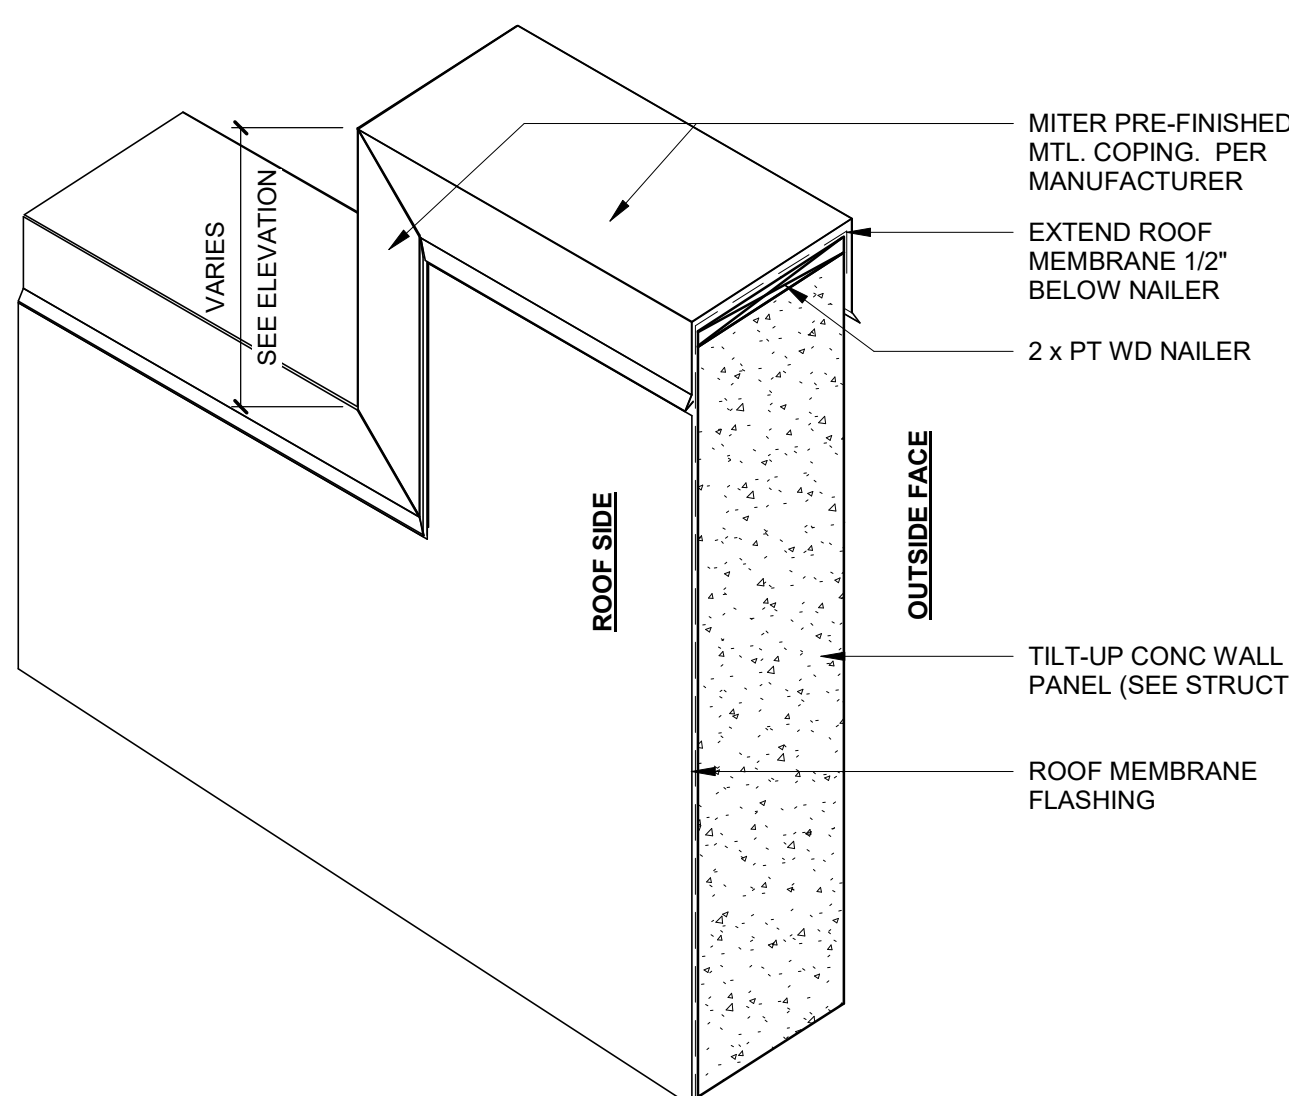


A3 COPING MITER STEP DETAIL
1 1/2" = 1'-0"

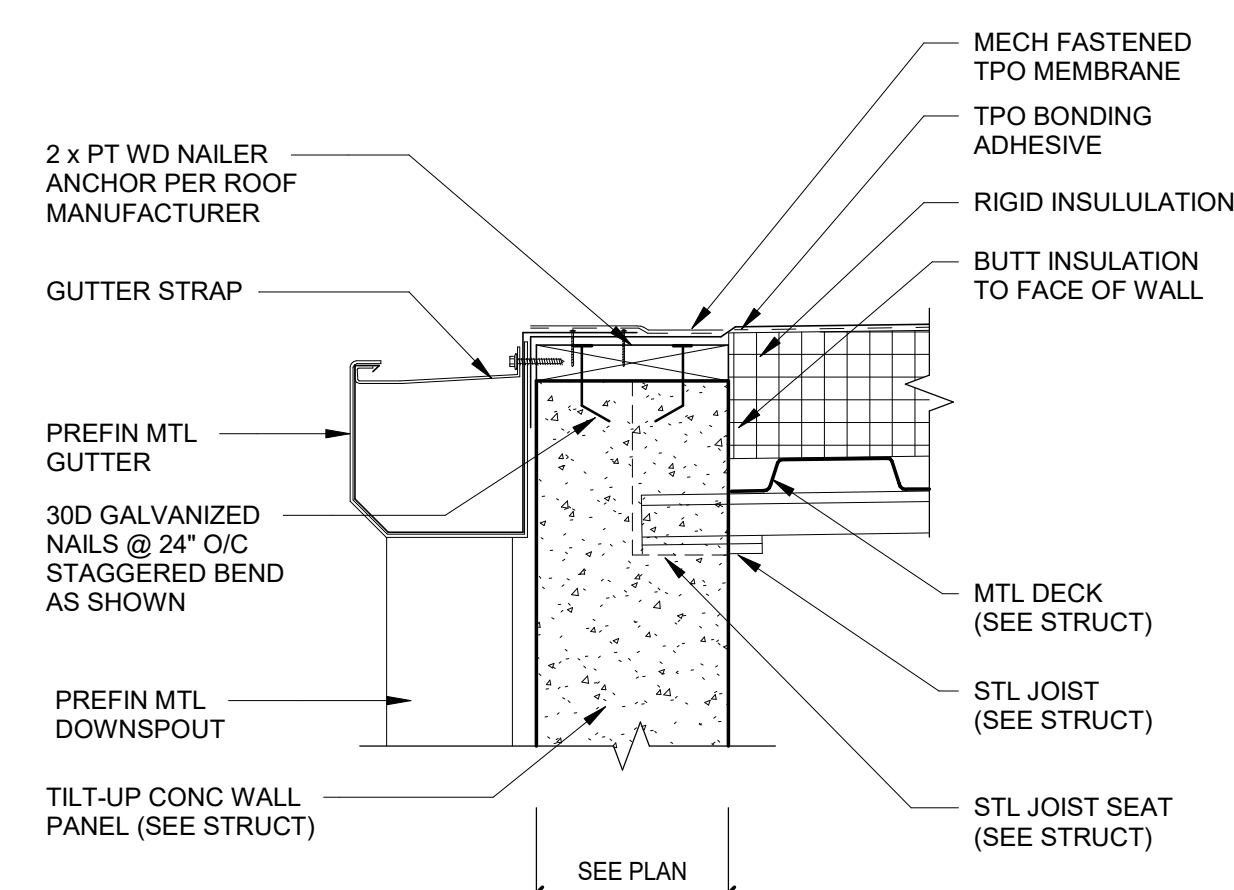


C5 **GUTTER DETAIL**
1 1/2" = 1'-0"

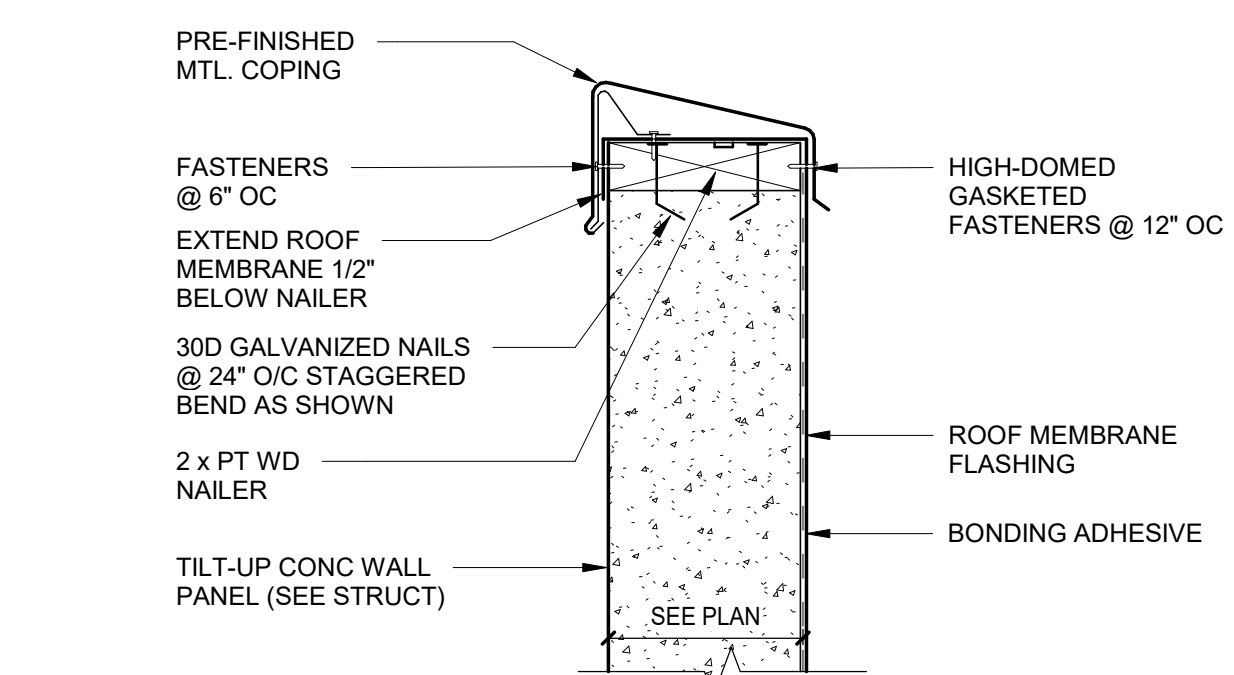


B5 COPING DETAIL
1 1/2" = 1'-0"

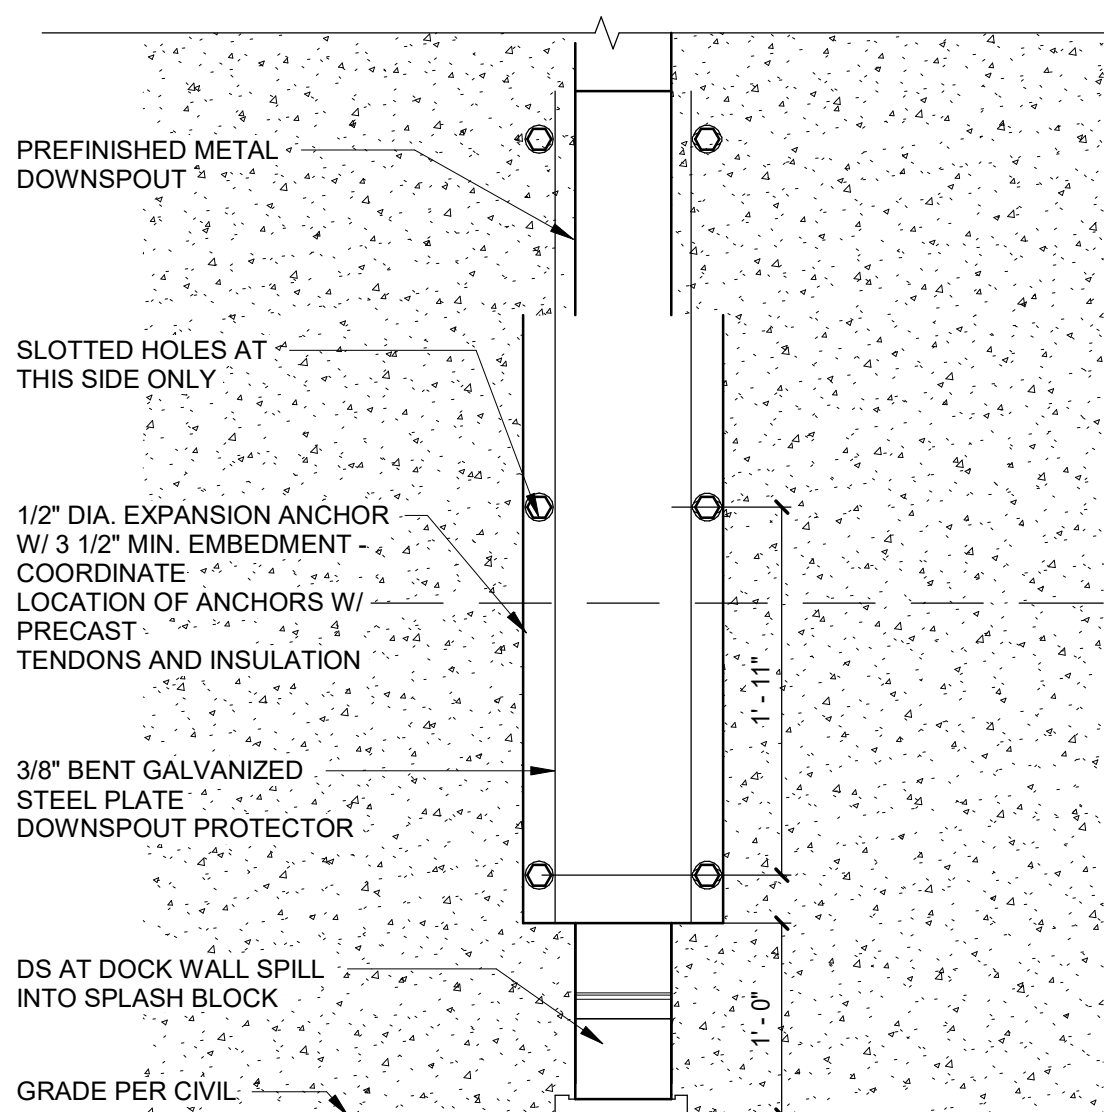

(A1) DOWNSPOUT PROTECTION ELEVATION
1" = 1'-0"

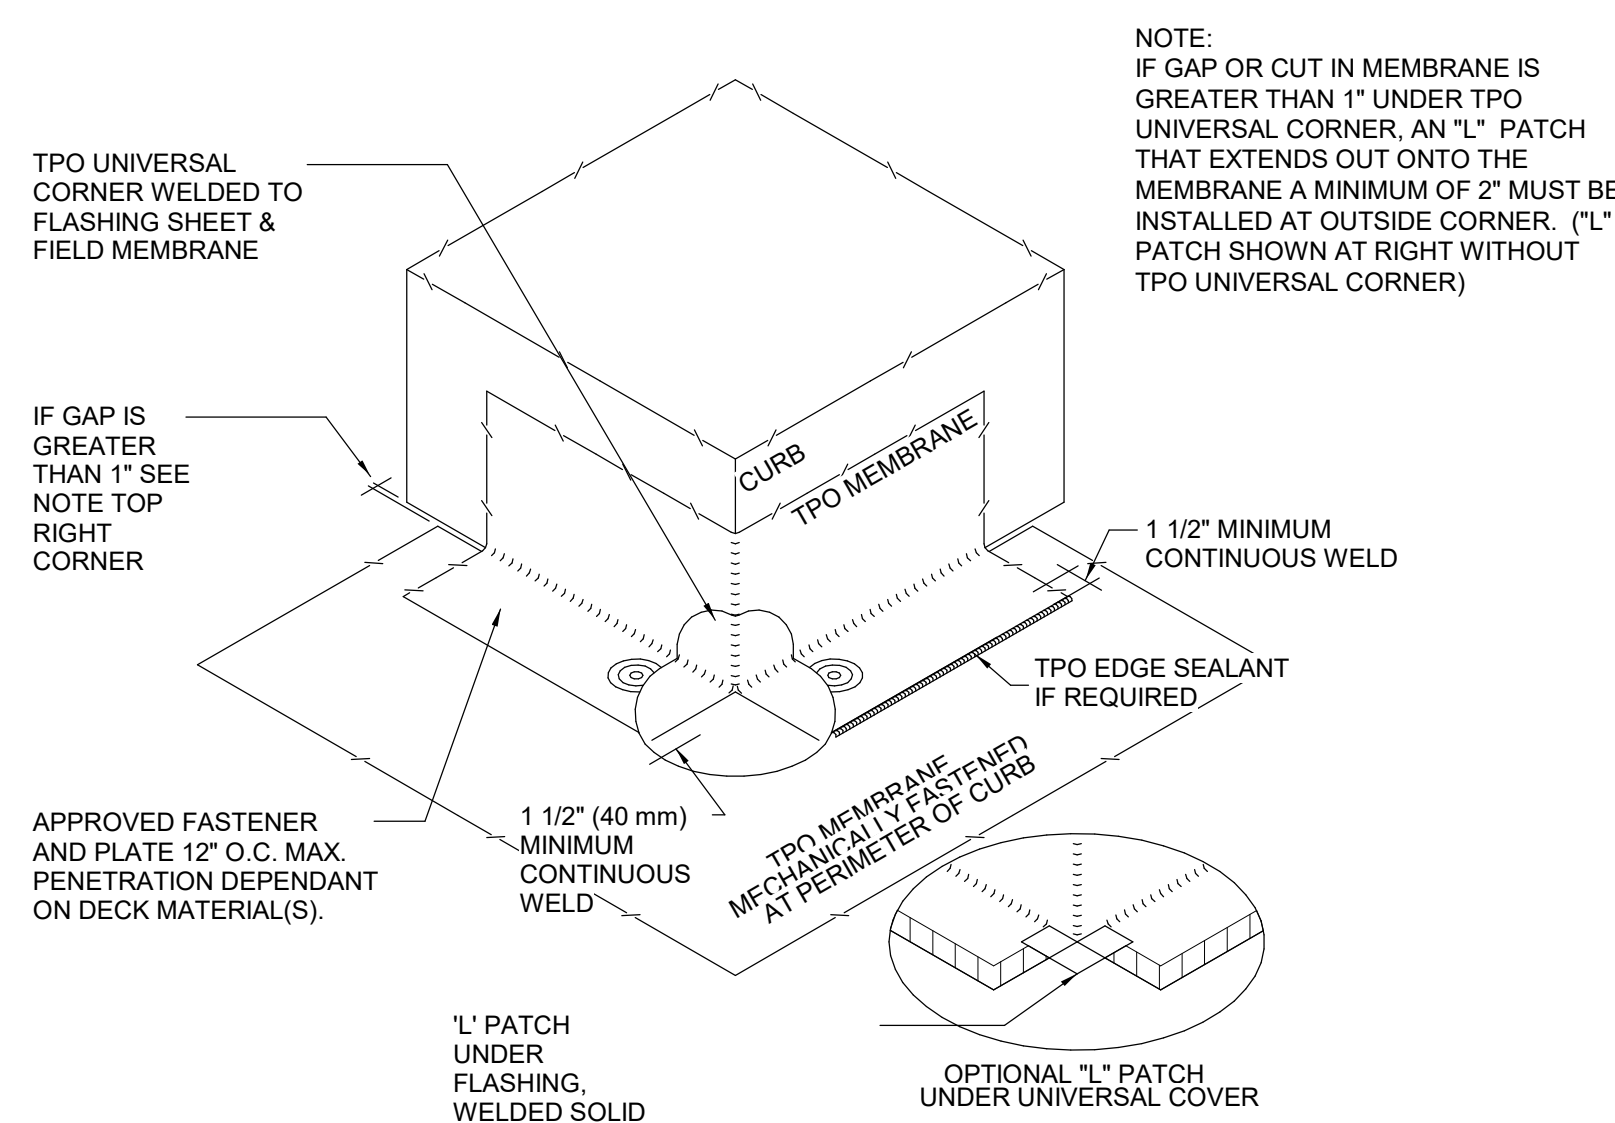

A2 TPO OUTSIDE CORNER
12" = 1'-0"

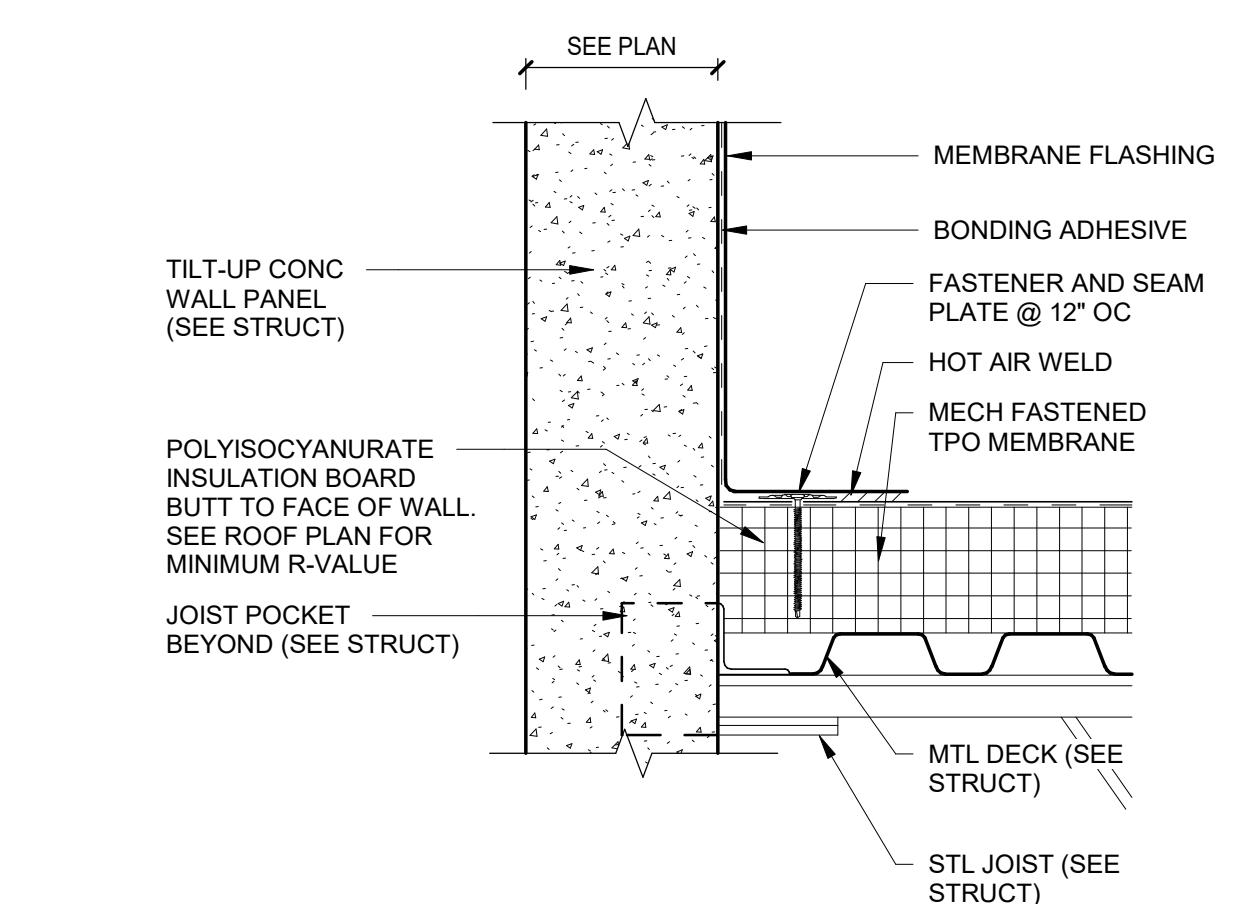

A5 BASE FLASHING DETAIL
1 1/2" = 1'-0"



Stett 95 Industrial Center
SPEC BUILDING 1
2983 Arrowhead Road
Dunn, North Carolina 28334

SUBMITTALS:	
DATE	DESCRIPTION
2025-05-23	90% REVIEW
2025-07-25	FOR CONSTRUCTION

REVISIONS:		
NO	DATE	DESCRIPTION
1	07/14/25	OWNER COMMENT

SHEET TITLE:
TPO ROOF DETAILS

DATE: DATE	
DRAWN: LWM	CHECKED: MTM
JOB NUMBER: 25-009	
SHEET:	

A502 R1

