

Michael A. Dennis, PE
 2542 Old Charleston Rd.
 Gilbert, SC 29054
 (803) 606-2835 - M
 madennis12@gmail.com

RECORD OF REVISIONS

No.	DATE	DESCRIPTION:
0	--/--	---
1	--/--	---
2	--/--	---

PROJECT NAME:
Coble Ski School

CUSTOMER NAME:
 Chris Eller

CUSTOMER ADDRESS:
 60 Coble Lakes Estate
 Lillington, NC 27546

PROJECT LOCATION:
 60 Coble Lakes Estate
 Lillington, NC 27546


CMI ORDER NO.:

CUSTOMER PO NO.:

	NAME	DATE
DRAWN BY:	MAD	10/3/09
CHECKED BY:	SLR	10/4/09

DRAWING NO.:
FP-1
 Fire Protection Plan

SEAL
 33454
 ENGINEER
 MICHAEL A. DENNIS
 4/9/2019

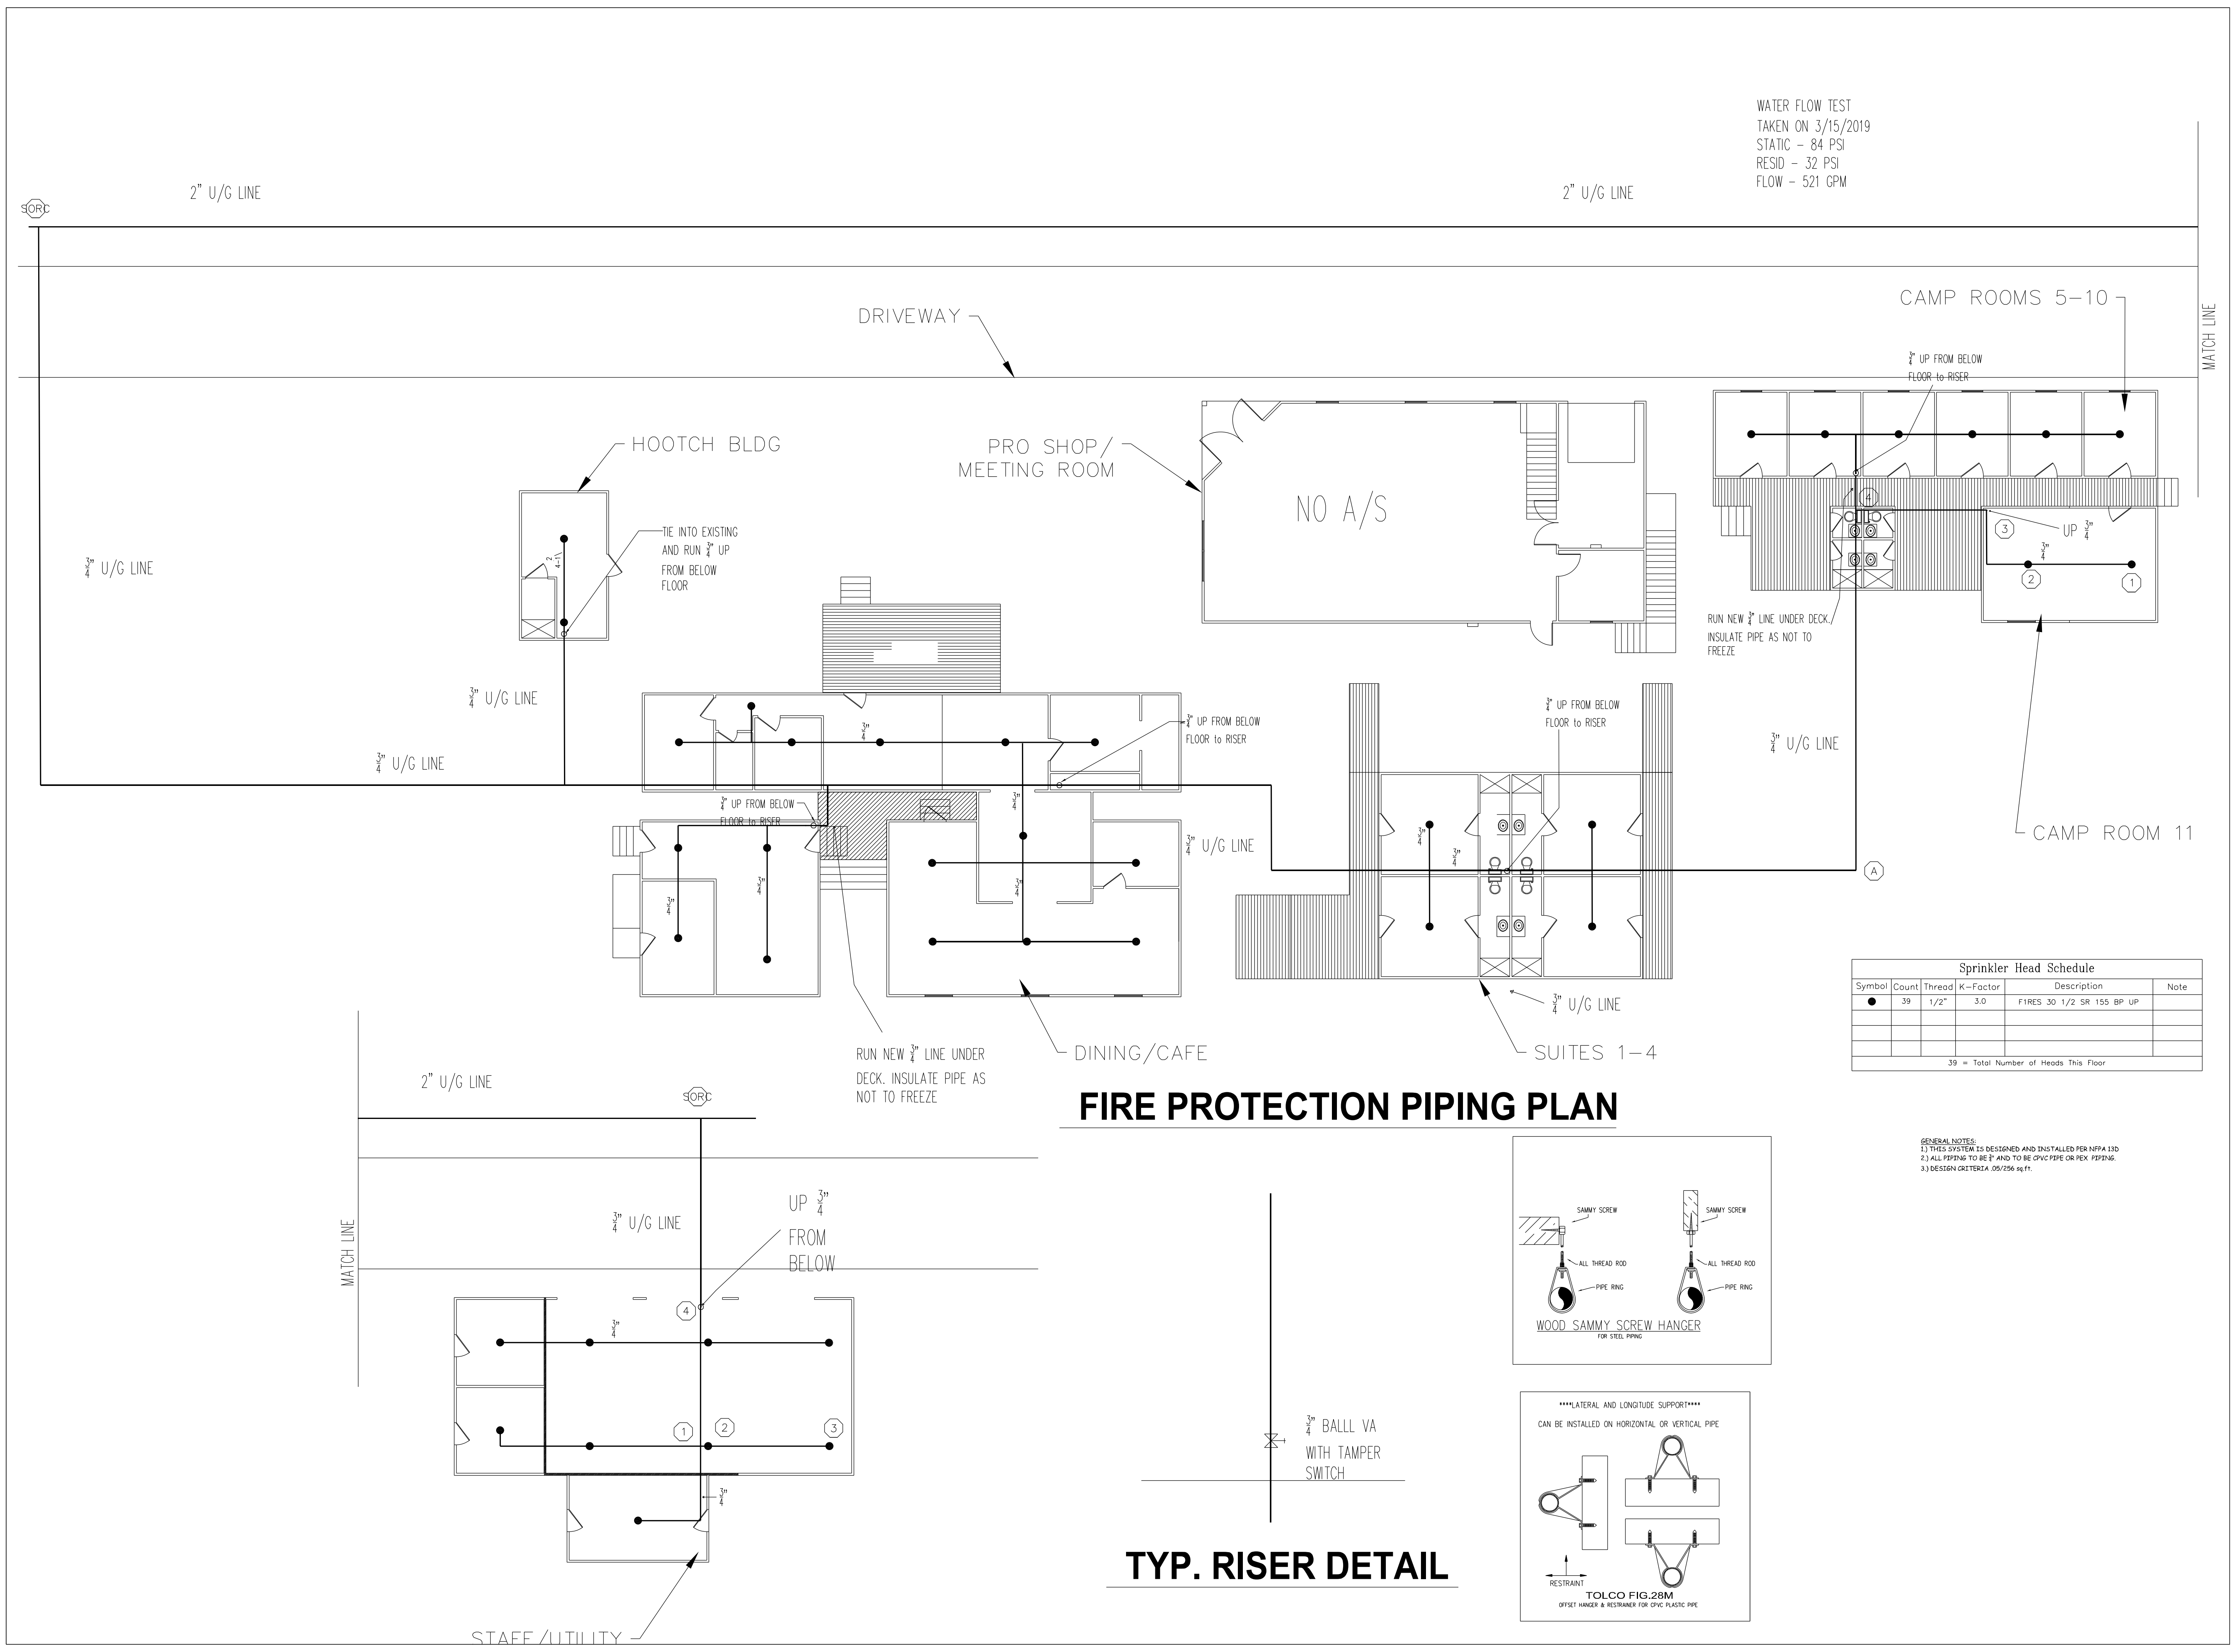

WATER FLOW TEST
 TAKEN ON 3/15/2019
 STATIC - 84 PSI
 RESID - 32 PSI
 FLOW - 521 GPM

Sprinkler Head Schedule

Symbol	Count	Thread	K-Factor	Description	Note
●	39	1/2"	3.0	F1RES 30 1/2 SR 155 BP UP	
39 = Total Number of Heads This Floor					

GENERAL NOTES:
 1) THIS SYSTEM IS DESIGNED AND INSTALLED PER NFPA 13D
 2) ALL PIPING TO BE 1/2" AND TO BE CPVC PIPE OR PEK PIPING.
 3) DESIGN CRITERIA: 05/256 sq ft.

FIRE PROTECTION PIPING PLAN

