




SPOON FAMILY RESIDENCE

LOT 2 HAMILTON ROAD

BUNNLEVEL, NORTH CAROLINA


WHITE HOUSE BUILDING ASSOCIATES LLC

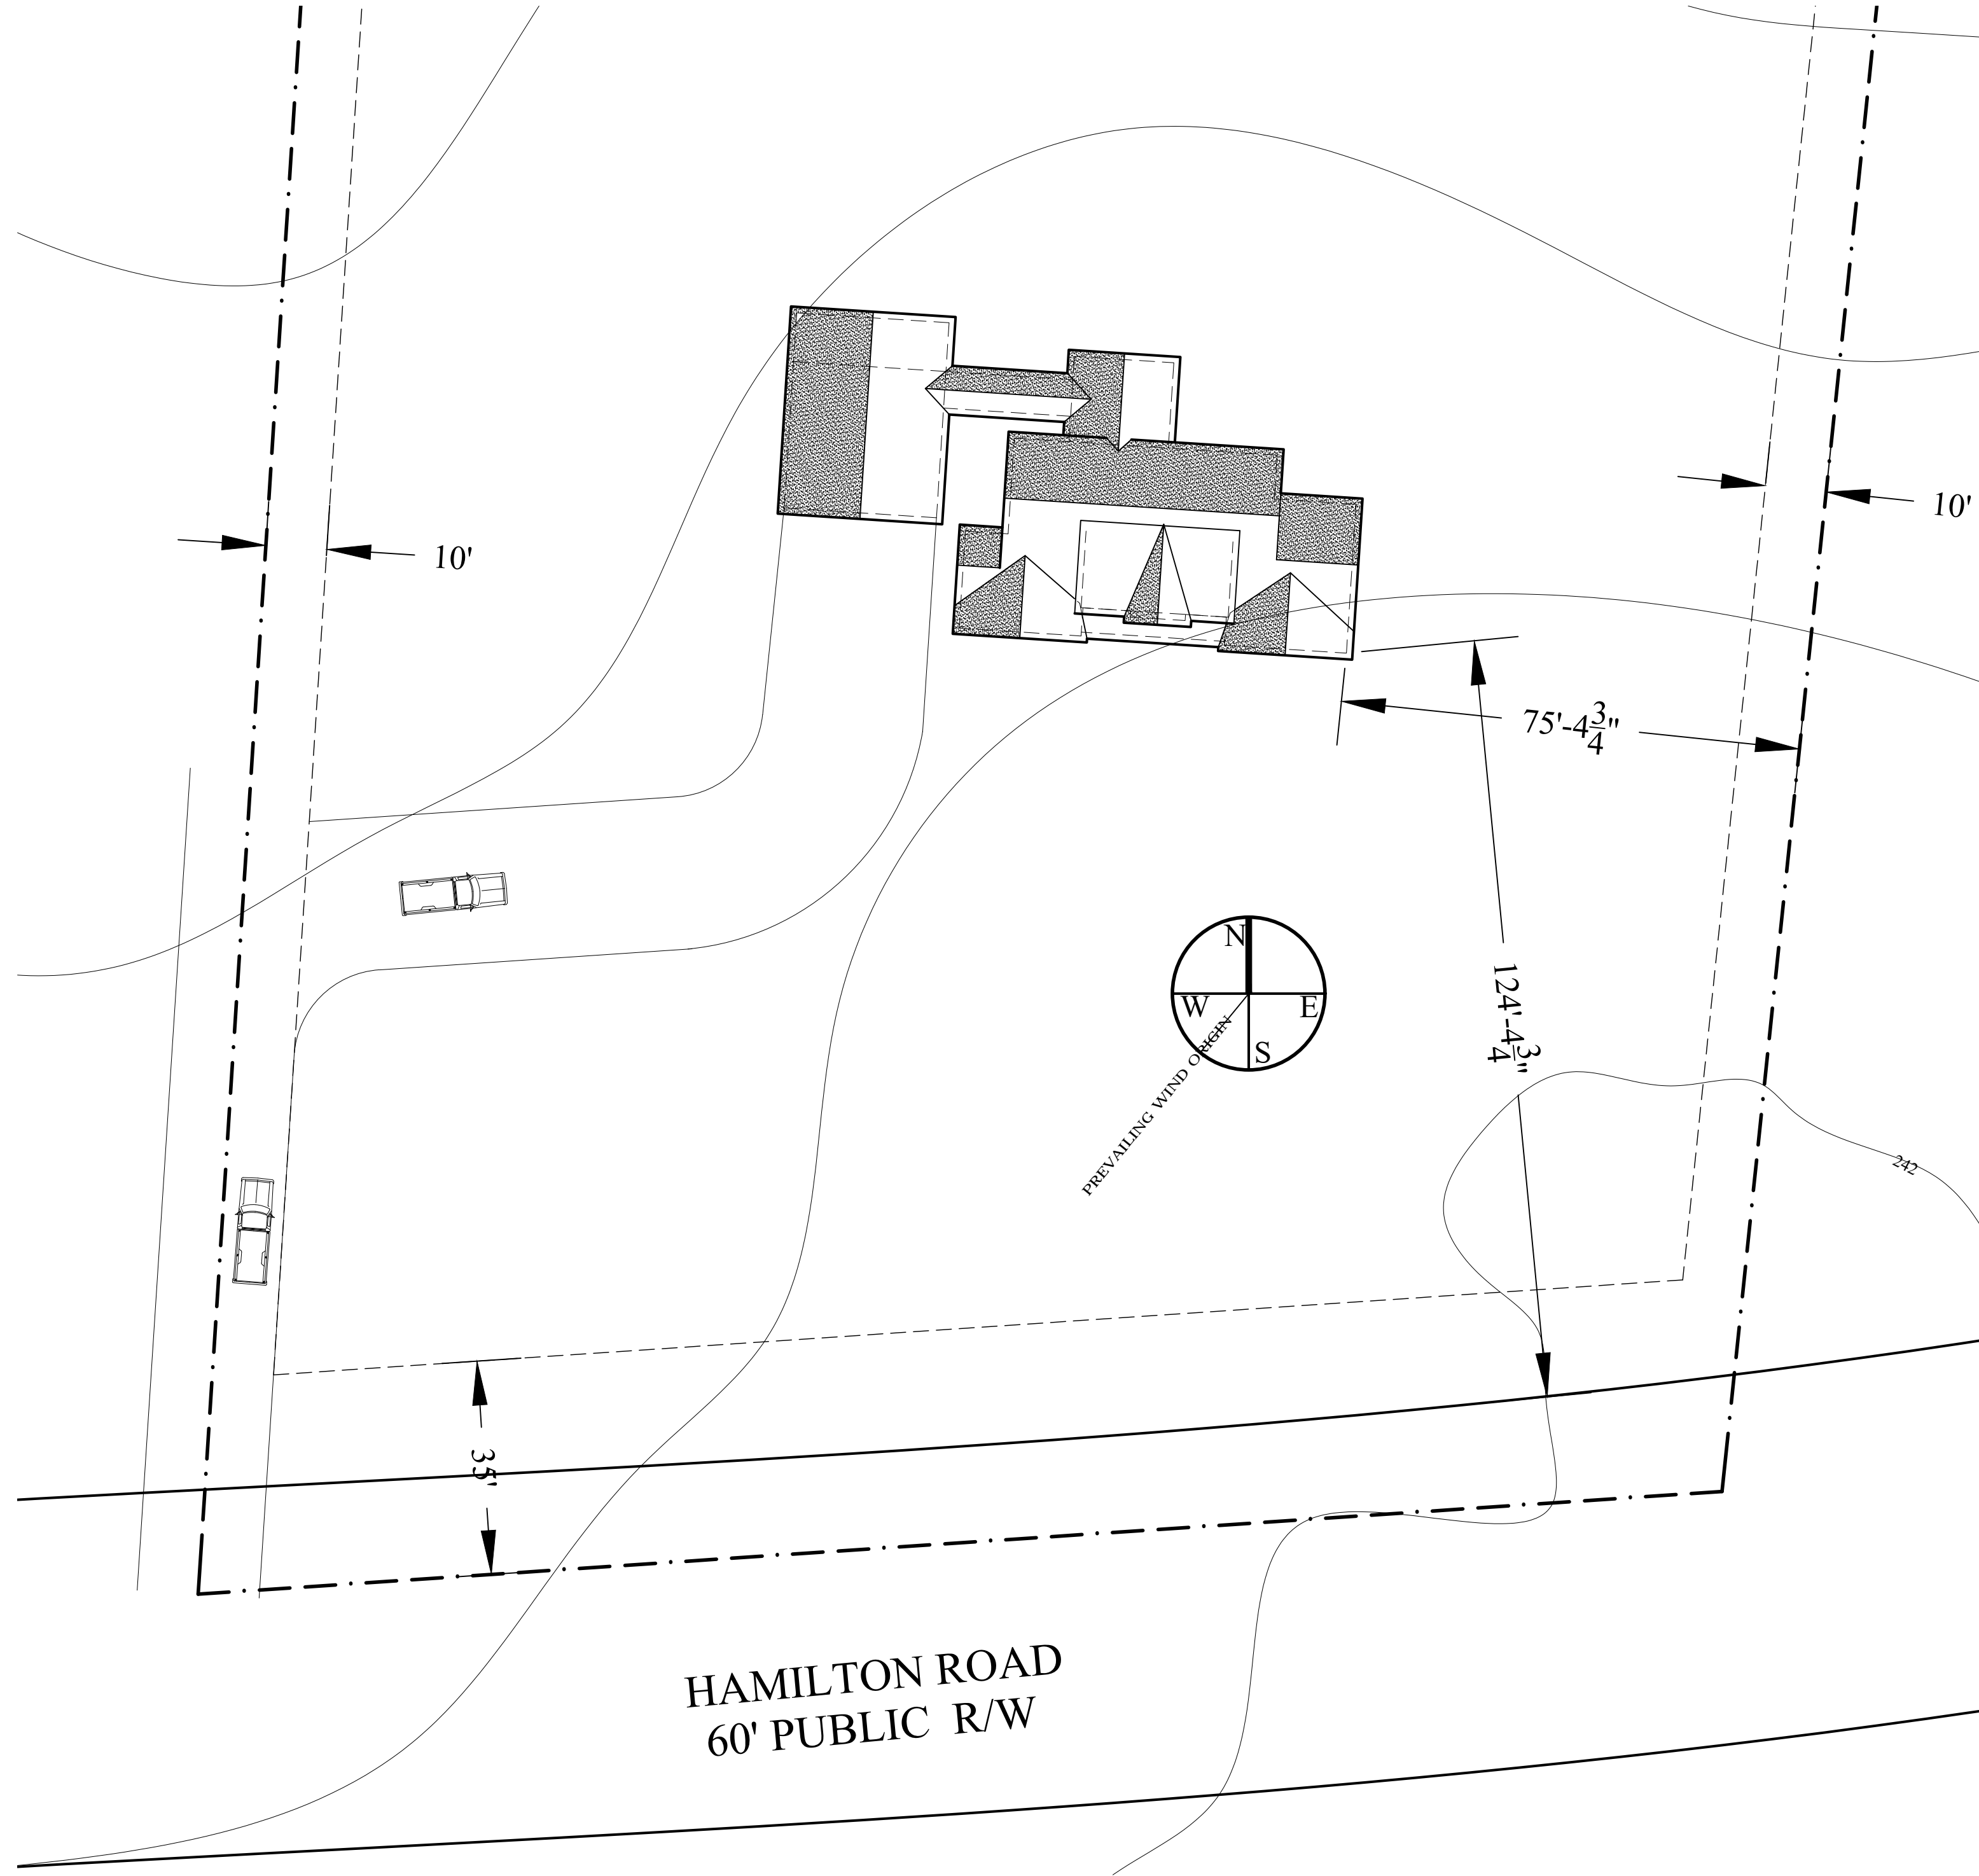

ENLARGED SITE PLAN


1"=40'

<p>R1 1 OF 8</p>	<p>SPOON RESIDENCE LOT 2 HAMILTON ROAD BUNNLEVEL, NORTH CAROLINA</p>	<p>SITE PLAN CONTRACTOR/BUILDER SHALL ENSURE COMPLIANCE WITH MUNICIPAL BUILDING CODE. ANY ERRORS OR OMISSIONS SHALL BE BROUGHT TO THE ATTENTION OF THE DESIGNER BEFORE CONSTRUCTION BEGINS. ALL LUMBER AND BEAM SPANS SHALL BE VERIFIED BY CONTRACTOR/BUILDER. TO INCLUDE ENGINEER'S EVALUATION IF REQUIRED.</p>	<p>DRAWN BY: LRW DATE: 29-Dec-19 REVISED: SCALE: AS NOTED</p>	<p>WHITE HOUSE BUILDING ASSOCIATES RESIDENTIAL DESIGN, GENERAL CONTRACTING, CAD SERVICES LARRY R. WHITE - DESIGNER PHONE: 910-978-5195 E-MAIL: SUREDWELLINGS@GMAIL.COM FAYETTEVILLE, NORTH CAROLINA</p>
-----------------------------	---	---	---	--

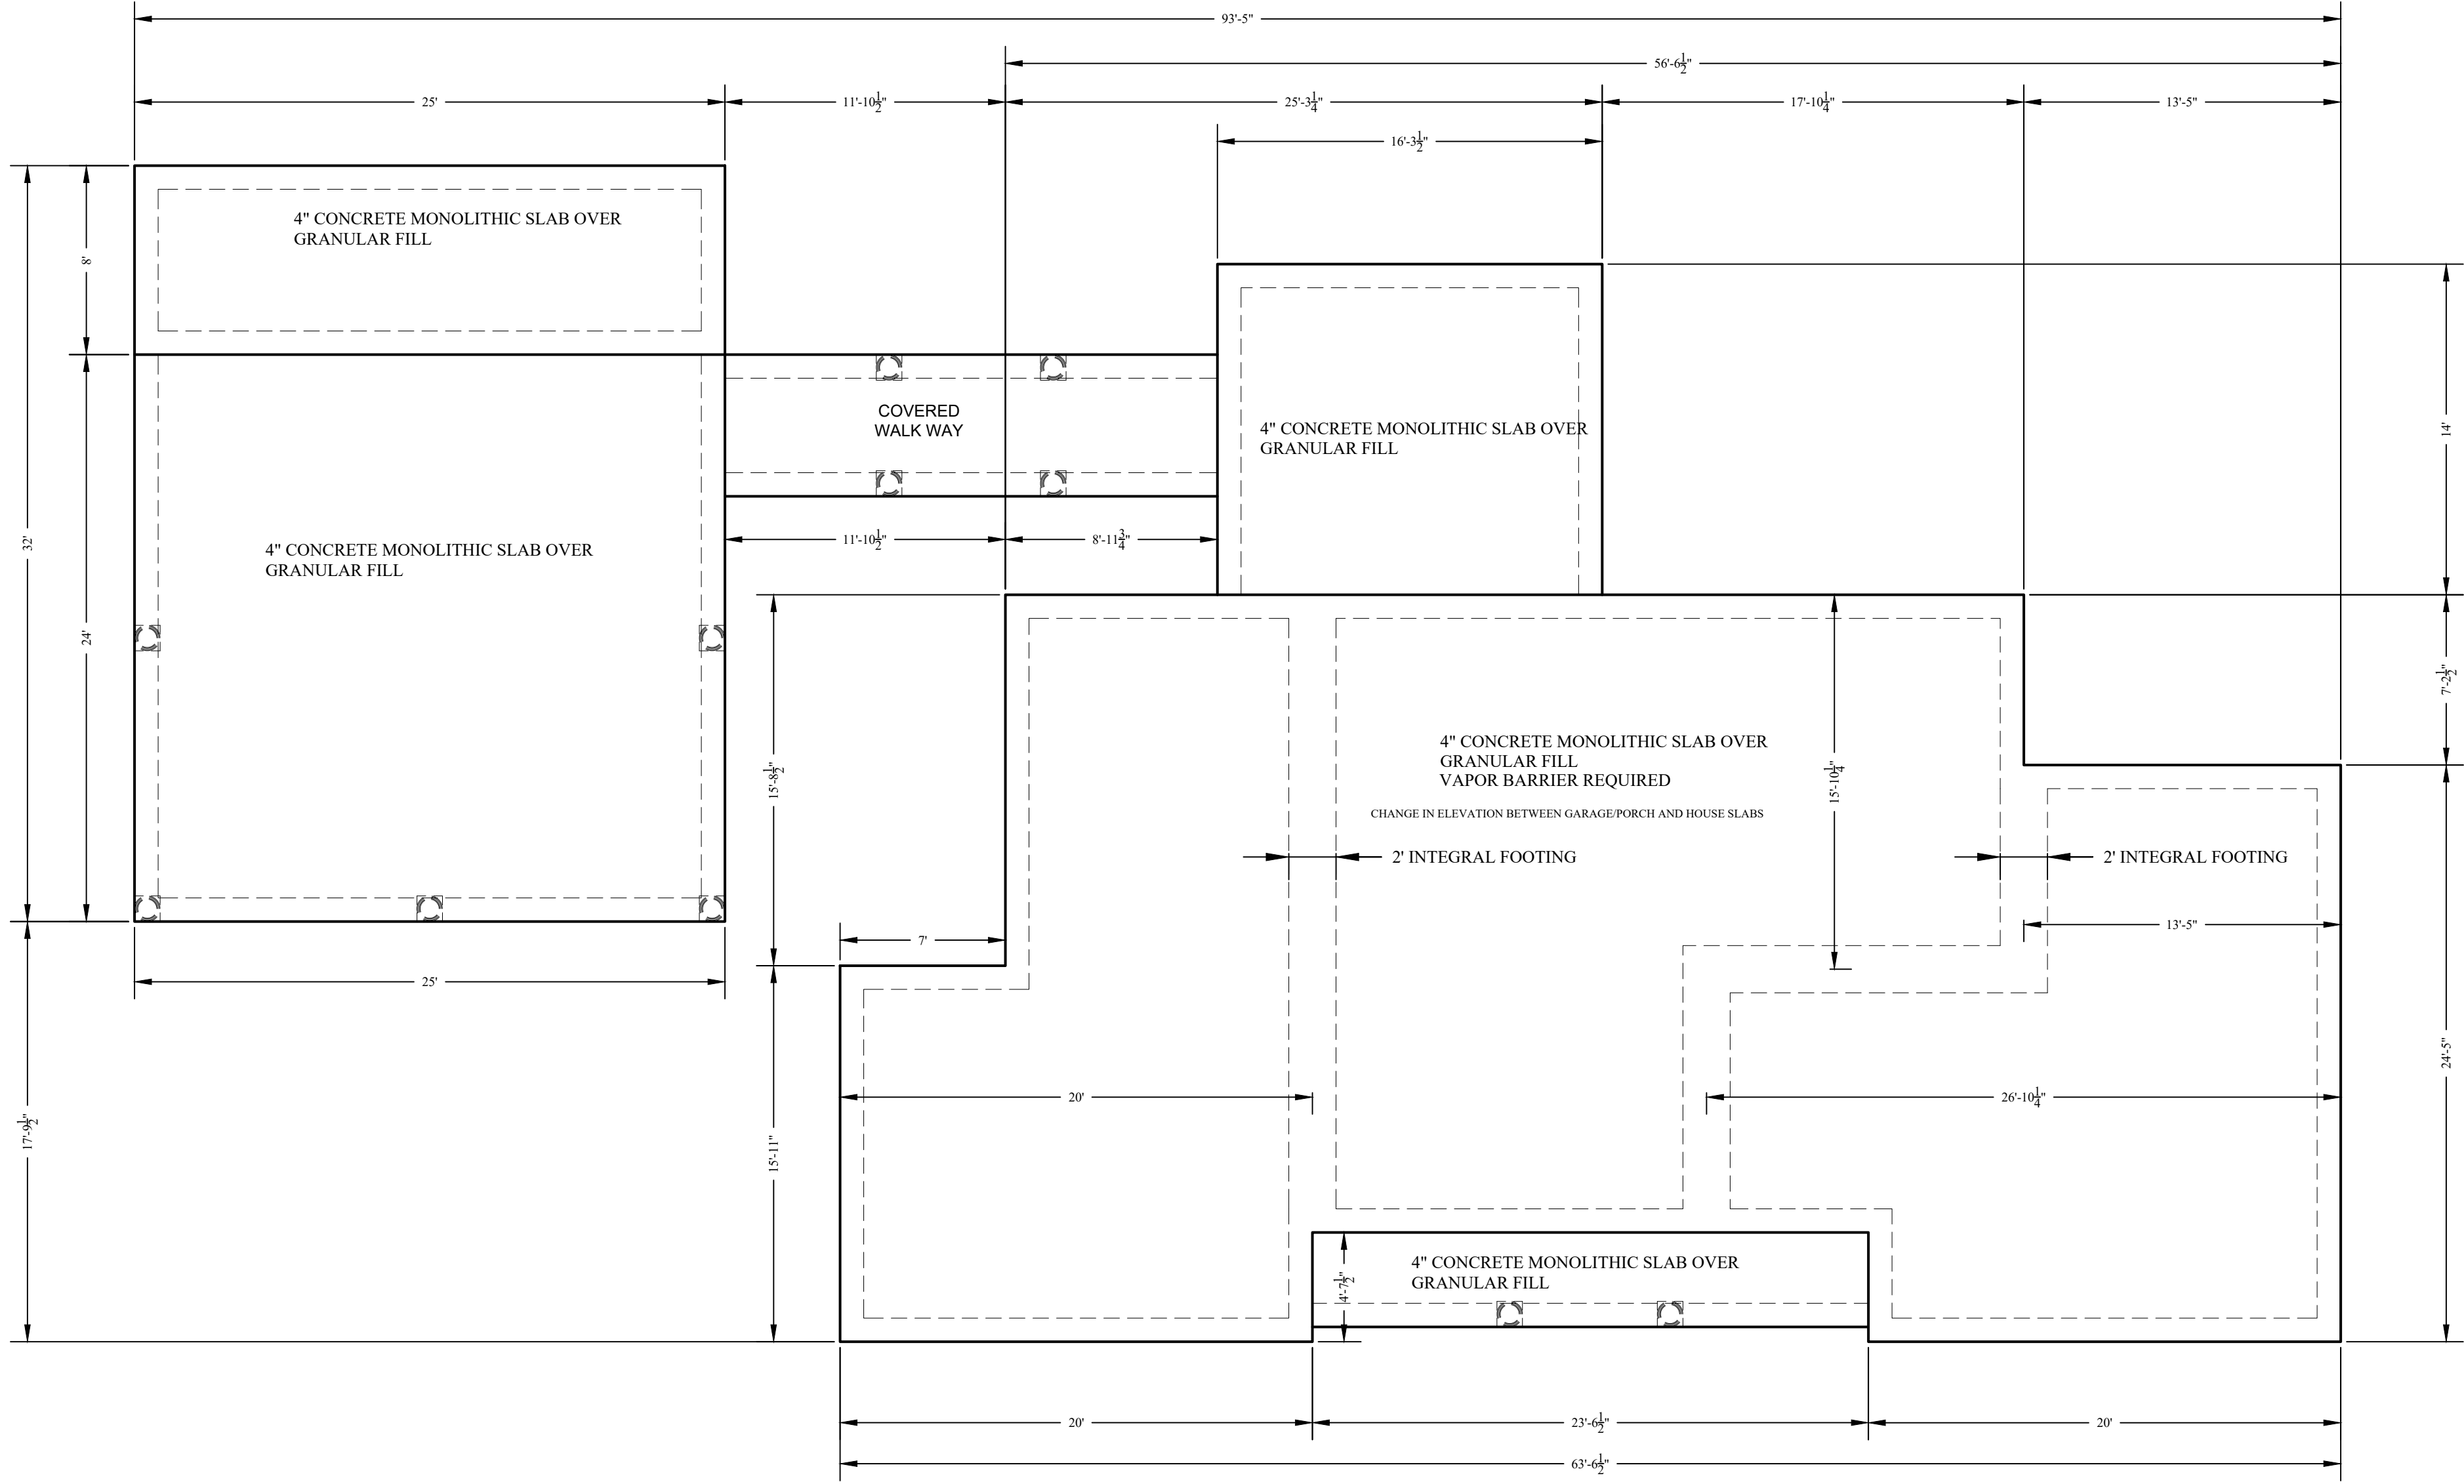

FOUNDATION PLAN
3/16"=1'-0"

<h1>R2</h1> <p>2 OF 8</p>	<p>SPOON RESIDENCE LOT 2 HAMILTON ROAD BUNNLEVEL, NORTH CAROLINA</p>	<p>FOUNDATION PLAN</p>	<p>DRAWN BY: LRW DATE: 29-Dec-19 REVISED: SCALE: AS NOTED</p>	<p>WHITE HOUSE BUILDING ASSOCIATES RESIDENTIAL DESIGN, GENERAL CONTRACTING, CAD SERVICES LARRY R. WHITE - DESIGNER PHONE: 910-978-5195 E-MAIL: SUREDWELLINGS@GMAIL.COM FAYETTEVILLE, NORTH CAROLINA</p>
	<p><small>CONTRACTOR/BUILDER SHALL ENSURE COMPLIANCE WITH MUNICIPAL BUILDING CODE. ANY ERRORS OR OMISSIONS SHALL BE BROUGHT TO THE ATTENTION OF THE DESIGNER BEFORE CONSTRUCTION BEGINS. ALL LUMBER AND BEAM SPANS SHALL BE VERIFIED BY CONTRACTOR/BUILDER. TO INCLUDE ENGINEER'S EVALUATION IF REQUIRED.</small></p>			

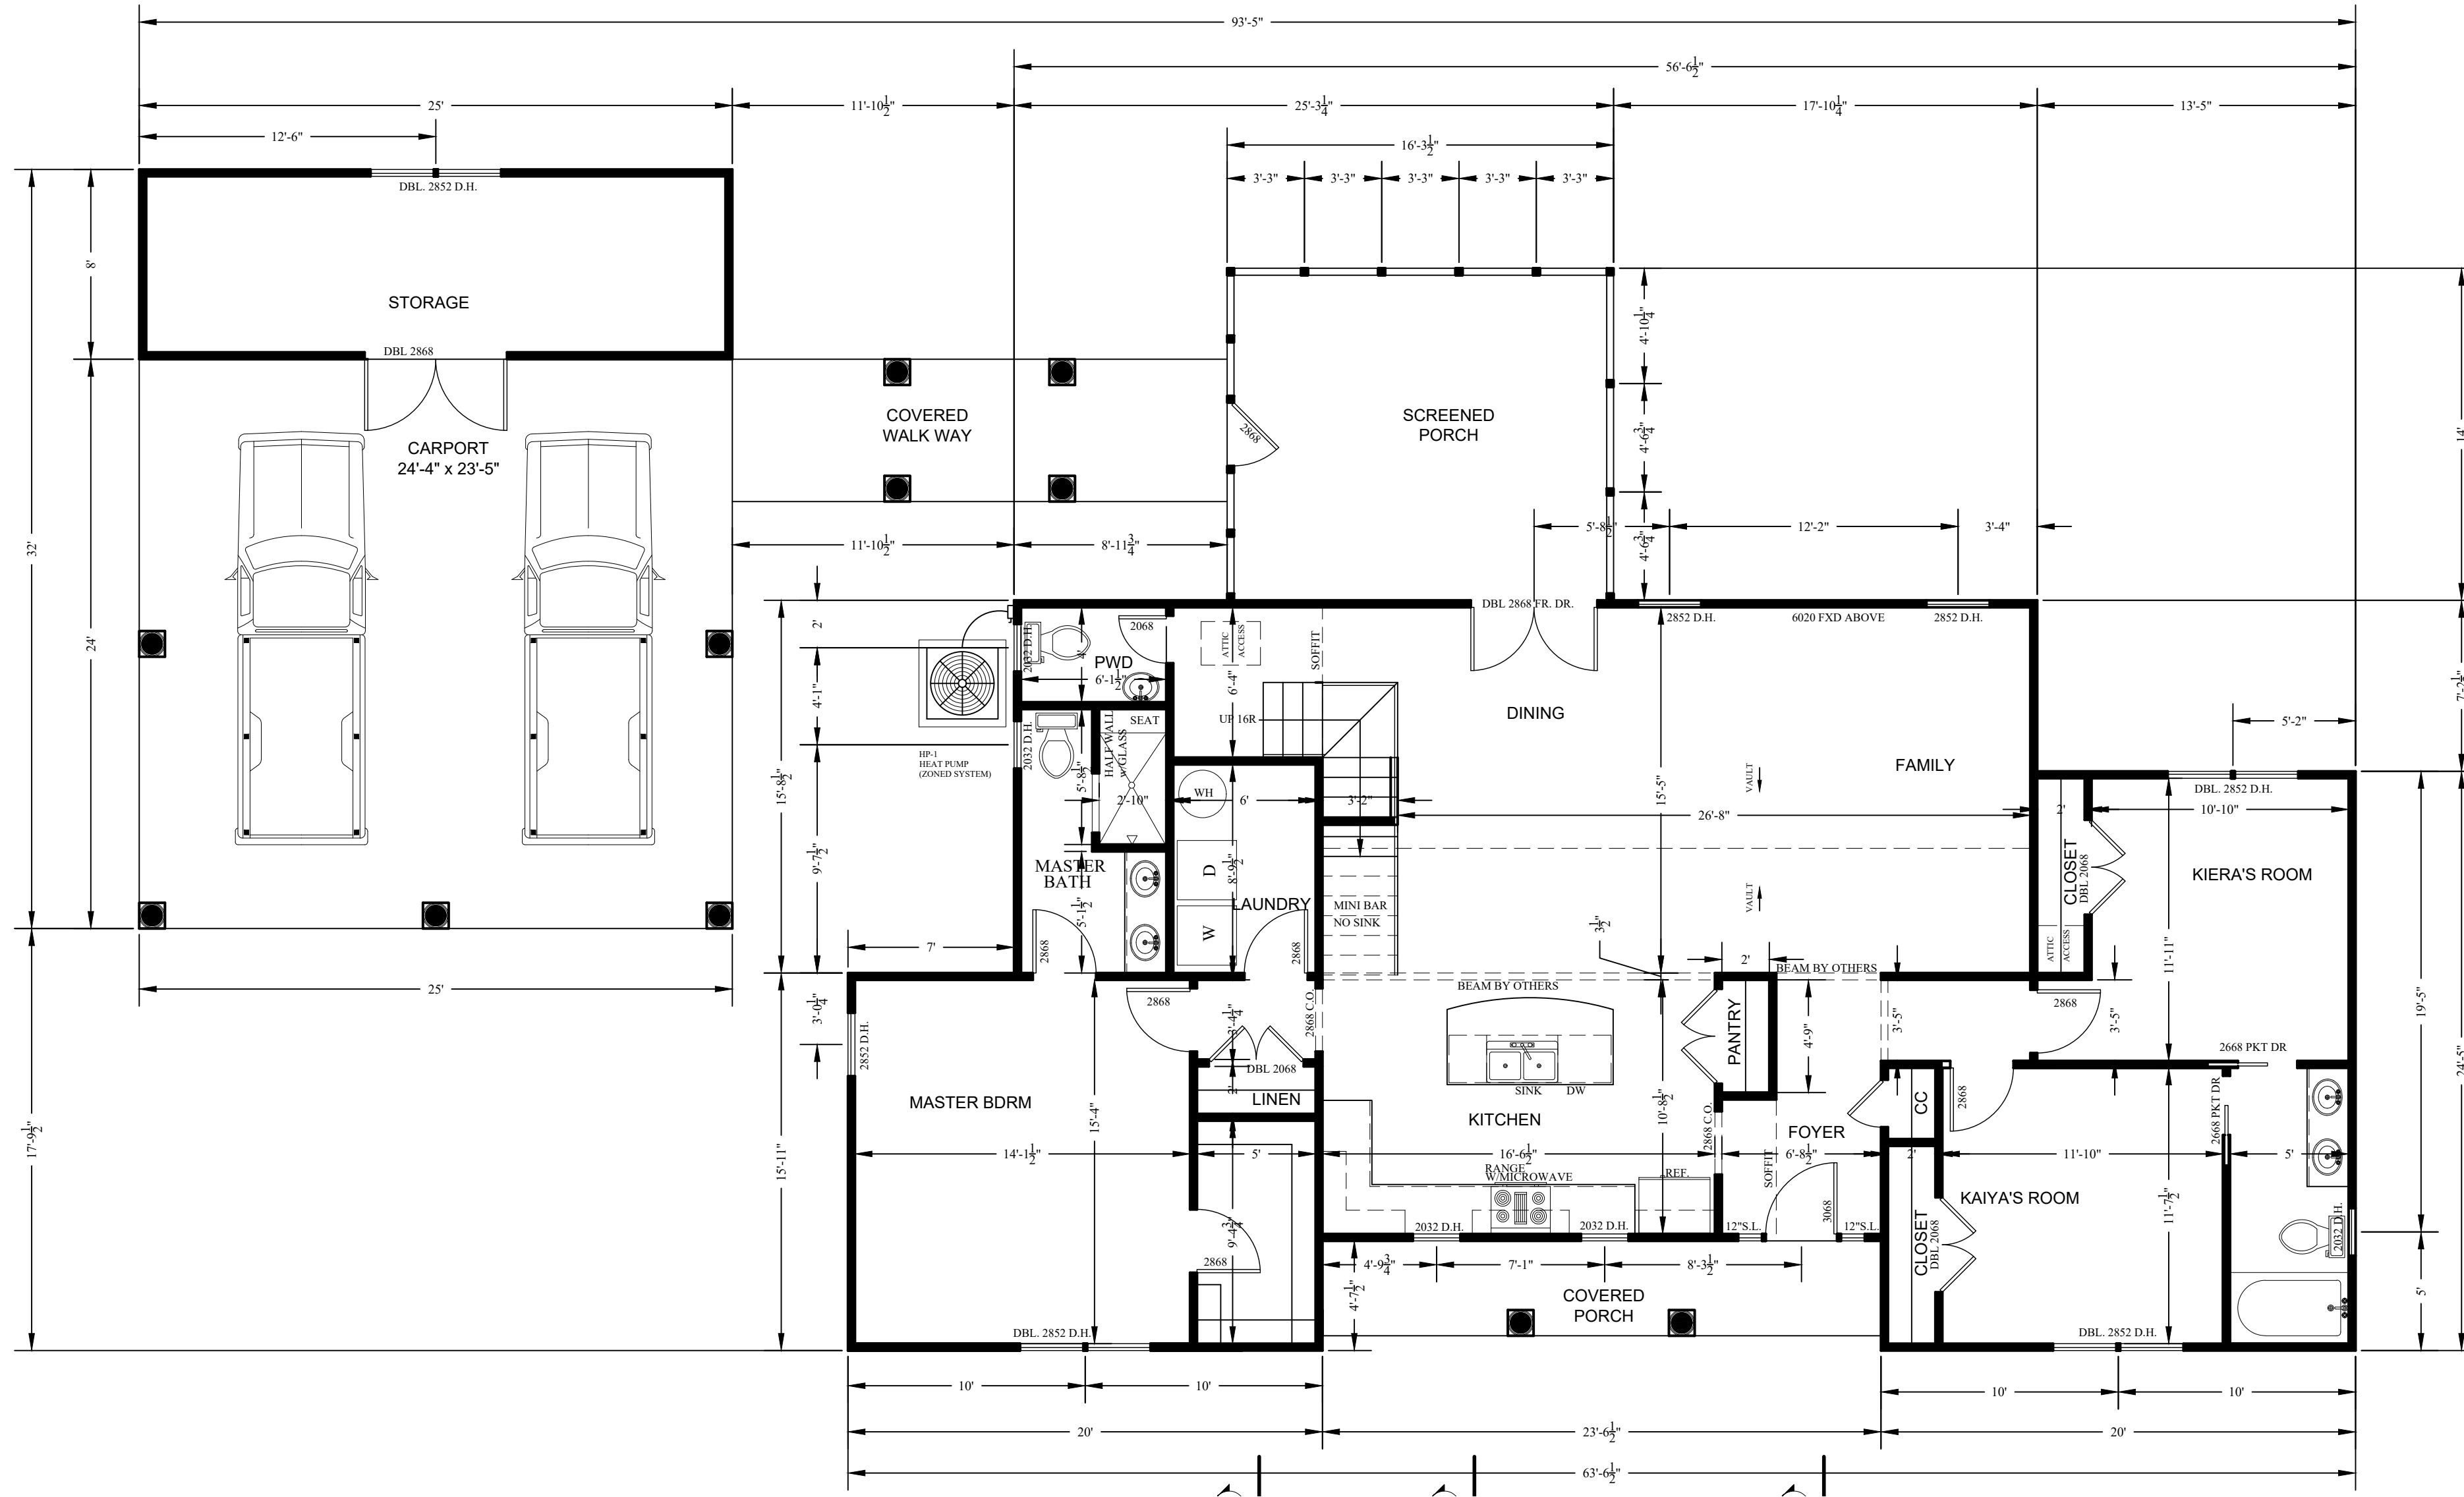


FLOOR PLAN

3/16"=1'-0"


SQUARE FOOTAGE LEGEND	
HEATED SQUARE FOOTAGE	1694
LOFT	216
TOTAL HEATED SQUARE FOOTAGE	1910
PORCHES	322
CARPORT	800
TOTAL UNHEATED SQUARE FOOTAGE	1122
TOTAL COMBINED SQUARE FOOTAGE	3032

<h2>R3</h2> <p>3 OF 8</p>	SPOON RESIDENCE LOT 2 HAMILTON ROAD BUNNLEVEL, NORTH CAROLINA	FLOOR PLAN	DRAWN BY: LRW DATE: 29-Dec-19 REVISIONS: SCALE: AS NOTED	WHITE HOUSE BUILDING ASSOCIATES RESIDENTIAL DESIGN, GENERAL CONTRACTING, CAD SERVICES LARRY R. WHITE - DESIGNER PHONE: 910-978-5195 E-MAIL: SUREDWELLINGS@GMAIL.COM FAYETTEVILLE, NORTH CAROLINA
	<small>CONTRACTOR/BUILDER SHALL ENSURE COMPLIANCE WITH MUNICIPAL BUILDING CODE. ANY ERRORS OR OMISSIONS SHALL BE BROUGHT TO THE ATTENTION OF THE DESIGNER BEFORE CONSTRUCTION BEGINS. ALL LUMBER AND BEAM SPANS SHALL BE VERIFIED BY CONTRACTOR/BUILDER. TO INCLUDE ENGINEER'S EVALUATION IF REQUIRED.</small>			

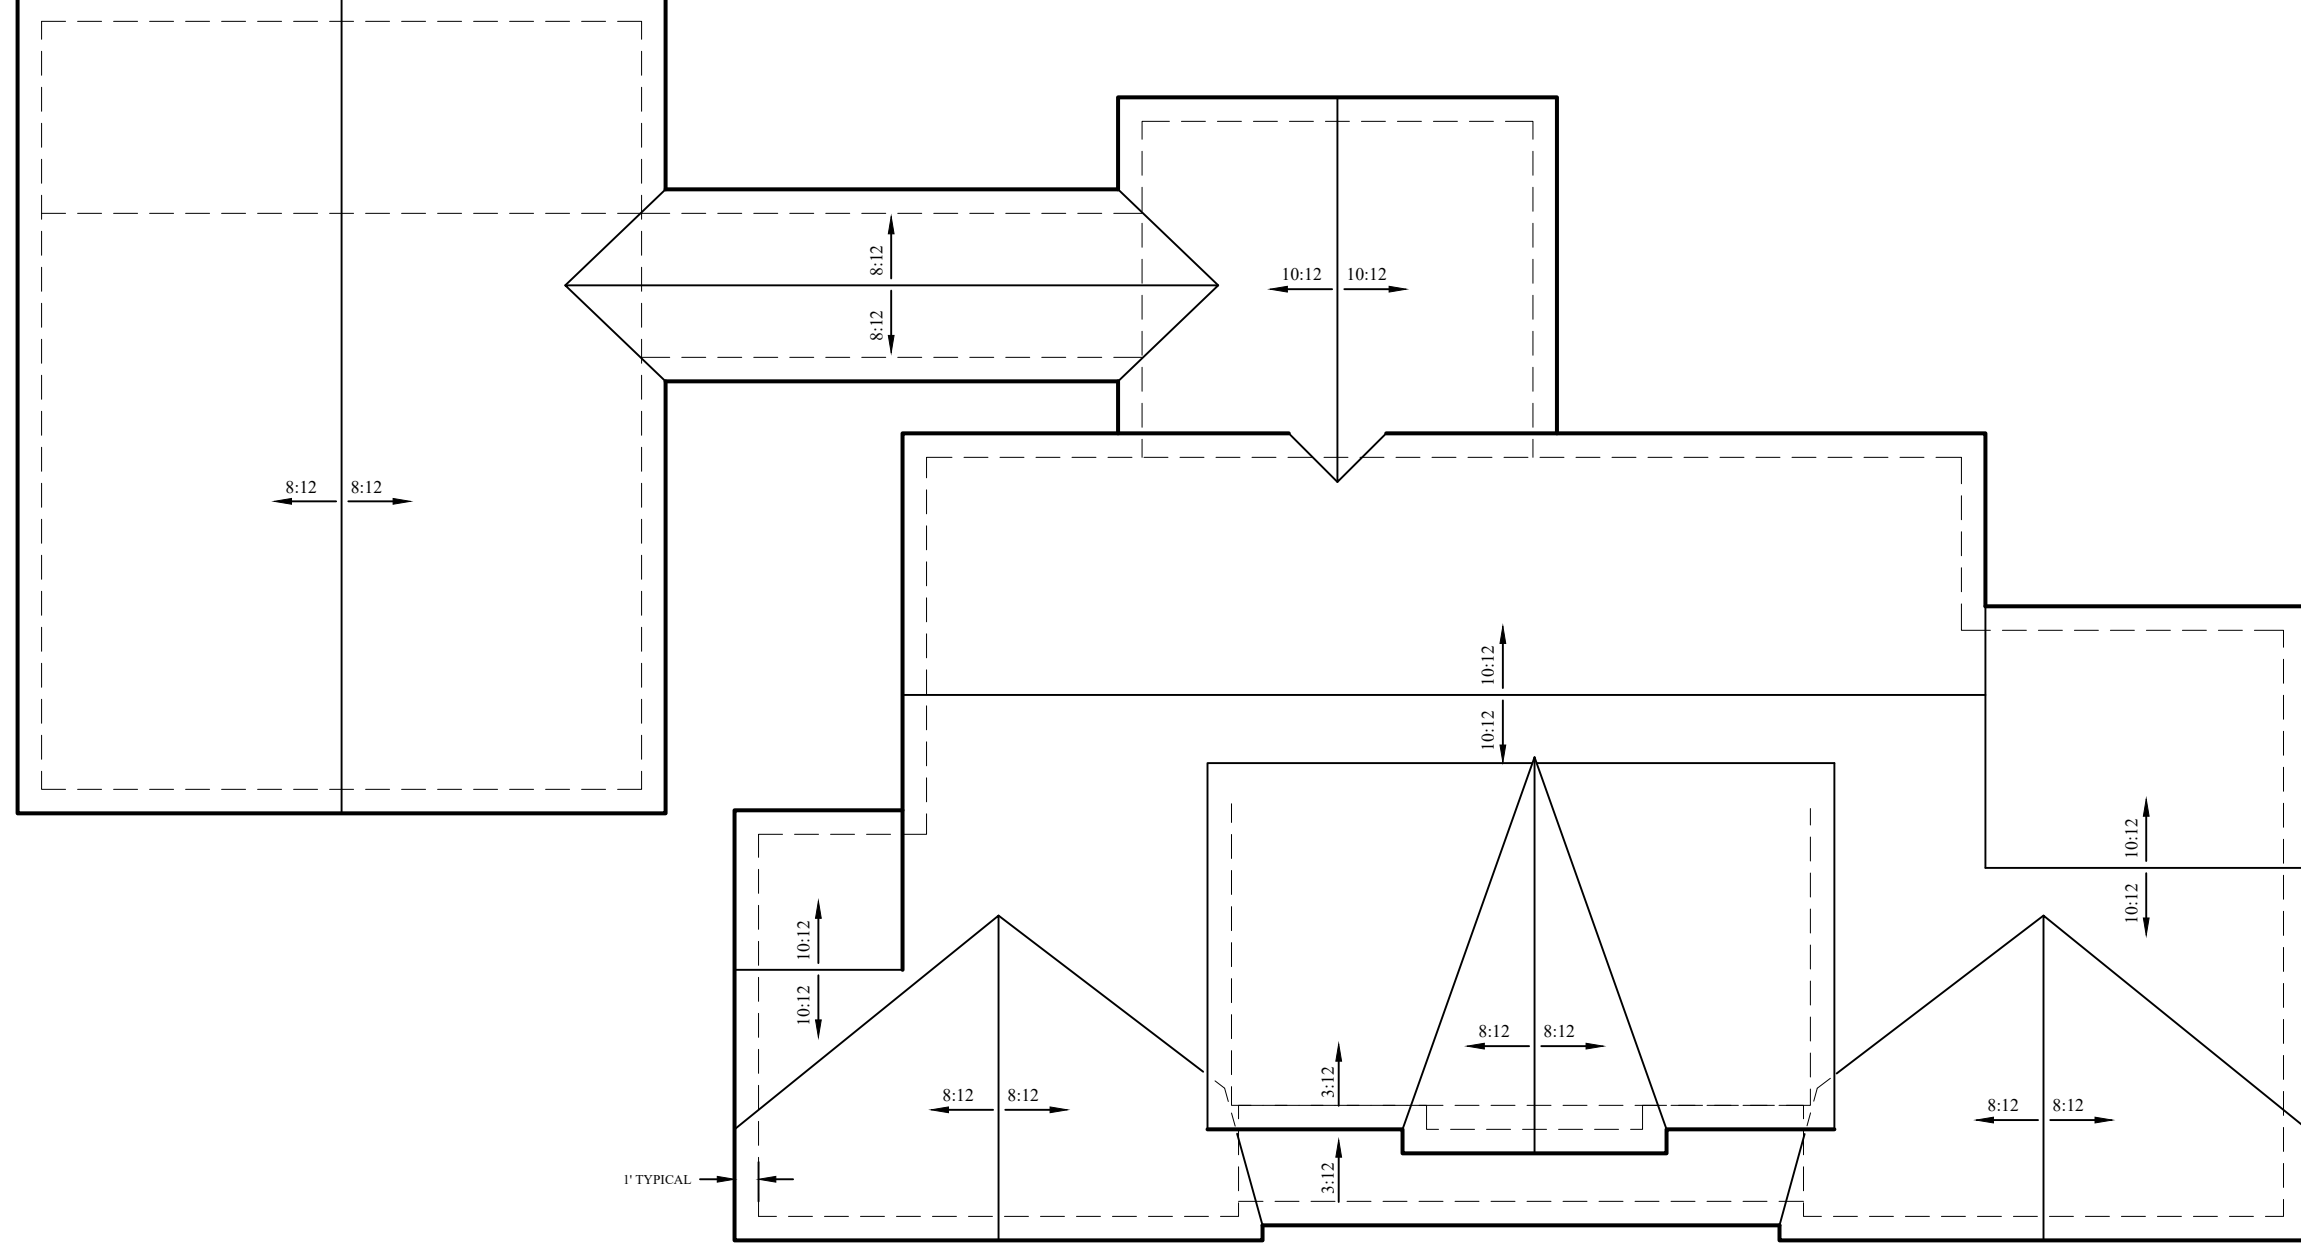


ROOF PLAN

1/8"=1'-0"

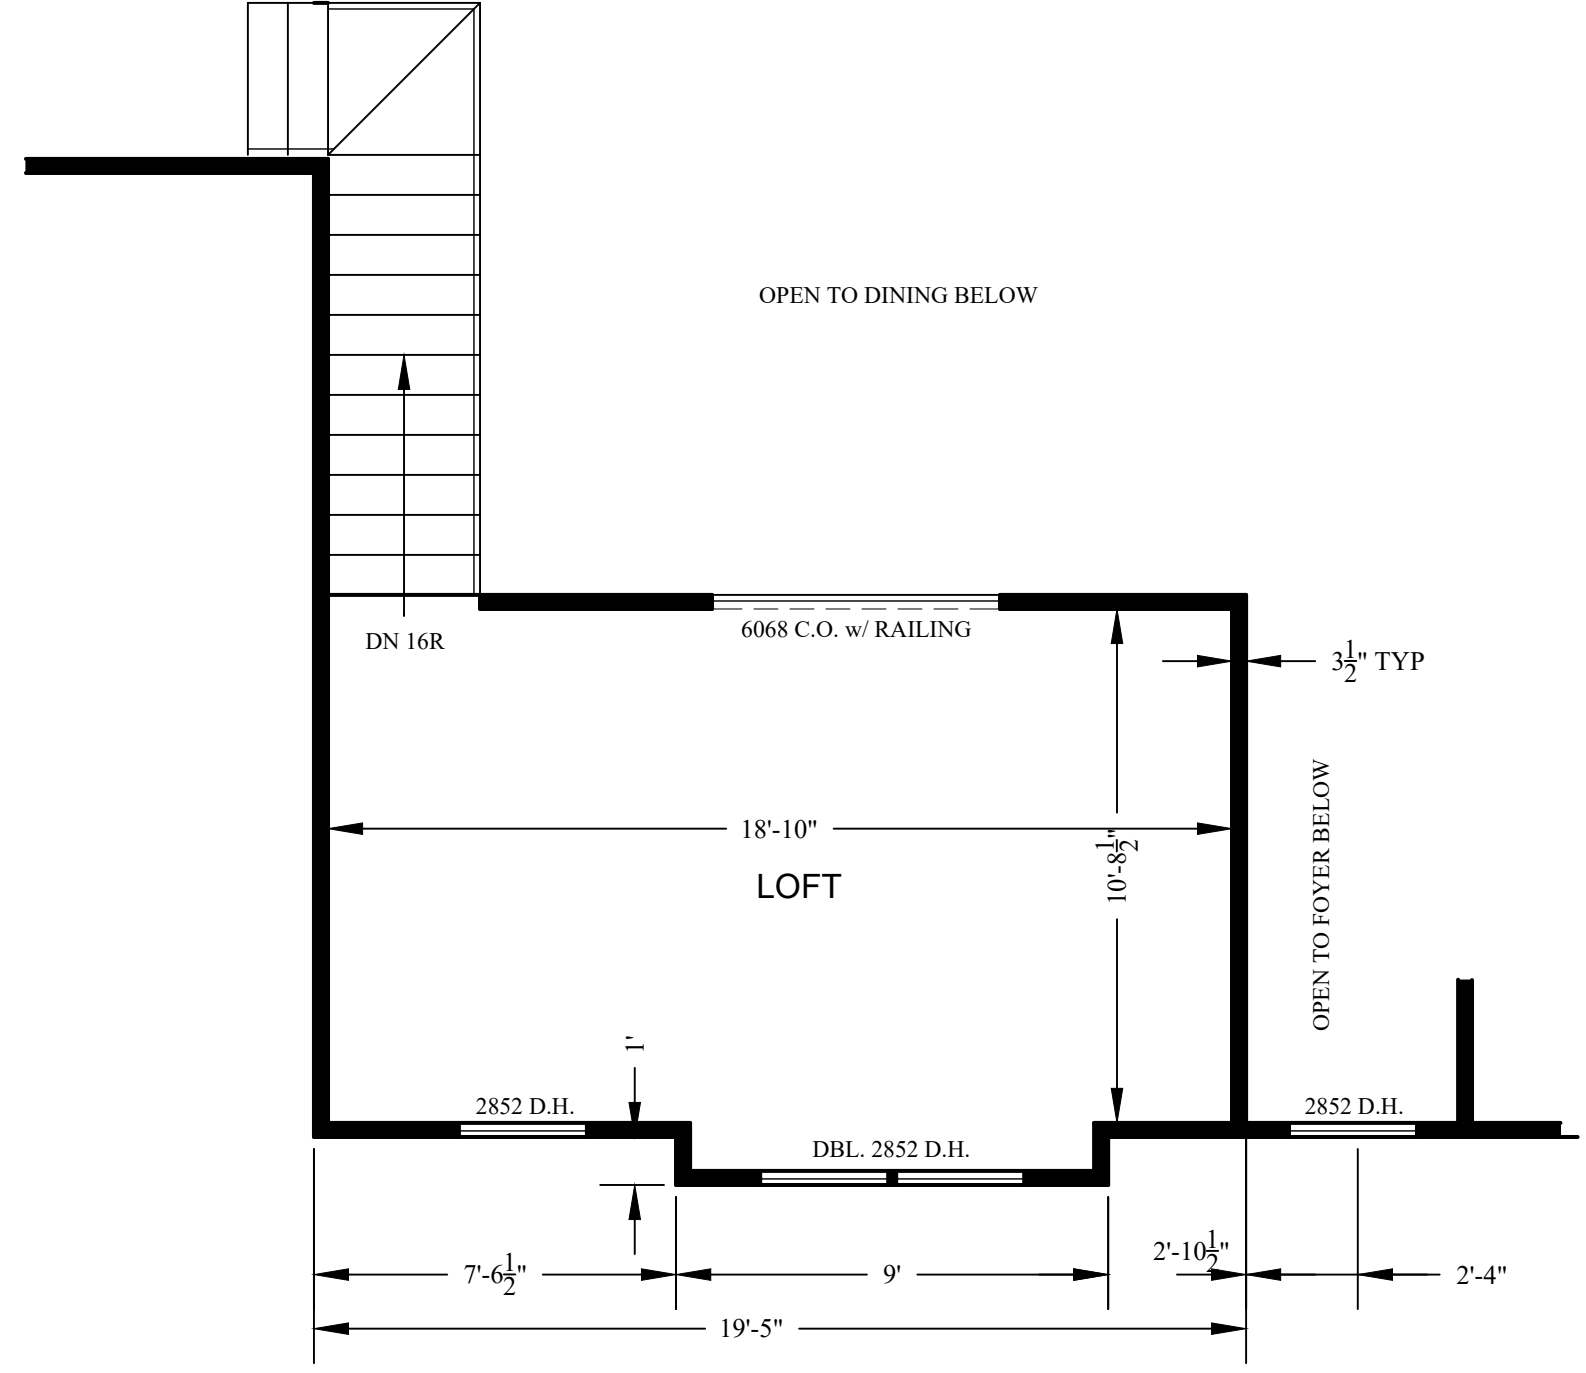

LOFT PLAN

1/4"=1'-0"

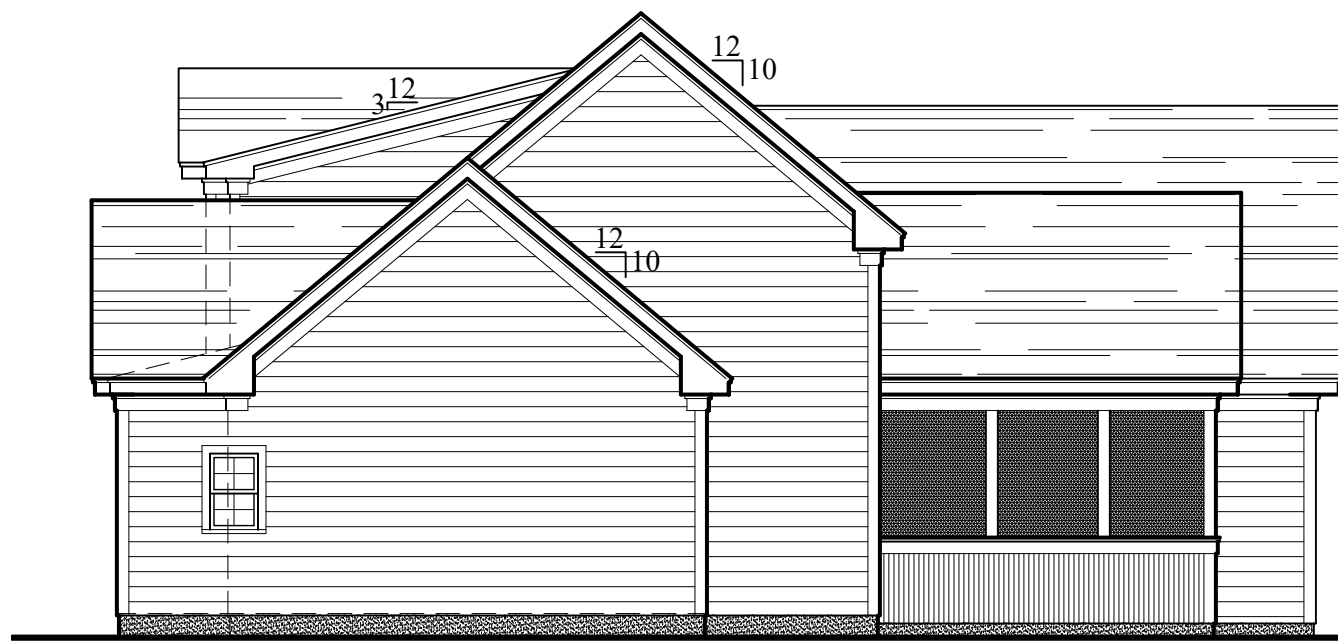

PLAN EAST ELEVATION

1/8"=1'-0"

8'-1 1/2" PLATE HT. ---
6'-8" WINDOW HT. ---

FIRST FLOOR ---
9'-1 1/2" PLATE HT. ---
6'-8" WINDOW HT. ---

FIRST FLOOR ---



PLAN NORTH ELEVATION

1/8"=1'-0"



PLAN SOUTH ELEVATION

1/8"=1'-0"

8'-1 1/2" PLATE HT. ---
6'-8" WINDOW HT. ---

LOFT FLOOR ---
9'-1 1/2" PLATE HT. ---
6'-8" WINDOW HT. ---

FIRST FLOOR ---



PLAN EAST ELEVATION

1/8"=1'-0"

WHITE HOUSE BUILDING ASSOCIATES

RESIDENTIAL DESIGN, GENERAL CONTRACTING, CAD SERVICES

LARRY R. WHITE - DESIGNER

PHONE: 910-978-5195

E-MAIL: SUREDWELLINGS@GMAIL.COM

FAYETTEVILLE, NORTH CAROLINA

DRAWN BY: LRW

DATE: 29-Dec-19

REVISIONS:

SCALE: AS NOTED

ELEVATIONS, ROOF PLAN


CONTRACTOR/BUILDER SHALL ENSURE COMPLIANCE WITH MUNICIPAL BUILDING CODE. ANY ERRORS OR OMISSIONS SHALL BE BROUGHT TO THE ATTENTION OF THE DESIGNER BEFORE CONSTRUCTION BEGINS. ALL LUMBER AND BEAM SPANS SHALL BE VERIFIED BY CONTRACTOR/BUILDER. TO INCLUDE ENGINEER'S EVALUATION IF REQUIRED.

SPOON RESIDENCE

LOT 2 HAMILTON ROAD
BUNNLEVEL, NORTH CAROLINA


R5

5 OF 8

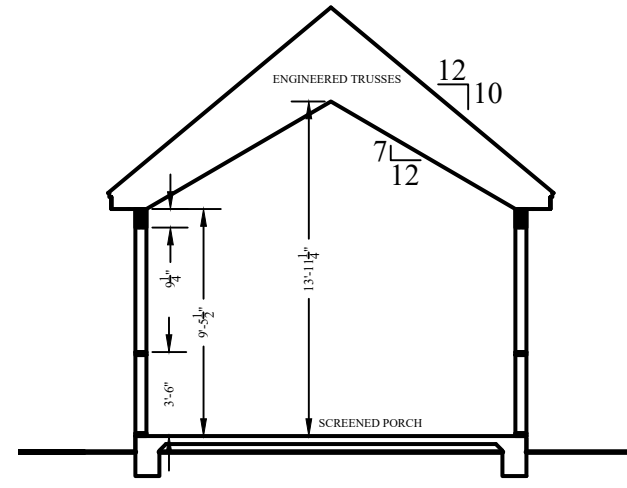


SCREENED PORCH SECTION

1/8"=1'-0"

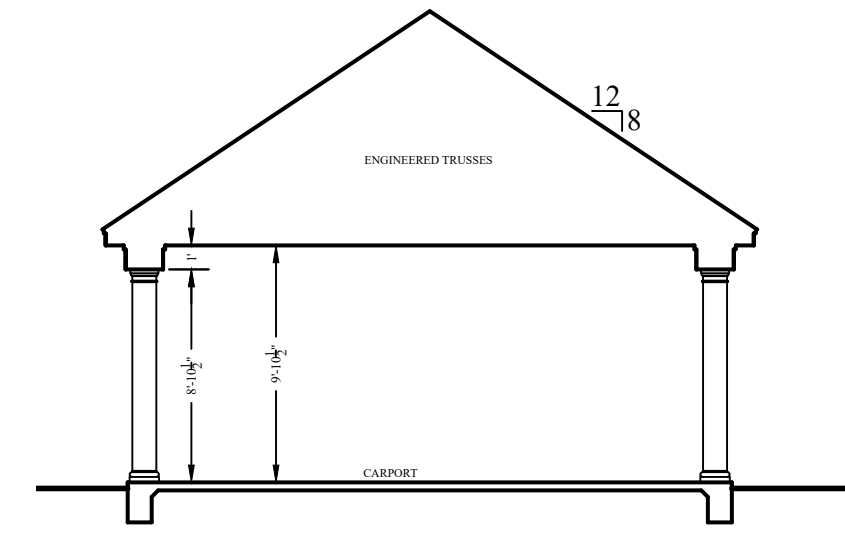


GARAGE SECTION

1/8"=1'-0"

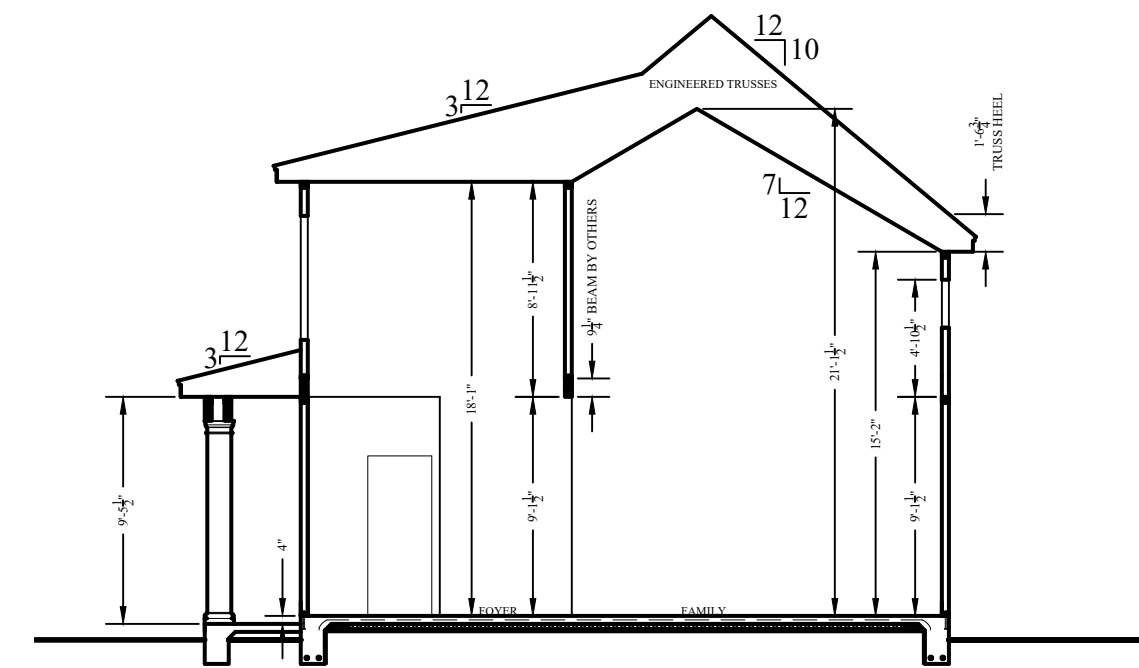

SECTION - C

1/8"=1'-0"

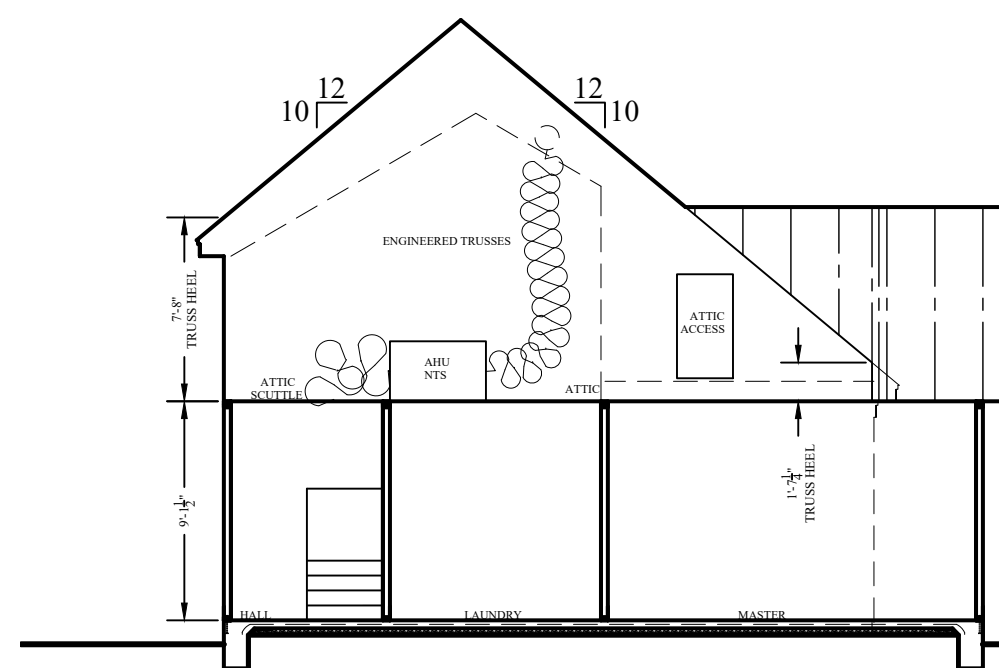


SECTION - A

1/8"=1'-0"

8'-1 1/2" PLATE HT. ---
6'-8" WINDOW HT. ---


LOFT FLOOR ---
9'-1 1/2" PLATE HT. ---
6'-8" WINDOW HT. ---

FIRST FLOOR ---

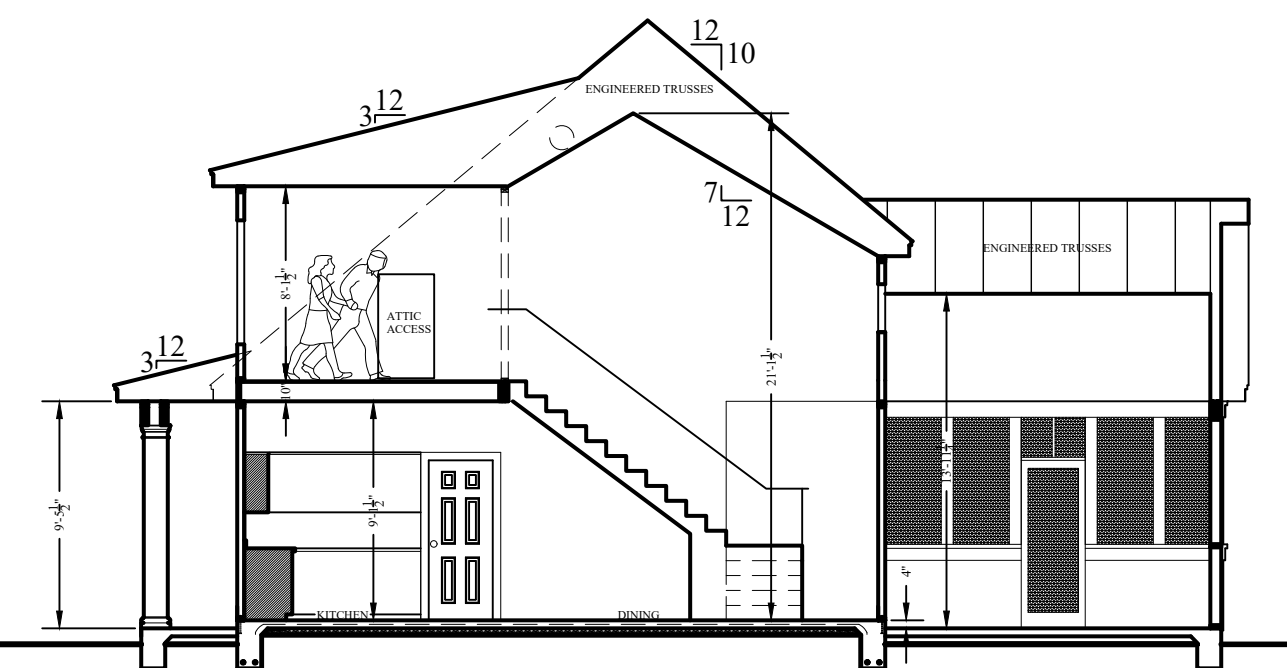


SECTION - B

1/8"=1'-0"

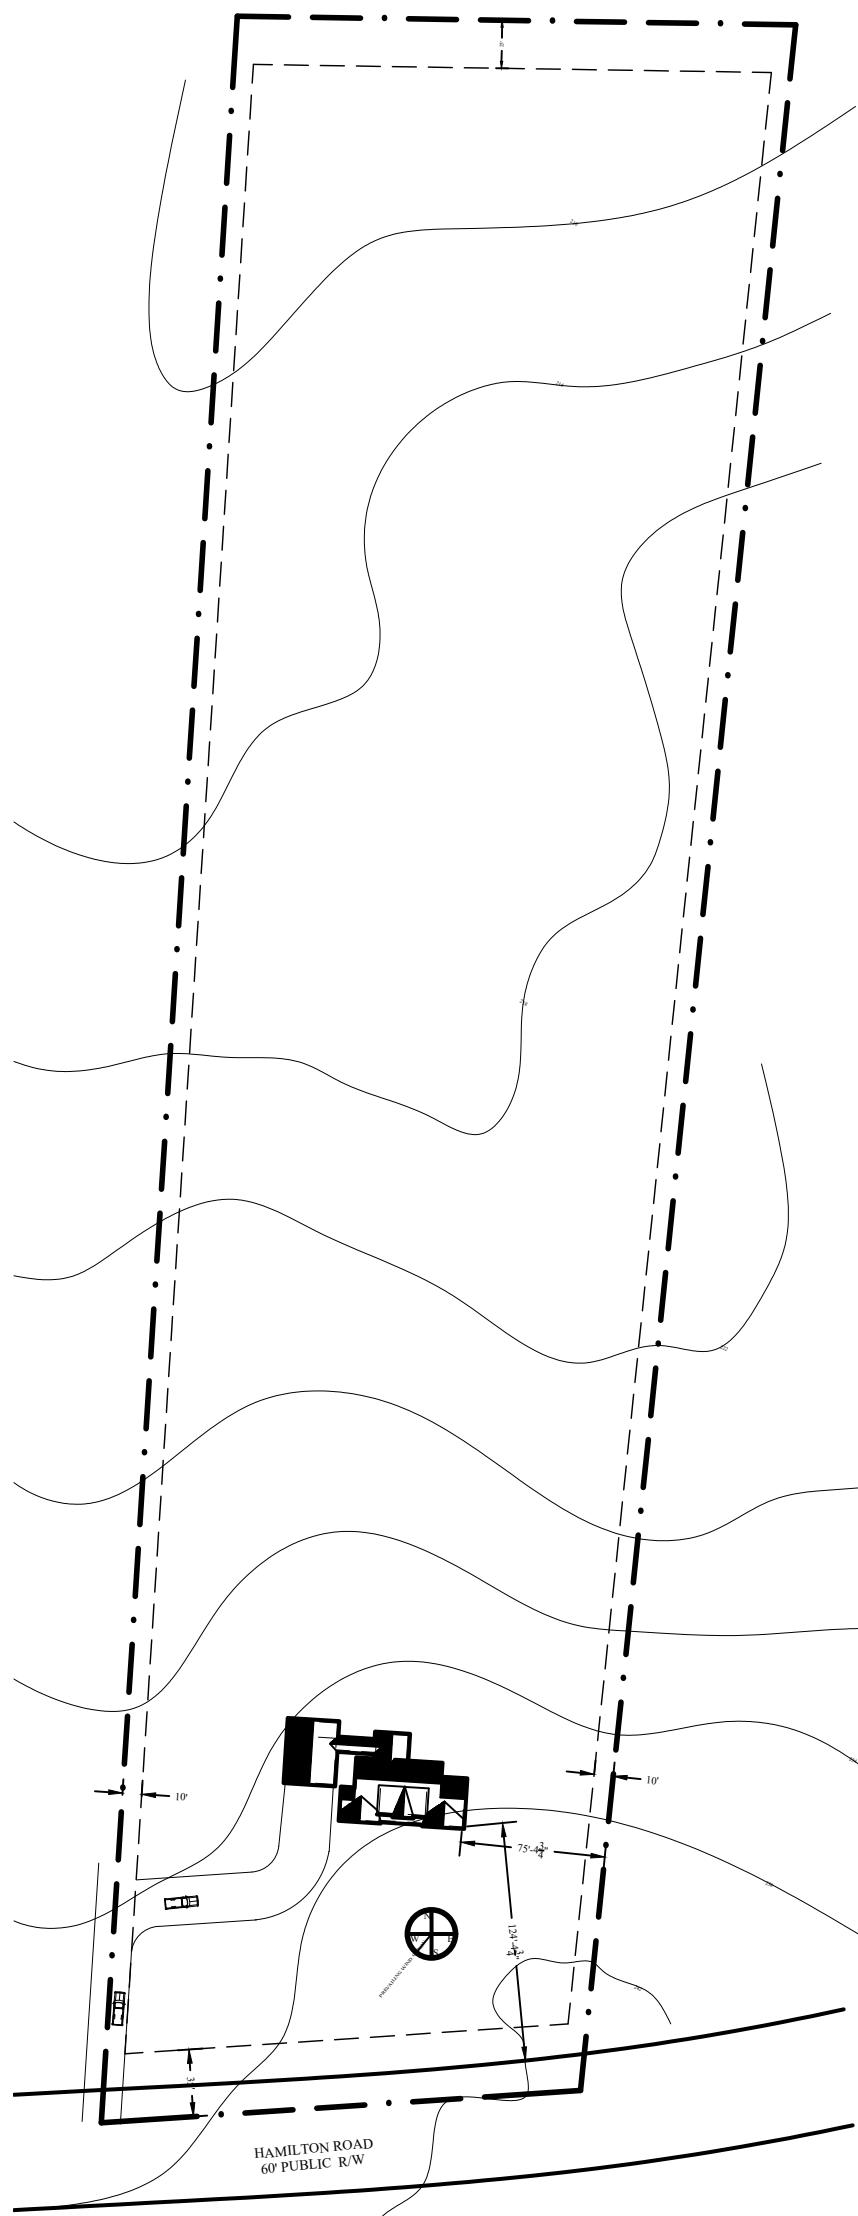



OVERALL SITE PLAN

1"=100'

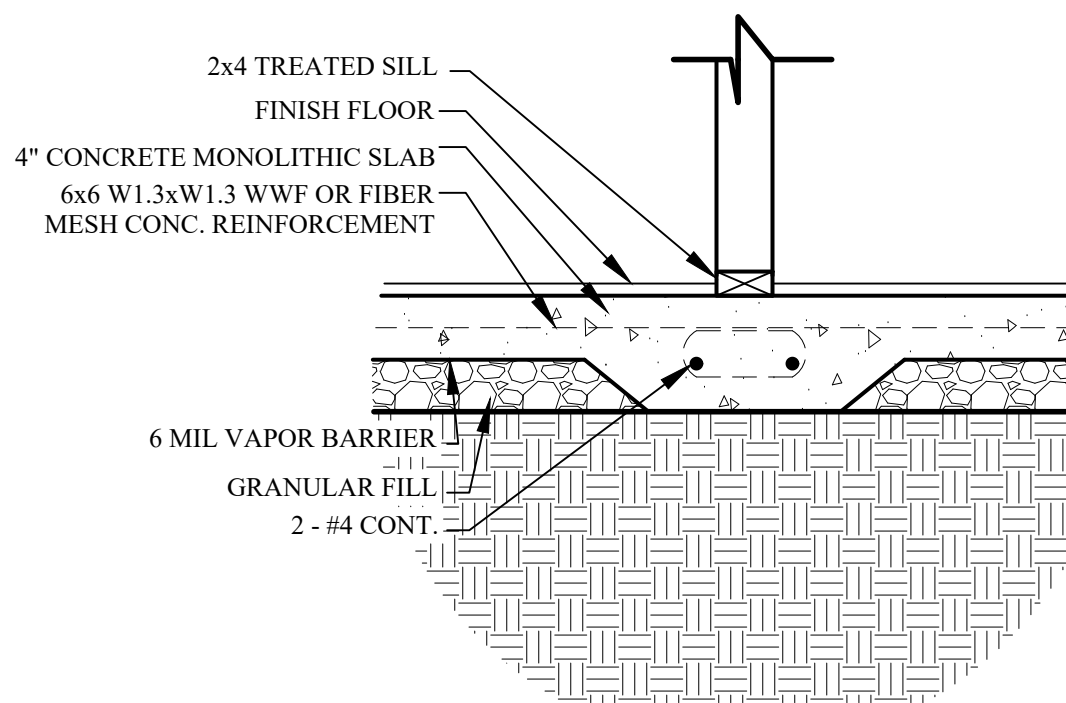

SECTION @ INTEGRAL FOOTING

1/4"=1'-0"

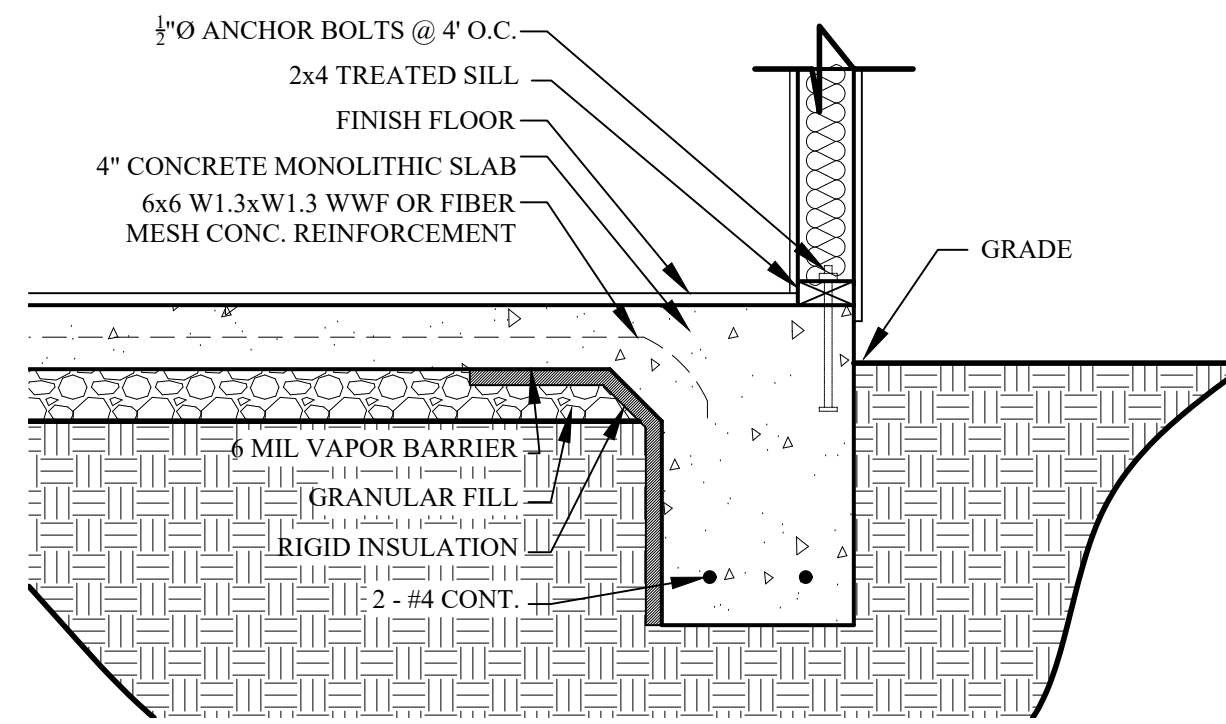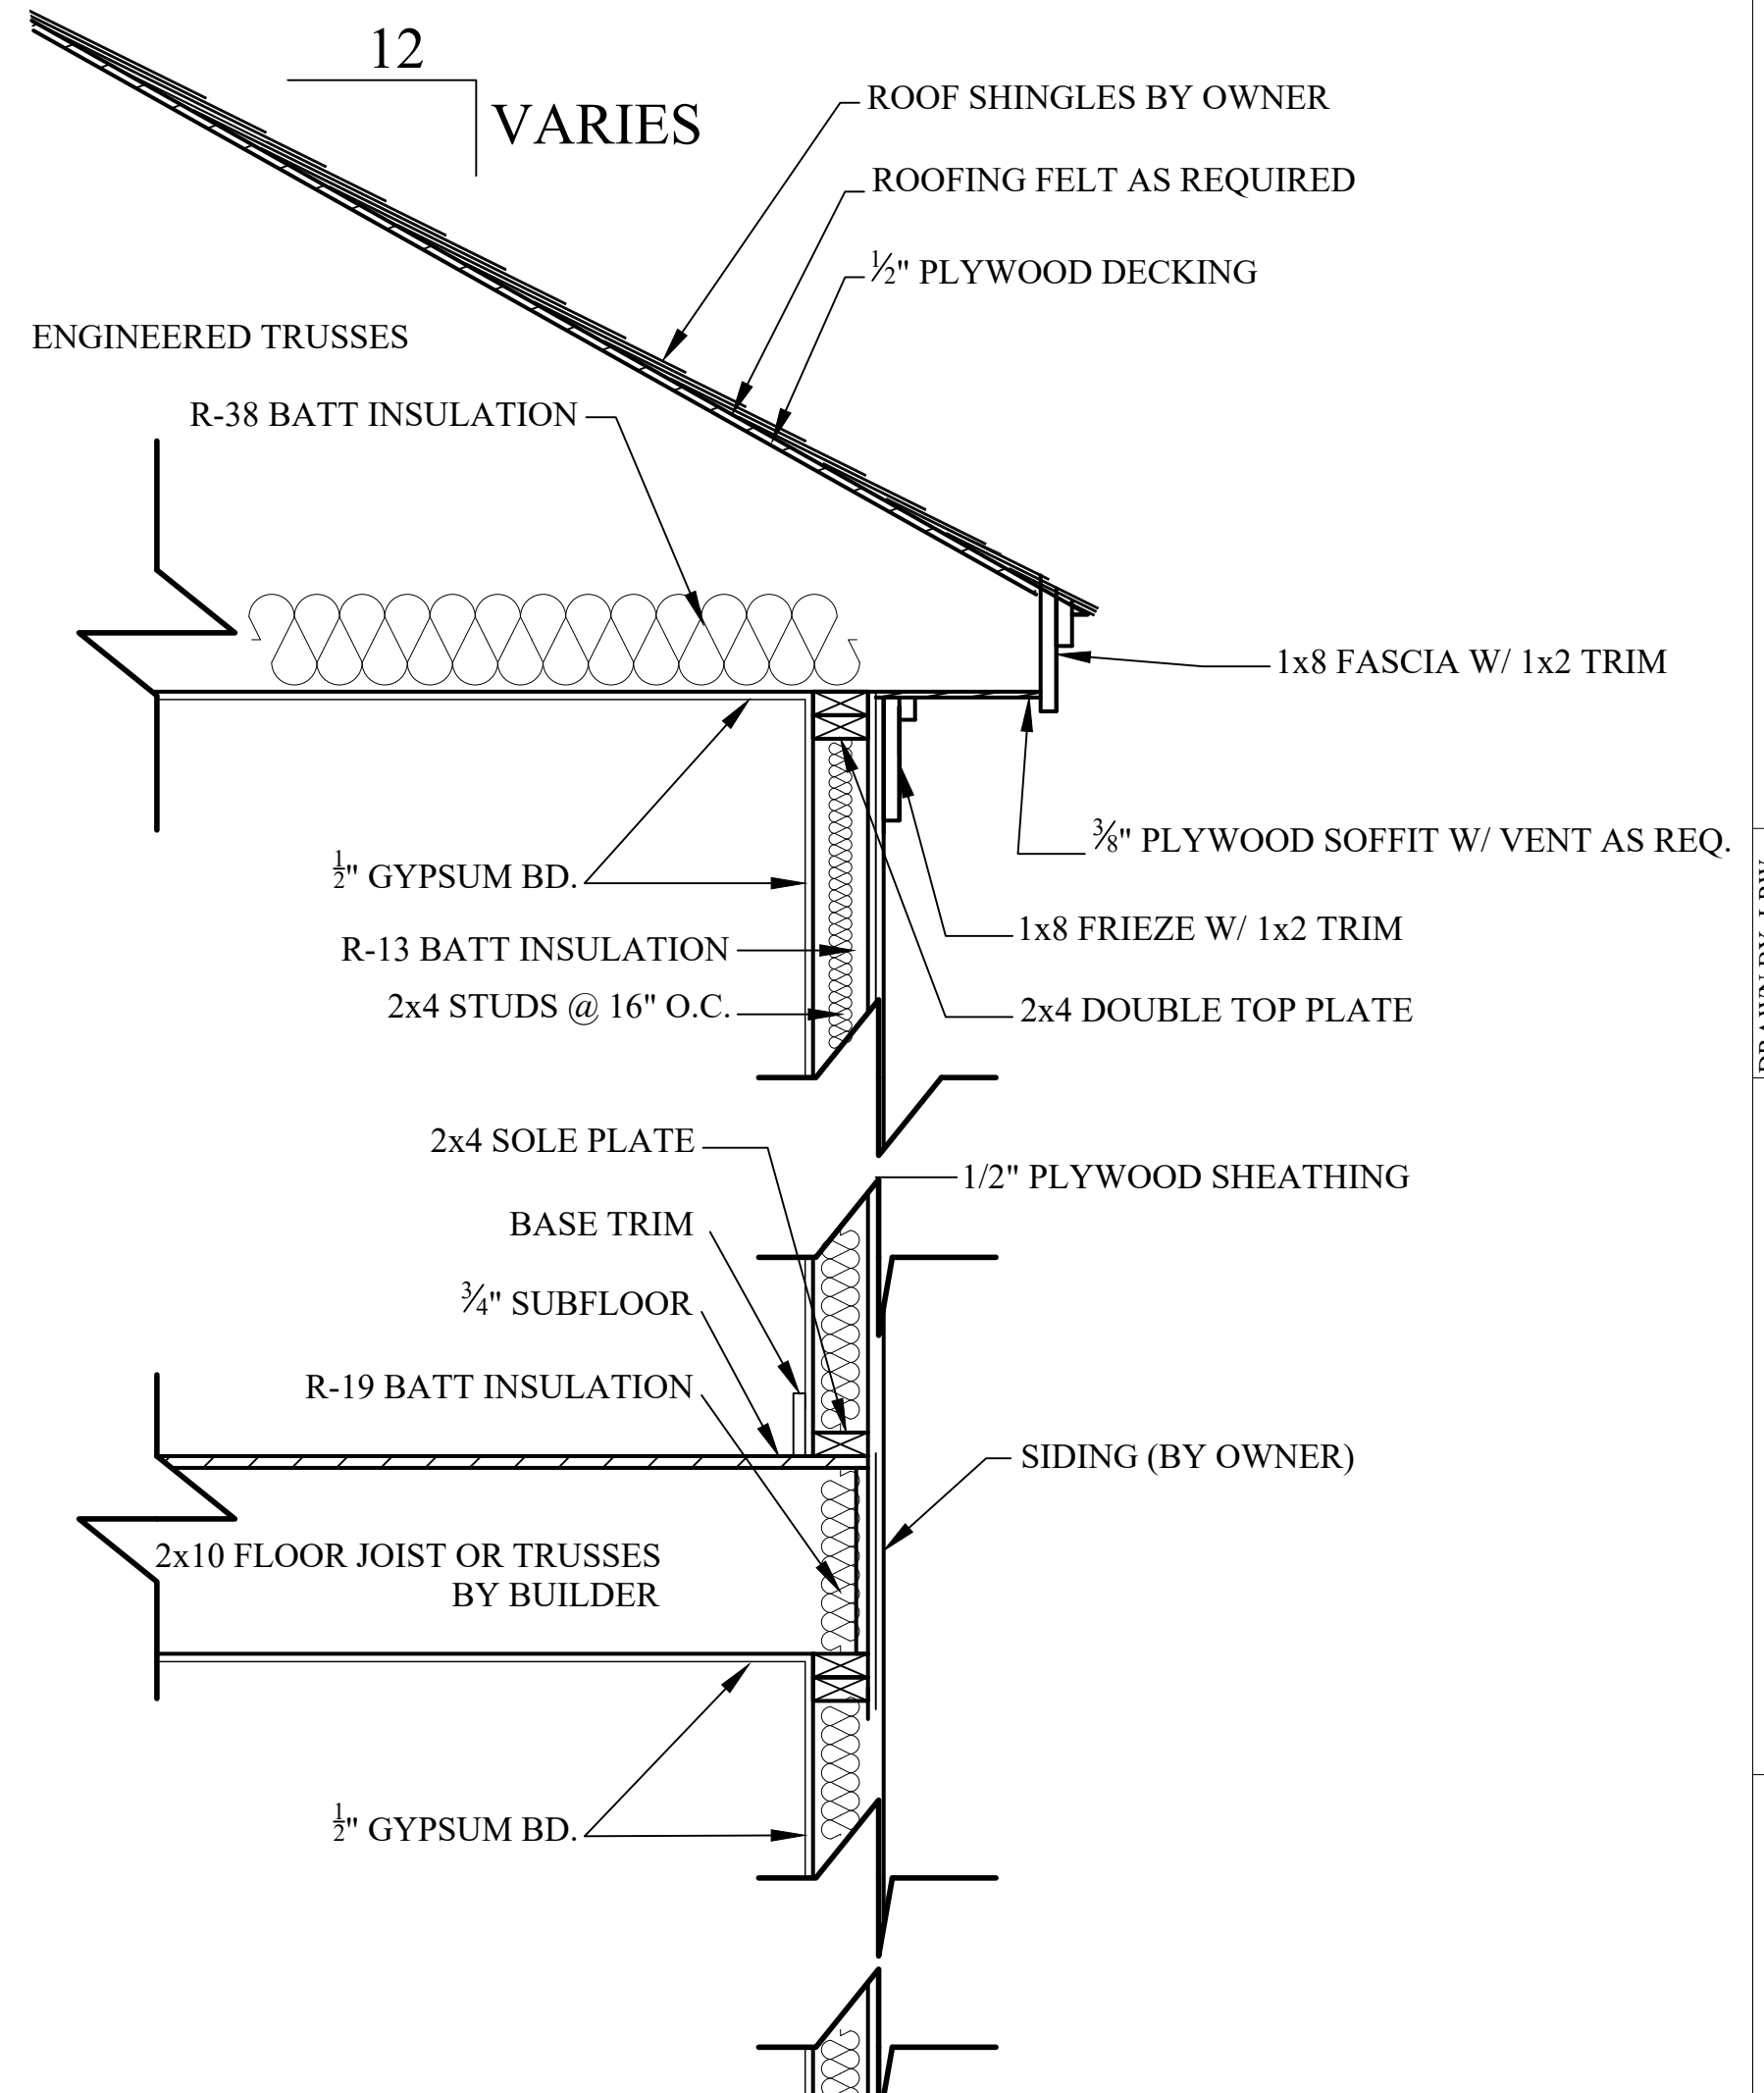

TYPICAL WALL SECTION-SIDING

1/4"=1'-0"

WHITE HOUSE BUILDING ASSOCIATES

RESIDENTIAL DESIGN, GENERAL CONTRACTING, CAD SERVICES

LARRY R. WHITE - DESIGNER
 PHONE: 910-978-5195
 E-MAIL: SUREDWELLINGS@GMAIL.COM
 FAYETTEVILLE, NORTH CAROLINA

DRAWN BY: LRW
 DATE: 29-Dec-19
 REVISED:
 SCALE: AS NOTED

DETAILS

CONTRACTOR/BUILDER SHALL ENSURE COMPLIANCE WITH MUNICIPAL BUILDING CODE. ANY ERRORS OR OMISSIONS SHALL BE BROUGHT TO THE ATTENTION OF THE DESIGNER BEFORE CONSTRUCTION BEGINS. ALL LUMBER AND BEAM SPANS SHALL BE VERIFIED BY CONTRACTOR/BUILDER. TO INCLUDE ENGINEER'S EVALUATION IF REQUIRED.

SPOON RESIDENCE



LOT 2 HAMILTON ROAD
 BUNNLEVEL, NORTH CAROLINA

R7

7 OF 8

LEGEND

- \$ SINGLE POLE SWITCH
- ⊞ DIMMER
- ⊞ 3 WAY SWITCH
- ⊞ CEILING FAN
- ▼ DATA OUTLET
- CEILING FIXTURE
- WALL FIXTURE
- RECESSED LIGHT
- FLUORESCENT FIXTURE
- ⊞ DUPLEX OUTLET
- ⊞ 240V OUTLET
- ⊞ GFI
- GFI CIRCUIT

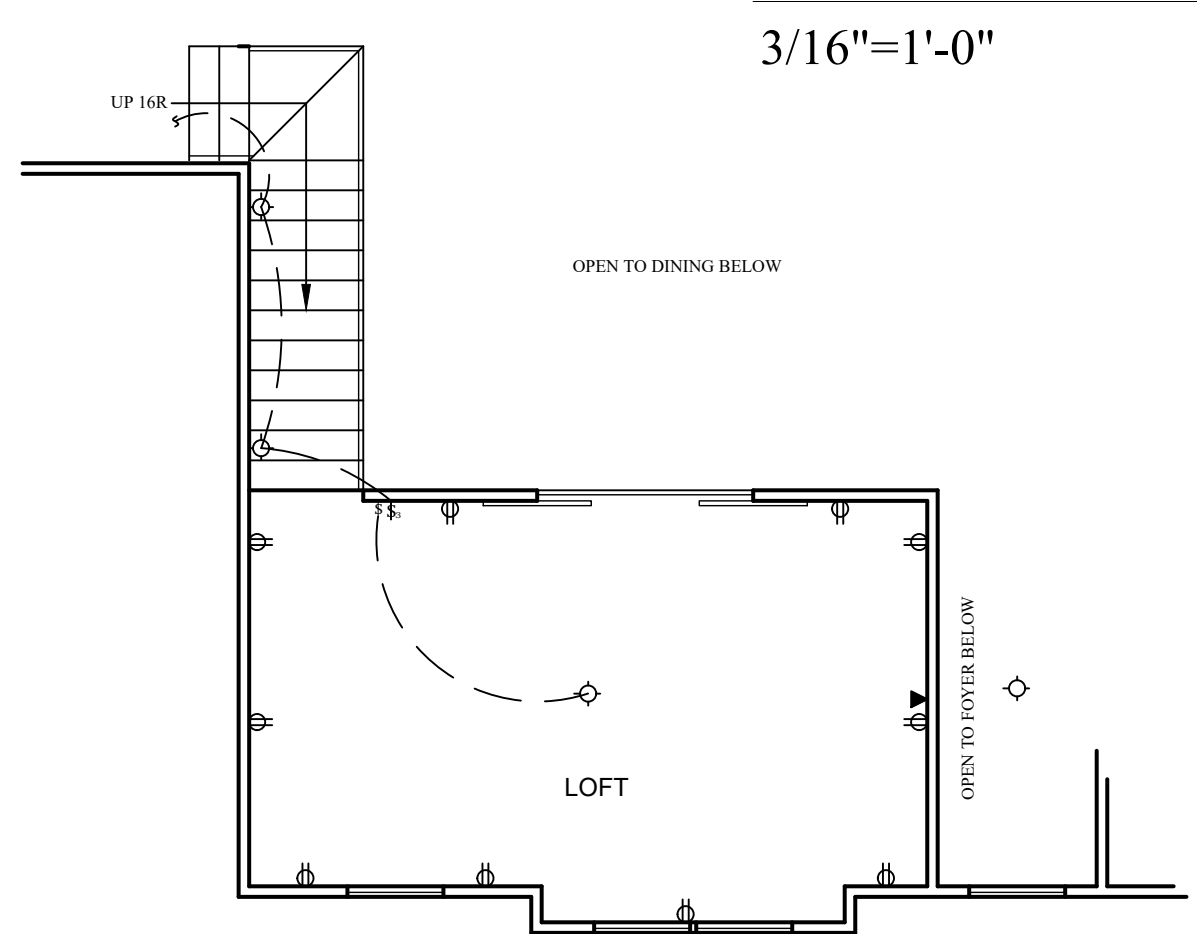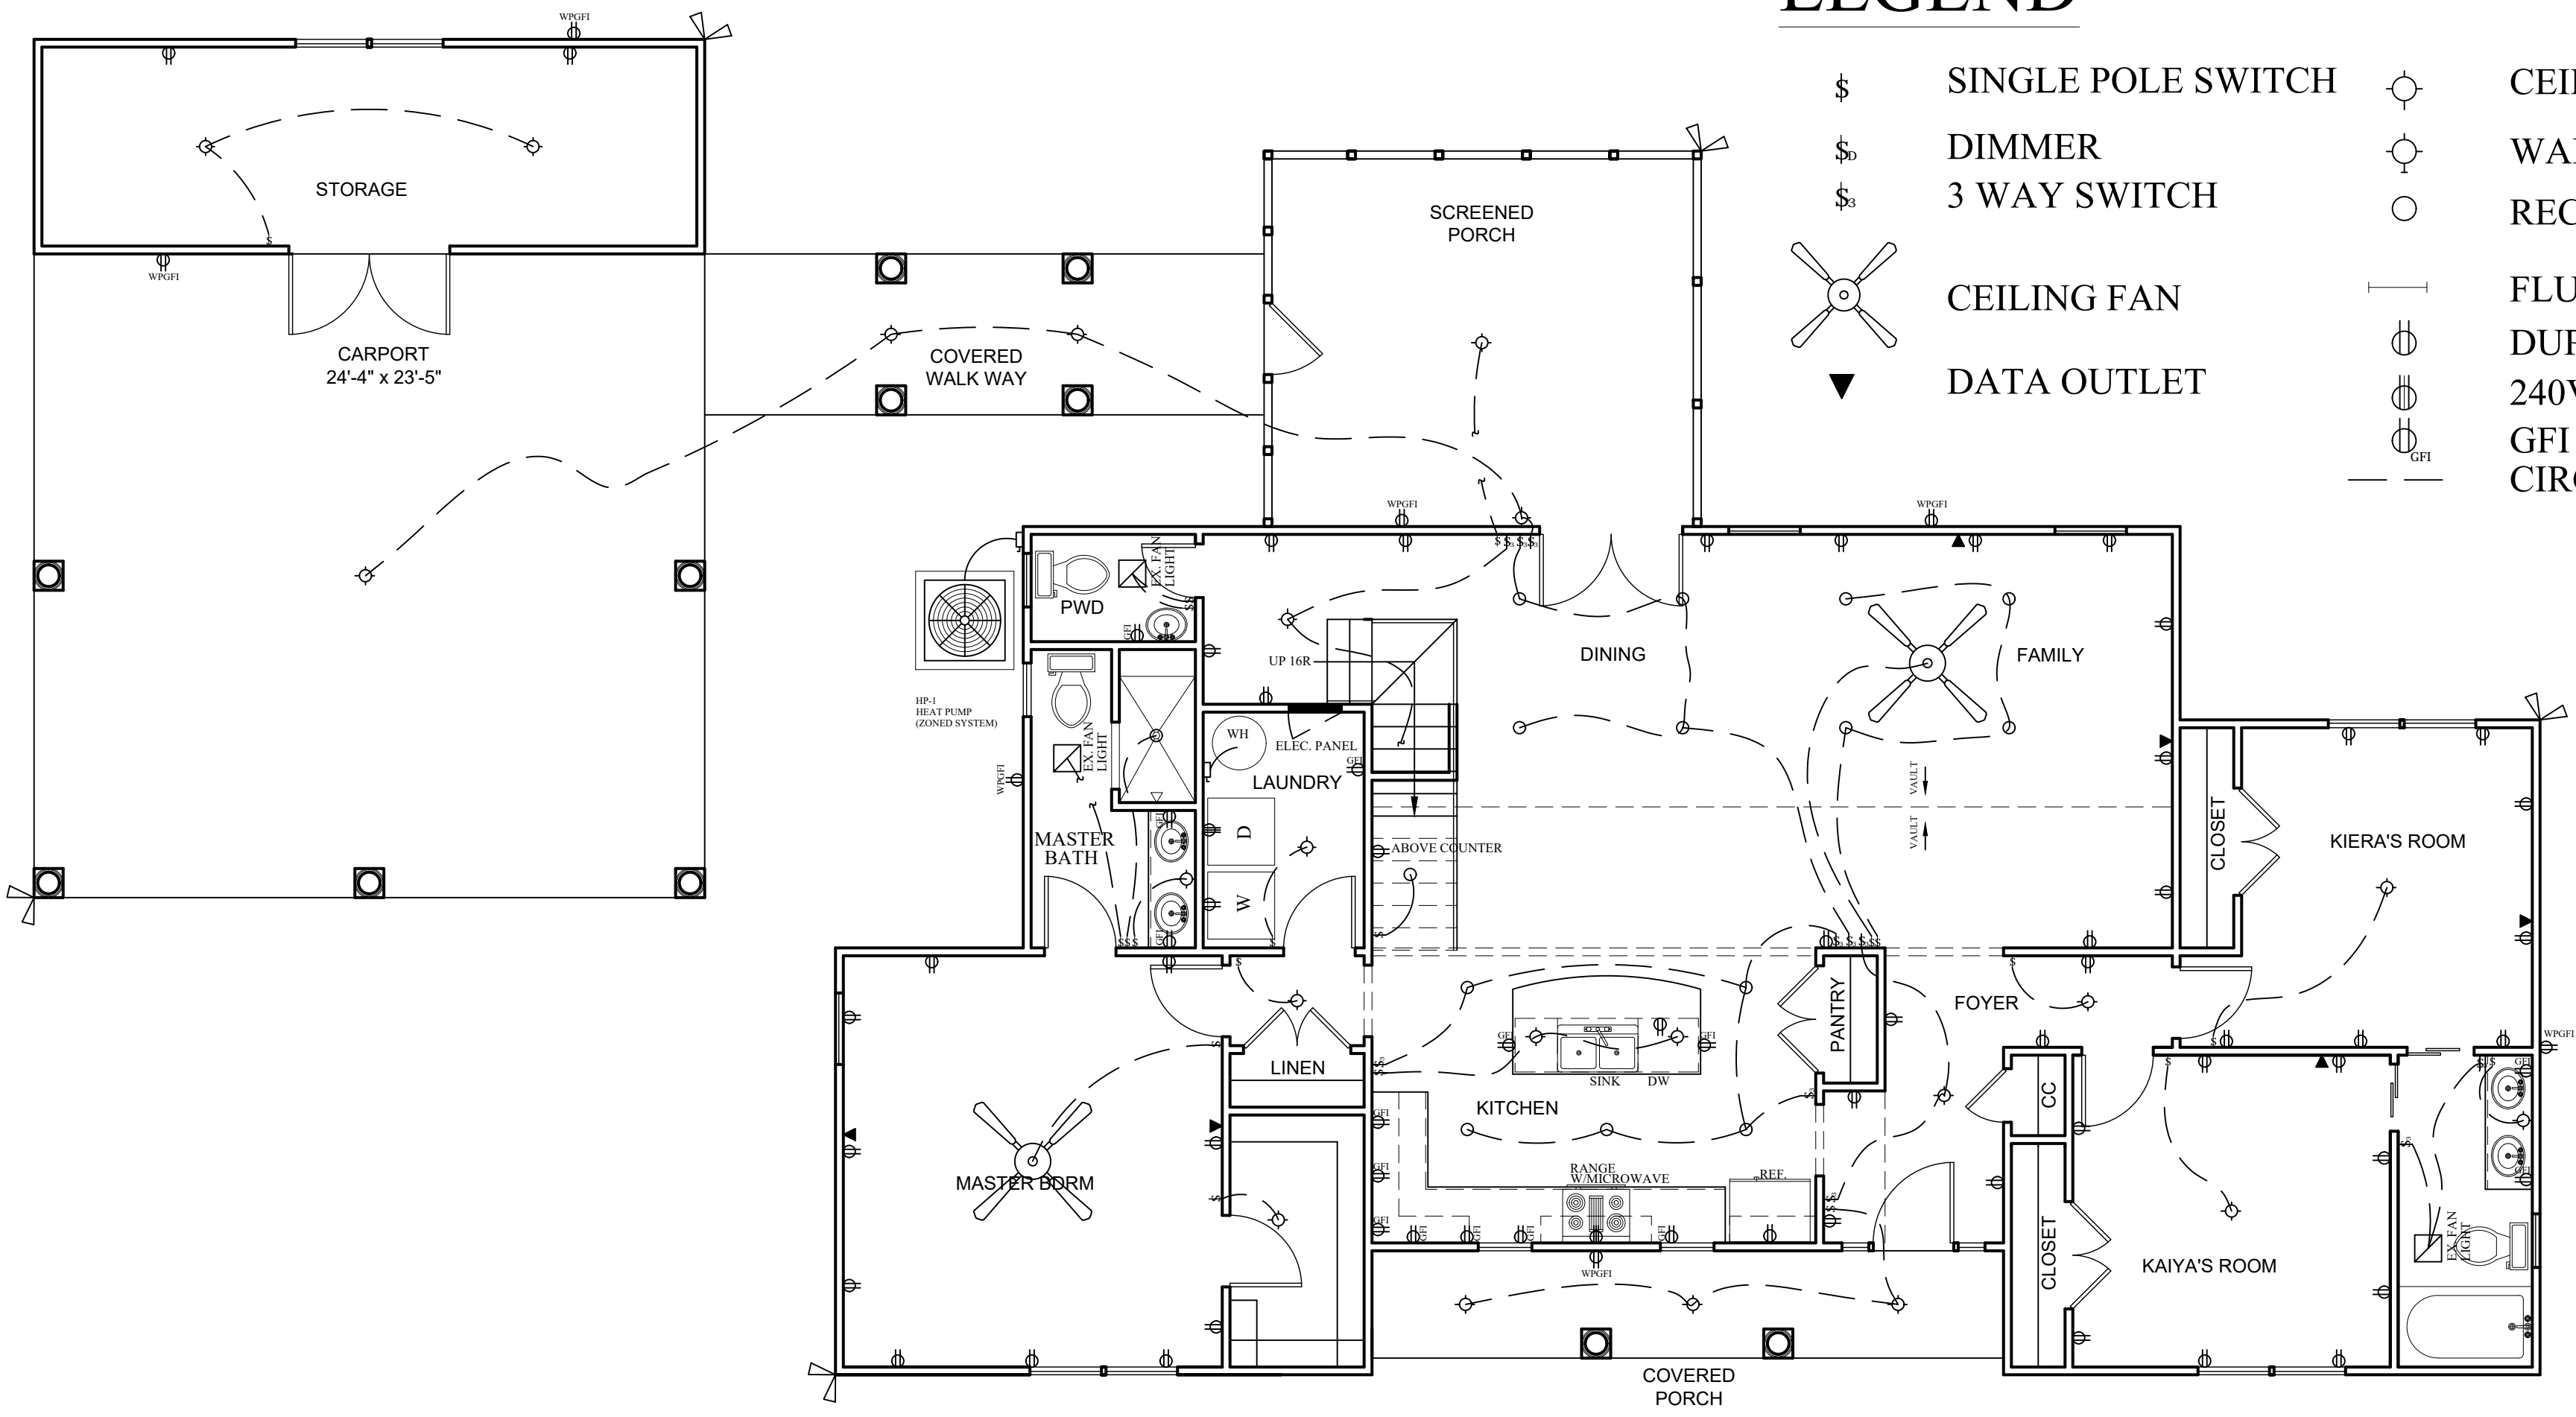

ELECTRICAL PLANS

3/16"=1'-0"

R8	SPoon RESIDENCE	WHITE HOUSE BUILDING ASSOCIATES RESIDENTIAL DESIGN, GENERAL CONTRACTING, CAD SERVICES LARRY R. WHITE - DESIGNER PHONE: 910-978-5195 E-MAIL: SUREDWELLINGS@GMAIL.COM FAYETTEVILLE, NORTH CAROLINA
8 OF 8	ELECTRICAL PLAN	DRAWN BY: LRW DATE: 29-Dec-19 REVISIONS: SCALE: AS NOTED <small>CONTRACTOR/BUILDER SHALL ENSURE COMPLIANCE WITH MUNICIPAL BUILDING CODE. ANY ERRORS OR OMISSIONS SHALL BE BROUGHT TO THE ATTENTION OF THE DESIGNER BEFORE CONSTRUCTION BEGINS. ALL LUMBER AND BEAM SPANS SHALL BE VERIFIED BY CONTRACTOR/BUILDER. TO INCLUDE ENGINEER'S EVALUATION IF REQUIRED.</small>
	LOT 2 HAMILTON ROAD BUNNLEVEL, NORTH CAROLINA	