


101 Front Elevation


Scale: 1/4" = 1'-0"

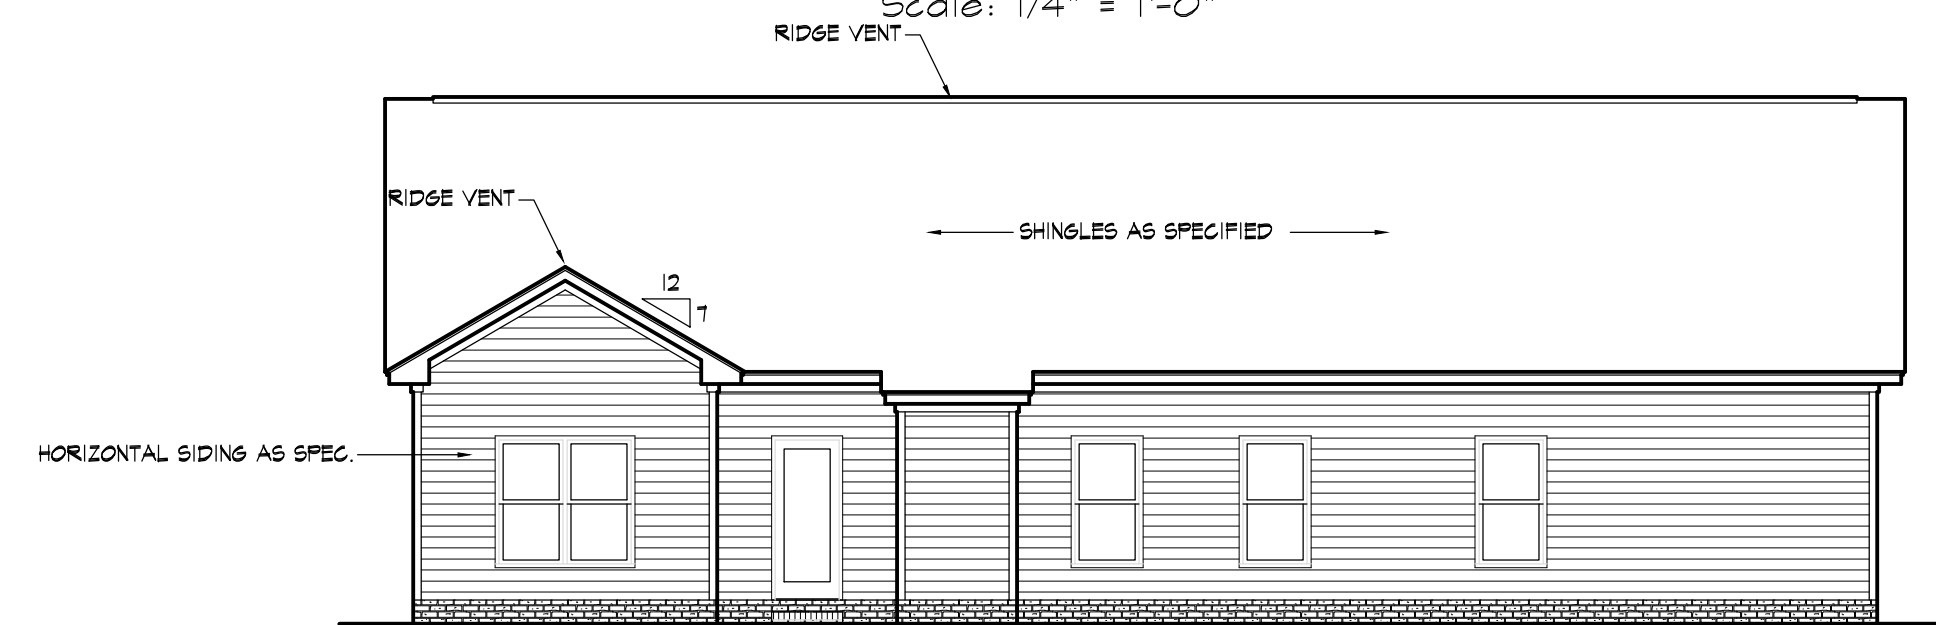

102 Rear Elevation


Scale: 1/8" = 1'-0"

Area Tabulations	
Main Floor Htd.	1723 SQ. FT.
Bonus Room Htd.	264 SQ. FT.
Total Htd.	1987 SQ. FT.
Garage	495 SQ. FT.
Front Porch	143 SQ. FT.
Total Unhtd.	638 SQ. FT.
Total Area	2625 SQ. FT.

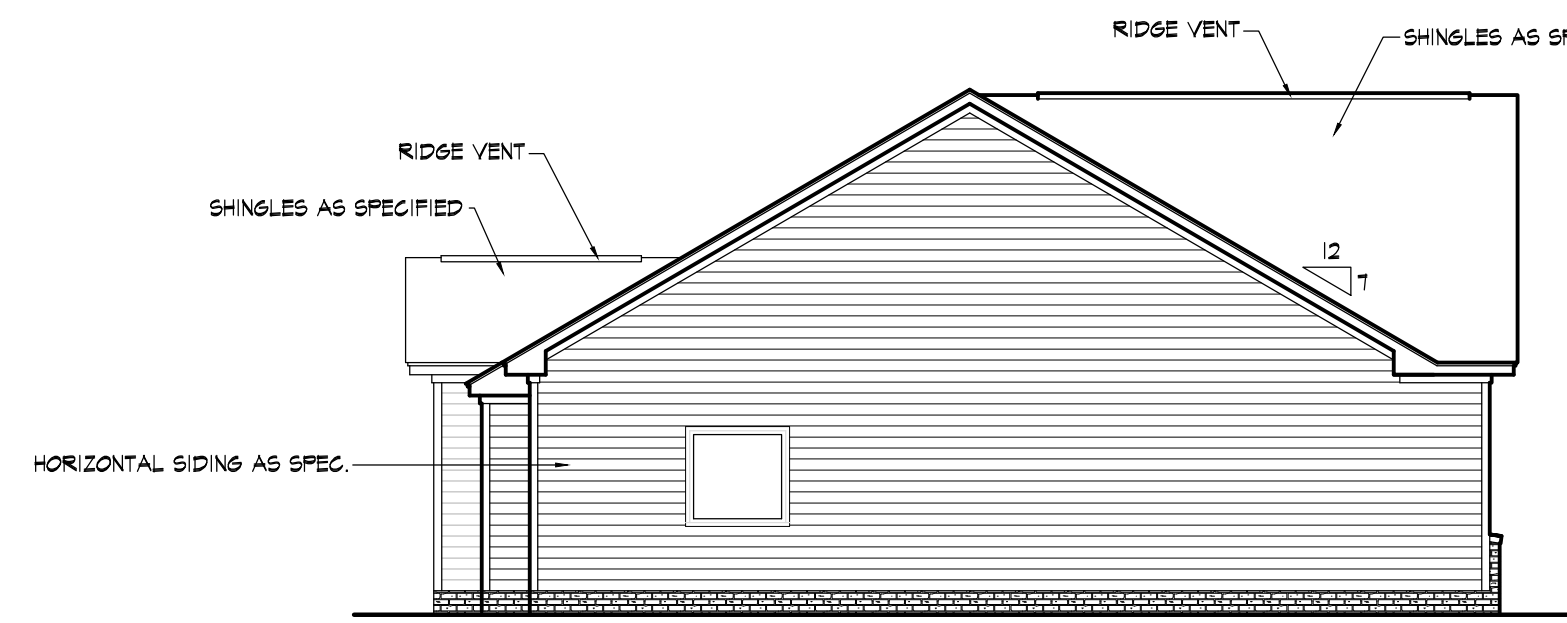

103 Left Elevation

Scale: 1/8" = 1'-0"

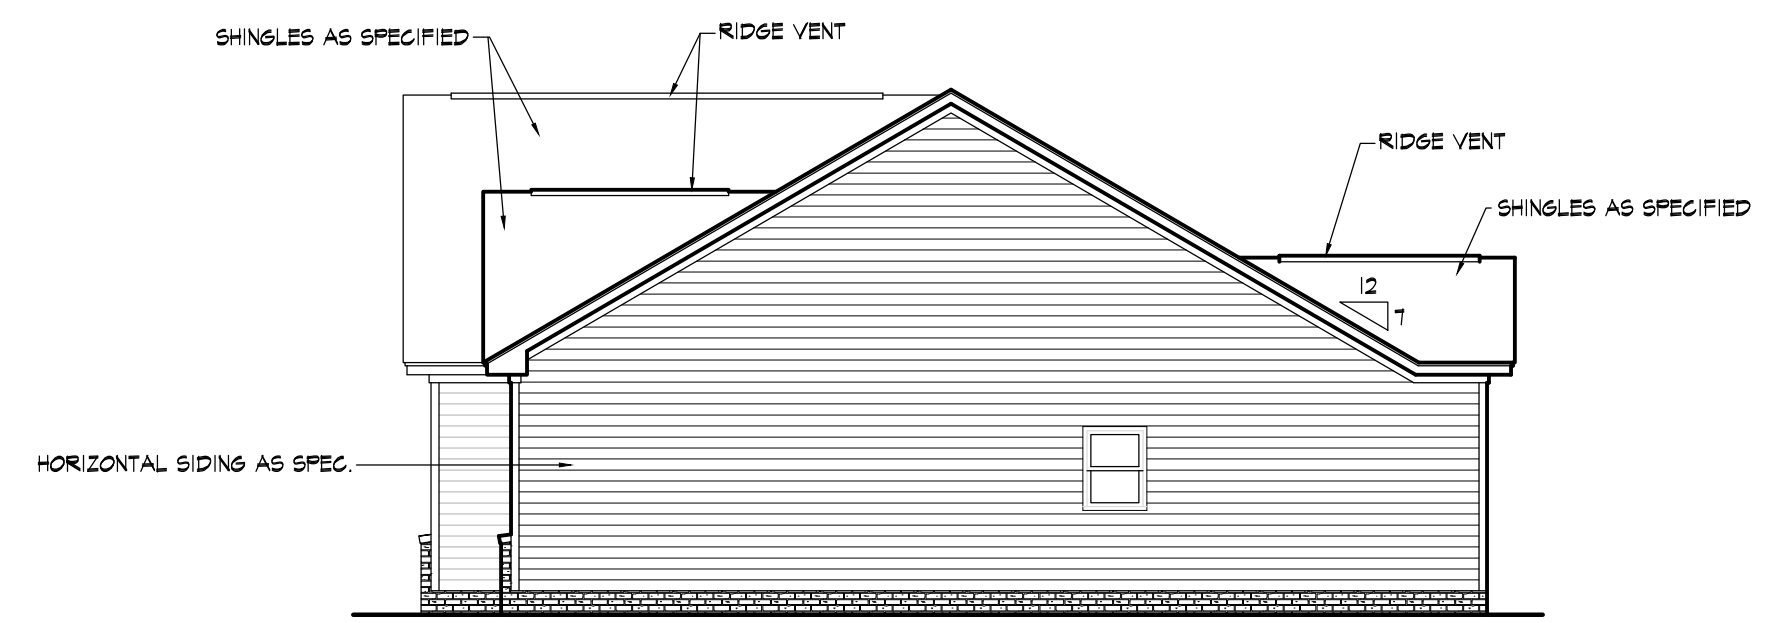


104 Right Elevation

Scale: 1/8" = 1'-0"

Revisions
 Reversed
 Sept. 21, 2020

Scale:
 as shown
 Date:
 September 2020

Sheet No.
 |

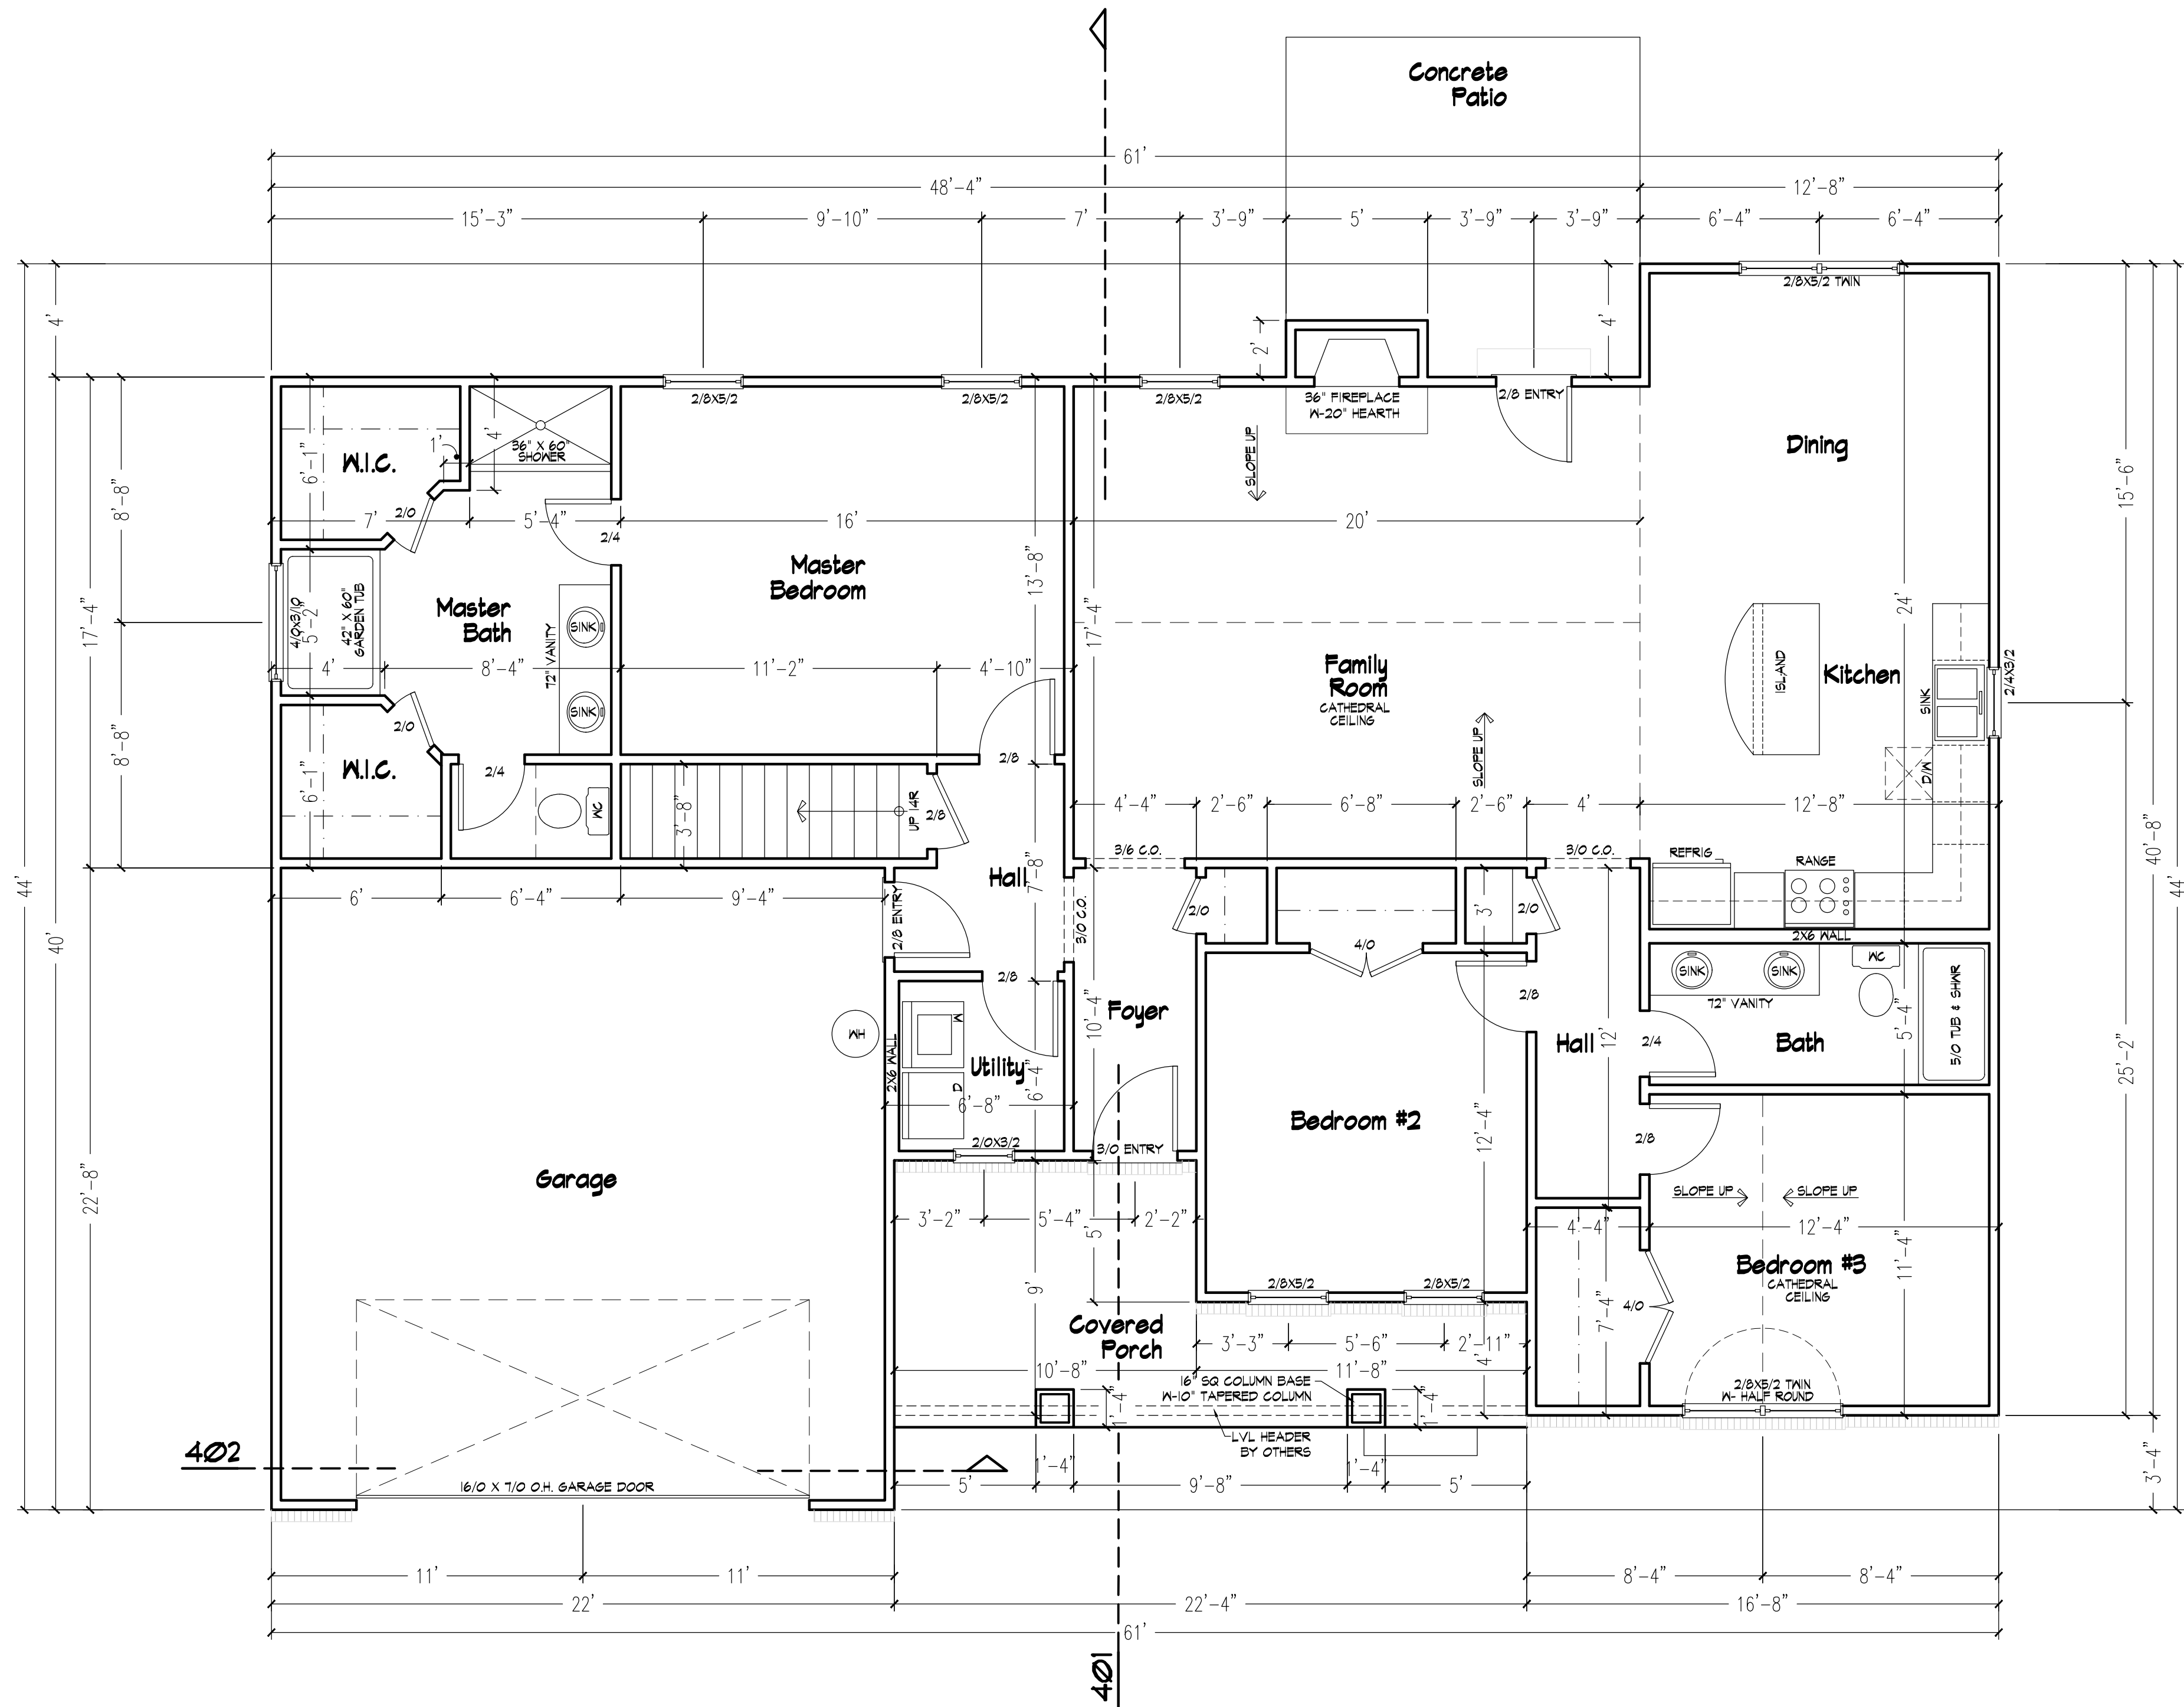

201 Main Floor Plan

Scale: 1/4" = 1'-0"

Project Title
The Lindsay


Sheet Title
Main Floor Plan

Revisions
Reversed
Sept. 21, 2020


Scale:
as shown
Date:
September 2020

Sheet No.

2

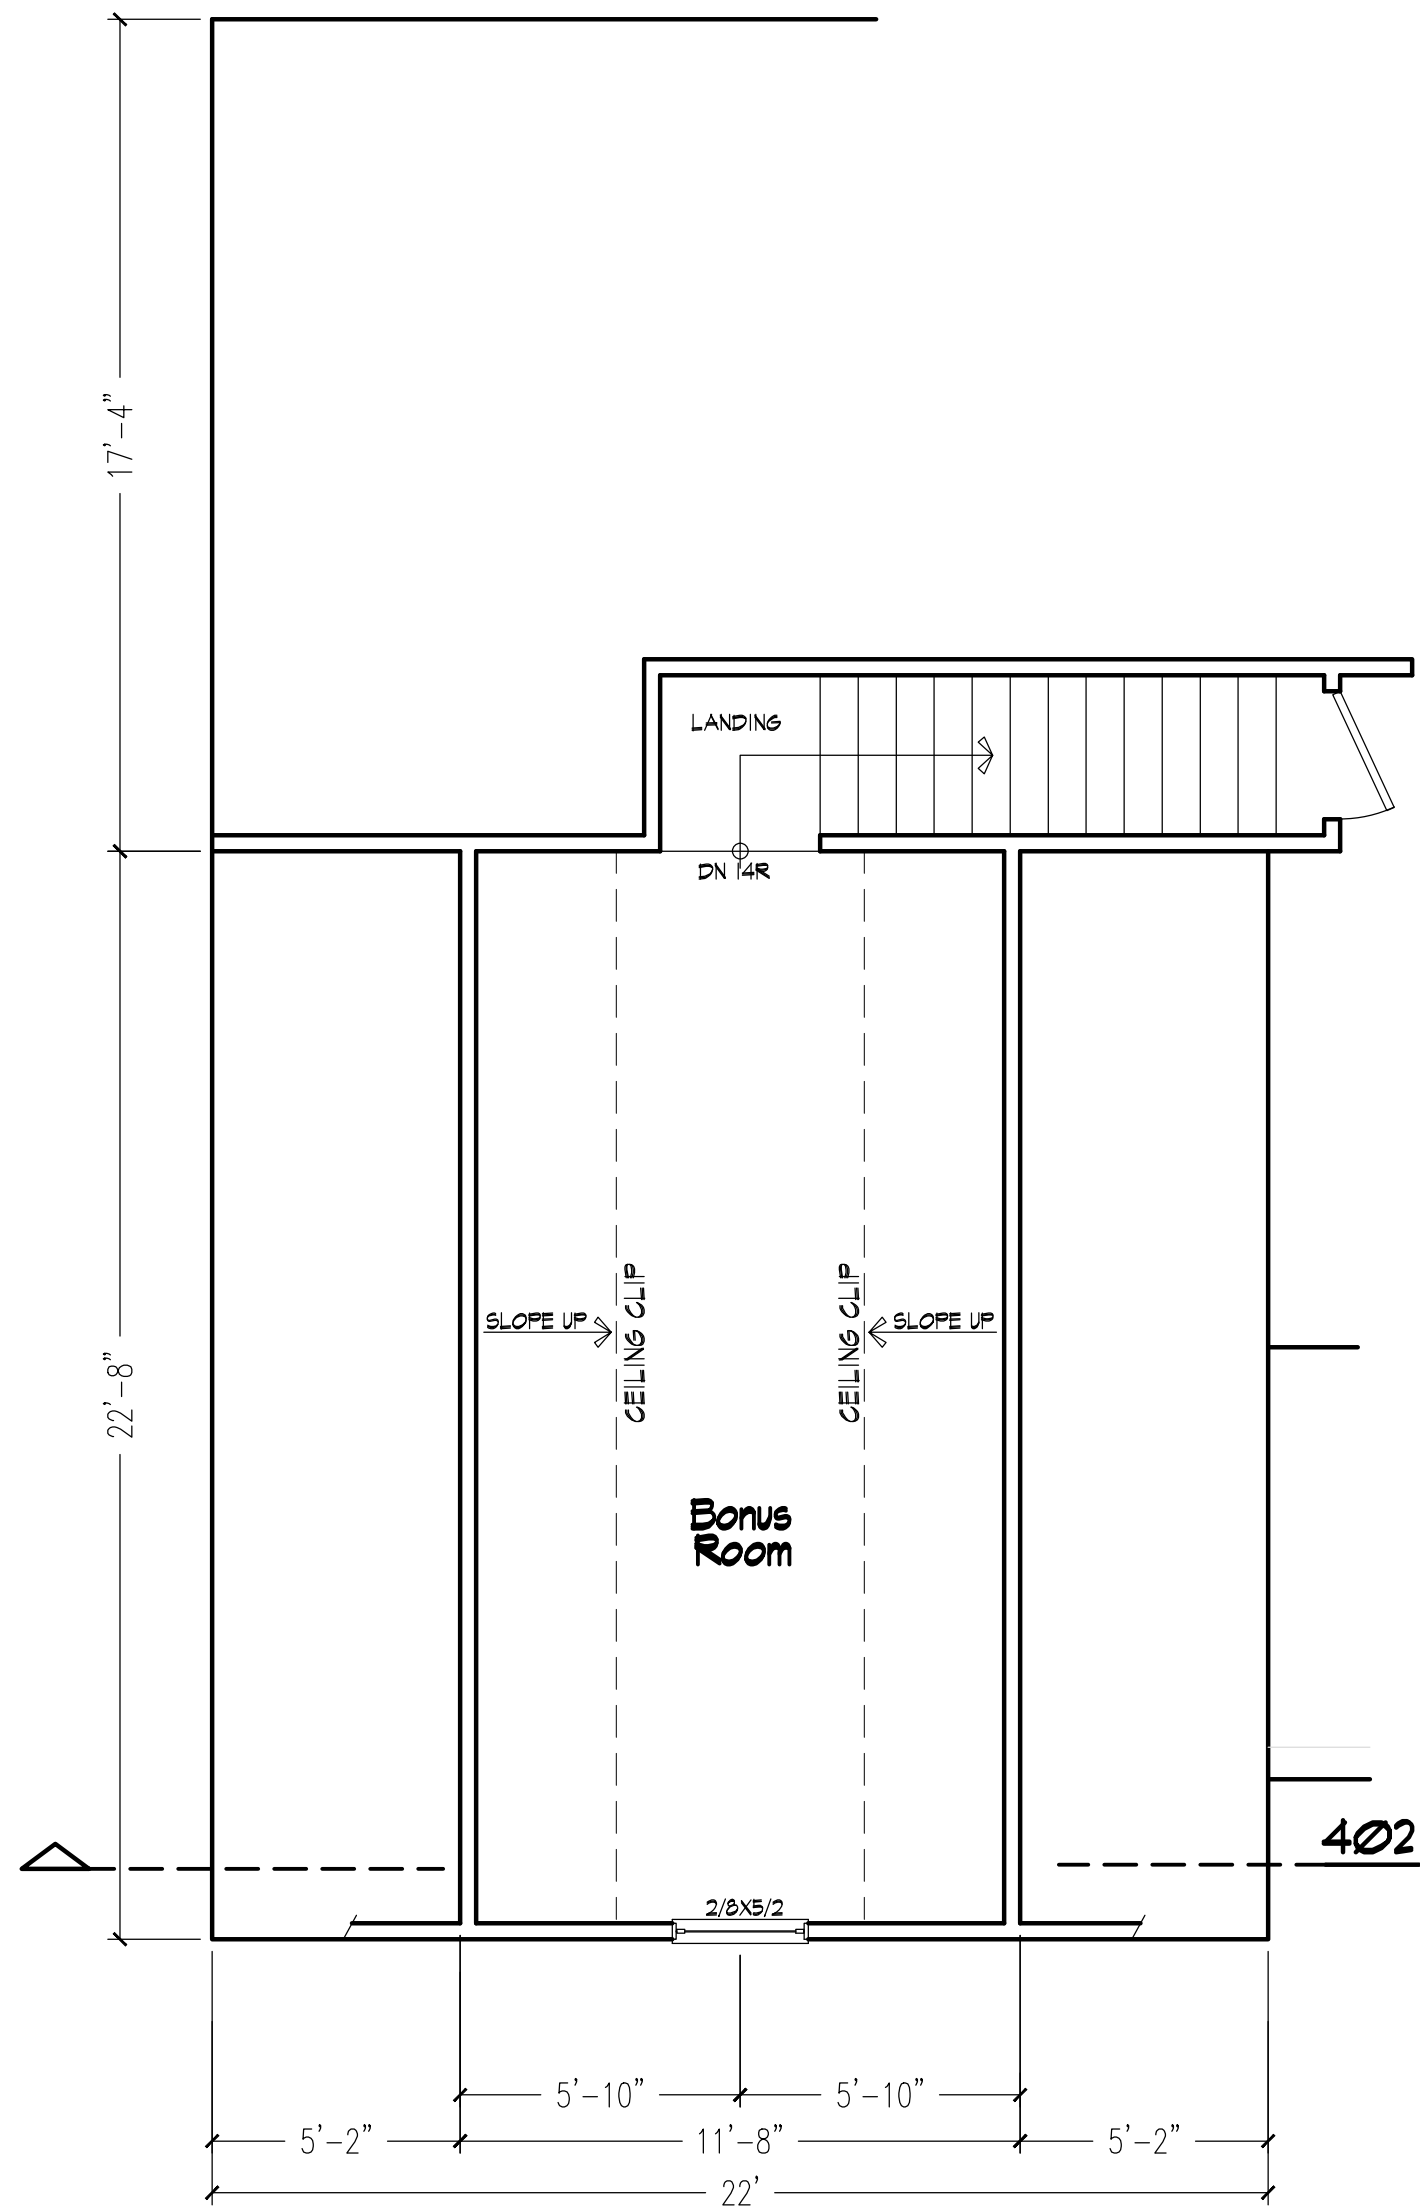

301 Bonus Room Floor Plan
 Scale: 1/4" = 1'-0"

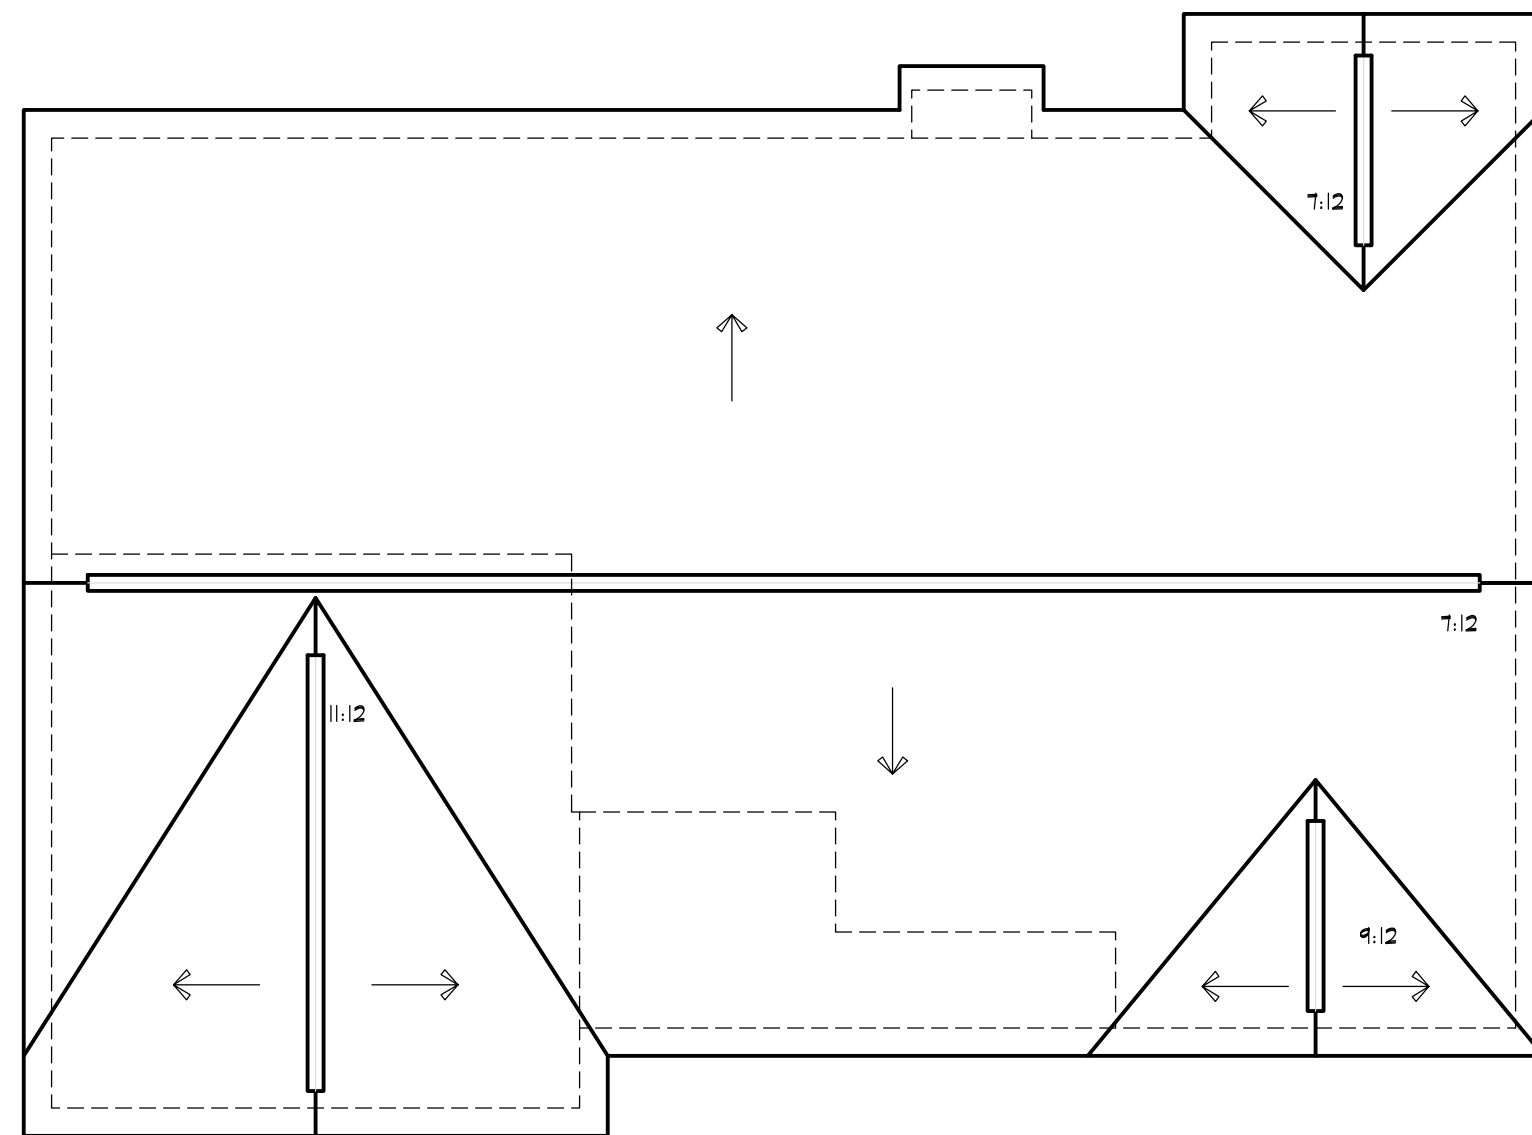


302 Roof Plan
 Scale: 1/8" = 1'-0"


Revisions
 Reversed
 Sept. 21, 2020

Scale:
 as shown
 Date:
 September 2020


Sheet No.
3

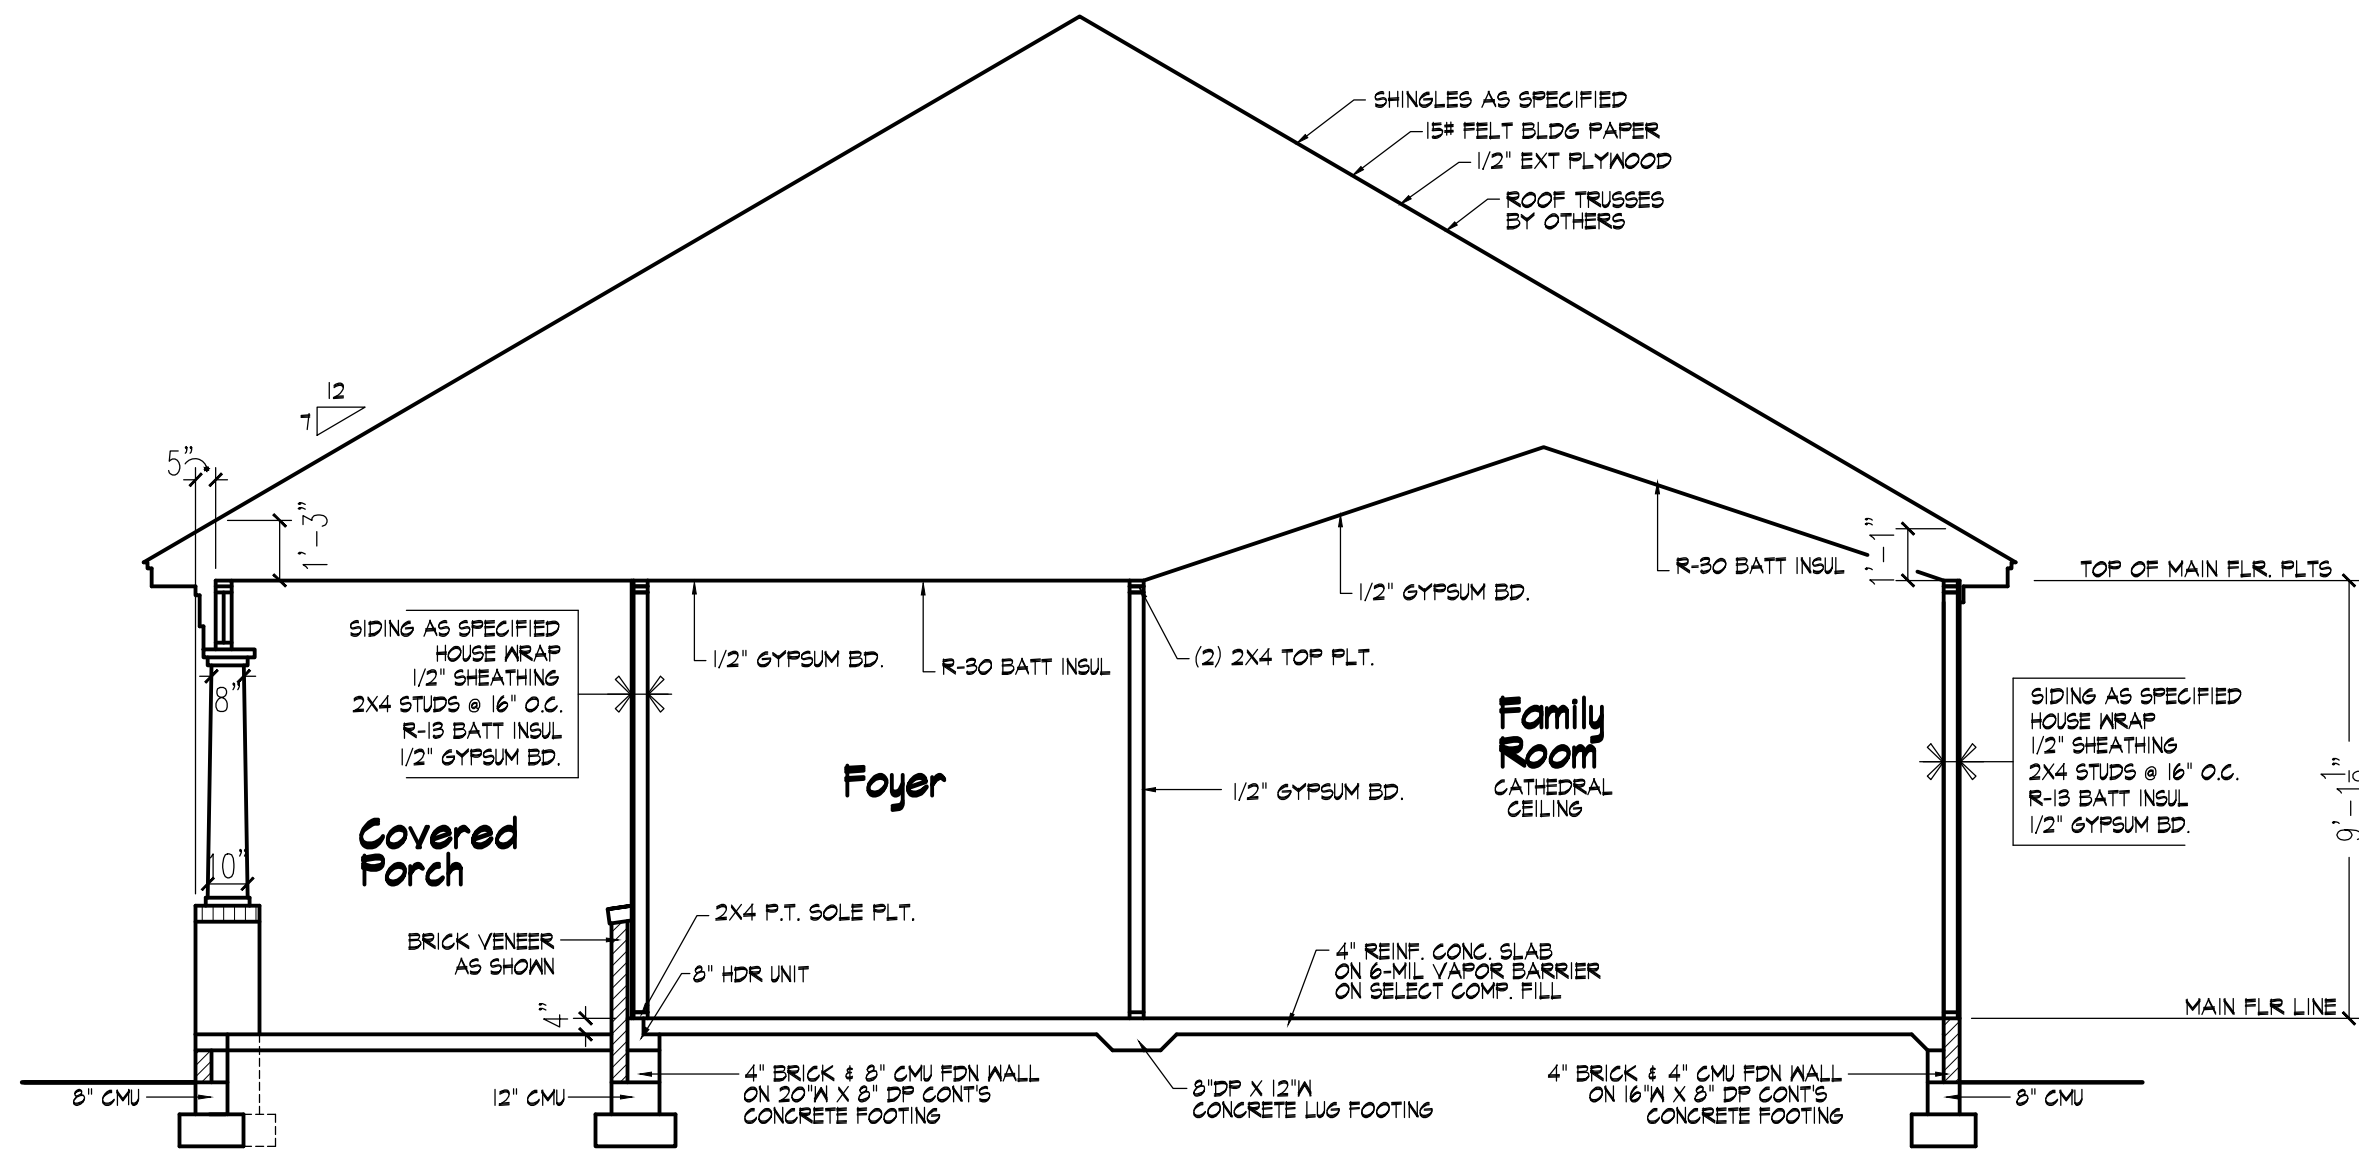

401 Building Section
Scale 1/4" = 1'-0"

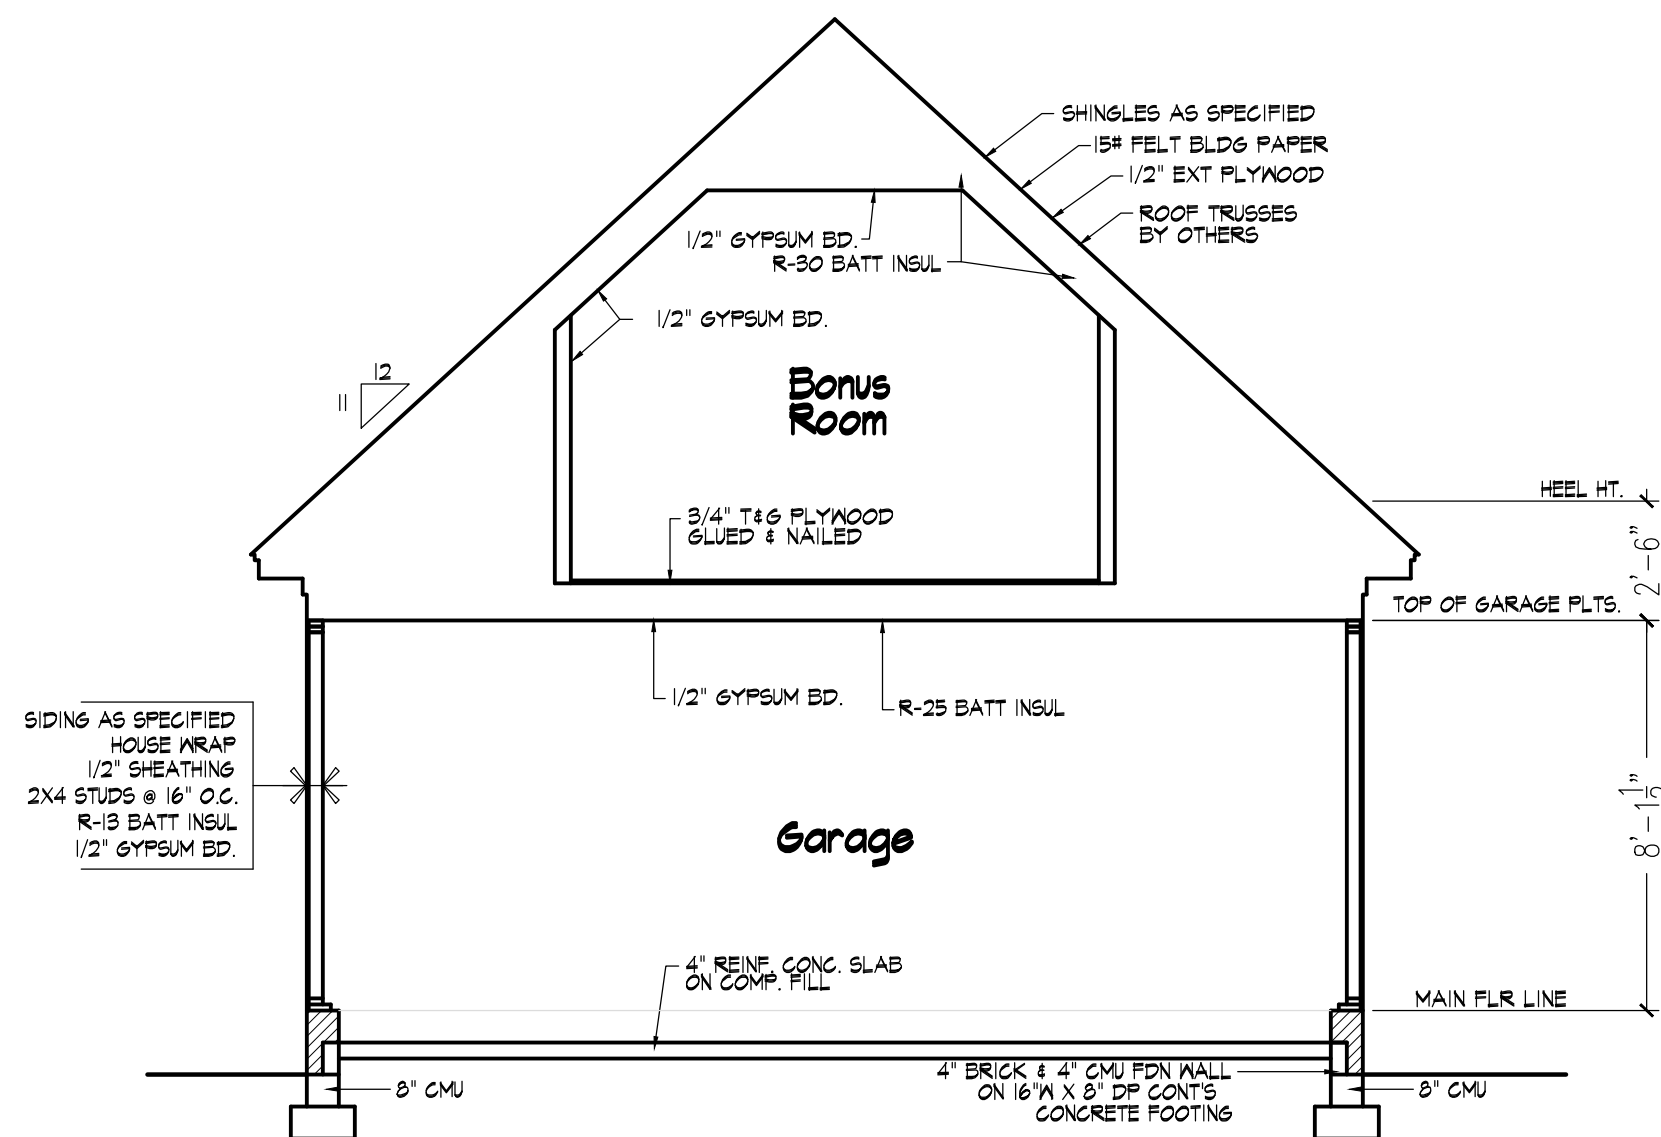


402 Building Section
Scale 1/4" = 1'-0"

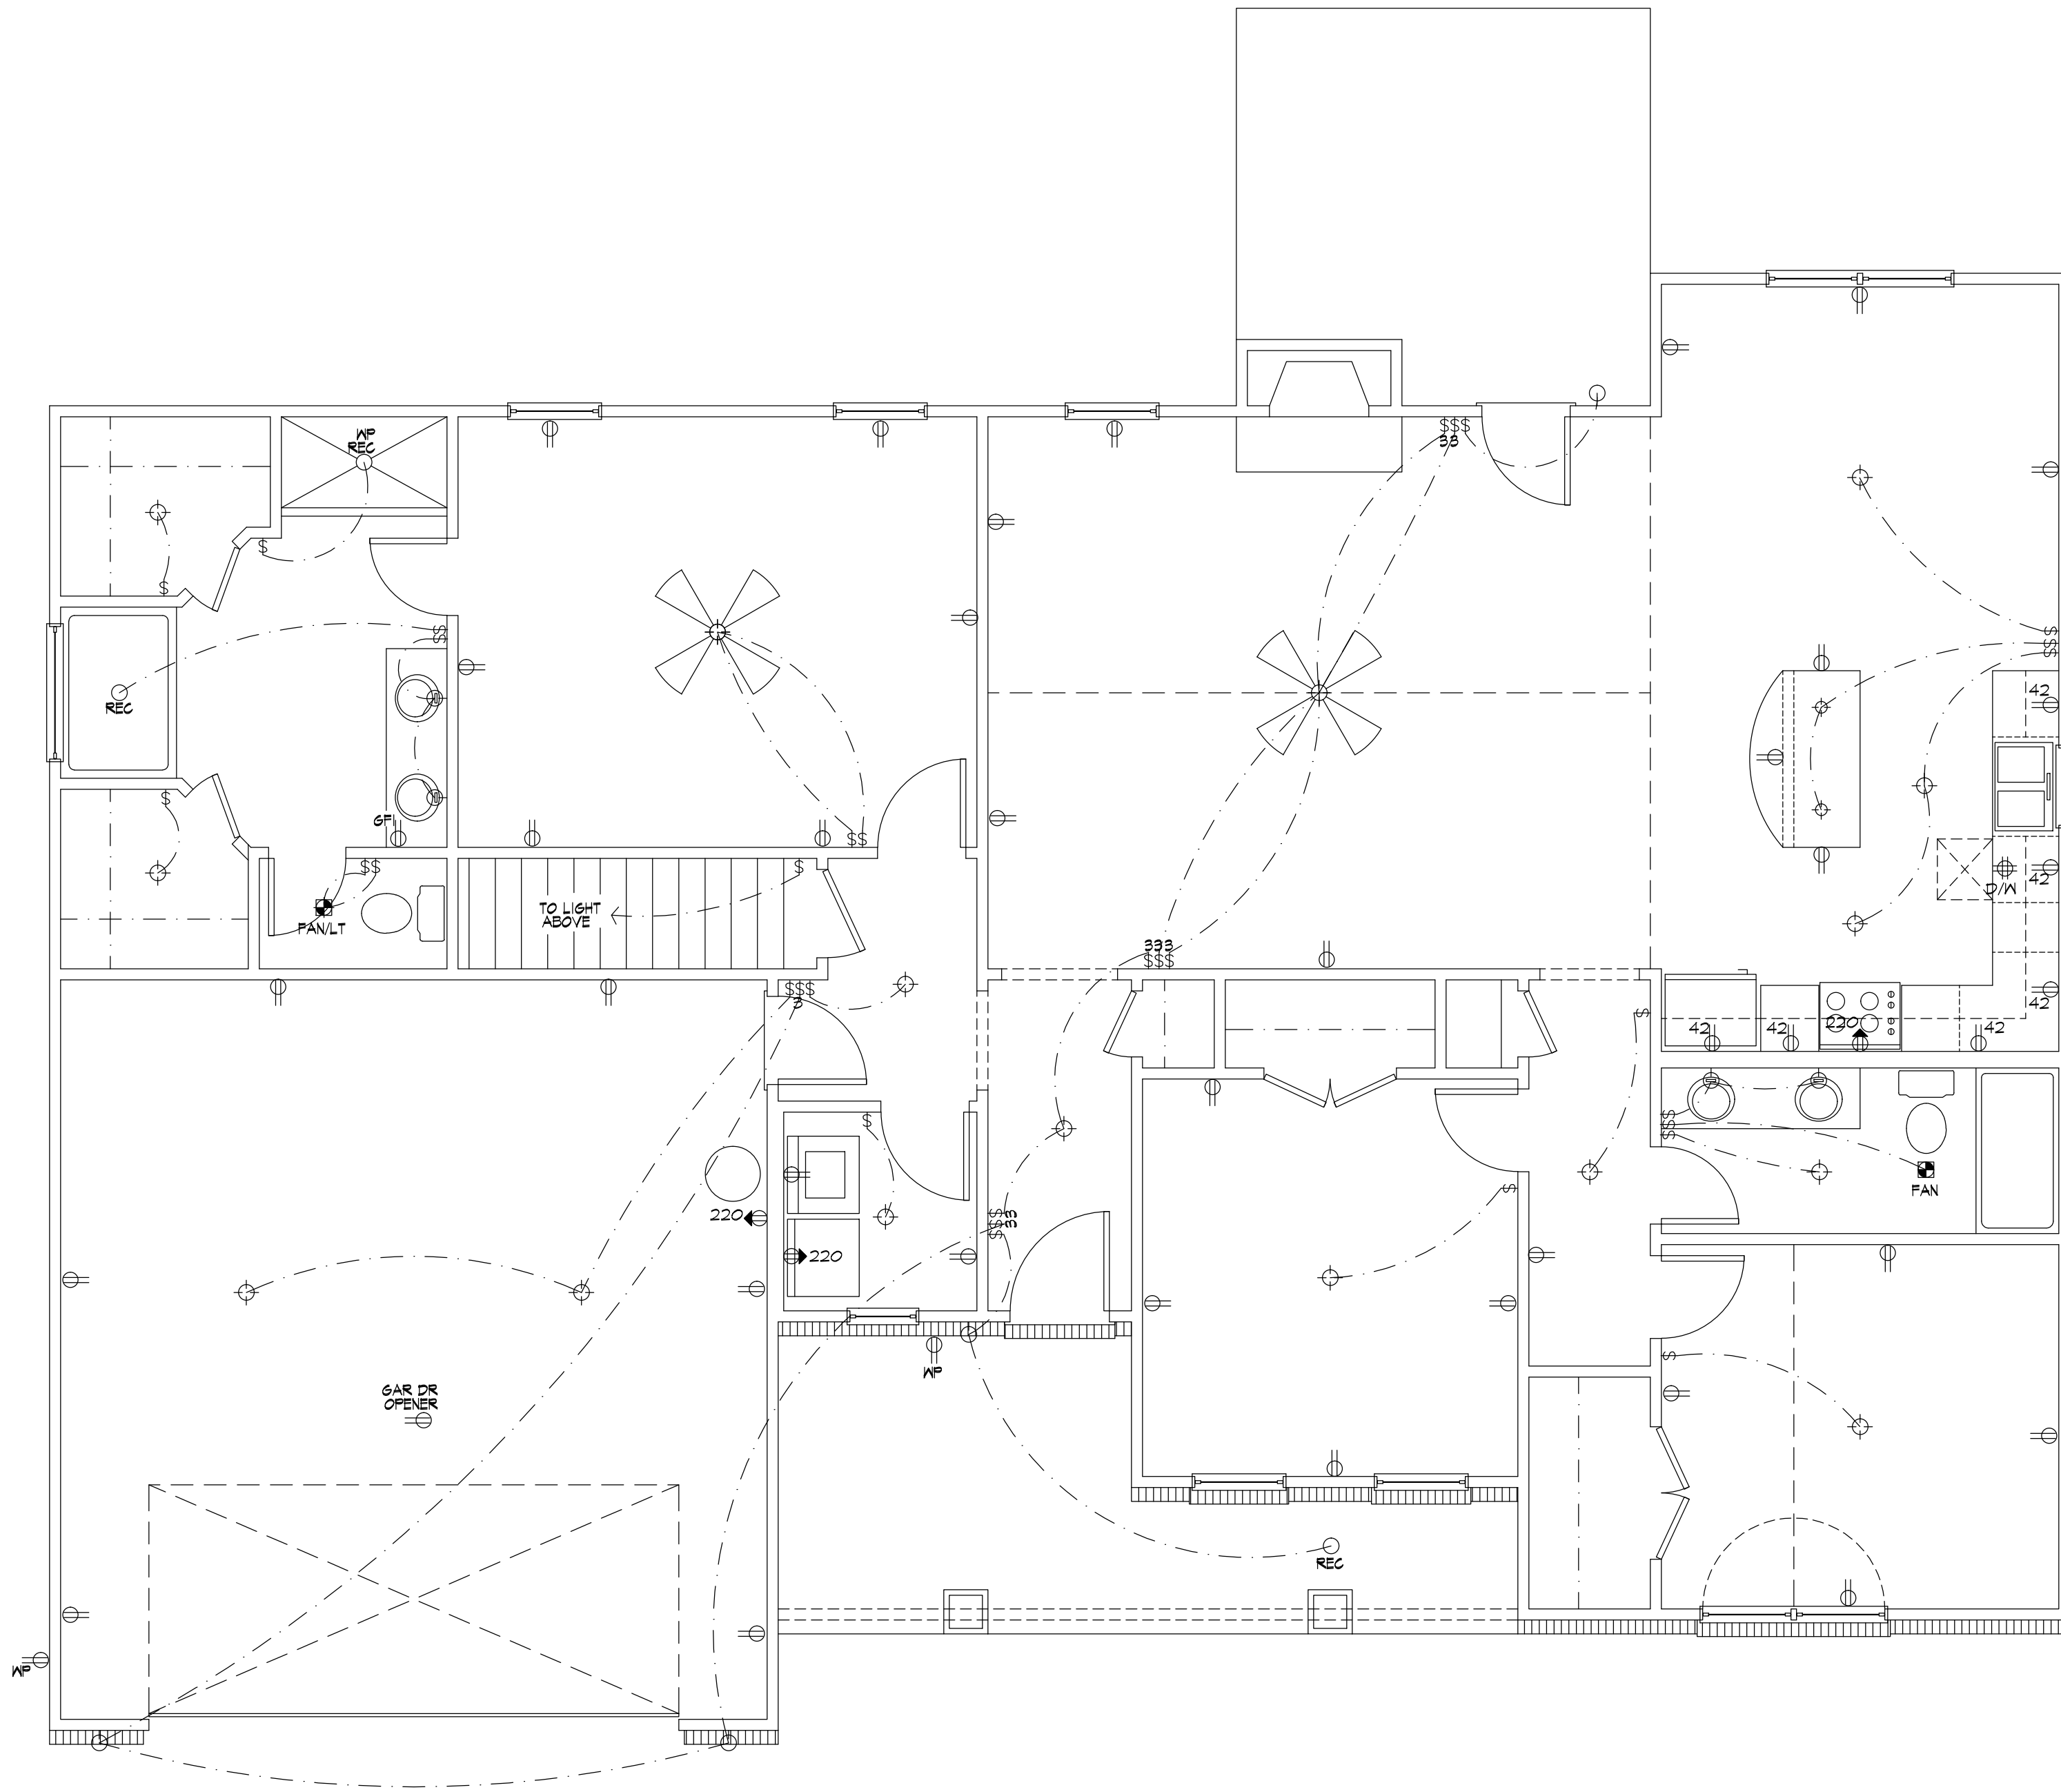

601 Main Floor Electrical Plan

Scale: 1/4" = 1'-0"

ELECTRICAL SYMBOLS	
	TYPICAL WALL RECEPTACLE
	110 V - 42" AFF
	HALF HOT AND HALF SWITCHED
	WATERPROOF RECEPTACLE
	110 V - GROUND FAULT
	220 V OUTLET
	110 V OUTLET - FLOOR MOUNT CEILING RECEPTACLE
	TOUCH - PAD
	TYPICAL SWITCH
	3 WAY OR MORE (SEE PLAN)
	DIMMER SWITCH
	LIGHT - WALL MOUNT
	LIGHT - CEILING MOUNT
	RECESSED LIGHT
	EXHAUST FAN
	LIGHT - FAN COMBINATION
	FLOOD LIGHTS
	FLOURESCENT TUBE
	FLOURESCENT LIGHT FIXTURE
	CLG. FAN
	PHONE JACK
	TV CABLE JACK
	MASTER FLOOD LIGHT SWITCH

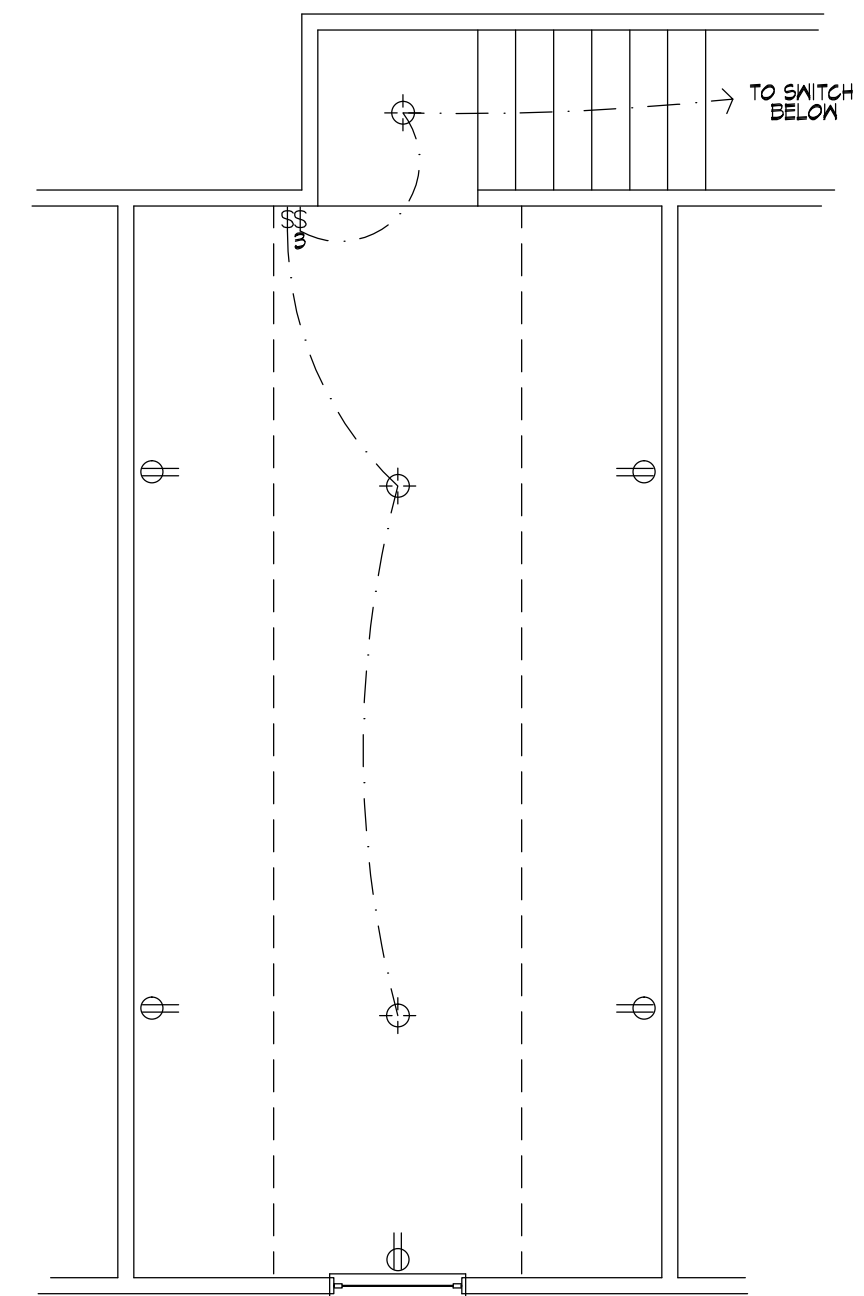

Bonus Room 602 Electrical Floor Plan

Scale: 1/4" = 1'-0"

Revisions
 Reversed
 Sept. 21, 2020

Scale:
 as shown
 Date:
 September 2020

Sheet No.
6