


E6

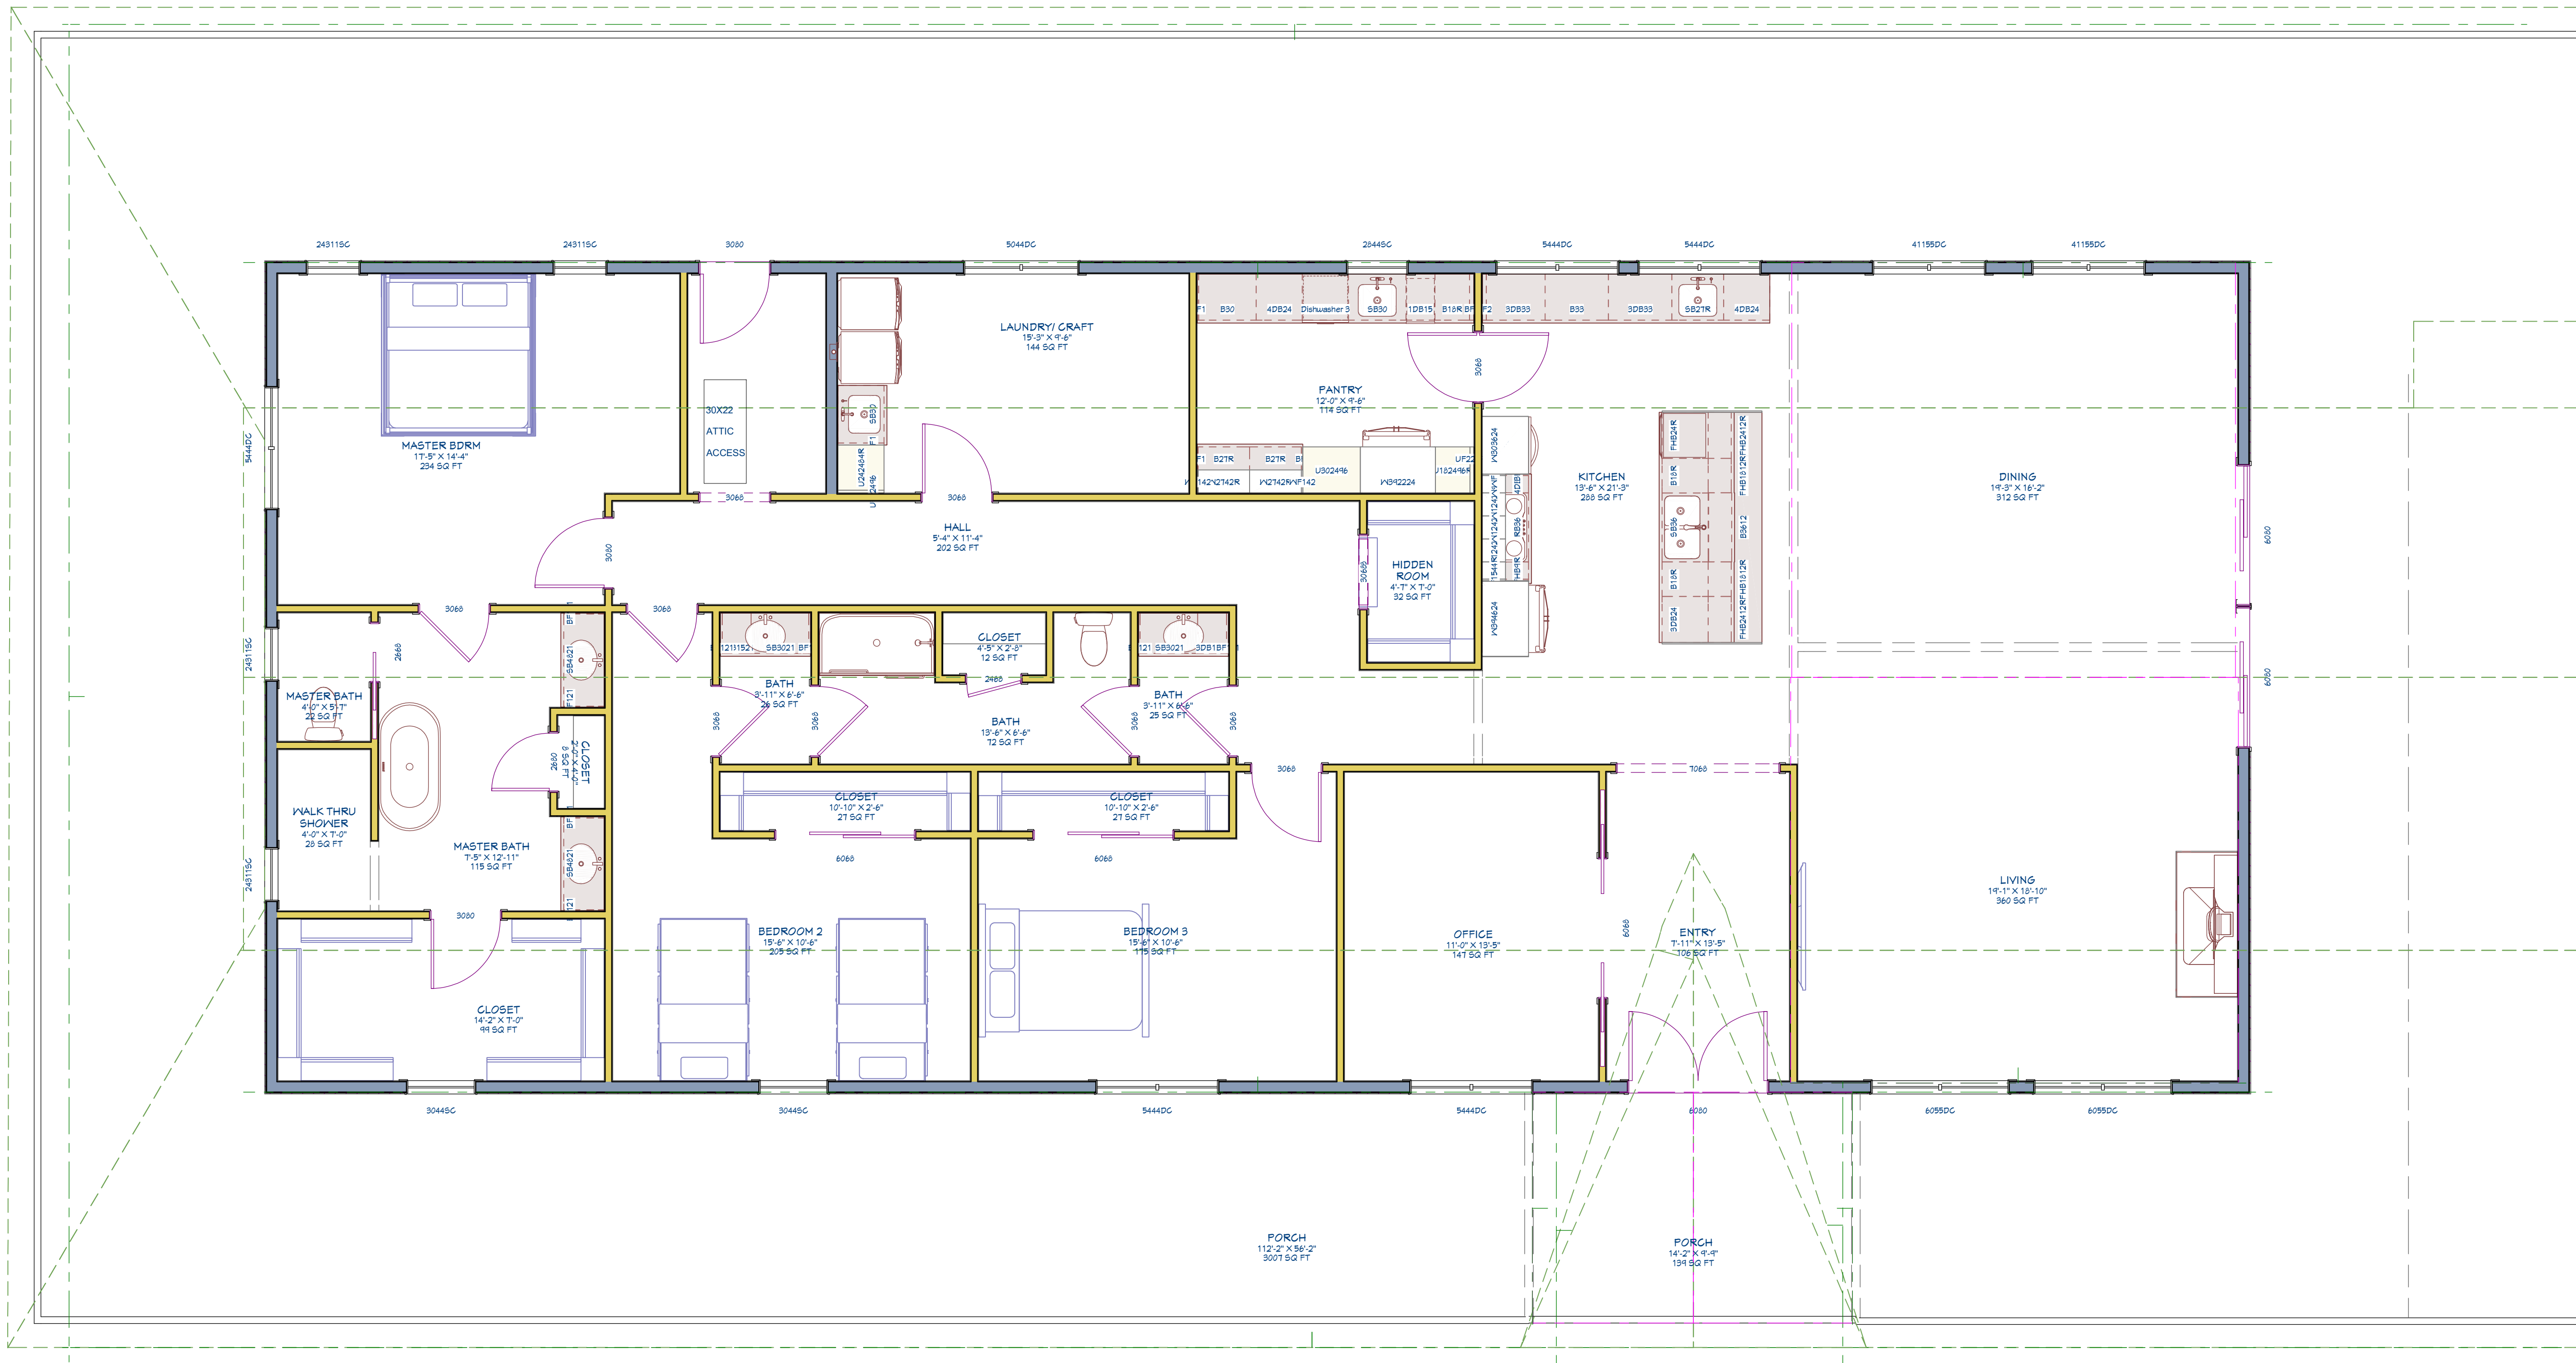

MAIN HOUSE PLAN

NUMBER	DATE	REVISION BY	DESCRIPTION

MAIN HOUSE PLAN

DATE:


2/5/2023

SCALE:

1/4" = 1' - 0"

SHEET:

A1

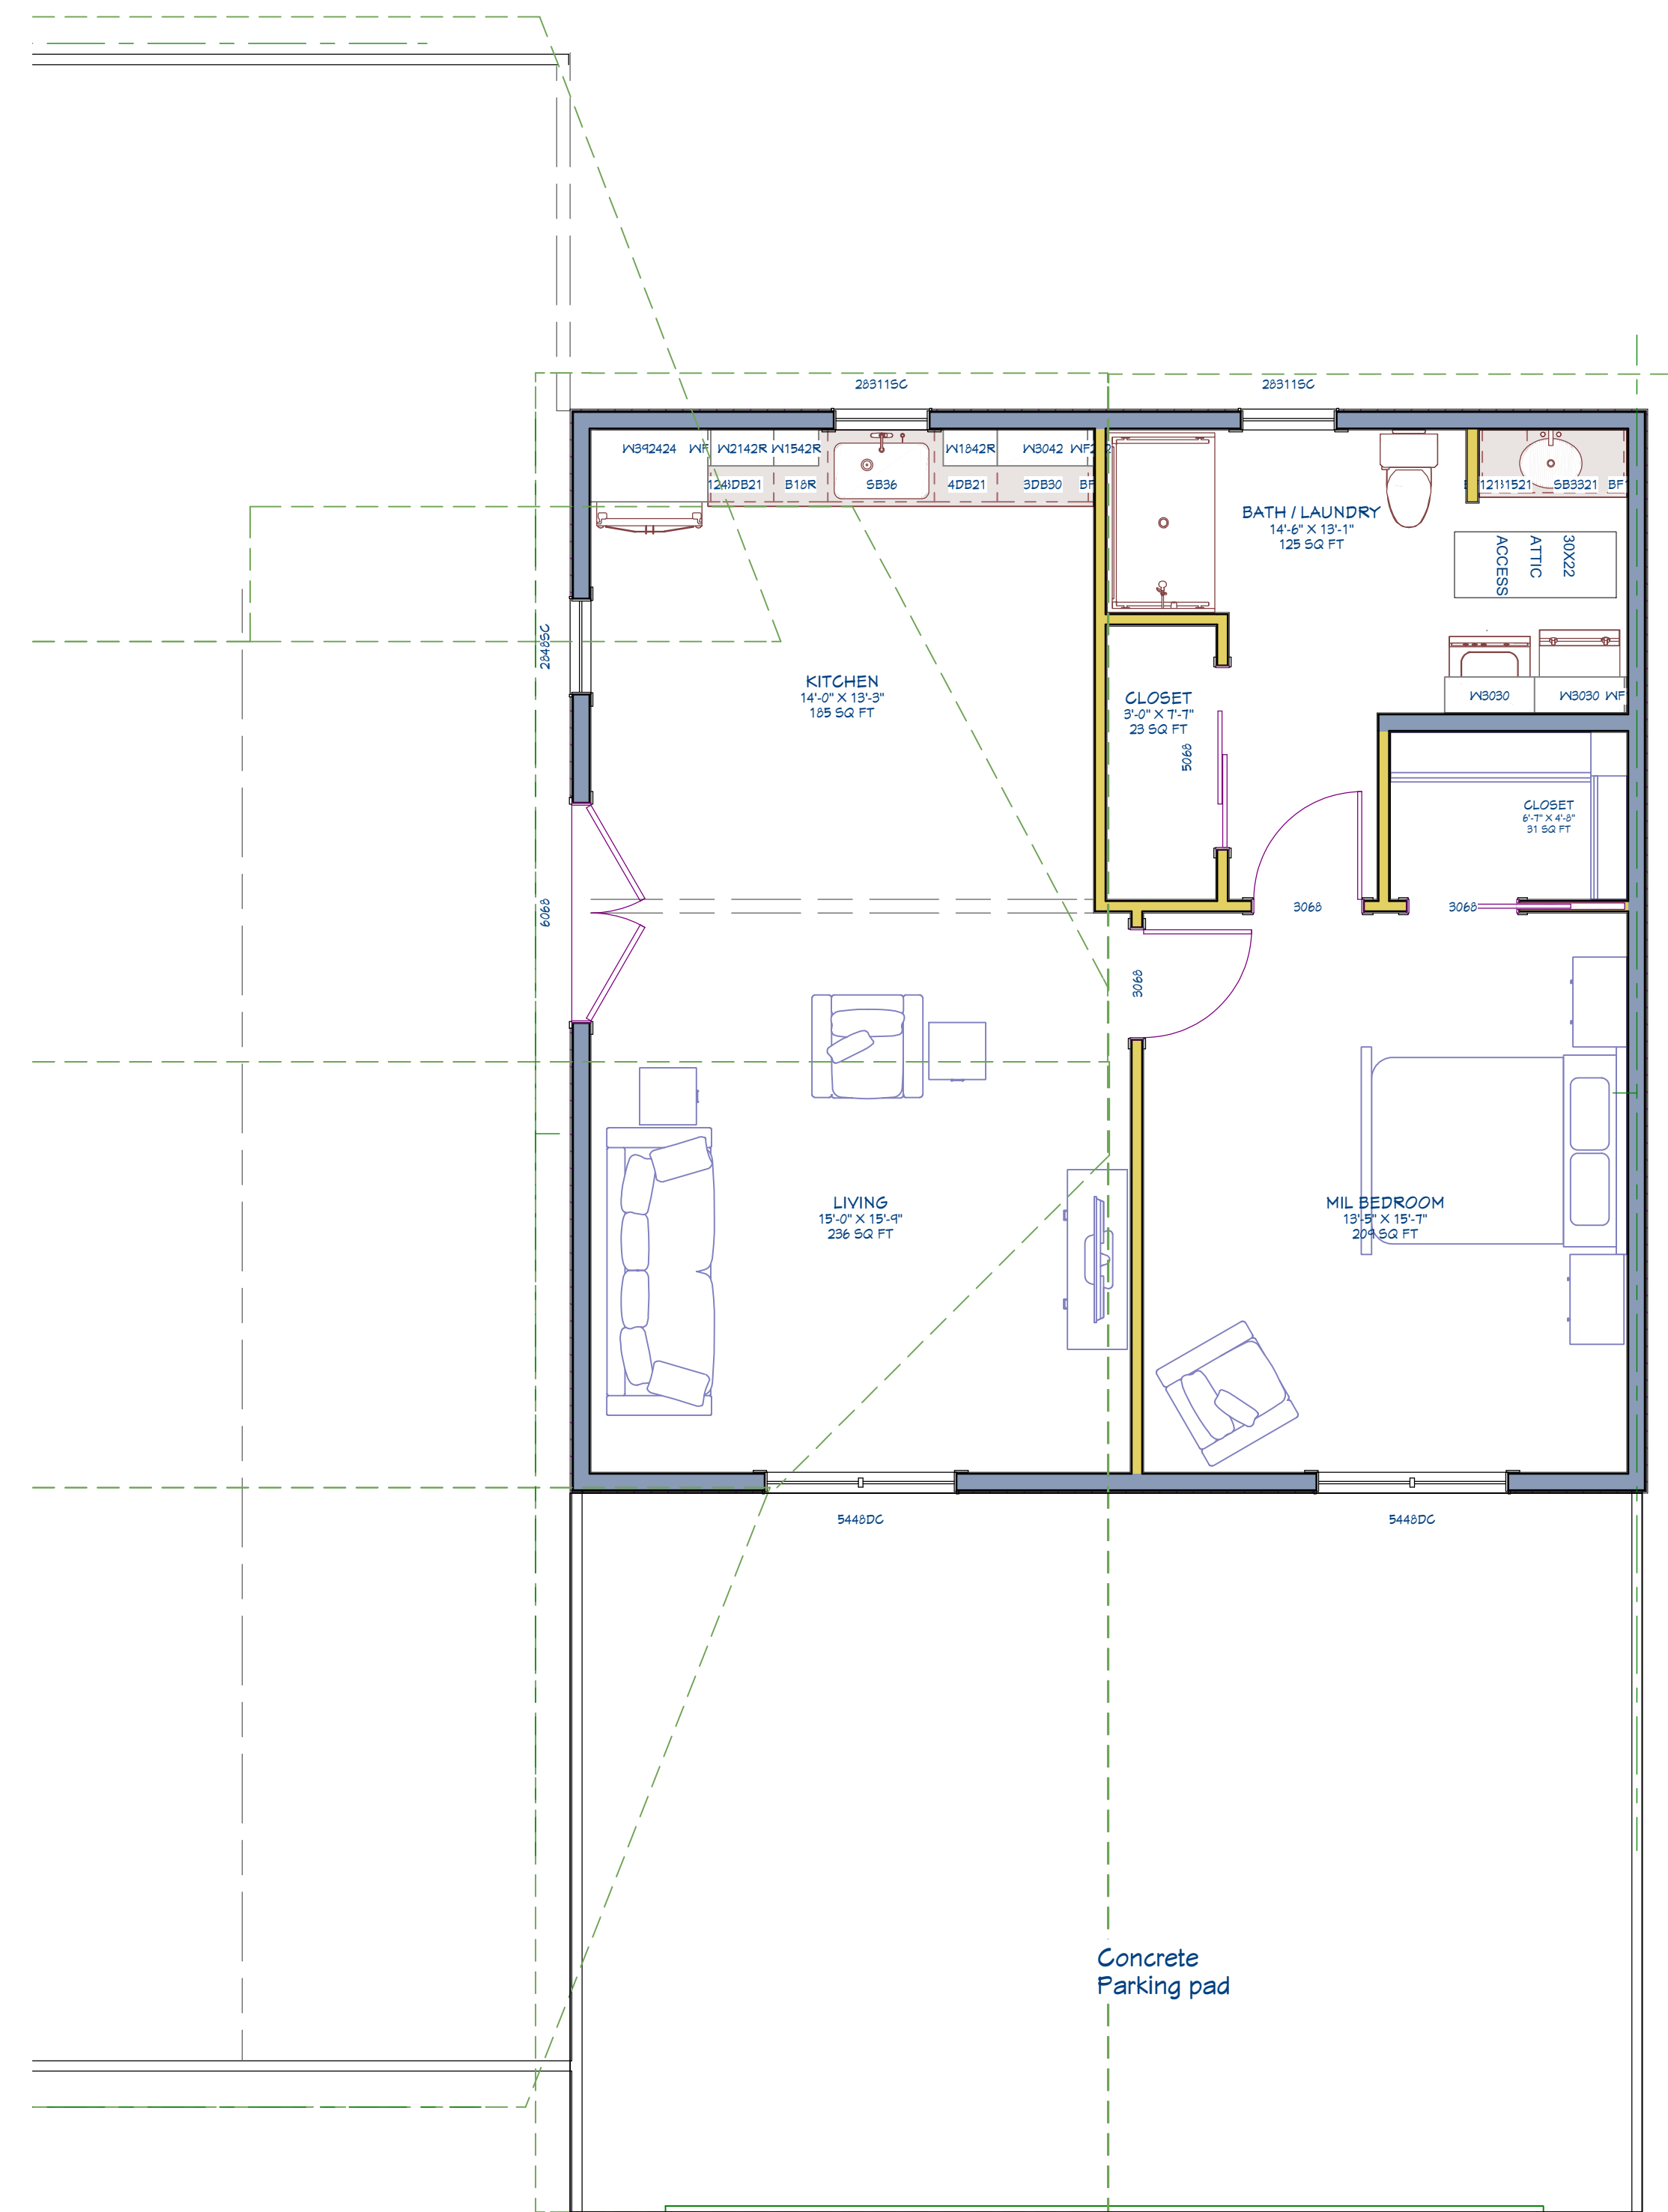

GUEST HOUSE PLAN

REVISION TABLE	
NUMBER	DATE

GUEST HOUSE PLAN

DATE:

2/5/2023


SCALE:

1/4" = 1' - 0"

SHEET:

A2

ROOF FRAMING LEGEND	
#	DESCRIPTION
1	STANDING SEAM MTL HIP ROOF, REFER TO SPEC
2	ASPHALT SINGLE ROOF, REFER TO SPEC
3	RIDGE VENT
4	REFER TO ELEVATIONS
5	GUTTER / DOWNSPOUT, REFER TO SPEC

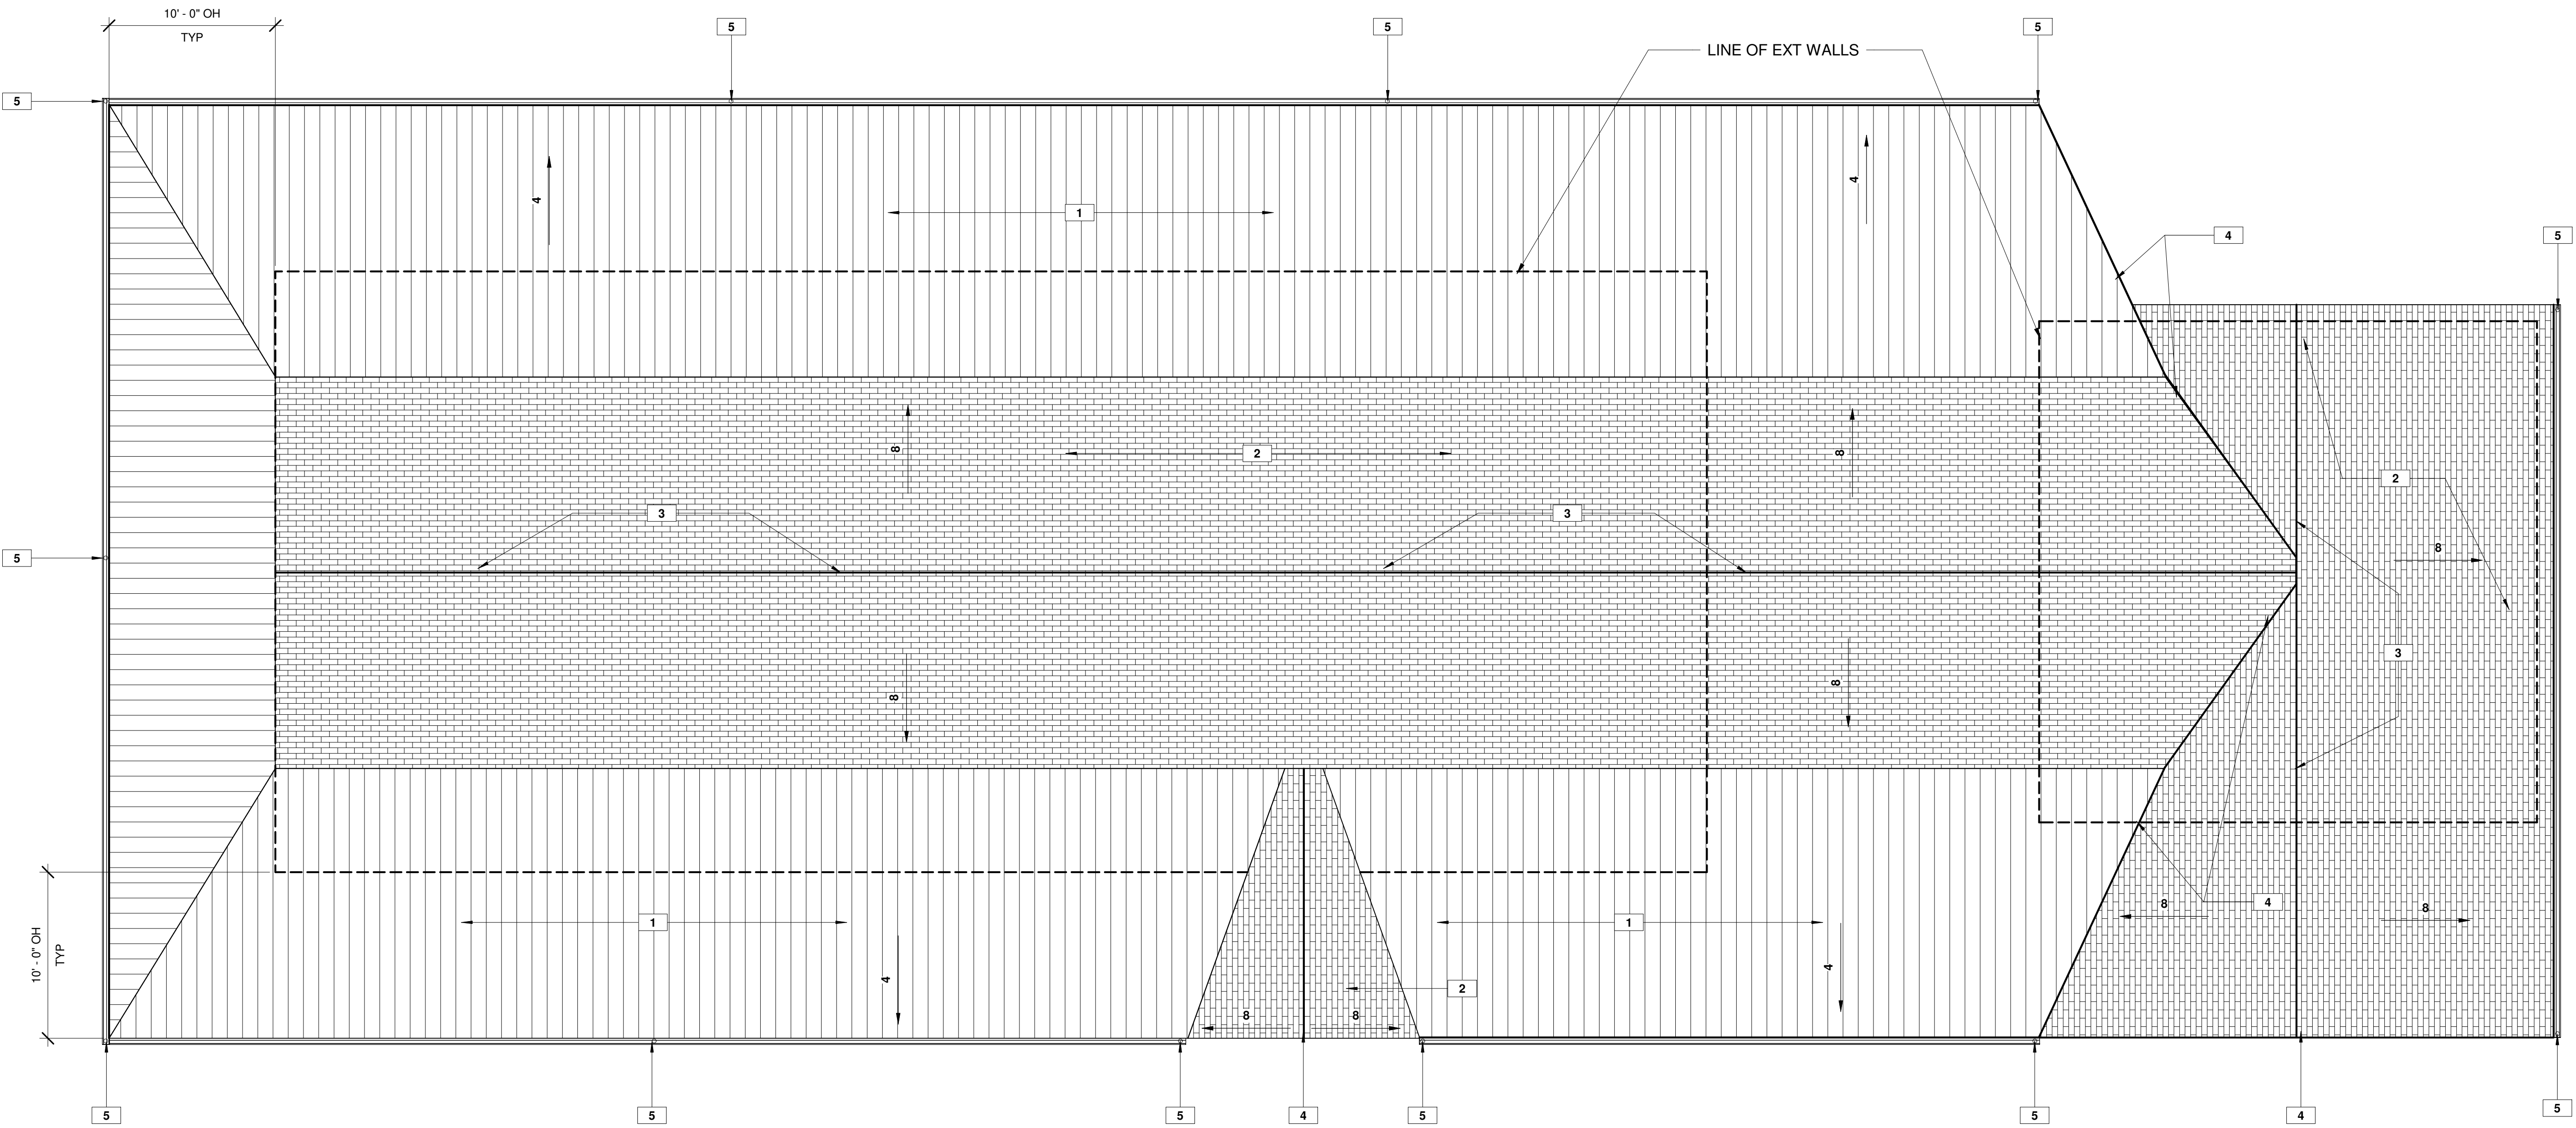

REVISION TABLE			
NUMBER	DATE	REVISED BY	DESCRIPTION

ROOF PLAN

DATE:	4/14/2023
SCALE:	3/16" = 1' - 0"
SHEET:	A3



ENTRY ELEVATION



ENTRY ELEVATION, CONT'D

NUMBER	DATE	REVISION BY	DESCRIPTION

ENTRY ELEVATIONS

DATE:  
2/5/2023

SCALE:  
1/4" = 1' - 0"

SHEET:  
A4



REAR ELEVATION



REAR ELEVATION, CONT'D

NUMBER	DATE	REVISION TABLE	REVISOR	DESCRIPTION

REAR ELEVATIONS

DATE:

2/5/2023

SCALE:

1/4" = 1' - 0"

SHEET:

A5



EXTERIOR ELEVATION, RIGHT



EXTERIOR ELEVATION, LEFT

REVISION TABLE		
NUMBER	DATE	DESCRIPTION

LEFT & RIGHT  
ELEVATIONS

DATE:


2/5/2023

SCALE:

1/4" = 1' - 0"

SHEET:

A6

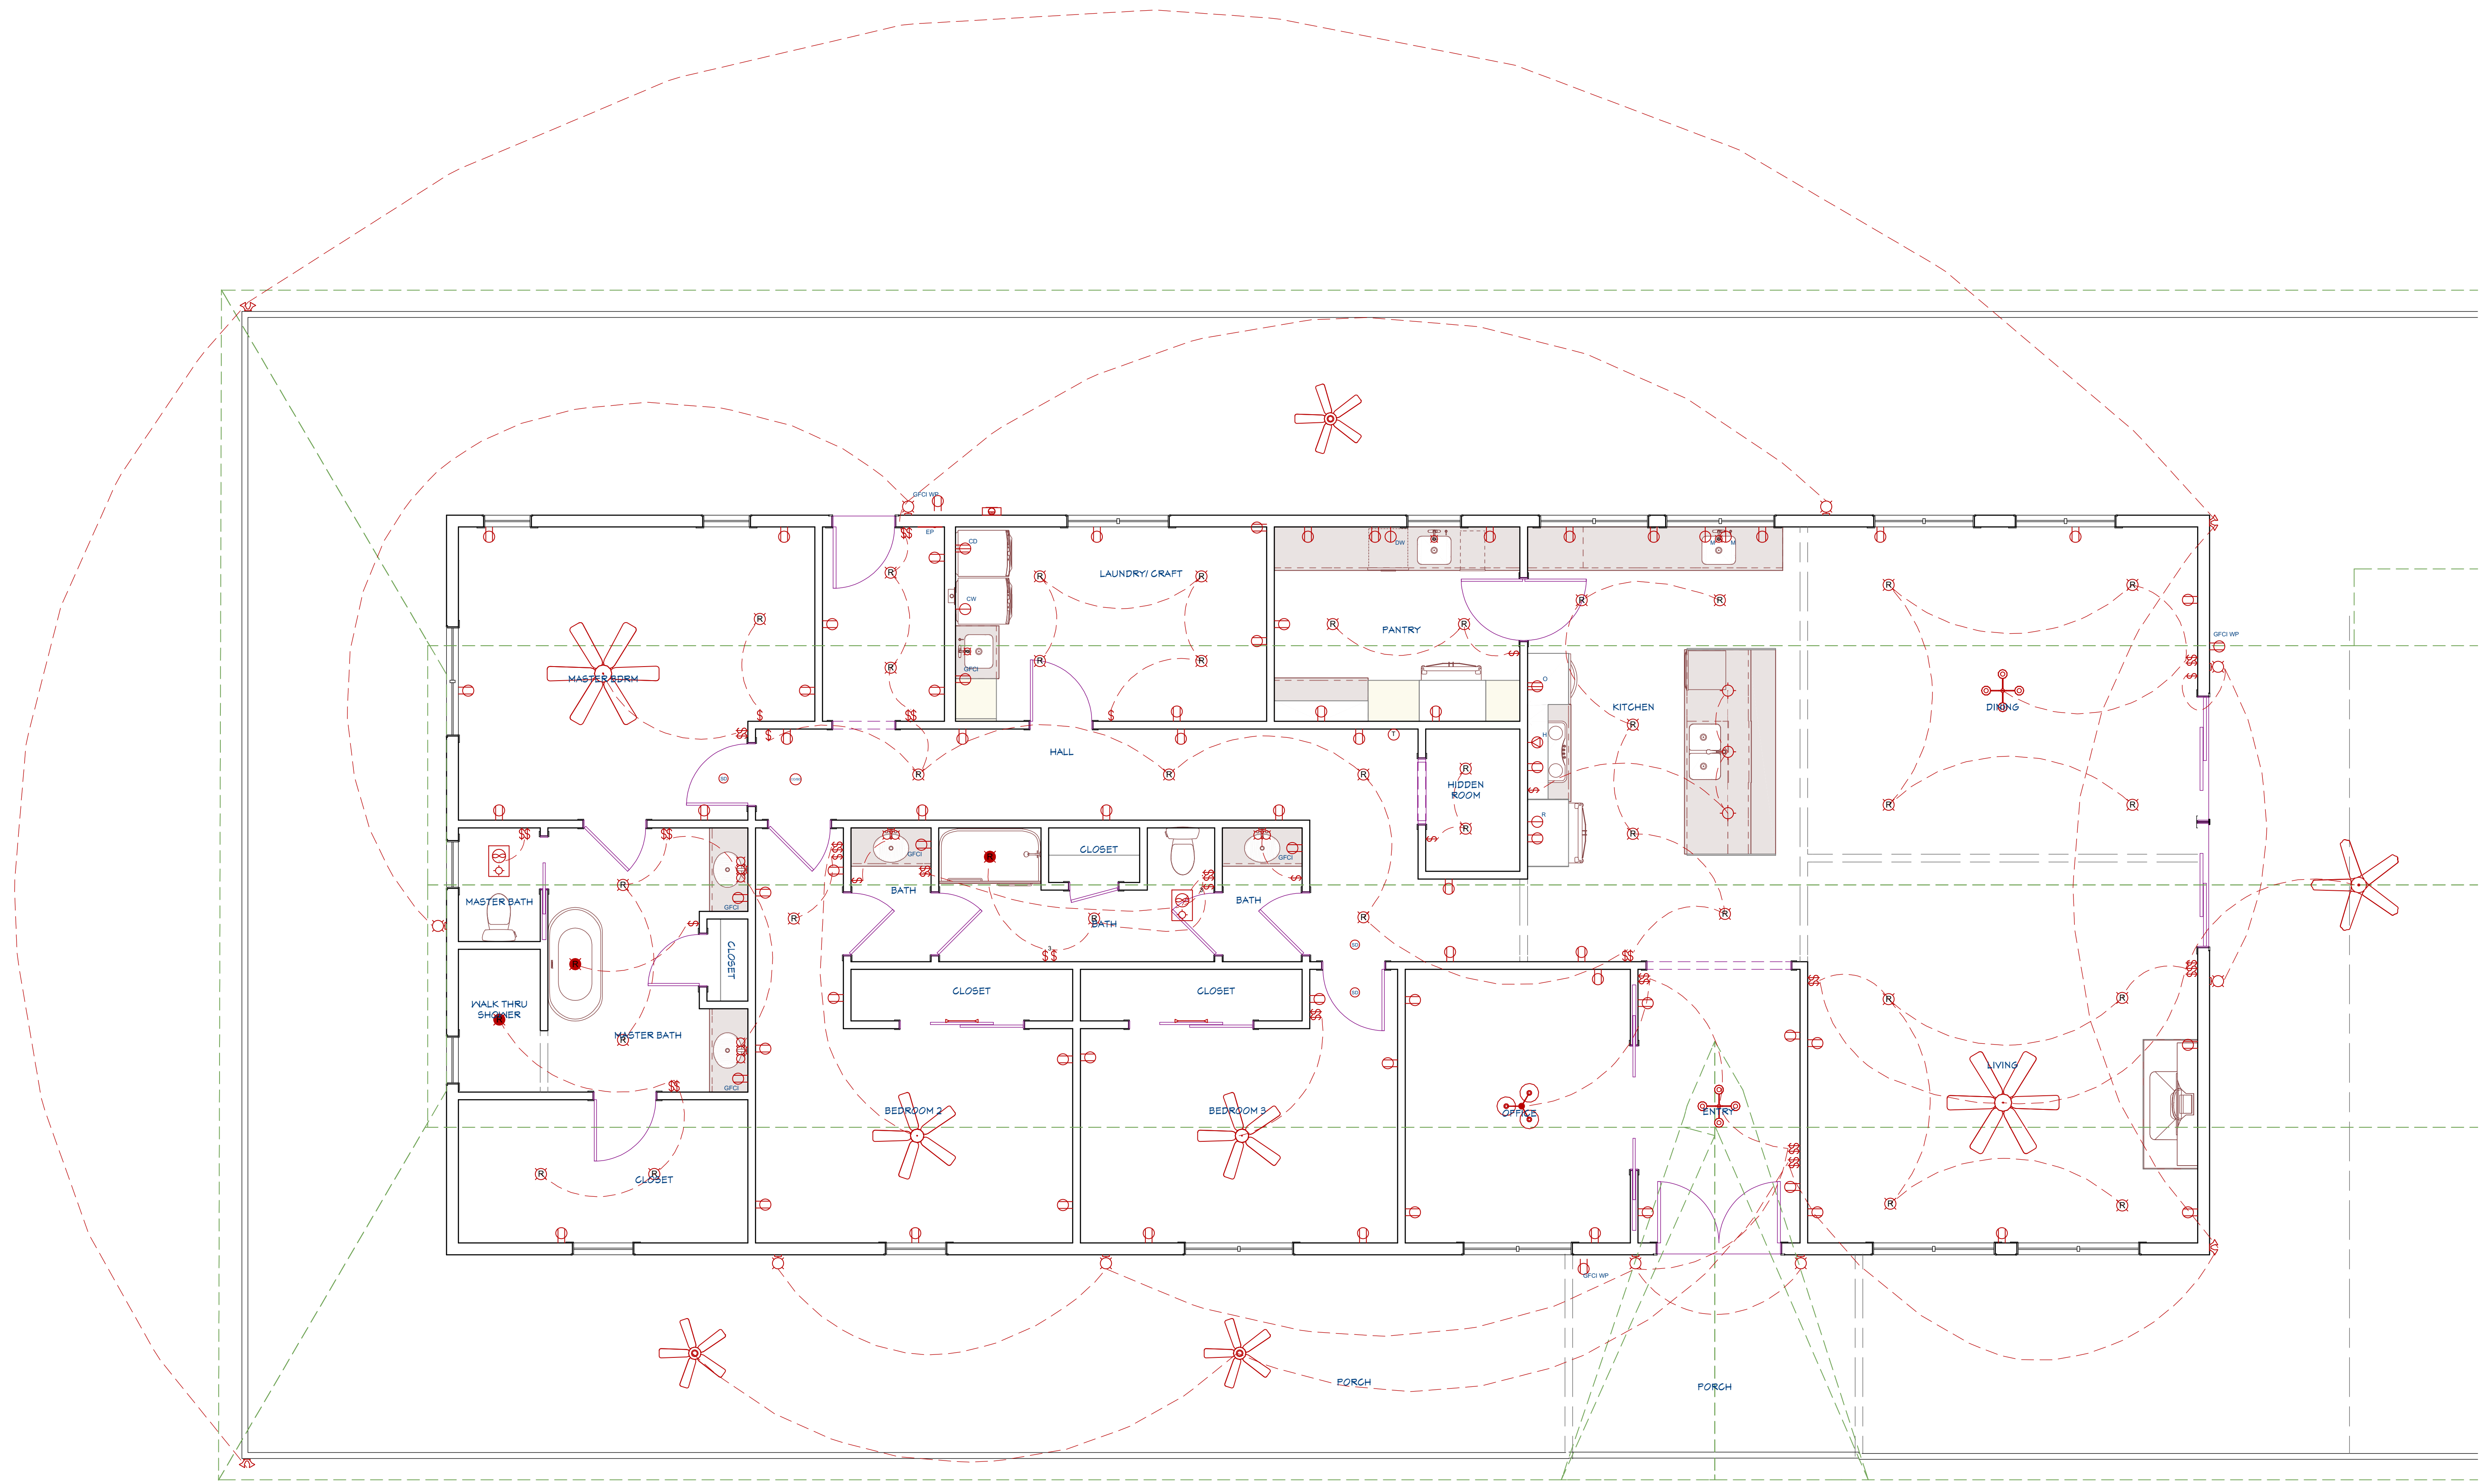

REVISION TABLE			
NUMBER	DATE	REVISED BY	DESCRIPTION


**MAIN HOUSE  
ELECTRICAL PLAN**

DATE:  
2/5/2023

SCALE:  
1/4" = 1' - 0"

SHEET:  
**E1**

**MAIN HOUSE ELECTRICAL PLAN**

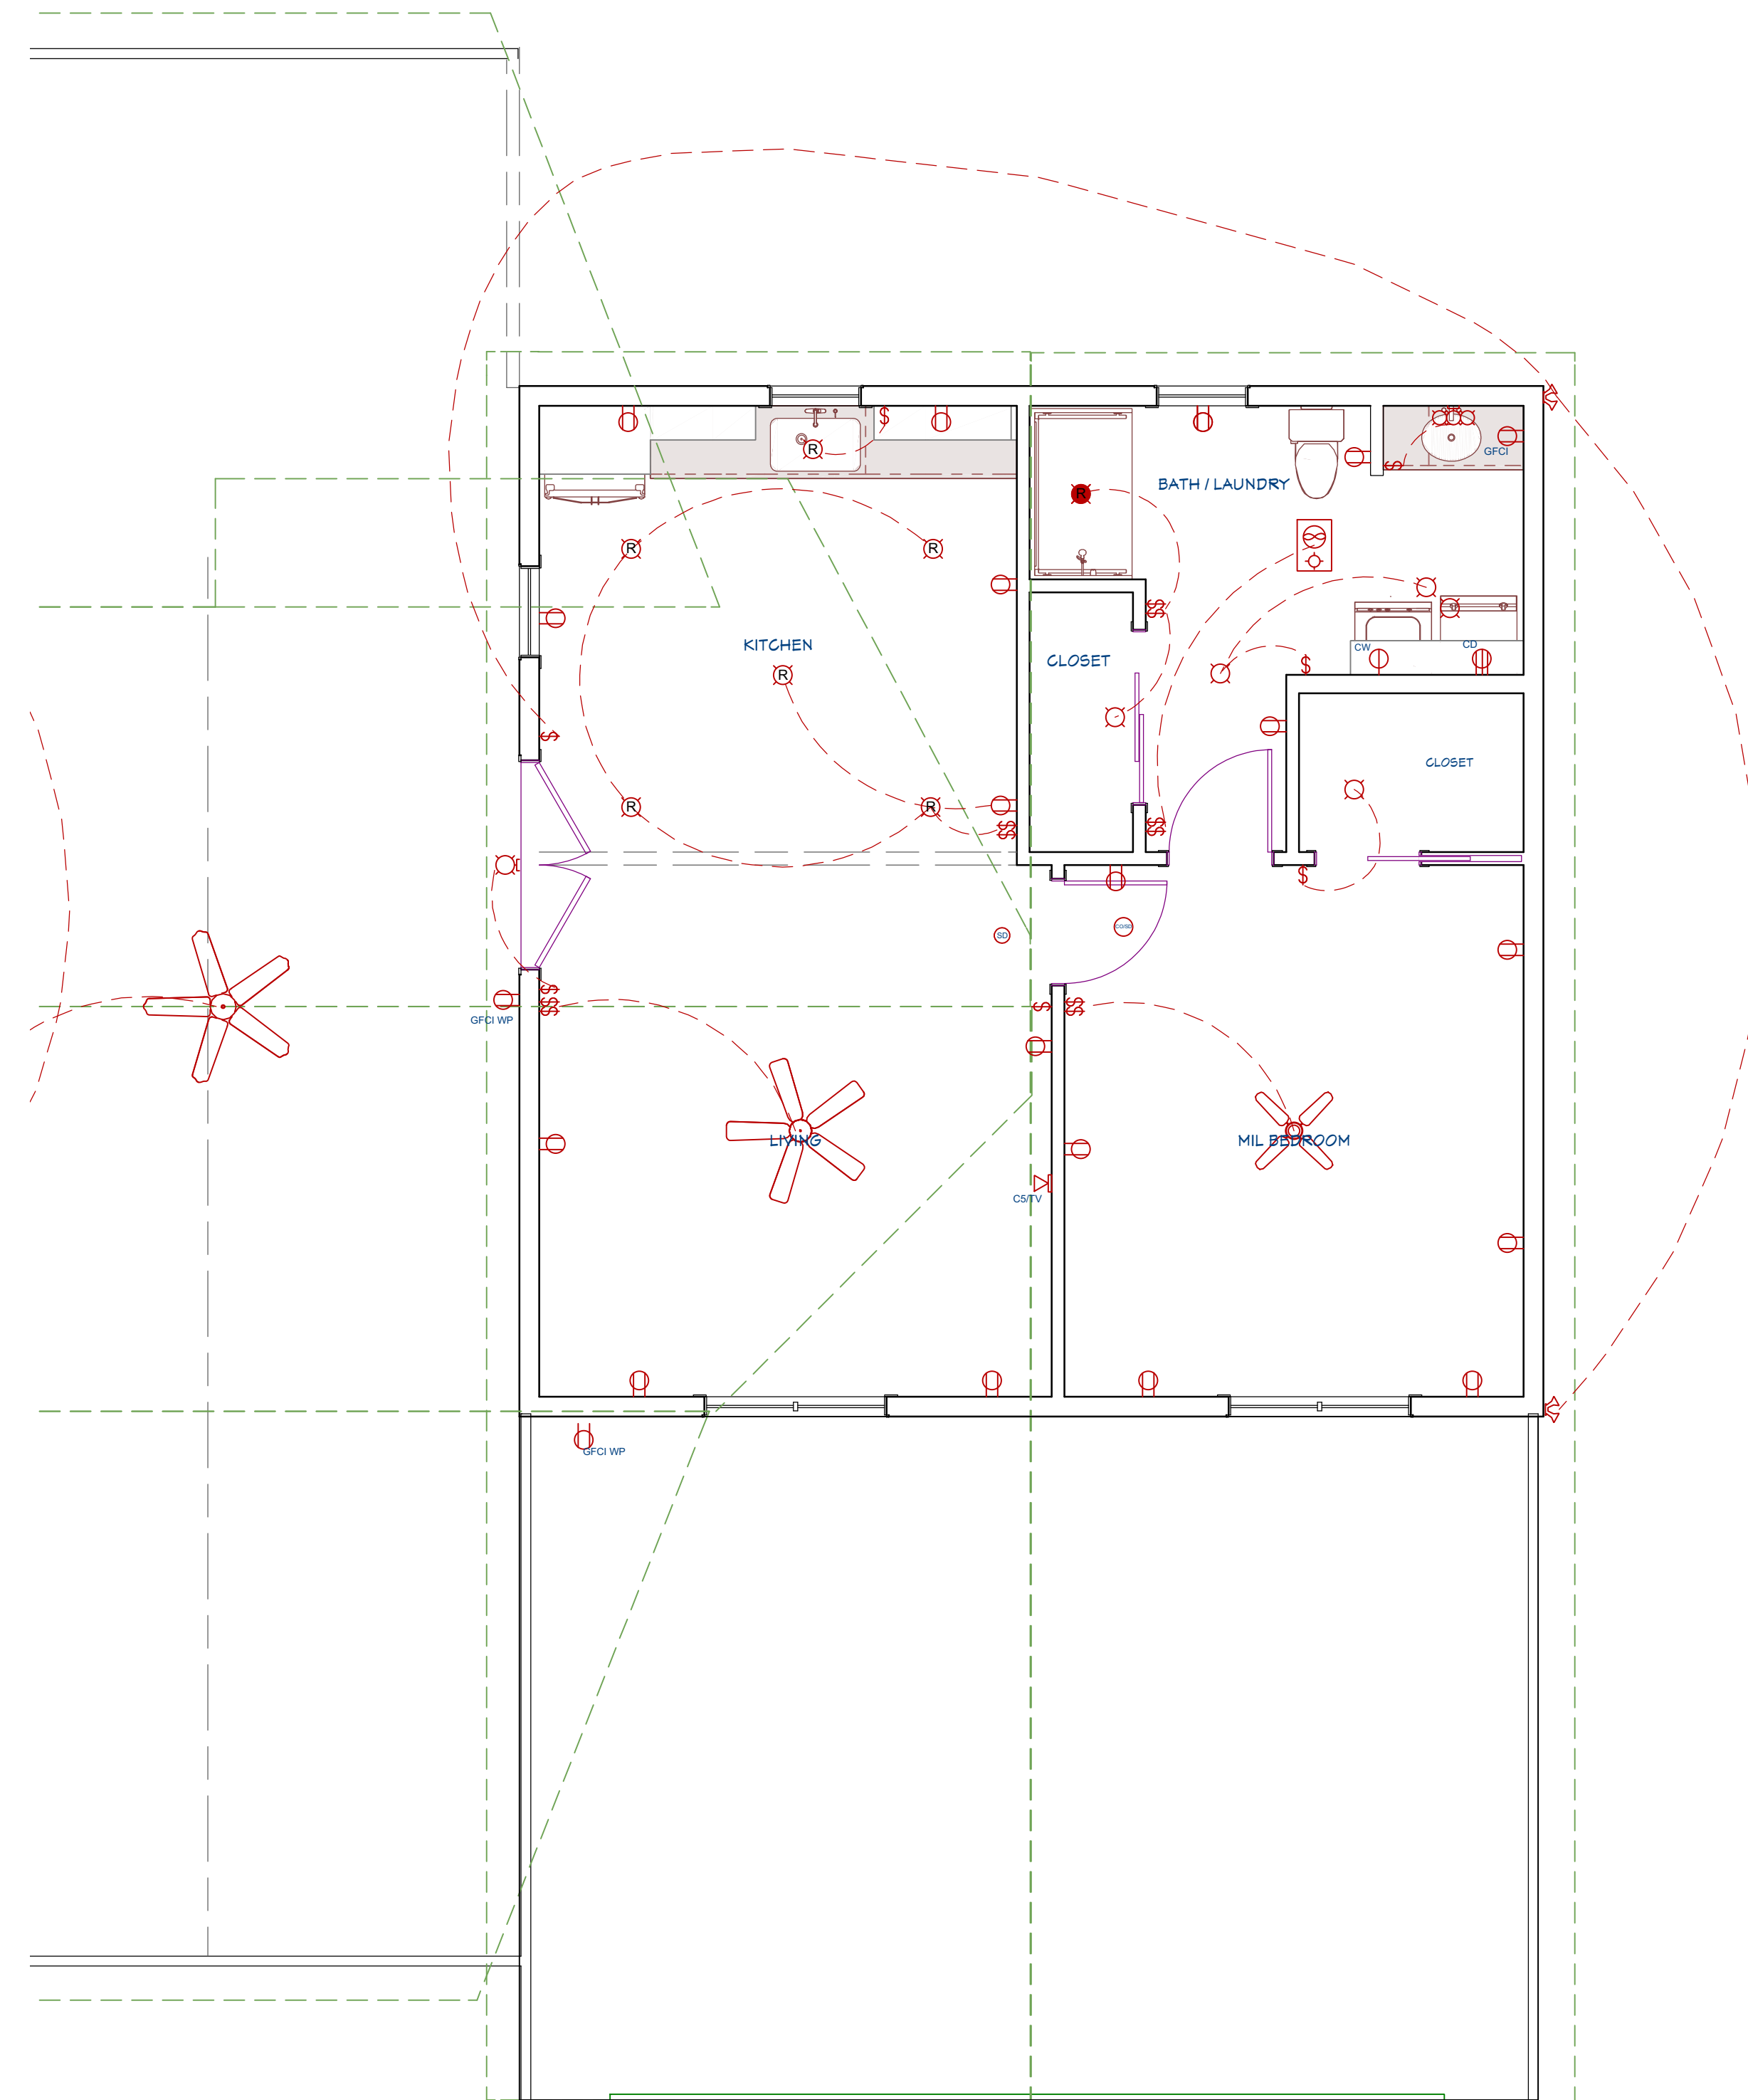

GUEST HOUSE ELECTRICAL PLAN

REVISION TABLE		
NUMBER	DATE	DESCRIPTION

GUEST HOUSE  
ELECTRICAL PLAN

DATE:

2/5/2023


SCALE:

1/4" = 1' - 0"


SHEET:

E2




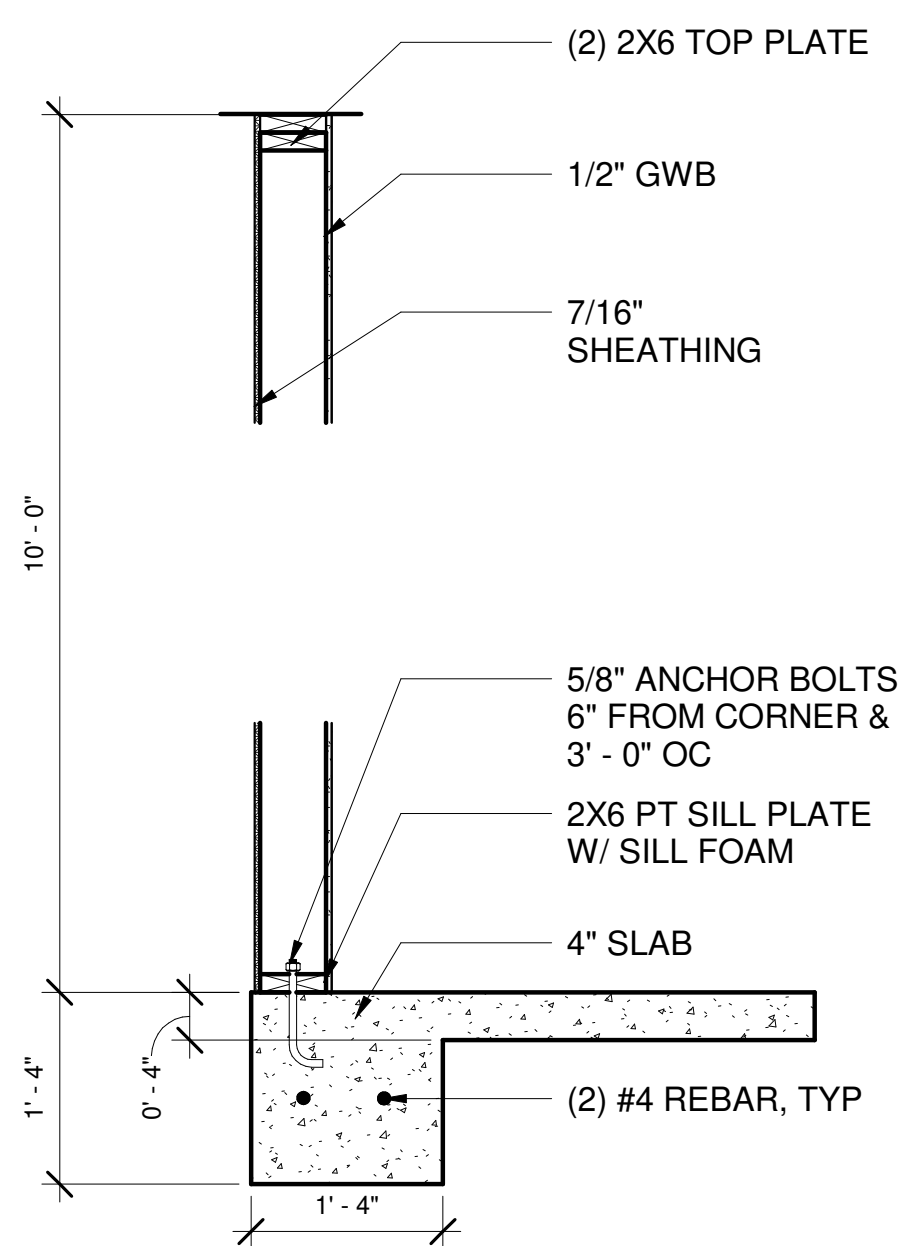

WALL SECTION @ FTG 3/4" = 1'-0"

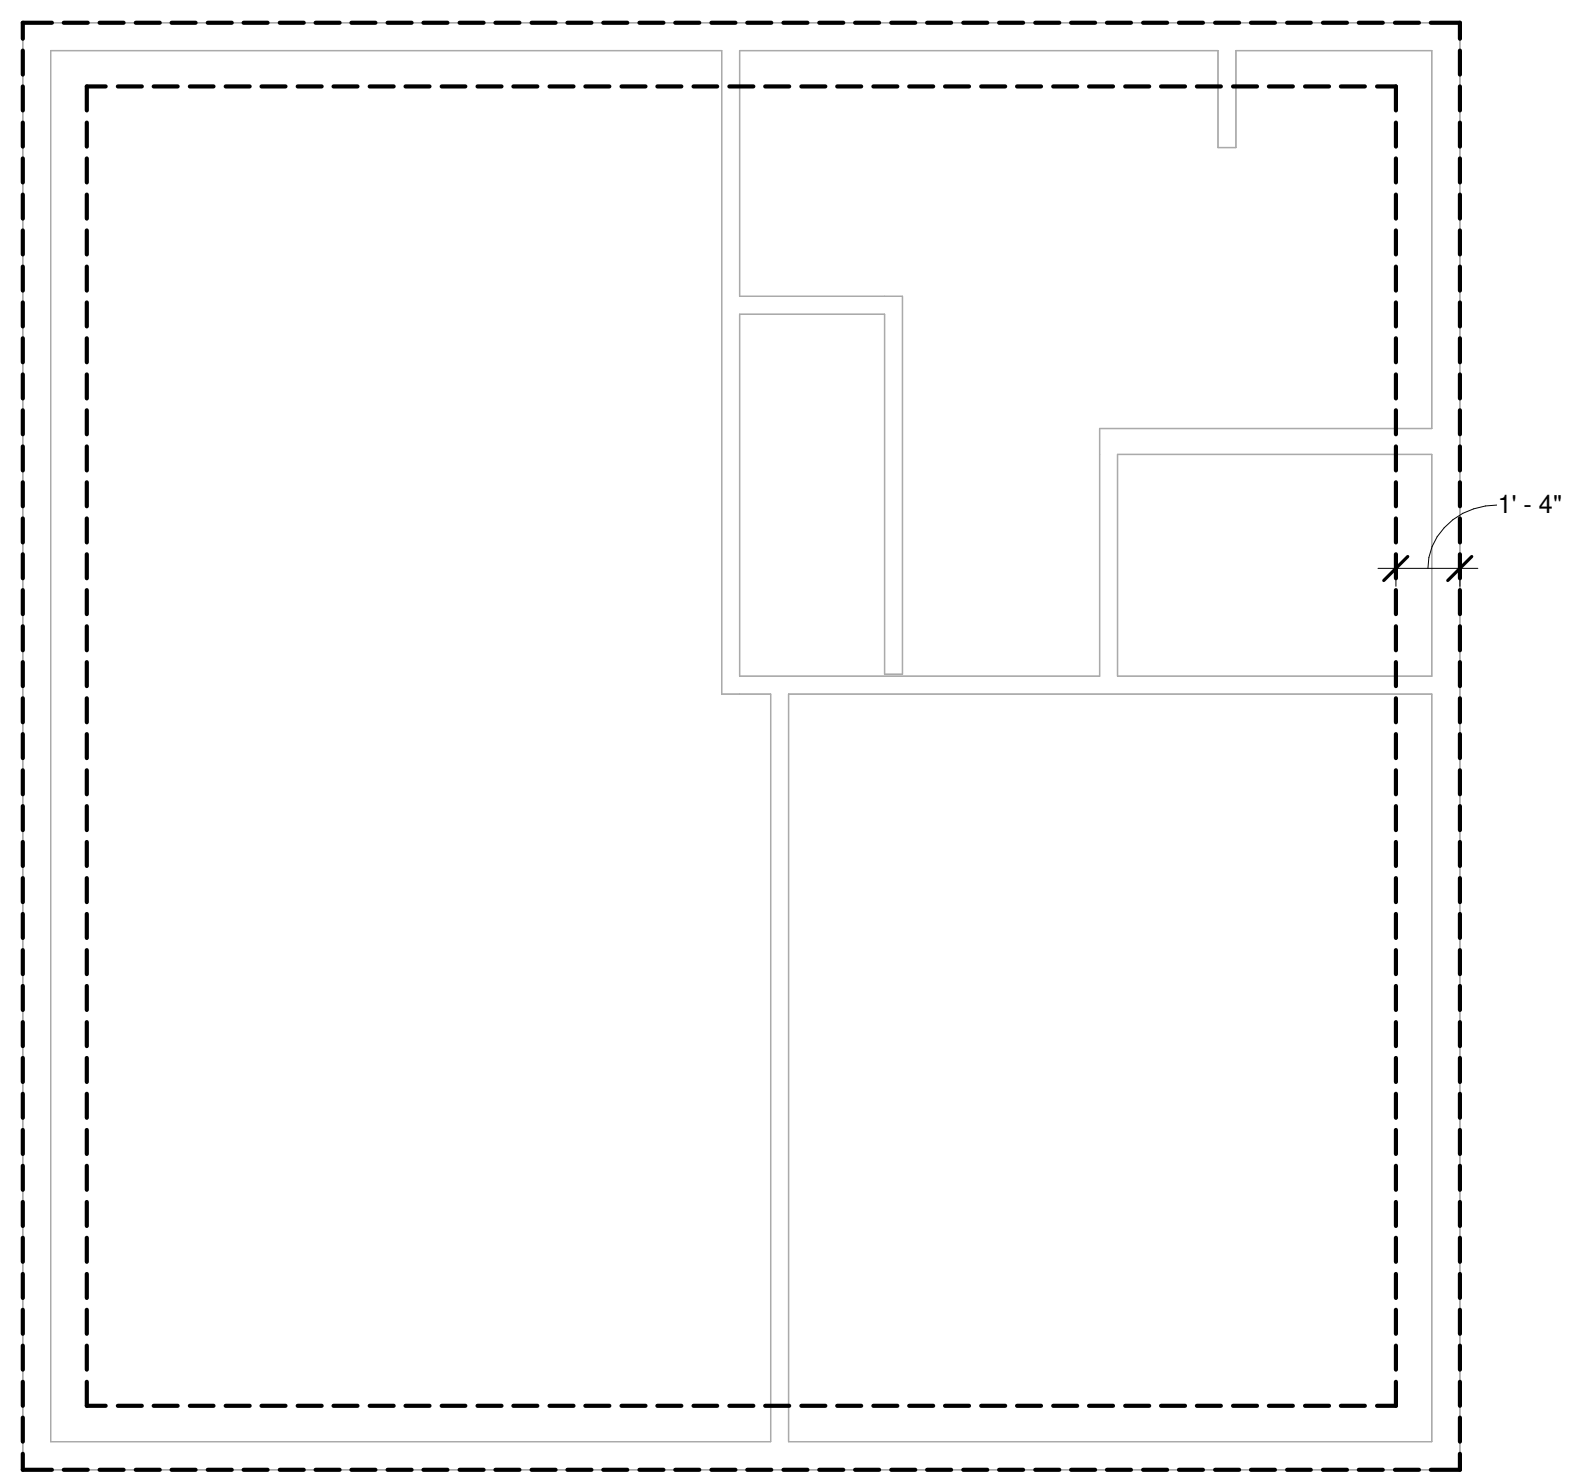

FOUNDATION PLAN, GUEST HOUSE 1/4" = 1'-0"

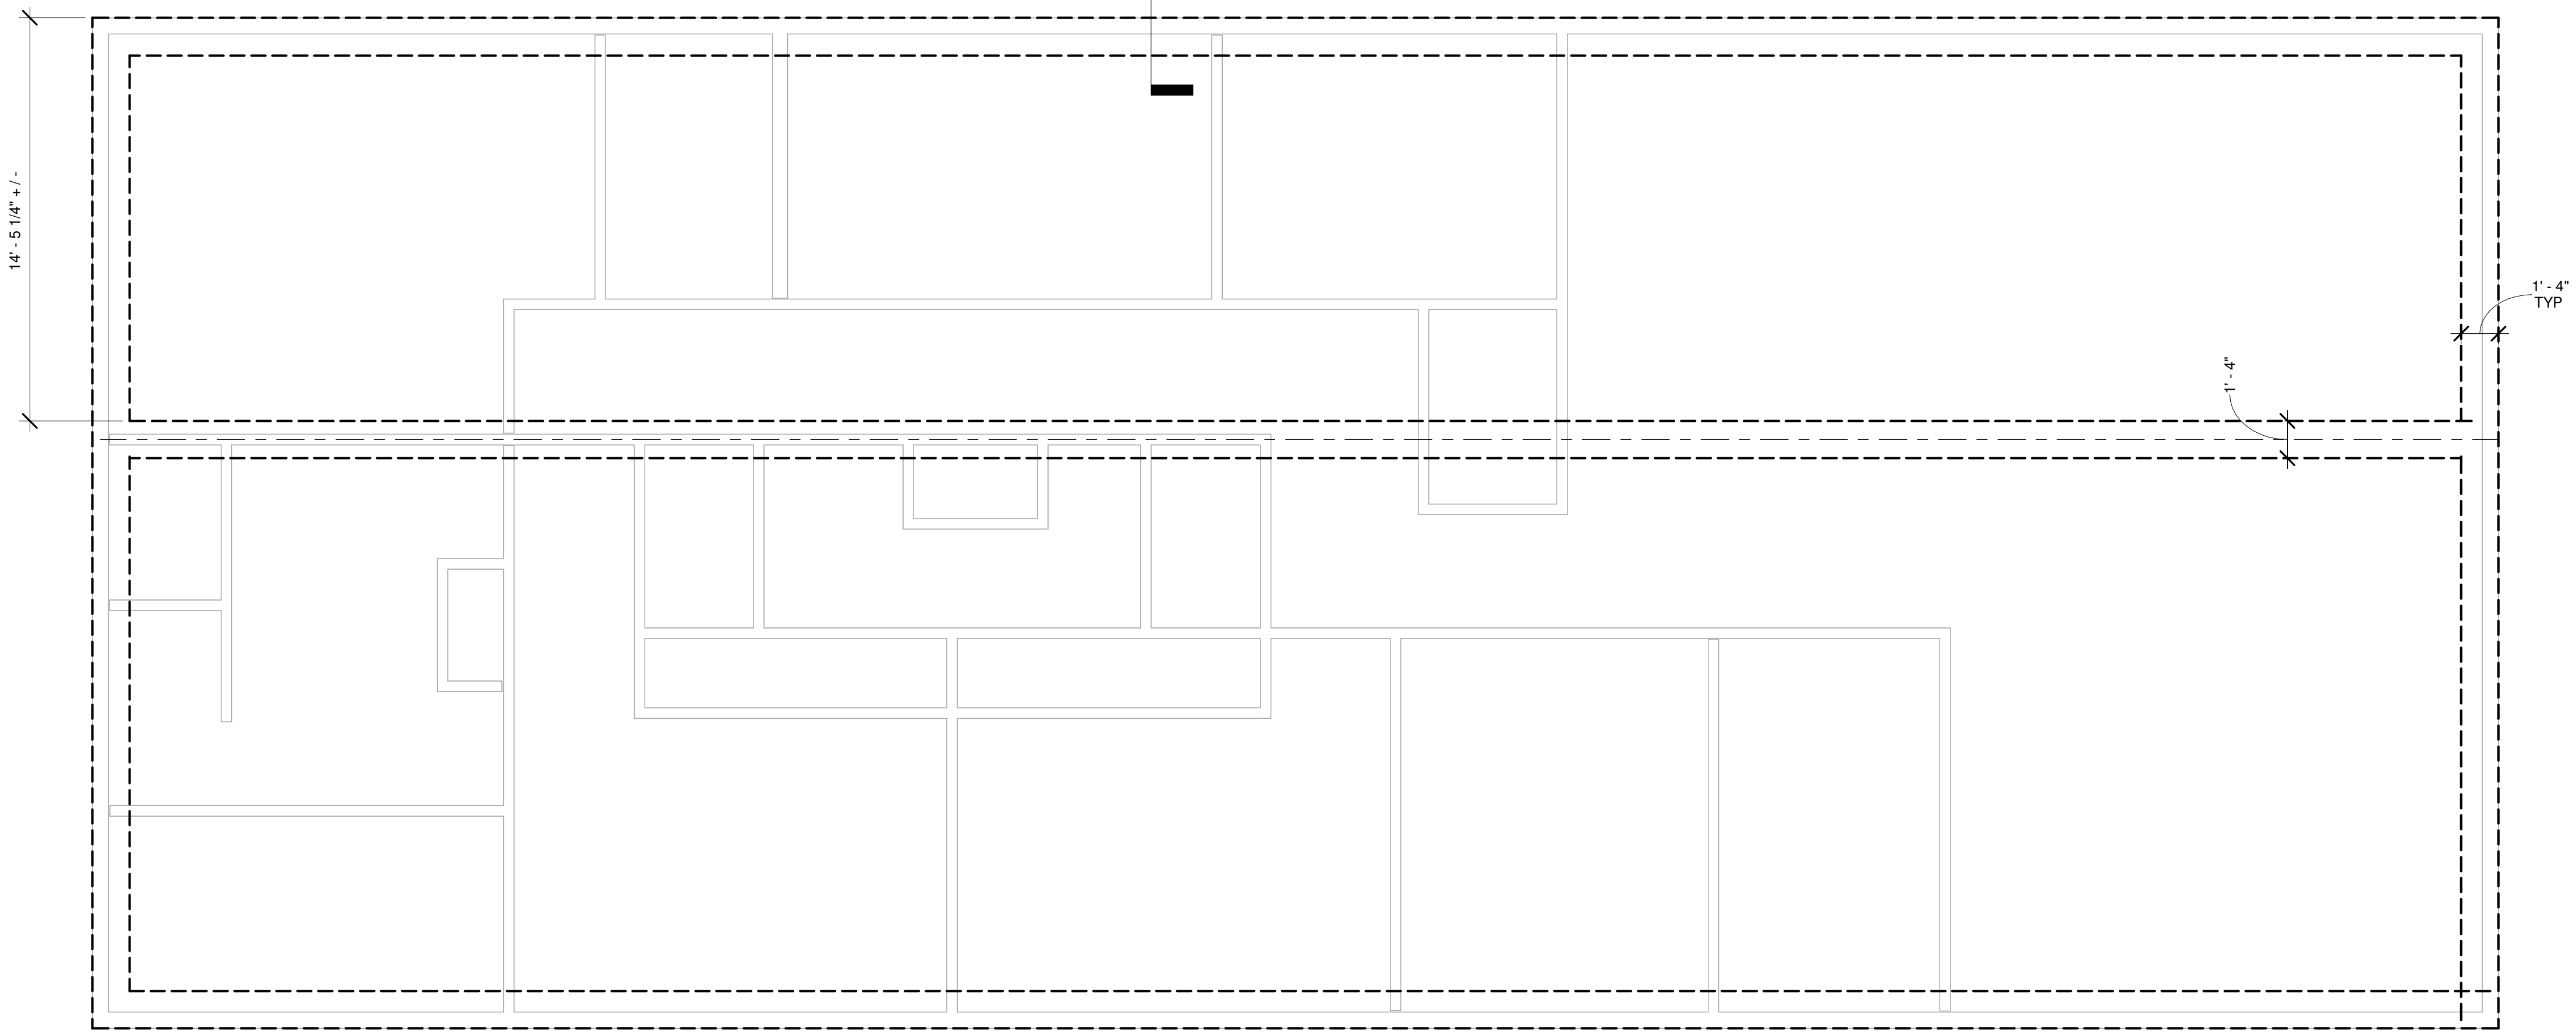

FOUNDATION PLAN, MAIN HOUSE 1/4" = 1'-0"

3  
S0

REVISION TABLE	
NUMBER	DESCRIPTION

FOUNDATION  
PLANS & WALL  
SECTION

DATE:  
4/14/2023

SCALE:  
AS SHOWN

SHEET:  
S1


REVISION TABLE	
NUMBER	DATE

# MAIN HOUSE FRAMING PLAN

DATE:  
2/5/2023


SCALE:  
1/4" = 1' - 0"

SHEET:  
S1

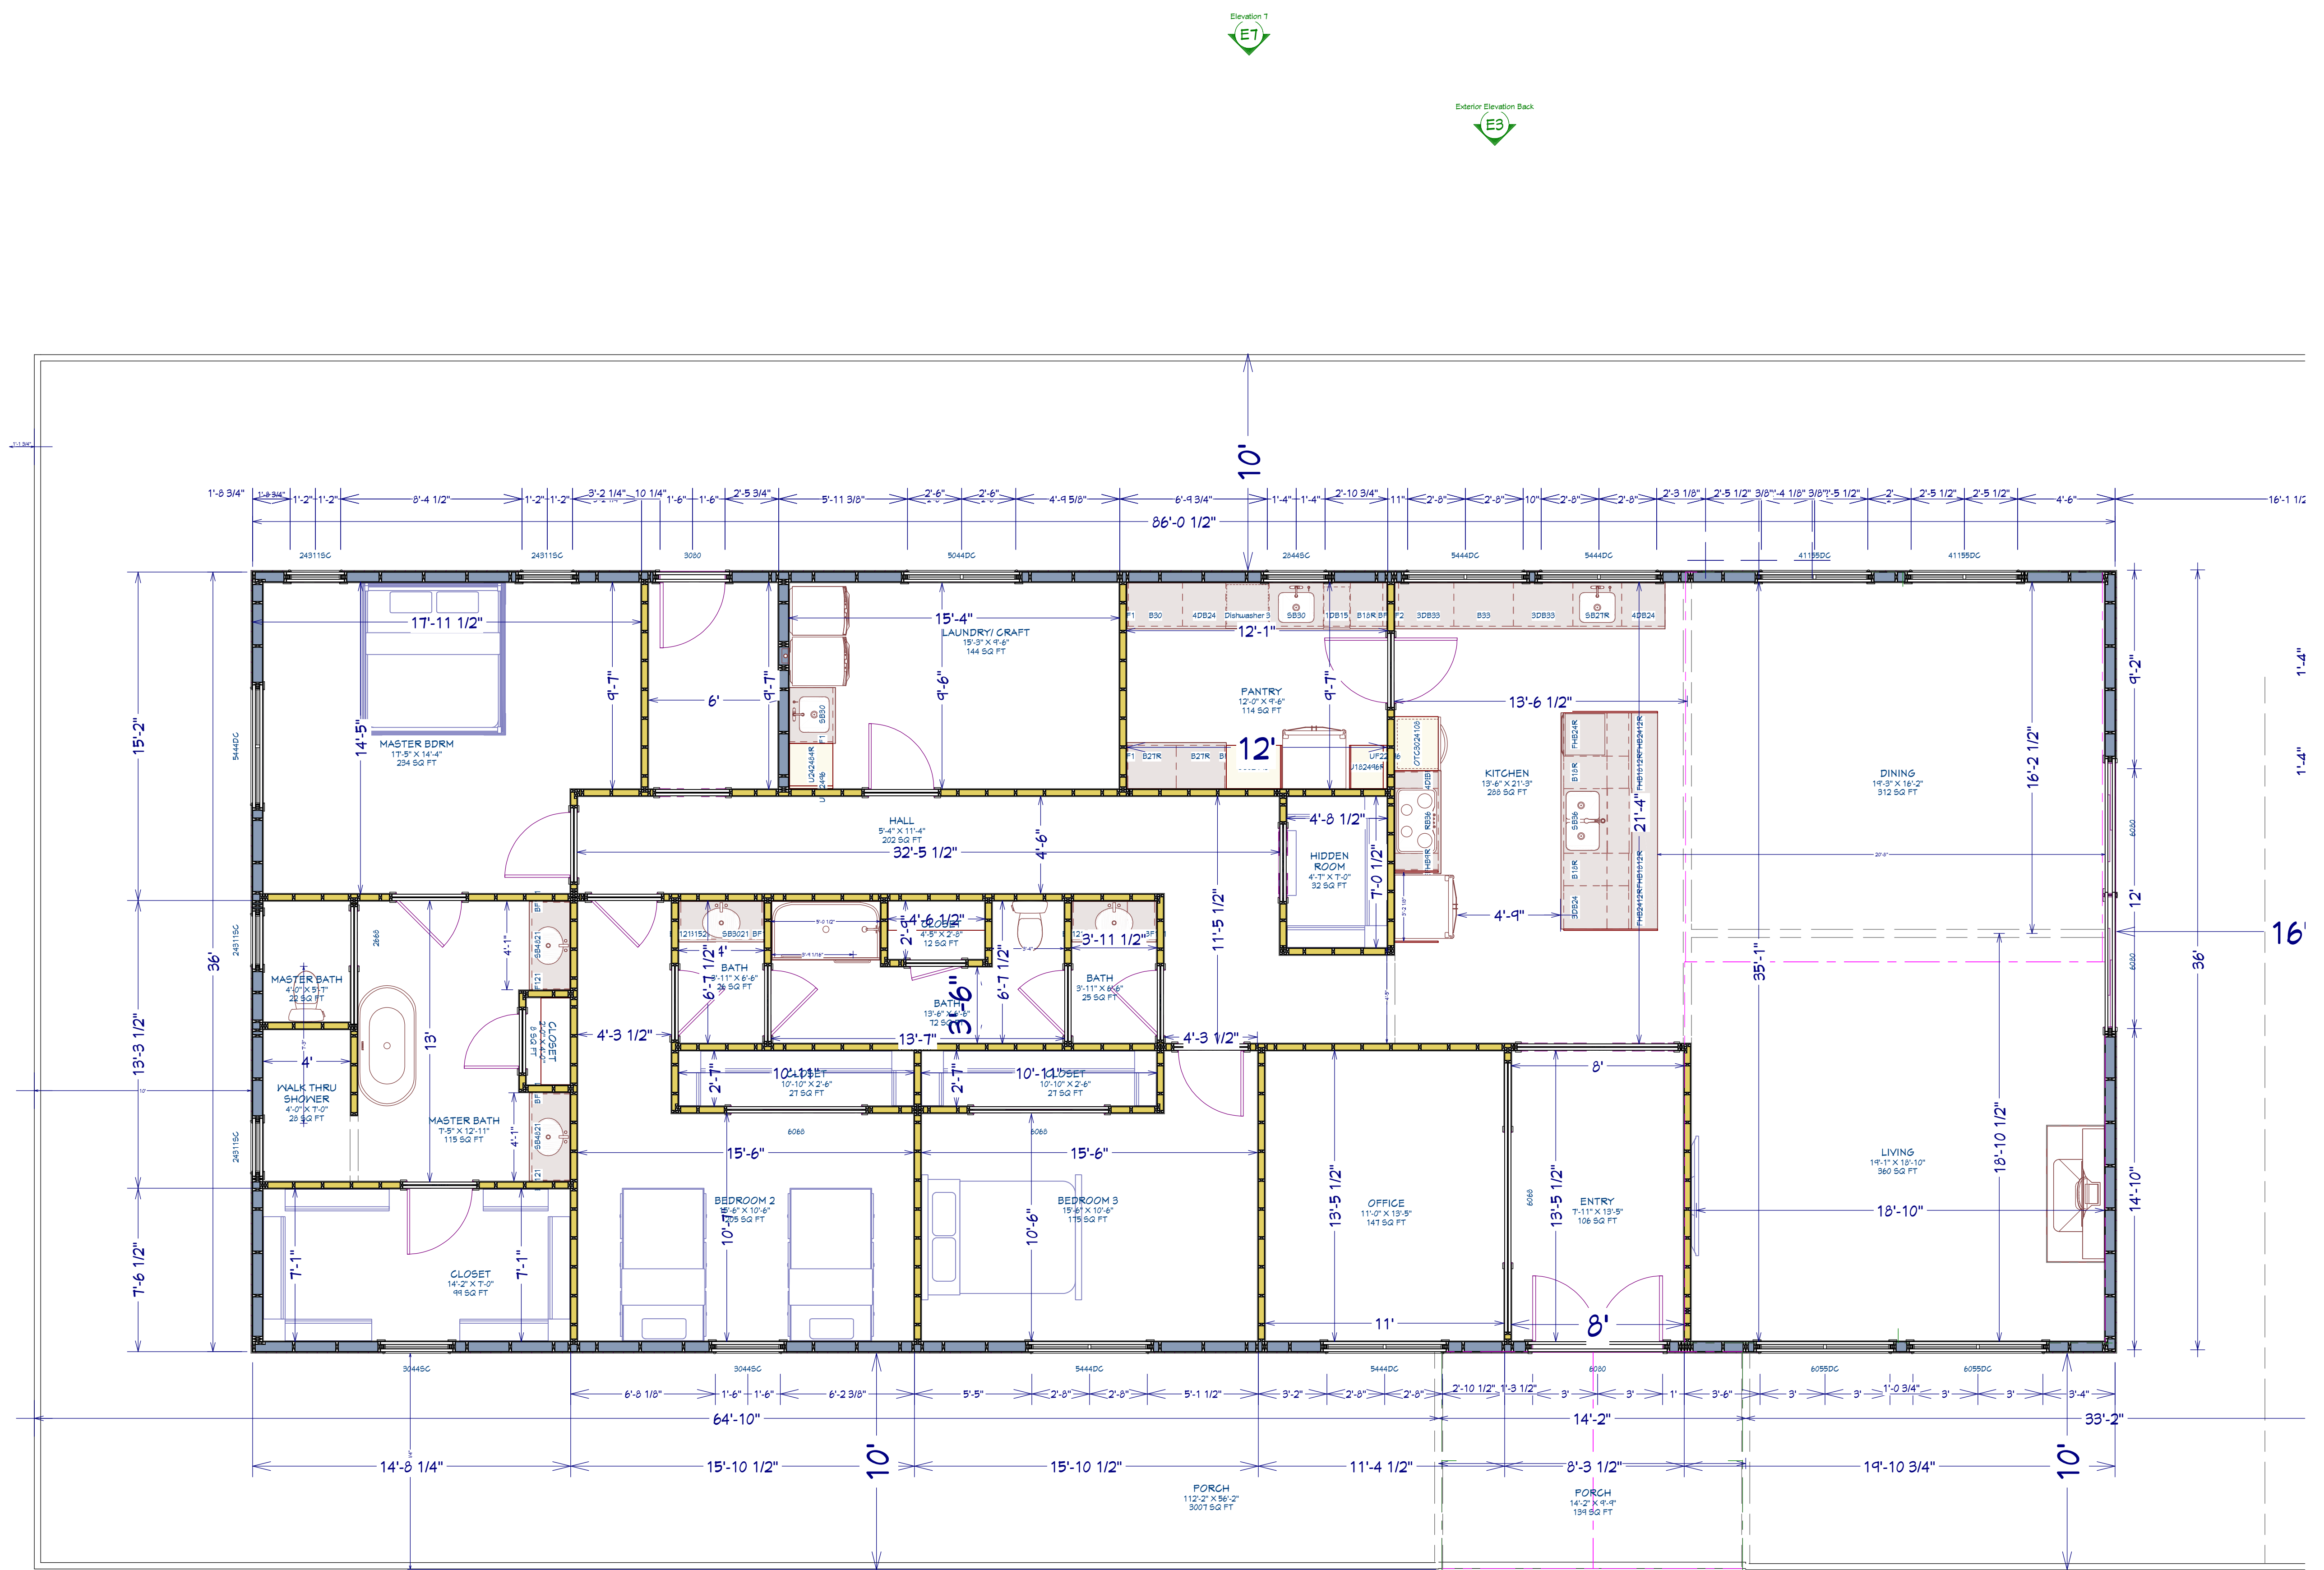

**MAIN FLOOR FRAMING PLAN**

LIVING AREA  
3440 SQ FT

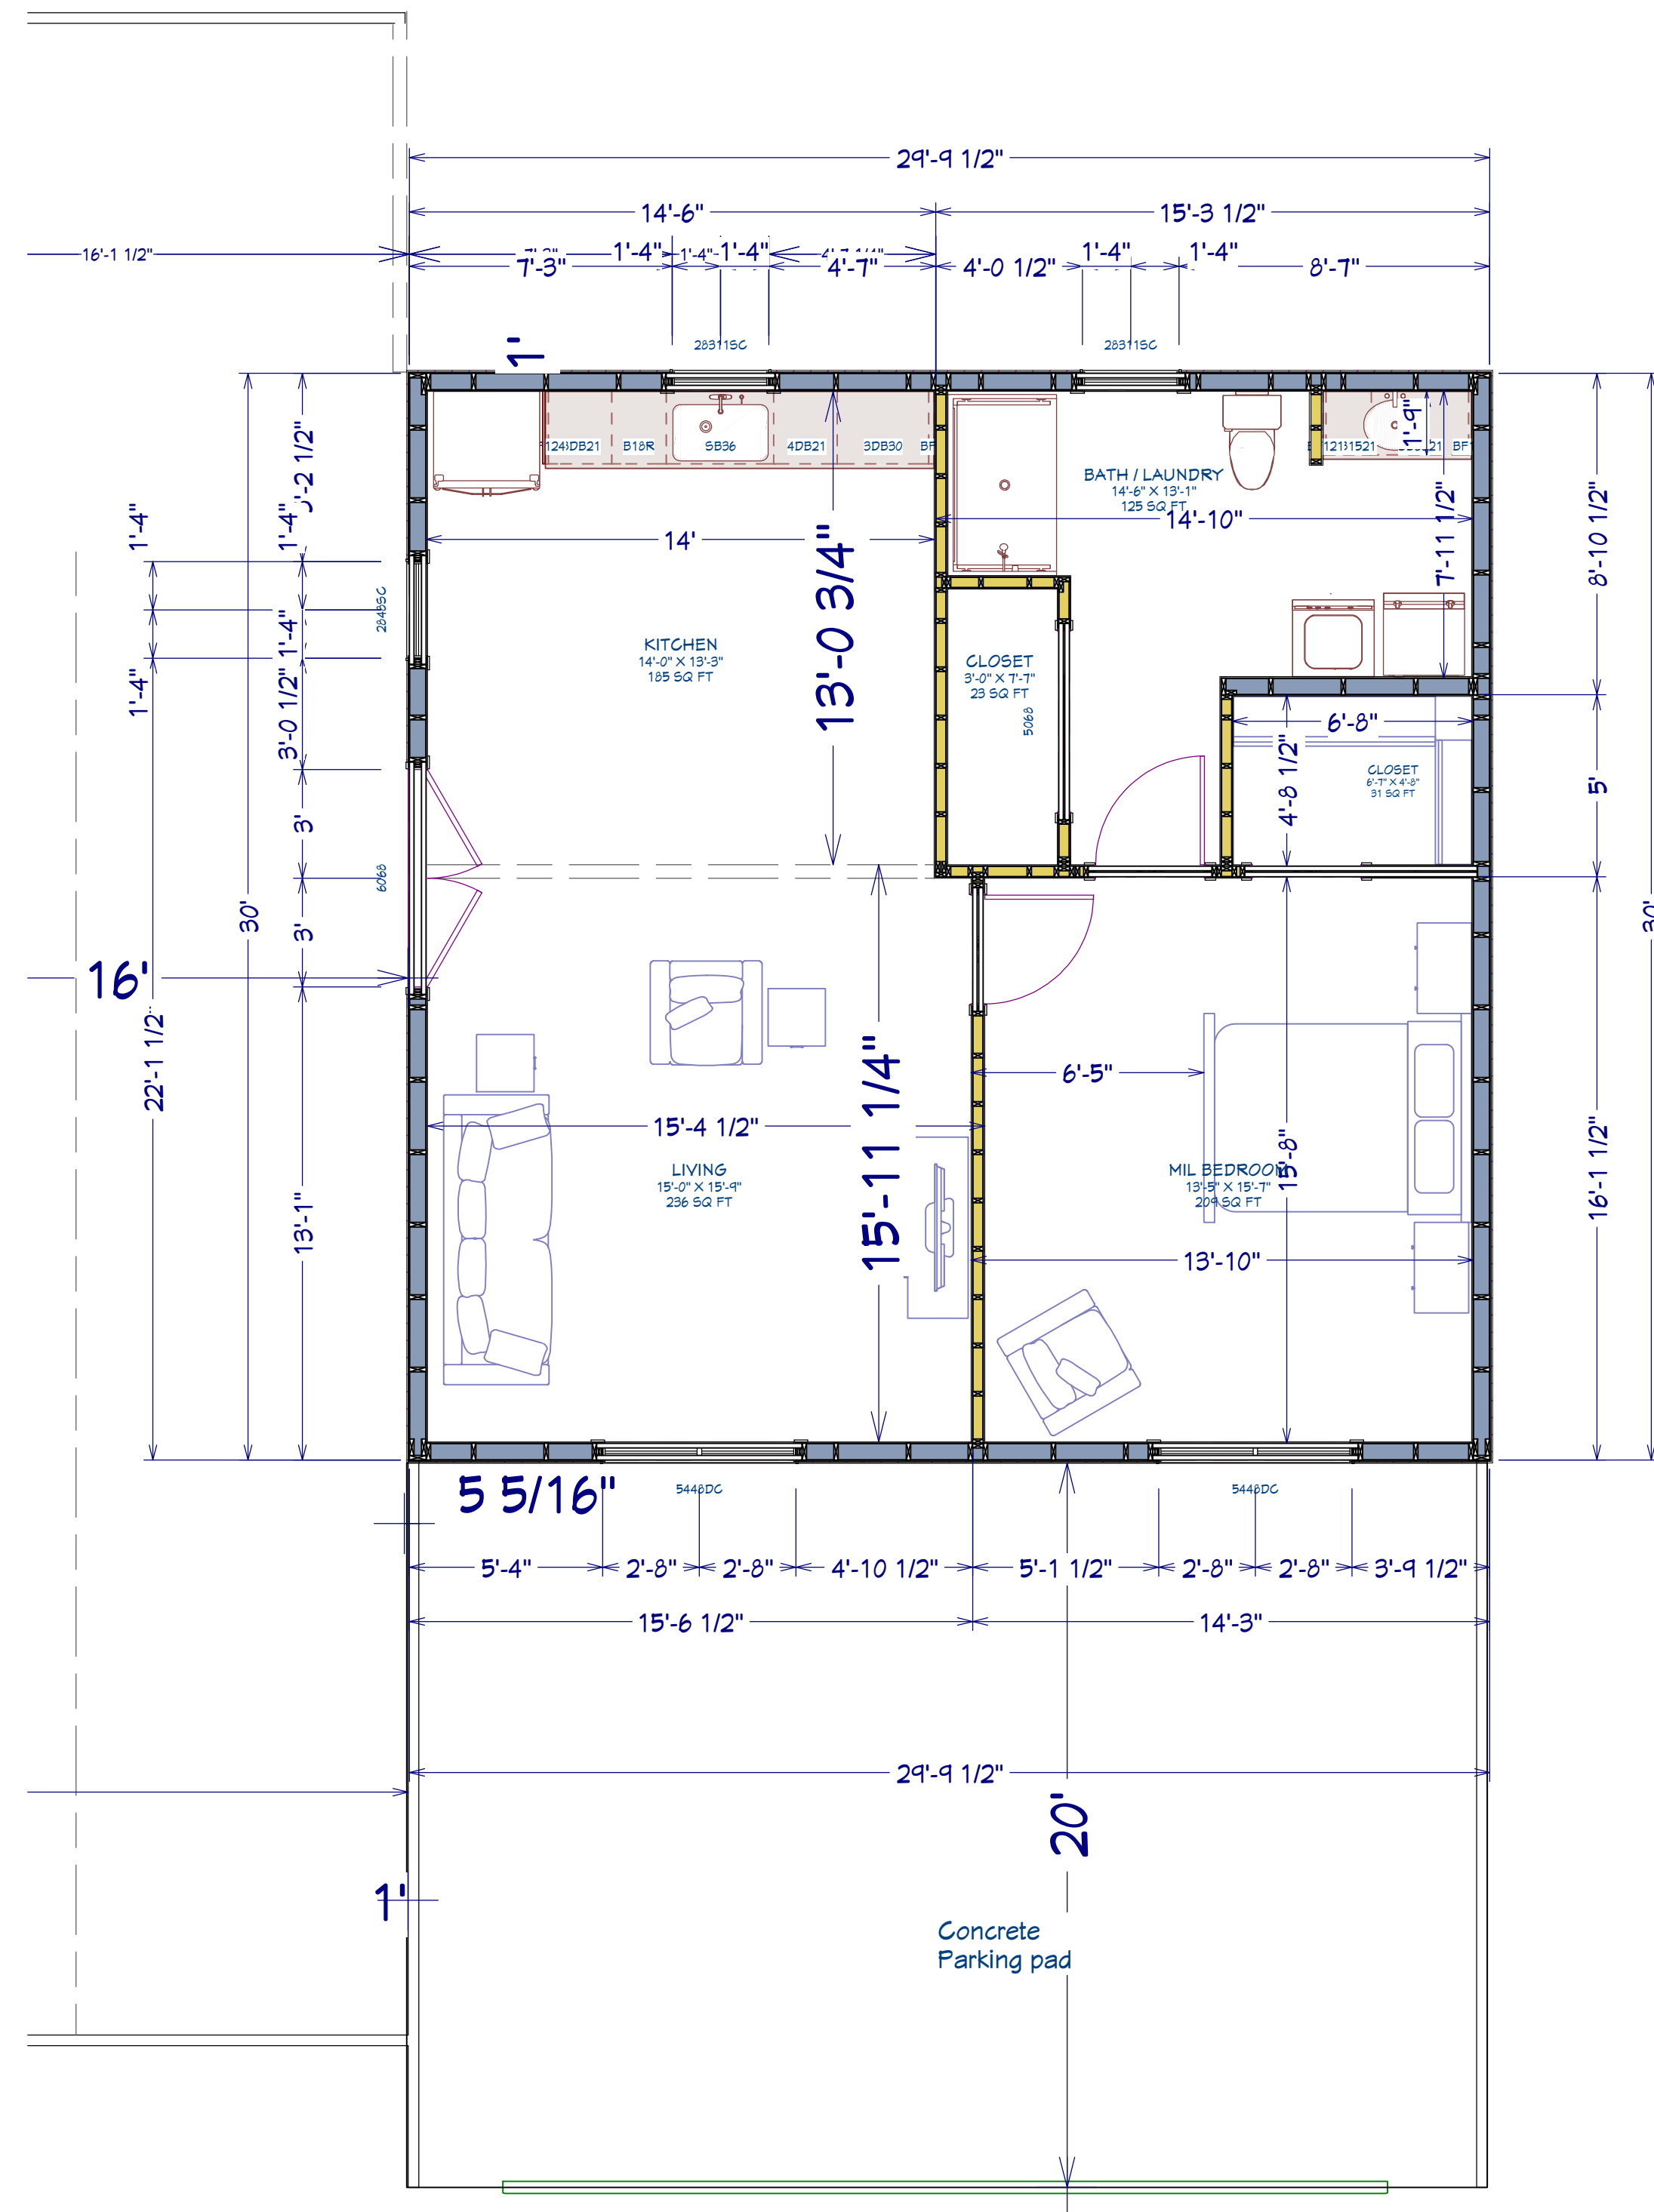

GUEST HOUSE FRAMING PLAN

REVISION TABLE	
NUMBER	DATE

**GUEST HOUSE  
FRAMING PLAN**

DRAWINGS PROVIDED BY:

DATE:

2/5/2023


SCALE:

1/4" = 1' - 0"

SHEET:

**S2**

ROOF FRAMING LEGEND	
#	DESCRIPTION
1	14" LAMINATED RIDGE BEAM
2	14" LVL RIDGE BEAM
3	(3) 16" LVL BEAMS
4	2 x 10 RIDGE BEAM
5	(2) 2 x 10 BEAMS
6	2 x 10 RAFTERS @ 1' - 4" OC
7	2 x 8 RAFTERS @ 1' - 4" OC
8	2 x 6 COLLAR TIES, 1/3 DN FROM RIDGE TO CLG
9	1 x 6 FASCIA BOARD, TYP

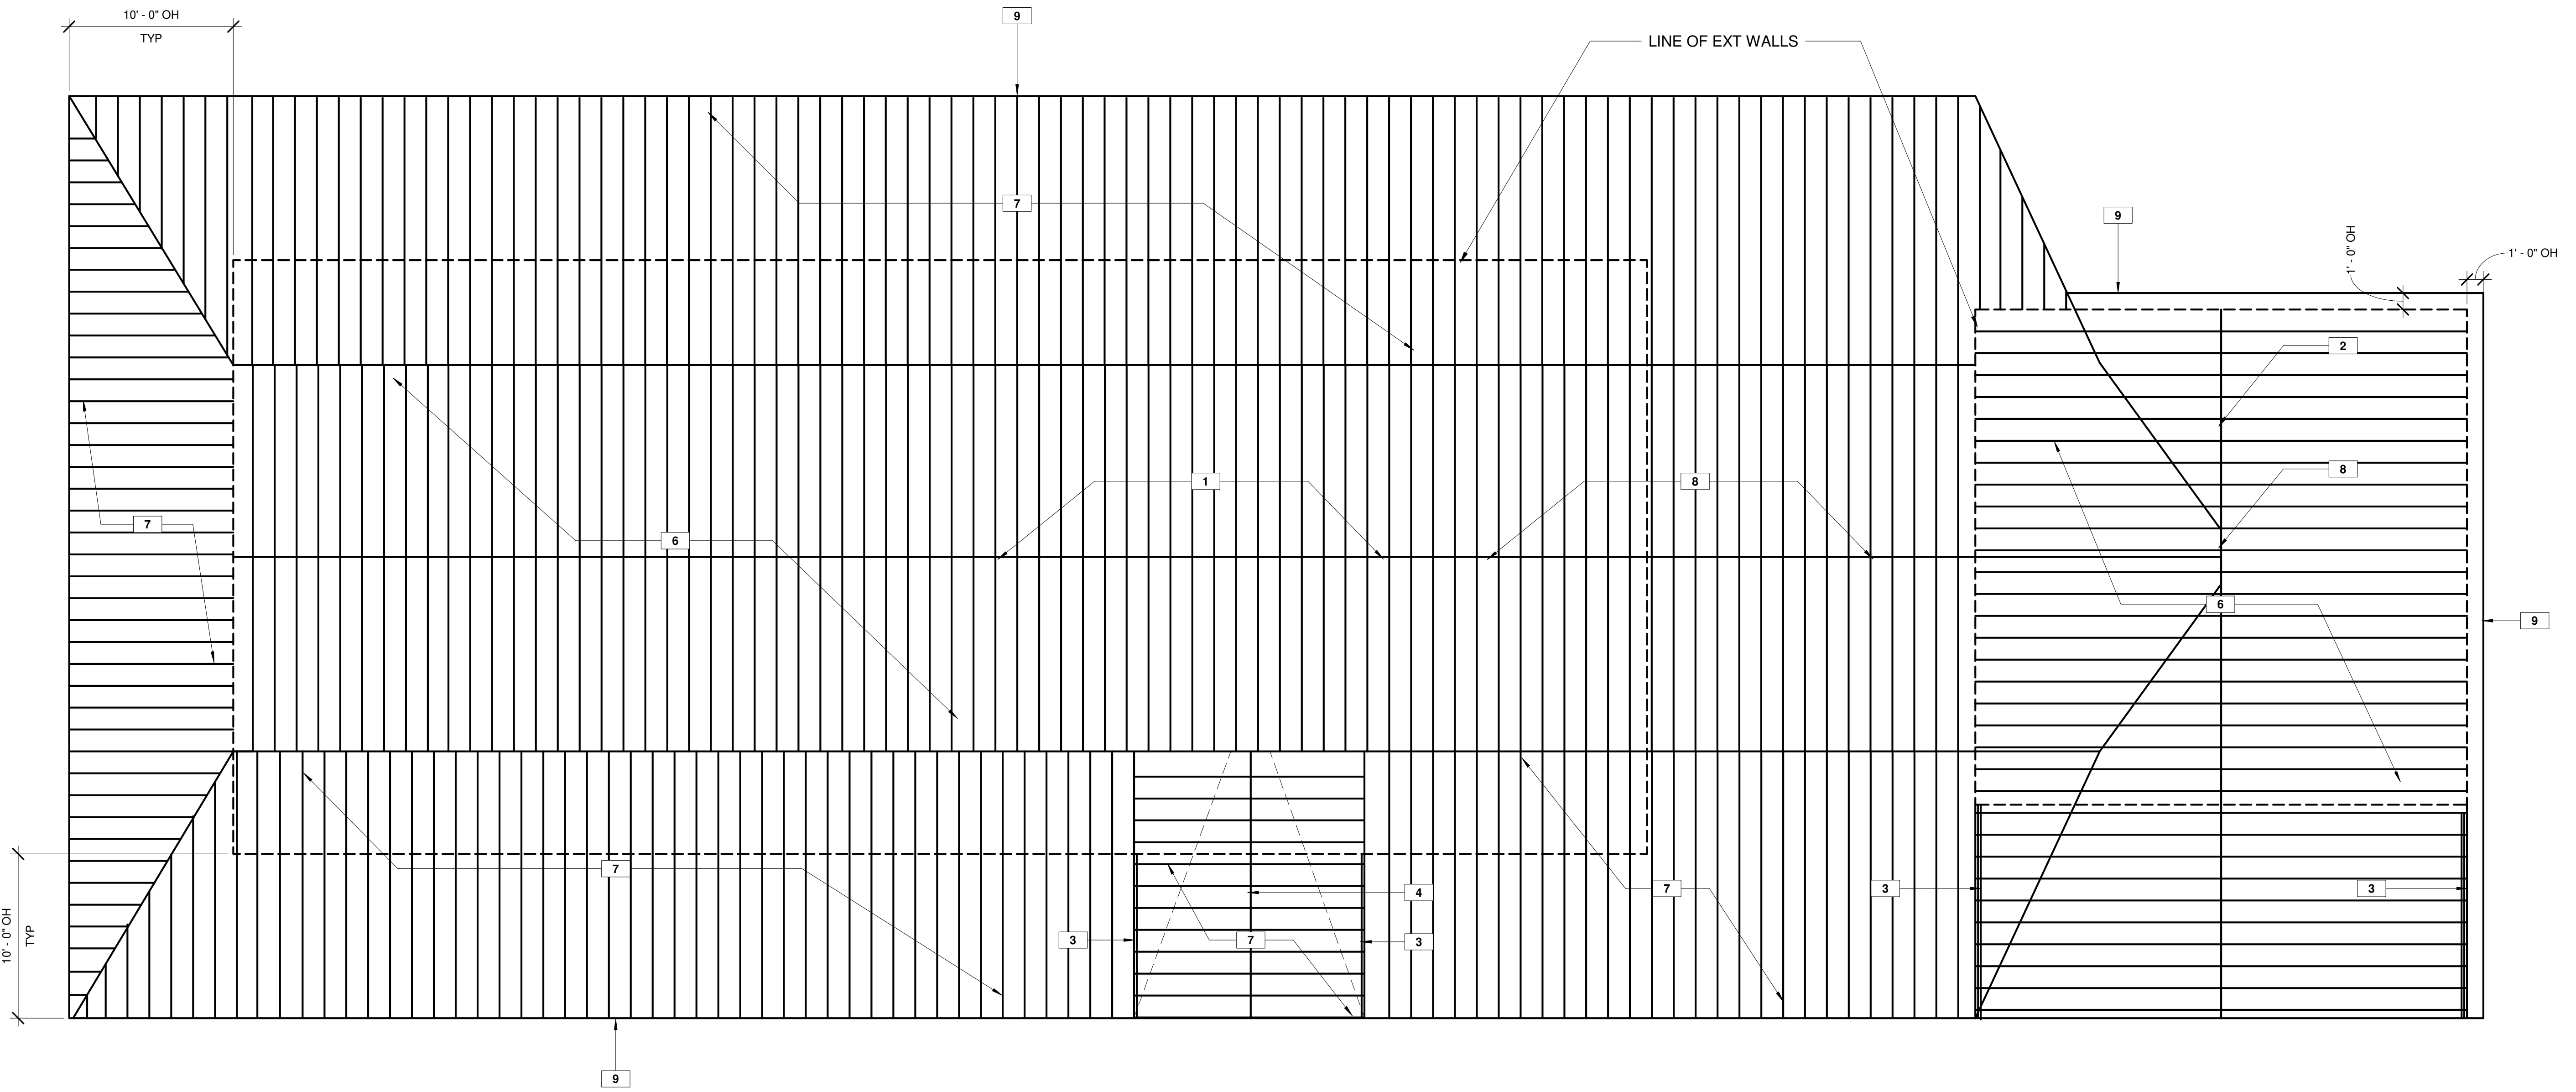

REVISION TABLE	
NUMBER	DATE

ROOF FRAMING  
PLAN

DATE:  
4/14/2023

SCALE:  
3/16" = 1' - 0"

SHEET: