


MAIN HOUSE PLAN

DATE: 2/5/2023
 SCALE: 1/4" = 1'-0"
 SHEET: A1

MAIN HOUSE PLAN

REVISION TABLE		
NUMBER	DATE	REVISION DESCRIPTION

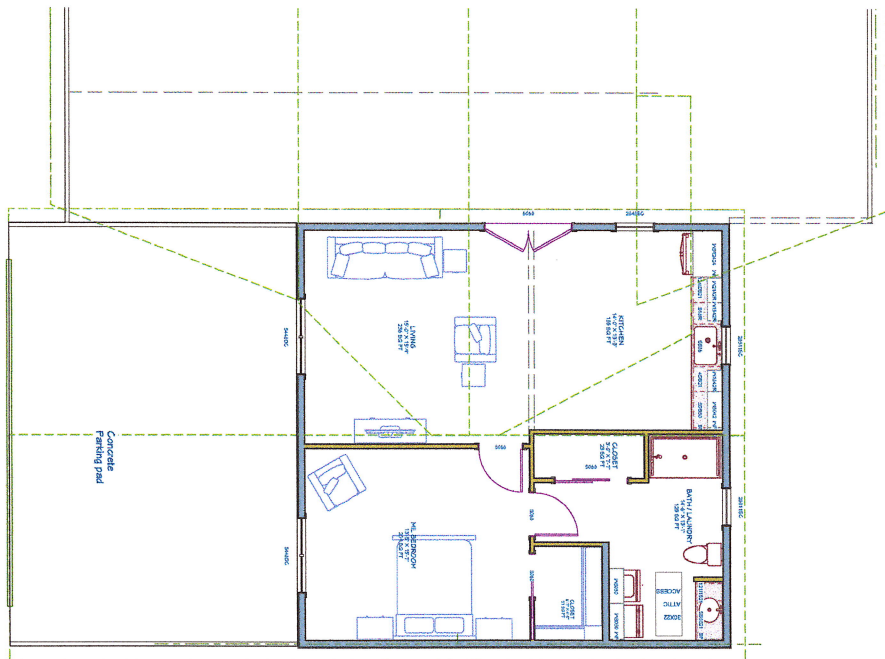


GUEST HOUSE PLAN



REVISION TABLE		
NUMBER	DATE	REVISION DESCRIPTION

GUEST HOUSE PLAN

DATE: 2/5/2023
 SCALE: 1/4" = 1' - 0"
 SHEET: A2

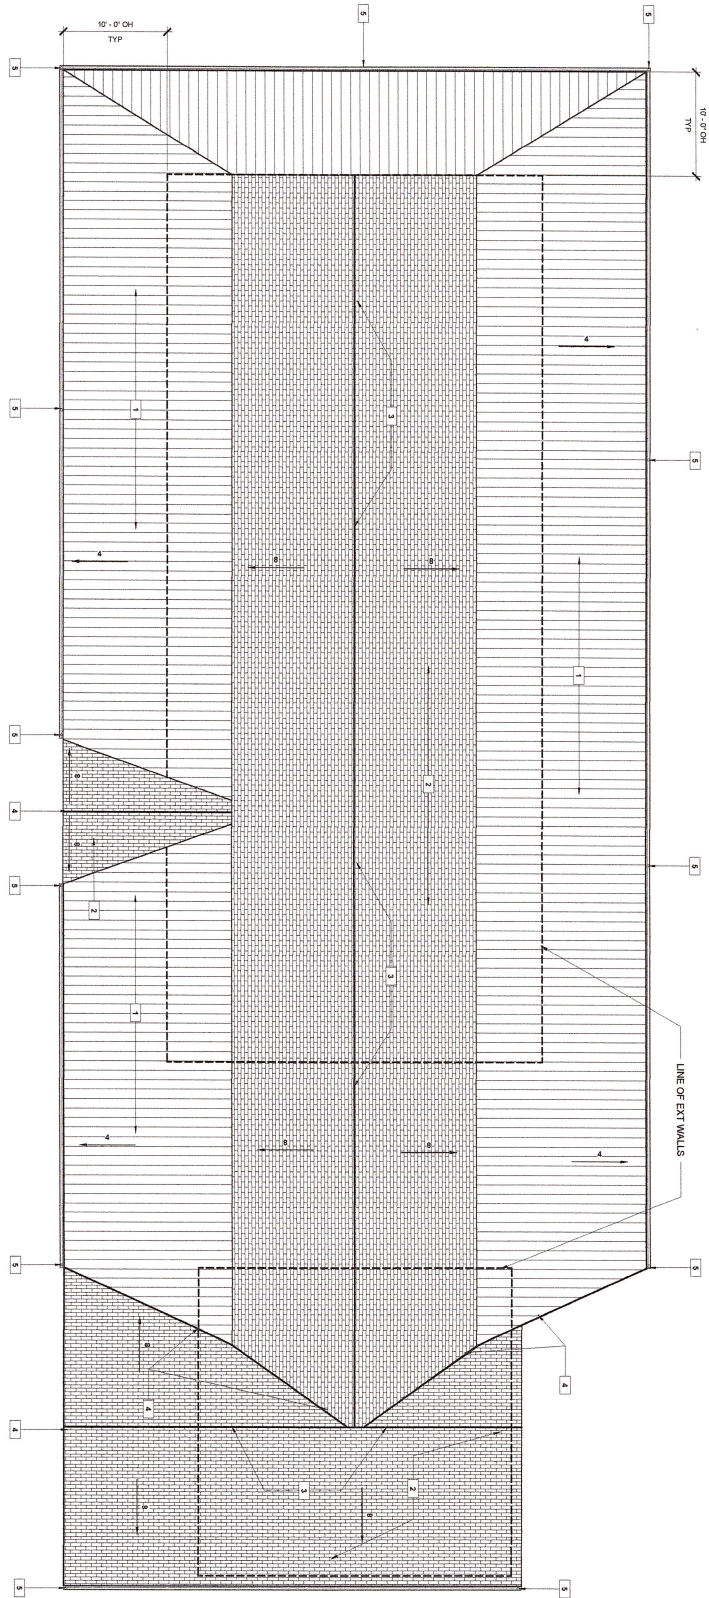

ROOF FRAMING LEGEND


#	DESCRIPTION
1	STANDING SEAM MET. HIP ROOF REFER TO SPEC
2	ASPHALT SINGLE ROOF REFER TO SPEC
3	ROOF JOINT
4	REFER TO ELEVATIONS
5	GUTTER / DOWNSPOUT REFER TO SPEC

REVISION TABLE


NUMBER	DATE	REVISED BY	DESCRIPTION

ROOF PLAN

DATE: _____
 4/14/2023
 SCALE: _____
 3/16" = 1'-0"
 SHEET: _____
 A3

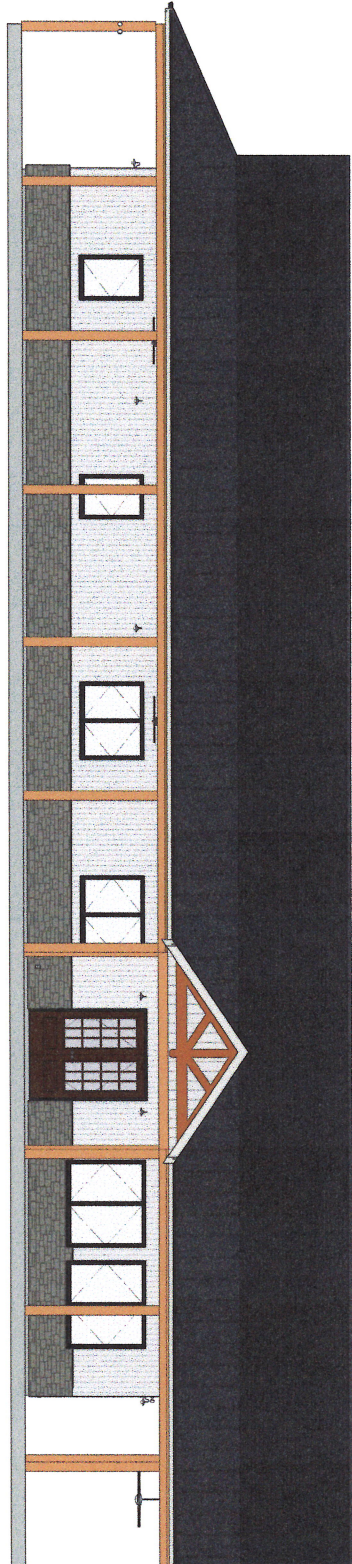

ENTRY ELEVATION

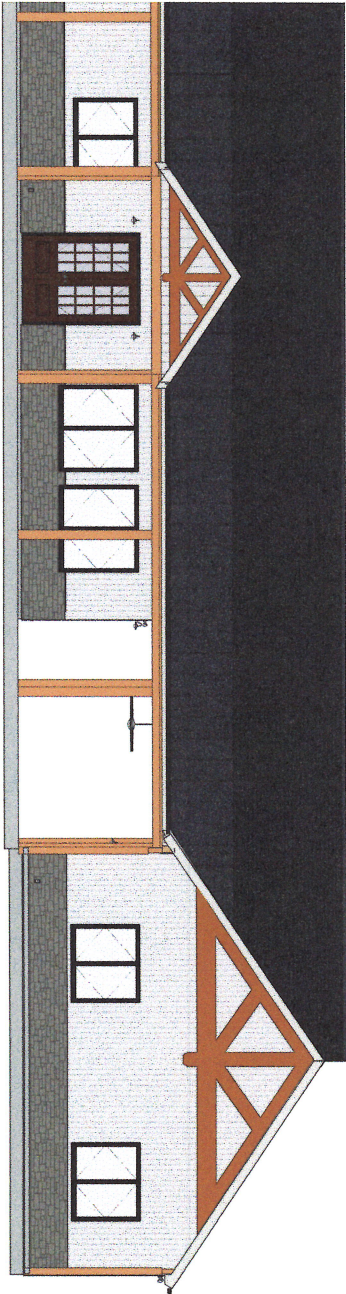

ENTRY ELEVATION, CONT'D


REVISION TABLE		
NUMBER	DATE	REVISION DESCRIPTION

ENTRY ELEVATIONS


DATE:
2/5/2023

SCALE:
1/4" = 1'-0"

SHEET:
A4

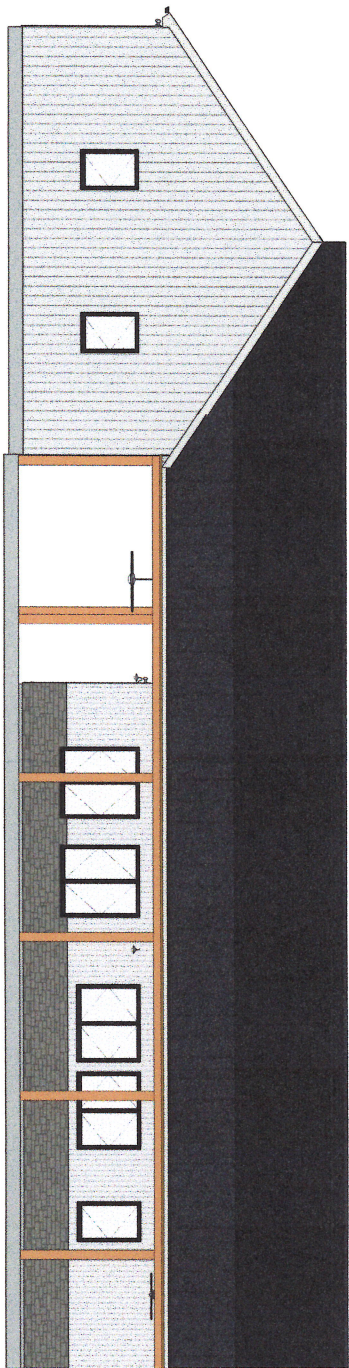

REAR ELEVATION

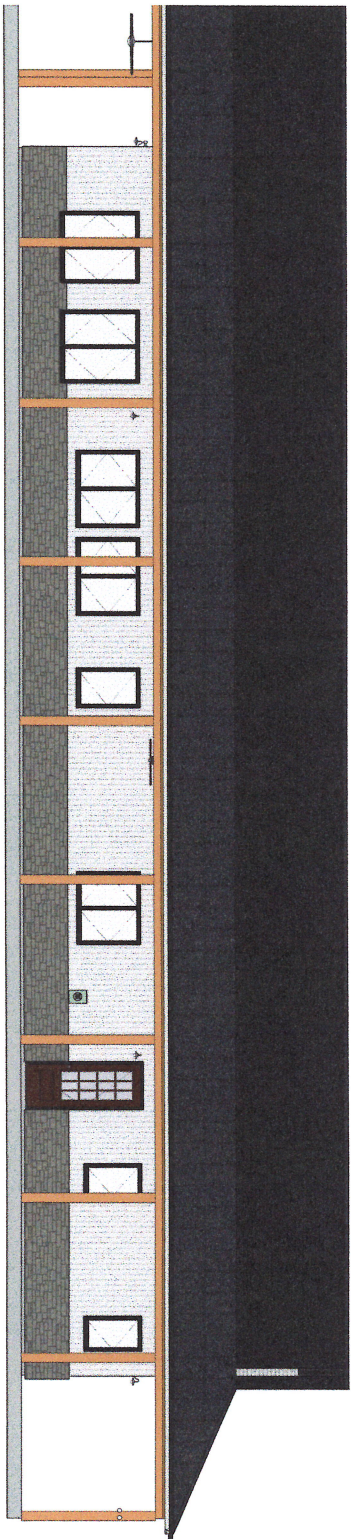

REAR ELEVATION, CONT'D


REVISION TABLE			
NUMBER	DATE	REVISOR	DESCRIPTION

REAR ELEVATIONS


DATE: 2/5/2023

SCALE: 1/4" = 1'-0"

SHEET: A5

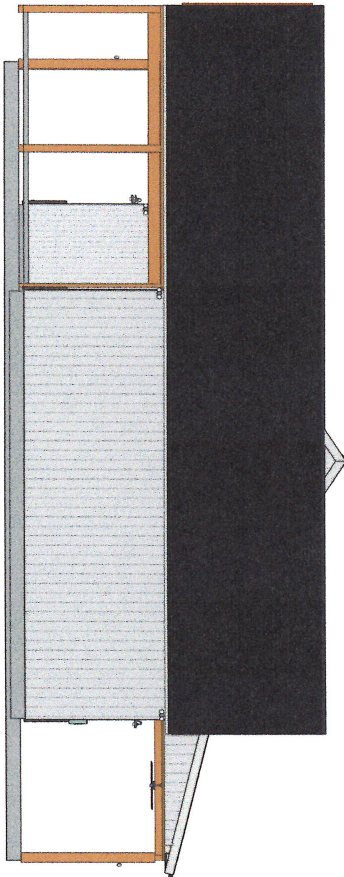

EXTERIOR ELEVATION, RIGHT

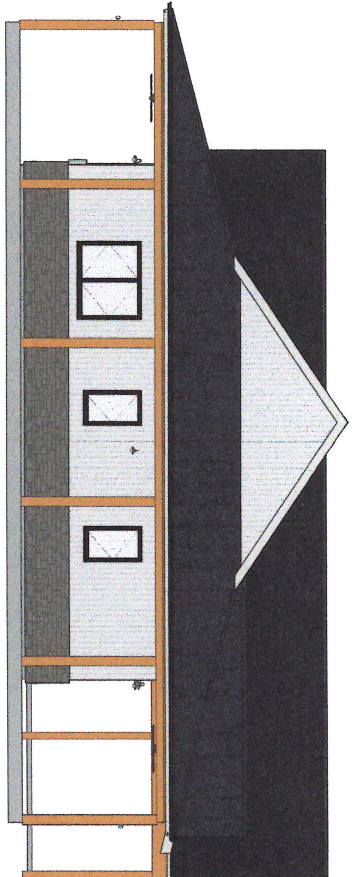


EXTERIOR ELEVATION, LEFT

REVISION TABLE			
NUMBER	DATE	REVISED BY	DESCRIPTION

LEFT & RIGHT ELEVATIONS

DATE: 2/5/2023
 SCALE: 1/4" = 1' - 0"
 SHEET: A6


MAIN HOUSE ELECTRICAL PLAN

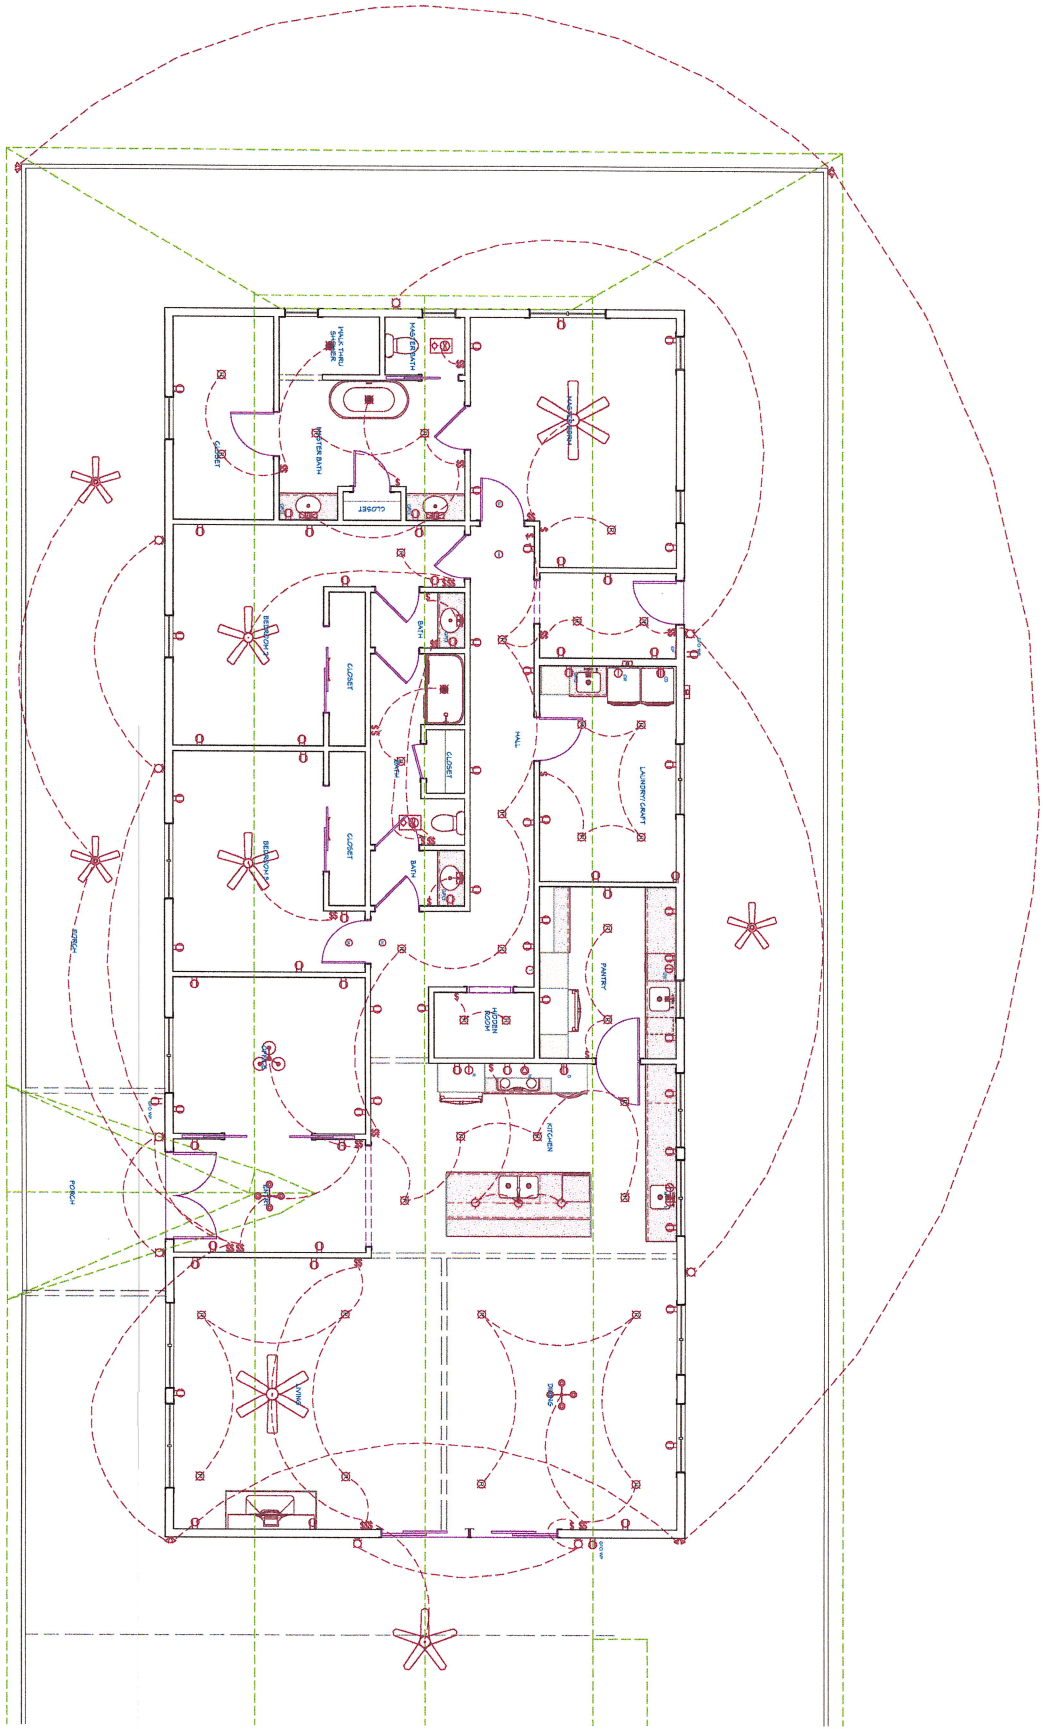

DATE: 2/5/2023
 SCALE: 1/4" = 1' - 0"
 SHEET: E1

MAIN HOUSE ELECTRICAL PLAN

REVISION TABLE		
NUMBER	DATE	REVISION DESCRIPTION

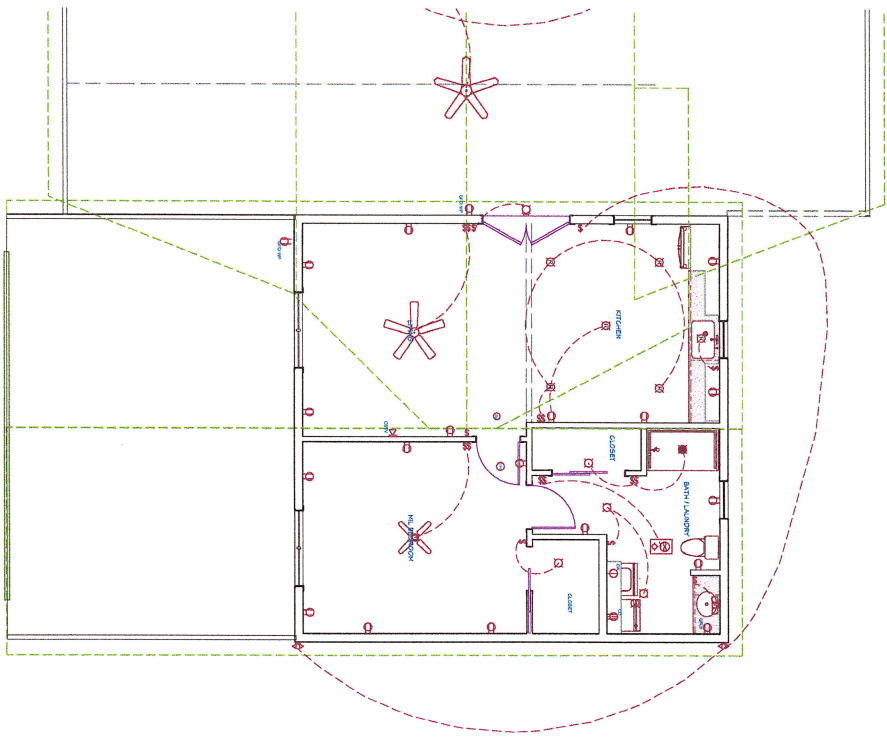

GUEST HOUSE ELECTRICAL PLAN

DATE: _____
 2/9/2023
 SCALE: _____
 1/4" = 1' - 0"


GUEST HOUSE ELECTRICAL PLAN

REVISION TABLE			
NUMBER	DATE	REVISED BY	DESCRIPTION

SHEET: E2


FOUNDATION PLAN

3/8" = 1'-0"

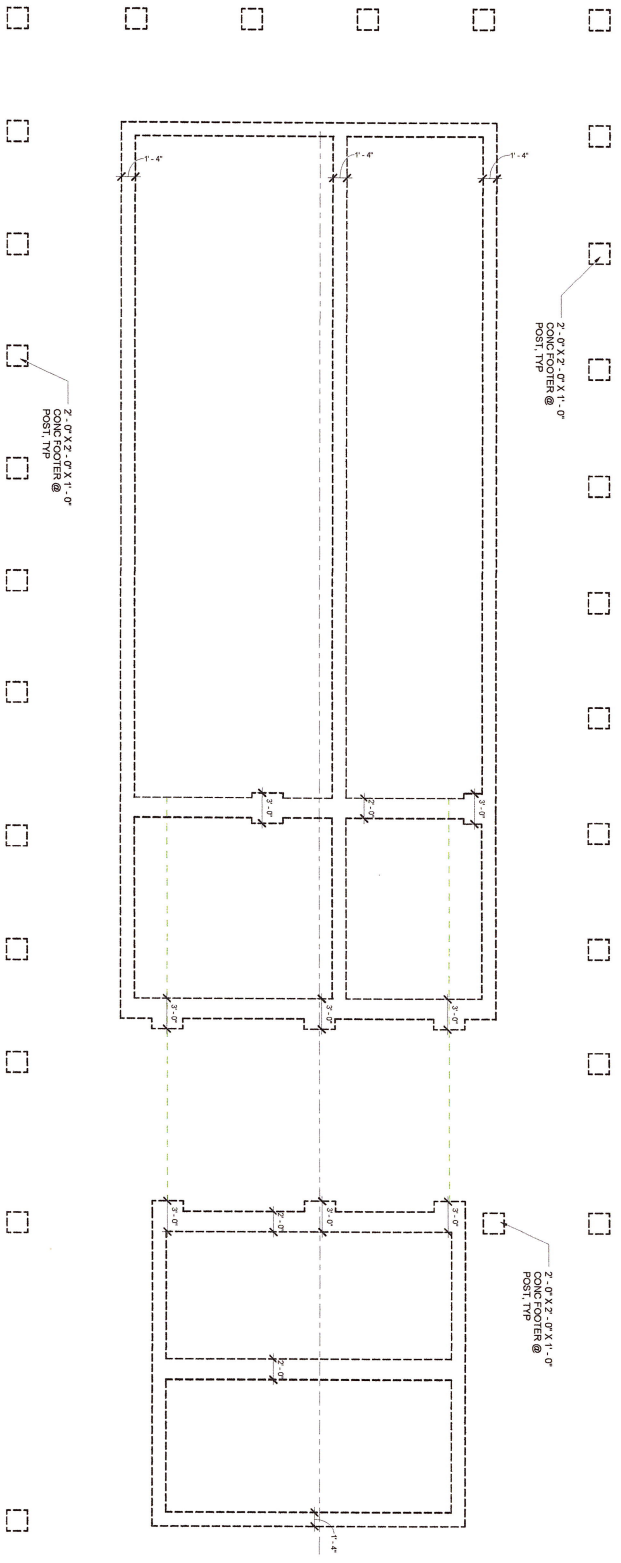

WALL SECTION @ FTG

3/8" = 1'-0"

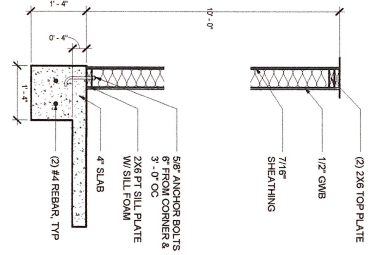


FOUNDATION PLANS & WALL SECTION

REVISION TABLE			
NUMBER	DATE	REVISED BY	DESCRIPTION

DATE: 4/14/2023

SCALE: AS SHOWN

SHEET: S1

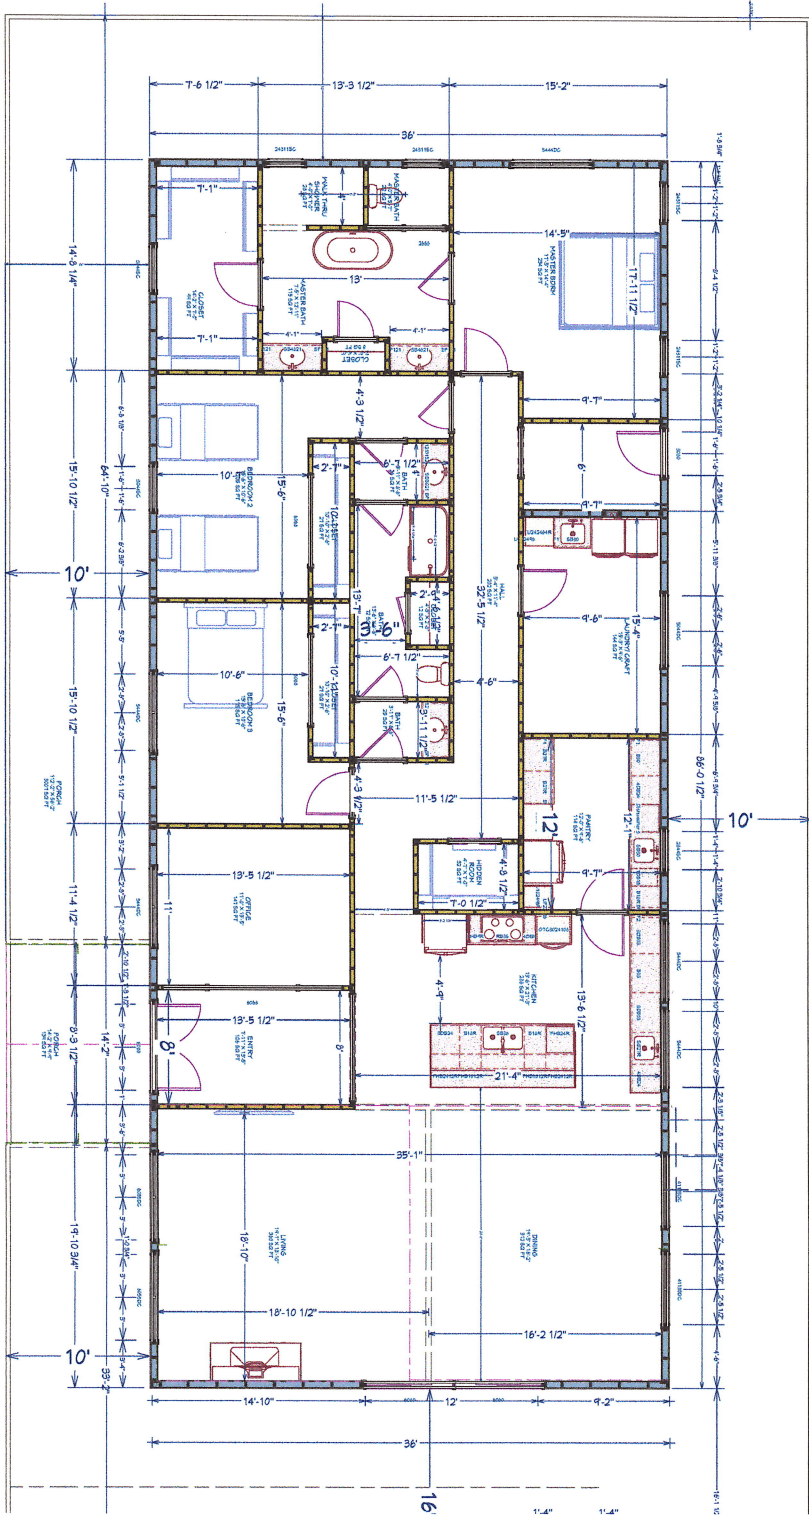


MAIN FLOOR FRAMING PLAN



DATE: 2/5/2023
 SCALE: 1/4" = 1'-0"
 SHEET: S1

MAIN HOUSE FRAMING PLAN

REVISION TABLE		
NUMBER	DATE	DESCRIPTION

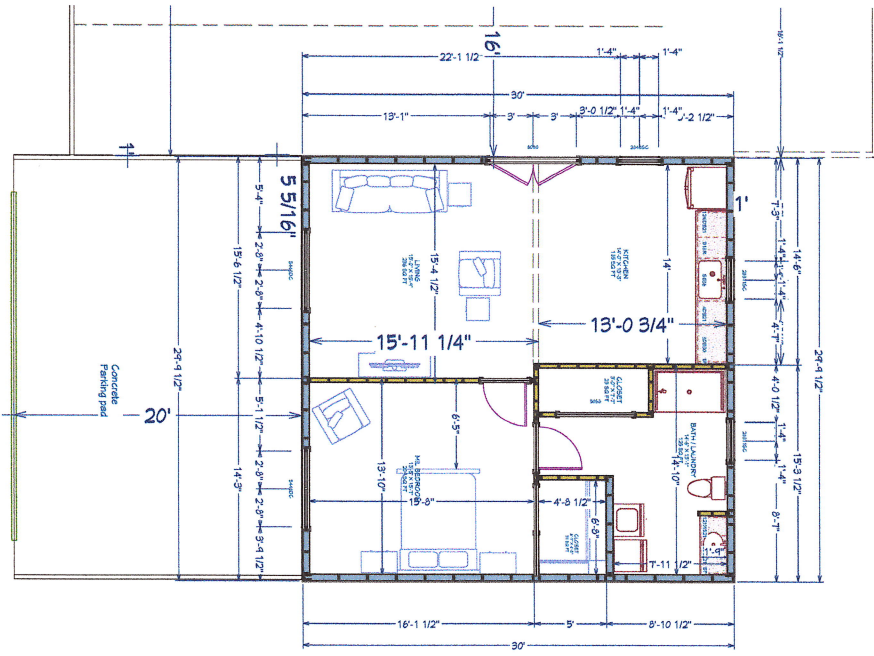


GUEST HOUSE FRAMING PLAN

DRAWINGS PROVIDED BY:
 DATE:
 2/5/2023
 SCALE:
 1/4" = 1' - 0"
 SHEET:
 S2

GUEST HOUSE FRAMING PLAN

REVISION TABLE		
NUMBER	DATE	DESCRIPTION

REVISION TABLE		
NUMBER	DATE	DESCRIPTION

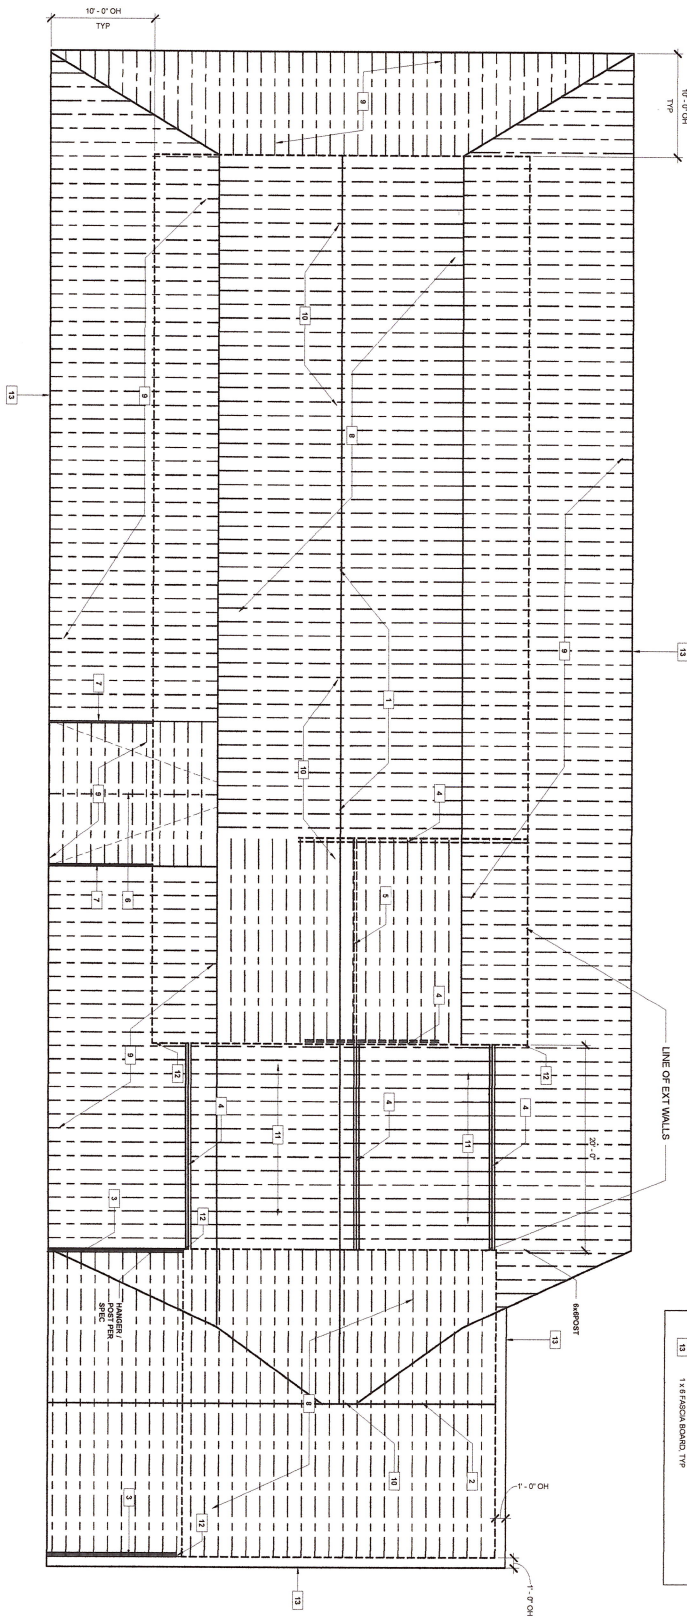


ROOF FRAMING LEGEND	
#	DESCRIPTION
1	1/2 LAMINATED ROOF BEAM
2	1/2 LVL ROOF BEAM
3	3/4 LVL BEAMS
4	3/4 LVL BEAMS
5	3/4 LVL ROOF BEAM
6	2 X 10 ROOF BEAM
7	2 X 10 BEAMS
8	2 X 10 RAFTERS @ 1'-0" OC
9	2 X 8 RAFTERS @ 1'-0" OC
10	2 X 6 COLUMN TIE, 1/2 IN FROM ROOF TO OLD
11	2 X 6 COLUMN TIE, 1/2 IN FROM ROOF TO OLD
12	BEAM JOCKET
13	1 X 6 PLYWOOD BOARD TYP

REVISION TABLE			
NUMBER	DATE	REVISED BY	DESCRIPTION

ROOF FRAMING PLAN

DATE: 4/14/2023
 SCALE: 3/16" = 1'-0"
 SHEET: S4

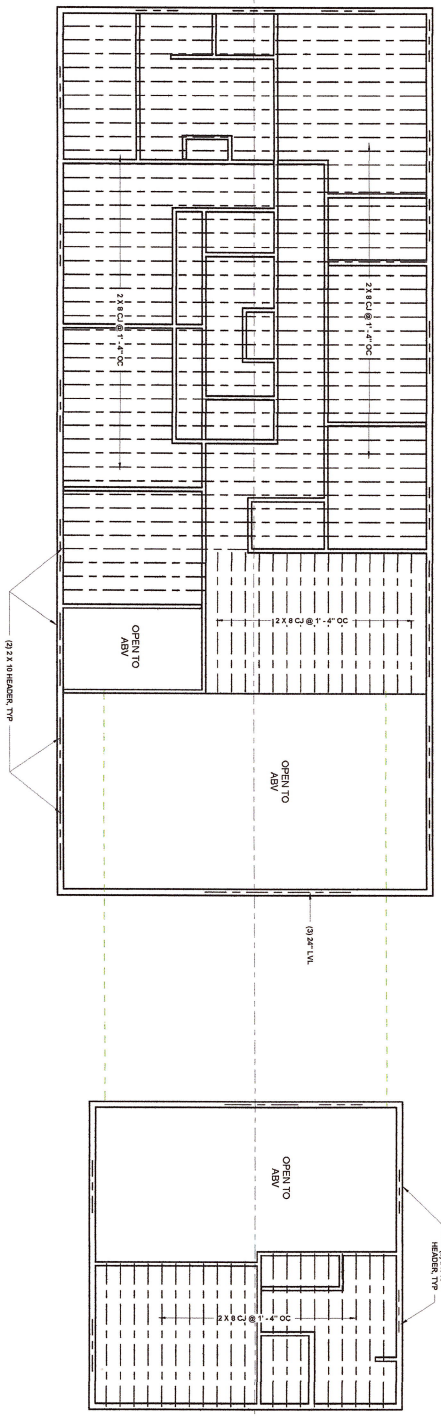

DATE: 4/14/2023
 SCALE: 3/16" = 1' - 0"
 SHEET: S4

CEILING FRAMING PLAN

REVISION TABLE			
NUMBER	DATE	REVISED BY	DESCRIPTION