


HVAC CONTRACTOR TO CONFIRM
VENT LOCATION AND SIZE OF UNIT

**HVAC PLAN
FIRST FLOOR**
SCALE: 1/4" = 1'0"

930 S/F ON FIRST FLOOR
1241 S/F ON SECOND FLOOR
2171 S/F TOTAL HEATED AREA
481 S/F IN DOUBLE GARAGE
96 S/F ON FRONT PORCH

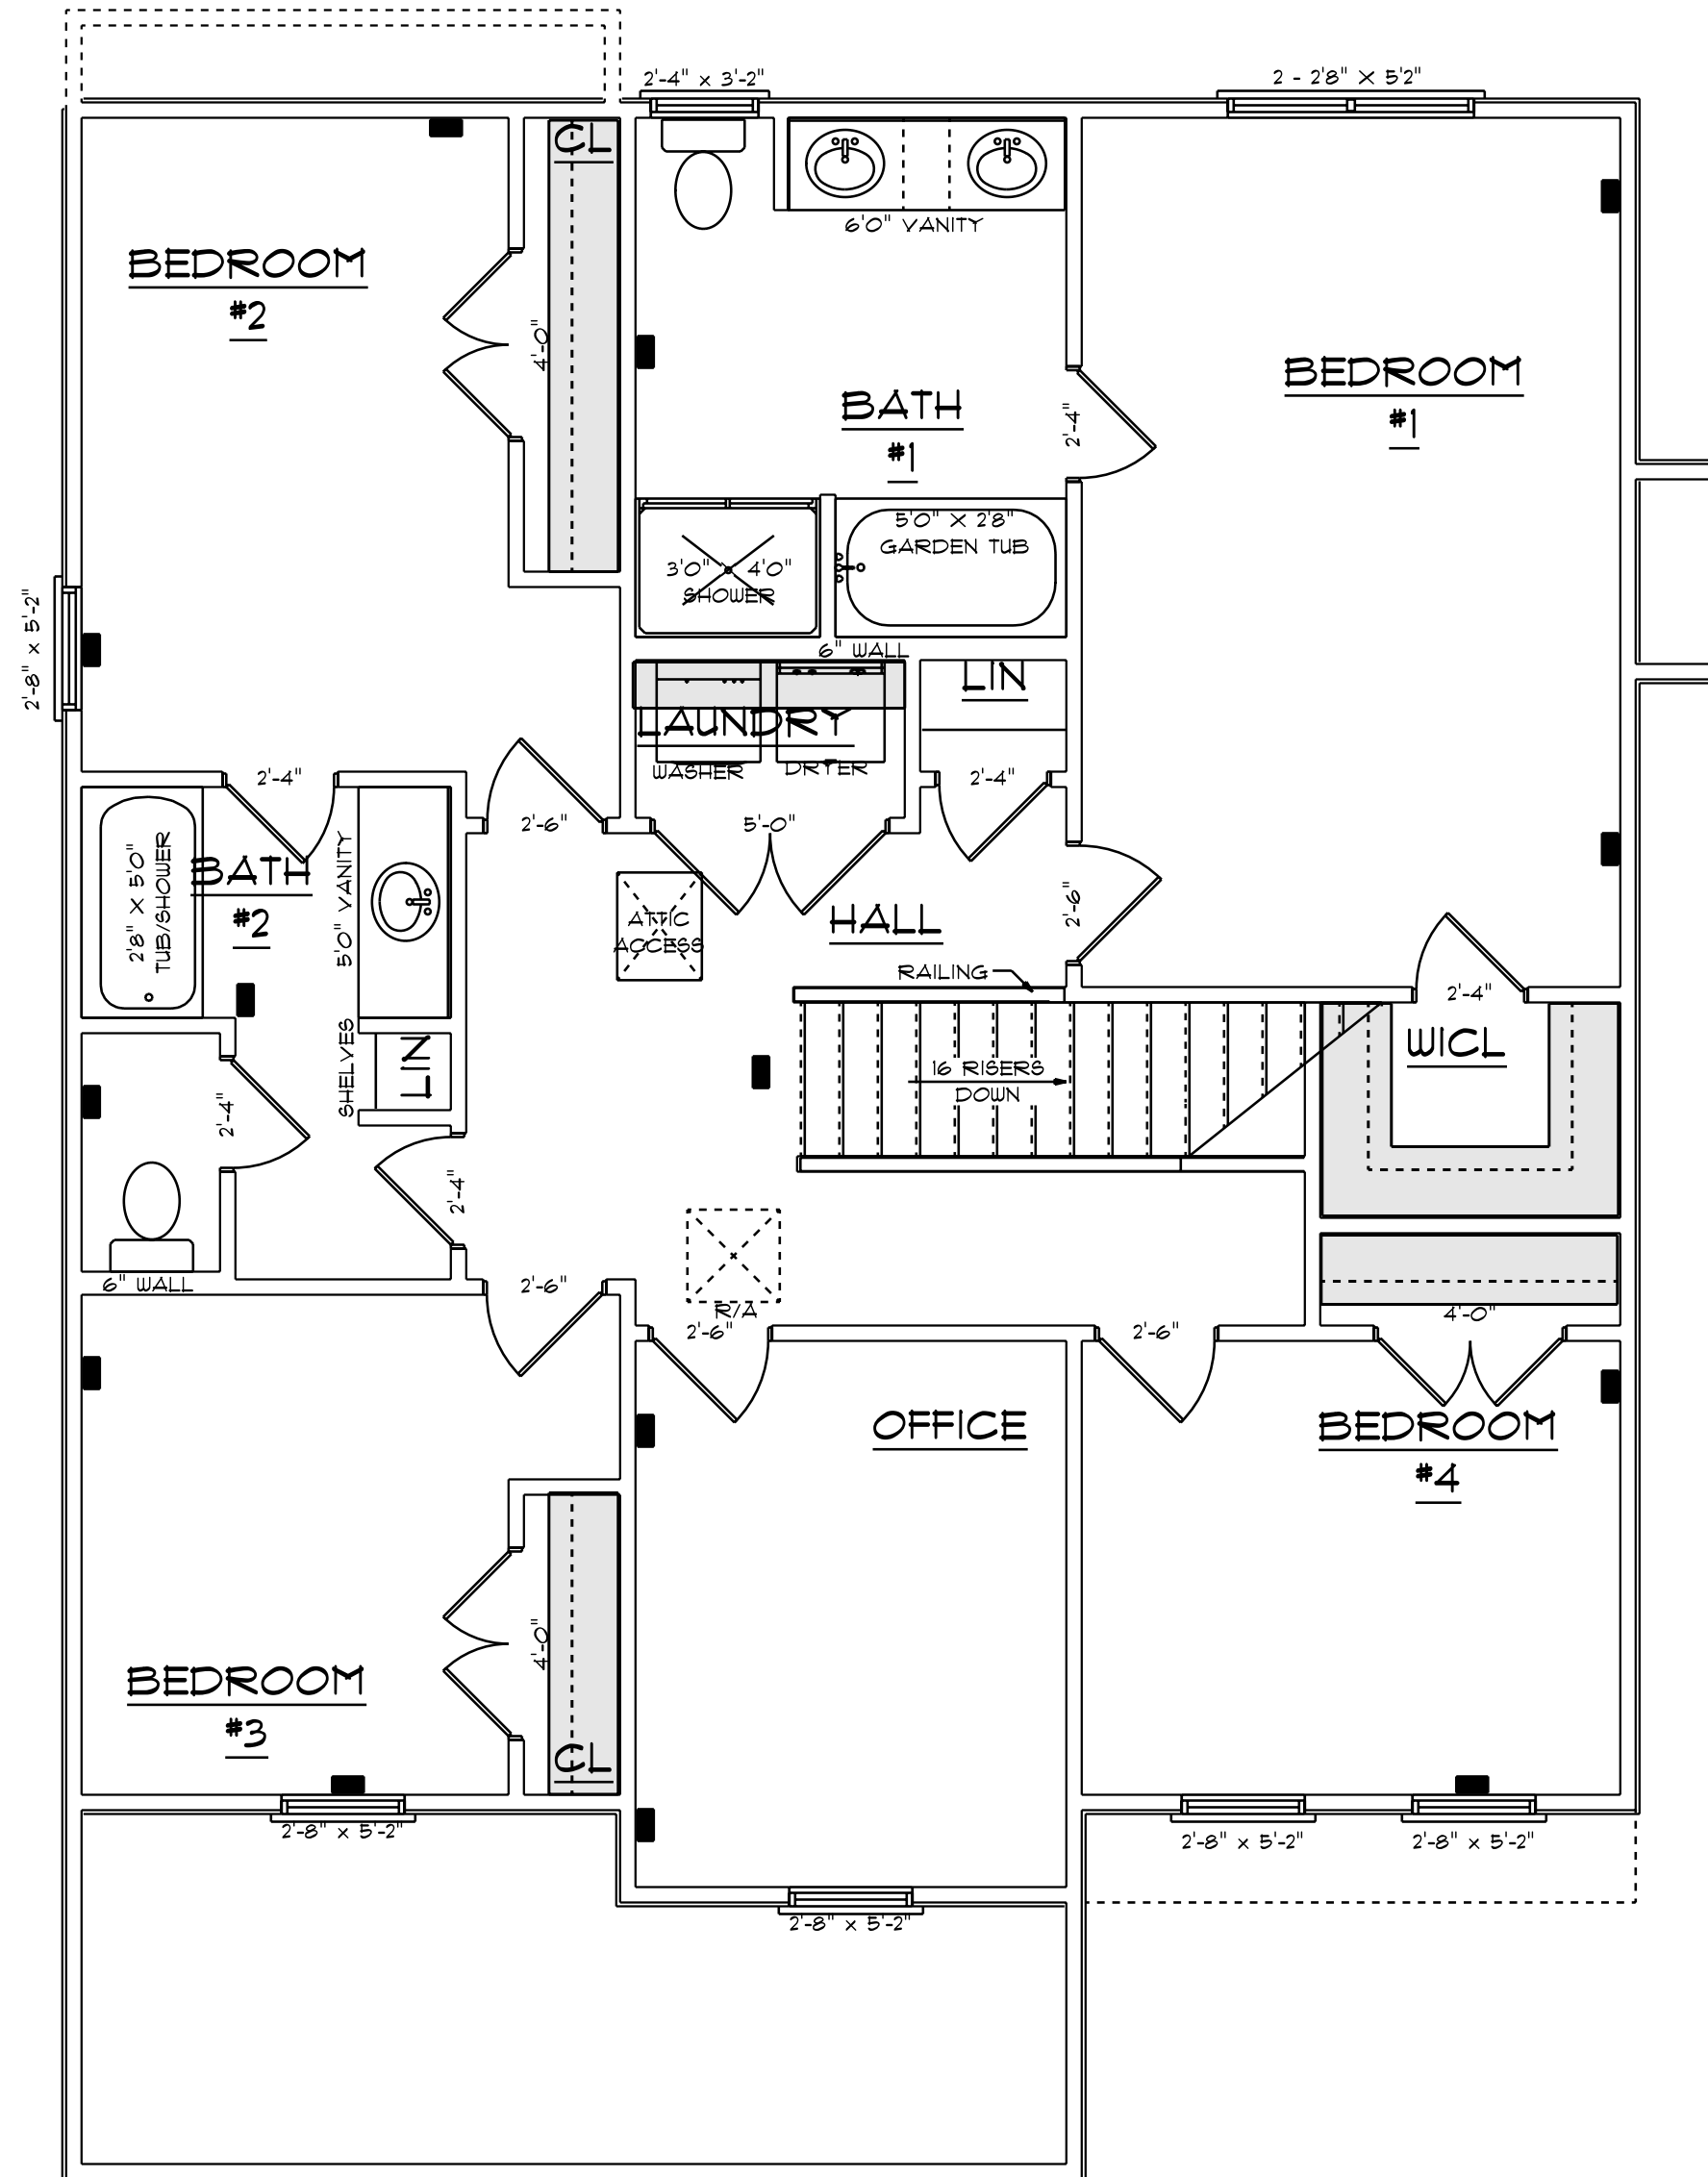

**HVAC PLAN
SECOND FLOOR**
SCALE: 1/4" = 1'0"

1241 S/F ON SECOND FLOOR
DOESN'T INCLUDE STAIRS

I DO HERBY CERTIFY THAT THIS DRAWING AND RELATED SPECIFICATIONS MEET ALL LOCAL REQUIREMENTS AND ARE IN SUBSTANTIAL CONFORMITY WITH THE INTERNATIONAL BUILDING CODE COUNCIL(2018 N.C. BUILDING CODE).

DESIGNED BY
GCP DESIGNS
HOPE MILLS, NORTH CAROLINA
WWW.GCP@MYWAY.COM

BOOHER
SE-2171

SOUTHEASTERN CONSTRUCTION

| | |
|-----------------|-------------|
| SCALE: AS NOTED | SUBDIVISION |
| DATE: FEB. 2021 | LOT NO. |
| DRAWN BY: GCP | NOTES |