


APPROVED: 10-26-2022
 REVISED: 03-20-2023

RIDGEWOOD CAROLINA / CUSTOM
 FRONT ELEVATION
 10' CEILING HEIGHTS - F.F.O.

6" FRIEZE BOARD & 6" CORNERS ON FRONT OF HOME ONLY

NOTE:
 CONTINUOUS RIDGE VENTS
 ALL ROOF RIDGES

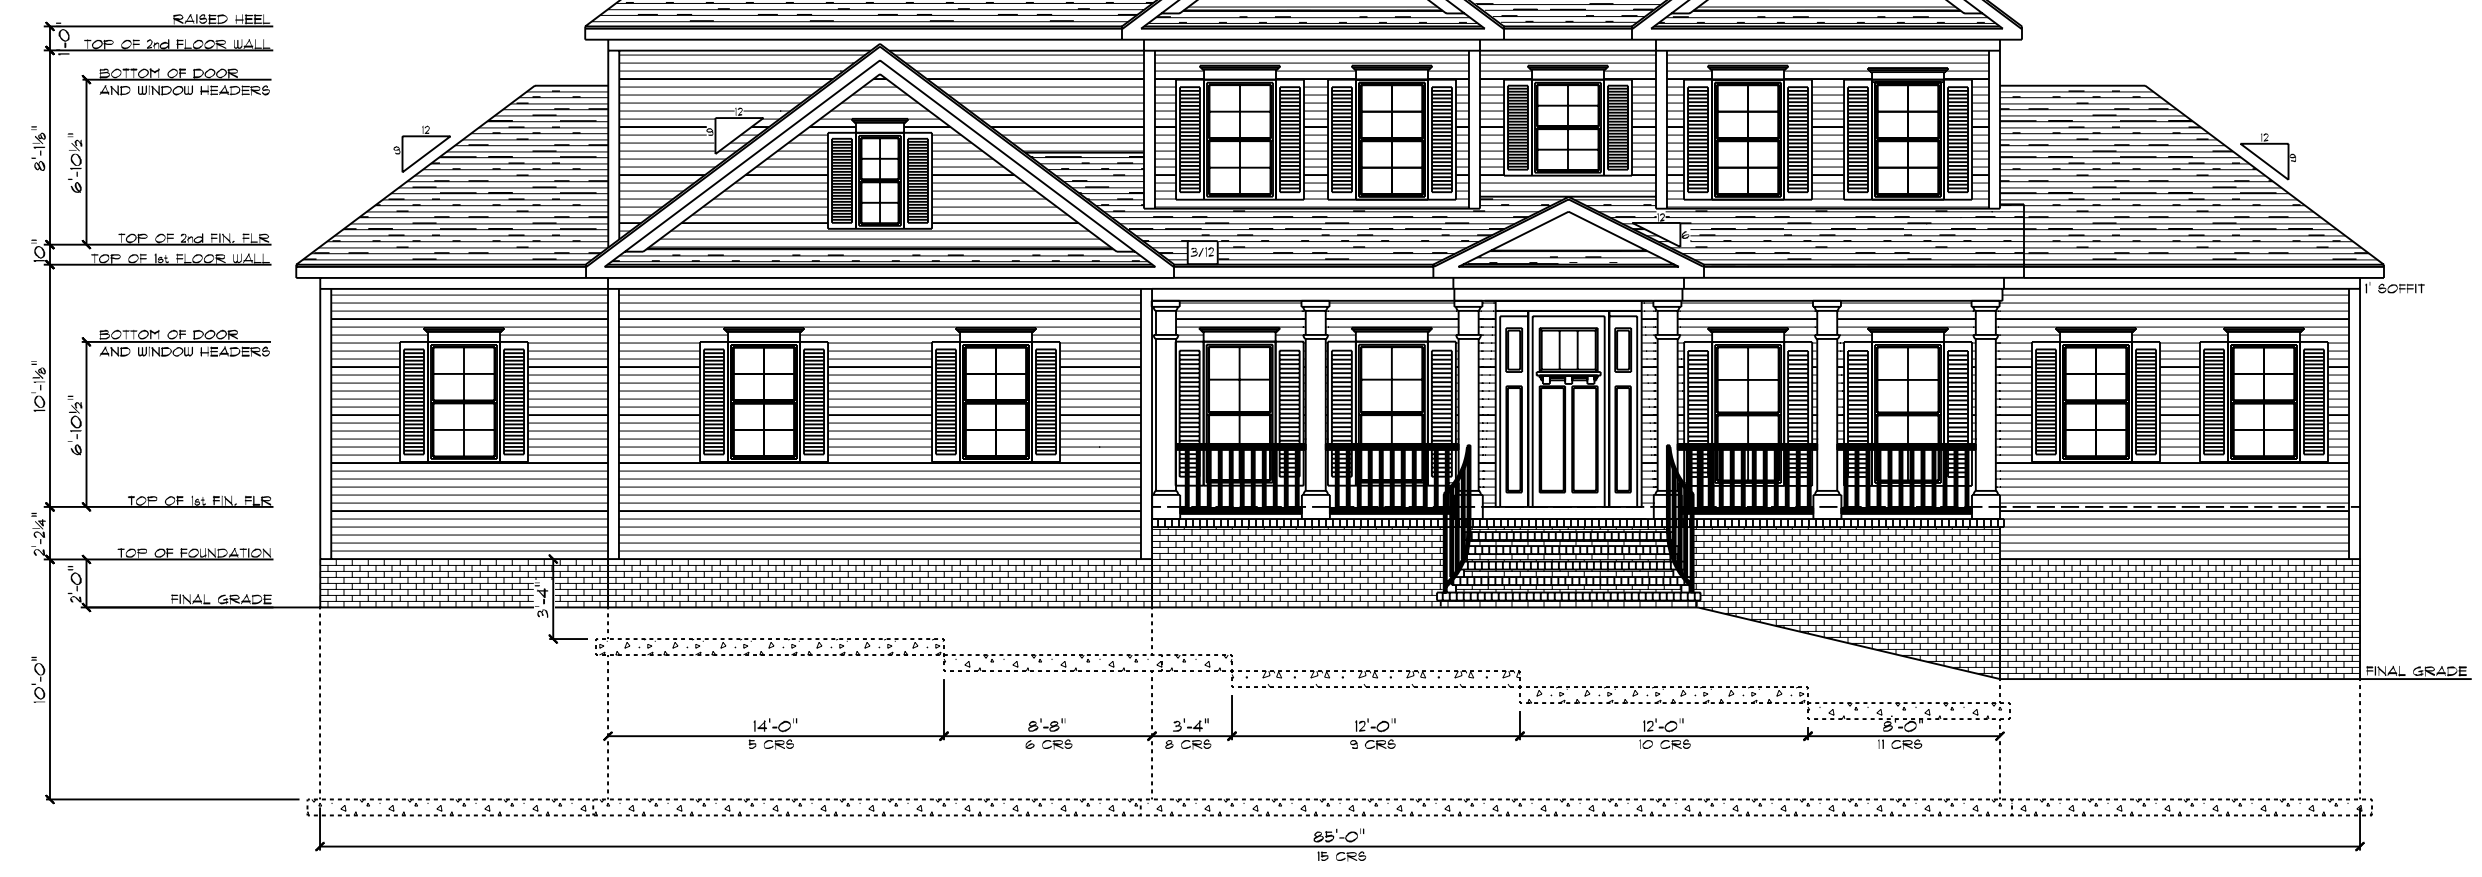


DATE: 3/20/2023
 SCALE: 1/8" = 1'-0"
 DRAWN BY: SG
 © 1991-2023 SCHUMACHER HOMES OPERATIONS, INC. ALL RIGHTS RESERVED. THE INFORMATION CONTAINED HEREIN IS THE PROPERTY OF SCHUMACHER HOMES OPERATIONS, INC. AND IS TO BE USED ONLY FOR THE PROJECT AND SITE SPECIFICALLY IDENTIFIED HEREIN. THESE PLANS ARE NOT TO BE USED TO CREATE DERIVATIVE WORKS, TECHNICAL DRAWINGS OR TO BUILD A STRUCTURE, REPRODUCED, COPIED, OR MODIFIED, IN WHOLE OR PART, WITHOUT THE EXPRESS WRITTEN CONSENT OF SCHUMACHER HOMES, AND SUCH UNAUTHORIZED USE OR COPYING IS A VIOLATION OF UNITED STATES COPYRIGHT LAW AND THAT RESULT IN DAMAGES IN EXCESS OF \$50000 PER ACT OF INFRINGEMENT.

SQUARE FOOTAGES (4096)
 BASEMENT: 2574
 1ST FL: 2574
 2ND FL: 5274
 OPEN SPACE: 384
 GARAGE: 414
 PORCH: 316

CUSTOM BUILT FOR: TRAVIS & SPARKLE BASS
 JOB #: DUTCO 022 OTT VN #: BA282
 LOCATION: 2184 WIRE RD CN #: 34100
 BUNNLEVEL, NC 28323 COUNTY: HARNETT

Raleigh/Durham, NC
 182 West Hamlin Road
 Benson, NC 27504
 (811) 261-3482
 www.schumacherhomes.com

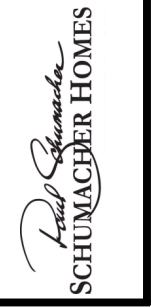

APPROVED: 10-26-2022
 REVISED: 03-20-2023



RIDGEWOOD CAROLINA / CUSTOM
 REAR ELEVATION
 10' CEILING HEIGHT - F.F.O.

DATE: 3/20/2023
 DRAWN BY: SG
 SCALE: 1/8" = 1'-0"
 SHEET: 2

SQUARE FOOTAGES (4096)
 BASEMENT: 2574
 1ST FL: 2574
 2ND FL: 5274
 OPEN SPACE: 384
 GARAGE: 414
 PORCH: 316

CUSTOM BUILT FOR:
 TRAVIS & SPARKLE BASS
 JOB #: DUTOO 022 0111 CN #: 34100 VN #: BA282
 LOCATION: 2184 WIRE RD
 BUNNLEVEL, NC, 28323
 COUNTY: HARNETT

Raleigh/Durham, NC
 182 West Hamlin Road
 Benson, NC 27504
 (811) 261-3482
 www.schumacherhomes.com




© 199-2023 SCHUMACHER HOMES OPERATIONS, INC. ALL RIGHTS RESERVED. THE INFORMATION CONTAINED HEREIN IS THE PROPERTY OF SCHUMACHER HOMES OPERATIONS, INC. AND IS TO BE USED ONLY FOR THE PROJECT AND HOME SPECIFICALLY IDENTIFIED IN THESE PLANS. THESE PLANS ARE NOT TO BE USED TO CREATE DERIVATIVE WORKS, TECHNICAL DRAWINGS OR TO BUILD A STRUCTURE, REPRODUCED, COPIED, OR MODIFIED, IN WHOLE OR PART, WITHOUT THE EXPRESS WRITTEN CONSENT OF SCHUMACHER HOMES, AND SUCH UNAUTHORIZED USE OR COPYING IS A VIOLATION OF UNITED STATES COPYRIGHT LAW AND THAT RESULT IN DAMAGES IN EXCESS OF \$50000 PER ACT OF INFRINGEMENT.

APPROVED: 10-26-2022
 REVISED: 03-20-2023


RIDGEWOOD CAROLINA / CUSTOM
 RIGHT ELEVATION
 10' CEILING HEIGHT - F.F.O.



 SCHUMACHER HOMES		Raleigh/Durham, NC 182 West Hamlin Road Benson, NC 27504 (811) 261-3482 www.schumacherhomes.com	
CUSTOM BUILT FOR: TRAVIS & SPARKLE BASS JOB #: DUTCO 022 OTT CN #: 34120 LOCATION: 2184 WIRE RD BUNNLEVEL, NC, 28323 COUNTY: HARNETT		SQUARE FOOTAGES (4096) BASEMENT: 2574 1ST FL: 2574 2ND FL: 2574 OPEN SPACE: 394 GARAGE: 414 PORCH: 96	
DRAWN BY: SG	DATE: 3/20/2023	SCALE: 1/8" = 1'-0"	SHEET: 3

© 1992-2023 SCHUMACHER HOMES OPERATIONS, INC. ALL RIGHTS RESERVED. THE INFORMATION CONTAINED HEREIN IS THE PROPERTY OF SCHUMACHER HOMES OPERATIONS, INC. AND IS TO BE USED ONLY FOR THE PROJECT AND SITE SPECIFICALLY IDENTIFIED HEREON. IT IS NOT TO BE USED TO CREATE DERIVATIVE WORKS, TECHNICAL DRAWINGS OR TO BUILD A STRUCTURE, REPRODUCED, COPIED, OR MODIFIED, IN WHOLE OR PART, WITHOUT THE EXPRESS WRITTEN CONSENT OF SCHUMACHER HOMES, AND SUCH UNAUTHORIZED USE OR COPYING IS A VIOLATION OF UNITED STATES COPYRIGHT LAW AND THAT RESULT IN DAMAGES IN EXCESS OF \$50000 PER ACT OF INFRINGEMENT.

APPROVED: 10-26-2022
 REVISED: 03-20-2023

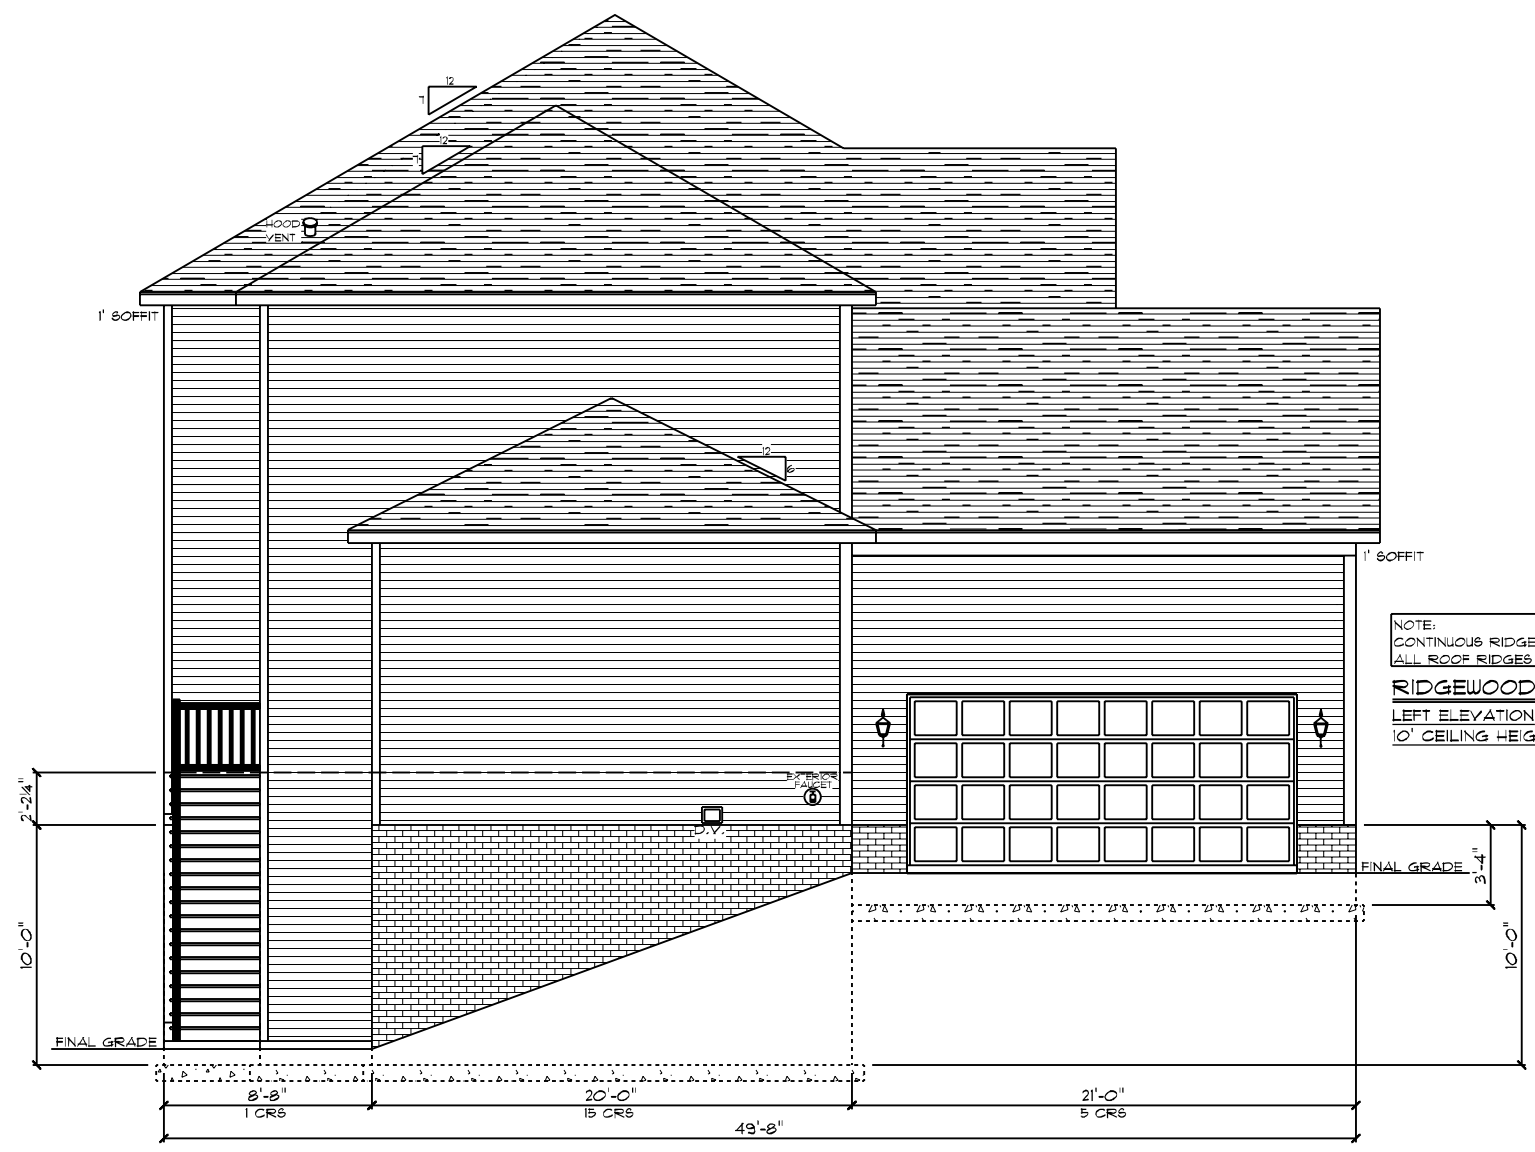


NOTE:
 CONTINUOUS RIDGE VENTS
 ALL ROOF RIDGES
RIDGEWOOD CAROLINA / CUSTOM
 LEFT ELEVATION
 10' CEILING HEIGHT - F.F.O.

<p>SCHUMACHER HOMES</p>		<p>Raleigh/Durham, NC 182 West Hamlin Road Benson, NC 27504 (811) 261-3482 www.schumacherhomes.com</p>	
<p>CUSTOM BUILT FOR:</p> <p>TRAVIS & SPARKLE BASS JOB #: DUTCO 022 OTT LOCATION: 2184 WIRE RD BUNNLEVEL, NC, 28323 COUNTY: HARNETT</p>		<p>SQUARE FOOTAGES (4096)</p> <p>BASEMENT: 2574 1ST FL: 2574 2ND FL: 5274 OPEN SPACE: 384 GARAGE: 474 PORCH: 316</p>	
<p>DRAIN BY: SG</p>	<p>DATE: 3/20/2023</p>	<p>SCALE: 1/8" = 1'-0"</p>	<p>DSUB: 4</p>
<p><small>© 1997-2023 SCHUMACHER HOMES OPERATIONS, INC. ALL RIGHTS RESERVED. THE INFORMATION CONTAINED HEREIN IS THE PROPERTY OF SCHUMACHER HOMES OPERATIONS, INC. AND IS TO BE USED ONLY FOR THE PROJECT AND SITE SPECIFICALLY IDENTIFIED HEREIN. THESE PLANS ARE NOT TO BE USED TO CREATE DERIVATIVE WORKS, TECHNICAL DRAWINGS OR TO BUILD A STRUCTURE, REPRODUCED, COPIED, OR MODIFIED, IN WHOLE OR PART, WITHOUT THE EXPRESS WRITTEN CONSENT OF SCHUMACHER HOMES, AND SUCH UNAUTHORIZED USE OR COPYING IS A VIOLATION OF UNITED STATES COPYRIGHT LAW AND THAT RESULT IN DAMAGES IN EXCESS OF \$50000 PER ACT OF INFRINGEMENT.</small></p>			

APPROVED: 10-26-2022
 REVISED: 03-20-2023

UTILITIES TO BE LOCATED ON-SITE
 COORDINATE ALL UTILITY LOCATIONS WITH
 THEIR RESPECTIVE TRADES PRIOR TO
 COMMENCING ANY INSTALLATION WORK

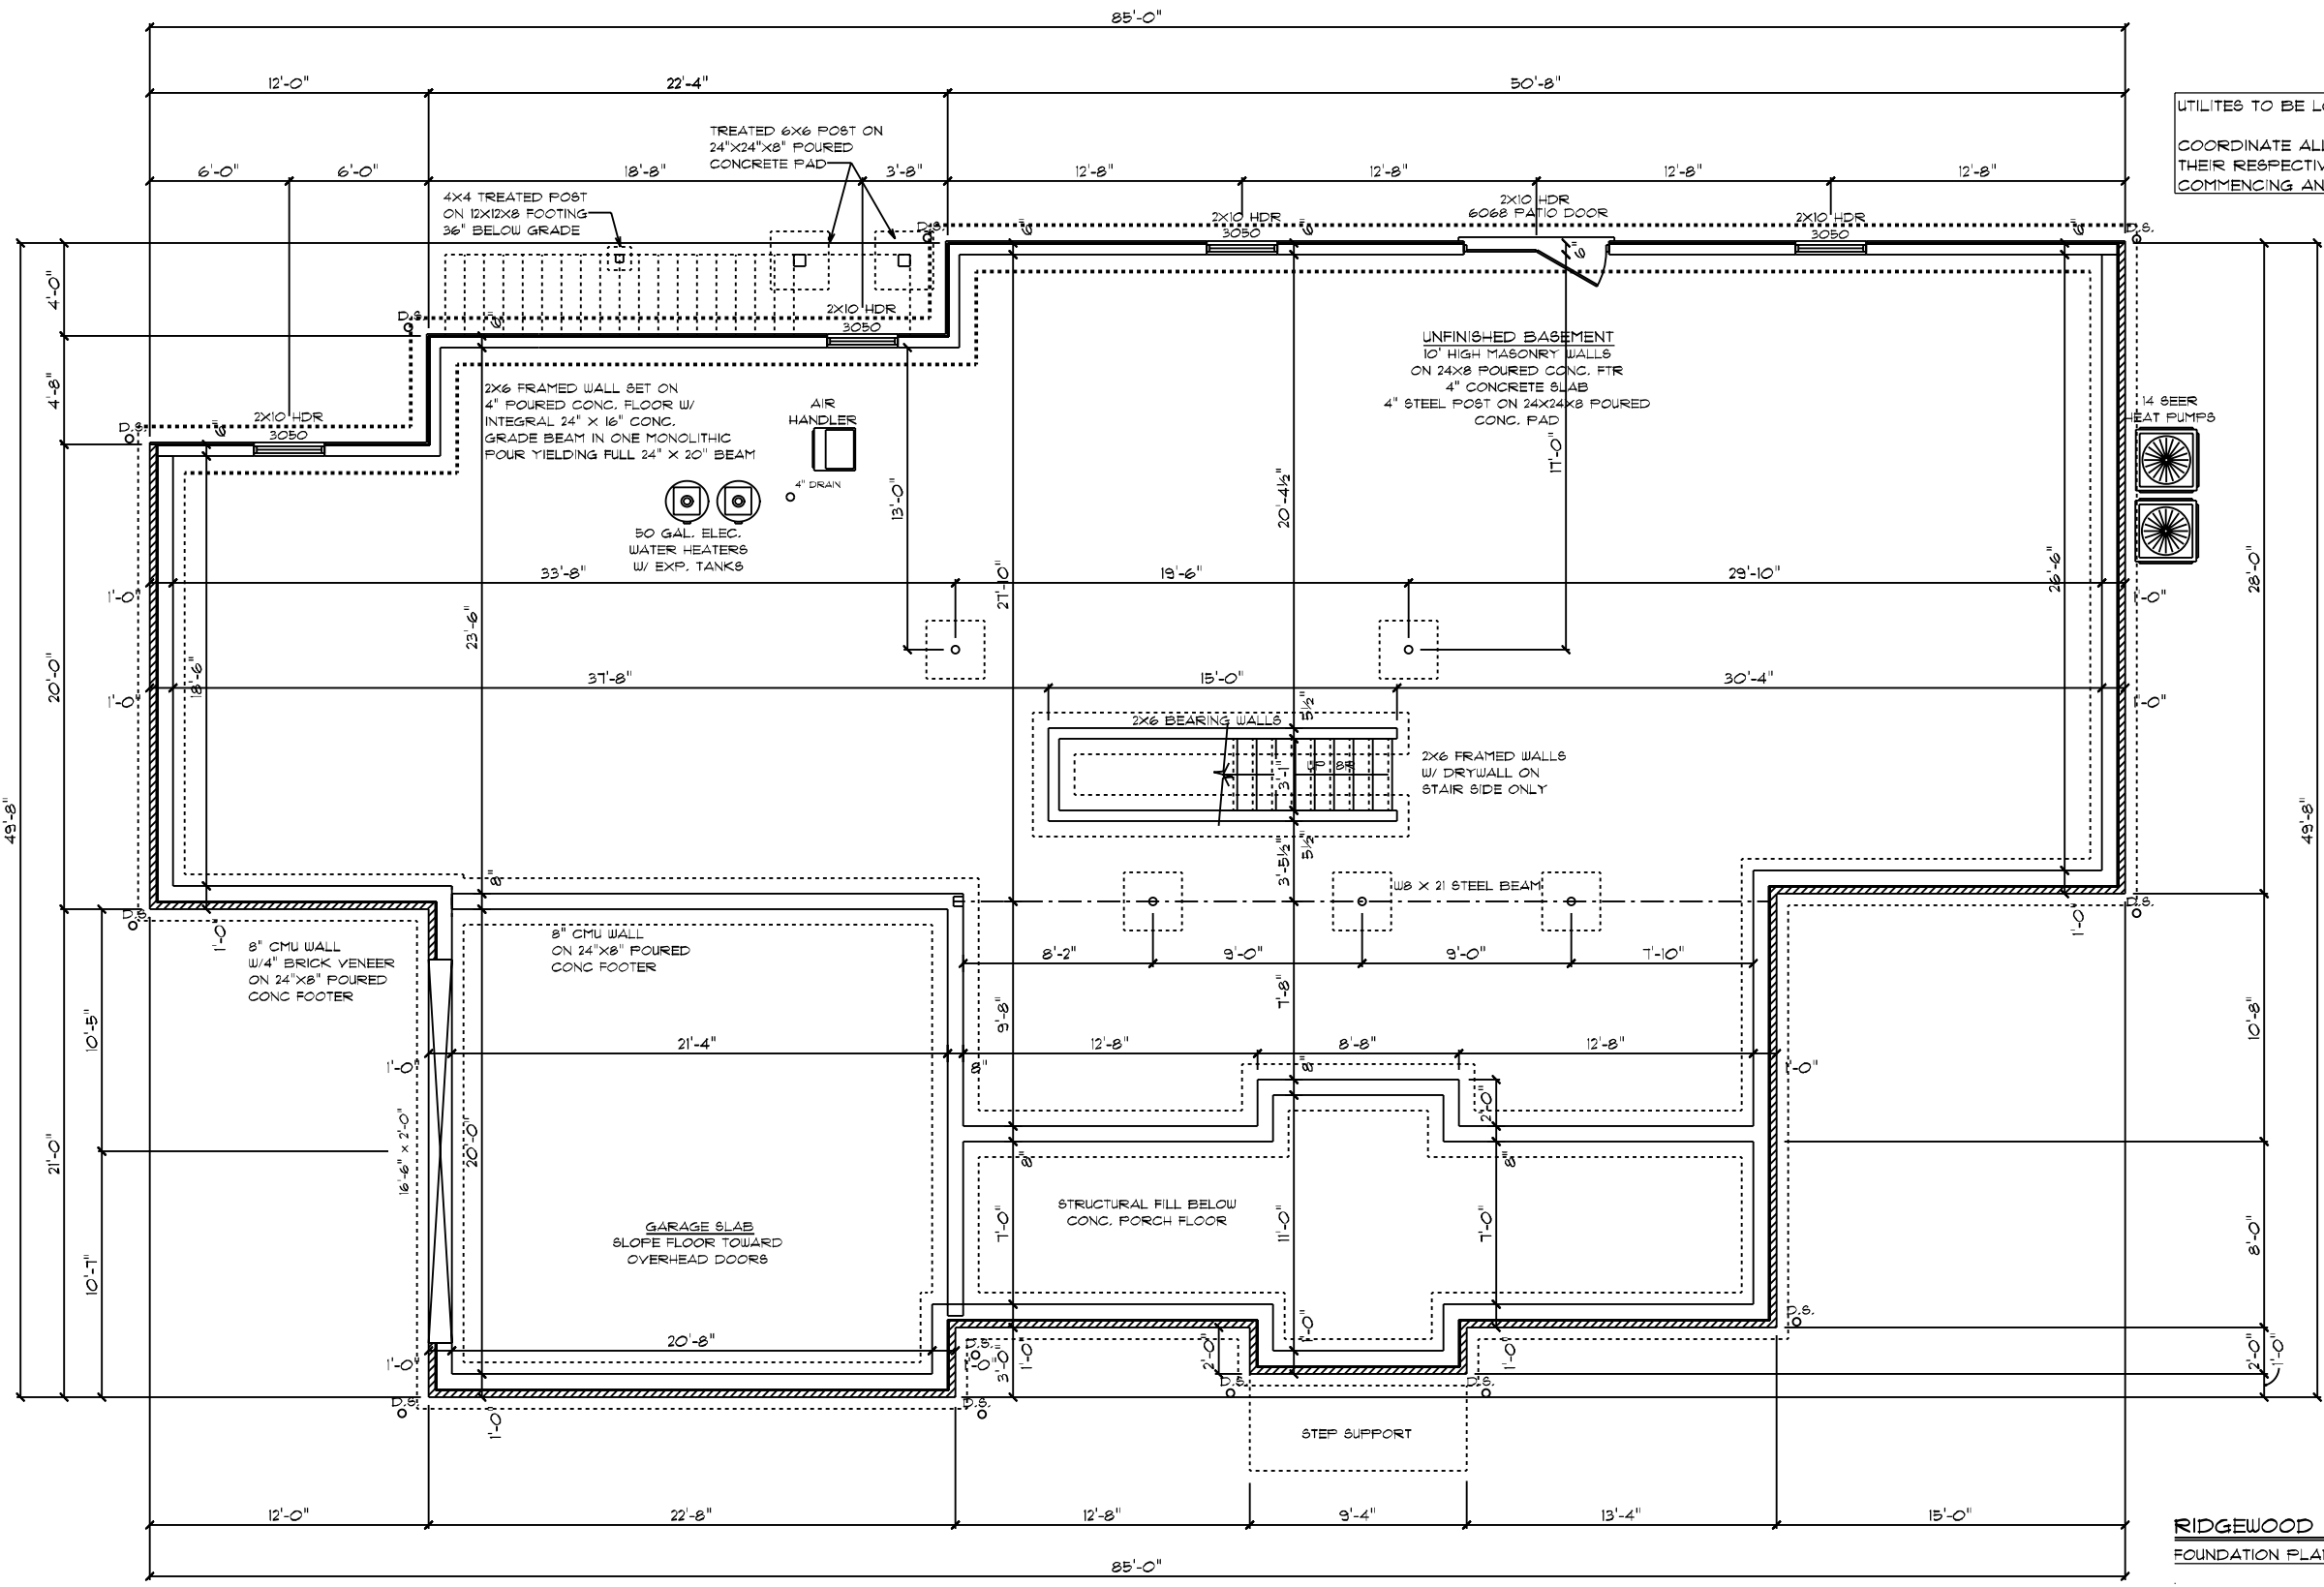

RIDGEWOOD CAROLINA / CUSTOM
 FOUNDATION PLAN


DATE: 3/20/2023
 SCALE: 1/8" = 1'-0"
 DRAIN BY: SG
 Dwg: B

© 1993-2023 SCHUMACHER HOMES OPERATIONS, INC. ALL RIGHTS RESERVED. THE
 INFORMATION CONTAINED HEREIN IS THE PROPERTY OF SCHUMACHER HOMES
 OPERATIONS, INC. AND IS TO BE USED ONLY FOR THE PROJECT AND SITE
 SPECIFIC OPERATIONS AND IS NOT TO BE REPRODUCED, COPIED, OR
 TRANSMITTED IN ANY FORM OR BY ANY MEANS, ELECTRONIC OR
 MECHANICAL, INCLUDING PHOTOCOPYING, RECORDING, OR BY ANY
 INFORMATION STORAGE AND RETRIEVAL SYSTEM. ANY UNAUTHORIZED
 REPRODUCTION OR USE OF THIS INFORMATION IS A VIOLATION OF
 FEDERAL AND STATE LAWS AND MAY BE SUBJECT TO CIVIL AND
 CRIMINAL PENALTIES. THE USER OF THIS INFORMATION AGREES TO
 HOLD SCHUMACHER HOMES OPERATIONS, INC. HARMLESS FROM AND
 AGAINST ALL DAMAGES, INCLUDING REASONABLE ATTORNEY'S FEES,
 IN CONNECTION WITH ANY SUCH VIOLATION.


SQUARE FOOTAGES (4096):
 BASEMENT: 2574
 1ST FL: 2874
 2ND FL: 522
 OPEN SPACE: 394
 GARAGE: 414
 PORCH: 316

CUSTOM BUILT FOR: TRAVIS & SPARKLE BASS
 JOB #: DUTCO 022 OTT CN #: 34120 VN #: BA282
 LOCATION: 2184 WIRE RD
 BUNNLEVEL, NC 28323
 COUNTY: HARNETT

Raleigh/Durham, NC
 182 West Hamlin Road
 Benson, NC 27504
 (877) 261-3482
 www.schumacherhomes.com

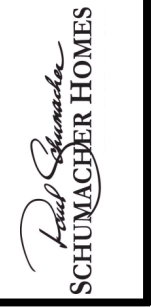

APPROVED: 10-26-2022
 REVISED: 03-20-2023

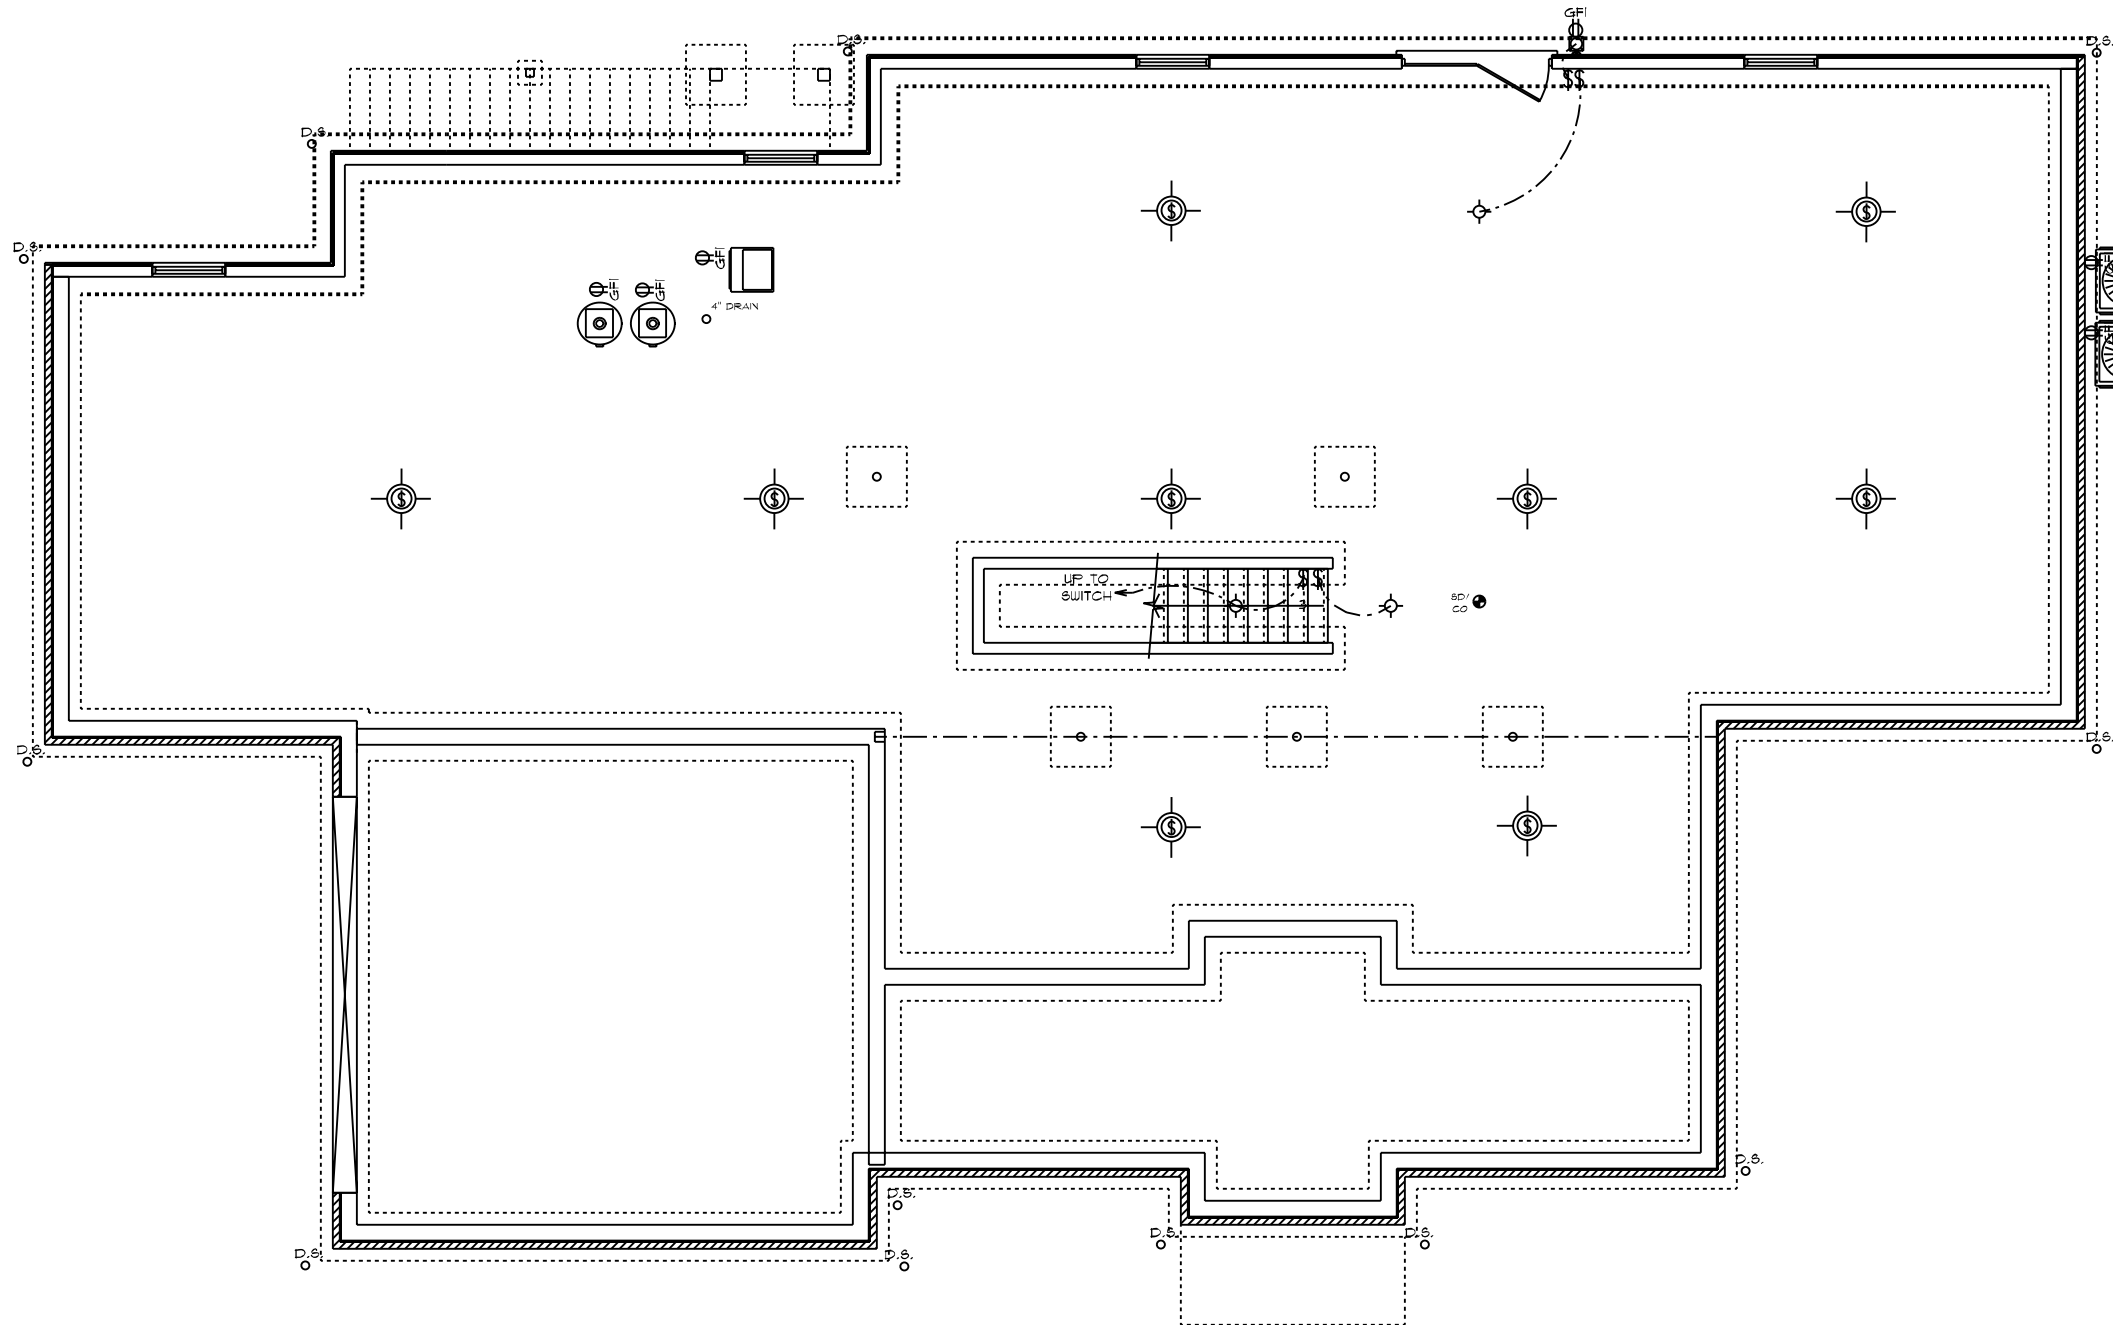

GENERAL ELECTRICAL NOTES:

- (1) EXISTING SWITCH UPGRADED TO A 3-WAY SWITCH, (1) ADDITIONAL 3-WAY SWITCH AND (1) COACH LIGHT WIRED TO A STANDARD SWITCH ARE INCLUDED WHEN A GARAGE SERVICE DOOR IS PURCHASED
- (1) COACH LIGHT, (1) SWITCH, AND (1) GFI OUTLET ARE INCLUDED WHEN ANY ADDITIONAL DOOR IS PURCHASED, EXCLUDING THE GARAGE SERVICE DOOR
- ALL SMOKE DETECTORS TO BE INTERCONNECTED WITH BATTERY BACKUP
- E3902.11 ARC-FAULT CIRCUIT-INTERRUPTER PROTECTION ALL BRANCH CIRCUITS THAT SUPPLY 120-VOLT, SINGLE-PHASE, 15- AND 20-AMPERE OUTLETS INSTALLED IN FAMILY ROOMS, DINING ROOMS, LIVING ROOMS, PARLORS, LIBRARIES, DENS, BEDROOMS, SUNROOMS, RECREATION ROOMS, CLOSETS, HALLWAYS AND SIMILAR ROOMS OR AREAS SHALL BE PROTECTED BY A COMBINATION TYPE ARC-FAULT CIRCUIT INTERRUPTER INSTALLED TO PROVIDE PROTECTION OF THE BRANCH CIRCUIT.
- *GARAGE DOOR LOW VOLTAGE WIRING BY ELECTRICIAN
- *TWO SEPARATE KITCHEN GENERAL ELECTRIC OUTLET CIRCUITS FED BY NUMBER 12 WIRE AND ON 20 AMP BREAKERS REQUIRED IN KITCHEN
- ALL OUTLETS INSTALLED IN BATHROOMS, GARAGES, & UNFINISHED BASEMENTS SHALL HAVE GFCI PROTECTIONS ALONG WITH OUTLETS LOCATED W/IN 6'-0" OF LAUNDRY, UTILITY & WET BAR SINKS & ALL OUTLETS SERVING KITCHEN COUNTERTOP SURFACES
- ALL OUTLETS TO BE PLACED PER CODE
- MOUNTING HEIGHTS
 - VANITY LIGHTS: 80" AFF
 - WALL SCONCES: 66" AFF
 - PENDANT LIGHTS: 66" AFF
 - CHANDELIERS (TO BTM OF FIXTURE)
 - FOYER 9' CEILING: 84"
 - FOYER OVER 9' CLG: 90"
 - DINING ROOM: 60"

ADDITIONAL ELECTRICAL NOTES:


- * CABLE & PHONE TO BE LOCATED AT ELECTRICAL WALK-THRU
- * ADDIT'L MINI RECESSED LIGHTS TO BE LOCATED AT ELECTRICAL WALK-THRU
- * INSTALL ALL BATHROOM LIGHT FIXTURES WITH GLOBES FACING DOWN

RIDGEWOOD CAROLINA / CUSTOM
 FOUNDATION PLAN
 ELECTRICAL PLAN

DATE: 3/20/2023	SCALE: 1/8" = 1'-0"	DRAWN BY: SG	DRIVER: 6
SQUARE FOOTAGES (4096) BASEMENT: 2574 1ST FL: 2574 2ND FL: 5274 OPEN SPACE: 354 GARAGE: 474 PORCH: 316			
CUSTOM BUILT FOR: TRAVIS & SPARKLE BASS JOB #: DUTCO 022 0111 CN #: 34100 VN #: BA282			
LOCATION: 2184 WIRE RD BUNNLEVEL, NC 28323 COUNTY: HARNETT			
Raleigh/Durham, NC 182 West Hamlin Road Benson, NC 27504 (811) 261-3482 www.schumacherhomes.com			


© 1992-2023 SCHUMACHER HOMES OPERATIONS, INC. ALL RIGHTS RESERVED. THE INFORMATION CONTAINED HEREIN IS THE PROPERTY OF SCHUMACHER HOMES OPERATIONS, INC. AND IS TO BE USED ONLY FOR THE PROJECT AND SITE SPECIFIC OPERATIONS AND IS NOT TO BE REPRODUCED, COPIED, OR MODIFIED IN WHOLE OR PART, WITHOUT THE EXPRESS WRITTEN CONSENT OF SCHUMACHER HOMES, AND SUCH UNAUTHORIZED USE OR COPYING IS A VIOLATION OF UNITED STATES COPYRIGHT LAW AND THAT RESULT IN DAMAGES IN EXCESS OF \$50000 PER ACT OF INFRINGEMENT.

APPROVED: 10-26-2022
REVISED: 03-20-2023

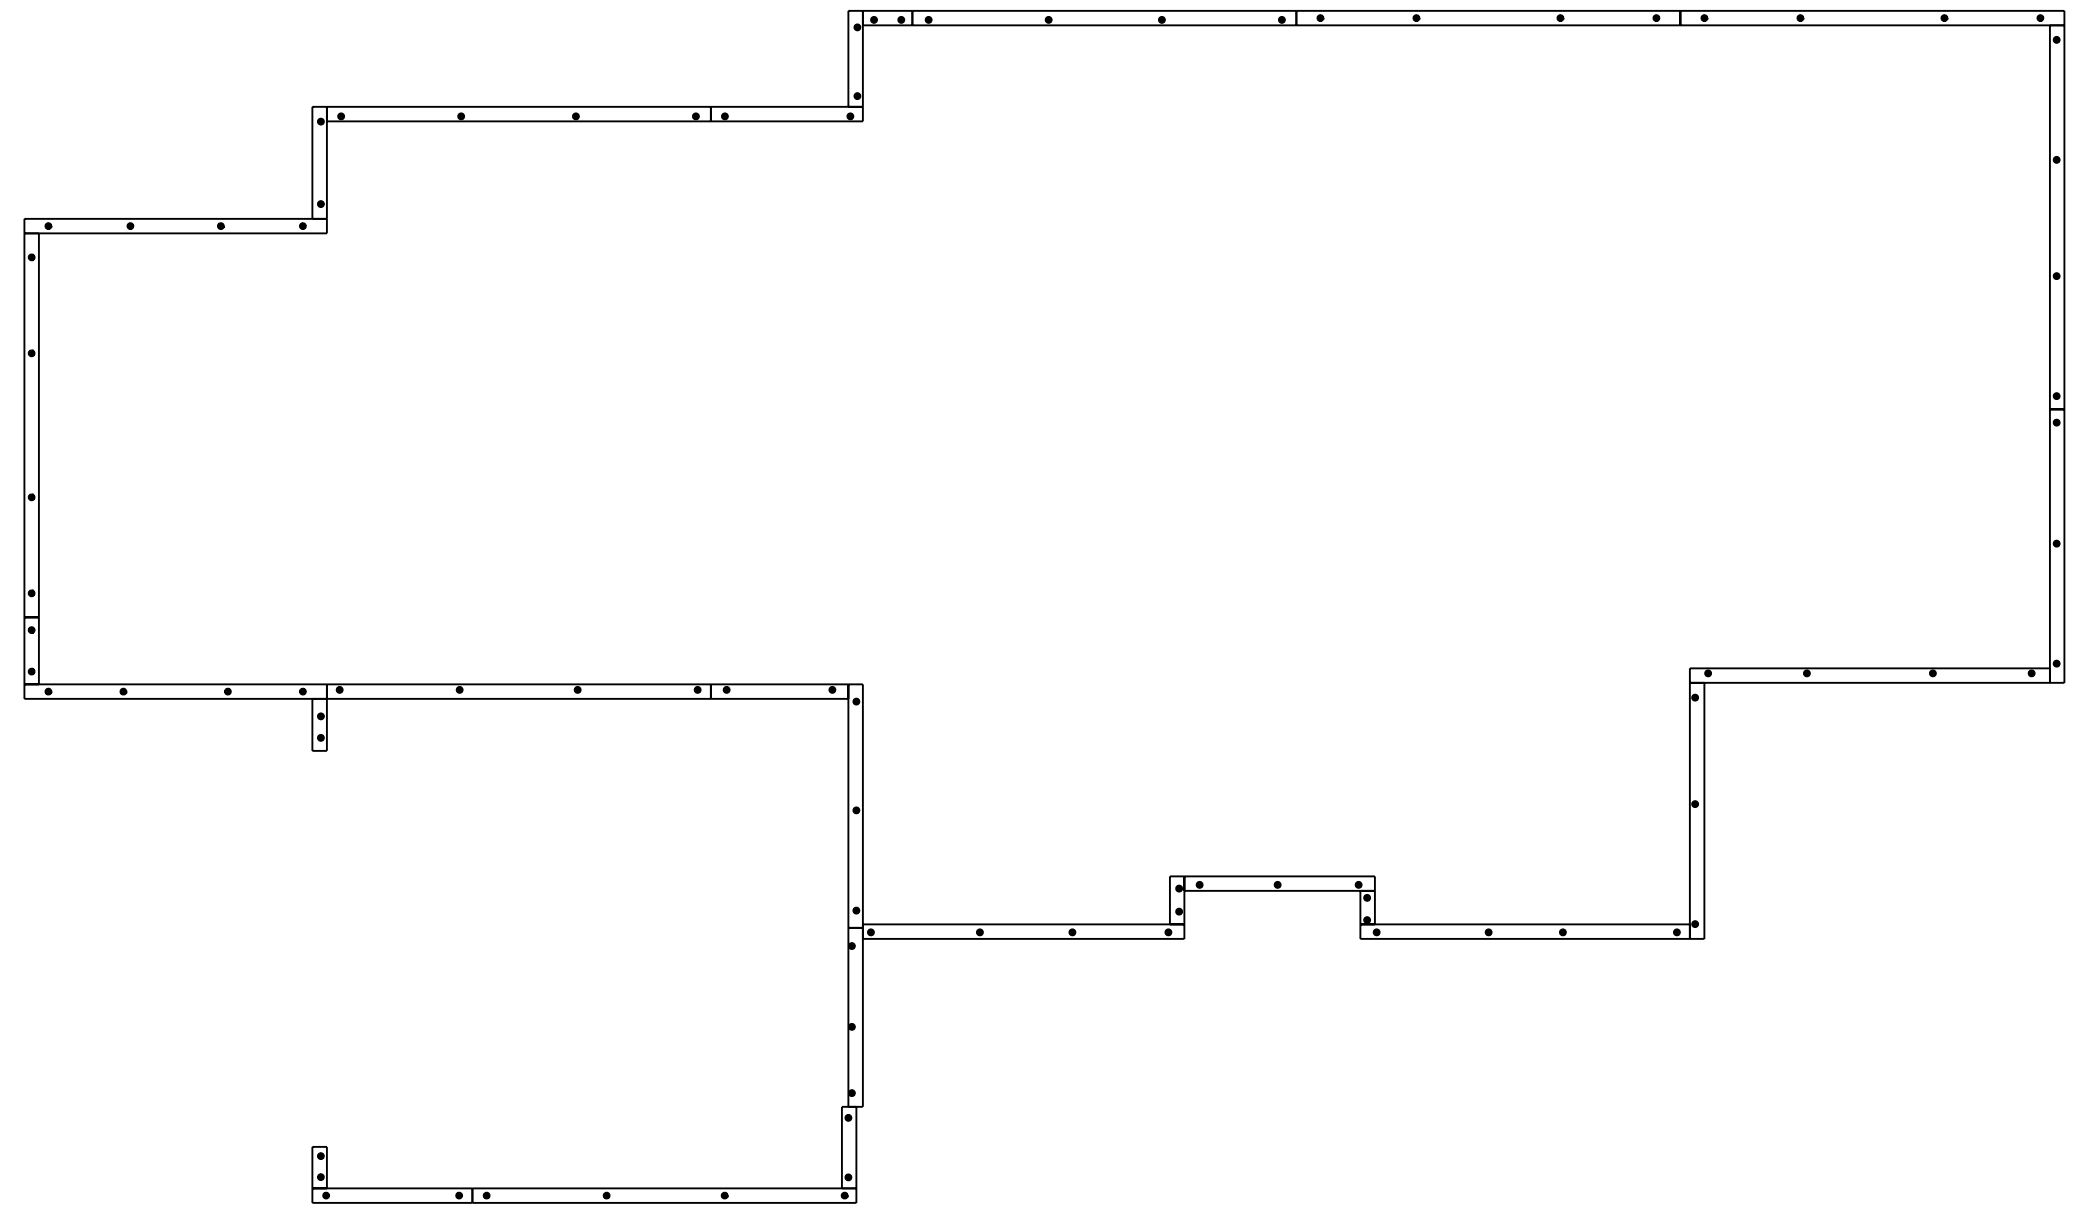


CONSTRUCTION NOTES:
1. 2X8 TREATED SILL PLATE
2. 1/2" DIAM. X 18" L. ANCHOR BOLTS SHALL EXTEND A MINIMUM OF 1" INTO MASONRY OR CONCRETE AS REQUIRED BY CODE @ 6' O.C. AND 12" FROM ALL CORNERS (2 PER CORNER)
3. ANCHOR BOLTS TO BE LOCATED IN CENTER 1/3 OF SILL PLATE

RIDGEWOOD CAROLINA / CUSTOM
BOLT AND PLATE PLAN

 SCHUMACHER HOMES	Raleigh/Durham, NC 182 West Hamlin Road Benson, NC 27504 (811) 261-3482 www.schumacherhomes.com	
	CUSTOM BUILT FOR: TRAVIS & SPARKLE BASS JOB #: DUTCO 022 OTT CN #: 34120 LOCATION: 2184 WIRE RD BUNNLEVEL, NC, 28323 COUNTY: HARNETT	
SQUARE FOOTAGES (4096): BASEMENT: 2574 1ST FL: 2814 2ND FL: 522 OPEN SPACE: 394 GARAGE: 414 PORCH: 36		DRAWN BY: SG
DATE: 3/20/2023		SCALE: 1/8" = 1'-0"
DESIGNER: T		
<small>© 1991-2023 SCHUMACHER HOMES OPERATIONS, INC. ALL RIGHTS RESERVED. THE INFORMATION CONTAINED HEREIN IS THE PROPERTY OF SCHUMACHER HOMES OPERATIONS, INC. AND IS UNLAWFULLY TO BE REPRODUCED, COPIED, OR MODIFIED IN WHOLE OR PART, WITHOUT THE EXPRESS WRITTEN CONSENT OF SCHUMACHER HOMES, AND SUCH UNAUTHORIZED USE OR COPYING IS A VIOLATION OF UNITED STATES COPYRIGHT LAW AND MAY RESULT IN DAMAGES IN EXCESS OF \$500,000 PER ACT OF INFRINGEMENT.</small>		

APPROVED: 10-26-2022
 REVISED: 03-20-2023

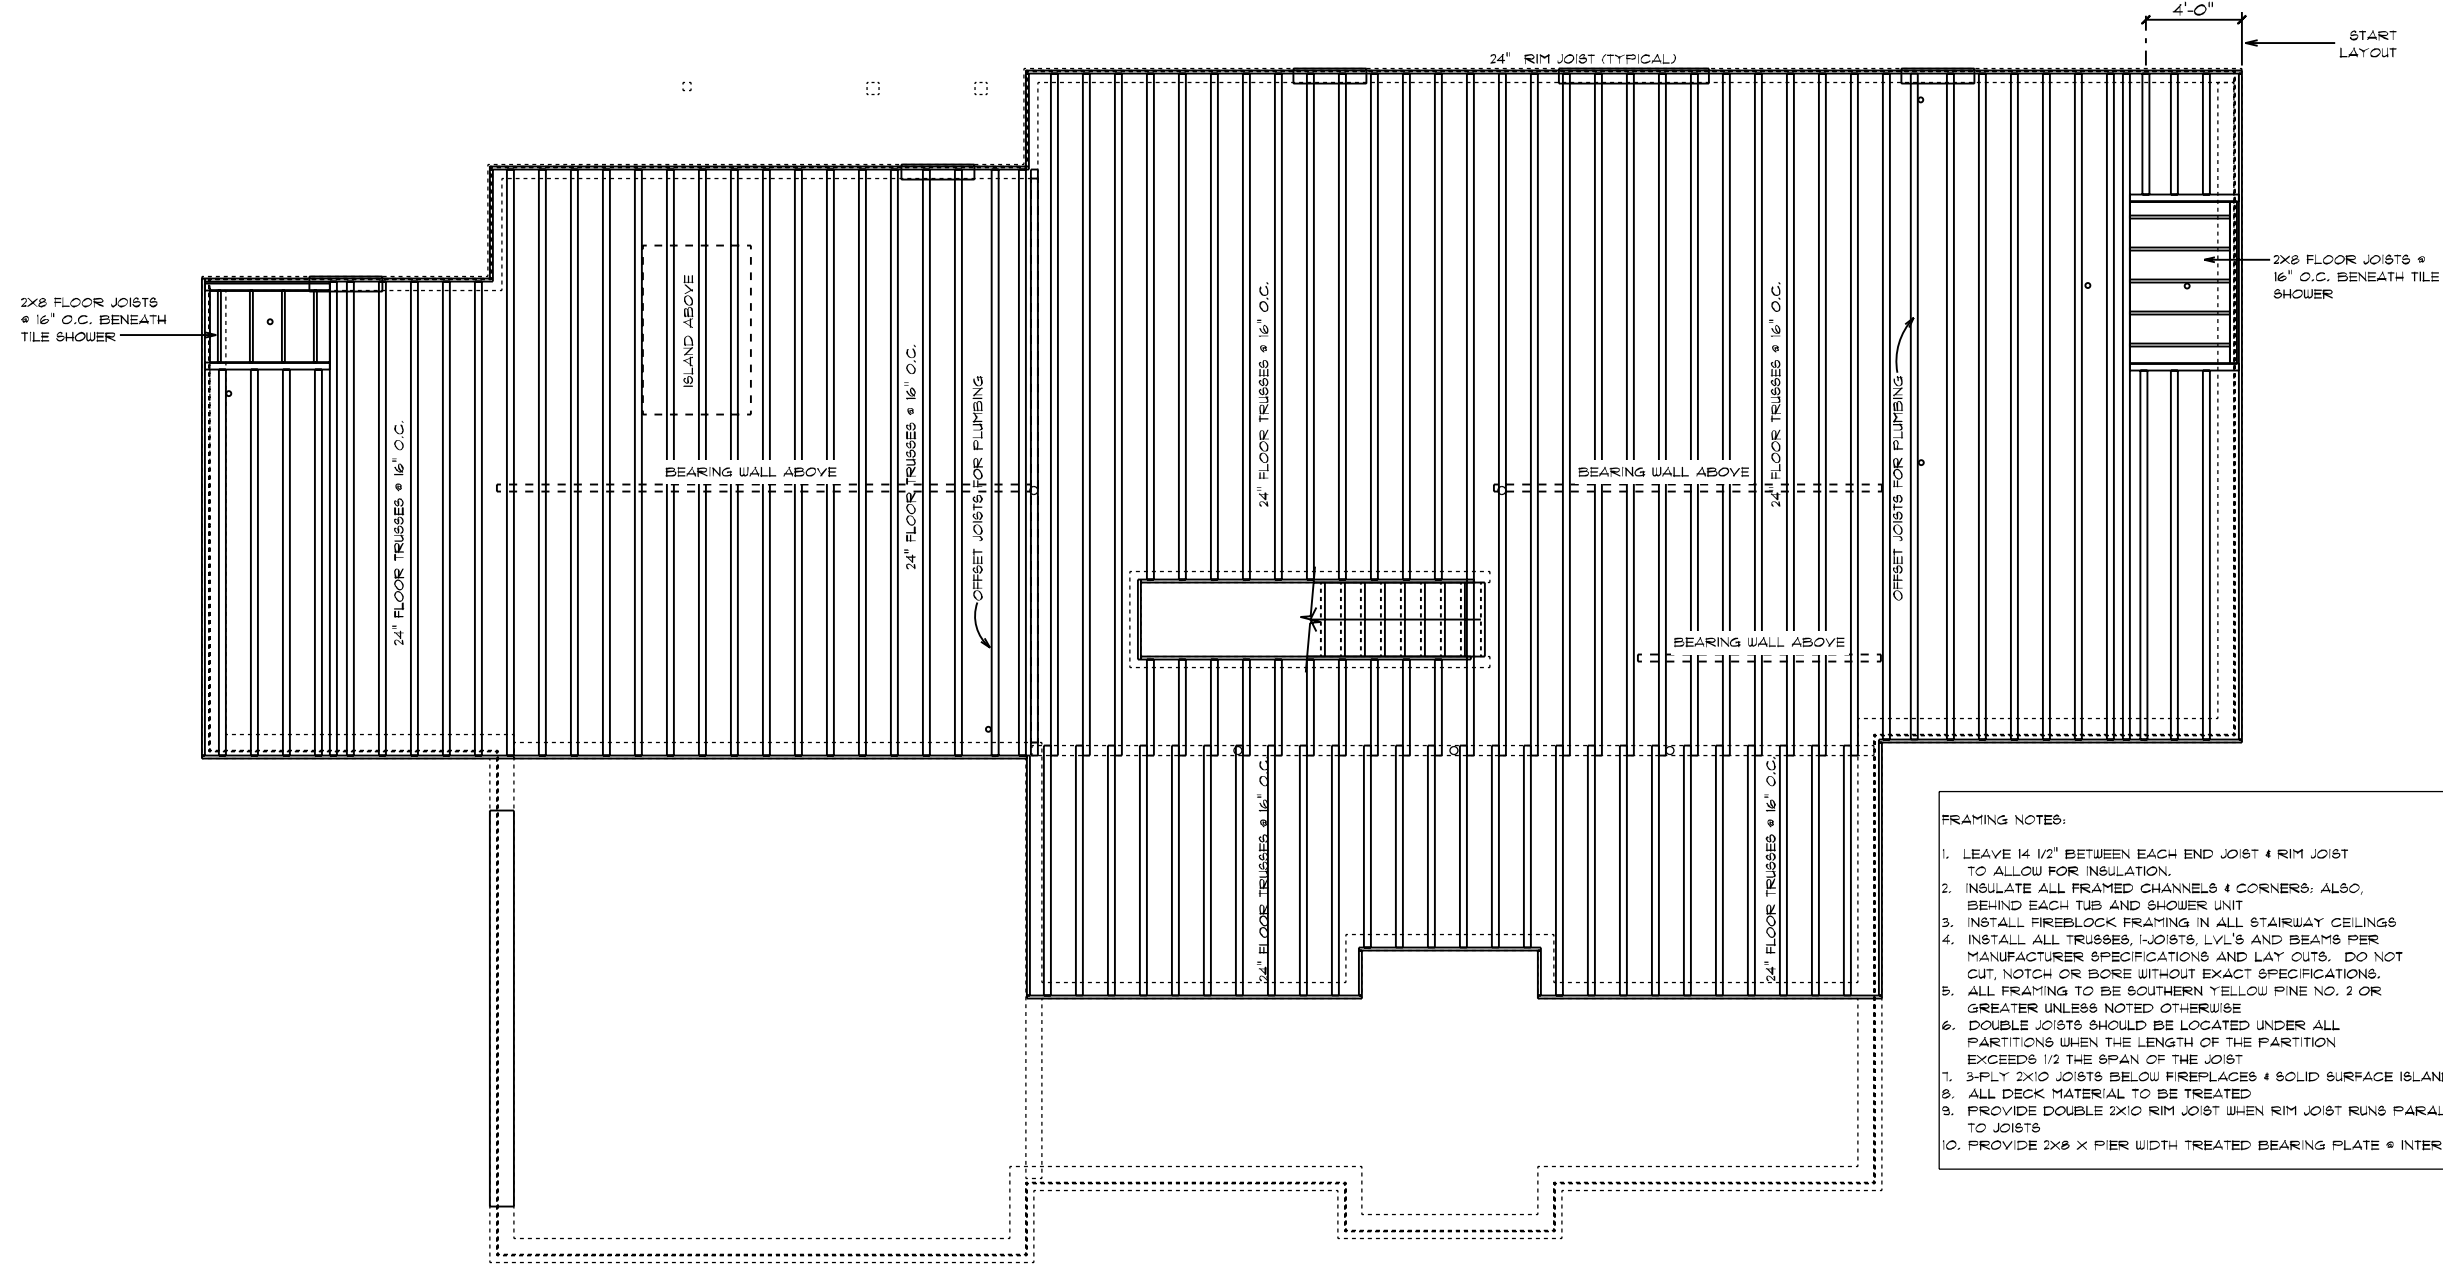

- FRAMING NOTES:
1. LEAVE 1/2" BETWEEN EACH END JOIST & RIM JOIST TO ALLOW FOR INSULATION.
 2. INSULATE ALL FRAMED CHANNELS & CORNERS, ALSO, BEHIND EACH TUB AND SHOWER UNIT.
 3. INSTALL FIREBLOCK FRAMING IN ALL STAIRWAY CEILINGS.
 4. INSTALL ALL TRUSSES, I-JOISTS, LVL'S AND BEAMS PER MANUFACTURER SPECIFICATIONS AND LAY OUTS. DO NOT CUT, NOTCH OR BORE WITHOUT EXACT SPECIFICATIONS.
 5. ALL FRAMING TO BE SOUTHERN YELLOW PINE NO. 2 OR GREATER UNLESS NOTED OTHERWISE.
 6. DOUBLE JOISTS SHOULD BE LOCATED UNDER ALL PARTITIONS WHEN THE LENGTH OF THE PARTITION EXCEEDS 1/2 THE SPAN OF THE JOIST.
 7. 3-PLY 2X10 JOISTS BELOW FIREPLACES & SOLID SURFACE ISLANDS.
 8. ALL DECK MATERIAL TO BE TREATED.
 9. PROVIDE DOUBLE 2X10 RIM JOIST WHEN RIM JOIST RUNS PARALLEL TO JOISTS.
 10. PROVIDE 2X8 X PIER WIDTH TREATED BEARING PLATE @ INTERIOR PIERS.

RIDGEWOOD CAROLINA / CUSTOM
 FIRST FLOOR JOIST PLAN


SCHUMACHER HOMES
 Raleigh/Durham, NC
 182 West Hamlin Road
 Benson, NC 27504
 (877) 261-3482
 www.schumacherhomes.com

CUSTOM BUILT FOR: TRAVIS & SPARKLE BASS
 JOB #: DUTCO 022 OTT CN #: 34120 VN #: BA282
 LOCATION: 2184 WIRE RD BUNNLEVEL, NC 28323 COUNTY: HARNETT

SQUARE FOOTAGES (4096):
 BASEMENT: 2574
 1ST FL: 2874
 2ND FL: 522
 OPEN SPACE: 394
 GARAGE: 414
 PORCH: 96

DATE: 3/20/2023
 DRAIN BY: SG
 SCALE: 1/8" = 1'-0"
 DRAWING: 8

© 1992-2023 SCHUMACHER HOMES OPERATIONS, INC. ALL RIGHTS RESERVED. THE INFORMATION CONTAINED HEREIN IS THE PROPERTY OF SCHUMACHER HOMES OPERATIONS, INC. AND IS TO BE USED ONLY FOR THE PROJECT AND SITE SPECIFICALLY IDENTIFIED HEREIN. THESE PLANS ARE NOT TO BE USED TO CREATE DERIVATIVE WORKS, TECHNICAL DRAWINGS OR TO BUILD A STRUCTURE, REPRODUCED, COPIED, OR MODIFIED, IN WHOLE OR PART, WITHOUT THE EXPRESS WRITTEN CONSENT OF SCHUMACHER HOMES, AND SUCH UNAUTHORIZED USE OR COPYING IS A VIOLATION OF UNITED STATES COPYRIGHT LAW AND THAT RESULT IN DAMAGES IN EXCESS OF \$50000 PER ACT OF INFRINGEMENT.

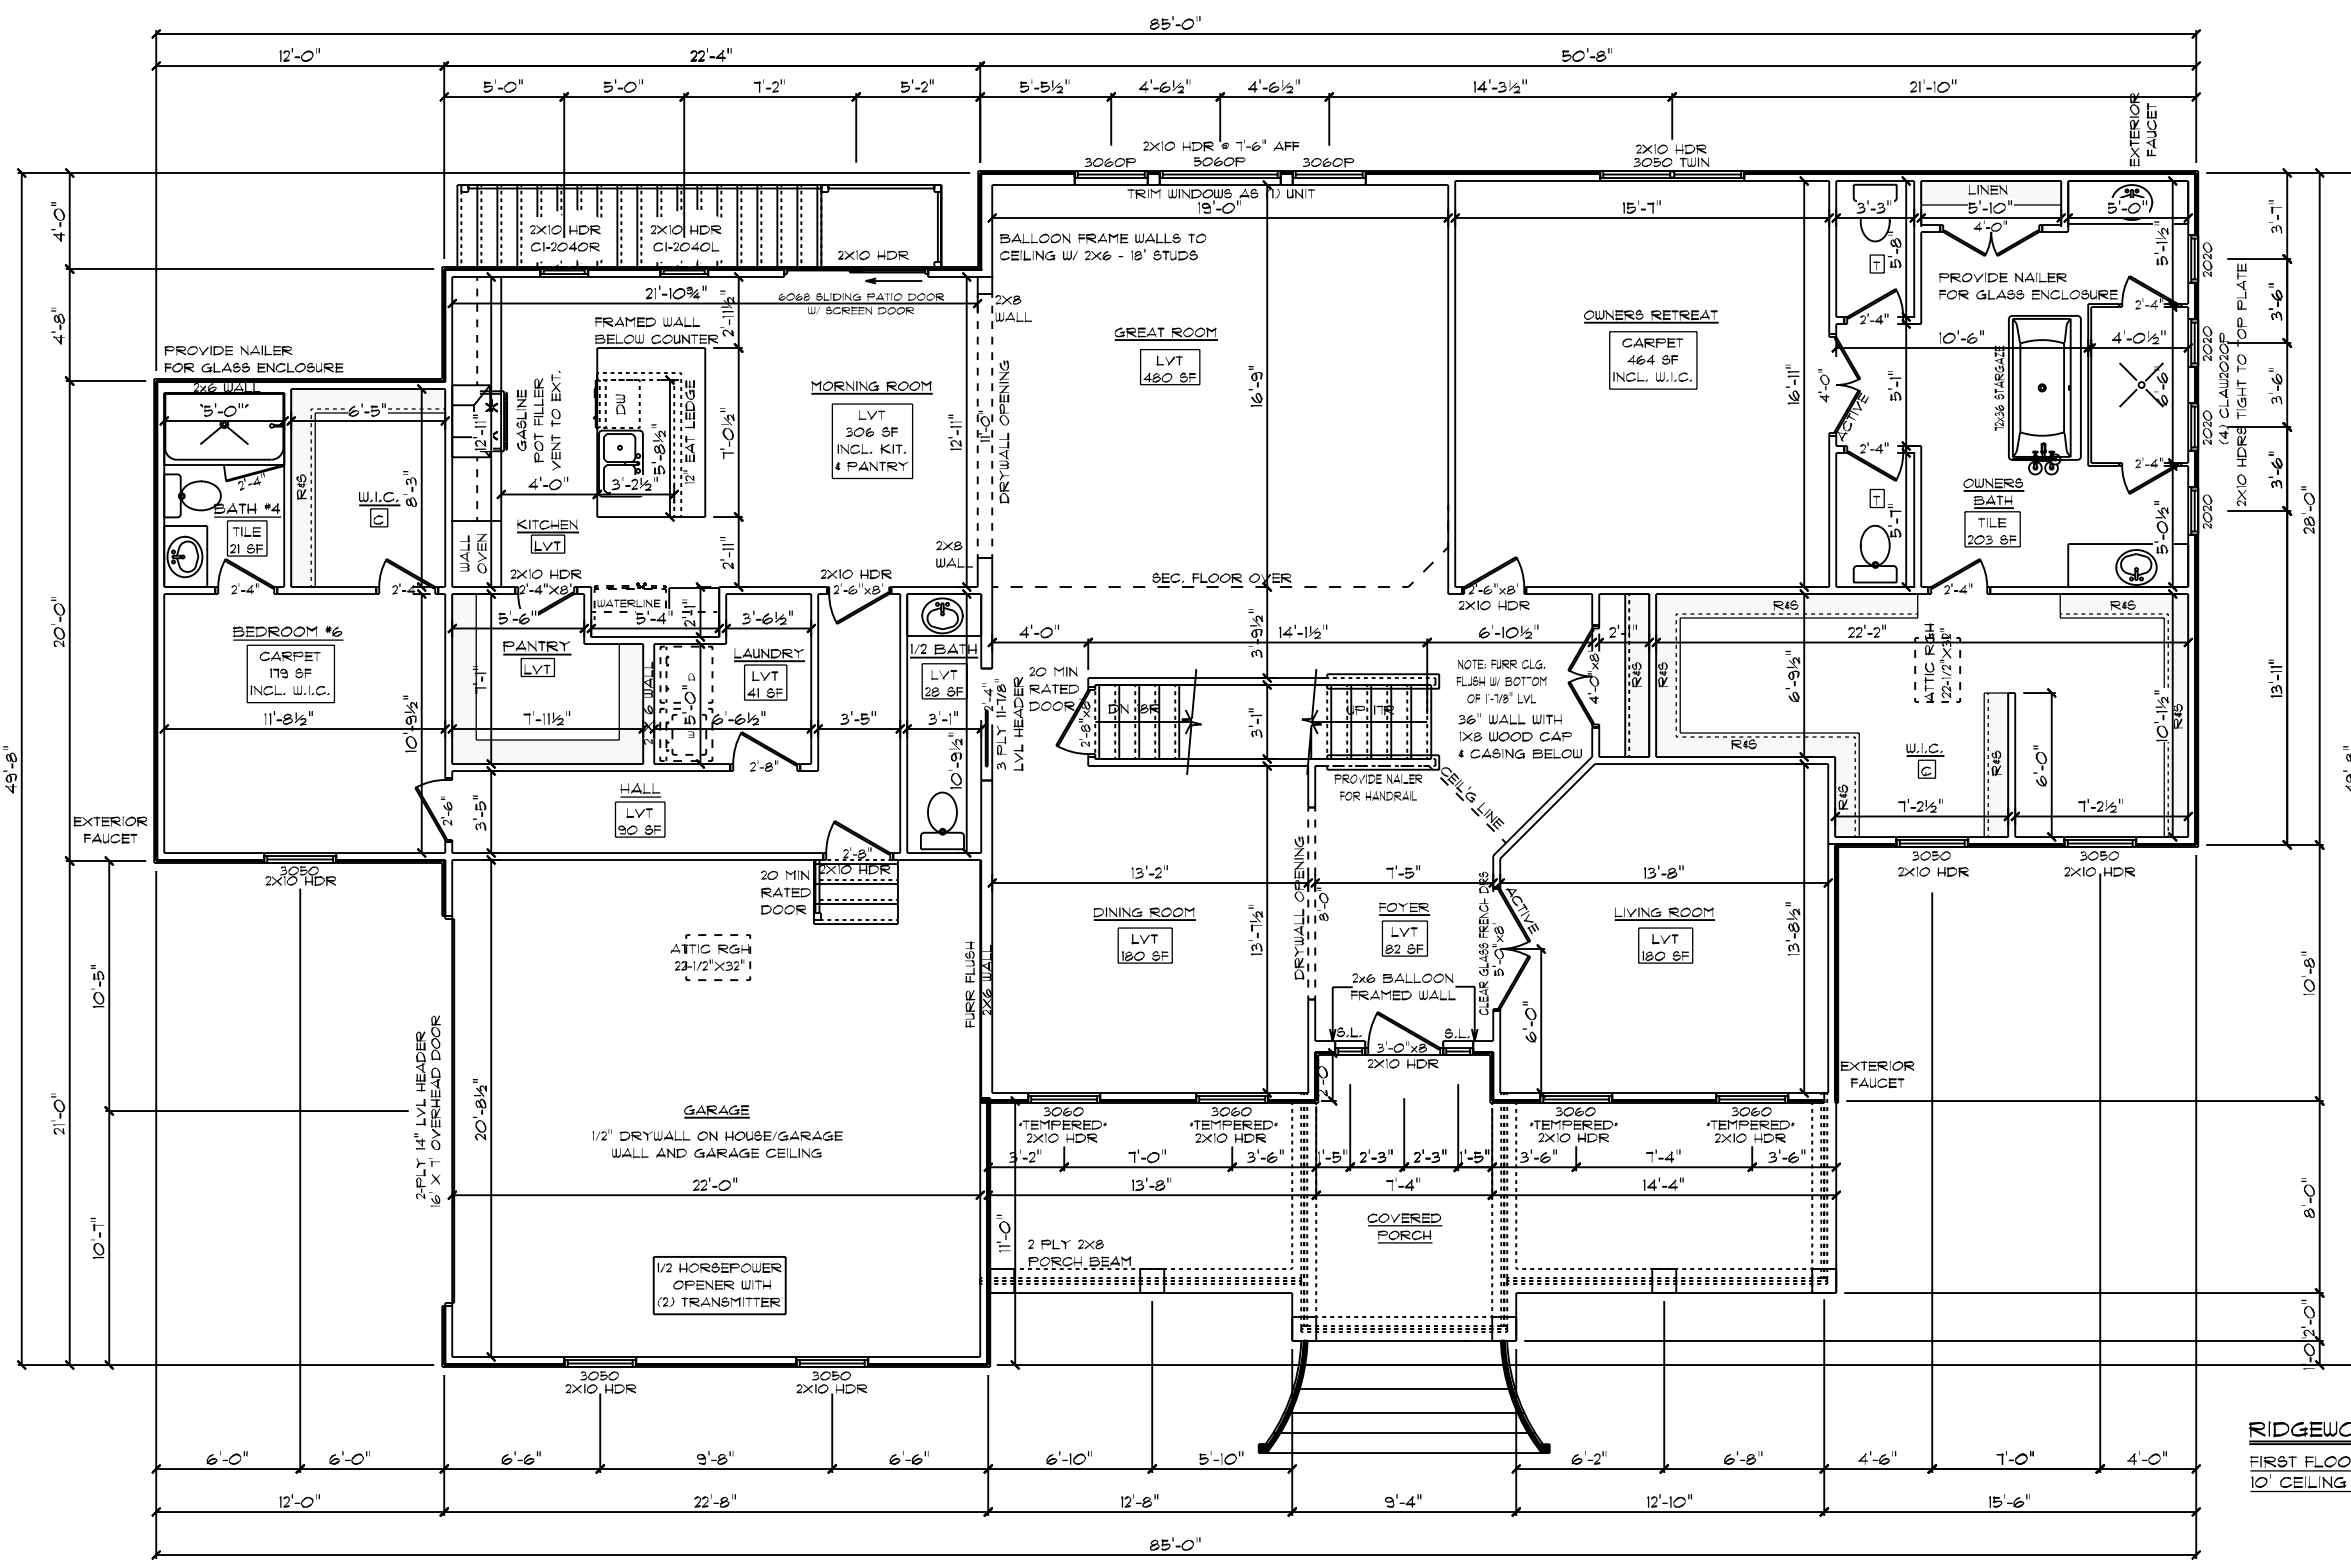

GENERAL FRAMING NOTES:


- DRYWALLED OPENINGS TO BE 9'-0" HEIGHT UNLESS OTHERWISE NOTED
- HEADERS TO BE 2-PLY 2X10 W/ (1) KING & (2) JACK STUDS UNLESS OTHERWISE NOTED

PLAN NOTES:

- SMOOTH CEILING THROUGHOUT HOME
- PAINTED TRIM
- 5-1/4" BASEBOARDS
- 3-1/4" CASING ON INTERIOR DOORS AND WINDOWS HAVE DRYWALLED RETURNS
- 2-PANEL HOLLOW CORE MOLDED INTERIOR DOORS
- SILVERLINE LOW-E VINYL WINDOWS W/ SOLAR GLAZING

FLOORING NOTES:

- ALL FLOORING BREAKS OCCUR @ CENTER LINE OF DOOR OPENINGS UNLESS OTHERWISE NOTED
- FLOORING SQUARE FOOTAGES INCLUDE CLOSETS RELATIVE TO THE AREA UNLESS OTHERWISE NOTED
- SOME FLOORING SQUARE FOOTAGES MAY INCLUDE HALLS OR AREAS THAT CONNECT WITHOUT WALL SEPARATION IF THE SAME FINISH IS CONTINUED

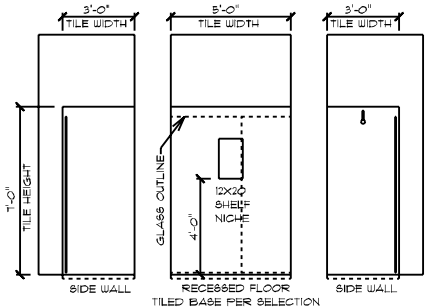


RIDGEWOOD CAROLINA / CUSTOM
 FIRST FLOOR PLAN
 10' CEILING HEIGHT

DATE: 3/20/2023
 SCALE: 1/8" = 1'-0"
 DRAWN BY: SG
 SQUARE FOOTAGES (4096)
 BASEMENT: 2574
 1ST FL: 2574
 2ND FL: 522
 OPEN SPACE: 384
 GARAGE: 414
 PORCH: 96

CUSTOM BUILT FOR: TRAVIS & SPARKLE BASS
 JOB #: DUTCO 022 OTT CN #: BA282
 LOCATION: 2184 WIRE RD BUNNLEVEL, NC 28323
 COUNTY: HARNETT

Raleigh/Durham, NC
 182 West Hamlin Road
 Benson, NC 27504
 (811) 261-3482
 www.schumacherhomes.com

SCHUMACHER HOMES

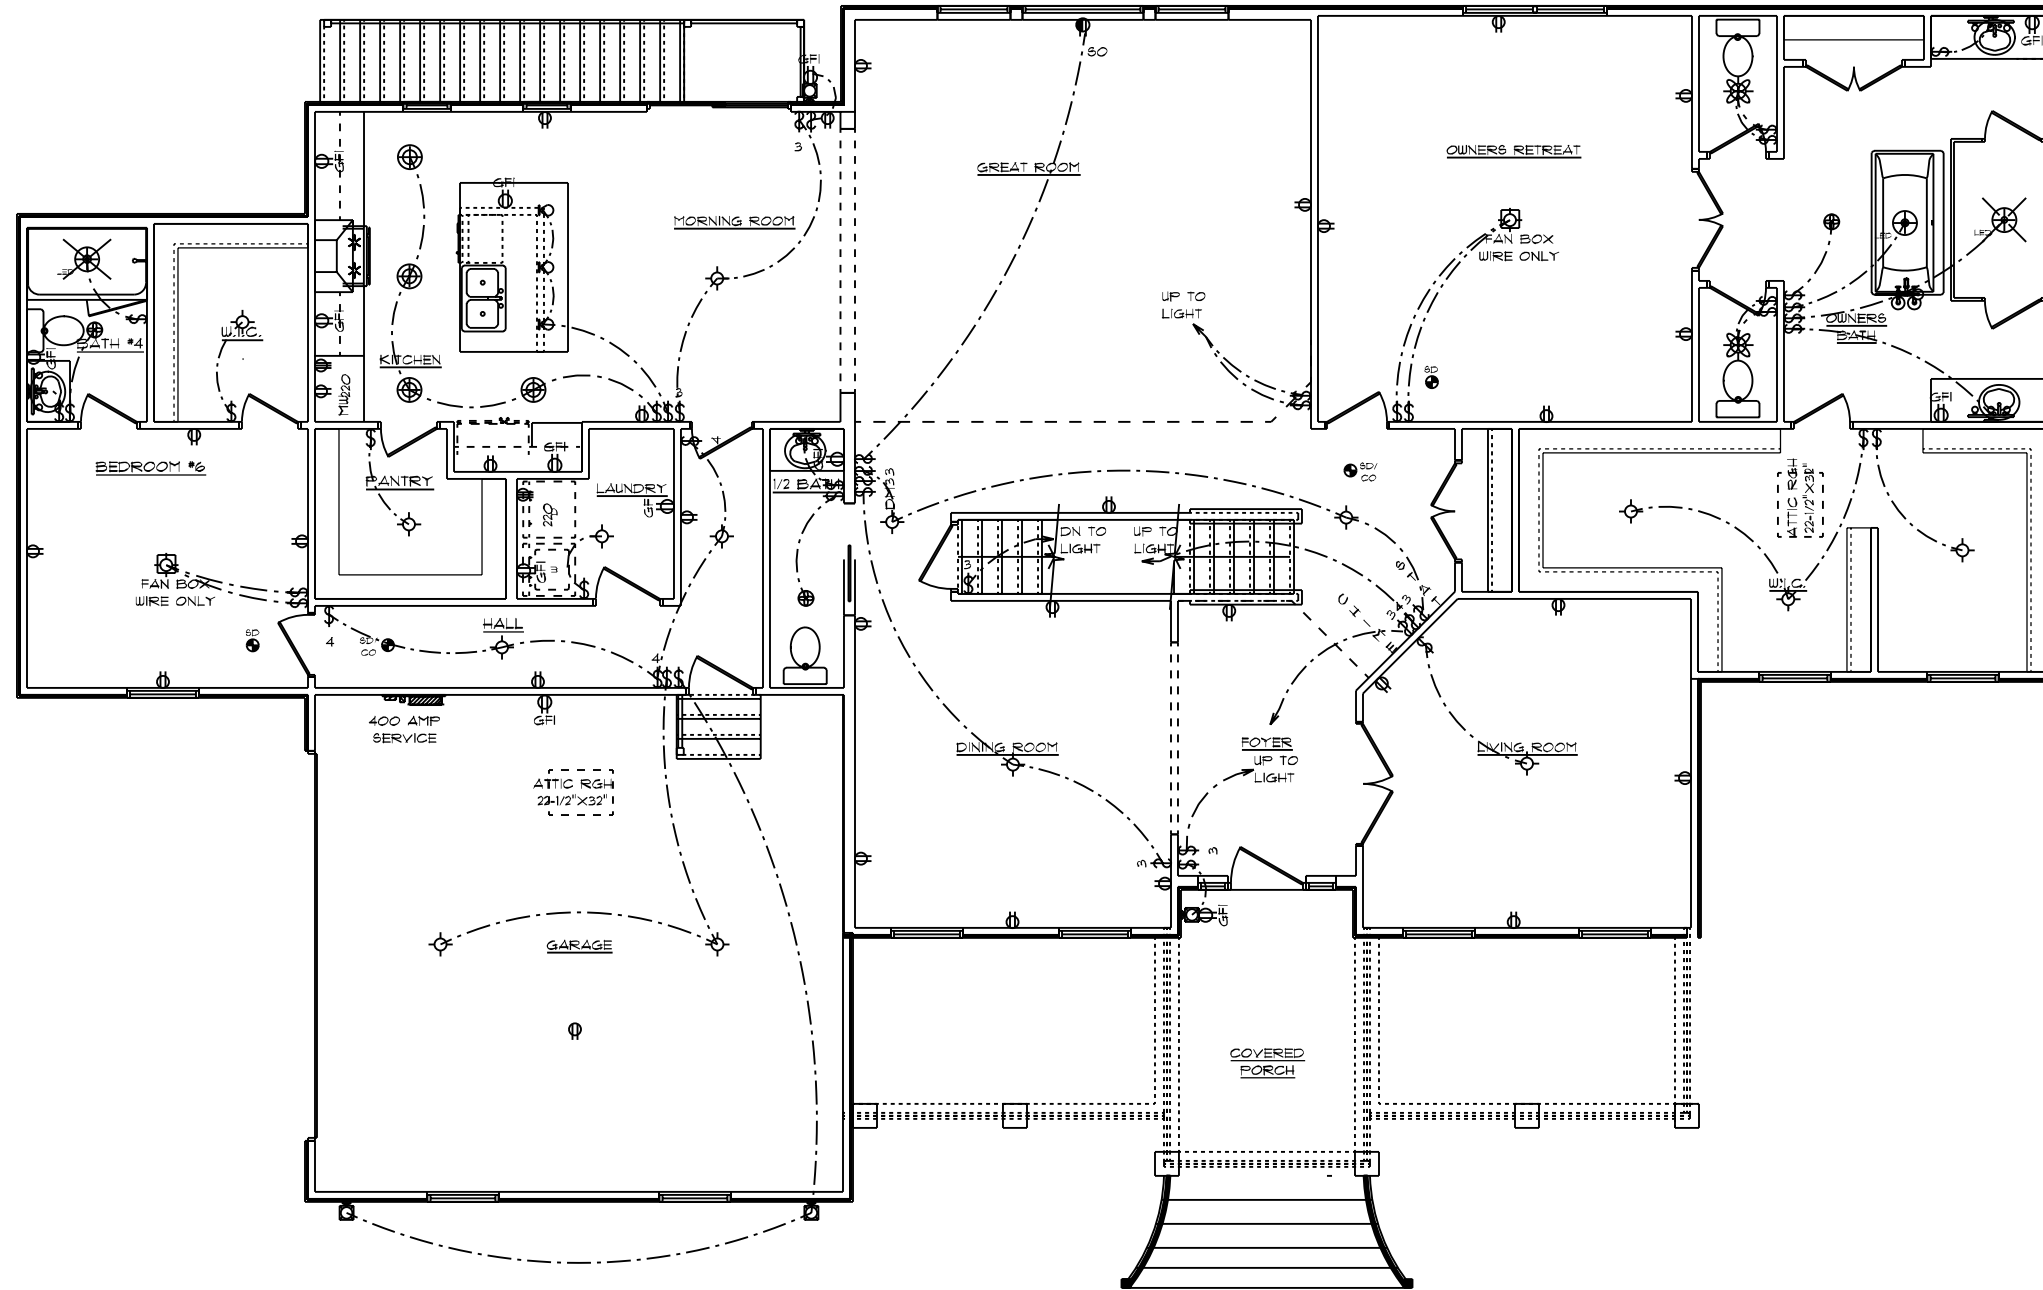

GENERAL ELECTRICAL NOTES:

- (1) EXISTING SWITCH UPGRADED TO A 3-WAY SWITCH, (1) ADDITIONAL 3-WAY SWITCH AND (1) COACH LIGHT WIRED TO A STANDARD SWITCH ARE INCLUDED WHEN A GARAGE SERVICE DOOR IS PURCHASED
- (1) COACH LIGHT, (1) SWITCH, AND (1) GFI OUTLET ARE INCLUDED WHEN ANY ADDITIONAL DOOR IS PURCHASED, EXCLUDING THE GARAGE SERVICE DOOR
- ALL SMOKE DETECTORS TO BE INTERCONNECTED WITH BATTERY BACKUP
- E3902.11 ARC-FAULT CIRCUIT-INTERRUPTER PROTECTION ALL BRANCH CIRCUITS THAT SUPPLY 120-VOLT, SINGLE-PHASE, 15- AND 20-AMPERE OUTLETS INSTALLED IN FAMILY ROOMS, DINING ROOMS, LIVING ROOMS, PARLORS, LIBRARIES, DENS, BEDROOMS, SUNROOMS, RECREATION ROOMS, CLOSETS, HALLWAYS AND SIMILAR ROOMS OR AREAS SHALL BE PROTECTED BY A COMBINATION TYPE ARC-FAULT CIRCUIT INTERRUPTER INSTALLED TO PROVIDE PROTECTION OF THE BRANCH CIRCUIT.
- GARAGE DOOR LOW VOLTAGE WIRING BY ELECTRICIAN
- TWO SEPARATE KITCHEN GENERAL ELECTRIC OUTLET CIRCUITS FED BY NUMBER 12 WIRE AND ON 20 AMP BREAKERS REQUIRED IN KITCHEN
- ALL OUTLETS INSTALLED IN BATHROOMS, GARAGES, & UNFINISHED BASEMENTS SHALL HAVE GFCI PROTECTIONS ALONG WITH OUTLETS LOCATED W/IN 6'-0" OF LAUNDRY, UTILITY & WET BAR SINKS & ALL OUTLETS SERVING KITCHEN COUNTERTOP SURFACES
- ALL OUTLETS TO BE PLACED PER CODE
- MOUNTING HEIGHTS
 - VANITY LIGHTS: 80" AFF
 - WALL SCONCES: 66" AFF
 - PENDANT LIGHTS: 66" AFF
 - CHANDELIERS (TO BTM OF FIXTURE)
 - FOYER 9' CEILING: 84"
 - FOYER OVER 9' CLG: 90"
 - DINING ROOM: 60"

ADDITIONAL ELECTRICAL NOTES:

- CABLE & PHONE TO BE LOCATED AT ELECTRICAL WALK-THRU
- ADDITIONAL MINI RECESSED LIGHTS TO BE LOCATED AT ELECTRICAL WALK-THRU
- (2) FLOOR OUTLETS IN GREAT ROOM TO BE LOCATED AT ELECTRICAL WALK-THRU
- INSTALL ALL BATHROOM LIGHT FIXTURES WITH GLOBES FACING DOWN

RIDGEWOOD CAROLINA / CUSTOM


FIRST FLOOR PLAN
 10' CEILING HEIGHT
 ELECTRICAL PLAN

CUSTOM BUILT FOR: TRAVIS & SPARKLE BASS JOB #: DUTCO 022 OTT LOCATION: 2184 WIRE RD BUNNLEVEL, NC 28323 COUNTY: HARNETT	SQUARE FOOTAGES (4096): BASEMENT: 2574 1ST FL: 2574 2ND FL: 522 OPEN SPACE: 394 GARAGE: 414 PORCH: 96	DATE: 3/20/2023 SCALE: 1/8" = 1'-0" DRAWN BY: SG DESIG: 10
	© 1992-2023 SCHUMACHER HOMES OPERATIONS, INC. ALL RIGHTS RESERVED. THE INFORMATION CONTAINED HEREIN IS THE PROPERTY OF SCHUMACHER HOMES OPERATIONS, INC. AND IS TO BE USED ONLY FOR THE PROJECT AND HOME IDENTIFIED HEREIN. THESE PLANS ARE NOT TO BE USED TO CREATE DERIVATIVE WORKS, TECHNICAL DRAWINGS OR TO BUILD A STRUCTURE, REPRODUCED, COPIED, OR MODIFIED, IN WHOLE OR PART, WITHOUT THE EXPRESS WRITTEN CONSENT OF SCHUMACHER HOMES, AND SUCH UNAUTHORIZED USE OR COPYING IS A VIOLATION OF UNITED STATES COPYRIGHT LAW AND THAT RESULT IN DAMAGES IN EXCESS OF \$50000 PER ACT OF INFRINGEMENT.	

Raleigh/Durham, NC
 182 West Hamlin Road
 Benson, NC 27504
 (811) 261-3482
 www.schumacherhomes.com




APPROVED: 10-26-2022
 REVISED: 03-20-2023

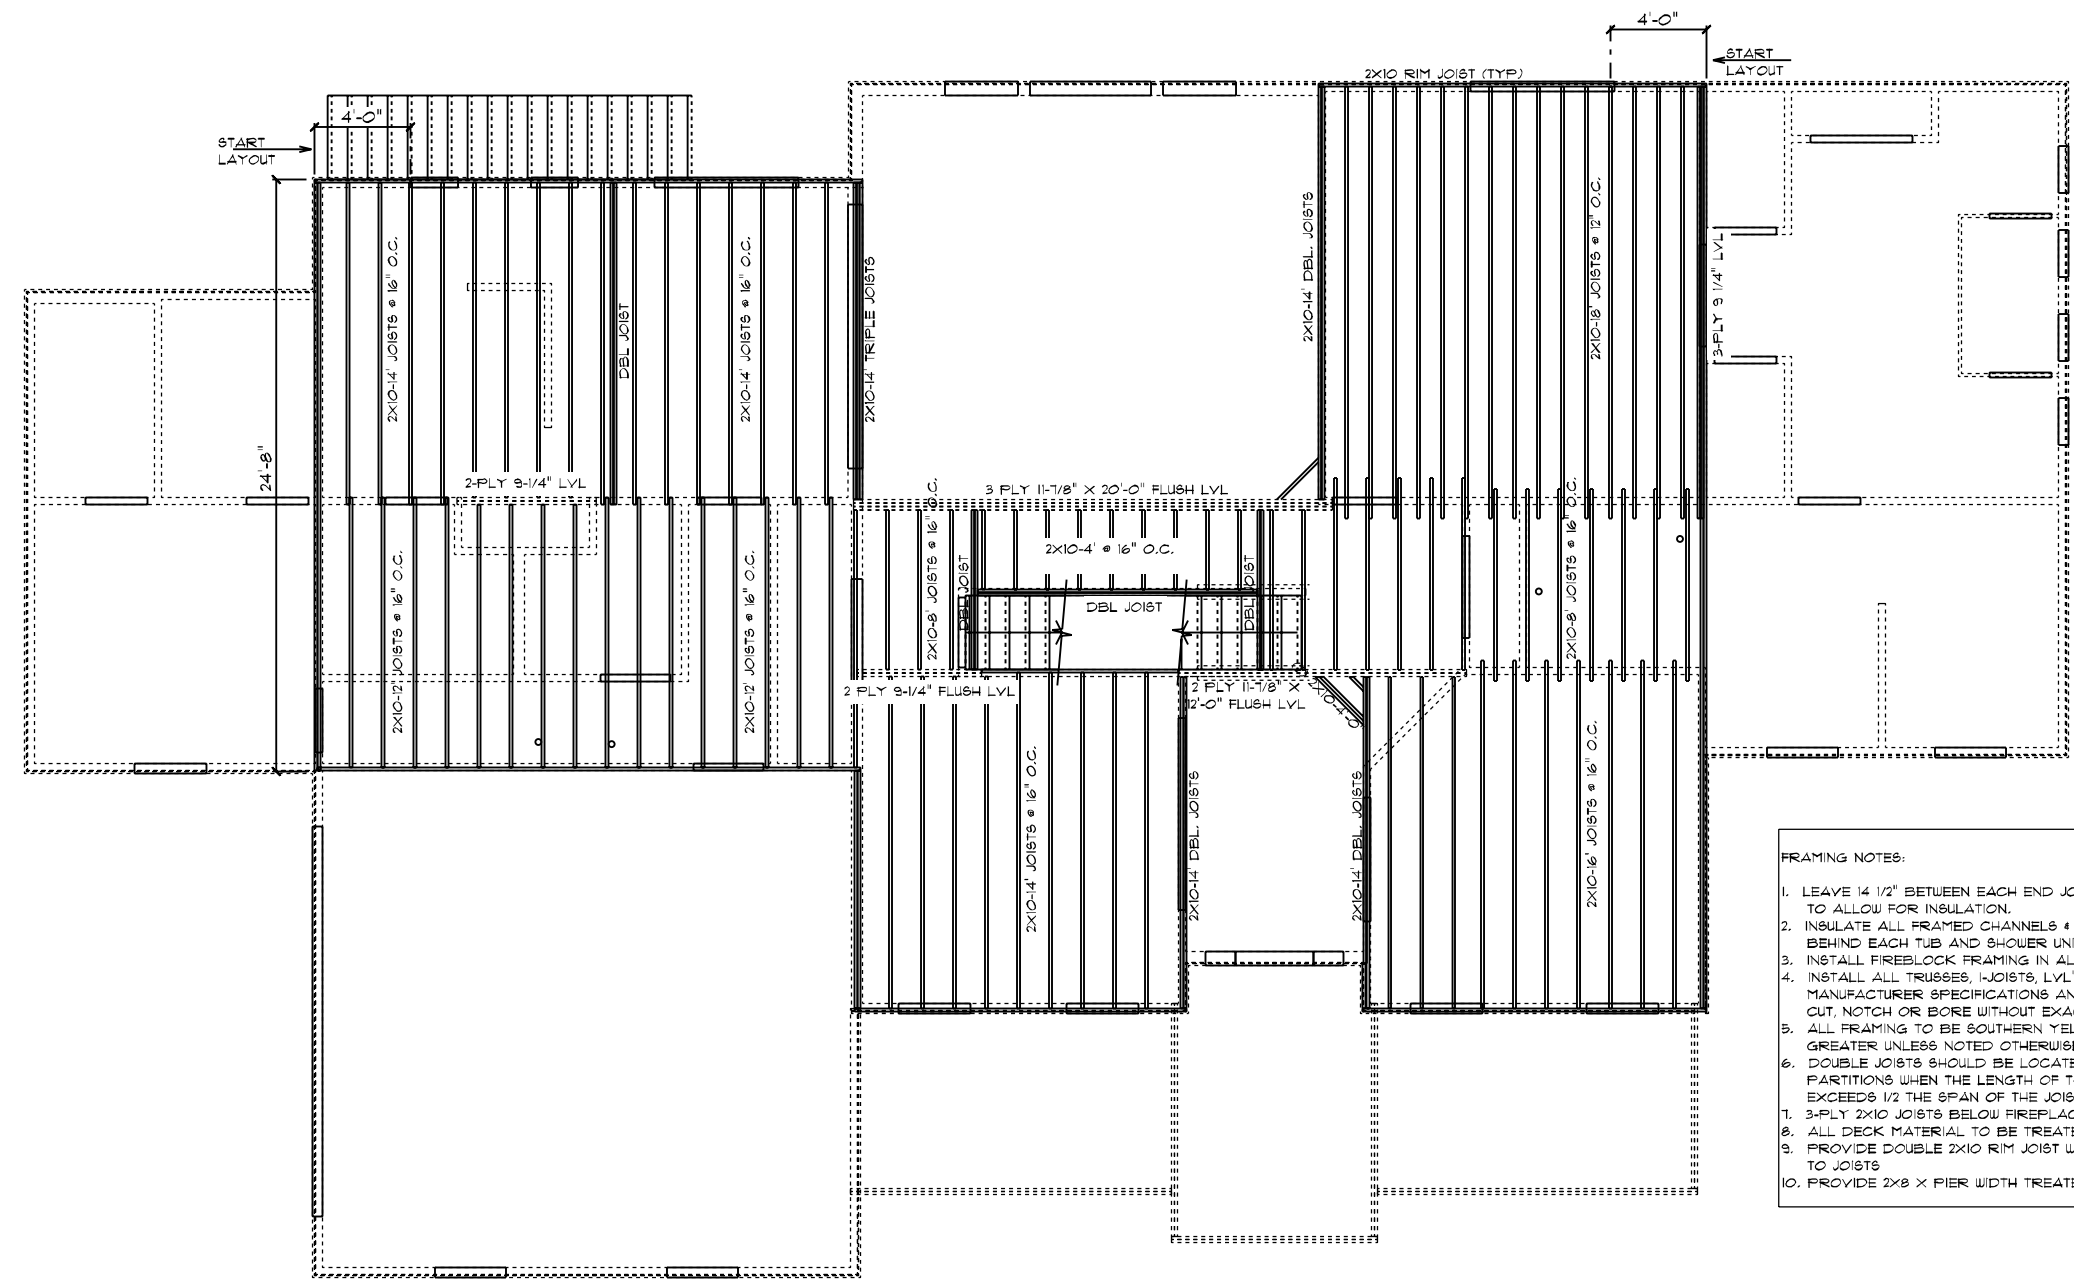

- FRAMING NOTES:
1. LEAVE 14 1/2" BETWEEN EACH END JOIST & RIM JOIST TO ALLOW FOR INSULATION.
 2. INSULATE ALL FRAMED CHANNELS & CORNERS; ALSO, BEHIND EACH TUB AND SHOWER UNIT
 3. INSTALL FIREBLOCK FRAMING IN ALL STAIRWAY CEILINGS
 4. INSTALL ALL TRUSSES, I-JOISTS, LVL'S AND BEAMS PER MANUFACTURER SPECIFICATIONS AND LAY OUTS. DO NOT CUT, NOTCH OR BORE WITHOUT EXACT SPECIFICATIONS.
 5. ALL FRAMING TO BE SOUTHERN YELLOW PINE NO. 2 OR GREATER UNLESS NOTED OTHERWISE
 6. DOUBLE JOISTS SHOULD BE LOCATED UNDER ALL PARTITIONS WHEN THE LENGTH OF THE PARTITION EXCEEDS 1/2 THE SPAN OF THE JOIST
 7. 3-PLY 2X10 JOISTS BELOW FIREPLACES & SOLID SURFACE ISLANDS
 8. ALL DECK MATERIAL TO BE TREATED
 9. PROVIDE DOUBLE 2X10 RIM JOIST WHEN RIM JOIST RUNS PARALLEL TO JOISTS
 10. PROVIDE 2x8 X PIER WIDTH TREATED BEARING PLATE @ INTERIOR PIERS

RIDGEWOOD CAROLINA / CUSTOM
 SECOND FLOOR JOIST PLAN

<p>SCHUMACHER HOMES Raleigh/Durham, NC 182 West Hamlin Road Benson, NC 27504 (811) 261-3482 www.schumacherhomes.com</p>	<p>DATE: 3/20/2023 SCALE: 1/8" = 1'-0"</p>
	<p>DRAWN BY: SG DWG: 11</p>
<p>CUSTOM BUILT FOR: TRAVIS & SPARKLE BASS JOB #: DUTCO 022 OTT CN #: 34120 LOCATION: 2184 WIRE RD BUNNLEVEL, NC, 28323 COUNTY: HARNETT</p>	<p>SQUARE FOOTAGES (4096): BASEMENT: 2574 1ST FL: 2814 2ND FL: 522 OPEN SPACE: 394 GARAGE: 414 PORCH: 96</p>
<p>© 199-2023 SCHUMACHER HOMES OPERATIONS, INC. ALL RIGHTS RESERVED. THE INFORMATION CONTAINED HEREIN IS THE PROPERTY OF SCHUMACHER HOMES OPERATIONS, INC. AND IS TO BE USED ONLY FOR THE PROJECT AND PERMITS SPECIFICALLY IDENTIFIED IN THESE PLANS. THESE PLANS ARE NOT TO BE USED TO CREATE DERIVATIVE WORKS, TECHNICAL DRAWINGS OR TO BUILD A STRUCTURE, REPRODUCED, COPIED, OR MODIFIED, IN WHOLE OR PART, WITHOUT THE EXPRESS WRITTEN CONSENT OF SCHUMACHER HOMES, AND SUCH UNAUTHORIZED USE OR COPYING IS A VIOLATION OF UNITED STATES COPYRIGHT LAW AND THAT RESULT IN DAMAGES IN EXCESS OF \$50000 PER ACT OF INFRINGEMENT.</p>	

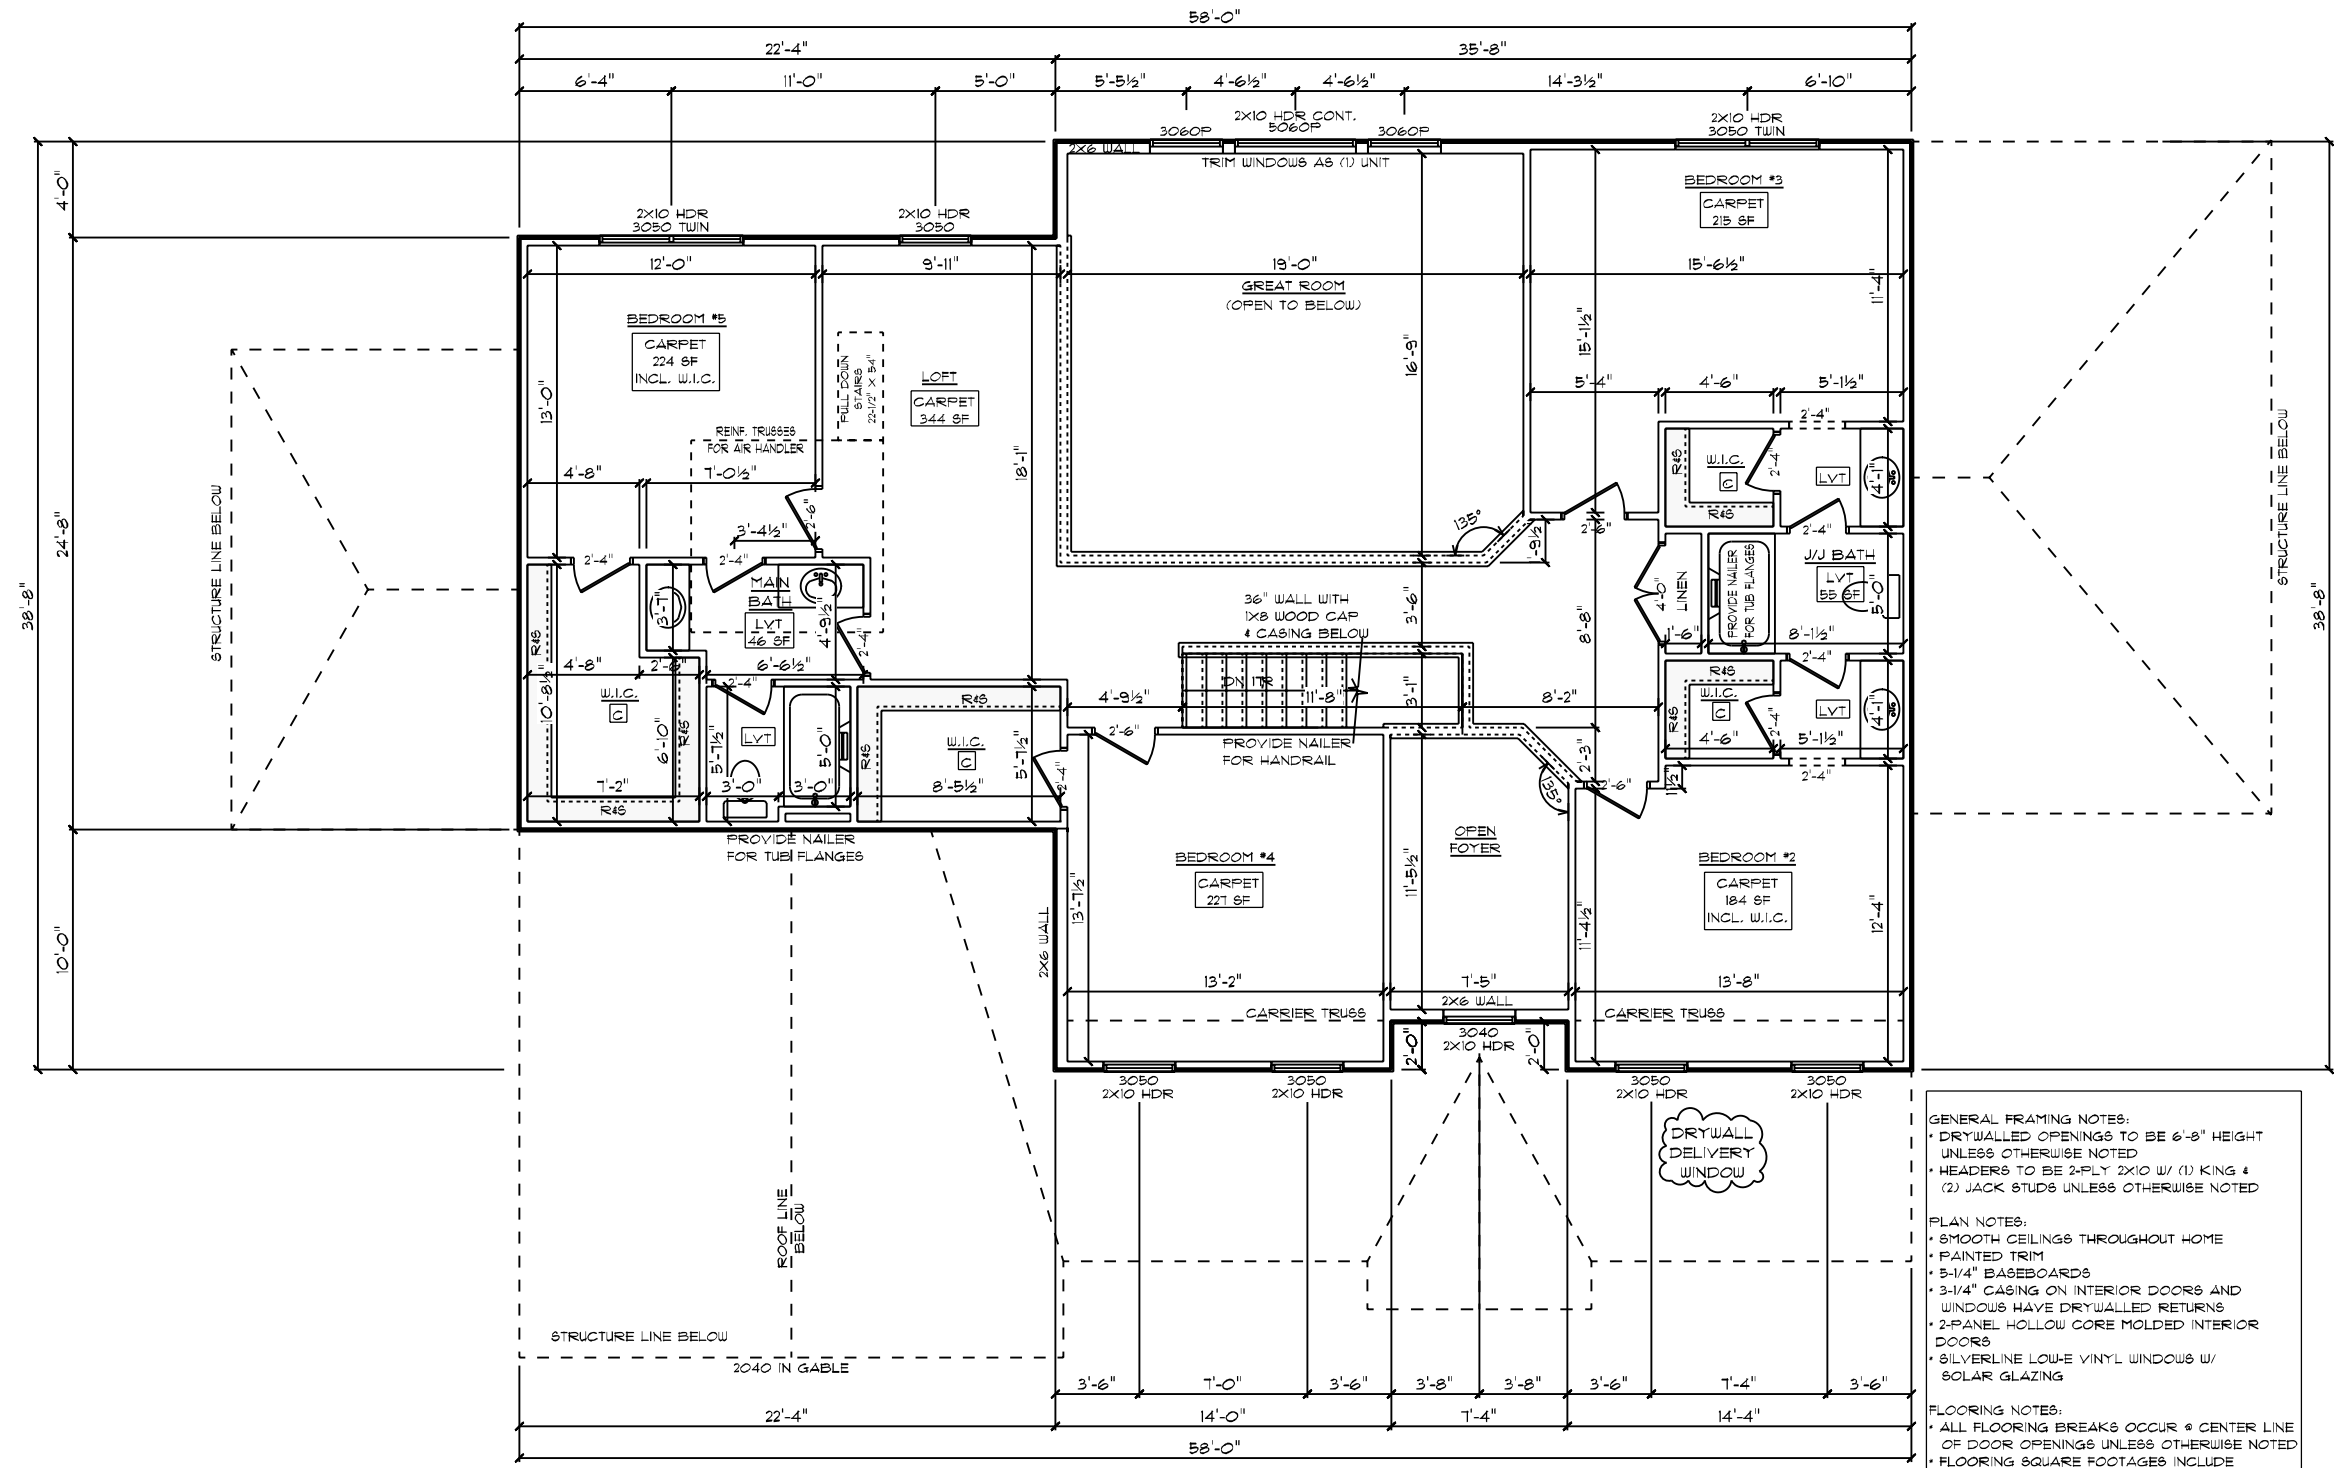

RIDGEWOOD CAROLINA / CUSTOM
 SECOND FLOOR PLAN
 8' CEILING HEIGHT

GENERAL FRAMING NOTES:

- DRYWALLED OPENINGS TO BE 6'-8" HEIGHT UNLESS OTHERWISE NOTED
- HEADERS TO BE 2-PLY 2X10 W/ (1) KING & (2) JACK STUDS UNLESS OTHERWISE NOTED

PLAN NOTES:

- SMOOTH CEILINGS THROUGHOUT HOME
- PAINTED TRIM
- 3/4" BASEBOARDS
- 3/4" CASING ON INTERIOR DOORS AND WINDOWS HAVE DRYWALLED RETURNS
- 2-PANEL HOLLOW CORE MOLDED INTERIOR DOORS
- SILVERLINE LOW-E VINYL WINDOWS W/ SOLAR GLAZING

FLOORING NOTES:

- ALL FLOORING BREAKS OCCUR @ CENTER LINE OF DOOR OPENINGS UNLESS OTHERWISE NOTED
- FLOORING SQUARE FOOTAGES INCLUDE CLOSETS RELATIVE TO THE AREA UNLESS OTHERWISE NOTED
- SOME FLOORING SQUARE FOOTAGES MAY INCLUDE HALLS OR AREAS THAT CONNECT WITHOUT WALL SEPARATION IF THE SAME FINISH IS CONTINUED


SCHUMACHER HOMES
 182 West Hamlin Road
 Benson, NC 27504
 (877) 261-3482
 www.schumacherhomes.com

CUSTOM BUILT FOR: TRAVIS & SPARKLE BASS
 JOB #: DUTCO 022 OTT CN #: 34120 VN #: BA282
 LOCATION: 2184 WIRE RD BUNNLEVEL, NC, 28333 COUNTY: HARNETT

SQUARE FOOTAGES (4096):
 BASEMENT: 2574
 1ST FL: 2574
 2ND FL: 522
 OPEN SPACE: 394
 GARAGE: 414
 PORCH: 96

DATE: 3/20/2023
SCALE: 1/8" = 1'-0"
DRAWN BY: SG
DATE: 3/20/2023
SCALE: 1/8" = 1'-0"
DWG. NO.: 12

© 1992-2023 SCHUMACHER HOMES OPERATIONS, INC. ALL RIGHTS RESERVED. THE INFORMATION CONTAINED HEREIN IS THE PROPERTY OF SCHUMACHER HOMES OPERATIONS, INC. AND IS TO BE USED ONLY FOR THE PROJECT AND HOME IDENTIFIED HEREIN. IT IS NOT TO BE USED TO CREATE DERIVATIVE WORKS, TECHNICAL DRAWINGS OR TO BUILD A STRUCTURE, REPRODUCED, COPIED, OR MODIFIED, IN WHOLE OR PART, WITHOUT THE EXPRESS WRITTEN CONSENT OF SCHUMACHER HOMES, AND SUCH UNAUTHORIZED USE OR COPYING IS A VIOLATION OF UNITED STATES COPYRIGHT LAW AND THAT RESULT IN DAMAGES IN EXCESS OF \$50000 PER ACT OF INFRINGEMENT.

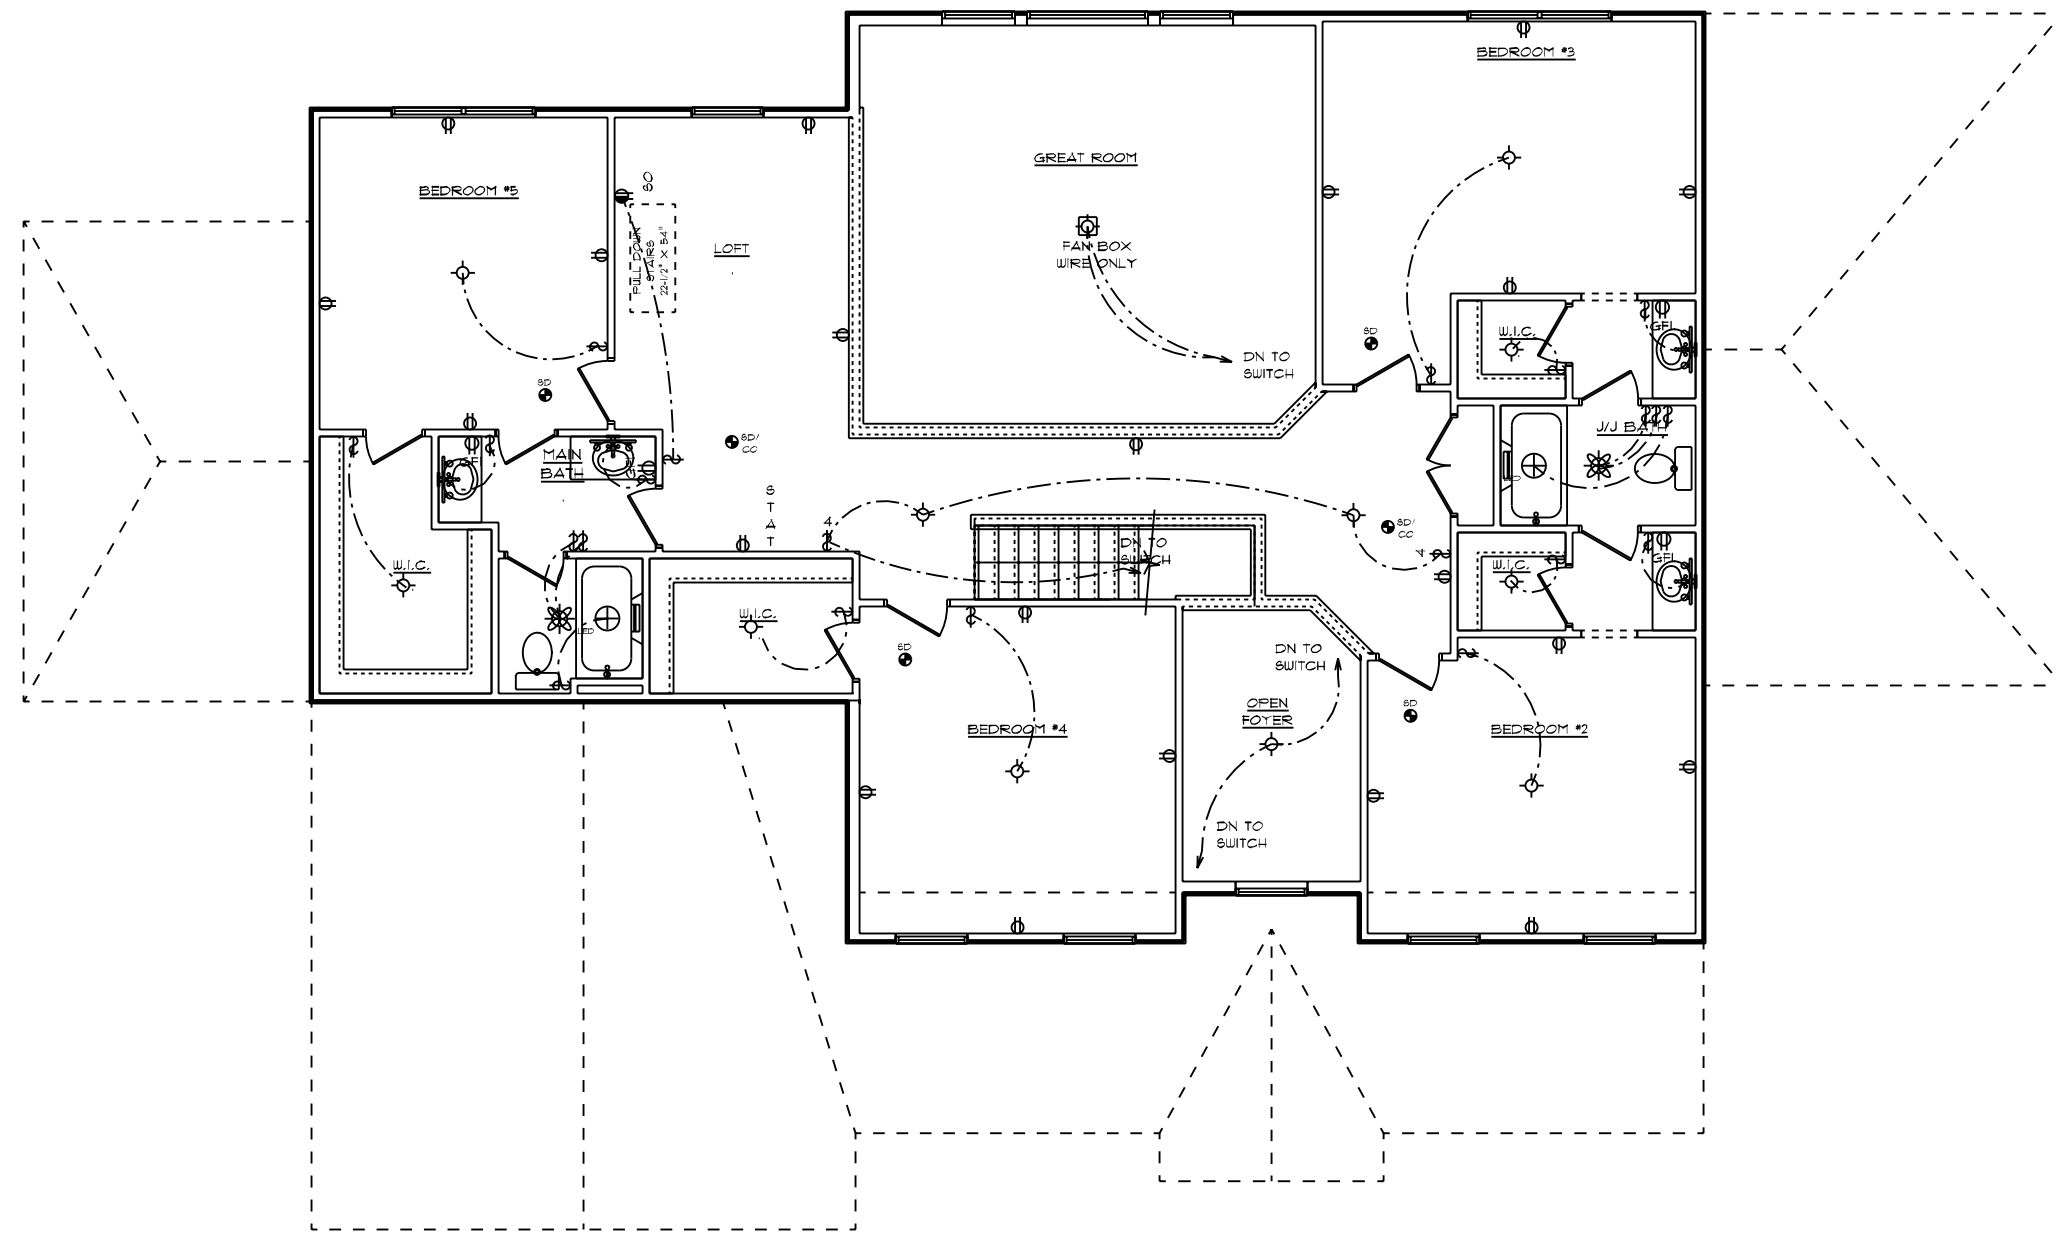

RIDGEWOOD CAROLINA / CUSTOM
 SECOND FLOOR PLAN
 8' CEILING HEIGHT
 ELECTRICAL PLAN



GENERAL ELECTRICAL NOTES:

- (1) EXISTING SWITCH UPGRADED TO A 3-WAY SWITCH, (1) ADDITIONAL 3-WAY SWITCH AND (1) COACH LIGHT WIRED TO A STANDARD SWITCH ARE INCLUDED WHEN A GARAGE SERVICE DOOR IS PURCHASED
- (1) COACH LIGHT, (1) SWITCH, AND (1) GFI OUTLET ARE INCLUDED WHEN ANY ADDITIONAL DOOR IS PURCHASED, EXCLUDING THE GARAGE SERVICE DOOR
- ALL SMOKE DETECTORS TO BE INTERCONNECTED WITH BATTERY BACKUP
- E3902.11 ARC-FAULT CIRCUIT-INTERRUPTER PROTECTION ALL BRANCH CIRCUITS THAT SUPPLY 120-VOLT, SINGLE-PHASE, 15- AND 20-AMPERE OUTLETS INSTALLED IN FAMILY ROOMS, DINING ROOMS, LIVING ROOMS, PARLORS, LIBRARIES, DEN'S, BEDROOMS, SUNROOMS, RECREATION ROOMS, CLOSETS, HALLWAYS AND SIMILAR ROOMS OR AREAS SHALL BE PROTECTED BY A COMBINATION TYPE ARC-FAULT CIRCUIT INTERRUPTER INSTALLED TO PROVIDE PROTECTION OF THE BRANCH CIRCUIT.
- GARAGE DOOR LOW VOLTAGE WIRING BY ELECTRICIAN
- TWO SEPARATE KITCHEN GENERAL ELECTRIC OUTLET CIRCUITS FED BY NUMBER 12 WIRE AND ON 20 AMP BREAKERS REQUIRED IN KITCHEN
- ALL OUTLETS INSTALLED IN BATHROOMS, GARAGES, & UNFINISHED BASEMENTS SHALL HAVE GFCI PROTECTIONS ALONG WITH OUTLETS LOCATED W/IN 6'-0" OF LAUNDRY, UTILITY & WET BAR SINKS & ALL OUTLETS SERVING KITCHEN COUNTERTOP SURFACES
- ALL OUTLETS TO BE PLACED PER CODE
- MOUNTING HEIGHTS
 - VANITY LIGHTS: 80" AFF
 - WALL SCONCES: 66" AFF
 - PENDANT LIGHTS: 66" AFF
 - CHANDELIERS (TO BTM OF FIXTURE)
 - FOYER 9' CEILING: 84"
 - FOYER OVER 9' CLG: 90"
 - DINING ROOM: 60"
- ADDITIONAL ELECTRICAL NOTES:
 - CABLE & PHONE TO BE LOCATED AT ELECTRICAL WALK-THRU
 - ADDIT'L MINI RECESSED LIGHTS TO BE LOCATED AT ELECTRICAL WALK-THRU
 - INSTALL ALL BATHROOM LIGHT FIXTURES WITH GLOBES FACING DOWN

DRAWING NO: 13
 SCALE: 1/8" = 1'-0"
 DATE: 3/20/2023
 DRAIN BY: SG
 SQUARE FOOTAGES (4096):
 BASEMENT: 2574
 1ST FL: 2574
 2ND FL: 2574
 OPEN SPACE: 394
 GARAGE: 414
 PORCH: 96
 CUSTOM BUILT FOR: TRAVIS & SPARKLE BASS
 JOB #: DUTCO 022 OTT CN #: 34120 VN #: BA282
 LOCATION: 2184 WIRE RD BUNNLEVEL, NC, 28323 COUNTY: HARNETT
 Raleigh/Durham, NC
 182 West Hamlin Road
 Benson, NC 27504
 (811) 261-3482
 www.schumacherhomes.com
 SCHUMACHER HOMES
 199-2023 SCHUMACHER HOMES OPERATIONS, INC. ALL RIGHTS RESERVED. THE INFORMATION CONTAINED HEREIN IS THE PROPERTY OF SCHUMACHER HOMES OPERATIONS, INC. AND IS TO BE USED ONLY FOR THE PROJECT AND HOME OPERATIONS AND IS NOT TO BE REPRODUCED, COPIED, OR MODIFIED IN WHOLE OR PART, WITHOUT THE EXPRESS WRITTEN CONSENT OF SCHUMACHER HOMES, INC. UNAUTHORIZED USE OR COPYING IS A VIOLATION OF UNITED STATES COPYRIGHT LAW AND MAY RESULT IN DAMAGES IN EXCESS OF \$50000 PER ACT OF INFRINGEMENT.



NOTE:
ROOF UNDERLAYMENT TO BE OVERLAPPED
50% PLUS 1" ON ROOFS LESS THAN 4/12 PITCH

APPROVED: 10-26-2022
REVISED: 03-20-2023

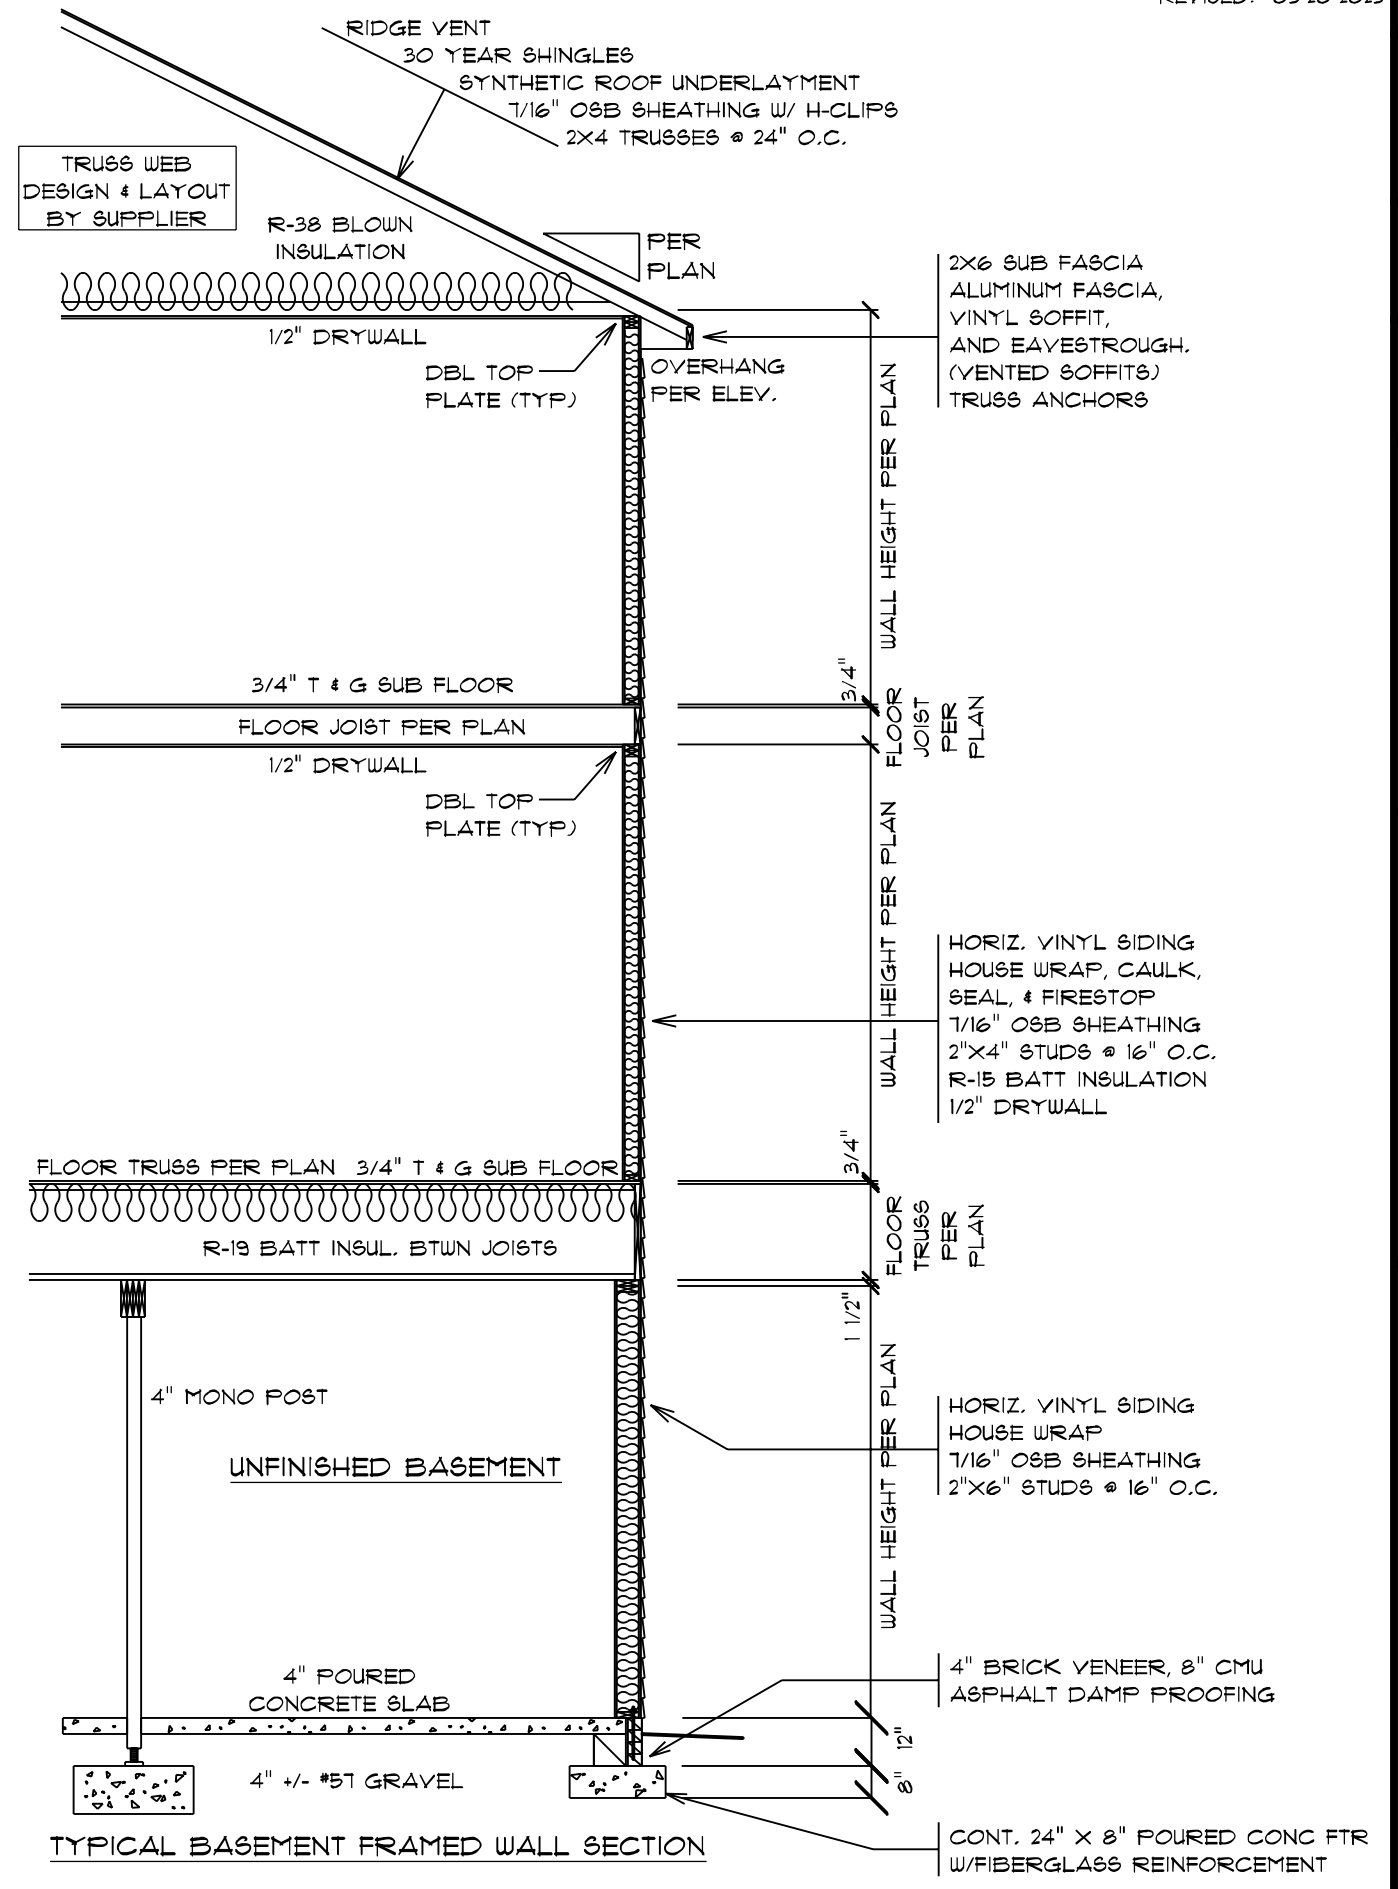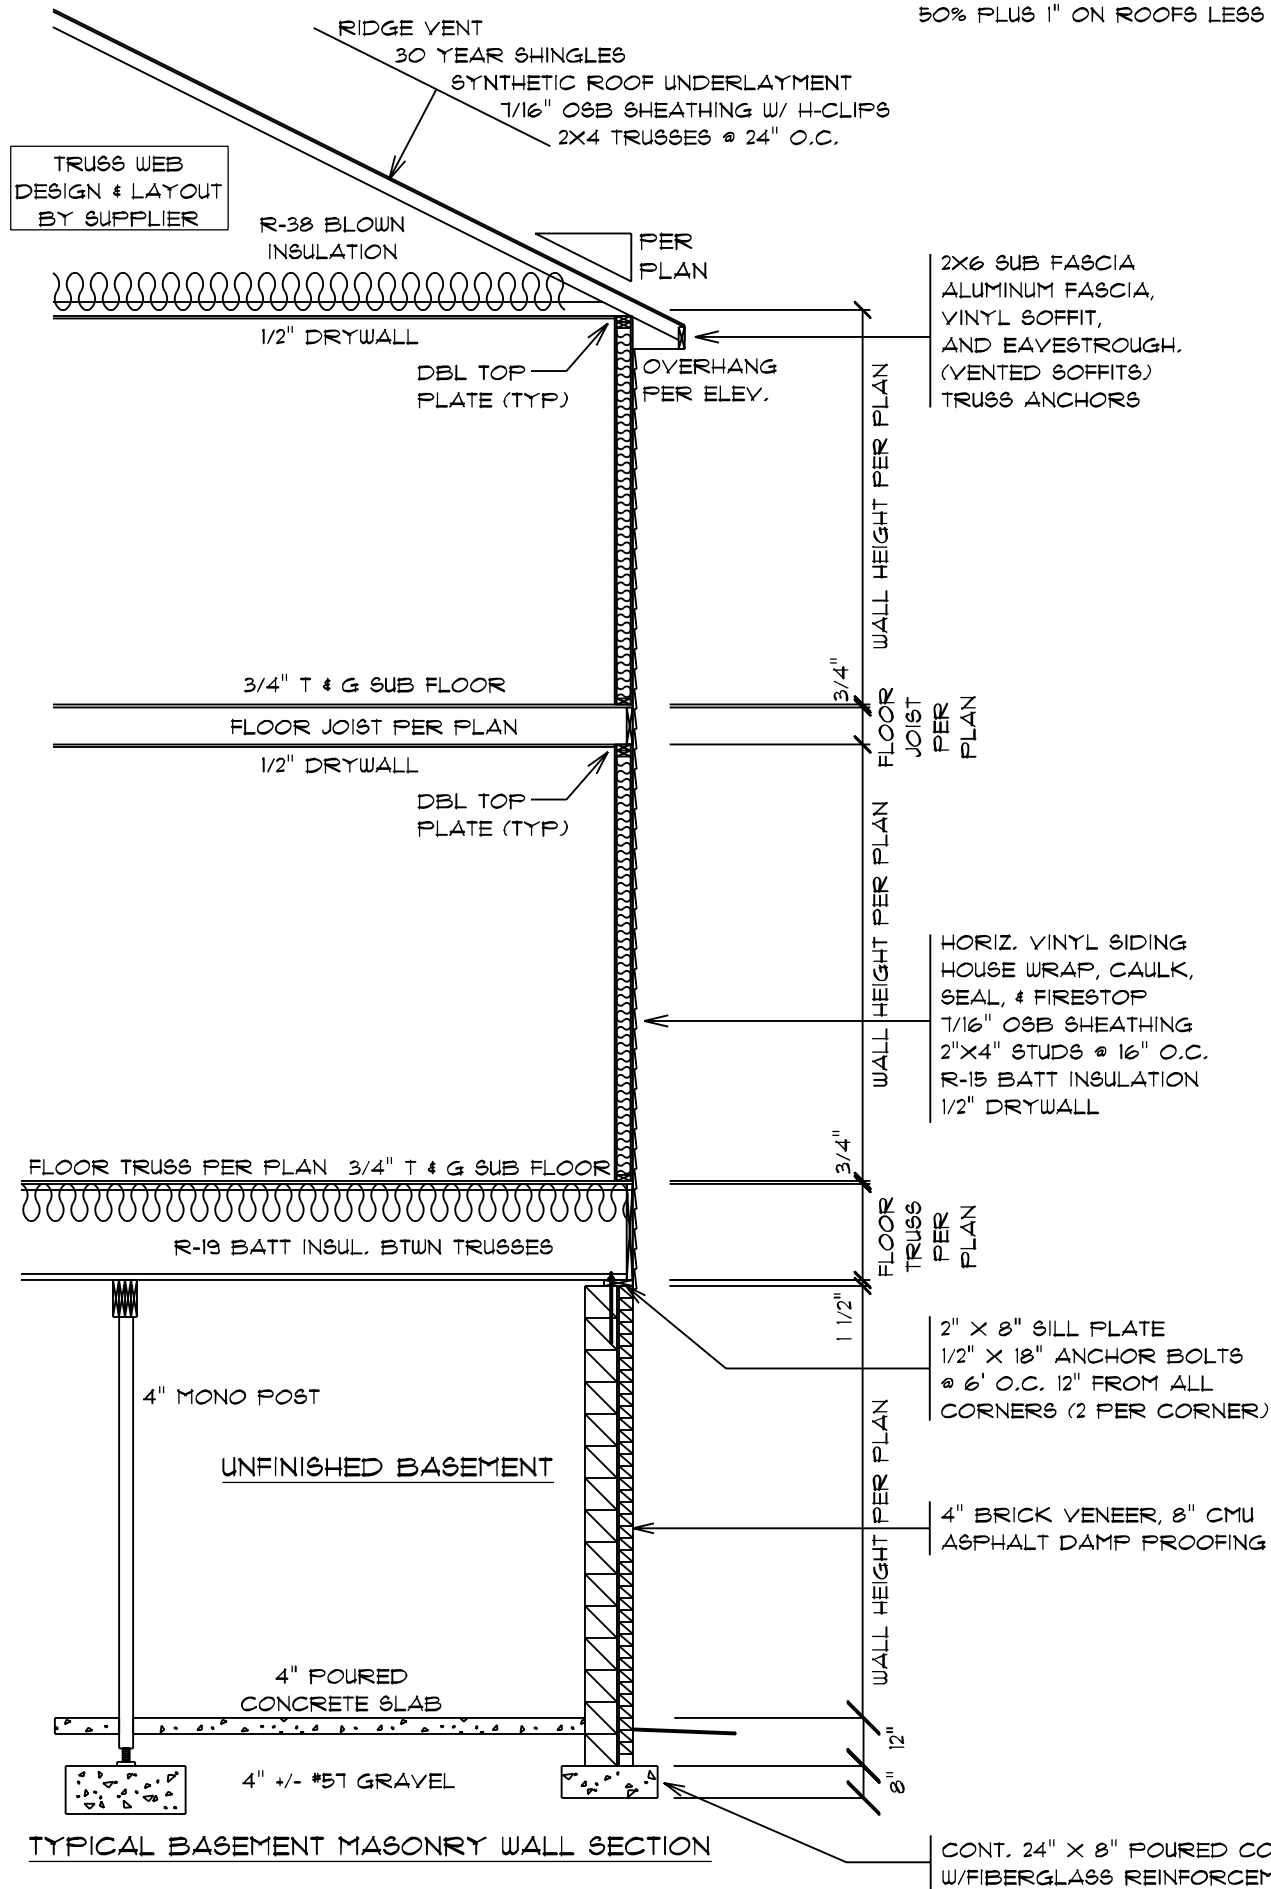


DRAWING NO. 14
 SCALE: 1/4" = 1'-0"
 DATE: 3/20/2023
 DRAIN BY: SG
 SQUARE FOOTAGES (4096):
 BASEMENT: 2574
 1ST FL: 2574
 2ND FL: 522
 OPEN SPACE: 394
 GARAGE: 414
 PORCH: 96
 CUSTOM BUILT FOR: TRAVIS & SPARKLE BASS
 JOB #: DUTCO 022 0111 CN #: 34120
 LOCATION: 2184 WIRE RD
 BUNNLEVEL, NC 28323
 COUNTY: HARNETT
 Raleigh/Durham, NC
 182 West Hamlin Road
 Benson, NC 27504
 (811) 261-3482
 www.schumacherhomes.com
 SCHUMACHER HOMES


© 1994-2023 SCHUMACHER HOMES OPERATIONS, INC. ALL RIGHTS RESERVED. THE
 INFORMATION CONTAINED HEREIN IS THE PROPERTY OF SCHUMACHER HOMES
 OPERATIONS, INC. AND IS TO BE USED ONLY FOR THE PROJECT AND
 HOME OPERATIONS AND IS NOT TO BE REPRODUCED, COPIED, OR
 MADE NOT TO BE USED TO CREATE DERIVATIVE WORKS, TECHNICAL DRAWINGS OR TO
 BUILD A STRUCTURE, REPRODUCED, COPIED, OR MODIFIED, IN WHOLE OR PART,
 WITHOUT THE EXPRESS WRITTEN CONSENT OF SCHUMACHER HOMES, AND SUCH
 UNAUTHORIZED USE OR COPYING IS A VIOLATION OF UNITED STATES COPYRIGHT LAW
 AND THAT RESULT IN DAMAGES IN EXCESS OF \$50000 PER ACT OF INFRINGEMENT

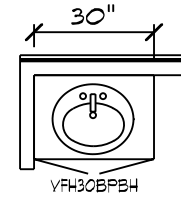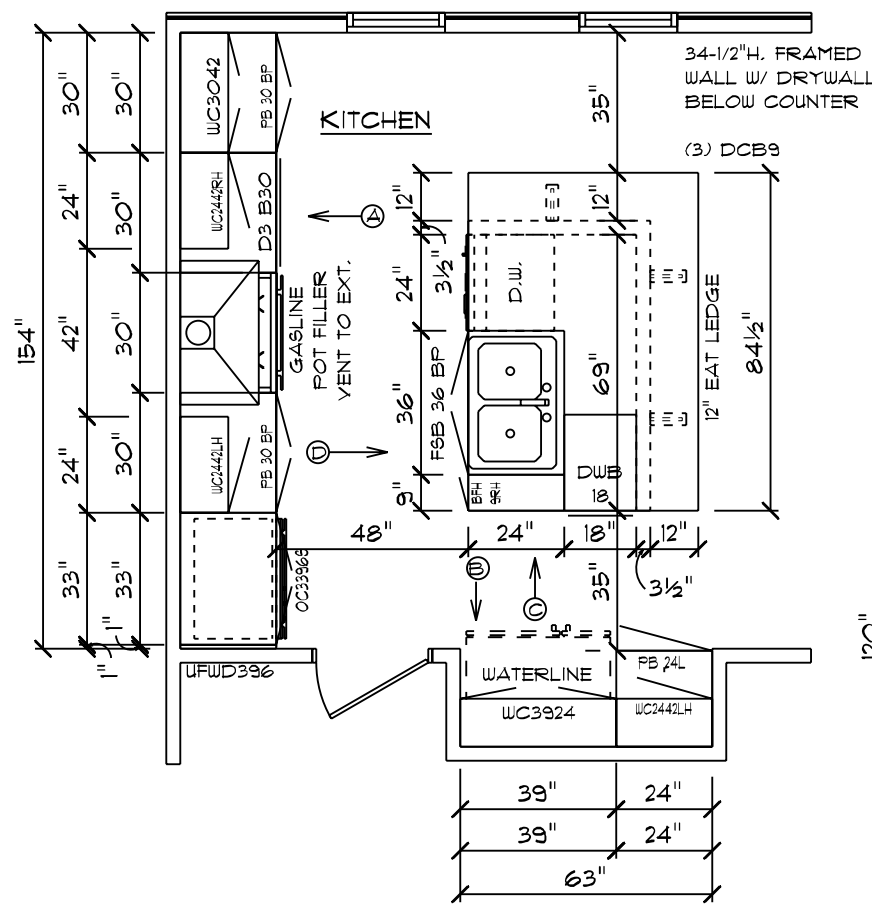



BATH #4

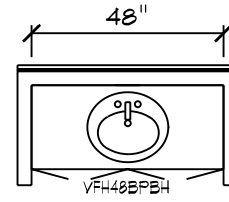


JACK & JILL BATH

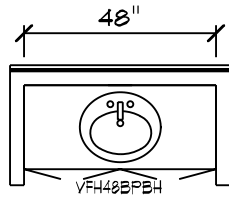

1/2 BATH

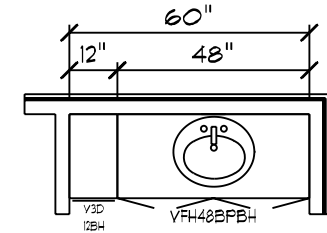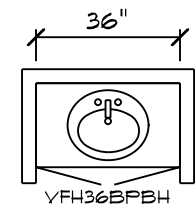


OWNER'S BATH

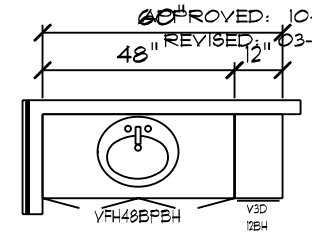


RIDGEWOOD CAROLINA / CUSTOM CABINET PLAN


NOTE: CABINET DRAWING DIMENSIONS ACCOUNT FOR 1/2" OF DRYWALL

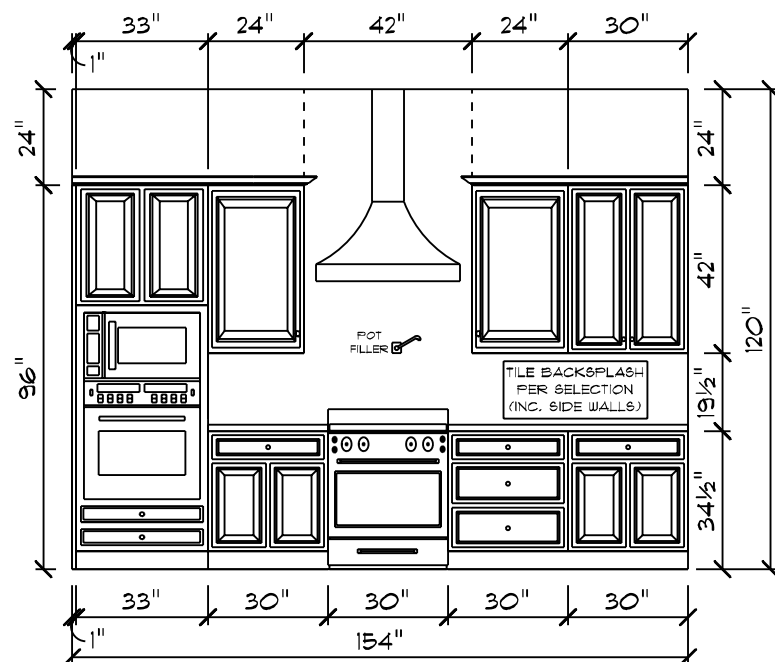


ELEVATION "A"

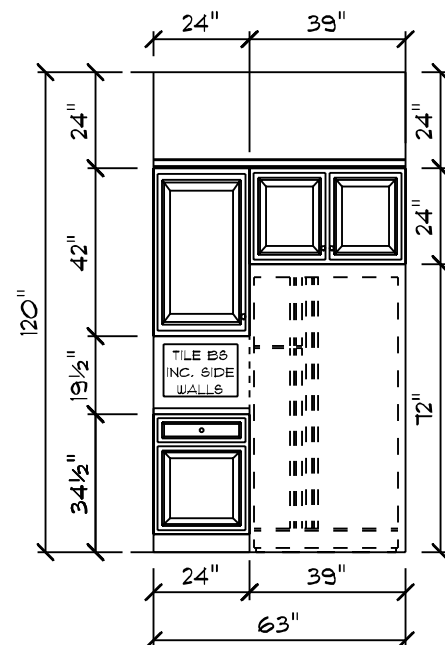

ELEVATION "B"

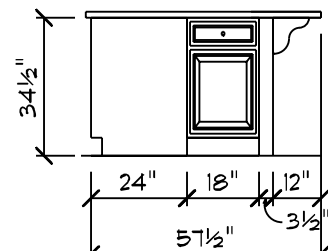


ELEVATION "C"

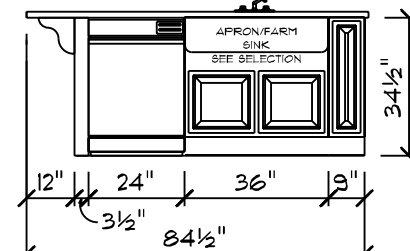


ELEVATION "D"

CABINET NOTES:
KITCHEN
 • MARSH CABINETS W/ TRADITIONAL OVERLAY
 • DELUXE CABINETS
 • 2-1/4" KITCHEN CABINET CROWN MOLDING
 • COUNTERTOPS PER SELECTION
 • 36" APRON STAINLESS STEEL KITCHEN SINK
 • HARDWARE PER SELECTION
BATHS
 • MARSH CABINETS W/ TRADITIONAL OVERLAY
 • DELUXE CABINETS
 • COUNTERTOPS PER SELECTION
 • HARDWARE PER SELECTION

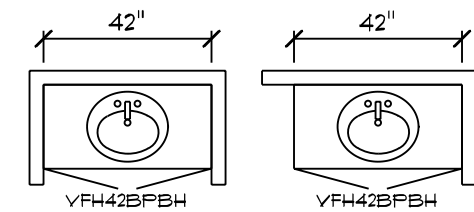

MAIN BATH

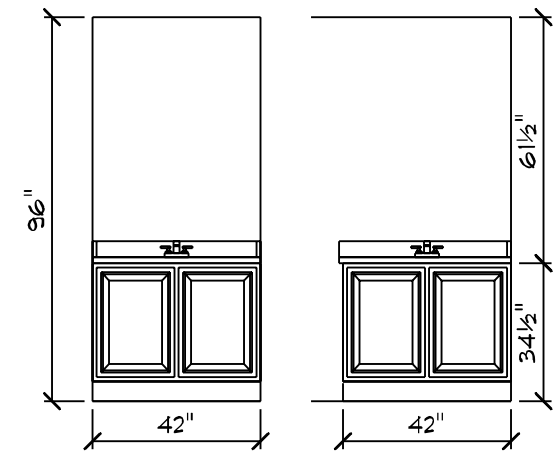

DATE: 3/20/2023
 SCALE: 1/4" = 1'-0"
 DRAIN BY: SG
 SQUARE FOOTAGES (4096)
 BASEMENT: 2574
 1ST FL: 2574
 2ND FL: 522
 OPEN SPACE: 394
 GARAGE: 414
 PORCH: 96
 TRAVIS & SPARKLE BAGS
 JOB #: DUTOO 022 OTT CN #: 34120 VN #: BA282
 LOCATION: 2184 WIRE RD BUNNLEVEL, NC 28323 COUNTY: HARNETT
 Raleigh/Durham, NC
 182 West Hamlin Road
 Benson, NC 27504
 (877) 261-3482
 www.schumacherhomes.com
 SCHUMACHER HOMES
 APPROVED: 10-26-2022
 REVISED: 03-20-2023
 © 1992-2023 SCHUMACHER HOMES OPERATIONS, INC. ALL RIGHTS RESERVED. THE INFORMATION AND DIMENSIONS ON THESE PLANS AND DRAWINGS ARE THE PROPERTY OF SCHUMACHER HOMES. THESE PLANS ARE NOT TO BE USED TO CREATE DERIVATIVE WORKS, TECHNICAL DRAWINGS OR TO BUILD A STRUCTURE, REPRODUCED, COPIED, OR MODIFIED, IN WHOLE OR PART, WITHOUT THE EXPRESS WRITTEN CONSENT OF SCHUMACHER HOMES. ANY UNAUTHORIZED USE OR COPYING IS A VIOLATION OF UNITED STATES COPYRIGHT LAW AND THAT RESULT IN DAMAGES IN EXCESS OF \$5000 PER ACT OF INFRINGEMENT.

APPROVED: 10-26-2022
REVISID: 03-20-2023

Silverline V1 Series Single Hung Windows																				
R.O	36 1/2	38 1/2	40 1/2	42 1/2	44 1/2	46 1/2	48 1/2	50 1/2	52 1/2	54 1/2	56 1/2	60 1/2	62 1/2	64 1/2	66 1/2	72 1/2	74 1/2	78 1/2	80 1/2	84 1/2
18 1/2	1630	1632			1638	16310	1640	1642	1644	1646	1648	1650	1652	1654	1656	1660	1662	1666		1670
20 1/2	1830	1832			1838	18310	1840	1842	1844	1846	1848	1850	1852	1854	1856	1860	1862	1866		1870
24 1/2	2030	2032	2034	2036	2038	20310	2040	2042	2044	2046	2048	2050	2052	2054	2056	2060	2062	2066		2070
28 1/2	2430	2432			2438	24310	2440	2442	2444	2446	2448	2450	2452	2454	2456	2460	2462	2466		2470
30 1/2	2630	2632	2634	2636	2638	26310	2640	2642	2644	2646	2648	2650	2652	2654	2656	2660	2662	2666		2670
32 1/2	2830	2832	2834	2836	2838	28310	2840	2842	2844	2846	2848	2850	2852	2854	2856	2860	2862	2866		2870
36 1/2	3030	3032	3034	3036	3038	30310	3040	3042	3044	3046	3048	3050	3052	3054	3056	3060	3062	3066	3068	3070
38 1/2	3230	3232			3238	32310	3240	3242	3244	3246	3248	3250	3252	3254	3256	3260	3262	3266		3270
40 1/2	3430	3432			3438	34310	3440	3442	3444	3446	3448	3450	3452	3454	3456	3460	3462	3466		3470
42 1/2	3630	3632			3638	36310	3640	3642	3644	3646		3650	3652	3654	3656	3660	3662			3670
44 1/2	3830	3832			3838	38310	3840	3842	3844	3846	3848	3850	3852	3854	3856	3860	3862	3866		3870
48 1/2	4030	4032			4038	40310	4040	4042	4044	4046	4048	4050	4052	4054	4056	4060	4062	4066		4070

BOLD TYPE MEETS EGRESS

UNDERLINED CALLOUTS MEET EGRESS WITH CLEAR OPENING HARDWARE

Silverline V3 Series Casement Windows						
R.O	18	21	24 5/8	28 7/8	34	36 7/16
24 5/8	C1-1520	C1-1820	C1-2020	C1-2420		
28 7/8	C1-1524	C1-1824	C1-2024	C1-2424	C1-2924	
36 7/16	C1-15211	C1-18211	C1-20211	C1-24211	C1-29211	C1-211211
41 5/16	C1-1534	C1-1834	C1-2034	C1-2434	C1-2934	C1-21134
48 1/2	C1-1540	C1-1840	C1-2040	C1-2440	C1-2940	C1-21140
53 5/16	C1-1544	C1-1844	C1-2044	C1-2444	C1-2944	C1-21144
60 3/8	C1-15411	C1-18411	C1-20411	C1-24411	C1-29411	C1-211411
65 5/16	C1-1554	C1-1854	C1-2054	C1-2454	C1-2954	C1-21154
72 3/8	C1-15511	C1-18511	C1-20511	C1-24511	C1-29511	C1-211511

Silverline V3 Series Awning Windows						
R.O	25 5/8	28 7/8	32	36 7/16	41 1/4	48 1/2
17 1/2	AW1-2015	AW1-2415	AW1-2715	AW1-21115	AW1-3415	AW1-4015
21	AW1-2018	AW1-2418	AW1-2718	AW1-21118	AW1-3418	AW1-4018
24 5/8	AW1-2020	AW1-2420	AW1-2720	AW1-21120	AW1-3420	AW1-4020
28 7/8	AW1-2024	AW1-2424	AW1-2724	AW1-21124	AW1-3424	AW1-4024
32		AW1-2427	AW1-2727	AW1-21127	AW1-3427	AW1-4027
36 4/9			AW1-27211	AW1-211211	AW1-34211	AW1-40211

Silverline Sliding Door	
6068	72-1/4"x80-1/2"

Masonite Patio Door Units	
Unit	Rough Opening
3068	38 1/2" x 82 1/2"
3080	38 1/2" x 98 1/2"
6068	75 5/8" x 82 1/2"
6080	75 5/8" x 98 1/2"
9068	112 5/8" x 82 1/2"
9080	112 5/8" x 98 1/2"

Exterior Door with Sidelites	
3'-0" w(1) 14" S.L.	54 5/8" X 82 1/2"
3'-0" w(2) 14" S.L.	69 5/8" X 82 1/2"

Andersen 200 Narroline Gliding Patio Door	
Unit	Rough Opening
NLGD6068	72" x 80"
NLGD12068-4	141 3/4" x 80"
NLGD6080	72" x 96"
NLGD12080-4	141 3/4" x 96"

Andersen 100 Patio Door	
Unit	Rough Opening
6068	72" x 80"
6080	72" x 96"

Silverline V3 Series Twin Casement Windows					
R.O	41 1/4	48 1/2	57	63 1/4	72 1/8
24 5/8	C2-3420	C2-4020	C2-4820		
28 7/8	C2-3424	C2-4024	C2-4824		
36 7/16	C2-34211	C2-40211	C2-48211	C2-52211	C2-511211
41 5/16	C2-3434	C2-4034	C2-4834	C2-5234	C2-51134
48 1/2	C2-3440	C2-4040	C2-4840	C2-5240	C2-51140
53 5/16	C2-3444	C2-4044	C2-4844	C2-5244	C2-51144
60 3/8	C2-34411	C2-40411	C2-48411	C2-52411	C2-511411
65 5/16	C2-3454	C2-4054	C2-4854		
72 3/8	C2-34511	C2-40511	C2-48511		

Silverline V3 Series Twin Awning Windows			
R.O	57	63 1/4	72 1/8
17 1/2	AW2-4815	AW2-5215	AW2-51115
21	AW2-4818	AW2-5218	AW2-51118
24 5/8	AW2-4820	AW2-5220	AW2-51120
28 7/8	AW2-4824	AW2-5224	AW2-51124
32		AW2-5227	AW2-51127
36 7/16			AW2-511211

Fireplace Framing	
36" WOOD BURNING EL36 W: 42" H: 40-1/4" D: 21-1/2"	
42" WOOD BURNING EL42 W: 48" H: 40-1/4" D: 21-1/2"	
36" DIRECT VENT NDV4236i W: 42" H: 35-1/4" D: 24"	
42" DIRECT VENT NDV4842i W: 49" H: 35-1/4" D: 24"	
36" MODERN GAS DV NEVO4236i W: 42" H: 40-1/4" D: 20-1/4"	
42" RAVE DIRECT VENT RAVE42-IFT-B W: 50" H: 33-1/4" D: 18-1/4"	
60" CRAVE DIRECT VENT CRAVE7260-B W: 72-1/4" H: 48-1/2" D: 18-3/4"	

HOLD FIREPLACE UP 2" TO ALLOW FOR STONE HEARTH IF APP.
A PLYWOOD FLOOR IS REQUIRED ON ALL WOODBURNERS AT LEAST 6' HIGH TO BE INSTALLED BY FRAMERS
2X6 WRAP AT TOP OF CHASE

Silverline V3 Triple Csmnt Windows			
R.O	61 1/2	72 3/8	85 1/8
24 5/8	C3-5120	C3-51120	C3-7020
28 7/8	C3-5124	C3-51124	C3-7024
36 7/16	C3-51211	C3-511211	C3-70211
41 5/16	C3-5134	C3-51134	C3-7034
48 1/2	C3-5140	C3-51140	C3-7040
53 5/16	C3-5144	C3-51144	C3-7044
60 3/8	C3-51411	C3-511411	C3-70411

Silverline Oval Windows		
Rough Opening		
	Width	Height
OVL-2030	24 1/2	36 1/2
OVL-2434	28 1/2	40 1/2
OVL-2838	32 1/2	44 1/2
OVL-3040	36 1/2	48 1/2
OVL-3050	36 1/2	60 1/2

Window Notes	Additional Important Information
1. TO CALCULATE THE R.O. FOR A WINDOW WITH A TRANSOM, ADD BOTH UNIT DIMENSIONS TOGETHER AND ADD 1/2". 2. TO CALCULATE THE R.O. FOR MULTIPLE UNITS, ADD BOTH ACTUAL UNIT DIM TOGETHER AND ADD 1/2" PER MULL 3. FOR R.O.'S NOT LISTED, ADD 1/2" TO THE ACTUAL UNIT DIM FOR BOTH THE WIDTH AND HEIGHT	1. THERE IS NO ALLOWANCE IN ANY OF THE HEIGHT DIMENSIONS FOR CARPET SHIM. (PLEASE ADD ACCORDINGLY) 2. BRICK OPENINGS ARE 2-1/2" WIDER AND 1-1/4" HIGHER THAN ACTUAL UNIT SIZE. 3. FOR 7' DOORS ADD 4" TO THE ACTUAL UNIT SIZE AND ROUGH OPENING HEIGHT DIMENSIONS. 4. DO NOT STORE PRE-HUNG UNITS OUTSIDE.

Lintel Schedule				1/2" or Equiv
Size of Steel Angle	No story Above	One story above	Two Stories Above	Reinforcing Bars
3 x 3 x 1/4	6'-0"	4'-6"	3'-0"	1
4 x 3 x 1/4	8'-0"	6'-0"	4'-6"	1
5 x 3-1/2 x 5/16	10'-0"	8'-0"	6'-0"	2
6 x 3-1/2 x 5/16	14'-0"	9'-6"	7'-0"	2
(2) 6 x 3-1/2 x 5/16	20'-0"	12'-0"	9'-6"	4

Miscellaneous Framing
FRAME SOFFITS THE SAME HEIGHT AS DRYWALL OPENINGS. LEAVE 14-1/2" BETWEEN EACH END JOIST & RIM JOIST TO ALLOW FOR INSULATION. INSULATE ALL FRAMED CHANNELS & CORNERS AND BEHIND SHOWER & TUB UNITS. INSTALL FIREBLOCK FRAMING IN ALL STAIRWAY CEILINGS.

16
SCALE: 1/8" = 1'-0"

DATE: 3/20/2023
DRAWN BY: SG

© 1994-2023 SCHUMACHER HOMES OPERATIONS, INC. ALL RIGHTS RESERVED. THE INFORMATION CONTAINED HEREIN IS THE PROPERTY OF SCHUMACHER HOMES OPERATIONS, INC. AND IS TO BE USED ONLY FOR THE PROJECT AND SITE SPECIFICALLY IDENTIFIED IN THESE PLANS. IT IS NOT TO BE USED TO CREATE DERIVATIVE WORKS, TECHNICAL DRAWINGS OR TO BUILD A STRUCTURE, REPRODUCED, COPIED, OR MODIFIED, IN WHOLE OR PART, WITHOUT THE EXPRESS WRITTEN CONSENT OF SCHUMACHER HOMES, AND SUCH UNAUTHORIZED USE OR COPYING IS A VIOLATION OF UNITED STATES COPYRIGHT LAW AND THAT RESULT IN DAMAGES IN EXCESS OF \$50000 PER ACT OF INFRINGEMENT.

SQUARE FOOTAGES (SQFB):
BASEMENT: 2574
1ST FL: 2574
2ND FL: 2574
OPEN SPACE: 394
GARAGE: 414
PORCH: 316

CUSTOM BUILT FOR: TRAVIS & SPARKLE BLAGS
JOB #: DUTCO 022 OMT CN #: 34100 VN #: BA282

LOCATION: 2184 WIRE RD
BUNNLEVEL, NC 28323
COUNTY: HARNETT

Raleigh/Durham, NC
182 West Hamlin Road
Benson, NC 27504
(811) 261-3482
www.schumacherhomes.com

SCHUMACHER HOMES