


ELECTRICAL LEGEND		
ELECTRICAL	COUNT	SYMBOL
ceiling fan spotlights OI	6	
pacu luster	1	
can light 6inch	2	
ceiling classic	1	
ceiling dish round	12	
fluorescent light 2 x 4	2	
pendant cone	4	
exterior craftsmen light fixture	4	
fan	3	
outlet	50	
outlet 220v	3	
outlet gfi	10	
switch	53	
italian sconce OI	2	
vanity bar light OI	1	
wall mounted O3 3 lights	3	

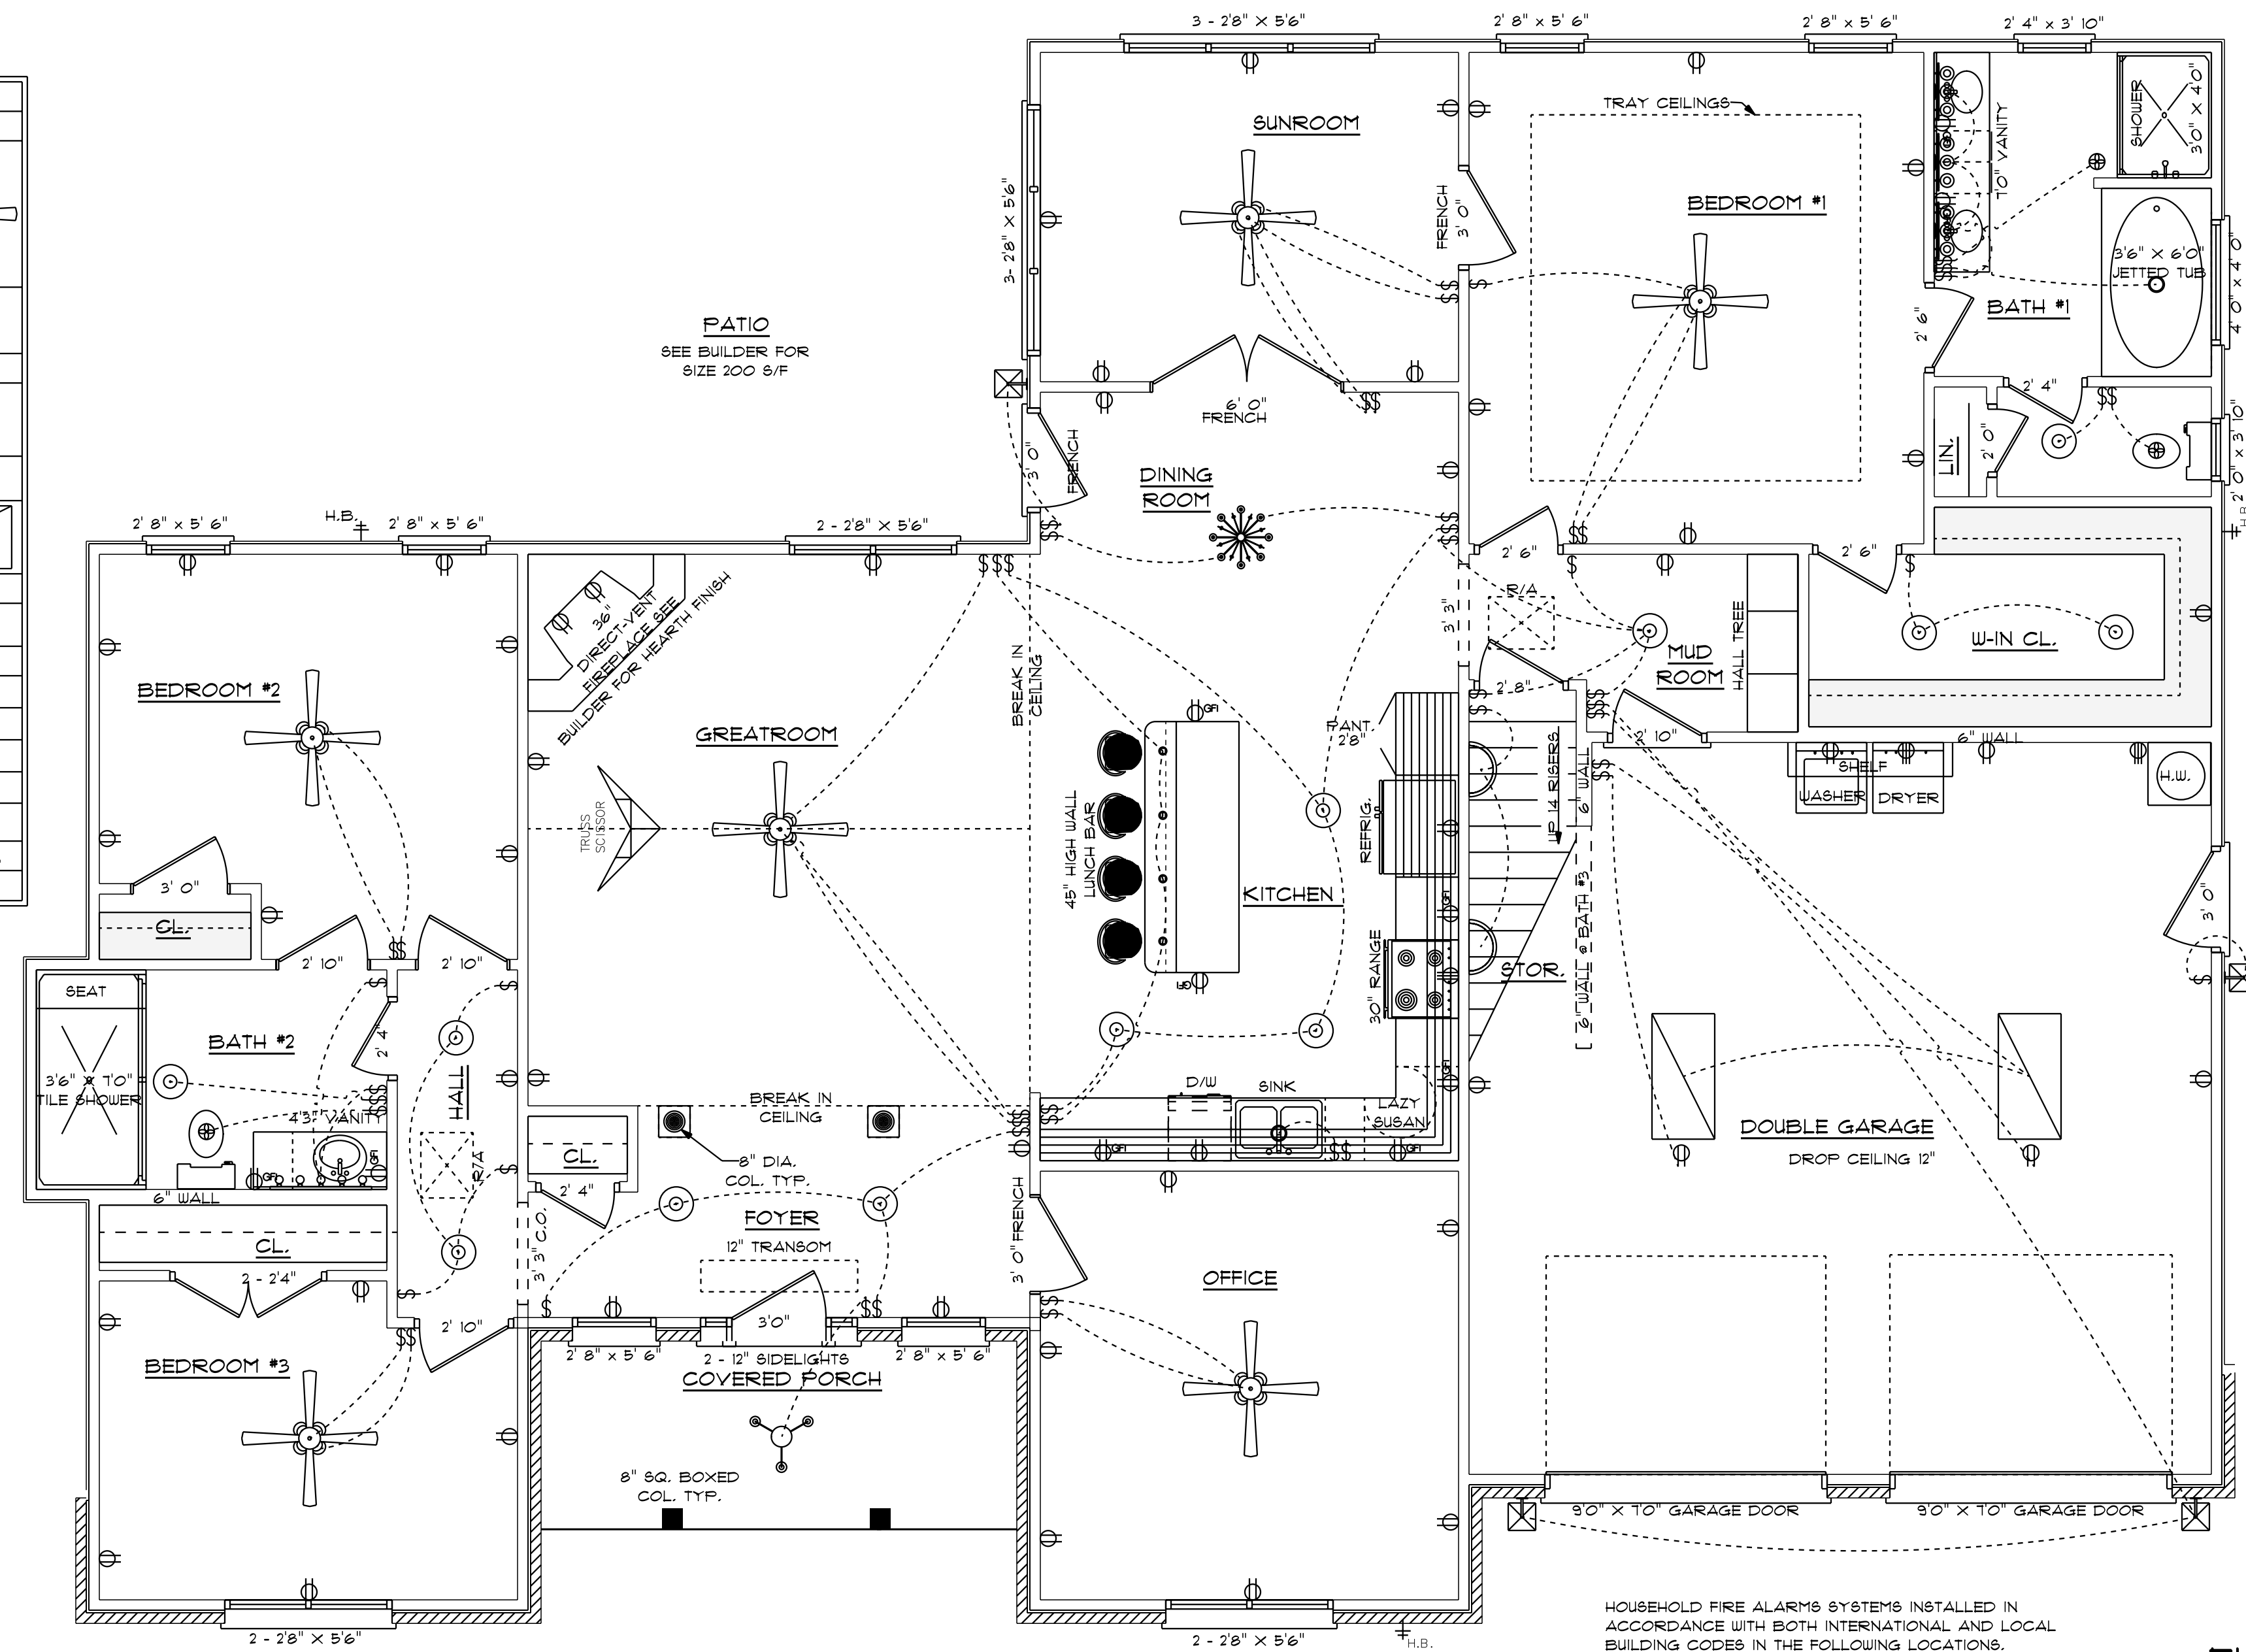

9'0" FINISHED CEILING HEIGHT
T4" WINDOW HEADER HEIGHT

ELECTRICAL CONTRACTOR TO CONFIRM LOCATION
OF OUTLET AND FIXTURES. SEE HOME OWNER FOR
TYPE AND STYLE OF ELECTRICAL FIXTURES

HOUSEHOLD FIRE ALARMS SYSTEMS INSTALLED IN
ACCORDANCE WITH BOTH INTERNATIONAL AND LOCAL
BUILDING CODES IN THE FOLLOWING LOCATIONS:

1. IN EACH SLEEPING ROOM
2. OUTSIDE EACH SEPARATE SLEEPING AREAS IN THE IMMEDIATE VICINITY OF BEDROOMS AND WIRED TOGETHER IN SUCH A MANNER THAT WHEN ONE IS ACTIVATED ALL SHALL ACTIVATE

ELECTRICAL PLAN
FIRST FLOOR

SCALE: 1/4" = 1'0"

SCALE: AS NOTED

DATE: JUNE 2021

DRAWN BY: CSP

BUILDING CONTRACTOR TO MEET LOCAL
AND LOCAL PERMITS CODES AS IT PERTAINS
TO CONSTRUCTION OF HOME
100, 101, 102, 103, 104, 105, 106

**RESIDENCE OF MS.
STACEY WALKER**

RESIDENTIAL DESIGNER
CHARLES SMITH ASSOC.
RESIDENTIAL DESIGNER - FAYETTEVILLE, NORTH CAROLINA

I DO HEREBY CERTIFY THAT THIS DRAWING OR PLAN AND RELATED SPECIFICATIONS
MEET ALL LOCAL REQUIREMENTS AND ARE IN SUBSTANTIAL CONFORMITY WITH
THE INTERNATIONAL BUILDING CODE COUNCIL (2018) N.C. BUILDING CODE.

DRAWING NUMBER
W-2477