


OPENING SCHEDULE				
PRODUCT CODE	SIZE	HINGE	REVERSED	COUNT
Door-MODIFIED	2' 0"	R	NO	1
Door-MODIFIED	2' 10"	L	NO	1
Door-MODIFIED	2' 10"	R	NO	1
Door-MODIFIED	2' 4"	R	NO	3
Door-MODIFIED	2' 6"	L	NO	1
Door-MODIFIED	2' 6"	R	NO	2
Door-MODIFIED	2' 8"	R	NO	1
Door-MODIFIED	3' 0"	L	NO	1
Door-MODIFIED	3' 0"	R	NO	1
Double Door-MODIFIED	4' 8"	LR	NO	1
36X80 FRENCH A 1-MODIFIED	3' 0"	L	NO	2
112X80 FRENCH A 2-MODIFIED	6' 0"	LR	NO	1
108X84 - 1 PANEL-MODIFIED	9'0" X 10" GARAGE DOOR	U	NO	2
28X80 COLONIAL C 1-MODIFIED	2' 10"	L	NO	1
34X80 COLONIAL A 1	2' 10"	R	NO	1
36X80 COLONIAL A 1	3' 0"	L	NO	1
36X80 FRENCH A 1	3' 0"	L	NO	1
Casement-MODIFIED	1' 0" x 6' 8"	N	NA	2
Casement-MODIFIED	2 - 2'8" x 5'6"	NN	NA	1
Casement-MODIFIED	2' 0" x 3' 10"	N	NA	1
Casement-MODIFIED	2' 4" x 3' 10"	N	NA	1
Casement-MODIFIED	2' 8" x 5' 6"	N	NA	6
Casement-MODIFIED	3 - 2'8" x 5'6"	NNN	NA	1
Casement-MODIFIED	4' 0" x 4' 0"	N	NA	1
Casement-MODIFIED	5' 4" x 5' 6"	NN	NA	2
18X24 DOUBLE HUNG 1-MODIFIED	3- 2'8" x 5'6"	UNN	NA	1

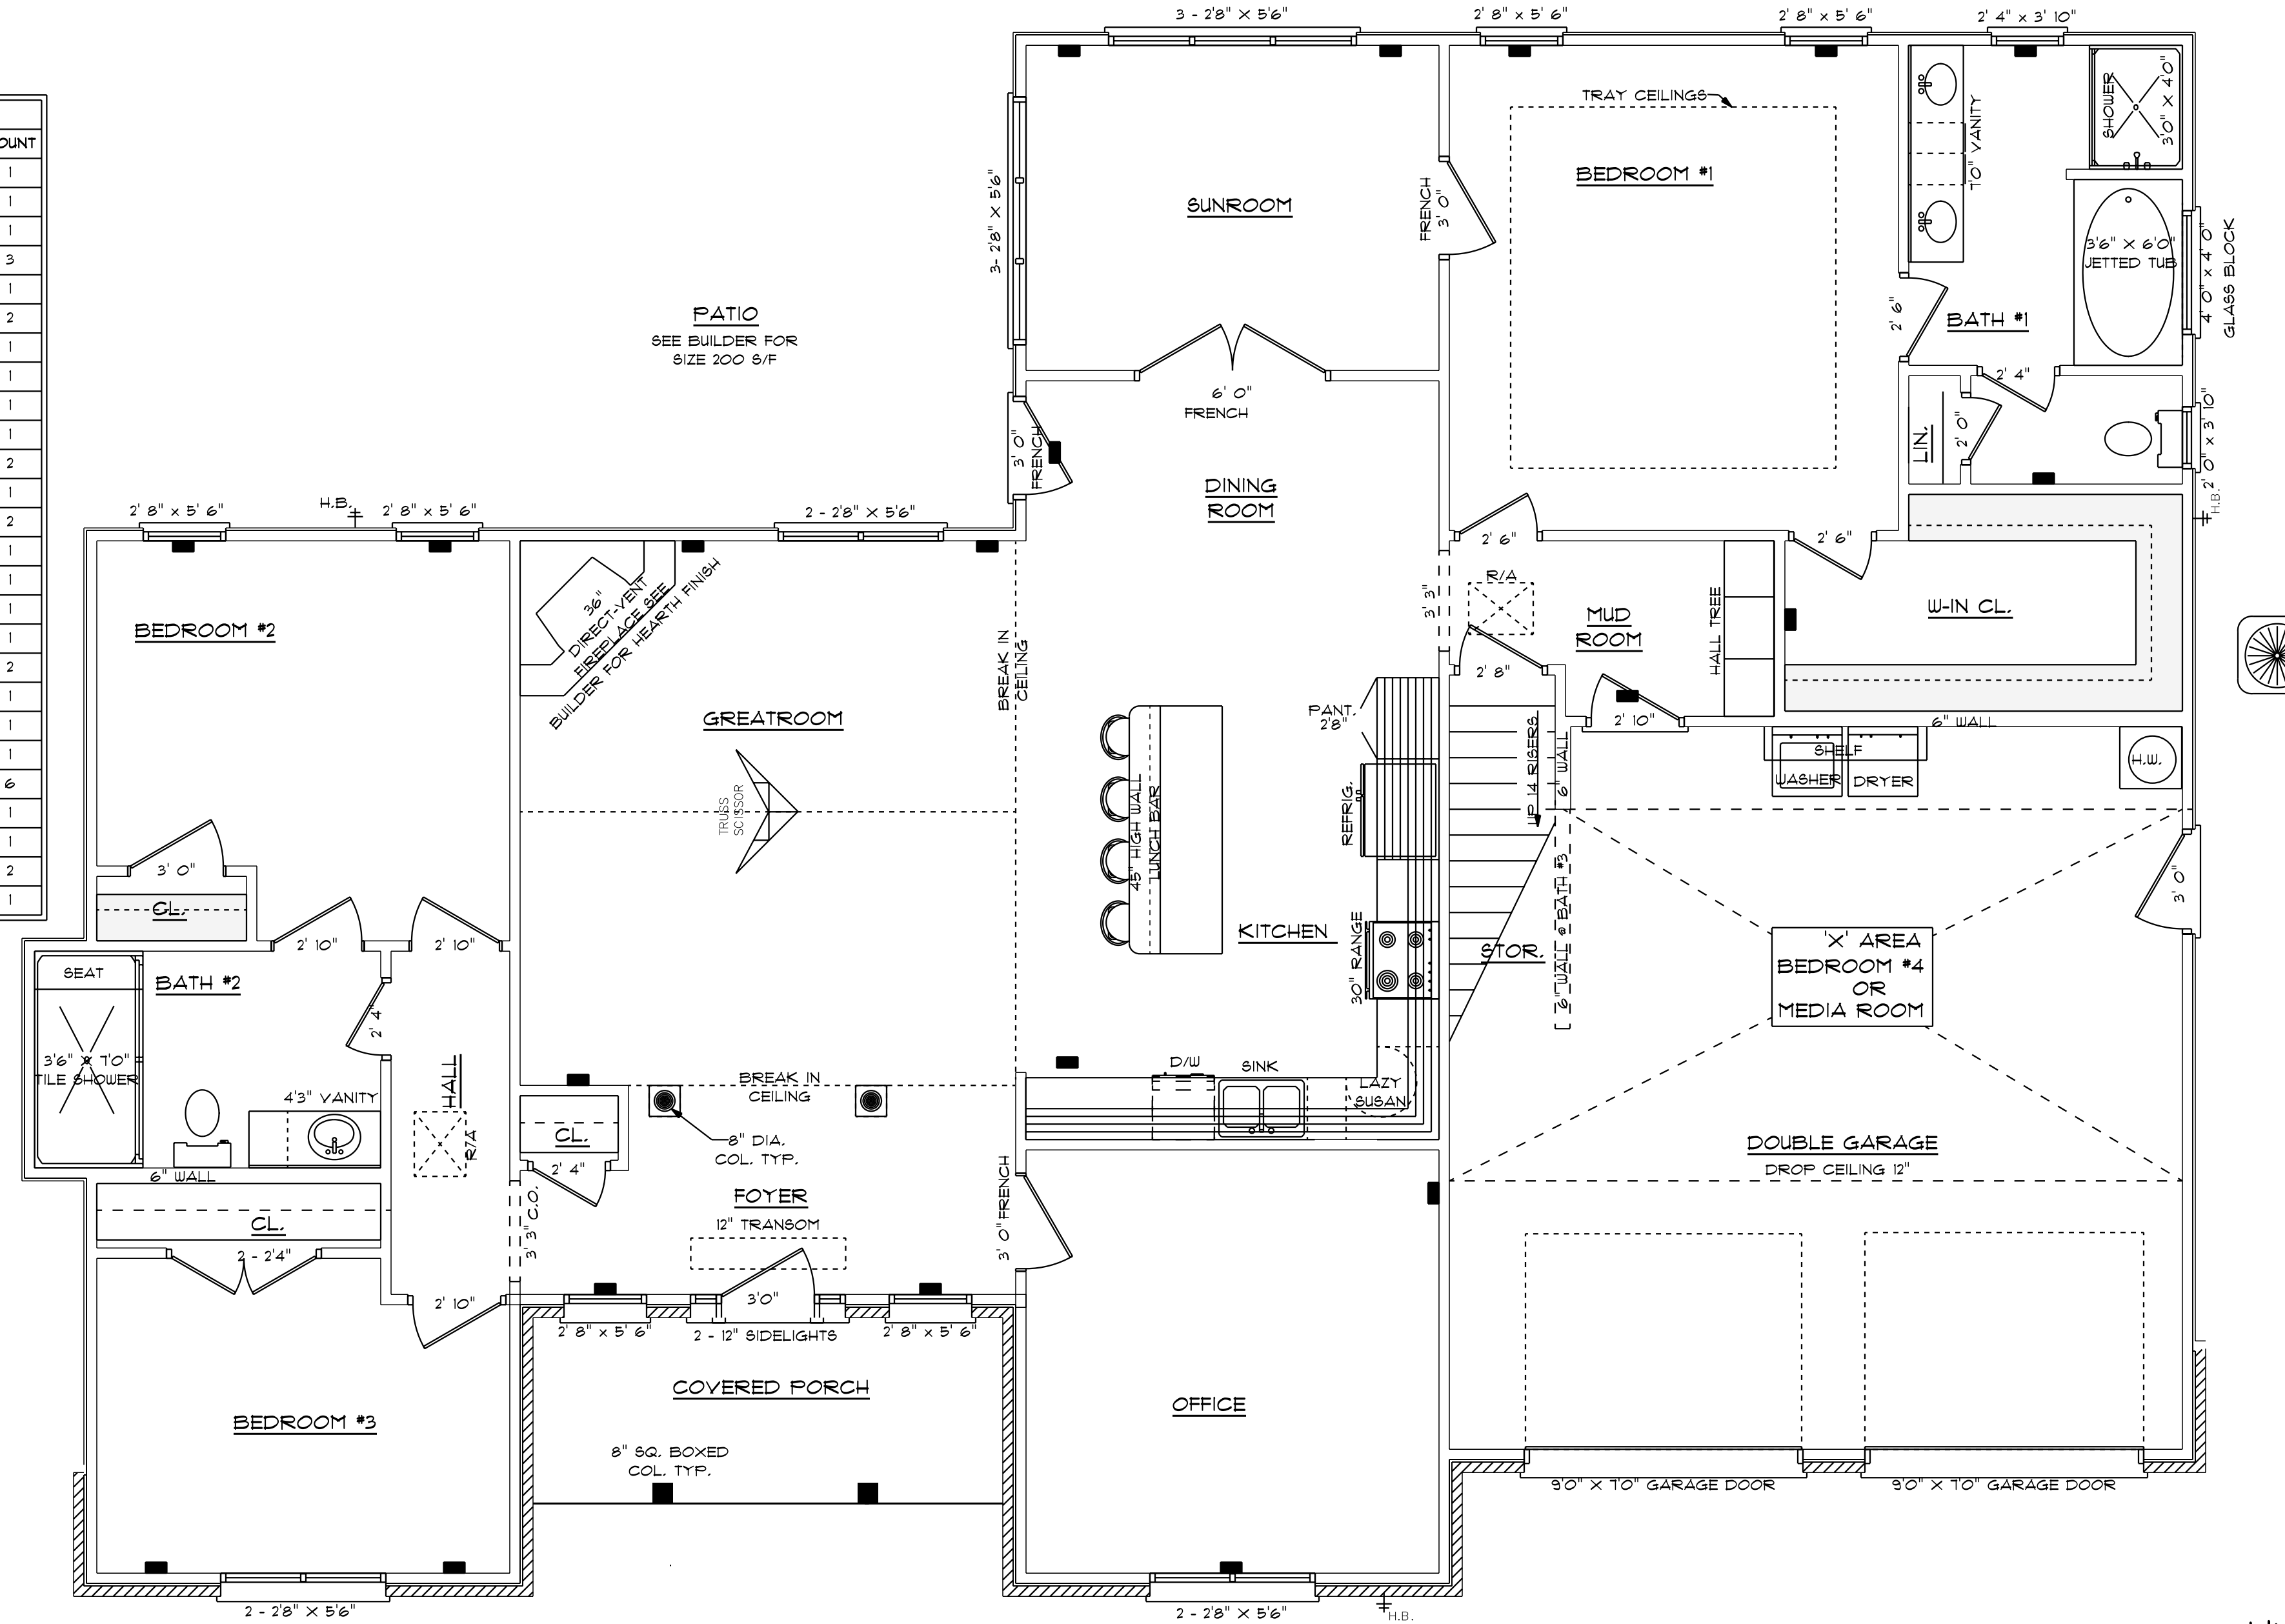

**HVAC PLAN  
FIRST FLOOR**

SCALE: 1/4" = 1'0"

HVAC CONTRACTOR TO CONFIRM  
VENT LOCATION AND SIZE OF UNIT

9'0" FINISHED CEILING HEIGHT  
1'4" WINDOW HEADER HEIGHT

2151 S.F. HEATED AREA (DOES NOT INCLUDE STAIRS)  
326 S.F. OPT. BEDROOM #4 OR MEDIA ROOM  
(INCLUDES STAIRS)  
2411 S.F. TOTAL

514 S.F. DOUBLE GARAGE  
(INCLUDES STORAGE UNDER STAIRS)  
80 S.F. COVERED PORCH

SCALE: AS NOTED

DATE: JUNE 2021

DRAWN BY: CSP

BUILDING CONTRACTOR TO MEET LOCAL  
LOADS PER CODE AS IT RELATES  
TO CONSTRUCTION OF HOUSE  
100, 150, 200, 300, 400, 500 PSF

**RESIDENCE OF MS.  
STACEY WALKER**

RESIDENTIAL DESIGNER  
**CHARLES SMITH ASSOC.**  
RESIDENTIAL DESIGNER - FAYETTEVILLE, NORTH CAROLINA

I DO HEREBY CERTIFY THAT THIS DRAWING OR PLAN AND RELATED SPECIFICATIONS  
MEET ALL LOCAL REQUIREMENTS AND ARE IN SUBSTANTIAL CONFORMITY WITH  
THE INTERNATIONAL BUILDING CODE COUNCIL (2018) N.C. BUILDING CODE.

DRAWING NUMBER  
**U-2477**