


The Information in These Construction Documents is for the Exclusive Use of the Client in Connection with the Building Project and is not to be used for any other purpose. The Client shall be responsible for obtaining all necessary permits and approvals. The Designer shall not be responsible for any delays or problems caused by the Client's failure to obtain the necessary permits and approvals. The Client shall be responsible for any delays or problems caused by the Client's failure to provide the necessary information. The Client shall be responsible for any delays or problems caused by the Client's failure to pay for the services. The Client shall be responsible for any delays or problems caused by the Client's failure to provide the necessary information. The Client shall be responsible for any delays or problems caused by the Client's failure to pay for the services. The Client shall be responsible for any delays or problems caused by the Client's failure to provide the necessary information. The Client shall be responsible for any delays or problems caused by the Client's failure to pay for the services.

APPROVED BY	DATE

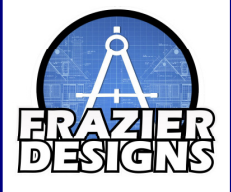

MEMBER  
**A I**  
**B D**  
AMERICAN INSTITUTE of  
BUILDING DESIGN


**Frazier Designs**  
A Residential Design Company  
(910) 818-2413  
www.frazierplans.com

Project:   
MODEL:   
FD-2281   
BUILDER:

DATE PRINTED:   
Nov2021   
DRAWN BY:   
ATF

Bonus Room   
Layout

SHEET   
6

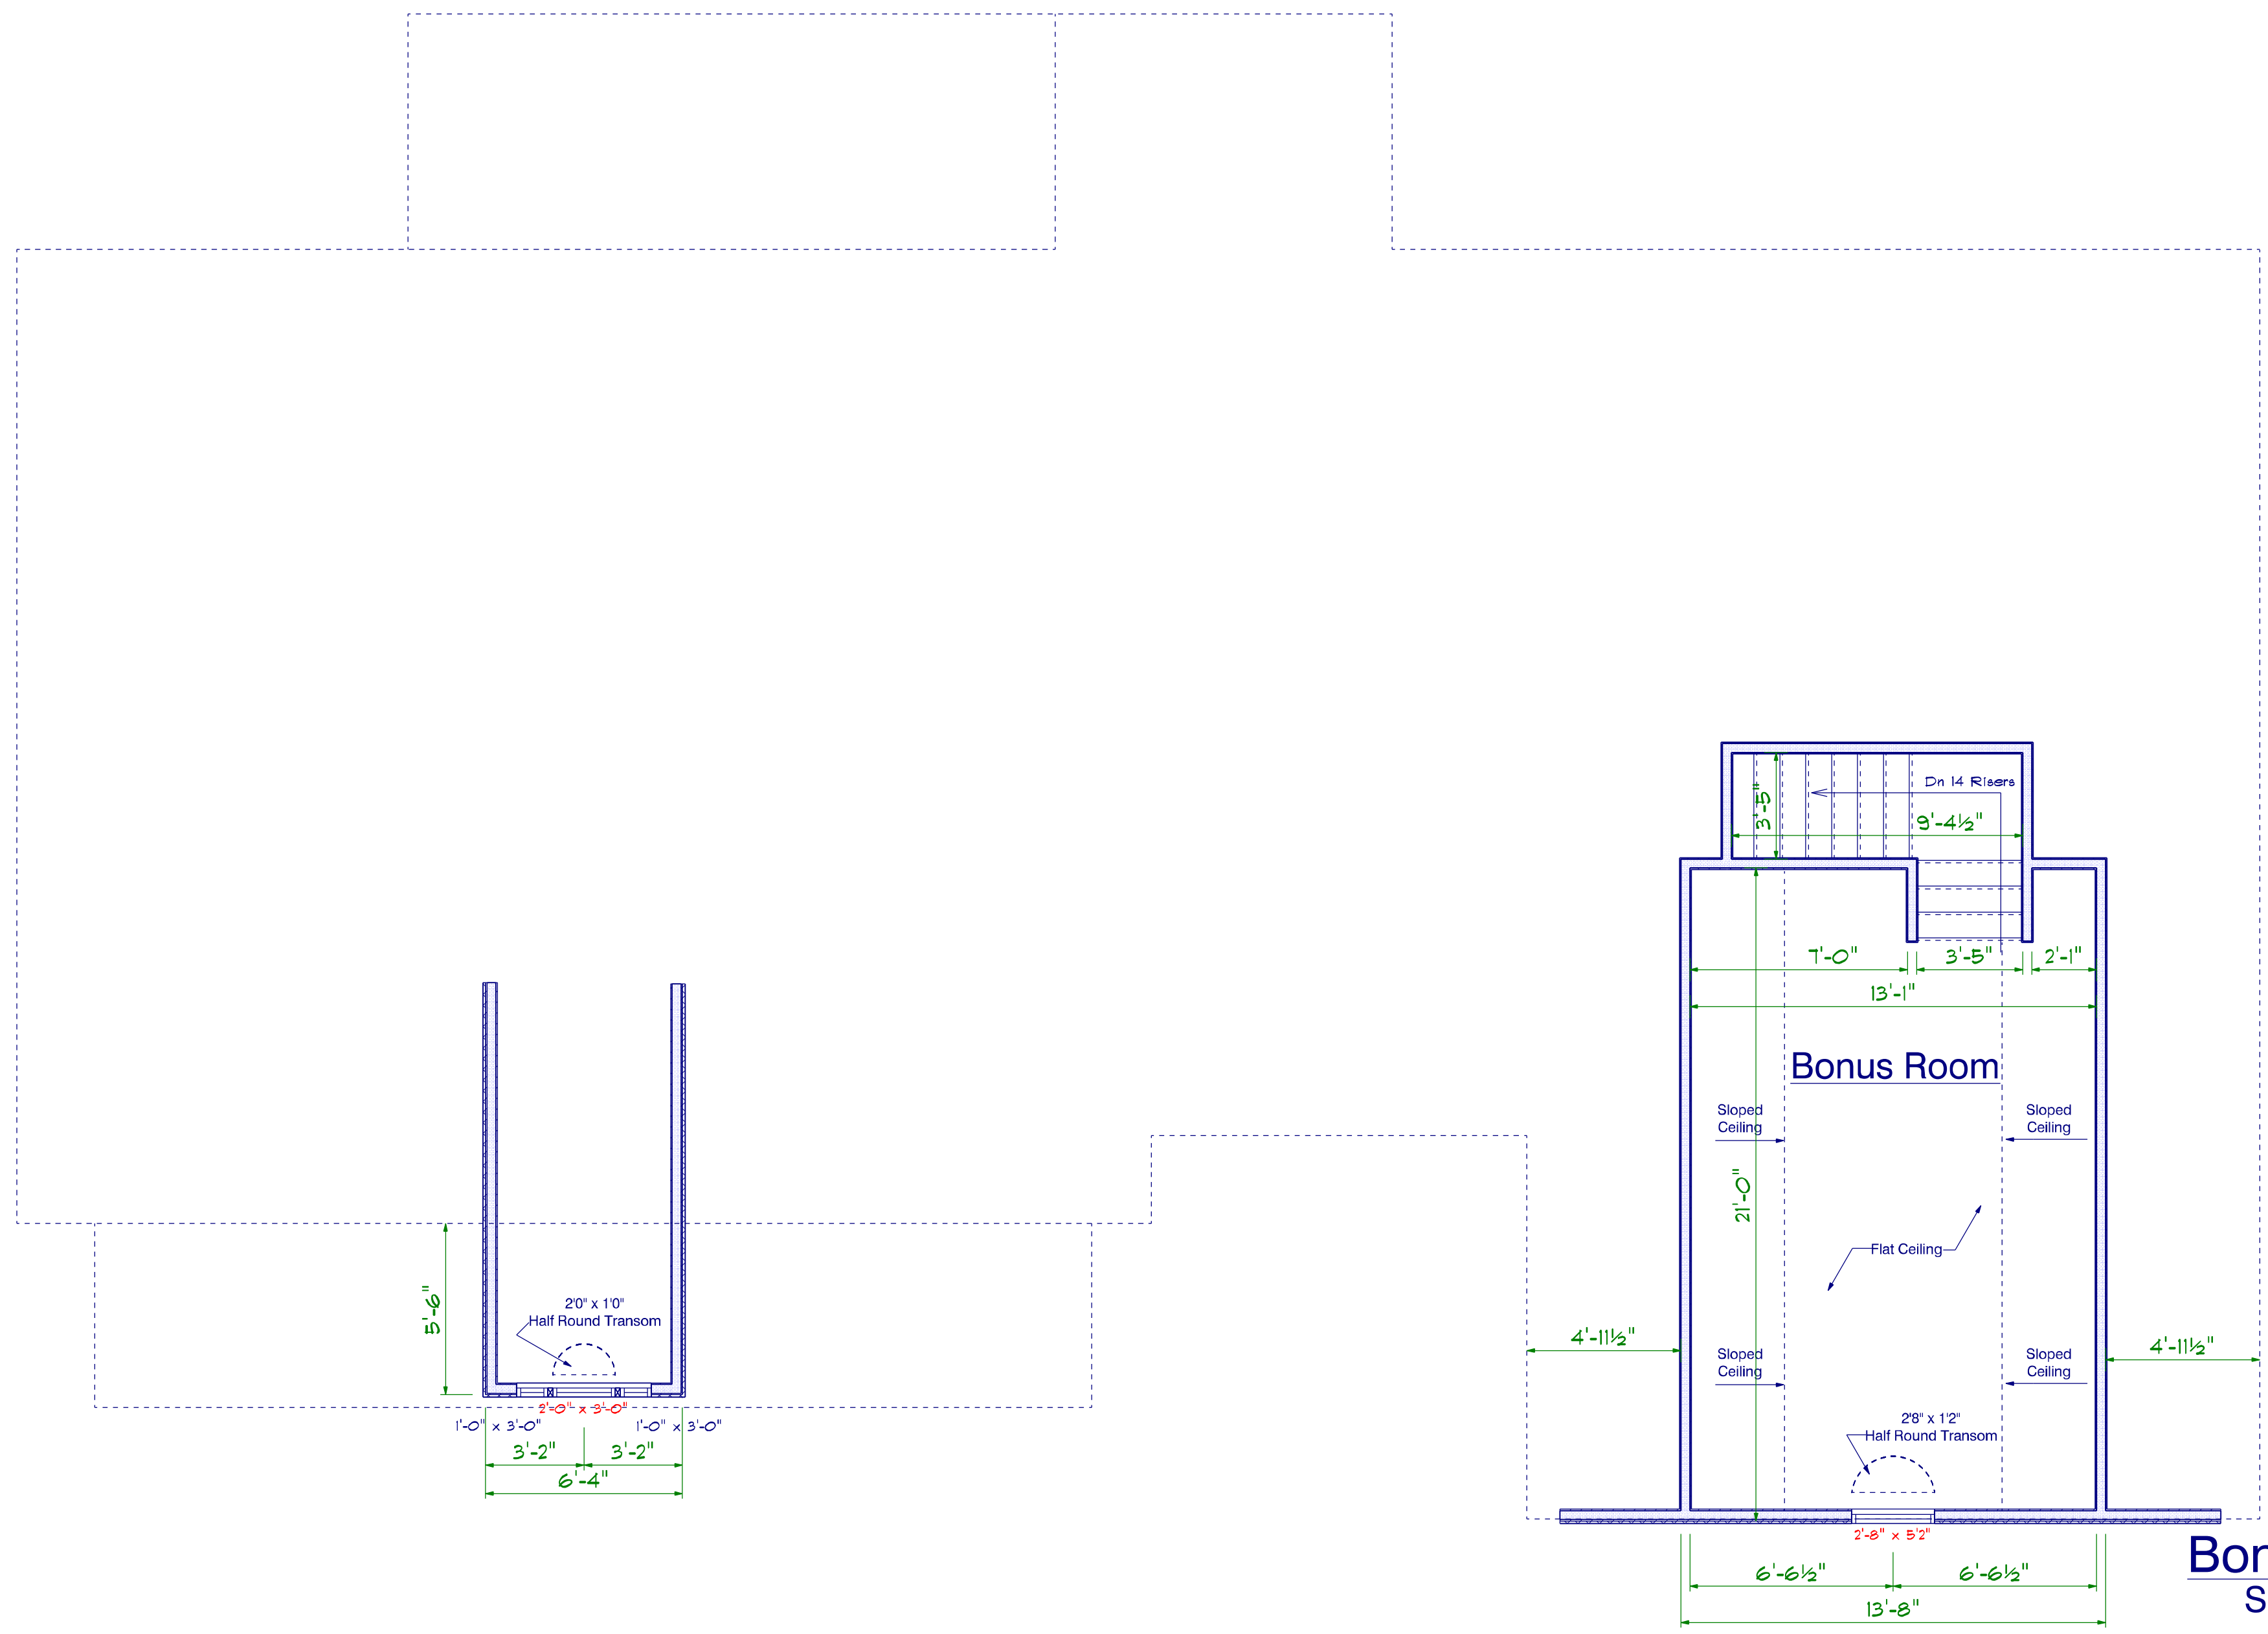

**Bonus Room Plan**  
Scale: 1/4" = 1'0"  
290 S.F. Bonus Room  
(Finished)  
Electrical and HVAC Layout  
Provided by Builder