



ELECTRICAL LEGEND		
ELECTRICAL	COUNT	SYMBOL
ceiling fan spotlights 01	3	
ceiling dish round	5	
fan	1	
outlet	21	
switch	15	
italian sconce 01	2	
wall mounted 03 3 lights	1	

OPENING SCHEDULE				
PRODUCT CODE	SIZE	HINGE	REVERSED	COUNT
28X80 COLONIAL A 1	2'-4"	L	NO	1
28X80 COLONIAL A 1	2'-4"	L	YES	1
28X80 COLONIAL A 1	2'-4"	R	YES	2
28X80 COLONIAL C 1	2'-4"	L	NO	1
28X80 COLONIAL C 1	2'-4"	R	NO	1
28X80 COLONIAL C 1	2'-4"	R	YES	1
30X80 COLONIAL A 1	2'-6"	R	YES	1
32X80 COLONIAL A 1	2'-8"	R	NO	1
48X80 COLONIAL A 2	4'-0"	LR	YES	1
18X24 DOUBLE HUNG 1-MODIFIED	2 - 2'-8" X 4'-6"	UN	NA	1
36X42 DOUBLE HUNG 1-MODIFIED	2'-4" X 3'-6"	U	NA	1
36X72 DOUBLE HUNG 1-MODIFIED	2'-8" X 5'-0"	U	NA	1
36X72 DOUBLE HUNG 1-MODIFIED	5'-4" X 5'-0"	UN	NA	2

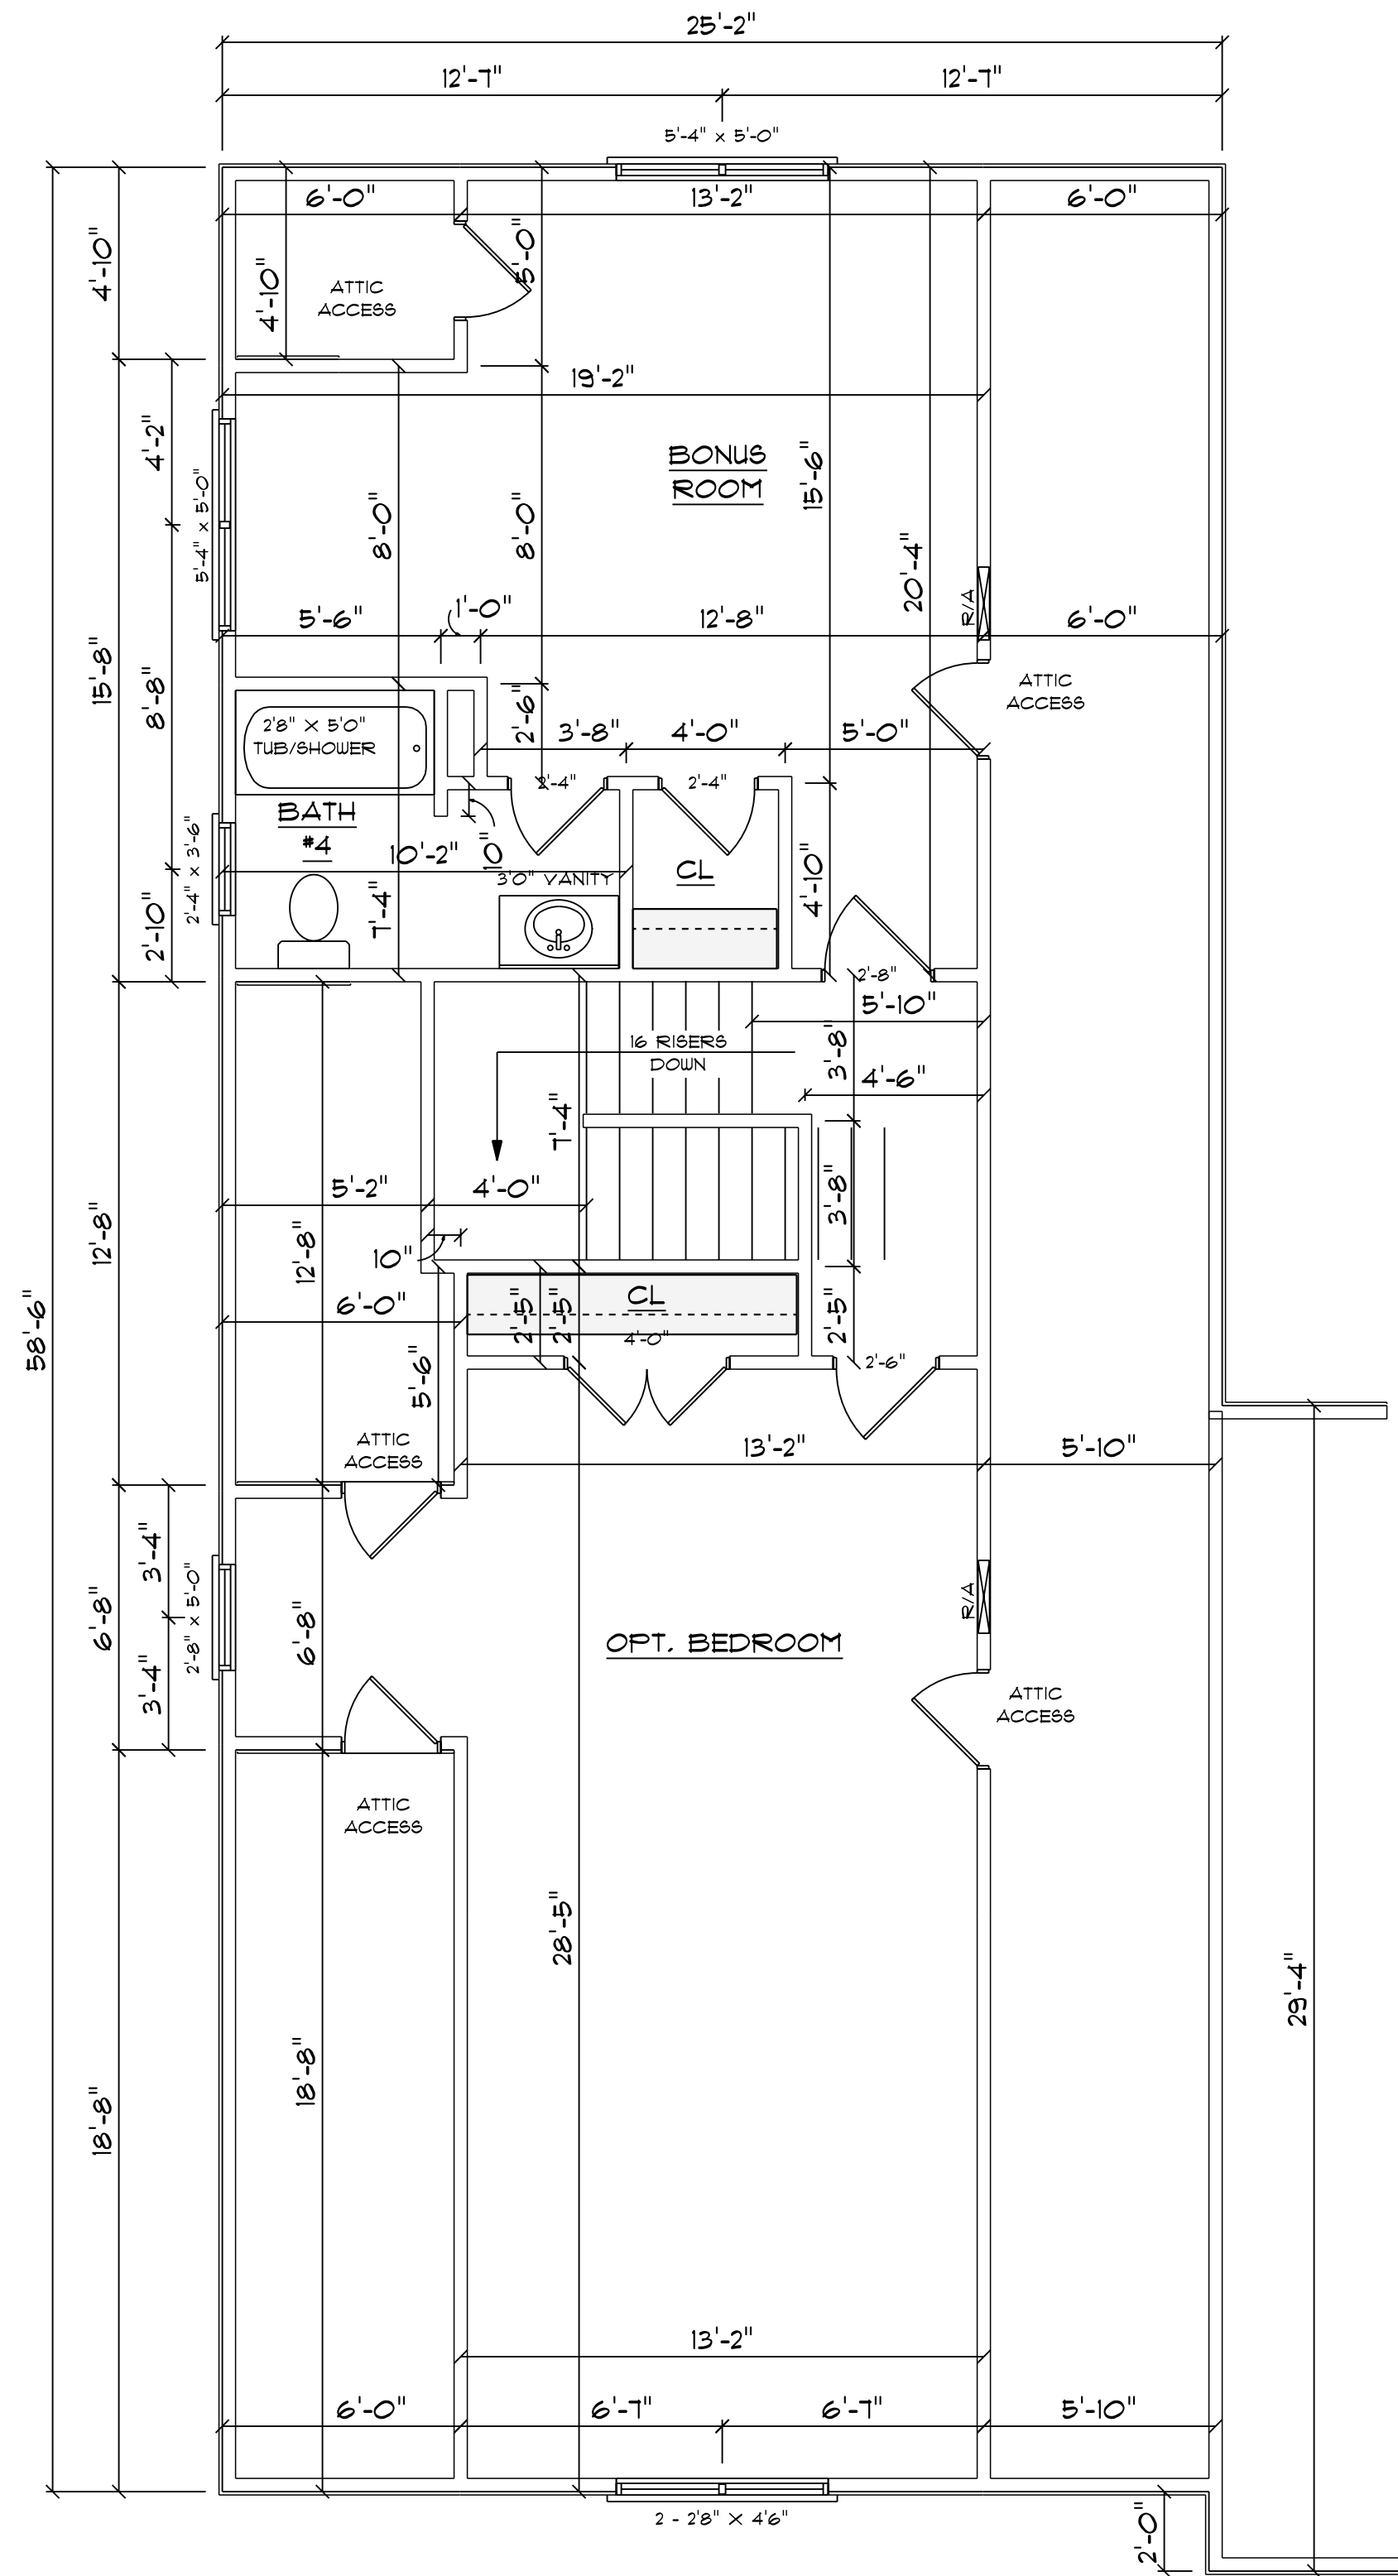


BONUS ROOM/OPT. BEDROOM
SCALE: 1/4" = 1'0"
861 S/F IN BONUS ROOM/OPT. BEDROOM

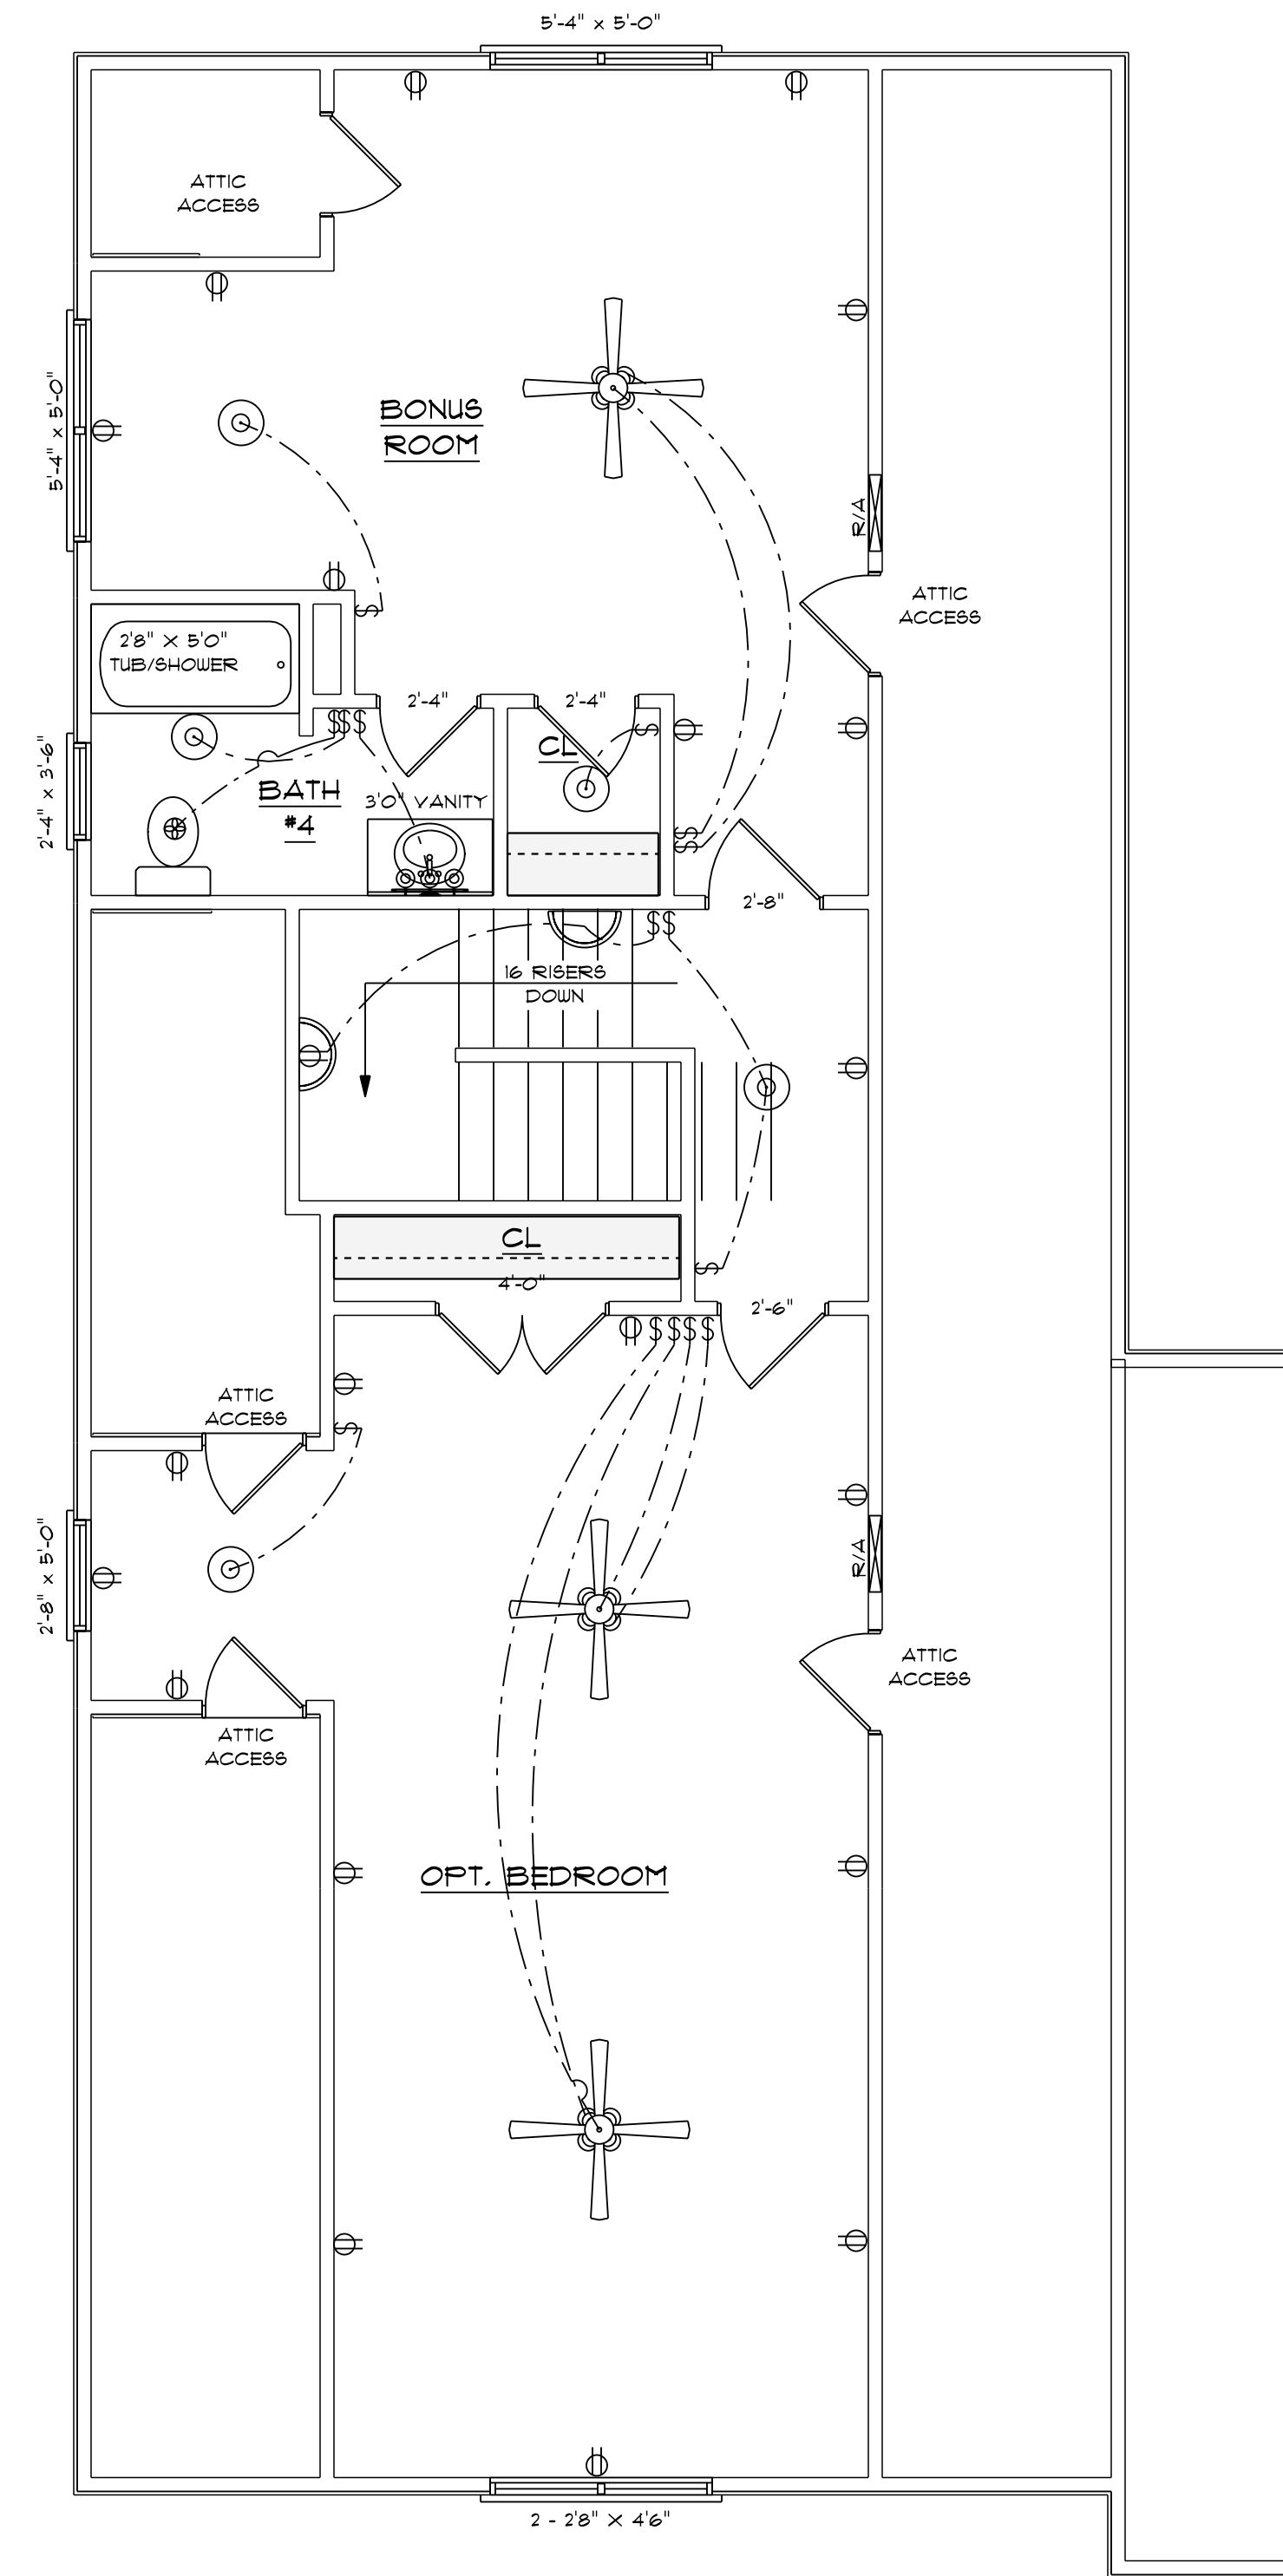

BONUS ROOM/OPT. BEDROOM
SCALE: 1/4" = 1'0"

ELECTRICAL CONTRACTOR TO CONFIRM LOCATION OF OUTLET AND FIXTURES, SEE HOME OWNER FOR TYPE AND STYLE OF ELECTRICAL FIXTURES

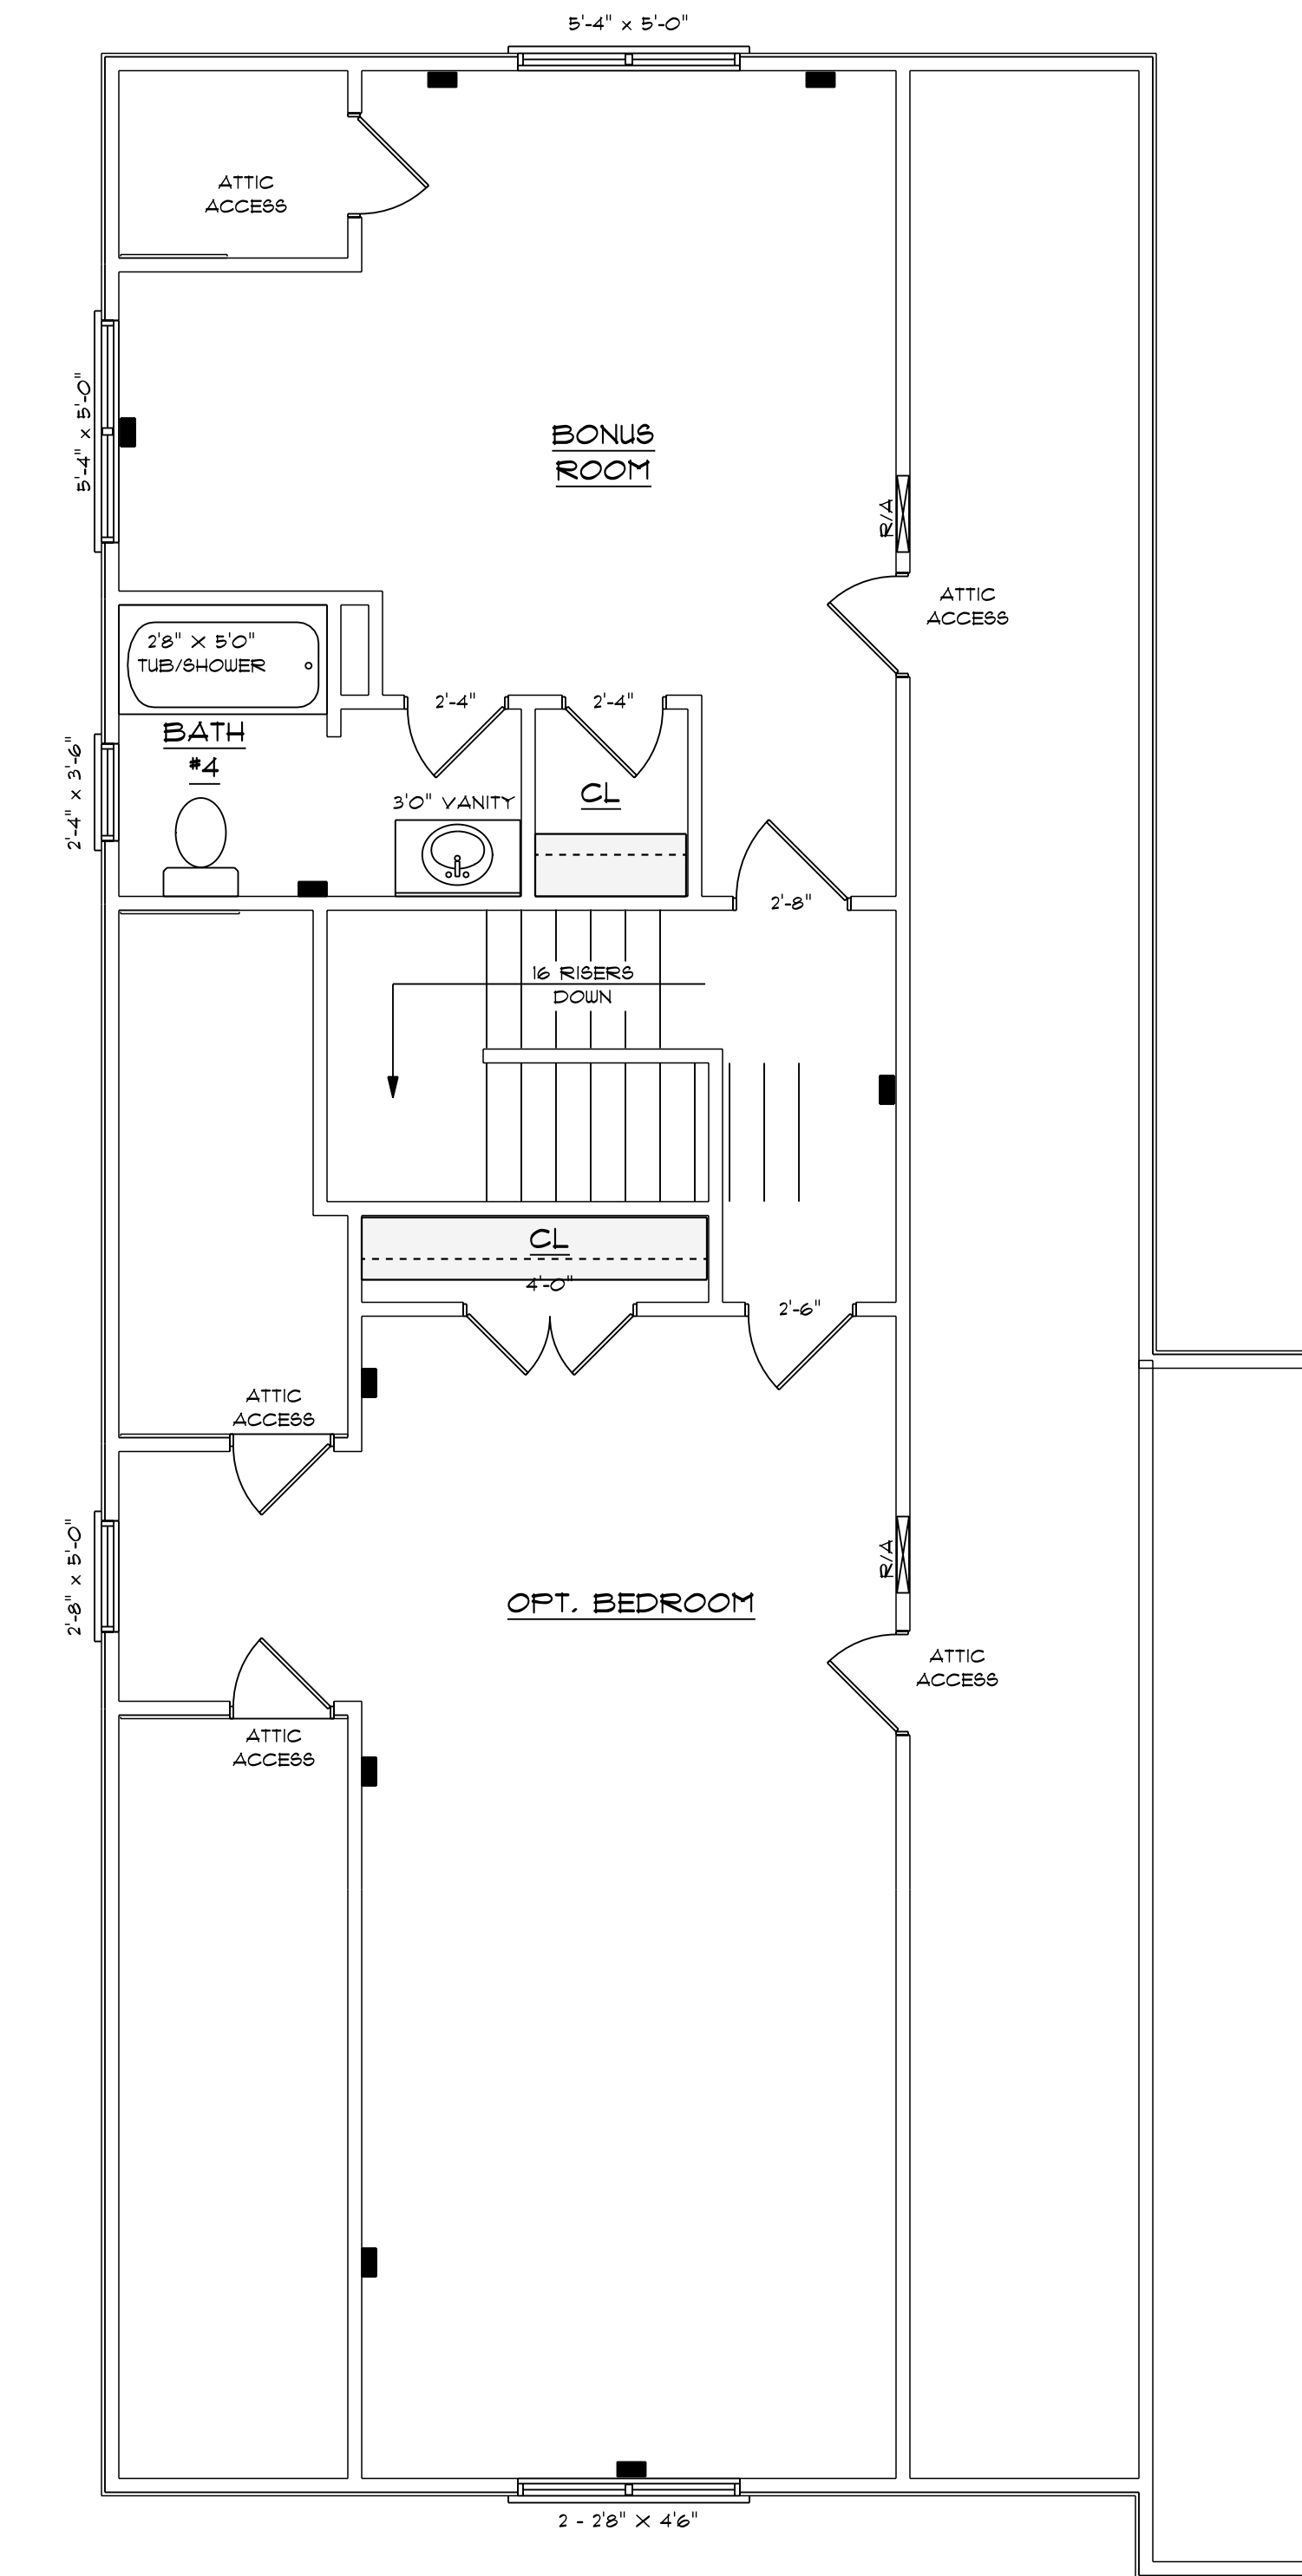


BONUS ROOM/OPT. BEDROOM
SCALE: 1/4" = 1'0"

861 S/F IN BONUS ROOM/OPT. BEDROOM

HVAC CONTRACTOR TO CONFIRM VENT LOCATION AND SIZE OF UNIT

- NOTES:
1. ALL FINAL MATERIALS ARE TO BE CHOSEN BY THE CLIENT.
 2. FINAL NUMBER OF EXTERIOR STEPS WILL BE DETERMINED ON SITE BY GRADE.
 3. CONTRACTOR MUST MEET OR EXCEED ALL APPLICABLE LOCAL, STATE AND FEDERAL REQUIREMENTS.
 4. DESIGNER ASSUMES NO RESPONSIBILITY FOR CHANGES TO DRAWINGS BY OTHERS DURING CONSTRUCTION.
 5. ALL STRUCTURAL INFO SHOWN ON PLANS ARE FOR INFORMATION ONLY. CONSULT WITH ARCHITECT OR STRUCTURAL ENGINEER FOR ALL STRUCTURAL ELEMENTS.

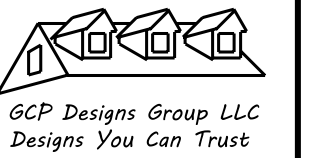

DATE: 9-30-2021
SUBDIVISION:
BUILDER:

RESIDENCE OF MR. & MRS. CASTILLO