


**MAIN FLOOR ELECTRICAL PLAN**  
**SCALE: 1/4" = 1'-0"**

NOTE: SWITCHES AND ARCS NOT SHOWN. OWNER TO LOCATE THESE ITEMS DURING ELECTRICAL WALK-THROUGH WITH ELECTRICAL CONTRACTOR.

ELECTRICAL SYMBOLS LEGEND		ELECTRICAL SYMBOLS LEGEND	
SYMBOL	DESCRIPTION	SYMBOL	DESCRIPTION
	110 VOLT OUTLET		TV SPEAKER
	GROUND FAULT PROTECTED OUTLET		RADIO SPEAKER
	WEATHERPROOF OUTLET		CEILING FAN ONLY, NO LIGHT KIT
	220 VOLT RECEPTACLE		CEILING FAN WITH LIGHT KIT
	FLOOR OUTLET (OWNER TO LOCATE)		TRACK LIGHTING (OWNER TO LOCATE)
	CEILING HUNG FIXTURE		WALL SCONCE (OWNER TO LOCATE)
	OVERHANG MOUNTED FLOODLIGHTS		CHANDELIER 1 (O.T.S.)
	WALL MOUNTED FLOODLIGHTS		CHANDELIER 2 (O.T.S.)
	RECESSED CEILING FIXTURE		UNDER COUNTER LIGHTING
	FLUORESCENT LIGHT		EMERGENCY LIGHTING/ EXIT SIGN
	CARBON MONOXIDE DETECTOR		
	SMOKE DETECTOR		
	SWITCH		
	THREE WAY SWITCH		
	WALL MOUNTED LIGHT		
	DIMMER SWITCH (OWNER TO LOCATE)		
	DOOR ACTIVATED SWITCH		
	WEATHERPROOF OUTLET		
	CAT5 NETWORKING JACK (OWNER TO LOCATE)		
	TELEPHONE OUTLET (OWNER TO LOCATE)		
	TELEVISION OUTLET (OWNER TO LOCATE)		
	DOORBELL BUTTON (CONTRACTOR TO LOCATE)		
	THERMOSTAT (CONTRACTOR TO LOCATE)		
	CEILING EXHAUST FAN, VENT TO EXTERIOR		

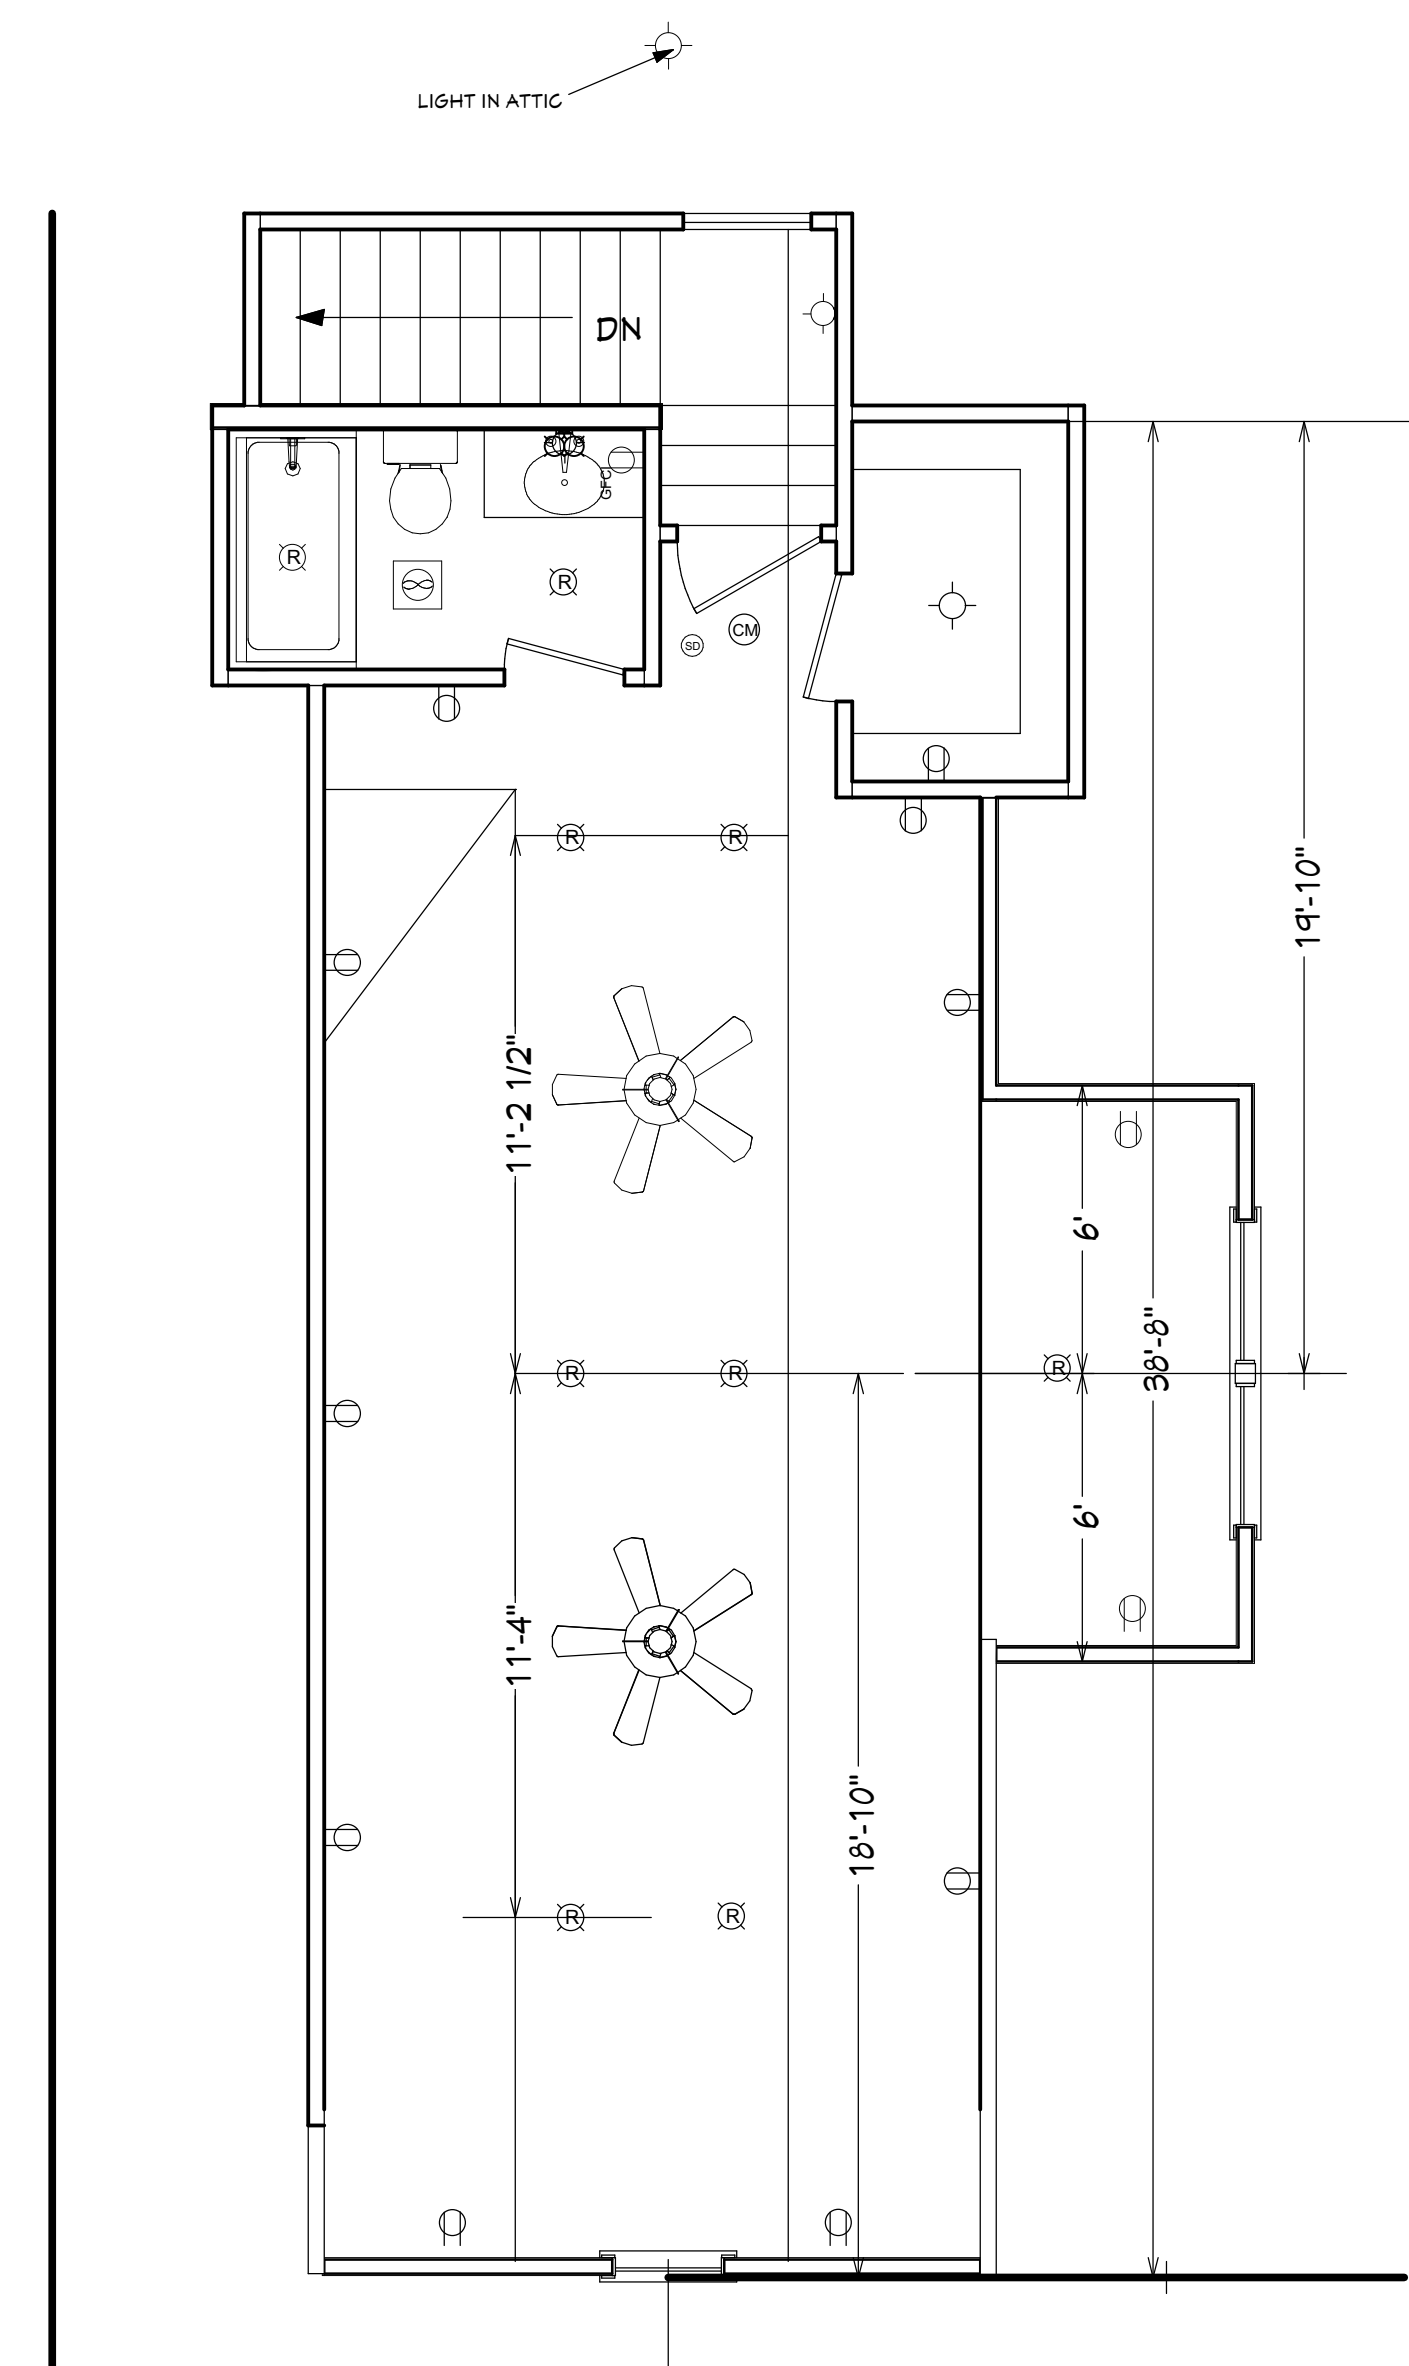

Pre-Drawn Plan ID:  
**BB-2553-3C-VC**

Date: 03/19/2023  
 Drawn By: R.B.W.


SHEET NUMBER

8

Website:  
[www.HPZplans.com](http://www.HPZplans.com)  
 Email:  
[sales@hpzplans.com](mailto:sales@hpzplans.com)

Phone:  
 601.336.3254

Fax:  
 1.800.574.1387

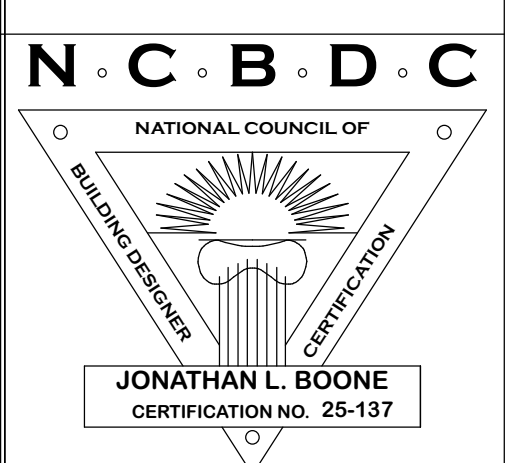

Designing Homes  
**HOUSEPLANZONE**  
 Building Relationships