
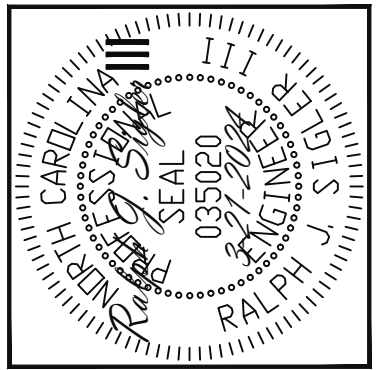


1ST FLOOR FRAMING PLAN

WALLS AND CEILING 1/4" = 1'-0"

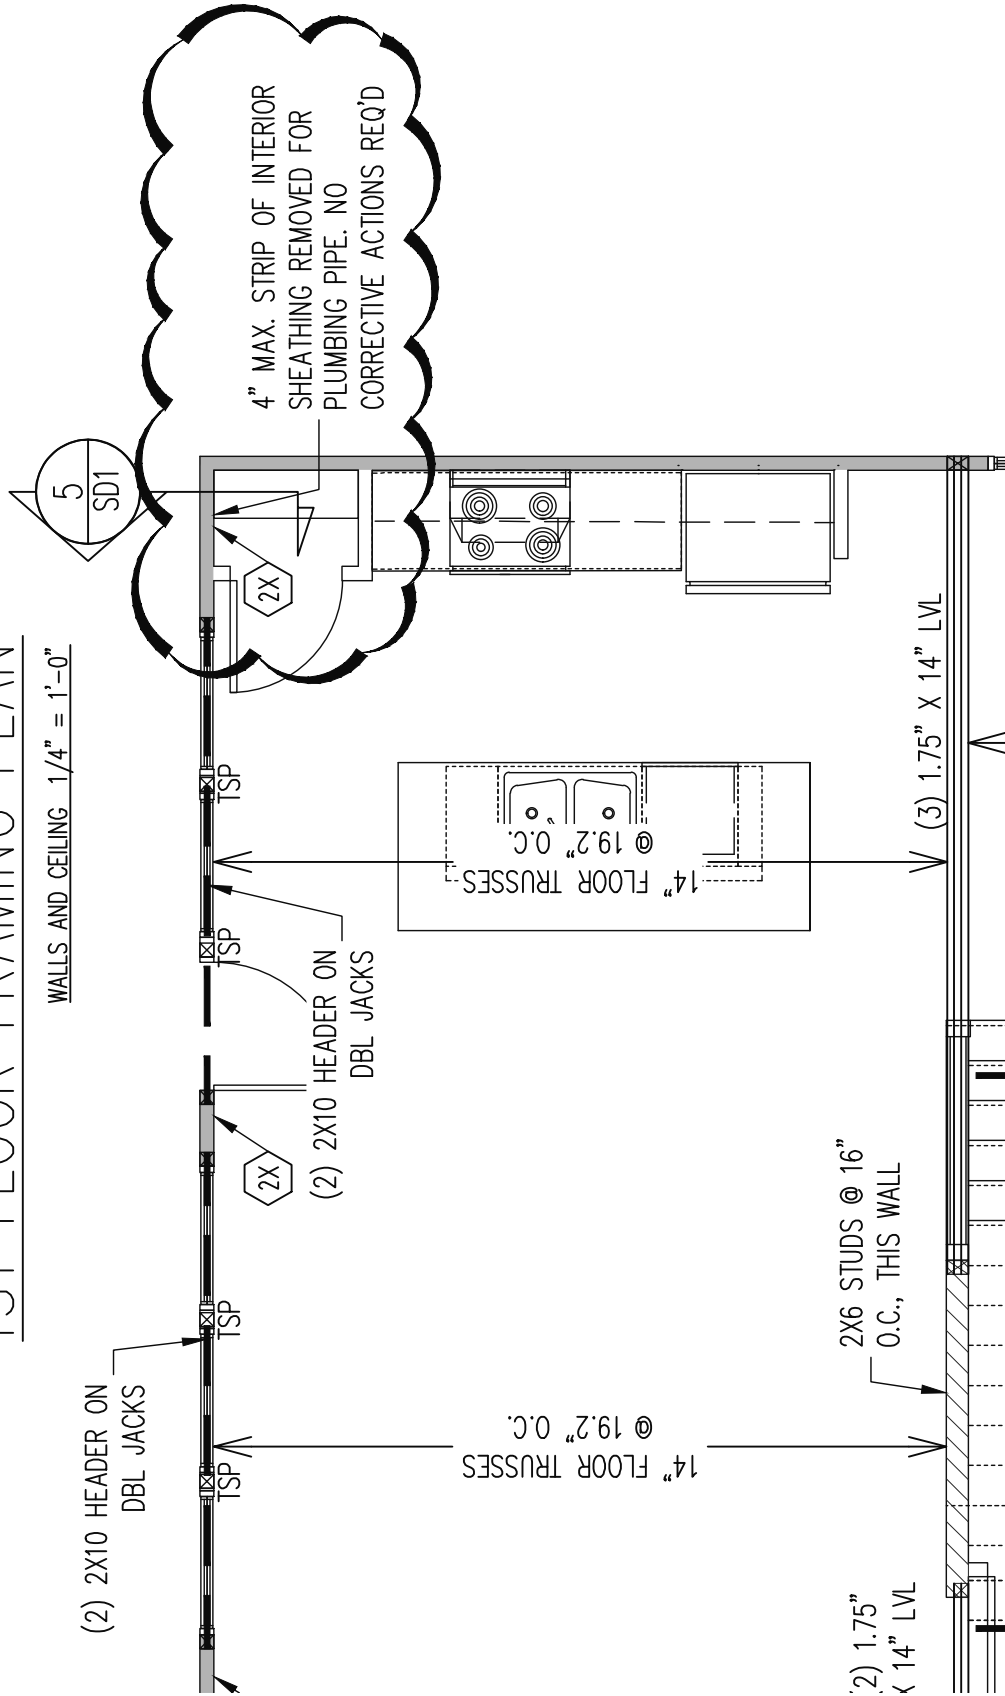

Engineering
Lech
 ASSOCIATES, P.A.

STRUCTURAL ENGINEERS
 License No. C-3870
 318 W Millbrook Rd. Unit 201
 Raleigh, North Carolina 27609
 Phone (919) 844-1661

NEW HOME INC	
SCOPE	CUT IN 2X FOR PLUMBING, DESIGN ONLY
LOC	148 DUNCAN'S CREEK
REV #	REF PROJ #
DATE	

ENG: RJS/MEB
 DATE: 3-21-2024

PARENT
 23-65-081-296

PROJECT NO.
 24-75-322

SHEET NO.
 SL1
 1 of 1