

ELECTRICAL LEGEND		
ELECTRICAL	COUNT	SYMBOL
ceiling fan 4 bladed 01	1	
ceiling fan spotlights 01	3	
fluorescent light 1 x 4	1	
fan	1	
light	15	
outlet	31	
switch	24	

ELEC. PLAN

SCALE: 1/4" = 1'0"

ELECTRICAL CONTRACTOR TO CONFIRM
LOCATION OF OUTLETS AND
STYLE OF LIGHTS WITH OWNER

ALL EXTERIOR FLOODLIGHTS
TO BE DETERMINED
ON SITE BY OWNER.

988 S/F - TOTAL HEATED AREA
160 S/F - FRONT COVERED PORCH AREA
20 S/F - STOR ROOM AREA
9'0" CEIL. HT. - 7'4" WINDOW HT.

"I DO HEREBY CERTIFY THAT THIS DRAWING OR PLAN AND RELATED SPECIFICAT
MEET ALL LOCAL REQUIREMENTS AND ARE IN SUBSTANTIAL CONFORMITY WITH VA
MINIMUM PROPERTY REQUIREMENTS INCLUDING THE ENERGY CONSERVATION STAND
OF THE 1992 COUNCIL OF AMERICAN BUILDING OFFICIALS (CABO) MODEL ENERGY


CHARLES SMITH ASSOCIATES
© copyright 2024

SCALE: AS NOTED
DATE: JAN. 2024
DRAWN BY: ECL


CHARLES SMITH ASSOC.
RESIDENTIAL DESIGNER
FAYETTEVILLE, NC
PHONE: (910) - 484 - 5924
WWW.CSAPLANS.COM

DEVON DORSETT
LEVELS TO HOMES INC.
(919) 353 - 3864


LTH-988

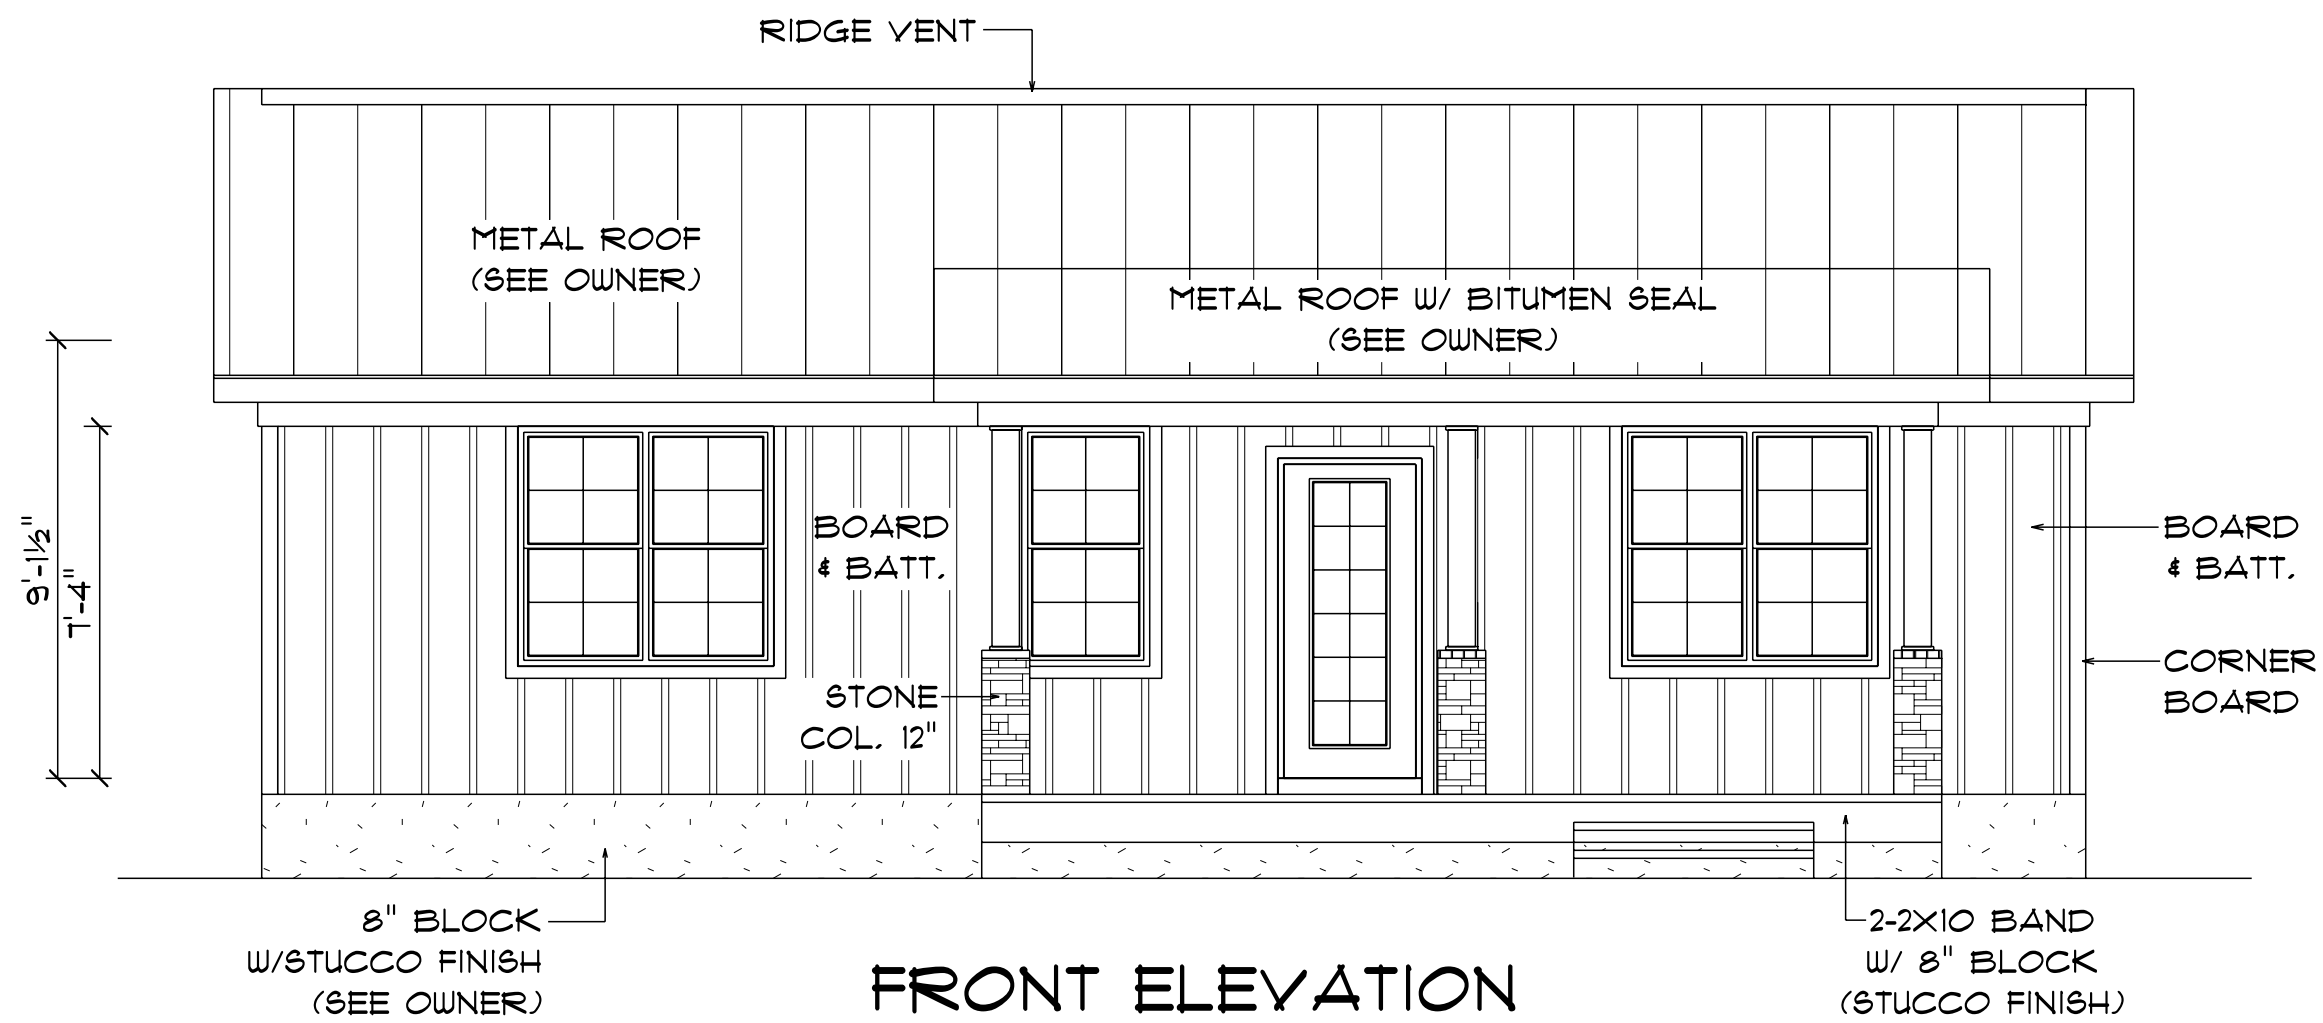


FRONT ELEVATION
SCALE: 1/4" = 1'0"

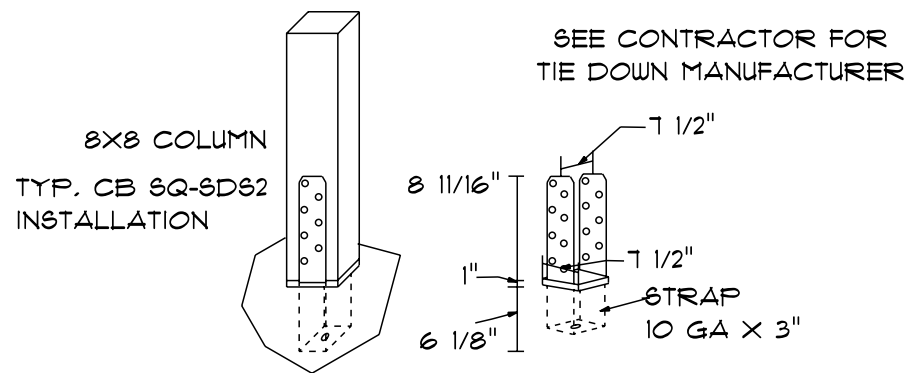


**TYP. TIE DOWN
DETAIL**
NOT TO SCALE

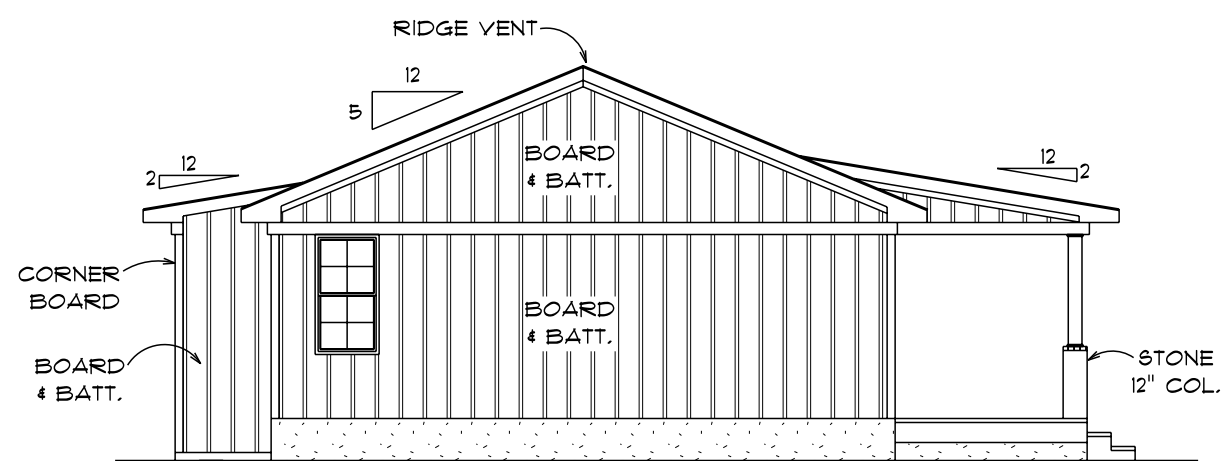

LEFT ELEVATION
SCALE: 1/8" = 1'0"

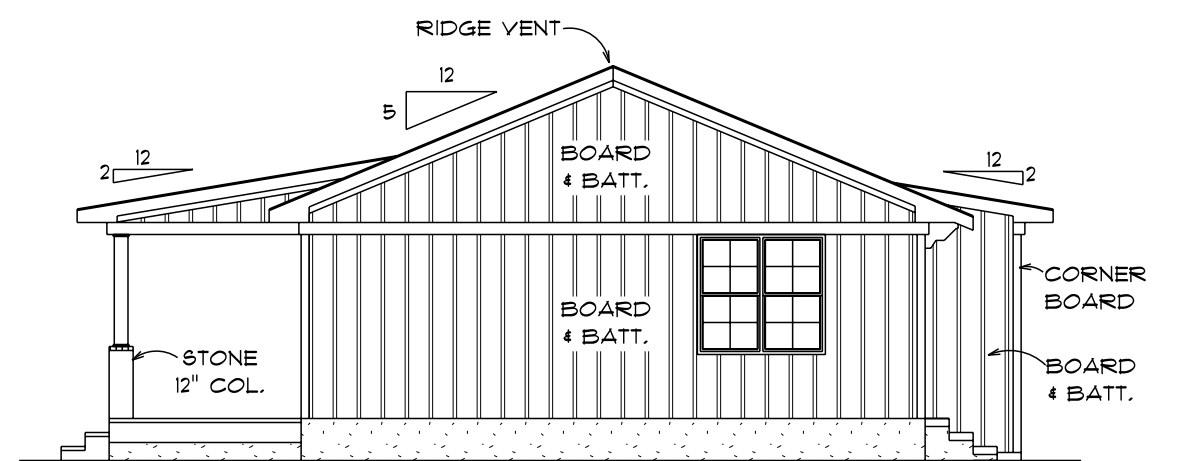

RIGHT ELEVATION
SCALE: 1/8" = 1'0"

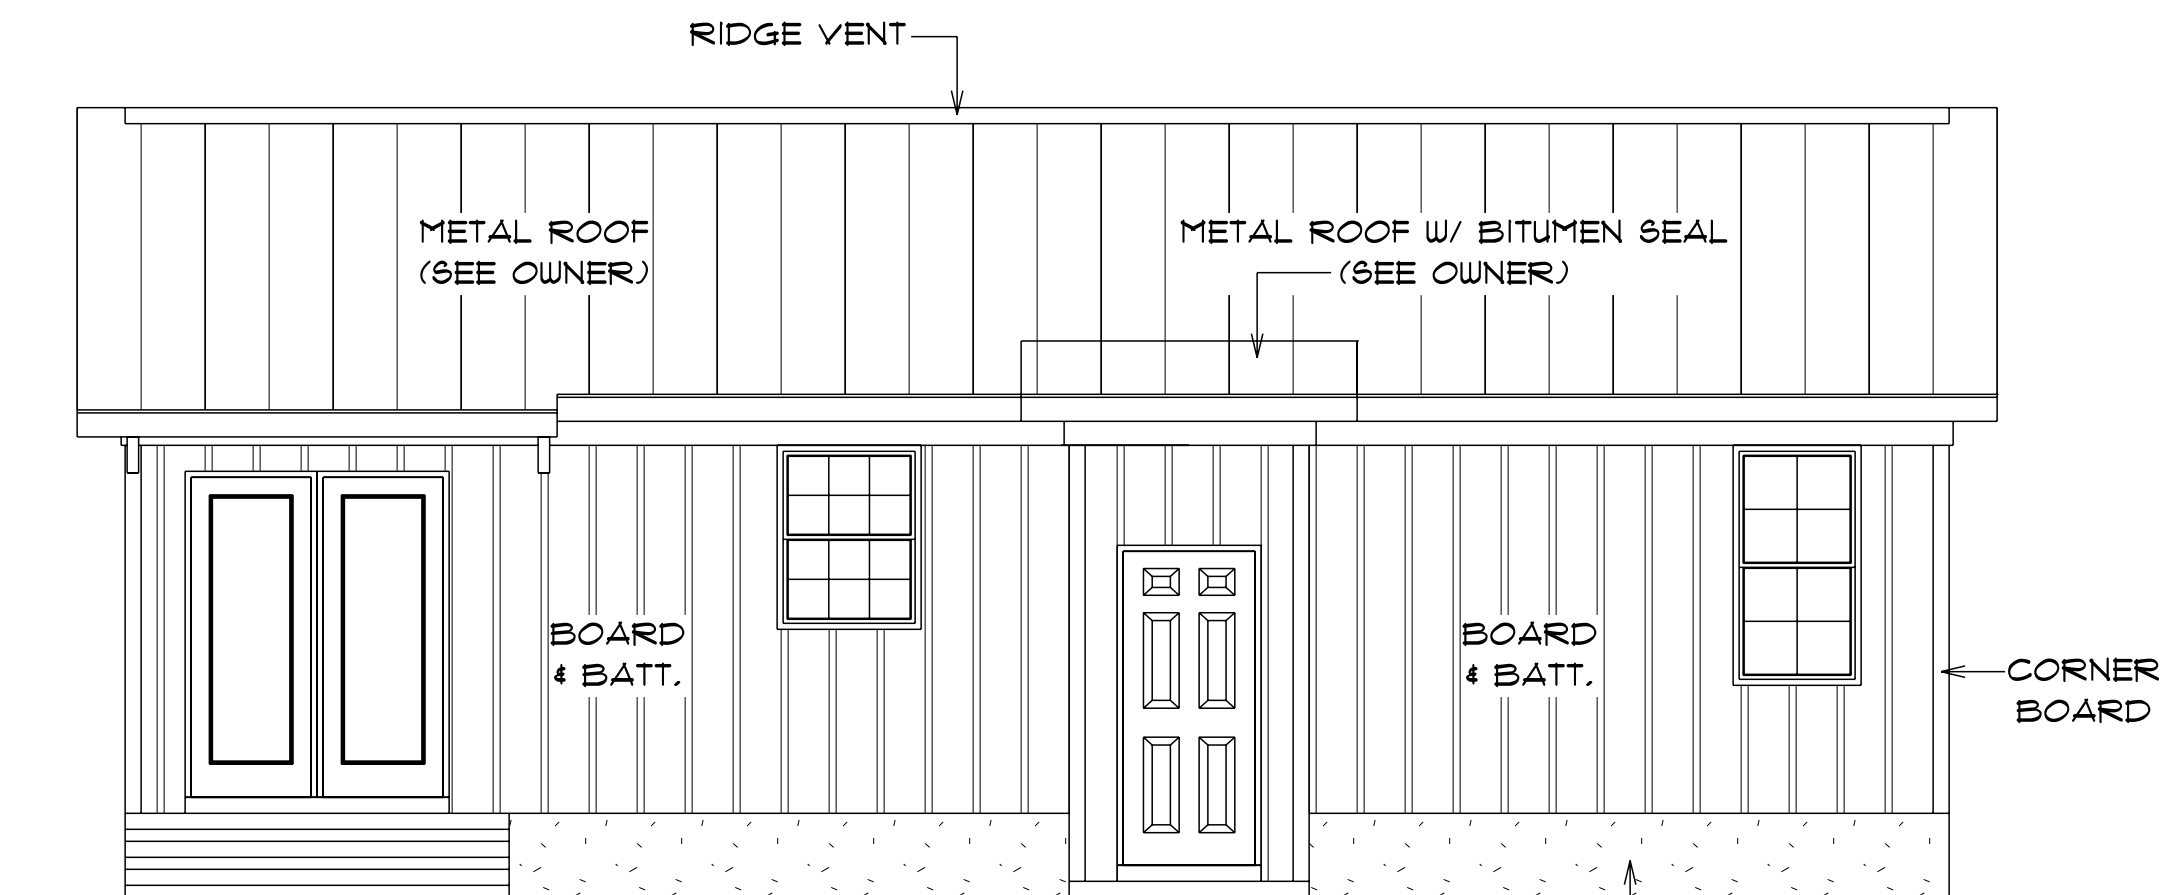

REAR ELEVATION
SCALE: 1/4" = 1'0"

988 S/F - TOTAL HEATED AREA
160 S/F - FRONT COVERED PORCH AREA
20 S/F - STOR ROOM AREA
9'0" CEIL. HT. - 7'4" WINDOW HT.

"I DO HEREBY CERTIFY THAT THIS DRAWING OR PLAN AND RELATED SPECIFICAT MEET ALL LOCAL REQUIREMENTS AND ARE IN SUBSTANTIAL CONFORMITY WITH VA MINIMUM PROPERTY REQUIREMENTS INCLUDING THE ENERGY CONSERVATION STAND OF THE 1992 COUNCIL OF AMERICAN BUILDING OFFICIALS (CABO) MODEL ENERGY



CHARLES SMITH ASSOCIATES
© copyright 2024

SCALE: AS NOTED
DATE: JAN. 2024
DRAWN BY: ECL

CHARLES SMITH ASSOC.
RESIDENTIAL DESIGNER
FAYETTEVILLE, NC
PHONE: (910) - 484 - 5924
WWW.CSAPLANS.COM

DEVON DORSETT
LEVELS TO HOMES INC.
(919) 353 - 3864

LTH-988

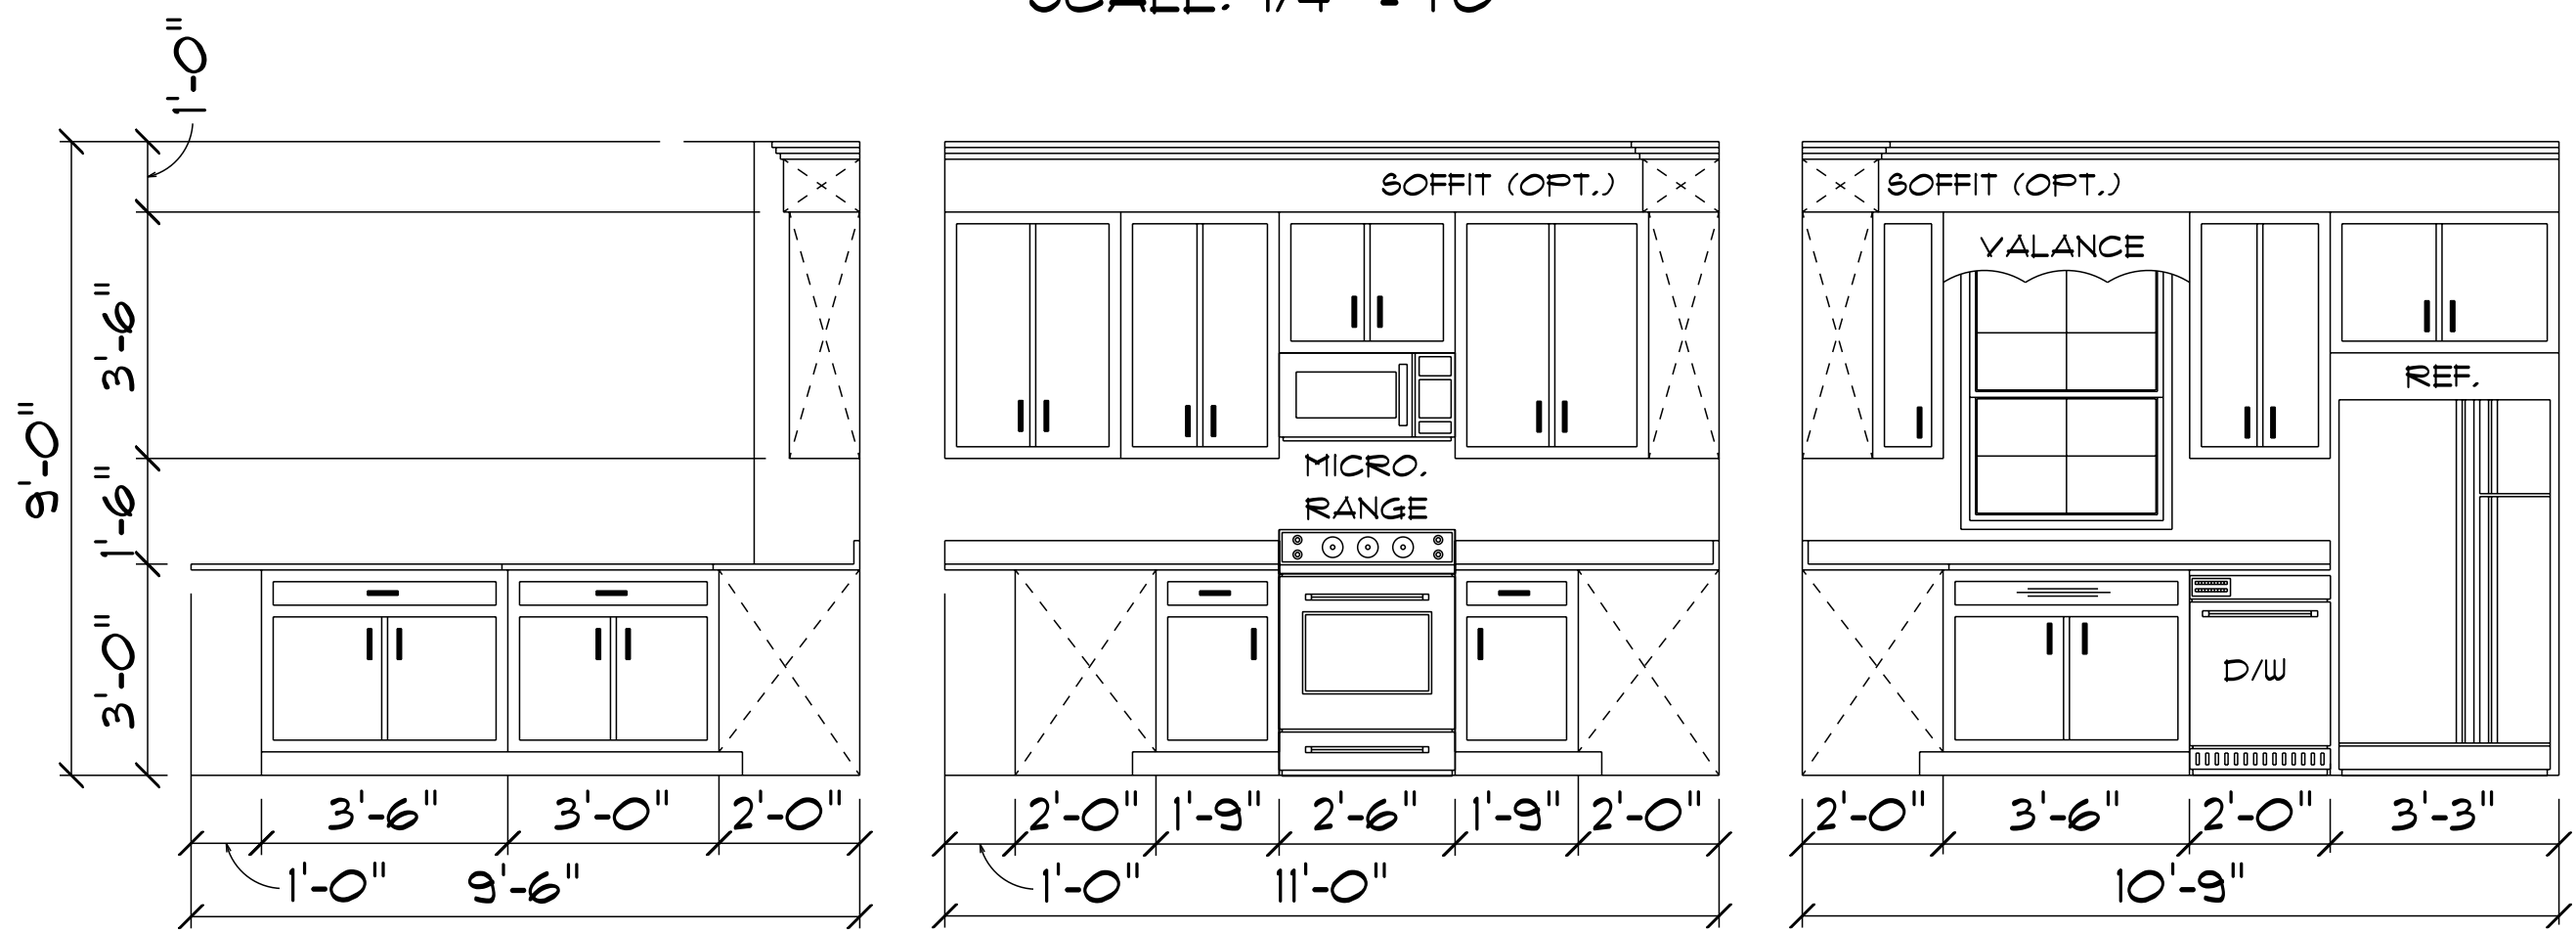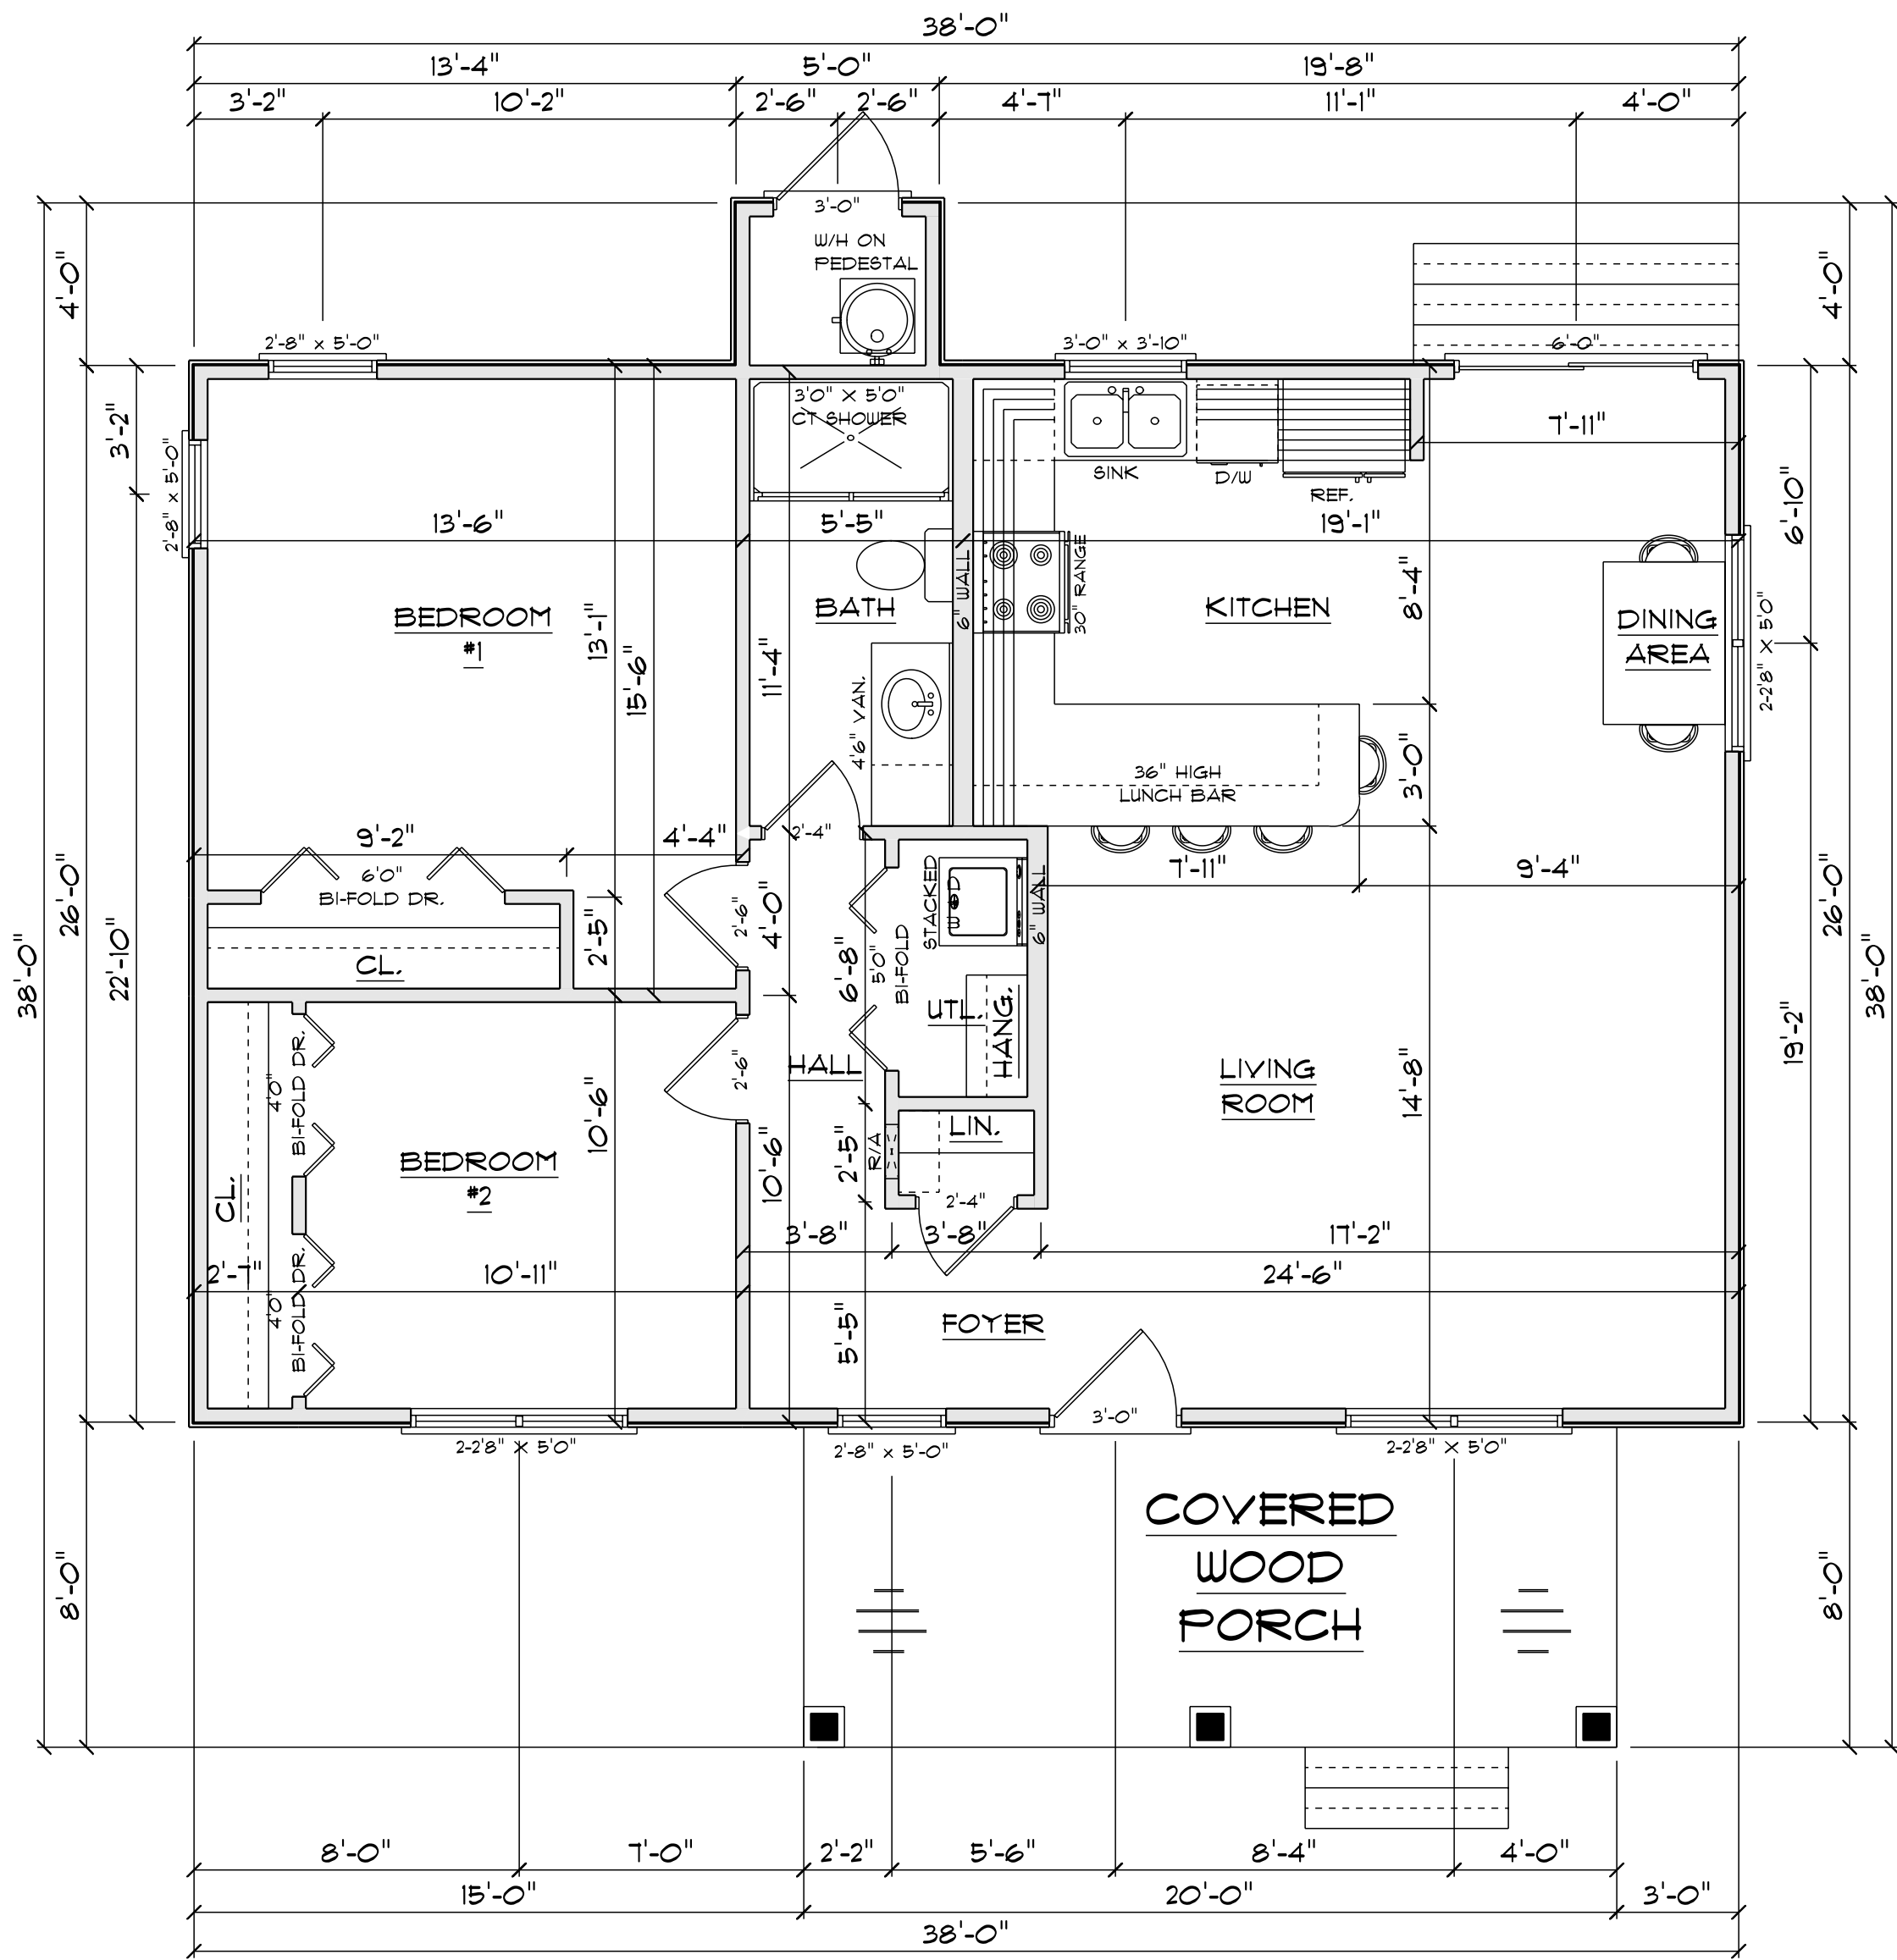

988 S/F - TOTAL HEATED AREA
160 S/F - FRONT COVERED PORCH AREA
20 S/F - STOR ROOM AREA
9'0" CEIL. HT. - T'4" WINDOW HT.

"I DO HEREBY CERTIFY THAT THIS DRAWING OR PLAN AND RELATED SPECIFICAT MEET ALL LOCAL REQUIREMENTS AND ARE IN SUBSTANTIAL CONFORMITY WITH VA MINIMUM PROPERTY REQUIREMENTS INCLUDING THE ENERGY CONSERVATION STAND OF THE 1992 COUNCIL OF AMERICAN BUILDING OFFICIALS (CABO) MODEL ENERGY

CHARLES SMITH ASSOCIATES
© copyright 2024

SCALE: AS NOTED


DATE: JAN. 2024

DRAWN BY: ECL

CHARLES SMITH ASSOC.
RESIDENTIAL DESIGNER
FAYETTEVILLE, NC
PHONE: (910) - 484 - 5924
WWW.CSAPLANS.COM

DEVON DORSETT
LEVELS TO HOMES INC.
(919) 353 - 3864


LTH-988

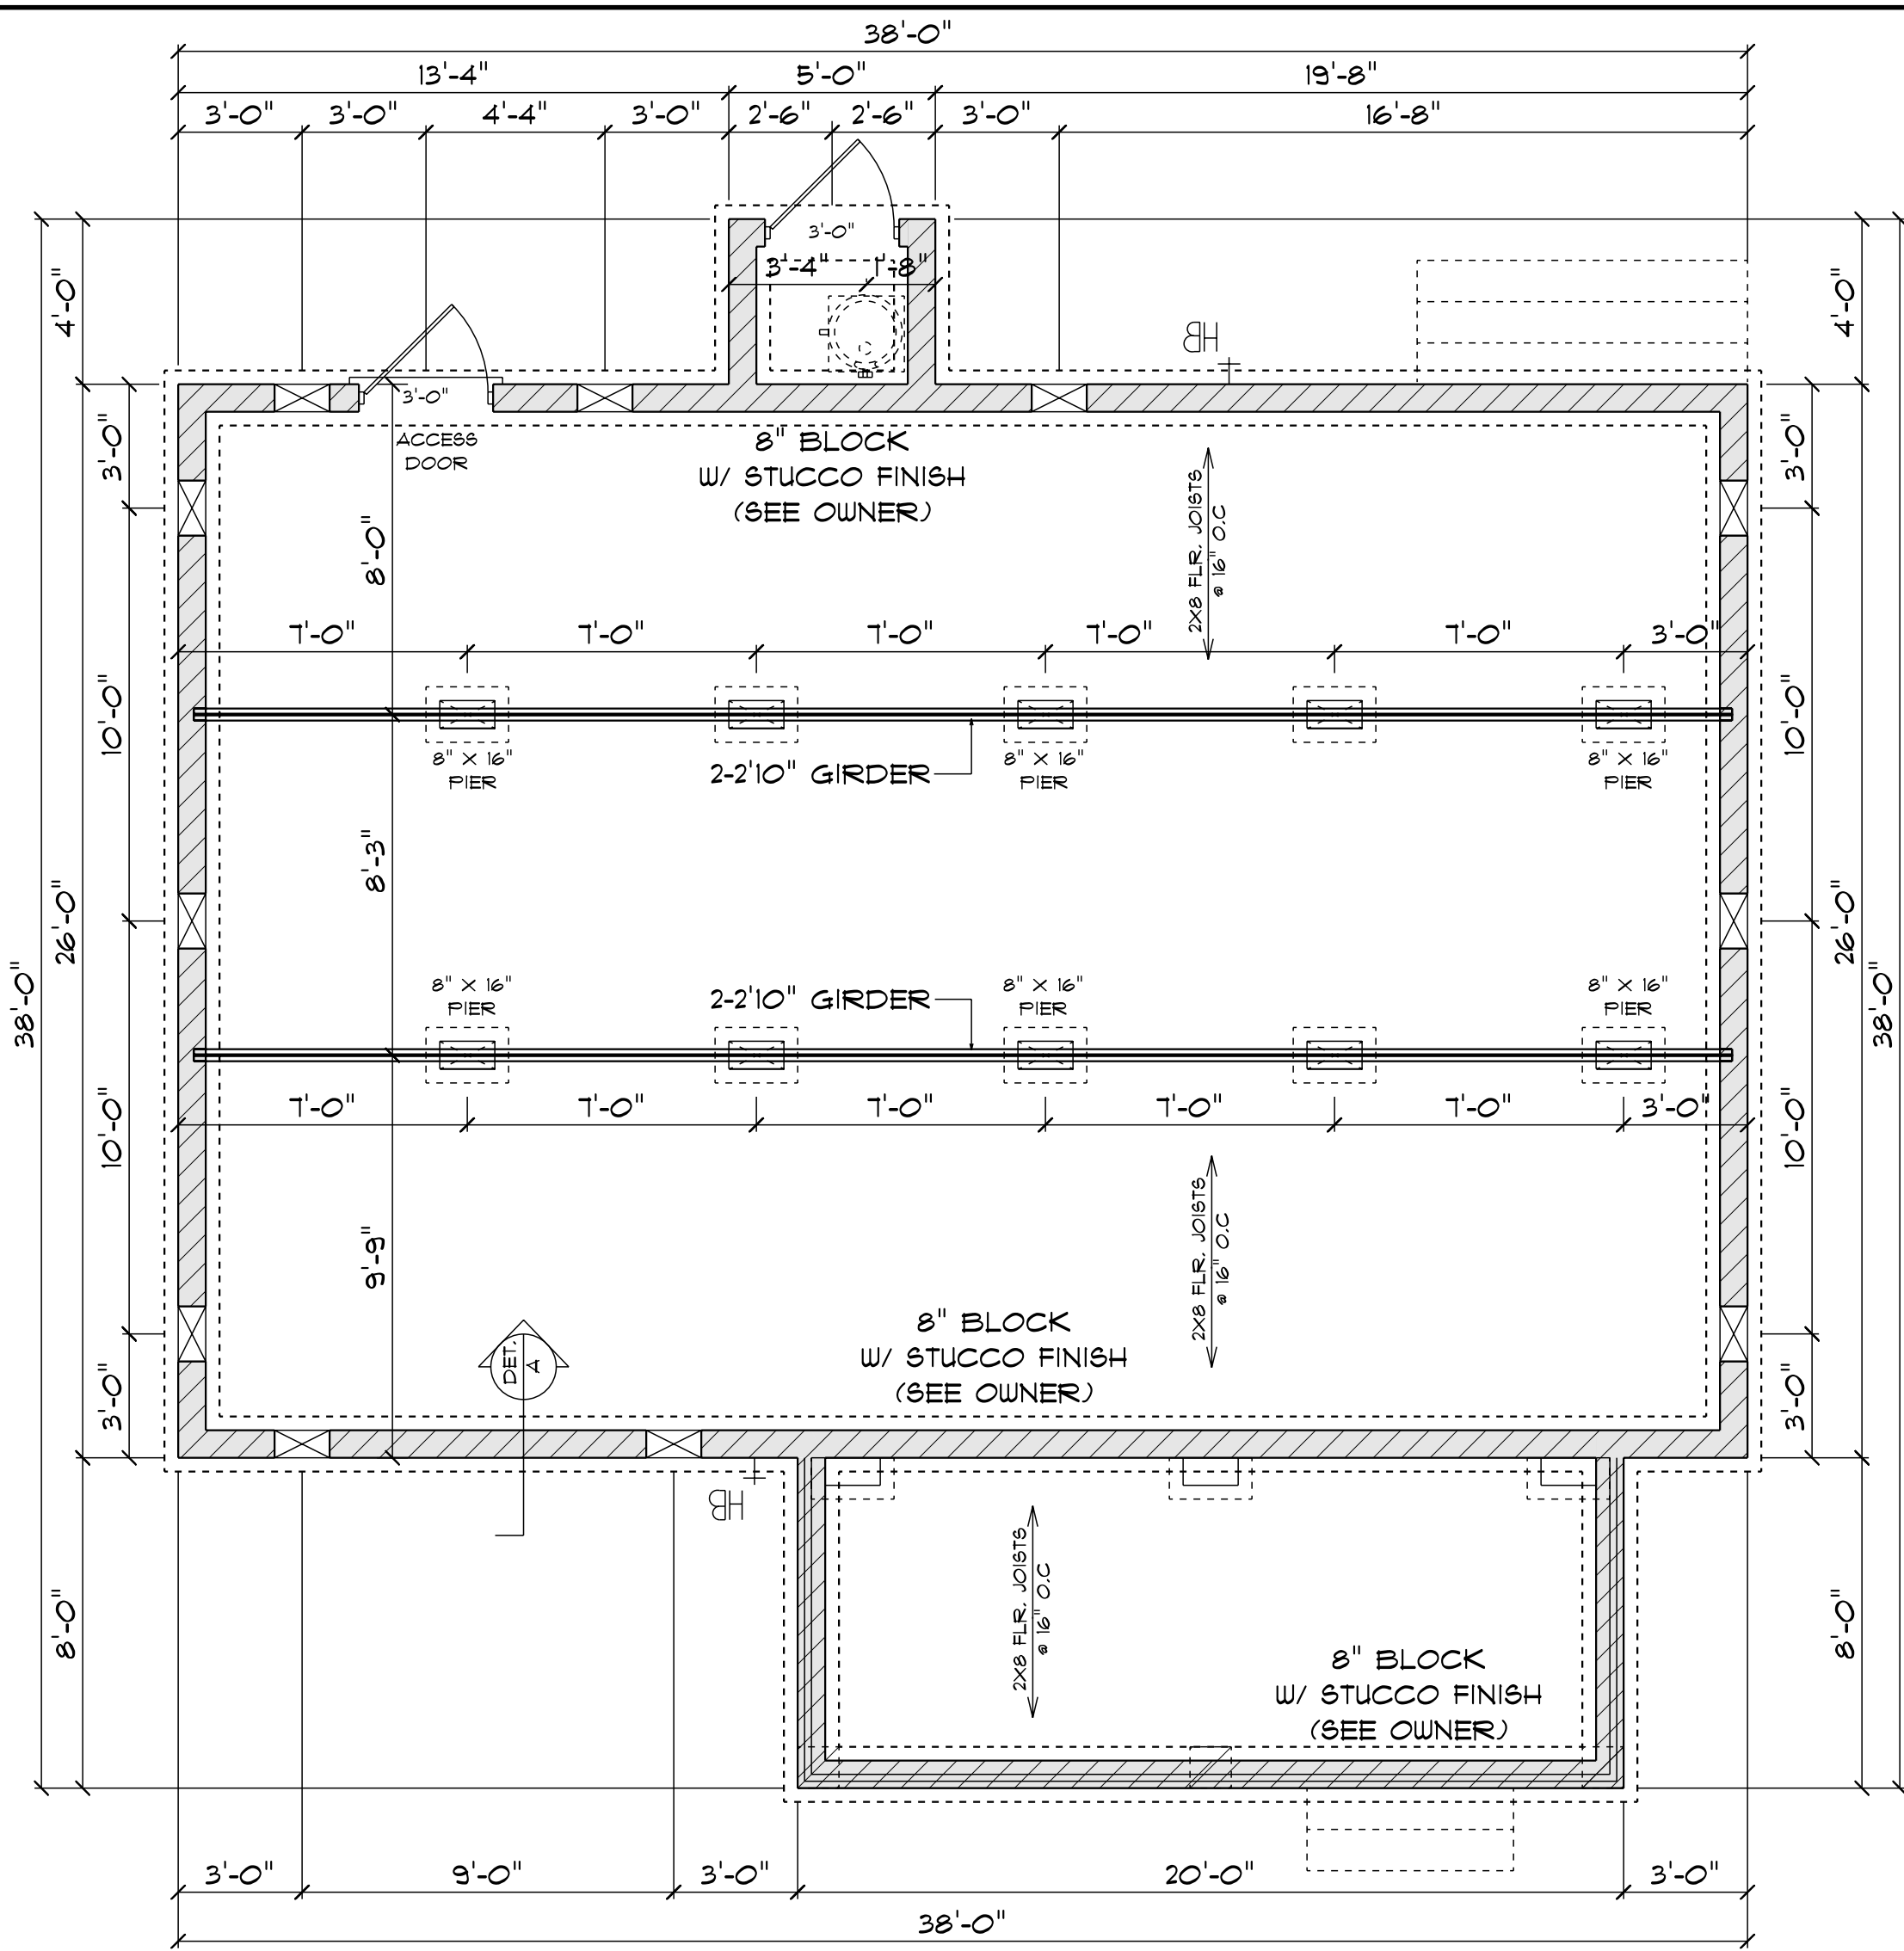

FOUNDATION PLAN

SCALE: 1/4" = 1'0"

TOTAL VENT CALCULATION:
988 S/F / 150 = 6.58 VENTS

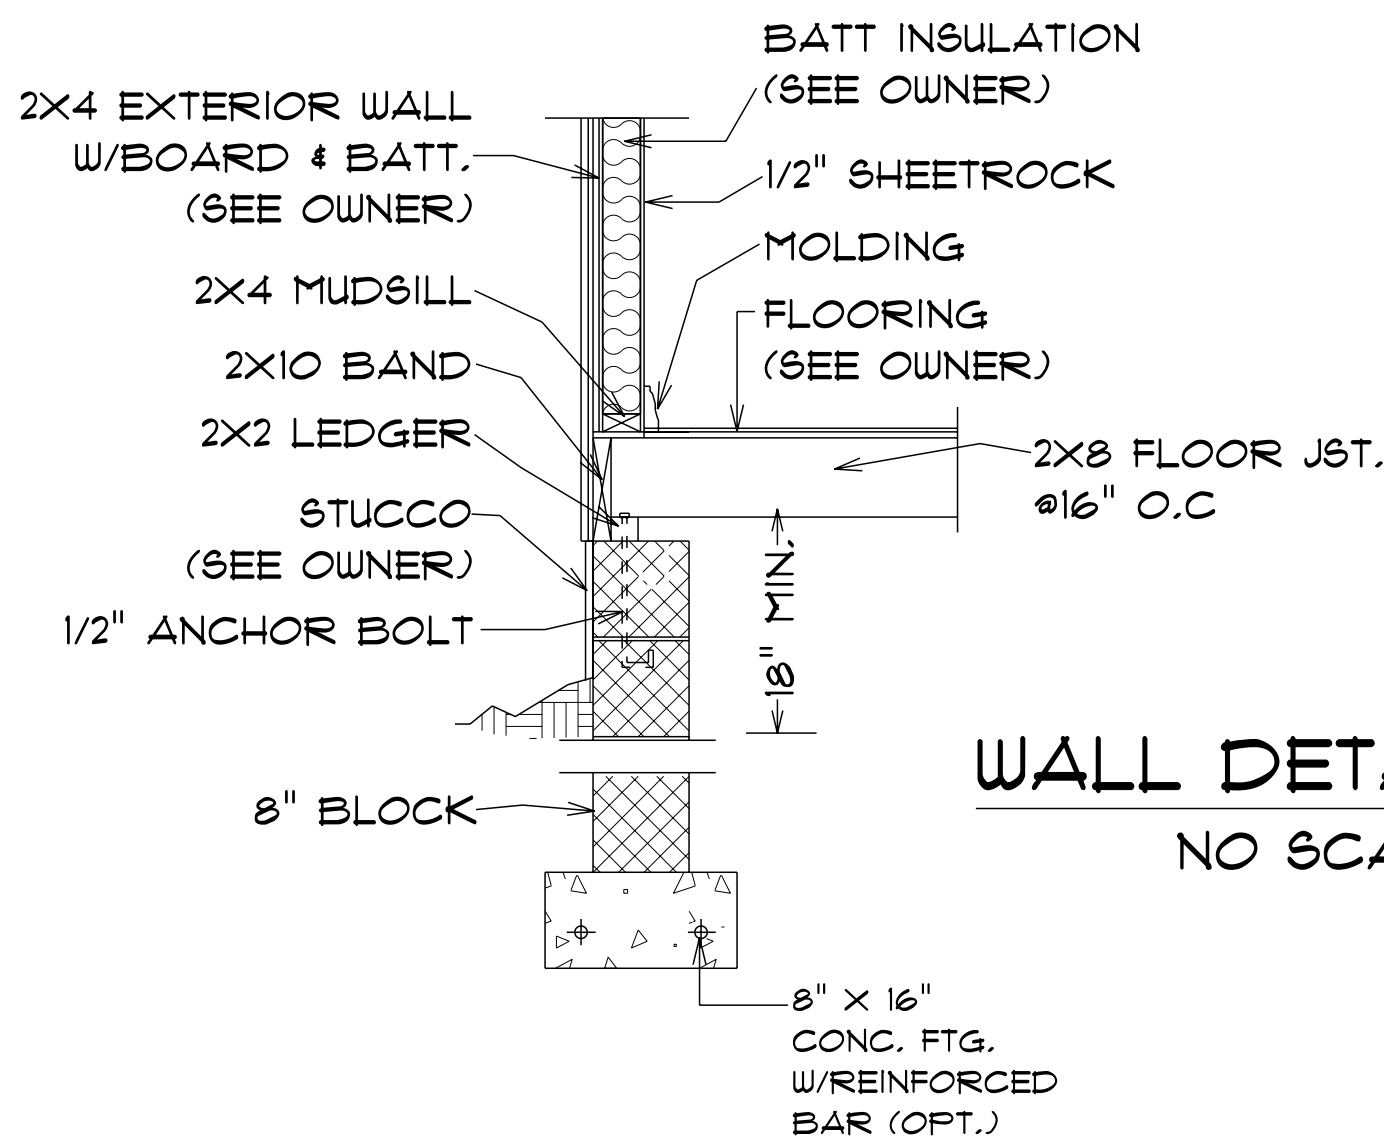

WALL DETAIL - A

NO SCALE

CONCRETE NOTES

- NOTES:
- 1) MINIMUM SOIL BEARING CAPACITY: 2000 psf.
 - 2) CONCRETE COMPRESSIVE STRENGTH @ END OF 28 DAYS (MIN) FOUNDATIONS, FOOTING, 4 INTERIOR SLABS = 3000 psi. EXTERIOR SLAB (EXPOSED TO WEATHER) = 3500 psi.

988 S/F - TOTAL HEATED AREA
160 S/F - FRONT COVERED PORCH AREA
20 S/F - STOR ROOM AREA
9'0" CEIL. HT. - T'4" WINDOW HT.

"I DO HEREBY CERTIFY THAT THIS DRAWING OR PLAN AND RELATED SPECIFICAT MEET ALL LOCAL REQUIREMENTS AND ARE IN SUBSTANTIAL CONFORMITY WITH VA MINIMUM PROPERTY REQUIREMENTS INCLUDING THE ENERGY CONSERVATION STAND OF THE 1992 COUNCIL OF AMERICAN BUILDING OFFICIALS (CABO) MODEL ENERGY


CHARLES SMITH ASSOCIATES
© copyright 2024

SCALE: AS NOTED
DATE: JAN. 2024
DRAWN BY: ECL

CHARLES SMITH ASSOC.
RESIDENTIAL DESIGNER
FAYETTEVILLE, NC
PHONE: (910) - 484 - 5924
WWW.CSAPLANS.COM

DEVON DORSETT
LEVELS TO HOMES INC.
(919) 353 - 3864

LTH-988

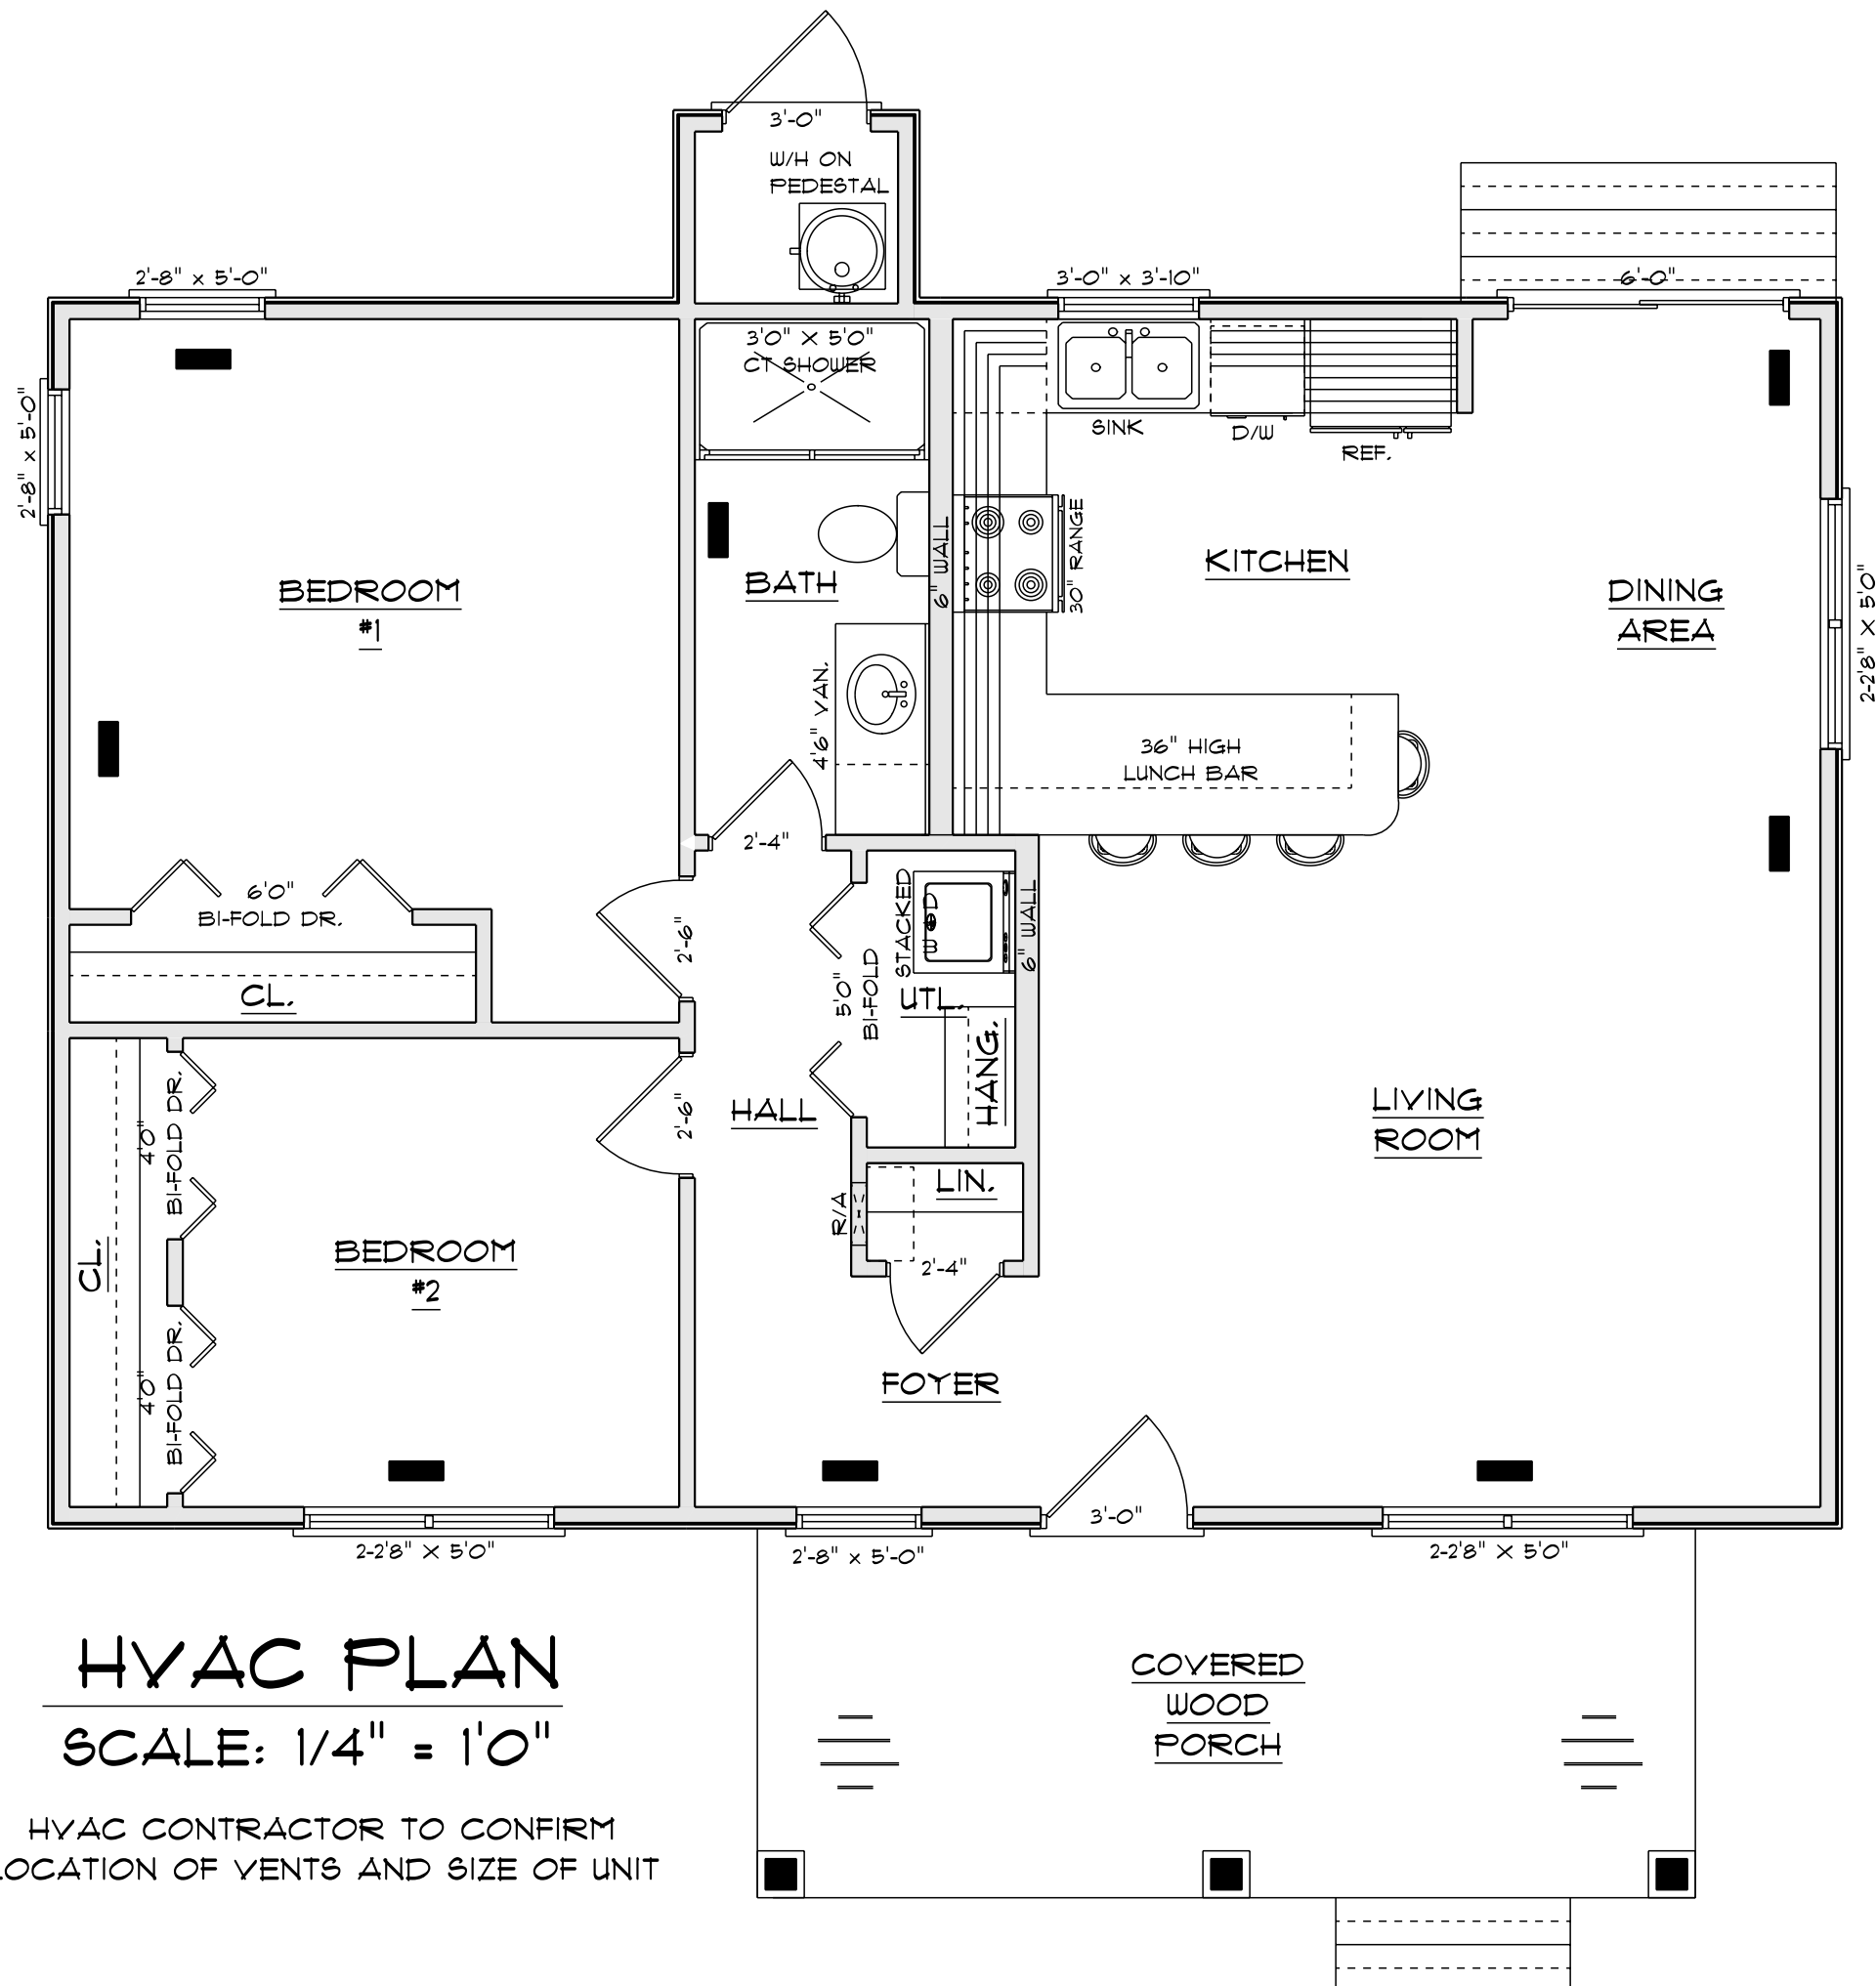

988 S/F - TOTAL HEATED AREA
 160 S/F - FRONT COVERED PORCH AREA
 20 S/F - STOR ROOM AREA
 9'0" CEIL. HT. - 7'4" WINDOW HT.

"I DO HEREBY CERTIFY THAT THIS DRAWING OR PLAN AND RELATED SPECIFICAT MEET ALL LOCAL REQUIREMENTS AND ARE IN SUBSTANTIAL CONFORMITY WITH VA MINIMUM PROPERTY REQUIREMENTS INCLUDING THE ENERGY CONSERVATION STAND OF THE 1992 COUNCIL OF AMERICAN BUILDING OFFICIALS (CABO) MODEL ENERGY

CHARLES SMITH ASSOCIATES
 © copyright 2024

SCALE: AS NOTED
 DATE: JAN. 2024
 DRAWN BY: ECL

CHARLES SMITH ASSOC.
 RESIDENTIAL DESIGNER
 FAYETTEVILLE, NC
 PHONE: (910) - 484 - 5924
 WWW.CSAPLANS.COM

DEVON DORSETT
LEVELS TO HOMES INC.
 (919) 353 - 3864

LTH-988