

CAROLINA SEASONS K18 - 899 PONDEROSA TRAIL, CAMERON

ELEVATION NOTES:
GRADE ELEVATIONS SHOWN DO NOT NECESSARILY REFER TO THIS OR ANY OTHER LOT. THEY ARE FOR DIAGRAMMATIC PURPOSES ONLY AND MAY VARY. BUILDER IS RESPONSIBLE FOR ADAPTING THIS PLAN TO SUIT THE EXISTING TOPOGRAPHY OF THE SITE.

ROOF VENTILATION TO BE DETERMINED BY BUILDER AS PER CODE.

ALL EGRESS OR RESCUE WINDOWS FROM SLEEPING ROOMS MUST HAVE A MIN. NET CLEAR OPENING OF 4.0 SQ FT. THE MIN NET CLEAR OPENING HEIGHT DIMENSION SHALL BE 22". THE MIN NET CLEAR OPENING WIDTH SHALL BE 20".

EACH EGRESS WINDOW FROM SLEEPING ROOMS MUST HAVE A SILL HIGHT OF NO MORE THAN 44" FROM THE FLOOR. ALL WINDOW SIZES ARE NOMINAL AND ARE TO BE VERIFIED WITH MANUFACTURER FOR AVAILABILITY AND CONFORMITY TO STATE AND LOCAL CODE REQUIREMENTS.

PORCHES, BALCONIES, OR RAISED FLOOR SURFACES LOCATED MORE THAN 30" ABOVE THE FLOOR OR GRADE BELOW SHALL HAVE GUARDRAILS NOT LESS THAN 32" IN HEIGHT.


I ASSUME NO RESPONSIBILITY FOR ANY DISTANCES AFTER START OF CONSTRUCTION.
CONTRACTOR/BUILDER SHALL CONSULT WITH HOME OWNER ON ALL INTERIOR AND EXTERIOR HOLDINGS, TRIMS, COLORS, FINISHES, CABINET LAYOUTS, AND MANUFACTURERS BEFORE CONSTRUCTION BEGINS.
ALL BEAMS AND FRAMING MEMBERS ARE SIZED BY OTHERS.

1.1 This plan has been drawn to comply with the 2018 NC Building Code


- 1.2 Minimum Design Loads for Building and Other Structures ASCE 7-95
- 2 Roof Dead Load 15 PSF
- 3 Roof Live Load 20 PSF
- 4 Typical Floor Dead Load 10 PSF
- 5 Floor Live Loads
- 5.1 Rooms other than sleeping rooms 40 PSF
- 5.2 Sleeping Rooms 30 PSF
- 5.3 Stairs 40 PSF
- 5.4 Decks 40 PSF
- 5.5 Exterior Balconies 60 PSF
- 6 Wind Loads
- 6.1 Ultimate Design Wind Speeds 15 MPH
- 6.2 Wind Importance Factor, IW 1.00
- 6.3 Exposure B
- 6.4 Walls (Component and Cladding) 25 PSF
- 6.5 Roofs (Component and Cladding)
- 6.5.1 Roof Slopes 2.25/12 to 1/12 34.8 PSF
- 6.5.2 Roof Slopes 1/12 to 12/12 21 PSF

It is the sole responsibility of the Contractor and/or Builder to conform to all standards, provisions, requirements, methods of construction and uses of materials provided in buildings and/or structures as required by NC Uniform Building Code, Local Agencies and in accordance with good engineering practices. Verify all dimensions prior to construction.


CRH HOMES RETAINS TITLE AND OWNERSHIP OF ALL PLANS. THESE PLANS CAN NOT BE COPIED OR REPRODUCED. THESE PLANS CAN NOT BE BUILT BY ANYONE BUILDER OTHER THAN CRH HOMES

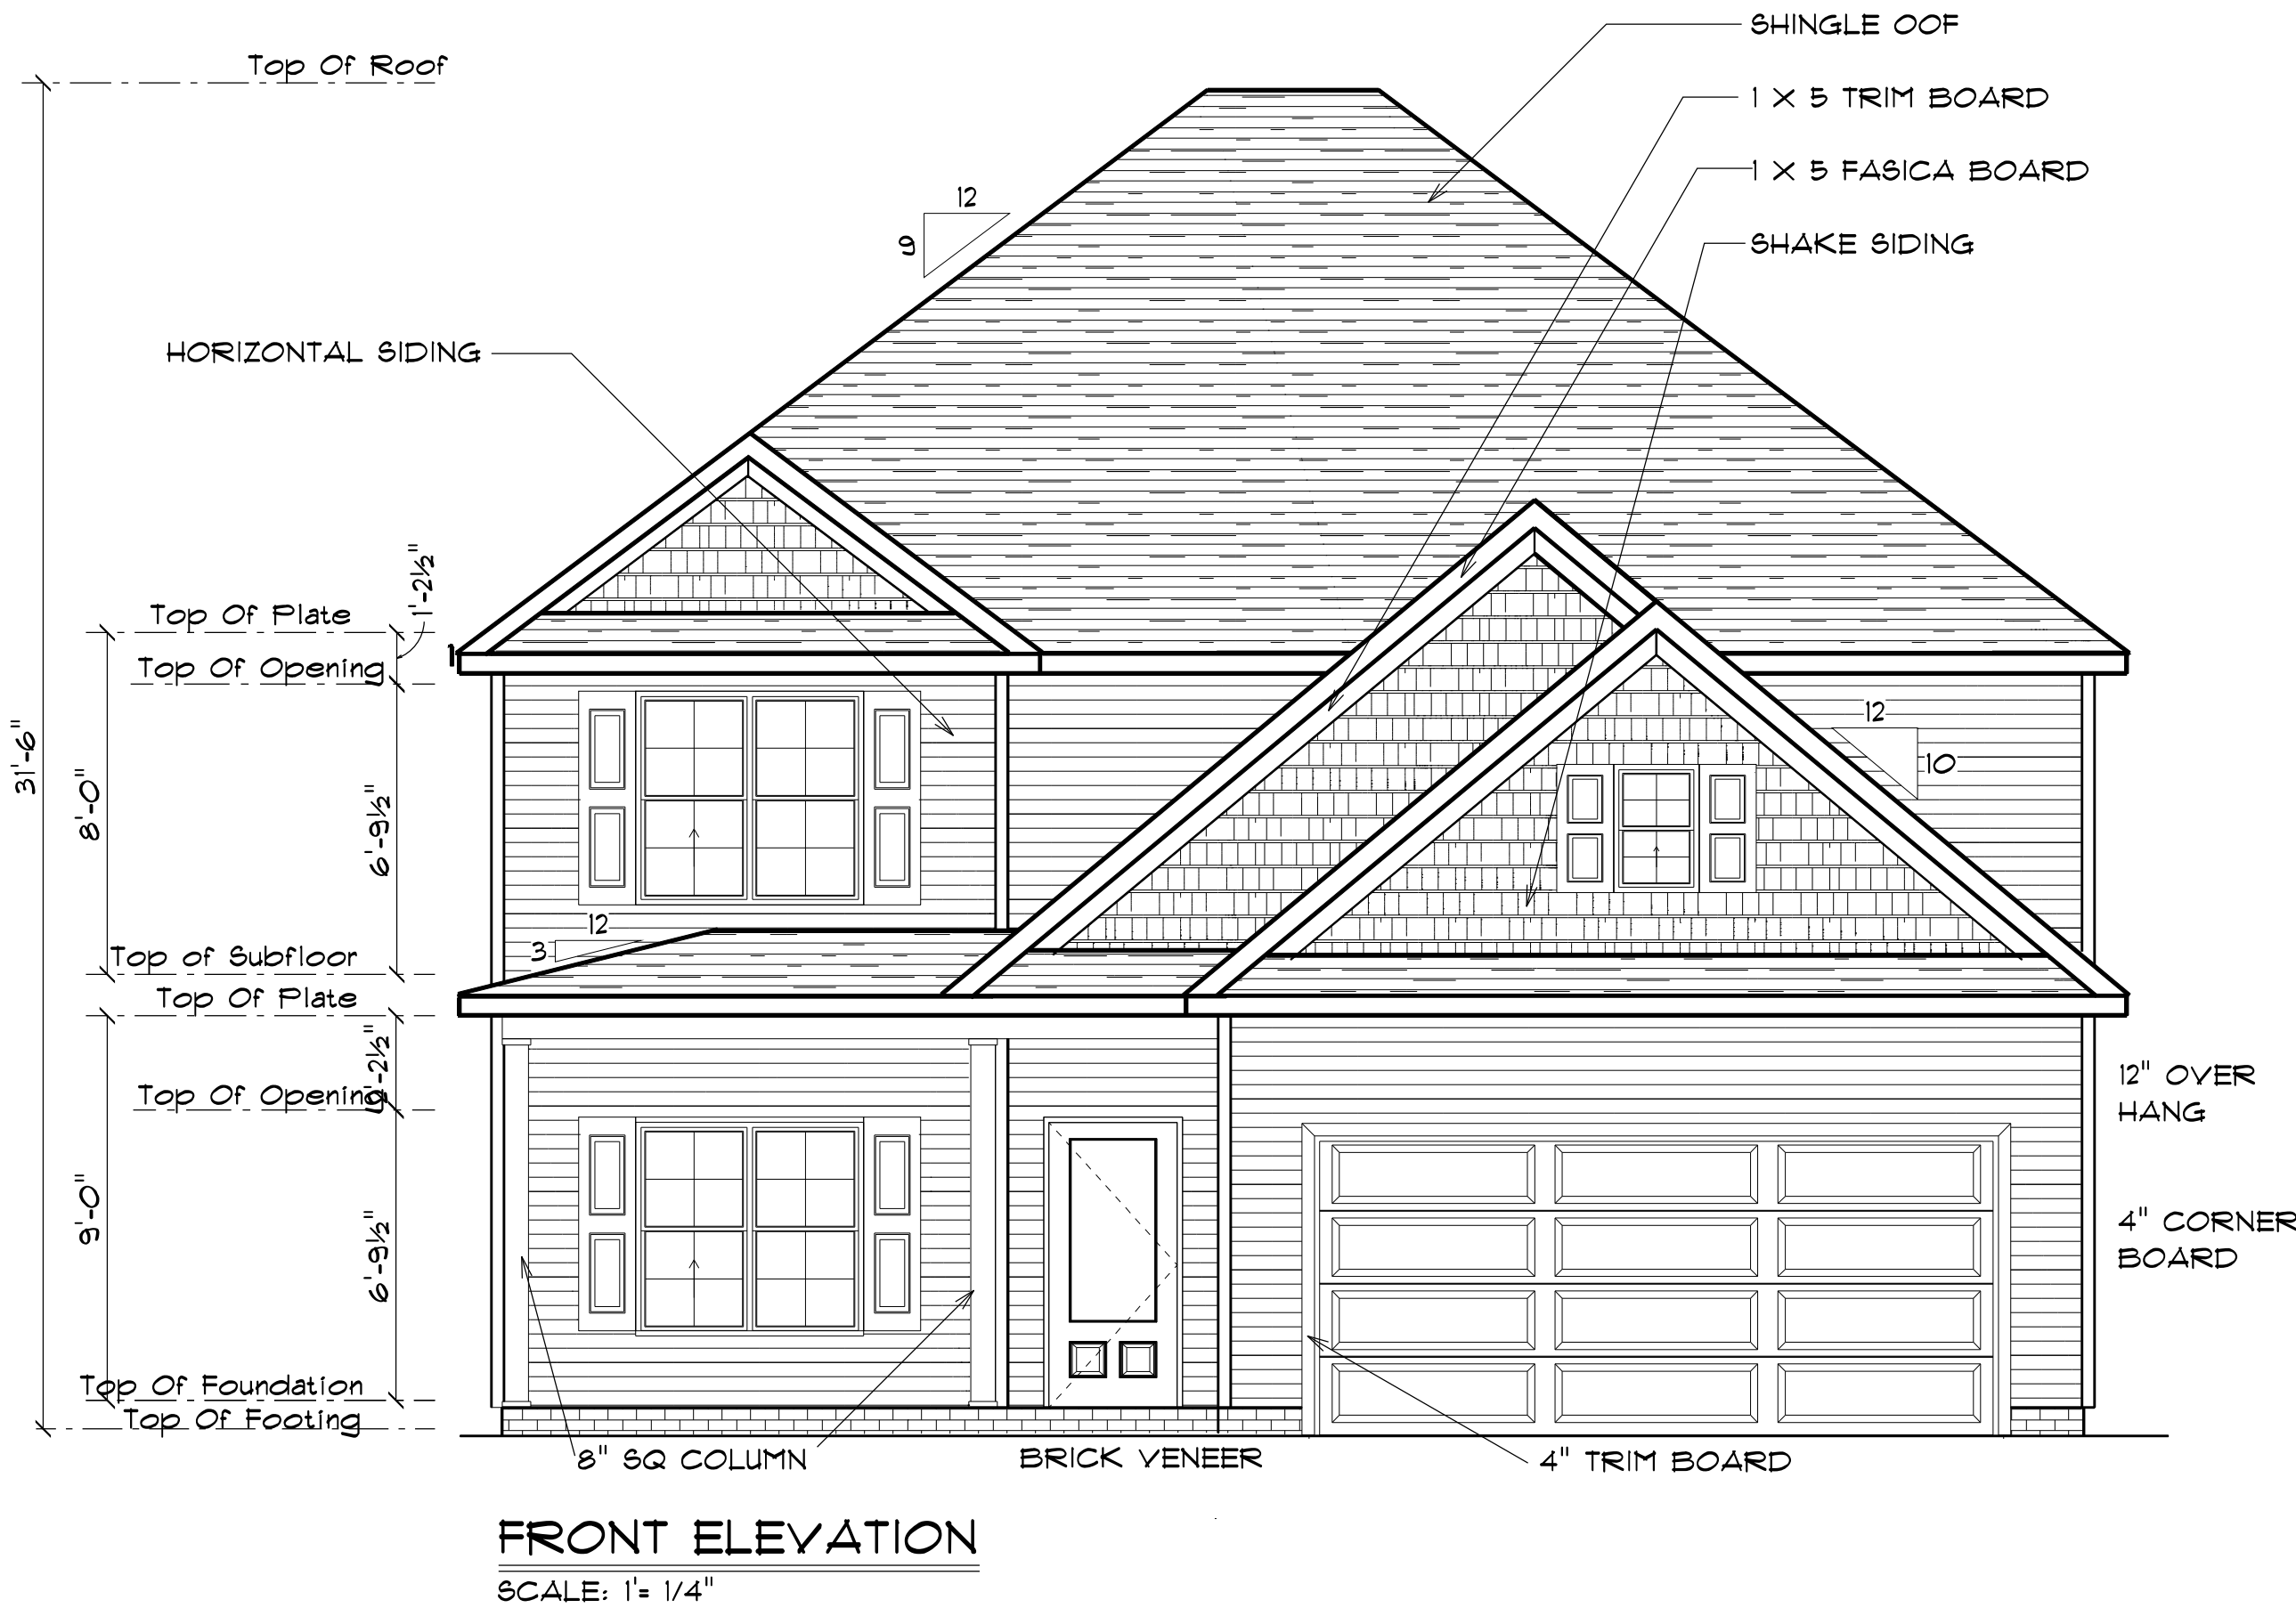


CRH HOMES RETAINS TITLE AND
OWNERSHIP OF ALL PLANS. THESE PLANS CAN NOT BE COPIED
OR REPRODUCED. THESE PLANS CAN NOT BE BUILT BY
ANYONE BUILDER OTHER THAN CRH HOMES

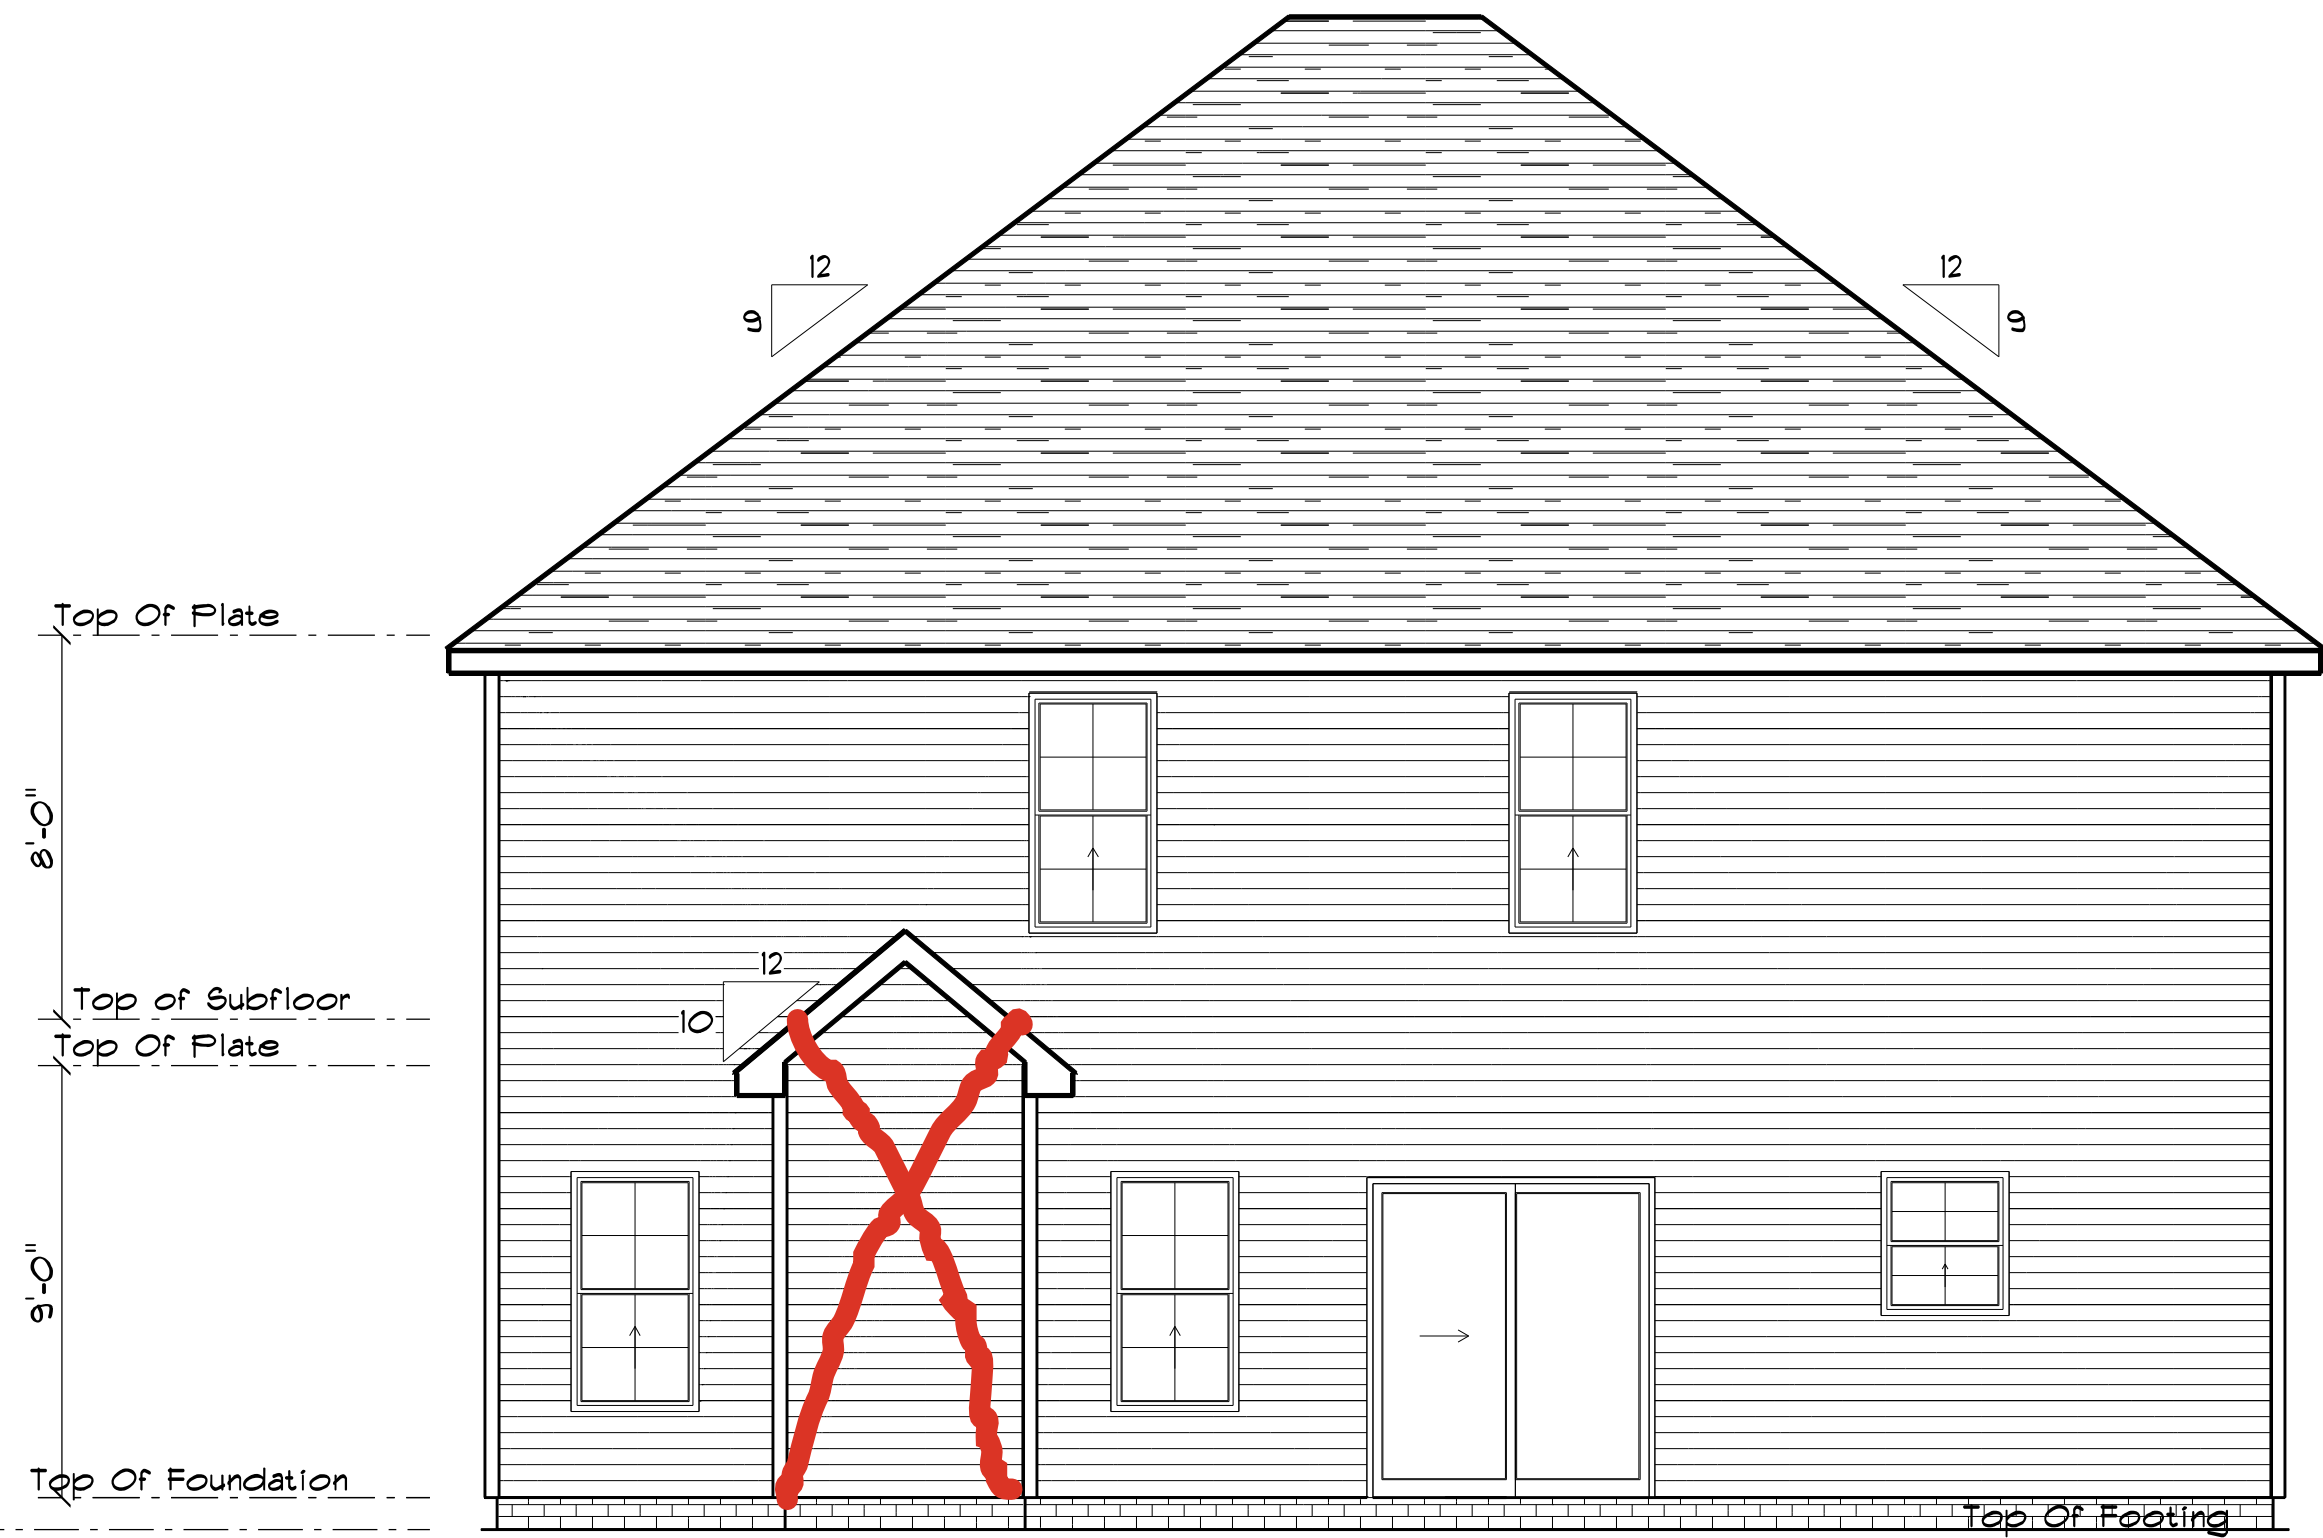

REAR ELEVATION
SCALE: 1"= 1/4"

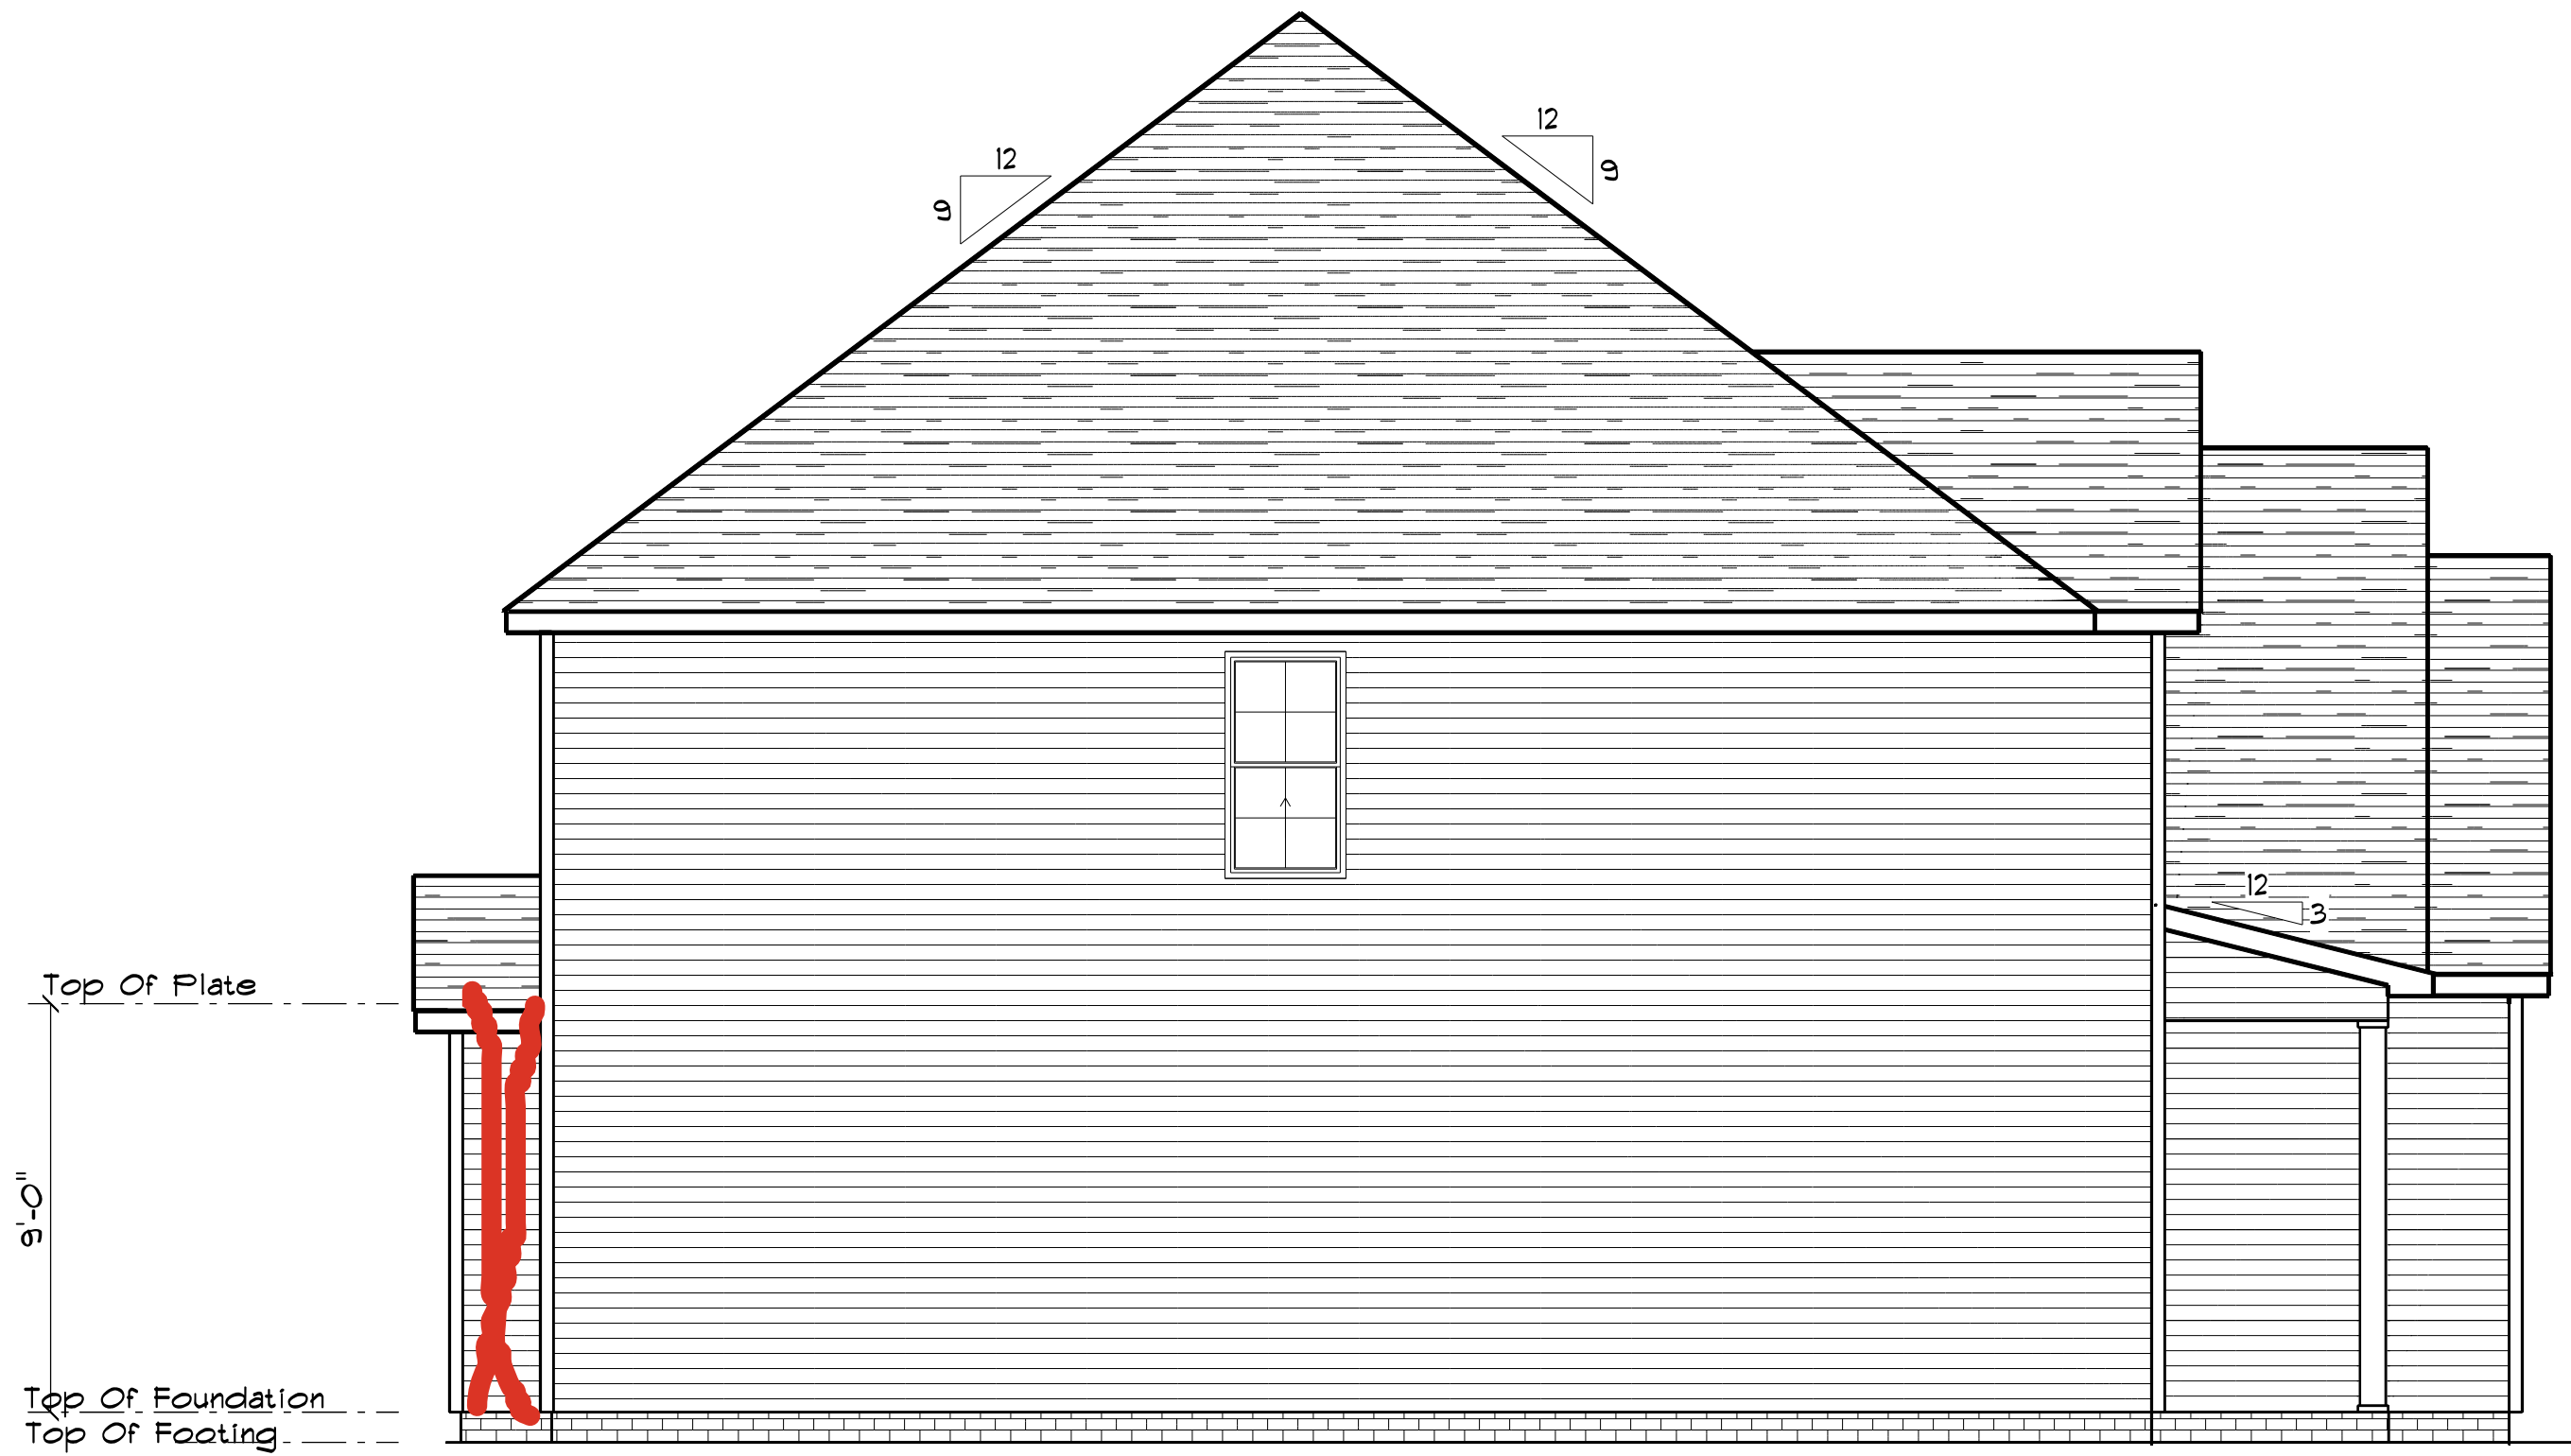

LEFT ELEVATION
SCALE: 1"= 1/4"

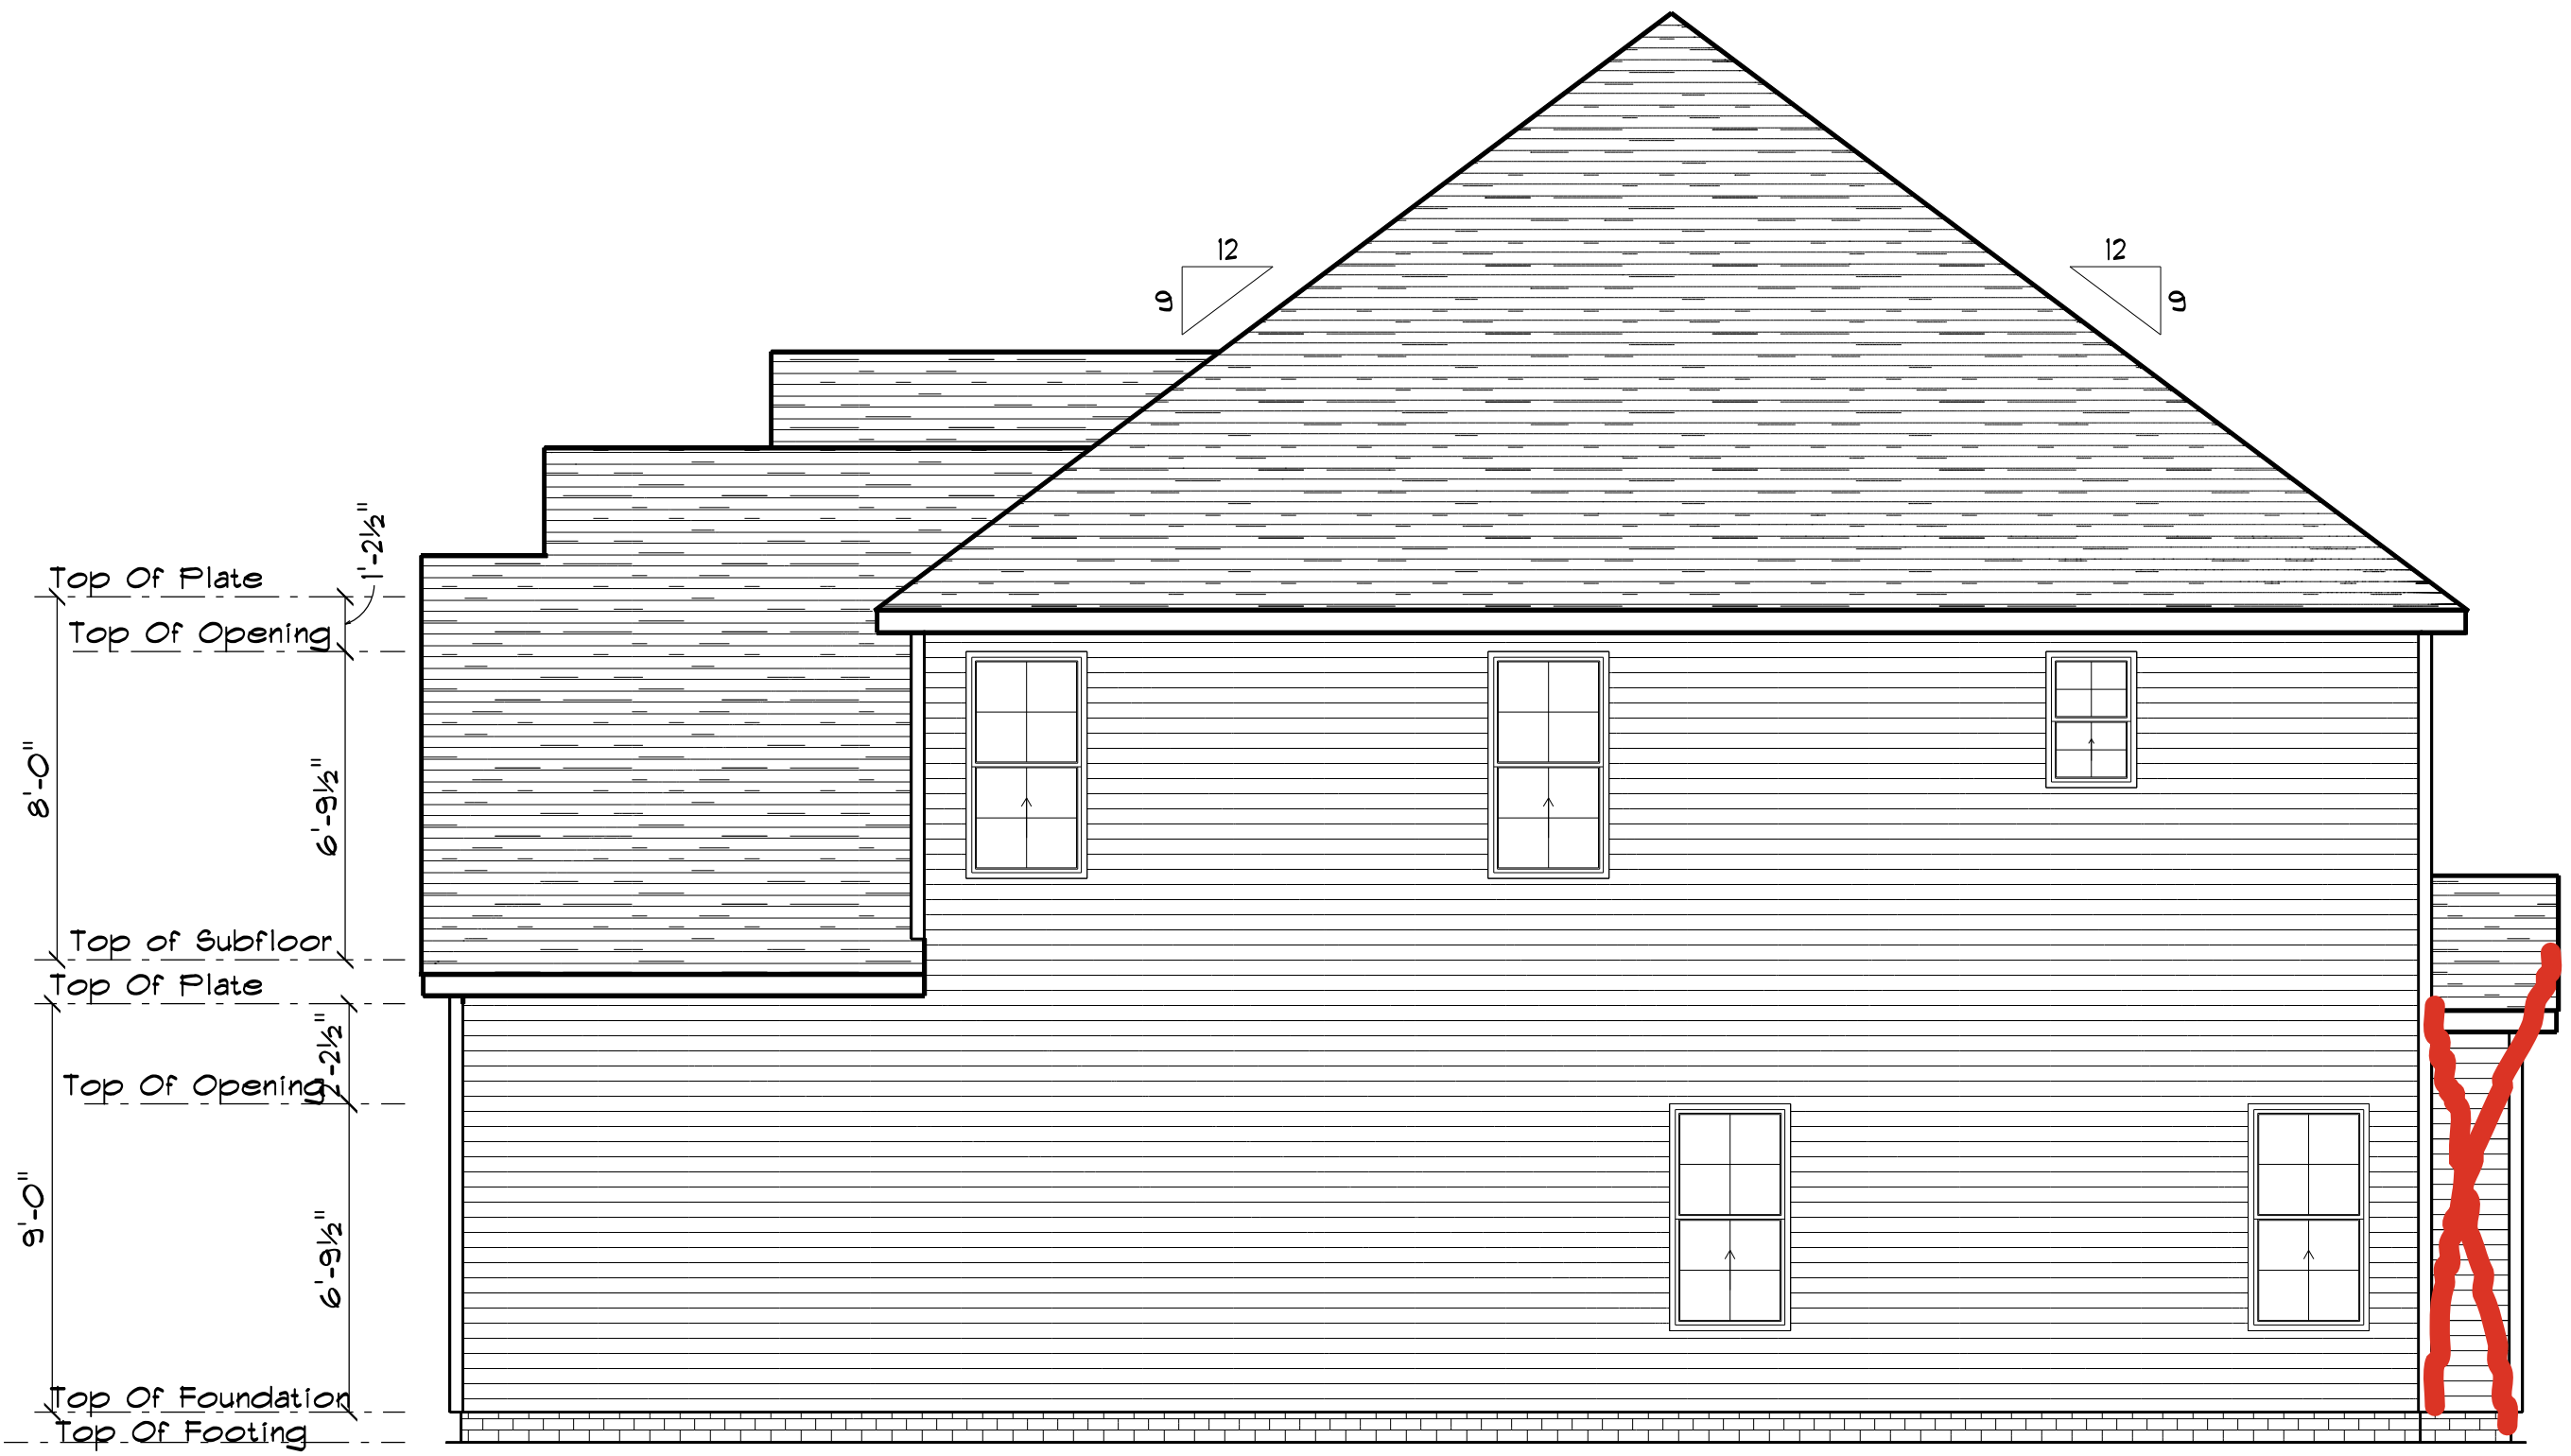

RIGHT ELEVATION
SCALE: 1"= 1/4"

FOUNDATION NOTES:
ALL FOOTINGS SHALL BEAR ON ORIGINAL UNDISTURBED SOIL.
THE 28 DAY COMPRESSIVE STRENGTH OF ALL FOOTINGS IS 3000 PSI.

PROVIDE WATER PROOFING AND PERIMETER DRAINS AS REQUIRED.


FOUNDATION CONCRETE MIX TO HAVE 1-1/2" MAX AGGREGATE SIZE. CONCRETE FILL MIX TO HAVE 1/2" MAX AGGREGATE SIZE.

FOOTING WIDTHS ARE BASED ON A LOAD-BEARING SOIL CAPACITY OF 2000 PSI.


PROVIDE 6 MIL POLY VAPOR BARRIER TO COVER GROUND SURFACE IN CRAWL SPACE

ALL ANCHOR BOLTS TO BE 12" LONG, 1/2" DIA. A36 UNO ANCHOR BOLTS SHALL BE SPACE AT A MAX OF 6' OC AND NO MORE THAN 1' FROM EA CORNER.

Termite Soil Treatment: Treat entire slab area soil or crawl space surface before vapor barrier is installed and slab is poured with a state approved termiticide. Termiticide should be applied by a licensed and certified pest control professional by the state of North Carolina.

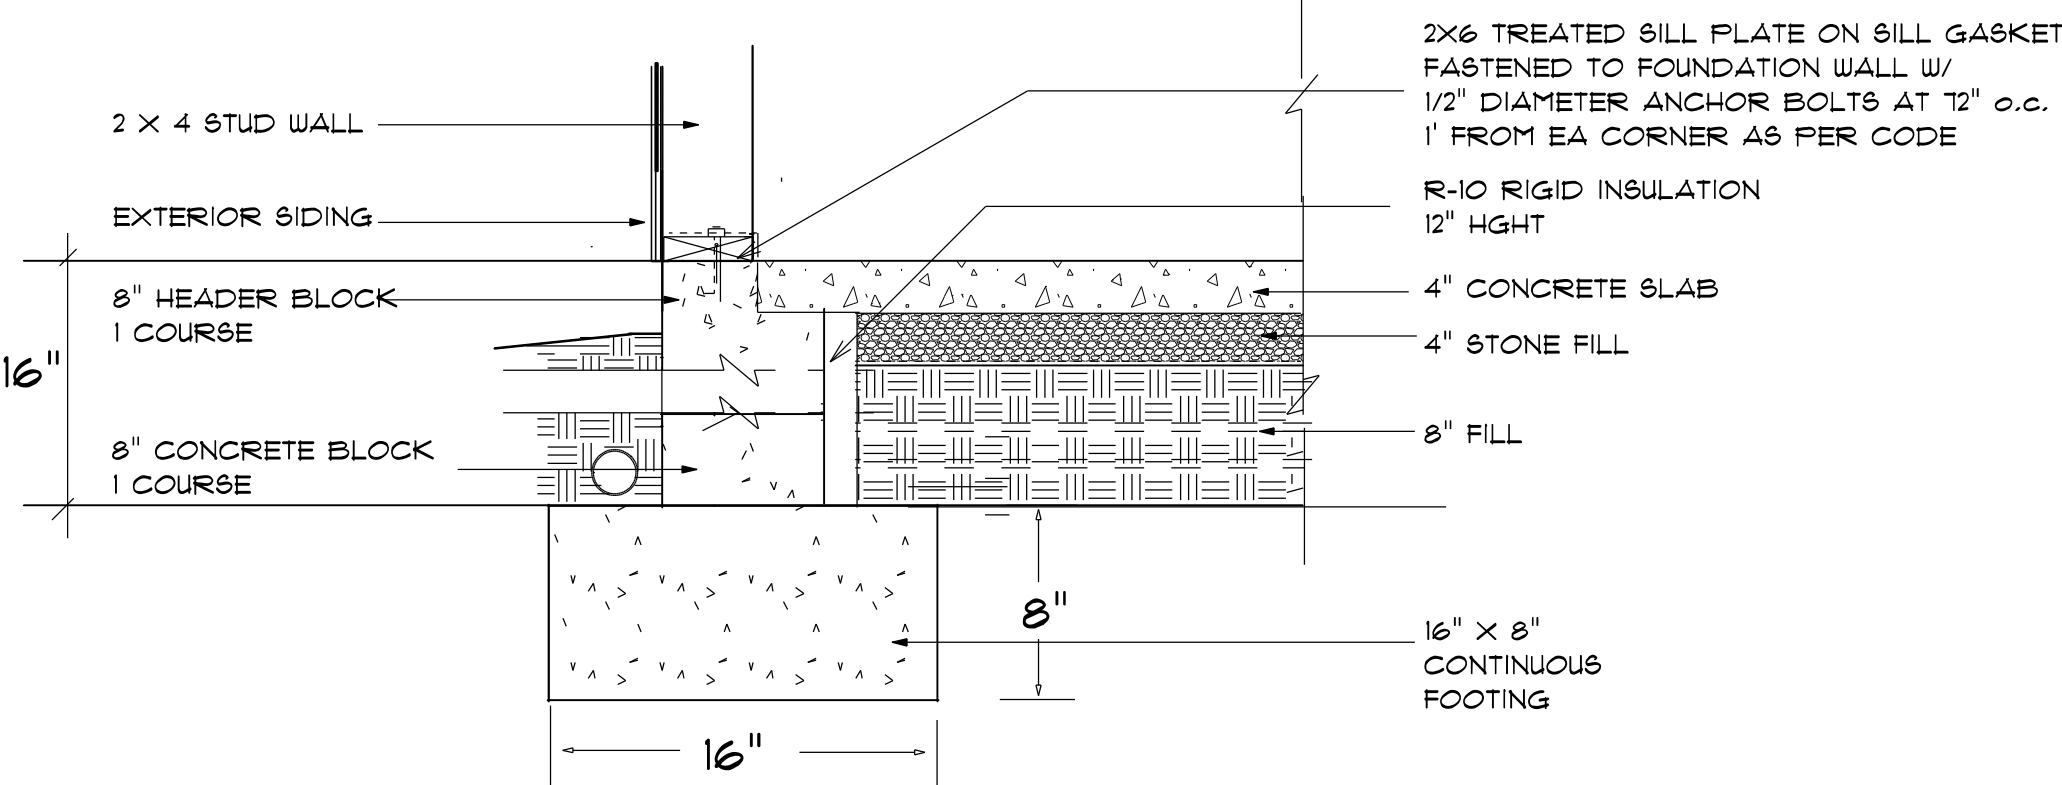


STEM WALL FOUNDATION Detail
NOT TO SCALE

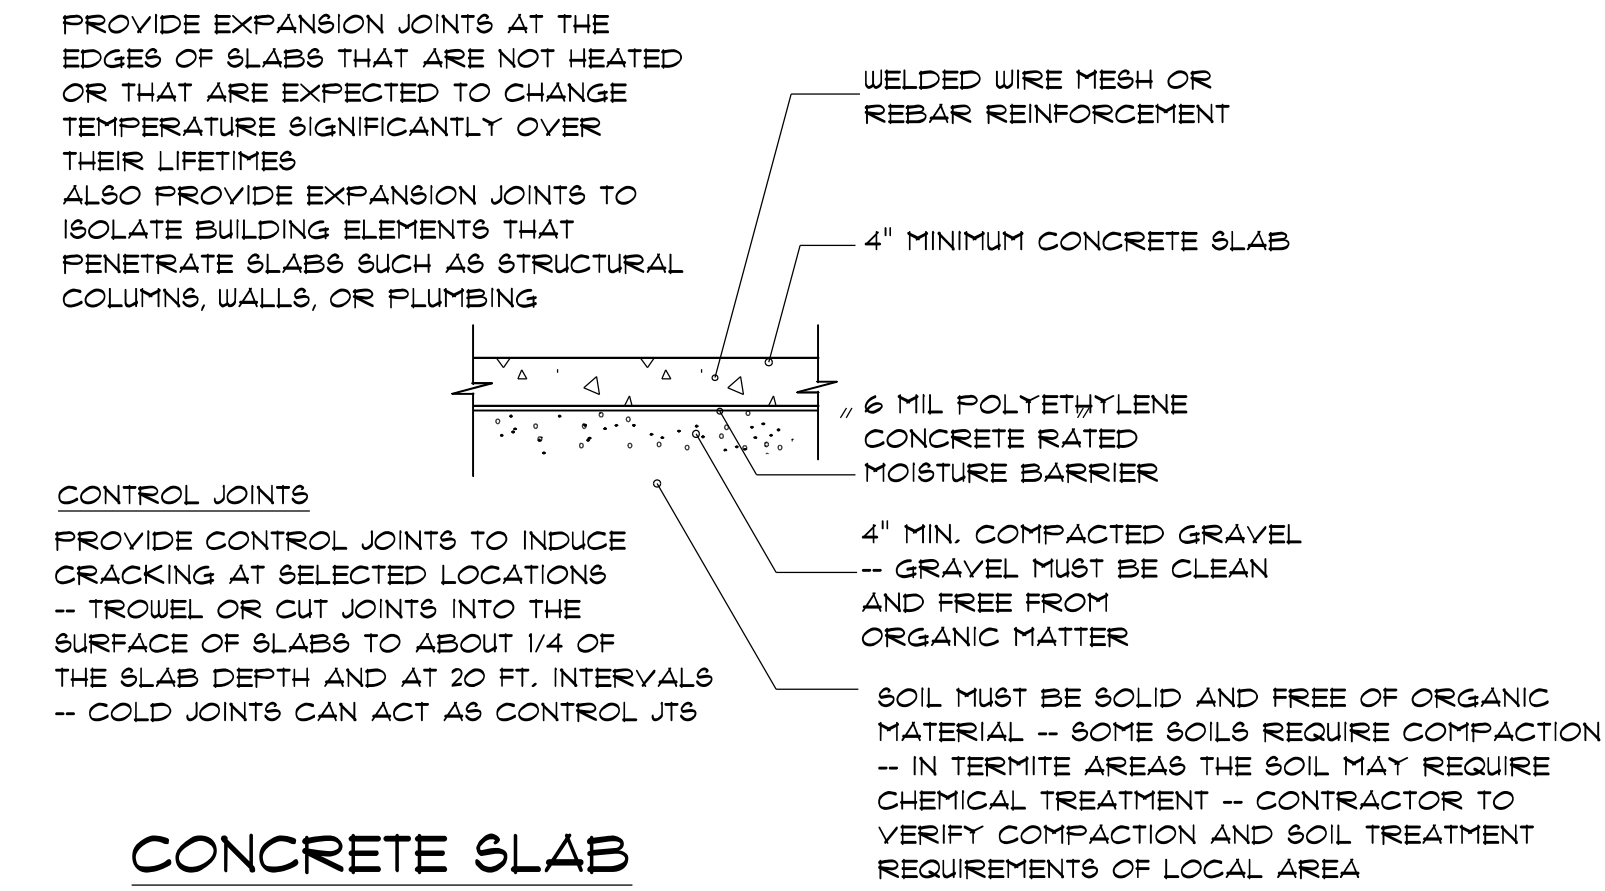


CONCRETE SLAB
DETAILS / NOTES

NOT TO SCALE

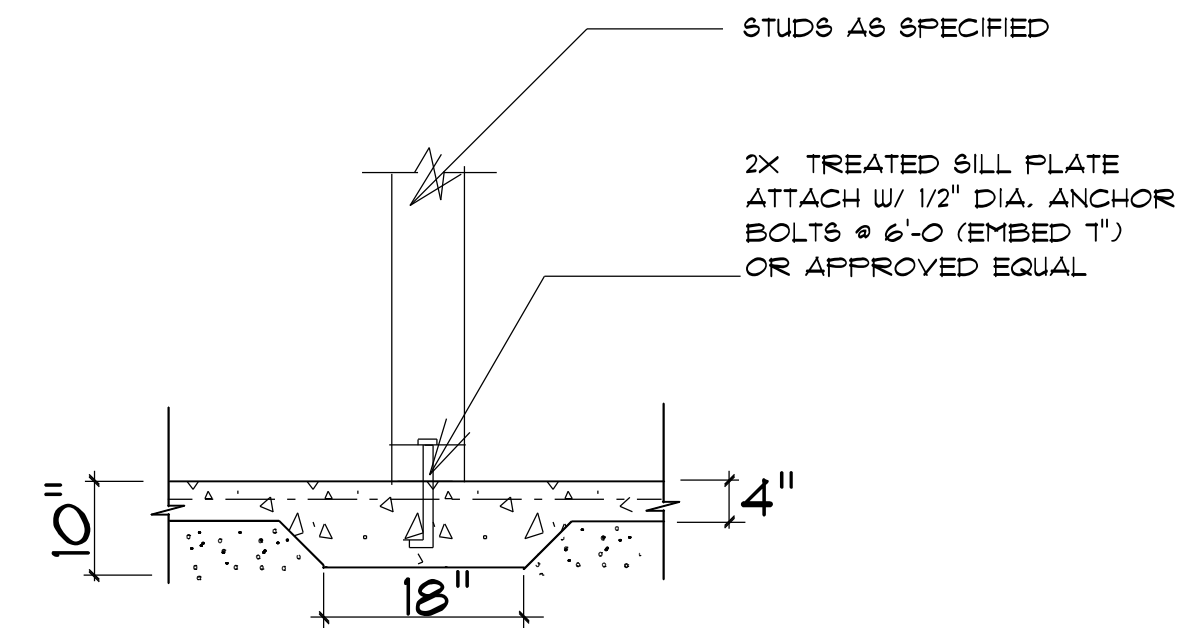

TYPICAL THICKENED SLAB
NOT TO SCALE

CRH HOMES RETAINS TITLE AND OWNERSHIP OF ALL PLANS. THESE PLANS CAN NOT BE COPIED OR REPRODUCED. THESE PLANS CAN NOT BE BUILT BY ANYONE BUILDER OTHER THAN CRH HOMES

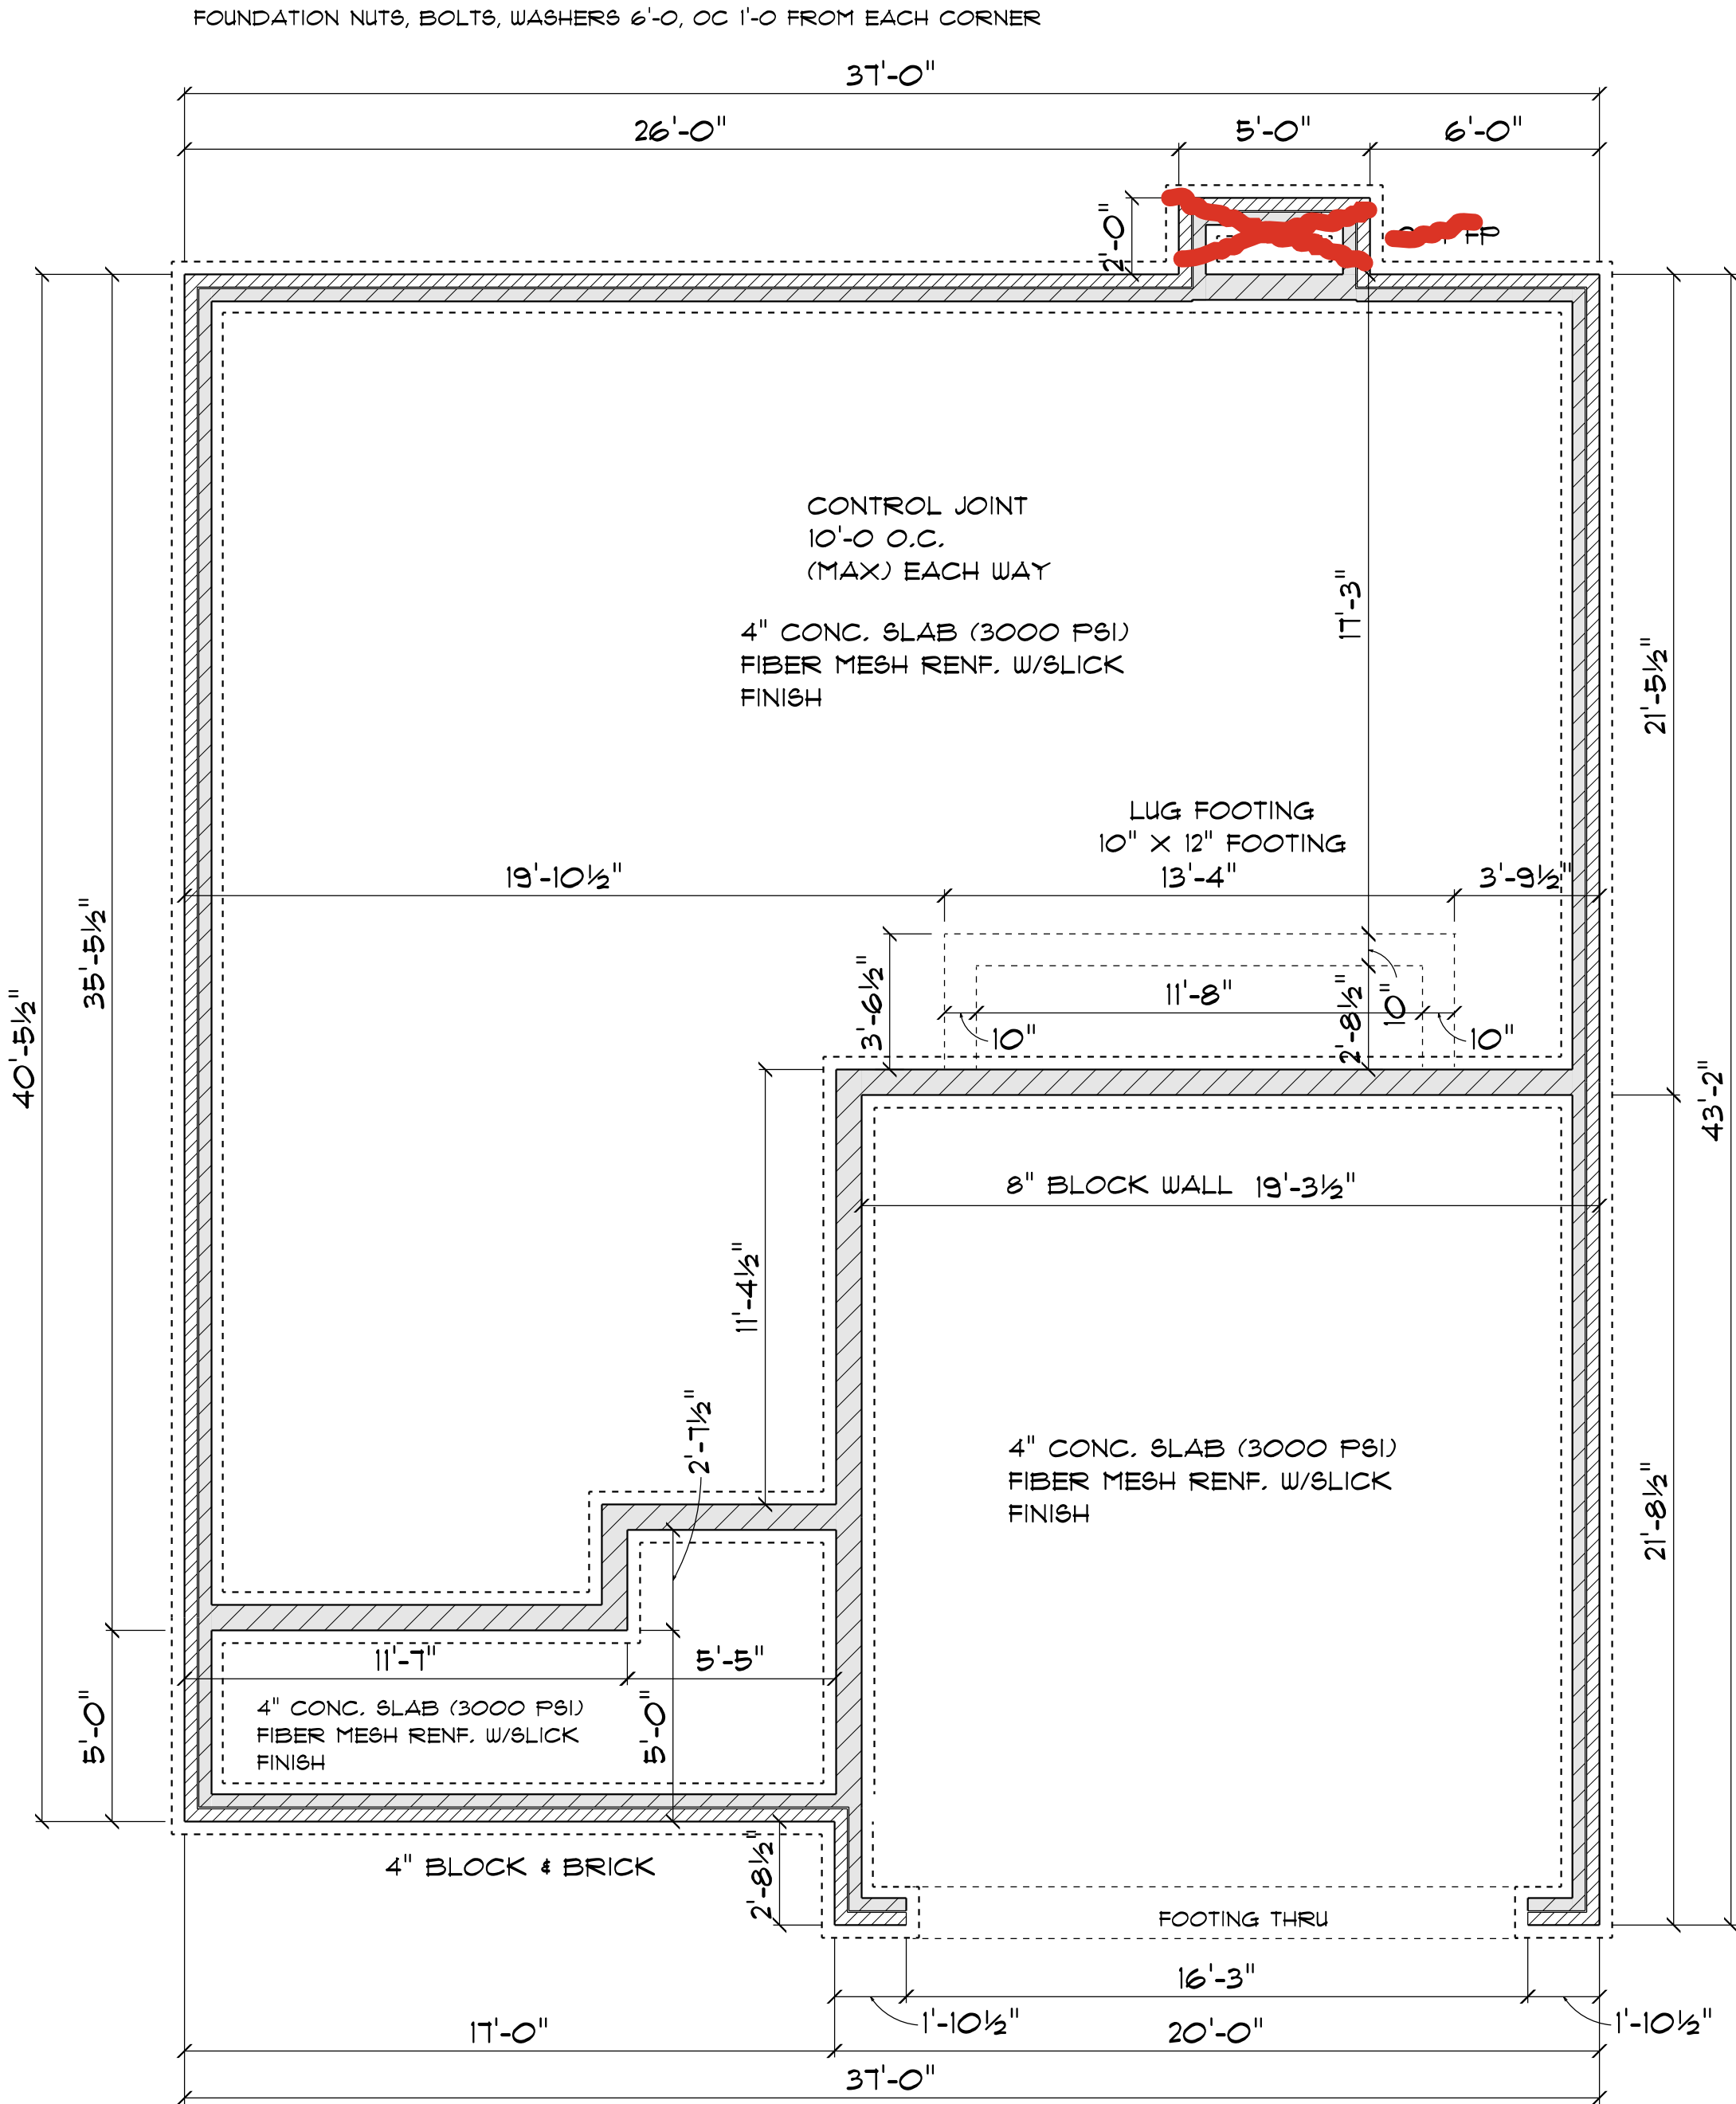

FOUNDATION PLAN
SCALE: 1"= 1/4"

3B

Diana Rivas Design
6205 Mockingbird Lane
Sanford, N.C. 27332
919-770-0353
golflandcharacter.net

SCALE: 1"= 1/4"
DRAWN BY:
DATE: 9/11/2023

CRH HOMES

THE OAKTON II
RIGHT GARAGE

STEM WALL FOUNDATION



GENERAL FRAMING NOTES:

ALL LUMBER IN CONTACT WITH CONCRETE OR MASONRY SHALL BE PRESSURE TREATED

FRAMING LUMBER SHALL BE SYP #2 GRADE AND/OR SPRUCE PINE FIR #1 AND/OR #2, KILN DRIED.

WHERE PRE-ENGINEERED JOISTS ARE USED, JOIST MANUFACTURER SHALL PROVIDE SHOP DRAWINGS, WHICH BEAR SEAL OF A N.C. ENGINEER.

STUDS AND JOISTS SHALL NOT BE CUT TO INSTALL PLUMBING OR WIRING WITHOUT ADDING METAL OR WOOD SIDE PANELS TO STRENGTHEN THE MEMBER TO ITS ORIGINAL CAPACITY.

NAIL MULTIPLE MEMBERS WITH 2 ROWS OF 16d NAILS STAGGERED 32" OC AN USE 3-6d NAILS 2" IN AT EACH END. DOUBLE ALL STUDS UNDER ROOF POST DOUBS UNO

NAIL FLOOR JOISTS TO BILL PLATE WITH 8d TOE NAILS.

ALL EXPOSED FRAMING ON PORCHES AND DECKS SHALL BE PRESSURE TREATED.

PROVIDE WATERPROOFING AND DRAINS AS REQUIRED.


ALL FRAMING TO BE 16" OC UNO. WALL FRAMING DIMENSIONS ARE BASED ON 2 X 4 STUDS UNO. DOUBLE STUDS UNDER ALL HEADERS.

LVL'S AND TJ'S TO BE SIZED BY OTHERS

EXTERIOR WALLS IN LIVING AREAS ARE 2 X 4

CRH HOMES RETAINS TITLE AND OWNERSHIP OF ALL PLANS. THESE PLANS CAN NOT BE COPIED OR REPRODUCED. THESE PLANS CAN NOT BE BUILT BY ANYONE BUILDER OTHER THAN CRH HOMES



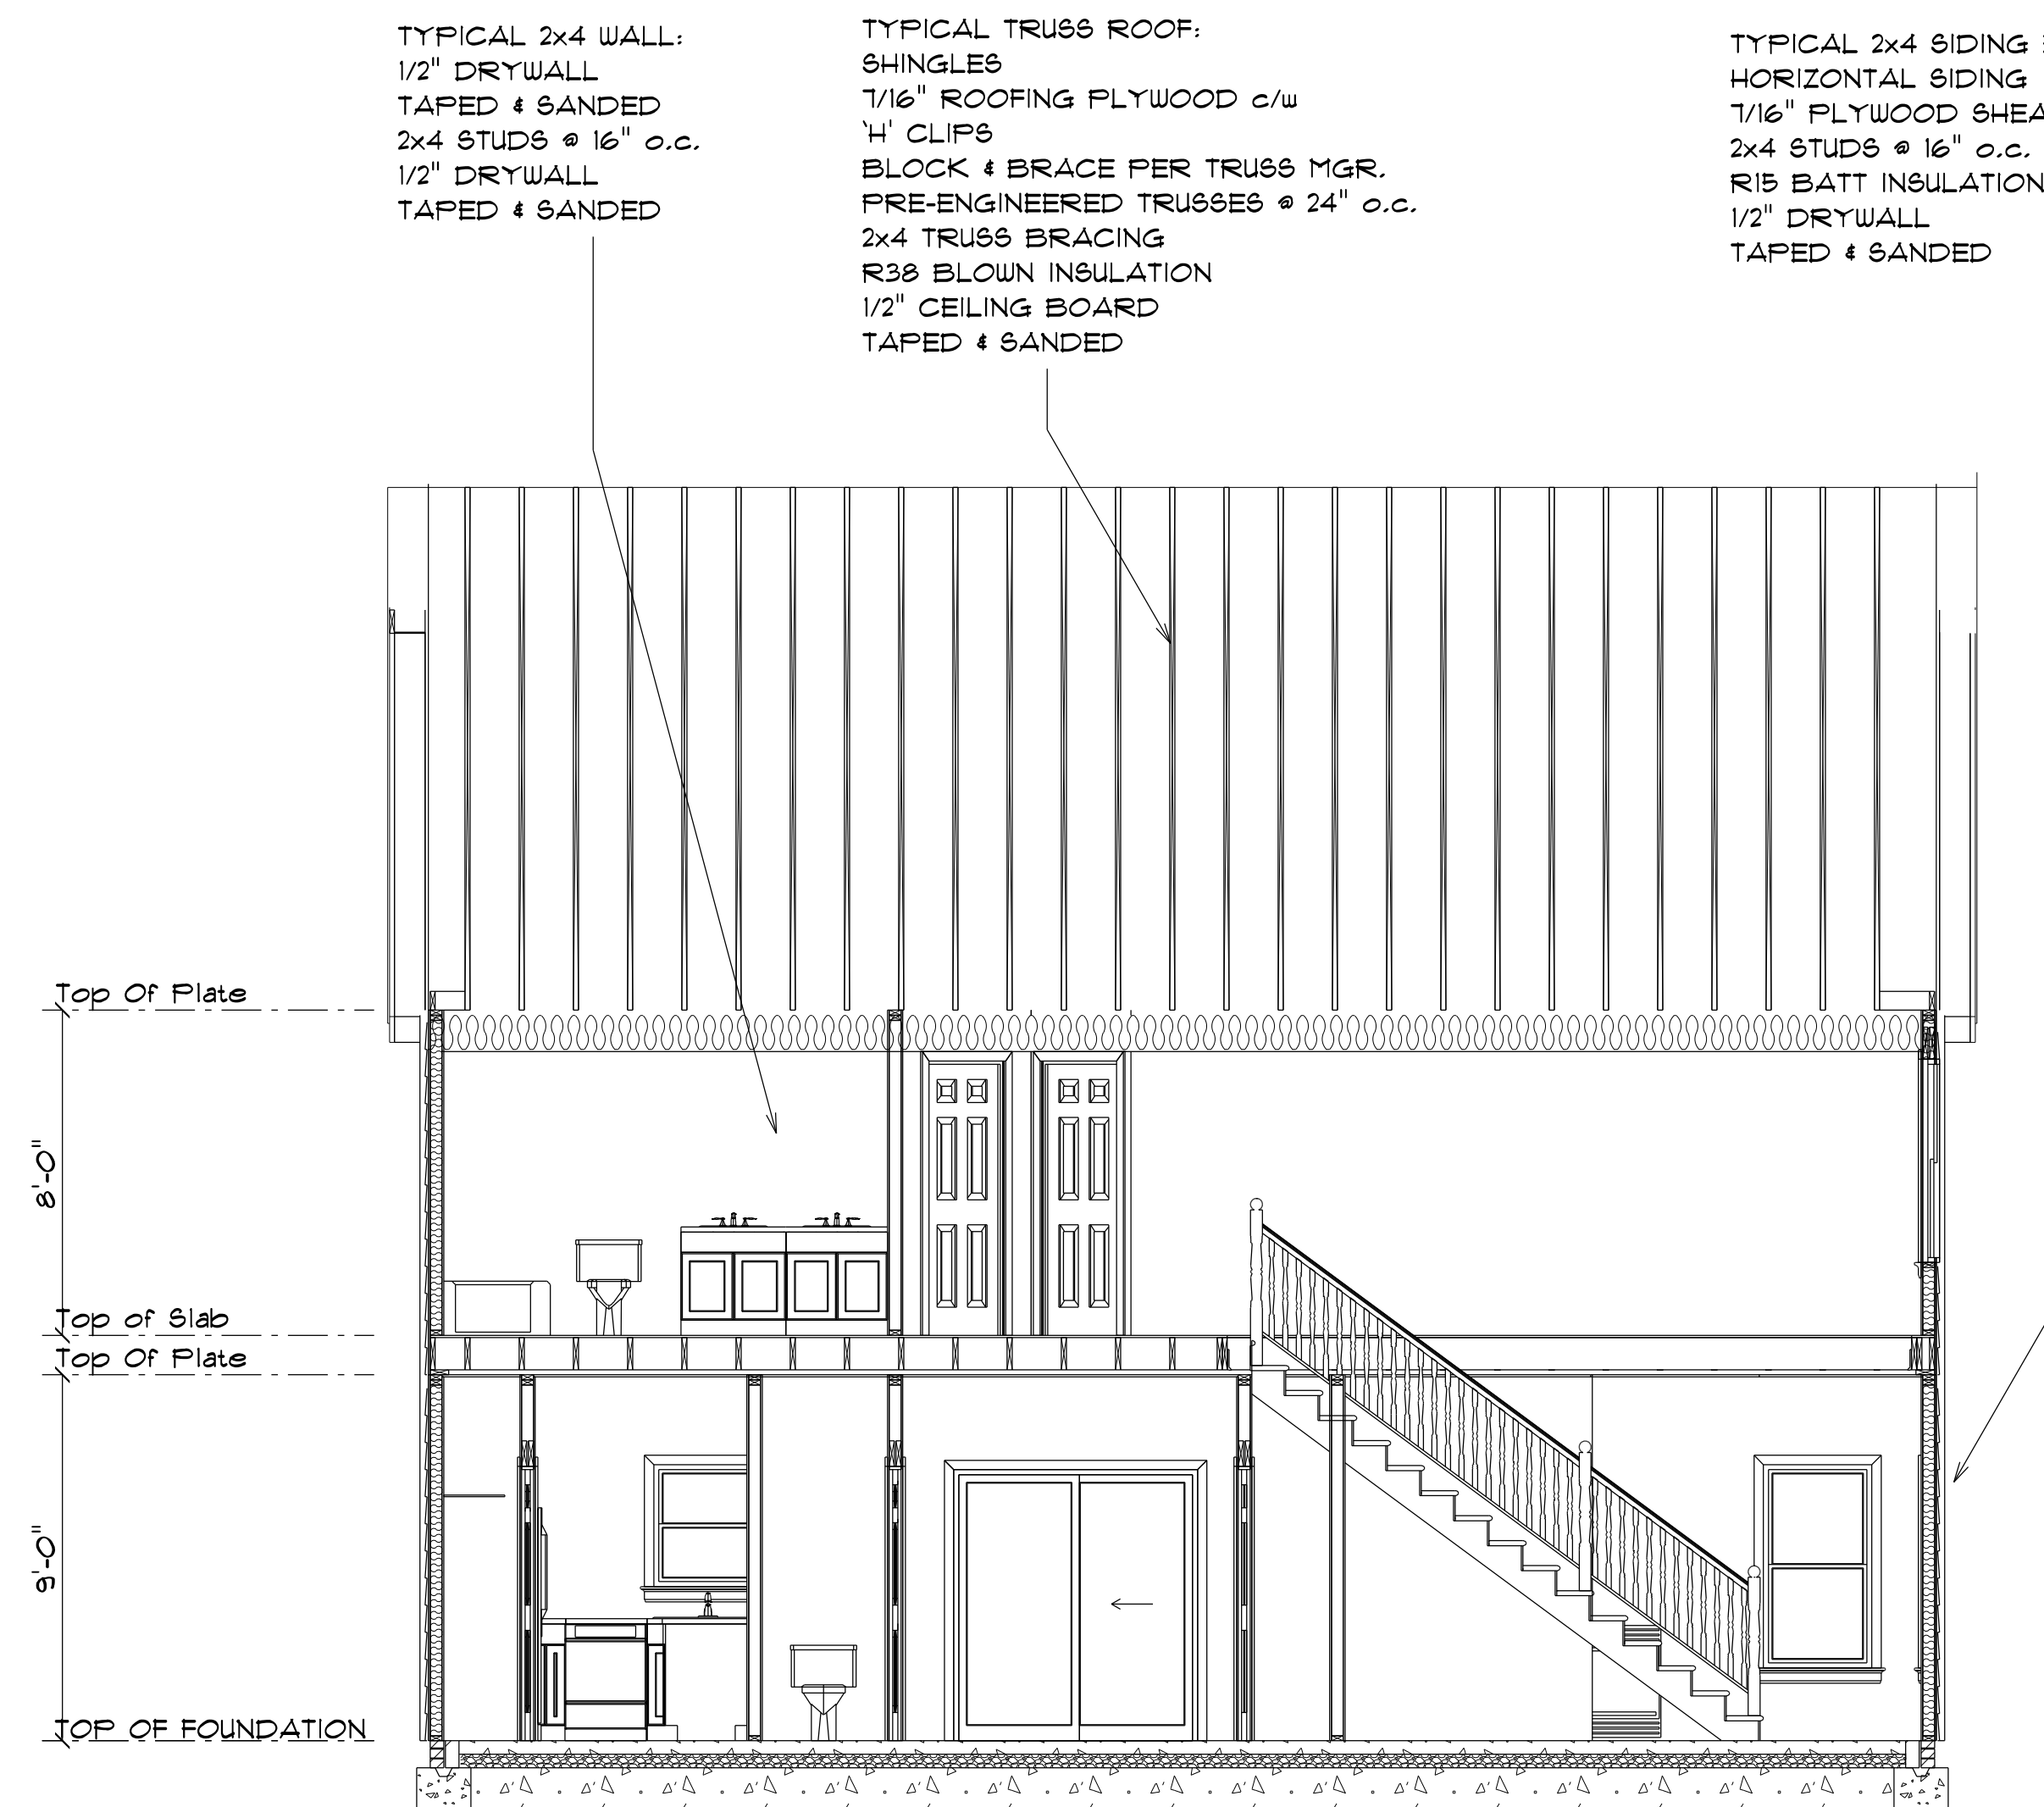

SECTION THROUGH
SCALE: 1" = 1/4"

ROOF NOTES:


TRUSSES, BRACINGS, BRIDGING AND CONNECTORS ARE TO BE DESIGNED BY THE TRUSS MANUFACTURER.


IDENTIFY LUMBER BY OFFICIAL GRADE MARKINGS.

DO NOT CUT OR REMOVE CHORDS OR OTHER TRUSS MEMBERS.
DO NOT NOTCH OR DRILL TRUSS MEMBERS.

WHERE PRE-ENGINEERED ROOF TRUSSES ARE USED, TRUSS MANUFACTURER SHALL PROVIDE SHOP DRAWINGS, WHICH BEAR SEAL OF A N. C. REGISTERED ENGINEER.

CRH HOMES RETAINS TITLE AND OWNERSHIP OF ALL PLANS. THESE PLANS CAN NOT BE COPIED OR REPRODUCED. THESE PLANS CAN NOT BE BUILT BY ANYONE BUILDER OTHER THAN CRH HOMES

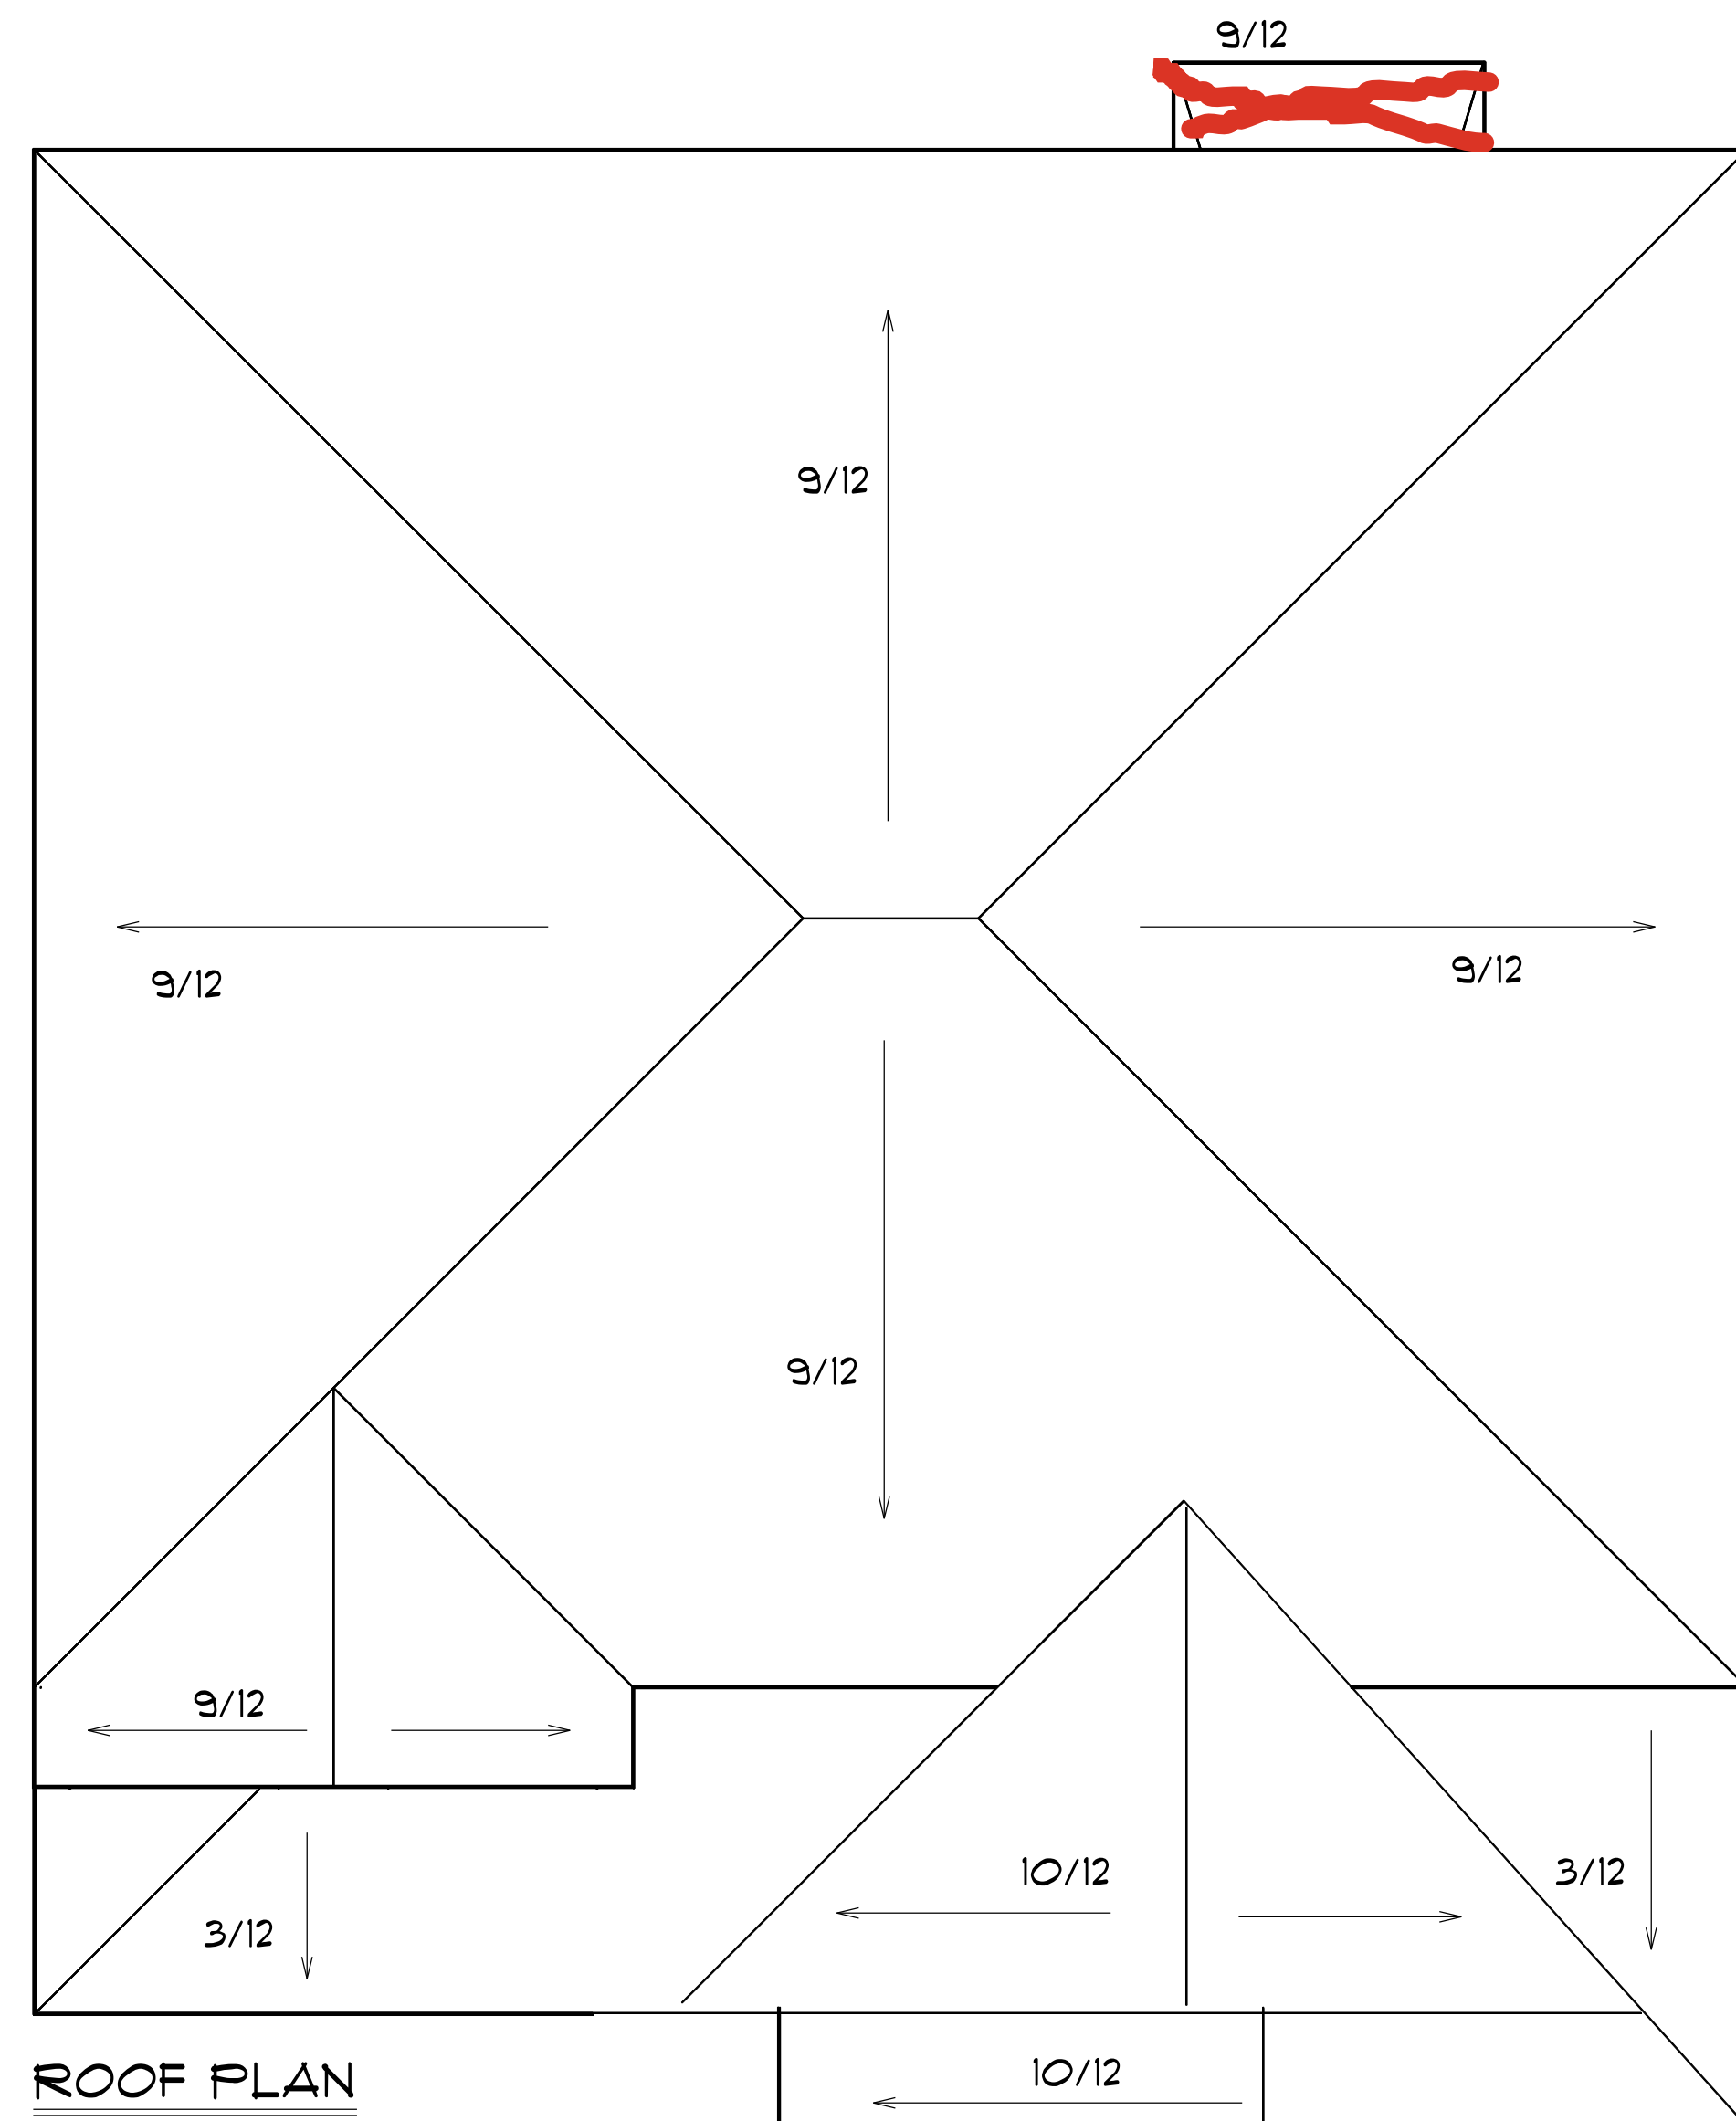


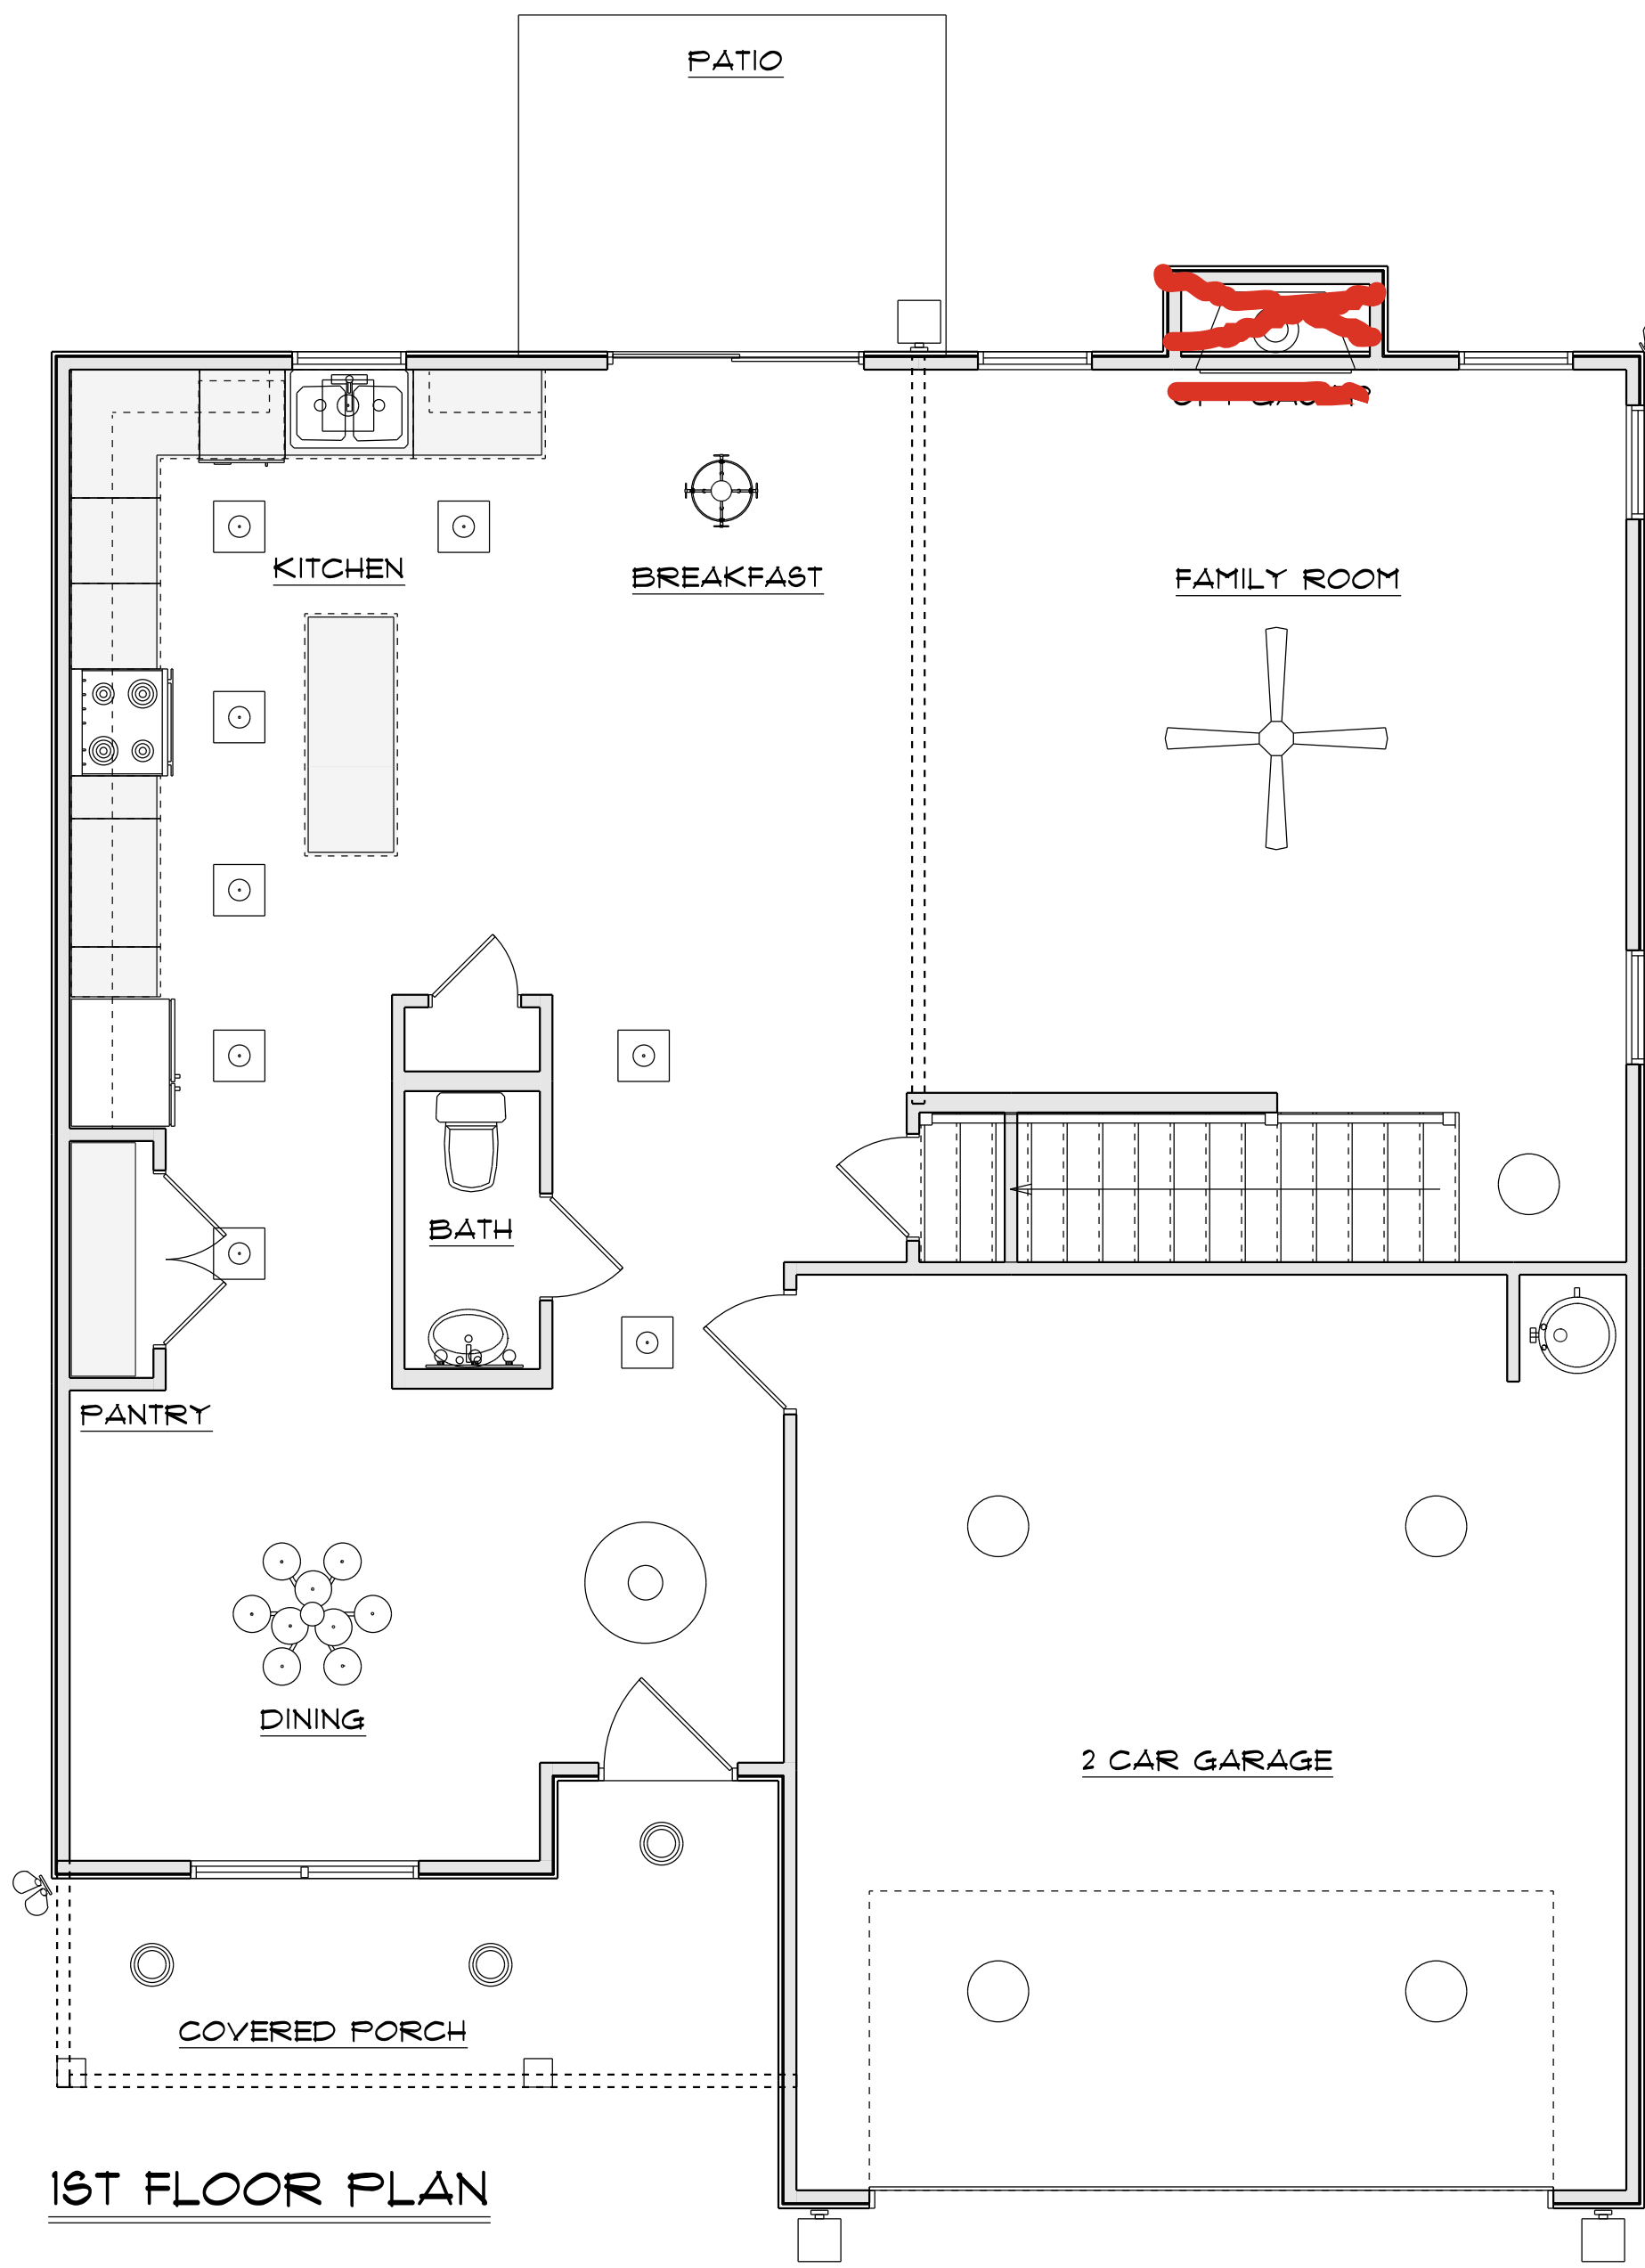


1ST FLOOR PLAN

CRH HOMES RETAINS TITLE AND OWNERSHIP OF ALL PLANS. THESE PLANS CAN NOT BE COPIED OR REPRODUCED. THESE PLANS CAN NOT BE BUILT BY ANYONE BUILDER OTHER THAN CRH HOMES

ELECTRICAL LEGEND		
ELECTRICAL	COUNT	SYMBOL
ceiling fan	2	
10" led	8	
7" led	21	
foyer light	1	
dinning room light	1	
coach light	3	
exterior over head	3	
flood light	3	
vanity bar light	5	
wall sconce		
nook light	1	

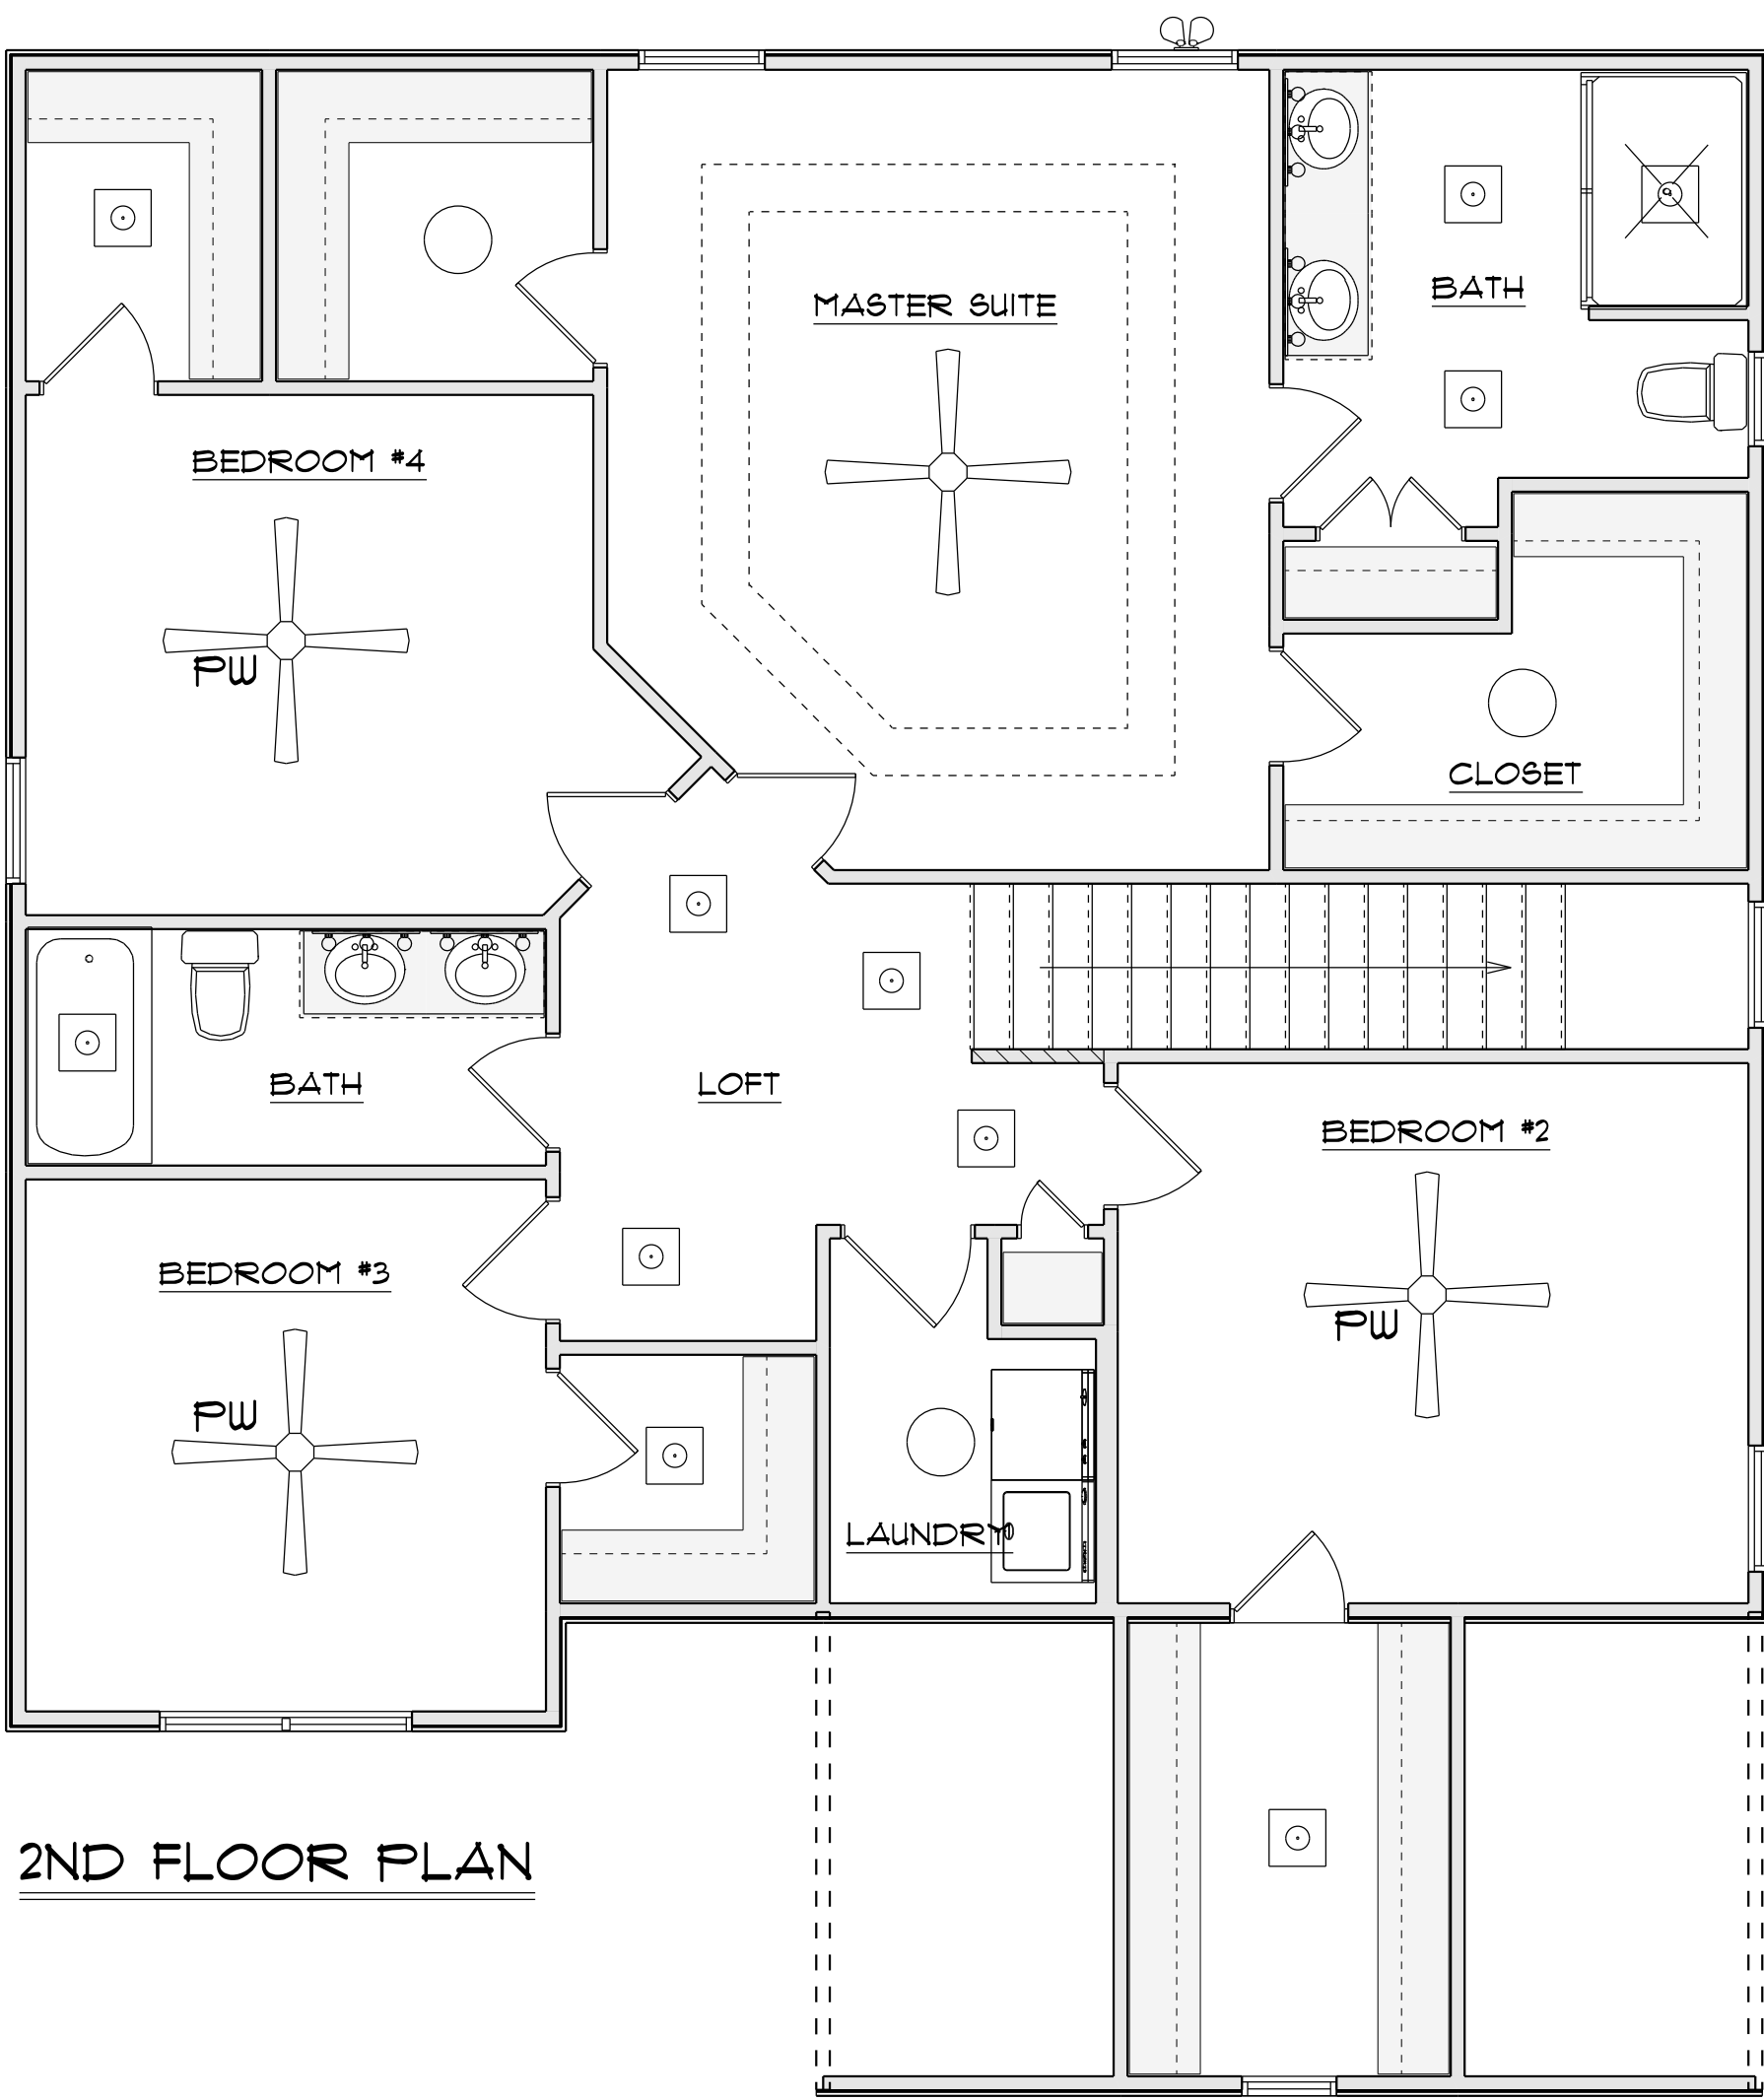

2ND FLOOR PLAN

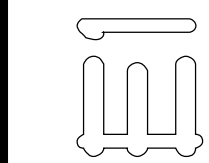

Diane Rivers Designs
6205 Mockingbird Lane
Sanford, N.C. 27332
919-710-0353
golfcoursecharter.net

SCALE: 1"= 1/4"
DRAWN BY:
DATE: 9/11/2023

CRH HOMES

THE OAKTON II
RIGHT GARAGE

ELECTRICAL LAYOUT